




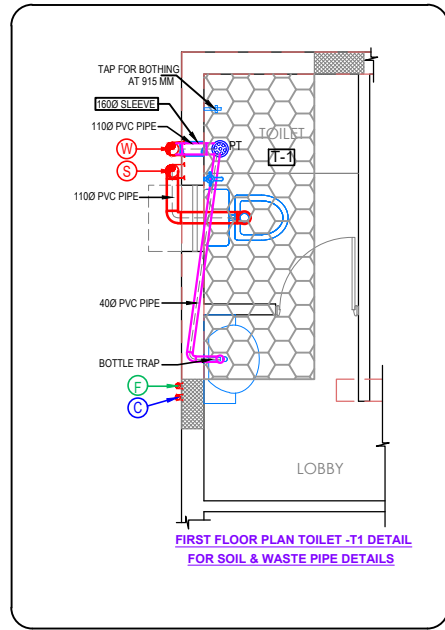


FIRST FLOOR PLAN TOILET -T1 DETAIL
FOR SOIL & WASTE PIPE DETAILS

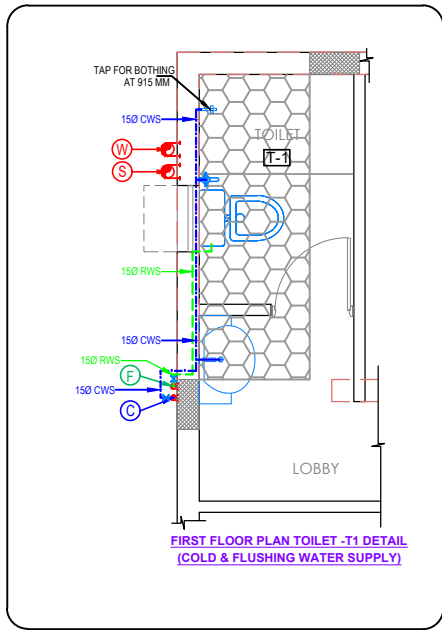


FIRST FLOOR PLAN TOILET -T1 DETAIL
(COLD & FLUSHING WATER SUPPLY)

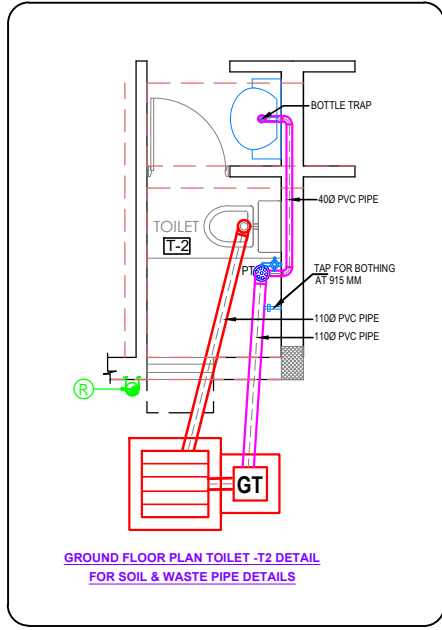


GROUND FLOOR PLAN TOILET -T2 DETAIL
FOR SOIL & WASTE PIPE DETAILS

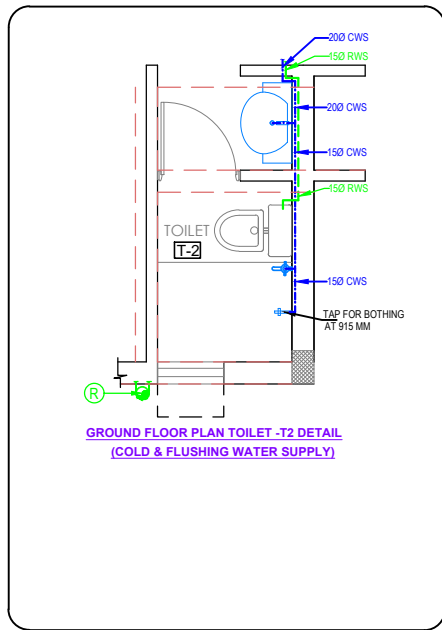


GROUND FLOOR PLAN TOILET -T2 DETAIL
(COLD & FLUSHING WATER SUPPLY)

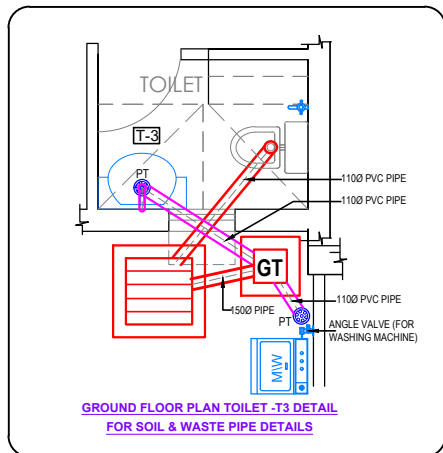


GROUND FLOOR PLAN TOILET -T3 DETAIL
FOR SOIL & WASTE PIPE DETAILS

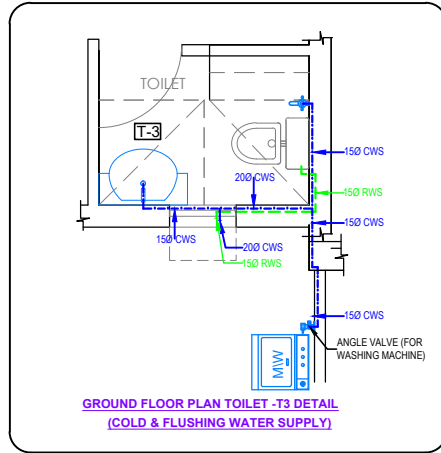


GROUND FLOOR PLAN TOILET -T3 DETAIL
(COLD & FLUSHING WATER SUPPLY)

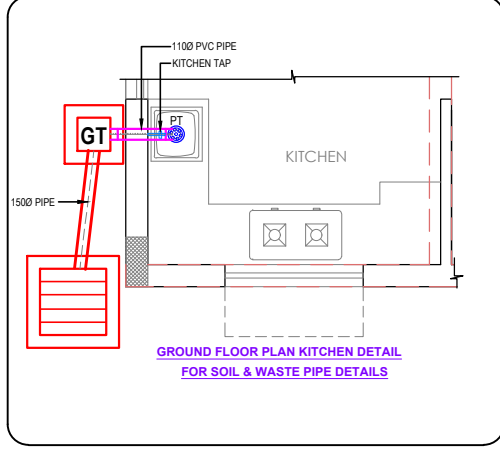


GROUND FLOOR PLAN KITCHEN DETAIL
FOR SOIL & WASTE PIPE DETAILS

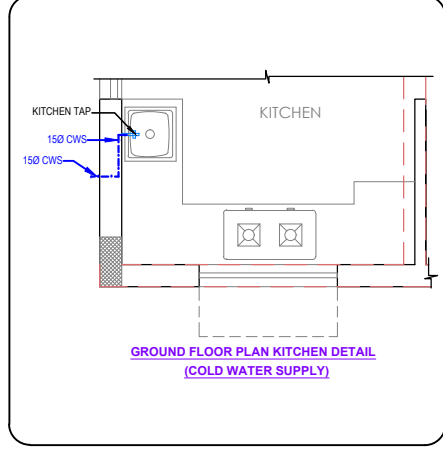

GROUND FLOOR PLAN KITCHEN DETAIL
(COLD WATER SUPPLY)

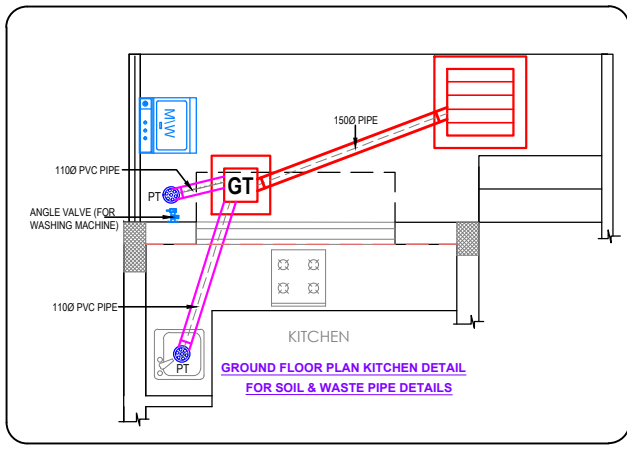

GROUND FLOOR PLAN KITCHEN DETAIL
FOR SOIL & WASTE PIPE DETAILS

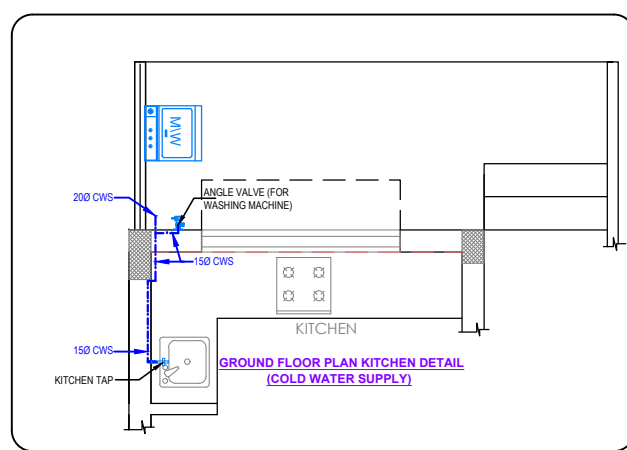

GROUND FLOOR PLAN KITCHEN DETAIL
(COLD WATER SUPPLY)

LEGEND : (Plumbing)












S. No.	SYMBOL	DESCRIPTION
1.	(S)	110 Ø PVC SOIL AND VENT PIPE
2.	(W)	75 Ø PVC WASTE AND VENT PIPE
3.	(R)	110 Ø PVC RAIN WATER PIPE
4.	(C)	WATER SUPPLY RISER TO TOILET / KITCHEN WATER LINE TO TOILET / KITCHEN
5.	(F)	RECYCLE WATER SUPPLY RISER
6.	(G)	GEYSER
7.	(CWS)	COLD WATER SUPPLY PIPE (CWS)
8.	(RWS)	RECYCLE WATER SUPPLY PIPE (R.W.S.)
9.	(SWS)	SOLAR WATER SUPPLY PIPE (SWS)
10.	(IV)	ISOLATING VALVE
11.	(PT)	P TRAP
12.	(DP)	DRAIN POINT
13.	(WP)	WATER PURIFIER
14.	(WM)	WASHING MACHINE
15.	(GT)	GULLY TRAP
16.	(M.H.)	MANHOLE
17.	(AV)	ANGLE VALVE

- COLD WATER SUPPLY PIPE MATERIAL**
 - FOR INSIDE TOILET (DOMESTIC) - CPVC (SDR-11) WITH SOLVENT CEMENT JOINTS
 - FOR INSIDE TOILET (RECYCLE) - UPVC SCH 40 PIPES WITH SCH 80 FITTINGS BY SOLVENT CEMENT JOINT
- HOT WATER SUPPLY PIPE MATERIAL**
 - FOR INSIDE TOILET - CPVC (SDR-11) WITH SOLVENT CEMENT JOINTS
- THE WATER SUPPLY PIPE DIAMETER MENTION ON THE DRAWING IS NOMINAL BORE / ID.
- SOIL / WASTE / VENT / RAIN WATER PIPE MATERIAL**
 - UPTO 65 MM DIA PIPE (TOILET FLOOR) - UPVC (6 KG/SQ.CM.) AS PER IS : 4985 (SUITABLE FOR SOLVENT CEMENT JOINT)
 - 75/ 90/ 110/ 160 MM DIA PIPE (VERTICAL PIPE IN SHAFT) - UPVC (TYPE B) AS PER IS : 13592 & IS : 14735 (SUITABLE FOR RUBBER RING JOINT)
 - 75 / 110 MM DIA PIPE (UNDER TOILET FLOOR) - UPVC (TYPE B) AS PER IS:13592 & IS:14735 (SUITABLE FOR SOLVENT CEMENT JOINT)
 - 110/ 160 MM DIA PIPE (UNDER FLOOR FROM MH / CP TO MH / CP) - UPVC PIPE (SN-4) IS 16096 (Part - 1) or Part - 2) Foam Core / Hollow Core or PE DWC type
- ALL THE FLOOR TRAPS WHICH ARE DIRECTLY CONNECTED TO PIPE AND MANHOLE SHALL STRICTLY BE OF P TRAP TYPE WITH MIN. 50 MM SEAL.
- THE SUNKEN FLOOR OF TOILETS AND WET AREAS SHALL BE PROVIDED WITH WATER PROOFING TREATMENT, SLOPE AND A 32 M.M. G.I. SPOUT.
- THE SLOPE OF THE PIPES LAID UNDER TOILET FLOOR SHALL BE IN BETWEEN 1 IN 10 TO 1 IN 40.
- THE SLOPE OF TOILET FLOORS TOWARDS THE FLOOR TRAP SHALL BE 1 IN 40 (MINIMUM).
- THE SLOPE OF TERRACE FROM RIDGE LINE TOWARDS RAIN WATER PIPES SHALL BE 1 IN 100.
- 160 / 110 M.M. DIA. UPVC SLEEVES (TYPE B) SHALL BE PROVIDED IN TOILET / KITCHEN BEAMS BEFORE CASTING FOR SOIL / WASTE PIPES RESPECTIVELY.
- ALL SOIL & WASTE PIPES LAID UNDER TOILET / KITCHEN FLOOR SHALL BE COVERED AROUND WITH 75 M.M. C.C. (1 : 1.5 : 3)
- THE MOUNTING HEIGHT OF DIFFERENT APPLIANCES / TAPS SHALL BE AS UNDER
 - WALL MIXTURE (FOR BATHING) 915 M.M.
 - SHOWER 2030 M.M. / OR AS SPECIFIED
 - KITCHEN TAP / MIXTURE TABLE TOP /940 M.M.
 - HEALTH SPRAY 600 M.M.
 - ANGLE VALVE
 - FOR TOILET GEYSER 2250 M.M. / OR AS PER SITE
 - FOR KITCHEN GEYSER 1850 M.M. / OR AS PER SITE
 - FOR WASHING MACHINE 940M.M.
 - FOR WATER PURIFIER 1220 M.M.
 - HEALTH SPRAY (FOR W.C.) 350 M.M.
 - FOR CISTERN (FOR W.C.) 300 M.M.
 - FOR WASH BASIN 460 M.M.
 - FOR WASH BASIN (TOP OF RIM) 815 M.M.



Sanjay Goel

OWNERS NAME	
Ashiana housing Ltd. Unit no.4 & 5,Plot No.D-2,3rd Floor, Southern park, saket District Centre, Saket New Delhi - 110017 Phone no. 011- 42 65 42 65	
PROJECT :	
GULMOHAR GARDEN EXTENSION EWS BLOCK AT JAIPUR	
ARCHITECT	
b.sengupta architect A305,RANGOLI,ASHIANAVILLAGEBHIWADI. PH. - 09887488263	
Services Consultant :	
Consummate Engineering Services (P) Ltd. Noida Office : B - 67, Sector - 67, Noida - 201 301 Tel : (0120) 2303500 (30 Lines) Lko. Office : R 006, Rohtas Plumeria, Gomti Nagar, Lucknow. e mail : mail@cespl.in, website : www.cespl.in	
BUILDING TYPE	BLOCK - EWS
DRG. TITLE:	TOILET DETAIL
SCALE: 1:35	KEY IN:
DATE: January 2021	PLOTTED ON:
Drawn By : Anuj	Design By : Sanjay Goel
	Ckd By : Anand Havelia
ISSUED FOR:	G.F.C.
SHEET. NO.: EWS-A-02	

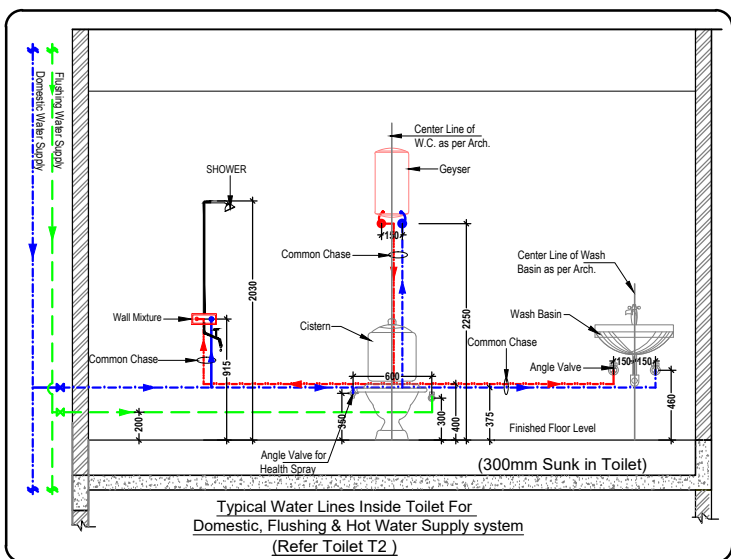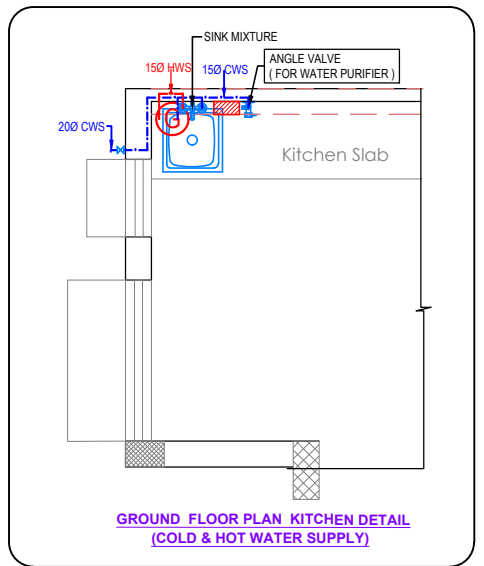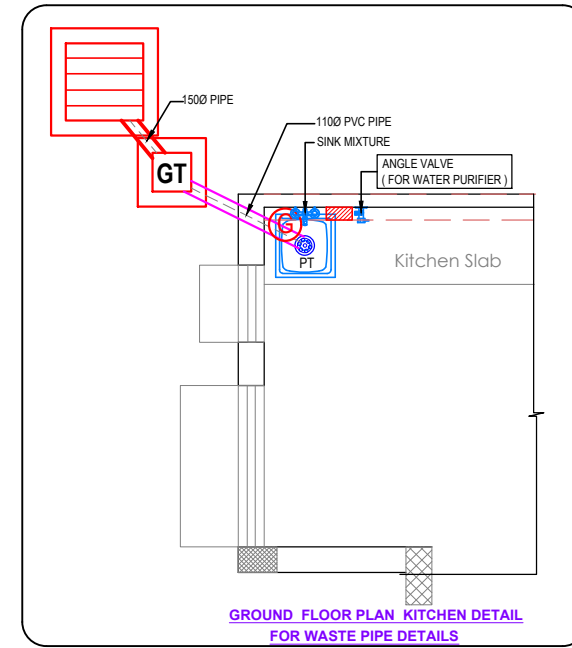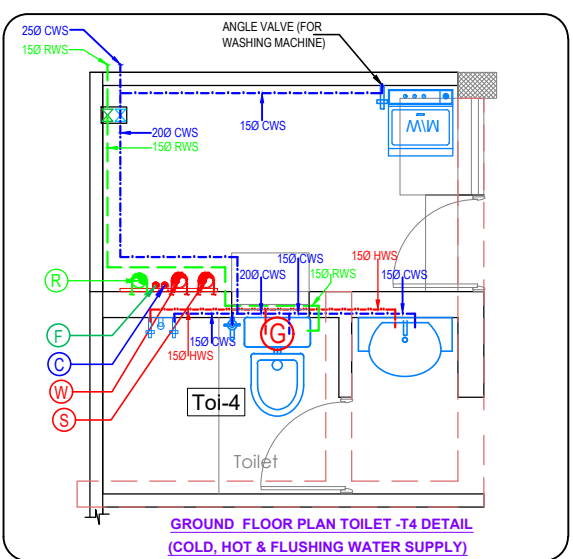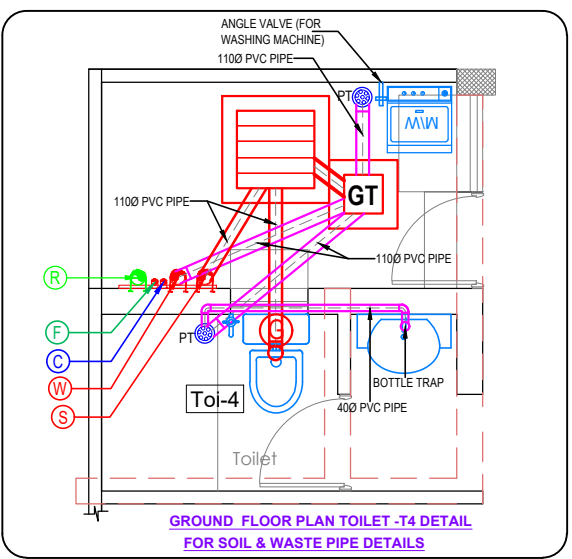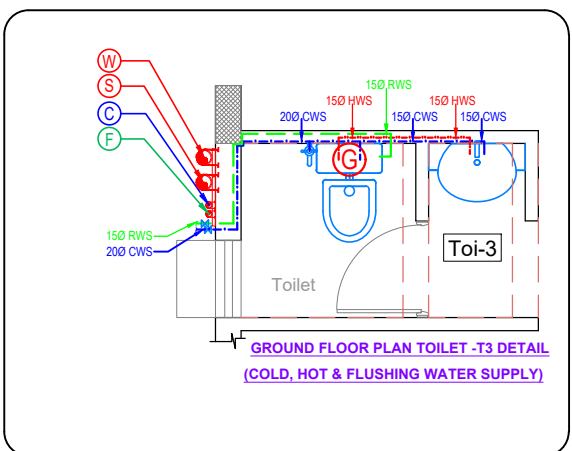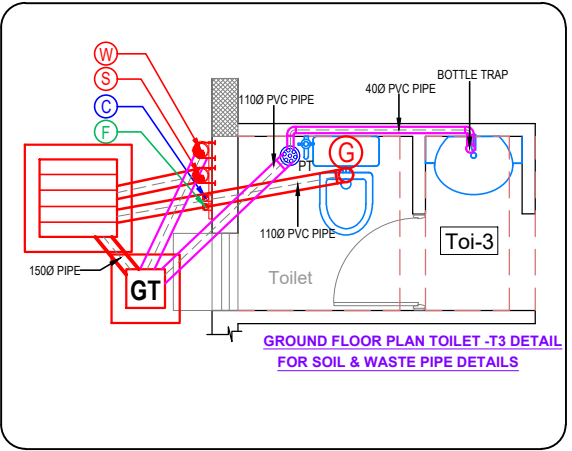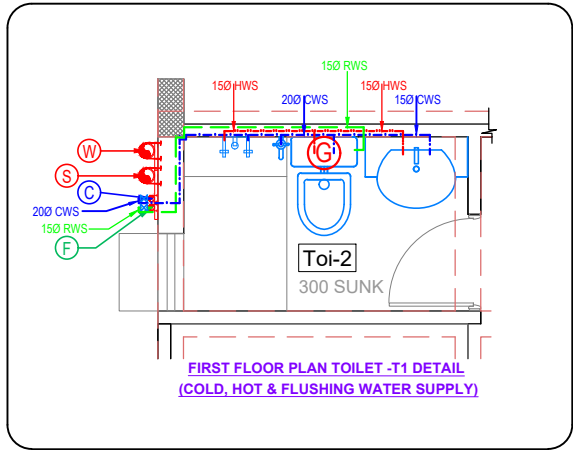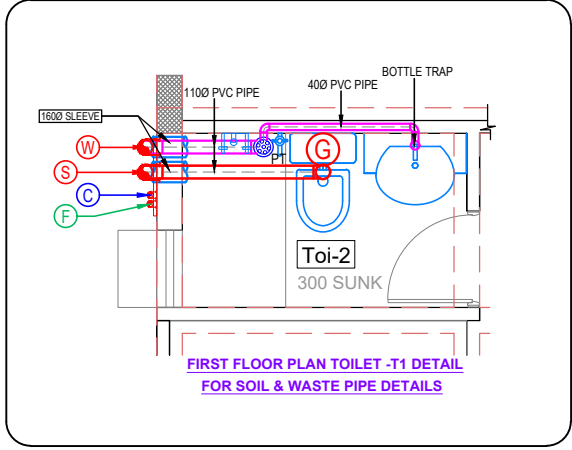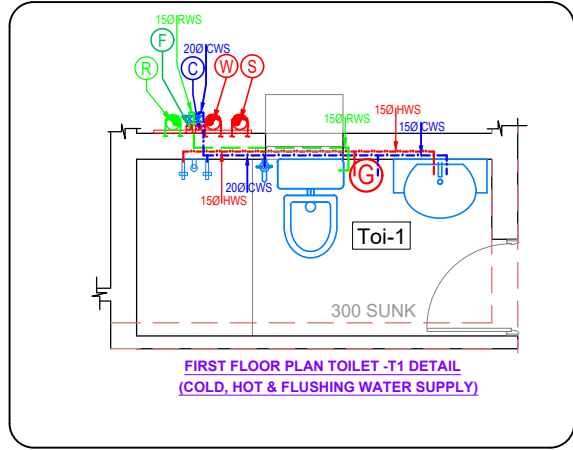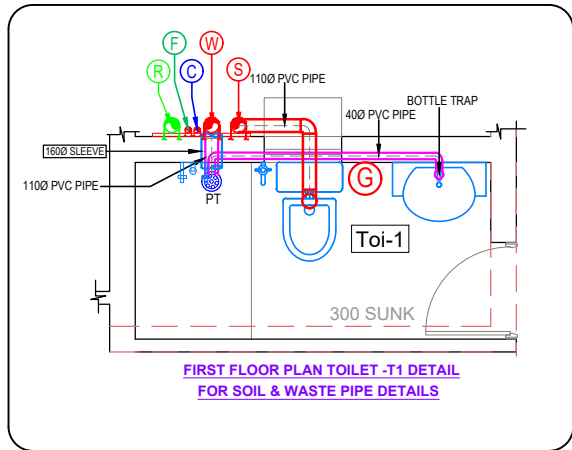

Sanjay Goel



- COLD WATER SUPPLY PIPE MATERIAL**
 - FOR INSIDE TOILET (DOMESTIC) - CPVC (SDR-11) WITH SOLVENT CEMENT JOINTS
 - FOR INSIDE TOILET (RECYCLE) - UPVC SCH 40 PIPES WITH SCH 80 FITTINGS BY SOLVENT CEMENT JOINT
- HOT WATER SUPPLY PIPE MATERIAL**
 - FOR INSIDE TOILET - CPVC (SDR-11) WITH SOLVENT CEMENT JOINTS
- THE WATER SUPPLY PIPE DIAMETER MENTION ON THE DRAWING IS NOMINAL BORE / ID.
- SOIL / WASTE / VENT / RAIN WATER PIPE MATERIAL**
 - UPTO 65 MM DIA PIPE (TOILET FLOOR) - UPVC (6 KG/SQ.CM.) AS PER IS : 4985 (SUITABLE FOR SOLVENT CEMENT JOINT)
 - 75/ 90/ 110/ 160 MM DIA PIPE (VERTICAL PIPE IN SHAFT) - UPVC (TYPE B) AS PER IS : 13592 & IS : 14735 (SUITABLE FOR RUBBER RING JOINT)
 - 75 / 110 MM DIA PIPE (UNDER TOILET FLOOR) - UPVC (TYPE B) AS PER IS:13592 & IS:14735 (SUITABLE FOR SOLVENT CEMENT JOINT)
 - 110/ 160 MM DIA PIPE (UNDER FLOOR FROM MH / CP TO MH / CP) - UPVC PIPE (SN-4) IS 16098 (Part- 1) or Part- 2) Foam Core / Hollow Core or PE DW type
- ALL THE FLOOR TRAPS WHICH ARE DIRECTLY CONNECTED TO PIPE AND MANHOLE SHALL STRICTLY BE OF P TRAP TYPE WITH MIN. 50 MM SEAL.
- THE SUNKEN FLOOR OF TOILETS AND WET AREAS SHALL BE PROVIDED WITH WATER PROOFING TREATMENT, SLOPE AND A 32 M.M. G.I. SPOUT.
- THE SLOPE OF THE PIPES LAID UNDER TOILET FLOOR SHALL BE IN BETWEEN 1 IN 10 TO 1 IN 40.
- THE SLOPE OF TOILET FLOORS TOWARDS THE FLOOR TRAP SHALL BE 1 IN 40 (MINIMUM).
- THE SLOPE OF TERRACE FROM RIDGE LINE TOWARDS RAIN WATER PIPES SHALL BE 1 IN 100.
- 160 / 110 M.M. DIA. UPVC SLEEVES (TYPE B) SHALL BE PROVIDED IN TOILET / KITCHEN BEAMS BEFORE CASTING FOR SOIL / WASTE PIPES RESPECTIVELY.
- ALL SOIL & WASTE PIPES LAID UNDER TOILET / KITCHEN FLOOR SHALL BE COVERED AROUND WITH 75 M.M. C.C. (1 : 1.5 : 3)
- THE MOUNTING HEIGHT OF DIFFERENT APPLIANCES / TAPS SHALL BE AS UNDER

a) WALL MIXTURE (FOR BATHING)	915 M.M.
b) SHOWER	2030 M.M. / OR AS SPECIFIED
c) KITCHEN TAP / MIXTURE	TABLE TOP /940 M.M.
d) HEALTH SPRAY	600 M.M.
e) ANGLE VALVE	
i) FOR TOILET GEYSER	2250 M.M. / OR AS PER SITE
ii) FOR KITCHEN GEYSER	1850 M.M. / OR AS PER SITE
iii) FOR WASHING MACHINE	940M.M.
iv) FOR WATER PURIFIER	1220 M.M.
v) HEALTH SPRAY (FOR W.C.)	350 M.M.
vi) FOR CISTERN (FOR W.C.)	300 M.M.
vii) FOR WASH BASIN	460 M.M.
f) FOR WASH BASIN (TOP OF RIM)	815 M.M.

LEGEND : (Plumbing)

S. No.	SYMBOL	DESCRIPTION
1.	(S)	110 Ø PVC SOIL AND VENT PIPE
2.	(W)	75 Ø PVC WASTE AND VENT PIPE
3.	(R)	110 Ø PVC RAIN WATER PIPE
4.	(C)	WATER SUPPLY RISER TO TOILET / KITCHEN WATER LINE TO TOILET / KITCHEN
5.	(F)	RECYCLE WATER SUPPLY RISER
6.	(G)	GEYSER
7.	---	COLD WATER SUPPLY PIPE (CWS)
8.	---	RECYCLE WATER SUPPLY PIPE (R.W.S.)
9.	---	ISOLATING VALVE
10.	PT	P TRAP
11.	DP	DRAIN POINT
12.	W.P.	WATER PURIFIER
13.	W.M.	WASHING MACHINE
14.	G.T.	GULLY TRAP
15.	M.H.	MANHOLE
16.	AV	ANGLE VALVE

Rev	Date	Description
OWNERS NAME		
ashiana housing ltd.		
Unit no.4 & 5,Plot No.D-2,3rd Floor, Southern park, saket District Centre, Saket New Delhi - 110017 Phone no. 011- 42 65 42 65		
PROJECT :		
GULMOHAR GARDEN EXTENSION LIG BLOCK AT JAIPUR		
ARCHITECT		
b.sengupta architect		
A305,RANGOLI,ASHIANAVILLAGEBHIWADI. PH . 09887488263		
Services Consultant :		
Consummate Engineering Services (P) Ltd.		
Noida Office : B - 67, Sector - 67, Noida - 201 301 Tel : (0120) 2303500 (30 Lines) Lko. Office : R 006, Rohtas Plumeria, Gomti Nagar, Lucknow . e mail : mail@cespl.in, website : www.cespl.in		
BUILDING TYPE	BLOCK - LIG	SHEET. NO.:
DRG. TITLE:	TOILET DETAIL	
SCALE: 1:30	KEY IN:	
DATE: January 2021	PLOTTED ON:	
Drawn By : Anuj	Design By : Sanjay Goel	Ckd By : Anand Havelia
ISSUED FOR:	G.F.C.	

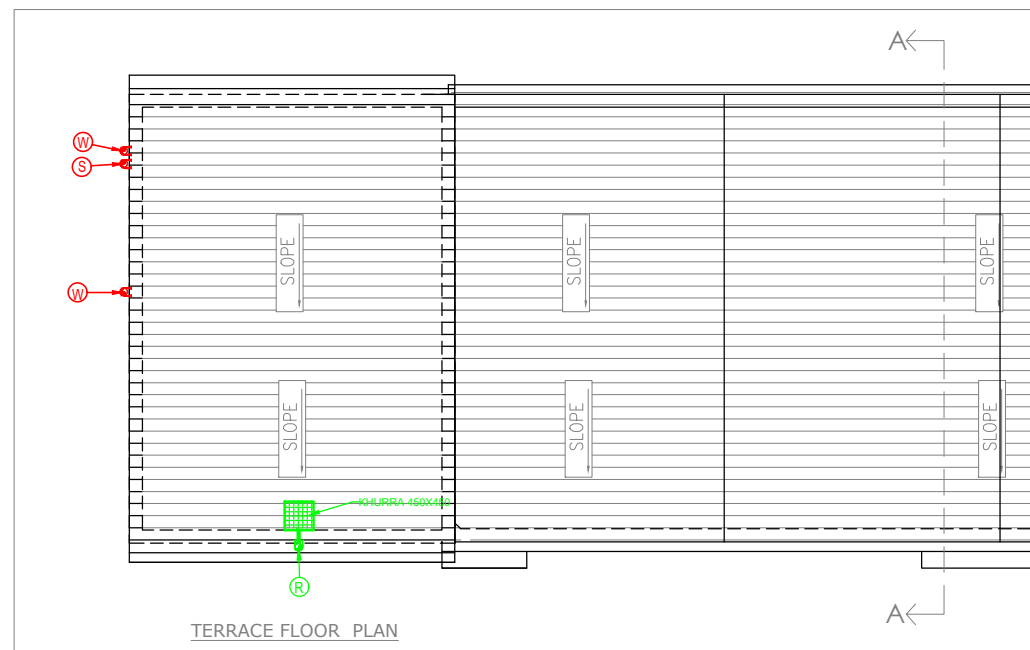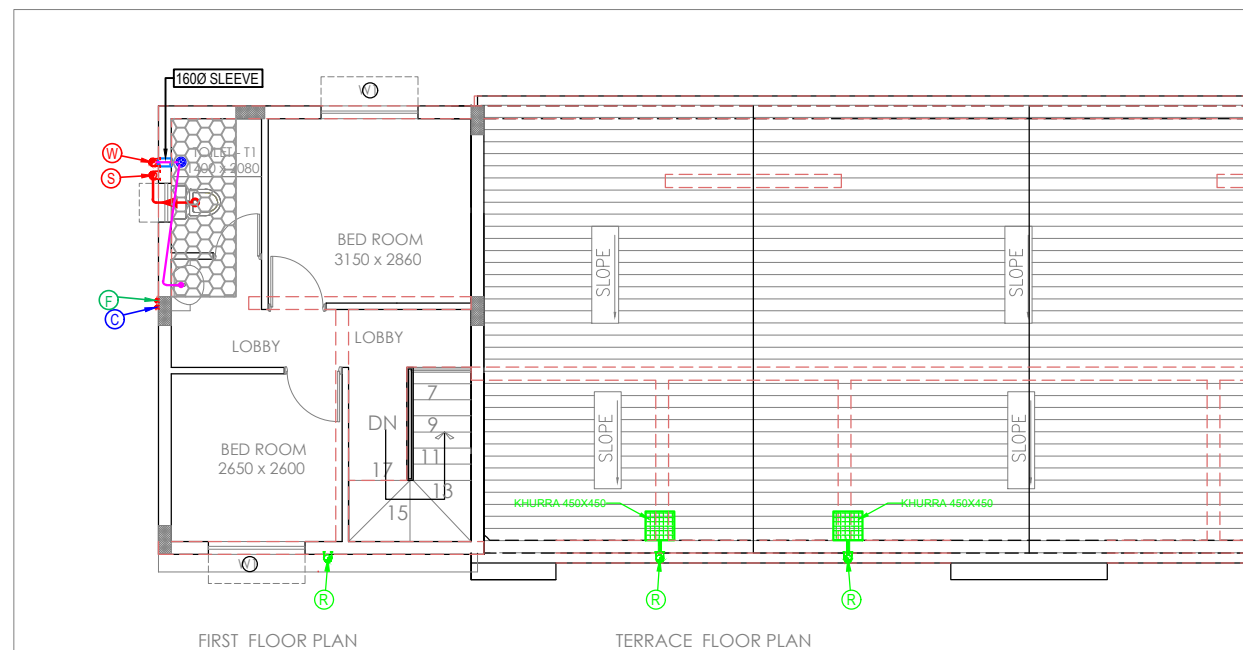

S. No.	SYMBOL	DESCRIPTION
1.		110 Ø PVC SOIL AND VENT PIPE
2.		75 Ø PVC WASTE AND VENT PIPE
3.		110 Ø PVC RAIN WATER PIPE
4.		WATER SUPPLY RISER TO TOILET / KITCHEN WATER LINE TO TOILET / KITCHEN
5.		RECYCLE WATER SUPPLY RISER
6.		GEYSER
7.		COLD WATER SUPPLY PIPE (CWS)
8.		RECYCLE WATER SUPPLY PIPE (R.W.S.)
9.		SOLAR WATER SUPPLY PIPE (SWS)
10.		ISOLATING VALVE
11.		P TRAP
12.		DRAIN POINT
13.		WATER PURIFIER
14.		WASHING MACHINE
15.		GULLY TRAP
16.		MANHOLE
17.		ANGLE VALVE
18.	G.L.	GROUND LEVEL
19.	I.L.	INVERT LEVEL
20.	C.L.	CONNECTION LEVEL

- | | |
|---|---|
| 1. <u>COLD WATER SUPPLY PIPE MATERIAL</u> | |
| a) FOR INSIDE TOILET (DOMESTIC) - | CPVC (SDR-11) WITH SOLVENT CEMENT JOINTS |
| b) FOR INSIDE TOILET (RECYCLE) - | UPVC SCH 40 PIPES WITH SCH 80 FITTINGS BY SOLVENT CEMENT JOINT |
| 2. <u>HOT WATER SUPPLY PIPE MATERIAL</u> | |
| a) FOR INSIDE TOILET - | CPVC (SDR-11) WITH SOLVENT CEMENT JOINTS |
| 3. THE WATER SUPPLY PIPE DIAMETER MENTION ON THE DRAWING IS NOMINAL BORE / I.D. | |
| 4. <u>SOIL / WASTE / VENT / RAIN WATER PIPE MATERIAL</u> | |
| a) UPTO 65 MM DIA PIPE (TOILET FLOOR) - | UPVC (6 KG/SQ.CM.)
AS PER IS : 4985 (SUITABLE FOR SOLVENT CEMENT JOINT) |
| b) 75/ 90/ 110/ 160 MM DIA PIPE (VERTICAL PIPE IN SHAFT) - | UPVC (TYPE B)
AS PER IS : 13592 & IS : 14735 (SUITABLE FOR RUBBER RING JOINT) |
| c) 75 / 110 MM DIA PIPE (UNDER TOILET FLOOR) - | UPVC (TYPE B)
AS PER IS : IS:14735 (SUITABLE FOR SOLVENT CEMENT JOINT) |
| d) 110/ 160 MM DIA PIPE (UNDER FLOOR FROM MH / CP TO MH / CP) - | UPVC PIPE (SN-4) IS 16098 (Part - 1) or (Part - 2) Foam Core / Hollow Core or PE DWC type |
| 5. ALL THE FLOOR TRAPS WHICH ARE DIRECTLY CONNECTED TO PIPE AND MANHOLE SHALL STRICTLY BE OF P TRAP TYPE WITH MIN. 50 MM SEAL. | |
| 6. THE SUNKEN FLOOR OF TOILETS AND WET AREAS SHALL BE PROVIDED WITH WATER PROOFING TREATMENT, SLOPE AND A 32 M.M. G.I. SPOUT. | |
| 7. THE SLOPE OF THE PIPES LAID UNDER TOILET FLOOR SHALL BE IN BETWEEN 1 IN 10 TO 1 IN 40. | |
| 8. THE SLOPE OF TOILET FLOORS TOWARDS THE FLOOR TRAP SHALL BE 1 IN 40 (MINIMUM). | |
| 9. THE SLOPE OF TERRACE FROM RIDGE LINE TOWARDS RAIN WATER PIPES SHALL BE 1 IN 100. | |
| 10. 160 / 110 M.M. DIA. UPVC SLEEVES (TYPE B) SHALL BE PROVIDED IN TOILET / KITCHEN BEAMS BEFORE CASTING FOR SOIL / WASTE PIPES RESPECTIVELY. | |
| 11. ALL SOIL & WASTE PIPES LAID UNDER TOILET / KITCHEN FLOOR SHALL BE COVERED AROUND WITH 75 M.M. C.C. (1 : 1.5 : 3) | |
| 12. <u>THE MOUNTING HEIGHT OF DIFFERENT APPLIANCES / TAPS SHALL BE AS UNDER</u> | |
| a) WALL MIXTURE (FOR BATHING) | 915 M.M. |
| b) SHOWER | 2030 M.M. / OR
AS SPECIFIED |
| c) KITCHEN TAP / MIXTURE | TABLE TOP /940 M.M. |
| d) HEALTH SPRAY | 600 M.M. |
| e) ANGLE VALVE | |
| i) FOR TOILET GEYSER | 2250 M.M. / OR
AS PER SITE |
| ii) FOR KITCHEN GEYSER | 1850 M.M. / OR
AS PER SITE |
| iii) FOR WASHING MACHINE | 940M.M. |
| iv) FOR WATER PURIFIER | 1220 M.M. |
| v) HEALTH SPRAY (FOR W.C.) | 350 M.M. |
| vi) FOR CISTERN (FOR W.C.) | 300 M.M. |
| vii) FOR WASH BASIN | 460 M.M. |
| f) FOR WASH BASIN (TOP OF RIM) | 815 M.M. |

[illegible]

	OWNERS NAME	

ashiana housing ltd.

Unit no.4 & 5,Plot No.D-2,3rd Floor,
Southern park, saket District Centre,
Saket New Delhi - 110017
Phone no. 011- 42 65 42 65

PROJECT :	
-----------	--

GULMOHAR GARDEN EXTENSION
LIG BLOCK AT JAIPUR

ARCHITECT

b.sengupta architect

A305,RANGOLI,ASHIANAVILLAGEBHIWADI.
PH . 09887488263

Services Consultant :

Consummate Engineering Services (P) Ltd
--

Noida Office : B - 67, Sector - 67, Noida - 201 301

cespi Tel : (0120) 2303500 (30 Lines)
 Lko. Office : B-006, Rohtas Bhumeria, Gombi Na

EXO: Office : K-000, Kailash Flaminia, Gomti Nagar,
Lucknow.
e-mail : mail@exo.in website : www.exo.in

e mail : mail@cespi.in, website : www.cespi.in

BUILDING	SHEET. NO
----------	-----------

BUILDING TYPE	BLOCK - EWS	EWS-A-C
------------------	-------------	---------

FILE		EW5790
------	--	--------

DDC TITLE:	GROUND, FIRST &
------------	-----------------

DRG. TITLE: TERRACE FLOOR PLAN

[illegible]

SCALE: 1:60	KEY IN:
-------------	---------

DATE.: January 2021	PLOTTED ON:
---------------------	-------------

Drawn By :	Design By :	Ckd By :

Varghese	Sanjay Goel	Anand Havel
----------	-------------	-------------

ISSUED FOR:	G.E.C.
-------------	--------