


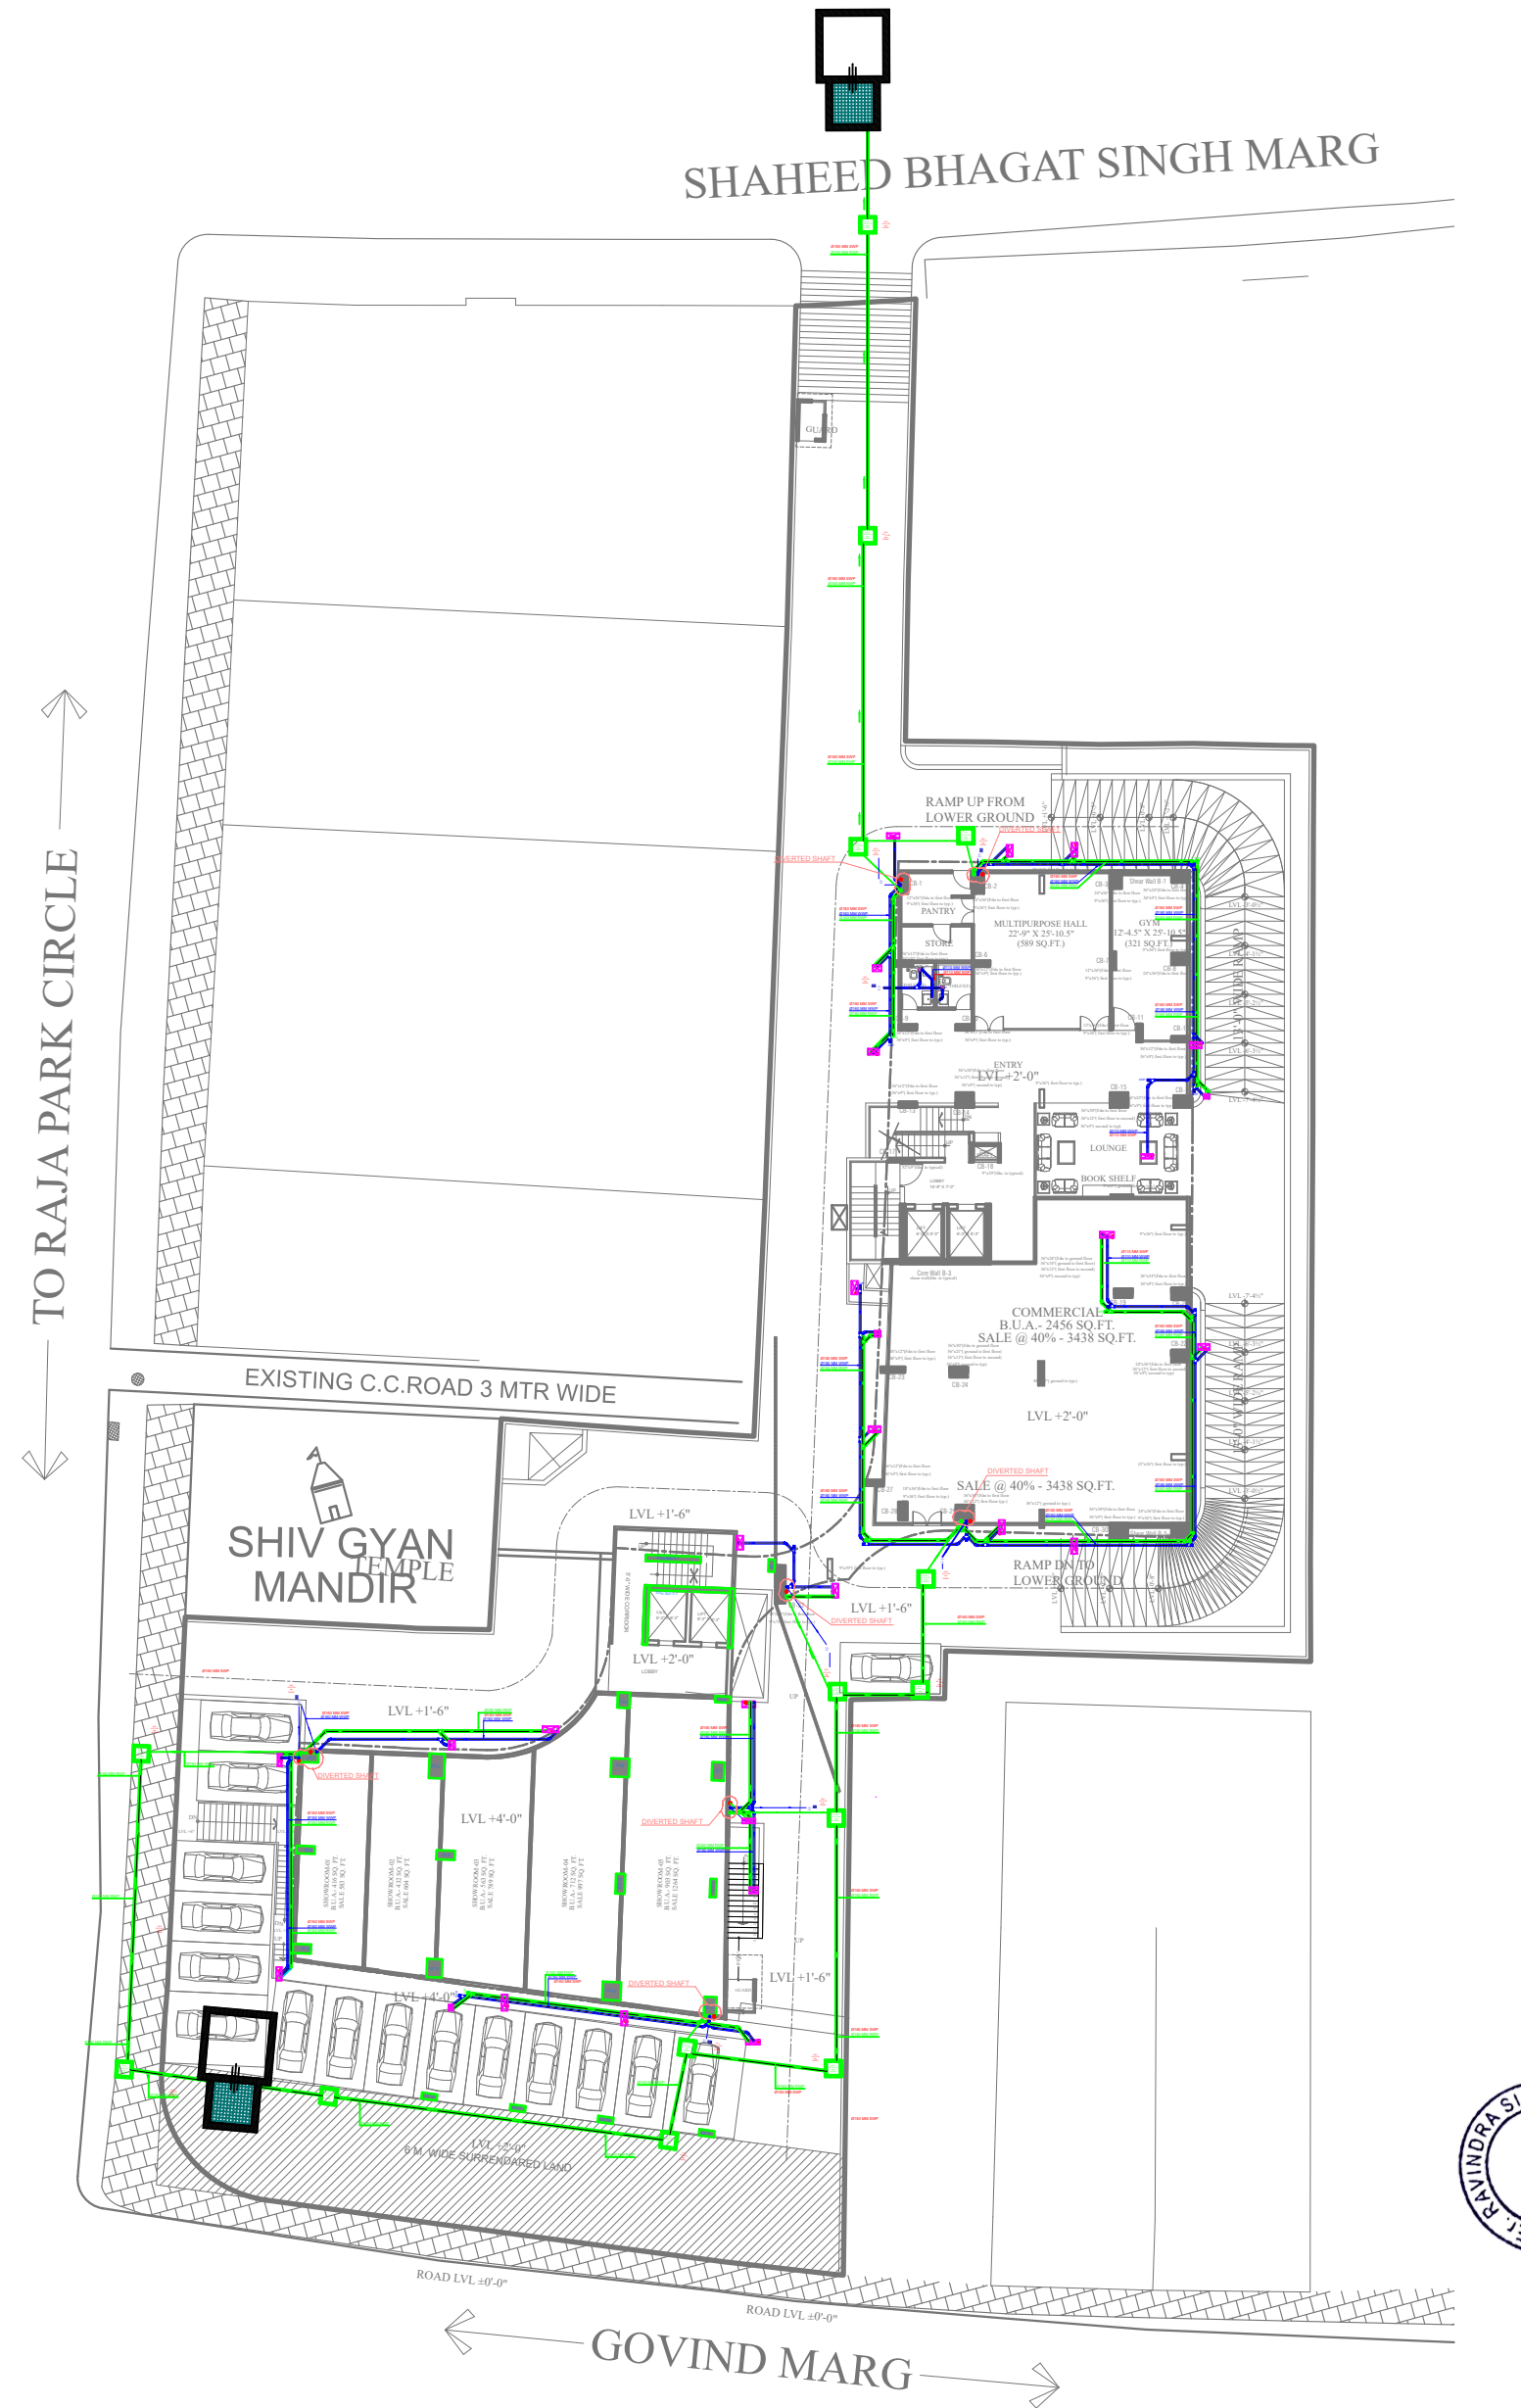

GROUND FLOOR PLAN

ARCHITECT



124, HIMMAT NAGAR , TONK ROAD, JAIPUR
PHONE - 0141-2706227,2712377
email: ideasjaipur@gmail.com, web: www.ideasjaipur.com

MEP CONSULTANT :



53 & 54, 2nd Floor Jaipur Electronic Market,
Ridhi Sidhi Circle, Gopal pura by Pass Road ,
Jaipur (Raj)
Ph:- 8696311408, 9971998408
Email:- ravisingira72@gmail.com ;
ravi@jrsquareengineers.com

LEGENDS:-

MOUNTING HT	QTY	SYMBOL	DESCREPTION
BELOW GROUND			110 MM & 160 MM SOIL WATER SUPPLY
BELOW GROUND			110 MM & 160 MM RAIN WATER SUPPLY
BELOW GROUND			110 MM & 160 MM WASTE WATER SUPPLY
BELOW GROUND	4		G.T 350 MM X 350 MM
BELOW GROUND	5		R . W . C 650 MM X 650 MM
BELOW GROUND	4		M . H. 650 MM X 650 MM
			SOIL WATER PIPE
			RAIN WATER PIPE
			WASTE WATER PIPE

ABBREVIATION DETAIL

SWP	SOIL WATER PIPE
RWP	RAIN WATER PIPE
WWP	WASTE WATER PIPE
MH	MAN HOLE
GT	GULLY TRAP
RWC	RAIN WATER CHAMBER

PMC CONSULTANT :

NOTES :-

- 1) THIS DRAWING IS PROPERTY OF IDEAS. JAIPUR
- 2) UNAUTHORIZED USE OF THIS DRAWING WITHOUT PERMISSION IS STRICTLY PROHIBITED.
- 3) ALL DIMENSIONS ARE IN FEET AND INCHES, UNLESS NOTED OTHERWISE.
- 4) ANY DISCREPANCY ARISING SHOULD BE INFORMED TO THE ARCHITECT IMMEDIATELY.


NOS.	DATE	PRINT ISSUED TO

REVISIONS:-

S.No.	DATE	REMARKS

KEY PLAN :-

NORTH :-

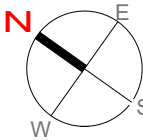

PROJECT:-	PLOT NO. 16.GOVIND MARG ADARSH NAGAR,RAJA PARK JAIPUR
-----------	---

CLIENT:- MANGALAM

DRAWING TITLE BLISS & SOUL TOWER GROUND FLOOR RAINWATER HARVESTING PLAN

DATE:- 22-11-22	
CHECKED BY:- RAVI	
DEALT BY:- AVI	DRG.NO.
DRAWN BY:- AARIF	JPS/BLISS SOUL /GROUND FLOOR/DRG-1