



L. G.F. KIOSK METER PANEL-1

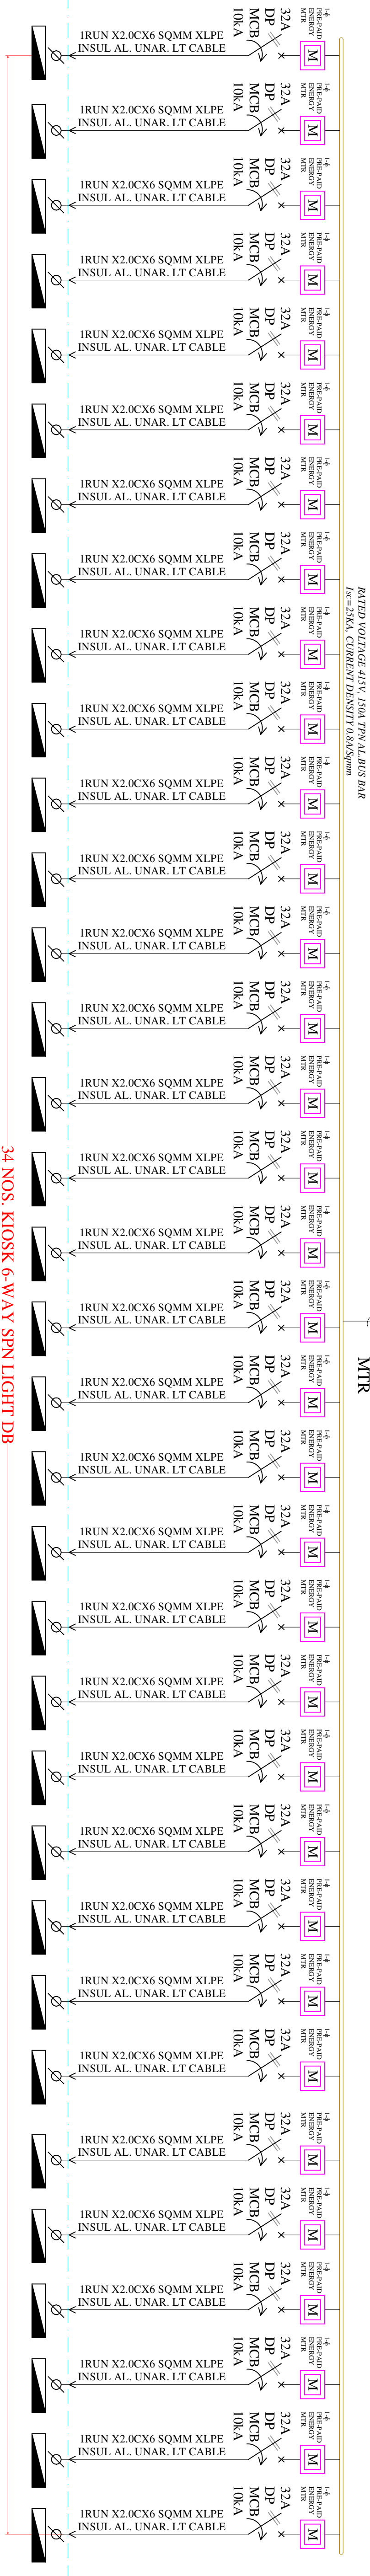

L. G.F. KIOSK METER PANEL-2

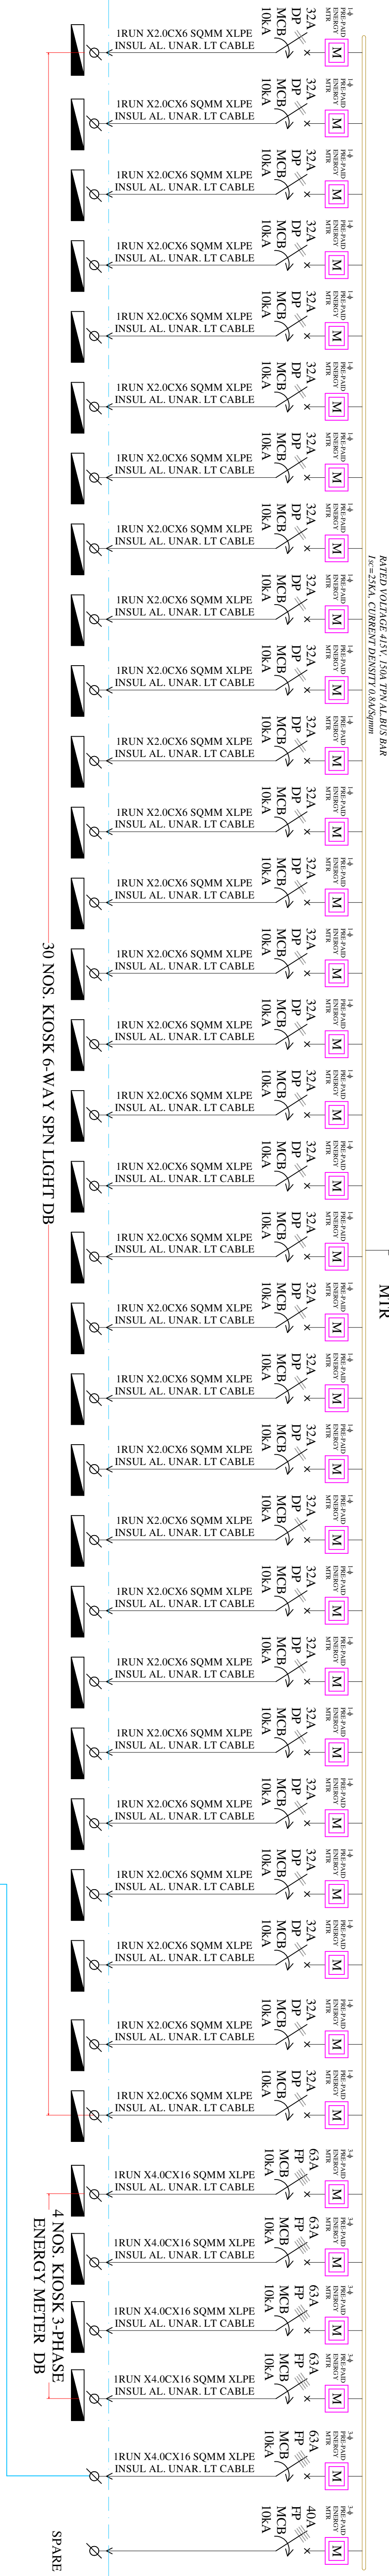

SERVICES CONSULTANT:
VIPUL CONSULTING
F 9-440, KESHAV MARG,
CHITRAKUT SCHEME, JAIPUR
PH:93146-10438,2440946
E MAIL: vipul8599@yahoo.com

PROJECT:
ANUKAMPA SODALA

TITLE:
LOWER GROUND FLOOR PANEL


DRAWING:
SINGLE LINE DIAGRAM

DATE:-
19-12-2020

REV:-
00

DRAWN BY:-
VICKY YADAV

CHECKED BY :-
VIPUL AGRAWAL

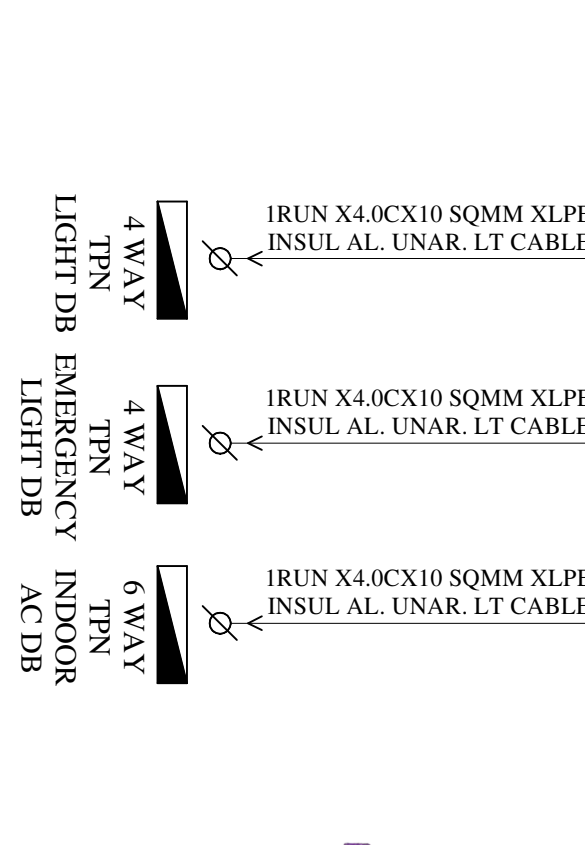

SERVICES CONSULTANT:
VIPUL CONSULTING
F 9-440, KESHAV MARG,
CHITRAKUT SCHEME, JAIPUR
PH:93146-10438,2440946
E MAIL:vipul8599@yahoo.com

PROJECT:
ANUKAMPA SODALA

TITLE:
1ST FLOOR & 1ST TO 3RD PANEL

DRAWING:
SINGLE LINE DIAGRAM



DATE:-
19-12-2020

REV:-
00

DRAWN BY:-
VICKY YADAV

CHECKED BY :-
VIPUL AGRAWAL

Vipul
VIPUL AGRAWAL
M.E.P. CONSULTANT
B.E. ELECTRICAL

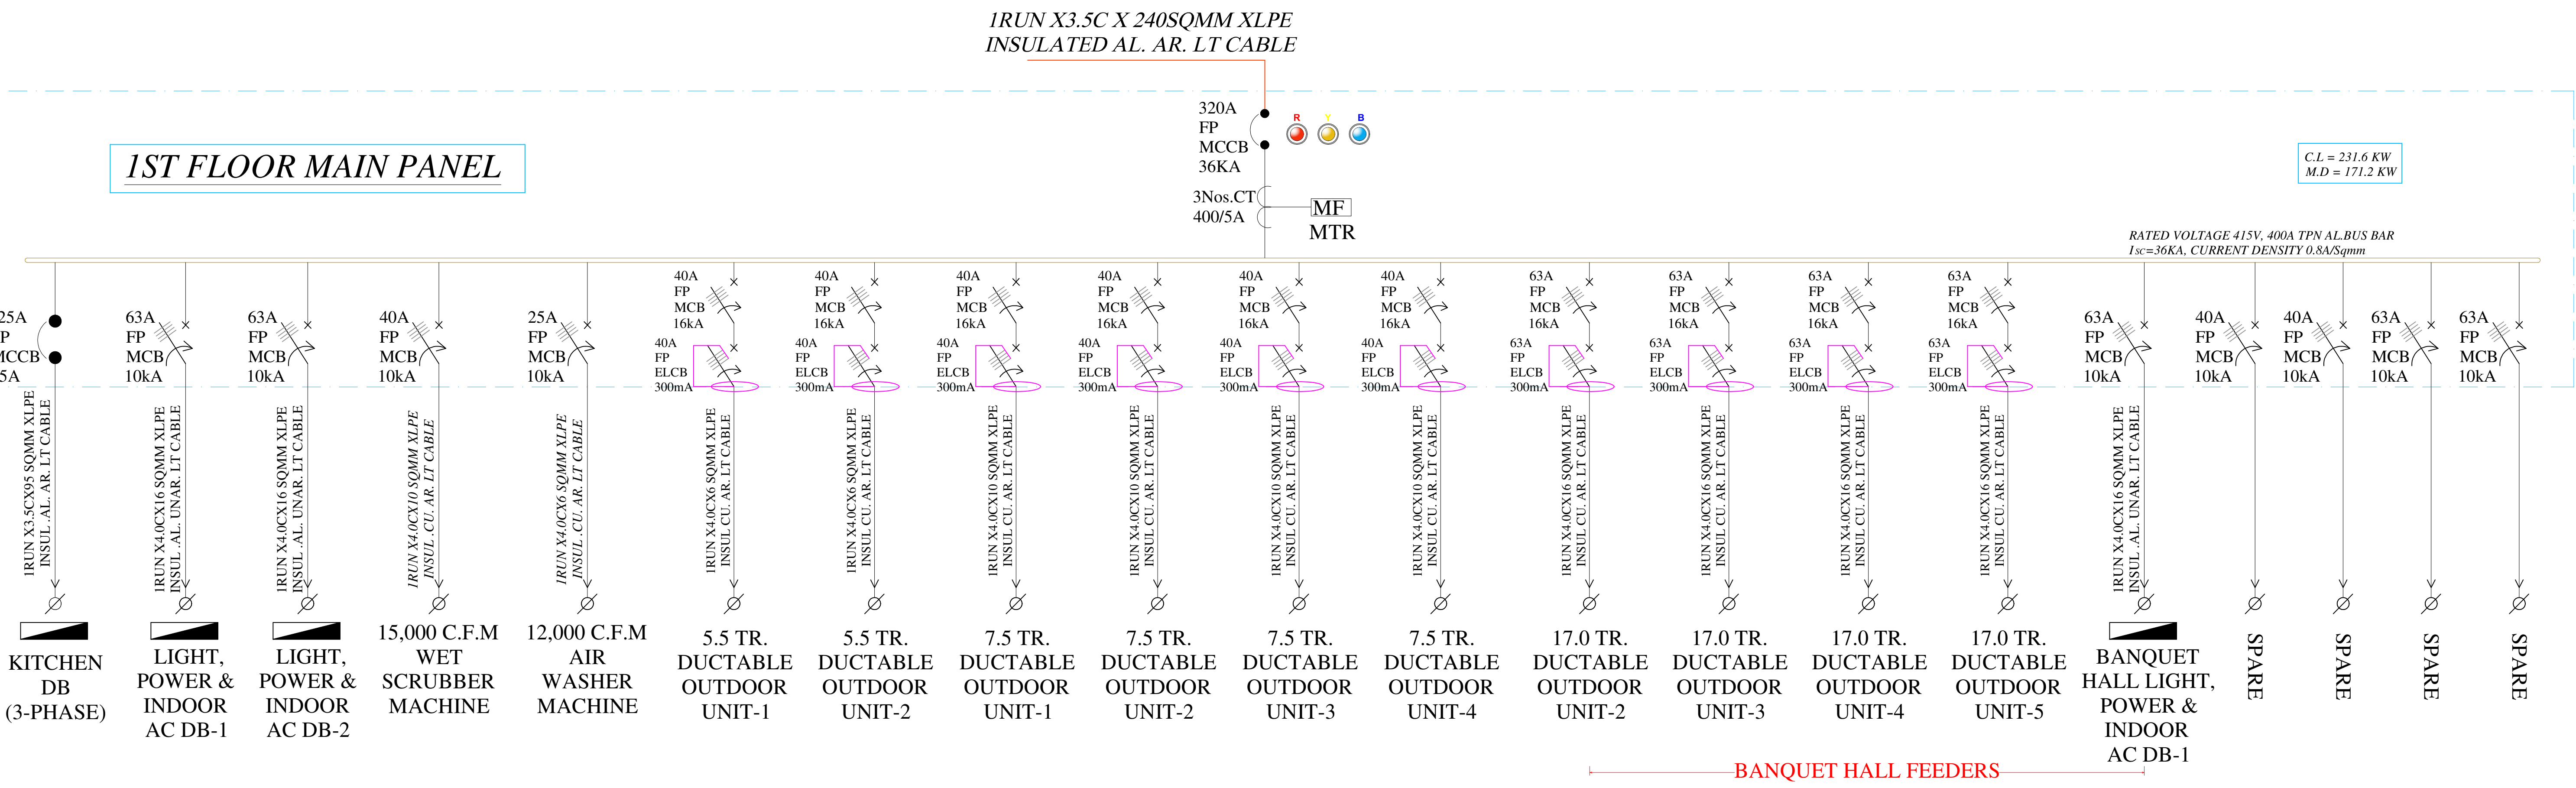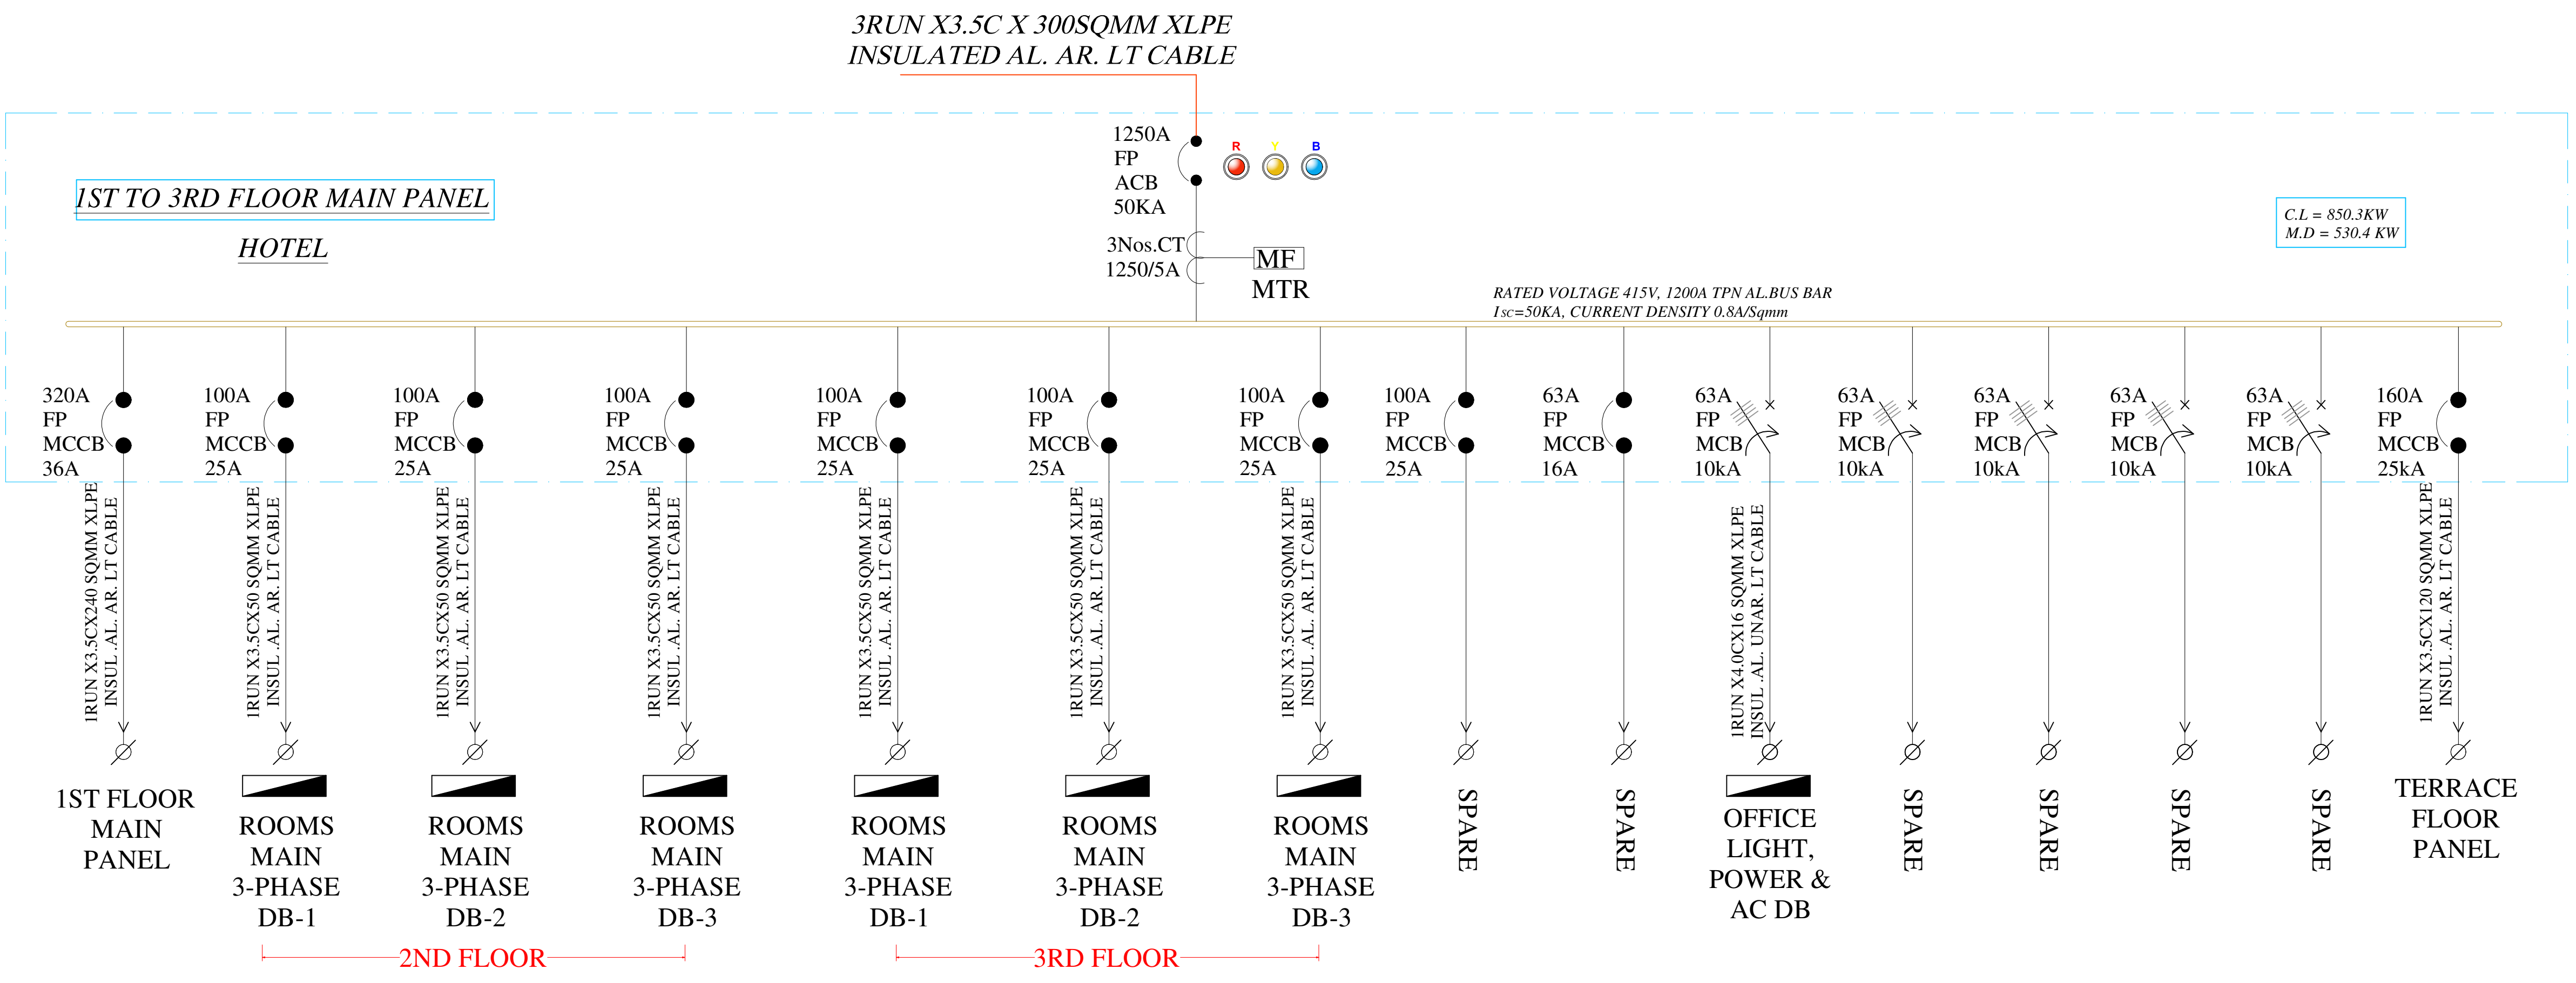

IRUN X3.5CX160SQMM XLPE
INSULATED AL. AR. LT CABLE

Vipul
VIPUL AGARWAL
M.E.P. CONSULTANT
B.E. ELECTRICAL

SERVICES CONSULTANT:
VIPUL CONSULTING
F-9-440, KESHAV MARG,
CHITRAKUT SCHEME, JAIPUR
PH:93146-10438,2440946
E MAIL: vipul8599@yahoo.com

PROJECT: ANUKAMPA SODALA

TITLE: 4TH TO 11TH FLOOR PANEL

DRAWING: SINGLE LINE DIAGRAM

DATE:- 19-12-2020 REV:- 00


DRAWN BY:-

VICKY YADAV

CHECKED BY :-


VIPUL AGRAWAL

4TH FLOOR ENERGY METER PANEL-1
TYPICAL 7 NOS. PANEL REQUIRED FOR
4TH TO 10TH FLOOR

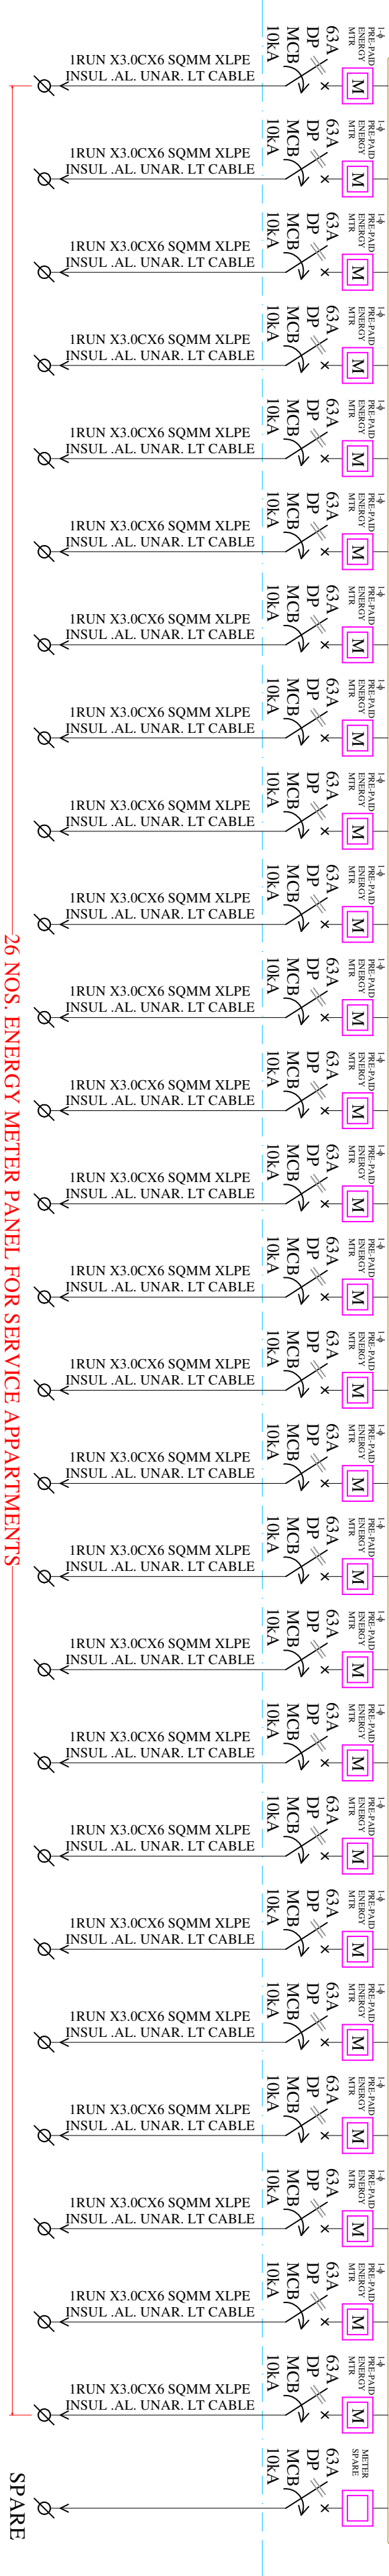

IRUN X3.5CX240SQMM XLPE
INSULATED AL. AR. LT CABLE

11TH FLOOR ENERGY METER PANEL

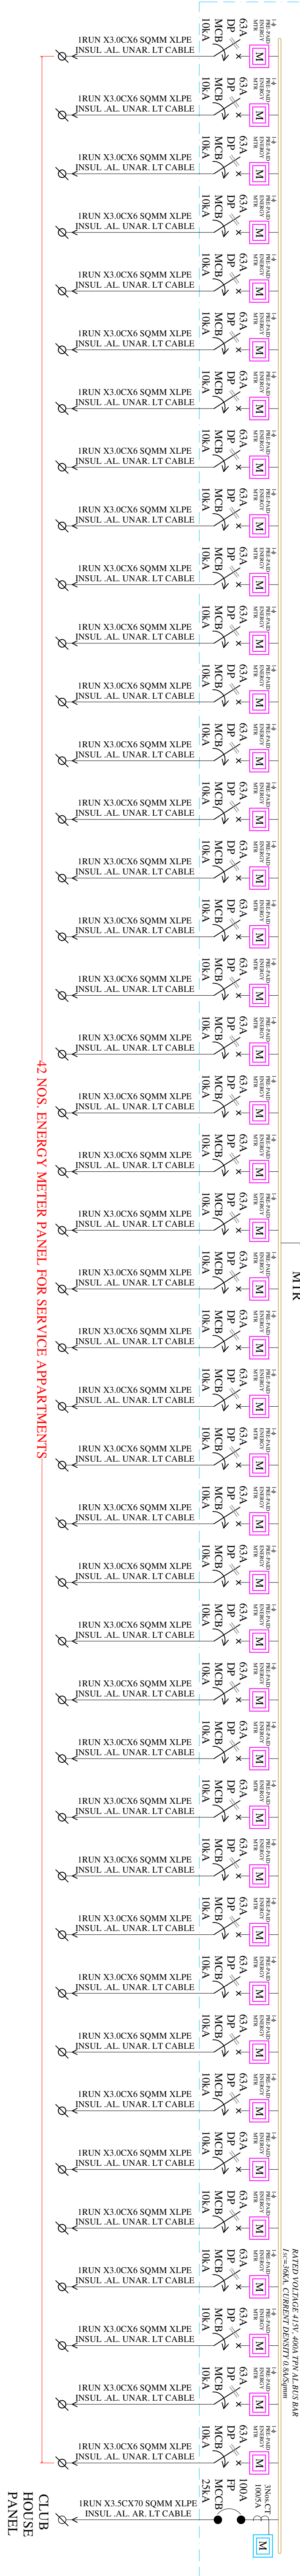

CL-125x75W
M.D = 138 KW

CLUB
HOUSE
PANEL