

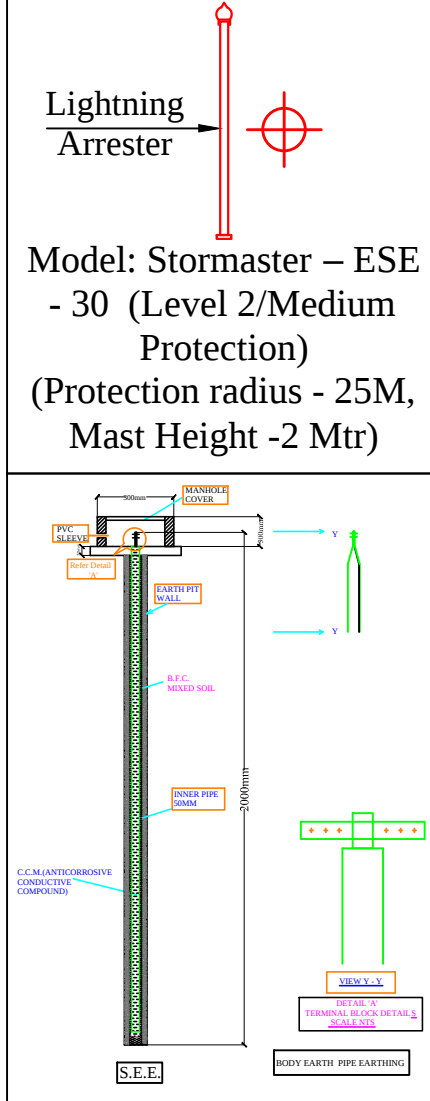


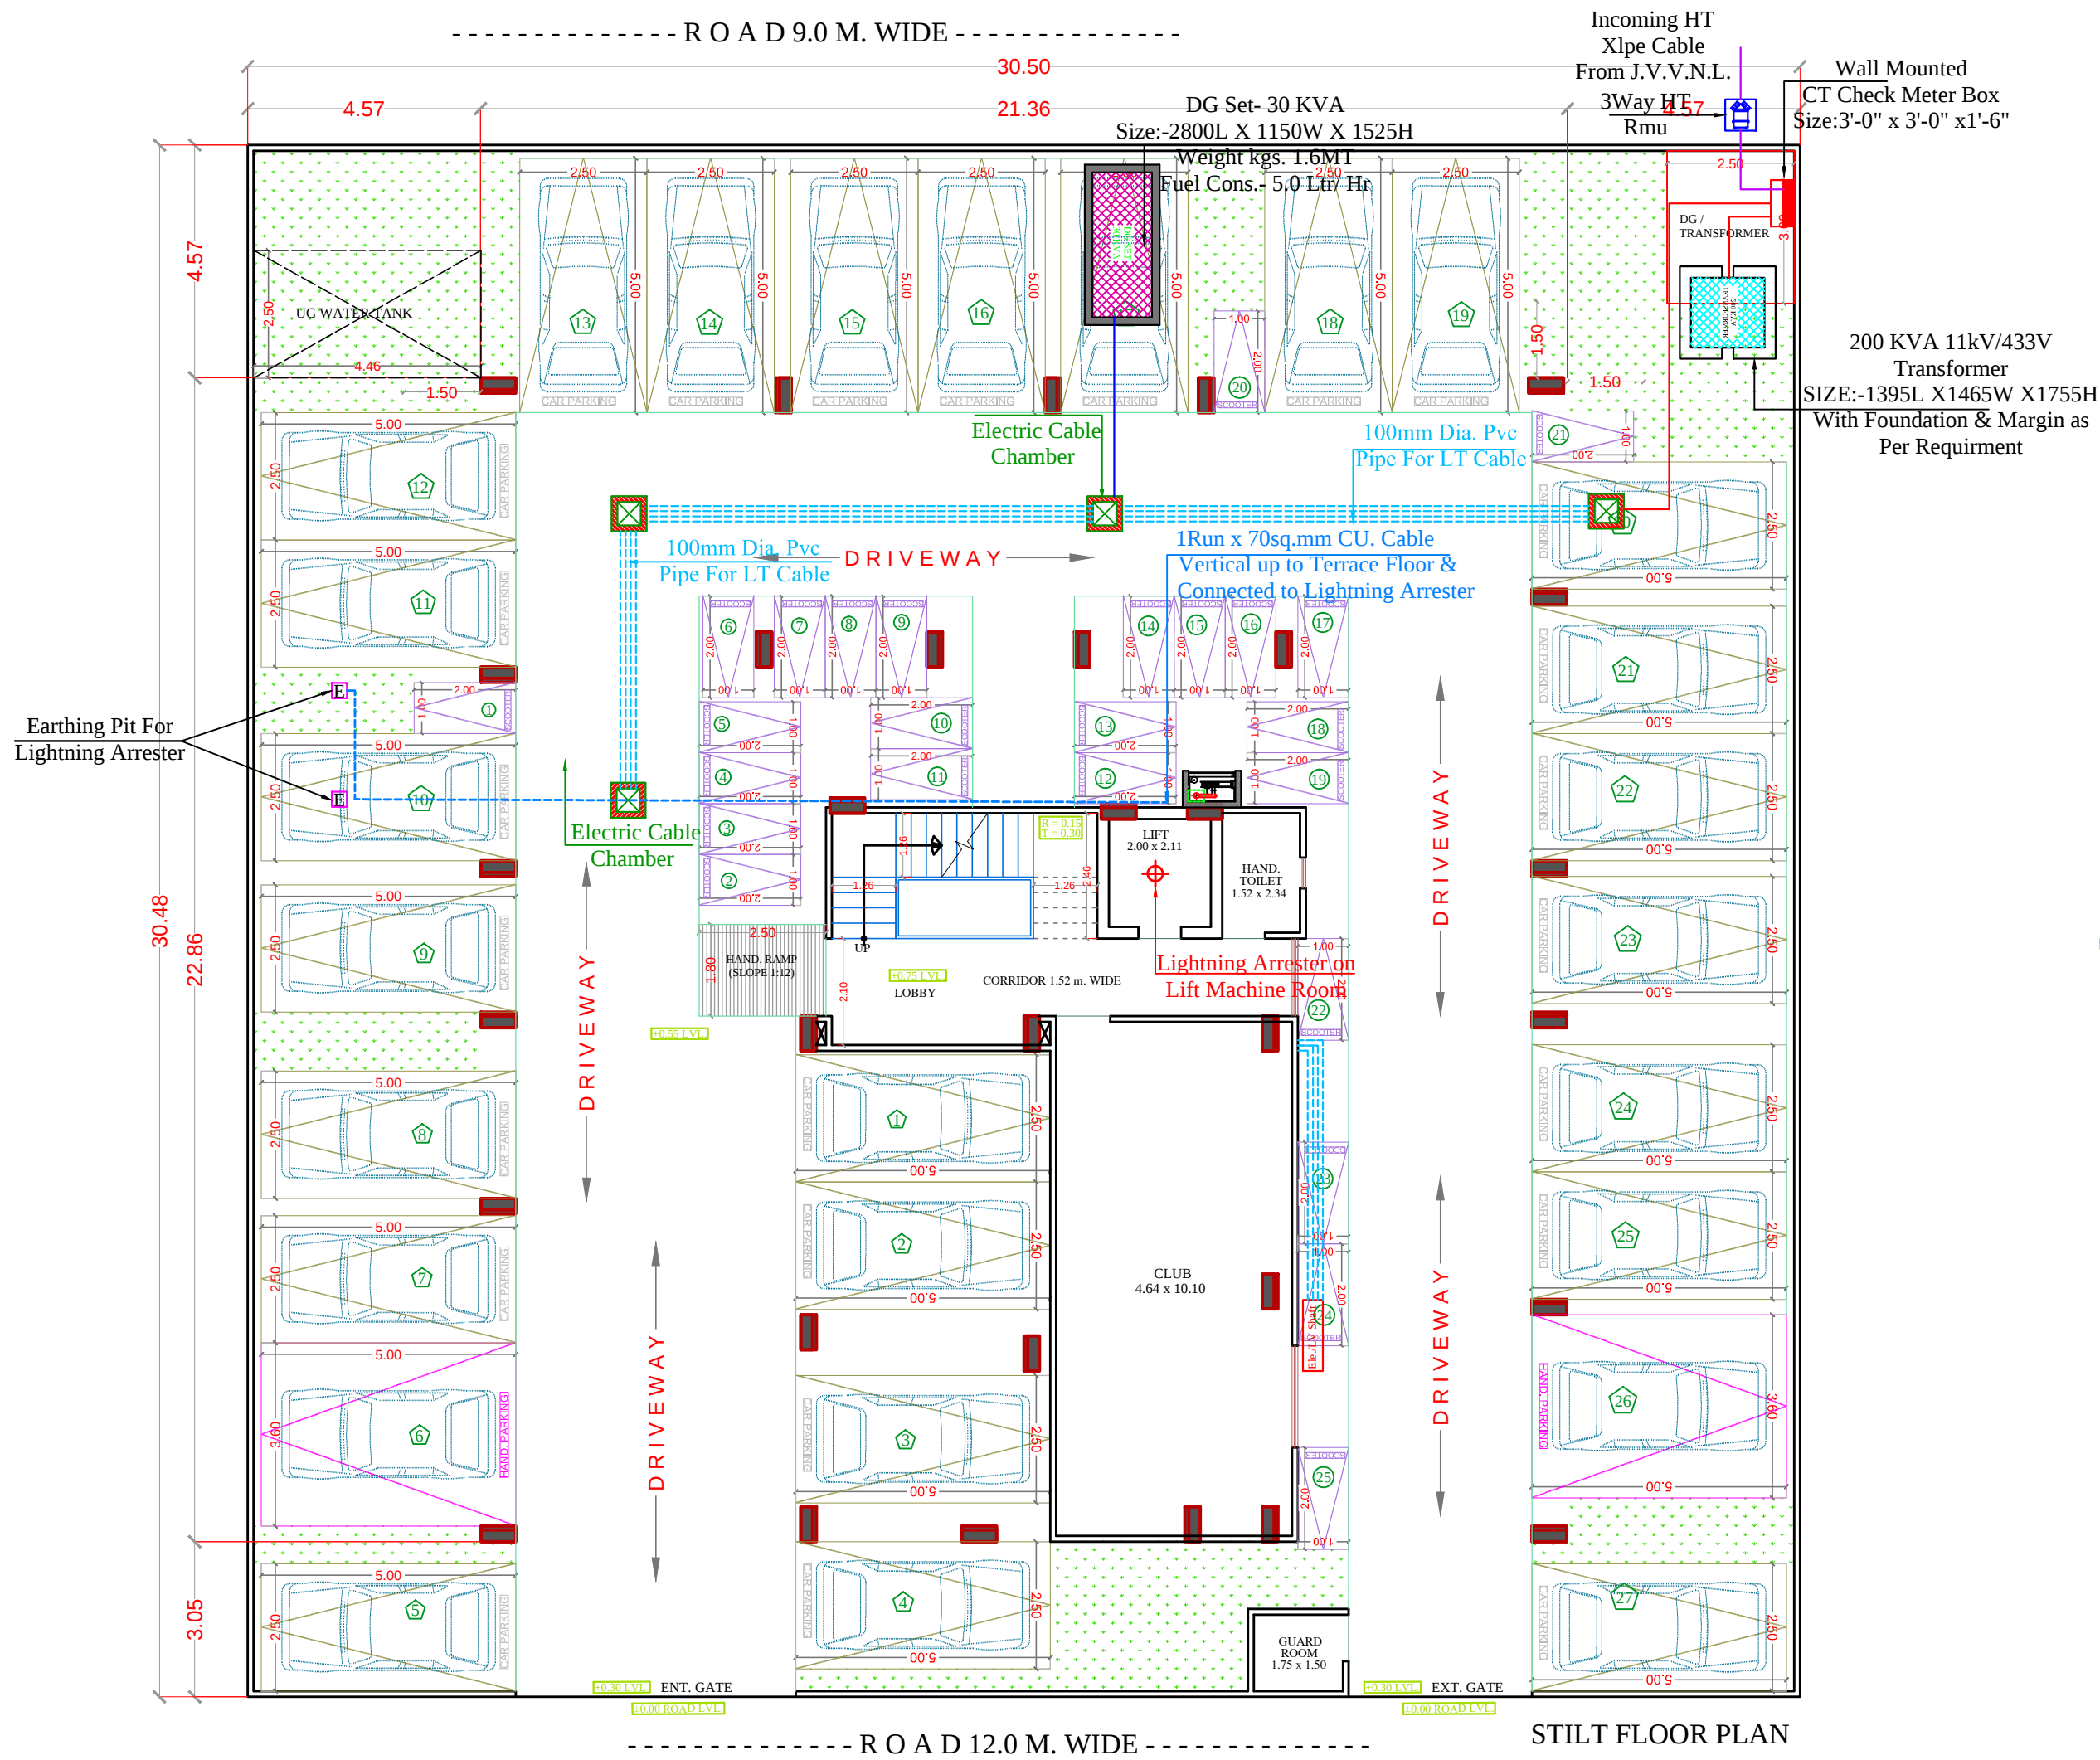

SIGN:-	
For: MOTHERS BUILDERS	Lavesh Partner
RAMESH KUMAR M.E.P. CONSULTANT B.E. CIVIL	
SPACE CONSULTANT	
PLOT-A-173, JAGDAMBA NAGAR, HEERAPURA POWER HOWER, JAIPUR (RAJ) 302024	
ARCHITECT :-	
FRANK SQUARE	
ARCHITECTURE PLANNER DESIGNER C-49 VIDYA APARTMENT PARAS MARG, BAPU NAGAR JAIPUR, (RAJ.) Email-afranksquare@gmail.com Mobile-9461302542	
PROJECT :-	
PROPOSED BUILDING AT PLOT NO-14, 15, 16, 17, 18, 23, 24, 25, 26, 27, PREAM SAROVAR, JAIPUR	
BUILDING NAME	Mothers heights
DEVELOPER NAME	Suresh kumar Bijarniya
DRAWING:	
STILT FLOOR ELECTRIC SUB STATION, CABLE ROUTE & LIGHTNING ARRESTER FOR RERA SUBMISSION PLAN	
DATE	
SCALE:-	N.T.S.

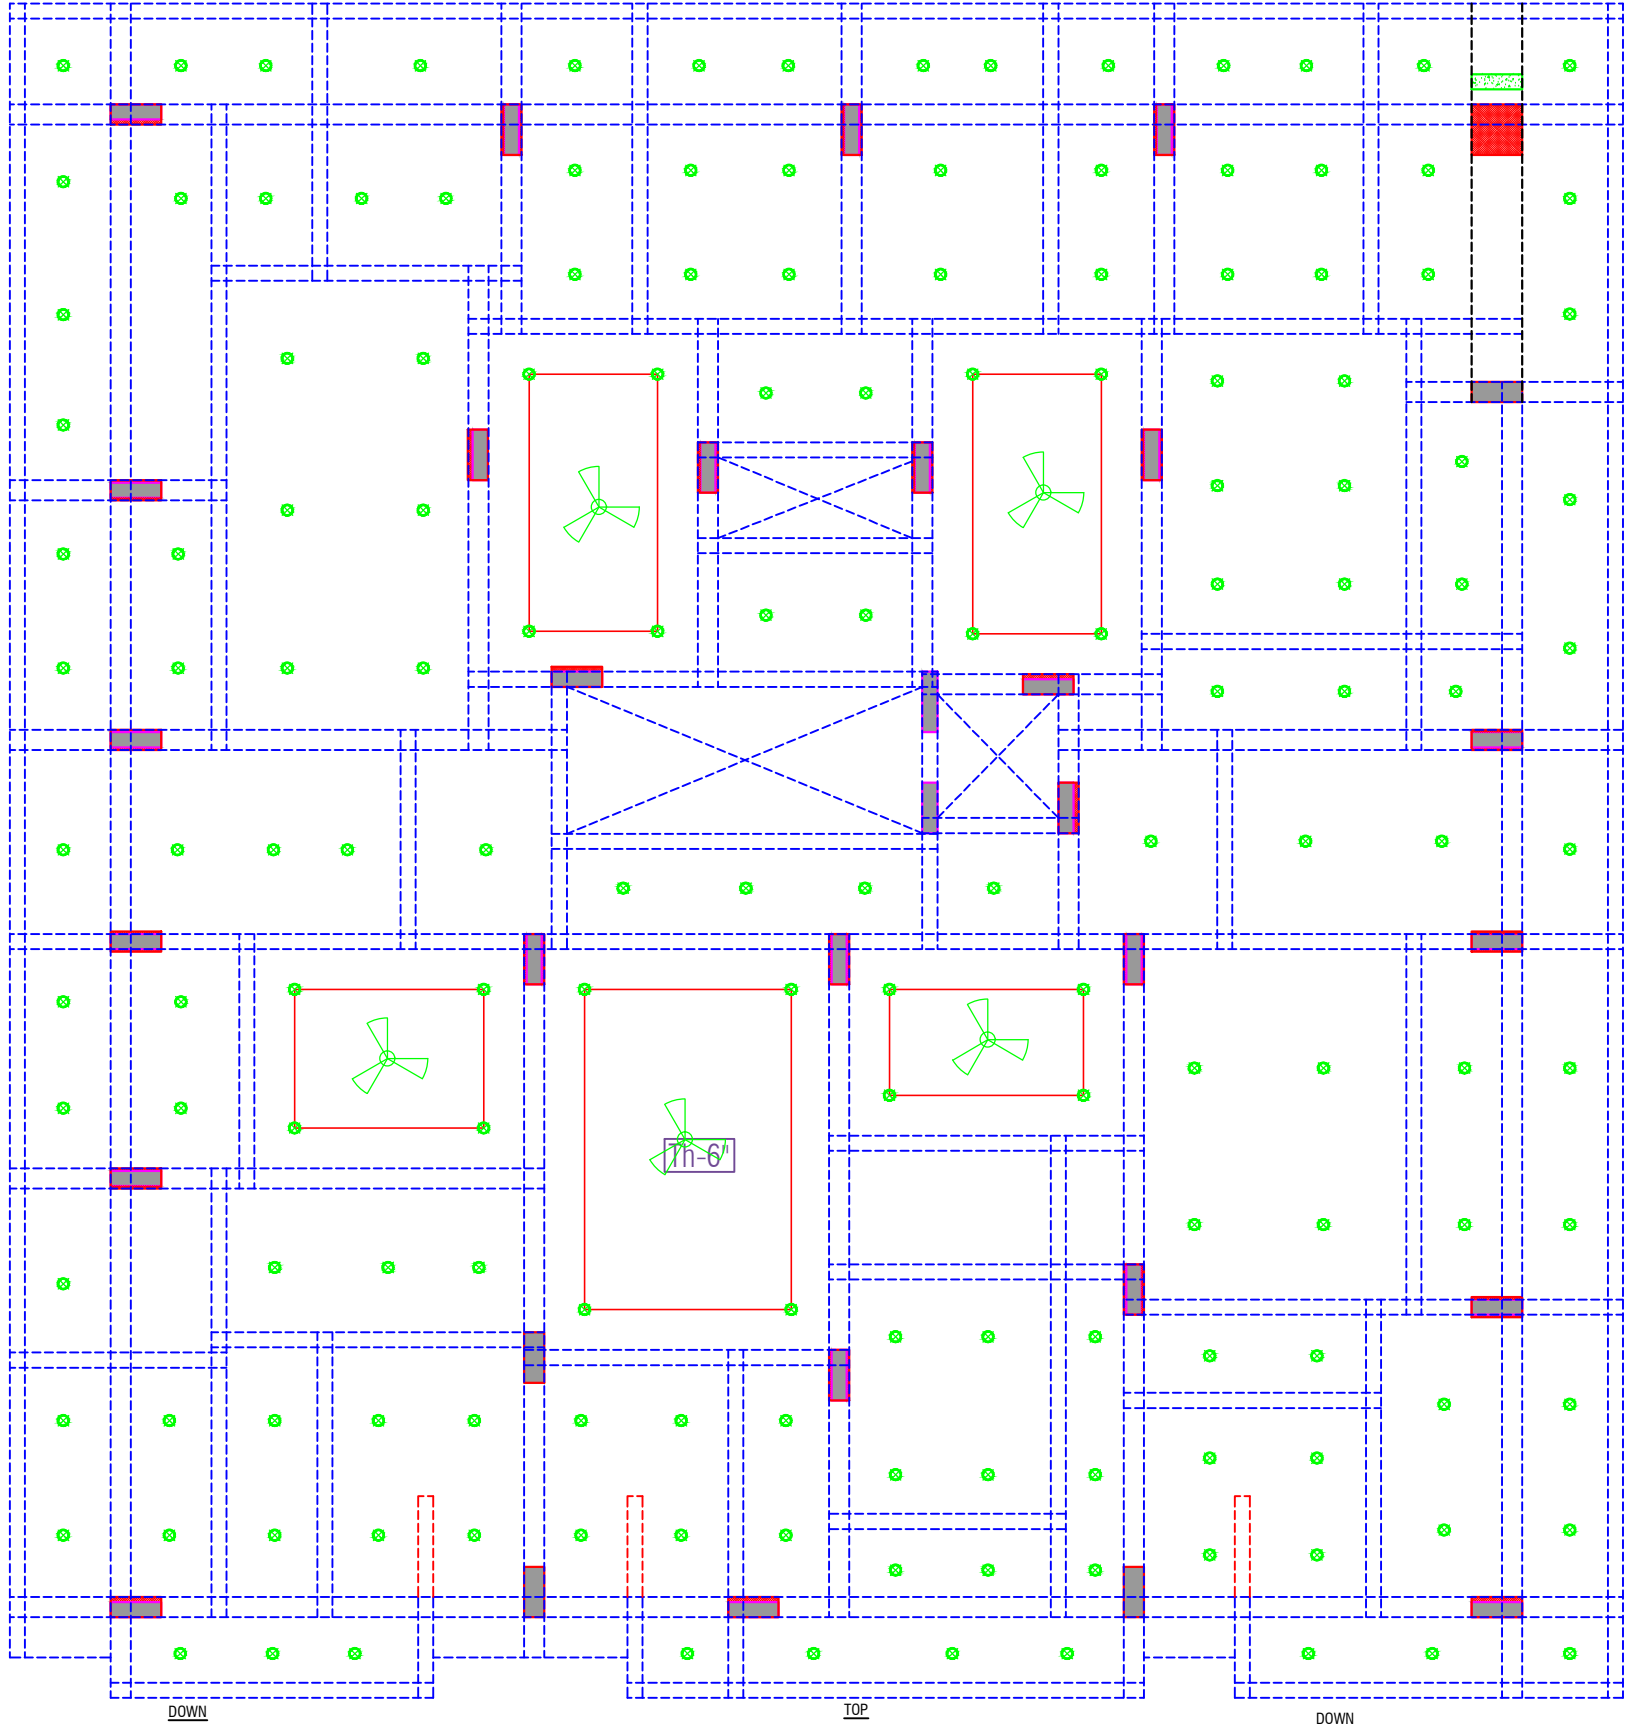


NO	ITEM	SYMBOL
1	CEILING FAN	ROOF
2	TUBE LIGHT	+8'6"
3	BULB	+8'6"
4	POWER POINT	+1'6"
5	BED POINT	+4'3"
6	CEILING LIGHT	ROOF
7	A.C.POINT	+6'6"
8	SWITCH BOARD	+4'3"
9	EXHAUST	VENT
10	TELEPHONE	+1'6"
11	GYSER	+6'0"
12	BELL POINT	+8'6"
13	T.V.	+1'6"
14	M.BOX	
15	M.C.B.	+6'6"
16	FANCY LIGHT	+8'6"
17	HANGING LIGHT	ROOF

For- MOTHERS BUILDERS
Suresh
Partner

RAMESH KUMAWAT
M.E.P. CONSULTANT
B.E. CIVIL

STILT FLOOR ELECTRIC PLAN

PROJECT TITLE :- PROPOSED BUILDING AT PLOT NO-14, 15, 16, 17, 18, 23, 24, 25, 26, 27, PREAM SAROVAR, JAIPUR	BUILDING NAME Mothers heights		SERVICES CONSULTANT	DRN. BY		PATH :-		NORTH
						DRN.	DATE	
	DEVELOPER NAME Suresh kumar Bijarniya			APPD. BY		SCALE	REVISION	
						N.T.S		

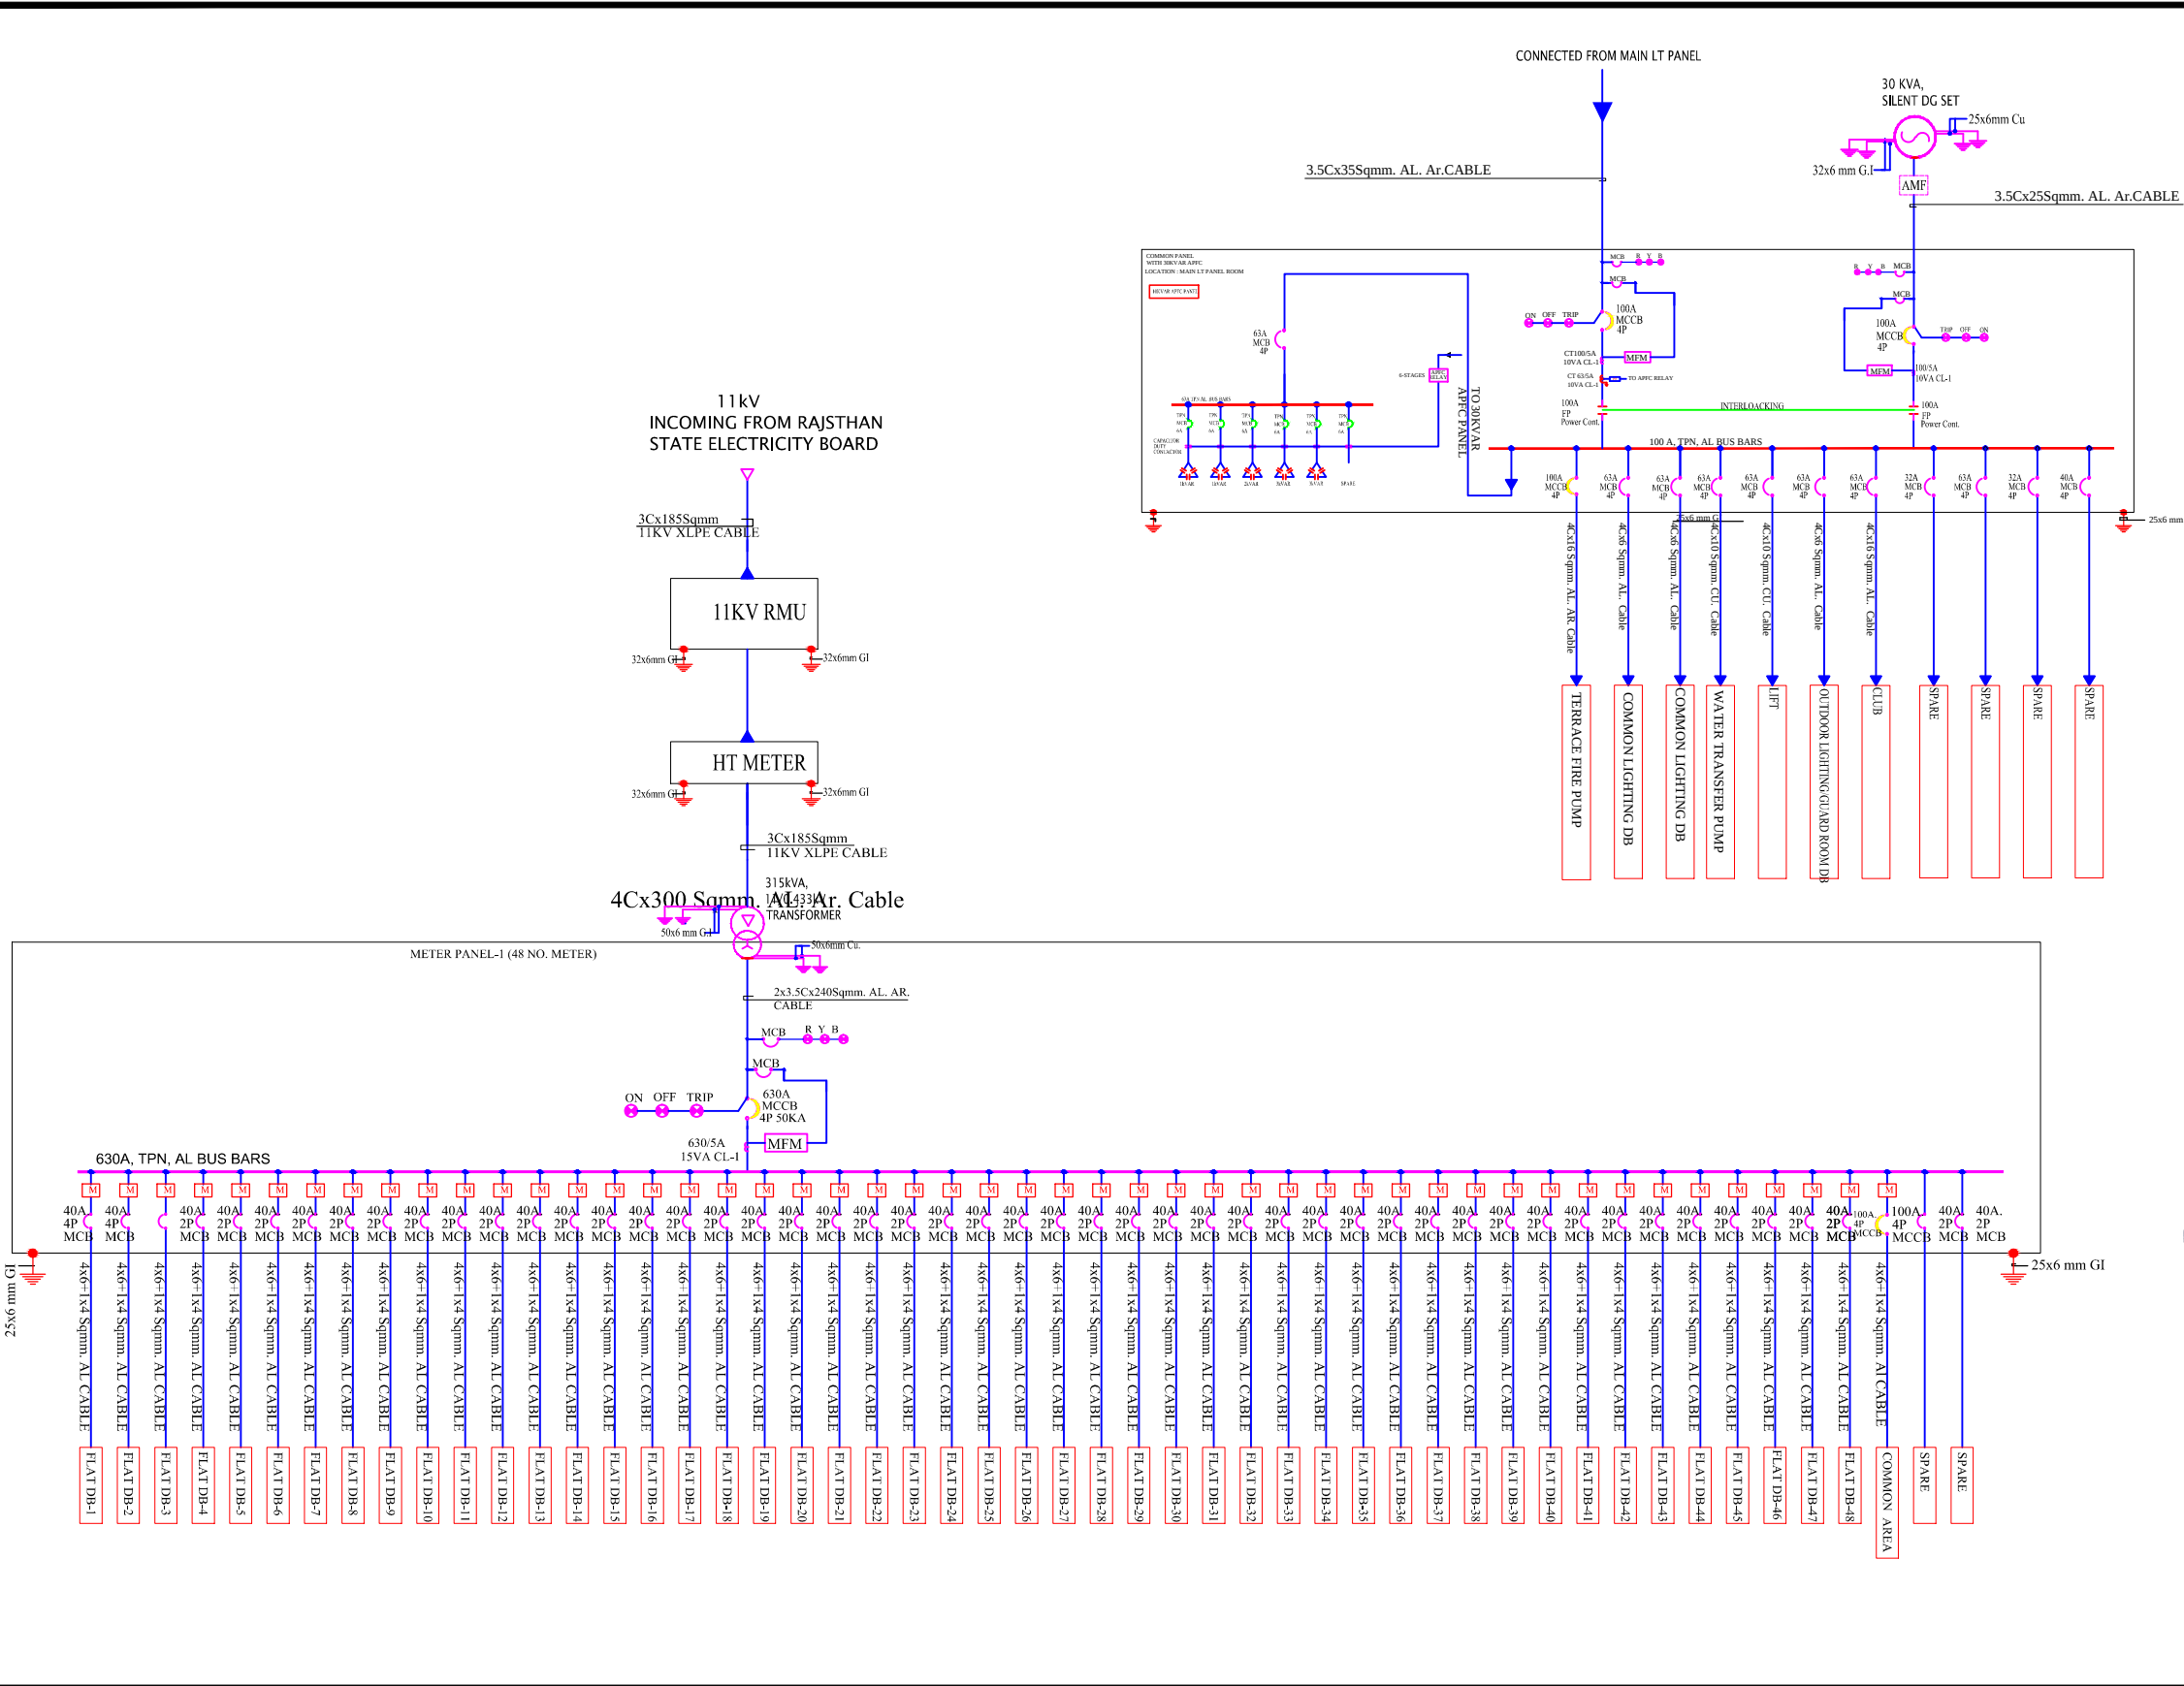

LEGEND	
SYMB.	DESCRIPTION
	AMMETER
	VOLTMETER
	POWER FACTOR METER
	VOLTMETER, AMMETER, FRICTION METER
	FREQUENCY METER
	KILOWATT HOUR METER
	KILOWATT METER
	AMMETER SELECTOR SWITCH
	VOLTMETER SELECTOR SWITCH
	LOCKOUT RELAY
	SUPERVISORY TRIP RELAY
	UNDER VOLTAGE DEVICE
	OVER VOLTAGE DEVICE
	REVERSE POWER PHASE DEVICE
	DIFFERENTIAL PROTECTION RELAY
	OVER CURRENT & EARTH FAULT RELAY
	MULTI FUNCTION RELEY
	ELECTRICAL OPERATED MANUALLY DRAWOUT
	CONTROL FUSE
	CURRENT TRANSFORMER
	TRIVECTOR METER
	INDICATING LAMP
	EXHAUST FAN
	OVER LOAD RELAY
	POWER CONTACTOR
	POTENTIAL TRANSFORMER
	DUAL SOURCE ELECTRONIC ENERGY METER
	GROUNDING
	MICRO PROCESSOR BASED RELEASE
	ELECTRONIC ENERGY METER
	AIR CIRCUIT BREAKER
	VACUUM CIRCUIT BREAKER
	MINIATURE CIRCUIT BREAKER
	MOULDED CASE CIRCUIT BREAKER
	MOTOR PROTECTION CIRCUIT BREAKER

REVISION - 00	
GENERAL NOTES :	
1. ALL THE DIMENSIONS ON THE DRAWING ARE IN WRITTEN.	
2. ONLY WRITTEN DIMENSIONS ARE TO BE FOLLOWED, DRAWING SHOULD NOT BE SCALED IN ANY CIRCUMSTANCES.	
3. ALL MEASUREMENTS MUST BE CHECKED AND VERIFIED BY THE CONTRACTORS PRIOR TO EXECUTION OF WORK AT THE SITE.	
4. THIS DRAWING IS TO BE READ IN CONJUNCTION WITH ALL RELEVANT STRUCTURAL, ARCHITECTURAL & FACILITY PLANNING DRAWINGS.	
5. ANY DISCREPANCIES MUST BE BROUGHT TO THE NOTICE OF THE ENGINEER IMMEDIATELY & PRIOR TO EXECUTION AT SITE.	
6. CO-ORDINATION WITH SERVICES SUCH AS HVAC, PLUMBING & ELECTRICAL, ETC. IS THE RESPONSIBILITY OF THE CONTRACTORS.	
7. FOR DETAILS, REFER RELEVANT LARGE SCALE DETAIL DRGS. AS INDICATED.	

LIGHTING LEGEND			
SR.NO	SYMBOL	DESCRIPTION	HEIGHT FROM FFL
1		CEILING TUBELIGHT POINT	CEILING
2		LED CEILING LIGHT POINT	CEILING
3		LED WALL BRACKET LIGHT POINT AT WALL	+7'-4"
4		6A SOCKET WITH SWITCH	+2'-0"
5		GENERAL POINT 16A SOCKET WITH SWITCH	+2'-0"
6		MDF BOX	+5'-0"
7		CEILING ROSE	+7'-4"
8		SWITCH BOARD	+4'-0"
9		EXHAUST FAN	VENT. HT.
10		LIGHT & POWER DISTRIBUTION BOARD	+5'-1"
11		825MM POINT CONDUIT	CEILING
12		825MM POWER CIRCUIT CONDUIT	CEILING FLOORING
13		825MM LIGHT CIRCUIT CONDUIT	CEILING FLOORING
14		CEILING FAN	CEILING

ARCHITECT

ARCHITECT :-

FRANK SQUARE

ARCHITECTURE | PLANNER | DESIGNER
C-49 VIDYA APARTMENT PARAS MARG,
BAPU NAGAR JAIPUR, (RAJ.)
Email-afranksquare@gmail.com
Mobile-9461302542

PROJECT :-

PROPOSED BUILDING AT PLOT NO-14, 15, 16, 17, 18, 23, 24, 25, 26, 27, PREAM SAROVAR, JAIPUR

BUILDER/DEVELOPER/CLIENT:-	
Suresh kumar Bijarniya	
DRAWING TITLE:- MAIN PANEL SLD	
BUILDING NAME Mothers heights	
SUBMITTED FOR :-	
PRELIMINARY	APPROVAL
PROPOSAL	FOR RERA
DATE :-	NORTH :-
DRAWN :-	
APPROVED :-	
DRAWING NO.:-	SCALE :-


CONSULTANT

AMP INFRA SERVICES
VILLA NO 16. SHUBHASIS GEETA
JAISINGHPURA, BHANKROTA &
CHIMANPURA,JAIPUR 302026
EMAIL ID- ampinfrajpr@gmail.com
CONTACT NO. :- 9462866389

For- MOTHERS BUILDERS

Suresh
Partner

RAMESH KUMAWAT
M.E.P. CONSULTANT
B.E. CIVIL

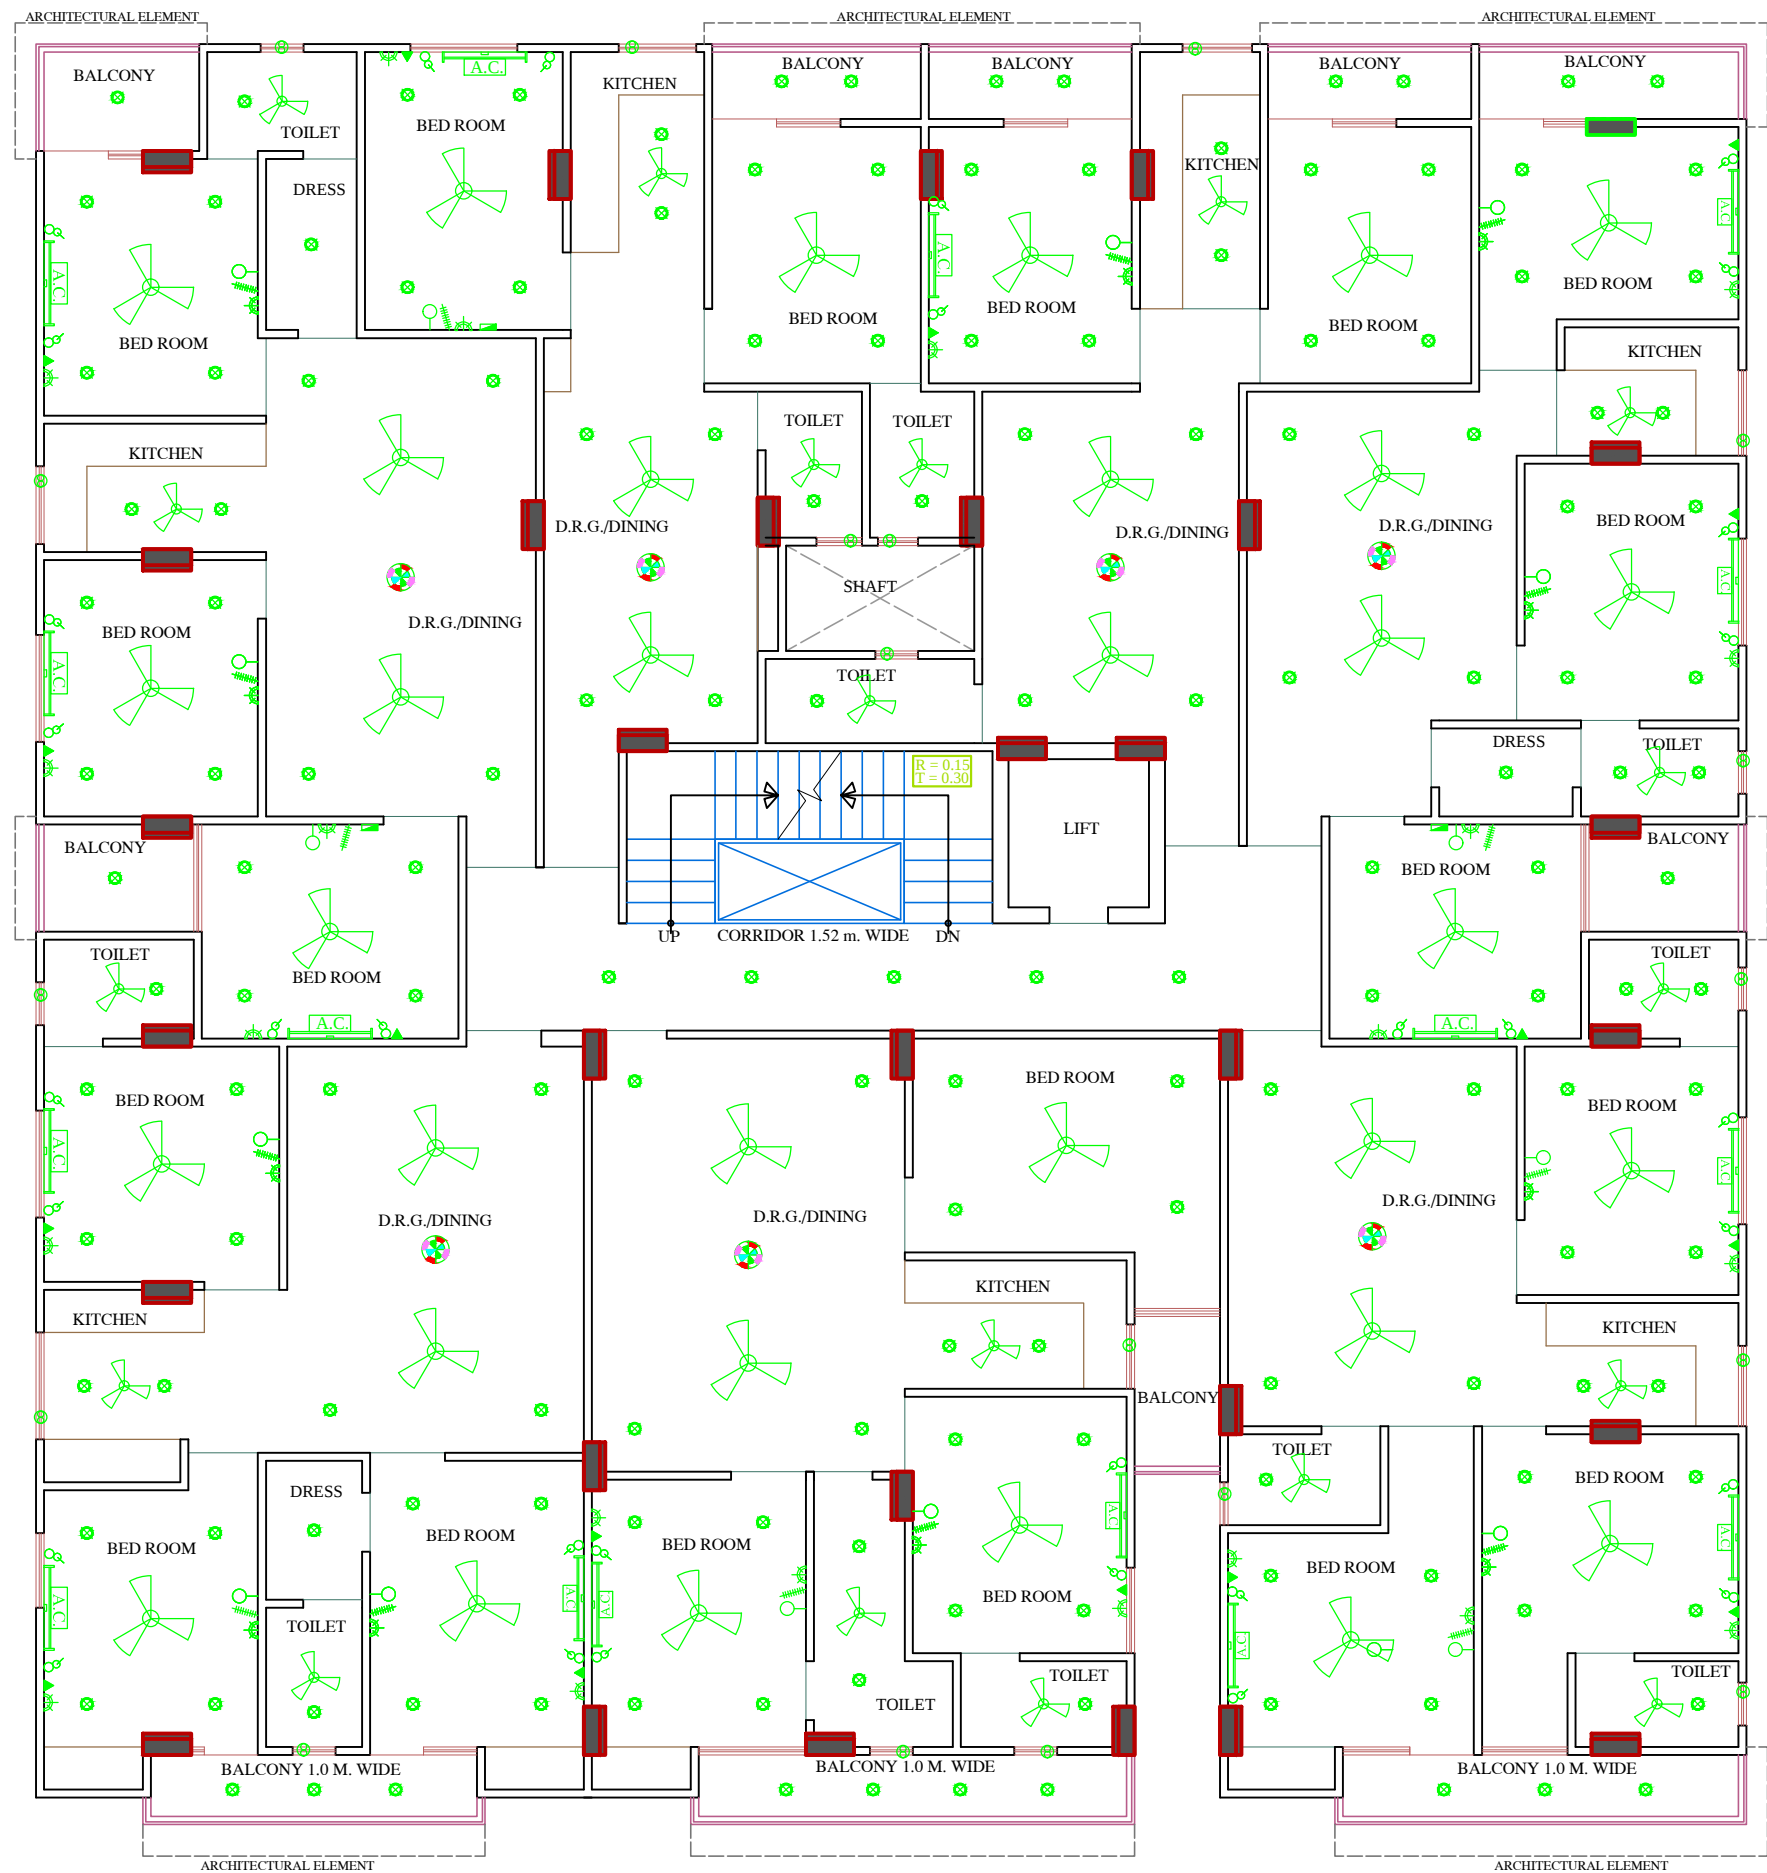

NO	ITEM	SYMBOL	
1	CEILING FAN		ROOF
2	TUBE LIGHT		+8'6"
3	BULB		+8'6"
4	POWER POINT		+1'6"
5	BED POINT		+4'3"
6	CEILING LIGHT		ROOF
7	A.C.POINT		+6'6"
8	SWITCH BOARD		+4'3"
9	EXHAUST		VENT
10	TELEPHONE		+1'6"
11	GYSER		+6'0"
12	BELL POINT		+8'6"
13	T.V.		+1'6"
14	M.BOX		
15	M.C.B.		+6'6"
16	FANCY LIGHT		+8'6"
17	HANGING LIGHT		ROOF

TYPICAL FLOOR ELECTRIC PLAN

PROJECT TITLE :-
PROPOSED BUILDING AT PLOT
NO-14, 15, 16, 17, 18, 23, 24, 25, 26,
27, PREAM SAROVAR, JAIPUR

BUILDING NAME
Mothers heights
DEVELOPER NAME
Suresh kumar Bijarniya

SERVICES CONSULTANT


DRN. BY
APPD. BY

PATH :-	
DRN.	DATE
SCALE	REVISION
N.T.S	

NORTH

RAMESH KUMAWAT
M.E.P. CONSULTANT
B.E. CIVIL

For- MOTHERS BUILDERS
Suresh
Partner

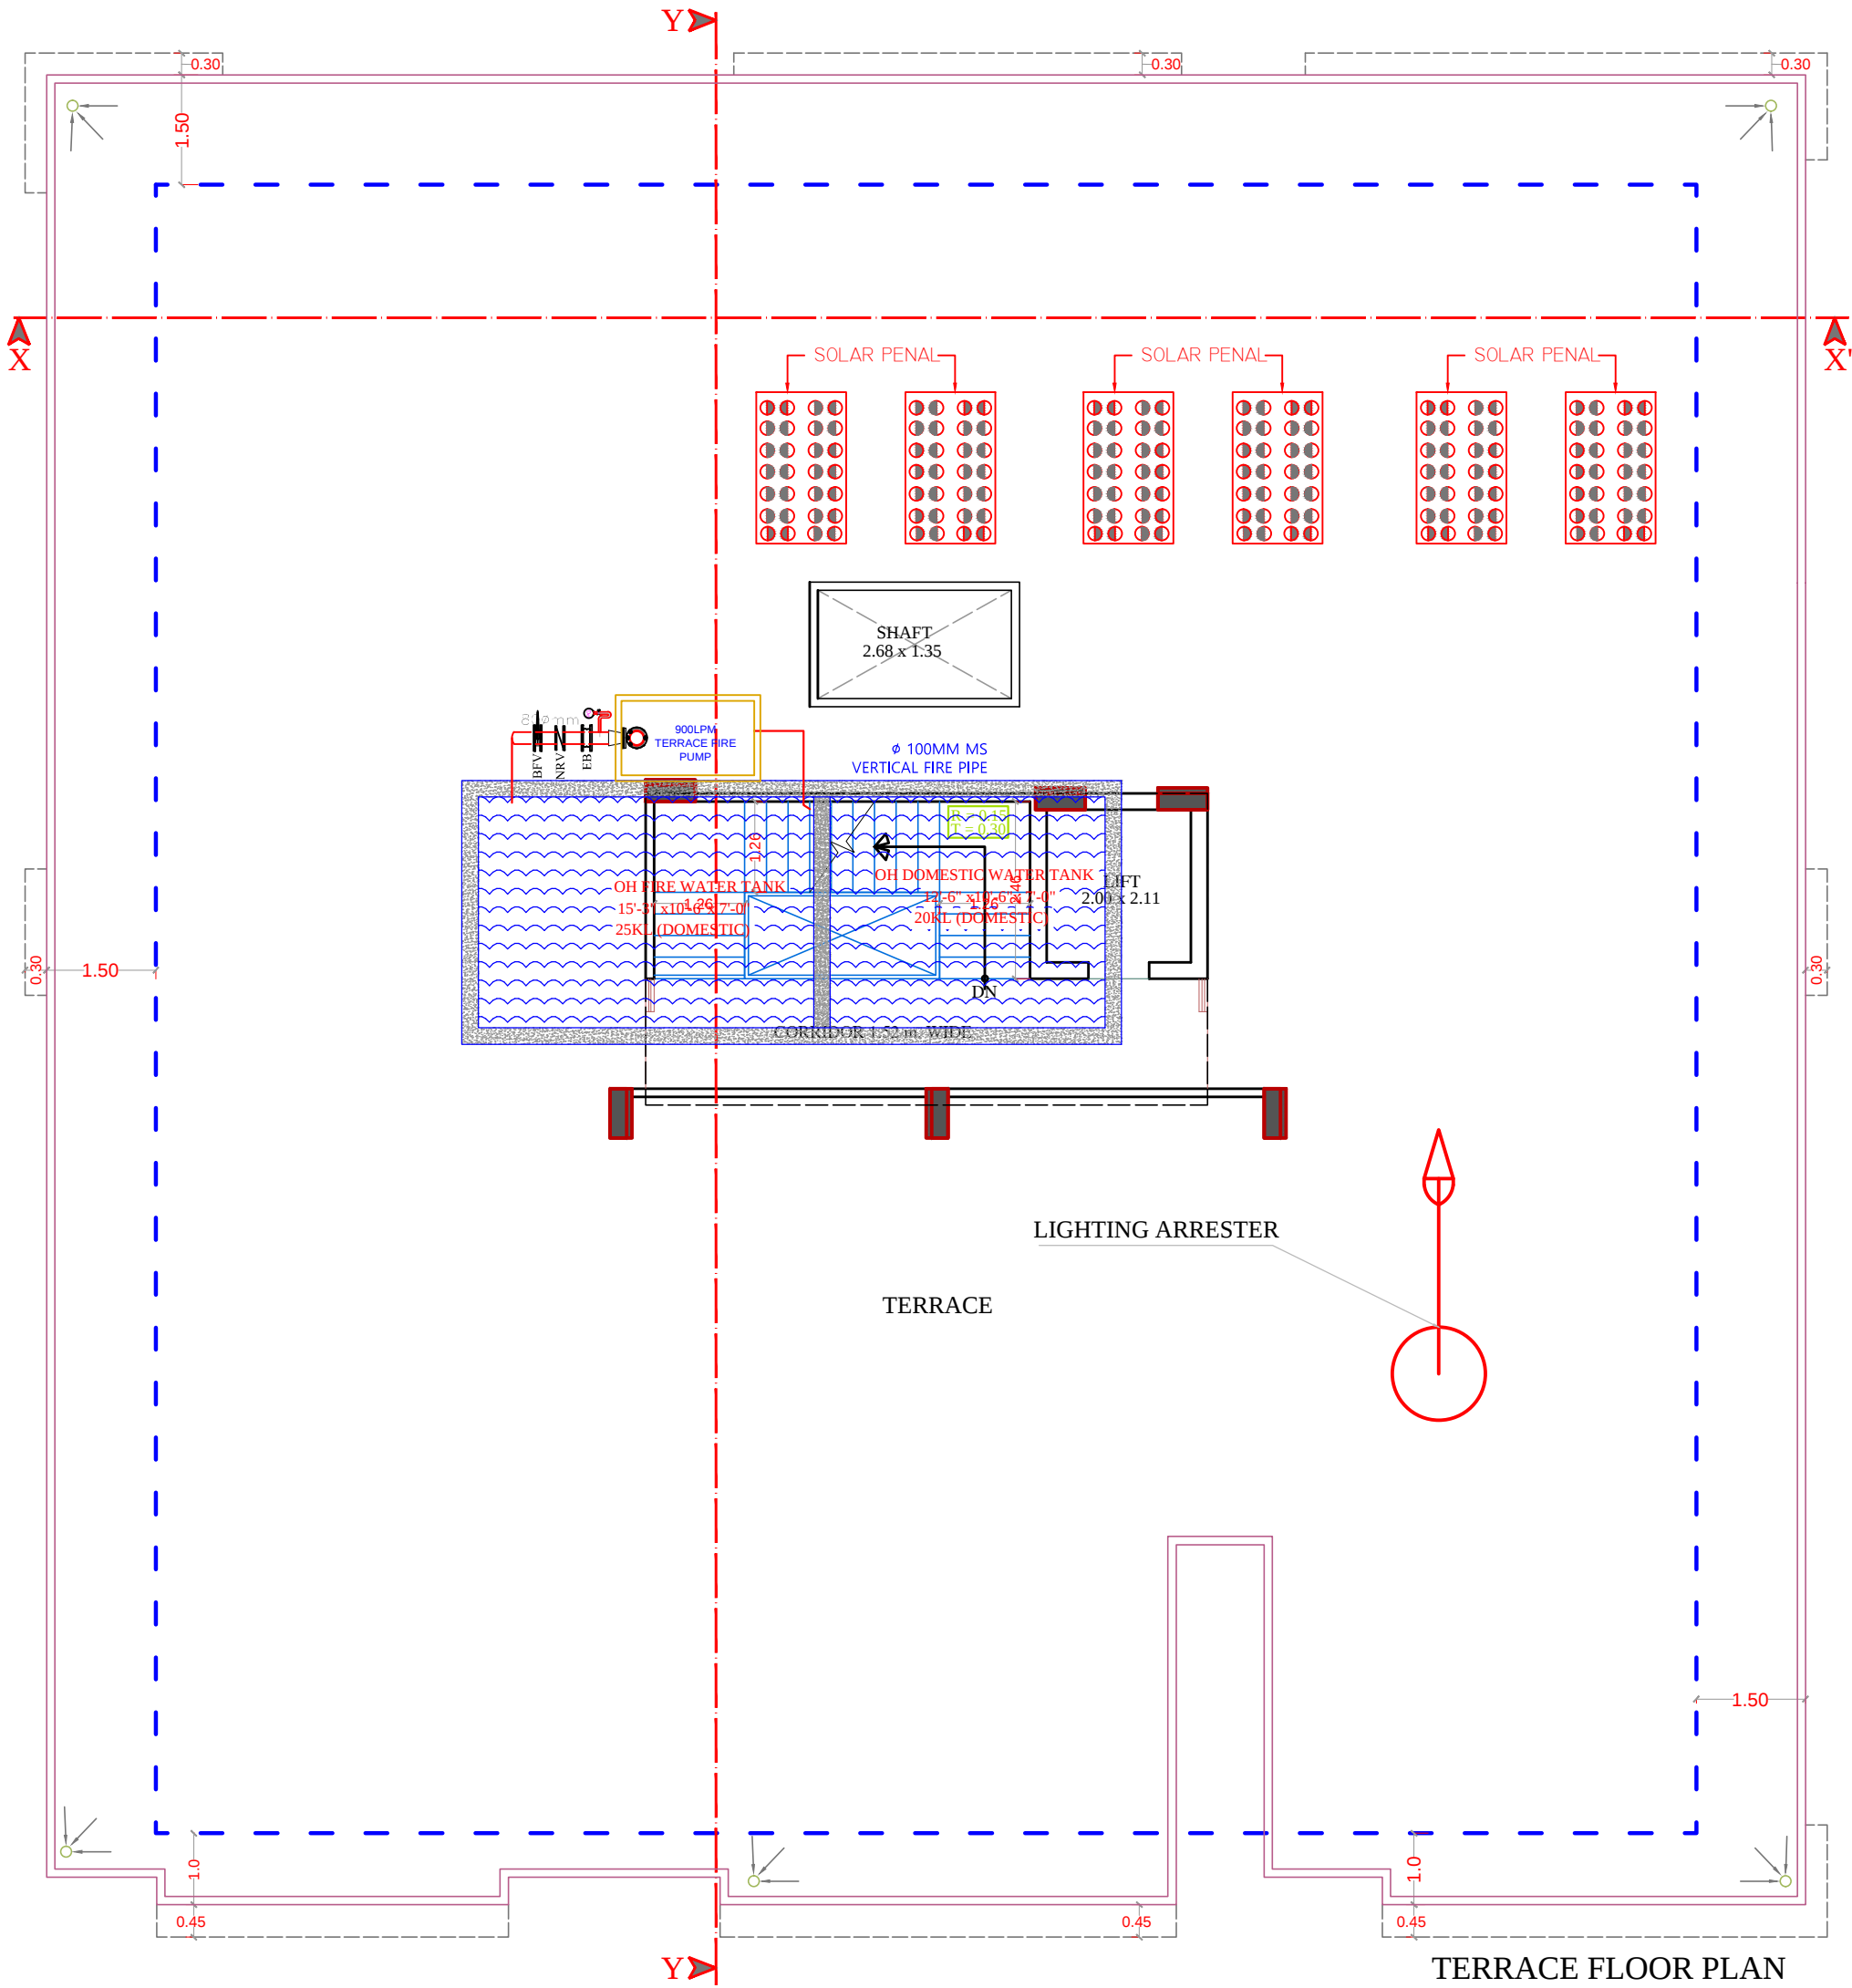

TERRACE FLOOR PLAN

LEGEND

	Symbole	DESCRIPTION
1.		HOSEREEL
2.		FIRE PIPE
3.		FIRE PIPE
4.		FIRE EXTINGUISHER
5.		EXTERNAL YARD HYDRANT


RAMESH KUMAWAT
M.E.P. CONSULTANT
B.E. CIVIL

For- MOTHERS BUILDERS

Partner

PROJECT TITLE :- PROPOSED BUILDING AT PLOT NO-14, 15, 16, 17, 18, 23, 24, 25, 26, 27, PREAM SAROVAR, JAIPUR	BUILDING NAME Mothers heights	DRAWING TITLE :- TARRACE FLOOR LIGHTING ARRESTER LOCATION	SPACE CONSULTANT PLOT-A-173, JAGDAMBA NAGAR, HEERAPURA POWER HOWER, JAIPUR (RAJ) 302024	DRN. BY		DATE	NORTH
				APPD. BY		REVISION	
	DEVELOPER NAME Suresh kumar Bijarniya			SCALE			

SCHEMATIC DIAGRAM
LIGHTNING PROTECTION SYSTEM

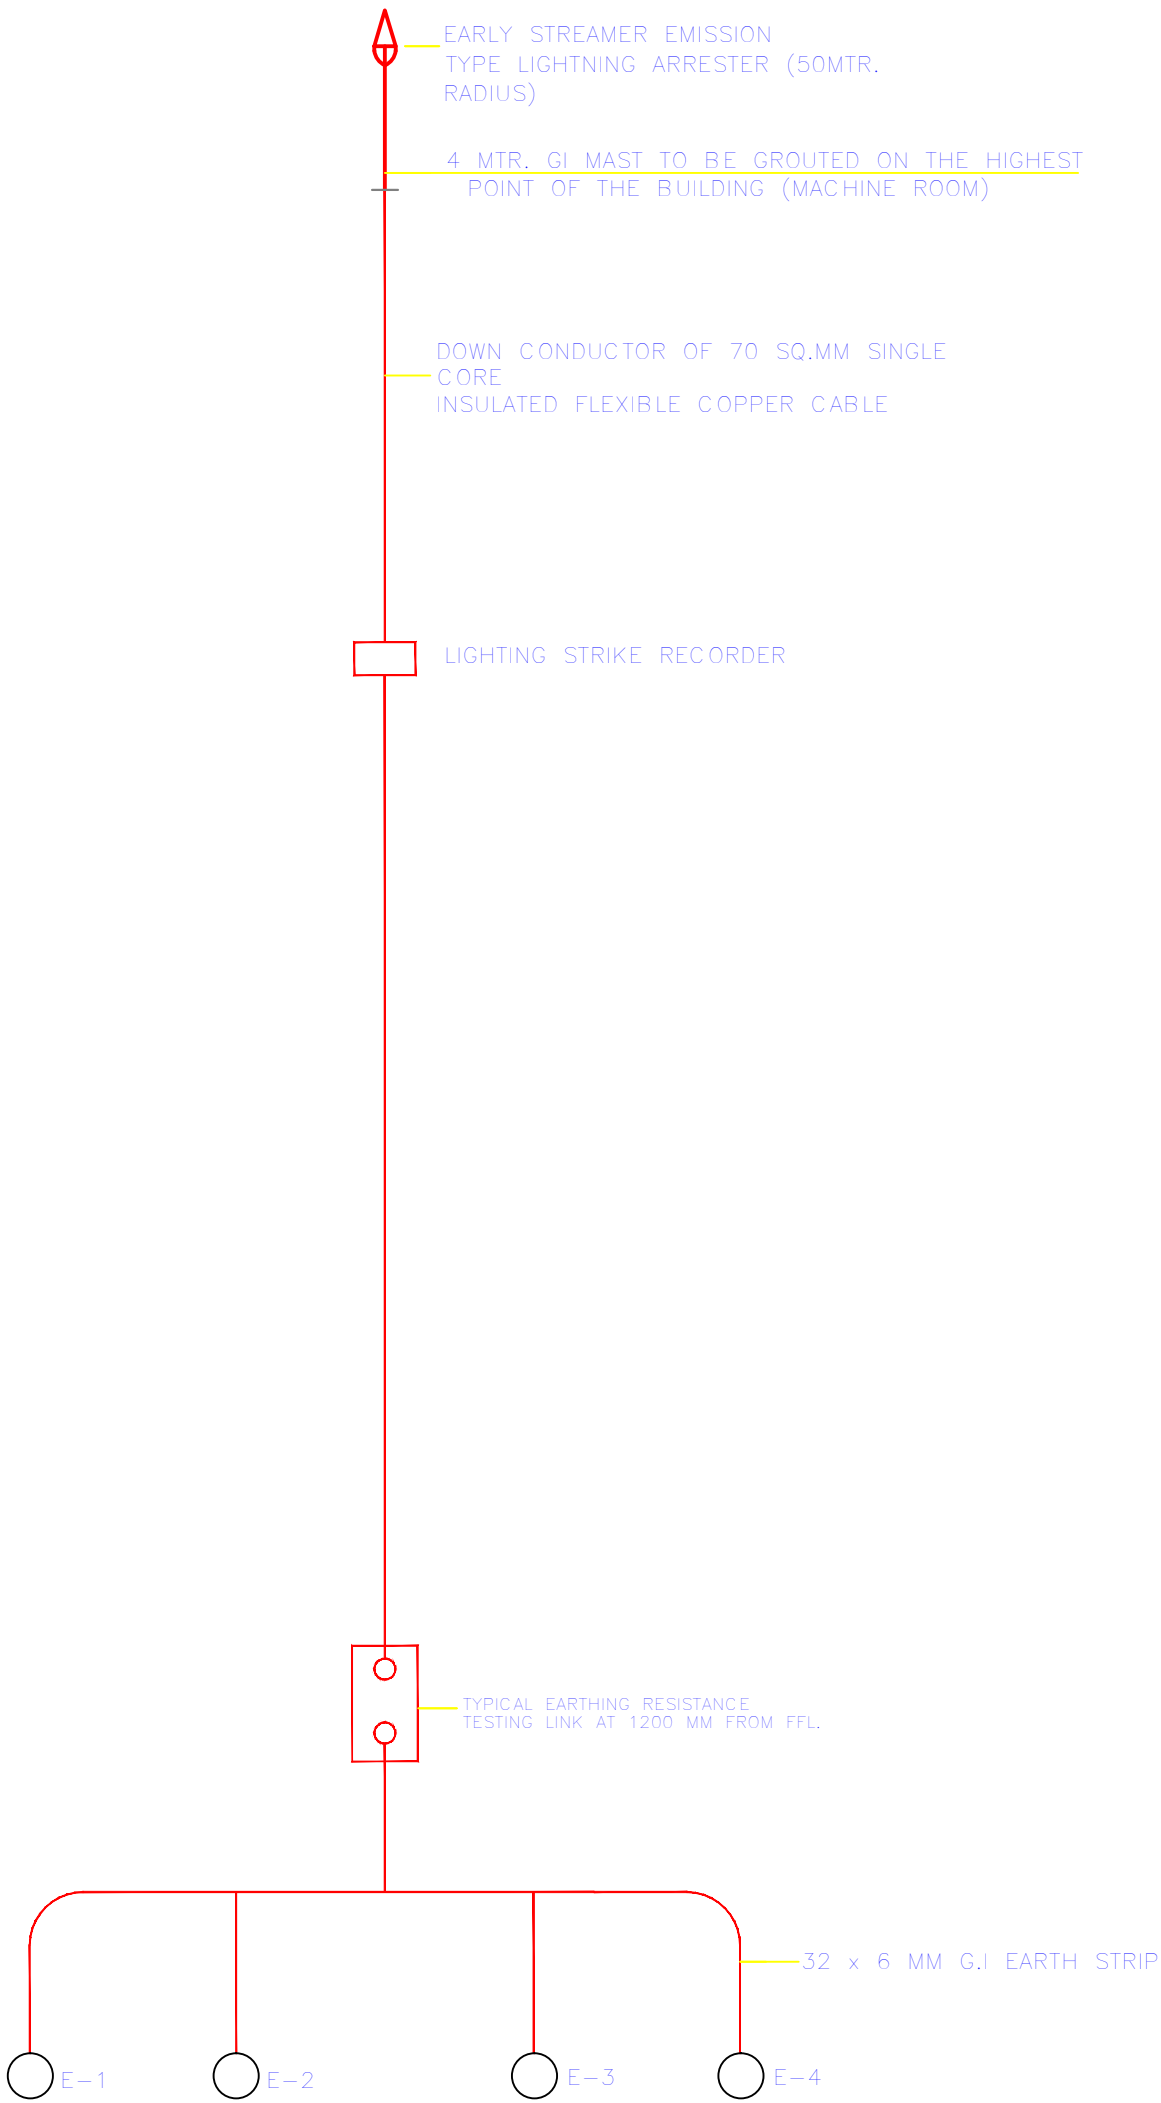

LIGHTENING ARRESTOR SLD


RAMESH KUMAWAT
M.E.P. CONSULTANT
B.E. CIVIL

For- MOTHERS BUILDERS

Partner

PROJECT TITLE :- PROPOSED BUILDING AT PLOT NO-14, 15, 16, 17, 18, 23, 24, 25, 26, 27, PREAM SAROVAR, JAIPUR	BUILDING NAME Mothers heights	DRAWING TITLE :- LIGHTENING ARRESTOR SLD	SPACE CONSULTANT PLOT-A-173, JAGDAMBA NAGAR, HEERAPURA POWER HOWER, JAIPUR (RAJ) 302024	DRN. BY		DATE	NORTH
				APPD. BY		REVISION	
	DEVELOPER NAME Suresh kumar Bijarniya			SCALE			

