


LEGENDS:

Mounting Height	No.	Symbol	Description
IN CEILING			600mm Wide Ceiling Suspended Cable Tray
IN CEILING			375mm Wide Ceiling Suspended Cable Tray
IN CEILING			Cut in Retaining Wall
IN CEILING			Cut in Roof

SERVICES CONSULTANT:
VIPUL CONSULTING,
F 9 / 440 , Keshav Marg Chitrakut Scheme,Jaipur
PH:91-0-93146-10438 ,0141-2440946 Mail:vipul8599@yahoo.com
REV.-00, DATE: 27-06-2018

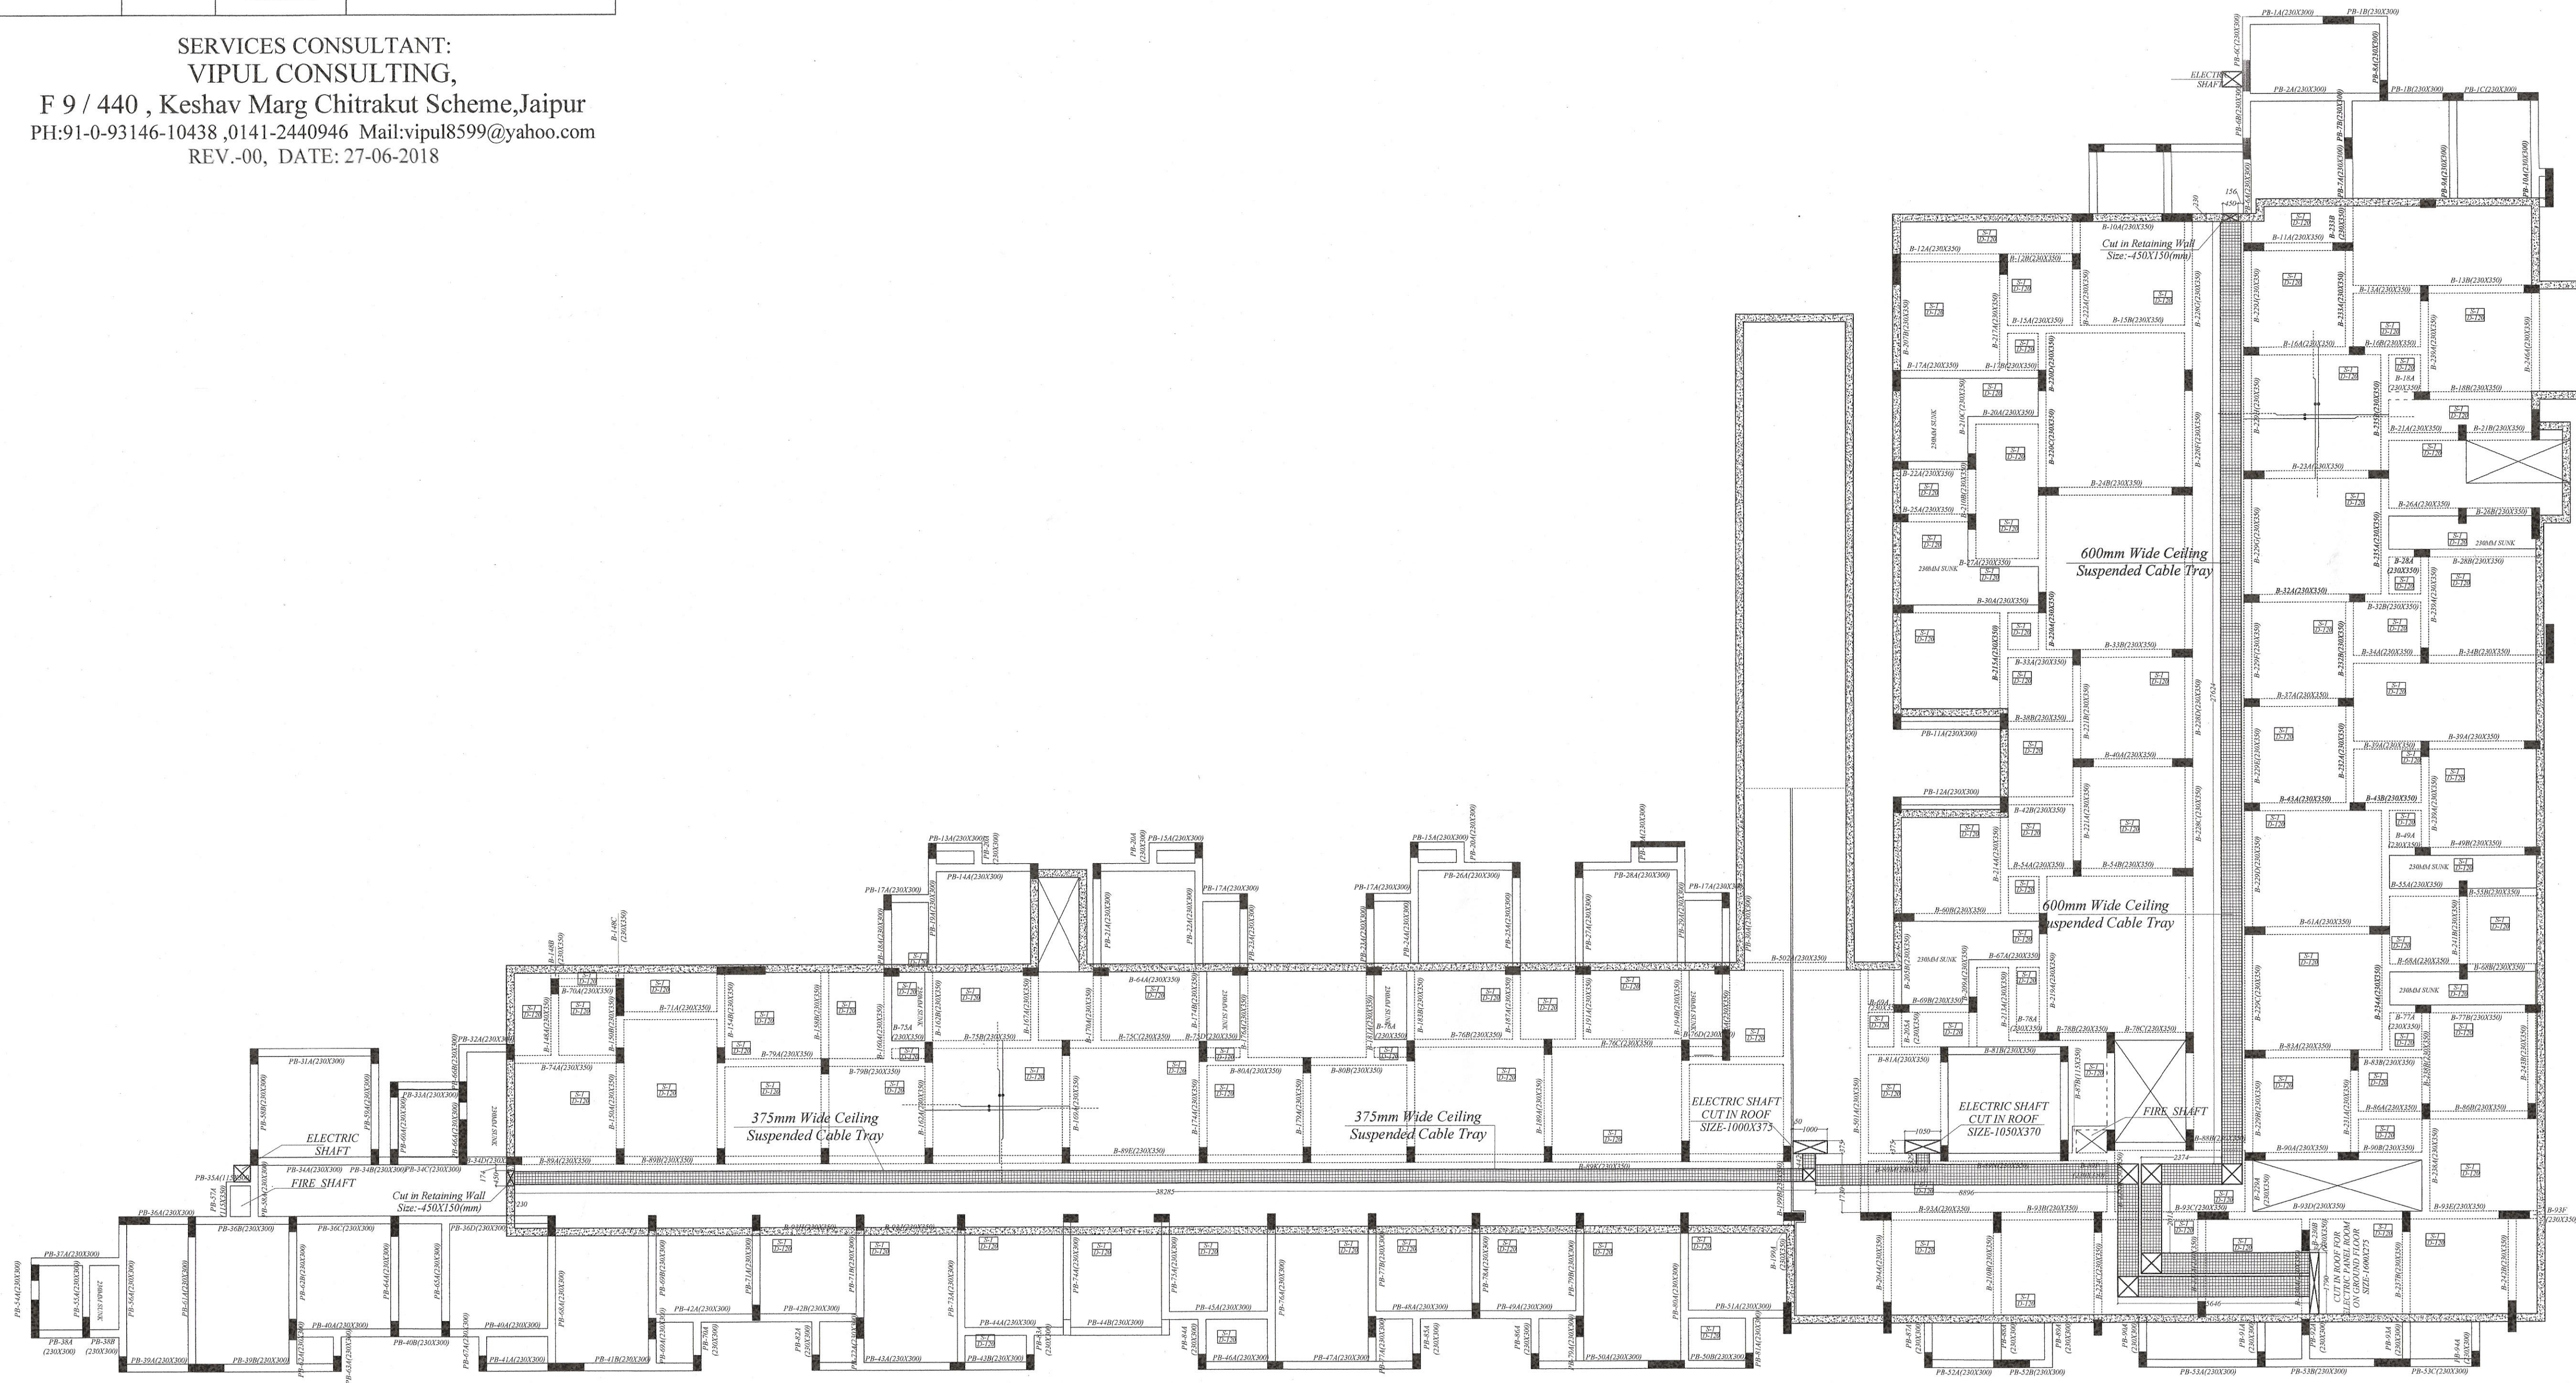

ARCHITECTS:

SKYLINE PLANNERS & DESIGN DEVELOPERS
ARCHITECTS . PLANNERS . INTERIOR DESIGNERS . LANDSCAPE
31, Shiv Path, Suraj Nagar (West),
Civil Lines, Jaipur - 302019 (Raj.)
Ph: 0141-4036189, Mo.: 09887483594
web : www.skylineplanners.com, email: sddjpr@gmail.com

PROJECT : PROPOSED AFFORDABLE HOUSING
KHASRA NO. 622 & 631
AT VILLAGE NARSINGHPURA URF RIKSHA , TEHSIL SANGANER, JAIPUR.

PROJECT TYPE : BASEMENT ROOF CEILING
SUSPENDED CABLE TRAY,
ELECTRIC & FIRE SHAFT CUT PLAN

CLIENT :

DRAWN BY :

CH. BY :

DRAWING NO.: MEN/ROOF/DRAWING/29-06-2018

REVISION NO.:

APPROVED BY :

PROJECT NO.:

SCALE :

N.T.S.

NORTH :




S.NO. DATE

REVISION DESCRIPTION

GENERAL NOTES :

1. ALL THE DIMENSIONS ON THE DRAWING ARE IN METERS.
2. ONLY WRITTEN DIMENSIONS ARE TO BE FOLLOWED. DRAWING SHOULD NOT BE SCALED IN ANY CIRCUMSTANCES.
3. ALL MEASUREMENTS MUST BE CHECKED AND VERIFIED BY THE CONTRACTORS PRIOR TO EXECUTION OF WORK AT THE SITE.
4. THIS DRAWING IS TO BE READ IN CONJUNCTION WITH ALL RELEVANT STRUCTURAL SERVICES & FACILITY PLANNING DRAWINGS.
5. ARCHITECTURAL DRAWINGS ARE TO BE FOLLOWED FOR THE LOCATION OF ALL STRUCTURAL MEMBERS & MASONRY WALLS. FOR SIZES & REINFORCEMENT DETAILS OF STRUCTURAL MEMBERS, RELEVANT STRUCTURAL DRAWINGS ARE TO BE REFERRED.
6. ANY DISCREPANCIES BETWEEN ARCHITECTURAL, STRUCTURAL AND SERVICES DRAWINGS MUST BE BROUGHT TO THE NOTICE OF THE ARCHITECTS IMMEDIATELY & PRIOR TO EXECUTION AT SITE.
7. CO-ORDINATION WITH SERVICES SUCH AS HVAC, PLUMBING & ELECTRICAL, ETC. IS THE RESPONSIBILITY OF THE CONTRACTORS.
8. ALL MASONRY WALLS SHOULD BE ALIGNED WITH THE COLUMNS AS INDICATED ON THE PLAN, IRRESPECTIVE OF THE POSITION AS CALCULATED WITH THE DIMENSIONS.
9. FOR DETAILS, REFER RELEVANT LARGE SCALE DETAIL DRWS. AS INDICATED.

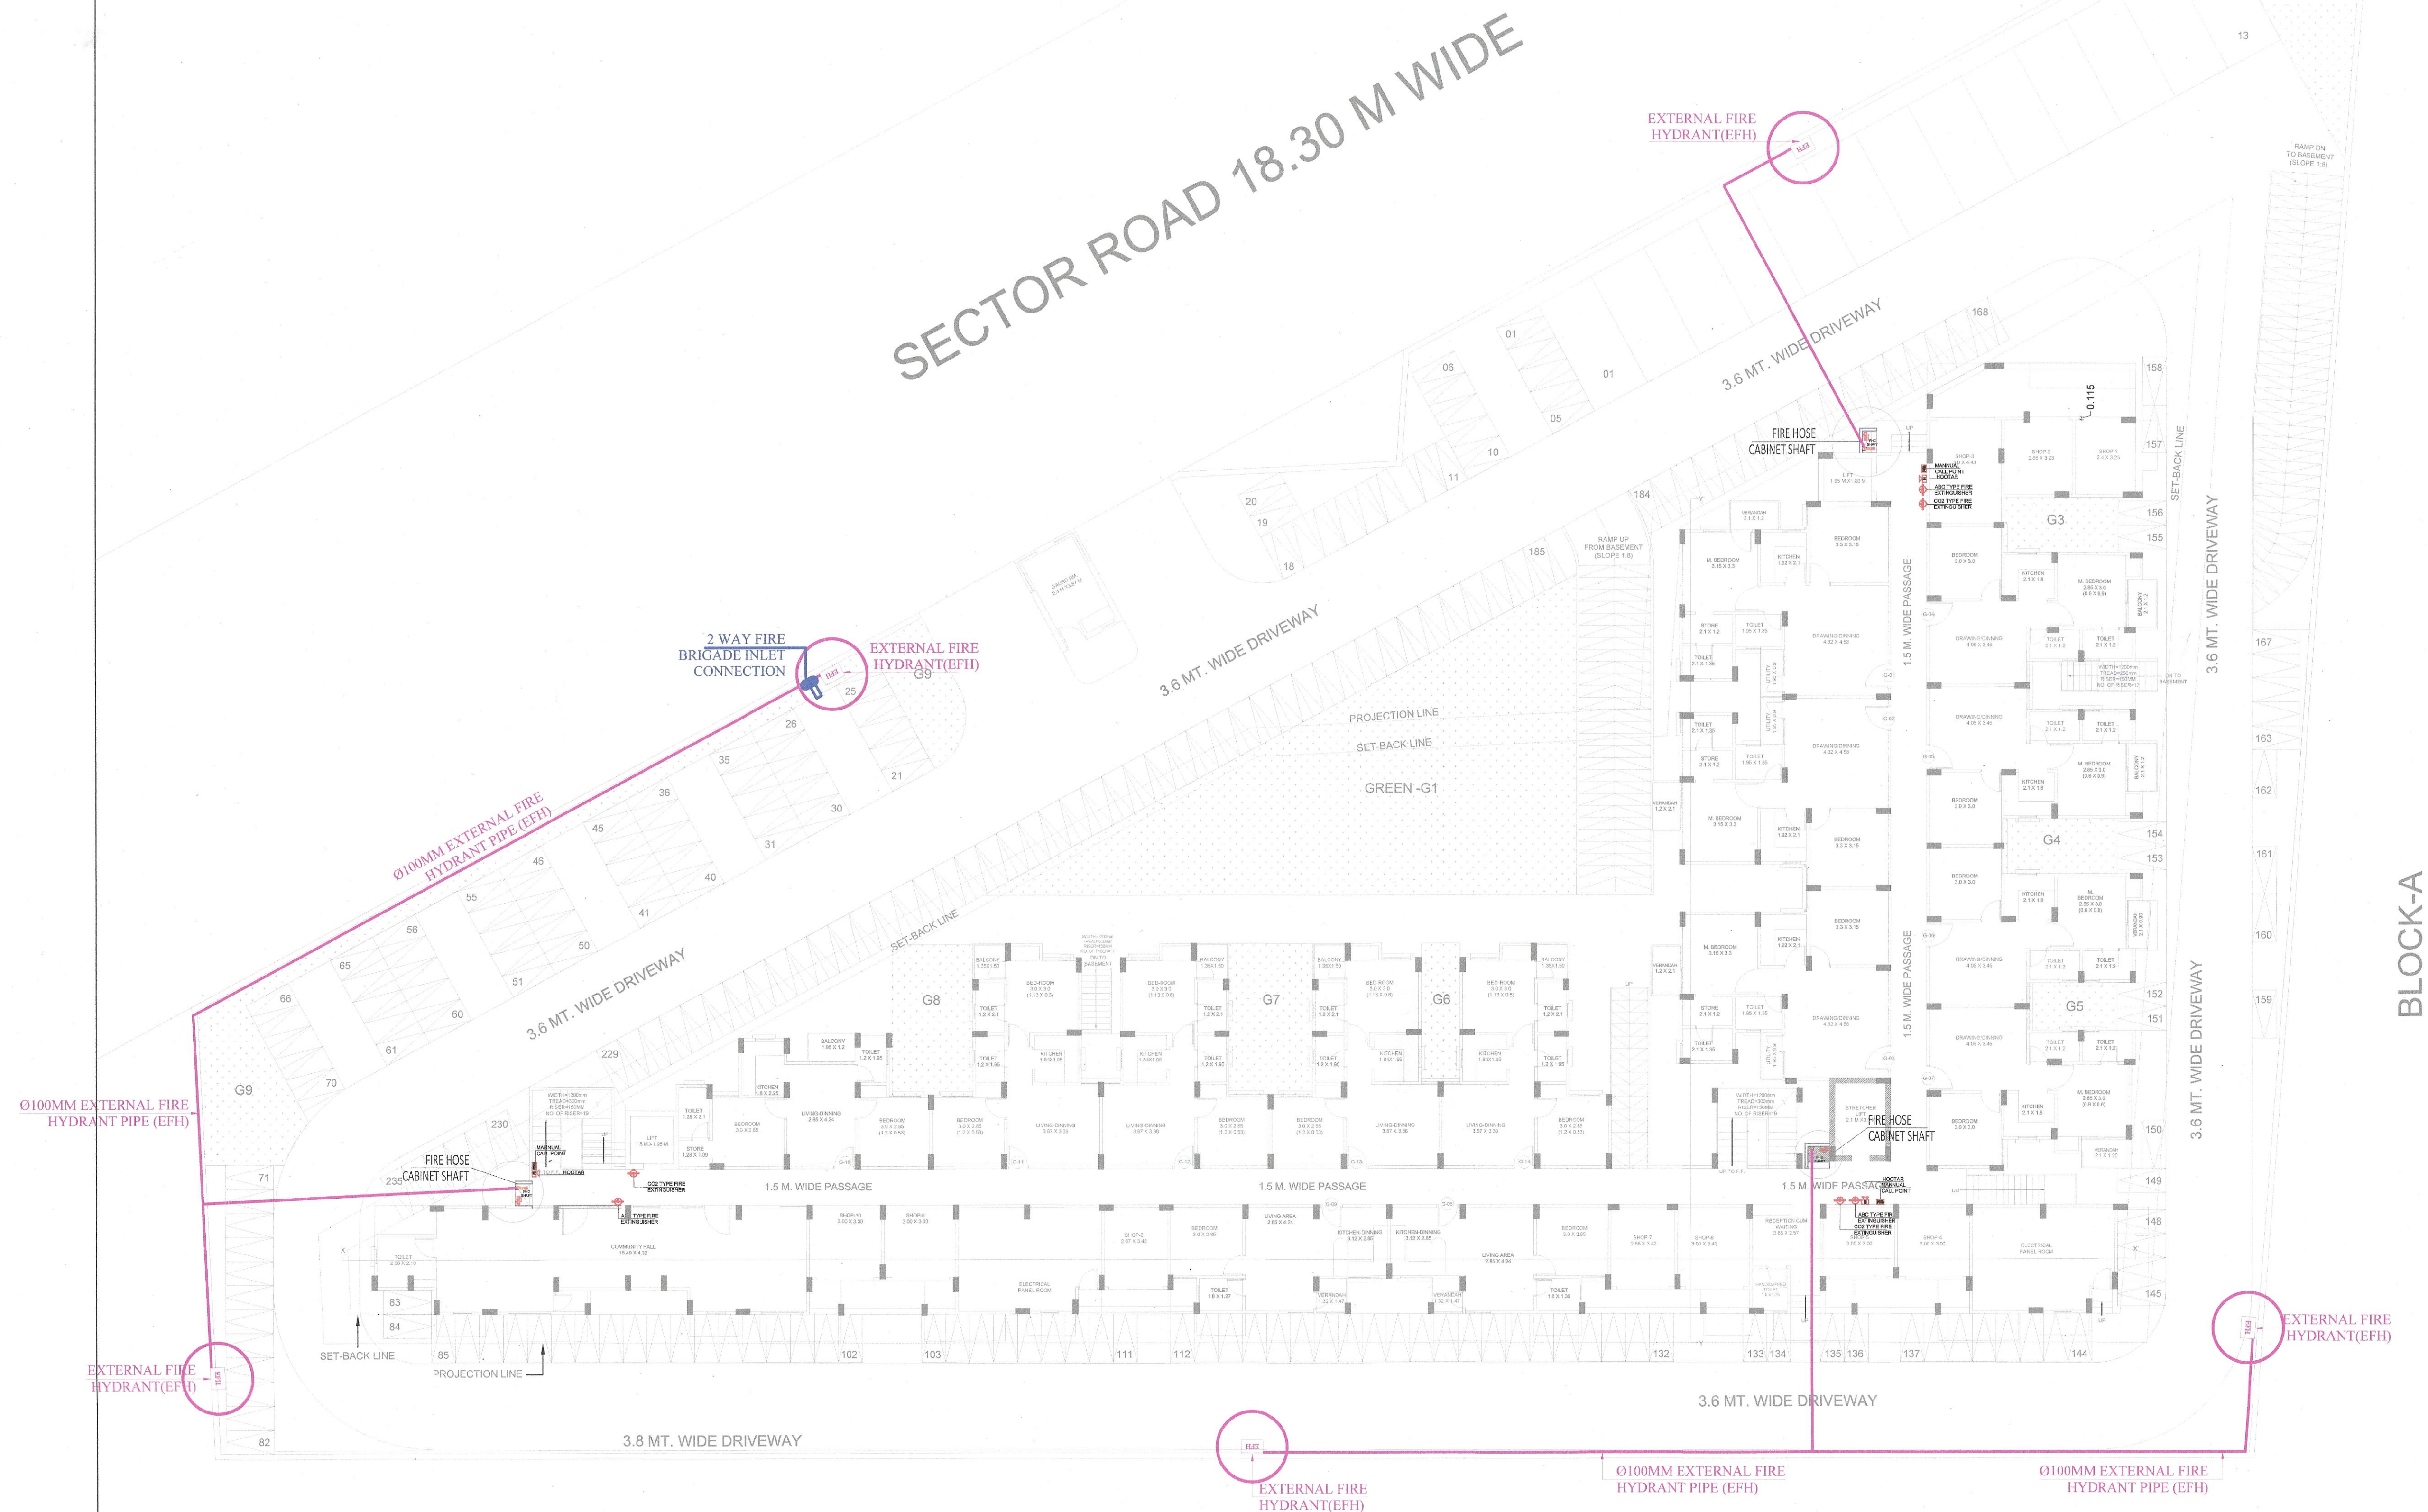

NOTE:- DRAWING APPROVAL BY EMPANELLED ARCHITECT ACCORDING TO LETTER NO. क्र . प.18(36) नविनि /एनएचपी/ 2014/ पार्ट DATED 31 MAY 2017

DRAWING TYPE:-

PROJECT:-

TITLE:-

MEP Consultancy

SUBMISSION DRAWINGS

PROPOSED AFFORDABLE HOUSING
KHASRA NO. 622 & 631
AT VILLAGE NARSINGHPURA URF RIKSHA ,
TEHSIL SANGANER, JAIPUR.

GROUND FLOOR PLAN
EXTERNAL FIRE HYDRANT
PIPE ROUTING PLAN
(BLOCK-A,B) FIRE DRAWING.

SCALE:- 1: 200

DATE:- 10-10-23

PILLARPLUS PVT LTD-The New Age MEP Consultancy Firm
Plot No. 45,46 guru Jambheshwar Nagar A,
Vijay Dwar, Gandhipath, Jaipur-302021
JAIPUR | GURGAON | BANGLORE
E-mail: contact@pillarplus.com | Contact No: +91-9799858301 | Website: www.pillarplus.com

