


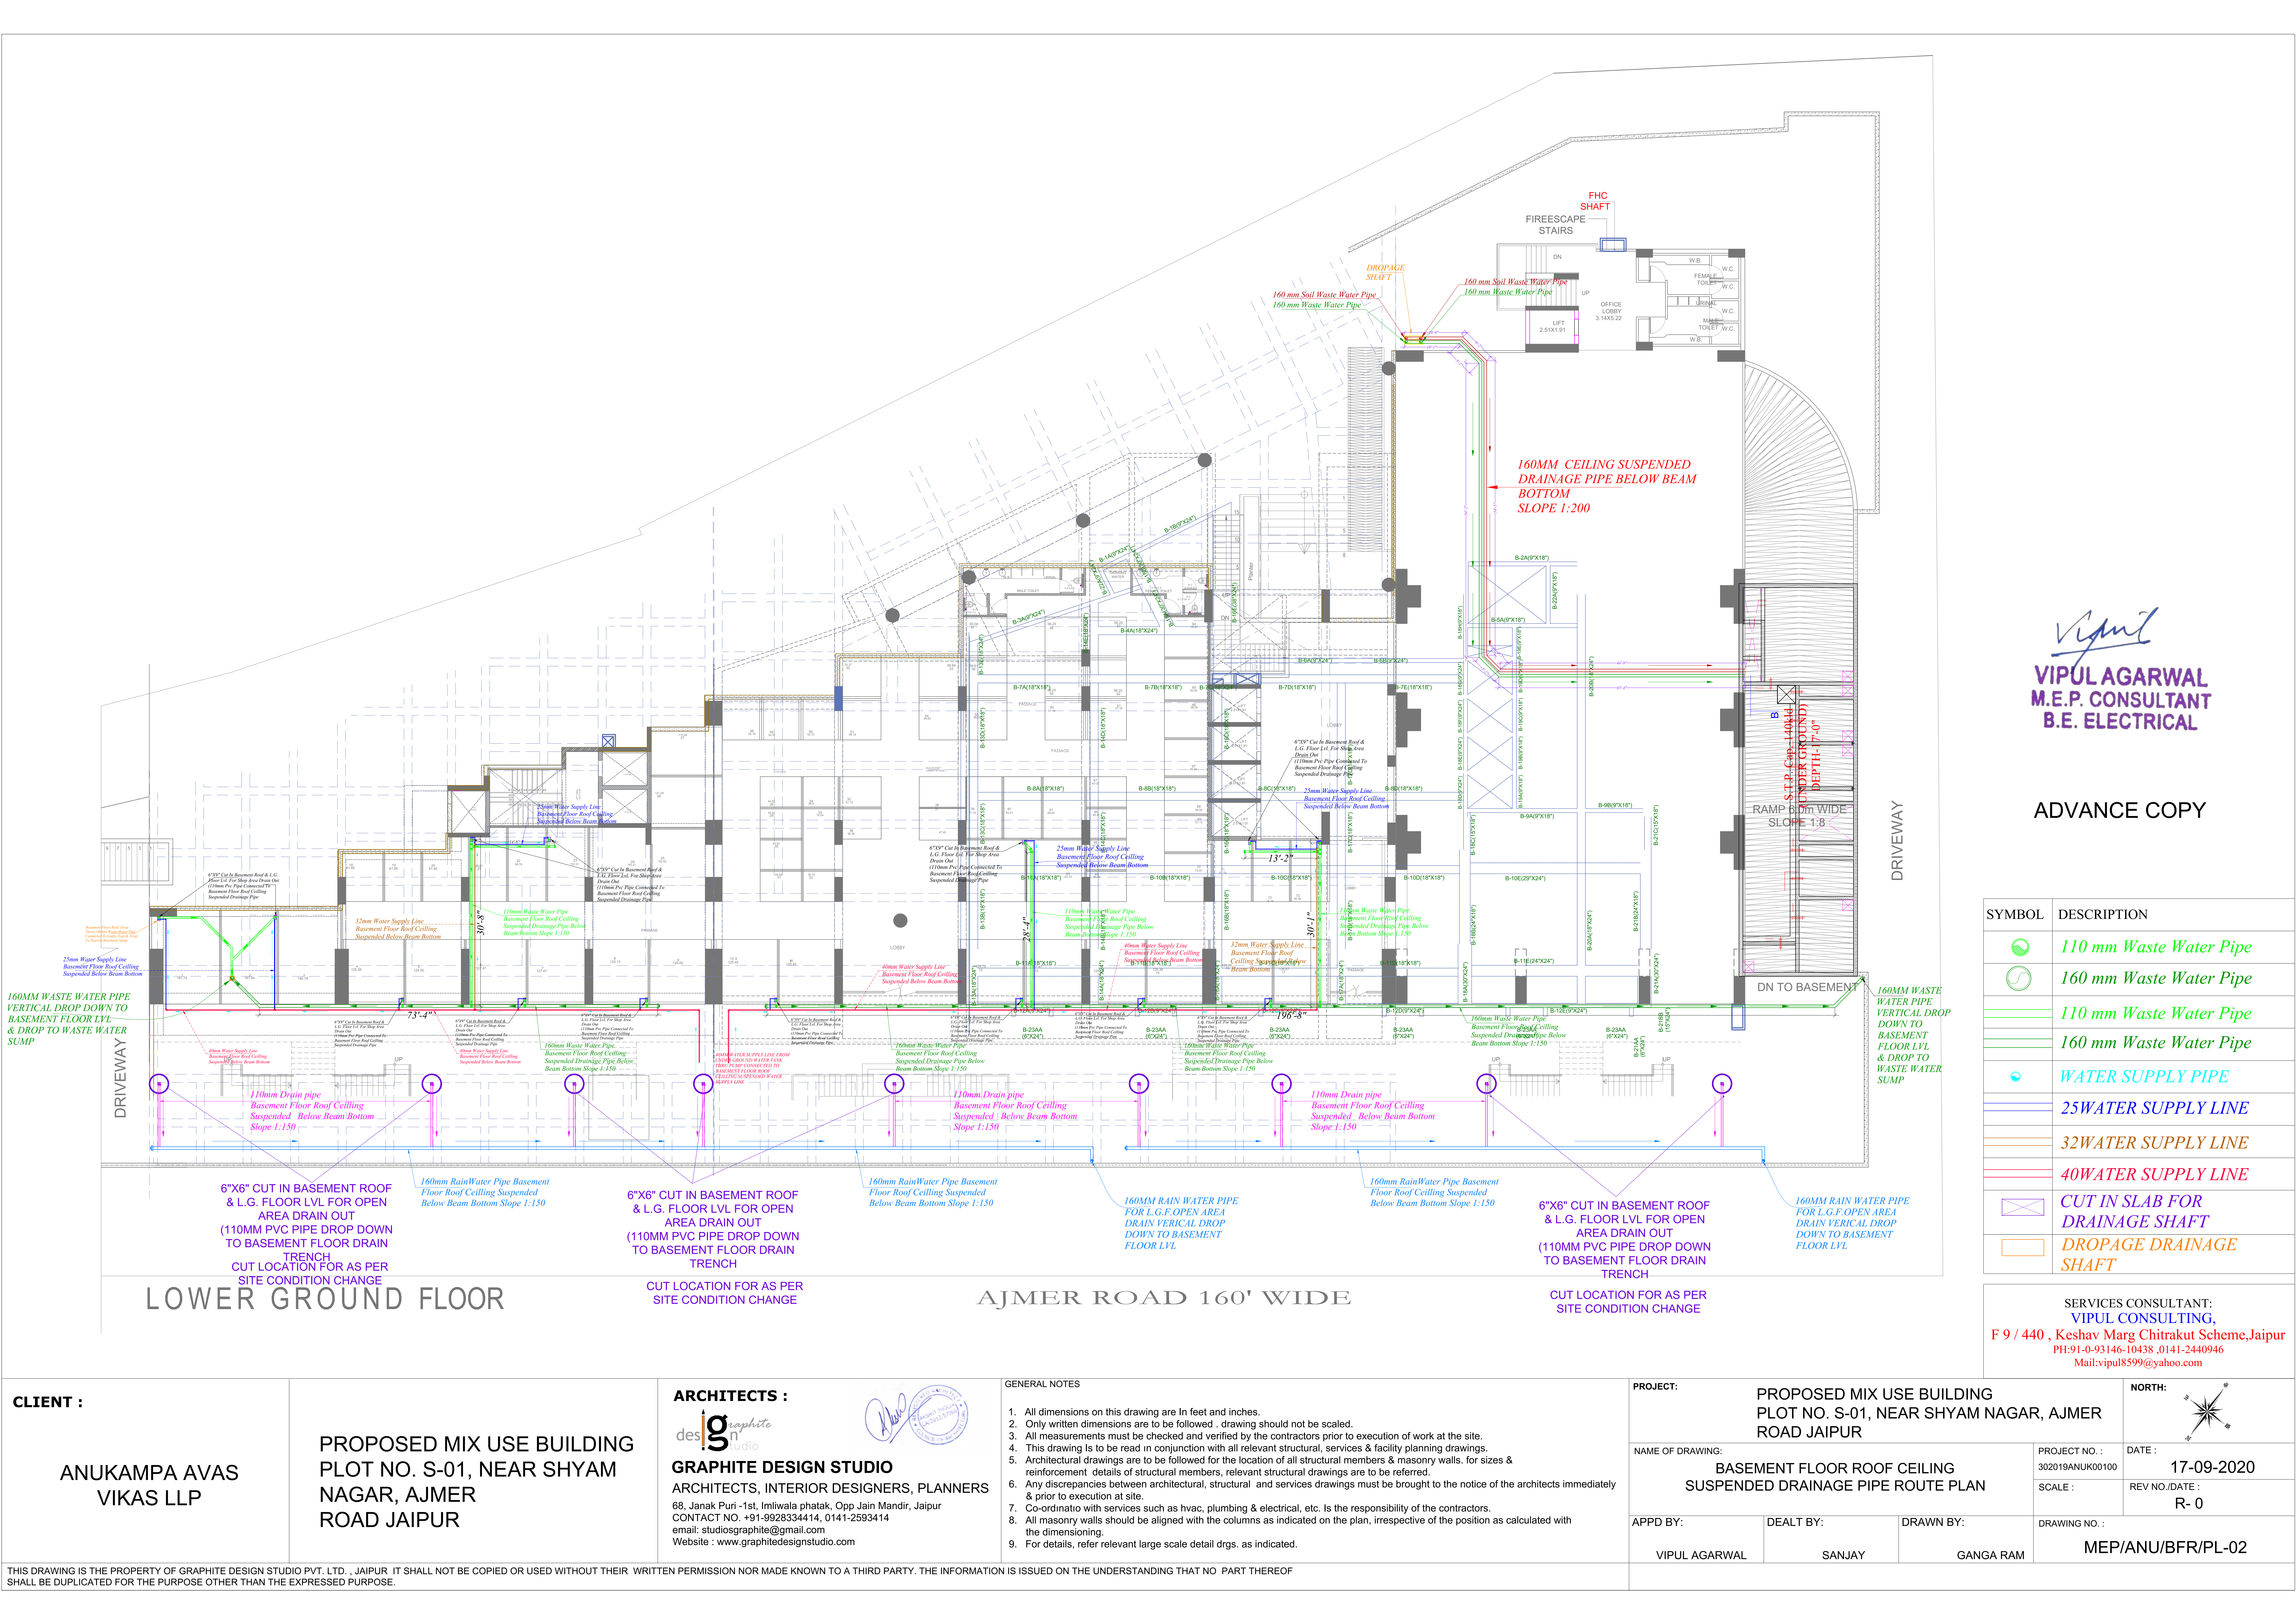

Vipul
VIPUL AGARWAL
M.E.P. CONSULTANT
B.E. ELECTRICAL

ADVANCE COPY

SYMBOL	DESCRIPTION
	110 mm Waste Water Pipe
	160 mm Waste Water Pipe
	110 mm Waste Water Pipe
	160 mm Waste Water Pipe
	WATER SUPPLY PIPE
	25mm WATER SUPPLY LINE
	32mm WATER SUPPLY LINE
	40mm WATER SUPPLY LINE
	CUT IN SLAB FOR DRAINAGE SHAFT
	DROPAGE DRAINAGE SHAFT

SERVICES CONSULTANT:
VIPUL CONSULTING,
F 9 / 440 , Keshav Marg Chitrakut Scheme,Jaipur
PH:91-0-93146-10438 ,0141-2440946
Mail:vipul8599@yahoo.com

CLIENT :

ANUKAMPA AVAS
VIKAS LLP

PROPOSED MIX USE BUILDING
PLOT NO. S-01, NEAR SHYAM
NAGAR, AJMER
ROAD JAIPUR

ARCHITECTS :
desⁱgraphite
studio
GRAPHITE DESIGN STUDIO
ARCHITECTS, INTERIOR DESIGNERS, PLANNERS
68, Janak Puri -1st, Imliwala phatak, Opp Jain Mandir, Jaipur
CONTACT NO. +91-9928334414, 0141-2593414
email: studiosgraphite@gmail.com
Website : www.graphitedesignstudio.com

GENERAL NOTES
1. All dimensions on this drawing are in feet and inches.
2. Only written dimensions are to be followed. Drawing should not be scaled.
3. All measurements must be checked and verified by the contractors prior to execution of work at the site.
4. This drawing is to be read in conjunction with all relevant structural, services & facility planning drawings.
5. Architectural drawings are to be followed for the location of all structural members & masonry walls. For sizes & reinforcement details of structural members, relevant structural drawings are to be referred.
6. Any discrepancies between architectural, structural and services drawings must be brought to the notice of the architects immediately & prior to execution at site.
7. Co-ordination with services such as hvac, plumbing & electrical, etc. is the responsibility of the contractors.
8. All masonry walls should be aligned with the columns as indicated on the plan, irrespective of the position as calculated with the dimensioning.
9. For details, refer relevant large scale detail drawings as indicated.

PROJECT: PROPOSED MIX USE BUILDING
PLOT NO. S-01, NEAR SHYAM NAGAR, AJMER
ROAD JAIPUR
NAME OF DRAWING: BASEMENT FLOOR ROOF CEILING
SUSPENDED DRAINAGE PIPE ROUTE PLAN
APPD BY: VIPUL AGARWAL
DEALT BY: SANJAY
DRAWN BY: GANGA RAM

NORTH:
17-09-2020
REV NO./DATE :
R-0
DRAWING NO. :
MEP/ANU/BFR/PL-02

Vipul
VIPUL AGARWAL
M.E.P. CONSULTANT
B.E. ELECTRICAL


LEGENDS:-

	RAIN WATER CHAMBER 450X450 MM
	RAIN WATER CHAMBER 600X600 MM
	RAIN WATER CHAMBER 750X600 MM
	RAIN WATER CHAMBER 900X750 MM

PIPES & SLOPE DETAIL :-


	Ø 250mm RAIN WATER PIPE SLOPE 1:200
	Ø 250mm RAIN WATER PIPE SLOPE 1:200
	Ø 200mm RAIN WATER PIPE SLOPE 1:200
	Ø 160mm RAIN WATER PIPE SLOPE 1:200

SERVICES CONSULTANT:
VIPUL CONSULTING,
F 9 / 440 , Keshav Marg Chitrakut
Scheme,Jaipur
PH:91-0-93146-10438 ,0141-2440946
Mail:vipul8599@yahoo.com
REV. NO. 01 DATE: 14-09-2020

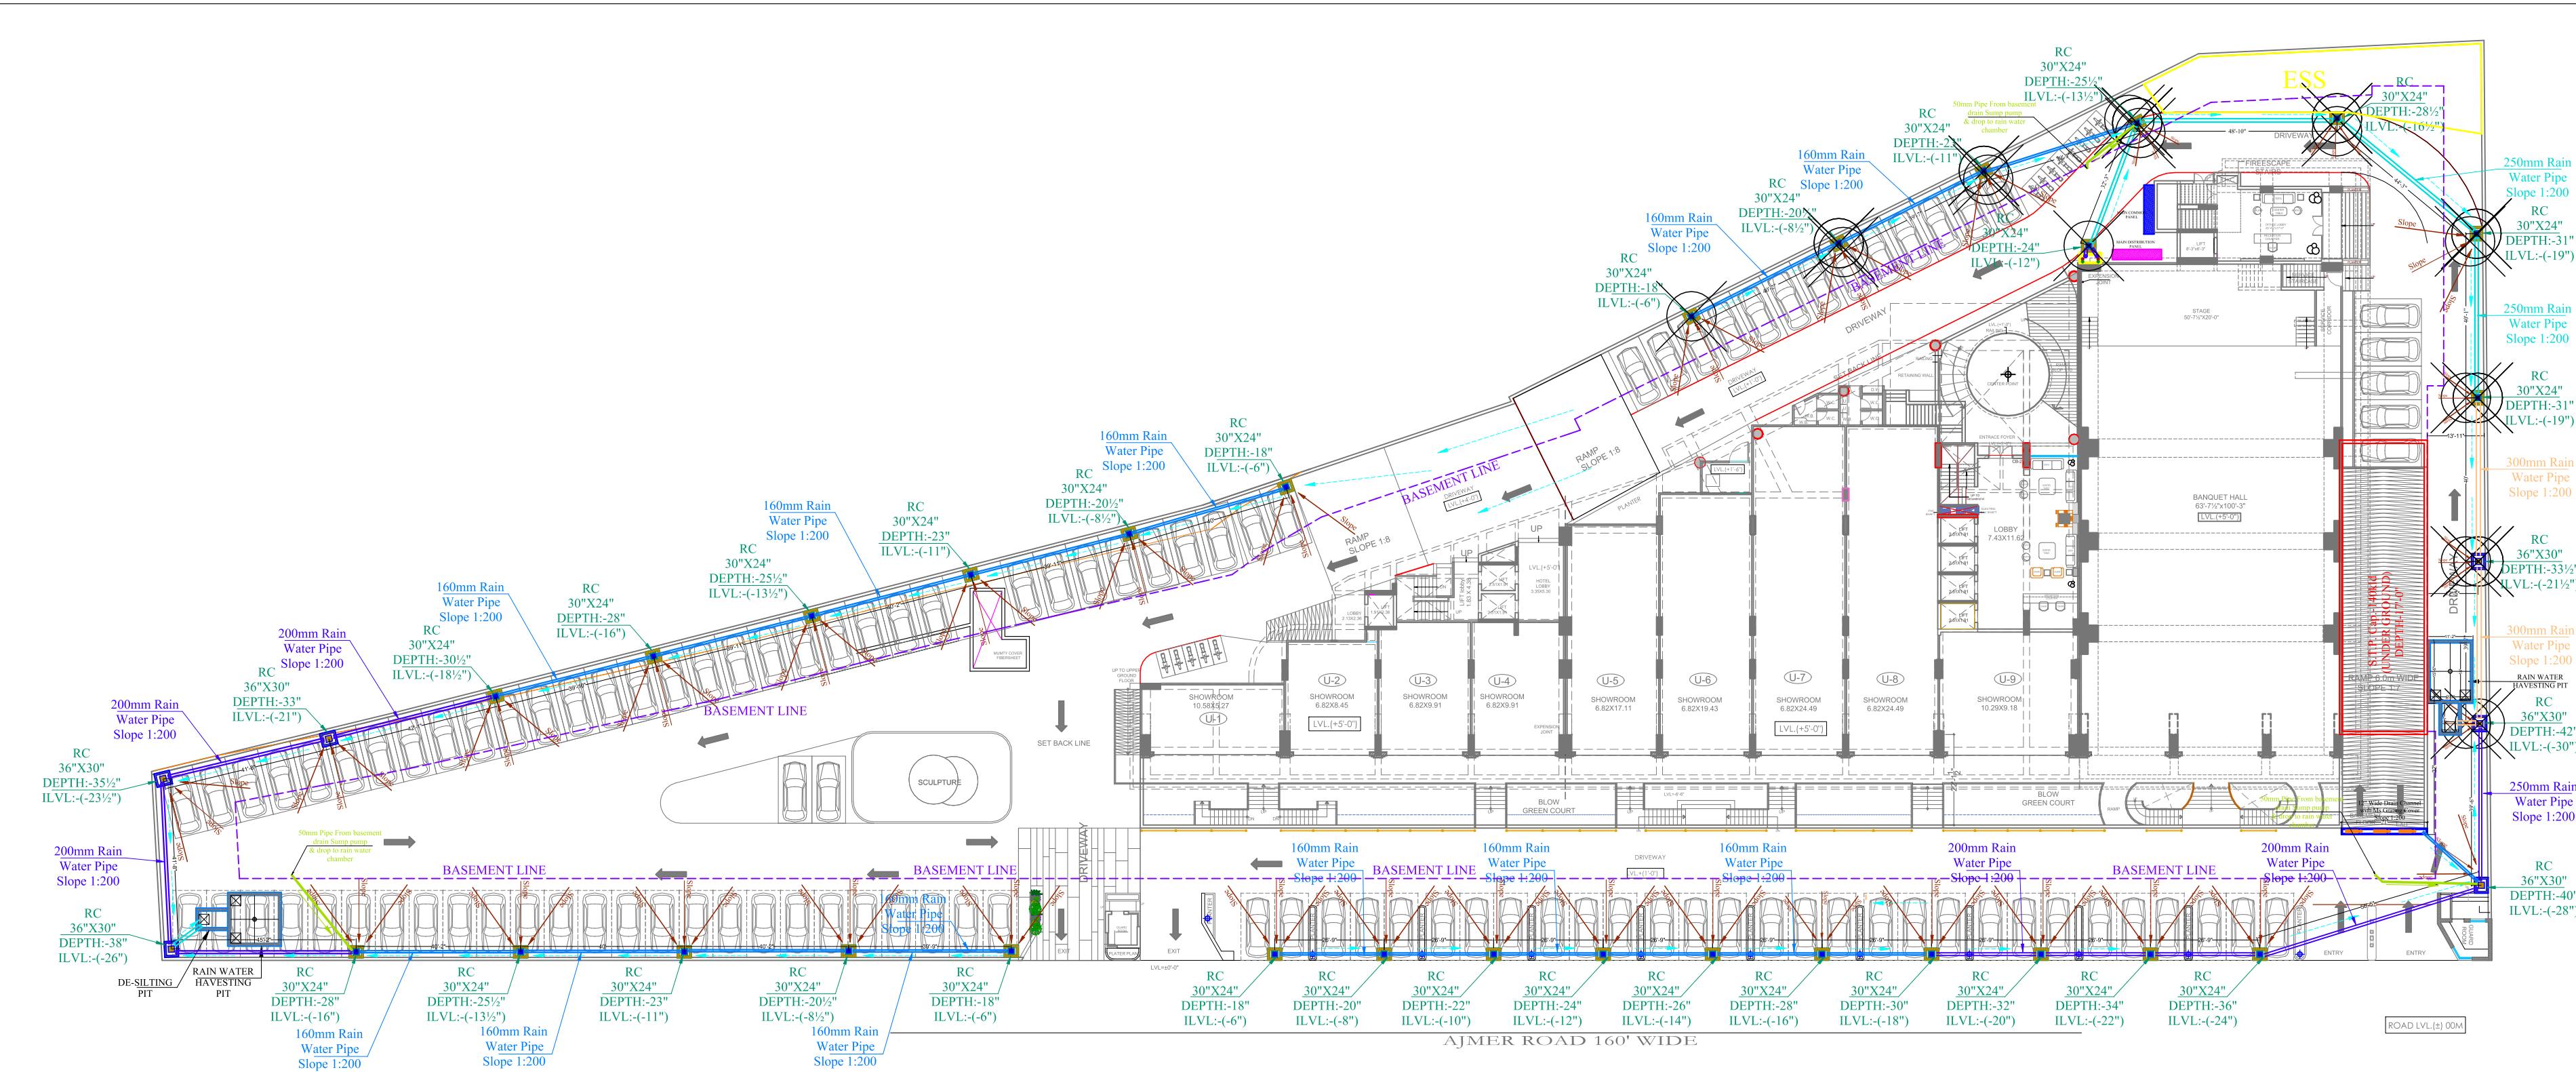

CLIENT : ANUKAMPA AVAS VIKAS LLP		ARCHITECTS :  GRAPHITE DESIGN STUDIO ARCHITECTS, INTERIOR DESIGNERS, PLANNERS 68, Janak Puri -1st, Imliwala phatak, Opp Jain Mandir, Jaipur CONTACT NO. +91-9928334414, 0141-2593414 email: studiosgraphite@gmail.com Website : www.graphitedesignstudio.com 		GENERAL NOTES 1. All dimensions on this drawing are In feet and inches. 2. Only written dimensions are to be followed . drawing should not be scaled. 3. All measurements must be checked and verified by the contractors prior to execution of work at the site. 4. This drawing Is to be read in conjunction with all relevant structural, services & facility planning drawings. 5. Architectural drawings are to be followed for the location of all structural members & masonry walls. for sizes & reinforcement details of structural members, relevant structural drawings are to be referred. 6. Any discrepancies between architectural, structural and services drawings must be brought to the notice of the architects immediately & prior to execution at site. 7. Co-ordinatio with services such as hvac, plumbing & electrical, etc. Is the responsibility of the contractors. 8. All masonry walls should be aligned with the columns as indicated on the plan, irrespective of the position as calculated with the dimensioning. 9. For details, refer relevant large scale detail drgs. as indicated.		PROJECT: PROPOSED MIX USE BUILDING PLOT NO. S-01, NEAR SHYAM NAGAR, AJMER ROAD JAIPUR NORTH: 	
		NAME OF DRAWING: EXTERNAL RAIN WATER PIPE ROUTE PLAN		PROJECT NO. : 302019ANUK00100 DATE : 14-09-2020 SCALE : REV NO./DATE : 14-09-2020			
		DRAWN BY: GANGA RAM		CHK. BY: SANJAY DRAWING NO. : MEP/EX.RWP-01			
		DRAWN BY: \\dataserver\Projects\COMPLETED\Anukampa Soda\vipul Ji\6 March 2024\ANUKAMPA SODALA REV.EXTERNAL. RA					

THIS DRAWING IS THE PROPERTY OF GRAPHITE DESIGN STUDIO PVT. LTD., JAIPUR. IT SHALL NOT BE COPIED OR USED WITHOUT THEIR WRITTEN PERMISSION NOR MADE KNOWN TO A THIRD PARTY. THE INFORMATION IS ISSUED ON THE UNDERSTANDING THAT NO PART THEREOF SHALL BE DUPLICATED FOR THE PURPOSE OTHER THAN THE EXPRESSED PURPOSE.

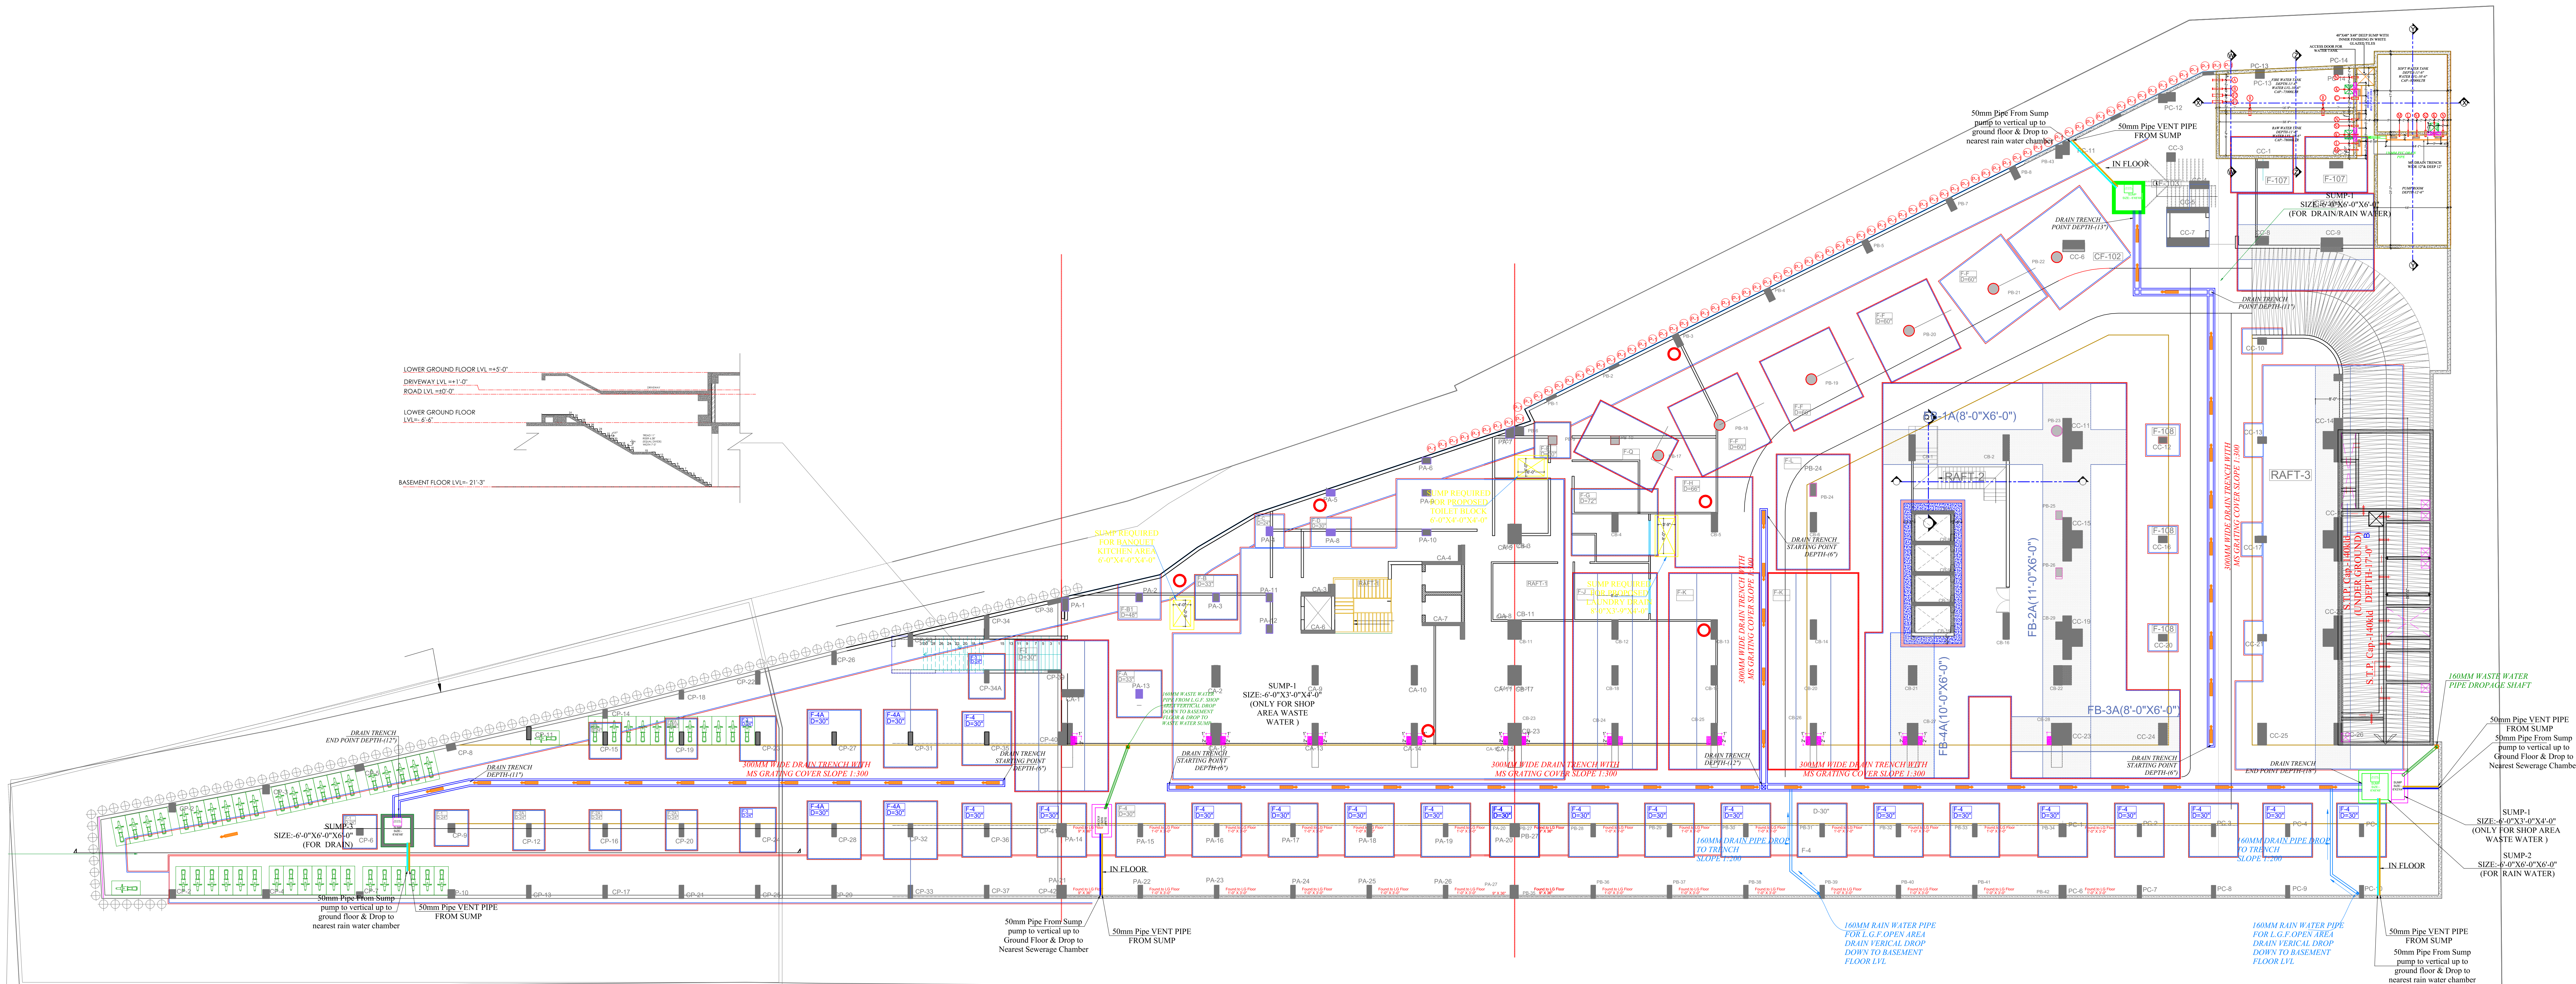

CLIENT :

ANUKAMPA AVAS
VIKAS LLP

PROPOSED MIX USE BUILDING
PLOT NO. S-01, NEAR SHYAM
NAGAR, AJMER
ROAD JAIPUR

ARCHITECTS :

des^{ign}
studio

GRAPHITE DESIGN STUDIO

ARCHITECTS, INTERIOR DESIGNERS, PLANNERS
68, Janak Puri -1st, Imliwala phatak, Opp Jain Mandir, Jaipur
CONTACT NO. +91-9928334414, 0141-2593414
email: studiosgraphite@gmail.com
Website : www.graphitedesignstudio.com

GENERAL NOTES

1. All dimensions on this drawing are in feet and inches.
2. Only written dimensions are to be followed . drawing should not be scaled.
3. All measurements must be checked and verified by the contractors prior to execution of work at the site.
4. This drawing is to be read in conjunction with all relevant structural, services & facility planning drawing.
5. Architectural drawings are to be followed for the location of all structural members & masonry walls. for sizes & reinforcement details of structural members, relevant structural drawings are to be referred.
6. Any discrepancies between architectural, structural and services drawings must be brought to the notice of the architects immediately & prior to execution at site.
7. Co-ordinatio with services such as hvac, plumbing & electrical, etc. is the responsibility of the contractors.
8. All masonry walls should be aligned with the columns as indicated on the plan, irrespective of the position as calculated with the dimensioning.
9. For details, refer relevant large scale detail drgs. as indicated.

VIPUL AGARWAL
M.E.P. CONSULTANT
E.E. ELECTRICAL

SERVICES CONSULTANT:
VIPUL CONSULTING,
F 9 / 440 , Keshav Marg
Chitrakut Scheme,Jaipur
PH:91-0-93146-10438, 0141-2440946
Mail:vipul8599@yahoo.com

PROJECT:

PROPOSED MIX USE BUILDING
PLOT NO. S-01, NEAR SHYAM NAGAR, AJMER
ROAD JAIPUR

NAME OF DRAWING:

BASEMENT FLOOR DRAIN TRENCH &
DRAINAGE PIPE & REQUIRED SUMP PLAN

DRAWN BY:

SANJAY

APPROVED BY:

VIPUL AGARWAL


PROJECT NO. :

302019ANUK00100

SCALE :

DRAWING NO. :

NORTH:

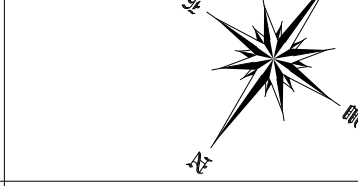

DATE :
29-08-2020

REV NO./DATE :

MEP/ANU/BF/DT-01