

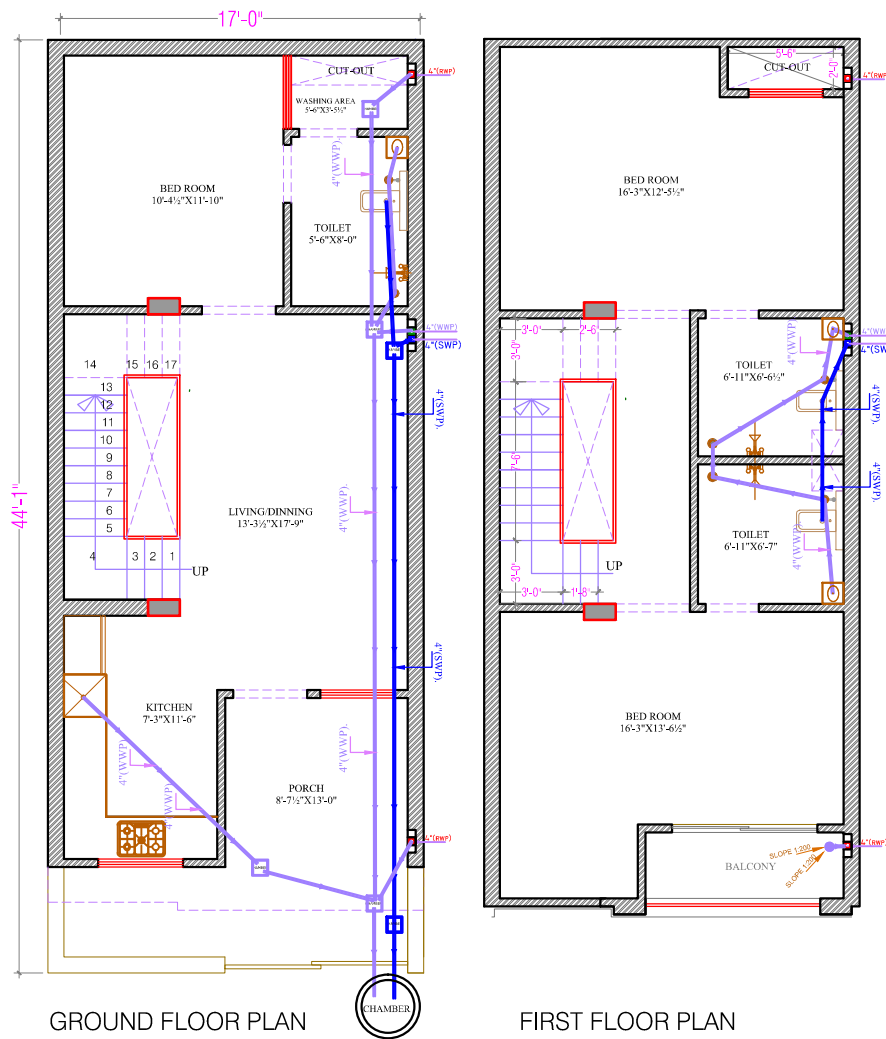


VILLA NO. L-30 PLUMBING PLAN

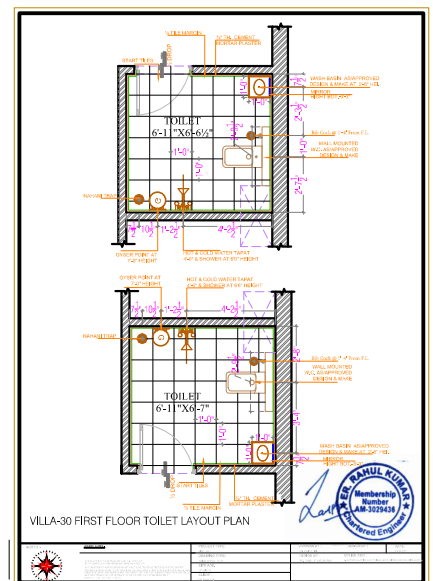







VILLA - 30 SANITARY LAYOUT PLAN

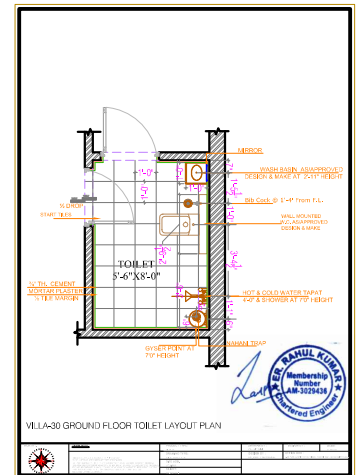









	GENERAL NOTES:		PROJECT TYPE:	DRAWN BY :	DESIGN BY :	DATE:
	THIS DRAWING IS THE PROPERTY OF "SIC" AND NOT YOUR CORRESPONDENCE WITHOUT YOUR PERMISSION. ALL DIMENSIONS ARE TO BE READ AND NOT SCALED - MEASURED FROM THE DRAWING. ALL DIMENSIONS ARE TO BE READ ALONGSIDE ALL RELATED ITEMS. IF ANY DIMENSIONS ARE NOT SHOWN, THEY ARE TO BE READ FROM THE DRAWING OR AT SITE MAY BE MODIFIED BY REFERENCE TO THIS ARCHITECTS.		DRAWING TYPE:	DESIGN BY :	OFFICE ADD :	
			1. SITE PLAN 2. FLOOR PLAN	1. S. K. SINGH 2. S. K. SINGH	1. S. K. SINGH 2. S. K. SINGH	1. S. K. SINGH 2. S. K. SINGH

VILLA - L03 TO L12

SANITARY PLAN

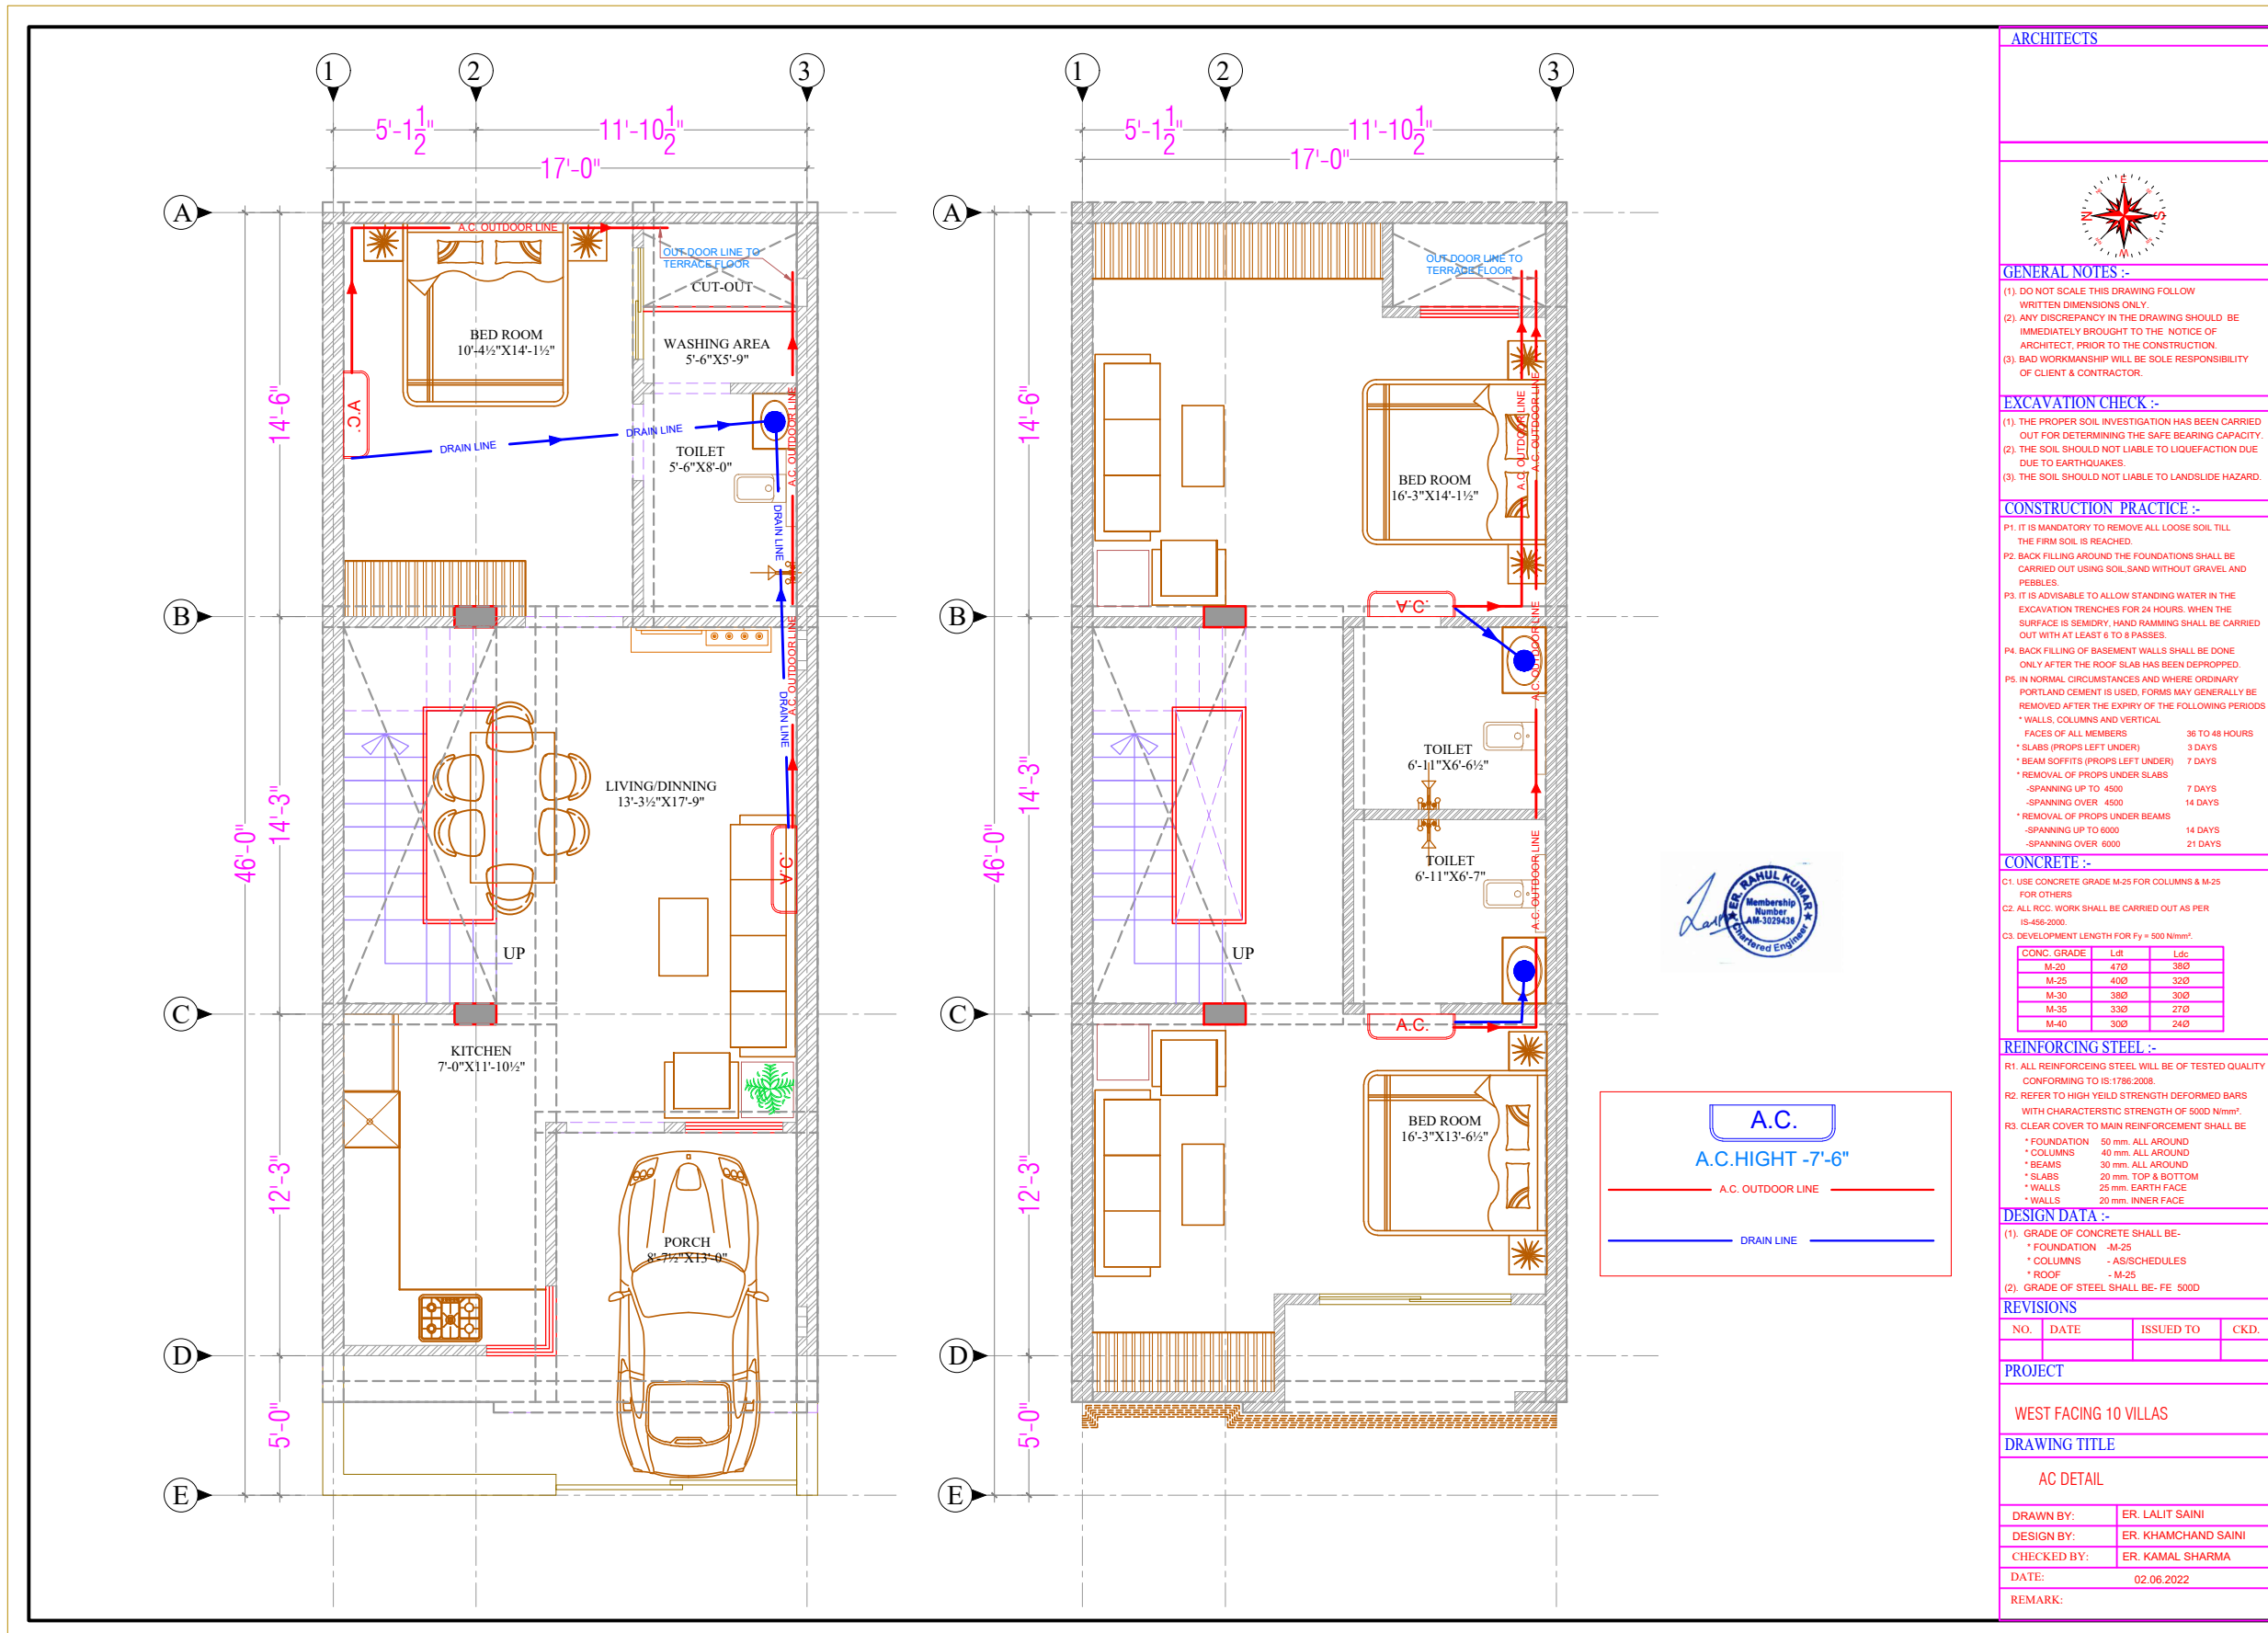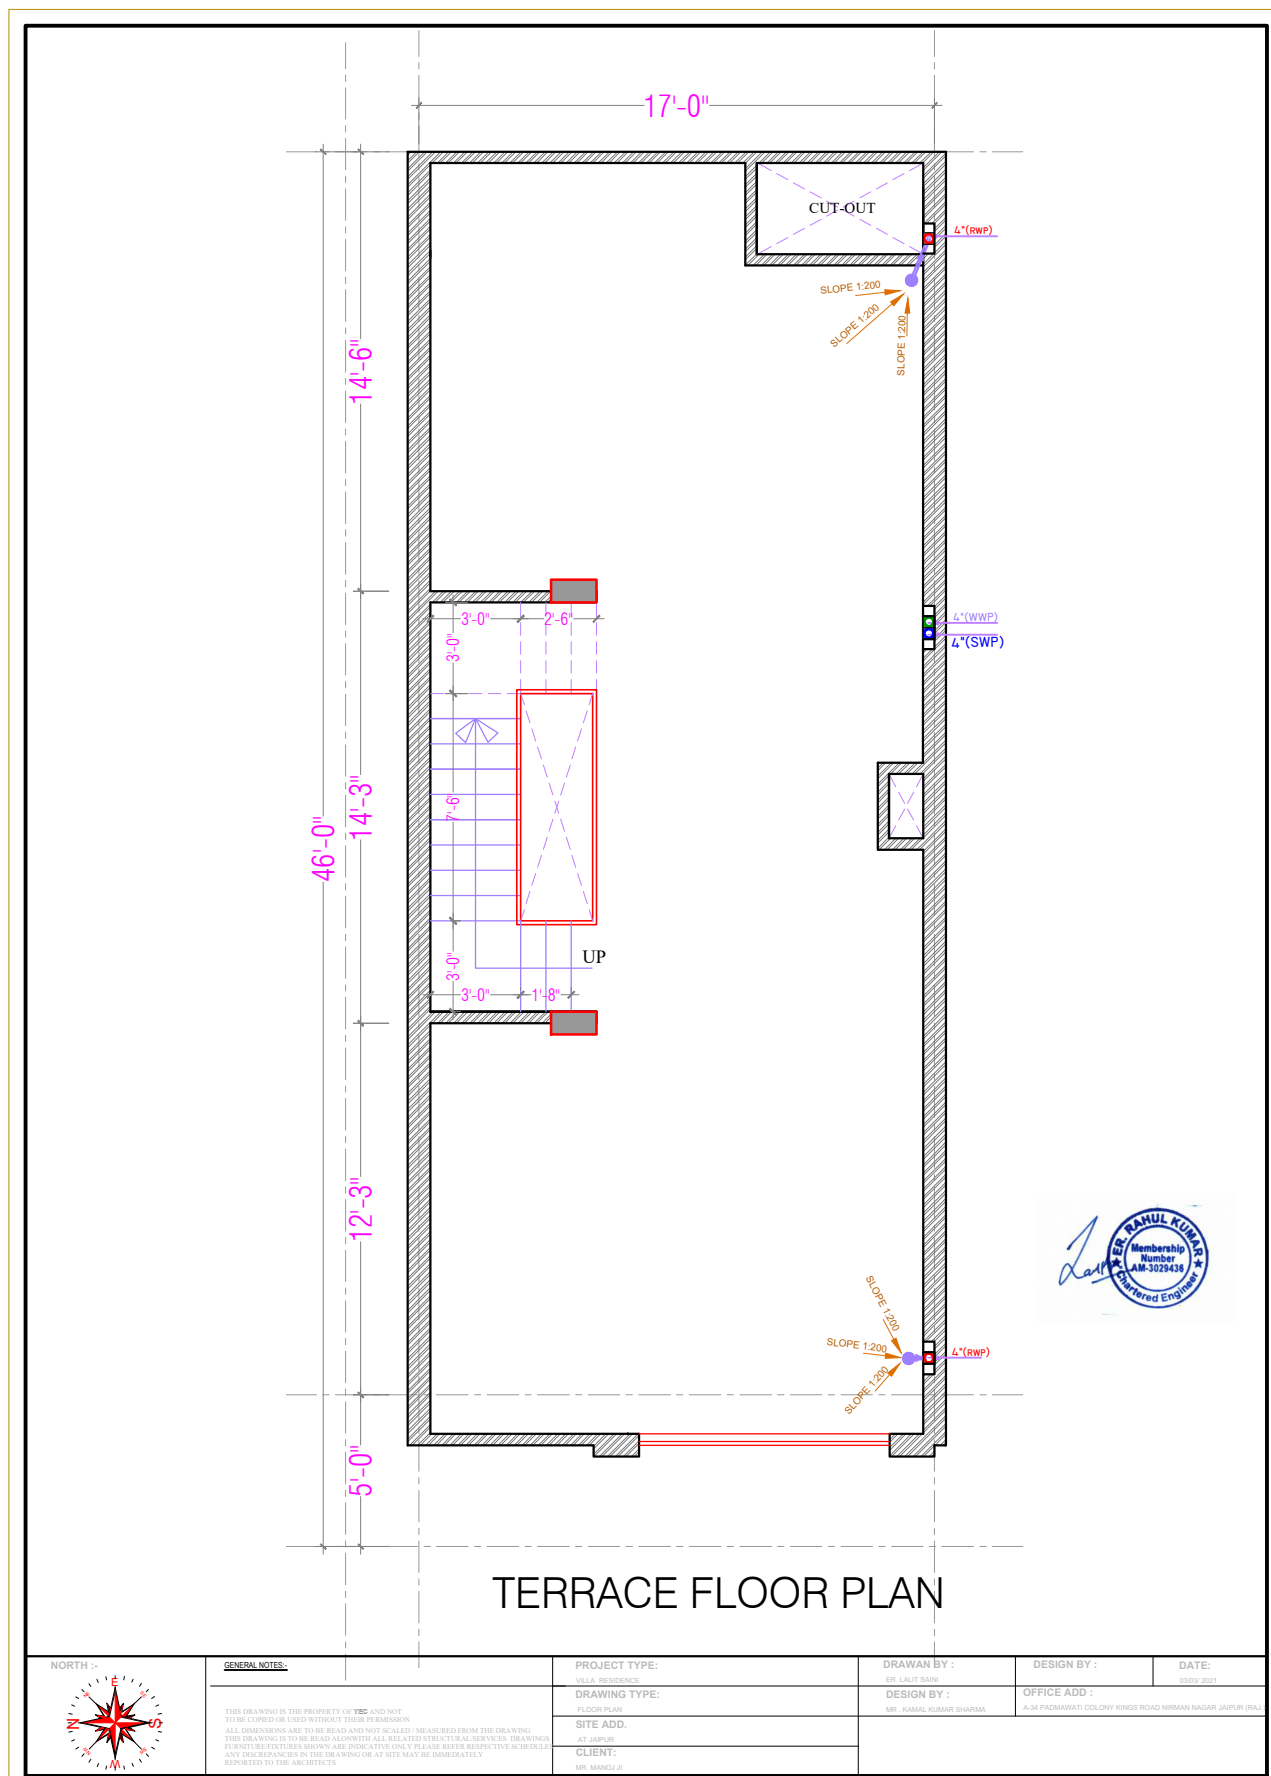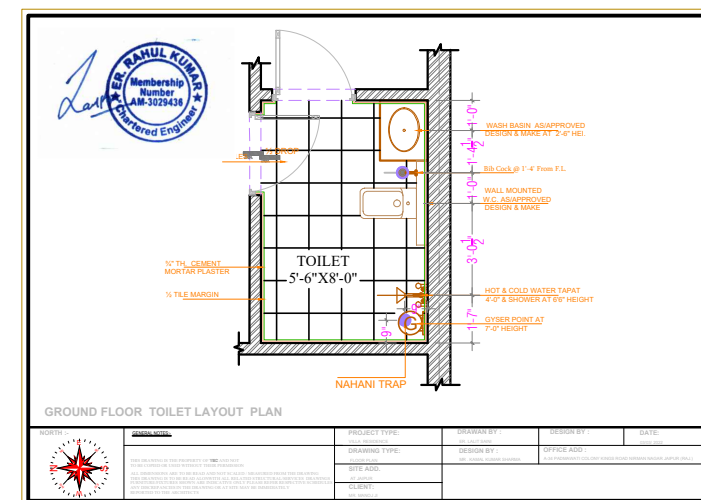
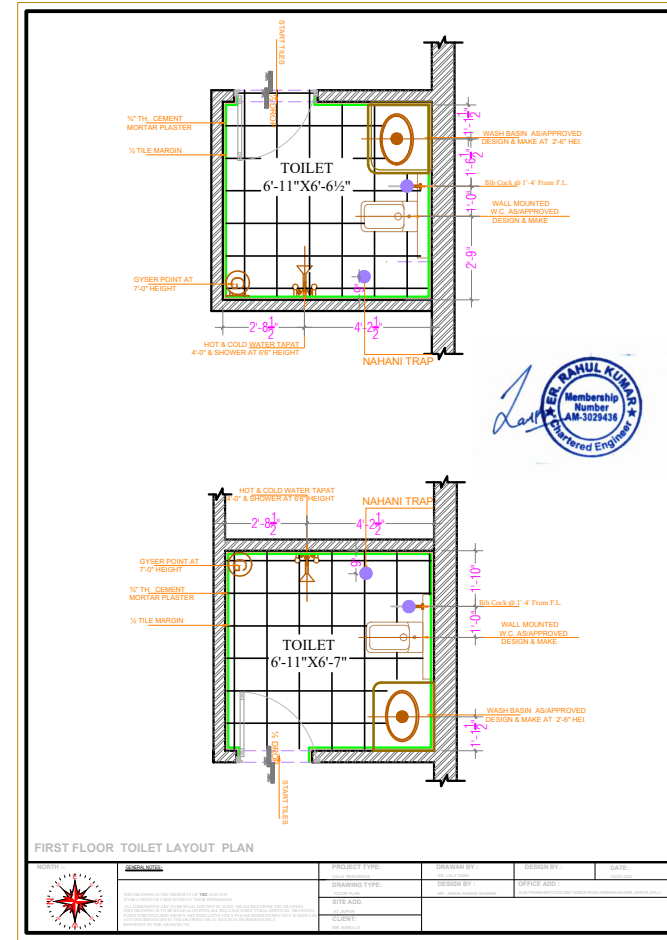
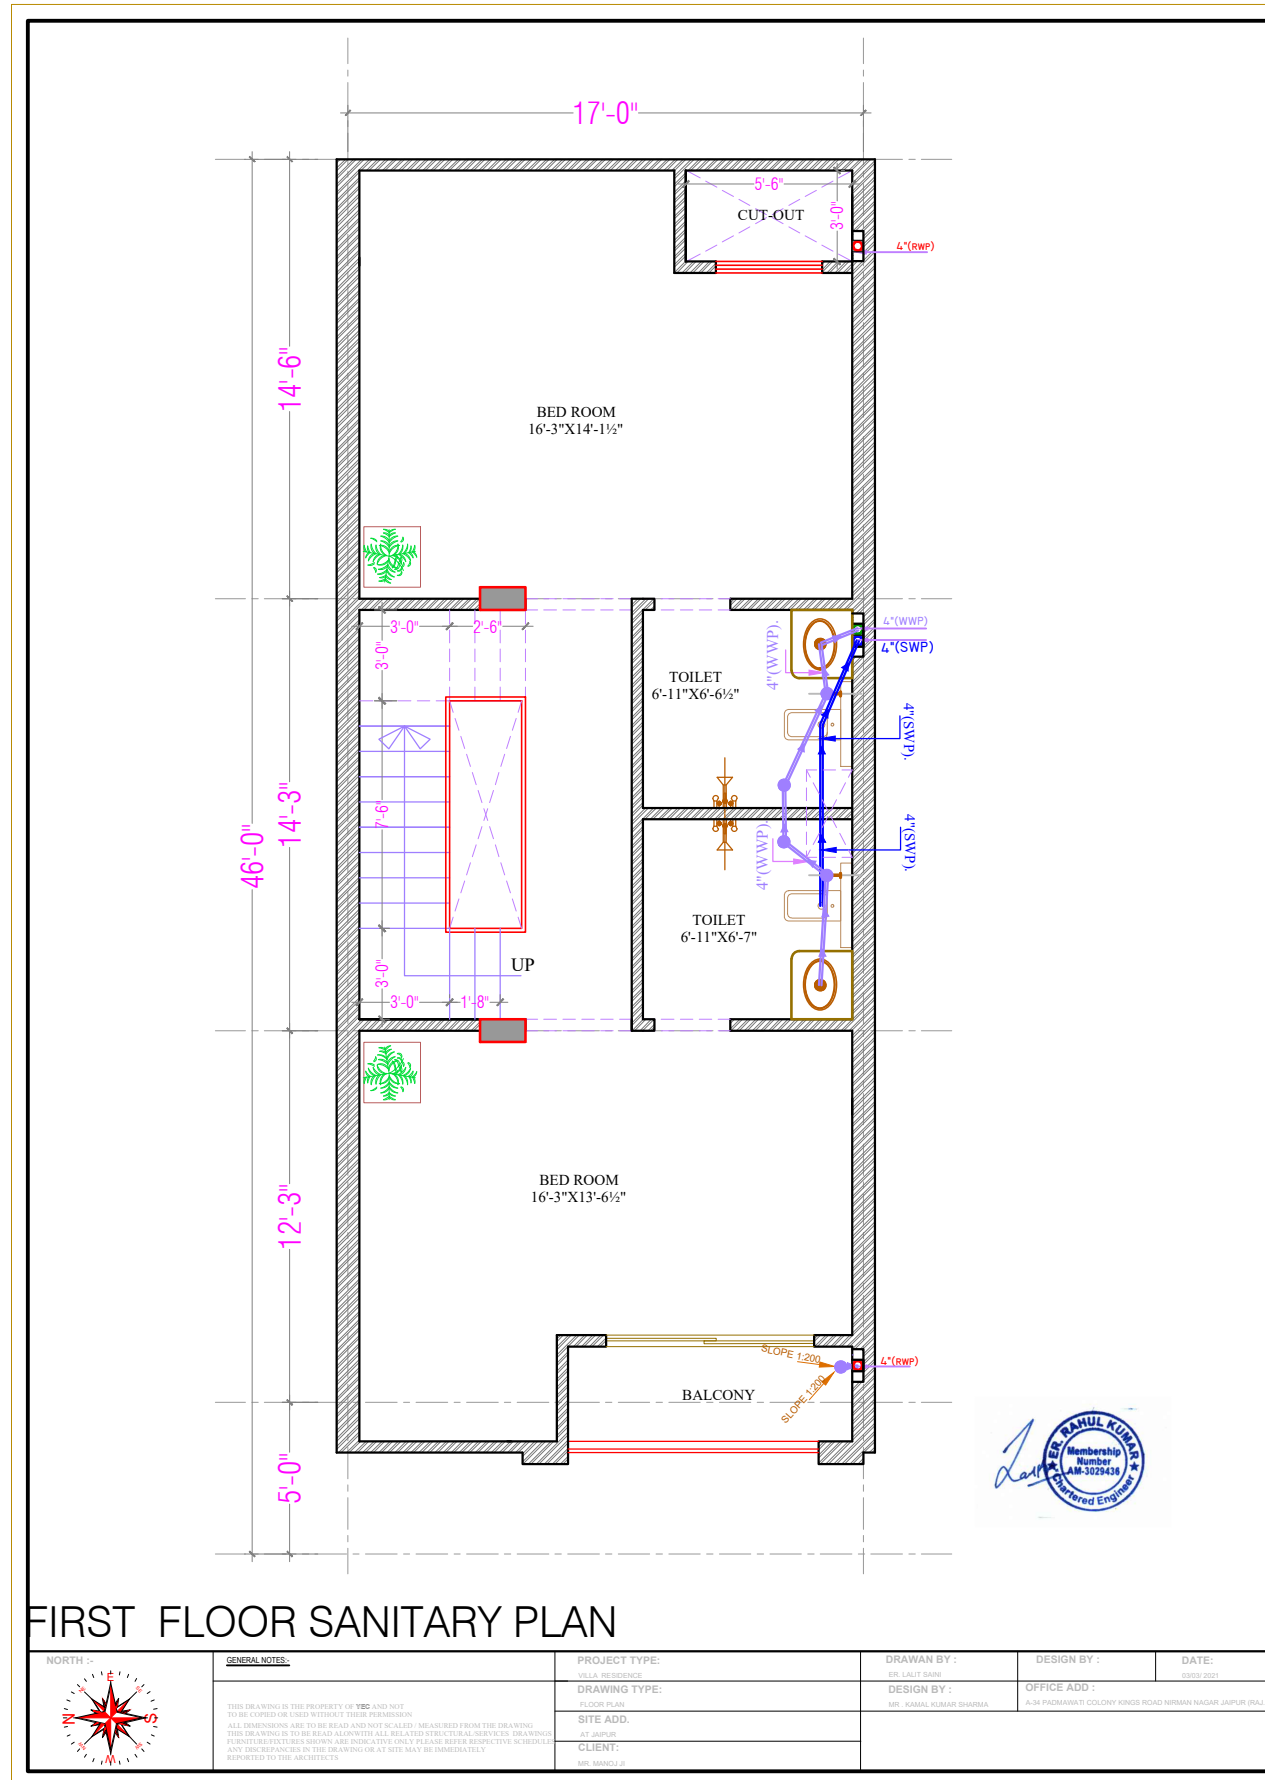
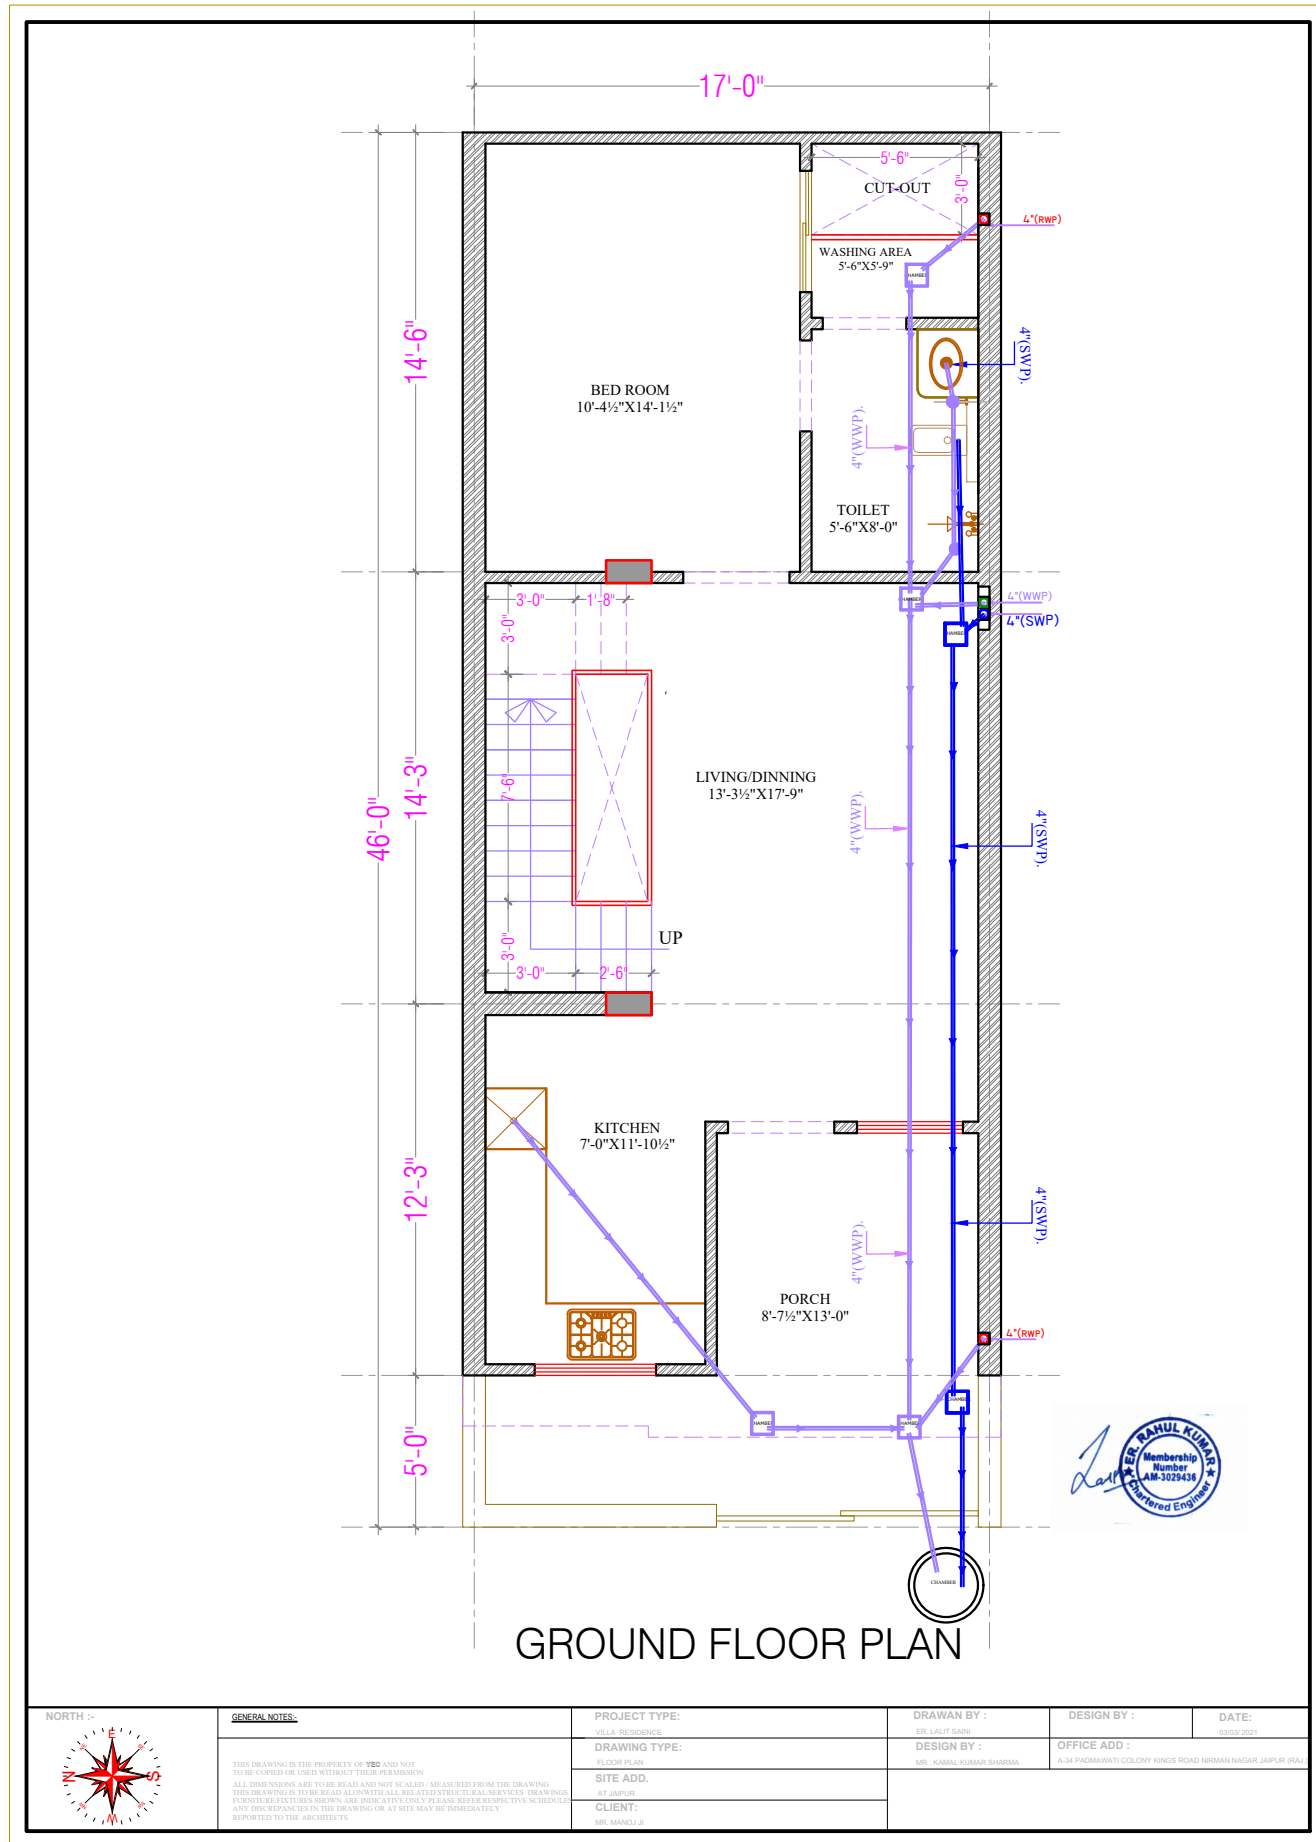


VILLA -L-24
SANITARY PLAN

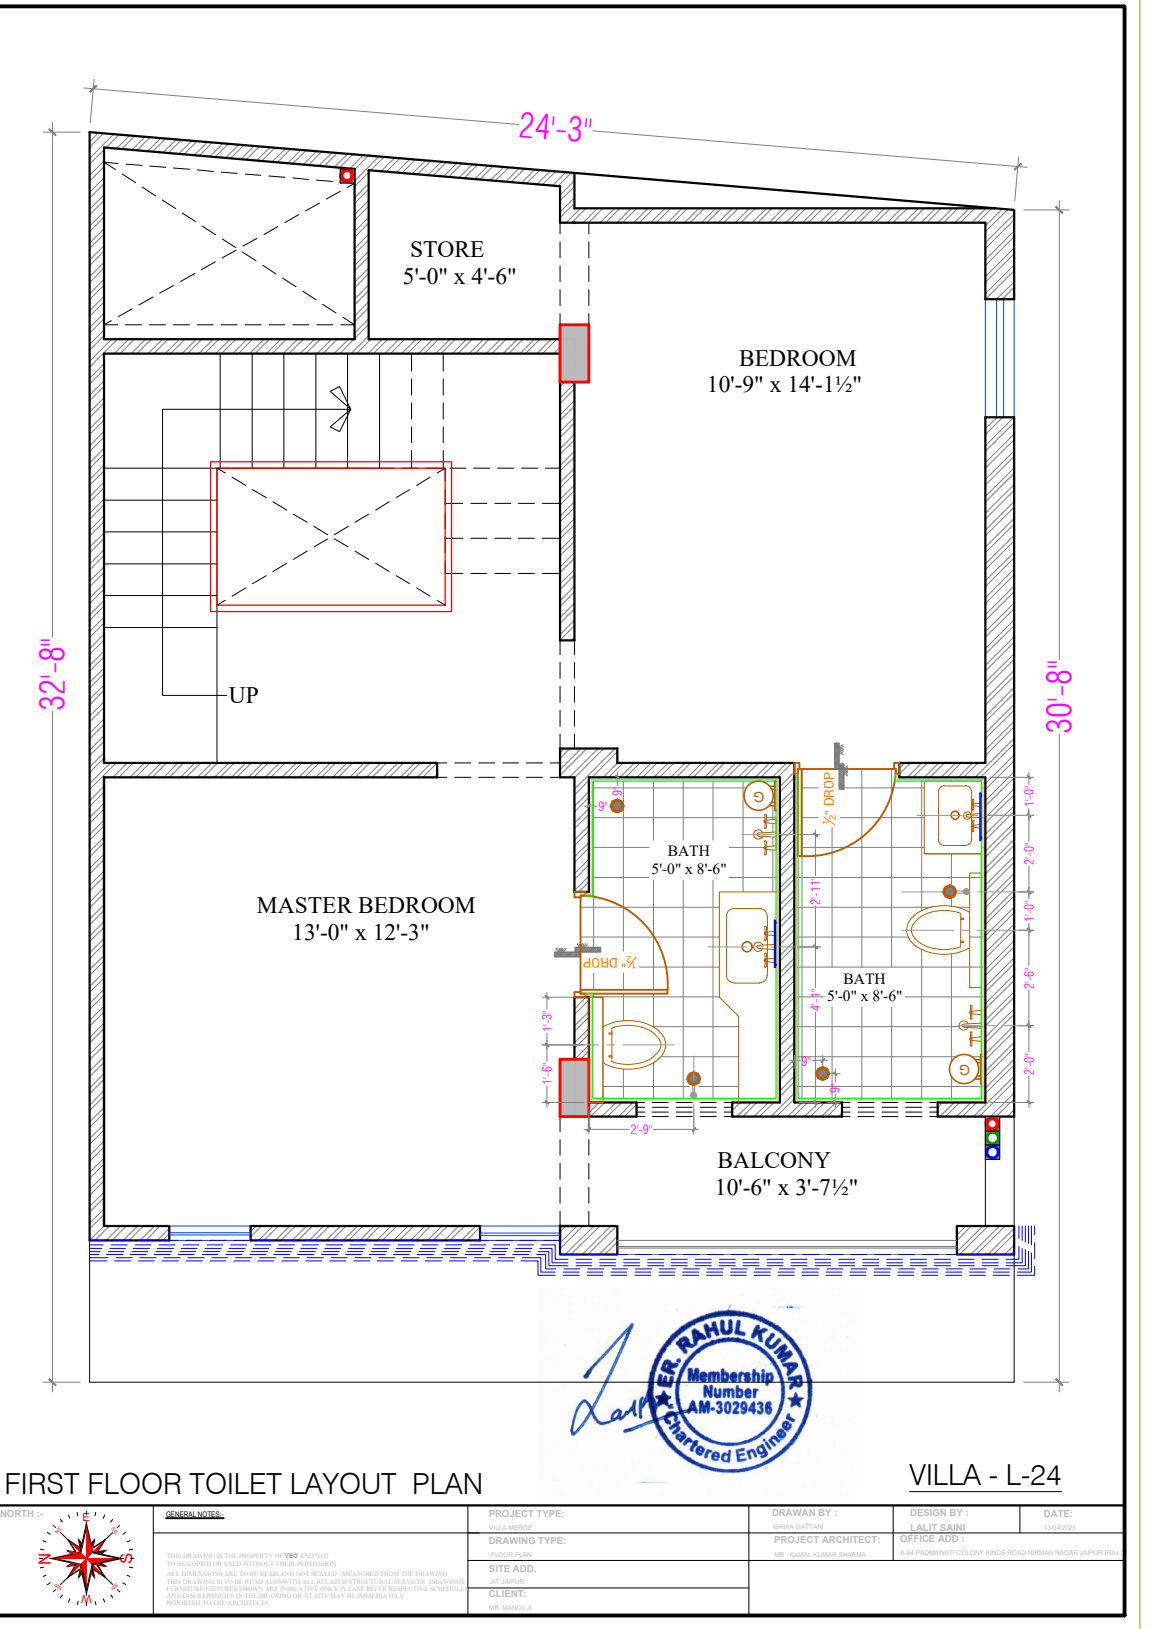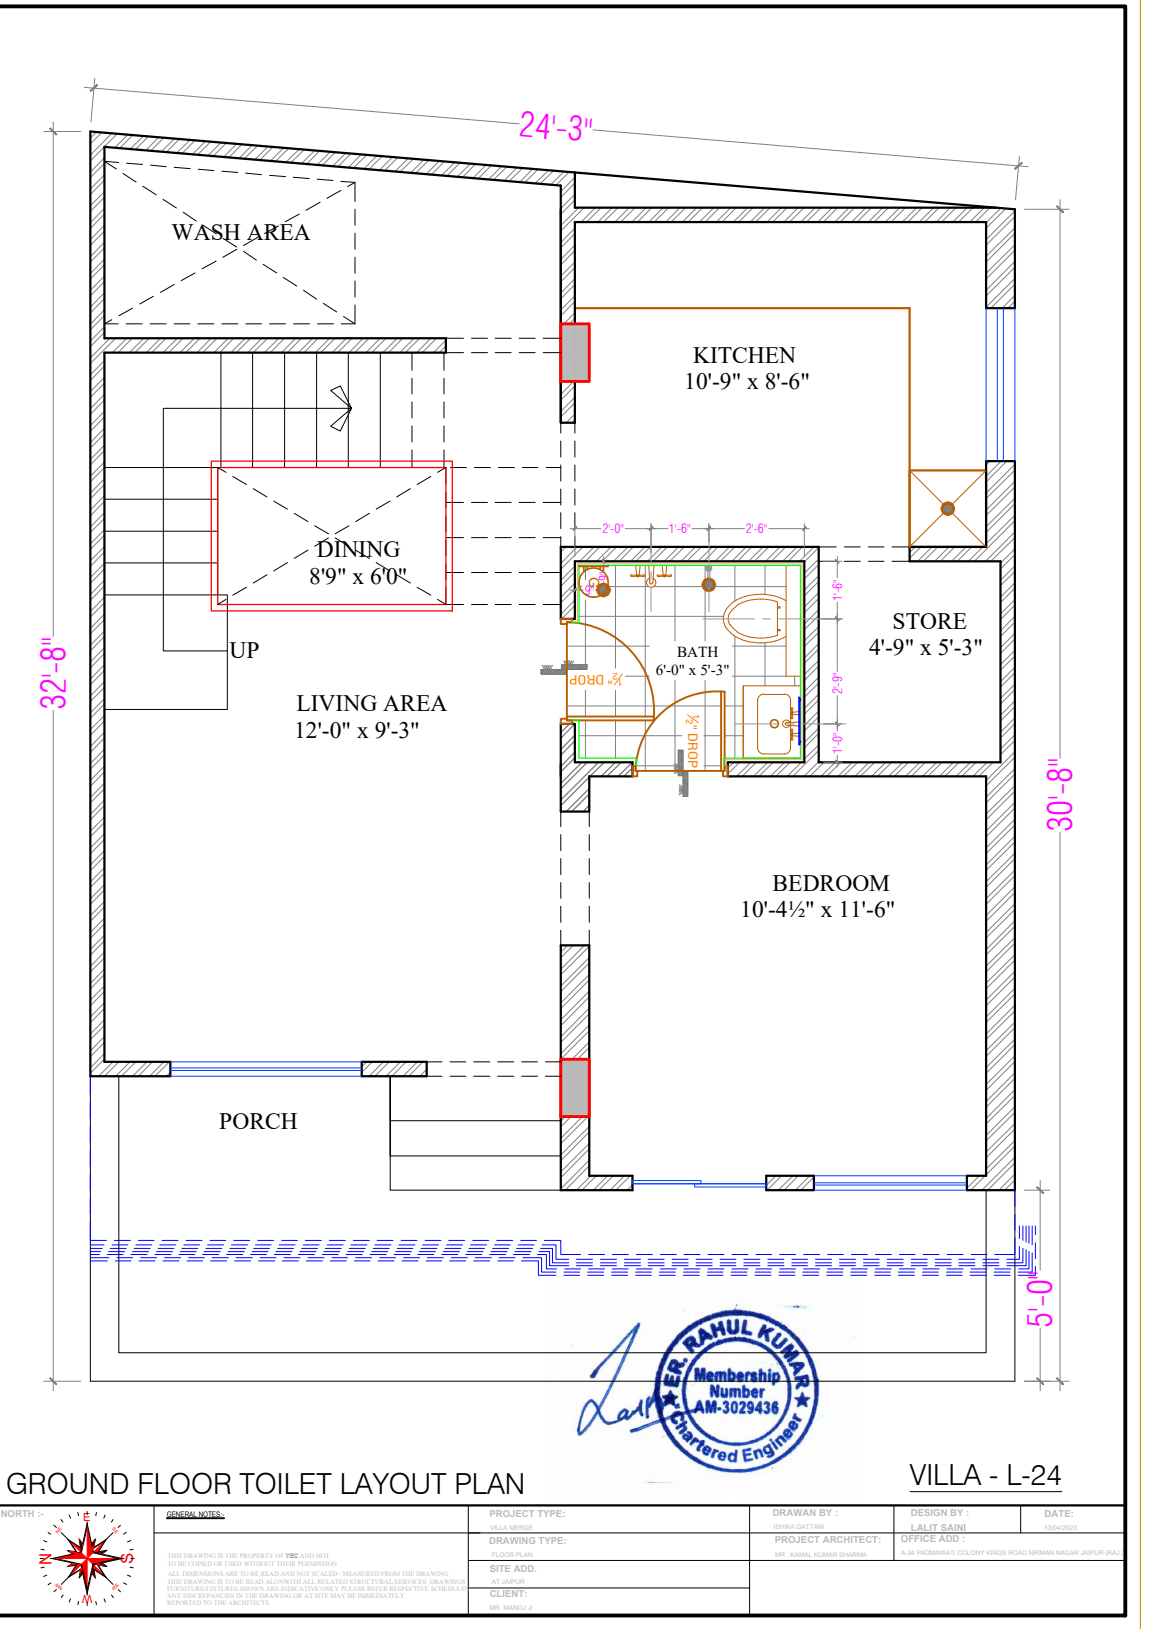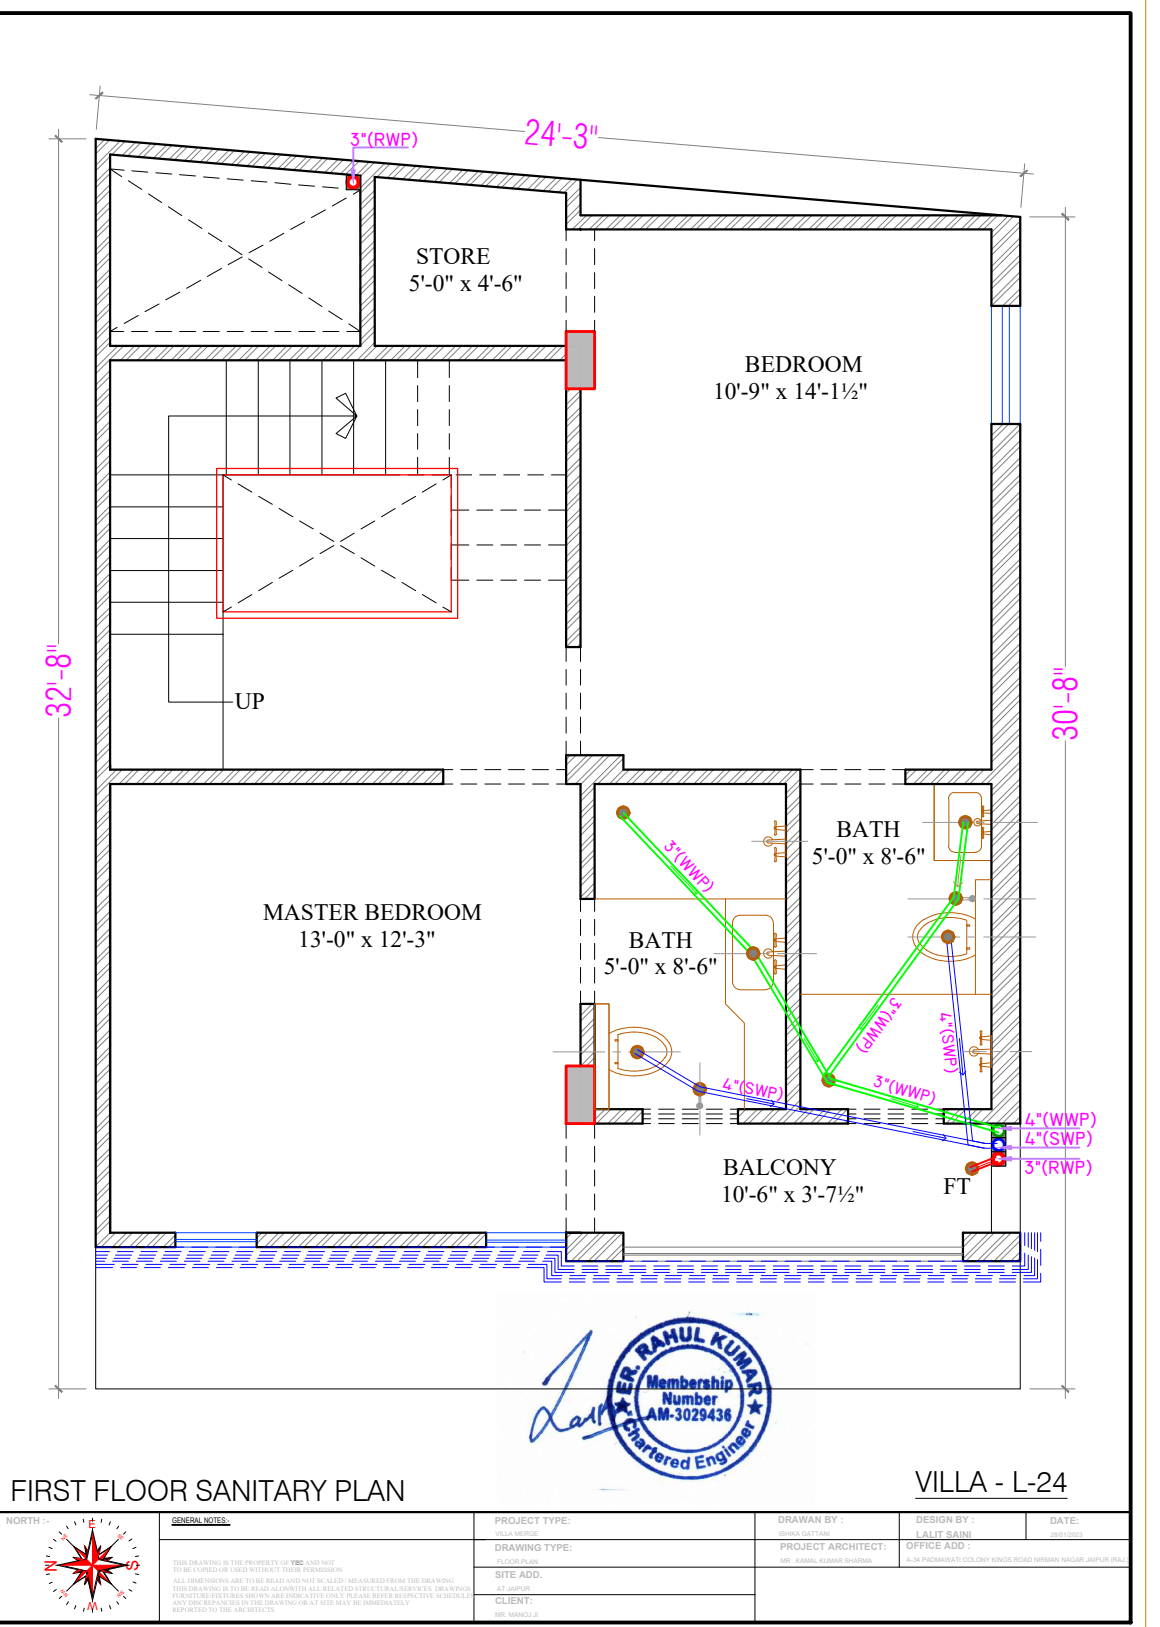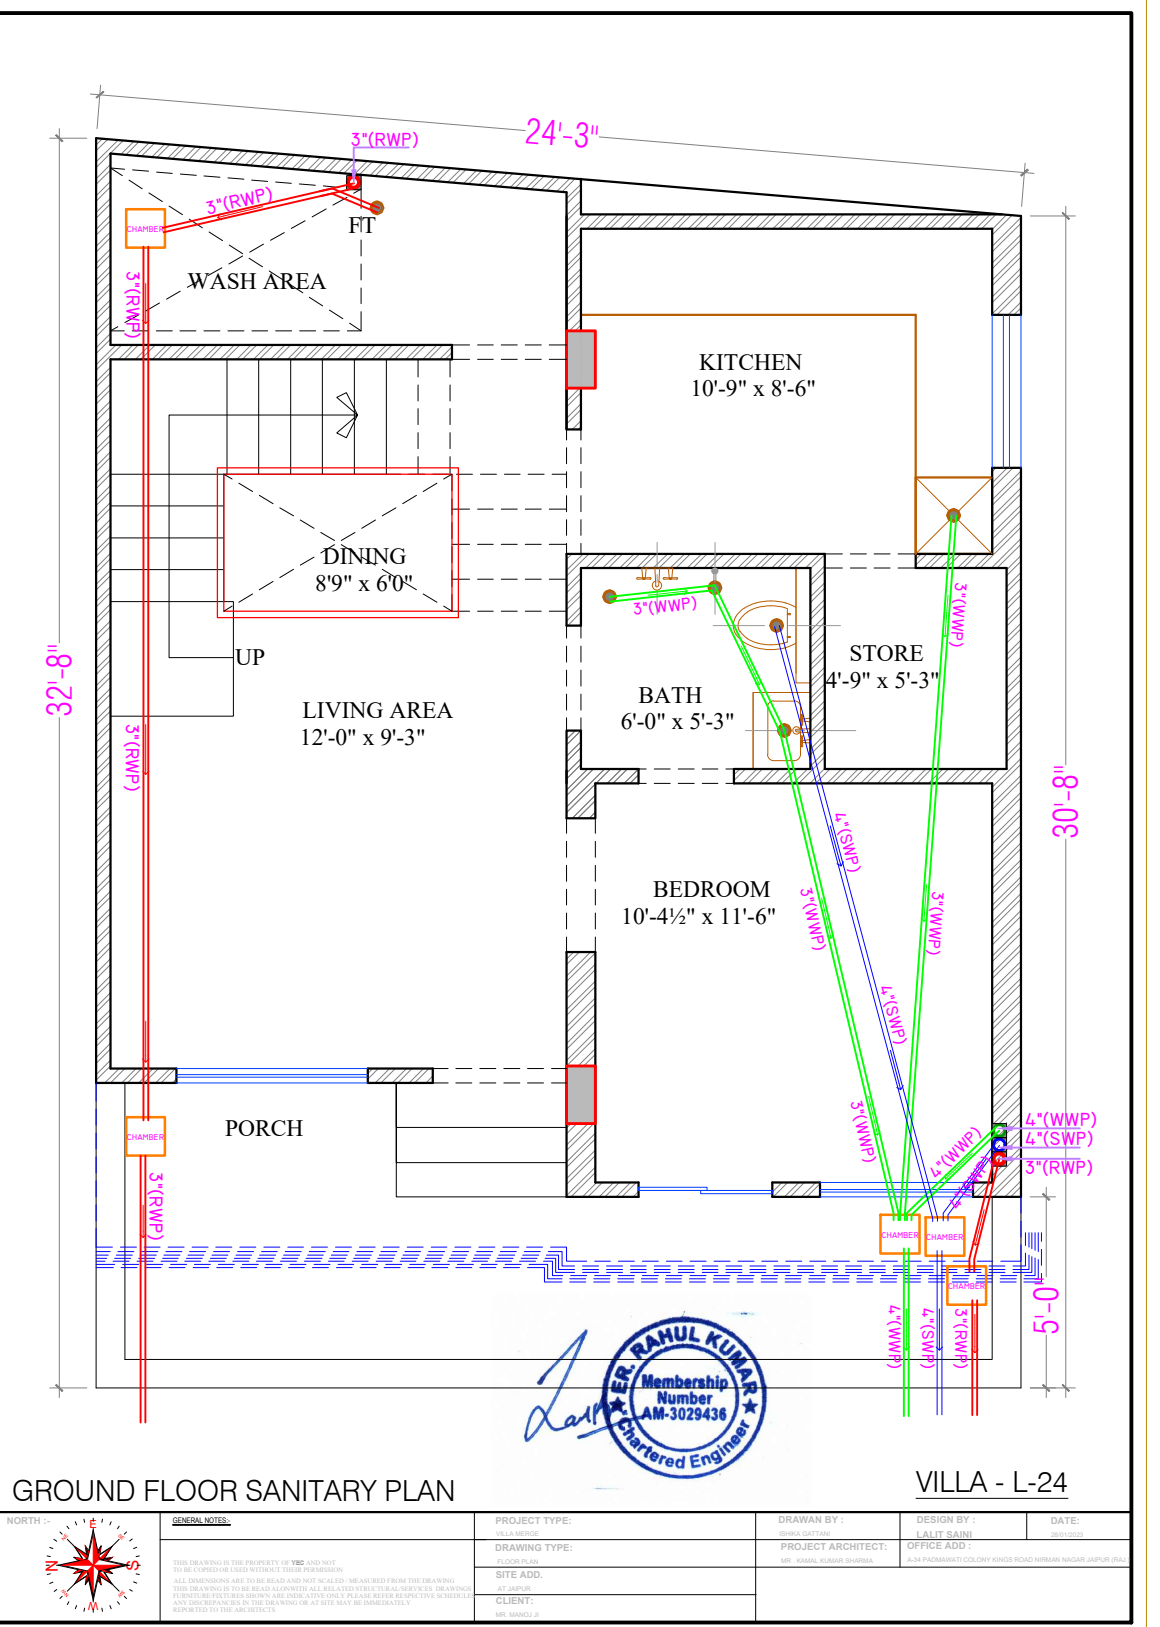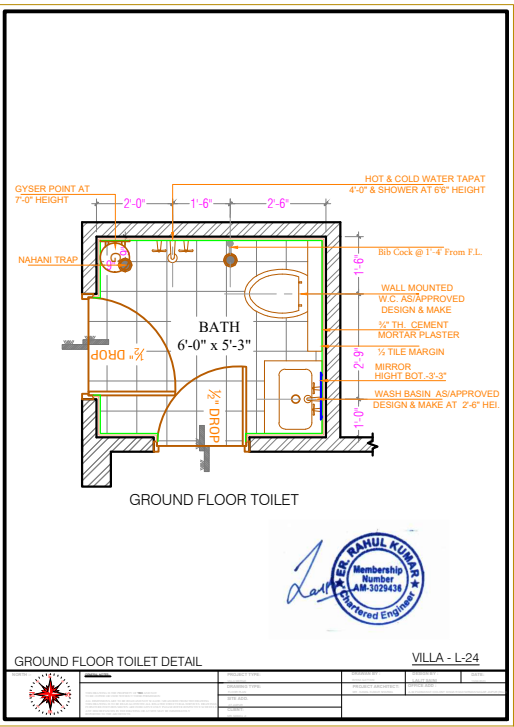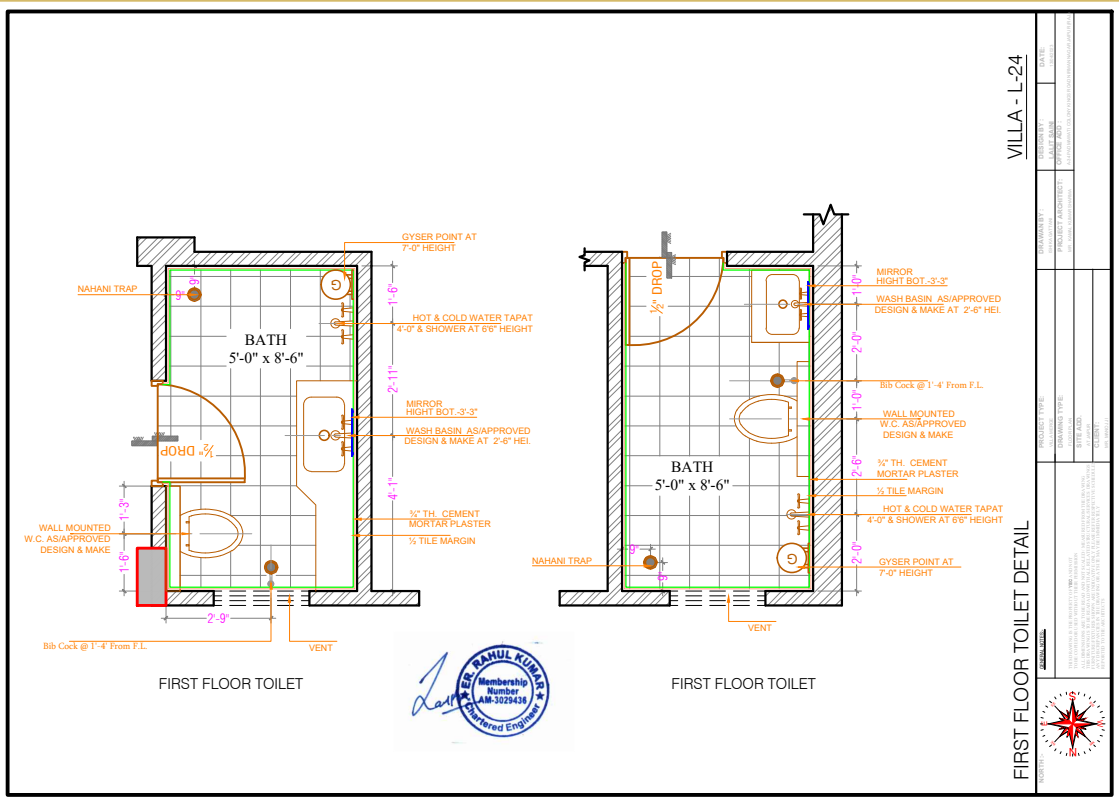
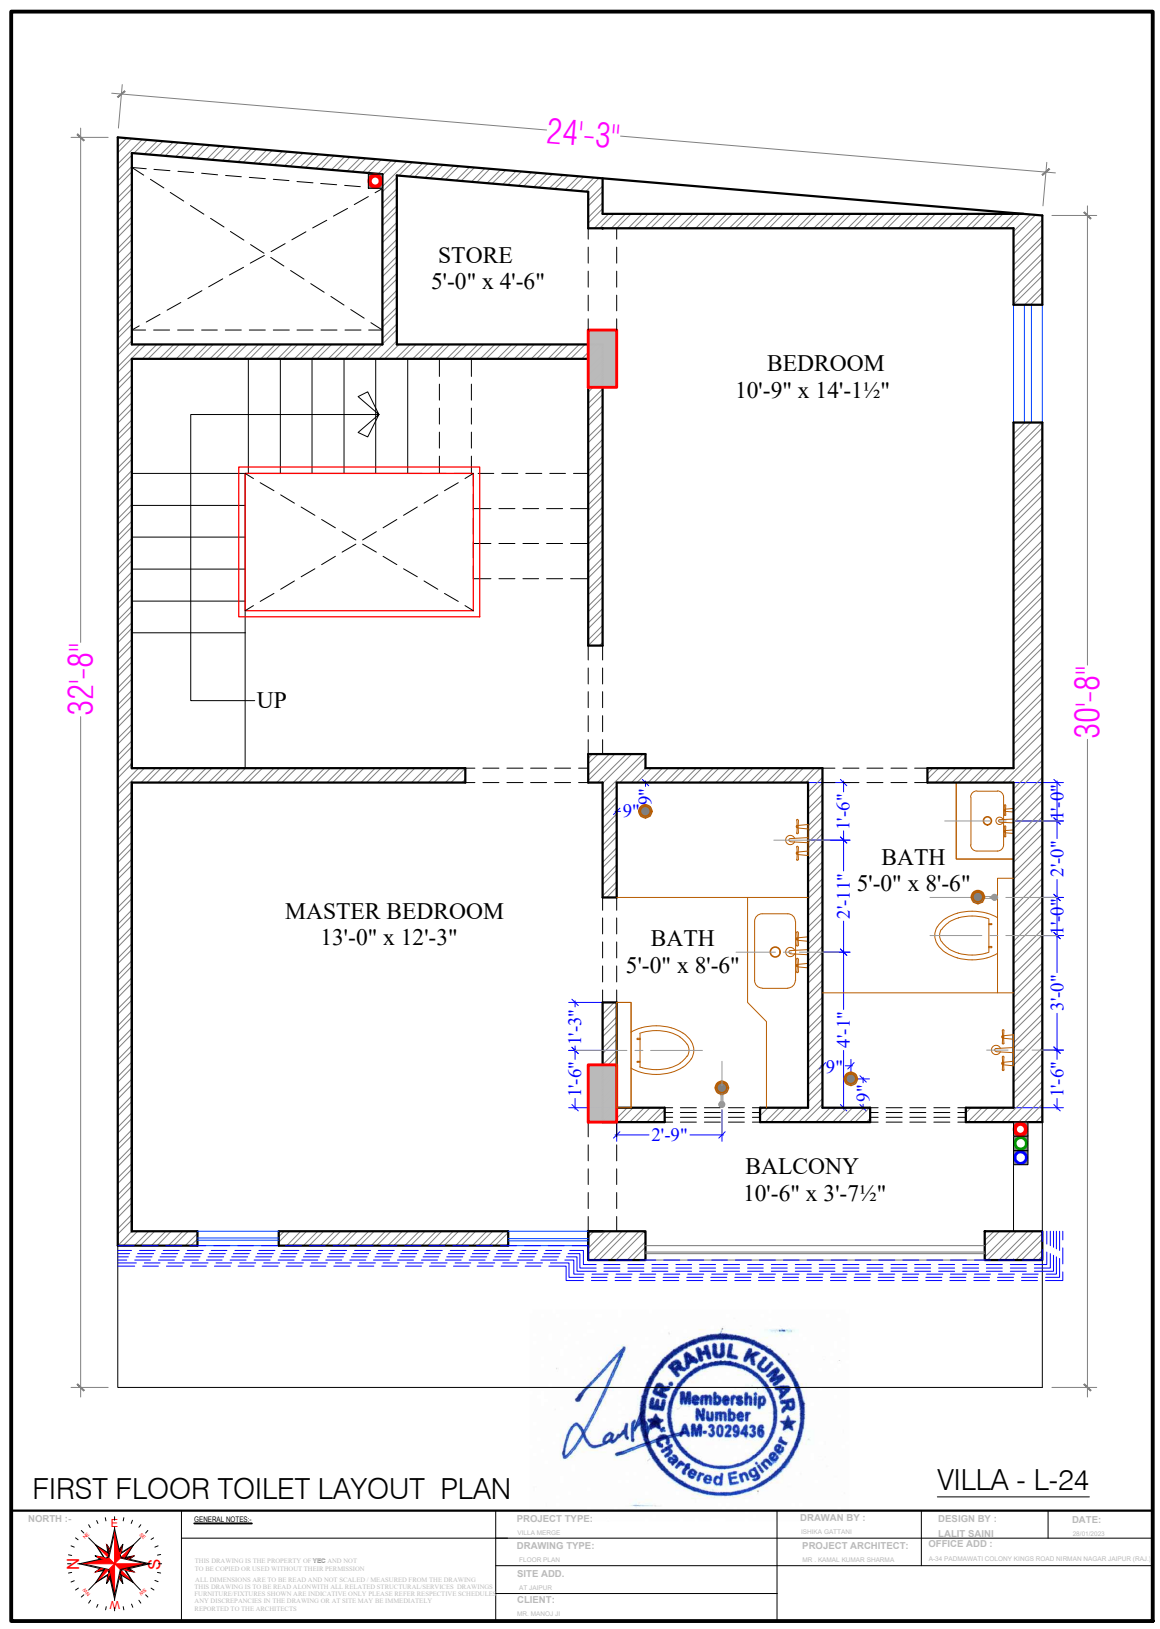
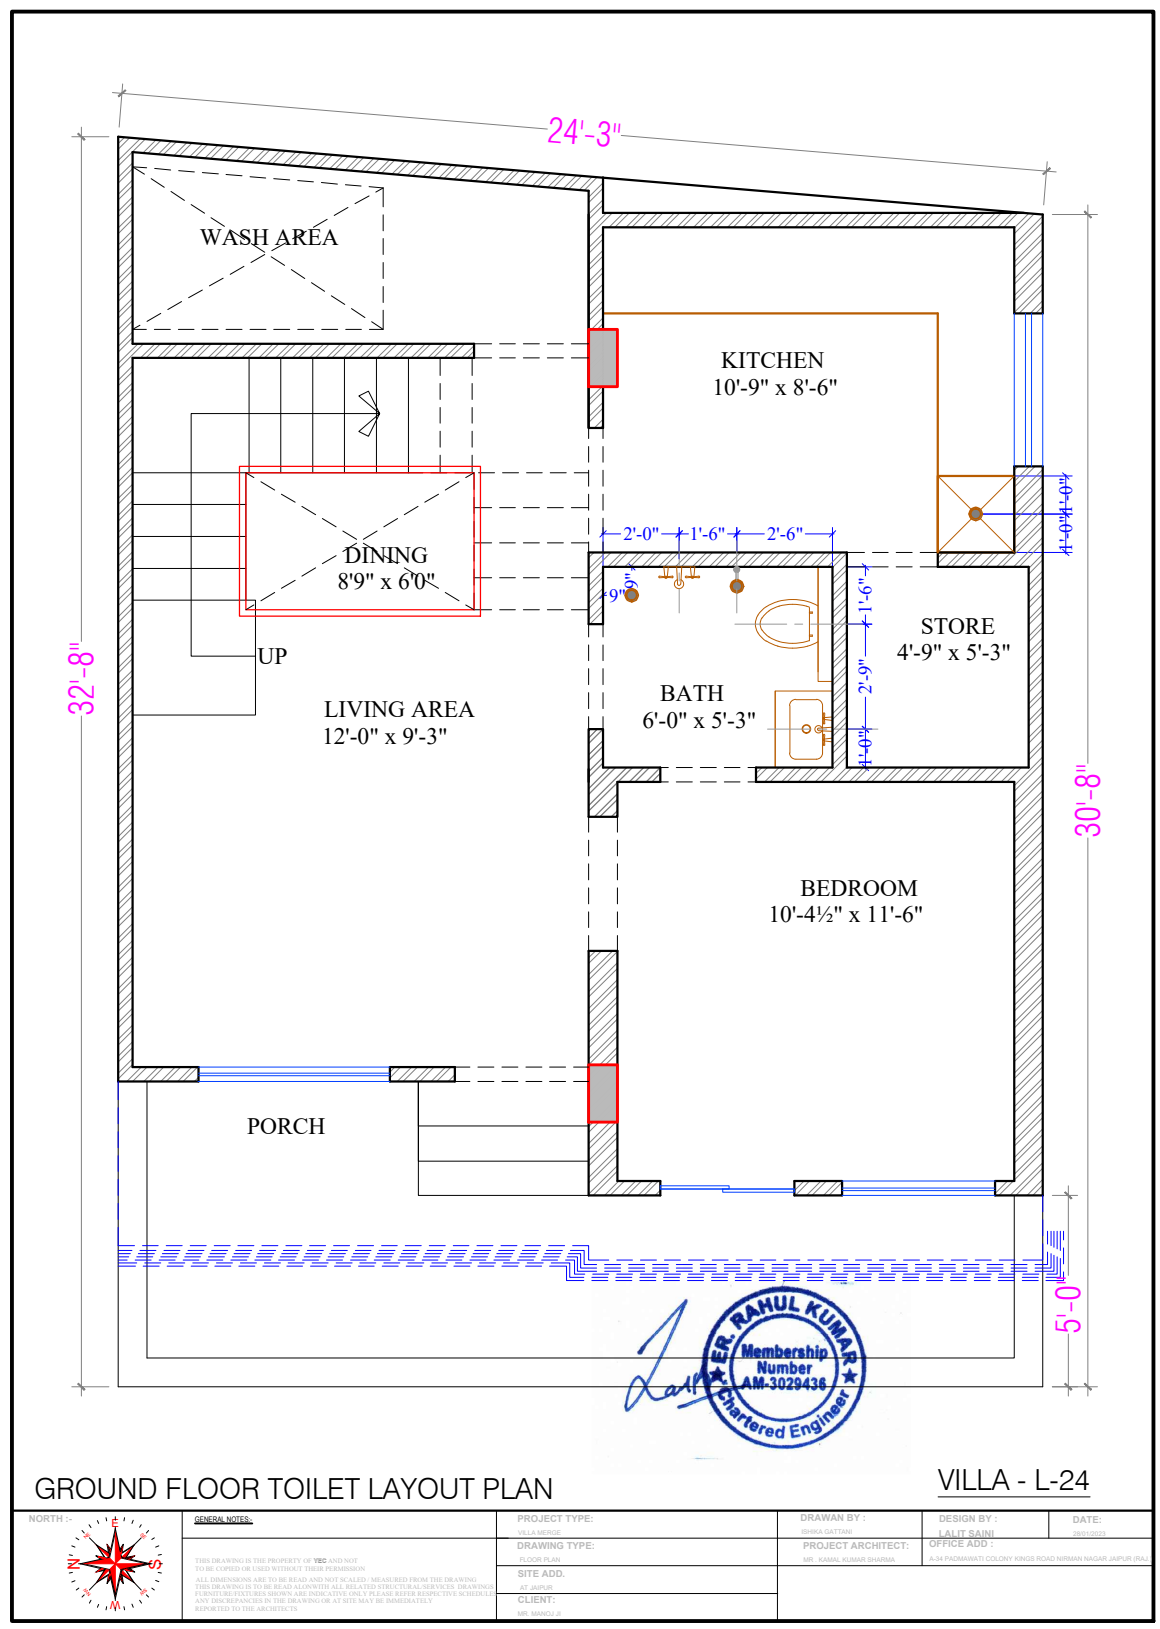


VILLA - L-01







SANITARY PLAN

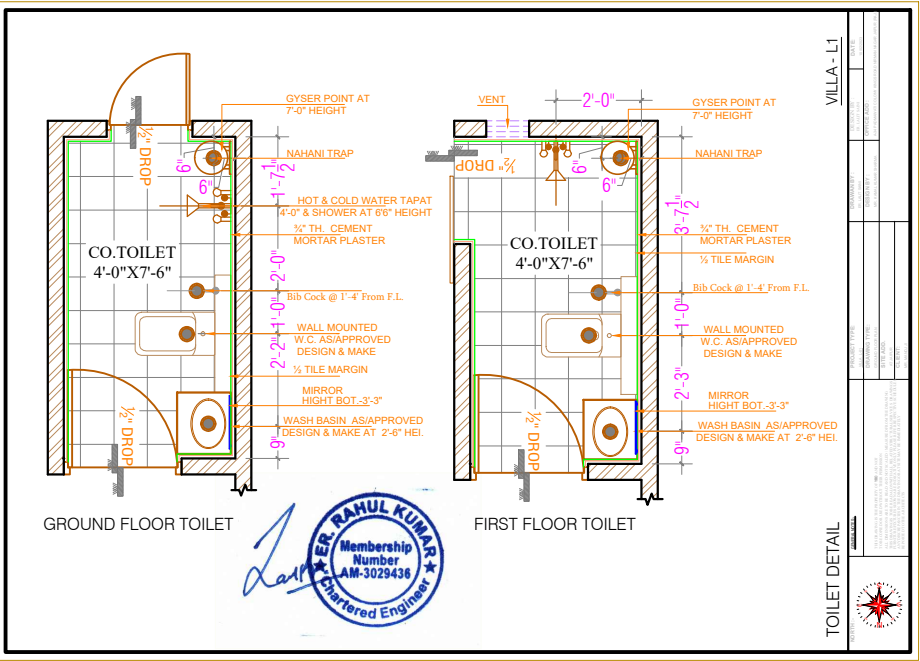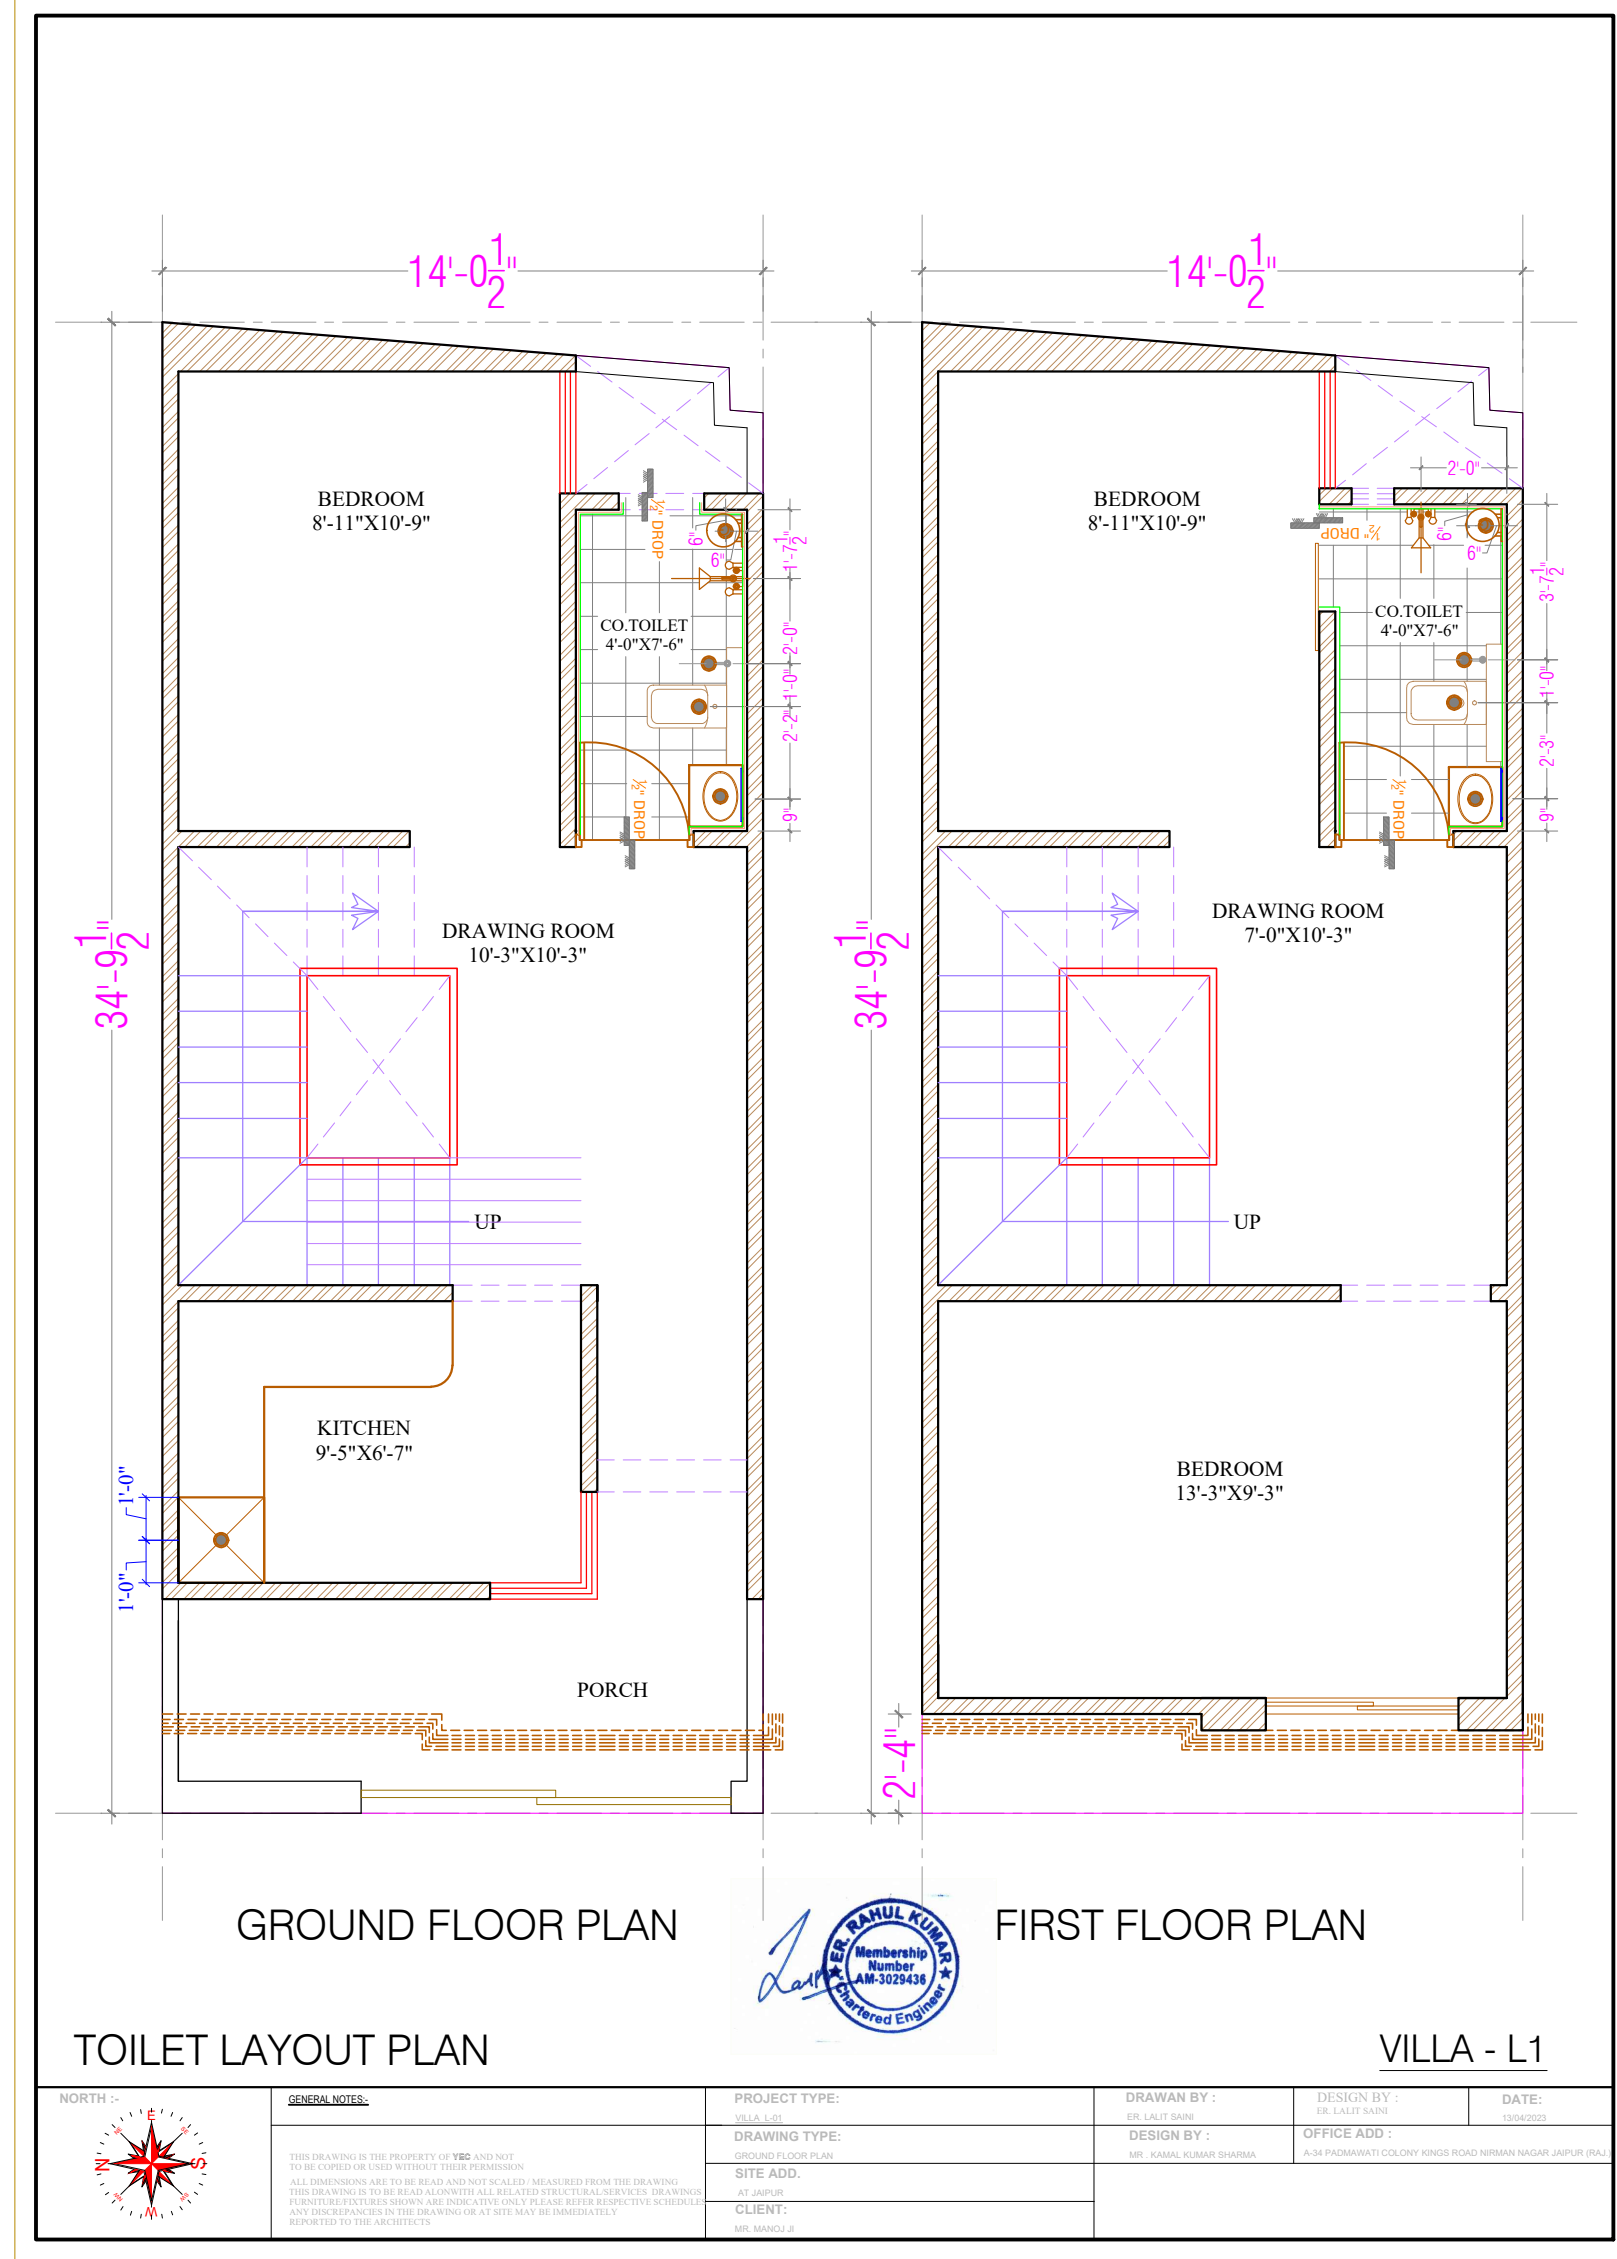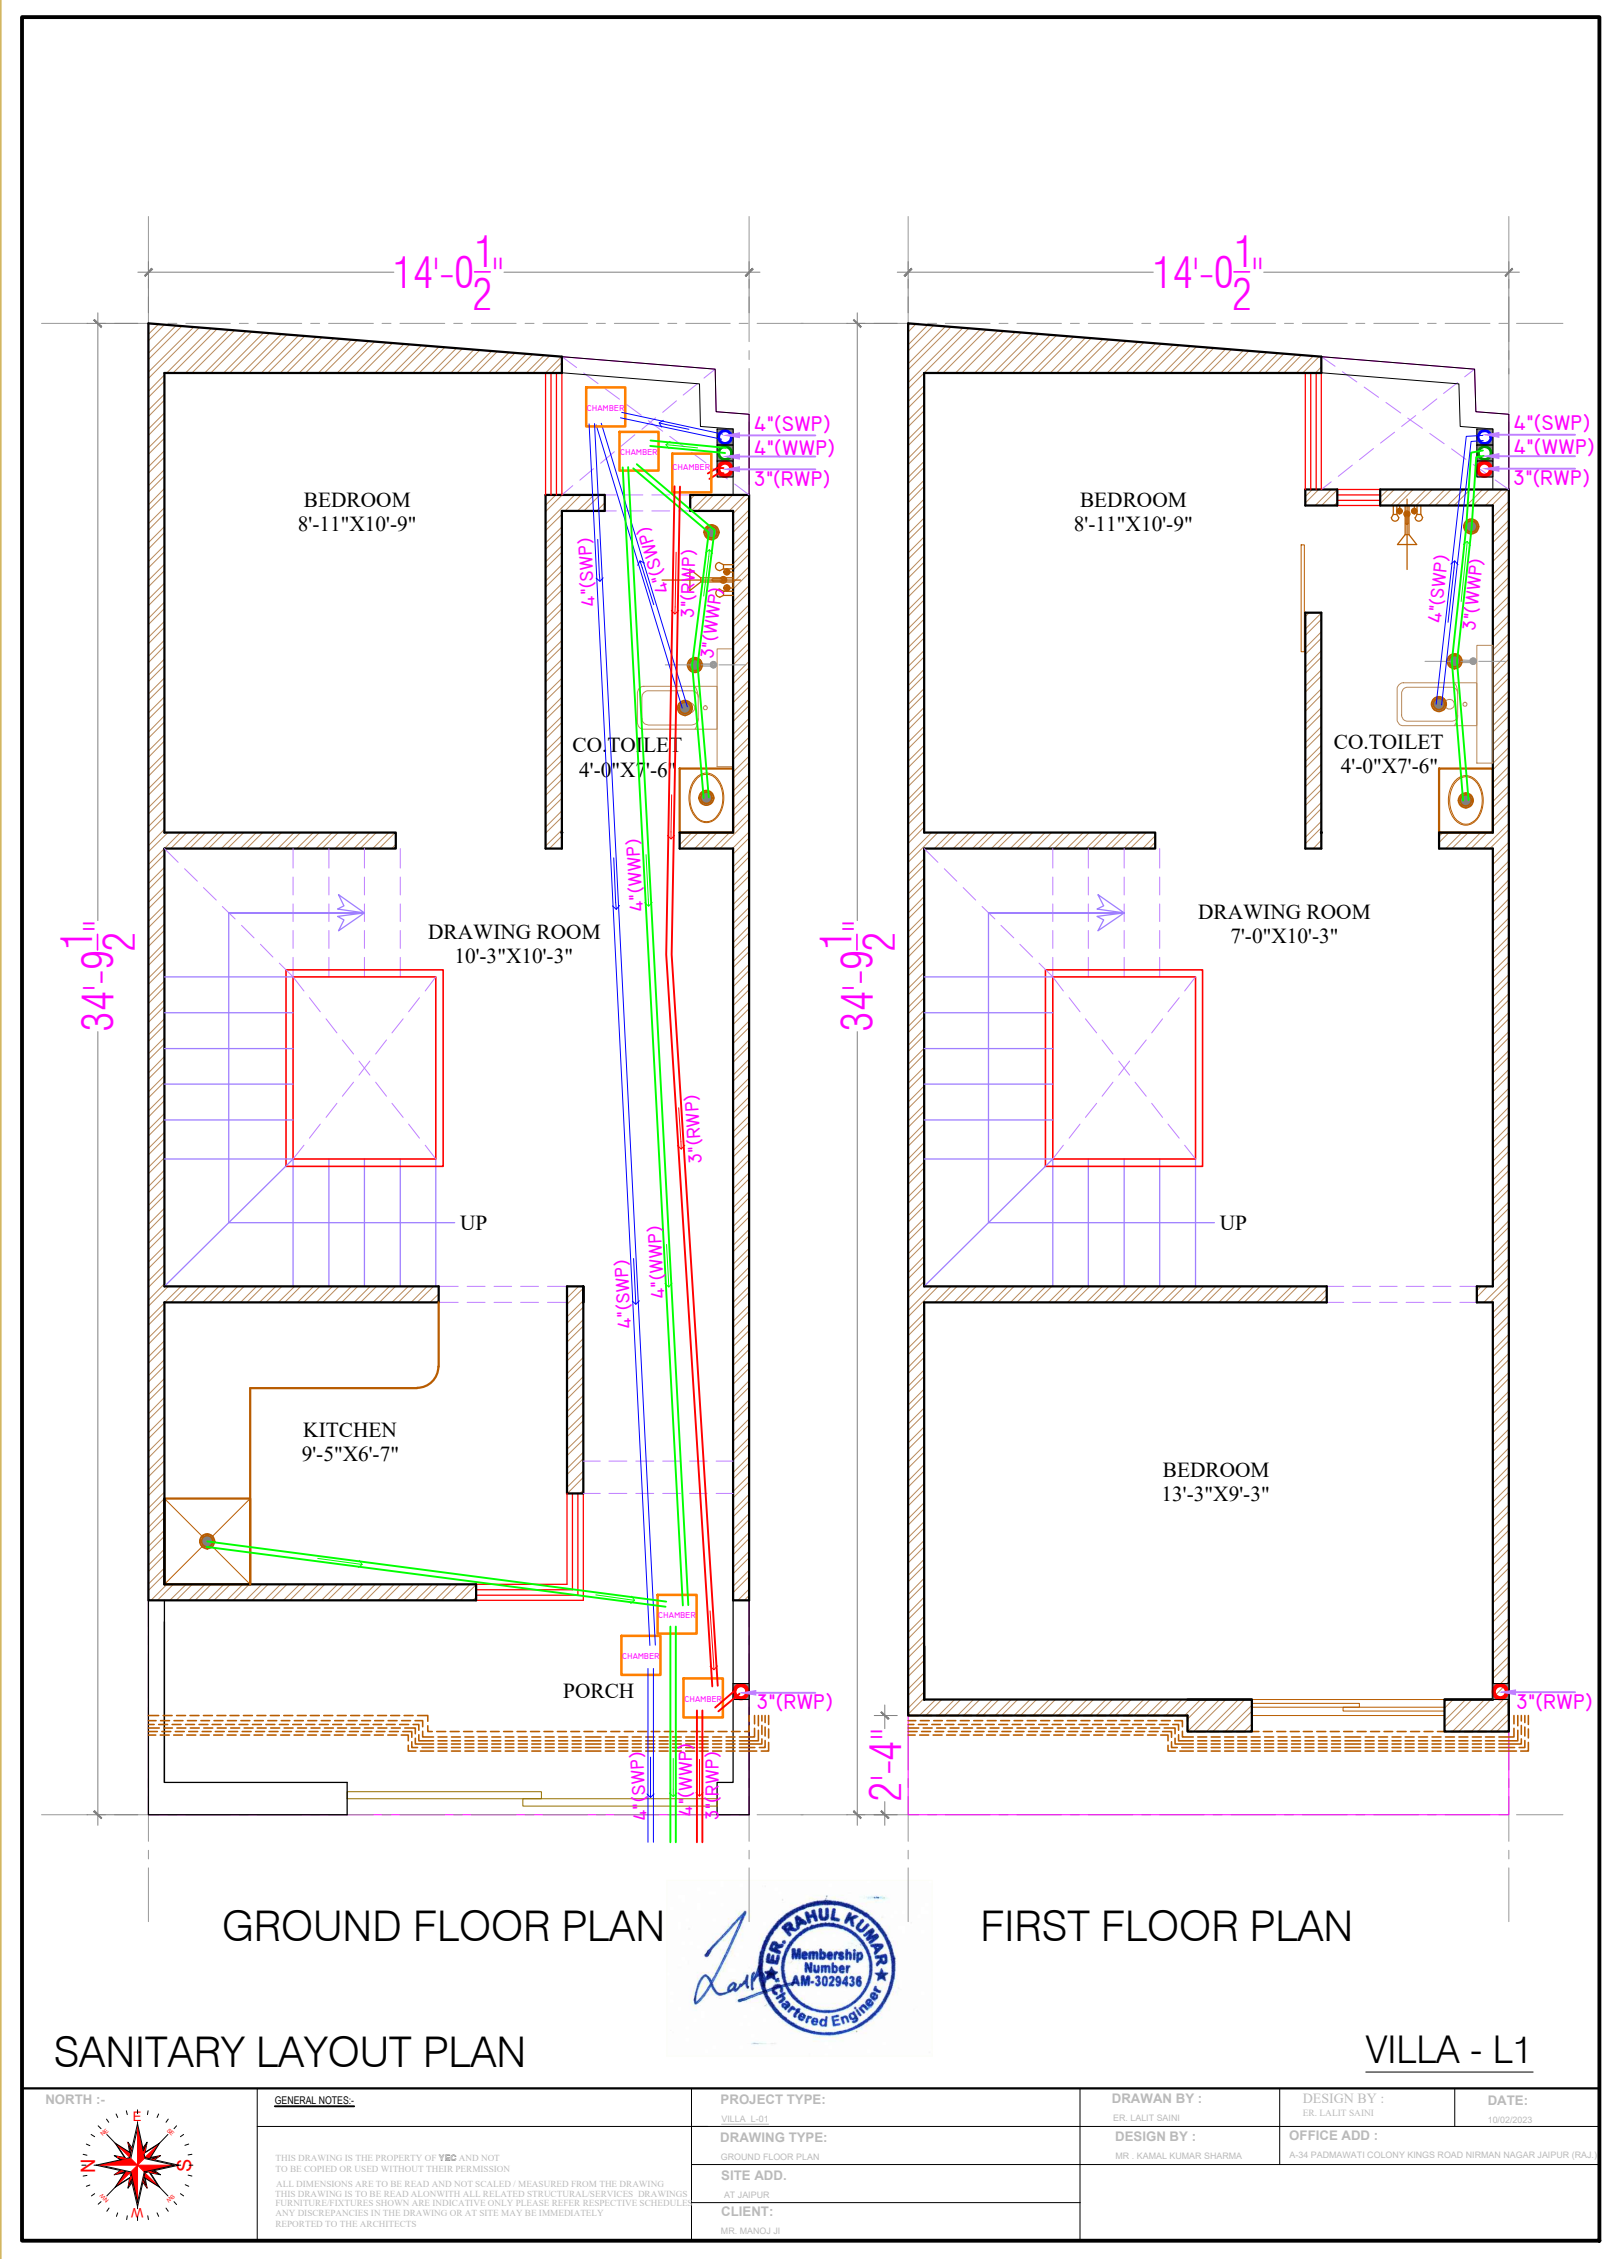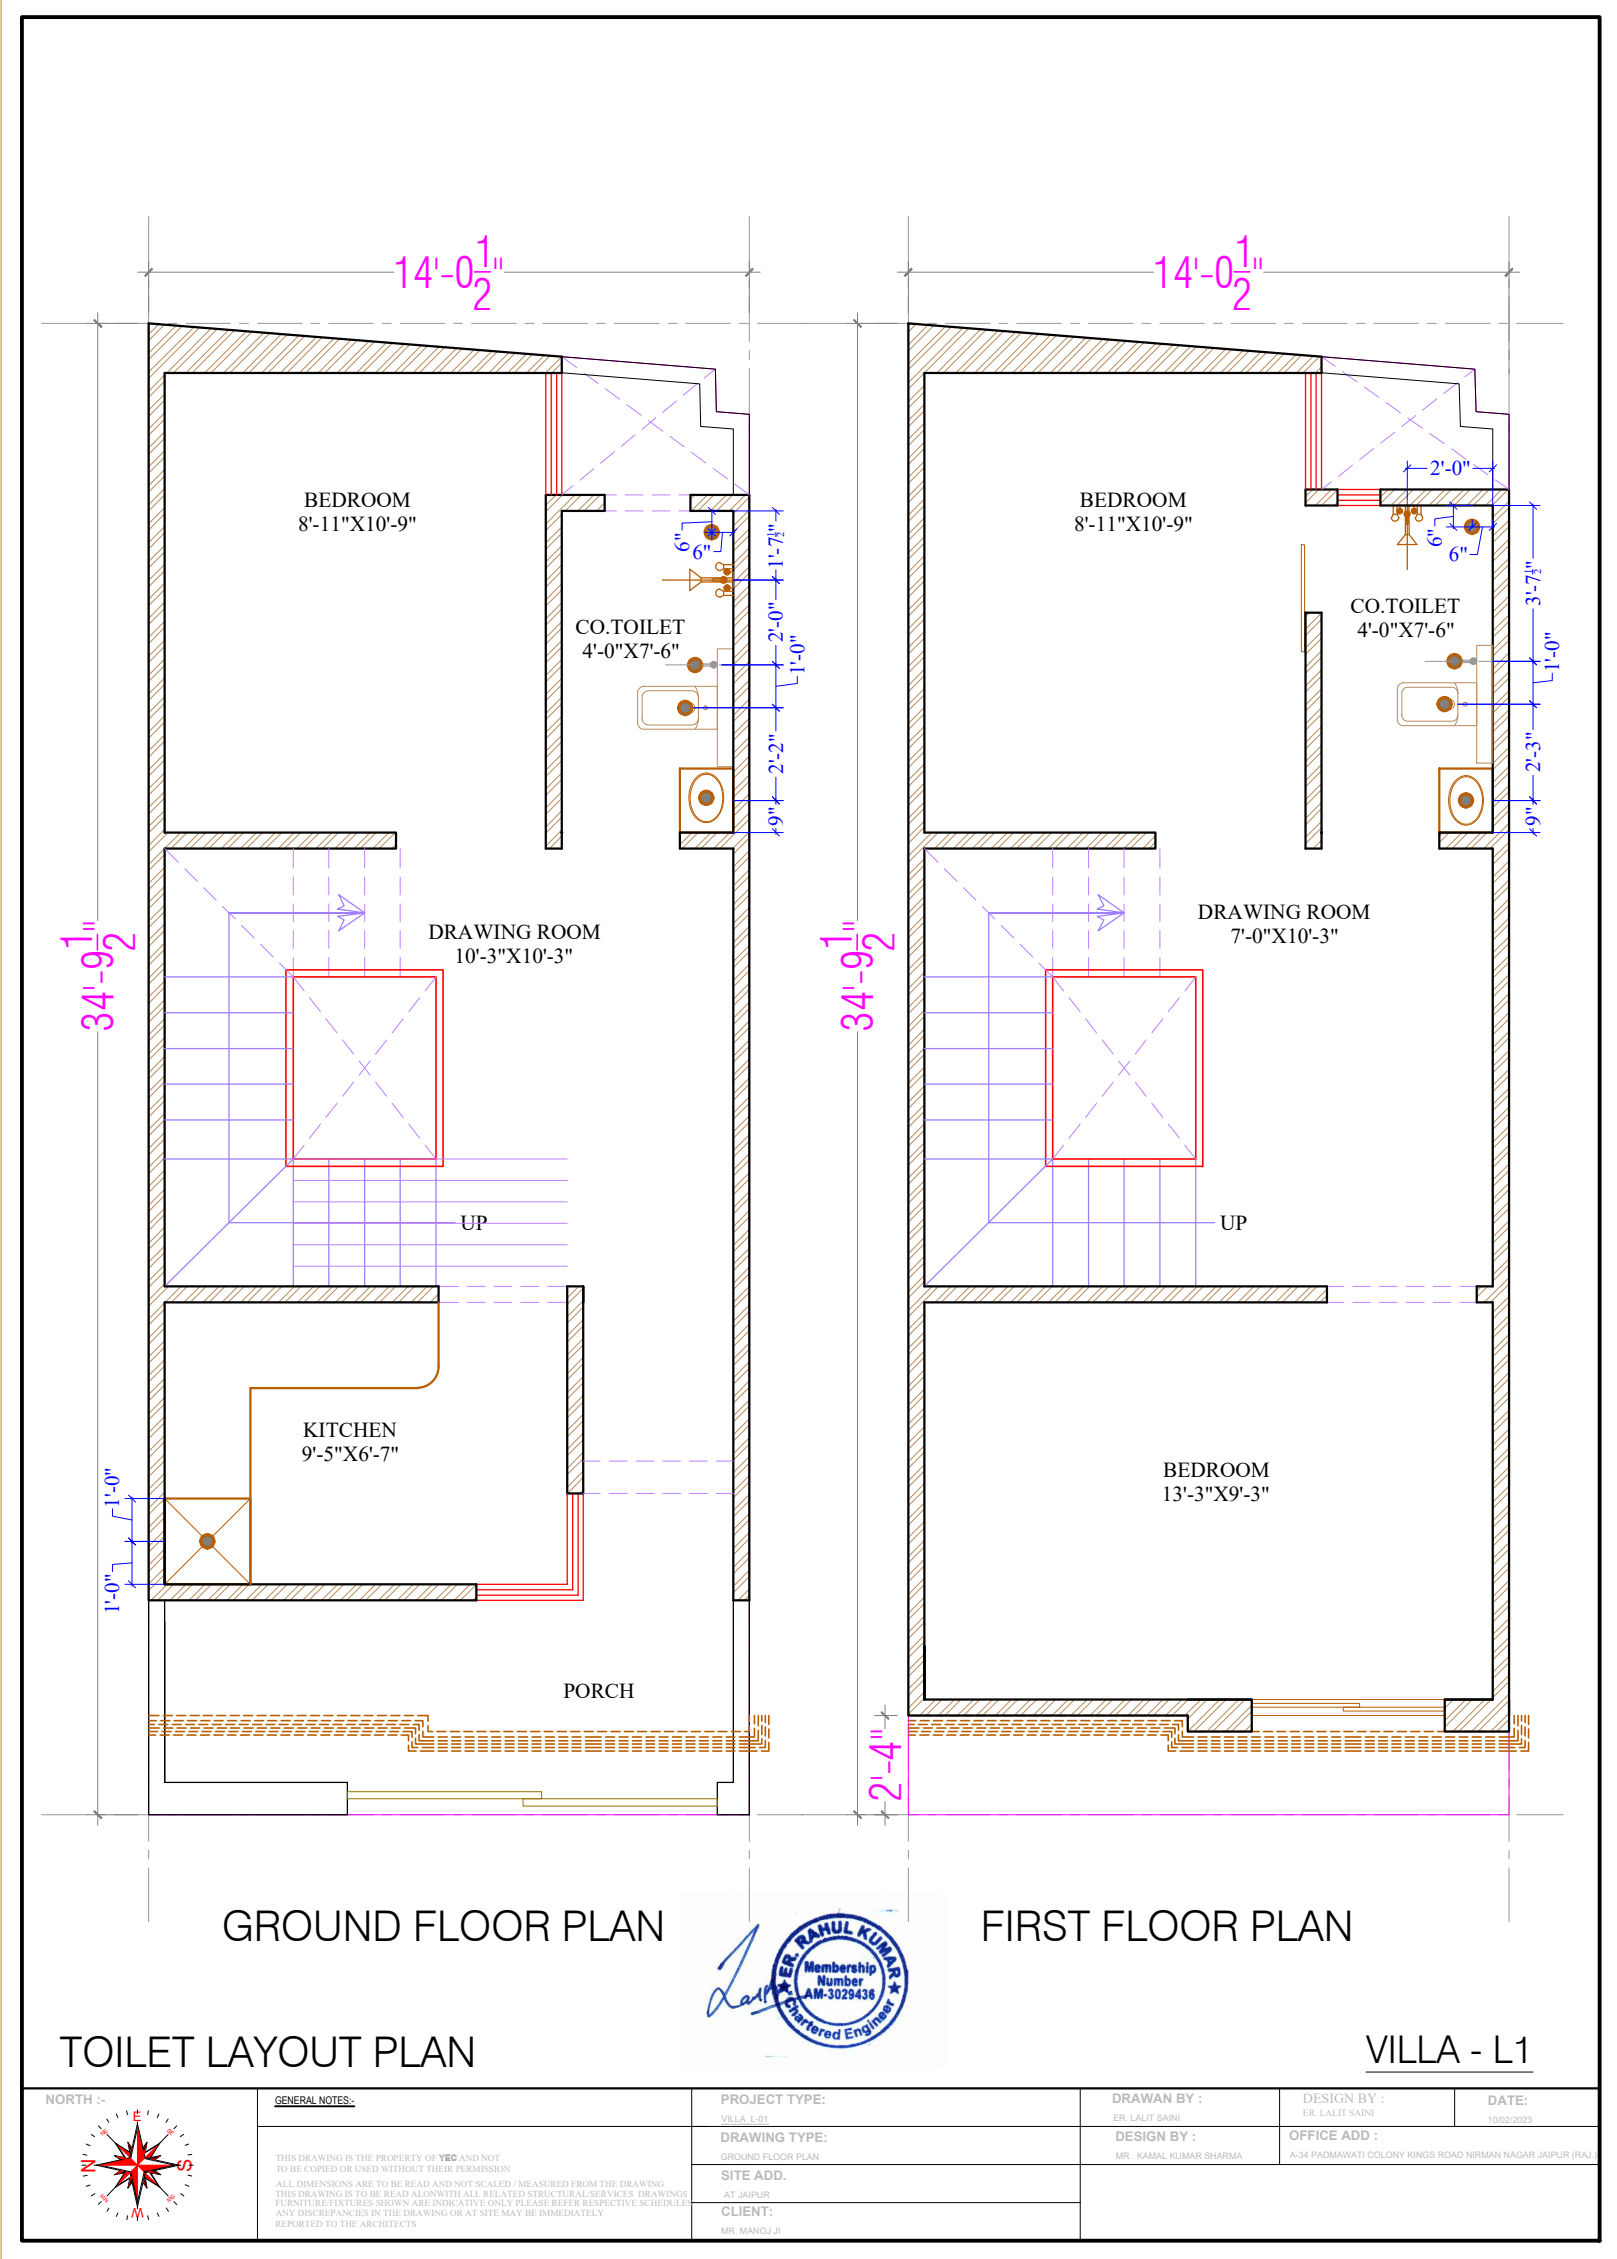

VILLA NO. L-02 & L-23
PLUMBING PLAN

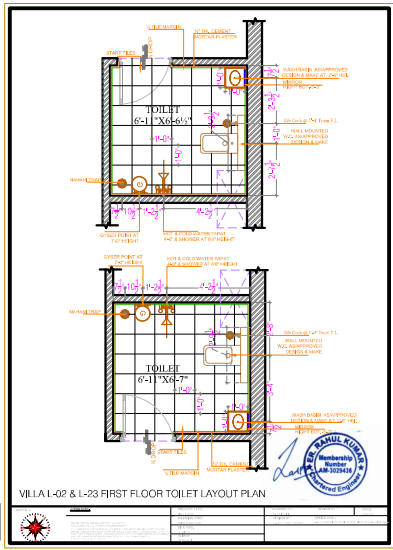
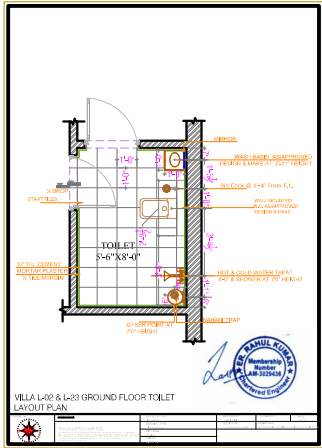
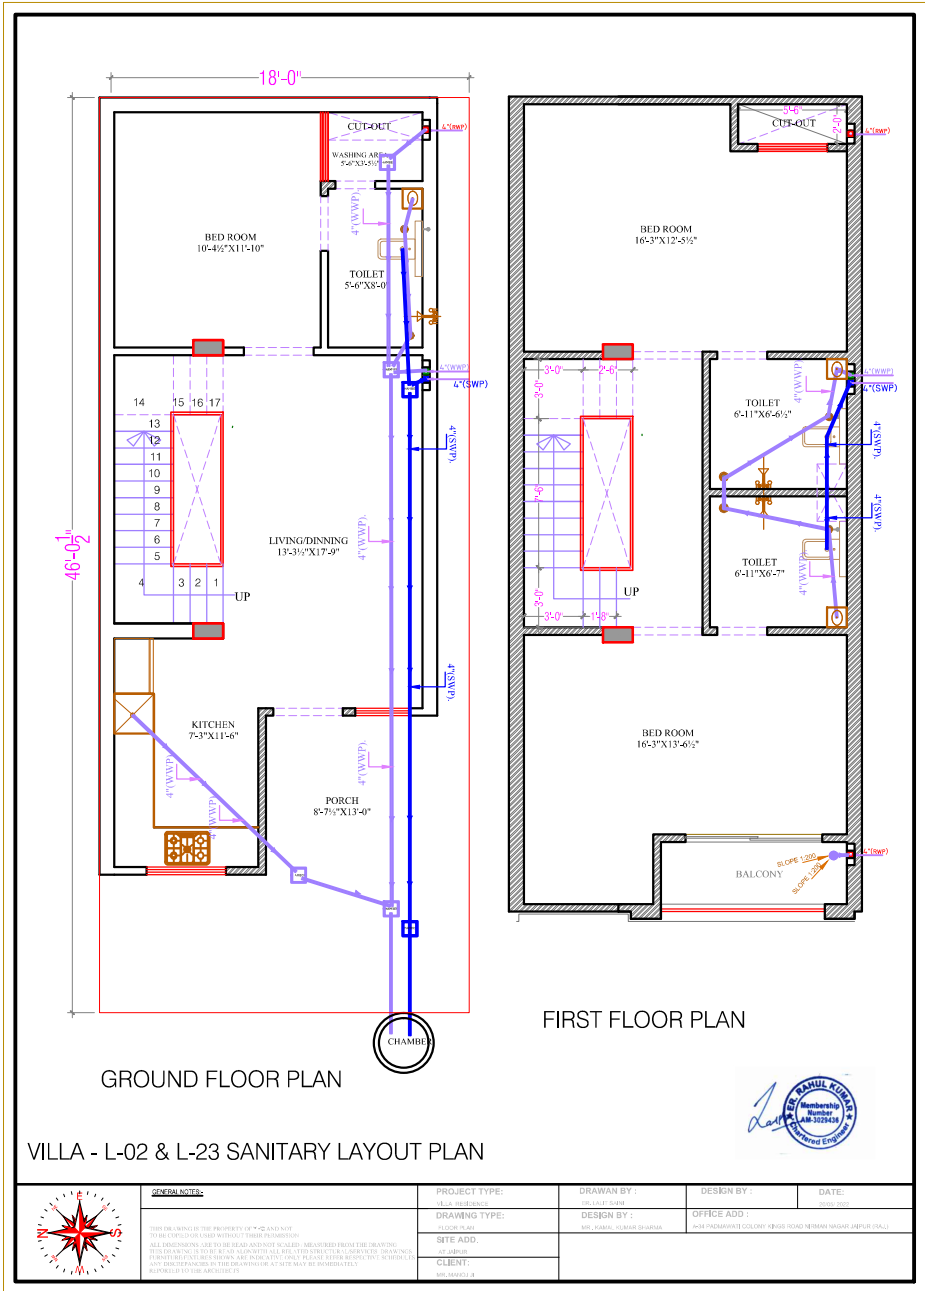


VILLA - L13 TO L22
SANITARY PLAN

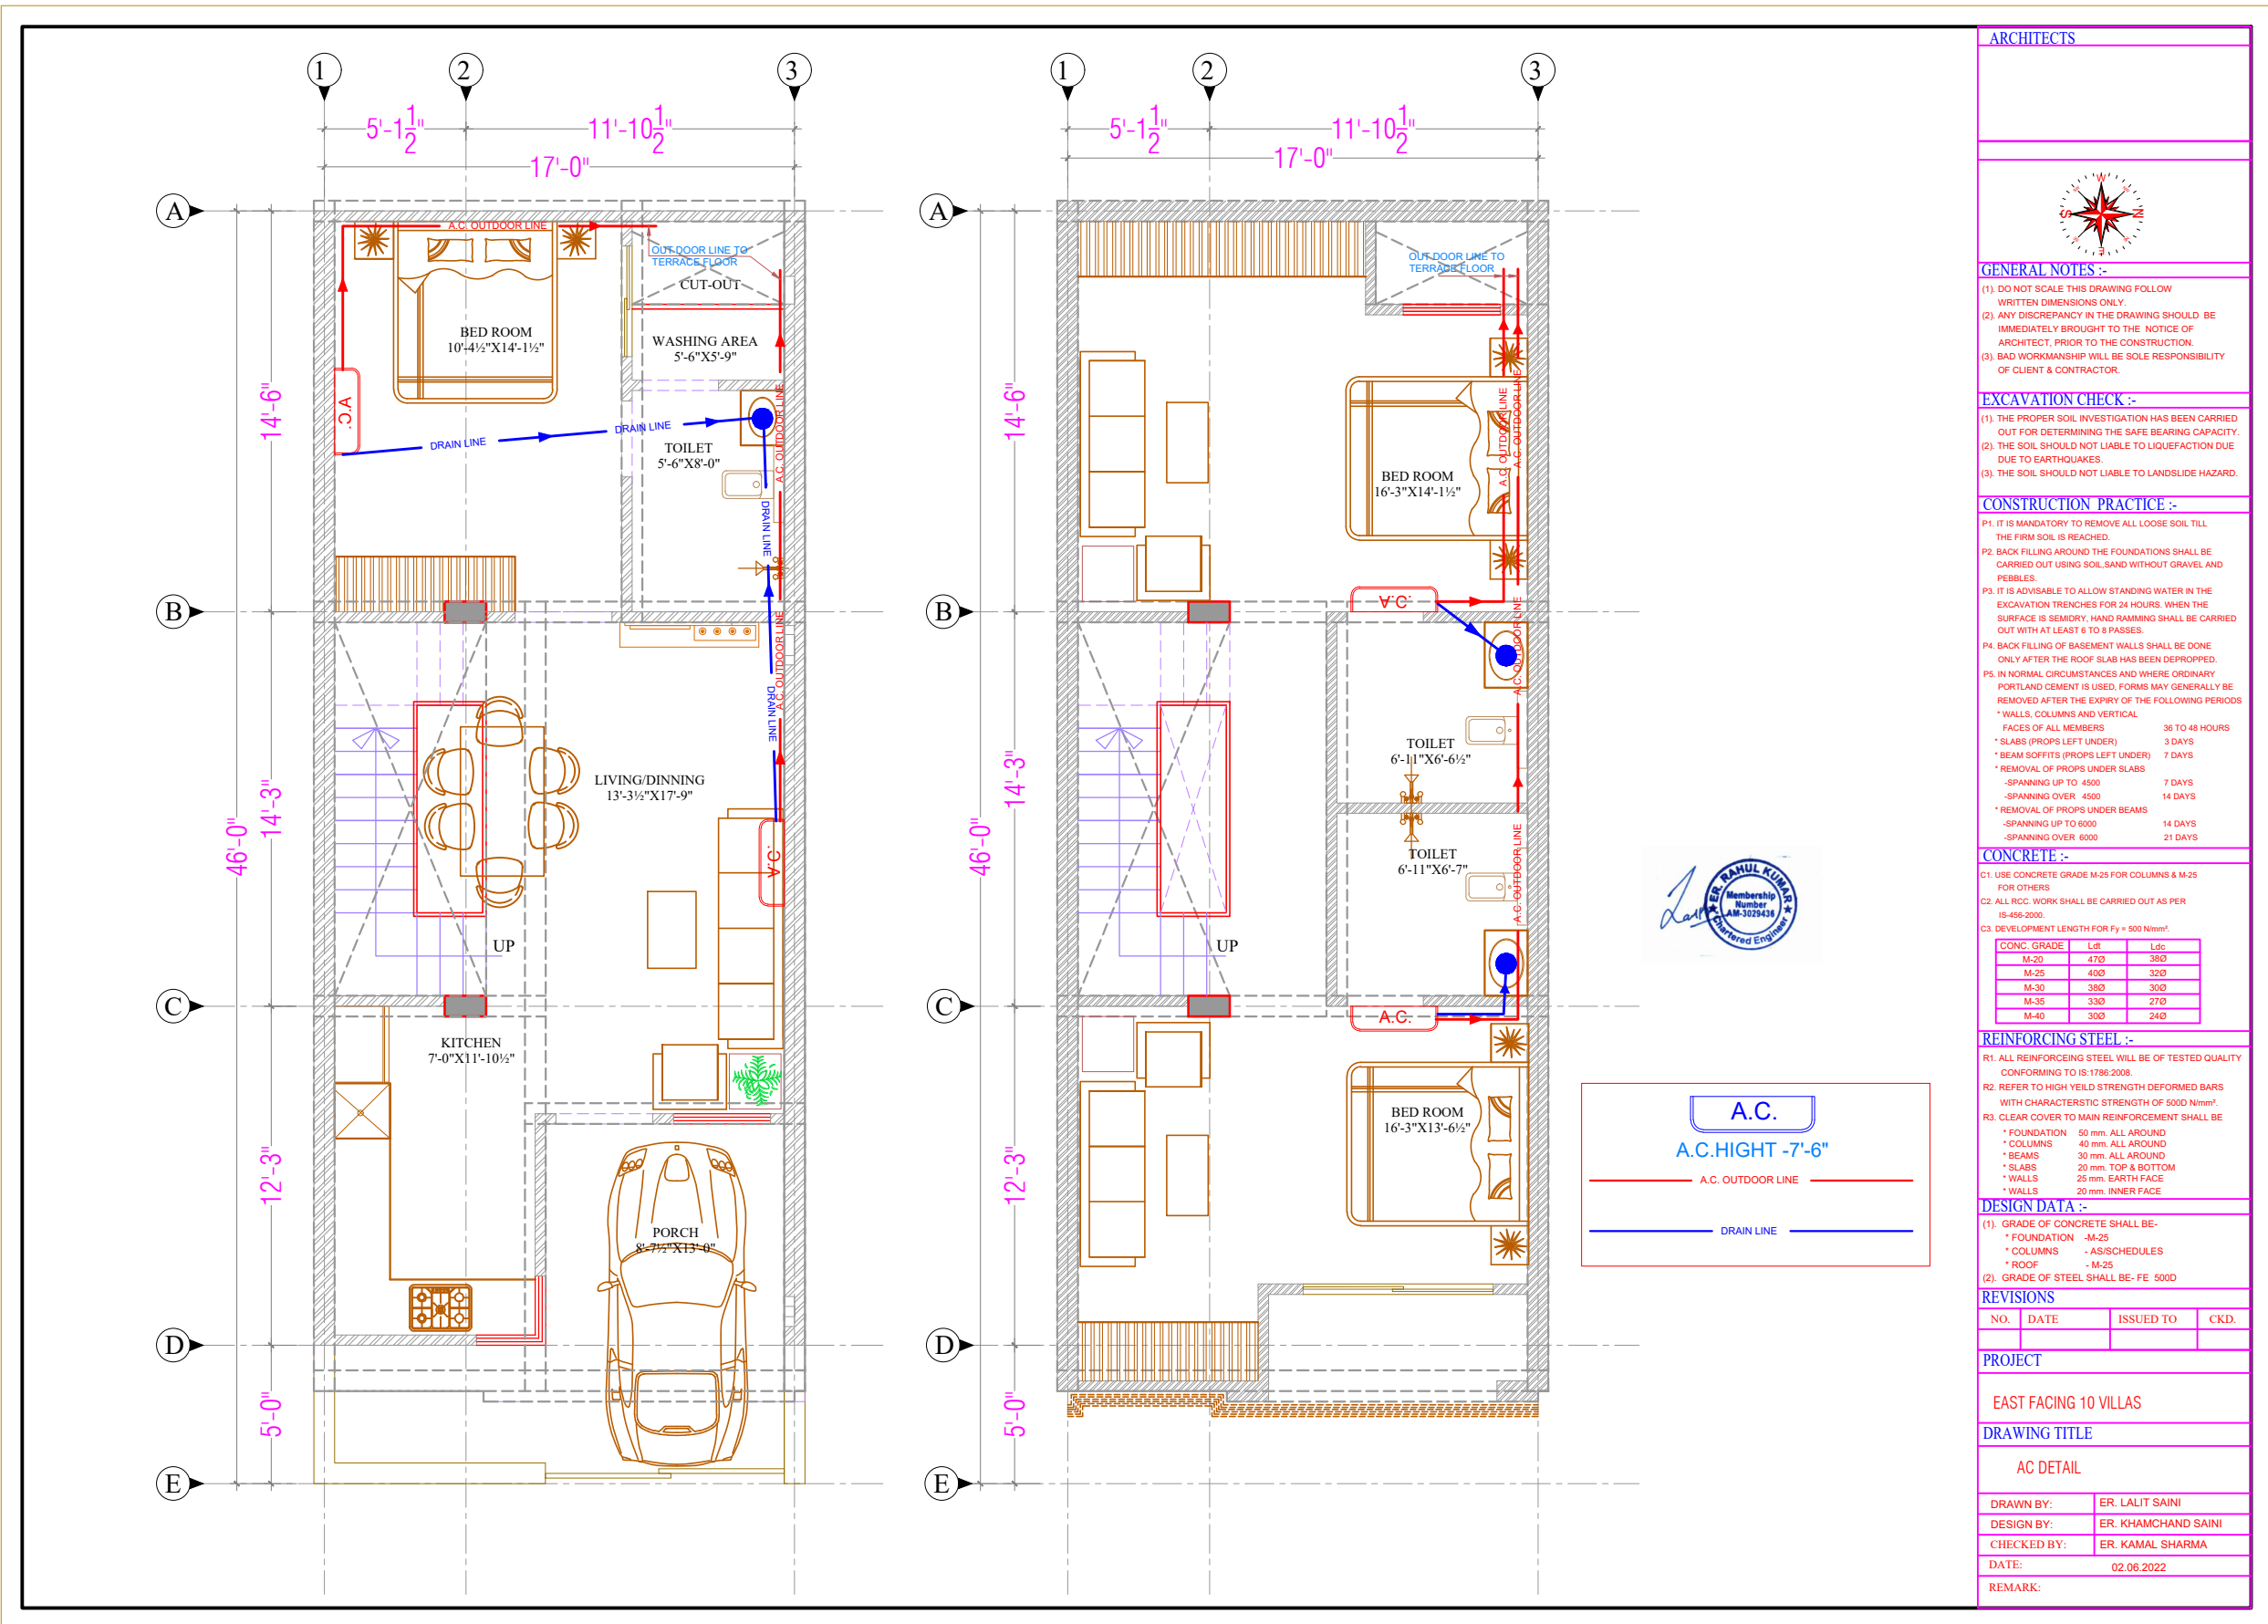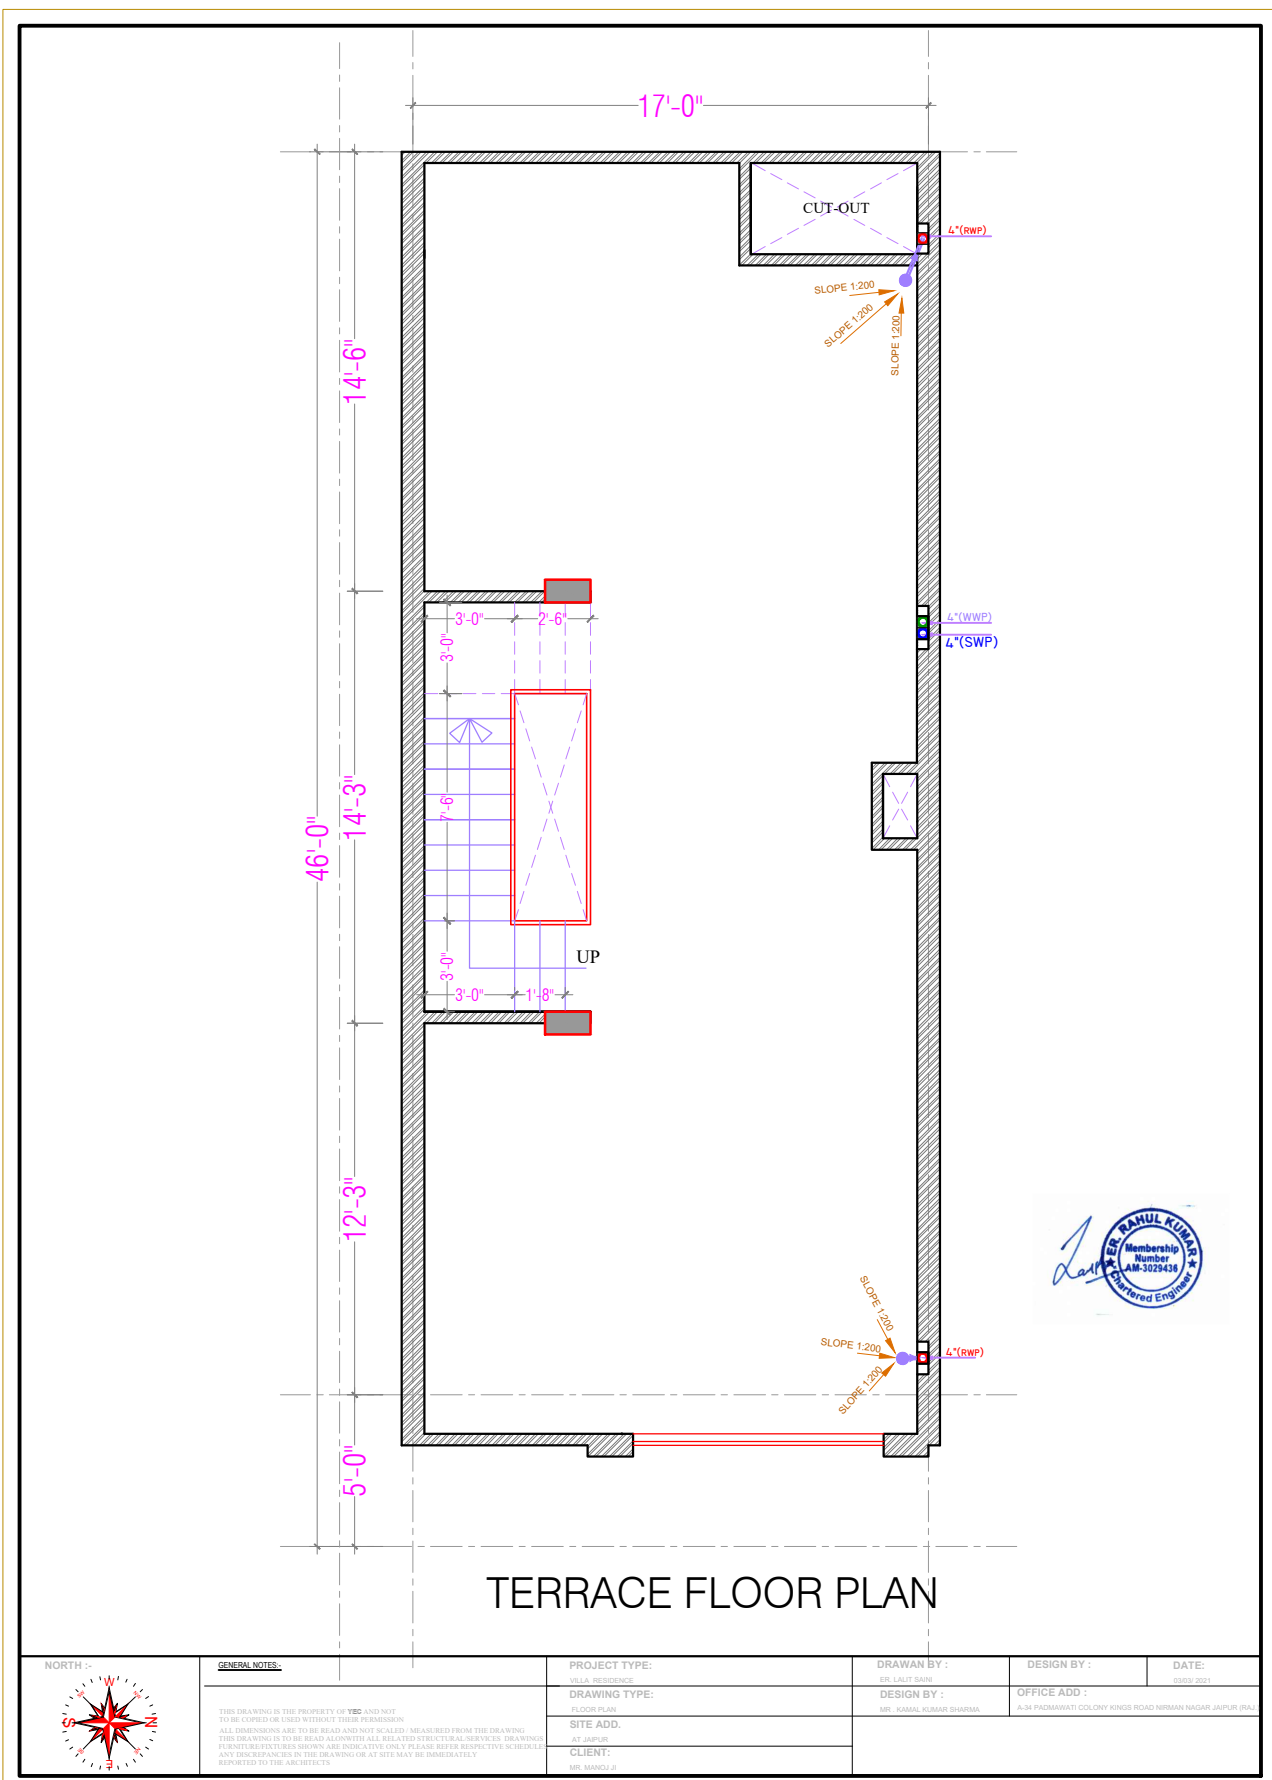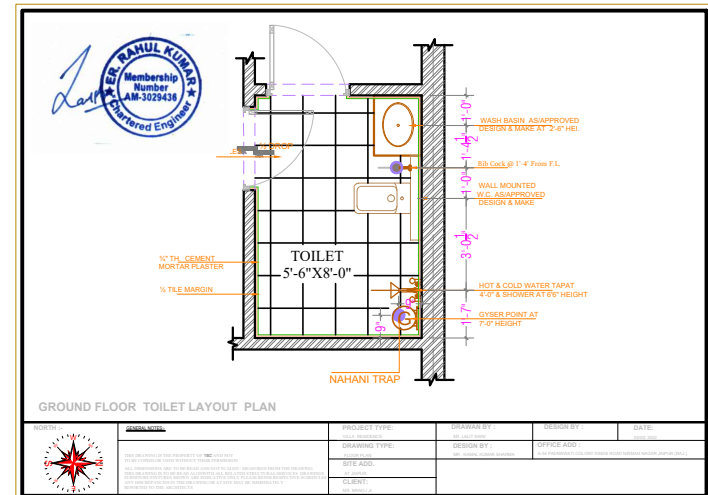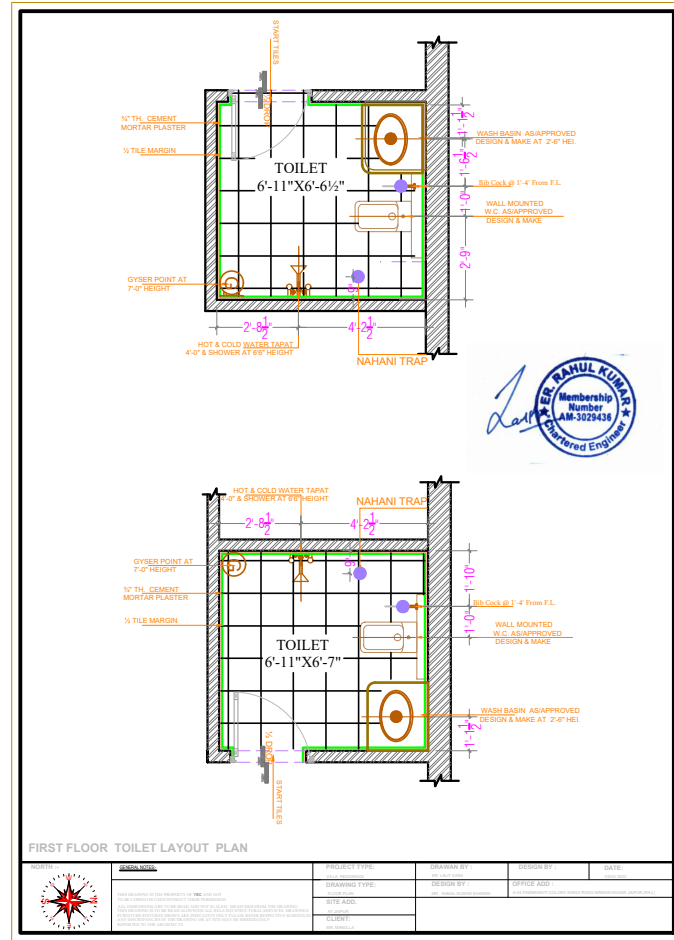
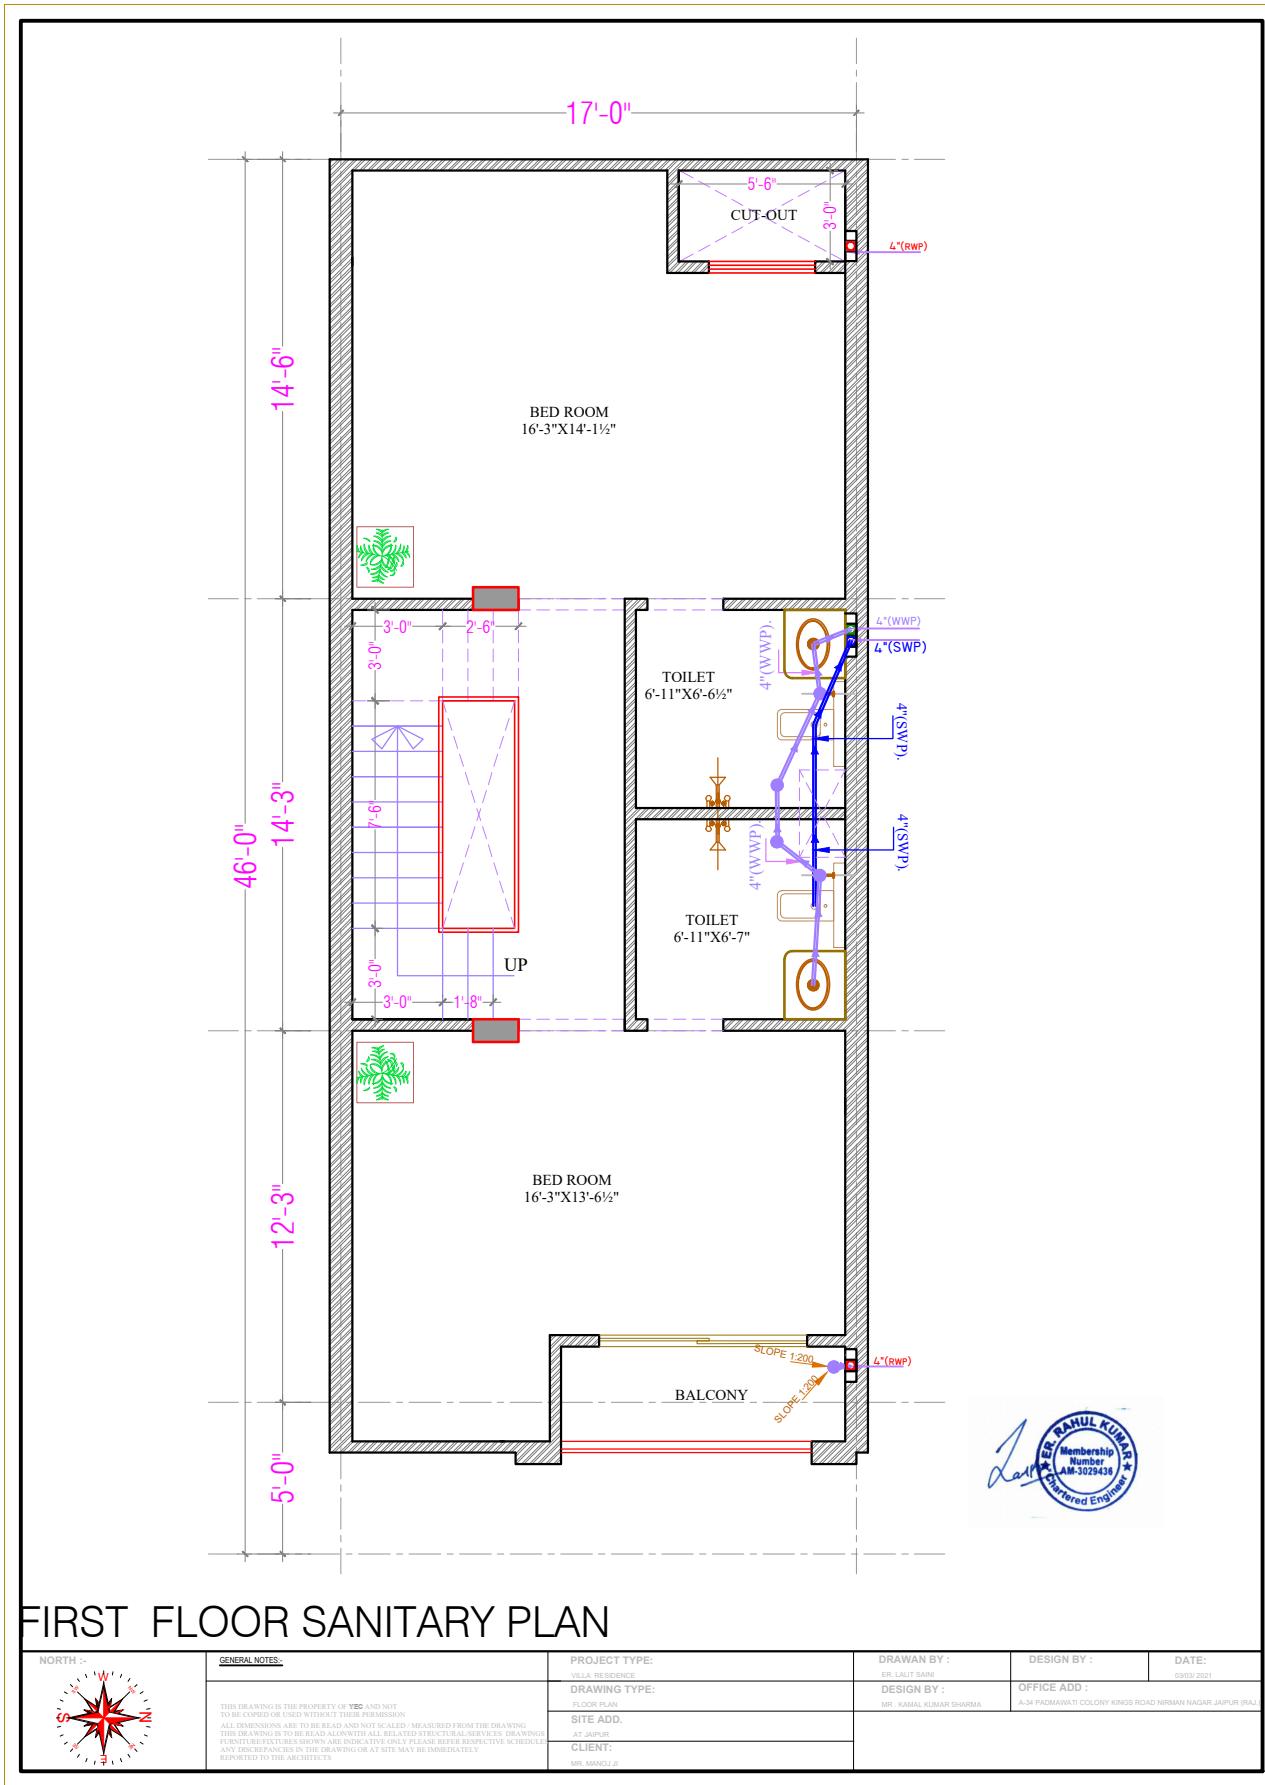
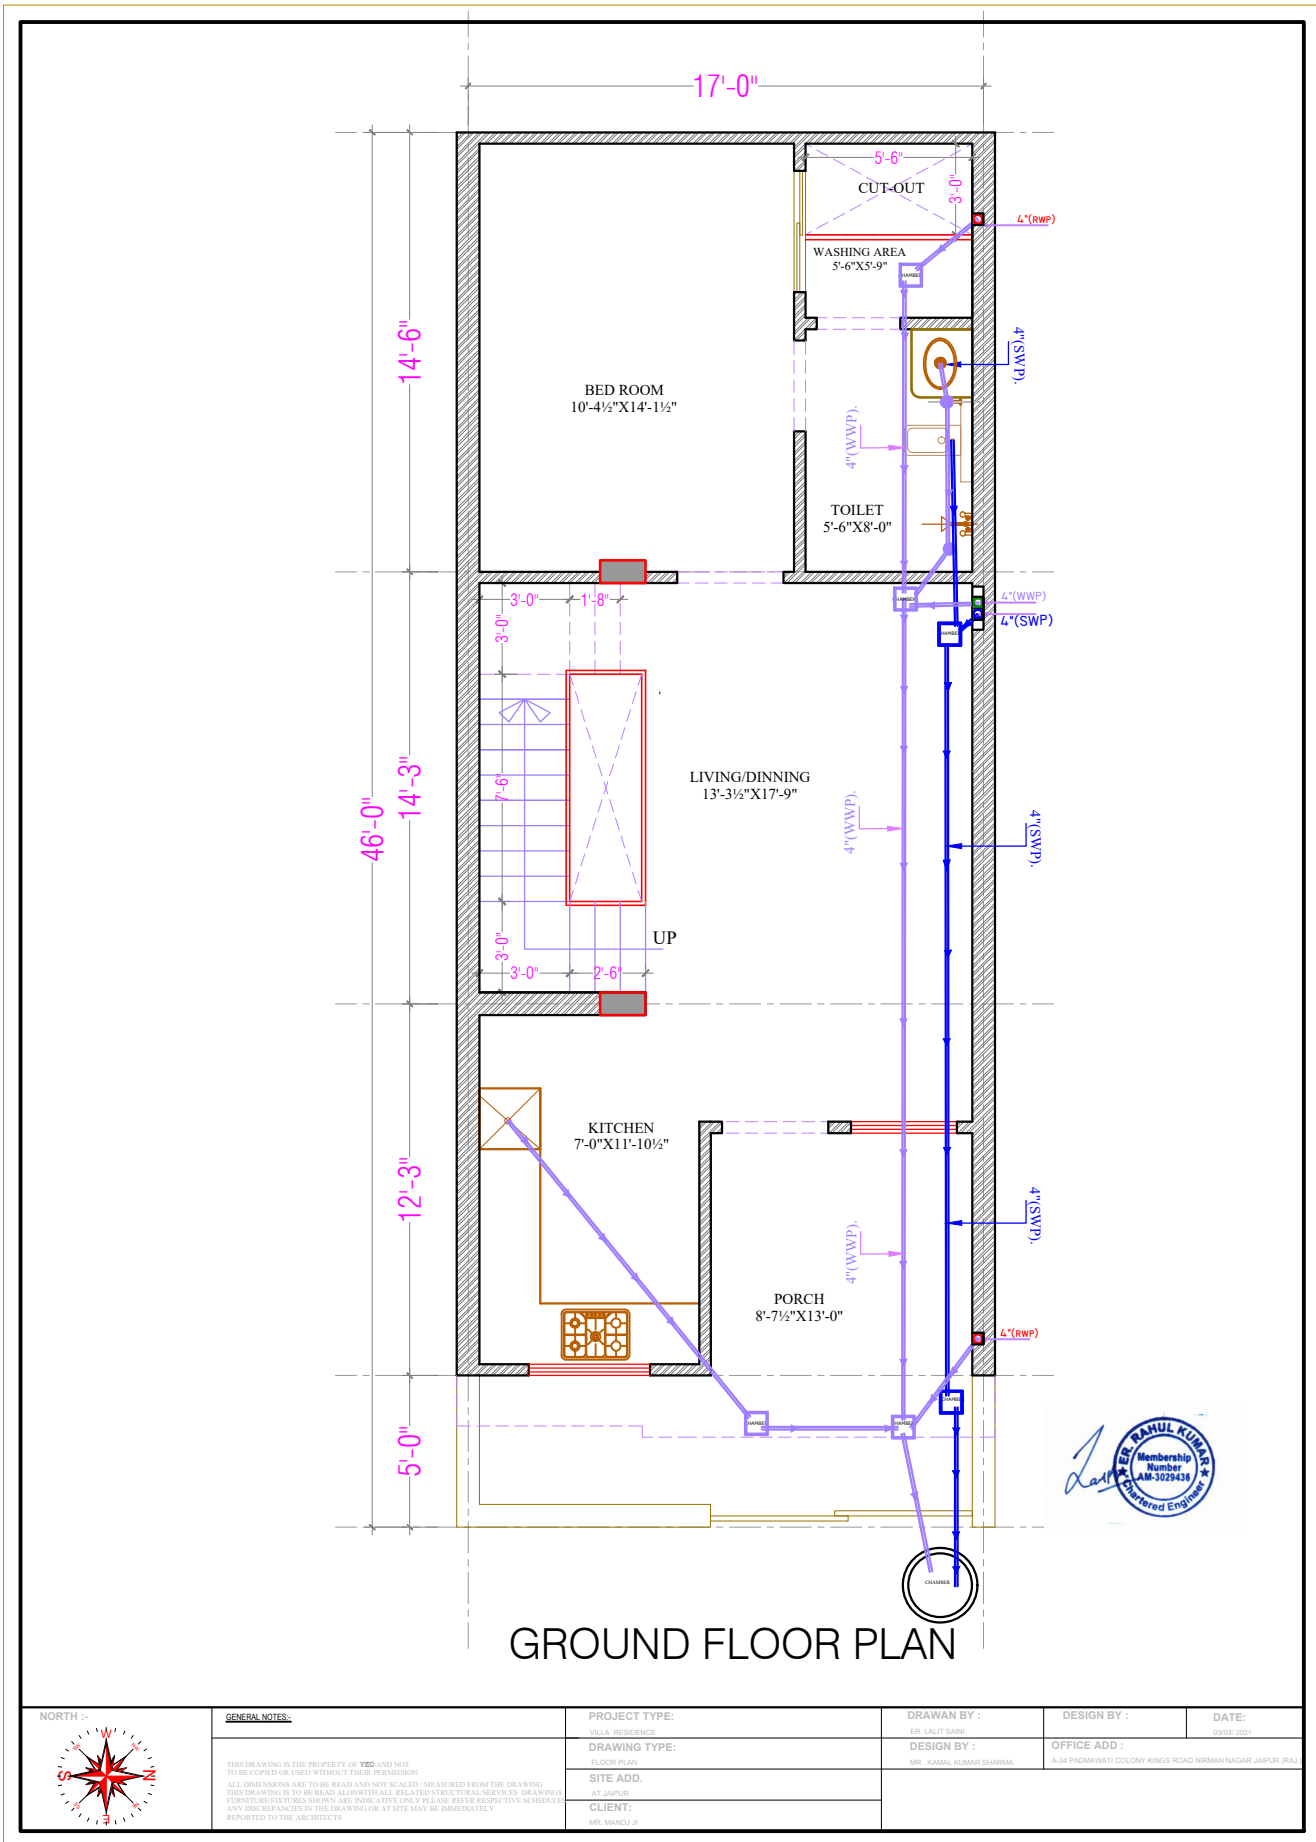


ARCHITECTS			
[Stamp]			
GENERAL NOTES:			
(1) DO NOT SCALE THIS DRAWING FOLLOW WRITTEN DIMENSIONS			
(2) ANY DISCREPANCY IN THE DRAWING SHOULD BE IMMEDIATELY BROUGHT TO THE NOTICE OF ARCHITECTS PRIOR TO THE CONSTRUCTION			
(3) ALL WORKMANSHIP SHALL BE THE RESPONSIBILITY OF CLIENT & CONTRACTOR			
EXCAVATION CHECK:			
(1) THE PROPOSED SOIL INVESTIGATION HAS BEEN CARRIED OUT FOR DETERMINING THE SOIL BEARING CAPACITY			
(2) THE SOIL SHOULD NOT BE LAMER TO DISAPPEARANCE DUE TO DISINTEGRATION			
(3) THE SOIL SHOULD NOT BE LAMER TO UNDESIRABLE HAZARD			
CONSTRUCTION PRACTICE:			
(1) IT IS MANDATORY TO REMOVE ALL LOOSE SOIL, TILL, AND OTHER DEBRIS BEFORE THE FOUNDATION IS LAYED			
(2) THE FOUNDATION SHALL BE CARRIED OUT ON THE SOIL WITHOUT GRAVEL AND FILLING			
(3) IT IS ADVISABLE TO ALLOW STANDING WATER IN THE EXCAVATION PROVIDED FOR A MINIMUM OF 24 HOURS			
(4) THE SURFACE OF EXCAVATION SHALL BE CARRIED OUT WITH A GRADIENT OF 1:1			
(5) THE FILL OF EXCAVATION SHALL BE DONE ONLY AFTER THE SOIL HAS BEEN COMPACTED			
(6) IN EXCAVATION, EXCAVATION SHALL BE DONE ONLY AFTER THE SOIL HAS BEEN COMPACTED			
(7) PORTLAND CEMENT IN LATEST FORMS MAY GENERALLY BE REMOVED AFTER THE SURFACE OF THE FILLING IS FINISHED			
CONCRETE:			
(1) USE OF CONCRETE GRADE M20 FOR COLUMNS & M25 FOR BEAMS			
(2) ALL RCC WORK SHALL BE CARRIED OUT AS PER IS: 456-2000			
(3) DEVELOPMENT LENGTH FOR ϕ 10mm			
REINFORCING STEEL:			
(1) ALL REINFORCING STEEL SHALL BE OF TESTED QUALITY CONFORMING TO IS: 1786			
(2) REFER TO HIGH YIELD STRENGTH DEFORMED BARS WITH CHARACTERISTIC STRENGTH OF 460 N/mm ²			
(3) CLEAR COVER TO MAIN REINFORCEMENT SHALL BE:			
- TO COLUMNS: 40mm ALL AROUND			
- TO BEAMS: 20mm ALL AROUND			
- TO SLABS: 20mm TOP & BOTTOM			
- TO WALLS: 20mm ALL AROUND			
- TO FLOORS: 20mm ALL AROUND			
DESIGN DATA:			
(1) GRADE OF CONCRETE SHALL BE:			
- FOUNDATION: M20			
- COLUMNS: M25			
(2) GRADE OF STEEL SHALL BE: FE 415			
REVISIONS			
NO.	DATE	ISSUED TO	CHKD.
1			
PROJECT			
EAST FACING 10 VILLAS			
DRAWING TITLE			
AC DETAIL			
DRAWN BY: []			
DESIGNED BY: []			
CHECKED BY: []			
DATE: 02.08.2022			
REMARK:			




VILLA NO. L-27 PLUMBING PLAN

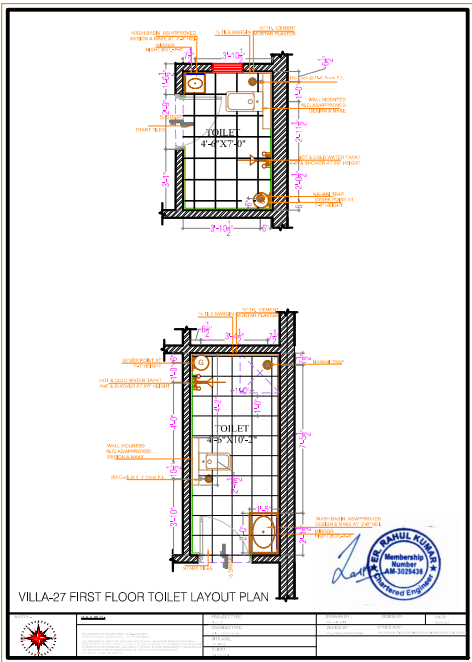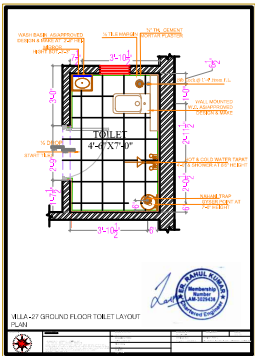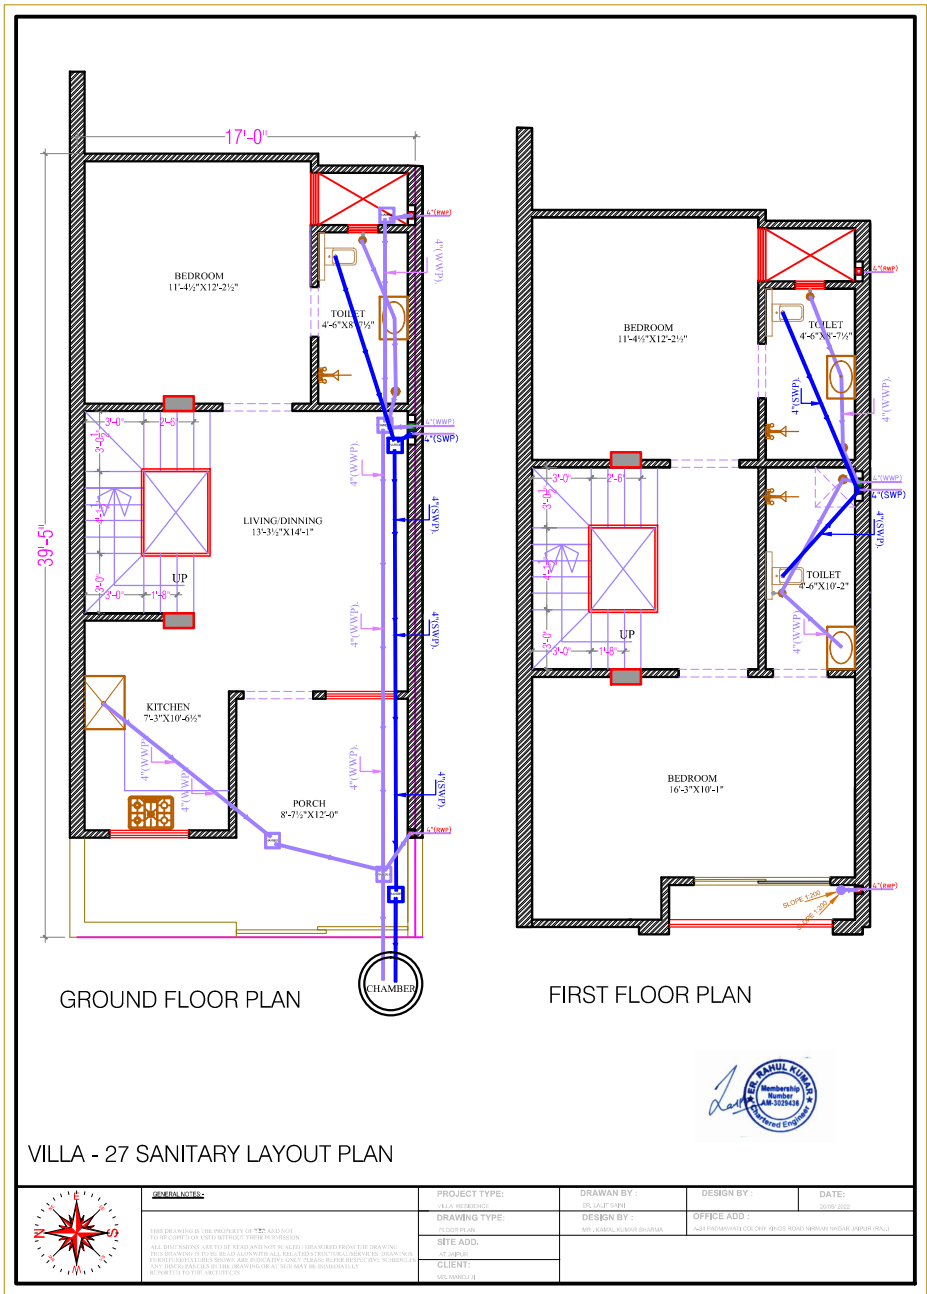




VILLA NO. L-26 PLUMBING PLAN

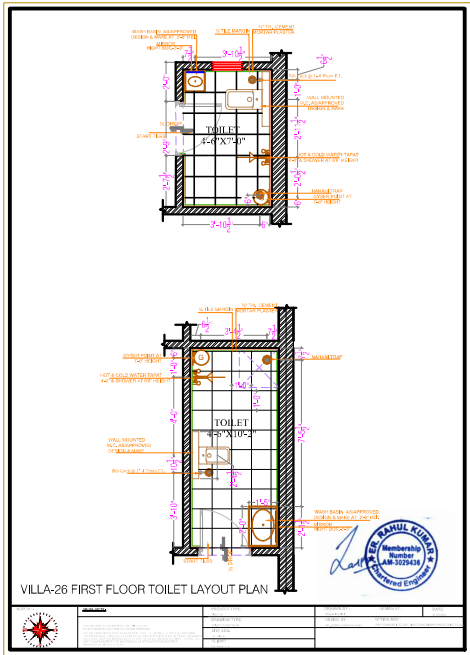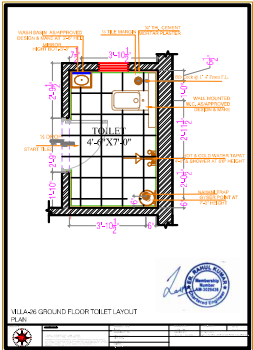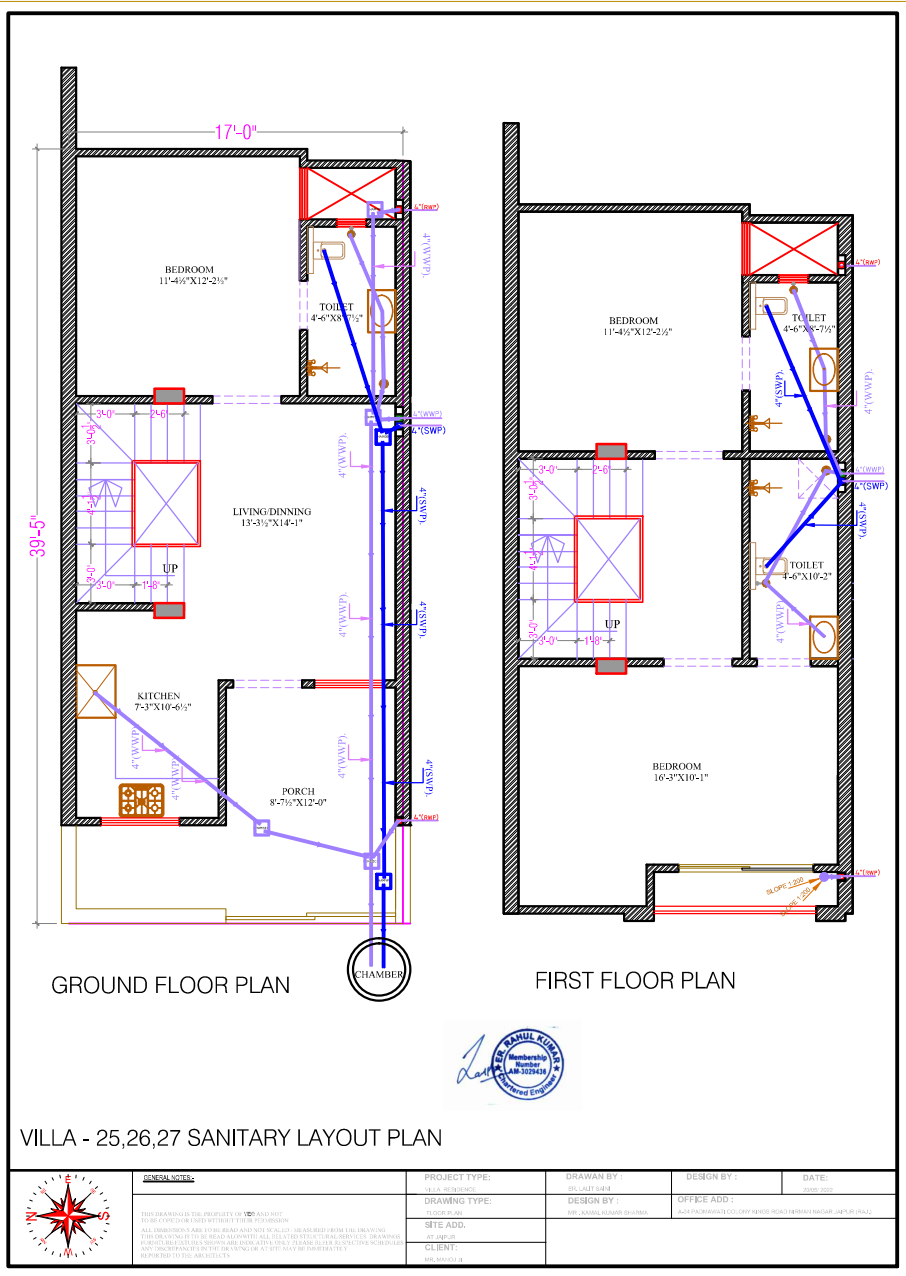

VILLA NO. L-25 PLUMBING PLAN

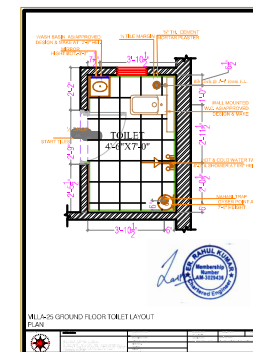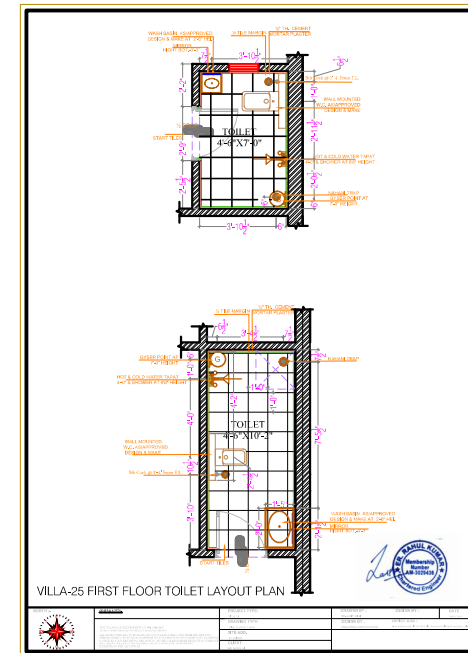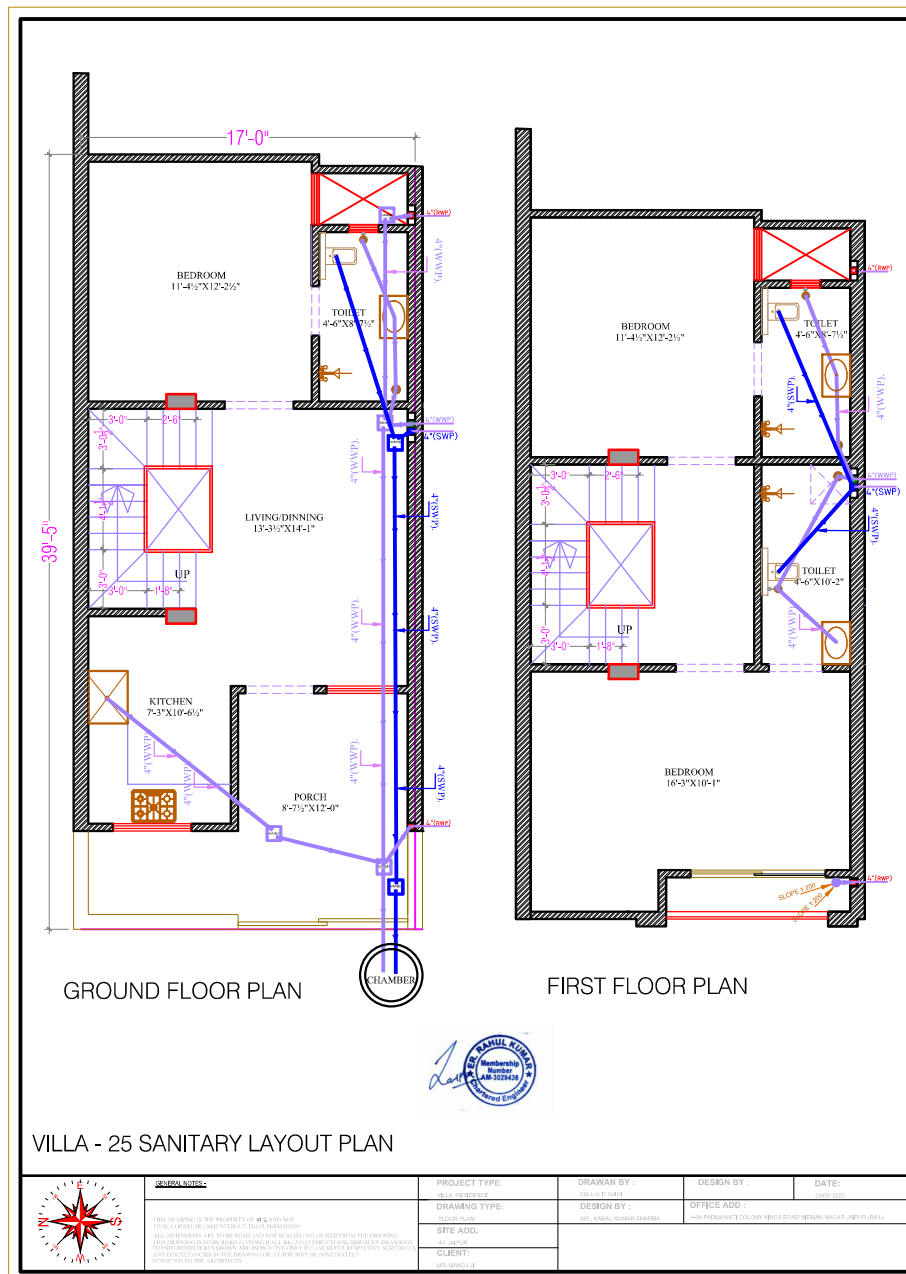

VILLA NO. L-29 PLUMBING PLAN

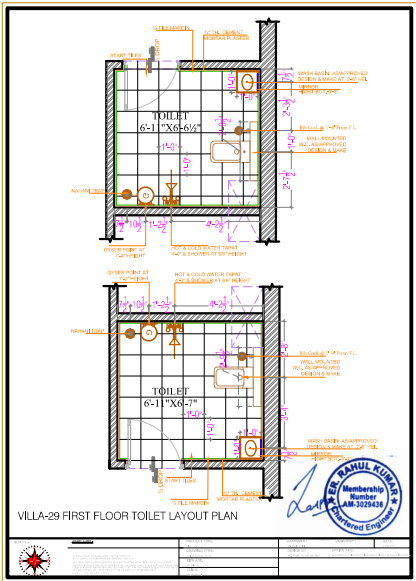
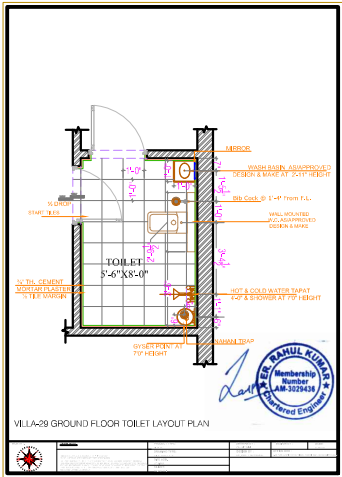
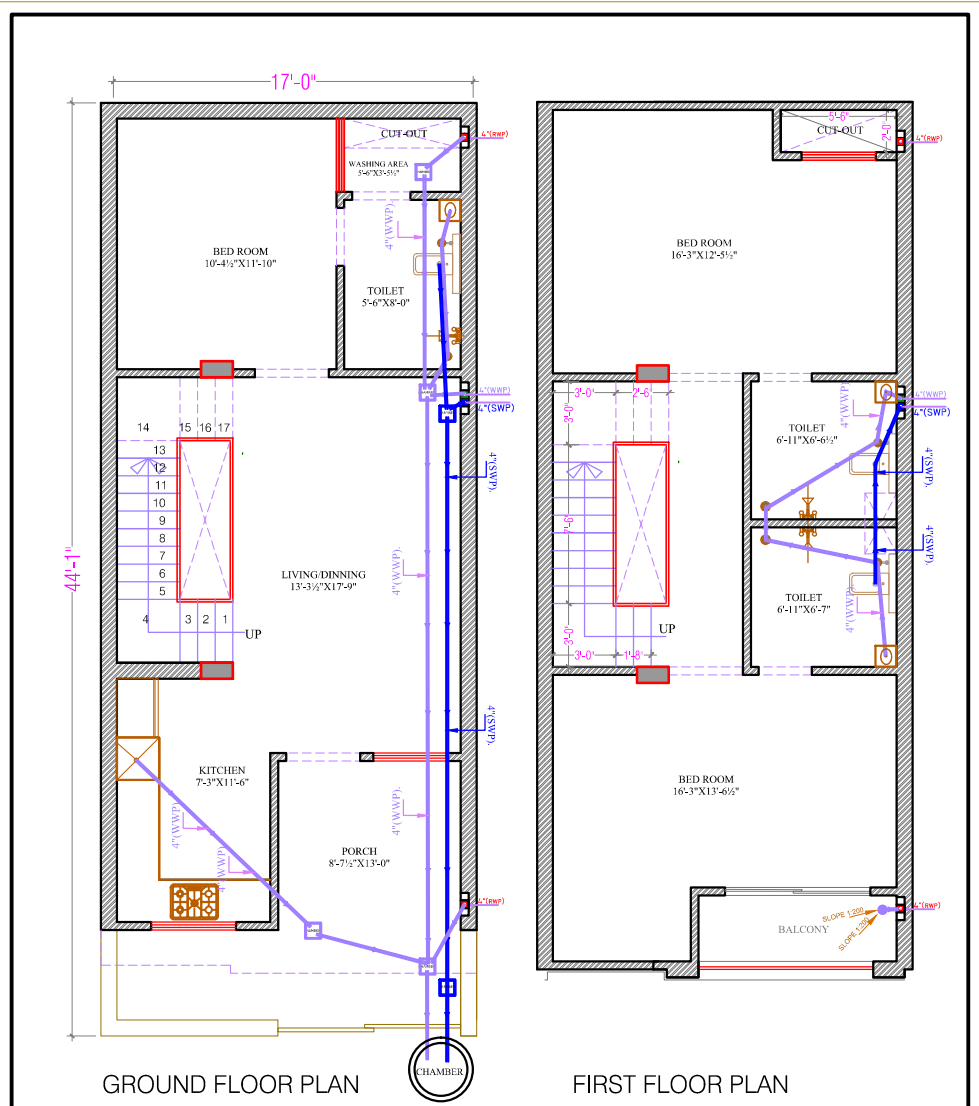


VILLA - 29 SANITARY LAYOUT PLAN



GENERAL NOTES: THIS DRAWING IS THE PROPERTY OF THE ARCHITECT AND NOT TO BE COPIED OR USED WITHOUT THEIR PERMISSION. ALL DIMENSIONS ARE TO BE READ AND NOT TO BE ALIGNED FROM THE DRAWING. THIS DRAWING IS TO BE READ ALONGWITH ALL RELATED STRUCTURAL SERVICES DRAWINGS. FOR THE SUPPLEMENTARY DRAWINGS ARE FROM OTHER ONLY TO BE READ BEING THE INCOMPLETE. ANY DISCREPANCIES IN THE DRAWING OR AT SITE MAY BE IMMEDIATELY REPORTED TO THE ARCHITECTS.	PROJECT TYPE: LOCAL RESIDENTIAL	DRAWN BY: MR. RAHUL KUMAR SHARMA	DESIGN BY: OFFICE ADD: A-34 PICHAWATI COLONY KINGS ROAD NEERAMANGAL (APUR) (RAJ)	DATE: 08/05/2023
	DRAWING TYPE: FLOOR PLAN	DESIGN BY: MR. RAHUL KUMAR SHARMA	OFFICE ADD: A-34 PICHAWATI COLONY KINGS ROAD NEERAMANGAL (APUR) (RAJ)	
	SITE ADD: AT GATEWAY			
	CLIENT: MR. RAHUL K.			

VILLA NO. L-28 PLUMBING PLAN

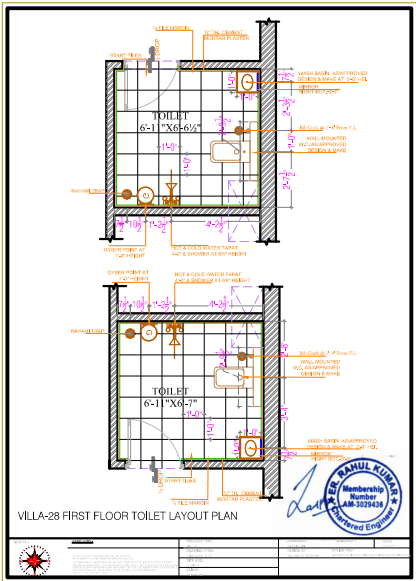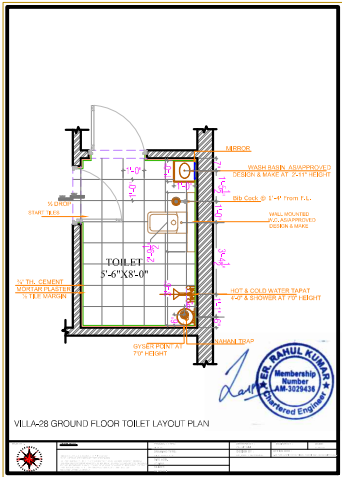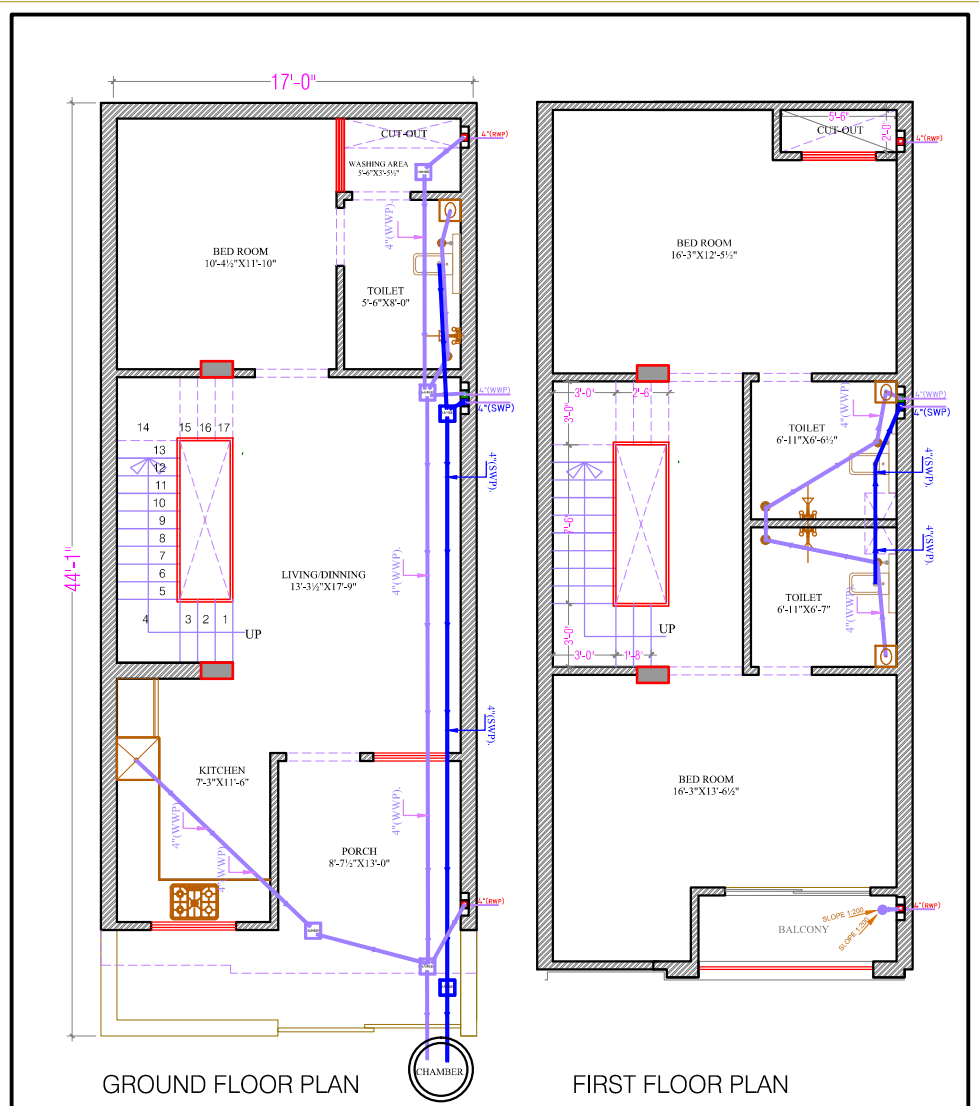

VILLA - 28 SANITARY LAYOUT PLAN



GENERAL NOTES: THIS DRAWING IS THE PROPERTY OF "R" AND NOT TO BE COPIED OR USED WITHOUT THEIR PERMISSION. ALL DIMENSIONS ARE TO BE READ AND NOT TO BE MEASURED FROM THE DRAWING. THIS DRAWING IS TO BE READ ALONGWITH ALL RELATED STRUCTURAL SERVICES DRAWINGS. FORGET SUPPORTED DRAWINGS ARE FROM OTHER ONLY TO BE READ BEING THE INVOICES. ANY DISCREPANCIES IN THE DRAWING OR AT SITE MAY BE IMMEDIATELY REPORTED TO THE ARCHITECTS.	PROJECT TYPE: WATER RESERVES	DRAWN BY : S. S. S. S. S.	DESIGN BY : OFFICE ADD :	DATE: 2020/2021
	DRAWING TYPE: FLOOR PLAN	DESIGN BY : MR. KAMAL KUMAR SHARMA	OFFICE ADD : A-34 PICHAWATI COLONY KINGS ROAD NEERAMANGAL (APUR) (RAJ)	
	SITE ADD: AT GATEWAY			
	CLIENT: MR. S. S. S. S.			