
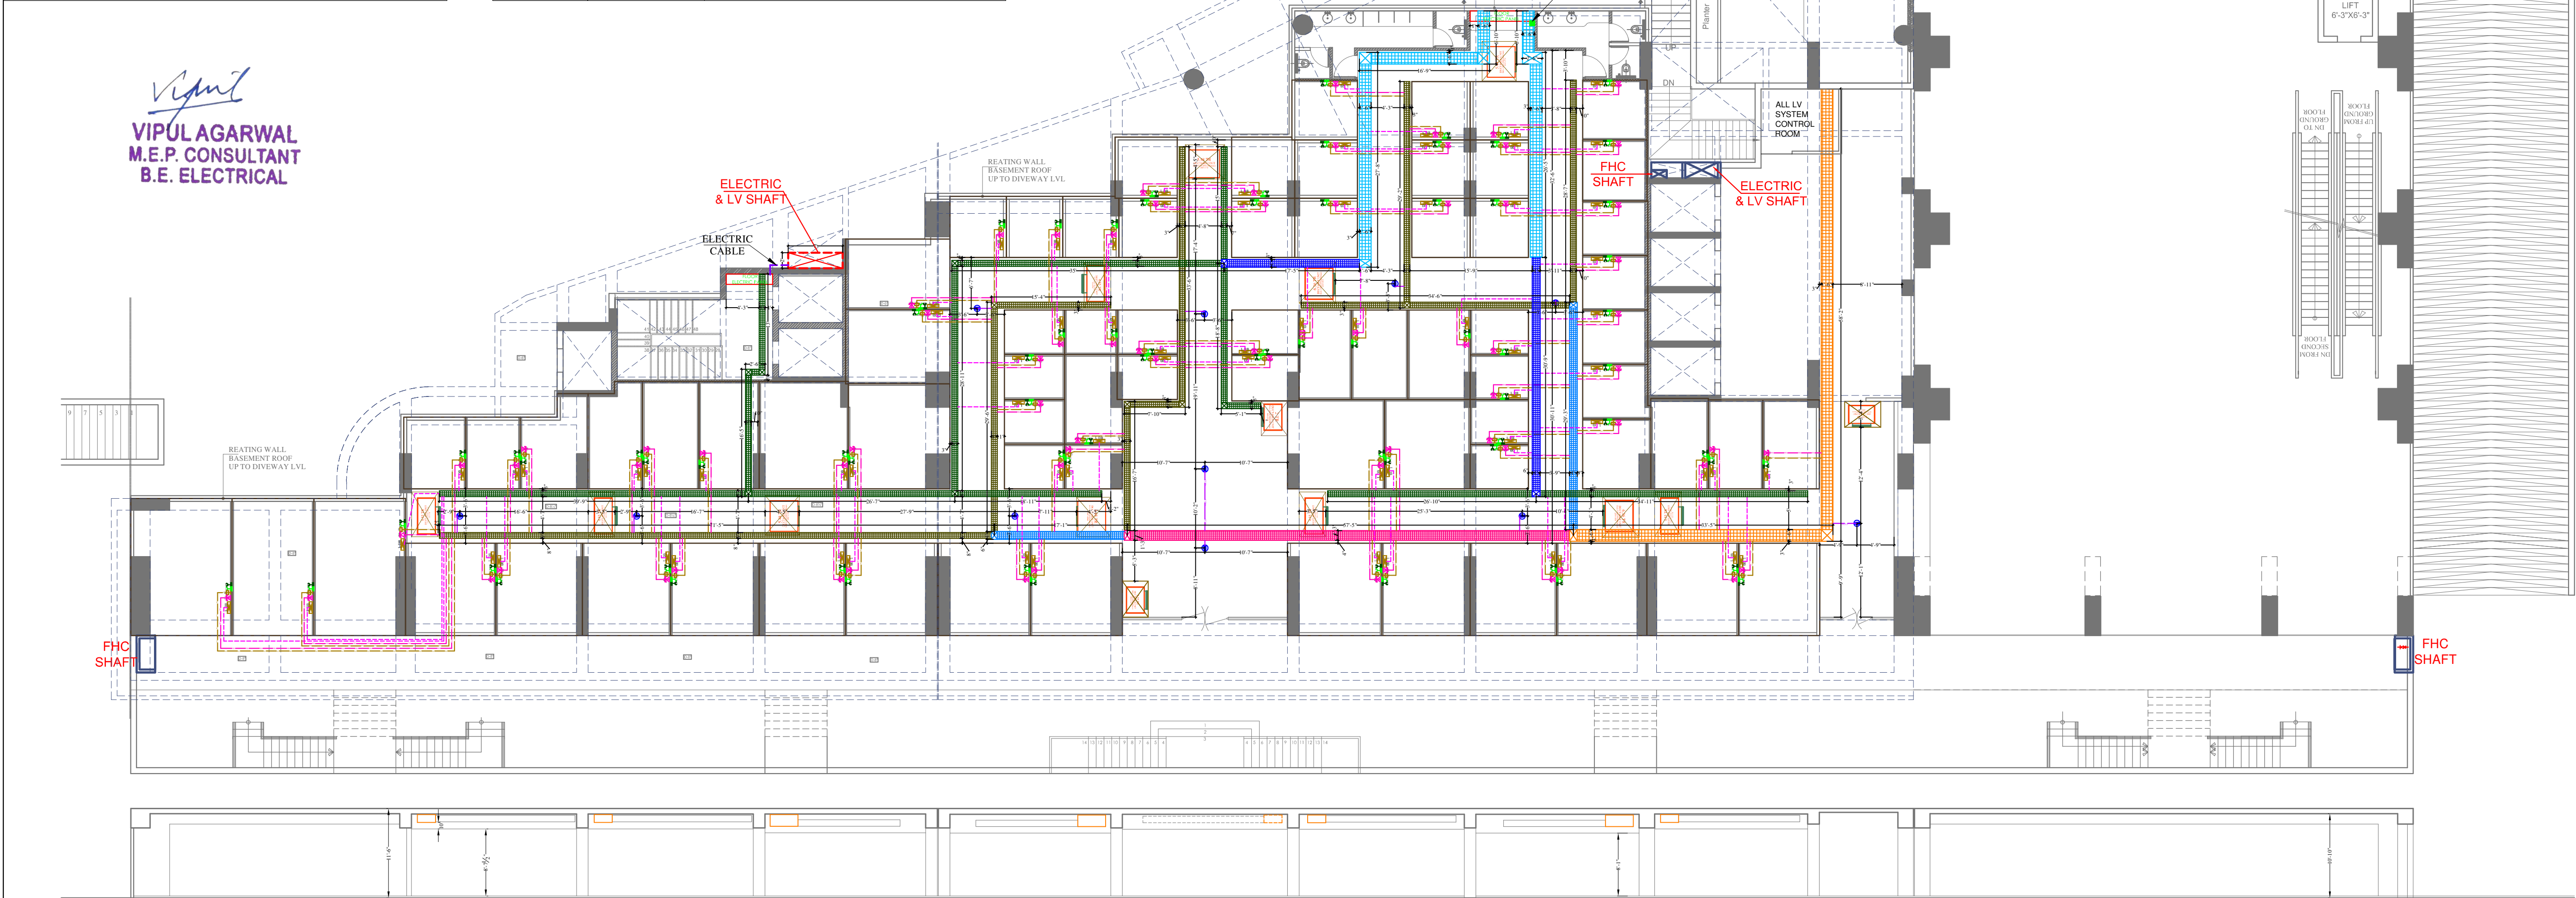



LEGENDS:				
Mounting Height	No.	1D	Symbol	Description
IN CABLE TRAY			TV	RG6 CABLE FOR TV WIRING
IN CABLE TRAY			TEL	0.5MM 2 PAIR WIRE FOR TEL WIRING
IN CABLE TRAY				MCBDB ELECTRIC CABLE
IN CABLE TRAY			CCTV	3+1 COAXIAL WIRE FOR SECURITY CAMERA (C.C.T.V.)
+18"	73	SET		1No.Telephone Jack, 1No. TV Coaxial Jack, 1Nos. 6A Socket Controlled by 1No. 6A Switch & 1Nos. 16A 5Pin Socket Controlled by 1No. 16A Switch
+60"	73	MCB DB		MCB DISTRIBUTION BOARD
CEILING	11	CCTV		CEILING CCTV CAMERA
SERVICES CONSULTANT: VIPUL CONSULTING, F 9 / 440 , Keshav Marg Chitrakut Scheme,Jaipur PH:91-0-93146-10438 ,0141-2440946 Mail:vipul8599@yahoo.com				

LEGENDS:		
Mounting Height	Symbol	Description
CEILING		CEILING SUSPENDEED ELECTRIC CABLE TRAY WIDE:-18"
CEILING		CEILING SUSPENDEED ELECTRIC CABLE TRAY WIDE:-12"
CEILING		CEILING SUSPENDEED ELECTRIC CABLE TRAY WIDE:-9"
CEILING		CEILING SUSPENDEED LV CABLE TRAY WIDE:-18"
CEILING		CEILING SUSPENDEED LV CABLE TRAY WIDE:-15"
CEILING		CEILING SUSPENDEED LV CABLE TRAY WIDE:-12"
CEILING		CEILING SUSPENDEED LV CABLE TRAY WIDE:-9"

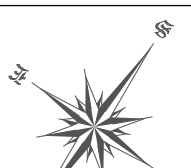

CLIENT :	PROJECT:	ARCHITECTS :	NAME OF DRAWING:	DRAWN BY:	PROJECT NO. :	NORTH:			
ANUKAMPA AVAS VIKAS LLP	PROPOSED MIX USE BUILDING PLOT NO. S-01, NEAR SHYAM NAGAR, AJMER ROAD JAIPUR	 GRAPHITE DESIGN STUDIO ARCHITECTS, INTERIOR DESIGNERS, PLANNERS 68, Janak Puri -1st, Imliwala phatak, Opp Jain Mandir, Jaipur CONTACT NO. +91-9928334414, 0141-2593414 email: studiosgraphite@gmail.com Website : www.graphitedesignstudio.com	LOWER GROUND FLOOR CCTV, TV, TELEPHONE, DB CABLE & CABLE TRAY PLAN	VIJESH	302019ANUK00100				
				CKD. BY:	SCALE :				
				SANJAY		APPROVED BY:	DATE :	REV.:	DRAWING NO. : MEP/AS/L.G.F./CT-02
				VIPUL AGARWAL	05-12-2020	00			


EARTHING DETAILS		
05		2POLE STRUCTURE BODY EARTH
02		HT METER BOX BODY EARTH
02		11KV HT VCB BOX BODY EARTH
04		TRANSFORMER BODY EARTH
04		TRANSFORMER NEUTRAL EARTH
04		DG SET BODY EARTH
04		DG SET NEUTRAL EARTH
04		LIGHTNING ARRESTER BODY EARTH
11		ELECTRIC PANEL BODY EARTH
02		TELEPHONE EXCH. BODY EARTH
16		LIFT PANEL BODY EARTH
NOTES: 1. ALL NEUTRAL EARTHS TO BE CONNECTED 50 X 3 GI EARTH STRIP FROM EARTH PIT TO EQUIPMENT. 2. ALL BODY EARTHS TO BE CONNECTED 25 X 3 GI EARTH STRIP FROM EARTH PIT TO EQUIPMENT.		

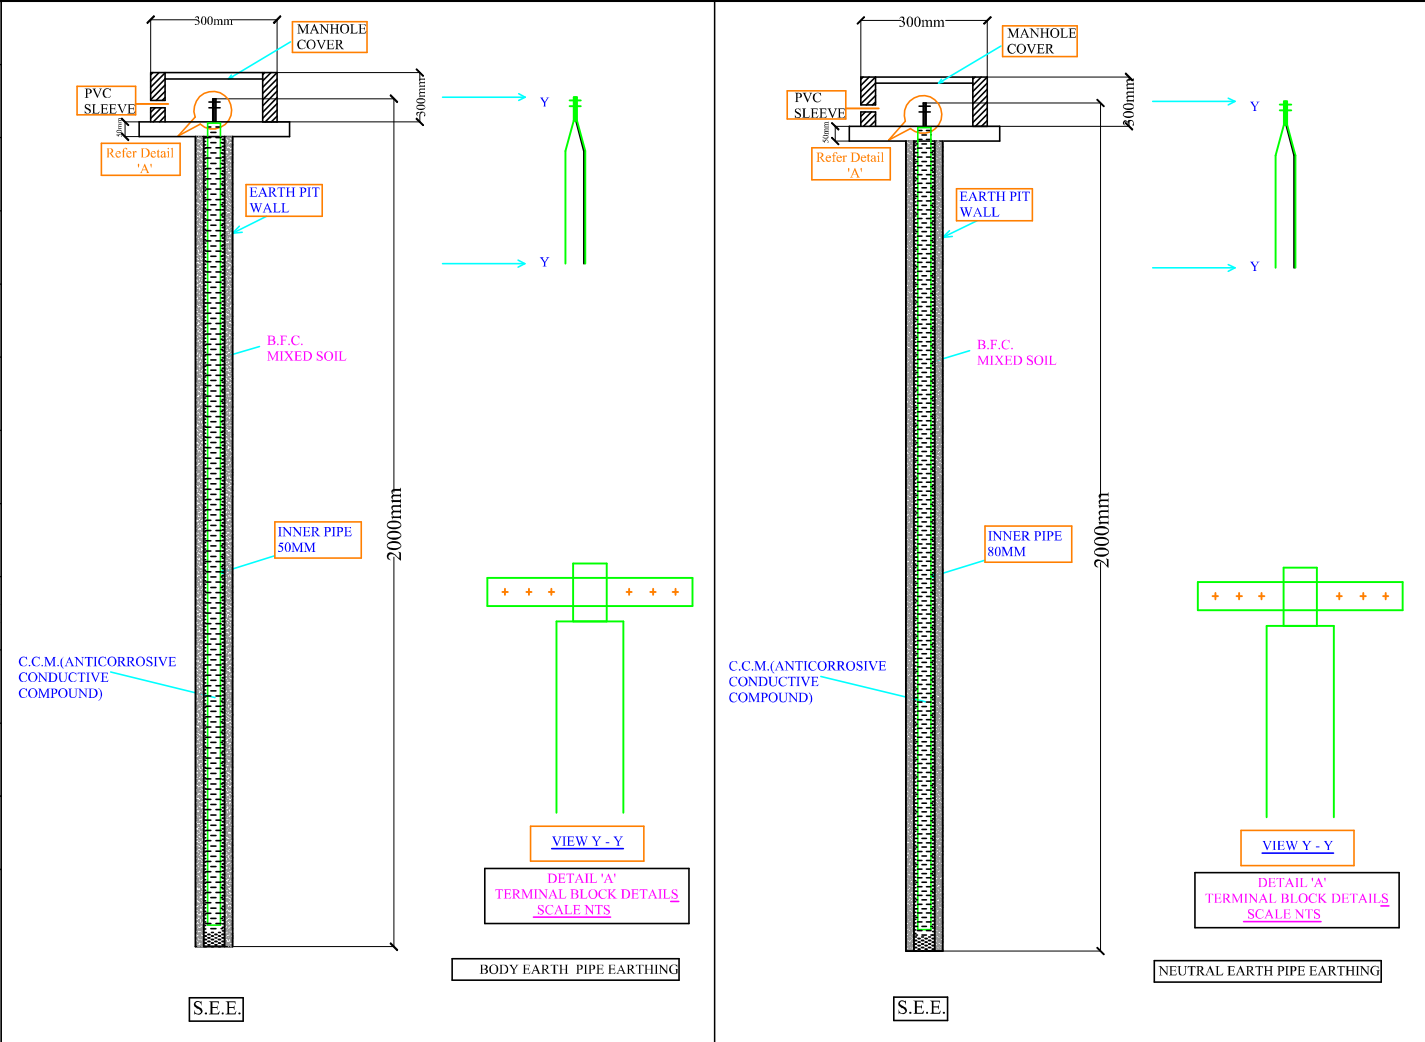

Lighting
Arrester

Model: Stormaster – ESE -
50 (Level 2/Medium
Protection)
(Protection radius - 35M,
Mast Height - 2 Mtr)

Vipul
VIPUL AGARWAL
M.E.P. CONSULTANT
B.E. ELECTRICAL

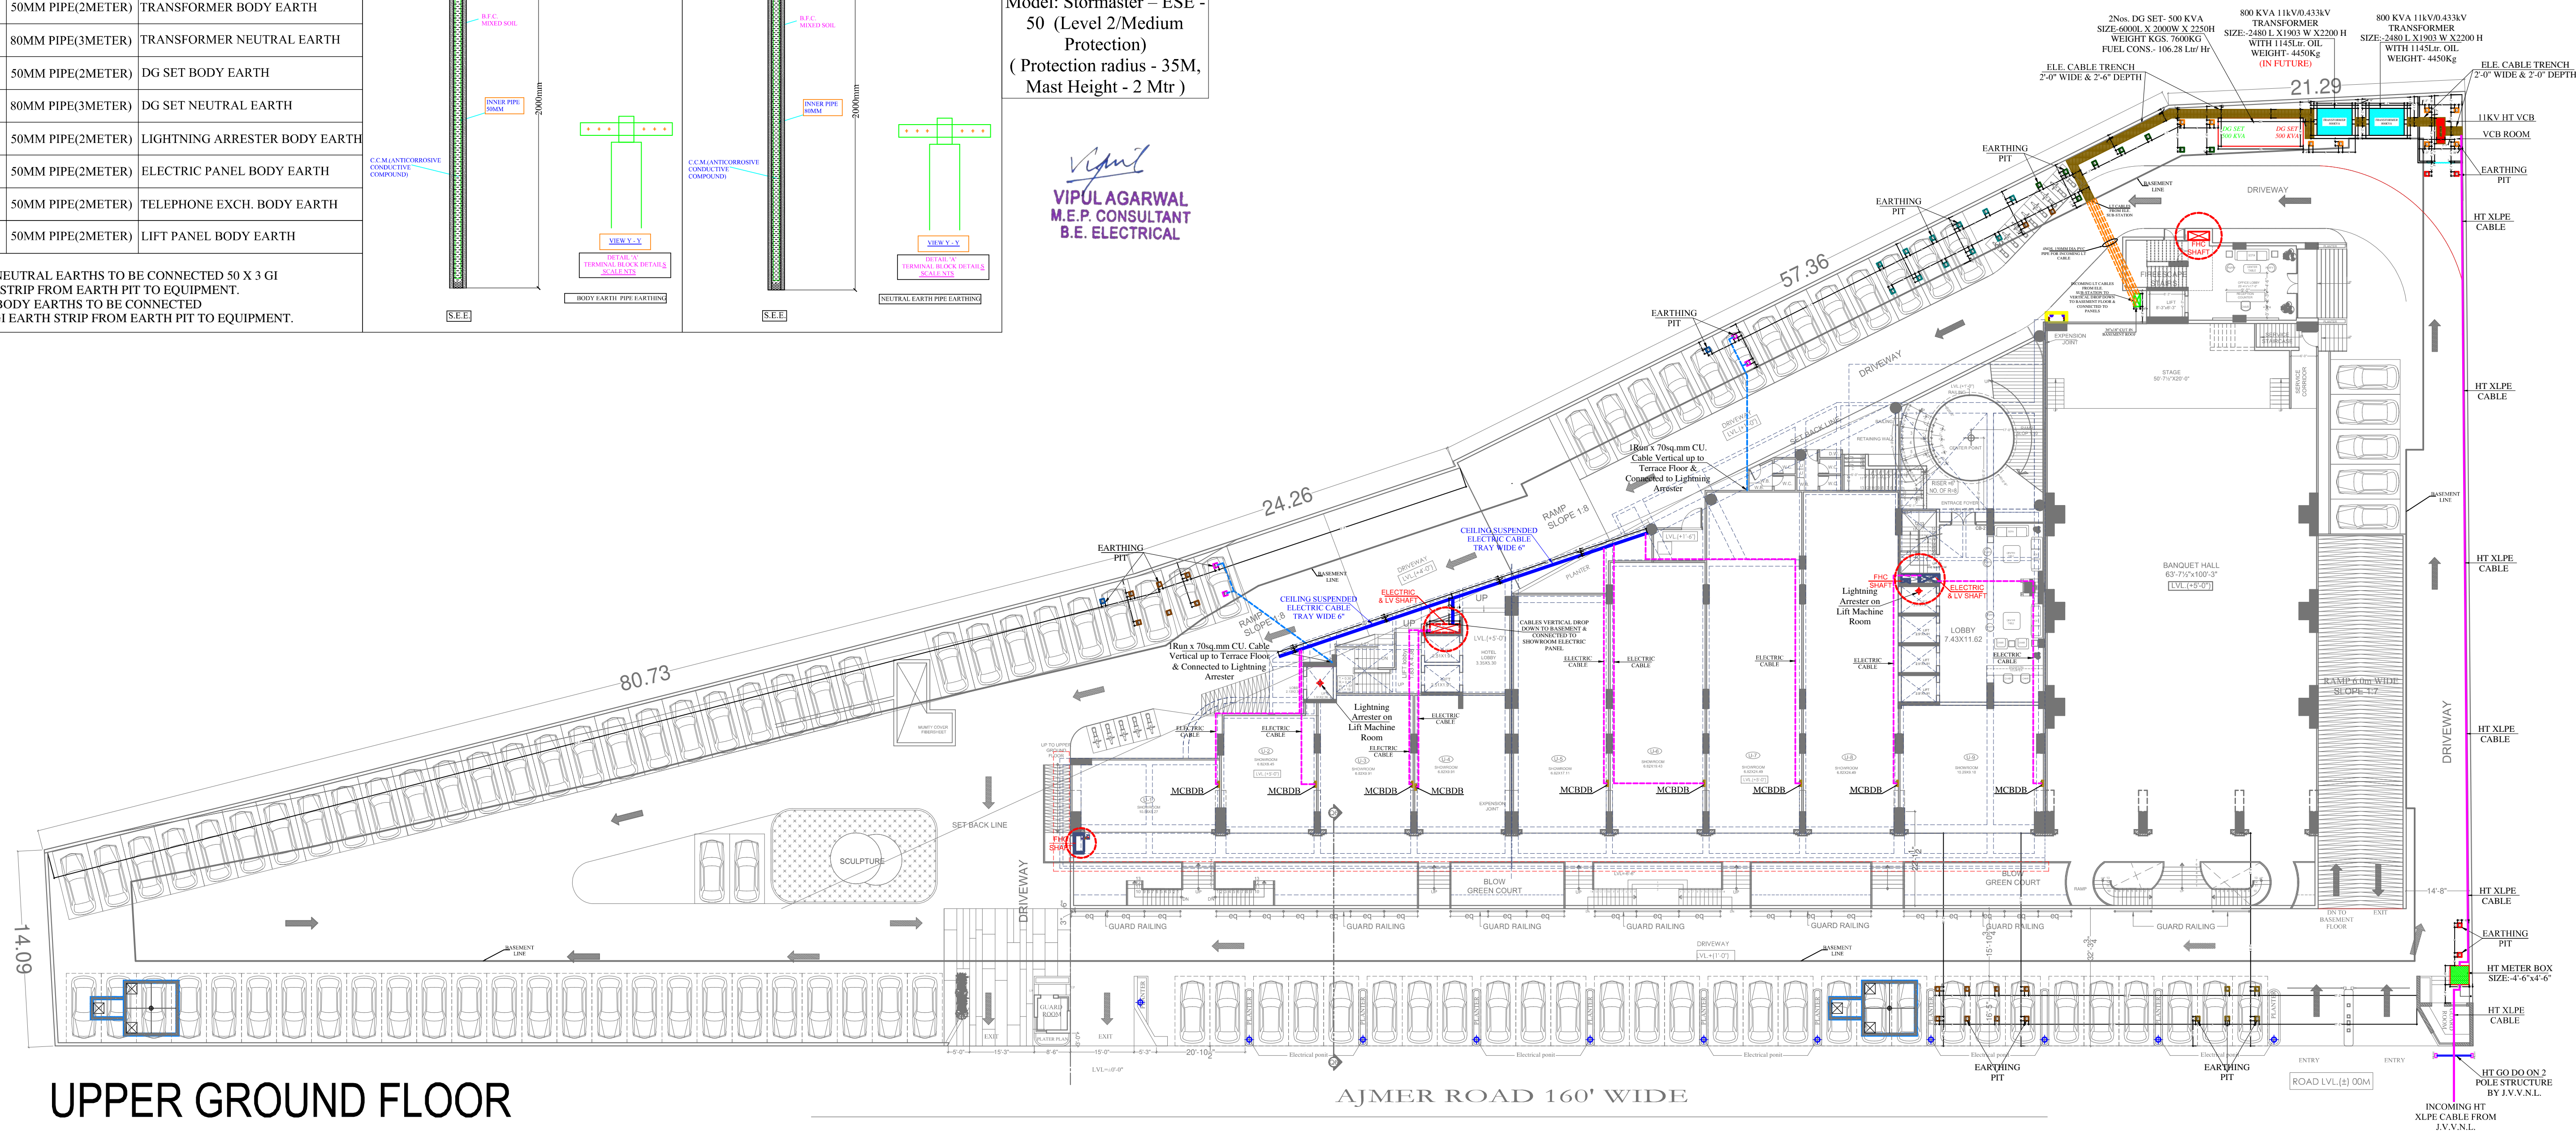


CLIENT : ANUKAMPA AVAS VIKAS LLP		ARCHITECTS : des^{ign}studio GRAPHITE DESIGN STUDIO ARCHITECTS, INTERIOR DESIGNERS, PLANNERS 68, Janak Puri -1st, Imliwala phatak, Opp Jain Mandir, Jaipur CONTACT NO. +91-9928334414, 0141-2593414 email: studiosgraphite@gmail.com Website : www.graphitedesignstudio.com		GENERAL NOTES 1. All dimensions on this drawing are in feet and inches. 2. Only written dimensions are to be followed. drawing should not be scaled. 3. All measurements must be checked and verified by the contractors prior to execution of work at the site. 4. This drawing is to be read in conjunction with all relevant structural, services & facility planning drawings. 5. Architectural drawings are to be followed for the location of all structural members & masonry walls, for sizes & reinforcement details of structural members, relevant structural drawings are to be referred. 6. Any discrepancies between architectural, structural and services drawings must be brought to the notice of the architects immediately & prior to execution at site. 7. Co-ordination with services such as hvac, plumbing & electrical, etc. is the responsibility of the contractors. 8. All masonry walls should be aligned with the columns as indicated on the plan, irrespective of the position as calculated with the dimensioning. 9. For details, refer relevant large scale detail drgs. as indicated.		PROJECT: PROPOSED MIX USE BUILDING PLOT NO. S-01, NEAR SHYAM NAGAR, AJMER ROAD JAIPUR SERVICES CONSULTANT: VIPUL CONSULTING, F 9 / 440 , Keshav Marg Chitrakut Scheme,Jaipur PH:91-0-93146-10438 ,0141-2440946 Mail:vipul8599@yahoo.com		NORTH:	
				SANJAY		VIJESH		MEP/ANU/U.G.F./ESS/03	

NAME OF DRAWING:		PROJECT NO. :	DATE :
UPPER GROUND FLOOR ELECTRIC SUB-STATION, CABLE ROUTE & LIGHTNING ARRESTER PLAN		302019ANUK00100	05-12-2020
DEALT BY:	DRAWN BY:	SCALE :	REV NO./DATE :
SANJAY	VIJESH		R-01/ 4-Jan-21
APPROVED BY:		DRAWING NO. :	
VIPUL AGARWAL			

THIS DRAWING IS THE PROPERTY OF GRAPHITE DESIGN STUDIO PVT. LTD. , JAIPUR. IT SHALL NOT BE COPIED OR USED WITHOUT THEIR WRITTEN PERMISSION NOR MADE KNOWN TO A THIRD PARTY. THE INFORMATION IS ISSUED ON THE UNDERSTANDING THAT NO PART THEREOF SHALL BE DUPLICATED FOR THE PURPOSE OTHER THAN THE EXPRESSED PURPOSE.

THIS DRAWING IS THE PROPERTY OF GRAPHITE DESIGN STUDIO PVT. LTD. , JAIPUR. IT SHALL NOT BE COPIED OR USED WITHOUT THEIR WRITTEN PERMISSION NOR MADE KNOWN TO A THIRD PARTY. THE INFORMATION IS ISSUED ON THE UNDERSTANDING THAT NO PART THEREOF SHALL BE DUPLICATED FOR THE PURPOSE OTHER THAN THE EXPRESSED PURPOSE.

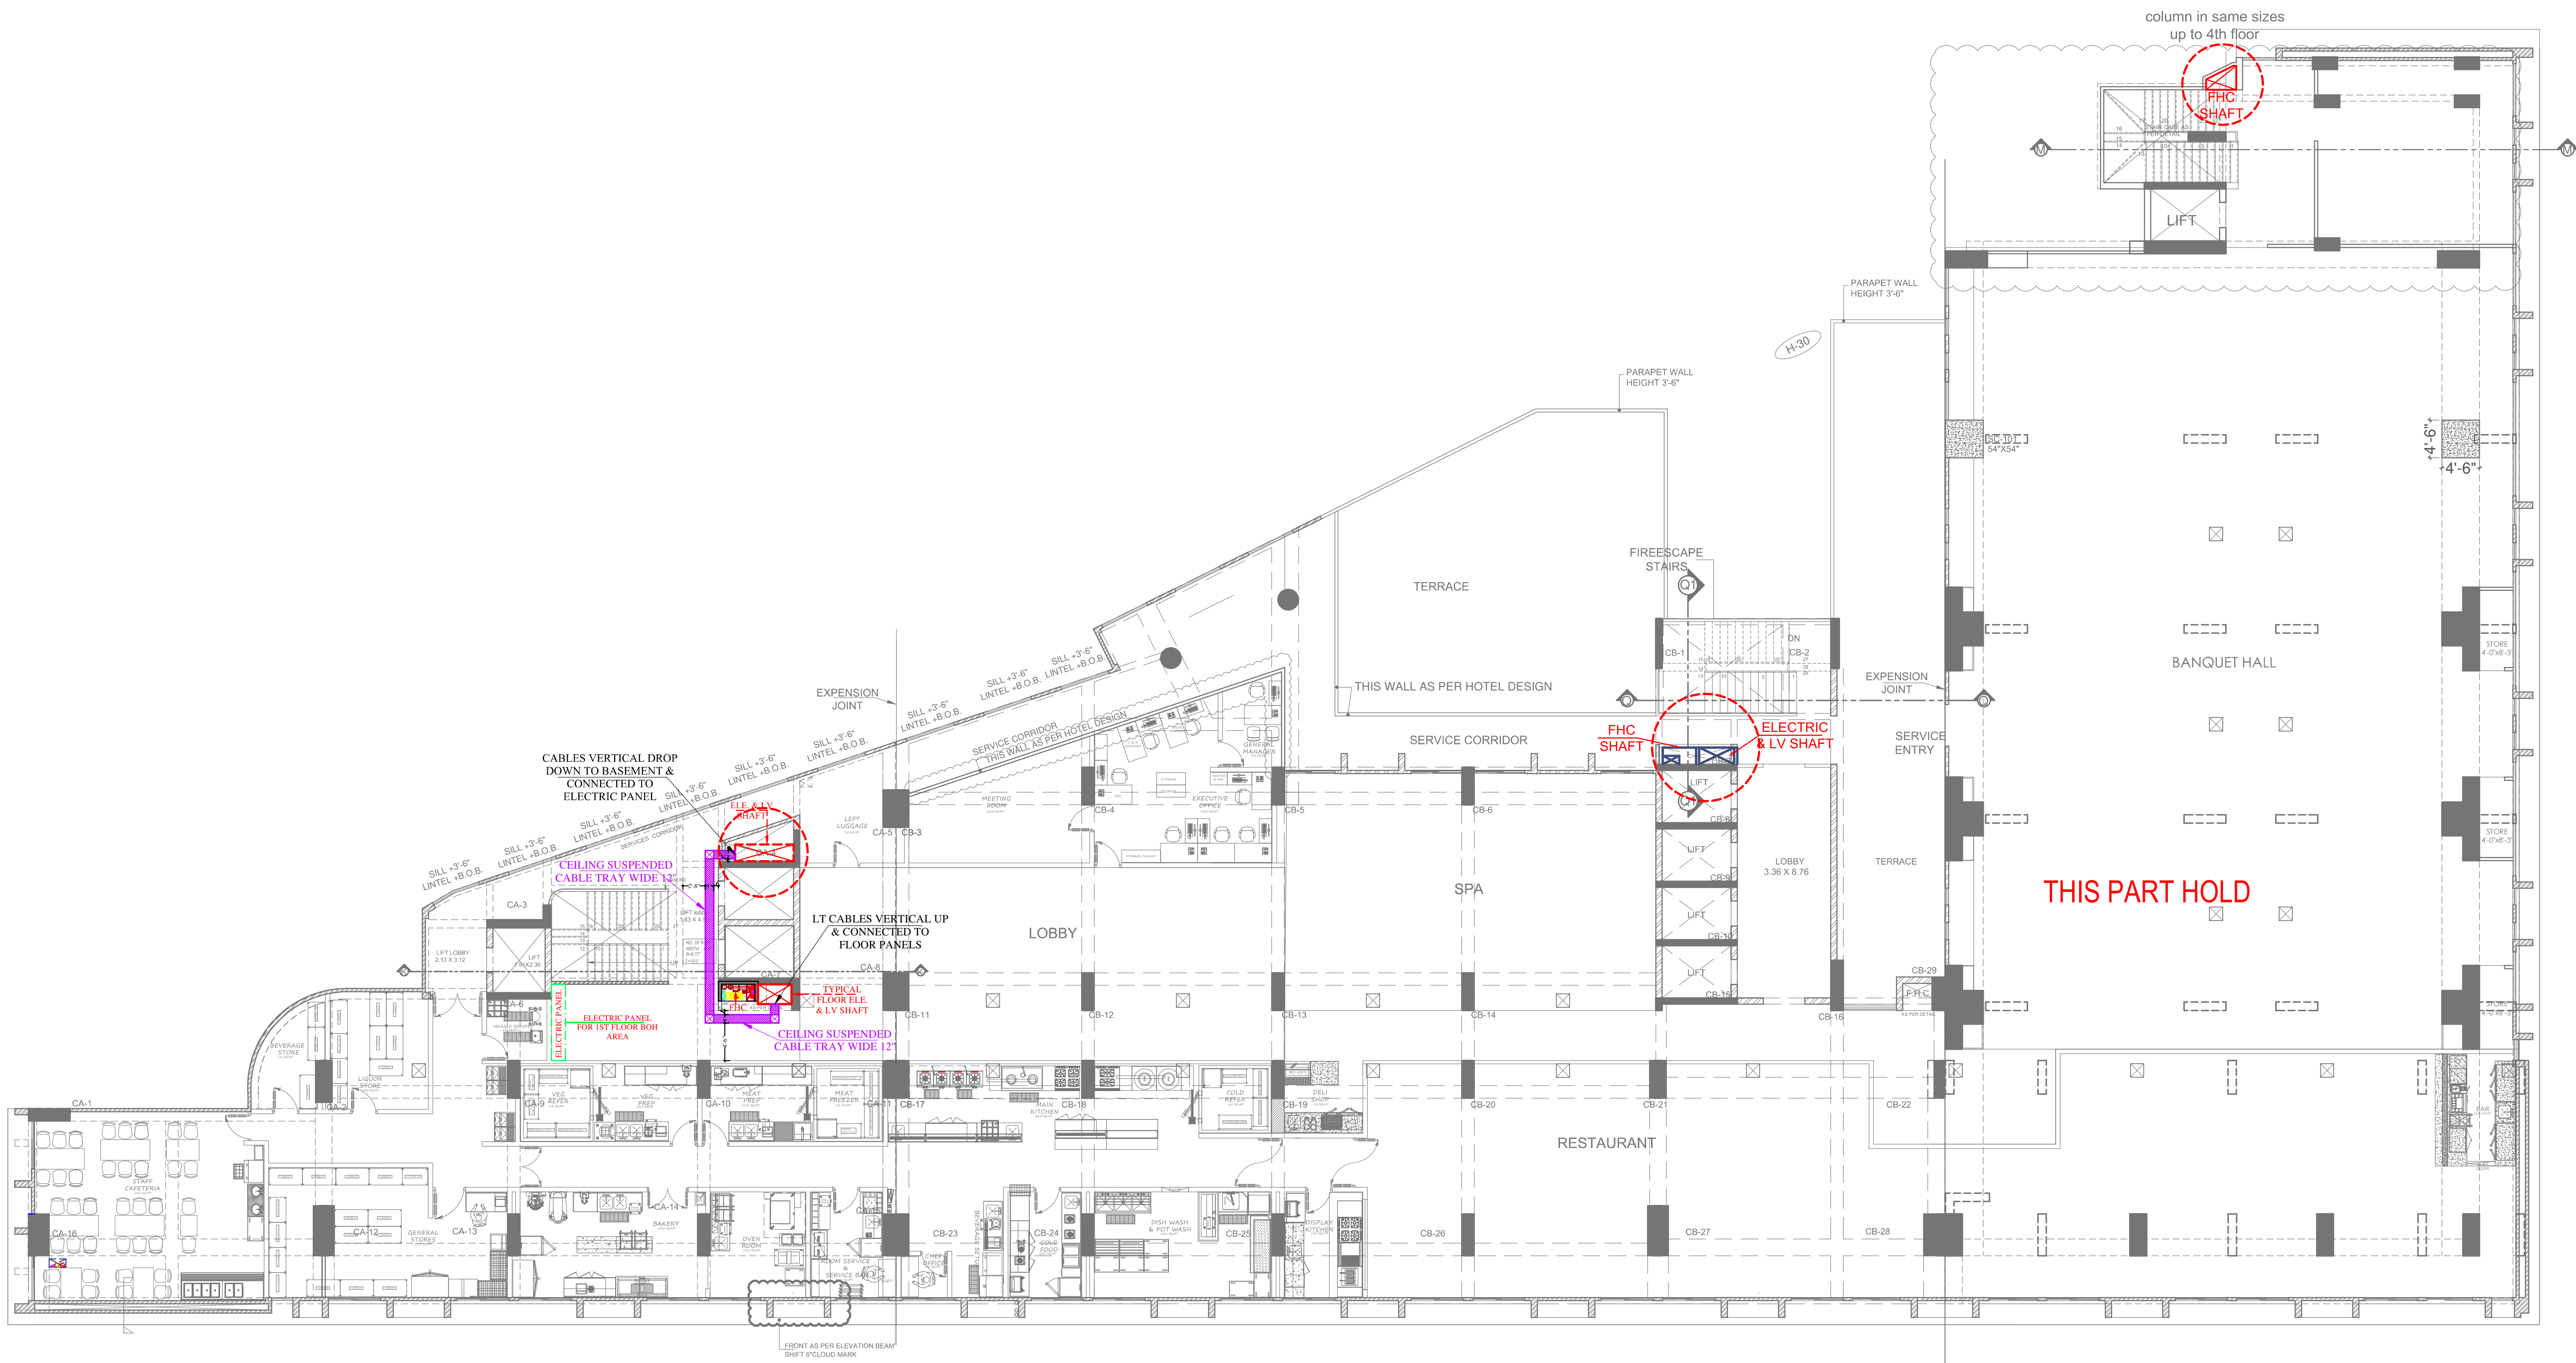

CLIENT :

ANUKAMPA AVAS
VIKAS LLP

ARCHITECTS :
des^{ig}n^hite
studio

GRAPHITE DESIGN STUDIO
ARCHITECTS, INTERIOR DESIGNERS, PLANNERS
88, Janak Puri - 1st, Indirawa phatak, Opp Jain Mandir, Jaipur
CONTACT NO. : +91-9828334414, 0141-2584414
email: studiosgraphite@gmail.com
Website : www.graphitedesignstudio.com

STRUCTURAL CONSULTANTS:

SERVICES CONSULTANTS:

VIPUL CONSULTING,
F 9 / 440 , Keshav Marg Chitrakut
Scheme Jaipur
PH:91-093146-10438, 0141-2440946
Mail:vipul8599@yahoo.com

Vipul
VIPUL AGARWAL
M.E.P. CONSULTANT
B.E. ELECTRICAL

S.No DATE REVISION DESCRIPTION

GENERAL NOTES:
1. All dimension on this drawing are in feet and inches.
2. Only written dimension are to be followed. Drawing should not be scaled.
3. All measurements must be checked and verified by the contractor prior to execution of work on site.
4. This drawing is to be read in conjunction with all relevant structural, services & building planning drawings.
5. Architectural drawings are to be followed for the location of all structural members & masonry walls. For access & implementation details of structural members, relevant structural drawings are to be referred.
6. Any discrepancies between architectural, structural and services drawings must be brought to the notice of the architect immediately & prior to execution on site.
7. Co-ordinate with services such as truss, plumbing & electrical, etc. is the responsibility of the contractor.
8. All masonry walls should be aligned with the columns as indicated on the plan, irrespective of the position as calculated with the dimensioning.
9. For details, refer relevant large scale detail drgn. as indicated.

PROJECT: PROPOSED MIX USE BUILDING
PLOT NO. S-01, NEAR SHYAM
NAGAR, AJMER ROAD JAIPUR

NAME OF DRAWING:

1ST FLOOR ELE.L.V. FIRE
SHAFT & CABLE TRAY PLAN

DRAWN BY:

APPROVED BY:

VUESH

SANJAY

NORTH:

PROJECT NO.:

DATE:

302019ANUK00100

05-12-2020

SCALE:

REV NO.:

REV. NO./DATE :14-05-2019

REV. COLUMN PB 2.17, CB-1.2.16

LOCATION

DRAWING NO.:

ANU_A_03


NOTE:-

ALL EXTERNAL STREET LIGHT
CONTROL BY GUARD ROOM DB

LEGENDS:

Qty.	I D	Symbol	Description
35	PL		STREET LIGHT

Vipul
VIPUL AGARWAL
M.E.P. CONSULTANT
B.E. ELECTRICAL

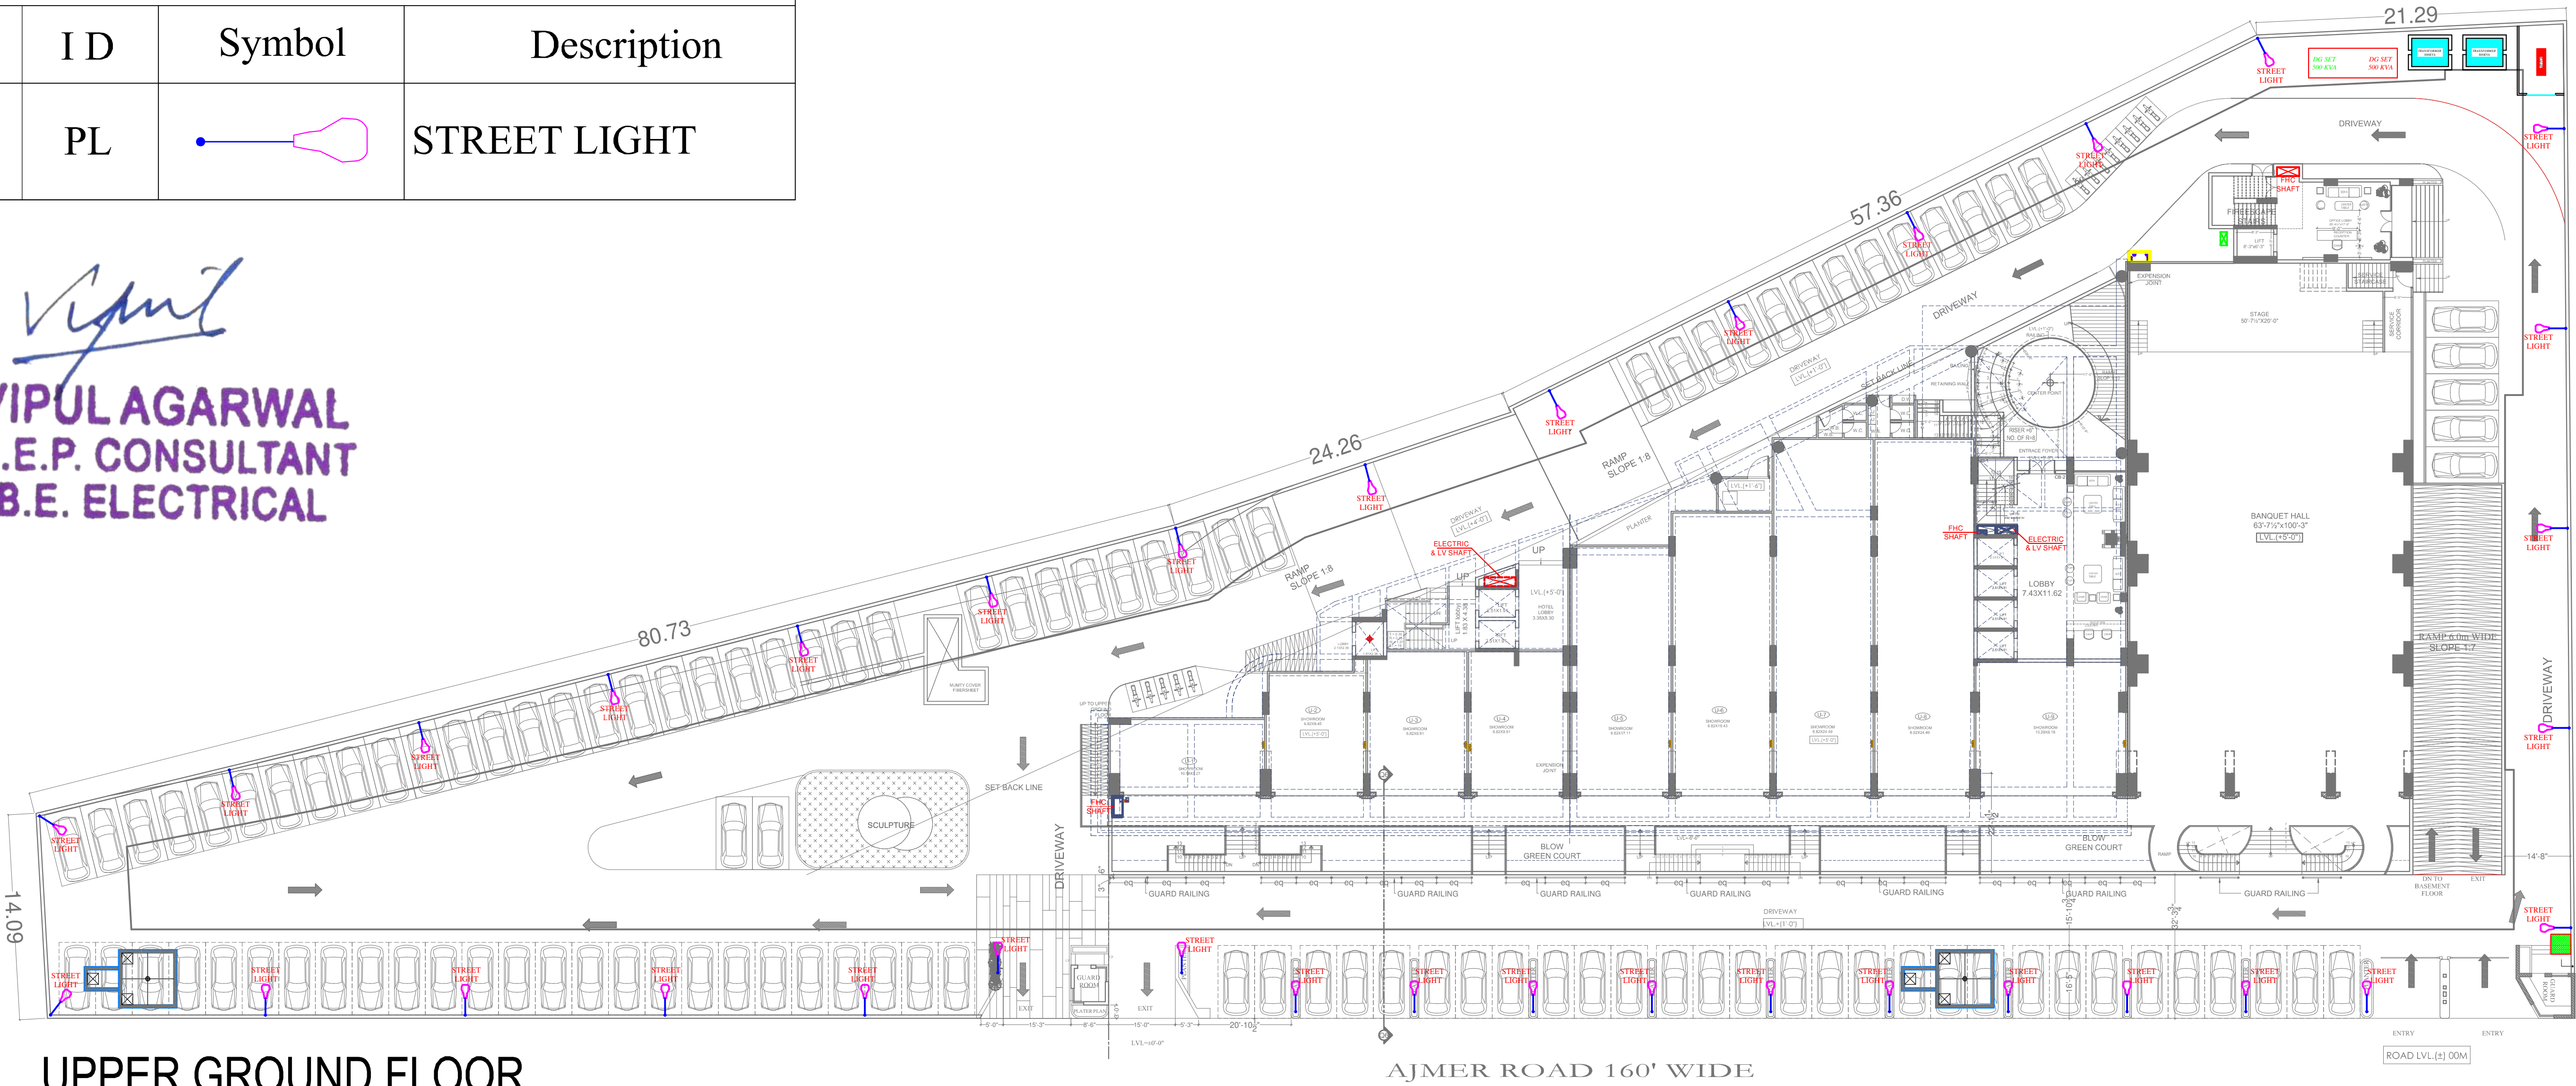

UPPER GROUND FLOOR

CLIENT : ANUKAMPA AVAS VIKAS LLP	PROPOSED MIX USE BUILDING PLOT NO. S-01, NEAR SHYAM NAGAR, AJMER ROAD JAIPUR	ARCHITECTS : desig n graphite audio GRAPHITE DESIGN STUDIO ARCHITECTS, INTERIOR DESIGNERS, PLANNERS 68, Janak Puri -1st, Imliwala phatak, Opp Jain Mandir, Jaipur CONTACT NO. +91-9928334414, 0141-2593414 email: studiosgraphite@gmail.com Website : www.graphitedesignstudio.com <td rowspan="4"> GENERAL NOTES 1. All dimensions on this drawing are in feet and inches. 2. Only written dimensions are to be followed - drawing should not be scaled. 3. All measurements must be checked and verified by the contractors prior to execution of work at the site. 4. This drawing is to be read in conjunction with all relevant structural, services & facility planning drawings. 5. Architectural drawings are to be followed for the location of all structural members & masonry walls. for sizes & reinforcement details of structural members, relevant structural drawings are to be referred. 6. Any discrepancies between architectural, structural and services drawings must be brought to the notice of the architects immediately & prior to execution at site. 7. Co-ordination with services such as hvac, plumbing & electrical, etc. is the responsibility of the contractors. 8. All masonry walls should be aligned with the columns as indicated on the plan, irrespective of the position as calculated with the dimensioning. 9. For details, refer relevant large scale detail drgs. as indicated. </td> <td rowspan="4"> PROJECT: PROPOSED MIX USE BUILDING PLOT NO. S-01, NEAR SHYAM NAGAR, AJMER ROAD JAIPUR SERVICES CONSULTANT: VIPUL CONSULTING, F 9 / 440 , Keshav Marg Chitrakut Scheme,Jaipur PH:91-0-93146-10438 ,0141-2440946 Mail:vipul8599@yahoo.com </td> <td colspan="2"> NORTH: </td>	GENERAL NOTES 1. All dimensions on this drawing are in feet and inches. 2. Only written dimensions are to be followed - drawing should not be scaled. 3. All measurements must be checked and verified by the contractors prior to execution of work at the site. 4. This drawing is to be read in conjunction with all relevant structural, services & facility planning drawings. 5. Architectural drawings are to be followed for the location of all structural members & masonry walls. for sizes & reinforcement details of structural members, relevant structural drawings are to be referred. 6. Any discrepancies between architectural, structural and services drawings must be brought to the notice of the architects immediately & prior to execution at site. 7. Co-ordination with services such as hvac, plumbing & electrical, etc. is the responsibility of the contractors. 8. All masonry walls should be aligned with the columns as indicated on the plan, irrespective of the position as calculated with the dimensioning. 9. For details, refer relevant large scale detail drgs. as indicated.	PROJECT: PROPOSED MIX USE BUILDING PLOT NO. S-01, NEAR SHYAM NAGAR, AJMER ROAD JAIPUR SERVICES CONSULTANT: VIPUL CONSULTING, F 9 / 440 , Keshav Marg Chitrakut Scheme,Jaipur PH:91-0-93146-10438 ,0141-2440946 Mail:vipul8599@yahoo.com	NORTH: 			
					NAME OF DRAWING: GROUND FLOOR EXTERNAL LIGHTING PLAN		PROJECT NO. : 302019ANUK00100	DATE : 10-07-2024
					DEALT BY: SANJAY	DRAWN BY: VIJESH	SCALE : R-01/ 10-Jul-24	DRAWING NO. : MEP/ANU/U.G.F./EX. L./00
					APPROVED BY: VIPUL AGARWAL			
THIS DRAWING IS THE PROPERTY OF GRAPHITE DESIGN STUDIO PVT. LTD. , JAIPUR IT SHALL NOT BE COPIED OR USED WITHOUT THEIR WRITTEN PERMISSION NOR MADE KNOWN TO A THIRD PARTY. THE INFORMATION IS ISSUED ON THE UNDERSTANDING THAT NO PART THEREOF SHALL BE DUPLICATED FOR THE PURPOSE OTHER THAN THE EXPRESSED PURPOSE.								