


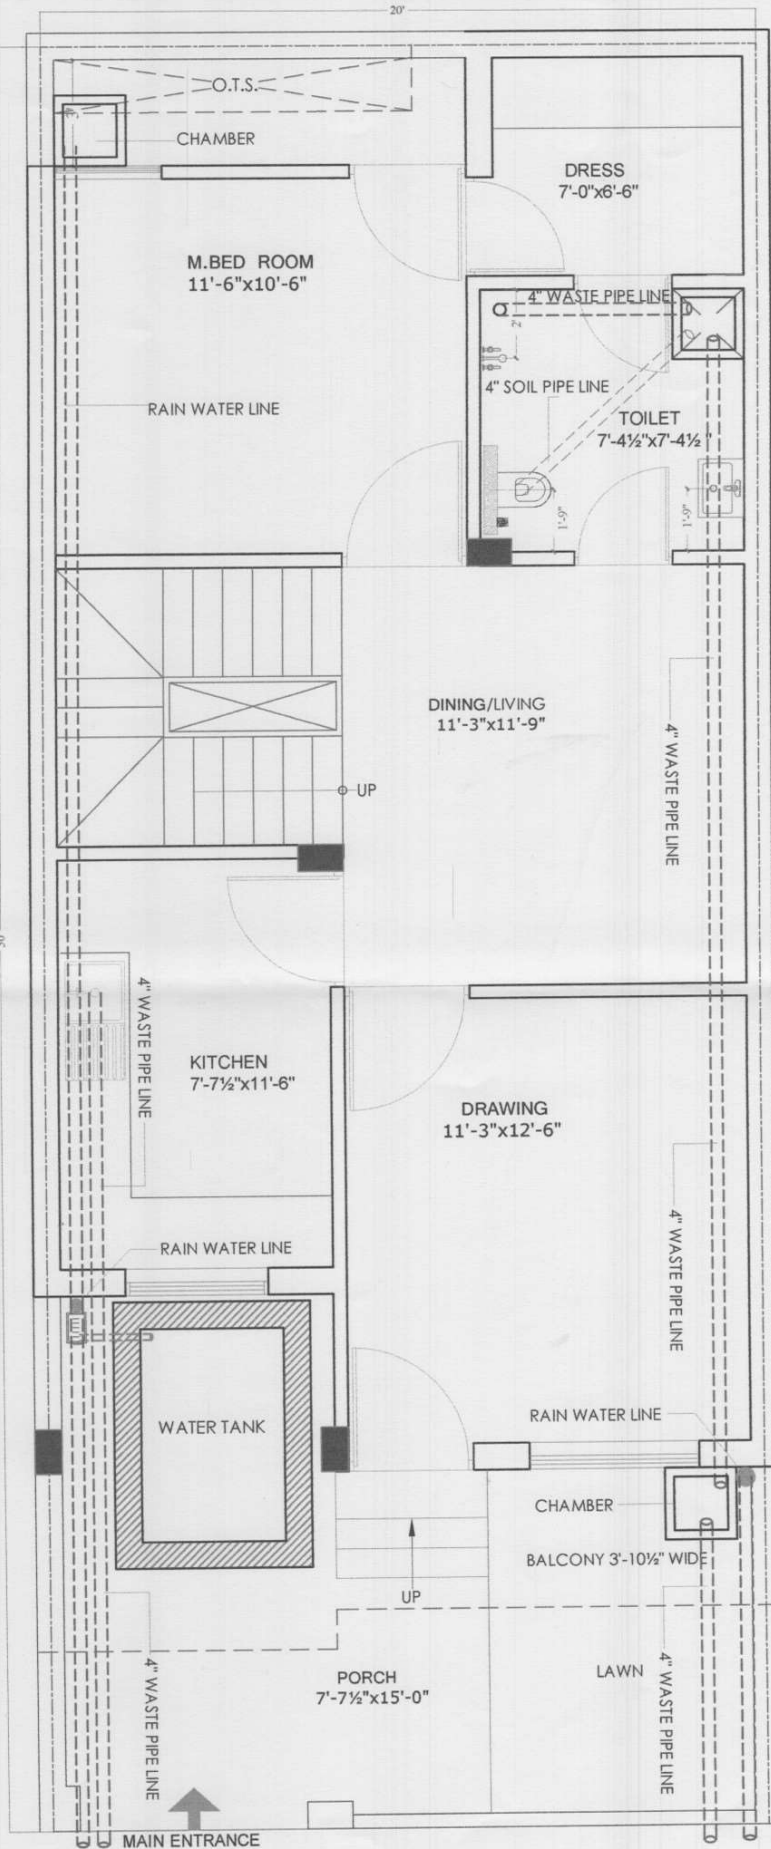

GENERAL NOTES:

1. ALL DIMENSION AND LEVEL ARE IN FEET, INCHES, AND MM
2. DO NOT SCALE THIS DRAWING. FOLLOW WRITTEN DIMENSION ONLY.
3. THIS DRAWING SHOULD BE READ IN CONJUNCTION WITH RELEVANT ARCHITECTURAL AND SERVICE DRAWING ANY DISCREPANCY SHOULD BE IMMEDIATELY BROUGHT TO NOTICE.
4. ONLY LOAD BEARING WALLS ARE SHOWN IN PLAN OTHER WALLS SHALL BE STOPPED 1/2" BELOW SOFFIT OF BEAM/SLAB AND GAP FILLED WITH LEAN CEMENT MORTAR UNLESS OTHERWISE SHOWN IN ARCHITECTURAL DRAWING.

Plan For Villa No.
37 to 42, 44 to 45,
66 to 73, 75

ABBREVIATIONS:

- * N.T.S. = NOT TO SCALE
- * R.F. = REINFORCEMENT
- * B.W. = BOTH WAYS
- * T/B = TOP & BOTTOM

DESIGN DATA:-

GRADE OF CONCRETE	M-25
GRADE OF STEEL	Fe-500 D
BUILDING DESIGN FOR	G+F+S
SBC CONSIDERED	15 T/m ²

REVISION NO.	DATE:	REMARK

PROJECT:

PROPOSED SANJEEVNI TRIANGLE
CROSS WINDS INDEPENDENT VILLAS
AT SEC.-30, BEHIND SKIT COLLEGE, NEAR
SHIV NAGAR -III, VILLAGE -RAMNAGARIA
JAGATPURA, JAIPUR, (RAJ.)

DRAWING TITLE:

GROUND FLOOR PLUMBING PLAN

ARCHITECTS:

STRUCTURAL CONSULTANT:

CADD DEVELOPED:-

DESIGN BY:-

CHECKED BY:-


SCALE:-

DRAWING. NO.

REVISION NO.

DATE:



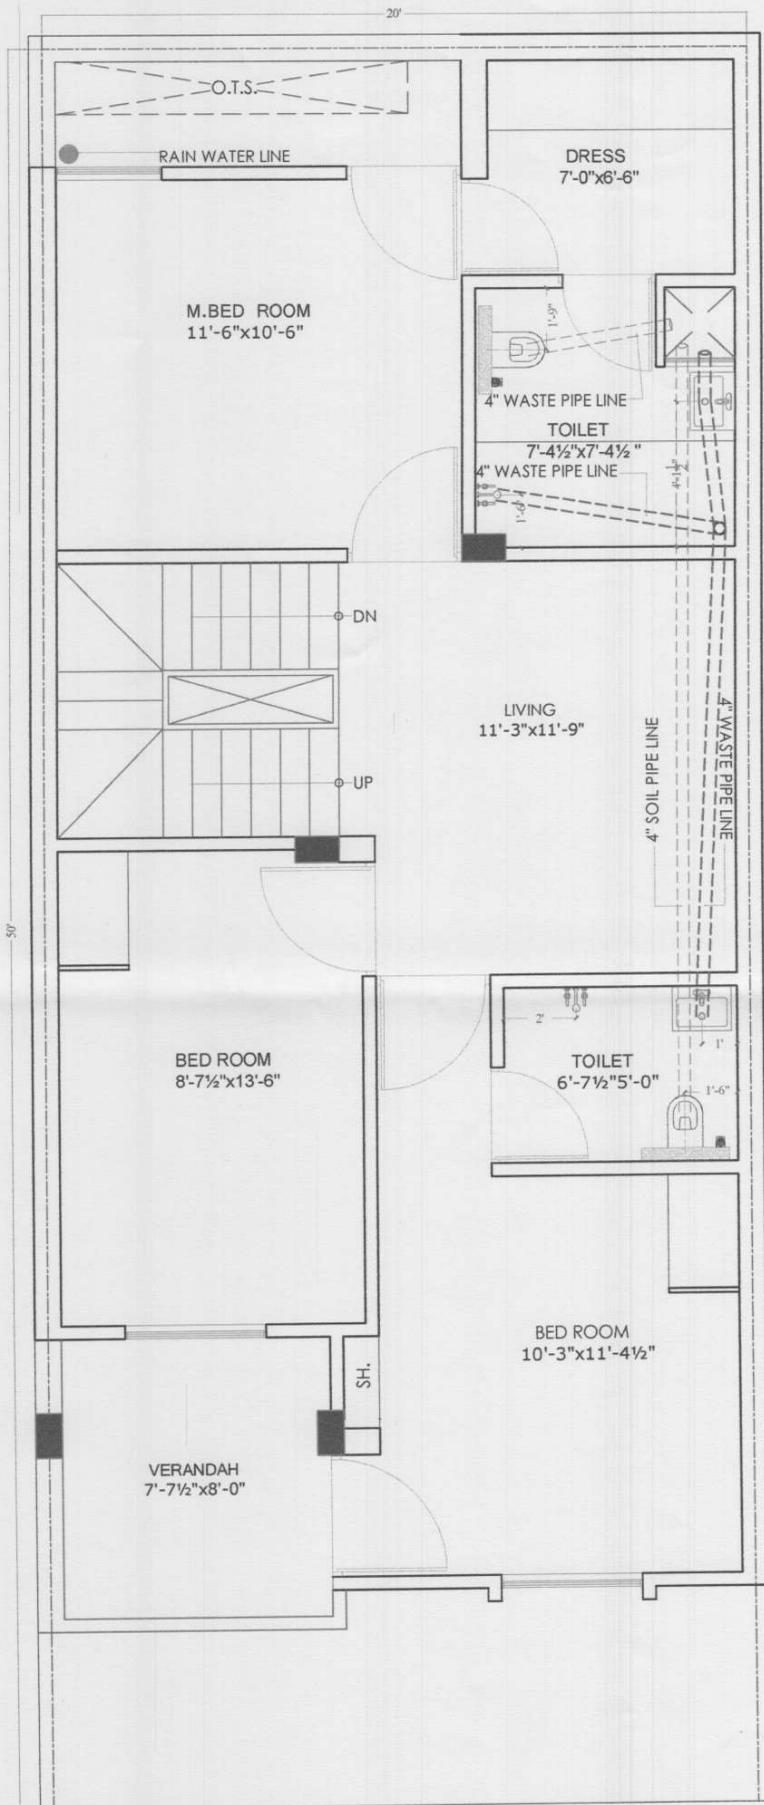

GENERAL NOTES:

1. ALL DIMENSION AND LEVEL ARE IN FEET, INCHES, AND MM
2. DO NOT SCALE THIS DRAWING FOLLOW WRITTEN DIMENSION ONLY.
3. THIS DRAWING SHOULD BE READ IN CONJUNCTION WITH RELEVANT ARCHITECTURAL AND SERVICE DRAWING ANY DISCREPANCY SHOULD BE IMMEDIATELY BROUGHT TO NOTICE.
4. ONLY LOAD BEARING WALLS ARE SHOWN IN PLAN OTHER WALLS SHALL BE STOPPED 1/2" BELOW SOFFIT OF BEAM/SLAB AND GAP FILLED WITH LEAN CEMENT MORTAR UNLESS OTHERWISE SHOWN IN ARCHITECTURAL DRAWING.

Plan For Villa No.
37 to 42, 44 to 45,
66 to 73, 75

ABBREVIATIONS:

- * N.T.S. = NOT TO SCALE
- * R.F. = REINFORCEMENT
- * B.W. = BOTH WAYS
- * T/B = TOP & BOTTOM

DESIGN DATA:-

GRADE OF CONCRETE	M-25
GRADE OF STEEL	Fe-500 D
BUILDING DESIGN FOR	G+F+S
SBC CONSIDERED	15 T/m2

REVISION NO.	DATE	REMARK

PROJECT:


PROPOSED SANJEEVNI TRIANGLE
CROSS WINDS INDEPENDENT VILLAS
AT SEC.-30, BEHIND SKIT COLLEGE, NEAR
SHIV NAGAR - III, VILLAGE - RAMNAGARIA
JAGATPURA, JAIPUR, (RAJ.)

DRAWING TITLE:

FIRST FLOOR PLUMBING PLAN

ARCHITECTS:

STRUCTURAL CONSULTANT

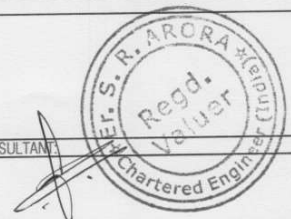

CADD DEVELOPED:-

DESIGN BY:-

CHECKED BY:-

SCALE:-

DRAWING NO.

REVISION NO.

DATE: