



VILLA NO. L-30 ELECTRICAL PLAN

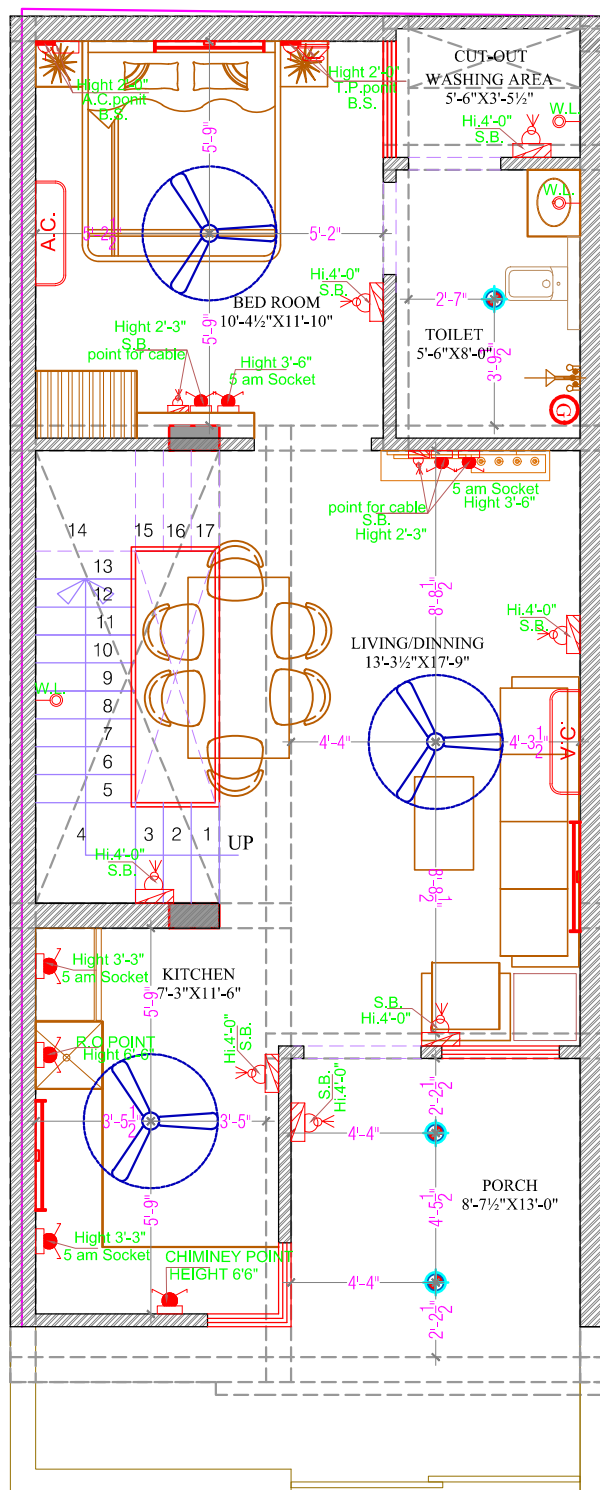

GROUND FLOOR PLAN

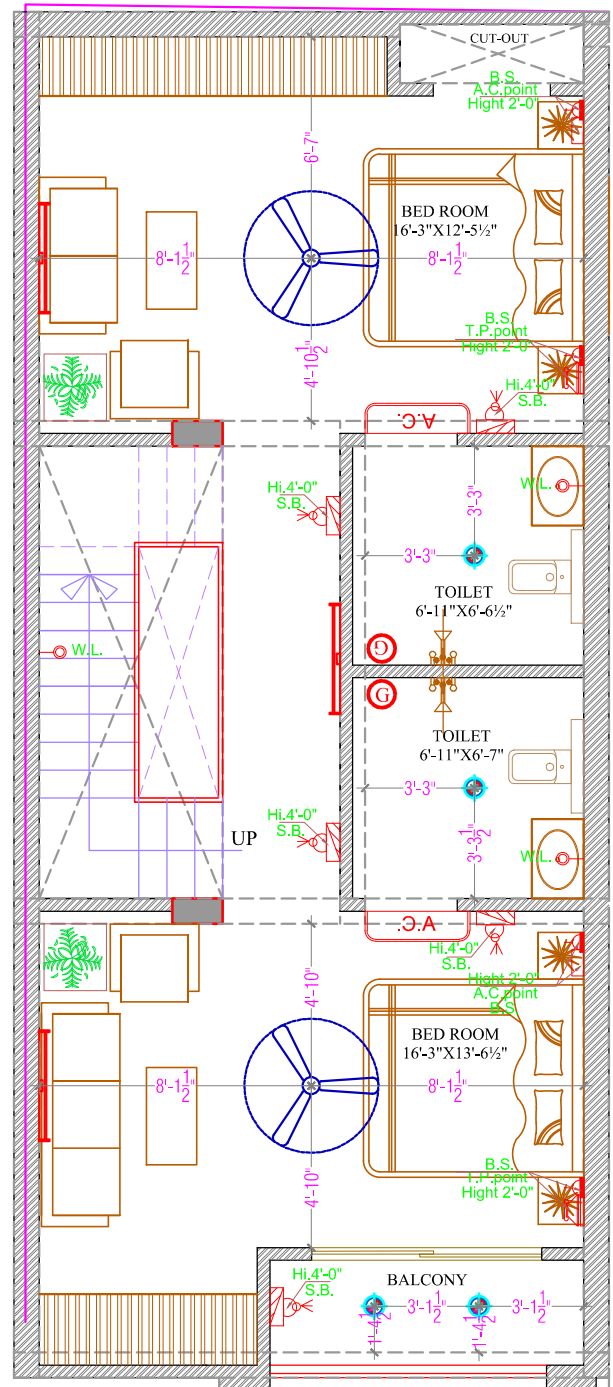

FIRST FLOOR PLAN

ELECTRICAL STANDARDS			
DESCRIPTION	SHORT NAME	SYMBOL	HEIGHT
CEILING FAN	C.F.		CEILING
CEILING LIGHT	C.L.		CEILING BEL.
WALL LIGHT	W.L.		8'-6"
EXHAUST FAN	E.F.		8'-6"
BELL BUZZER	B.B.		8'-6"
BELL PUSH	B.P.		4'-6"
TELEPHONE	T.P.		1'-6"
TELEVISION	T.V.		2'-2"
CHANDLER	CR		CEILING VOL.
TUBE LIGHT	T.L.		8'-6"
SWITCH BOARD	SB		4'-6"
POWER SWITCH BOARD	15 am SB		2'-2"
5m SWITCH BOARD	5m SB		2'-2"
WALL HANGED FAN	W.H.F.		8'-6"
DISTRIBUTION BOARD	D.B.		6'-6"
GENERATOR	G		5'-6"
BED SWITCH	B.S.		1'-6"
BED LAMPS	B.L.		AS PER PLAN
FOOT LIGHT	F.L.		0'-6"
SECURITY	D.P.		AS PER PLAN
SPILT A.C.	A.C.		8'-0"
LIGHT CIRCUIT			AS PER PLAN
POWER CIRCUIT			AS PER PLAN
TWO WAY			AS PER PLAN
INTERNET	INT.		4'-3"

ELECTRICAL LAYOUT PLAN



GENERAL NOTES:-

PROJECT TYPE:

DRAWING TYPE:

SITE ADD.

CLIENT:

DRAWN BY :

ER. LALIT SAINI

DESIGN BY :

DESIGN BY :


OFFICE ADD :

A-34 PADMAWATI COLONY KINGS ROAD NIRMAN NAGAR JAIPUR (RAJ.)


DATE: _____

07/03/ 2022

VILLA NO. L-27
ELECTRICAL PLAN

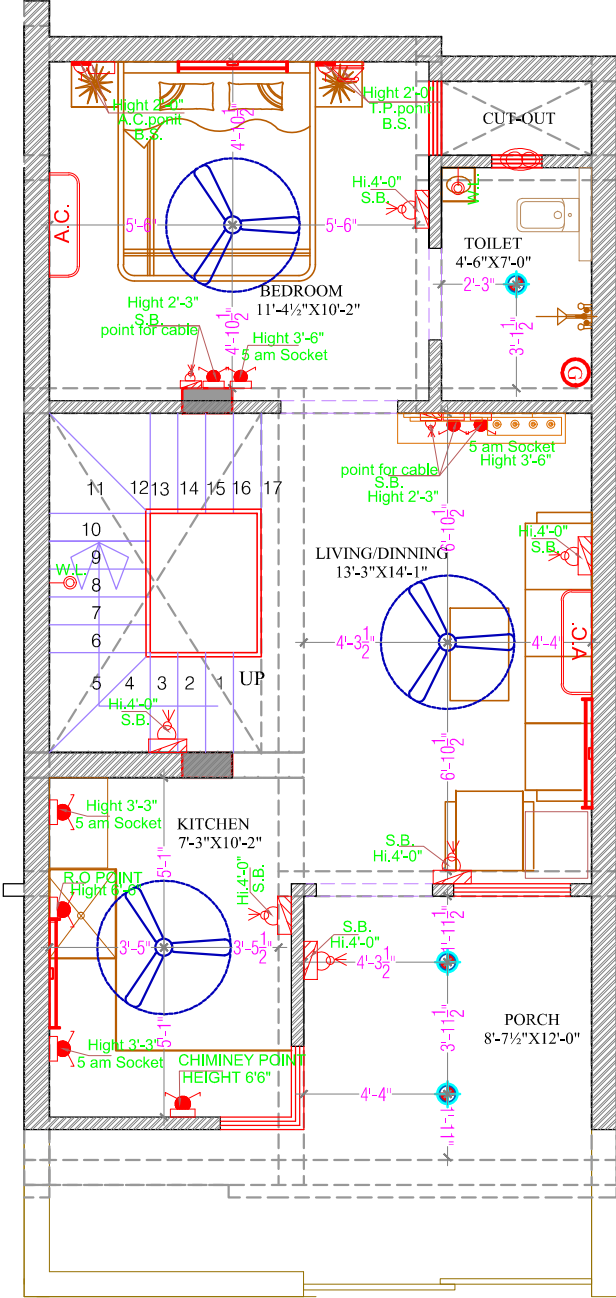

GROUND FLOOR PLAN

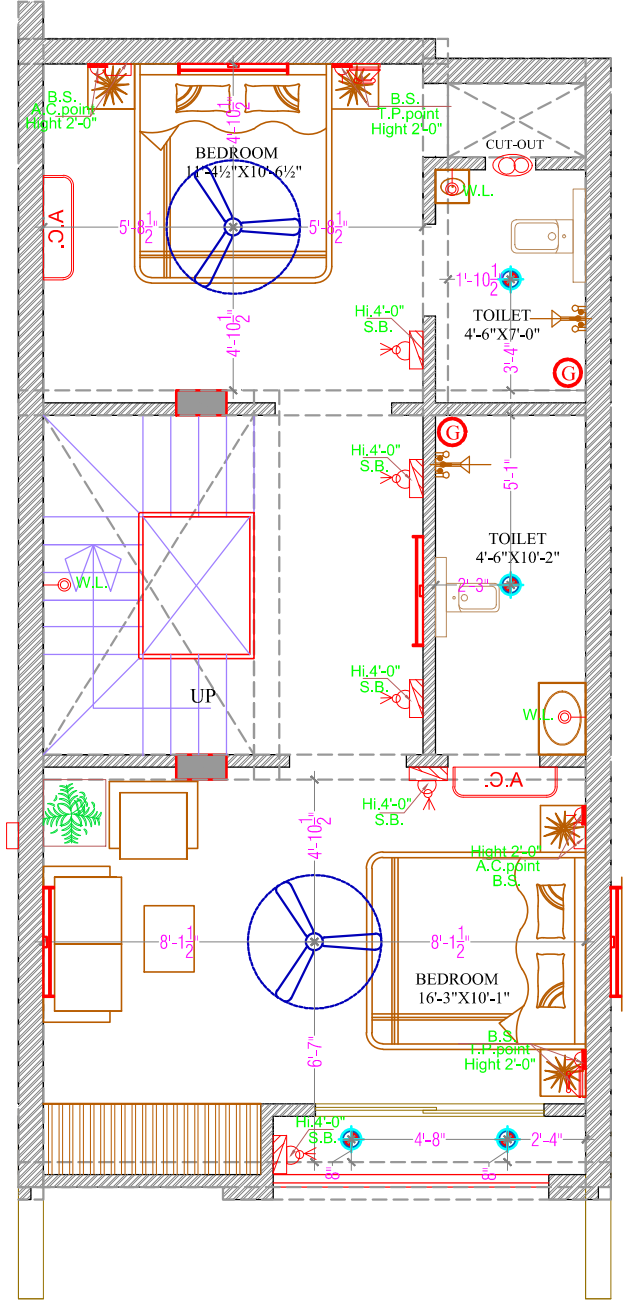

FIRST FLOOR PLAN

ELECTRICAL LAYOUT PLAN



ELECTRICAL STANDARDS			
DESCRIPTION	SYMBOL	HEIGHT	STANDARD
CILING FAN	C.F.	8'-0"	IS: 1181
CILING LIGHT	C.L.	8'-0"	IS: 1181
WALL LIGHT	W.L.	8'-0"	IS: 1181
EXHAUST FAN	E.F.	8'-0"	IS: 1181
BELL ROSSER	B.R.	8'-0"	IS: 1181
TELEPHONE	T.P.	8'-0"	IS: 1181
CHANDLIER	C.H.	8'-0"	IS: 1181
TUBE LIGHT	T.L.	8'-0"	IS: 1181
POWER SWITCH BOARD	P.S.B.	8'-0"	IS: 1181
WALL MOUNTED FAN	W.M.F.	8'-0"	IS: 1181
GRVSR	G.	8'-0"	IS: 1181
BED SWITCH	B.S.	8'-0"	IS: 1181
BED LAMP	B.L.	8'-0"	IS: 1181
FOOT LIGHT	F.L.	8'-0"	IS: 1181
SECURITY LIGHT	S.L.	8'-0"	IS: 1181
SPLIT A.C.	S.A.C.	8'-0"	IS: 1181
POWER CIRCUIT	P.C.	8'-0"	IS: 1181
TWO WAY	T.W.	8'-0"	IS: 1181
INTERRUPTE	I.	8'-0"	IS: 1181

NORTH :-



GENERAL NOTES:-

THIS DRAWING IS THE PROPERTY OF Y&S AND NOT TO BE COPIED OR USED WITHOUT THEIR PERMISSION
ALL DIMENSIONS ARE TO BE READ AND NOT SCALED / MEASURED FROM THE DRAWING
THIS DRAWING IS TO BE READ ALONGWITH ALL RELATED STRUCTURAL SERVICES DRAWINGS
FURNITURE/FIXTURES SHOWN ARE INDICATIVE ONLY IN CASE REFER RESPECTIVE SCHEDULES
ANY DISCREPANCIES IN THE DRAWING OR AT SITE MAY BE IMMEDIATELY REPORTED TO THE ARCHITECTS

DRAWN BY :

MR. KAMAL KUMAR SHARMA

DESIGN BY :

OFFICE ADD :


A-34 PADMAWATI COLONY KINGS ROAD NIRMAN NAGAR JAIPUR (RAJ.)

DATE:


07/03/2022

VILLA NO. L-25

ELECTRICAL PLAN

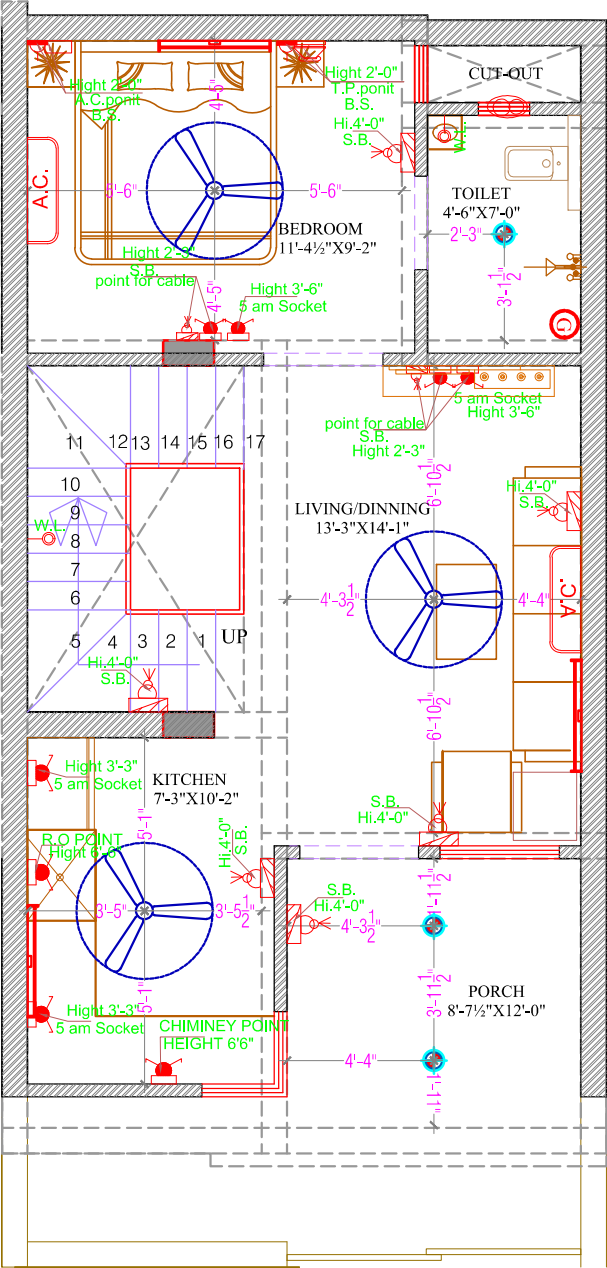

GROUND FLOOR PLAN

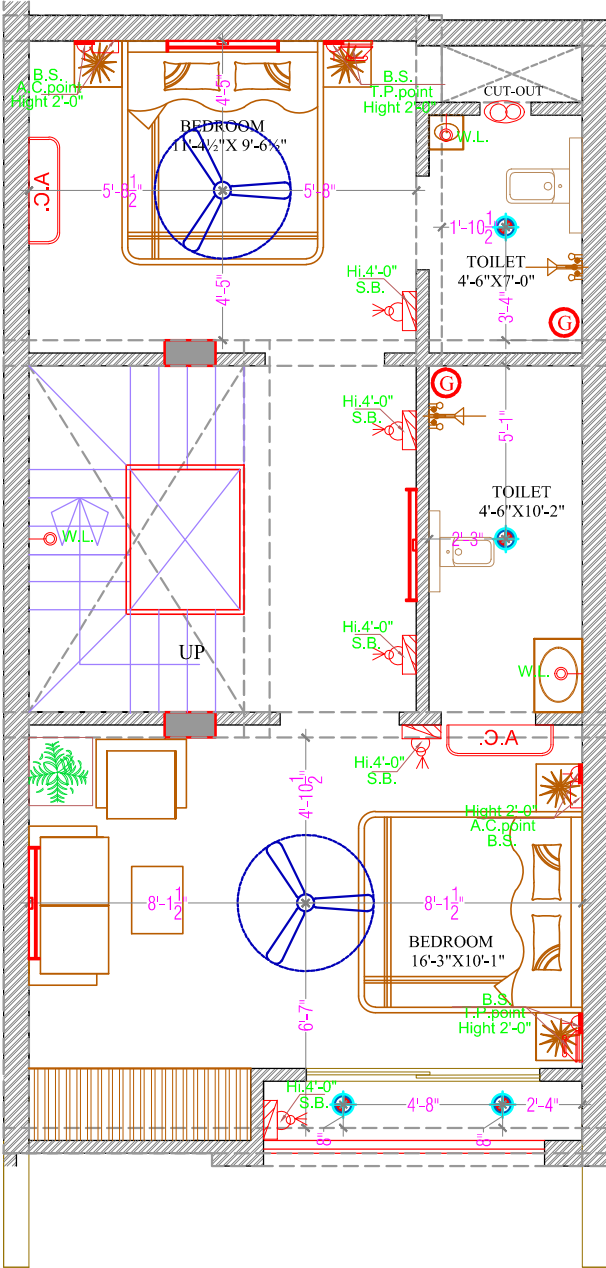


FIRST FLOOR PLAN

ELECTRICAL LAYOUT PLAN



ELECTRICAL STANDARDS			
DESCRIPTION	SYMBOL	STANDARD	HEIGHT
CEILING FAN	C.F.	IS: 8000	CEILING
CEILING LIGHT	C.L.	IS: 8000	CEILING
WALL LIGHT	W.L.	IS: 8000	+8'-6"
EXHAUST FAN	E.F.	IS: 8000	+8'-6"
BELL BUZZER	B.B.	IS: 8000	+8'-6"
BELL PUSH	B.P.	IS: 8000	+8'-6"
TELEPHONE	T.P.	IS: 8000	+7'-6"
TELEVISION	T.V.	IS: 8000	+7'-6"
CHANGELER	C.R.	IS: 8000	+7'-6"
TUBE LIGHT	T.L.	IS: 8000	+8'-6"
SWITCH BOARD	S.B.	IS: 8000	+4'-0"
POWER SWITCH BOARD	P.S.B.	IS: 8000	+4'-0"
5mm SWITCH BOARD	5mm SB	IS: 8000	+2'-0"
WALL HANGING FAN	W.H.F.	IS: 8000	+8'-6"
DISTRIBUTION BOARD	D.B.	IS: 8000	+6'-6"
GLASSER	G.	IS: 8000	+5'-6"
BIRD SWITCH	B.S.	IS: 8000	+1'-0"
BED LAMP	B.L.	IS: 8000	+4'-0"
FOOT LIGHT	F.L.	IS: 8000	+0'-6"
SECURITY LIGHT	S.L.	IS: 8000	+8'-6"
SPLIT A.C.	S.P.A.C.	IS: 8000	+8'-6"
POWER CIRCUIT	P.C.	IS: 8000	+8'-6"
TWO WAY	T.W.	IS: 8000	+8'-6"
INTERNET	I.N.T.	IS: 8000	+4'-0"

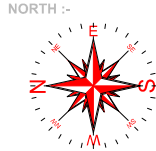

GENERAL NOTES:-

THIS DRAWING IS THE PROPERTY OF YBC AND NOT TO BE COPIED OR USED WITHOUT THEIR PERMISSION. ALL DIMENSIONS ARE TO BE READ AND NOT SCALED / MEASURED FROM THE DRAWING. THIS DRAWING IS TO BE READ ALONG WITH ALL RELATED STRUCTURAL SERVICES DRAWINGS. FURNITURE/FIXTURES SHOWN ARE INDICATIVE ONLY. PLEASE REFER RESPECTIVE SCHEDULES. ANY DISCREPANCIES IN THE DRAWING OR AT SITE MAY BE IMMEDIATELY REPORTED TO THE ARCHITECTS.

DRAWN BY :

ER. LALIT SAINI

DESIGN BY :

MR. KAMAL KUMAR SHARMA

DESIGN BY :


OFFICE ADD :

A-34 PADMAVATI COLONY KINGS ROAD NIRMAN NAGAR JAIPUR (RAJ.)


DATE:

07/03/2022

VILLA NO. L-26
ELECTRICAL PLAN

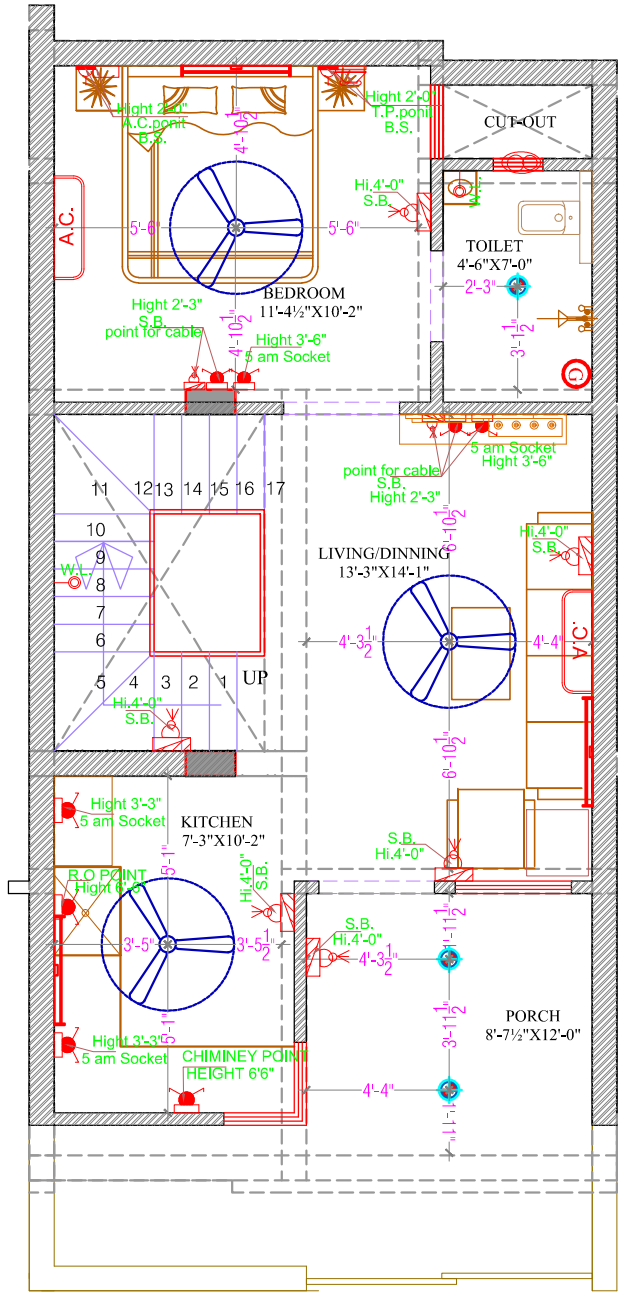

GROUND FLOOR PLAN

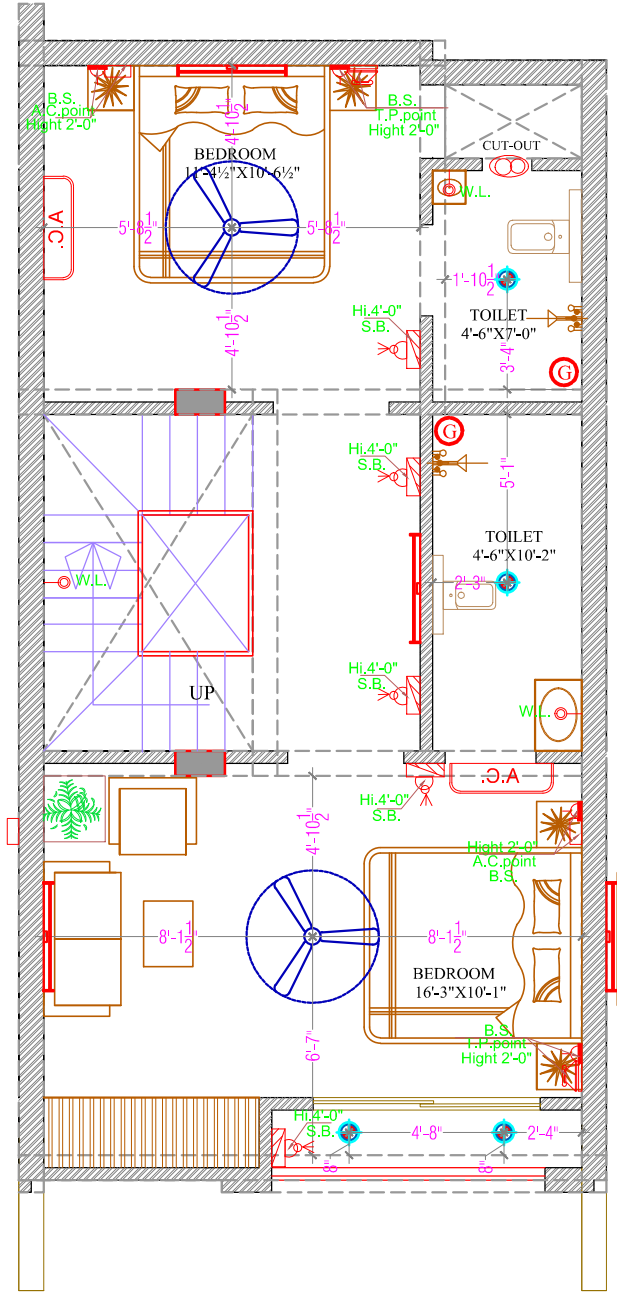

FIRST FLOOR PLAN

ELECTRICAL LAYOUT PLAN



ELECTRICAL STANDARDS			
DESCRIPTION	SHORT NAME	SYMBOL	HEIGHT
CEILING FAN	C.F.		CEILING
CEILING LIGHT	C.L.		CEILING
WALL LIGHT	W.L.		8'-6"
EXTRACTOR FAN	E.F.		AS PER MANUFACTURER
BELL BUZZER	B.B.		8'-6"
BELL PUSH	B.P.		4'-6"
TELEPHONE	T.P.		4'-9"
TELEVISION	T.V.		4'-9"
CHIMNEY FAN	C.F.		AS PER MANUFACTURER
TUBE LIGHT	T.L.		8'-6"
SWITCH BOARD	S.B.		4'-6"
POWER SWITCH BOARD	P.S.B.		4'-6"
WALL HANGING FAN	W.H.F.		7'-0"
GLASSER	G		16'-0"
BED SWITCH	B.S.		4'-6"
BED LAMP	B.L.		AS PER MANUFACTURER
FOOT LIGHT	F.L.		0'-9"
SECURITY ROOM LIGHT	S.R.L.		AS PER MANUFACTURER
SHUT A.C.	A.C.		8'-0"
LIGHT CIRCUIT			AS PER MANUFACTURER
POWER CIRCUIT			AS PER MANUFACTURER
TWO WAY			AS PER MANUFACTURER
INHERENT			4'-6"

NORTH :-



GENERAL NOTES:-

THIS DRAWING IS THE PROPERTY OF TSS AND NOT TO BE COPIED OR USED WITHOUT THEIR PERMISSION
ALL DIMENSIONS ARE TO BE READ AND NOT SCALED / MEASURED FROM THE DRAWING
THIS DRAWING IS TO BE READ ALONGWITH ALL RELATED STRUCTURAL SERVICES DRAWINGS
FURNITURE/FIXTURES SHOWN ARE INDICATIVE ONLY PLEASE REFER RESPECTIVE SCHEDULES
ANY DISCREPANCIES IN THE DRAWING OR AT SITE MAY BE IMMEDIATELY REPORTED TO THE ARCHITECTS

DRAWN BY :

ER. LAIT SAINI

DESIGN BY :

MR. KAMAL KUMAR SHARMA

DESIGN BY :

OFFICE ADD :


A-34 PADMAWATI COLONY KINGS ROAD NIRMAN NAGAR JAIPUR (RAJ.)

DATE:


07/03/2022

VILLA NO. L-29

ELECTRICAL PLAN

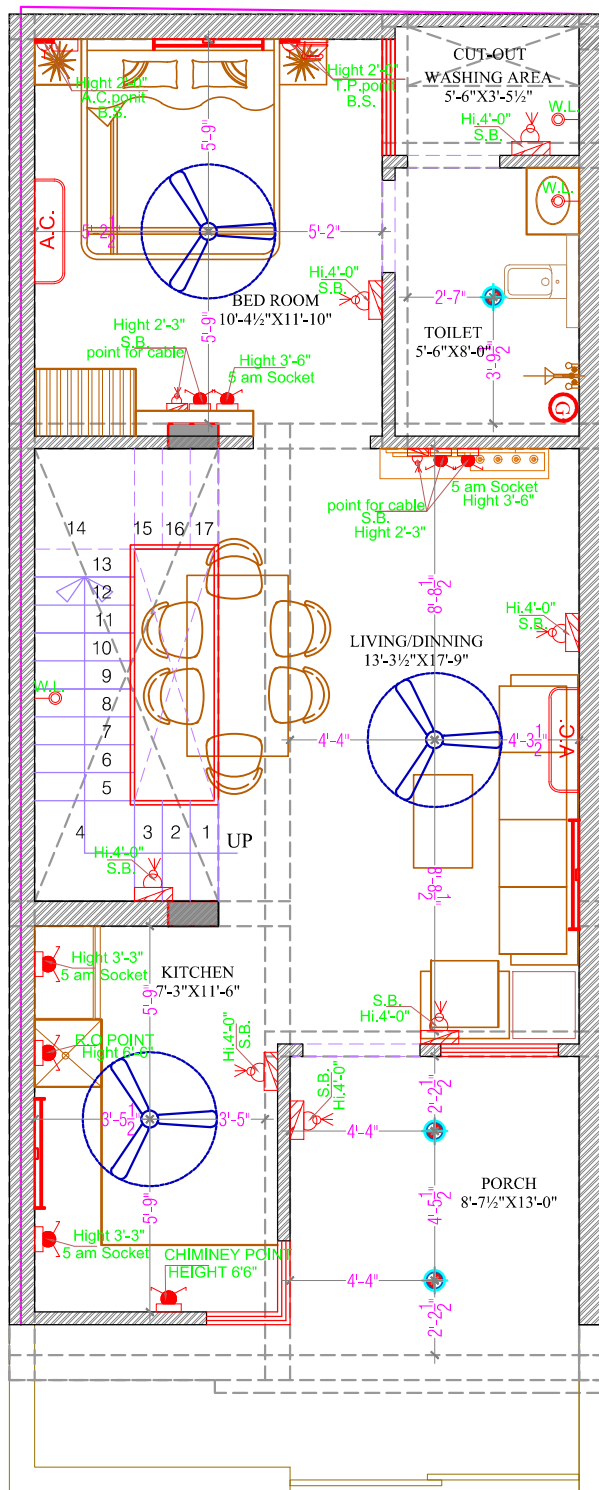

GROUND FLOOR PLAN

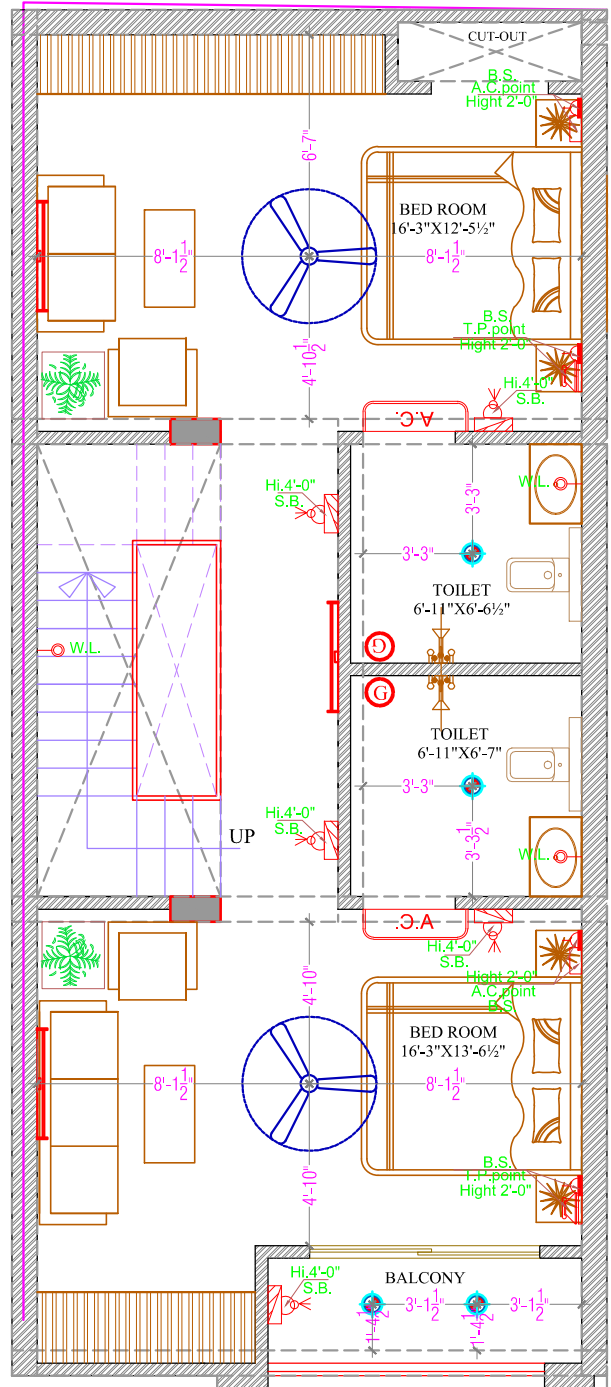

FIRST FLOOR PLAN

ELECTRICAL STANDARDS			
DESCRIPTION	SYMBOL	HEIGHT	STANDARD
CUTTING FAN	C.F.	8'-6"	IS: 12892
CUTTING LIGHT	C.L.	8'-6"	IS: 12892
WALL LIGHT	W.L.	8'-6"	IS: 12892
EXHAUST FAN	E.F.	8'-6"	IS: 12892
BELL BUZZER	B.B.	8'-6"	IS: 12892
BELL PUSH	B.P.	8'-6"	IS: 12892
TELEPHONE	T.P.	8'-6"	IS: 12892
TELEVISION	T.V.	8'-6"	IS: 12892
CHANDLER	C.R.	8'-6"	IS: 12892
TUBE LIGHT	T.L.	8'-6"	IS: 12892
SWITCH BOARD	S.B.	8'-6"	IS: 12892
POWER SWITCH BOARD	P.S.B.	8'-6"	IS: 12892
WALL HANGED FAN	W.H.F.	8'-6"	IS: 12892
DISTRIBUTION BOARD	D.B.	8'-6"	IS: 12892
GRINDER	G.	8'-6"	IS: 12892
BED SWITCH	B.S.	8'-6"	IS: 12892
BED LIGHT	B.L.	8'-6"	IS: 12892
FOOT LIGHT	F.L.	8'-6"	IS: 12892
SECURITY	S.	8'-6"	IS: 12892
SPLIT A.C.	A.C.	8'-6"	IS: 12892
LIGHT CIRCUIT	L.C.	8'-6"	IS: 12892
POWER CIRCUIT	P.C.	8'-6"	IS: 12892
TWO WAY	T.W.	8'-6"	IS: 12892
INTERNET	I.N.T.	8'-6"	IS: 12892

ELECTRICAL LAYOUT PLAN

VILLA NO. L-29

NORTH :-



GENERAL NOTES:-

THIS DRAWING IS THE PROPERTY OF YEC AND NOT TO BE COPIED OR USED WITHOUT THEIR PERMISSION
ALL DIMENSIONS ARE TO BE READ AND NOT SCALED / MEASURED FROM THE DRAWING
THIS DRAWING IS TO BE READ ALONG WITH ALL RELATED STRUCTURAL SERVICES DRAWINGS
FURNITURE/FIXTURES SHOWN ARE INDICATIVE ONLY PLEASE REFER RESPECTIVE SCHEDULES
ANY DISCREPANCIES IN THE DRAWING OR AT SITE MAY BE IMMEDIATELY REPORTED TO THE ARCHITECTS

PROJECT TYPE:

VILLA RESIDENCE

DRAWING TYPE:

FLOOR PLAN

SITE ADDR.

AT JAIPUR

CLIENT:

MR. MANOJ JI

DRAWN BY :

ER. LAJIT SAINI

DESIGN BY :

MR. KAMAL KUMAR SHARMA

DESIGN BY :

OFFICE ADDR :


A-34 PADMAWATI COLONY KINGS ROAD NIRMAN NAGAR JAIPUR (RAJ.)

DATE:


07/03/2022



VILLA NO. L-28 ELECTRICAL PLAN

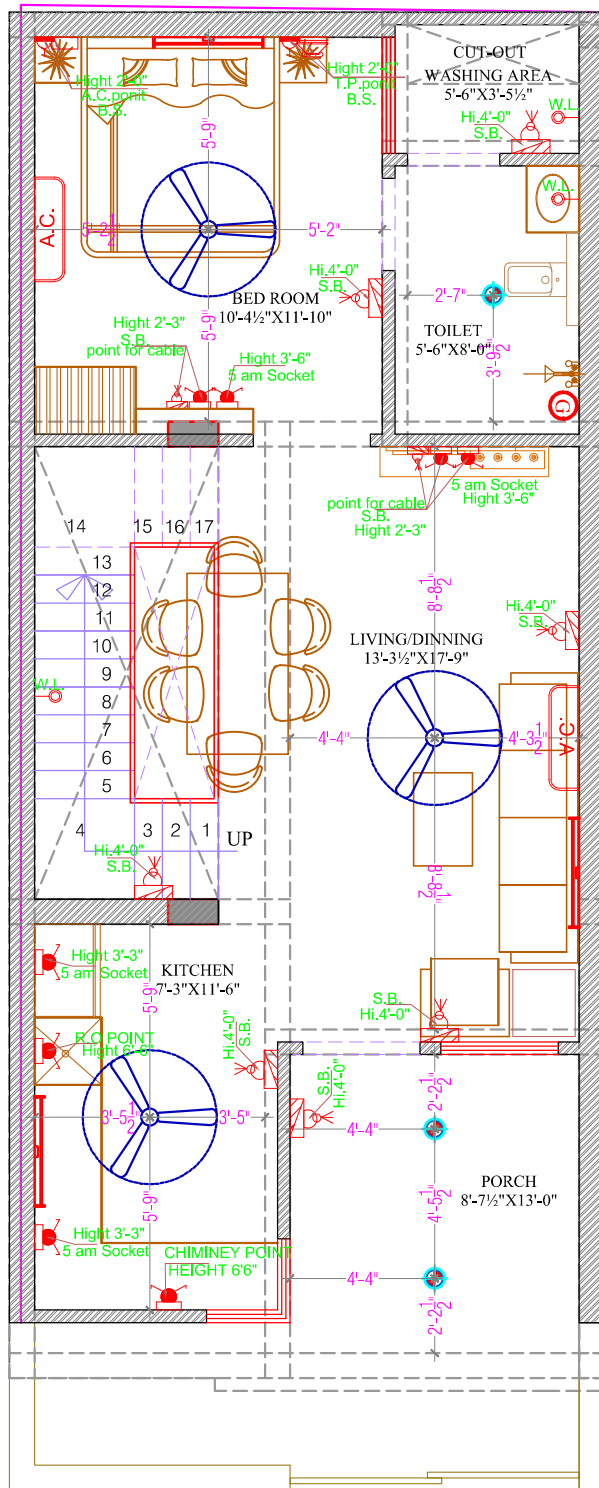

GROUND FLOOR PLAN

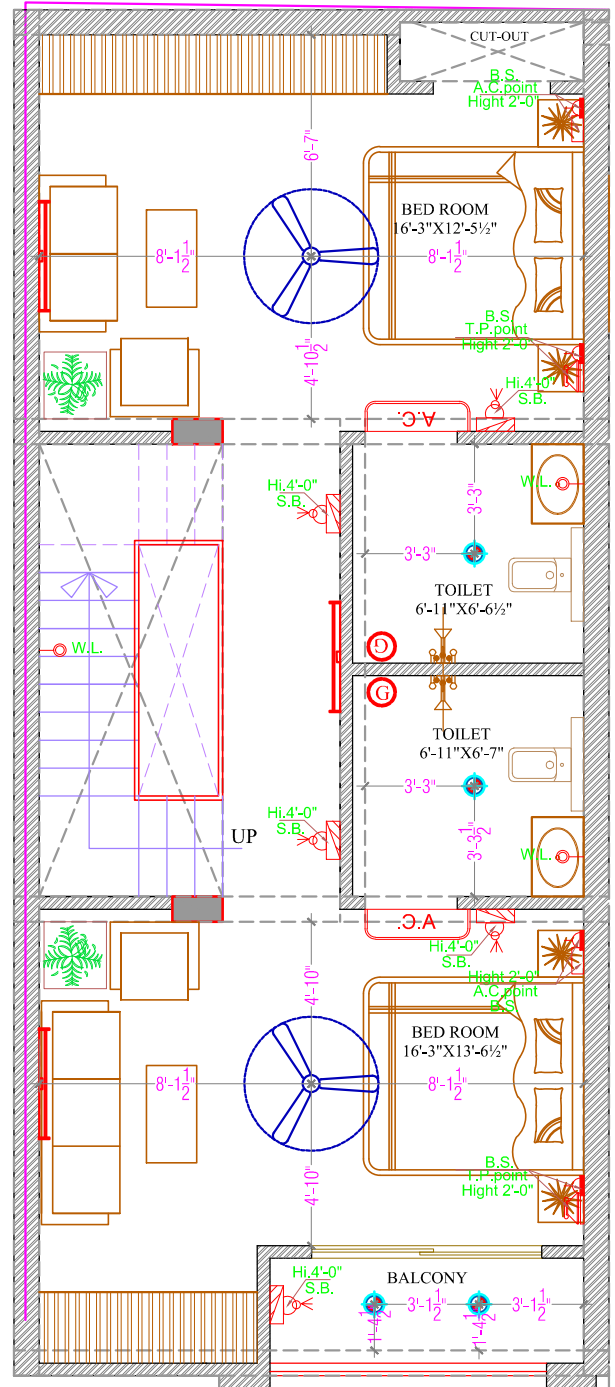

FIRST FLOOR PLAN

ELECTRICAL STANDARDS			
DESCRIPTION	SYMBOL	HEIGHT	STANDARD
CUTTING FAN	C.F.	8'-0"	INDIAN
CUTTING LIGHT	C.L.	8'-0"	INDIAN
WALL LIGHT	W.L.	8'-0"	INDIAN
EXHAUST FAN	E.F.	8'-0"	INDIAN
BELL BUZZER	B.B.	8'-0"	INDIAN
BELL PUSH	B.P.	8'-0"	INDIAN
TELEPHONE	T.P.	8'-0"	INDIAN
TELEVISION	T.V.	8'-0"	INDIAN
CHANDLER	C.R.	8'-0"	INDIAN
TUBE LIGHT	T.L.	8'-0"	INDIAN
SWITCH BOARD	S.B.	8'-0"	INDIAN
POWER SWITCH BOARD	P.S.B.	8'-0"	INDIAN
WALL HANGED FAN	W.H.F.	8'-0"	INDIAN
DISTRIBUTION BOARD	D.B.	8'-0"	INDIAN
GRINDER	G.	8'-0"	INDIAN
BED SWITCH	B.S.	8'-0"	INDIAN
BED LIGHT	B.L.	8'-0"	INDIAN
FOOT LIGHT	F.L.	8'-0"	INDIAN
SECURITY	S.	8'-0"	INDIAN
SPLIT A.C.	S.A.C.	8'-0"	INDIAN
LIGHT CIRCUIT	L.C.	8'-0"	INDIAN
POWER CIRCUIT	P.C.	8'-0"	INDIAN
TWO WAY	T.W.	8'-0"	INDIAN
INTERNET	I.N.T.	8'-0"	INDIAN

ELECTRICAL LAYOUT PLAN

VILLA NO. L-28

NORTH :-



GENERAL NOTES:-

THIS DRAWING IS THE PROPERTY OF YEC AND NOT TO BE COPIED OR USED WITHOUT THEIR PERMISSION
ALL DIMENSIONS ARE TO BE READ AND NOT SCALED / MEASURED FROM THE DRAWING
THIS DRAWING IS TO BE READ ALONG WITH ALL RELATED STRUCTURAL SERVICES DRAWINGS
FURNITURE/FIXTURES SHOWN ARE INDICATIVE ONLY PLEASE REFER RESPECTIVE SCHEDULES
ANY DISCREPANCIES IN THE DRAWING OR AT SITE MAY BE IMMEDIATELY REPORTED TO THE ARCHITECTS

PROJECT TYPE:

VILLA RESIDENCE

DRAWING TYPE:

FLOOR PLAN

SITE ADD.

AT JAIPUR

CLIENT:

MR. MANOJ JI

DRAWN BY :

ER. LAJIT SAINI

DESIGN BY :

MR. KAMAL KUMAR SHARMA

DESIGN BY :

OFFICE ADD :





A-34 PADMAWATI COLONY KINGS ROAD NIRMAN NAGAR JAIPUR (RAJ.)

DATE:





07/03/2022




VILLA - L13 TO L22
ELECTRICAL PLAN

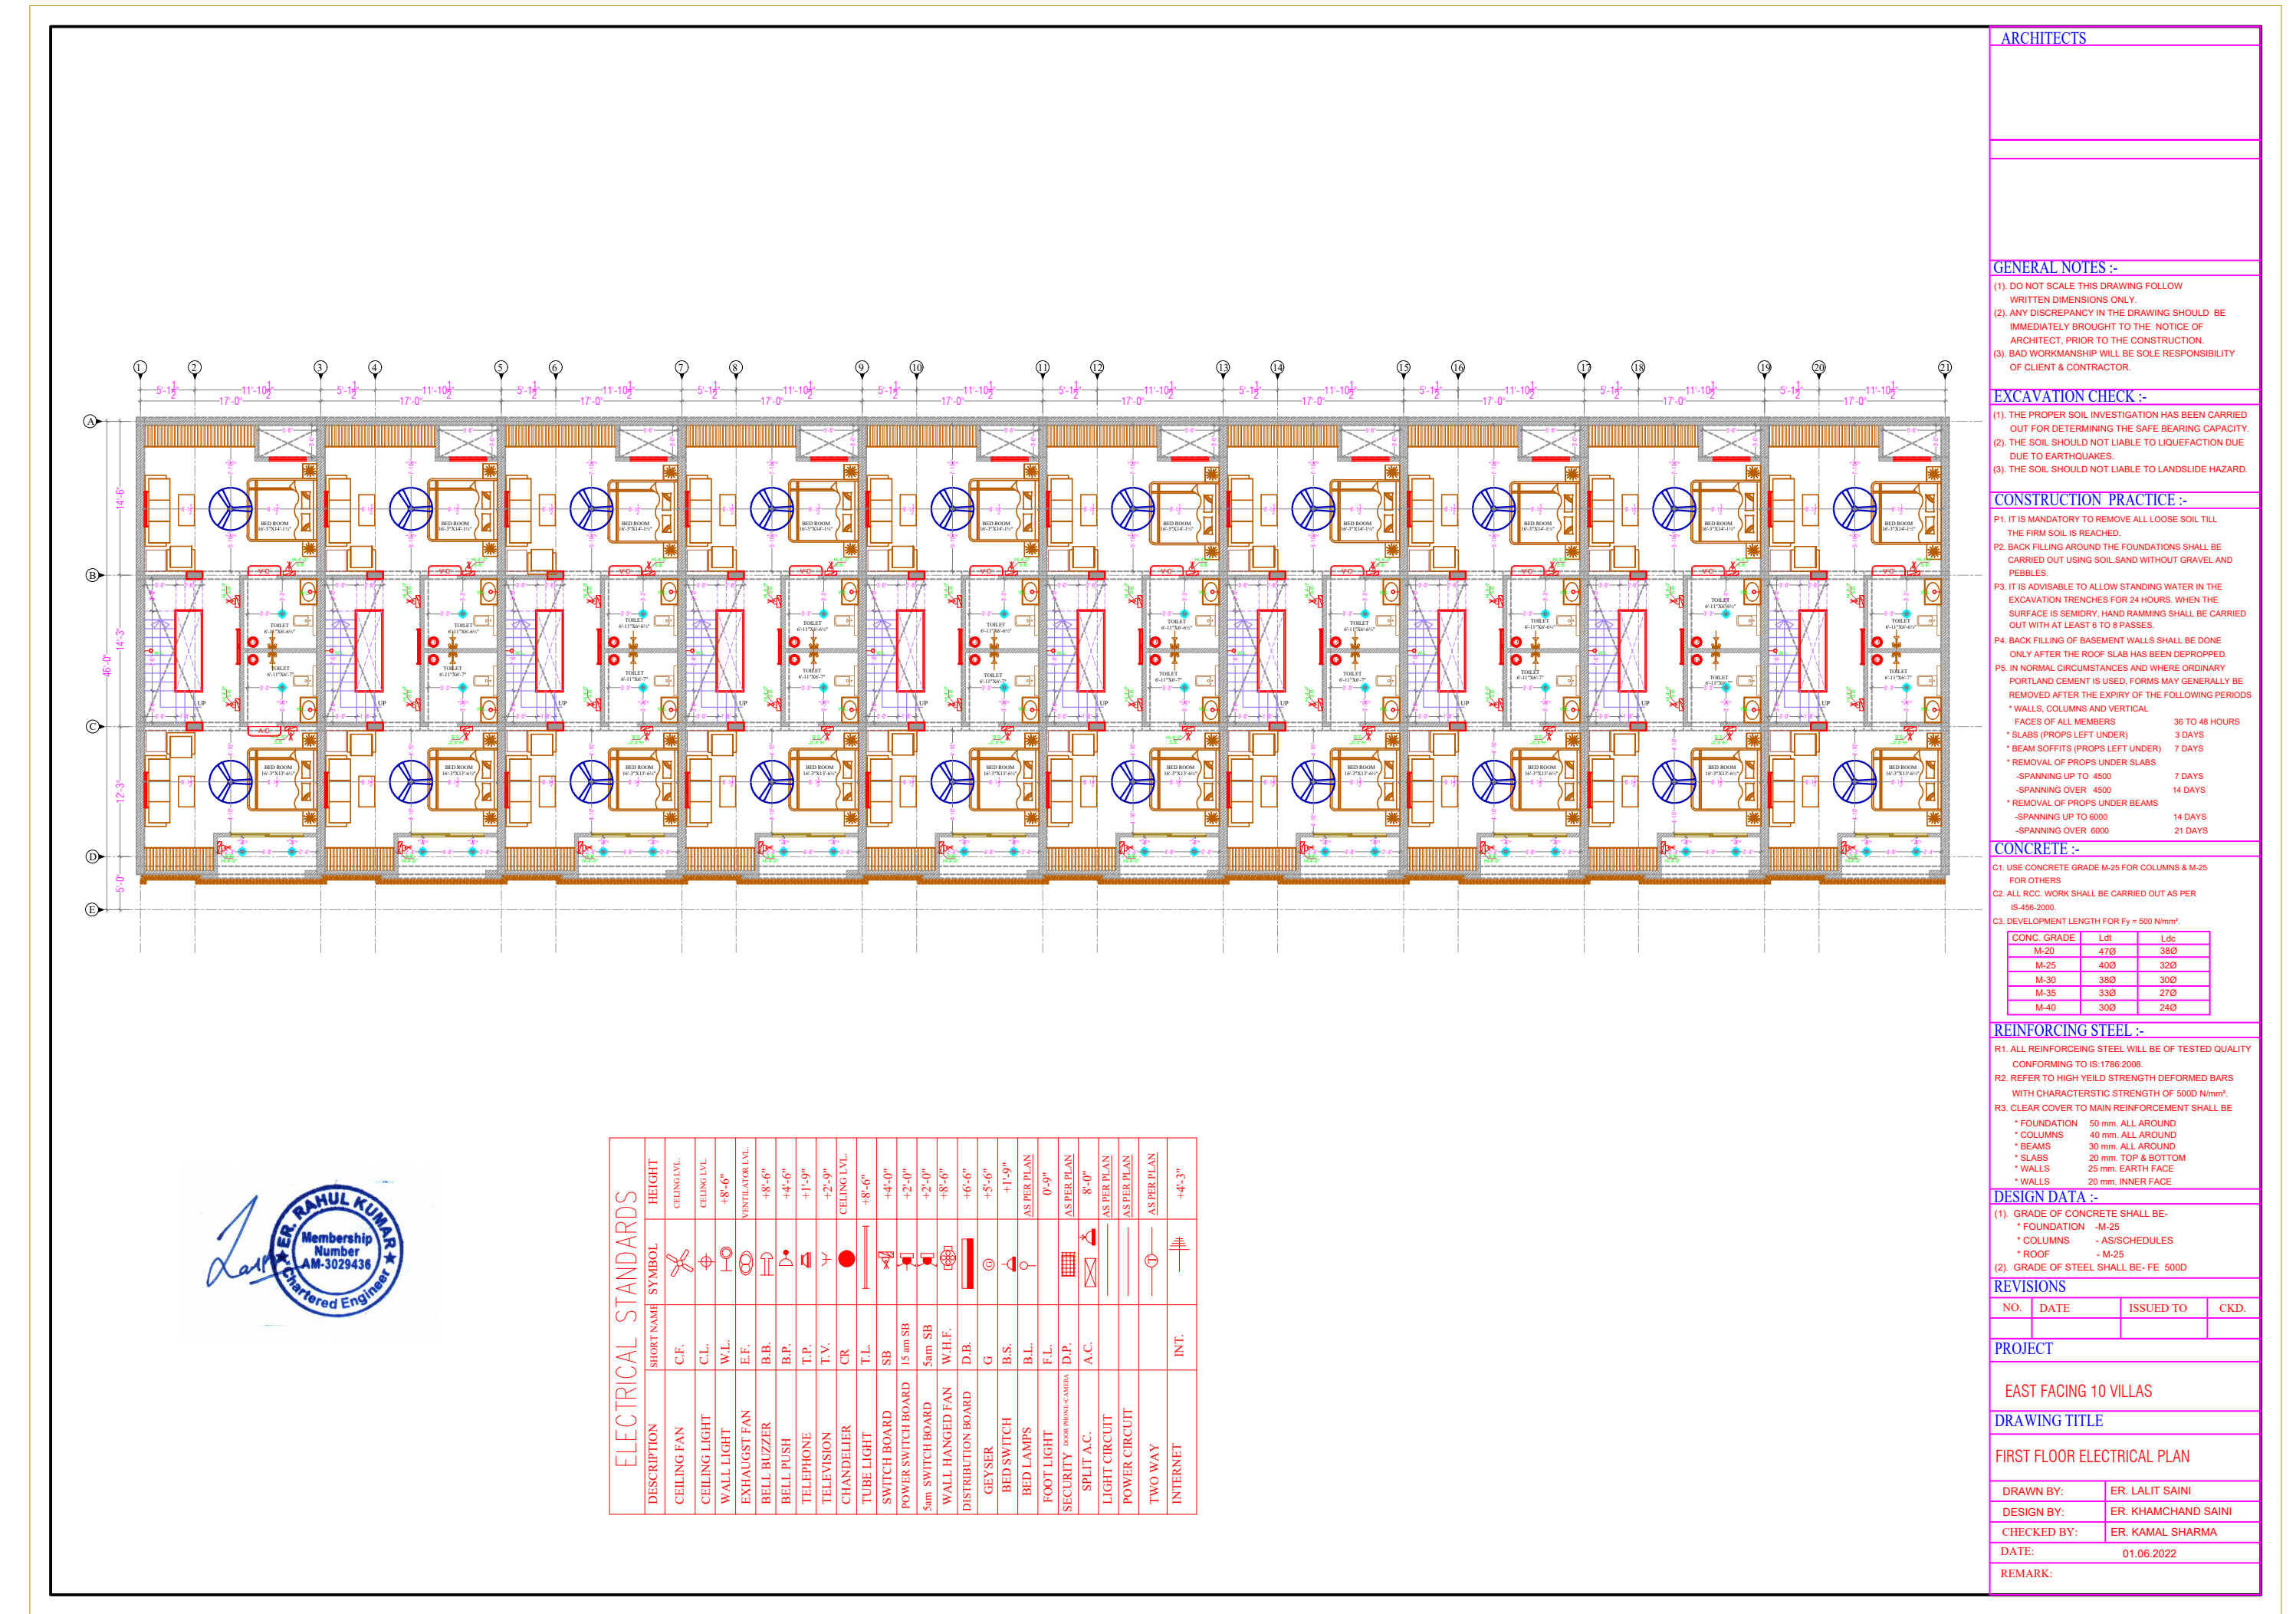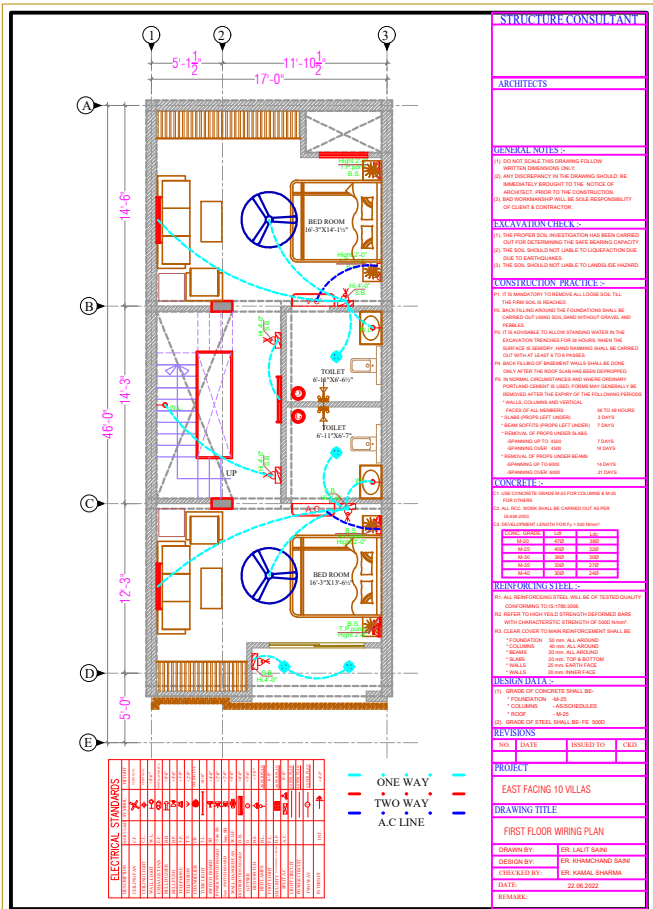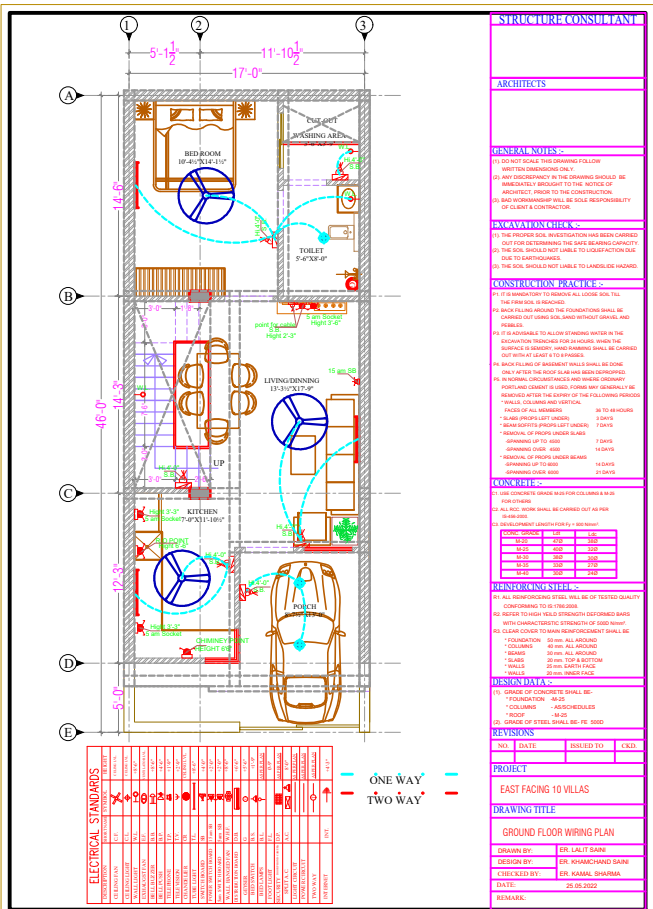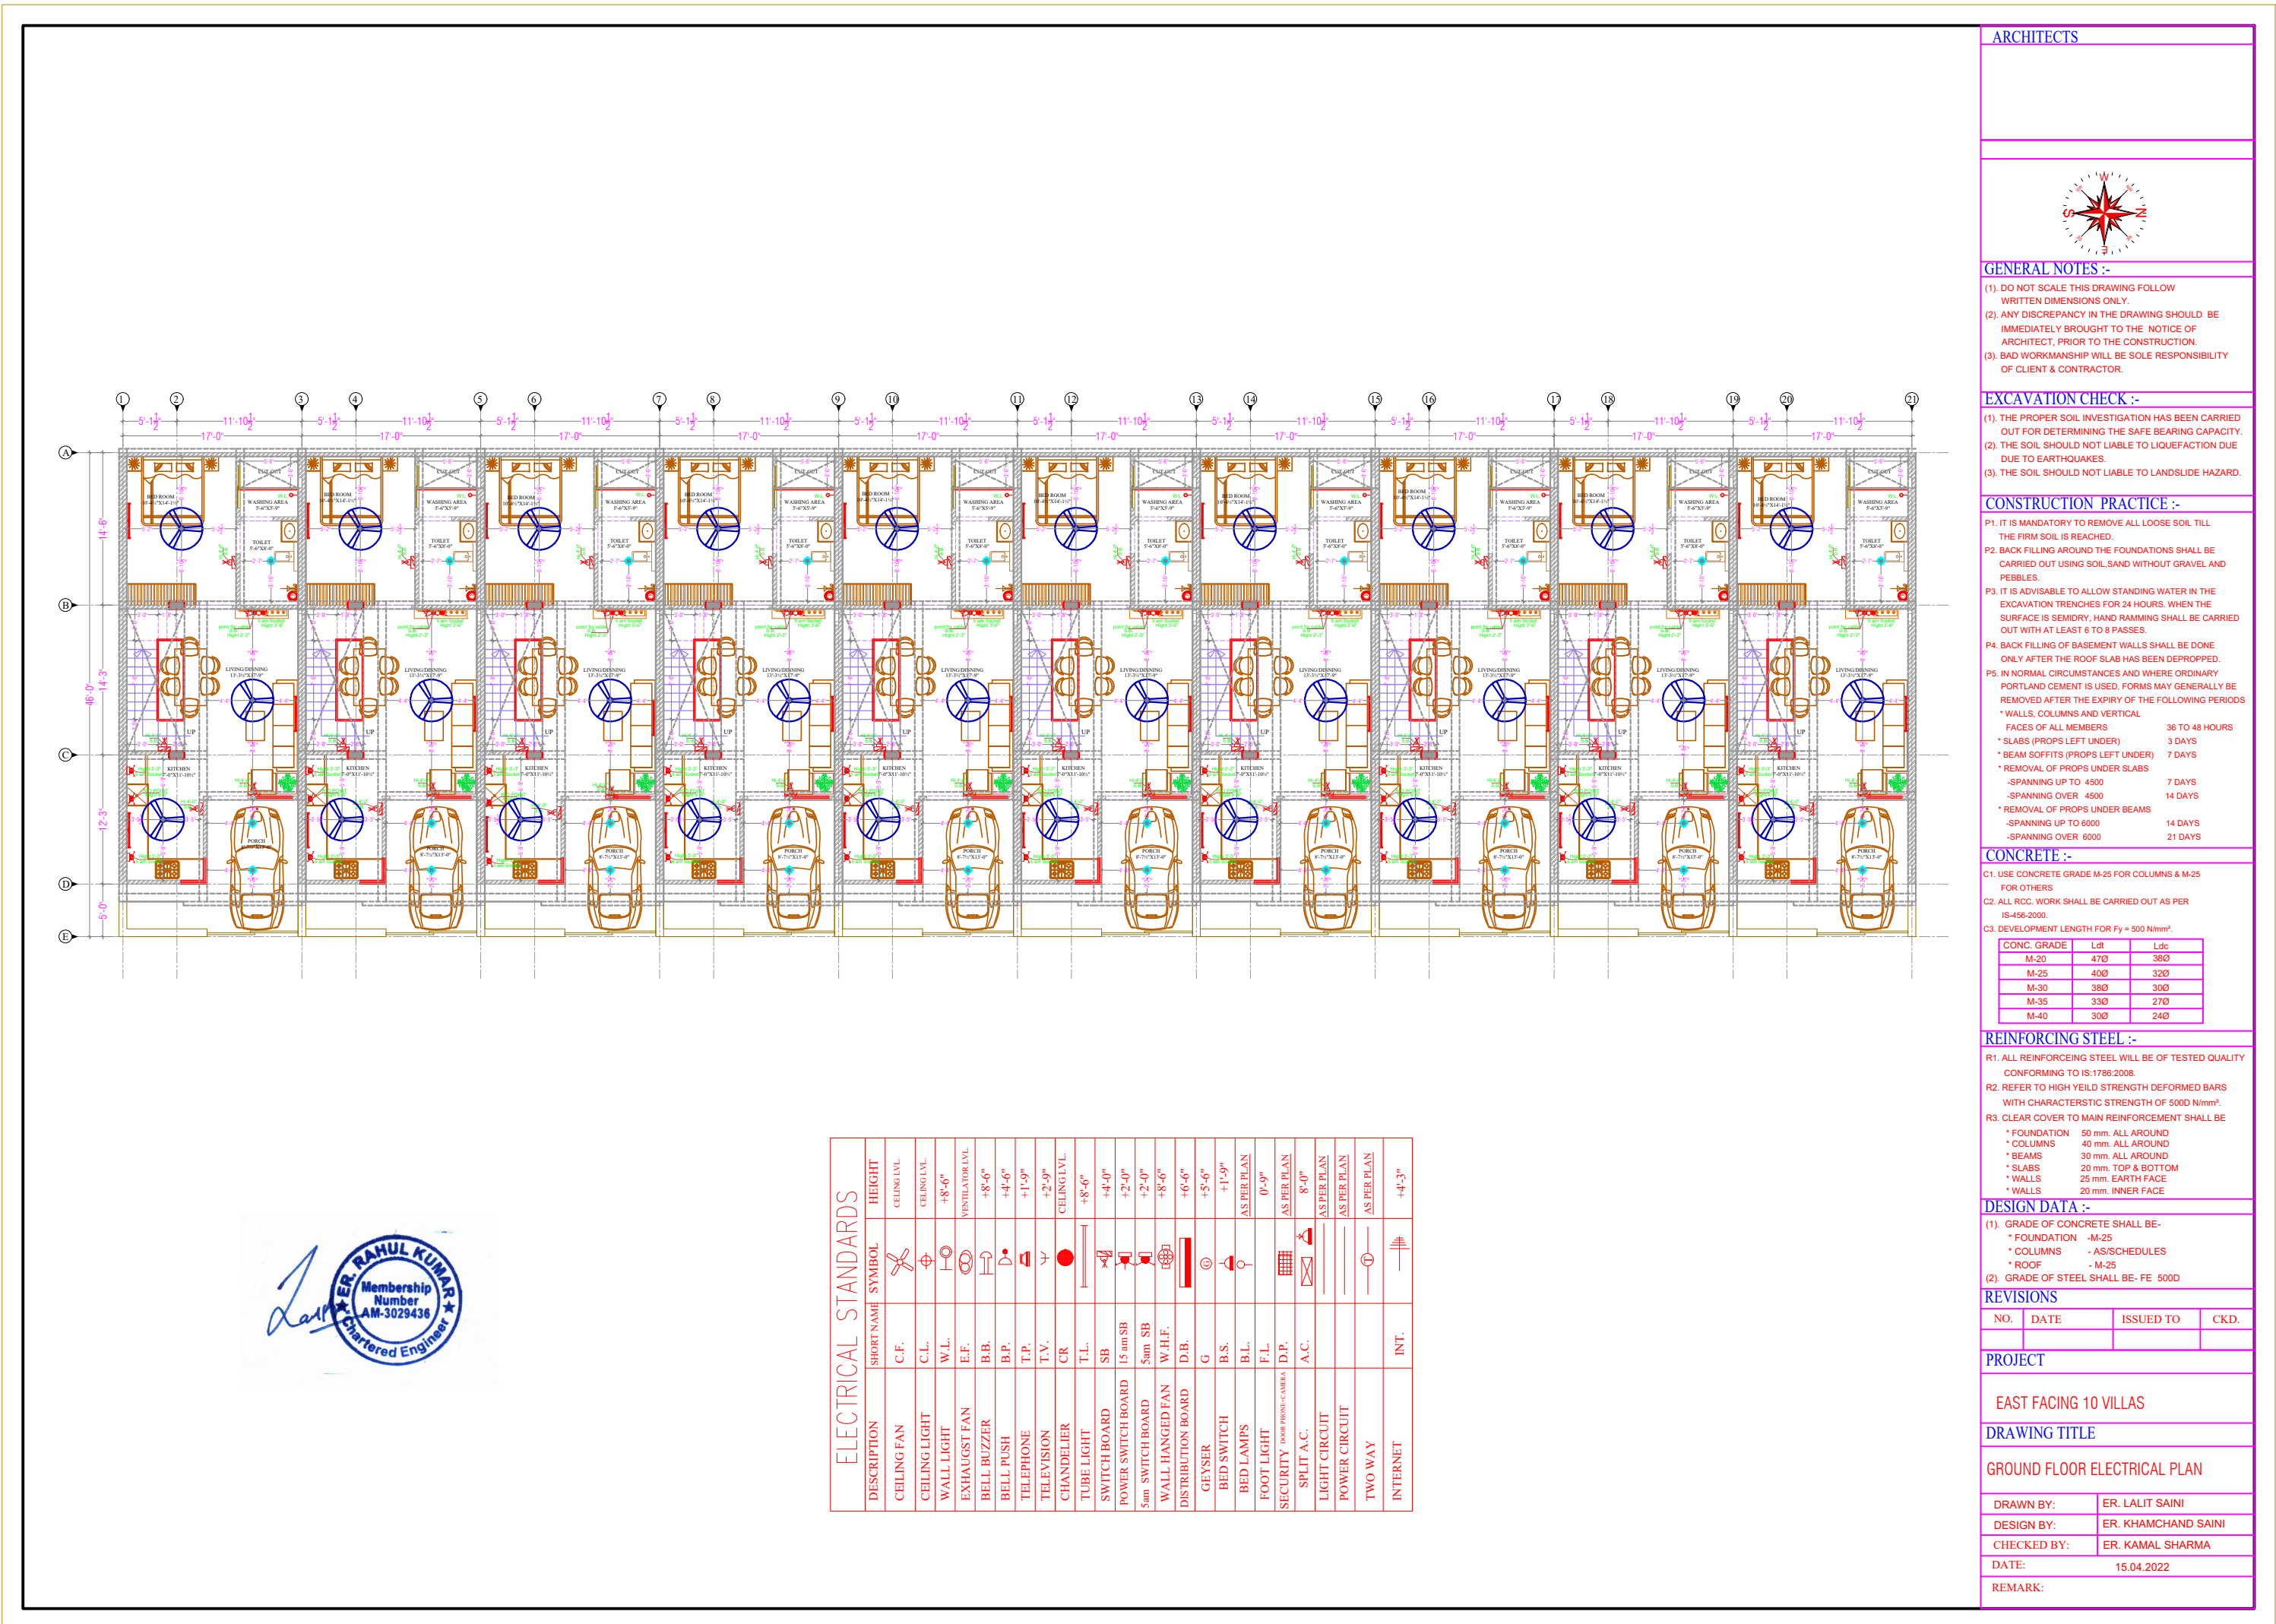

VILLA - L03 TO L12
ELECTRICAL PLAN

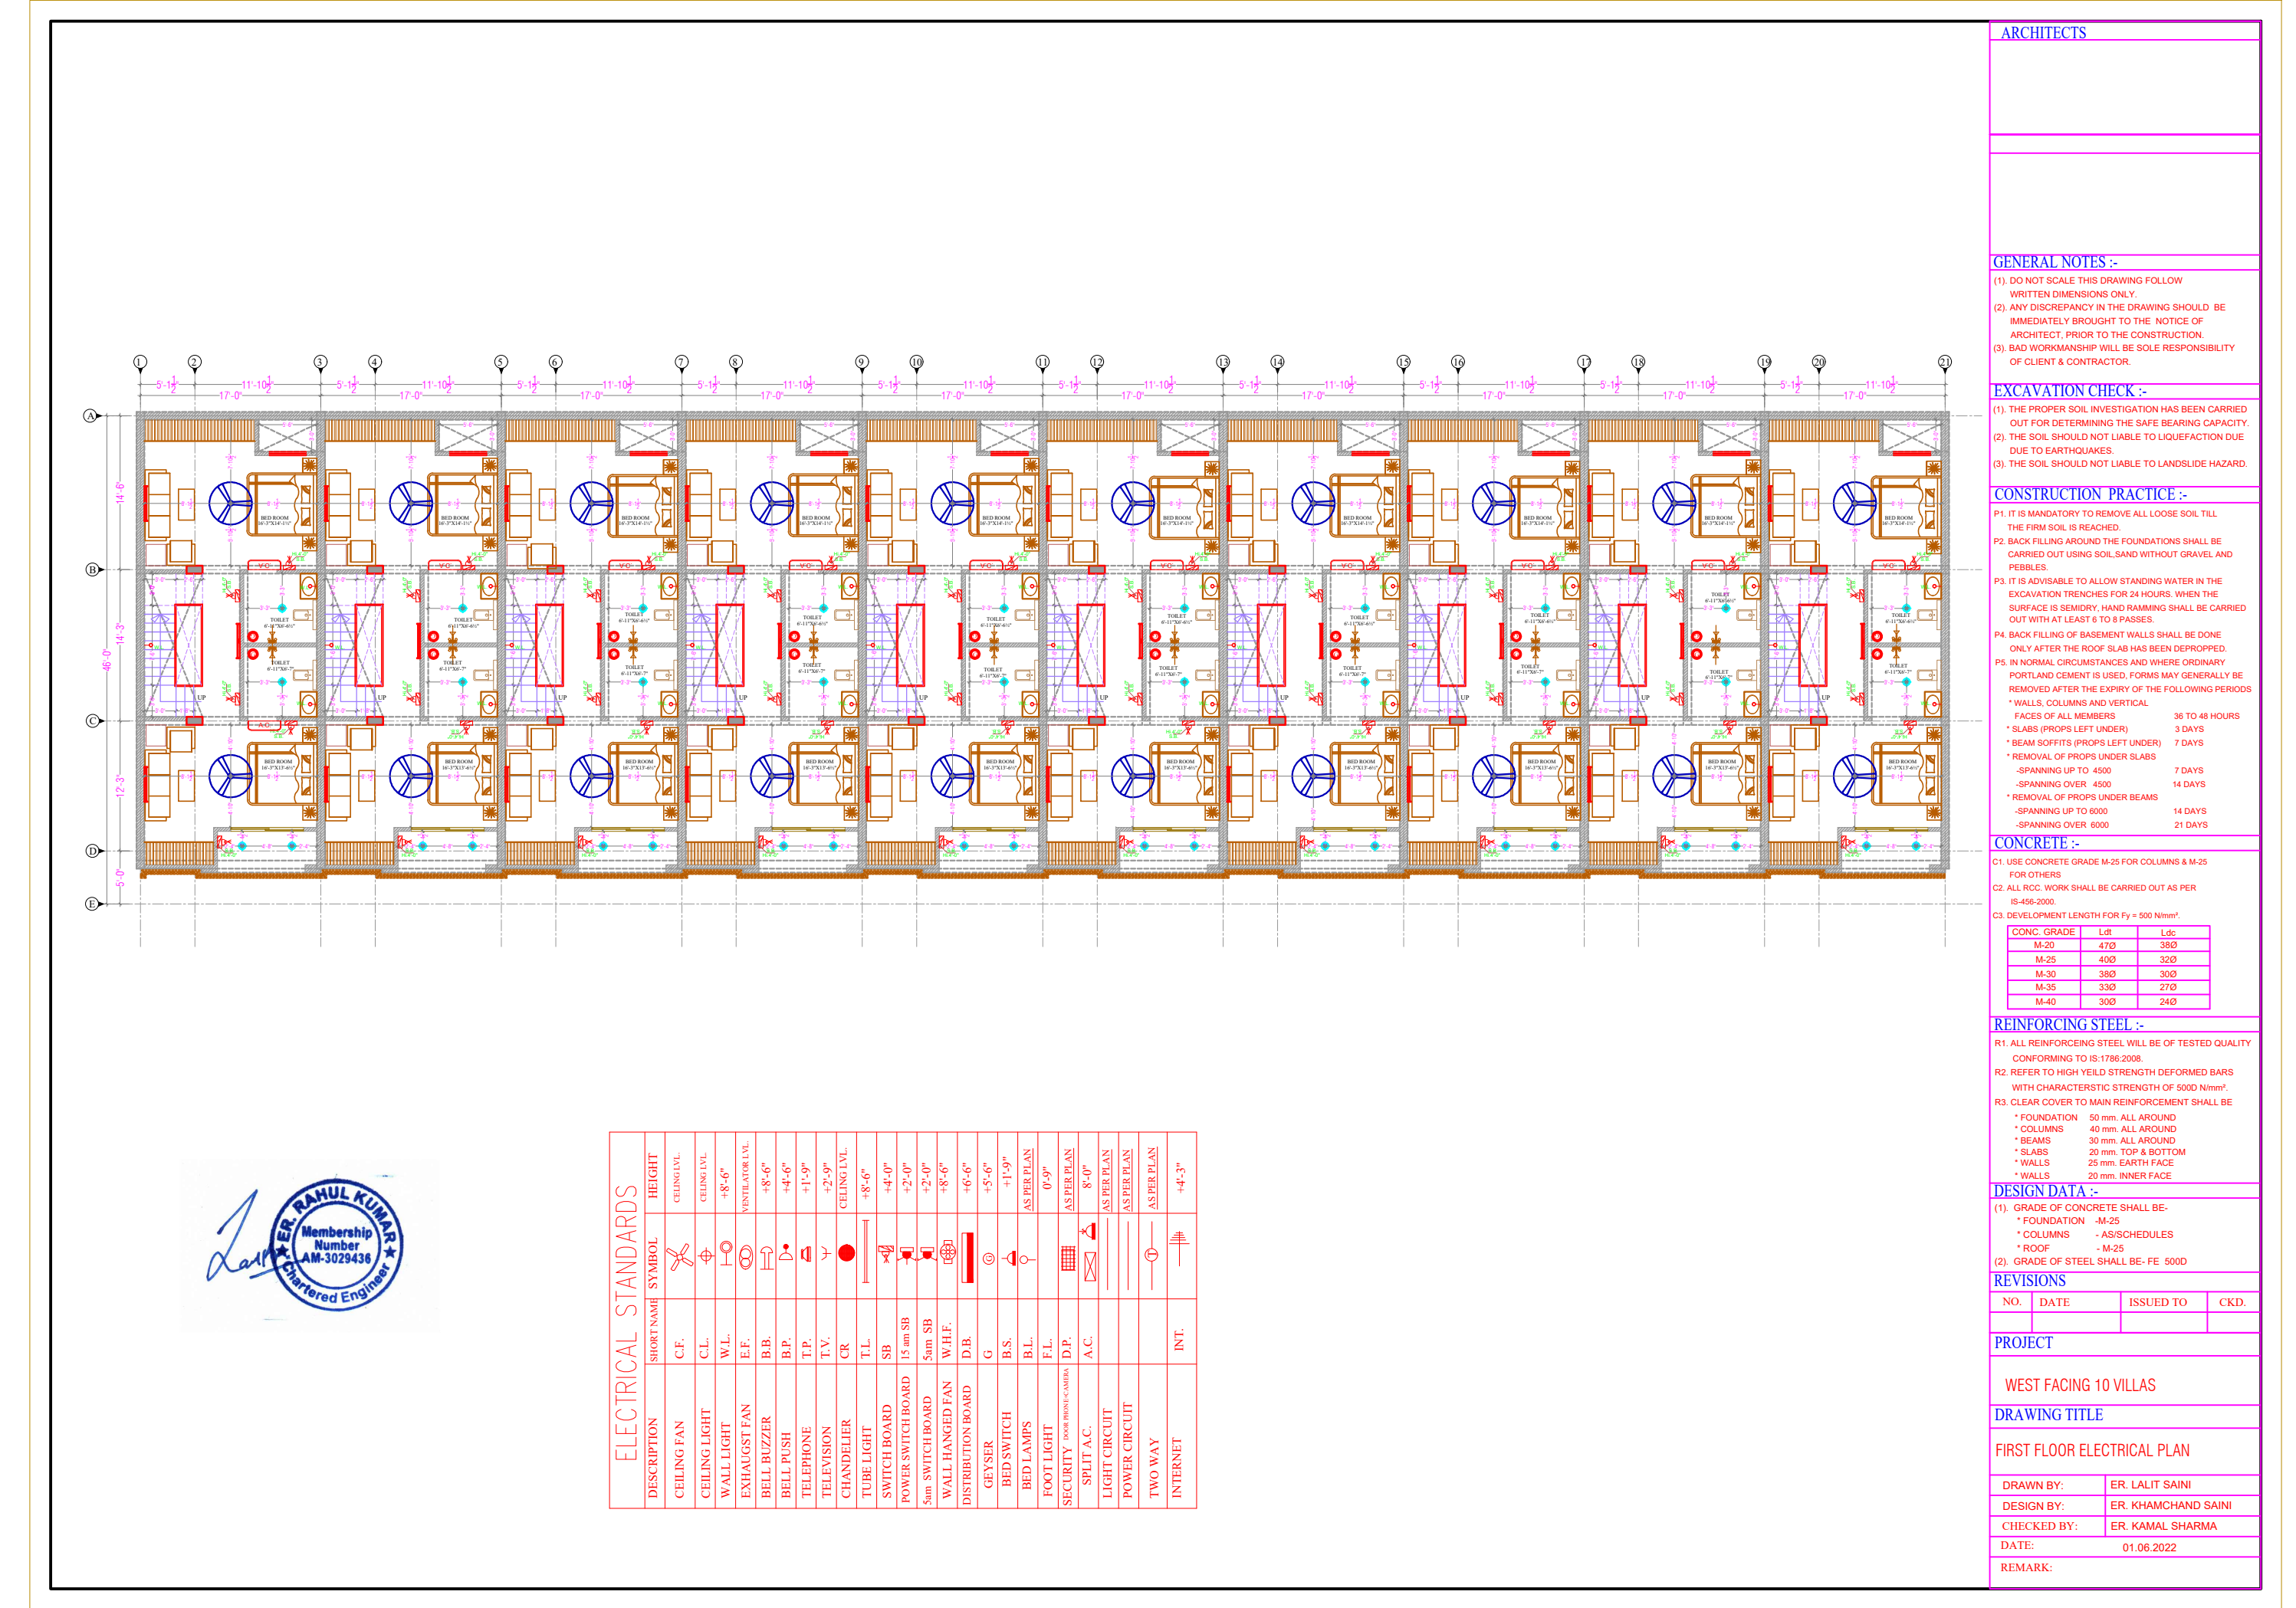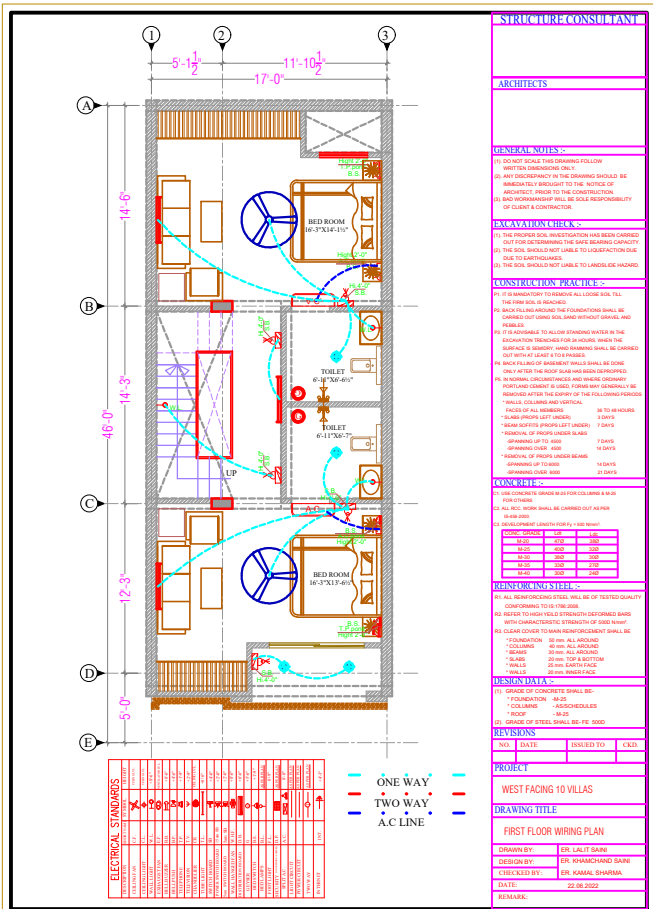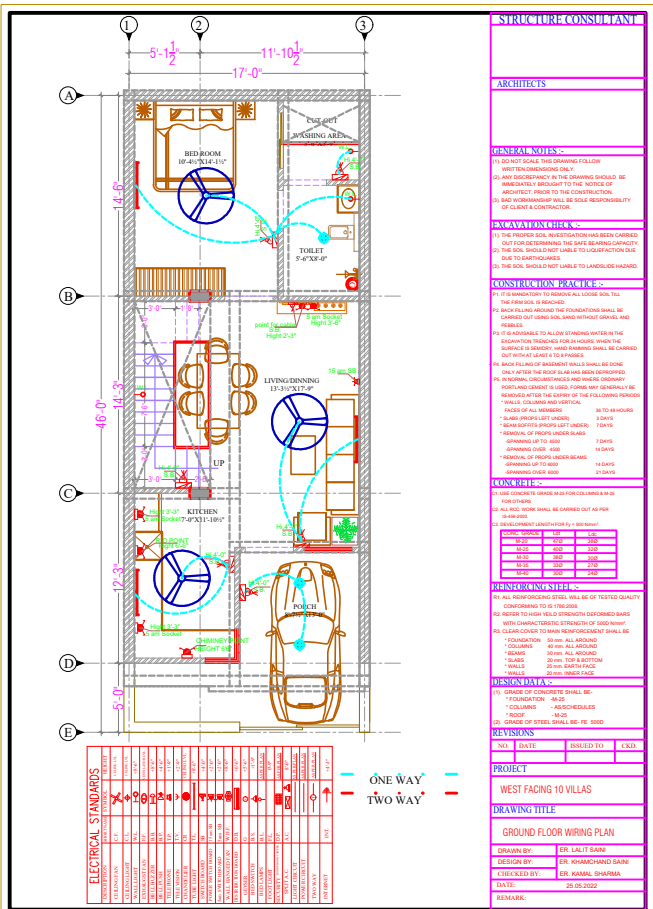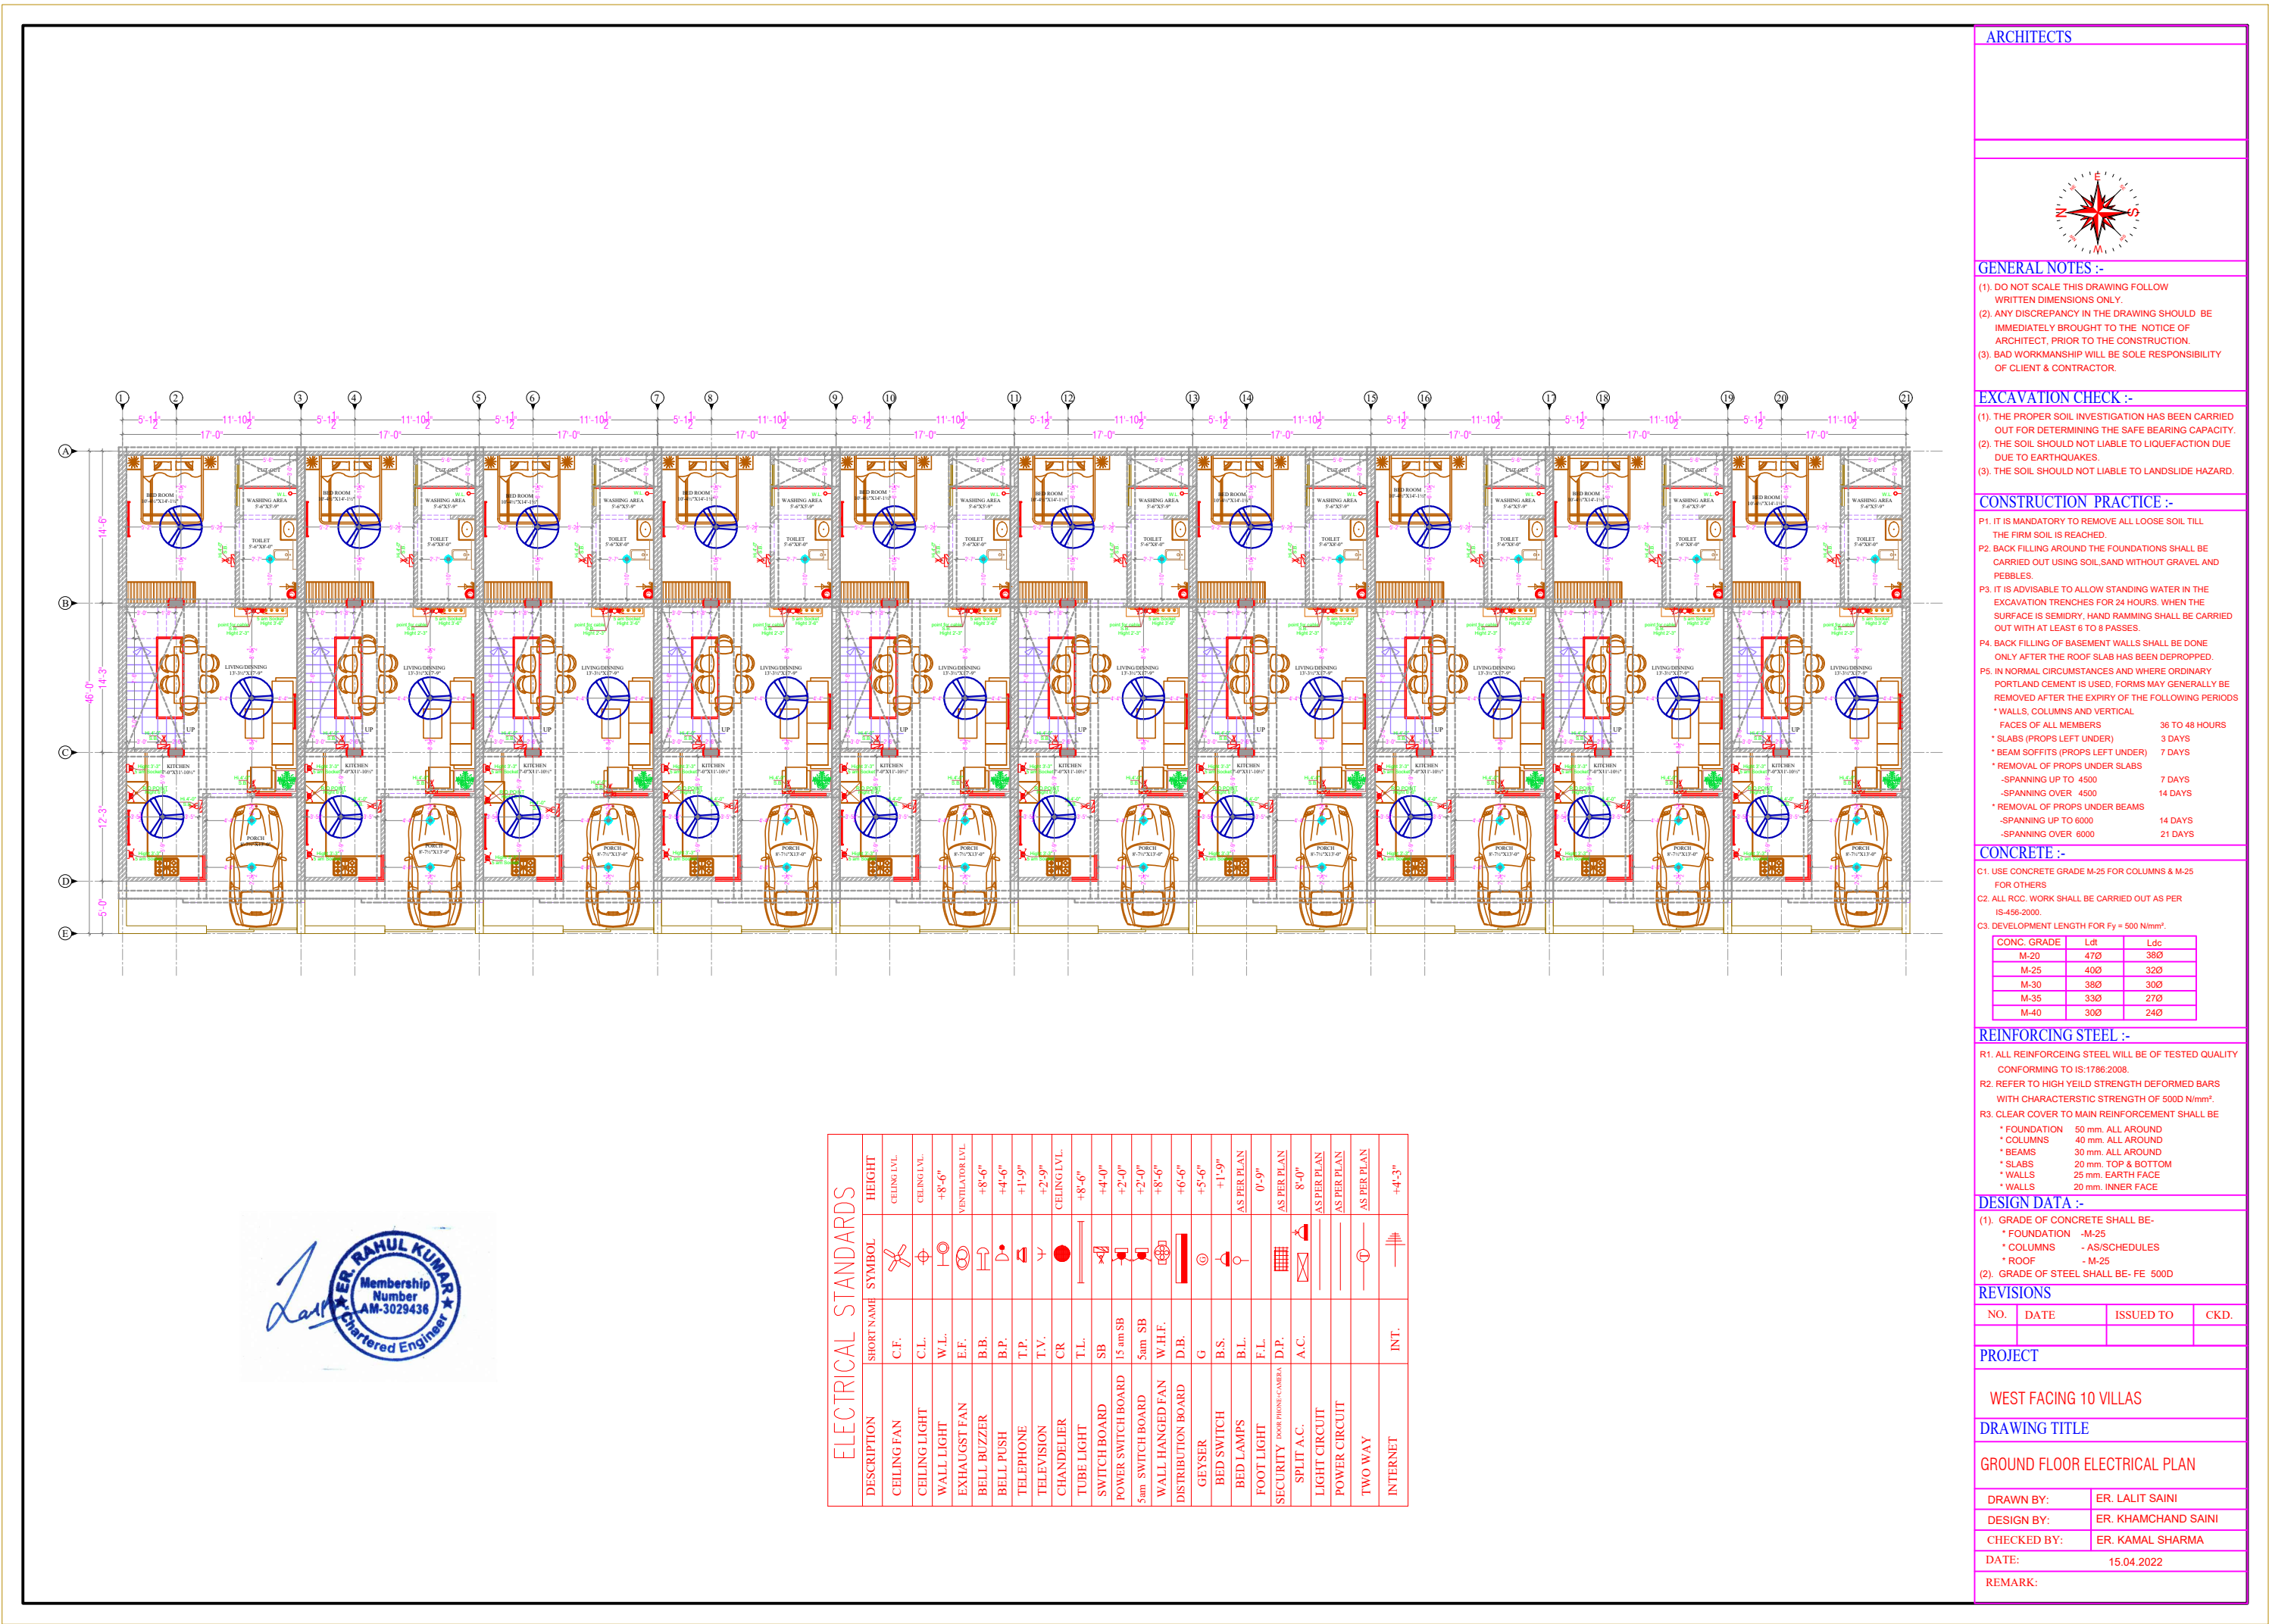

VILLA - L-01
ELECTRICAL PLAN

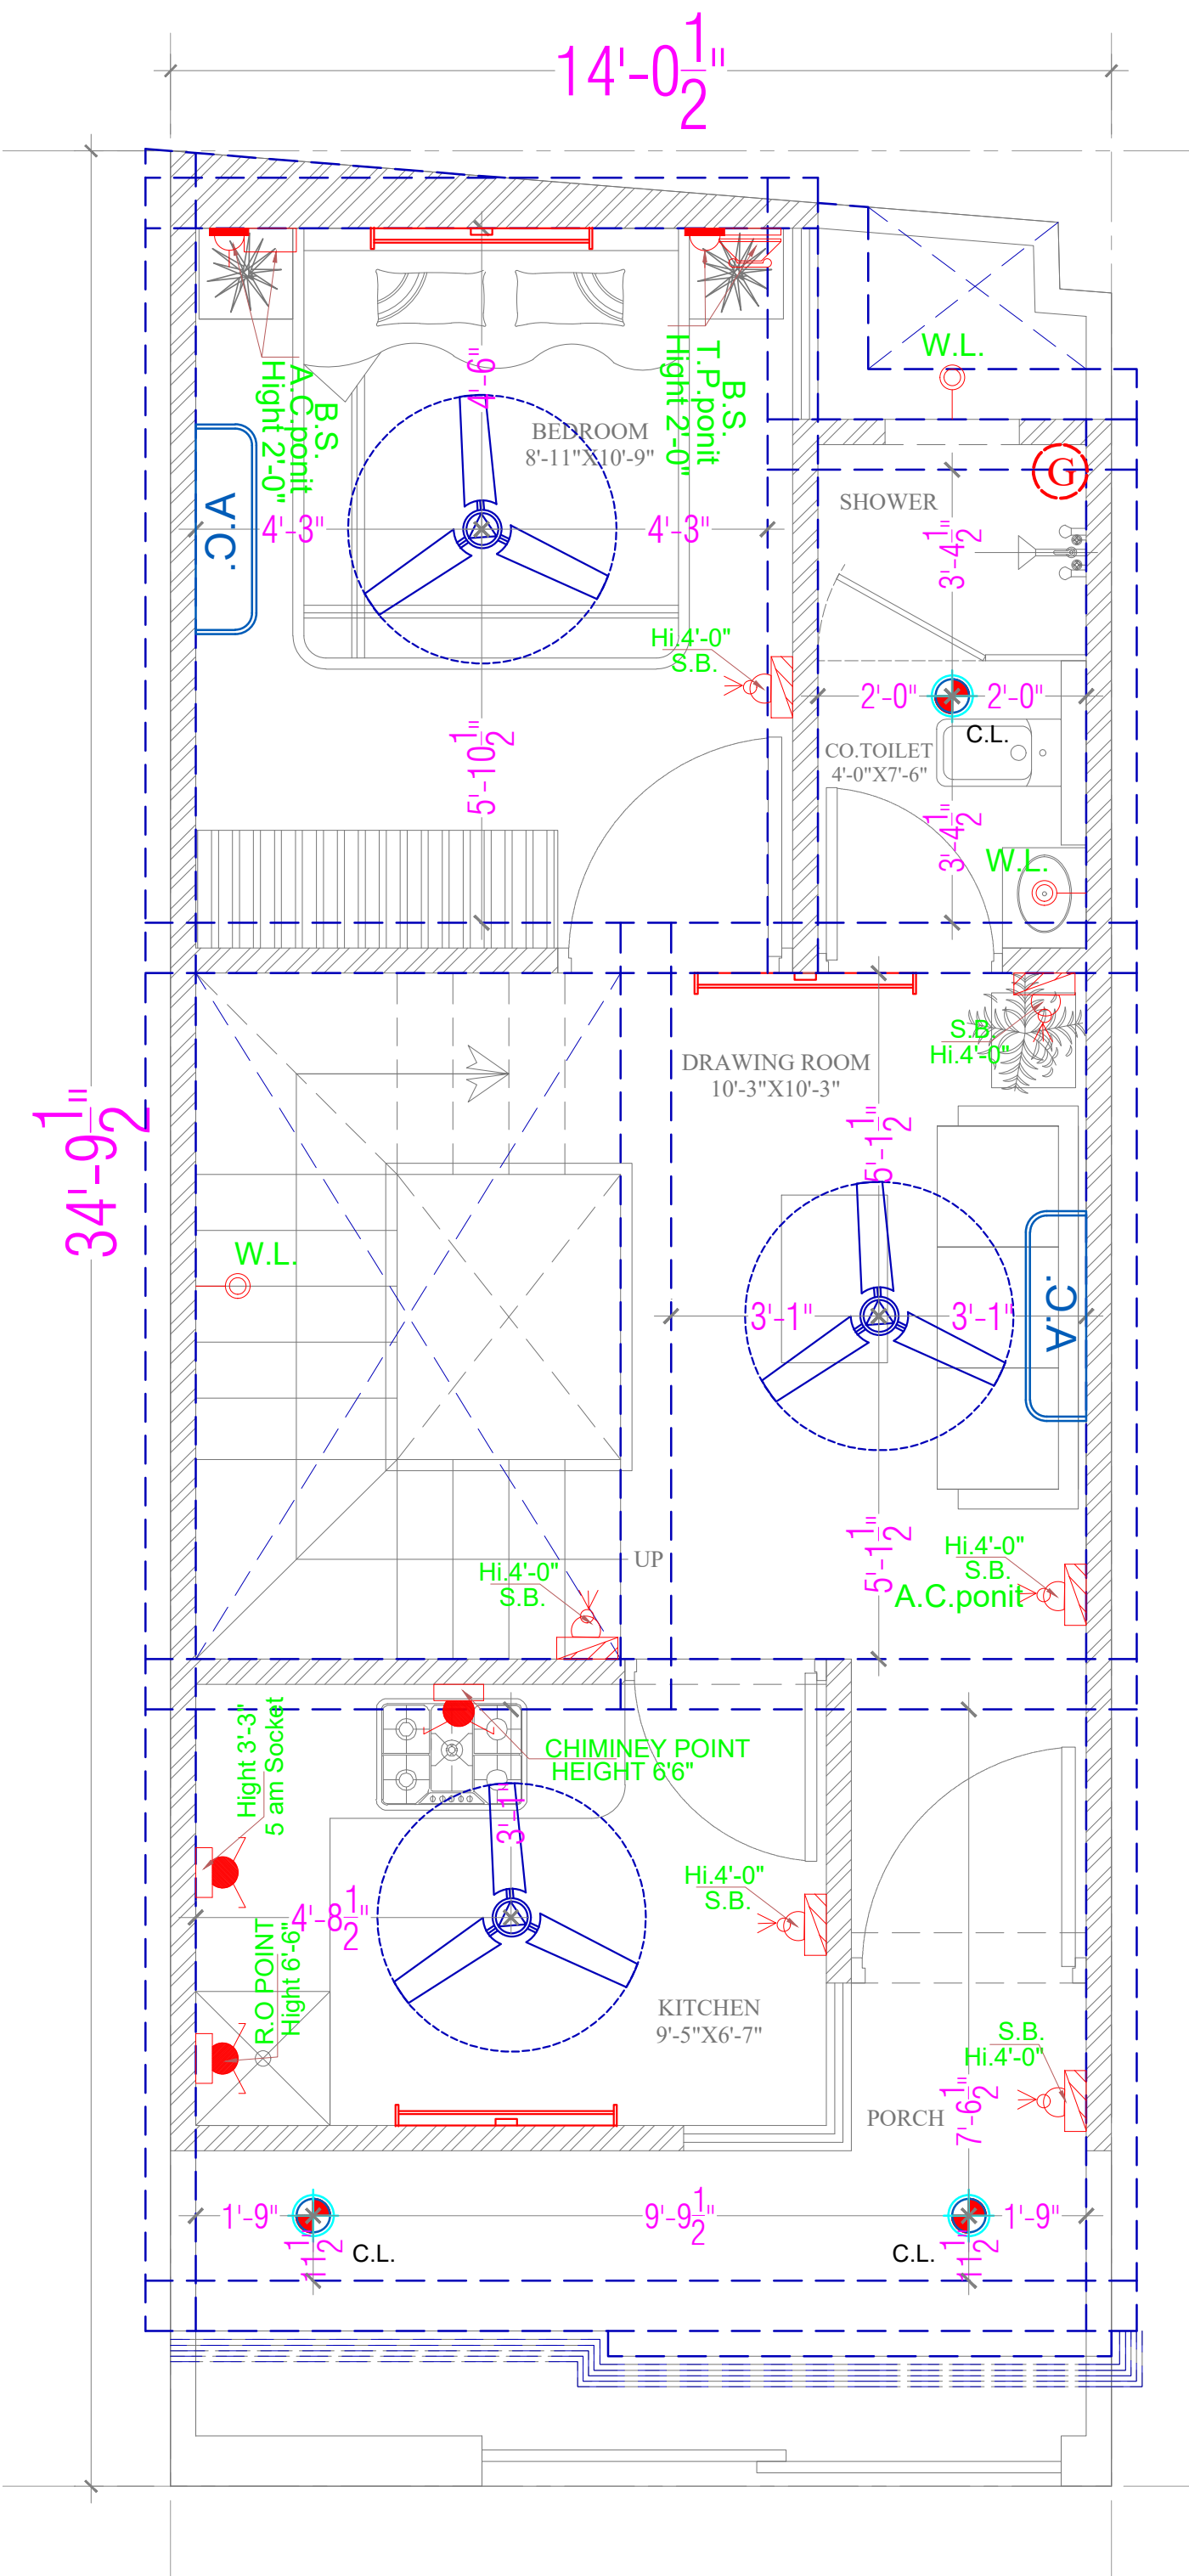


ELECTRICAL STANDARDS			
DESCRIPTION	SHORT NAME	SYMBOL	HEIGHT
CEILING FAN	C.F.		CEILING LVL.
CEILING LIGHT	C.L.		CEILING LVL.
WALL LIGHT	W.L.		+8'-6"
EXHAUGST FAN	E.F.		VENTILATOR LVL.
BELL BUZZER	B.B.		+8'-6"
BELL PUSH	B.P.		+4'-6"
TELEPHONE	T.P.		+1'-9"
TELEVISION	T.V.		+2'-9"
CHANDELIER	CR		CEILING LVL.
TUBE LIGHT	T.L.		+8'-6"
SWITCH BOARD	SB		+4'-0"
POWER SWITCH BOARD	15 am SB		+2'-0"
5am SWITCH BOARD	5am SB		+2'-0"
WALL HANGED FAN	W.H.F.		+8'-6"
DISTRIBUTION BOARD	D.B.		+6'-6"
GEYSER	G		+5'-6"
BED SWITCH	B.S.		+1'-9"
BED LAMPS	B.L.		AS PER PLAN
FOOT LIGHT	F.L.		0'-9"
SECURITY DOOR PHONE-CAMERA	D.P.		AS PER PLAN
SPLIT A.C.	A.C.		8'-0"
LIGHT CIRCUIT			AS PER PLAN
POWER CIRCUIT			AS PER PLAN
TWO WAY			AS PER PLAN
INTERNET	INT.		+4'-3"



GROUND FLOOR ELECTRICAL PLAN

VILLA - L1

NORTH :- 	GENERAL NOTES: THIS DRAWING IS THE PROPERTY OF YED AND NOT TO BE COPIED OR USED WITHOUT THEIR PERMISSION. ALL DIMENSIONS ARE TO BE READ AND NOT SCALED. MEASURED FROM THE DRAWING. FURNITURE/FIXTURES SHOWN ARE INDICATIVE ONLY. PLEASE REFER RESPECTIVE SCREENS. ANY DISCREPANCIES IN THE DRAWING OR AT SITE MAY BE IMMEDIATELY REPORTED TO THE ARCHITECTS.	PROJECT TYPE: VILLA L-01	DRAWN BY : ER. LAJUT SAINI	DESIGN BY : ER. LAJUT SAINI	DATE: 23/03/2023
		DRAWING TYPE: GROUND FLOOR PLAN	DESIGN BY : MR. KAMAL KUMAR SHARMA	OFFICE ADD : A-34 PADMAWATI COLONY KINGS ROAD NIRMAL NAGAR JAIPUR (RAJ.)	
		SITE ADD: AT JAIPUR	CLIENT: MR. MANOJ J		

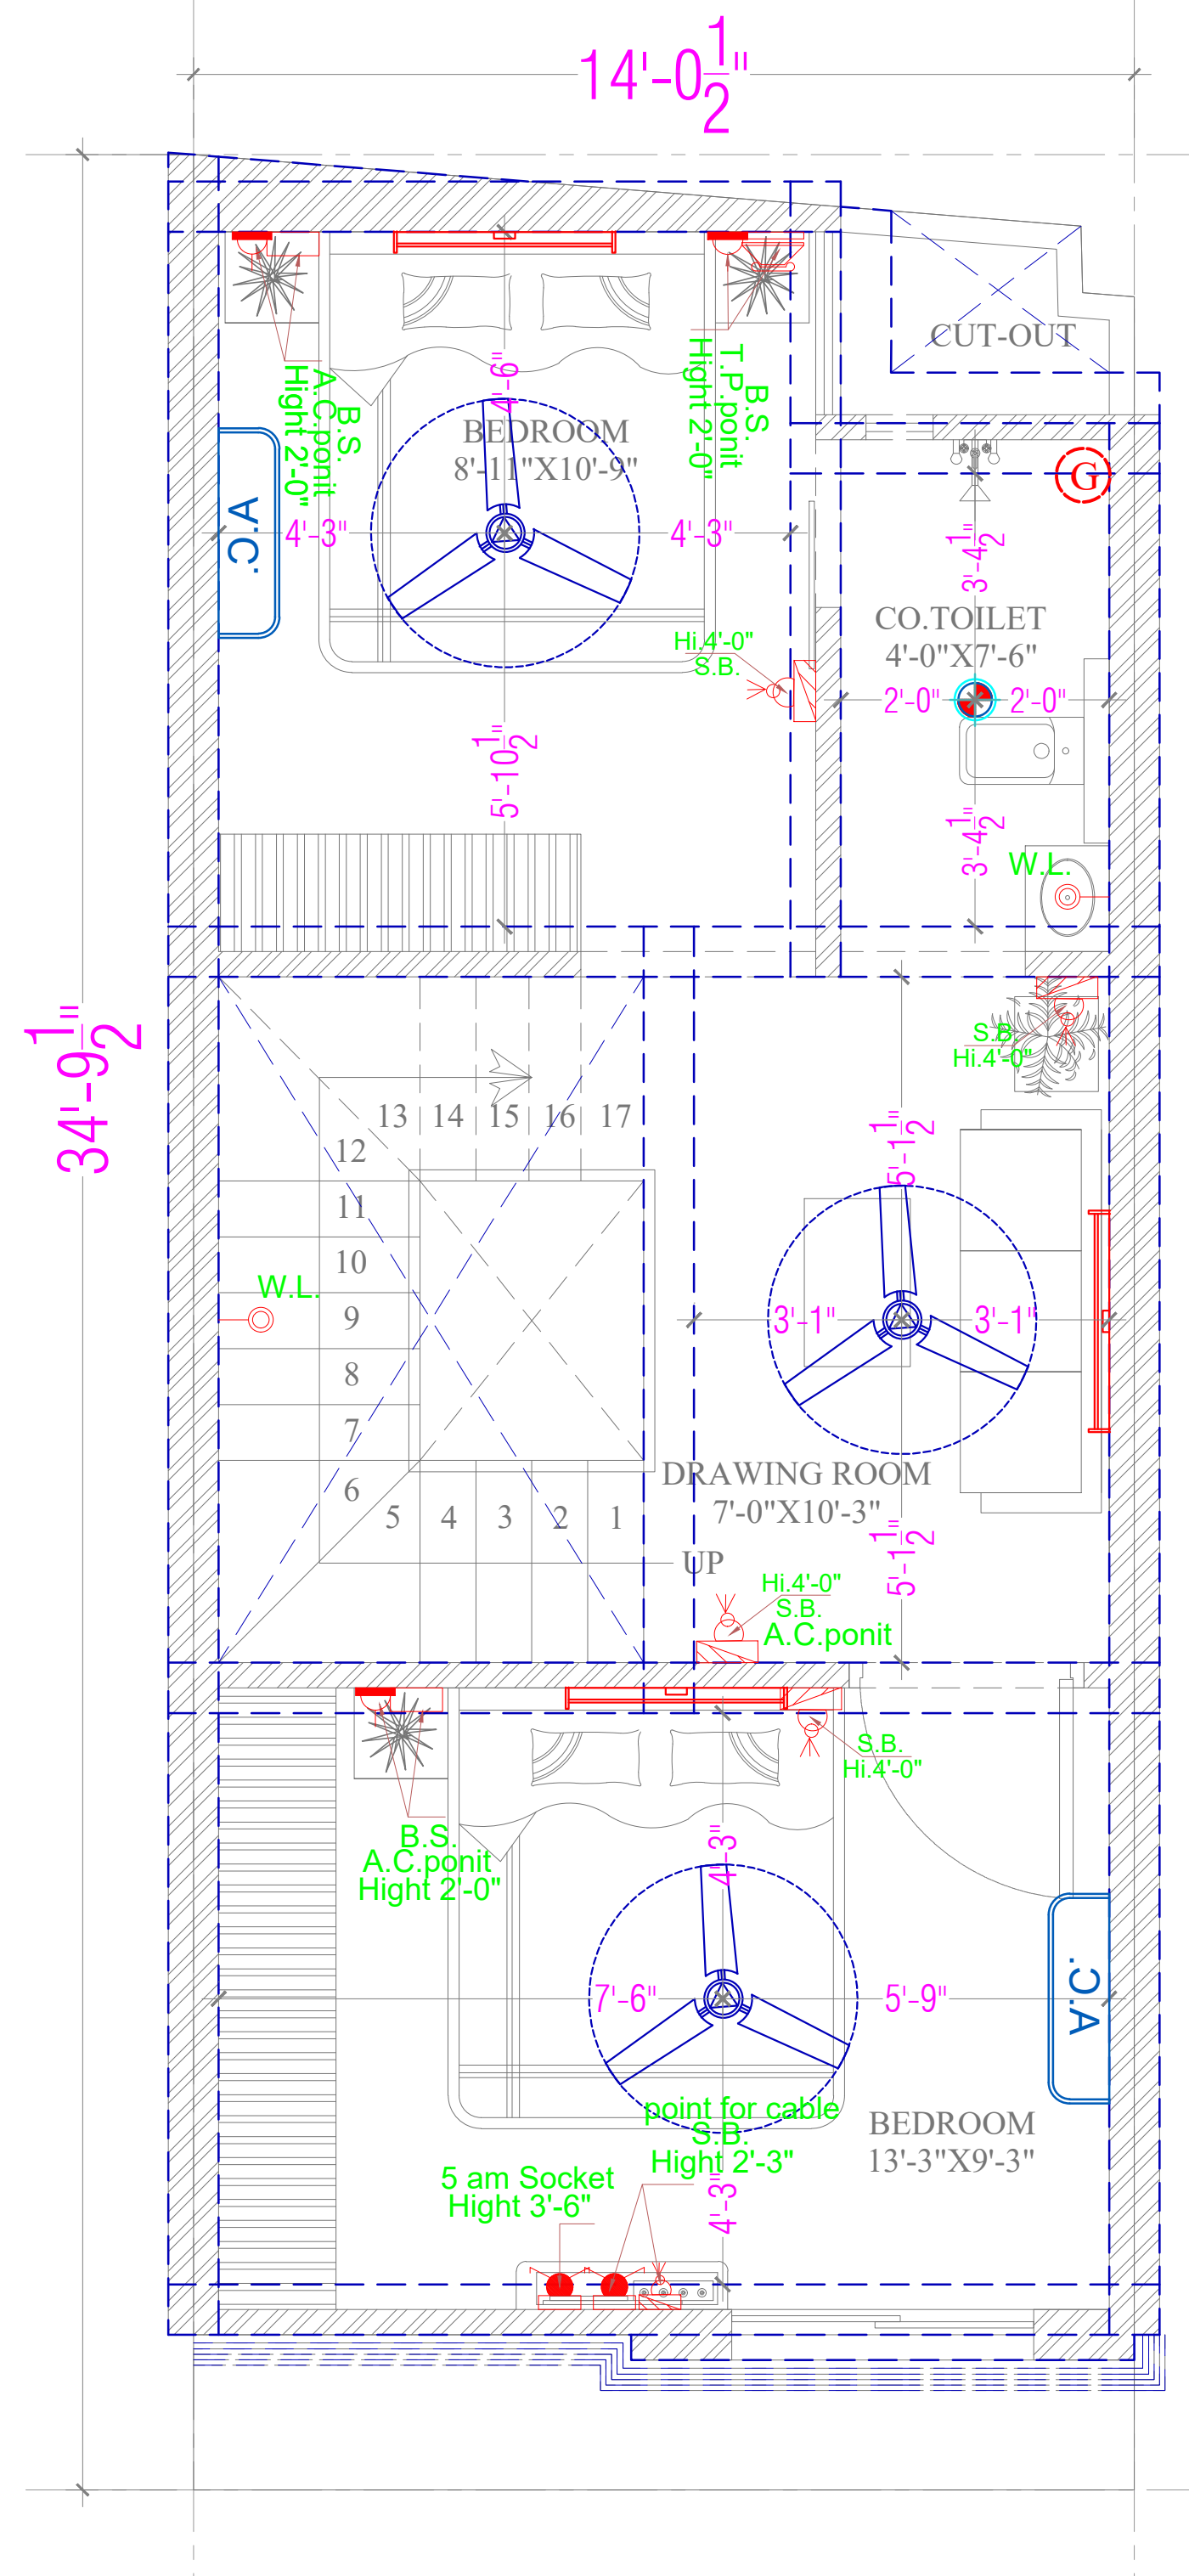

ELECTRICAL STANDARDS			
DESCRIPTION	SHORT NAME	SYMBOL	HEIGHT
CEILING FAN	C.F.		CEILING LVL.
CEILING LIGHT	C.L.		CEILING LVL.
WALL LIGHT	W.L.		+8'-6"
EXHAUGST FAN	E.F.		VENTILATOR LVL.
BELL BUZZER	B.B.		+8'-6"
BELL PUSH	B.P.		+4'-6"
TELEPHONE	T.P.		+1'-9"
TELEVISION	T.V.		+2'-9"
CHANDELIER	CR		CEILING LVL.
TUBE LIGHT	T.L.		+8'-6"
SWITCH BOARD	SB		+4'-0"
POWER SWITCH BOARD	15 am SB		+2'-0"
5am SWITCH BOARD	5am SB		+2'-0"
WALL HANGED FAN	W.H.F.		+8'-6"
DISTRIBUTION BOARD	D.B.		+6'-6"
GEYSER	G		+5'-6"
BED SWITCH	B.S.		+1'-9"
BED LAMPS	B.L.		AS PER PLAN
FOOT LIGHT	F.L.		0'-9"
SECURITY DOOR PHONE-CAMERA	D.P.		AS PER PLAN
SPLIT A.C.	A.C.		8'-0"
LIGHT CIRCUIT			AS PER PLAN
POWER CIRCUIT			AS PER PLAN
TWO WAY			AS PER PLAN
INTERNET	INT.		+4'-3"





FIRST FLOOR ELECTRICAL PLAN

VILLA - L1


NORTH :- 	GENERAL NOTES: THIS DRAWING IS THE PROPERTY OF YED AND NOT TO BE COPIED OR USED WITHOUT THEIR PERMISSION. ALL DIMENSIONS ARE TO BE READ AND NOT SCALED. MEASURED FROM THE DRAWING. FURNITURE/FIXTURES SHOWN ARE INDICATIVE ONLY. PLEASE REFER RESPECTIVE SCREENS. ANY DISCREPANCIES IN THE DRAWING OR AT SITE MAY BE IMMEDIATELY REPORTED TO THE ARCHITECTS.	PROJECT TYPE: VILLA L-01	DRAWN BY : ER. LAJUT SAINI	DESIGN BY : ER. LAJUT SAINI	DATE: 23/03/2023
		DRAWING TYPE: GROUND FLOOR PLAN	DESIGN BY : MR. KAMAL KUMAR SHARMA	OFFICE ADD : A-34 PADMAWATI COLONY KINGS ROAD NIRMAL NAGAR JAIPUR (RAJ.)	
		SITE ADD: AT JAIPUR	CLIENT: MR. MANOJ J		

VILLA -L-24


ELECTRICAL PLAN

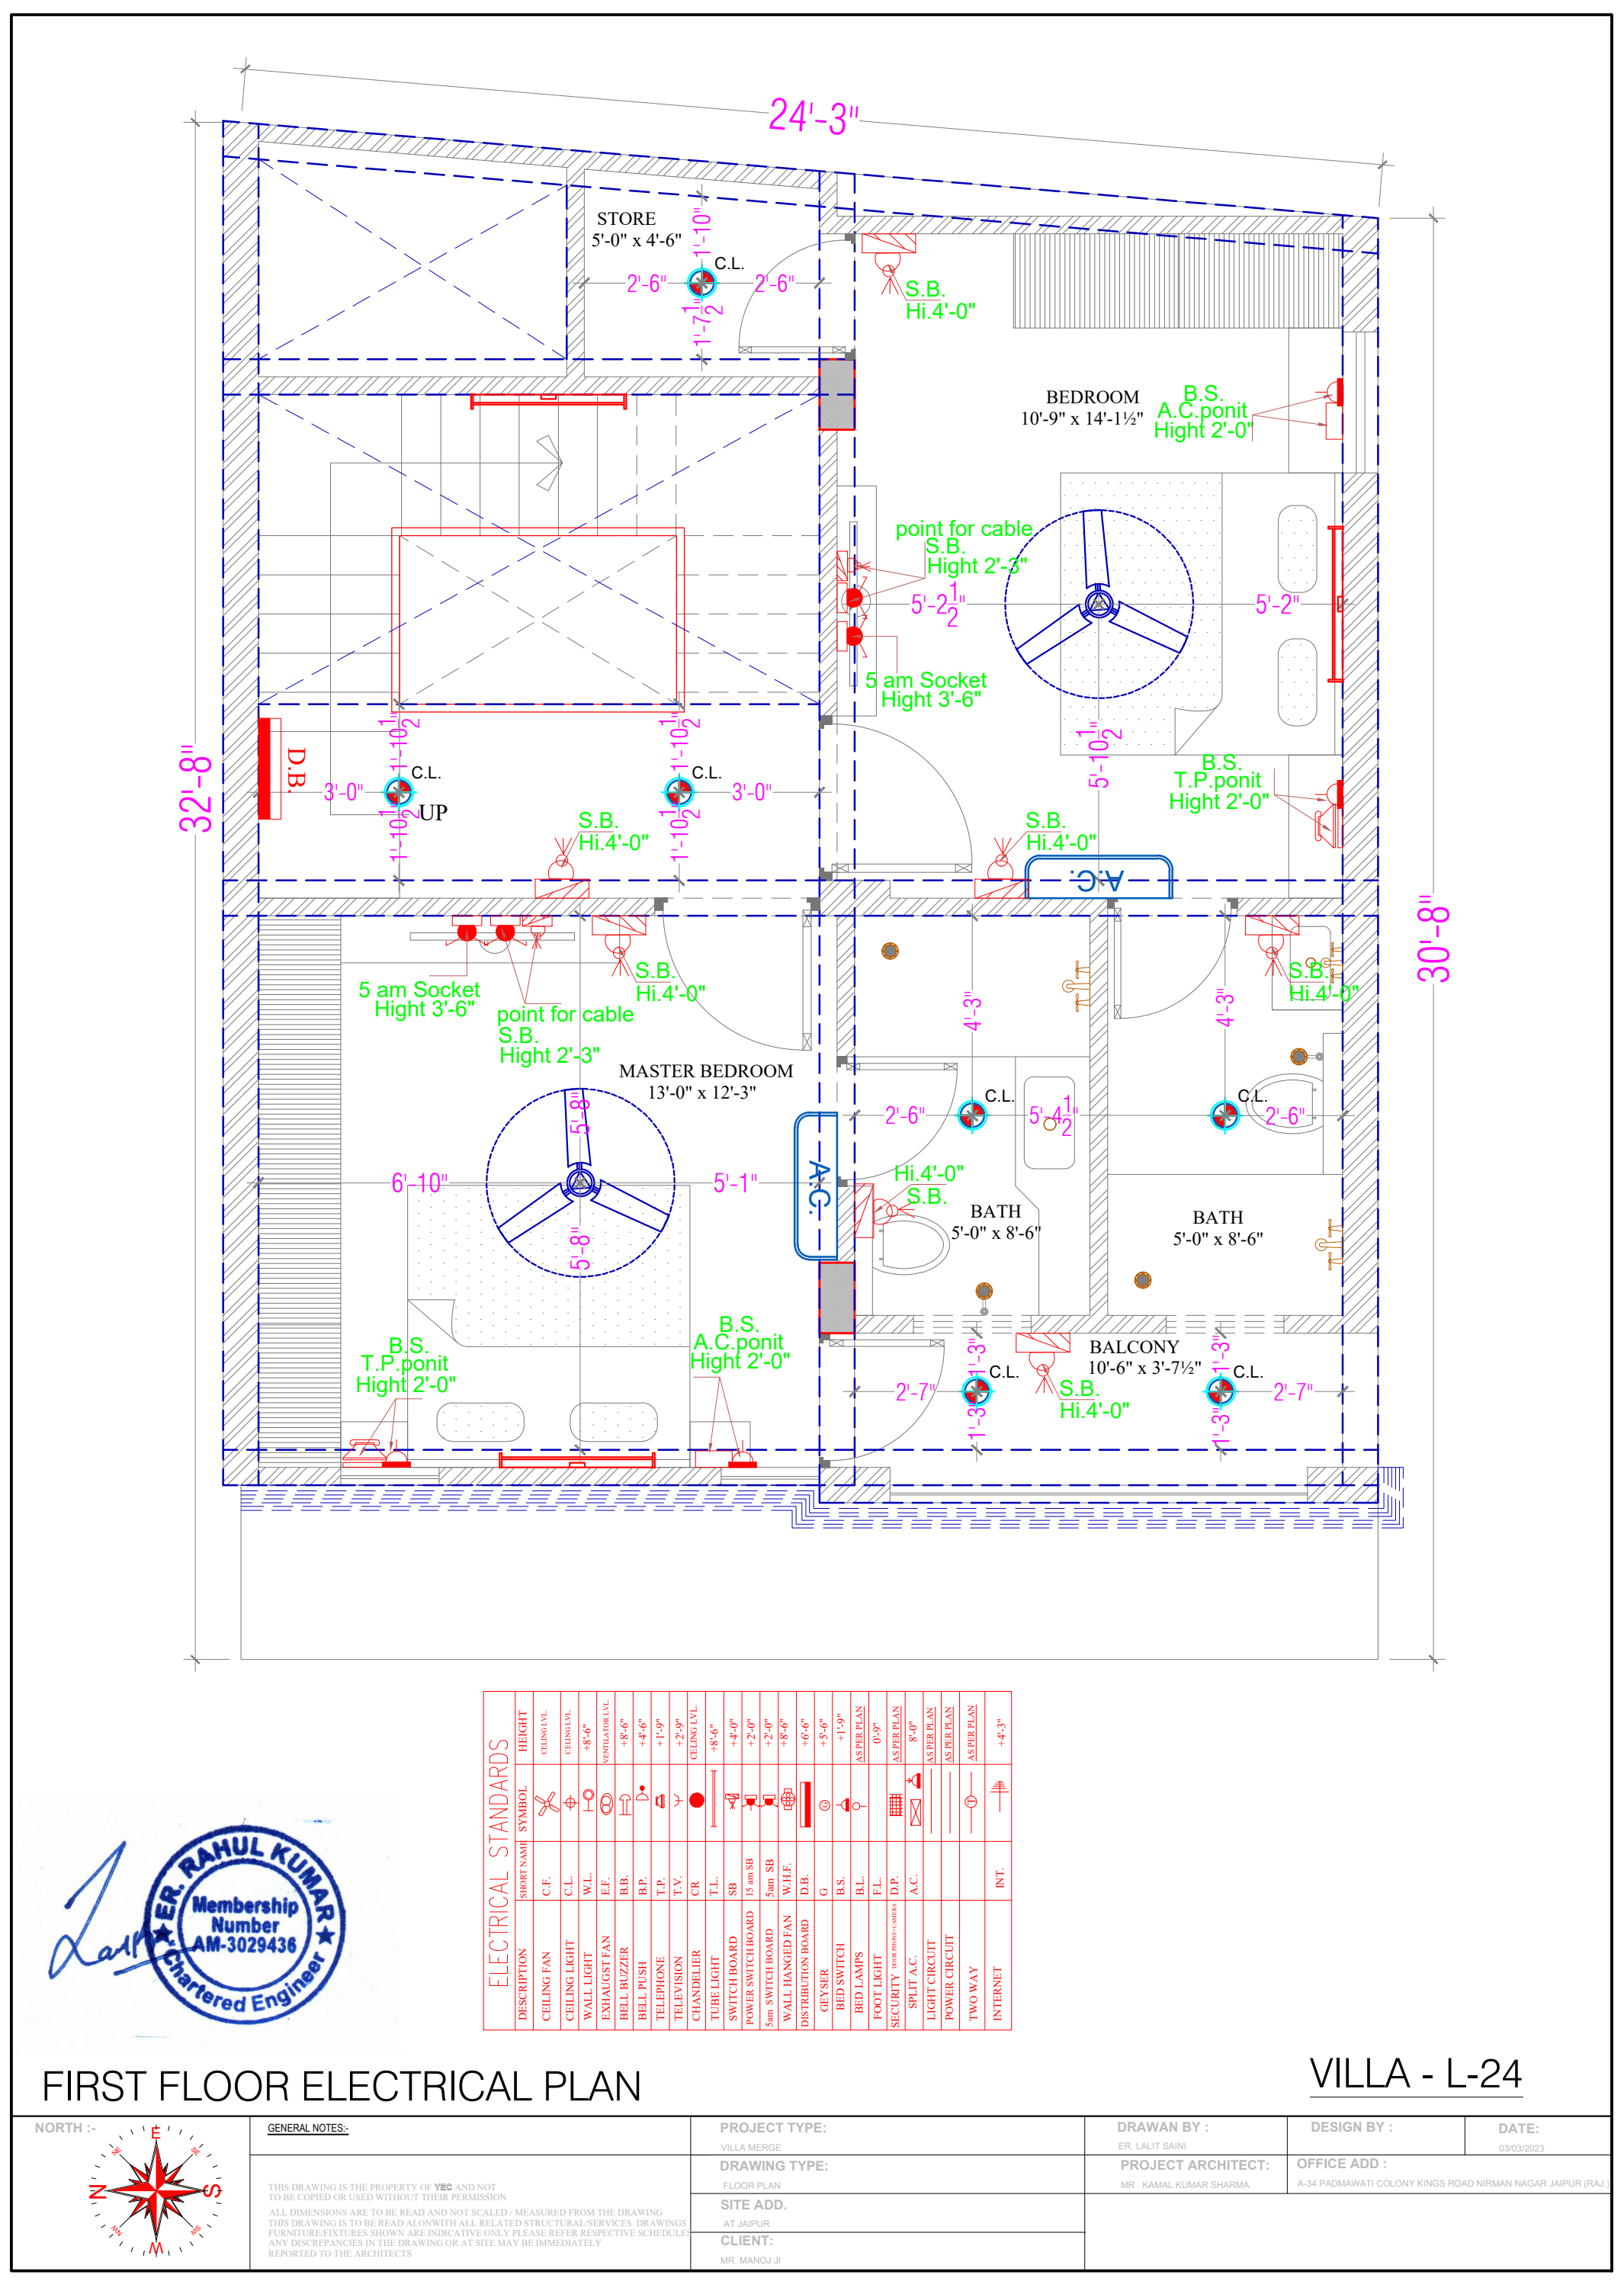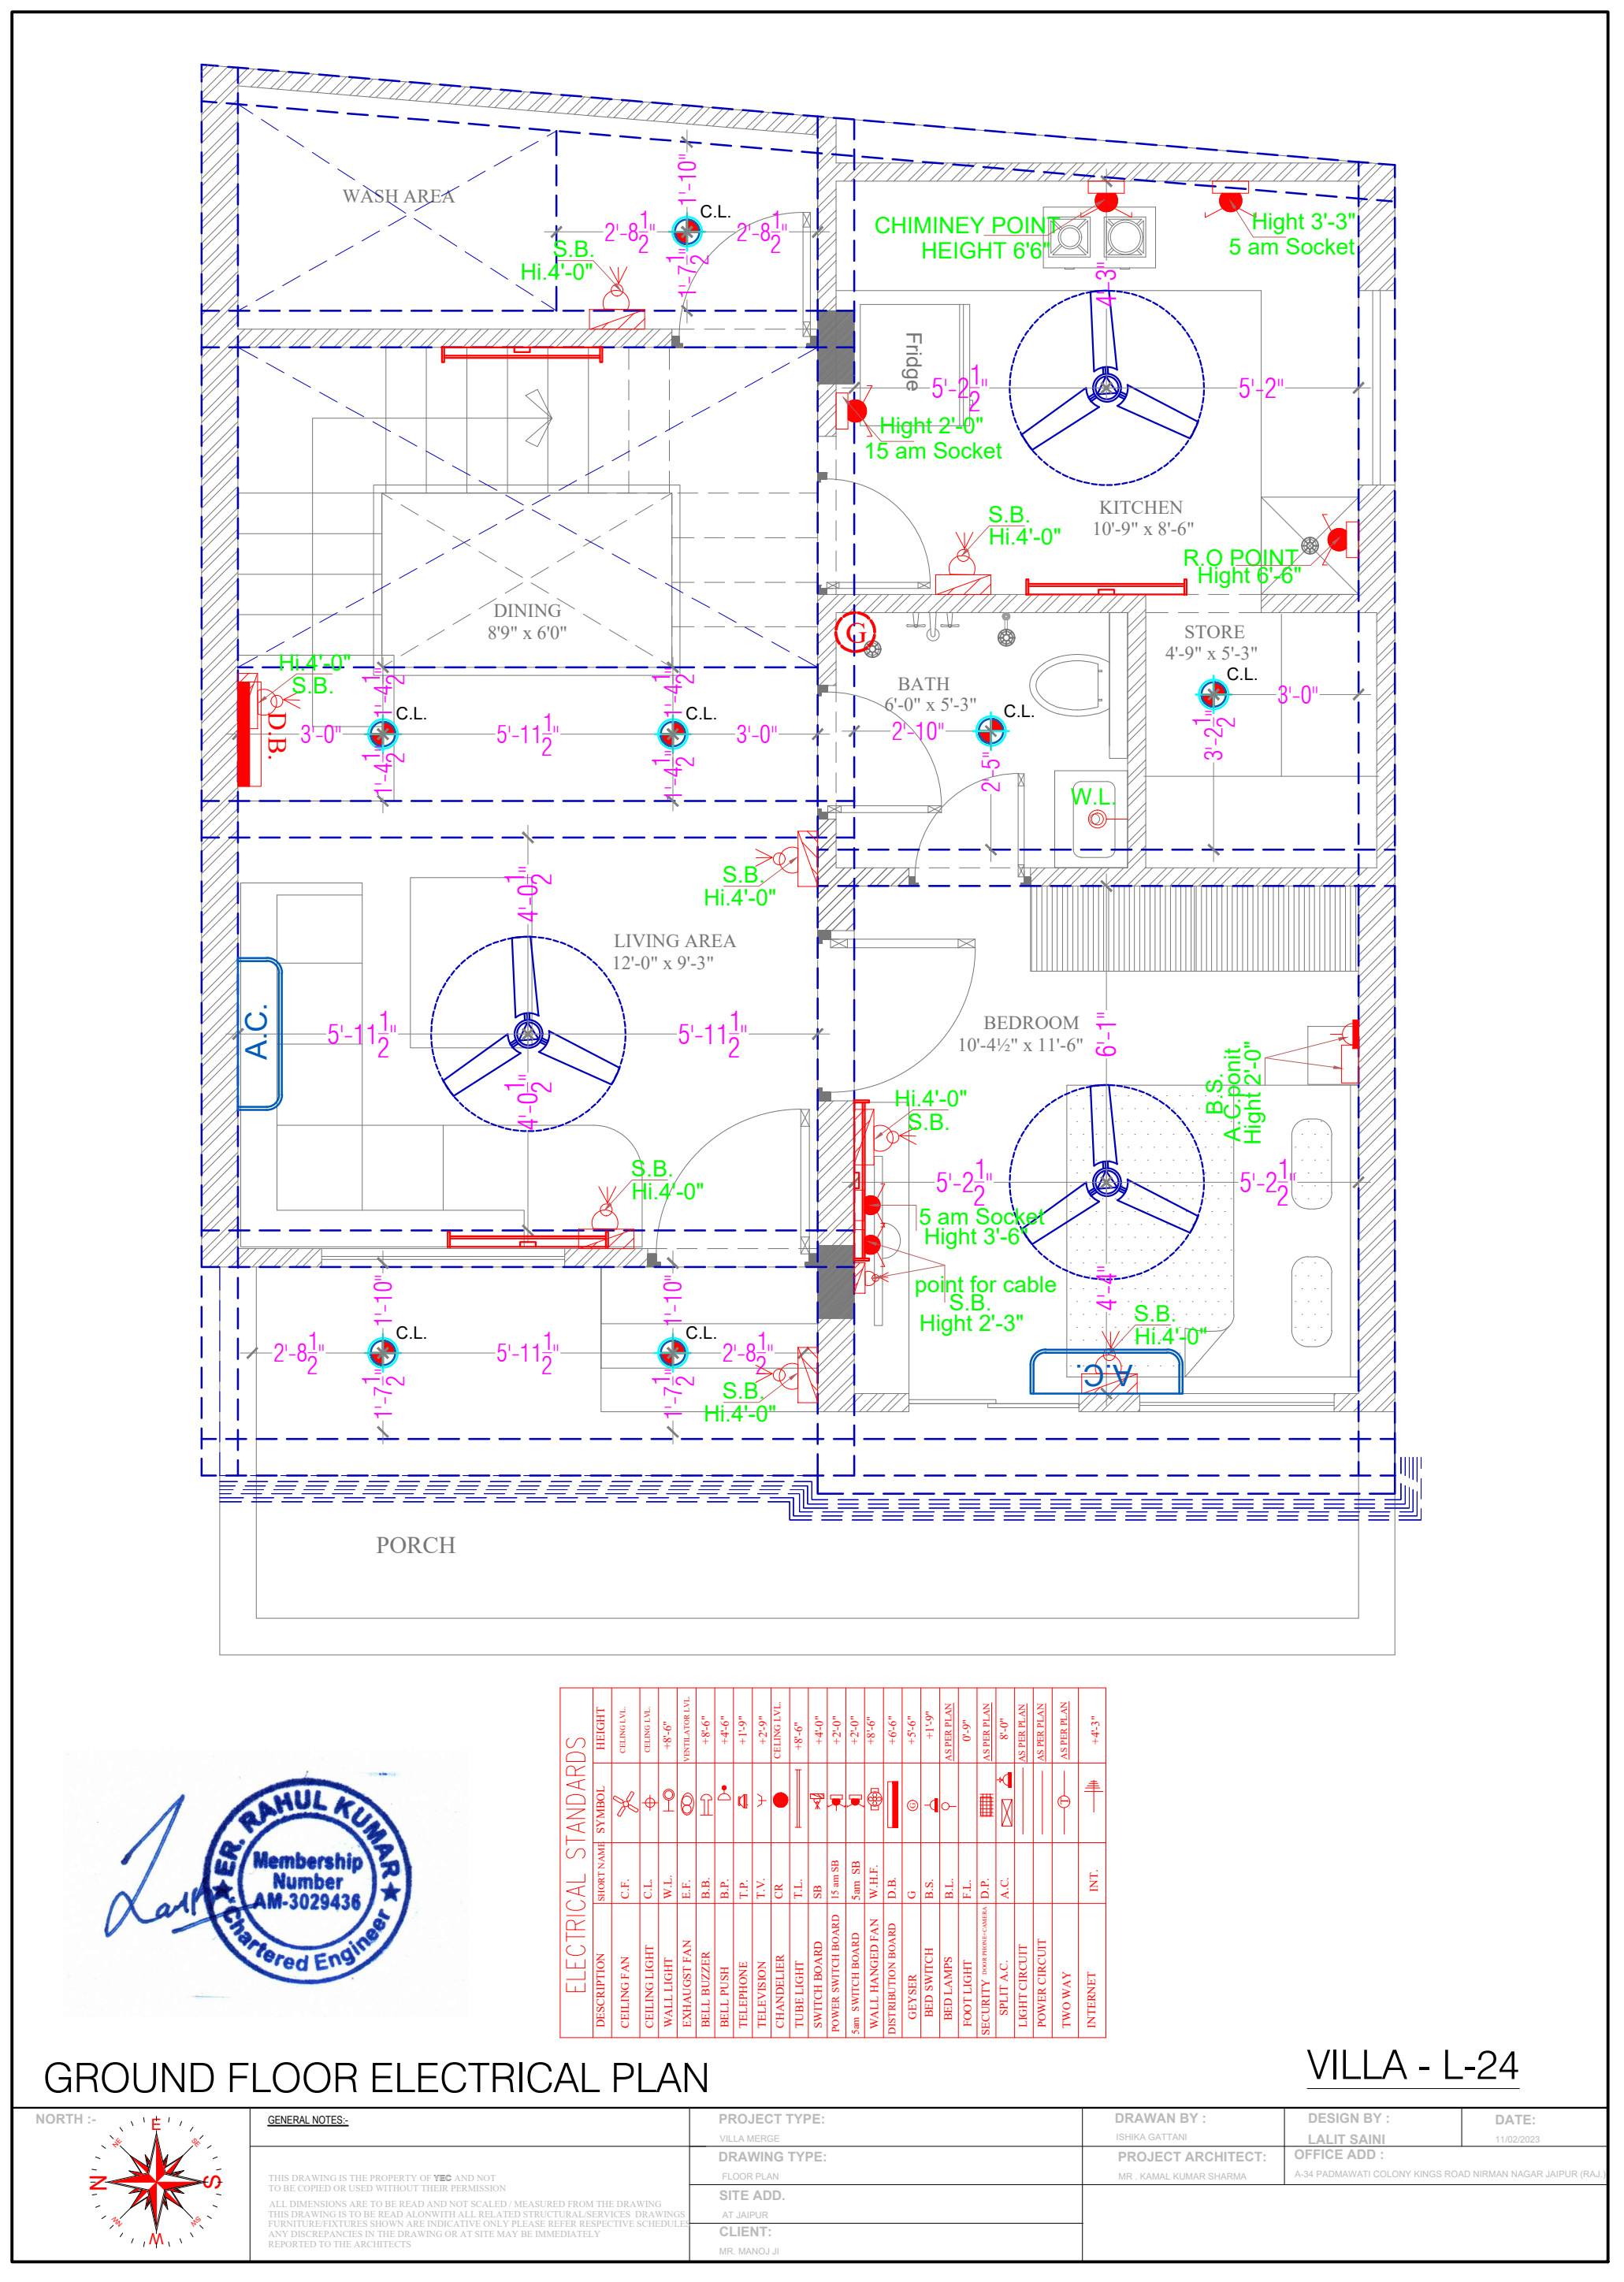

VILLA NO. L-02 & L-23
ELECTRICAL PLAN

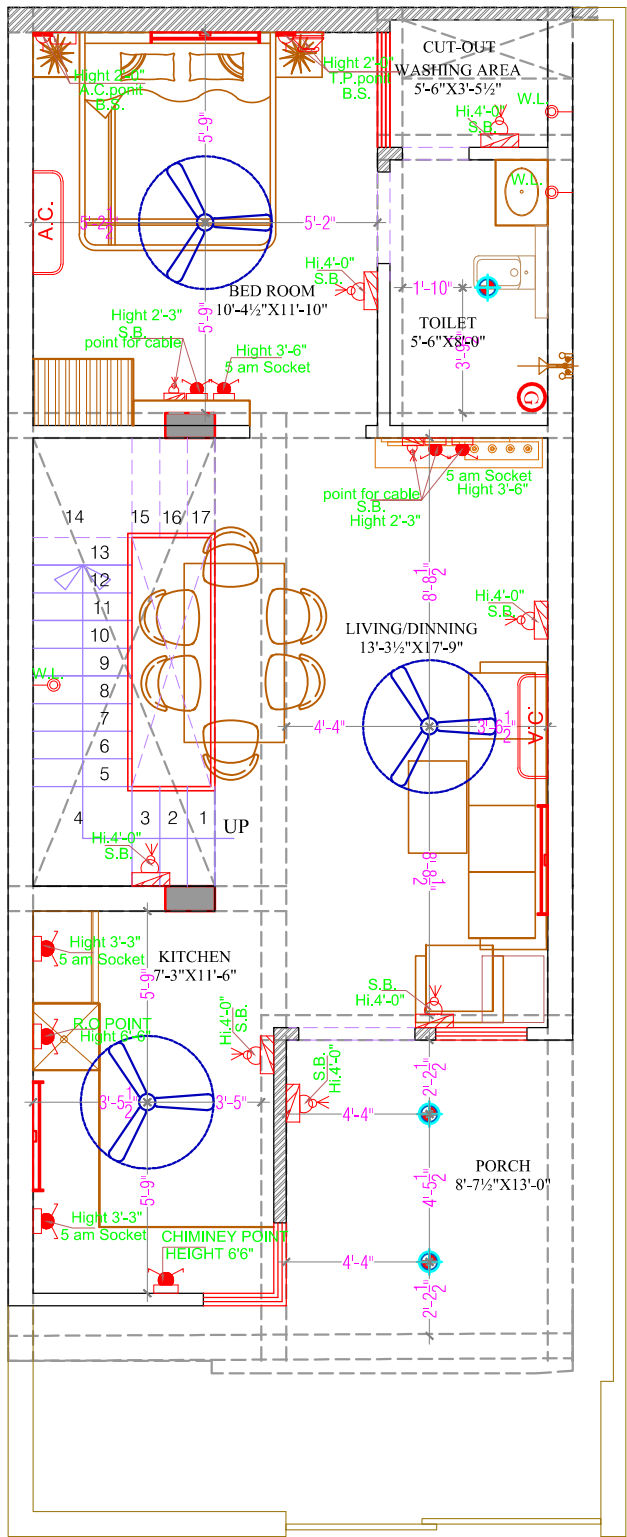

GROUND FLOOR PLAN

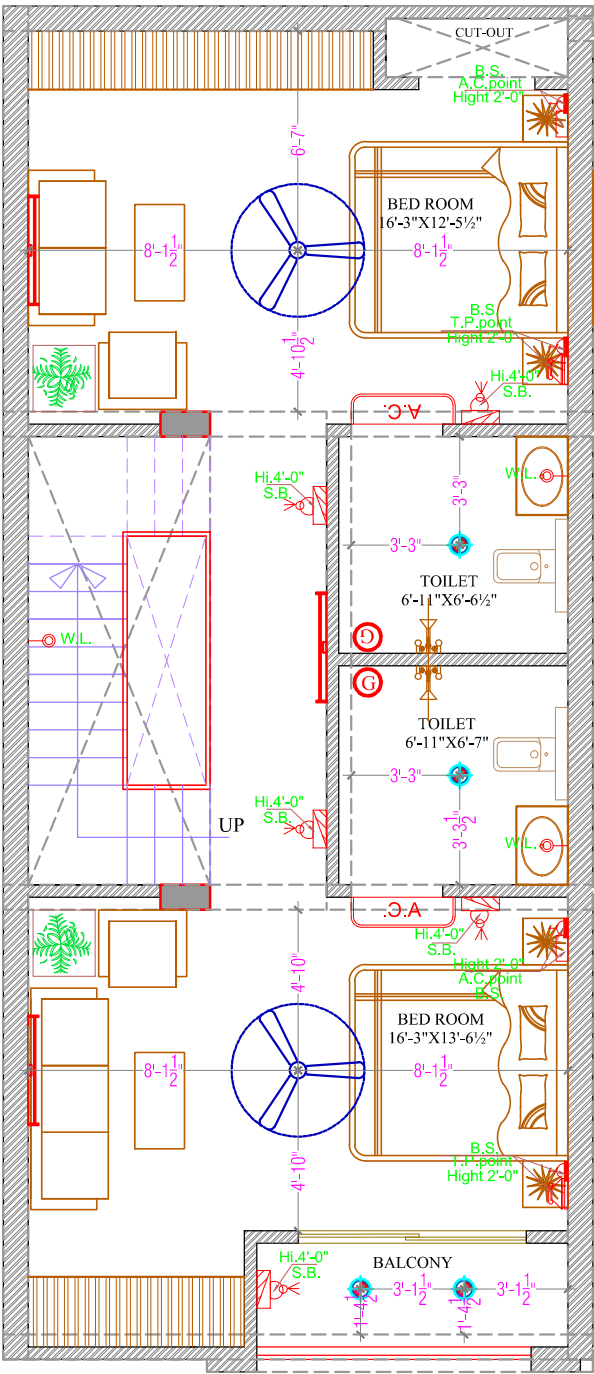

FIRST FLOOR PLAN

ELECTRICAL LAYOUT PLAN

VILLA NO. L-02 & 23

NORTH :-	GENERAL NOTES:- THIS DRAWING IS THE PROPERTY OF VCB AND NOT TO BE COPIED OR USED WITHOUT THEIR PERMISSION ALL DIMENSIONS ARE TO BE READ AND NOT SCALED / MEASURED FROM THE DRAWING THIS DRAWING IS TO BE READ ALONG WITH ALL RELATED STRUCTURAL SERVICES DRAWINGS FURNITURE/FIXTURES SHOWN ARE INDICATIVE ONLY PLEASE REFER RESPECTIVE SCHEDULES ANY DISCREPANCIES IN THE DRAWING OR AT SITE MAY BE IMMEDIATELY REPORTED TO THE ARCHITECTS	PROJECT TYPE: VILLA RESIDENCE DRAWING TYPE: FLOOR PLAN SITE ADD. AT JAIPUR CLIENT: MR. MANOJ JI	DRAWN BY : ER. RAHUL KUMAR DESIGN BY : MR. KAMAL KUMAR SHARMA	DESIGN BY : OFFICE ADD : A-34 PADMAWATI COLONY KINGS ROAD NIRMAN NAGAR JAIPUR (RAJ.)	DATE: 07/03/2022

ELECTRICAL STANDARDS			
DESCRIPTION	SYMBOL	SYMBOL	HEIGHT
CEILING FAN	C.F.		CEILING
CEILING LIGHT	C.L.		CEILING
WALL LIGHT	W.L.		8'-6"
EXTRACTOR FAN	E.F.		8'-6"
BELL BUZZER	B.B.		8'-6"
BELL RING	B.R.		8'-6"
TELEPHONE	T.P.		8'-6"
TELEVISION	T.V.		8'-6"
CHANGELIER	C.R.		8'-6"
TUBE LIGHT	T.L.		8'-6"
SWITCH BOARD	S.B.		4'-6"
POWER SWITCH BOARD	P.S.B.		4'-6"
WALL HANGING FAN	W.H.F.		8'-6"
DISTRIBUTION BOARD	D.B.		8'-6"
CHYSE	C.		8'-6"
BED SWITCH	B.S.		8'-6"
BED LAMP	B.L.		8'-6"
FOOT LIGHT	F.L.		8'-6"
SECURITY LIGHT	S.L.		8'-6"
SPLIT A.C.	A.C.		8'-6"
POWER CIRCUIT	P.C.		8'-6"
TWO WAY	T.W.		8'-6"
INTRINSIC	I.N.T.		8'-6"