


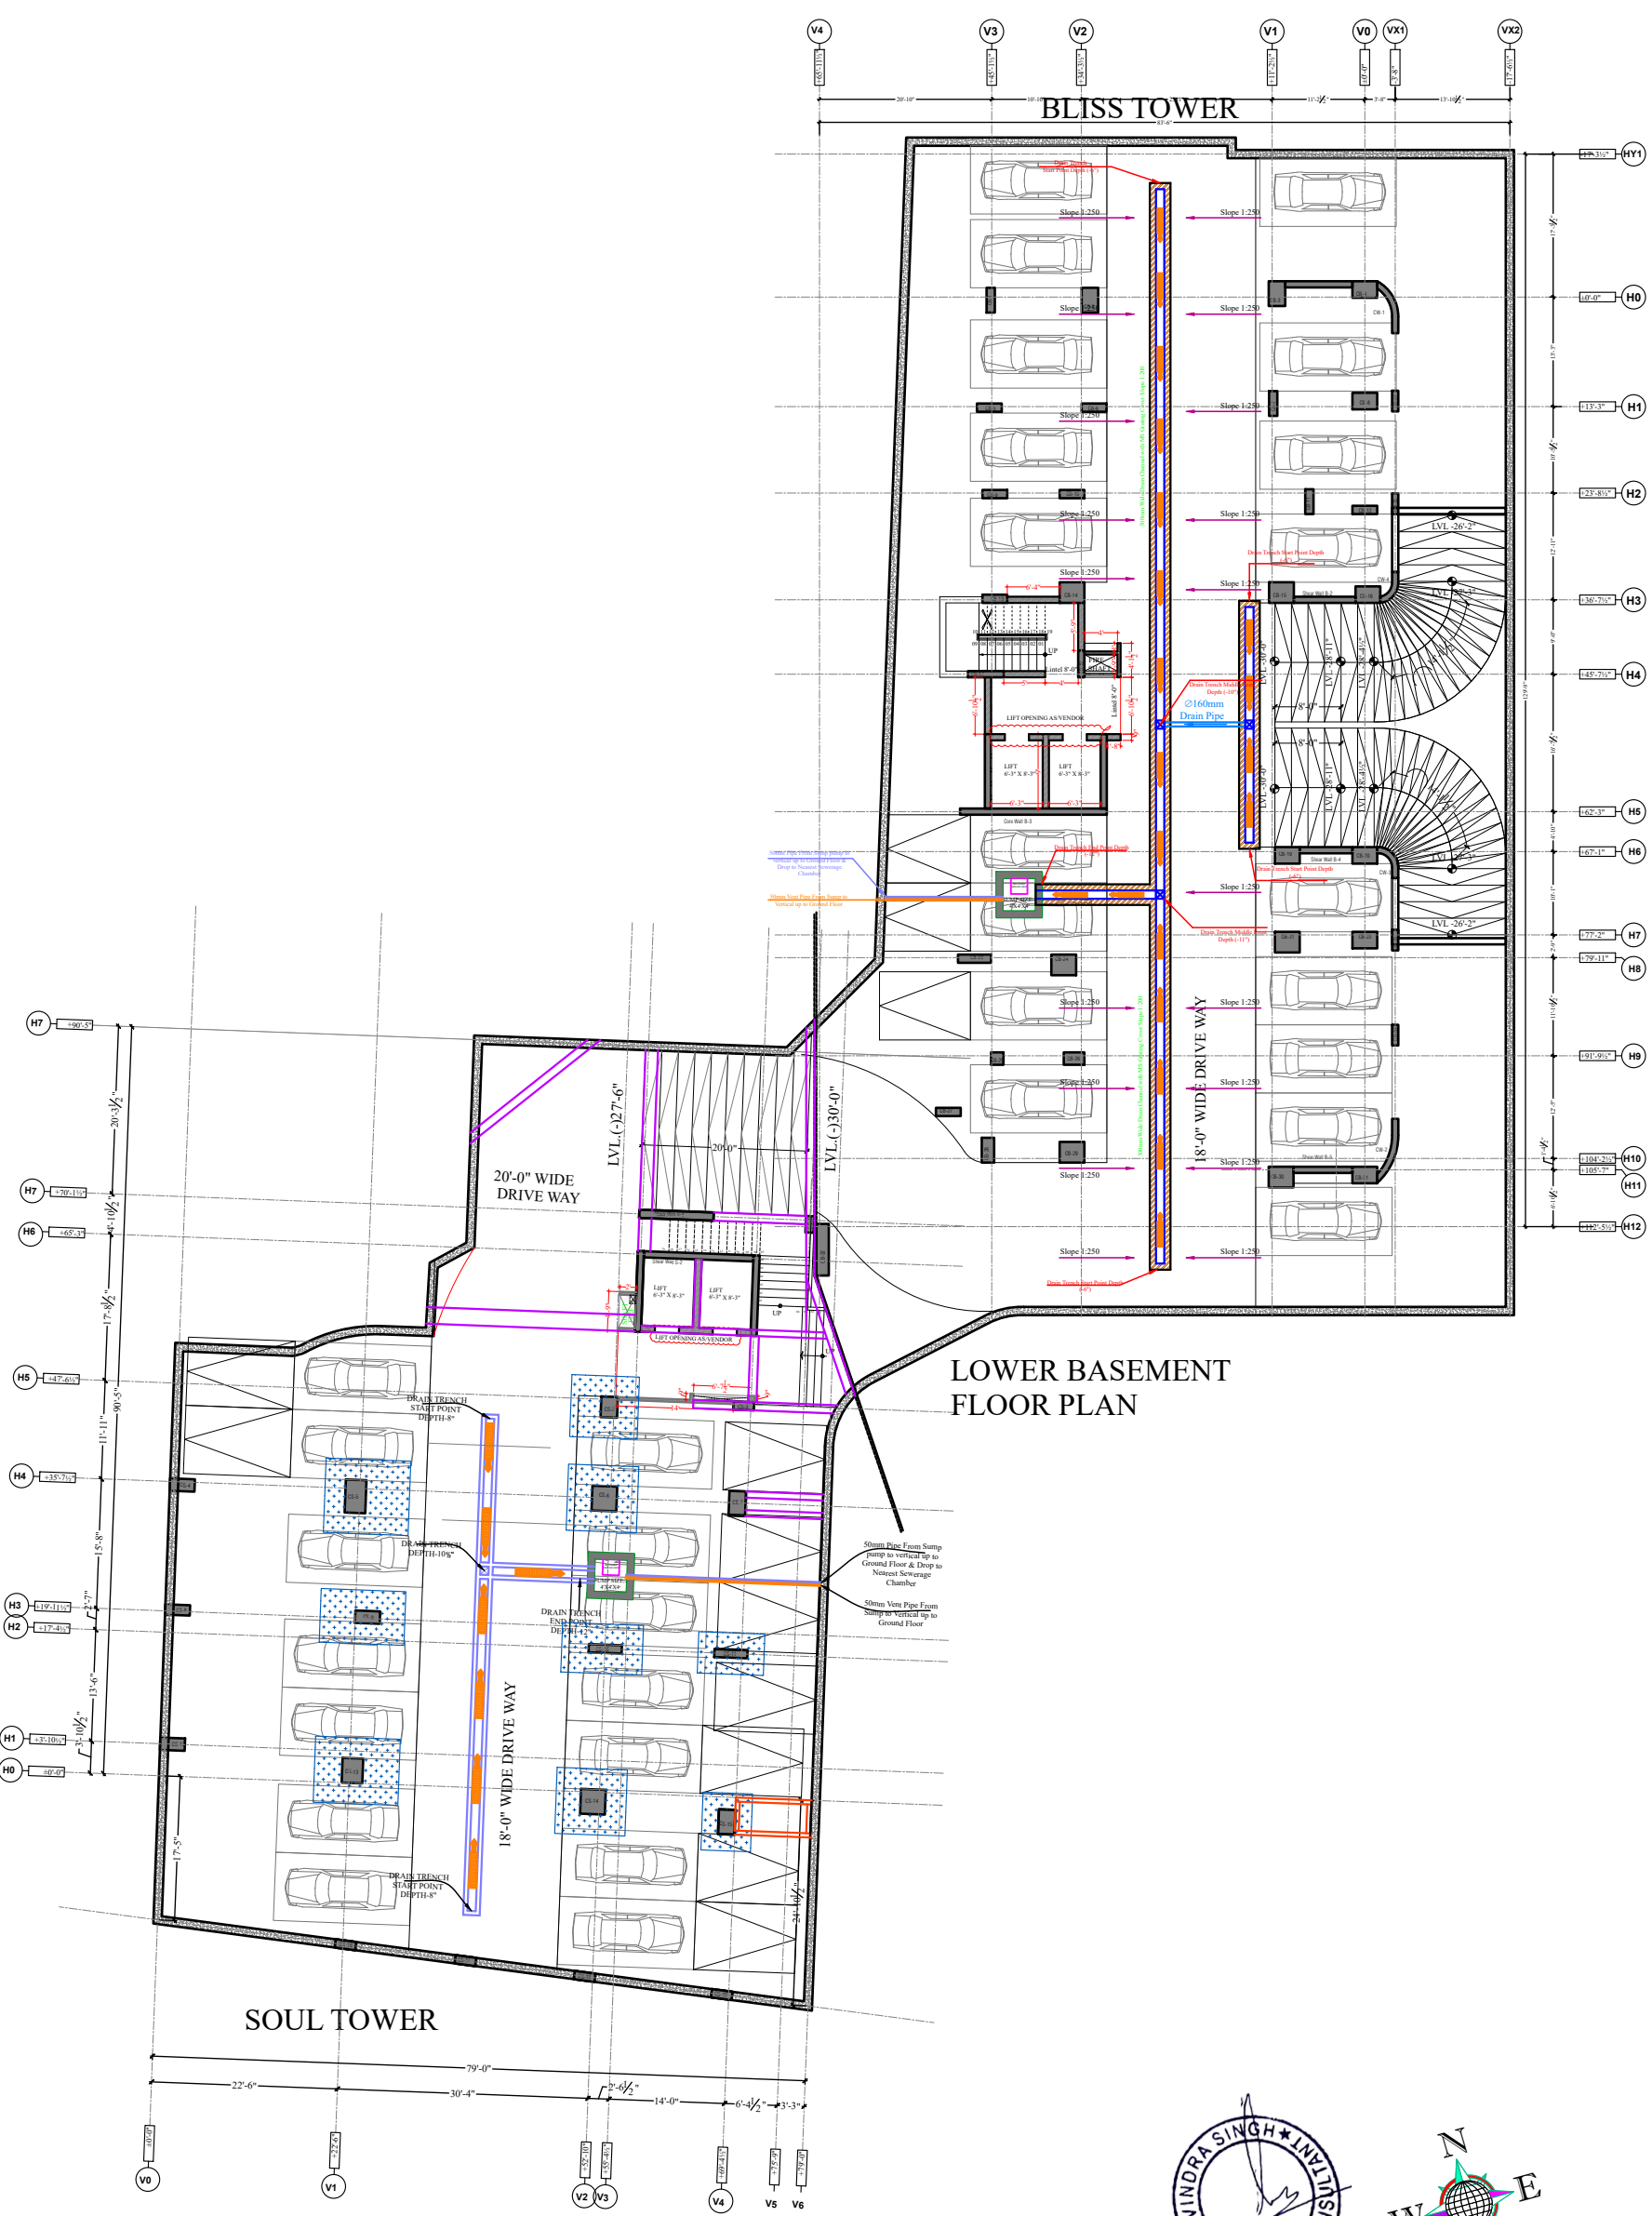

DEVELOPERS

आपका सपना हमारा प्रयास

PROJECT

PARK INFINIA
luxu residences at RAJA PARK, Jaipur

ARCHITECT

ideas
ARCHITECTURE | URBAN PLANNING | INTERIORS

124, HIMMAT NAGAR , TONK ROAD, JAIPUR
PHONE : 0141-2706227,2712377
email: ideasjaipur@gmail.com, web: www.ideasjaipur.com


NOTES :-

1) THIS DRAWING IS PROPERTY OF IDEAS, JAIPUR
2) UNAUTHORIZED USE OF THIS DRAWING WITHOUT PERMISSION IS STRICTLY PROHIBITED
3) ALL DIMENSIONS ARE IN MM, UNLESS NOTED OTHERWISE
4) ANY DISCREPANCY ARISING SHOULD BE INFORMED TO THE ARCHITECT IMMEDIATELY

NOs.	DATE	PRINT ISSUED TO
3	Dec. 6, 21	TO SITE

REVISIONS:-		
S.No.	DATE	REMARKS
R0	Dec. 6, 21	GFC

KEY PLAN :-	
PROJECT:-	PLOT NO.16, GOVIND MARG ADARSH NAGAR, RAJA PARK JAIPUR
CLIENT:-	MANGLAM
DRAWING TITLE	LOWER BASEMENT TRENCH & SUMP PLAN
DATE:- 6 December 2021	DRG.NO.
CHECKED BY:- GIRISH KHANDLWAL	SH-03
DEALT BY:- DEEPAK	
DRAWN BY:- AMIT	

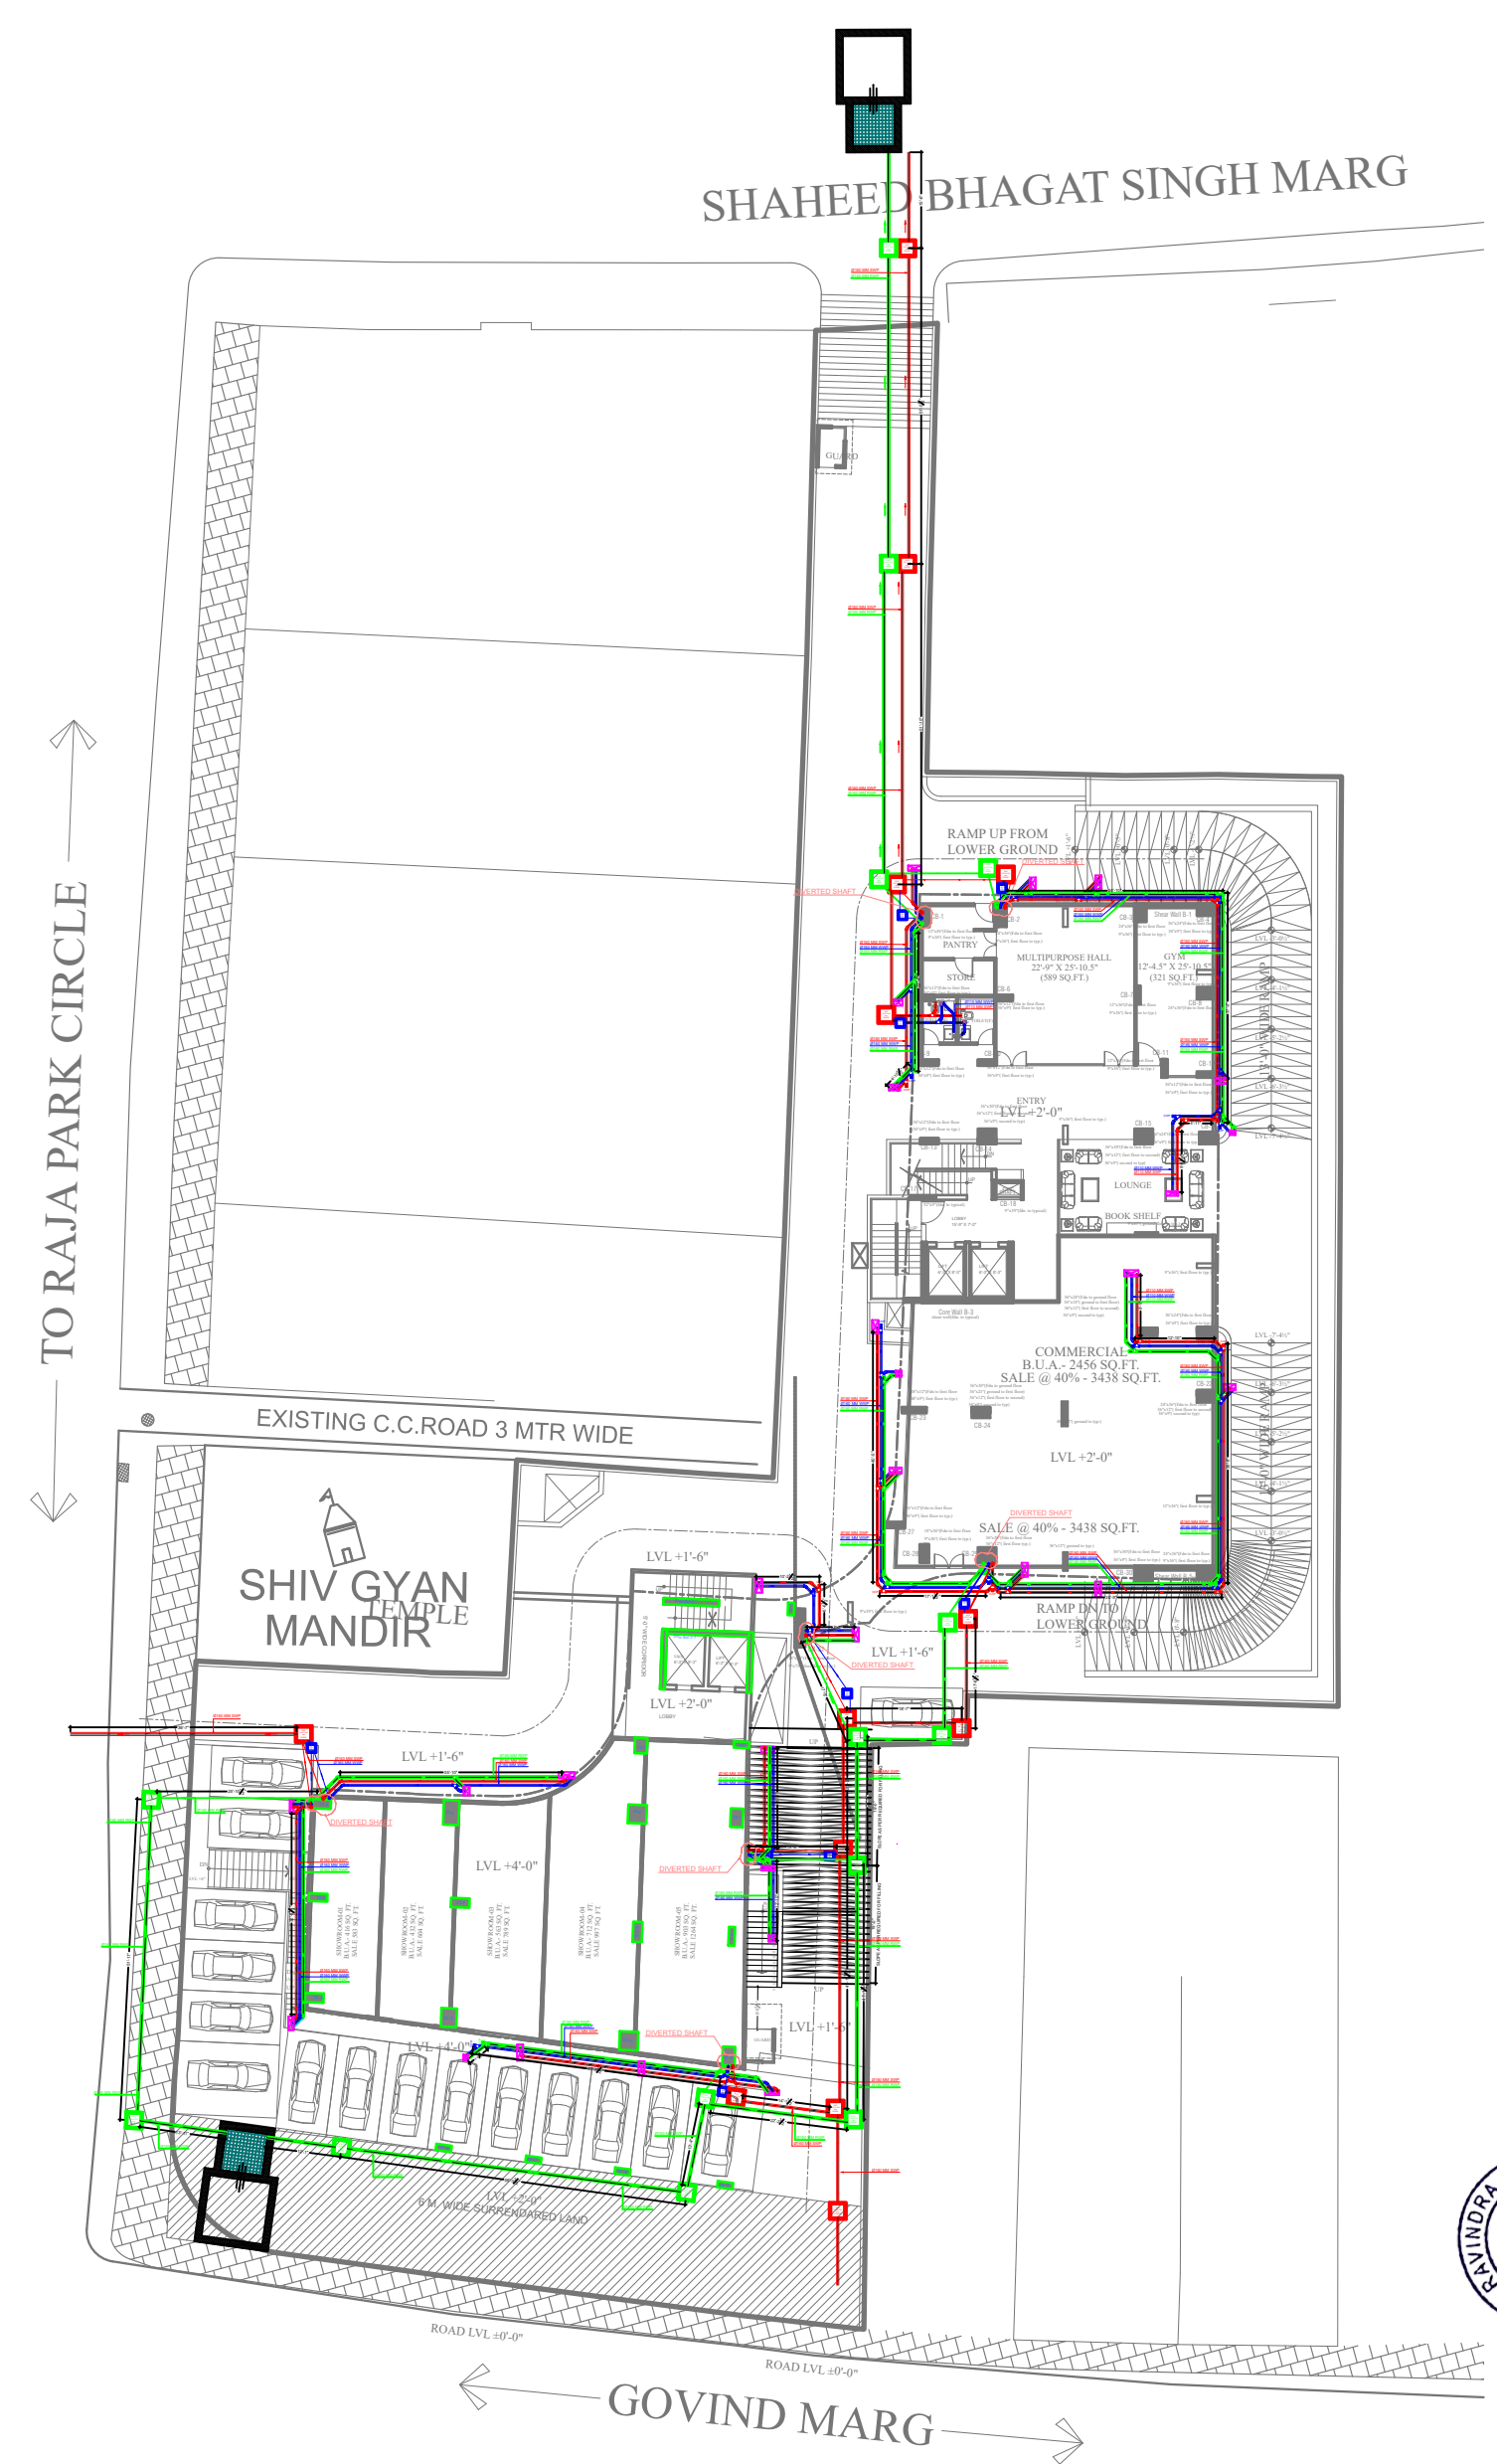

GROUND FLOOR PLAN

ARCHITECT



124, HIMMAT NAGAR , TONK ROAD, JAIPUR
PHONE - 0141-2706227,2712377
email: ideasjaipur@gmail.com, web: www.ideasjaipur.com

MEP CONSULTANT :



53 & 54, 2nd Floor Jaipur Electronic Market,
Ridhi Sidhi Circle, Gopal pura by Pass Road ,
Jaipur (Raj)
Ph:- 8696311408, 9971998408
Email:- ravisingira72@gmail.com ;
ravi@jrsquareengineers.com

LEGENDS:-			
MOUNTING HT	QTY	SYMBOL	DESCREPTION
BELOW GROUND			110 MM & 160 MM SOIL WATER SUPPLY
BELOW GROUND			110 MM & 160 MM RAIN WATER SUPPLY
BELOW GROUND			110 MM & 160 MM WASTE WATER SUPPLY
BELOW GROUND	4		G.T 350 MM X 350 MM
BELOW GROUND	5		R . W . C 650 MM X 650 MM
BELOW GROUND	4		M . H. 650 MM X 650 MM
			SOIL WATER PIPE
			RAIN WATER PIPE
			WASTE WATER PIPE

ABBREVIATION DETAIL

SWP	SOIL WATER PIPE
RWP	RAIN WATER PIPE
WWP	WASTE WATER PIPE
MH	MAN HOLE
GT	GULLY TRAP
RWC	RAIN WATER CHAMBER


PMC CONSULTANT :

NOTES :-
1) THIS DRAWING IS PROPERTY OF IDEAS, JAIPUR
2) UNAUTHORIZED USE OF THIS DRAWING WITHOUT PERMISSION IS STRICTLY PROHIBITED.
3) ALL DIMENSIONS ARE IN FEET AND INCHES, UNLESS NOTED OTHERWISE.
4) ANY DISCREPANCY ARISING SHOULD BE INFORMED TO THE ARCHITECT IMMEDIATELY.

NOS.	DATE	PRINT ISSUED TO

REVISIONS:-		
S.No.	DATE	REMARKS

KEY PLAN :- NORTH :-

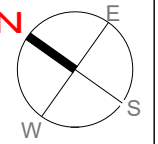

PROJECT:- PLOT NO.16. GOVIND MARG ADARSH NAGAR, RAJA PARK JAIPUR

CLIENT:- MANGALAM


DRAWING TITLE GROUND FLOOR PLUMBING PLAN

DATE:- 22-11-22

CHECKED BY:- RAVI

DEALT BY:- AVI DRG.NO.

DRAWN BY:- AARIF

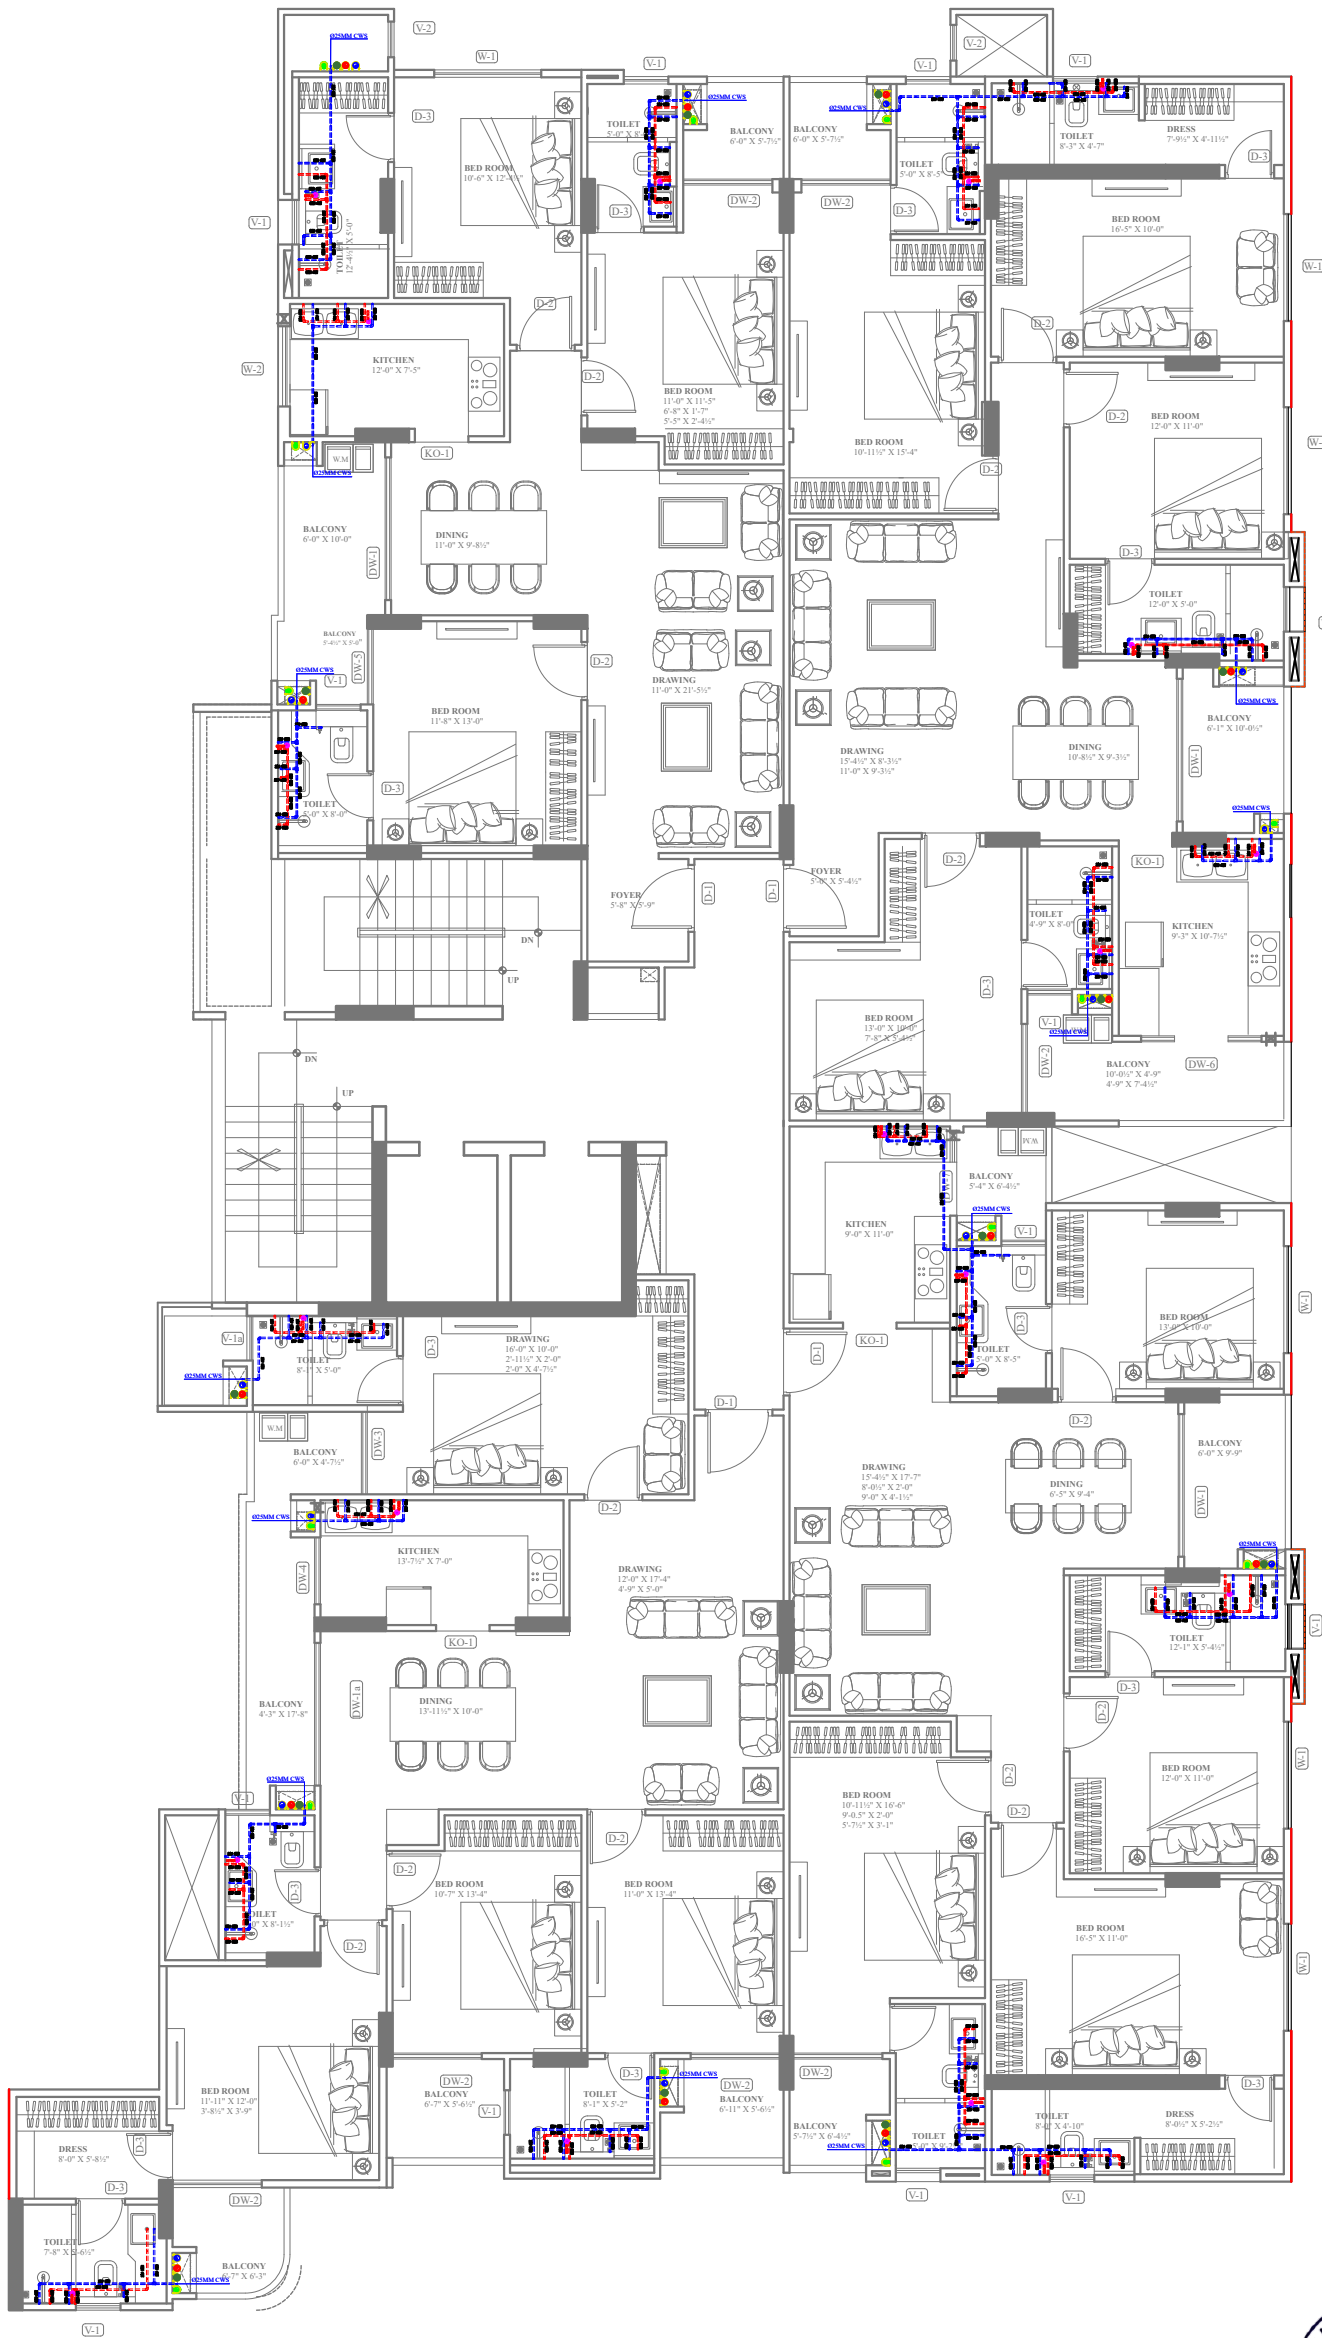

DEVELOPER

..\\..\\LOGO\\Manglam-Png.png

ARCHITECT



124, HIMMAT NAGAR, TONK ROAD, JAIPUR
PHONE - 0141-2706227, 2712377
email: ideasjaipur@gmail.com, web: www.ideasjaipur.com

STRUCTURE CONSULTANT :
CONSULTANTS



Vijaytech Consultants Pvt. Ltd.

LEGEND CONSULTING ENGINEERS
H-17, GAUTAM MARG, SHYAM NAGAR, JAIPUR-19 INDIA
Phone : 91-141 2294432, 3257592, Fax : 91-141-4023198
E-mail : vijaytech.jpr@gmail.com

LEGENDS:

Mounting Ht.	Qty.	Symbol	Description
BELOW CEILING/ GROUND			25 MM CWS (COLD WATER SUPPLY)
BELOW CEILING/ GROUND			20MM HWS (HOT WATER SUPPLY)
VERTICAL SHAFT			25MM COOL WATER DOWNSTACK
ON WALL			GEYSER

MEP CONSULTANT :



JR Square

Engineers & Consultancy Pvt. Ltd.

53 & 54, 2nd Floor Jaipur Electronic Market,
Ridhi Sidhi Circle, Gopal pura by Pass Road ,
Jaipur (Raj)
Ph:- 8696311408, 9971998408
Email:- ravisongira72@gmail.com ;
ravi@jrsquareengineers.com

NOTES :-


- 1) THIS DRAWING IS PROPERTY OF IDEAS. JAIPUR
- 2) UNAUTHORIZED USE OF THIS DRAWING WITHOUT PERMISSION IS STRICTLY PROHIBITED.
- 3) ALL DIMENSIONS ARE IN FEET AND INCHES, UNLESS NOTED OTHERWISE
- 4) ANY DISCREPANCY ARISING SHOULD BE INFORMED TO THE ARCHITECT IMMEDIATELY.

NOs.	DATE	PRINT ISSUED TO


REVISIONS:-

S.No.	DATE	REMARKS

KEY PLAN :- NORTH :-

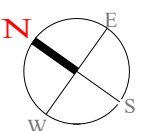

PROJECT:-	PLOT NO.16. GOVIND MARG ADARSH NAGAR, RAJA PARK JAIPUR
CLIENT:-	MANGALAM
DRAWING TITLE	BUSS TOWER TYPICAL FLOOR PLUMBING PLAN
DATE:-	22-11-22
CHECKED BY:-	RAVI
DEALT BY:-	AVI
DRAWN BY:-	AARIF
DRG.NO.	JRS/TYP-FLOOR/WS/R-4

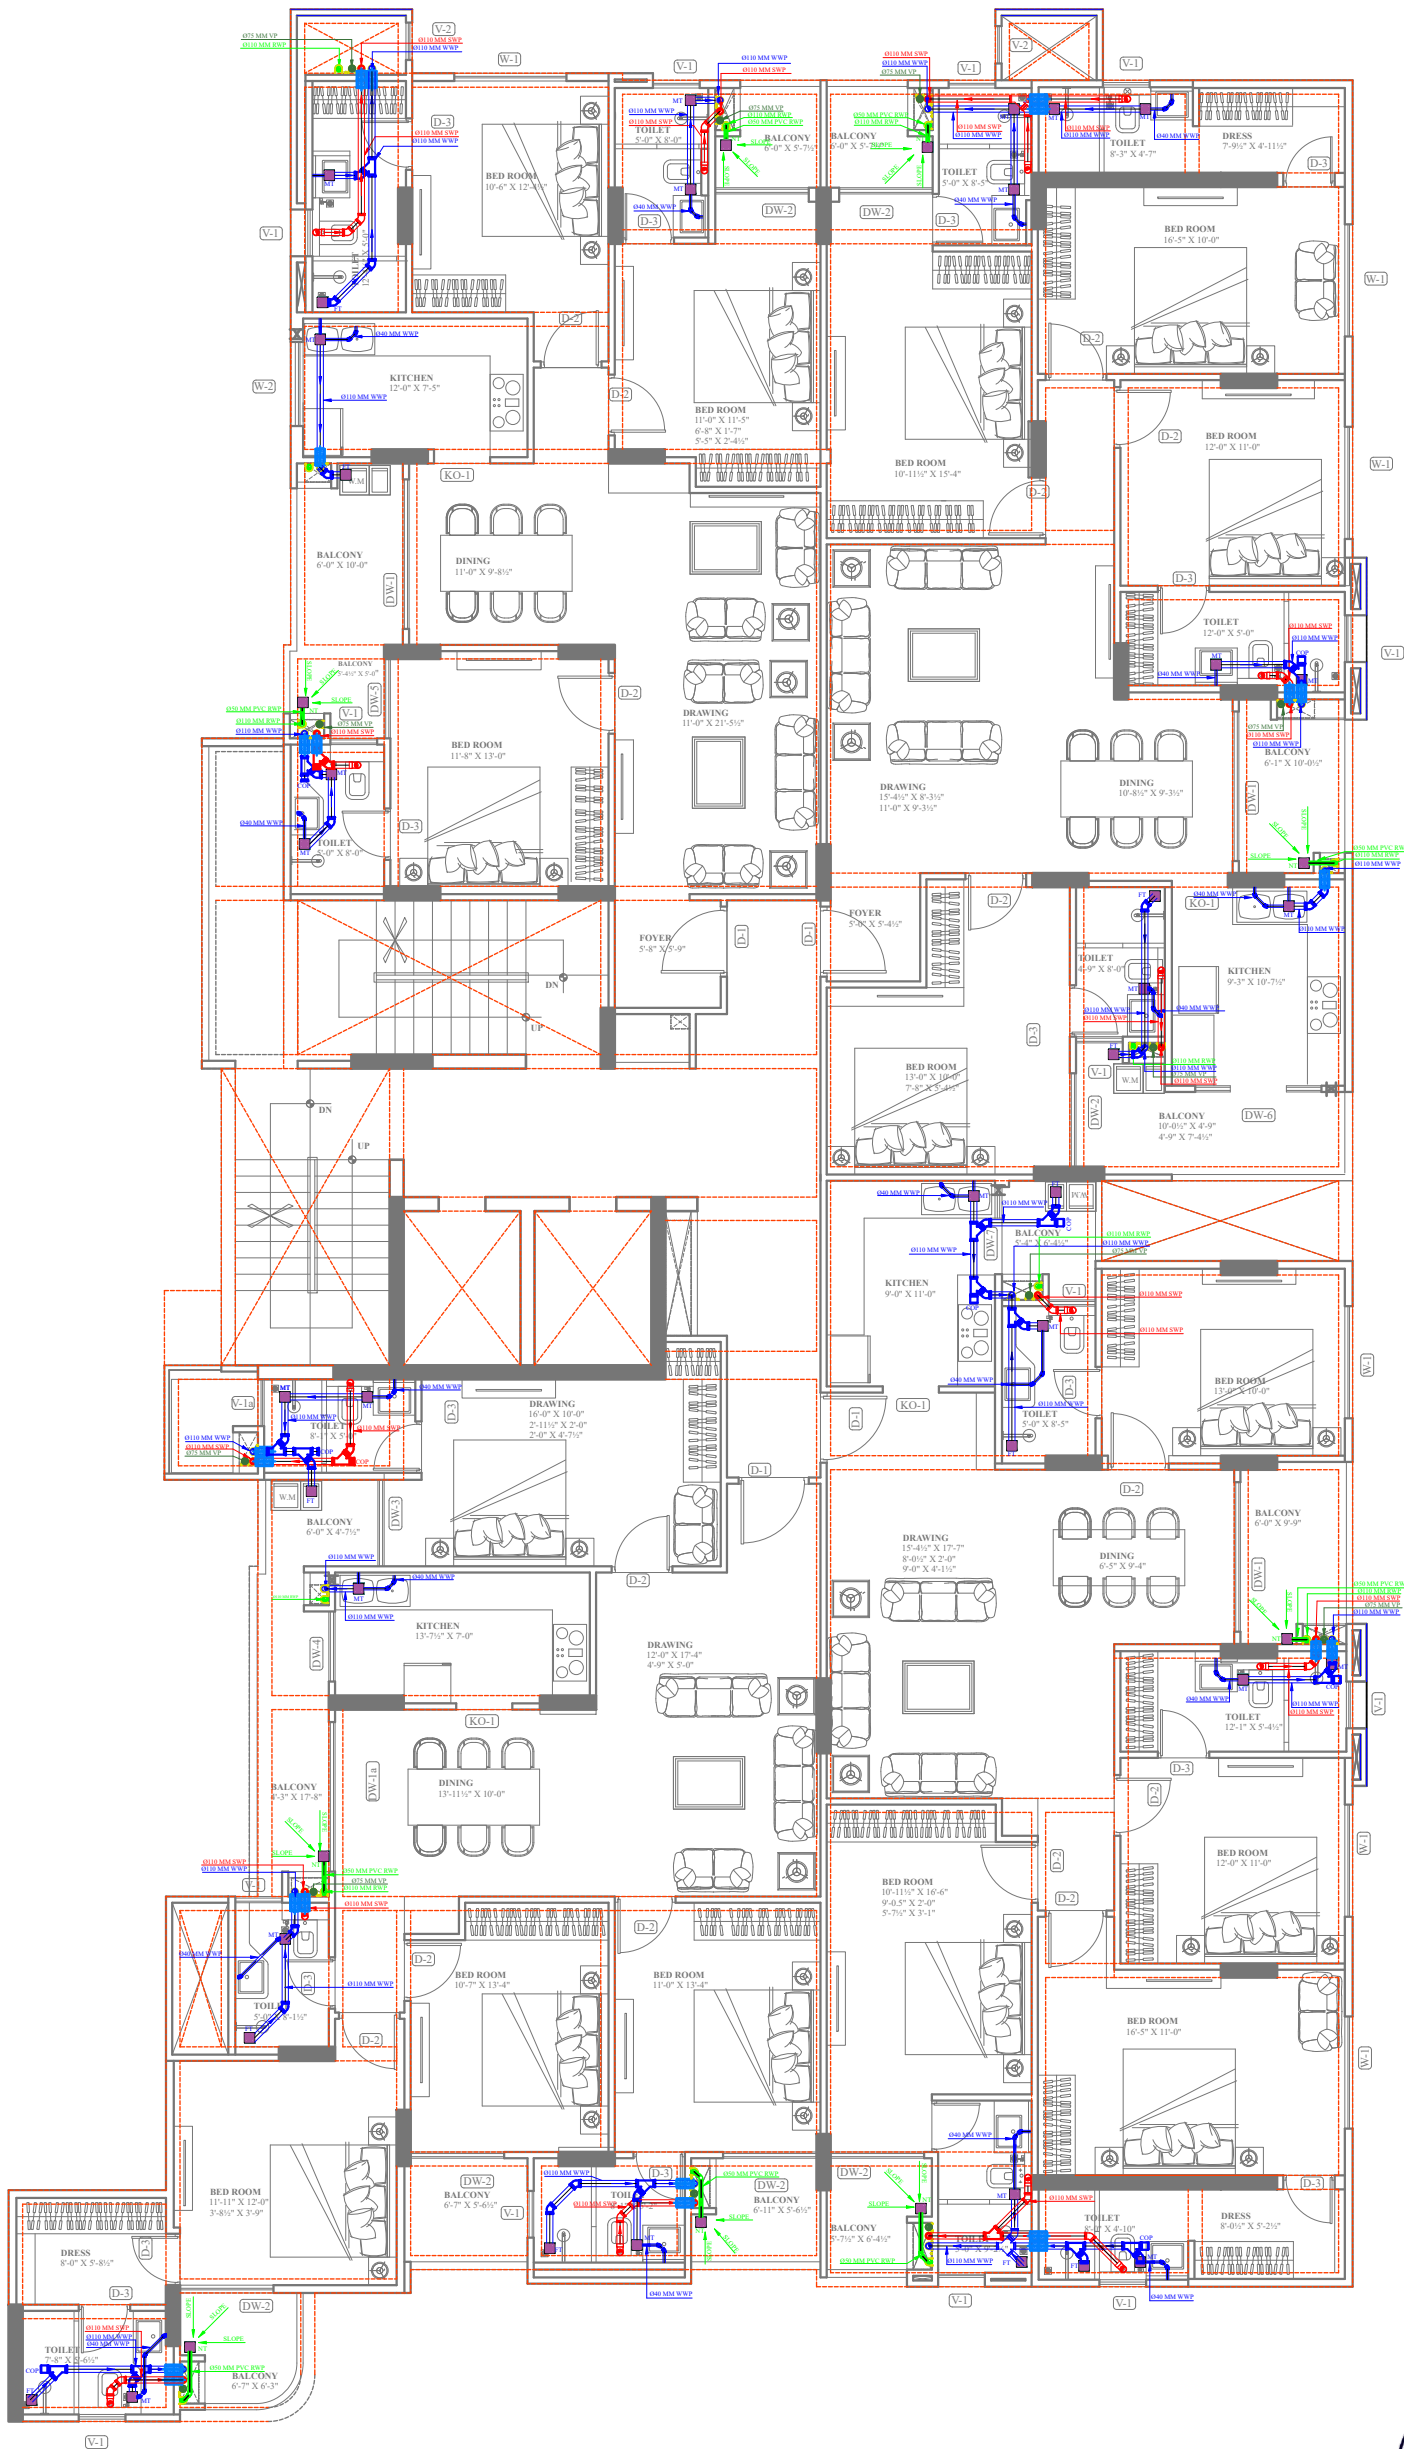

DEVELOPER

...\\.\LOGO\Manglam-Png.png

ARCHITECT



124, HIMMAT NAGAR , TONK ROAD, JAIPUR
PHONE - 0141-2706227,2712377
email: ideasjaipur@gmail.com, web: www.ideasjaipur.com

STRUCTURE CONSULTANT :
CONSULTANTS



Vijaytech Consultants Pvt. Ltd.

CONSULTING ENGINEERS

H-17, GAUTAM MARG, SHYAM NAGAR, JAIPUR-19 INDIA
Phone : 91-141 2294432, 3257592 , Fax : 91-141-4023198
E-mail : vijaytech.jr@gmail.com

LEGENDS:

Mounting Ht.	Qty.	Symbol	Description
BELOW GROUND VERTICAL SHAFT			110MM-60MM INTERNAL / EXTERNAL SEWAGE LINE
BELOW GROUND VERTICAL SHAFT			110MM-60MM INTERNAL / EXTERNAL WASTE WATER LINE
HANGING / BELOW GROUND			110MM 'Y' WITH 45 DEG BEND FOR WASTE WATER LINE
HANGING / BELOW GROUND			110MM 45 DEG BEND FOR SOIL LINE
HANGING / BELOW GROUND			75MMX 50MM X 50MM MULTITRAP
HANGING / BELOW GROUND			PT FLOOR TRAP AS PER INTERIOR
HANGING / BELOW GROUND			NT FLOOR TRAP AS PER INTERIOR
HANGING / BELOW GROUND			110MM 'Y' FOR SOIL LINE
HANGING / BELOW GROUND			110MM 45 DEG BEND FOR WASTE
VERTICAL SHAFT			110MM WASTE WATER DOWNSTACK
VERTICAL SHAFT			110MM RAIN WATER DOWNSTACK
VERTICAL SHAFT			110MM SOIL DOWNSTACK
VERTICAL SHAFT			75MM VENT PIPE DOWNSTACK

MEP CONSULTANT :



53 & 54, 2nd Floor Jaipur Electronic Market,
Ridhi Sidhi Circle, Gopal pura by Pass Road ,
Jaipur (Raj)
Ph:- 8696311408, 9971998408
Email:- ravisongira72@gmail.com ;
ravi@jrsquareengineers.com

NOTES :-


- 1) THIS DRAWING IS PROPERTY OF IDEAS, JAIPUR.
- 2) UNAUTHORIZED USE OF THIS DRAWING WITHOUT PERMISSION IS STRICTLY PROHIBITED.
- 3) ALL DIMENSIONS ARE IN FEET AND INCHES, UNLESS NOTED OTHERWISE
- 4) ANY DISCREPANCY ARISING SHOULD BE INFORMED TO THE ARCHITECT IMMEDIATELY.

NOs.	DATE	PRINT ISSUED TO


REVISIONS:-

S.No.	DATE	REMARKS


KEY PLAN :- NORTH :-

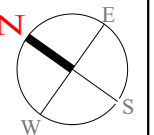

PROJECT:-	PLOT NO.16. GOVIND MARG ADARSH NAGAR,RAJA PARK JAIPUR
CLIENT:-	MANGALAM
DRAWING TITLE	BLISS TOWER TYPICAL FLOOR FLAT DRAINAGE PLAN
DATE:-	22-11-22
CHECKED BY:-	RAVI
DEALT BY:-	AVI
DRAWN BY:-	AARIF
	DRG.NO. JRS/TYP/DR-R-04

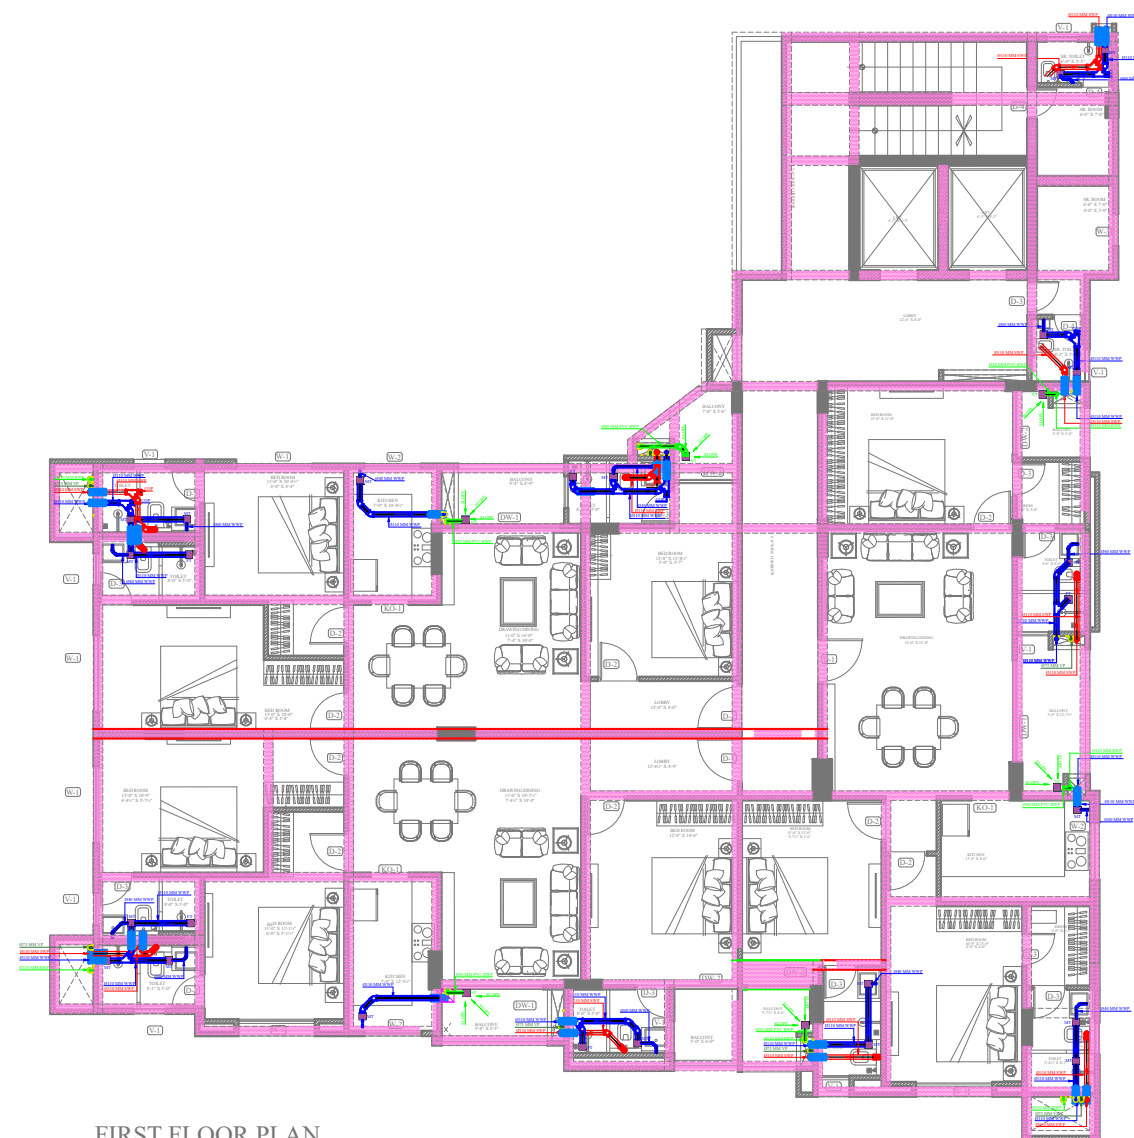

DRAINAGE

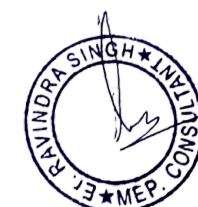

DEVELOPER

..\..\LOGO\Manglam-Png.png

ARCHITECT



124, HIMMAT NAGAR, TONK ROAD, JAIPUR
PHONE - 0141-2706227, 2712377
email: ideasjaipur@gmail.com, web: www.ideasjaipur.com

STRUCTURE CONSULTANT:
CONSULTANTS



Vijaytech Consultants Pvt. Ltd.
CONSULTING ENGINEERS
H-17, GAUTAM MARG, SHYAM NAGAR, JAIPUR-19 INDIA
Phone : 91-141 229432, 3257592 , Fax : 91-141-4023198
E-mail : vijaytech.jpr@gmail.com

LEGEND

LEGENDS:			
Mounting Ht.	Qty.	Symbol	Description
RELAY GROUND VERTICAL SHARP			110MM/80MM INTERNAL, EXTERIOR STANDARD LINE
RELAY GROUND VERTICAL SMOOTH			110MM/80MM INTERNAL, EXTERIOR WASTE WATER LINE
HANGING RELAY GROUND			110MM/80 YD AT DEEP BEIND YD WASTE WATER LINE
HANGING RELAY GROUND			110MM/80 YD BEIND FOR SOIL LINE
RELAY GROUND HANGING			70MM/50MM X 30MM MULTIPLE
RELAY GROUND HANGING			FLOOR PLAT FOR AIR DUCTURE
RELAY GROUND HANGING			110MM Y FOR SOIL LINE
HANGING RELAY GROUND			110MM AT DEEP BEIND FOR SOIL
VERTICAL SHARP			110MM/80MM WASTE WATER DOWNSTAKE
VERTICAL SHARP			110MM/80MM RAIN WATER DOWNSTAKE
VERTICAL SHARP			110MM/80MM DOWNSTAKE X 30MM

MEP CONSULTANT :



JR Square
Engineers & Consultancy Pvt. Ltd.

53 & 54, 2nd Floor Jaipur Electronic Market,
Ridhi Sidhi Circle, Gopal pura by Pass Road ,
Jaipur (Raj)
Ph:- 8696311408, 9971998408
Email:- ravisiongira72@gmail.com ;
ravi@jrsquareengineers.com

PMC CONSULTANT :

NOTES :-

1) THIS DRAWING IS PROPERTY OF IDEAS, JAIPUR
2) UNAUTHORIZED USE OF THIS DRAWING WITHOUT PERMISSION IS
STRICTLY PROHIBITED.
3) ALL DIMENSIONS ARE IN FEET AND INCHES, UNLESS NOTED OTHERWISE
4) ANY DISCREPANCY ARISING SHOULD BE INFORMED TO THE ARCHITECT
IMMEDIATELY.

NOs.	DATE	PRINT ISSUED TO
------	------	-----------------

REVISIONS:-		
-------------	--	--

KEY PLAN :-	NORTH :-
-------------	----------



PROJECT:-

PLOT NO.16, GOVIND MARG
ADARSH NAGAR, RAJA PARK
JAIPUR

CLIENT:-	MANGALAM
----------	----------

DRAWING TITLE	SOUL TOWER TYPICAL FLOOR FLAT DRAINAGE PLAN
---------------	--


FLAT DRAINAGE PLAN	
DATE:- 22-11-22	

DATE:-	22-11-22	
CHECKED BY:-	RAVI	

CHECKED BY:-	RAVI	
DEALT BY:-	AVI	DRG.NO.

DEALT BY:-	AVI	DRG.NO.
DRAWN BY:-	AARIF	IRS/ST/TYP-FLOOR DRAINAGE/R

	IRS/ST/TYP-FLOOR DRAINAGE RD
--	------------------------------

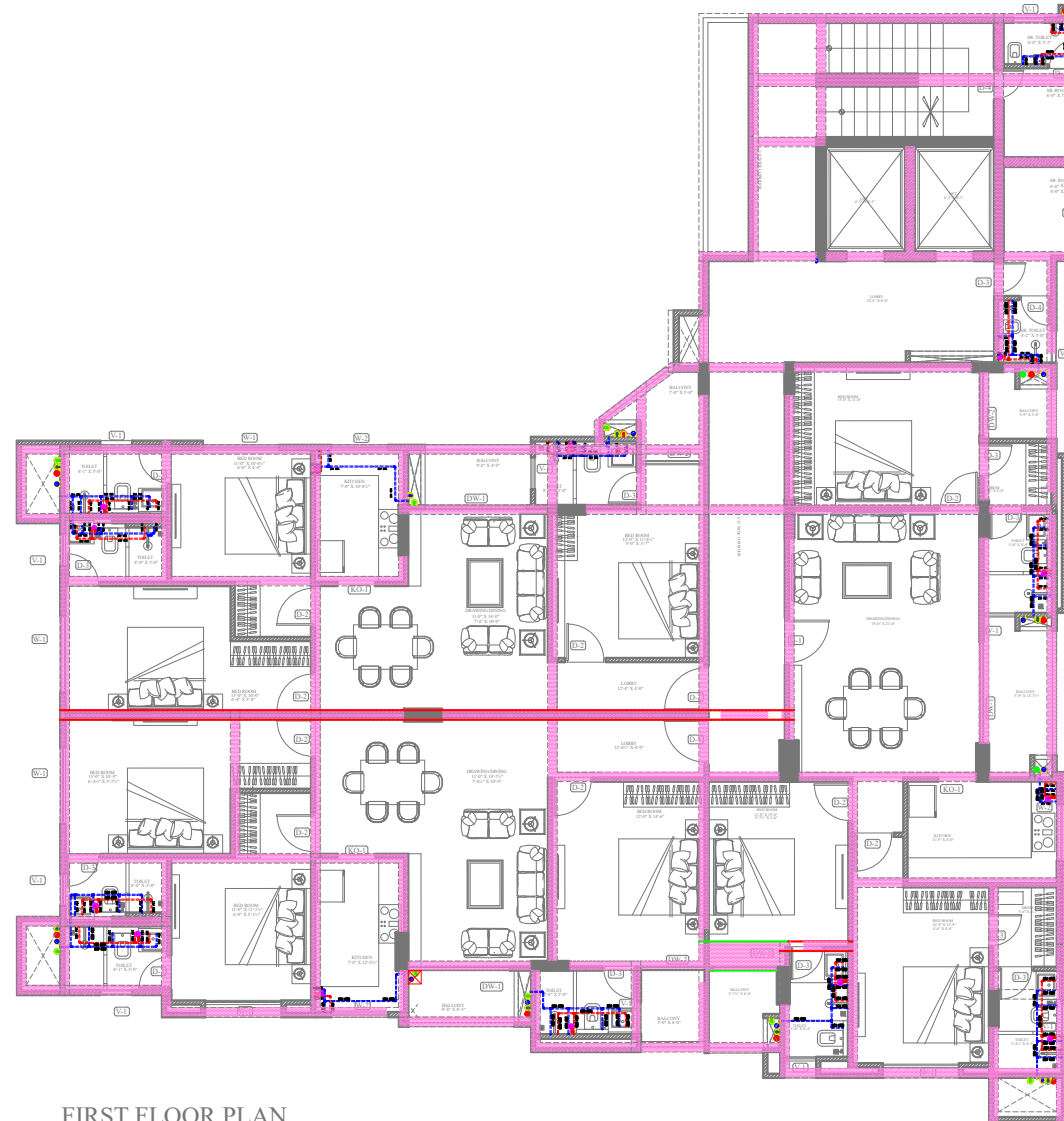

FIRST FLOOR PLAN

WATER SUPPLY



DEVELOPER

\\\\LOGO\\Manglam-Png.png

ARCHITECT



124, HIMMAT NAGAR , TONK ROAD, JAIPUR
PHONE : 0141-2706227,2712377
email: ideasjaipur@gmail.com, web: www.ideasjaipur.com

STRUCTURE CONSULTANT :
CONSULTANTS



Vijaytech Consultants Pvt. Ltd.
CONSULTANCY ENGINEERS
711-7 GUNDI JAM MARG, SHYAM NAGAR, JAIPUR-30 RAJ. RAJ.
Phone : 01-141 2284432, 3257552 , Fax : 01-141-4023108
E-mail : vijaytech.pr@gmail.com

LEGEND

LEGENDS:

Mounting Ht.	Qty.	Symbol	Description
BELOW CEILING BRACKET			25 MM C/W (COLD WATER SUPPLY)
BELOW CEILING BRACKET			25MM D/W (HOT WATER SUPPLY)
VERTICAL SHAFT			25MM C/W WATER DOWNSTACK
ON WALL			GEYSER

MEP CONSULTANT :



JR Square
Engineers & Consultancy Pvt. Ltd.
53 & 54, 2nd Floor Jaipur Electronic Market,
Ridhi Sidhi Circle, Gopal pura by Pass Road ,
Jaipur (Raj)
Ph:- 8696311408, 9971998408
Email:- ravisongira72@gmail.com ;
ravij@jrsquareengineers.com

PMC CONSULTANT :

NOTES :-
1) THIS DRAWING IS PROPERTY OF IDEAL , JAIPUR
2) UNAUTHORIZED USE OF THIS DRAWING WITHOUT PERMISSION IS
STRICTLY PROHIBITED
3) ALL DIMENSIONS ARE IN FEET AND INCHES, UNLESS NOTED OTHERWISE.
4) ANY DISCREPANCY ARISING SHOULD BE INFORMED TO THE ARCHITECT
IMMEDIATELY


NO.	DATE	PRINT ISSUED TO

REVISIONS:-

S.No.	DATE	REMARKS

KEY PLAN :-

 NORTH :-



PROJECT:-

PLOT NO.16. GOVIND MARG
ADARSH NAGAR,RAJA PARK
JAIPUR

CLIENT:-

MANGALAM

DRAWING TITLE

SOUL TOWER TYPICAL FLOOR
FLAT PLUMBING PLAN

DATE:- 22-11-22

CHECKED BY:-

RAVI

DEALT BY:-

AVI

DRG.NO.

DRAWN BY:-

AARIF

REVISIONS:-