




Ramesh Kumar
(VP - PHE & Fire)

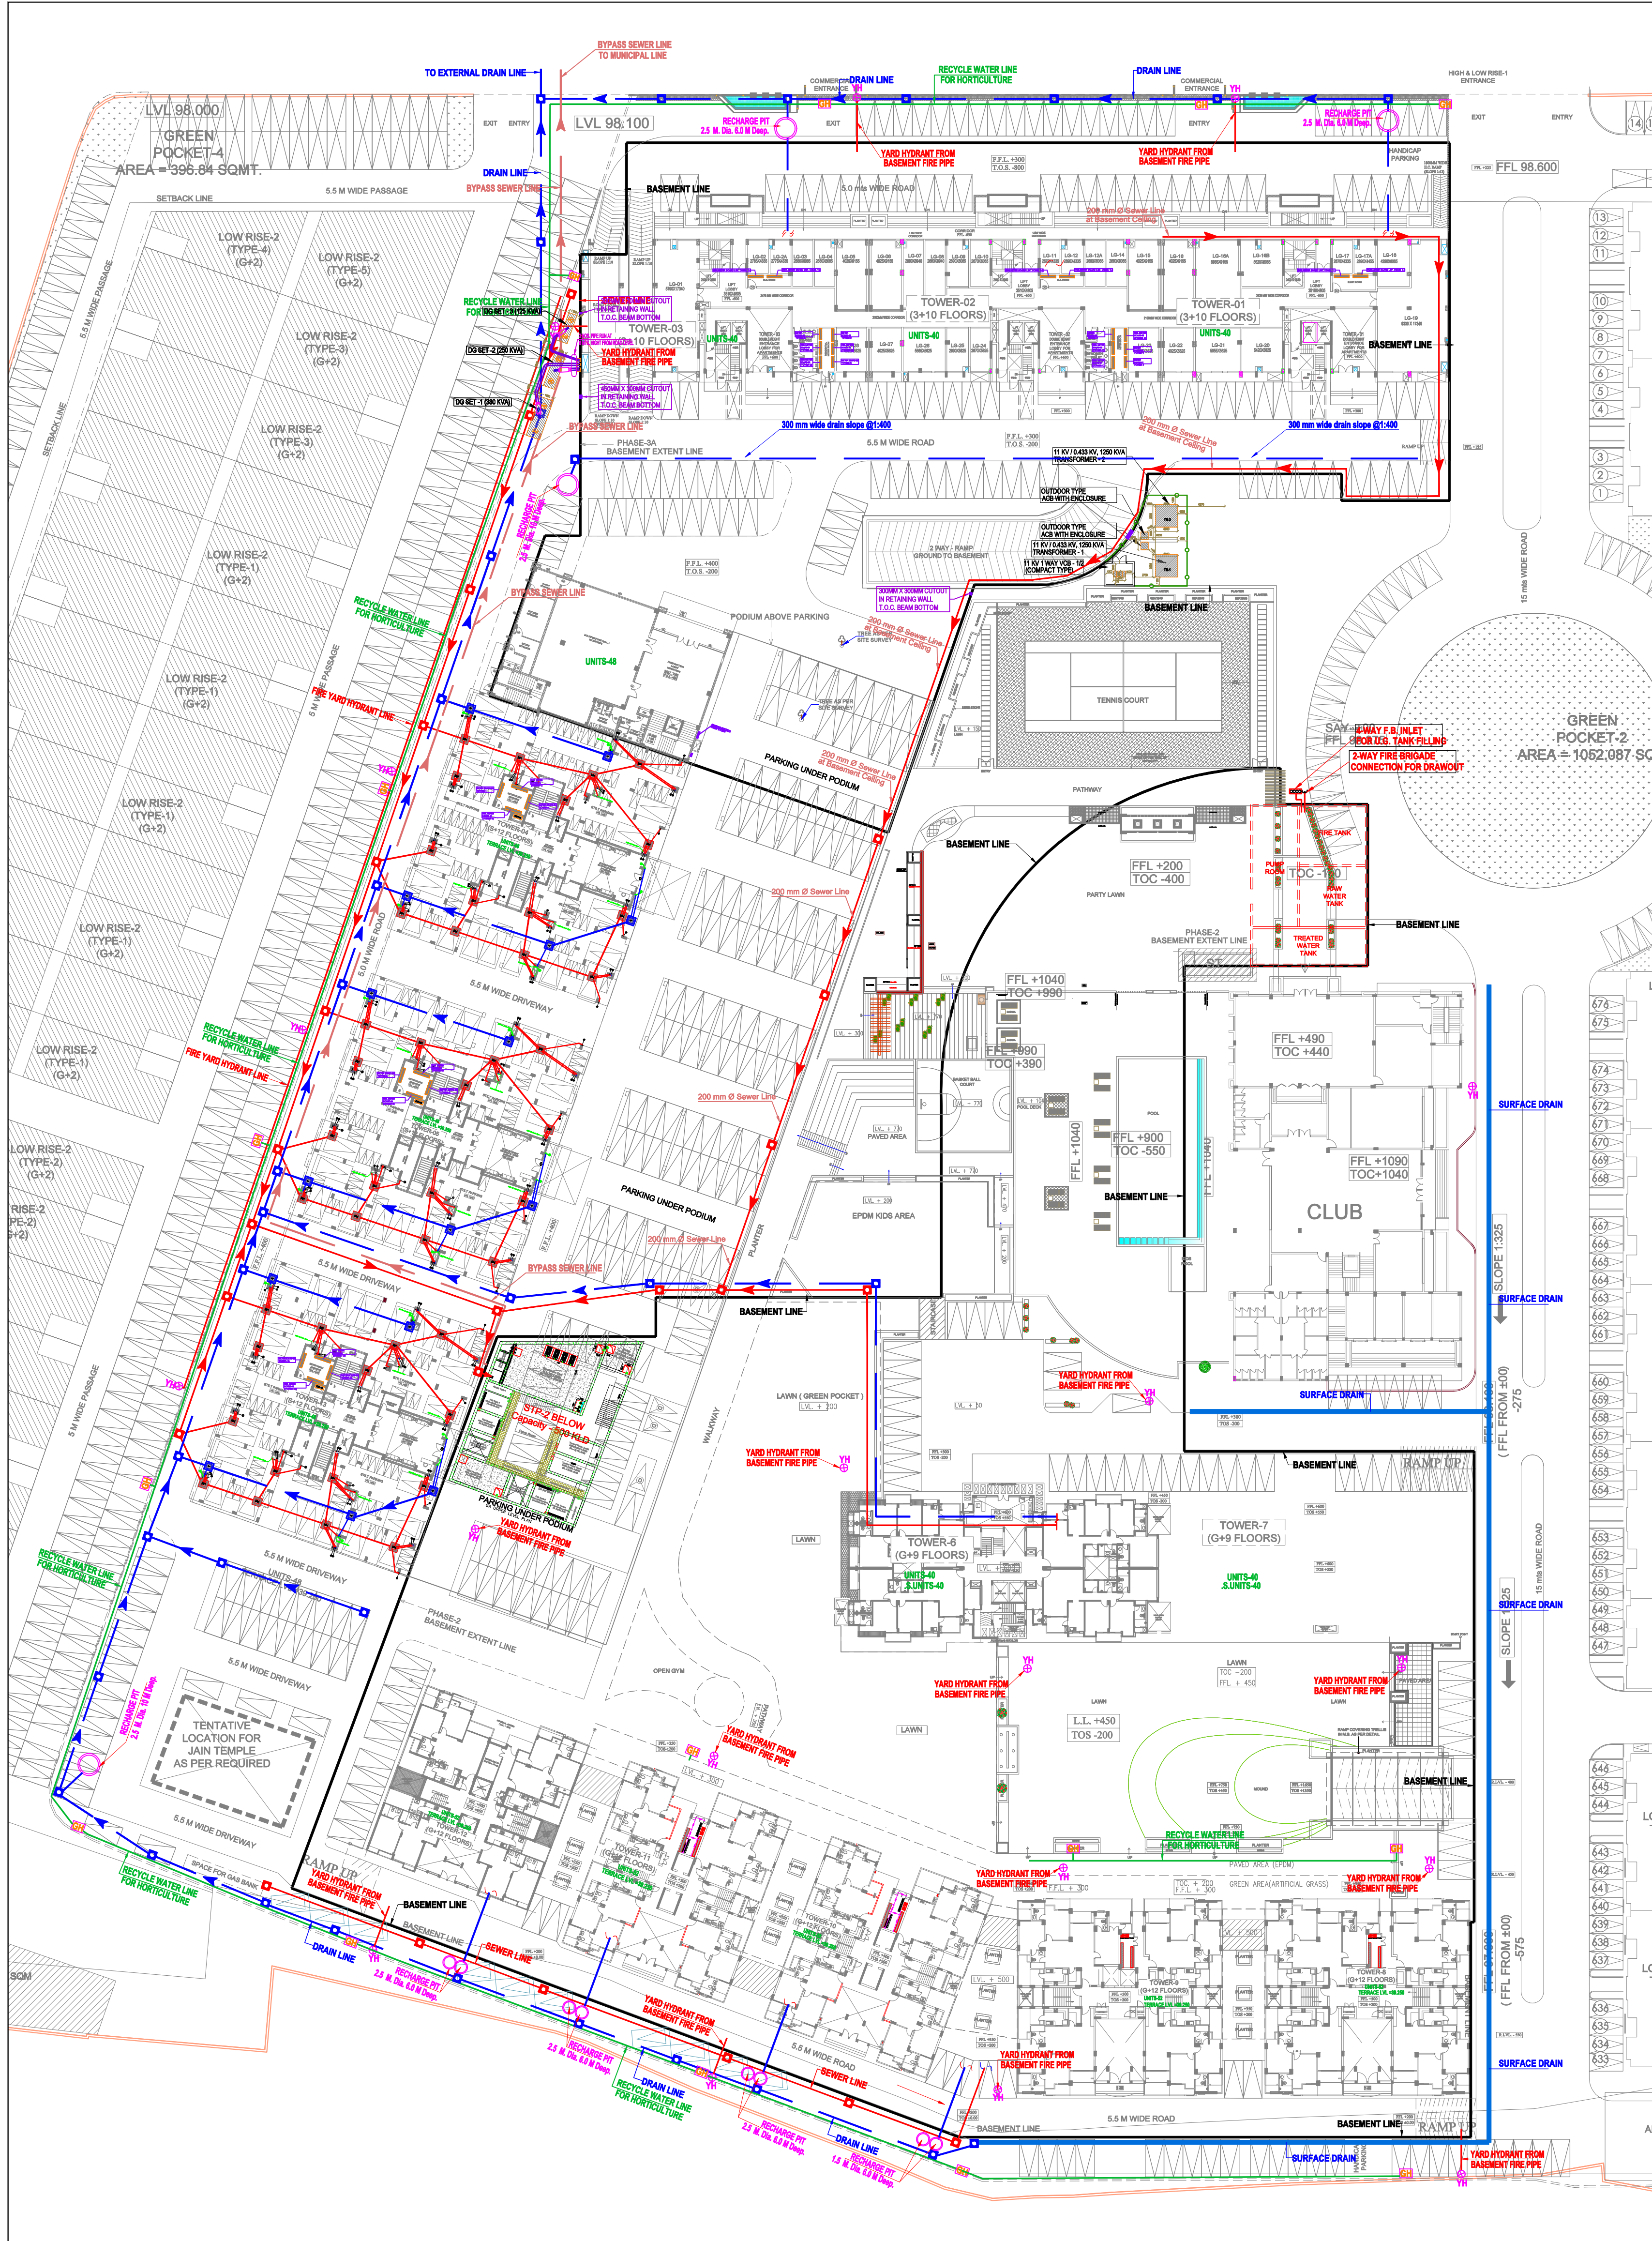

GIAN P. MATHUR
ARCHITECT
B. Arch., M.C.A., A.I.I.A.
CA No 80/5769

LEGEND :

S. No.	SYMBOL	DESCRIPTION
1.	M.H.	MANHOLE
2.	SEWER LINE	SEWER LINE
3.	BYPASS MANHOLE	BYPASS MANHOLE
4.	BYPASS SEWER LINE	BYPASS SEWER LINE
5.	C.P.	CATCH PIT
6.	UNDER GROUND DRAIN	UNDER GROUND DRAIN
7.	RAIN WATER HARVESTING	RAIN WATER HARVESTING
8.	RECYCLED WATER SUPPLY PIPE LINE.	RECYCLED WATER SUPPLY PIPE LINE.
9.	RISING MAIN WATER PIPE LINE.	RISING MAIN WATER PIPE LINE.
10.	MUNICIPAL WATER SUPPLY PIPE LINE.	MUNICIPAL WATER SUPPLY PIPE LINE.
11.	DOMESTIC WATER SUPPLY PIPE LINE.	DOMESTIC WATER SUPPLY PIPE LINE.
12.	FLUSHING WATER SUPPLY PIPE LINE.	FLUSHING WATER SUPPLY PIPE LINE.
13.	ISOLATING VALVE	ISOLATING VALVE
14.	PROPOSED TUBE WELL	PROPOSED TUBE WELL
15.	BASEMENT LINE	BASEMENT LINE
16.	GH	GARDEN HYDRANT

LEGEND : FIRE SYSTEM

S. No.	SYMBOL	DESCRIPTION
1.	FIRE LINE	FIRE LINE
2.	YH	YARD HYDRANT 63 M.M. DIA. SINGLE HEADED HYDRANT VALVE WITH 2 NOS. 15 M. LONG, 63 M.M. DIA. FIRE HOSE PIPE & 1 NO. BRANCH PIPE WITH NOZZLE
3.	FIRE BRIGADE CONNECTION	FIRE BRIGADE CONNECTION
4.	BUTTERFLY VALVE	BUTTERFLY VALVE
5.	NONRETURN VALVE (CHECK VALVE)	NONRETURN VALVE (CHECK VALVE)
6.	ISOLATING VALVE WITH MASONARY CHAMBER	ISOLATING VALVE WITH MASONARY CHAMBER

Project

AANANDA - PHASE 3b
JAIPUR

Title

SITE PLAN

Subtitle

EXTERNAL COMBINED SERVICES
Storm Water, Drainage, Sewerage, STP
Water Supply, Rainwater Harvesting

Drawing released for

- ☐ APPROVAL
☐ ADVANCE COPY
☐ SUBMISSION
☒ CONSTRUCTION

Drg. no.

M.A. / EX / PH-2 / S-05

Scale

A1@ 1:470

Date

Sep. 2017

Drawn by

MAK

Designed by

R.K.

Checked by

Anand Havela

Architects

GIAN P. MATHUR
ARCHITECTS
& PLANNERS

GIAN P. MATHUR AND ASSOCIATES (P) LTD.
C - 55, East Of Kailash, New Delhi-110065
T : 011-46599599 / F 011-46599512
E : gpma@airtelmail.in / W : www.gpmaindia.com

Services Consultant

Consummate Engineering Services (P) Ltd.

Noida Office : B - 67, Sector - 67, Noida - 201 301
Tel : (0120) 6943500 (23 Lines)
Lko. Office : R 006, Rohas Plumeria, Gomti Nagar, Lucknow
Tel : (0522) 4025902
e mail : mail@cespln, website : www.cespln