



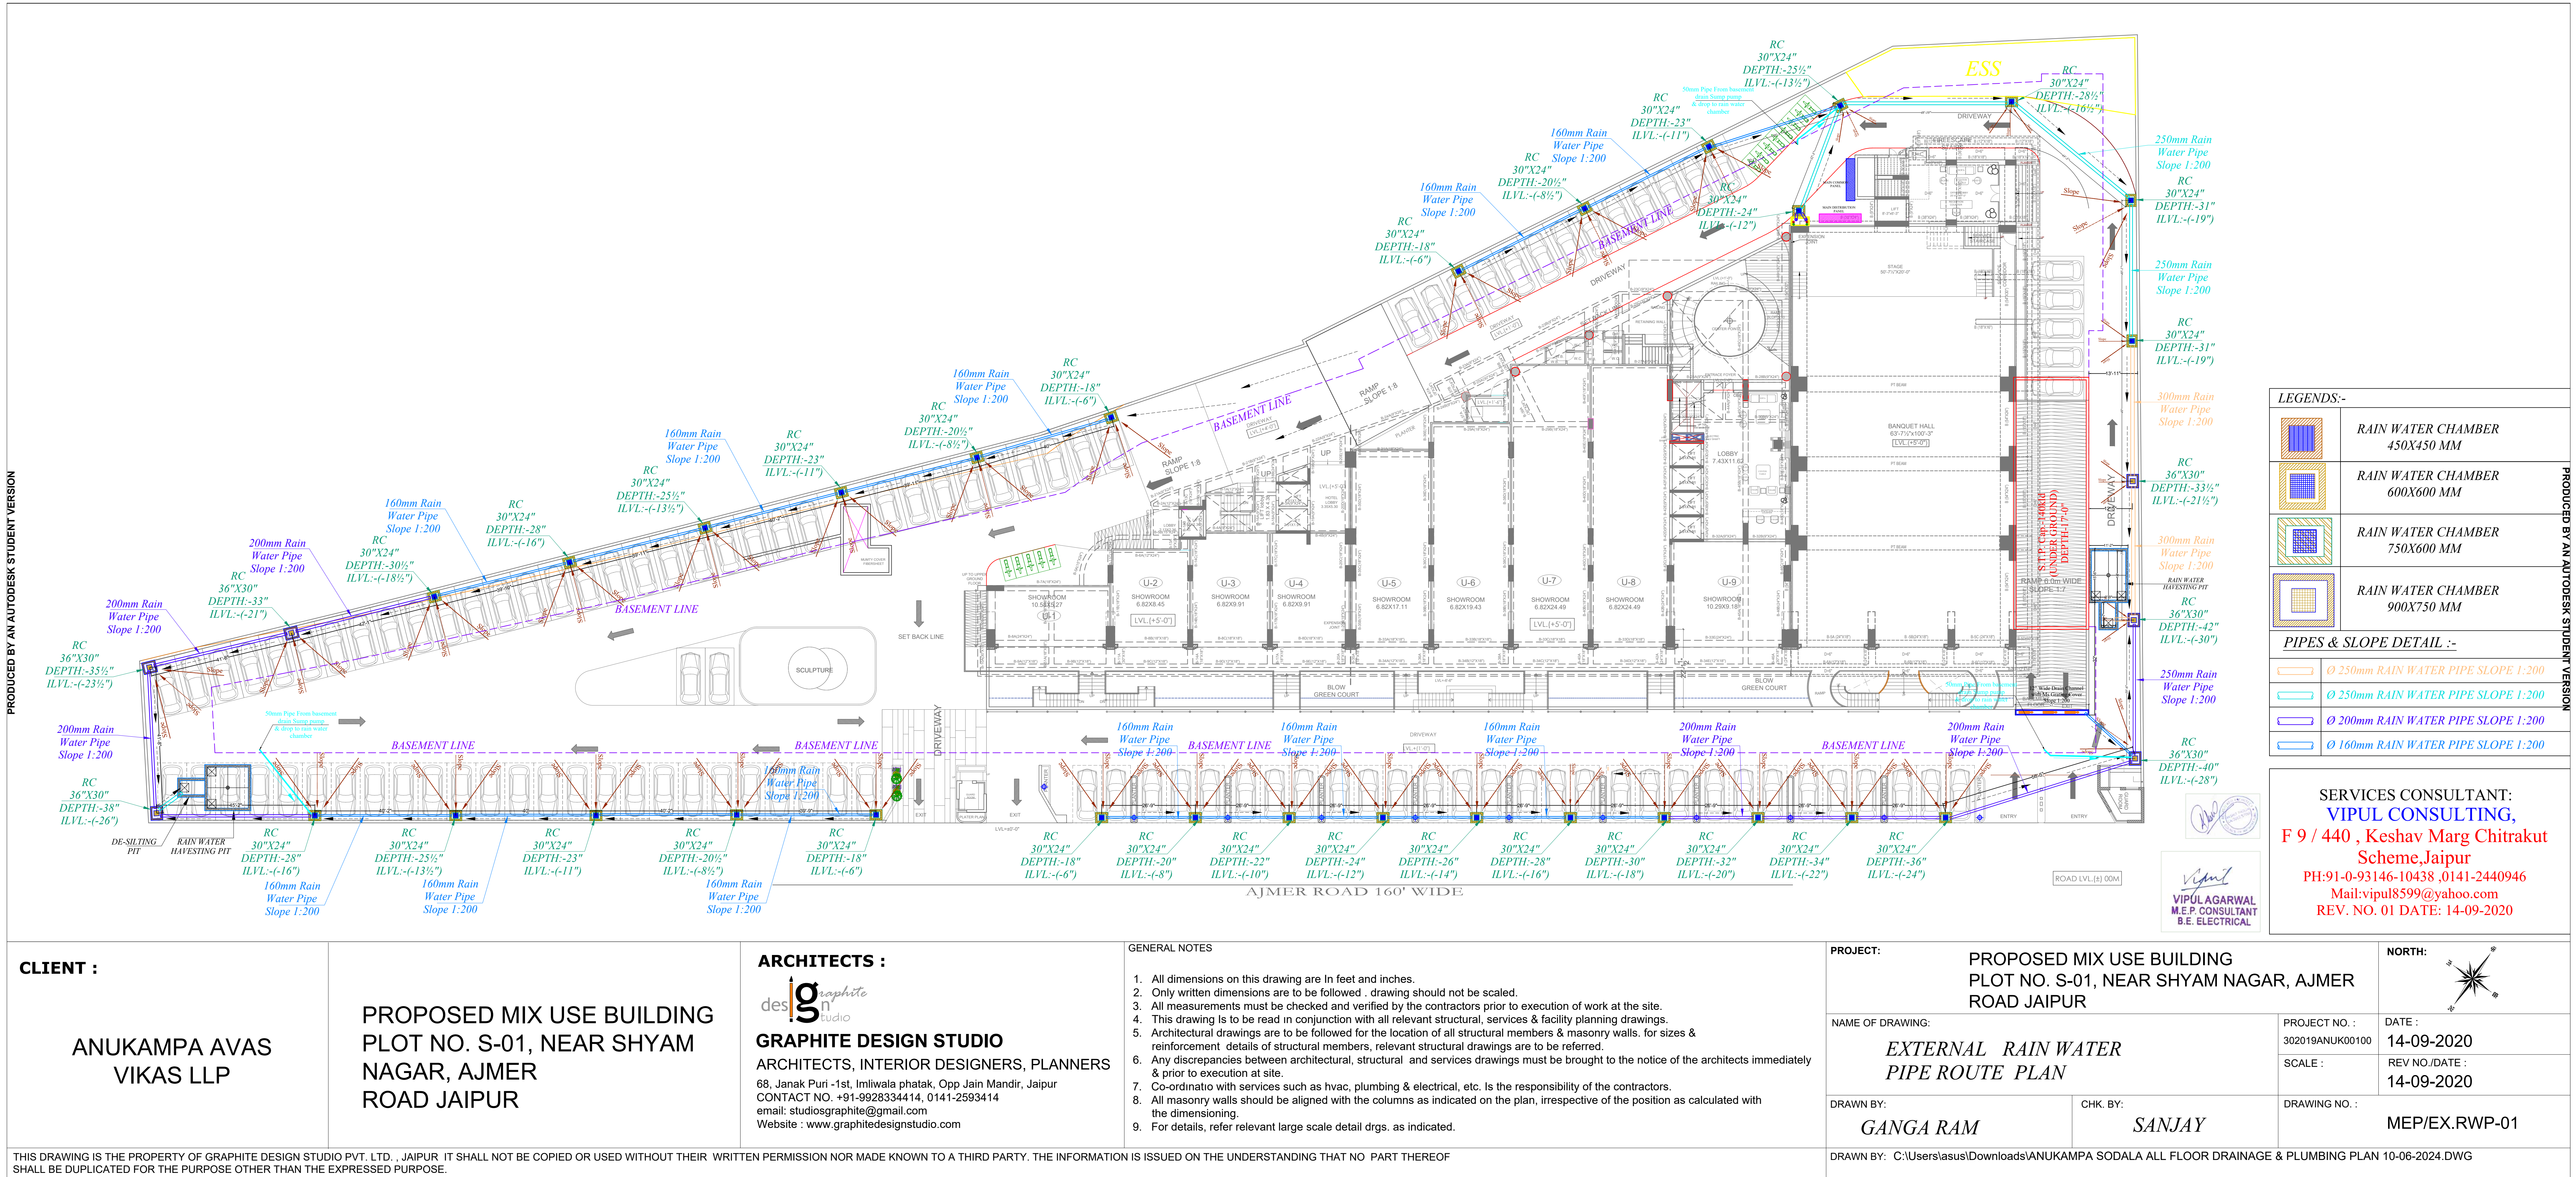

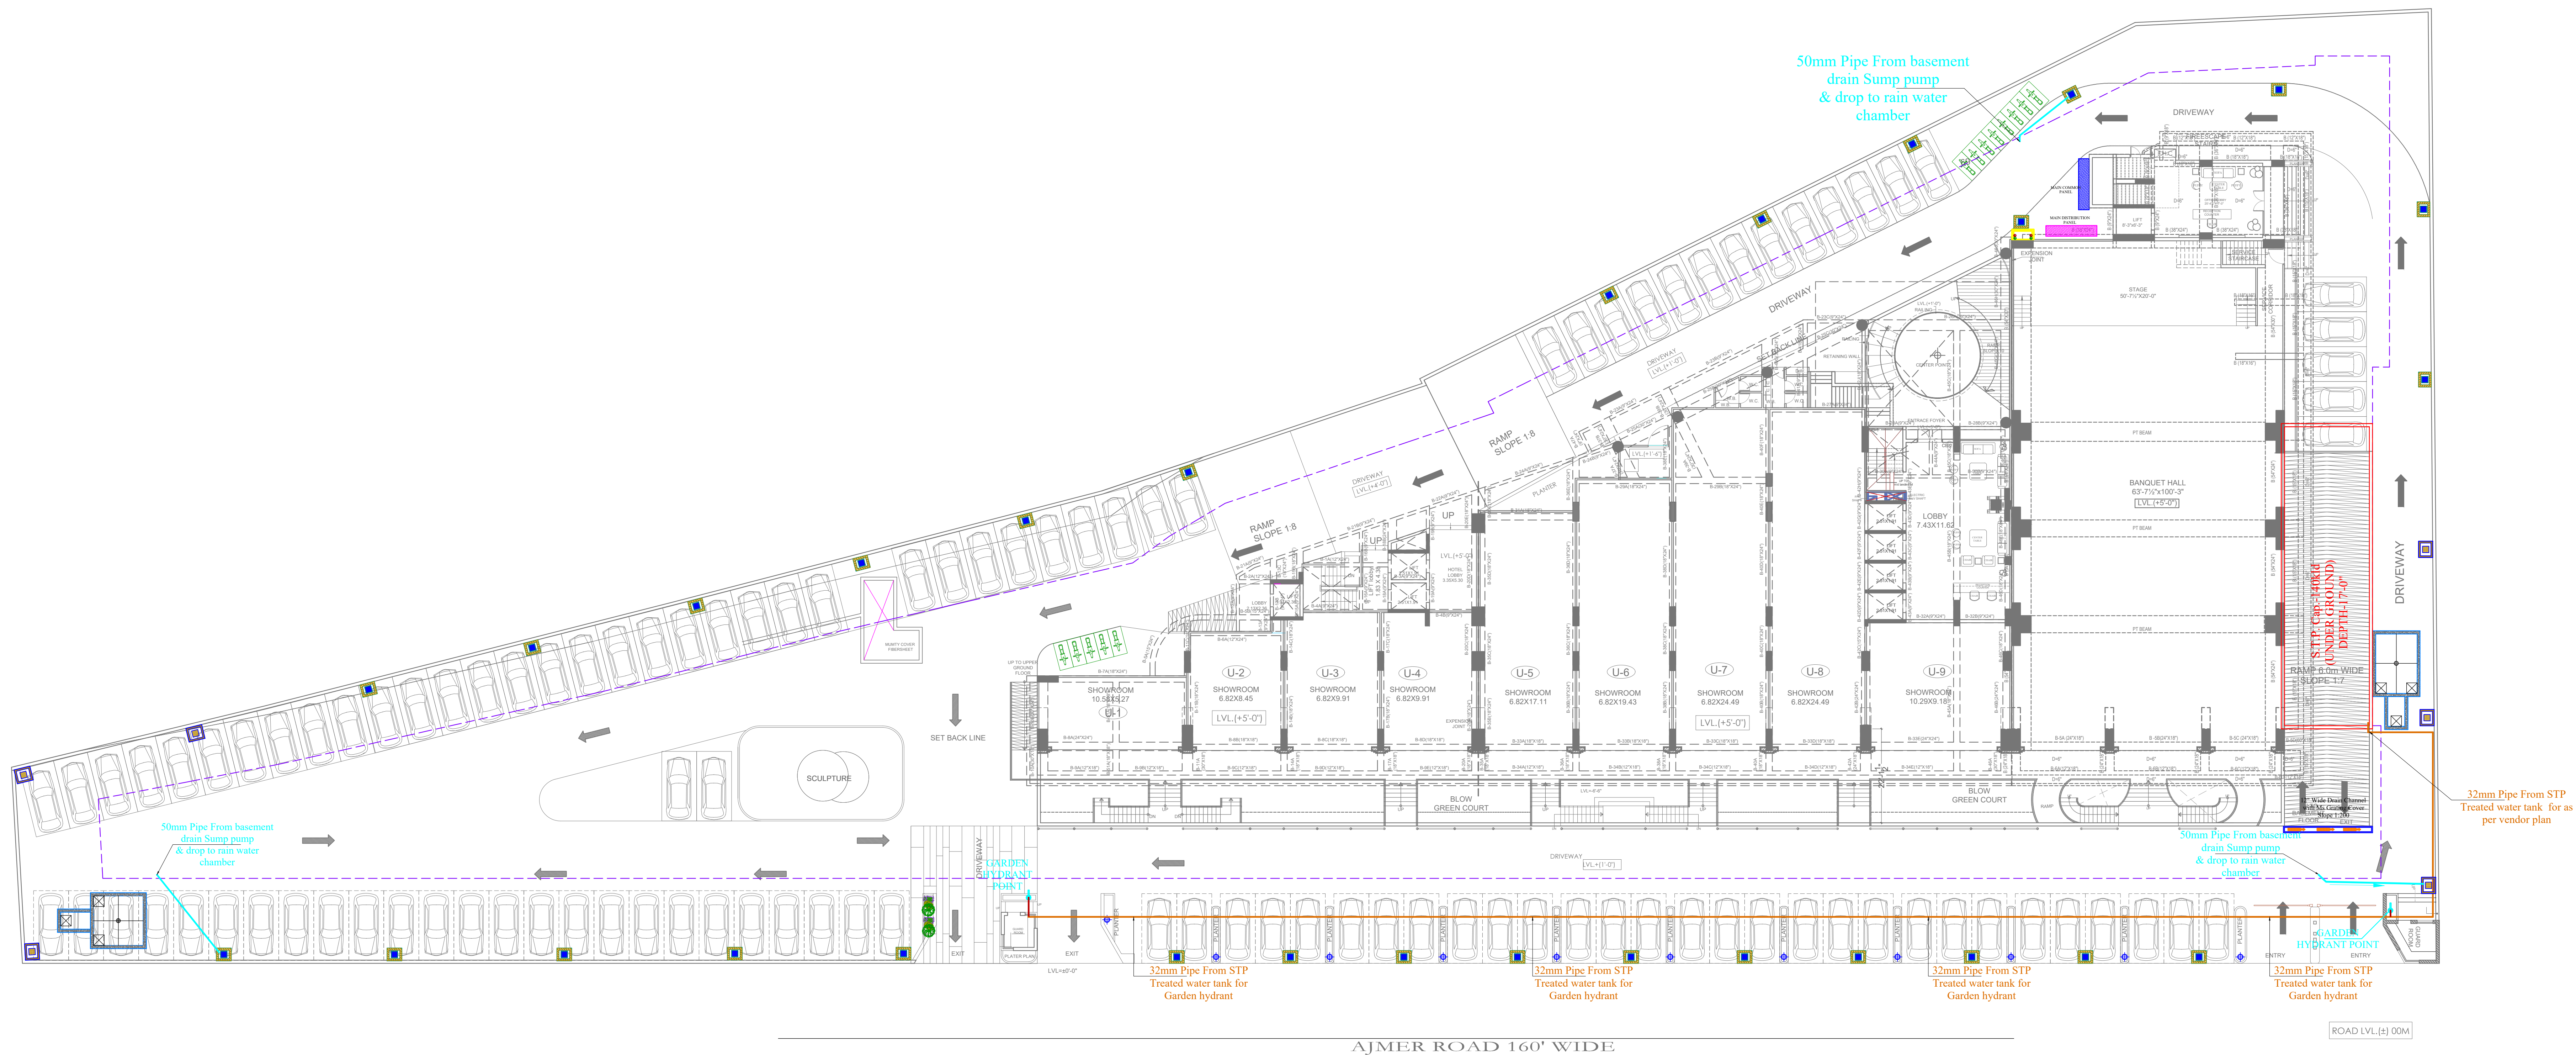

Vipul
VIPUL AGARWAL
M.E.P. CONSULTANT
B.E. ELECTRICAL

SERVICES CONSULTANT:
VIPUL CONSULTING,
F 9 / 440 , Keshav Marg Chitrakut
Scheme,Jaipur
PH:91-0-93146-10438 ,0141-2440946
Mail:vipul8599@yahoo.com
REV. NO. 02,DATE:-04-12-2020

CLIENT :

ANUKAMPA AVAS
VIKAS LLP

PROPOSED MIX USE BUILDING
PLOT NO. S-01, NEAR SHYAM
NAGAR, AJMER
ROAD JAIPUR

ARCHITECTS :

des^{ig}n^{studio}

GRAPHITE DESIGN STUDIO

ARCHITECTS, INTERIOR DESIGNERS, PLANNERS


68, Janak Puri -1st, Imliwala phatak, Opp Jain Mandir, Jaipur
CONTACT NO. +91-9928334414, 0141-2593414
email: studiosgraphite@gmail.com
Website : www.graphitedesignstudio.com

GENERAL NOTES

1. All dimensions on this drawing are in feet and inches.
2. Only written dimensions are to be followed. Drawing should not be scaled.
3. All measurements must be checked and verified by the contractors prior to execution of work at the site.
4. This drawing is to be read in conjunction with all relevant structural, services & facility planning drawings.
5. Architectural drawings are to be followed for the location of all structural members & masonry walls. For sizes & reinforcement details of structural members, relevant structural drawings are to be referred.
6. Any discrepancies between architectural, structural and services drawings must be brought to the notice of the architects immediately & prior to execution at site.
7. Co-ordination with services such as hvac, plumbing & electrical, etc. is the responsibility of the contractors.
8. All masonry walls should be aligned with the columns as indicated on the plan, irrespective of the position as calculated with the dimensioning.
9. For details, refer relevant large scale detail drgs. as indicated.

PROJECT:

PROPOSED MIX USE BUILDING
PLOT NO. S-01, NEAR SHYAM NAGAR, AJMER
ROAD JAIPUR

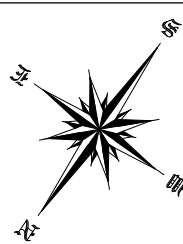NORTH:**NAME OF DRAWING:**

*EXTERNAL STP TREATED WATER
GARDEN HYDRANT LINE PLAN*

PROJECT NO. :

302019ANUK00100

DATE :

04-12-2020

SCALE :

REV NO./DATE :

04-12-2020

DRAWN BY:

VIJESH

CHK. BY:


SANJAY

DRAWING NO. :

MEP/GH/W-02

DRAWN BY: C:\Users\sasul\Downloads\ANUKAMPA SODALA ALL FLOOR DRAINAGE & PLUMBING PLAN 10-06-2024.DWG

THIS DRAWING IS THE PROPERTY OF GRAPHITE DESIGN STUDIO PVT. LTD., JAIPUR. IT SHALL NOT BE COPIED OR USED WITHOUT THEIR WRITTEN PERMISSION NOR MADE KNOWN TO A THIRD PARTY. THE INFORMATION IS ISSUED ON THE UNDERSTANDING THAT NO PART THEREOF SHALL BE DUPLICATED FOR THE PURPOSE OTHER THAN THE EXPRESSED PURPOSE.

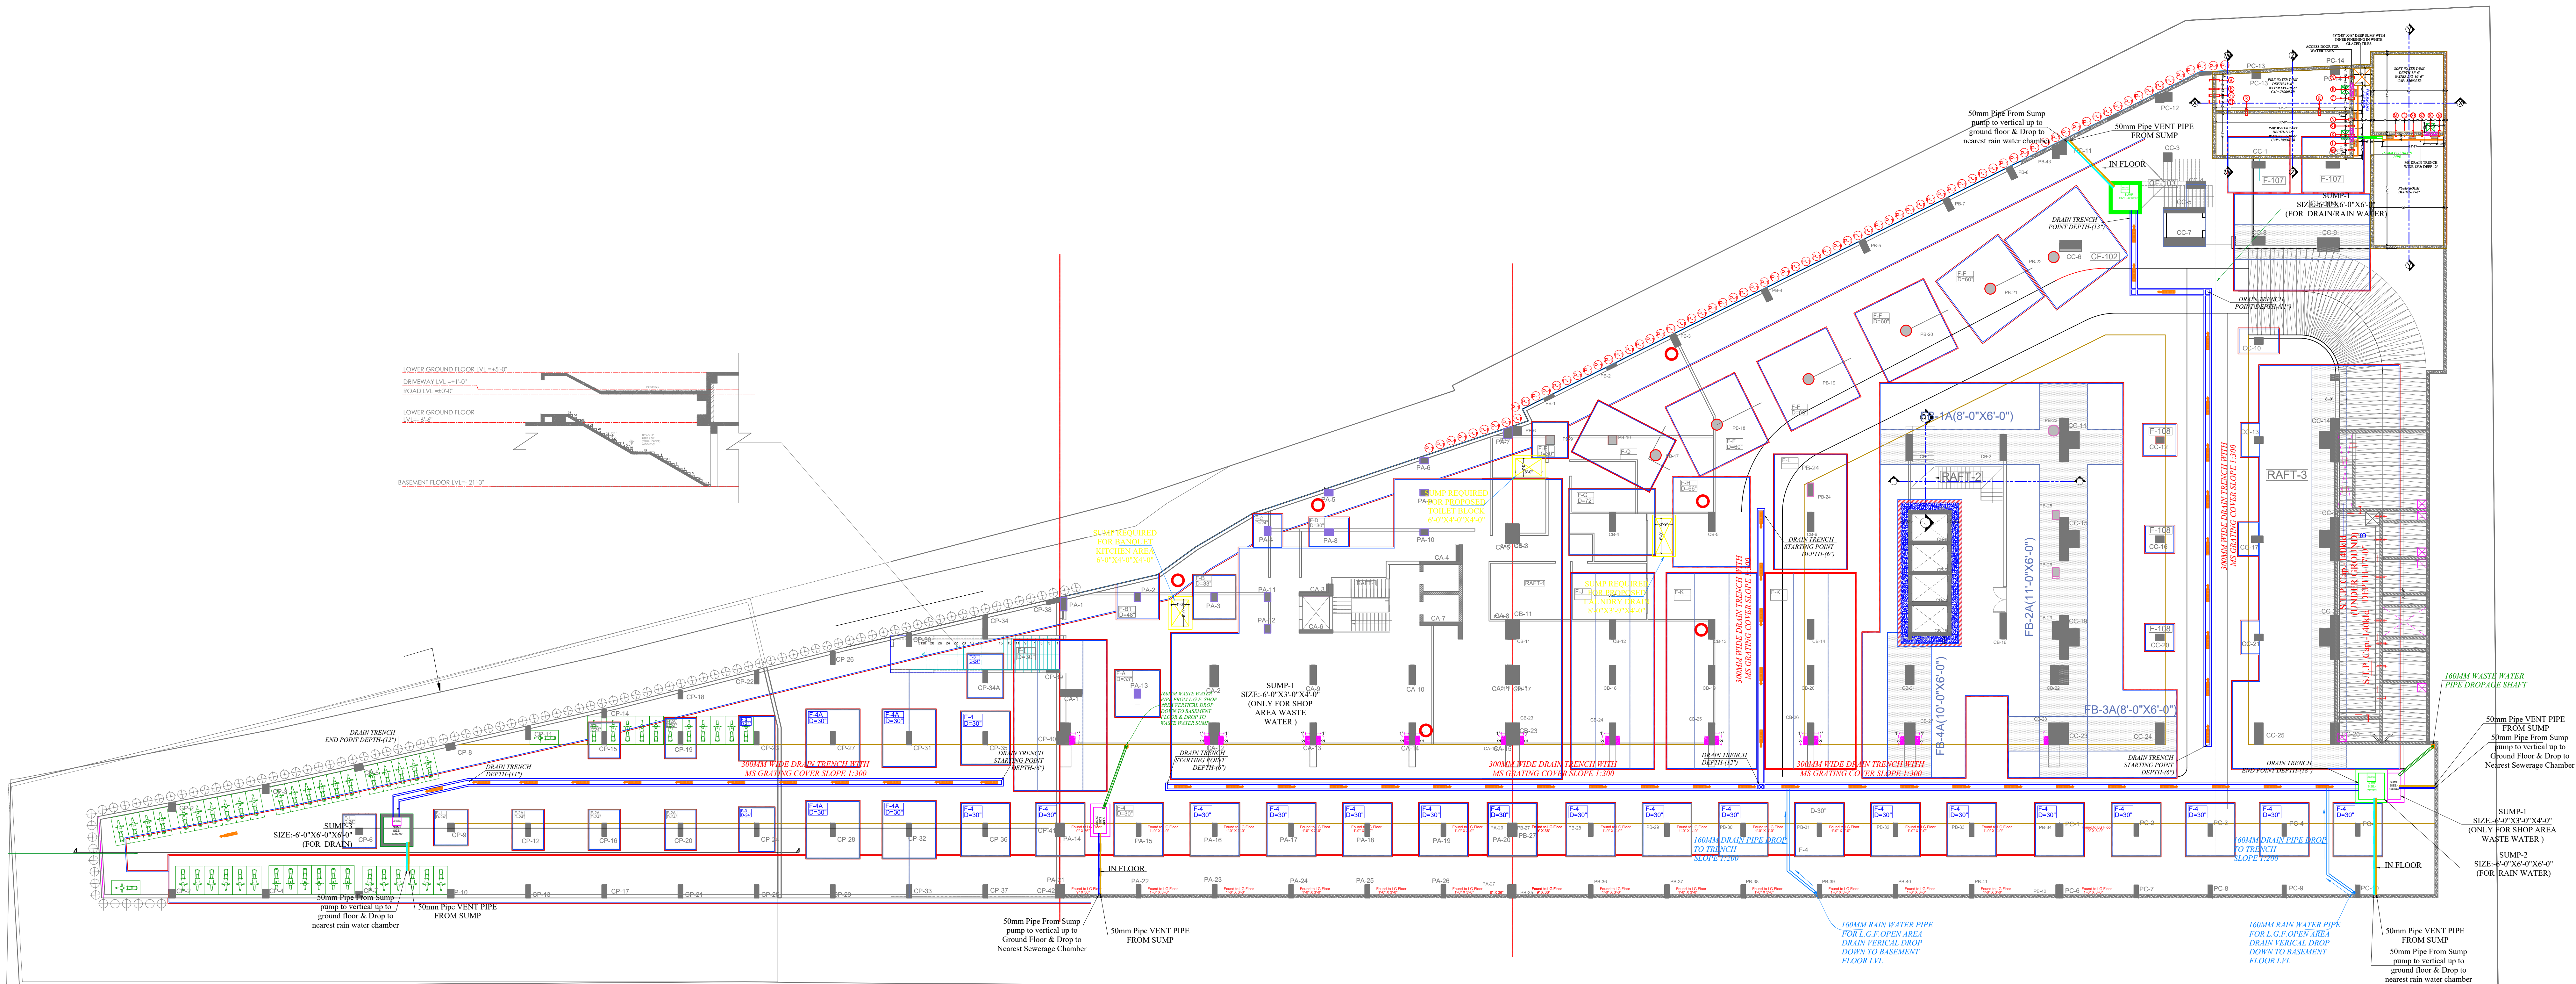

CLIENT :

ANUKAMPA AVAS
VIKAS LLPPROPOSED MIX USE BUILDING
PLOT NO. S-01, NEAR SHYAM
NAGAR, AJMER
ROAD JAIPUR

ARCHITECTS :

desⁱgⁿ
studio

GRAPHITE DESIGN STUDIO

ARCHITECTS, INTERIOR DESIGNERS, PLANNERS

68, Janak Puri -1st, Imliwala phatak, Opp Jain Mandir, Jaipur
CONTACT NO. +91-9928334414, 0141-2593414
email: studiosgraphite@gmail.com
Website : www.graphitedesignstudio.com

GENERAL NOTES

1. All dimensions on this drawing are in feet and inches.
2. Only written dimensions are to be followed. drawing should not be scaled.
3. All measurements must be checked and verified by the contractors prior to execution of work at the site.
4. This drawing is to be read in conjunction with all relevant structural, services & facility planning drawings.
5. Architectural drawings are to be followed for the location of all structural members & masonry walls. for sizes & reinforcement details of structural members, relevant structural drawings are to be referred.
6. Any discrepancies between architectural, structural and services drawings must be brought to the notice of the architects immediately & prior to execution at site.
7. Co-ordination with services such as hvac, plumbing & electrical, etc. is the responsibility of the contractors.
8. All masonry walls should be aligned with the columns as indicated on the plan, irrespective of the position as calculated with the dimensioning.
9. For details, refer relevant large scale detail drgs. as indicated.

SERVICES CONSULTANT:
VIPUL CONSULTING,
F 9 / 440 , Keshav Marg
Chitrakut Scheme, Jaipur
PH: 91-0-93146-10438, 0141-2440946
Mail: vipul8599@yahoo.com

PROJECT:

PROPOSED MIX USE BUILDING
PLOT NO. S-01, NEAR SHYAM NAGAR, AJMER
ROAD JAIPUR

NAME OF DRAWING:

**BASEMENT FLOOR DRAIN TRENCH &
DRAINAGE PIPE & REQUIRED SUMP PLAN**

DRAWN BY:

SANJAY

APPROVED BY:

VIPUL AGARWAL

DRAWN BY:

PROJECT NO. :


302019ANUK00100

SCALE :

DRAWING NO. :

MEP/ANU/BF/DT-03

NORTH:

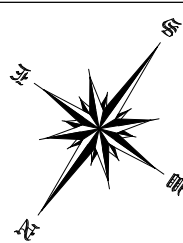


DATE :

29-08-2020

REV NO./DATE :

THIS DRAWING IS THE PROPERTY OF GRAPHITE DESIGN STUDIO PVT. LTD., JAIPUR. IT SHALL NOT BE COPIED OR USED WITHOUT THEIR WRITTEN PERMISSION NOR MADE KNOWN TO A THIRD PARTY. THE INFORMATION IS ISSUED ON THE UNDERSTANDING THAT NO PART THEREOF SHALL BE DUPLICATED FOR THE PURPOSE OTHER THAN THE EXPRESSED PURPOSE.

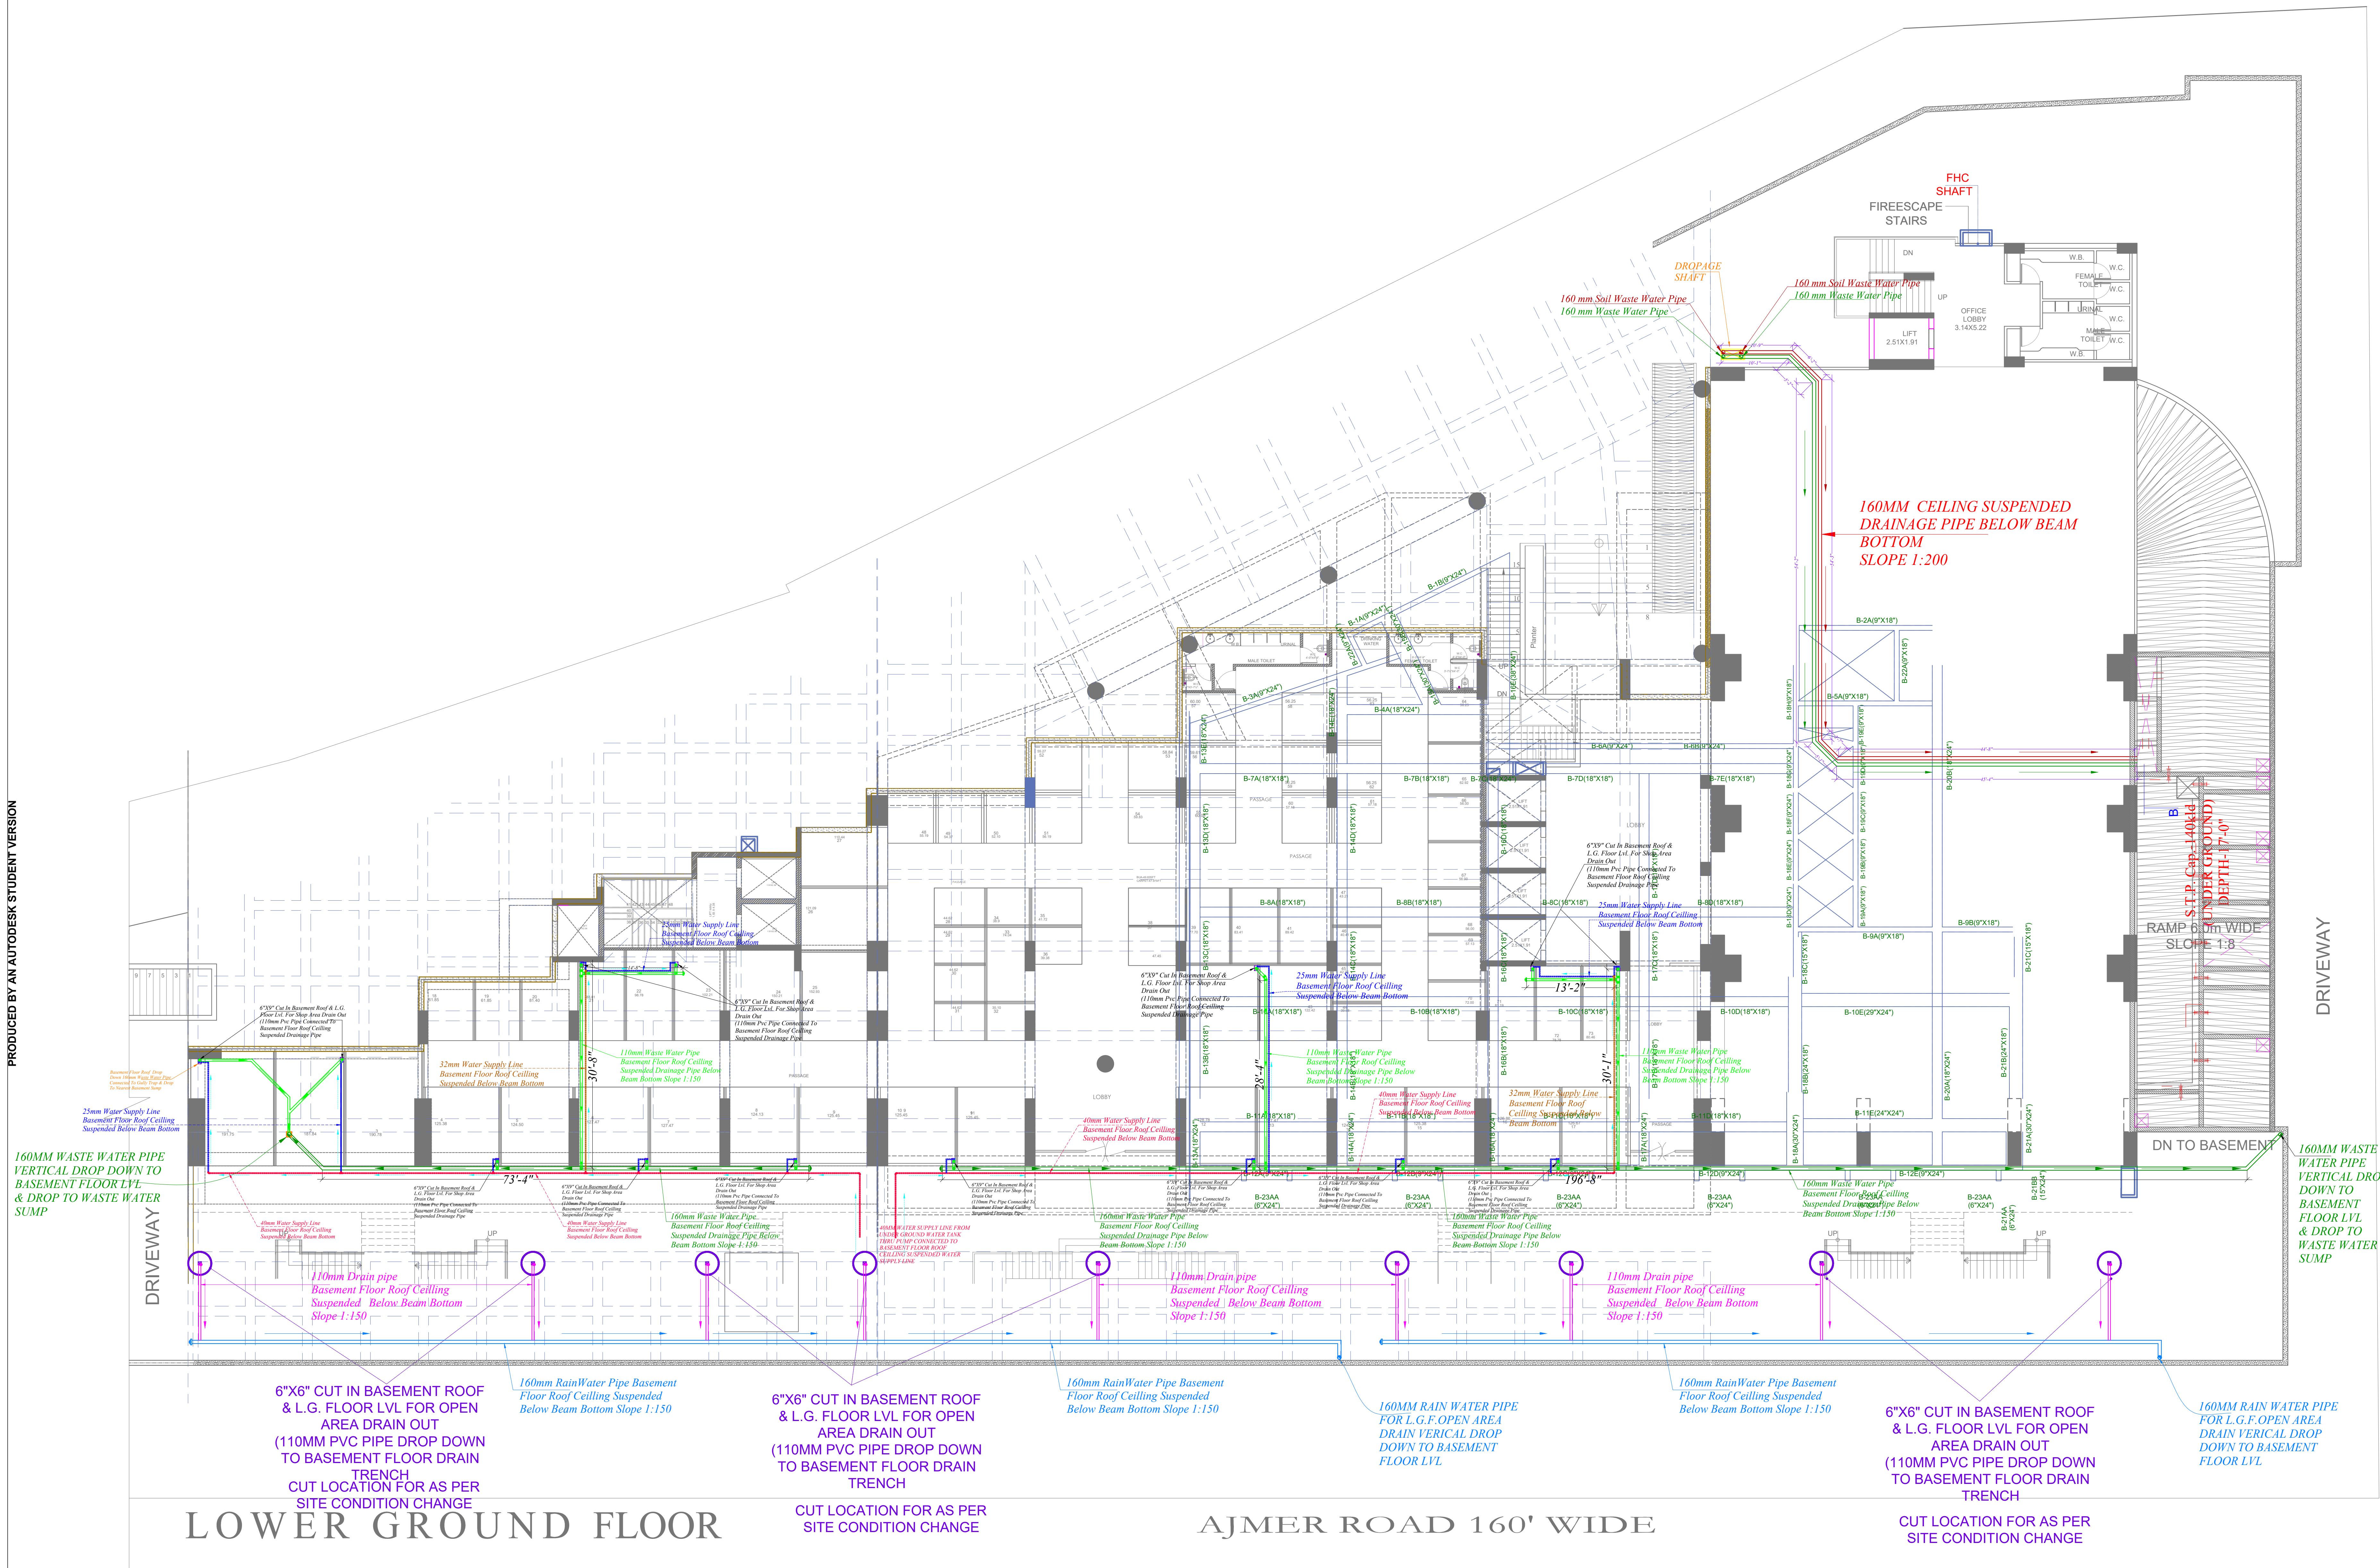

Vipul
VIPUL AGARWAL
M.E.P. CONSULTANT
B.E. ELECTRICAL

SYMBOL	DESCRIPTION
	110 mm Waste Water Pipe
	160 mm Waste Water Pipe
	110 mm Waste Water Pipe
	160 mm Waste Water Pipe
	WATER SUPPLY PIPE
	25mm WATER SUPPLY LINE
	32mm WATER SUPPLY LINE
	40mm WATER SUPPLY LINE
	CUT IN SLAB FOR DRAINAGE SHAFT
	DROPAGE DRAINAGE SHAFT

SERVICES CONSULTANT:
VIPUL CONSULTING,
F 9 / 440 , Keshav Marg Chitrakut Scheme,Jaipur
PH:91-0-93146-10438 ,0141-2440946
Mail:vipul8599@yahoo.com

CLIENT : ANUKAMPA AVAS VIKAS LLP	PROPOSED MIX USE BUILDING PLOT NO. S-01, NEAR SHYAM NAGAR, AJMER ROAD JAIPUR	ARCHITECTS :  GRAPHITE DESIGN STUDIO ARCHITECTS, INTERIOR DESIGNERS, PLANNERS 68, Janak Puri -1st, Imliwala phatak, Opp Jain Mandir, Jaipur CONTACT NO. +91-9928334414, 0141-2593414 email: studiosgraphite@gmail.com Website : www.graphitedesignstudio.com	GENERAL NOTES 1. All dimensions on this drawing are In feet and inches. 2. Only written dimensions are to be followed . drawing should not be scaled. 3. All measurements must be checked and verified by the contractors prior to execution of work at the site. 4. This drawing Is to be read in conjunction with all relevant structural, services & facility planning drawings. 5. Architectural drawings are to be followed for the location of all structural members & masonry walls. for sizes & reinforcement details of structural members, relevant structural drawings are to be referred. 6. Any discrepancies between architectural, structural and services drawings must be brought to the notice of the architects immediately & prior to execution at site. 7. Co-ordinatio with services such as hvac, plumbing & electrical, etc. Is the responsibility of the contractors. 8. All masonry walls should be aligned with the columns as indicated on the plan, irrespective of the position as calculated with the dimensioning. 9. For details, refer relevant large scale detail drgs. as indicated.	PROJECT: PROPOSED MIX USE BUILDING PLOT NO. S-01, NEAR SHYAM NAGAR, AJMER ROAD JAIPUR		NORTH: 		
				NAME OF DRAWING: BASEMENT FLOOR ROOF CEILING SUSPENDED DRAINAGE PIPE ROUTE PLAN		PROJECT NO. : 302019ANUK00100	DATE : 17-09-2020	
						SCALE :	REV NO./DATE : R- 0	
				APPD BY: VIPUL AGARWAL	DEALT BY: SANJAY	DRAWN BY: GANGA RAM	DRAWING NO. : MEP/ANU/BFR/PL-04	
THIS DRAWING IS THE PROPERTY OF GRAPHITE DESIGN STUDIO PVT. LTD. , JAIPUR IT SHALL NOT BE COPIED OR USED WITHOUT THEIR WRITTEN PERMISSION NOR MADE KNOWN TO A THIRD PARTY. THE INFORMATION IS ISSUED ON THE UNDERSTANDING THAT NO PART THEREOF SHALL BE DUPLICATED FOR THE PURPOSE OTHER THAN THE EXPRESSED PURPOSE.								

THIS DRAWING IS THE PROPERTY OF GRAPHITE DESIGN STUDIO PVT. LTD., JAIPUR. IT SHALL NOT BE COPIED OR USED WITHOUT THEIR WRITTEN PERMISSION NOR MADE KNOWN TO A THIRD PARTY. THE INFORMATION IS ISSUED ON THE UNDERSTANDING THAT NO PART THEREOF SHALL BE DUPLICATED FOR THE PURPOSE OTHER THAN THE EXPRESSED PURPOSE.



GENERAL NOTES :

1. All dimension on this drawing are in feet and inches.
2. Only written dimensions are to be followed. Drawing should not be scaled.
3. All measurements must be checked and verified by the contractors prior to execution of work at the site.
4. This drawing is to be read in conjunction with all relevant structural, services & facility planning drawings.
5. Architectural drawings are to be followed for the location of all structural members & masonry walls, for sizes & reinforcement details of structural members, relevant structural drawings are to be referred.
6. Any discrepancies between architectural, structural & services drawings must be brought to the notice of the architects immediately prior to execution at site.
7. Co-ordination with services such as HVAC, plumbing & electrical etc. is the responsibility of the contractor.
8. All masonry walls must be aligned with the columns as indicated on the plan, irrespective of the position as calculated with the dimensioning.

For details refer relevant drawings and specifications as indicated.

NAME OF DRAWING

DRAWN BY:

SURYA

NORTH:

PROJECT NO. : 302019ANUK00100	DATE : 06-04-19
SCALE :	REV NO. : REV NO./DATE :14-05-2019 REV.COLUMN PB 2,17, CB-1,2,16 LOCATION
DRAWING NO. : ANU_A_03	

<i>T</i>



DRAWING NO. :
MEP/1st.F.R/DRA-05