


LEGENDS:			
Monitors	Qty	Symbols	
CEILING	65		SPRINKLER POINT
WALL	10		
CEILING	150mm		25 MM DIA MS PIPE
CEILING	65mm		32 MM DIA MS PIPE
CEILING	30mm		50 MM DIA MS PIPE
CEILING	30mm		50 MM DIA MS PIPE
CEILING	16mm		65 MM DIA MS PIPE
CEILING	12mm		80 MM DIA MS PIPE
CEILING	02		100 MM DIA SLEEVE
			CONTROL VALVE
			HYDRANT
			ROPE DRUM
			NOZZLE
			AIRTIGHT FIRE EXTINGUISHER
			CO2 TYPE FIRE EXTINGUISHER
			MANNUAL CALL POINT
			HOOTER

50mm thk slab


Typical Section of Beam for Sprinkler Pipe /Lvl

-100mm below roof bottom

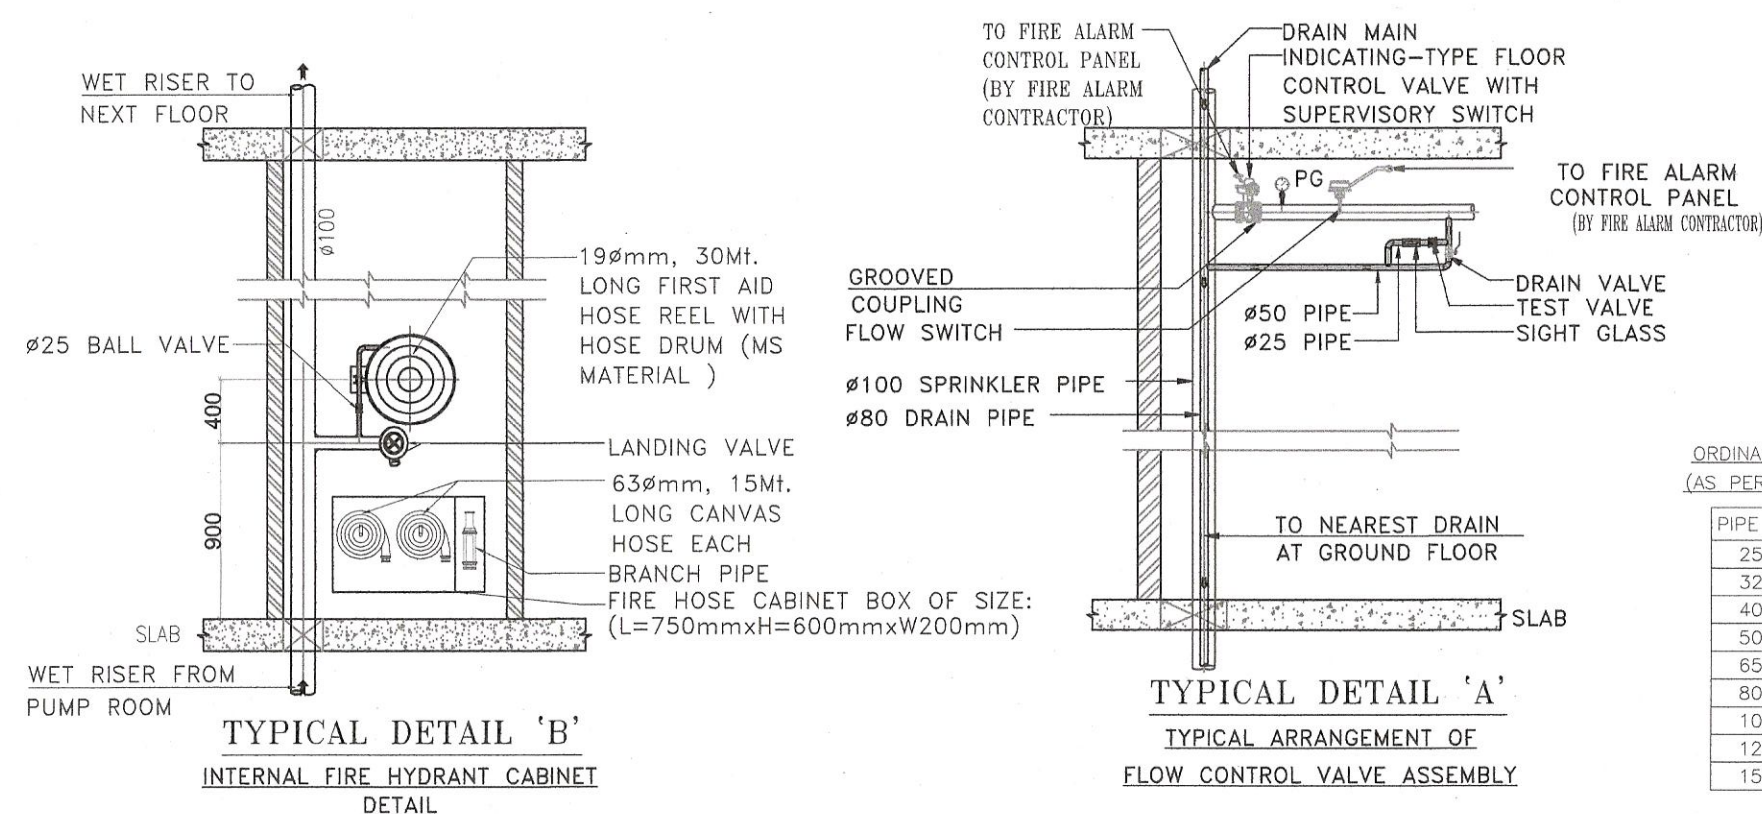

PIPE DIA.	NO. OF SPRINKLER
25ø	2 SPRINKLER
32ø	3 SPRINKLER
40ø	5 SPRINKLER
50ø	10 SPRINKLER
65ø	20 SPRINKLER
80ø	40 SPRINKLER
100ø	100 SPRINKLER
125ø	160 SPRINKLER
150ø	275 SPRINKLER

INTERNAL HYDRANT AND SPRINKLER ASSEMBLY

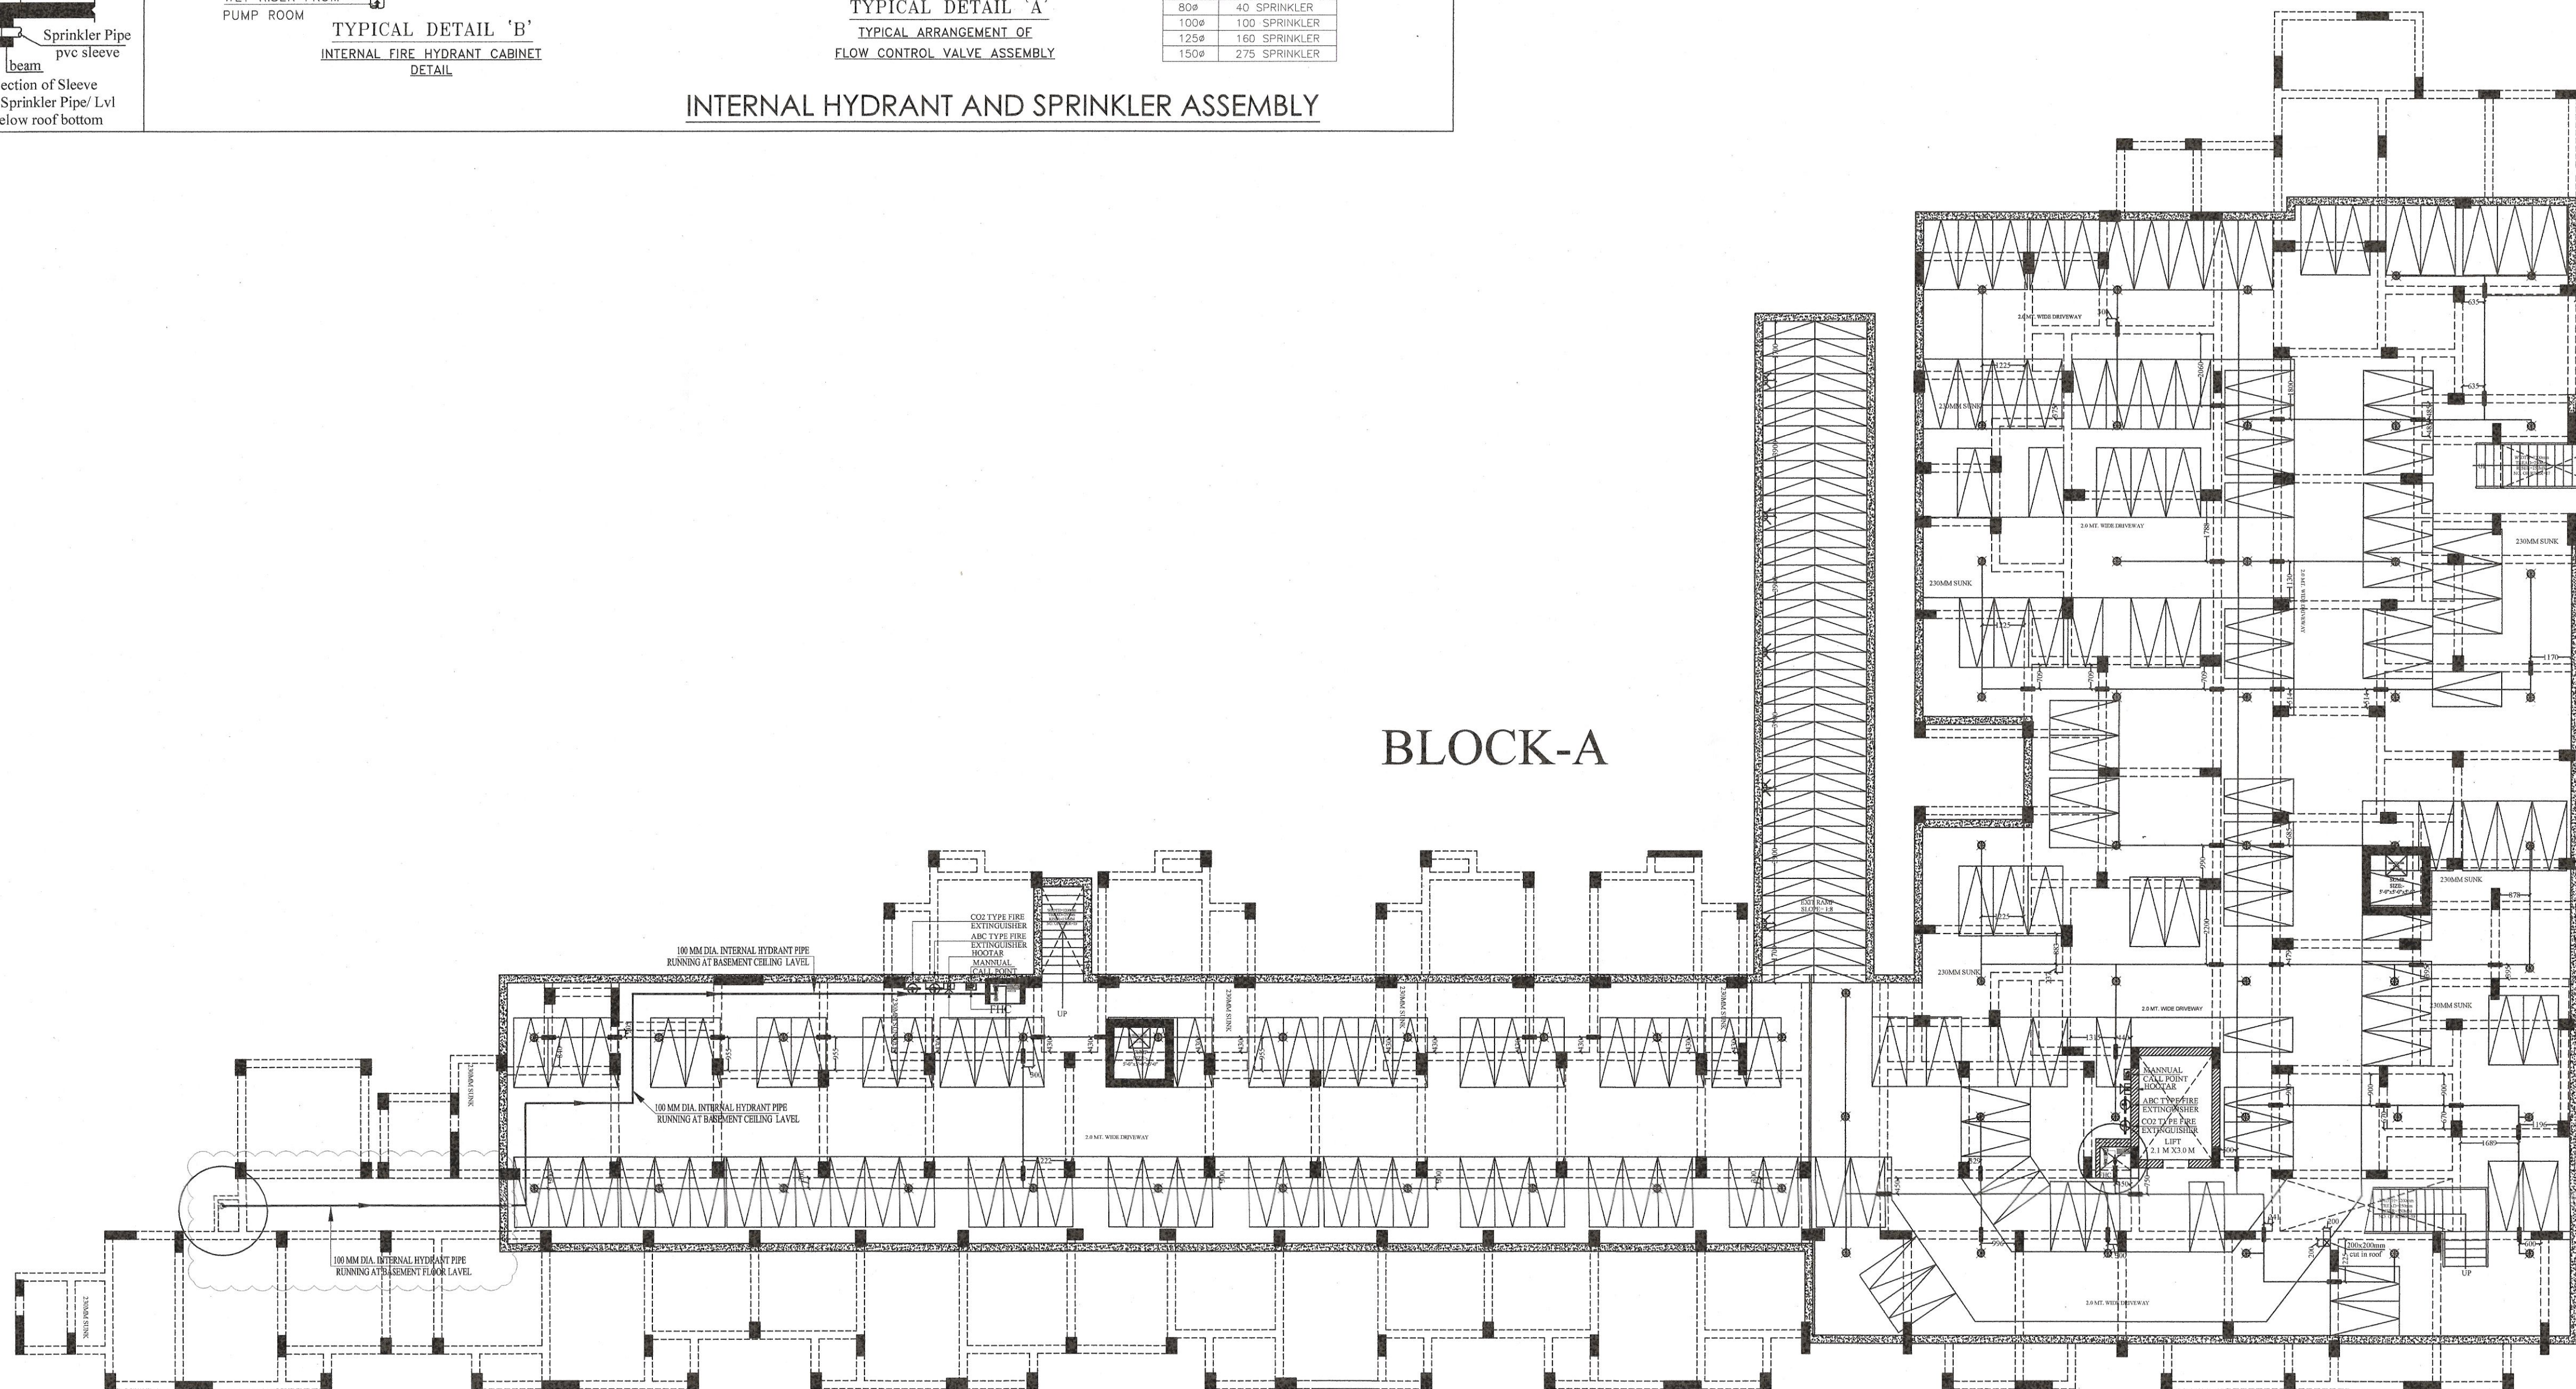


BLOCK-A

PILLARPLUS PVT LTD-The New Age MEP Consultancy Firm
Plot No. 45,46 guru jambheshwar Nagar A,
Vijay Dwar, Gandhipath, Jaipur-302021

JAIPUR | GURGAON | BANGLORE

PillarPlus
Email: contact@pillarplus.com | Contact No: +91-9799858301 | Website: www.pillarplus.com

ARCHITECT:

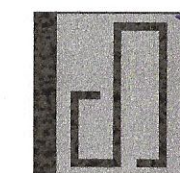

SKYLINE PLANNERS & DESIGN DEVELOPERS
ARCHITECTS . PLANNERS . INTERIOR DESIGNERS . LANDSCAPE
31, Shiv Path, Suraj Nagar (West),
Civil Lines, Jaipur - 302006 (Raj.)
Ph: 0141-2223594, Mo.: 09887483594
Email: Sddjpr@gmail.com

PROJECT DETAILS:

PROPOSED AFFORDABLE HOUSING
KHASRA NO. 622 & 631
AT VILLAGE NARSINGHPURA URF
RIKSHA,
TEHSIL SANGANER, JAIPUR.

CLINT - B3B GROUP

TITEL :-


BLOCK-A
BASEMENT FLOOR
SPRINKLER PLAN

DRAWN BY :	CHECKD BY :	APPD.:
------------	-------------	--------

RAJESH	WASEEM	RUSHIL JI
--------	--------	-----------

SHEET NO. -	DATE:-
-------------	--------

DATE : 14-06-2023

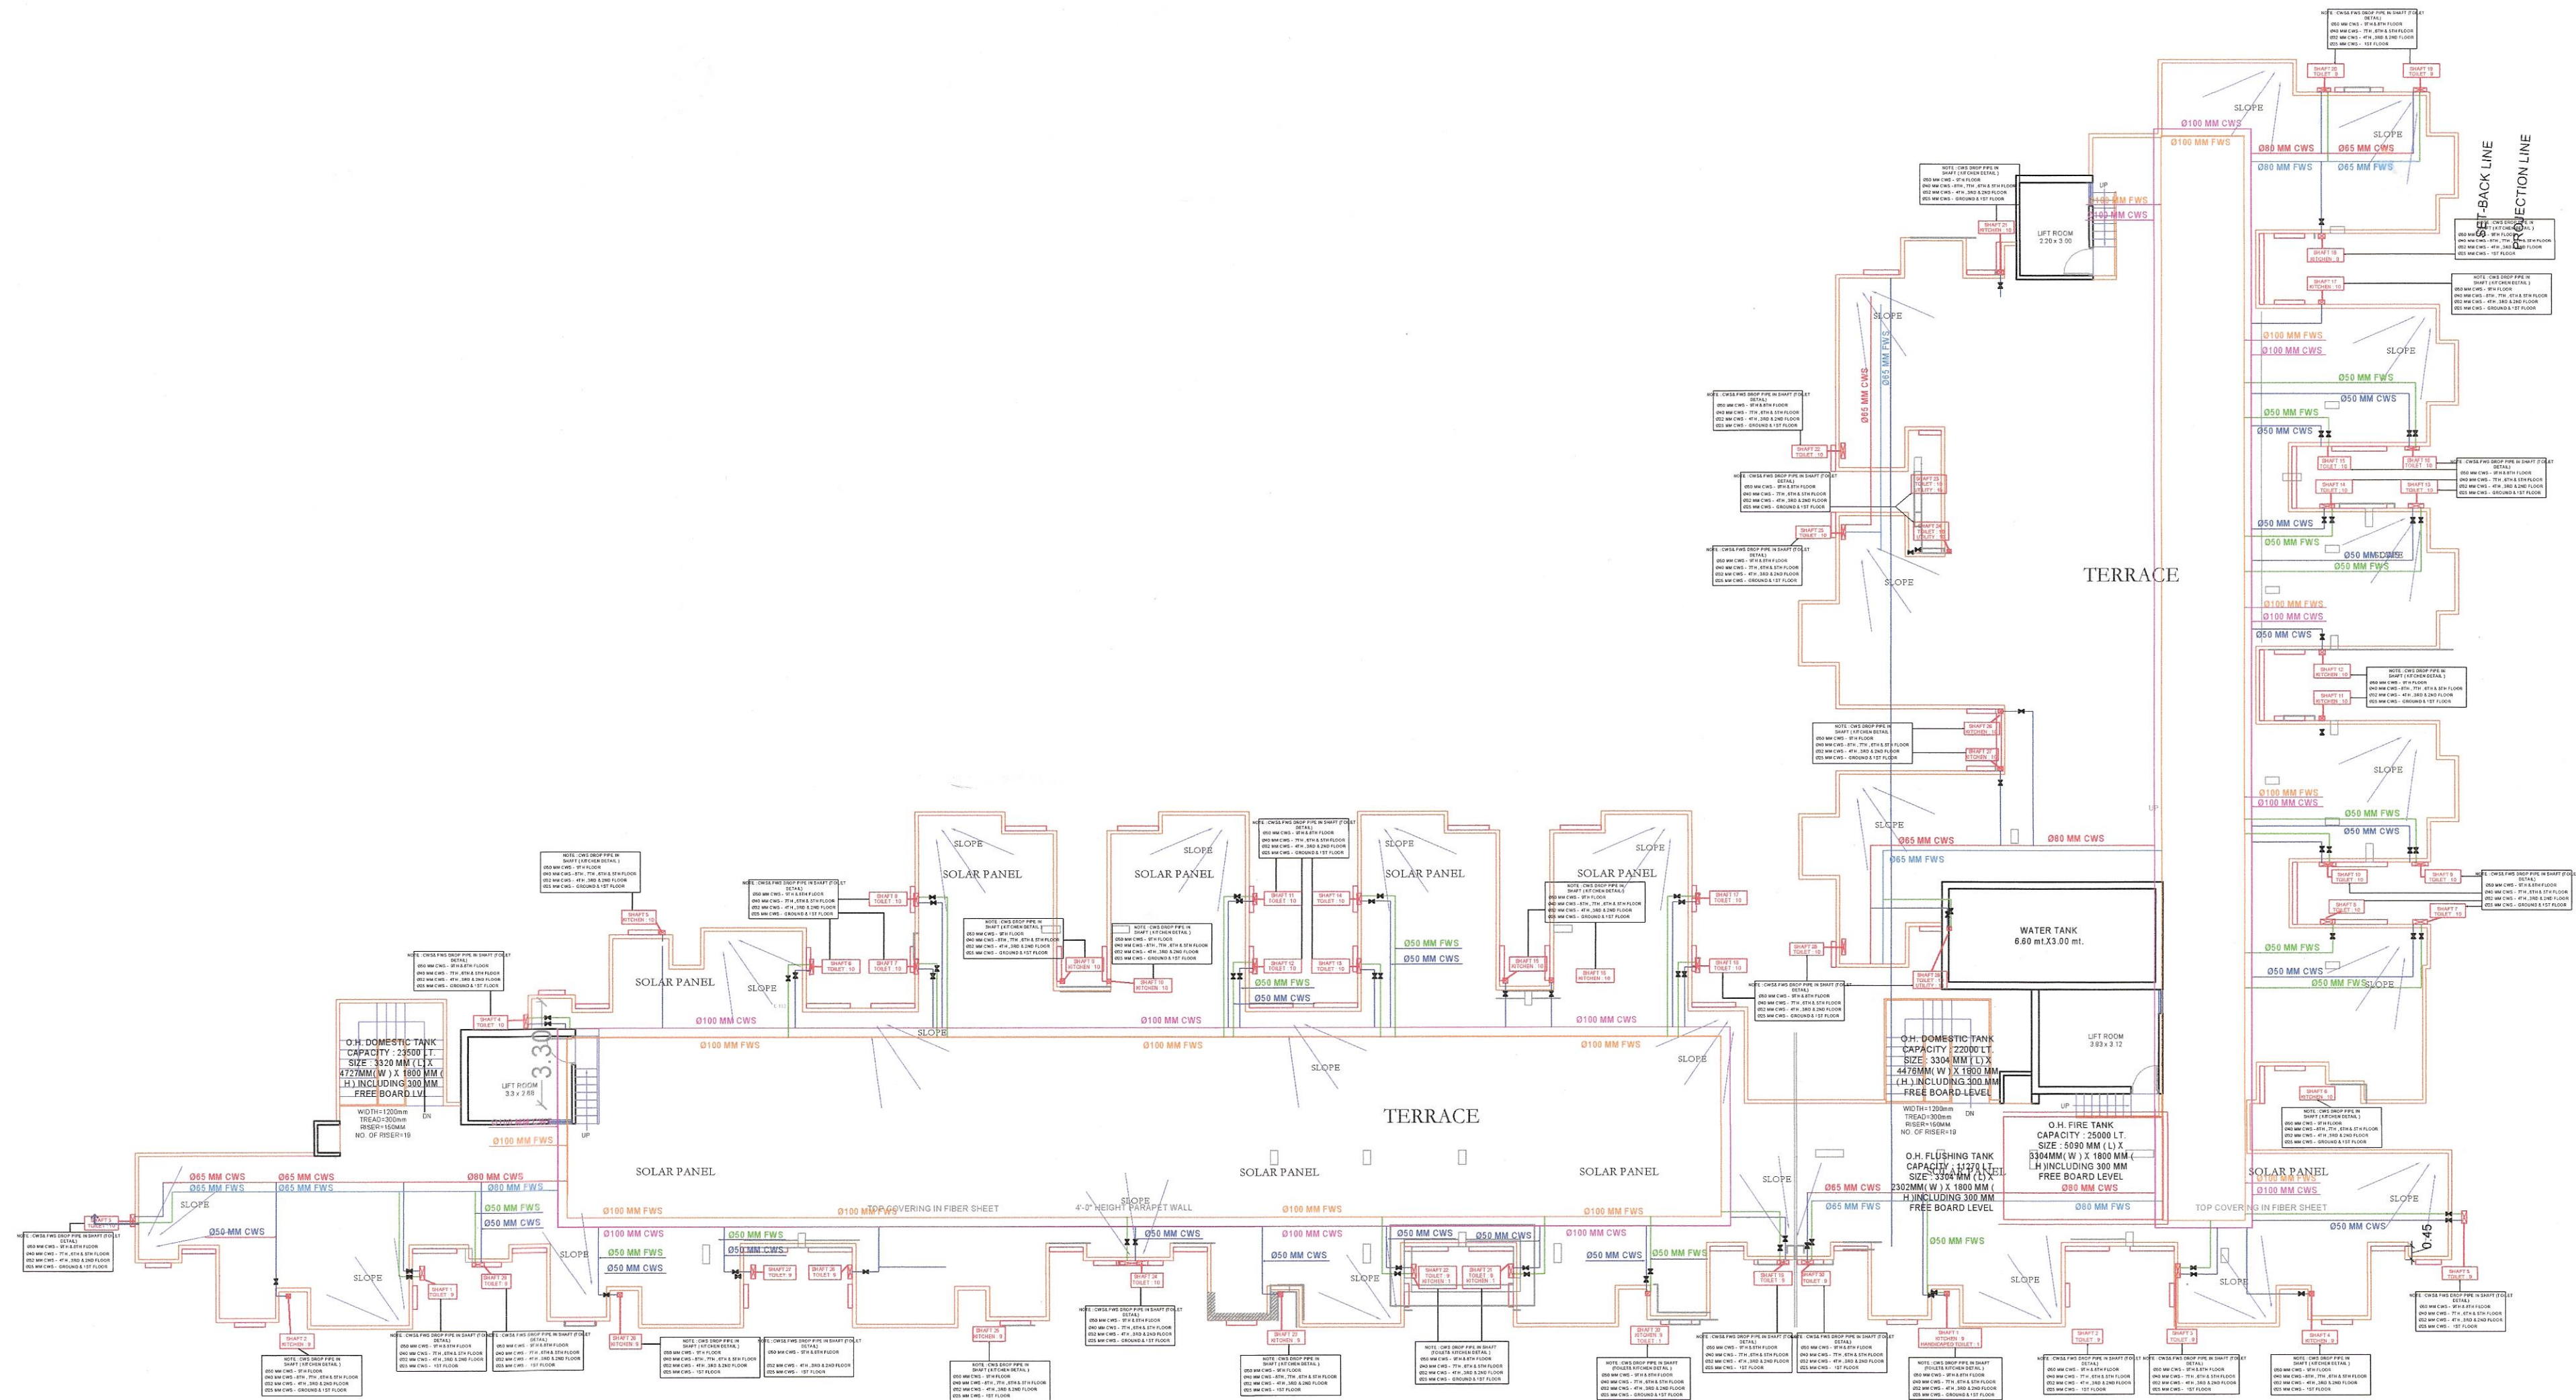

NOTE:- DRAWING APPROVAL BY EMPANELLED ARCHITECT ACCORDING TO LETTER NO. क प 18(36) निवि / एनएचपी / 2014/ पार्ट DATED 31 MAY 2017

DRAWING TYPE:-

SUBMISSION DRAWINGS

PROJECT:-

PROPOSED AFFORDABLE HOUSING
KHASRA NO. 622 & 631
AT VILLAGE NARSINGHPURA URF RIKSHA ,
TEHSIL SANGANER, JAIPUR.

TITLE:-

TERRACE WATER SUPPLY

SCALE:- 1: 200

DATE:- 10-10-23

MEP Consultancy

PILLARPLUS PVT LTD-The New Age MEP Consultancy Firm
Plot No. 45,46 guru Jambheshwar Nagar A,
Vijay Dwar, Gandhipath, Jaipur-302021

JAIPUR | GURGAON | BANGLORE
Email: contact@pillarplus.com | Contact No: +91-9799858369 | Website: www.pillarplus.com