




Ramesh Kumar
(VP - PHE & Fire)

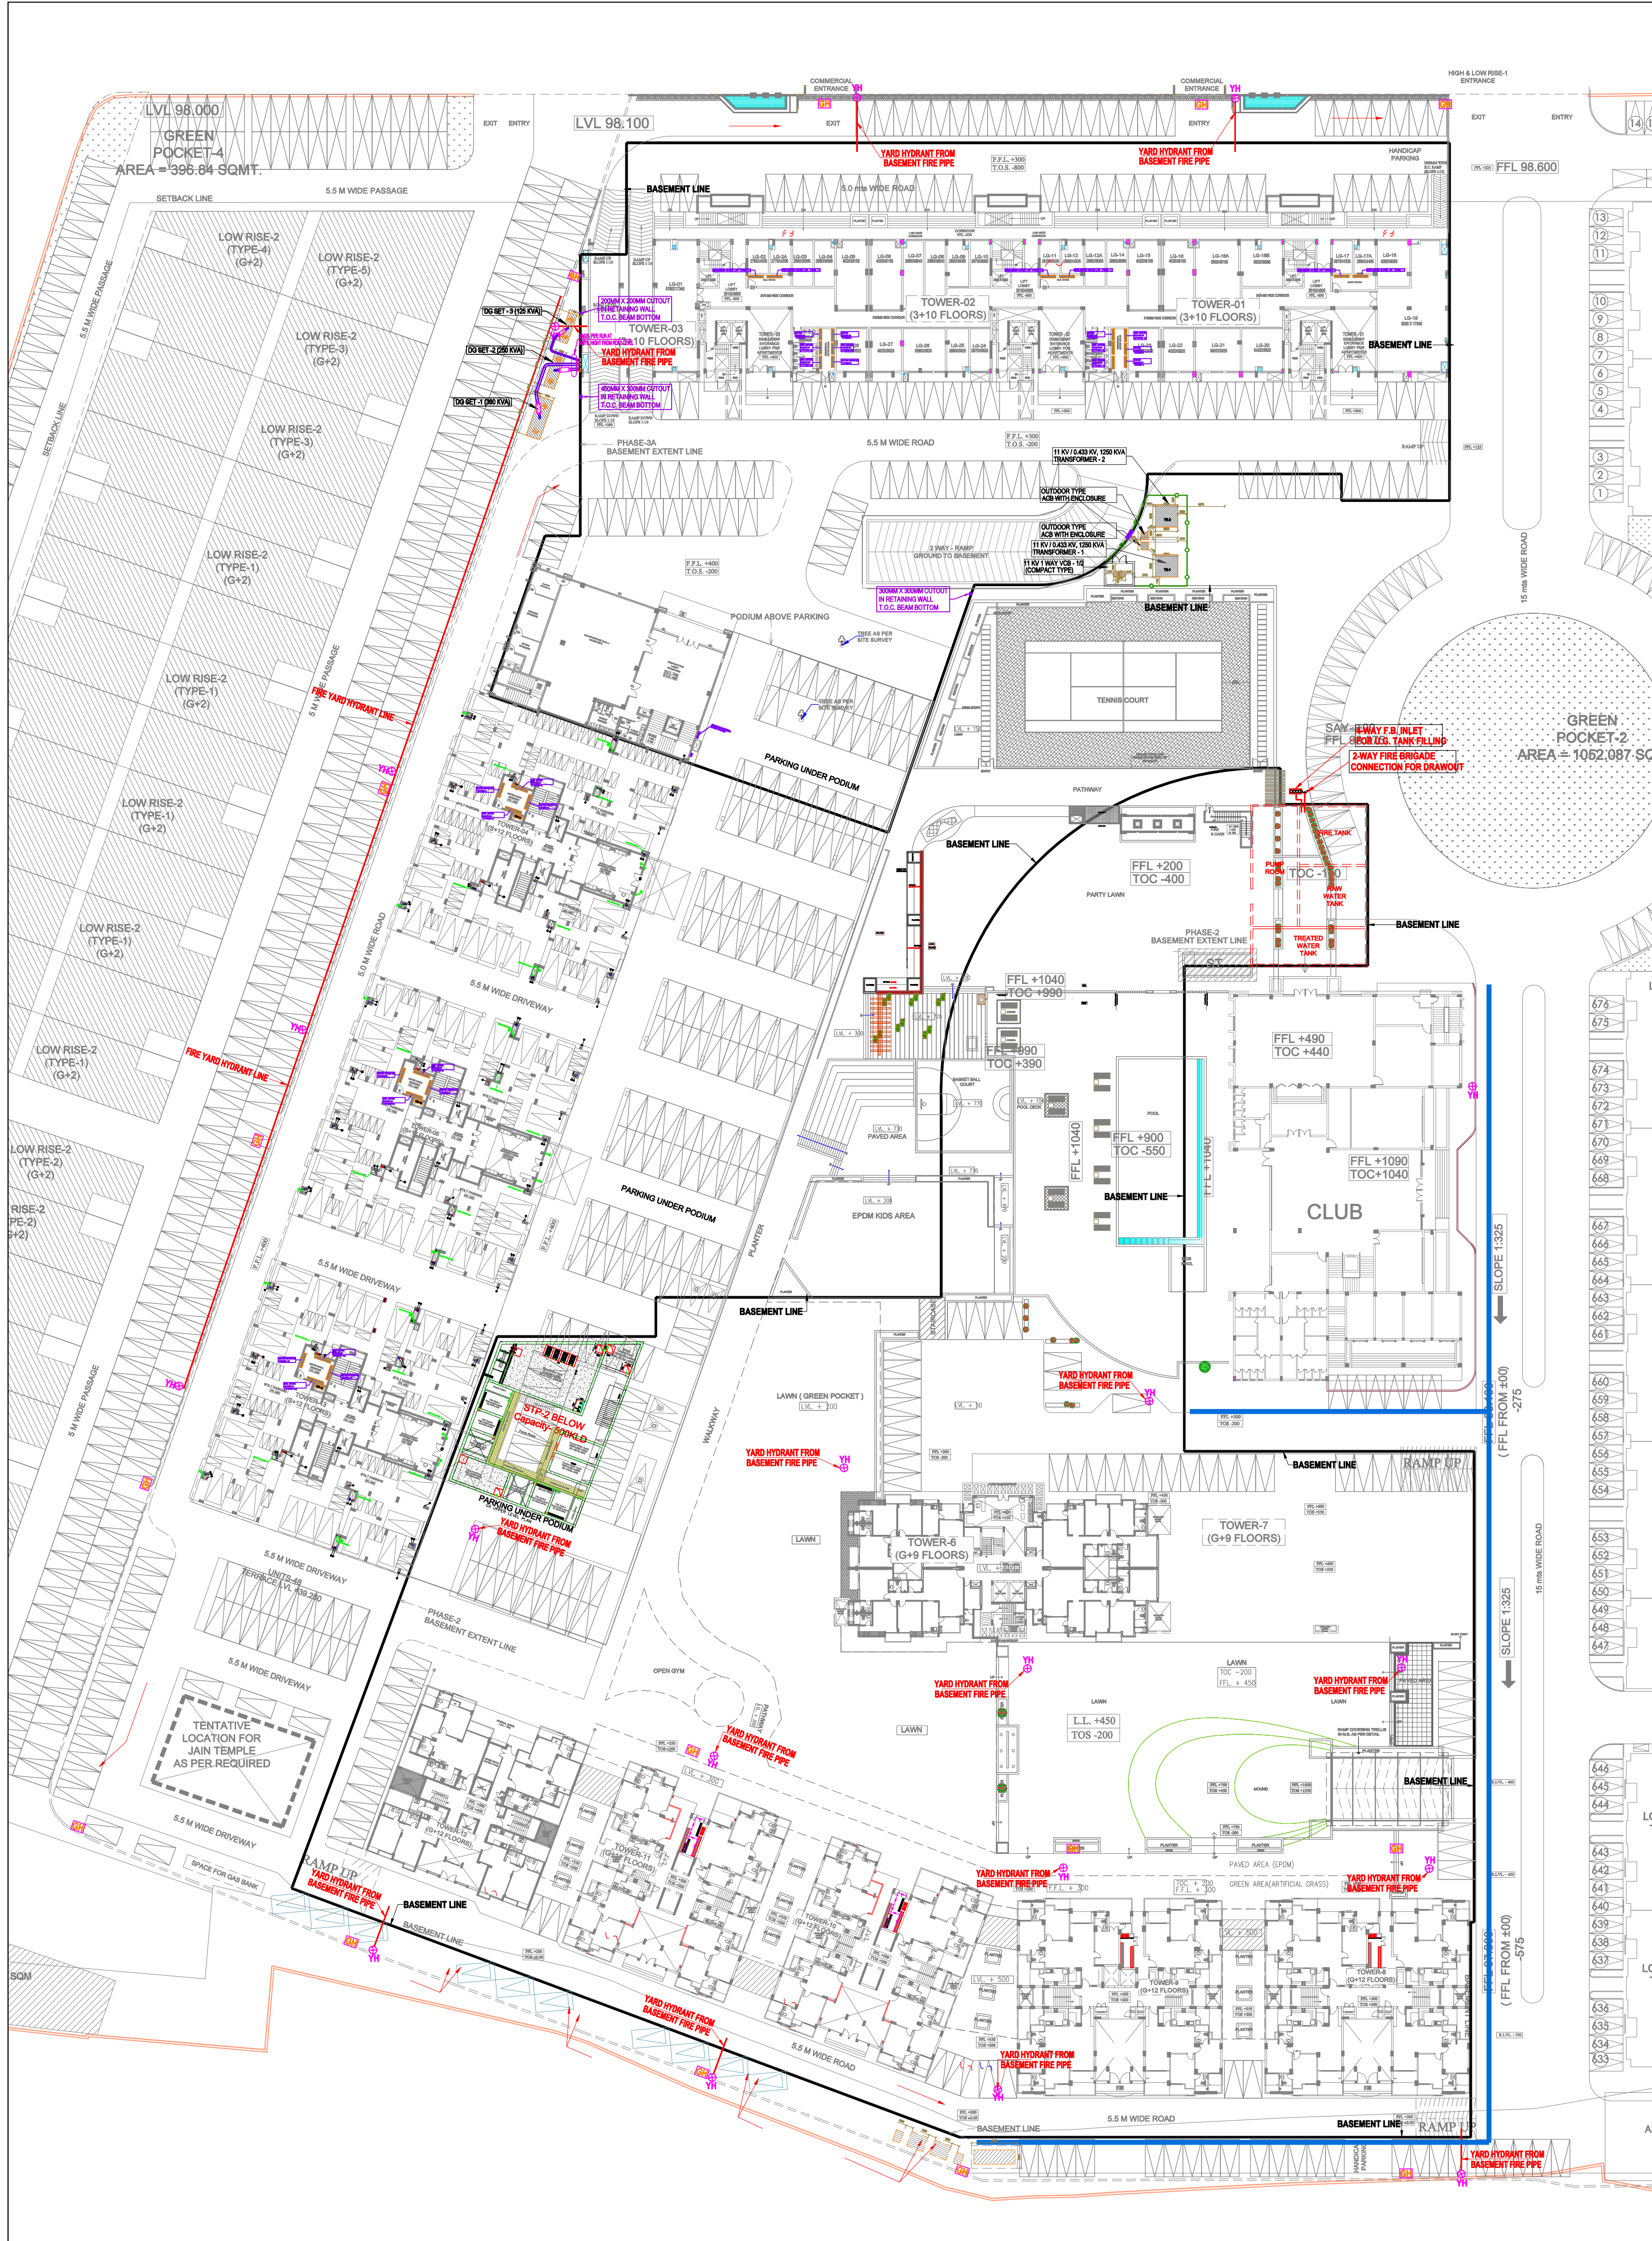

GIAN P. MATHUR
ARCHITECT
B. Arch., M.C.A., A.I.I.A.
CA No 80/5769

LEGEND :

S. No.	SYMBOL	DESCRIPTION
1.	M.H.	MANHOLE
2.	□	SEWER LINE
3.	□	BYPASS MANHOLE
4.	□	BYPASS SEWER LINE
5.	C.P.	CATCH PIT
6.	—	UNDER GROUND DRAIN
7.	—	RISING MAIN WATER PIPE LINE.
8.	—	MUNICIPAL WATER SUPPLY PIPE LINE.
9.	—	DOMESTIC WATER SUPPLY PIPE LINE.
10.	—	FLUSHING WATER SUPPLY PIPE LINE.
11.	—	ISOLATING VALVE
12.	—	PROPOSED TUBE WELL
13.	—	BASEMENT LINE
14.	GH	GARDEN HYDRANT

LEGEND : FIRE SYSTEM

S. No.	SYMBOL	DESCRIPTION
1.	—	FIRE LINE
2.	YH	YARD HYDRANT 63 M.M. DIA. SINGLE HEADED HYDRANT VALVE WITH 2 NOS. 15 M. LONG, 63 M.M. DIA. FIRE HOSE PIPE & 1 NO. BRANCH PIPE WITH NOZZLE
3.	—	FIRE BRIGADE CONNECTION
4.	—	BUTTERFLY VALVE
5.	—	NONRETURN VALVE (CHECK VALVE)
6.	—	ISOLATING VALVE WITH MASONARY CHAMBER

Project

AANANDA PHASE-3b
JAIPUR

Title

SITE PLAN

Subtitle

EXTERNAL COMBINED SERVICES
Fire Fighting, Yard hydrant layout

Drawing released for

- ☐ APPROVAL
☐ ADVANCE COPY
☐ SUBMISSION
☒ CONSTRUCTION

Drg. no.

M.A. / EX / PH-2 / S-05

Scale

A1@ 1:470

Date

Sep. 2017

Drawn by

MAK

Designed by

R.K.

Checked by

Anand Havela

Architects

GIAN P. MATHUR
ARCHITECT
& PLANNERS

GIAN P. MATHUR AND ASSOCIATES (P) LTD.
C - 55, East Of Kailash, New Delhi-110065
T : 011-46599599 / F 011-46599512
E : gpma@airtelmail.in / W : www.gpmindia.com

Services Consultant

Consummate Engineering Services (P) Ltd.

Noida Office : B - 67, Sector - 67, Noida - 201 301
Tel : (0120) 6943500 (23 Lines)
Lko. Office : R 006, Rohas Plumeria, Gomti Nagar, Lucknow
Tel : (0522) 4025902
e mail : mail@cespln, website : www.cespln