


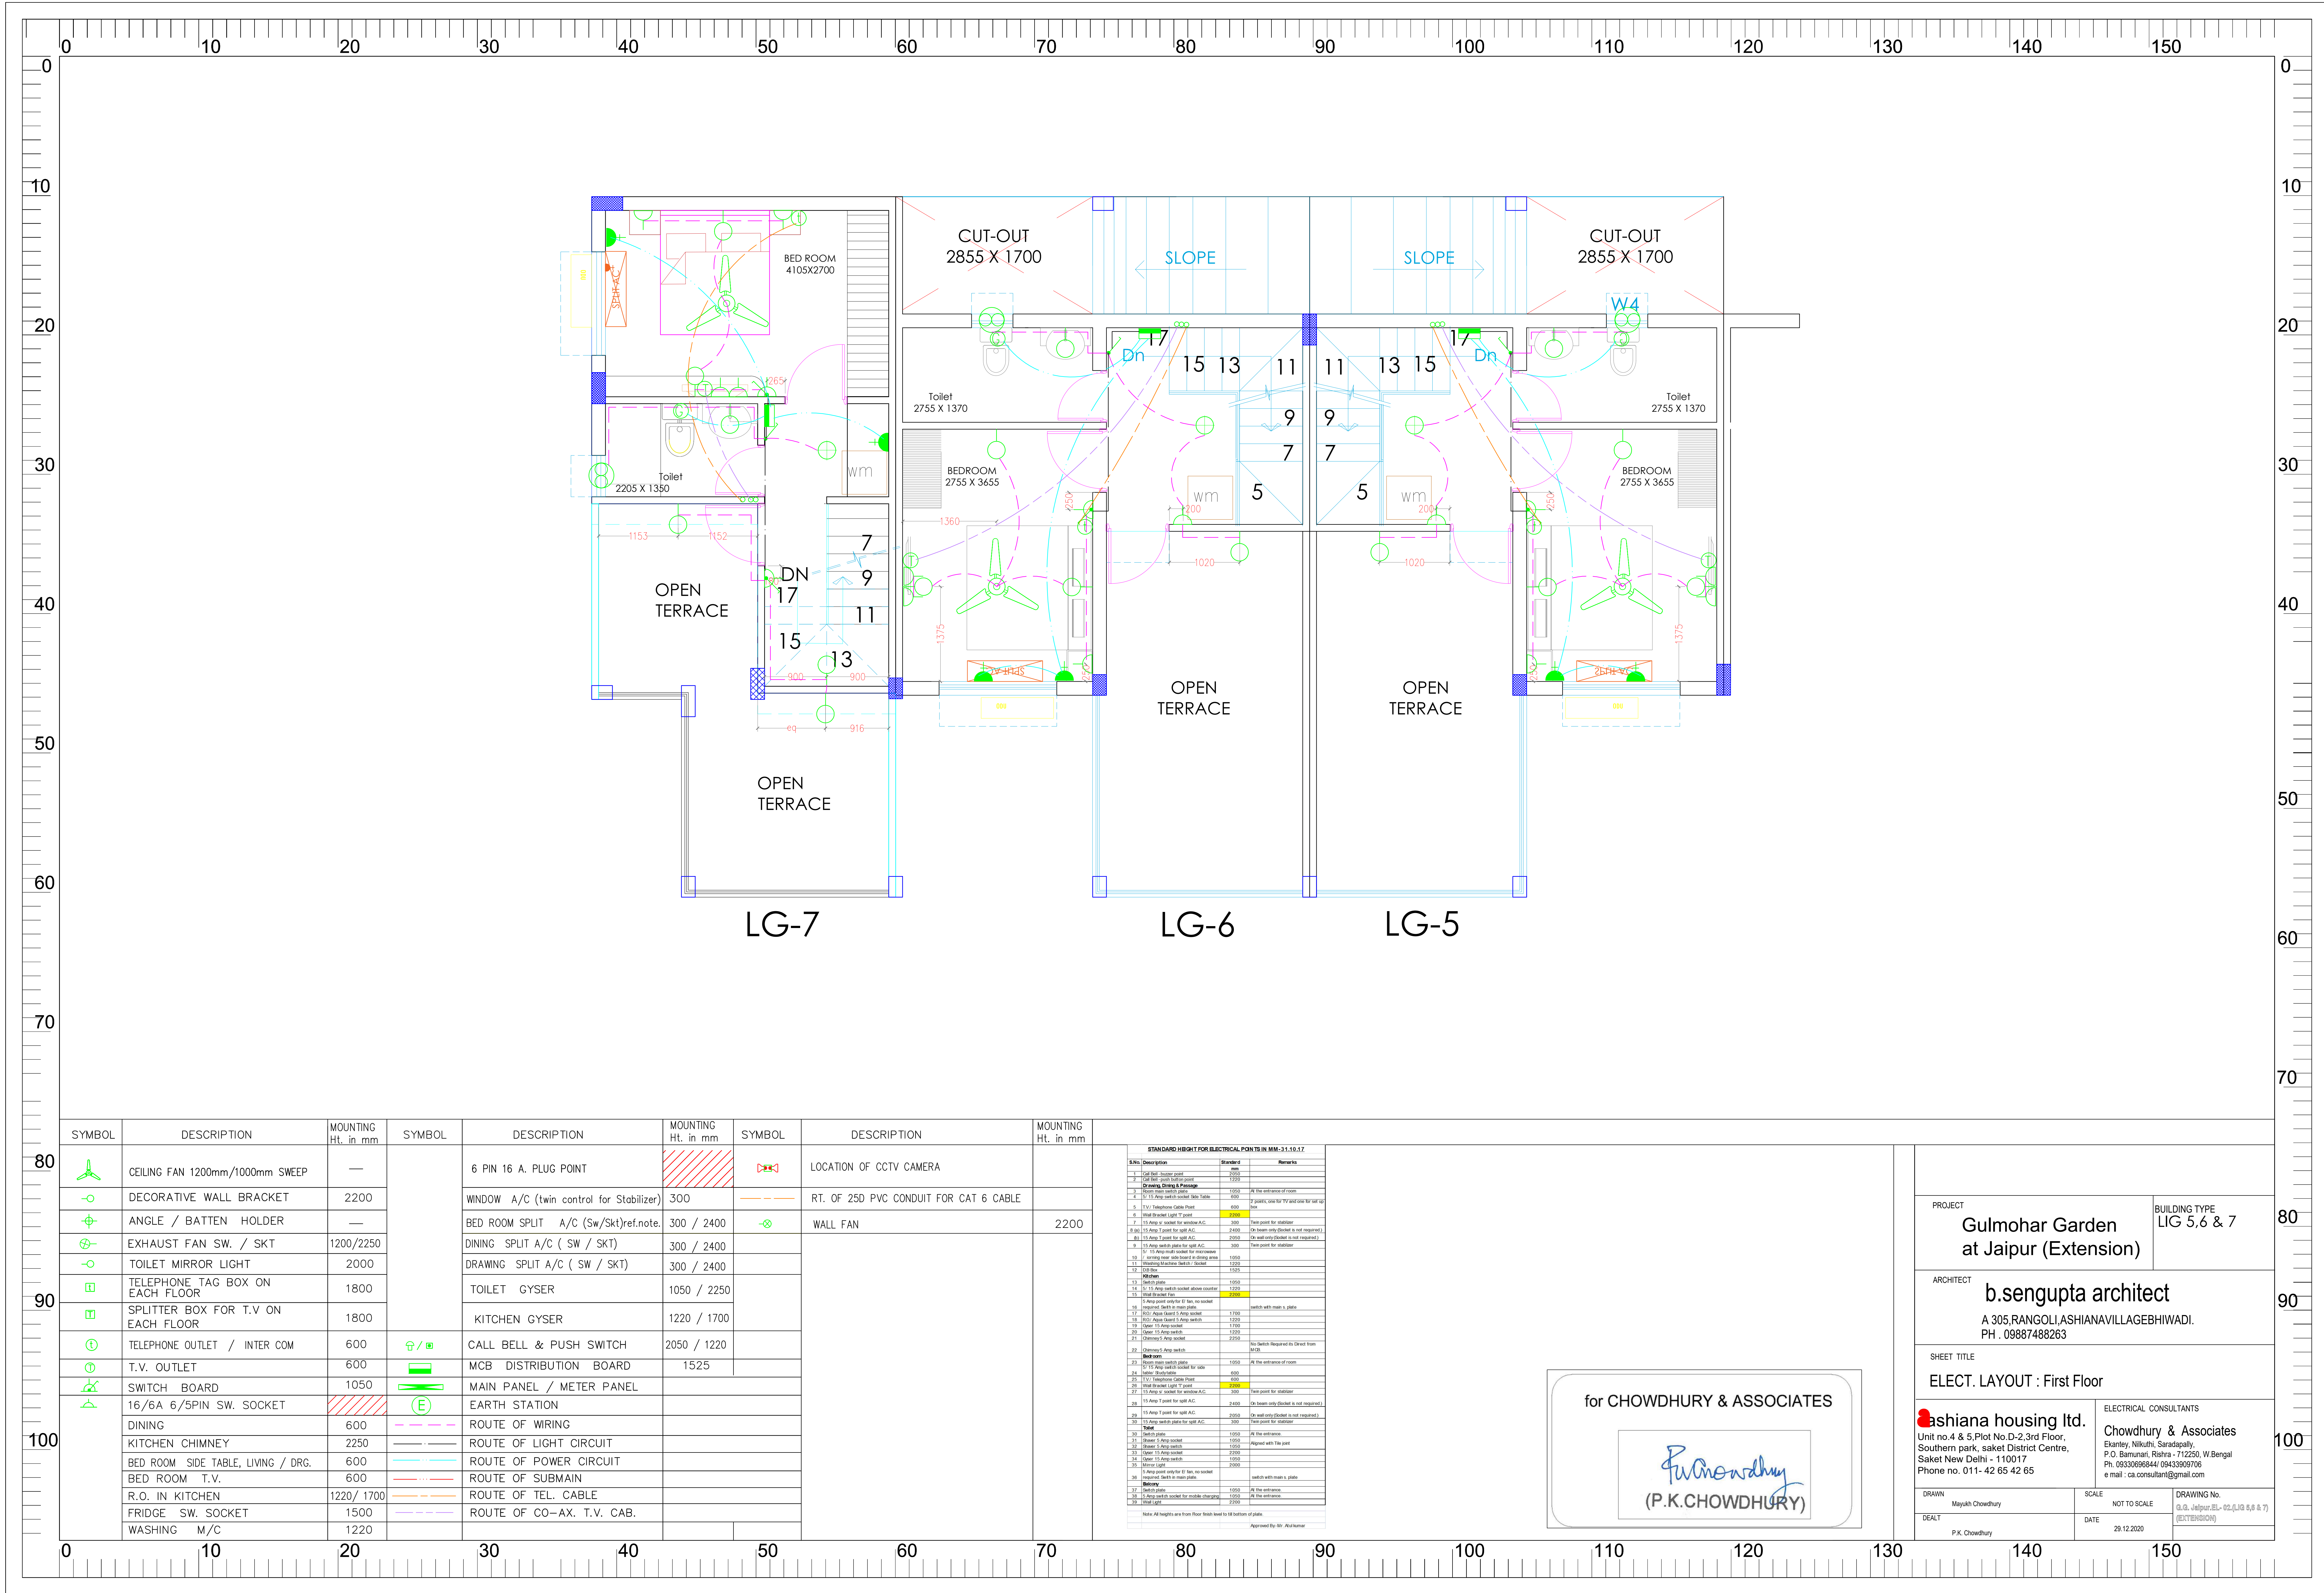


SYMBOL	DESCRIPTION	MOUNTING Ht. in mm	SYMBOL	DESCRIPTION	MOUNTING Ht. in mm	SYMBOL	DESCRIPTION	MOUNTING Ht. in mm
	CEILING FAN 1200mm/1000mm SWEEP	—		6 PIN 16 A. PLUG POINT			LOCATION OF CCTV CAMERA	
	DECORATIVE WALL BRACKET	2200		WINDOW A/C (twin control for Stabilizer)	300		RT. OF 25D PVC CONDUIT FOR CAT 6 CABLE	
	ANGLE / BATTEN HOLDER	—		BED ROOM SPLIT A/C (Sw/Skt)ref.note.	300 / 2400		WALL FAN	2200
	EXHAUST FAN SW. / SKT	1200/2250		DINING SPLIT A/C (SW / SKT)	300 / 2400			
	TOILET MIRROR LIGHT	2000		DRAWING SPLIT A/C (SW / SKT)	300 / 2400			
	TELEPHONE TAG BOX ON EACH FLOOR	1800		TOILET GYSER	1050 / 2250			
	SPLITTER BOX FOR T.V. ON EACH FLOOR	1800		KITCHEN GYSER	1220 / 1700			
	TELEPHONE OUTLET / INTER COM	600		CALL BELL & PUSH SWITCH	2050 / 1220			
	T.V. OUTLET	600		MCB DISTRIBUTION BOARD	1525			
	SWITCH BOARD	1050		MAIN PANEL / METER PANEL				
	16/6A 6/5PIN SW. SOCKET			EARTH STATION				
	DINING	600		ROUTE OF WIRING				
	KITCHEN CHIMNEY	2250		ROUTE OF LIGHT CIRCUIT				
	BED ROOM SIDE TABLE, LIVING / DRG.	600		ROUTE OF POWER CIRCUIT				
	BED ROOM T.V.	600		ROUTE OF SUBMAIN				
	R.O. IN KITCHEN	1220/ 1700		ROUTE OF TEL. CABLE				
	FRIDGE SW. SOCKET	1500		ROUTE OF CO-AX. T.V. CAB.				
	WASHING M/C	1220						


STANDARD HEIGHT FOR ELECTRICAL POINTS IN MM-3.1.10.1.2		
S.No.	Description	Standard
1	Light Switch, Switch point	1800
2	Light Switch, Switch point	2200
3	Decorative Wall Bracket	2200
4	Decorative Wall Bracket	2200
5	TV / Telephone Cable Point	600
6	Wall Bracket Light T. point	2000
7	15 Amp 1 point for split A/C	2400
8	15 Amp 1 point for split A/C	2400
9	15 Amp 1 point for split A/C	2400
10	15 Amp 1 point for split A/C	2400
11	15 Amp 1 point for split A/C	2400
12	15 Amp 1 point for split A/C	2400
13	15 Amp 1 point for split A/C	2400
14	15 Amp 1 point for split A/C	2400
15	15 Amp 1 point for split A/C	2400
16	15 Amp 1 point for split A/C	2400
17	15 Amp 1 point for split A/C	2400
18	15 Amp 1 point for split A/C	2400
19	15 Amp 1 point for split A/C	2400
20	15 Amp 1 point for split A/C	2400
21	15 Amp 1 point for split A/C	2400
22	15 Amp 1 point for split A/C	2400
23	15 Amp 1 point for split A/C	2400
24	15 Amp 1 point for split A/C	2400
25	15 Amp 1 point for split A/C	2400
26	15 Amp 1 point for split A/C	2400
27	15 Amp 1 point for split A/C	2400
28	15 Amp 1 point for split A/C	2400
29	15 Amp 1 point for split A/C	2400
30	15 Amp 1 point for split A/C	2400
31	15 Amp 1 point for split A/C	2400
32	15 Amp 1 point for split A/C	2400
33	15 Amp 1 point for split A/C	2400
34	15 Amp 1 point for split A/C	2400
35	15 Amp 1 point for split A/C	2400
36	15 Amp 1 point for split A/C	2400
37	15 Amp 1 point for split A/C	2400
38	15 Amp 1 point for split A/C	2400
39	15 Amp 1 point for split A/C	2400
40	15 Amp 1 point for split A/C	2400
41	15 Amp 1 point for split A/C	2400
42	15 Amp 1 point for split A/C	2400
43	15 Amp 1 point for split A/C	2400
44	15 Amp 1 point for split A/C	2400
45	15 Amp 1 point for split A/C	2400
46	15 Amp 1 point for split A/C	2400
47	15 Amp 1 point for split A/C	2400
48	15 Amp 1 point for split A/C	2400
49	15 Amp 1 point for split A/C	2400
50	15 Amp 1 point for split A/C	2400

for CHOWDHURY & ASSOCIATES


P.K. Chowdhury
(P.K.CHOWDHURY)

PROJECT Gulmohar Garden at Jaipur (Extension)		BUILDING TYPE LIG 5,6 & 7
ARCHITECT b.sengupta architect A 305,RANGOLI,ASHIANAVILLAGEBHIWADI. PH . 09887488263		
SHEET TITLE ELECT. LAYOUT : First Floor		
Ashiana housing Ltd. Unit no.4 & 5 Plot No.D-2,3rd Floor, Southern park, saket District Centre, Saket New Delhi - 110017 Phone no. 011- 42 65 42 65		ELECTRICAL CONSULTANTS Chowdhury & Associates Ekantey, Nilkuthi, Saradapally, P.O. Baramuni, Rishra - 712250, W.Bengal Ph. 08330696844/ 08433059706 e mail : ca_consultant@gmail.com
DRAWN Mayank Chowdhury	SCALE NOT TO SCALE	DRAWING No. G.D. Jaipur-EL-02(LIG 5,6 & 7) (EXTENSION)
DEALT P.K. Chowdhury	DATE 29.12.2020	

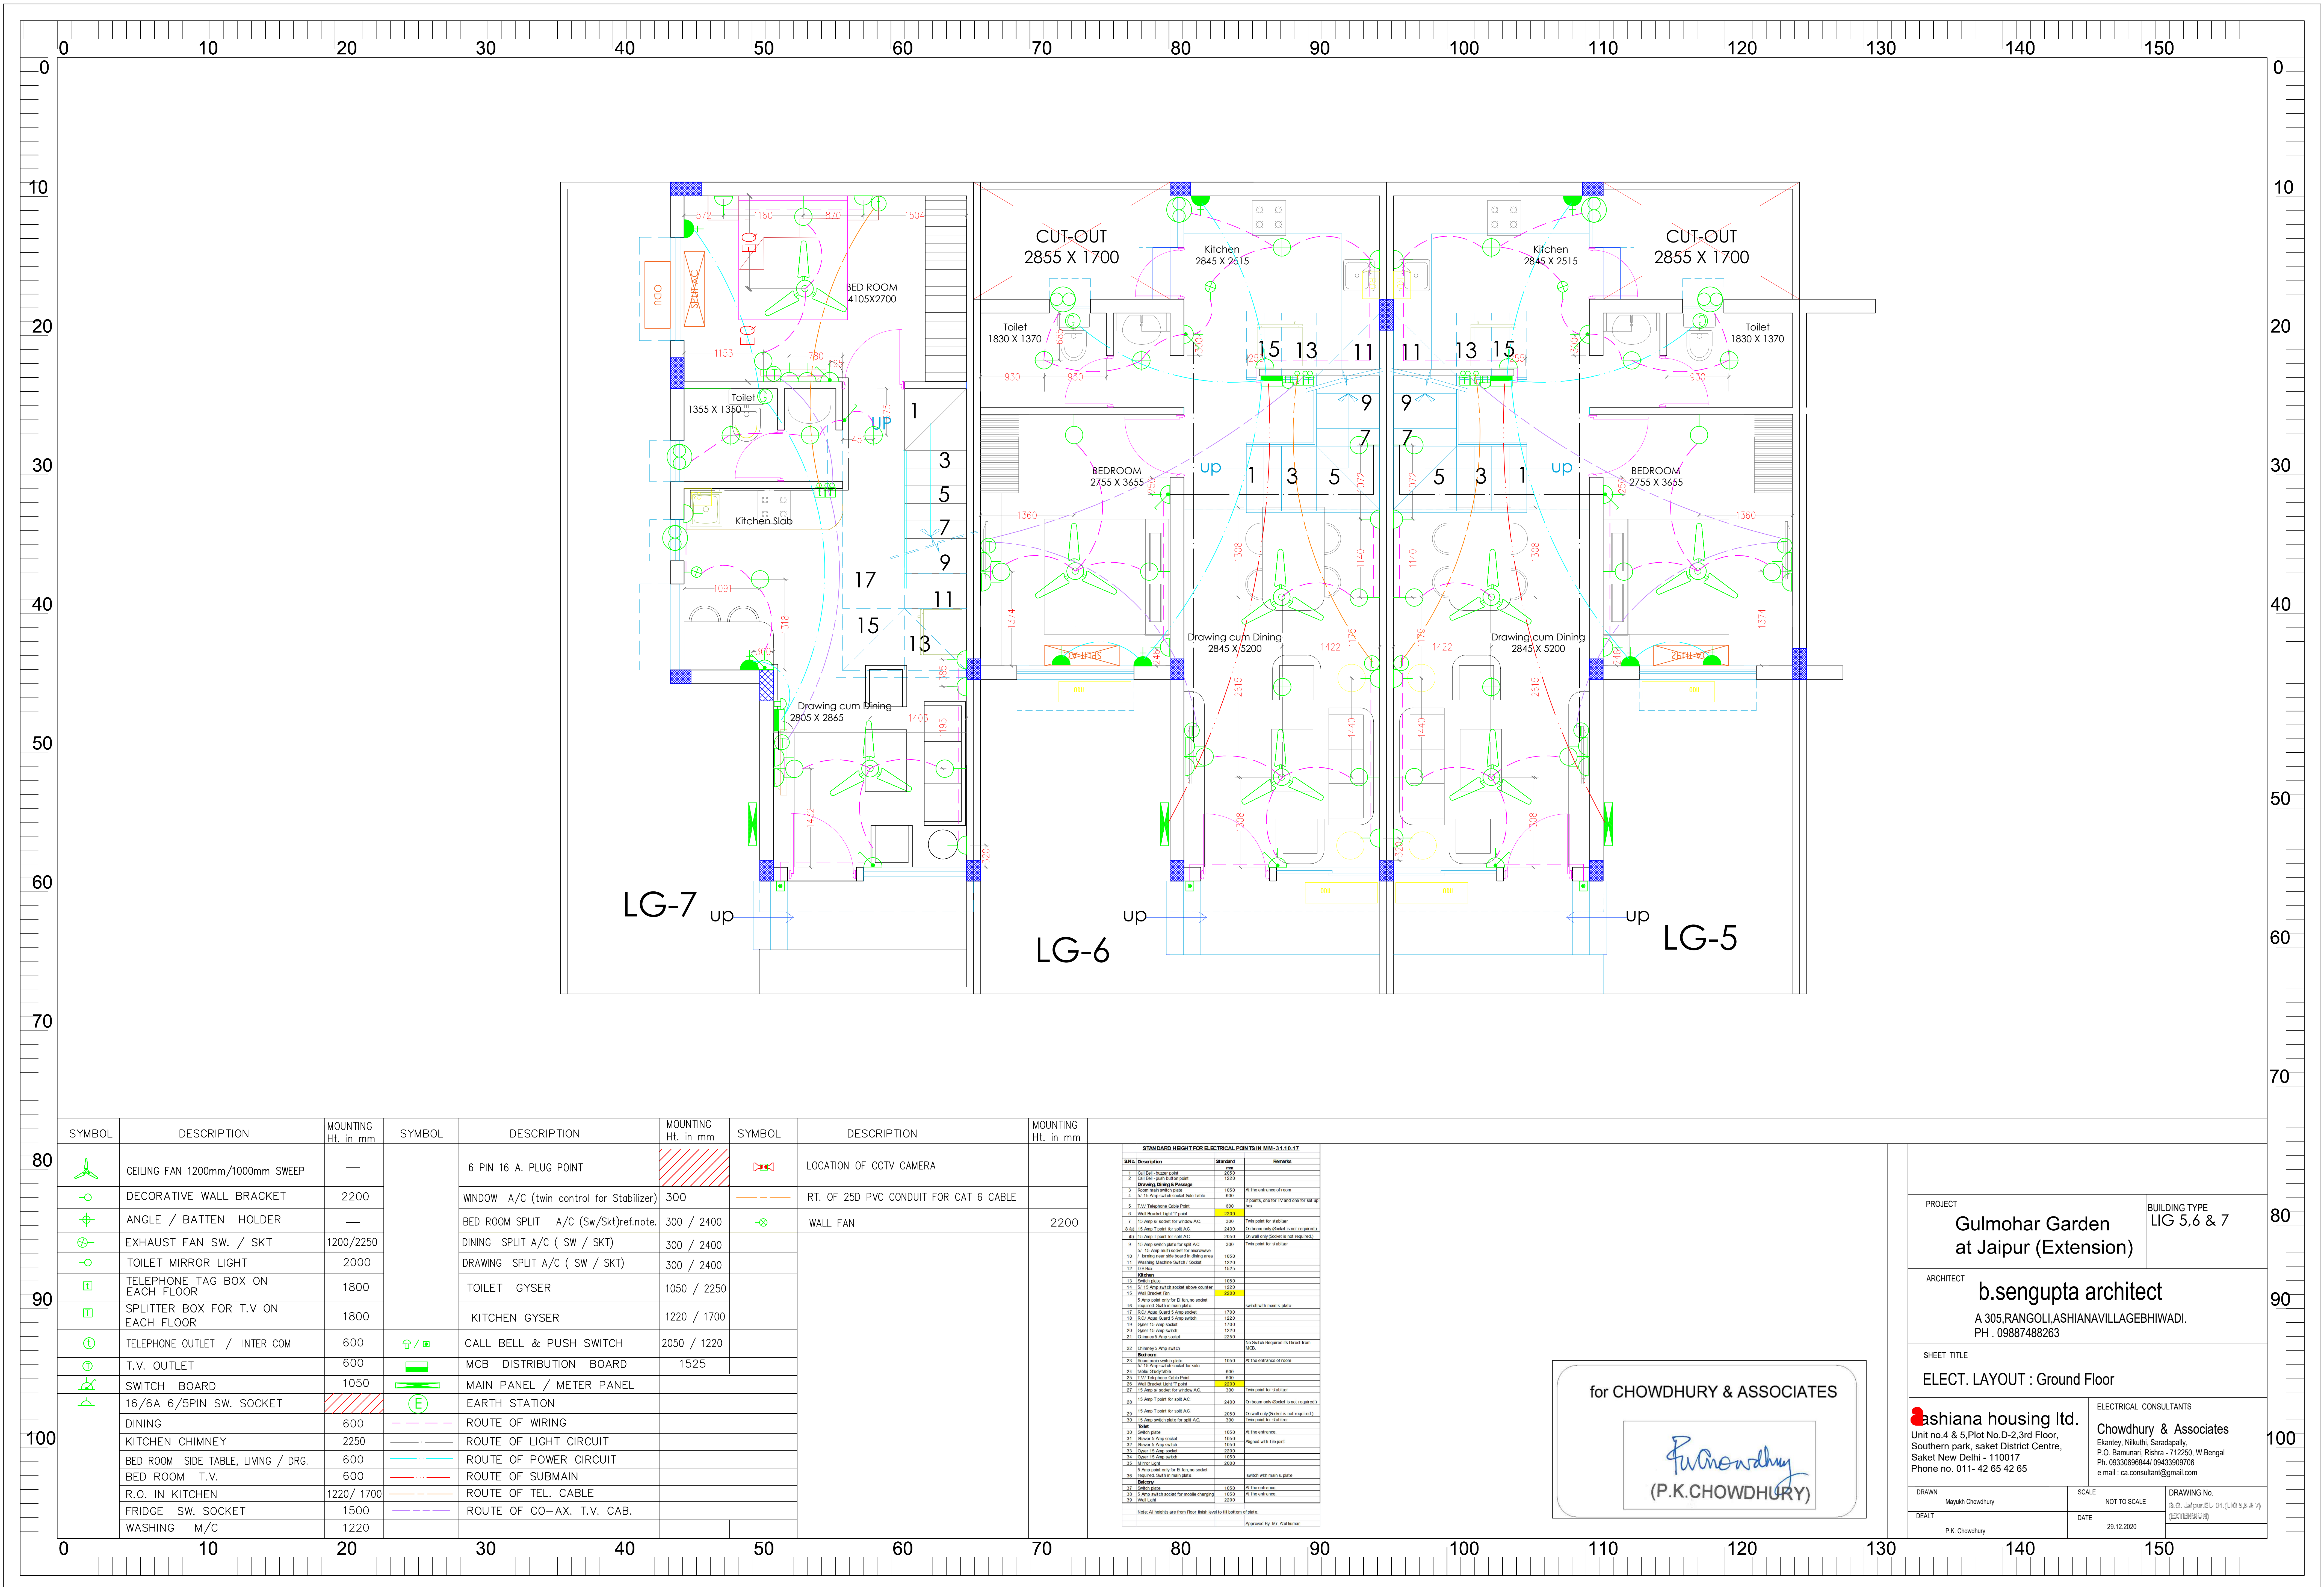

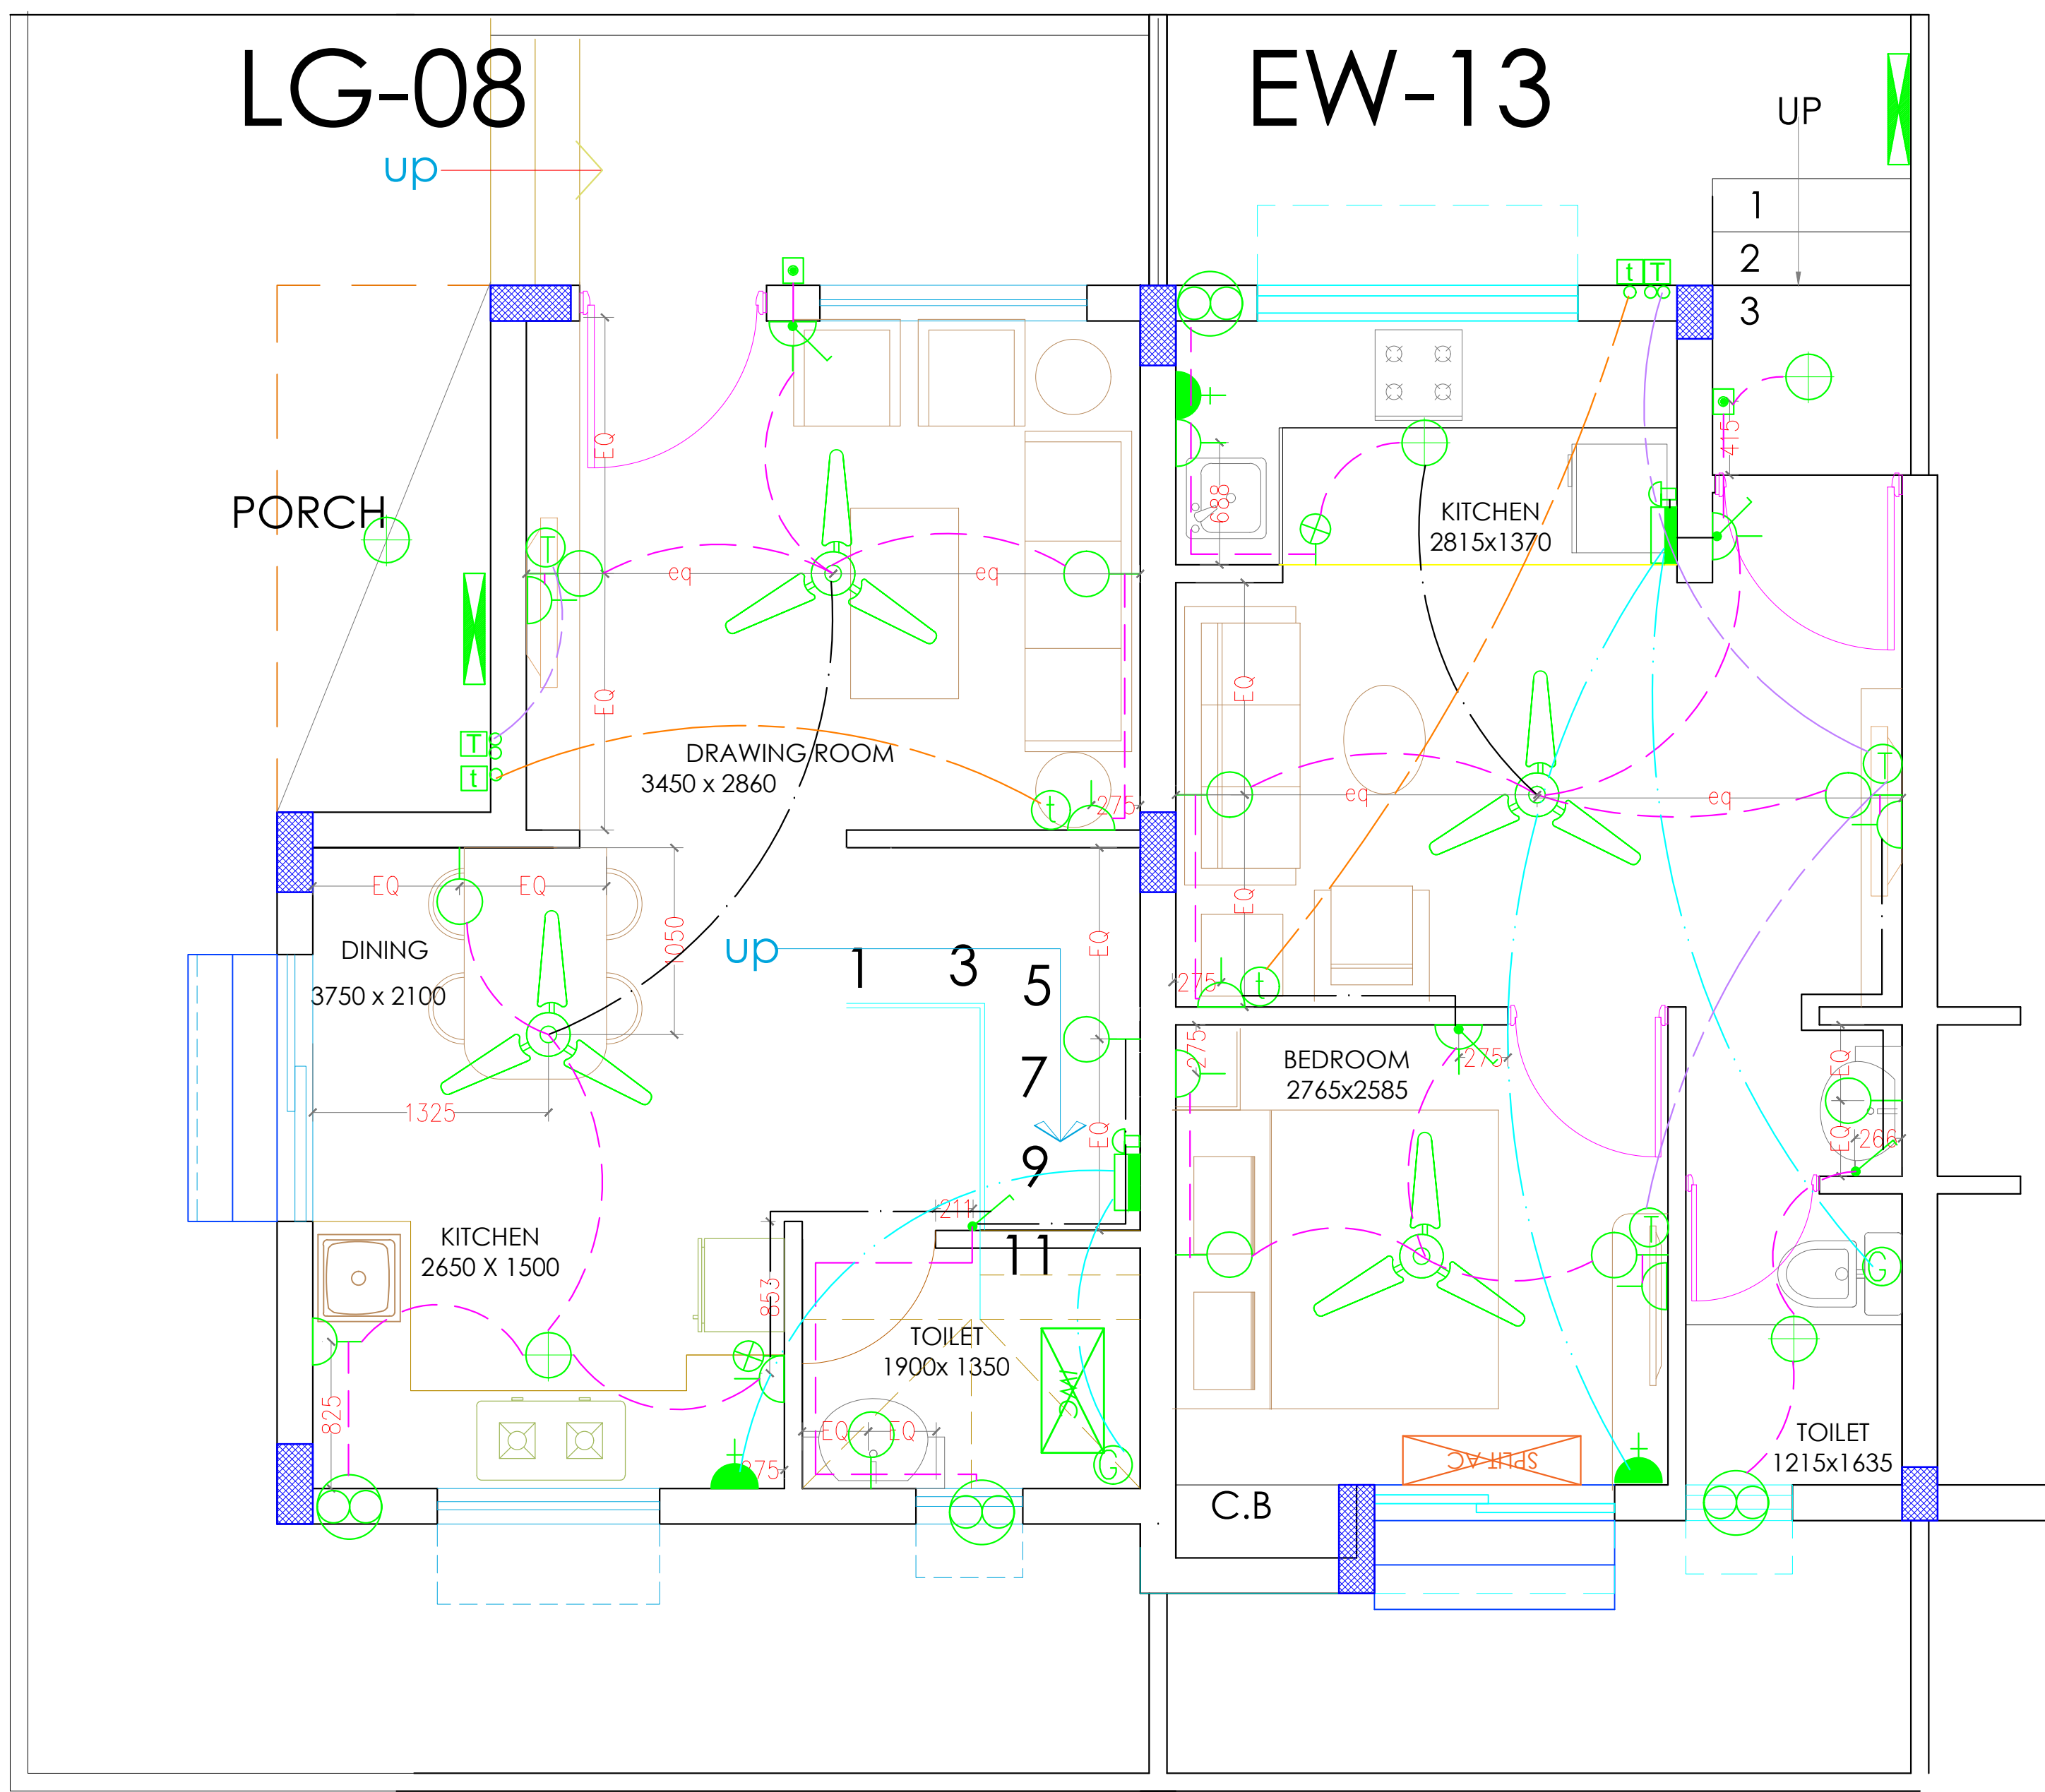

LG-08 EW-13
GROUND FLOOR PLAN

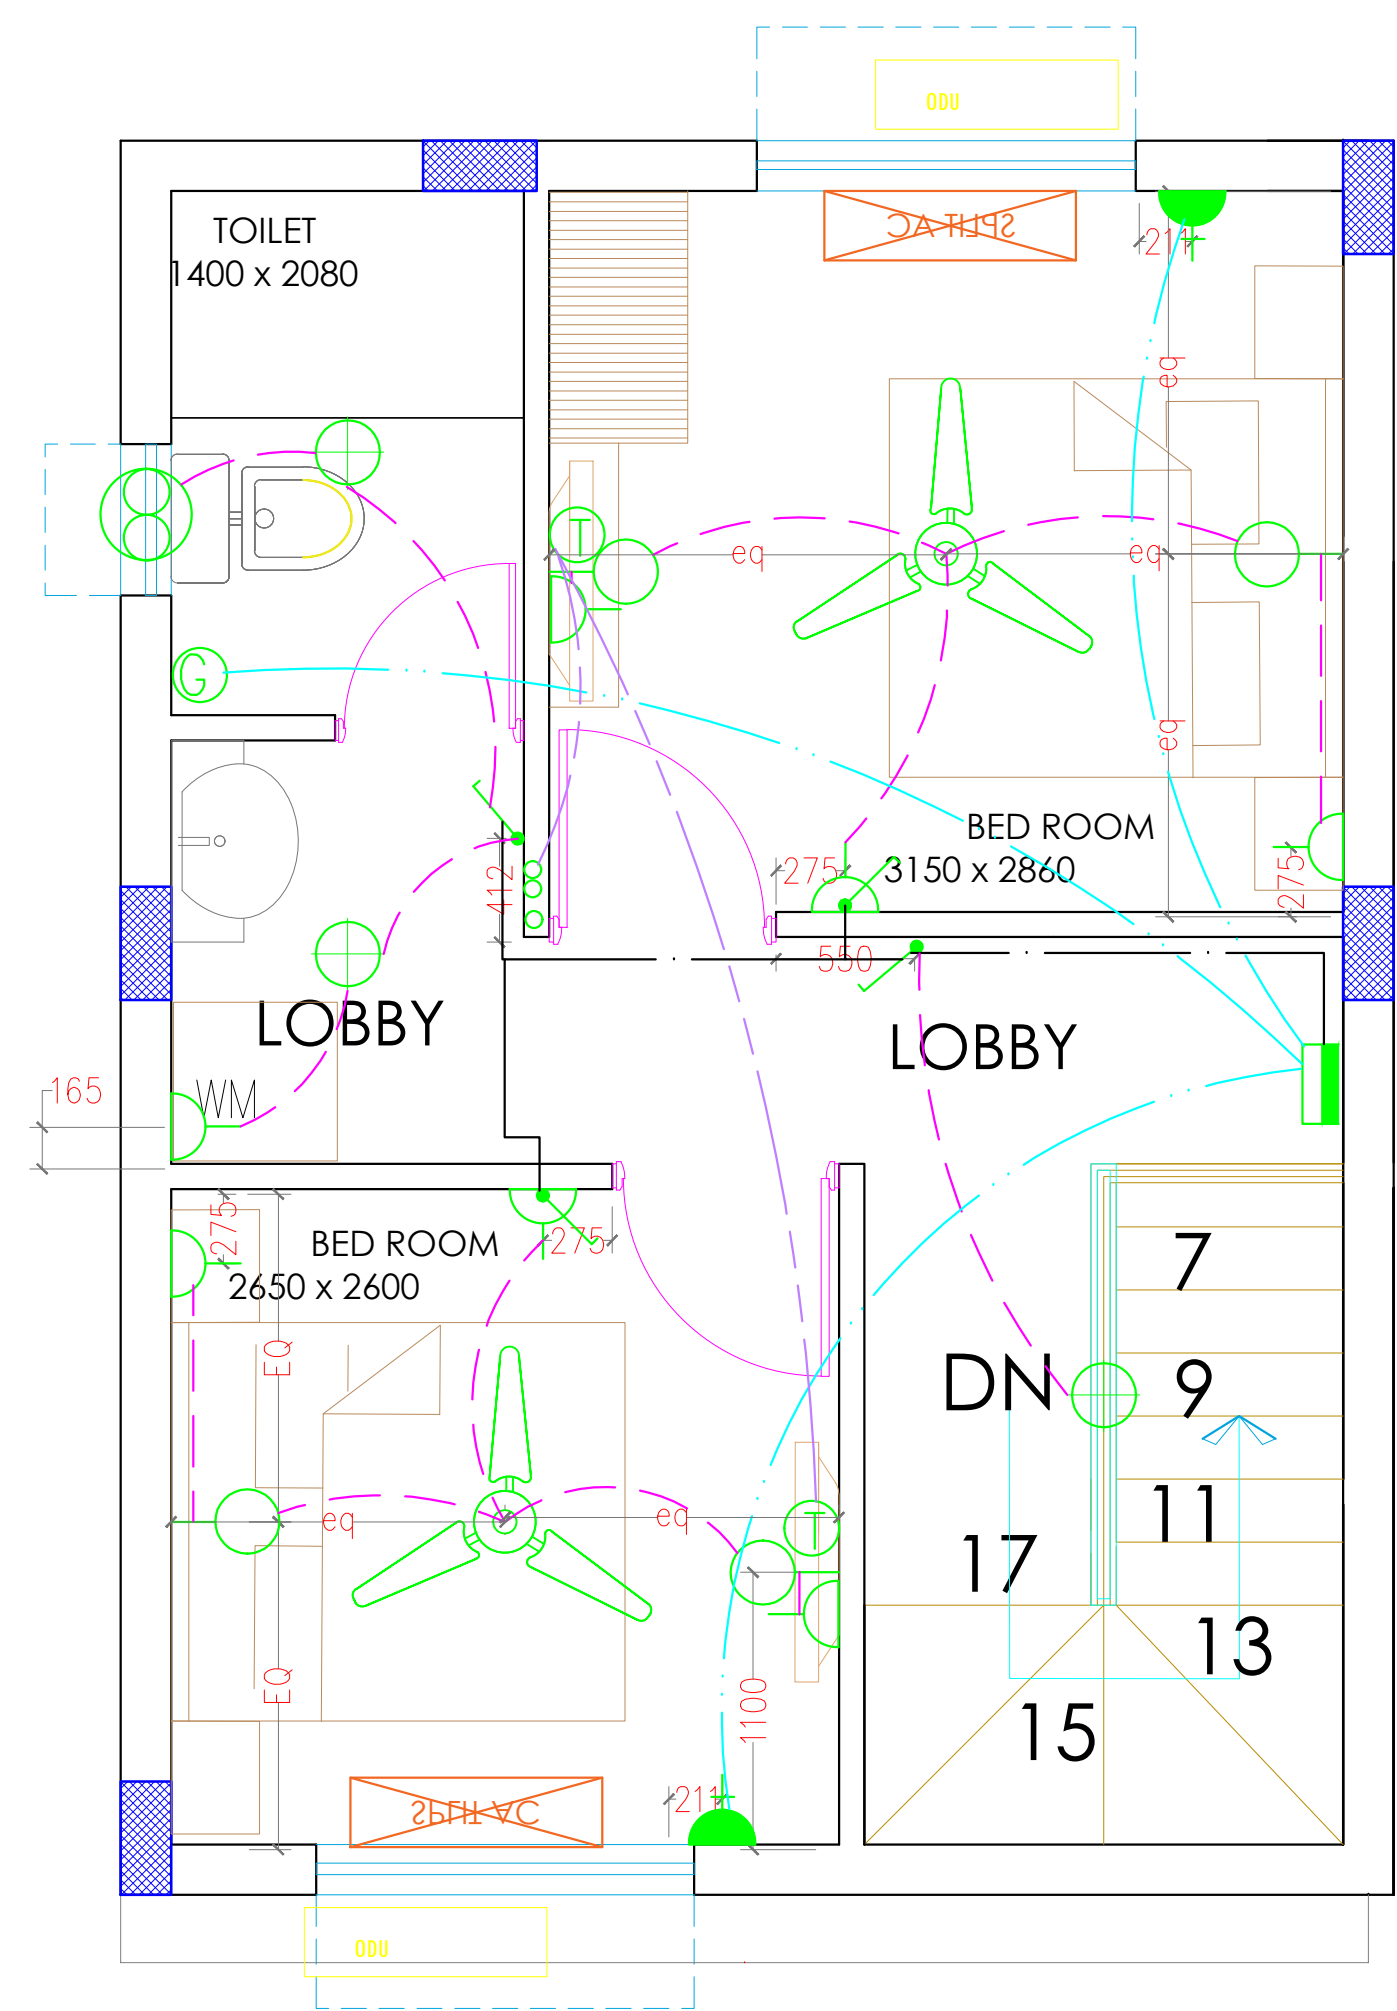

LG-08
FIRST FLOOR PLAN

SYMBOL	DESCRIPTION	MOUNTING Ht. in mm	SYMBOL	DESCRIPTION	MOUNTING Ht. in mm
	CEILING FAN 1200mm/1000mm SWEEP	—		6 PIN 16 A. PLUG POINT	—
	DECORATIVE WALL BRACKET	2200		WINDOW A/C (twin control for Stabilizer)	300
	ANGLE / BATTEN HOLDER	—		BED ROOM SPLIT A/C (Sw/Skt)ref.note.	300 / 2400
	EXHAUST FAN SW. / SKT	1200/2250		DINING SPLIT A/C (SW / SKT)	300 / 2400
	TOILET MIRROR LIGHT	2000		DRAWING SPLIT A/C (SW / SKT)	300 / 2400
	TELEPHONE TAG BOX ON EACH FLOOR	1800		TOILET GYSER	1050 / 2250
	SPLITTER BOX FOR T.V. ON EACH FLOOR	1800		KITCHEN GYSER	1220 / 1700
	TELEPHONE OUTLET / INTER COM	600		CALL BELL & PUSH SWITCH	2050 / 1220
	T.V. OUTLET	600		MCB DISTRIBUTION BOARD	1525
	SWITCH BOARD	1050		MAIN PANEL / METER PANEL	—
	16/6A 6/5PIN SW. SOCKET	—		EARTH STATION	—
	DINING	600		ROUTE OF WIRING	—
	KITCHEN CHIMNEY	2250		ROUTE OF LIGHT CIRCUIT	—
	BED ROOM SIDE TABLE, LIVING / DRG.	600		ROUTE OF POWER CIRCUIT	—
	BED ROOM T.V.	600		ROUTE OF SUBMAIN	—
	R.O. IN KITCHEN	1220/ 1700		ROUTE OF TEL. CABLE	—
	FRIDGE SW. SOCKET	1500		ROUTE OF CO-AX. T.V. CAB.	—
	WASHING M/C	1220			

SYMBOL	DESCRIPTION	MOUNTING Ht. in mm
	LOCATION OF CCTV CAMERA	—
	RT. OF 25D PVC CONDUIT FOR CAT 6 CABLE	—
	WALL FAN	2200

S/N	Description	Standard	Remarks
1	Call Bell - Push Switch	2050	
2	Call Bell - Push Switch	2050	
3	Decorative Wall Bracket	2200	As the entrance of room
4	Decorative Wall Bracket	2200	As the entrance of room
5	Decorative Wall Bracket	2200	As the entrance of room
6	Decorative Wall Bracket	2200	As the entrance of room
7	Decorative Wall Bracket	2200	As the entrance of room
8	Decorative Wall Bracket	2200	As the entrance of room
9	Decorative Wall Bracket	2200	As the entrance of room
10	Decorative Wall Bracket	2200	As the entrance of room
11	Decorative Wall Bracket	2200	As the entrance of room
12	Decorative Wall Bracket	2200	As the entrance of room
13	Decorative Wall Bracket	2200	As the entrance of room
14	Decorative Wall Bracket	2200	As the entrance of room
15	Decorative Wall Bracket	2200	As the entrance of room
16	Decorative Wall Bracket	2200	As the entrance of room
17	Decorative Wall Bracket	2200	As the entrance of room
18	Decorative Wall Bracket	2200	As the entrance of room
19	Decorative Wall Bracket	2200	As the entrance of room
20	Decorative Wall Bracket	2200	As the entrance of room
21	Decorative Wall Bracket	2200	As the entrance of room
22	Decorative Wall Bracket	2200	As the entrance of room
23	Decorative Wall Bracket	2200	As the entrance of room
24	Decorative Wall Bracket	2200	As the entrance of room
25	Decorative Wall Bracket	2200	As the entrance of room
26	Decorative Wall Bracket	2200	As the entrance of room
27	Decorative Wall Bracket	2200	As the entrance of room
28	Decorative Wall Bracket	2200	As the entrance of room
29	Decorative Wall Bracket	2200	As the entrance of room
30	Decorative Wall Bracket	2200	As the entrance of room
31	Decorative Wall Bracket	2200	As the entrance of room
32	Decorative Wall Bracket	2200	As the entrance of room
33	Decorative Wall Bracket	2200	As the entrance of room
34	Decorative Wall Bracket	2200	As the entrance of room
35	Decorative Wall Bracket	2200	As the entrance of room
36	Decorative Wall Bracket	2200	As the entrance of room
37	Decorative Wall Bracket	2200	As the entrance of room
38	Decorative Wall Bracket	2200	As the entrance of room
39	Decorative Wall Bracket	2200	As the entrance of room
40	Decorative Wall Bracket	2200	As the entrance of room

for CHOWDHURY & ASSOCIATES

P.K. Chowdhury
(P.K.CHOWDHURY)

PROJECT	Gulmohar Garden at Jaipur (Extension)	BUILDING TYPE	LIG & EWS
ARCHITECT	b.sengupta architect A 305,RANGOLI,ASHIANAVILLAGEBHIWADI. PH . 09887488263		
SHEET TITLE	ELECT. LAYOUT : Ground Floor & First Floor		
ashiana housing ltd.	Unit no.4 & 5,Plot No D-2,3rd Floor, Southern park, Saket District Centre, Saket New Delhi - 110017 Phone no. 011-42 65 42 65	ELECTRICAL CONSULTANTS	Chowdhury & Associates Ekantey, Nikuthi, Saradapally, P.O. Bamunari, Rishra - 712250, W.Bengal Ph. 09330696844/ 09433909706 e mail : ca.consultant@gmail.com
DRAWN	Mayukh Chowdhury	SCALE	NOT TO SCALE
DEALT	P.K. Chowdhury	DATE	28.12.2020
		DRAWING No.	01.01.2020 (EXTENSION)