

LEGEND FOR VERTICAL PIPES

- ① 110 OD uPVC SOIL & VENT PIPE
- ② 110 OD uPVC WASTE & VENT PIPE
- ③ 75 OD uPVC ANTI SYPHONAGE PIPE
- ④ DOMESTIC WATER SUPPLY PIPE D.N.TAKE PIPE
- ⑤ FLUSHING WATER SUPPLY PIPE D.N.TAKE PIPE
- ⑥ DOMESTIC WATER SUPPLY FROM HYDROPNEUMATIC SYSTEM FOR UPPER THREE FLOORS.
- ⑦ HOT WATER PIPE FROM SOLAR TO M.BED ROOM
- ⑧ 63 OD uPVC AC DRAIN PIPE
- Ⓣ FT FLOOR TRAP (110x110 mm)

FOR SUBMISSION
 ABL Hospitech Pvt. Ltd.
 New Delhi.

No.	Date	By	Description

No.	Date	By	Description

OWNERS NAME
Ashiana Housing Ltd.
 Unit no.4 & 5, Plot No.D-2, 3rd Floor,
 Southern park, Saket District Centre,
 Saket New Delhi - 110017
 Phone no. 011- 42 65 42 65


ARCHITECT:-
b.sengupta architect
A-305,RANGOLI, ASHIANA VILLAGE BHIWADI.
PH . 09887488263

Electro - Mechanical Consultants
ABL
ALL PURPOSE (P) LTD
Electro-Mechanical Consulting Engineers
 B-137, Basement, Kalkaji, New Delhi-110019
 P: +91-11-41625566, 46524180, 81, 82, 83, 84
 F: +91-11-46524182
 E-mail: abl@abhospitech.com
 ablhospitech@gmail.com


PROJECT:-
Ashiana Nirmay
AT BHIWADI

Drawing Title
GROUND FLOOR PLAN
DRAINAGE LAYOUT
(BLOCK)

Job No.	Drawing No.
Drawn S.J.	Checked N.V.
Date 18/01/2018	Scale 1:125
	Revisions DR-01

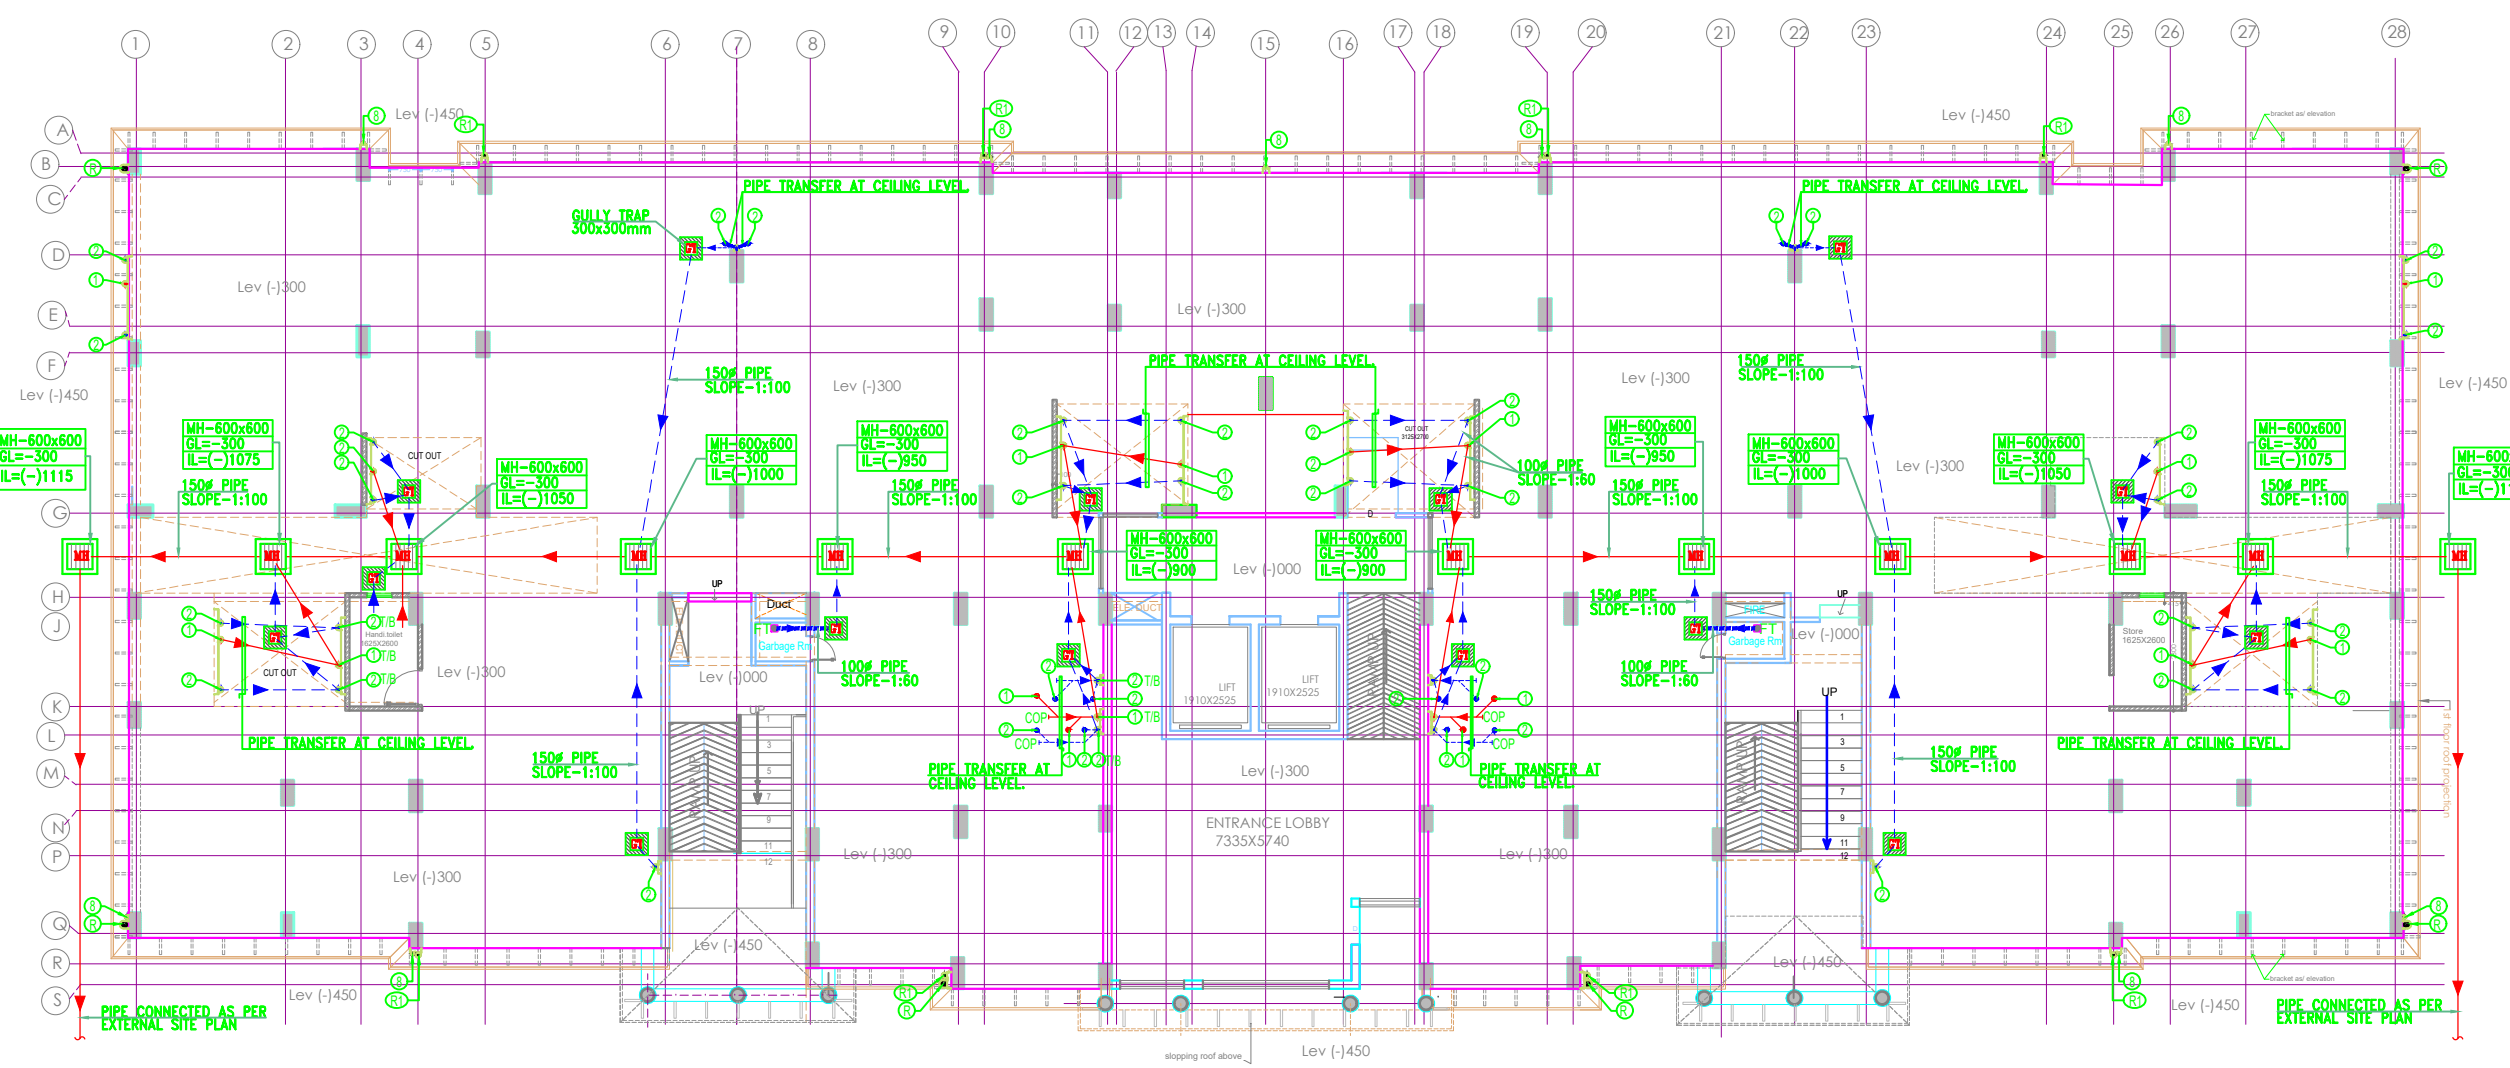

GROUND FLOOR PLAN

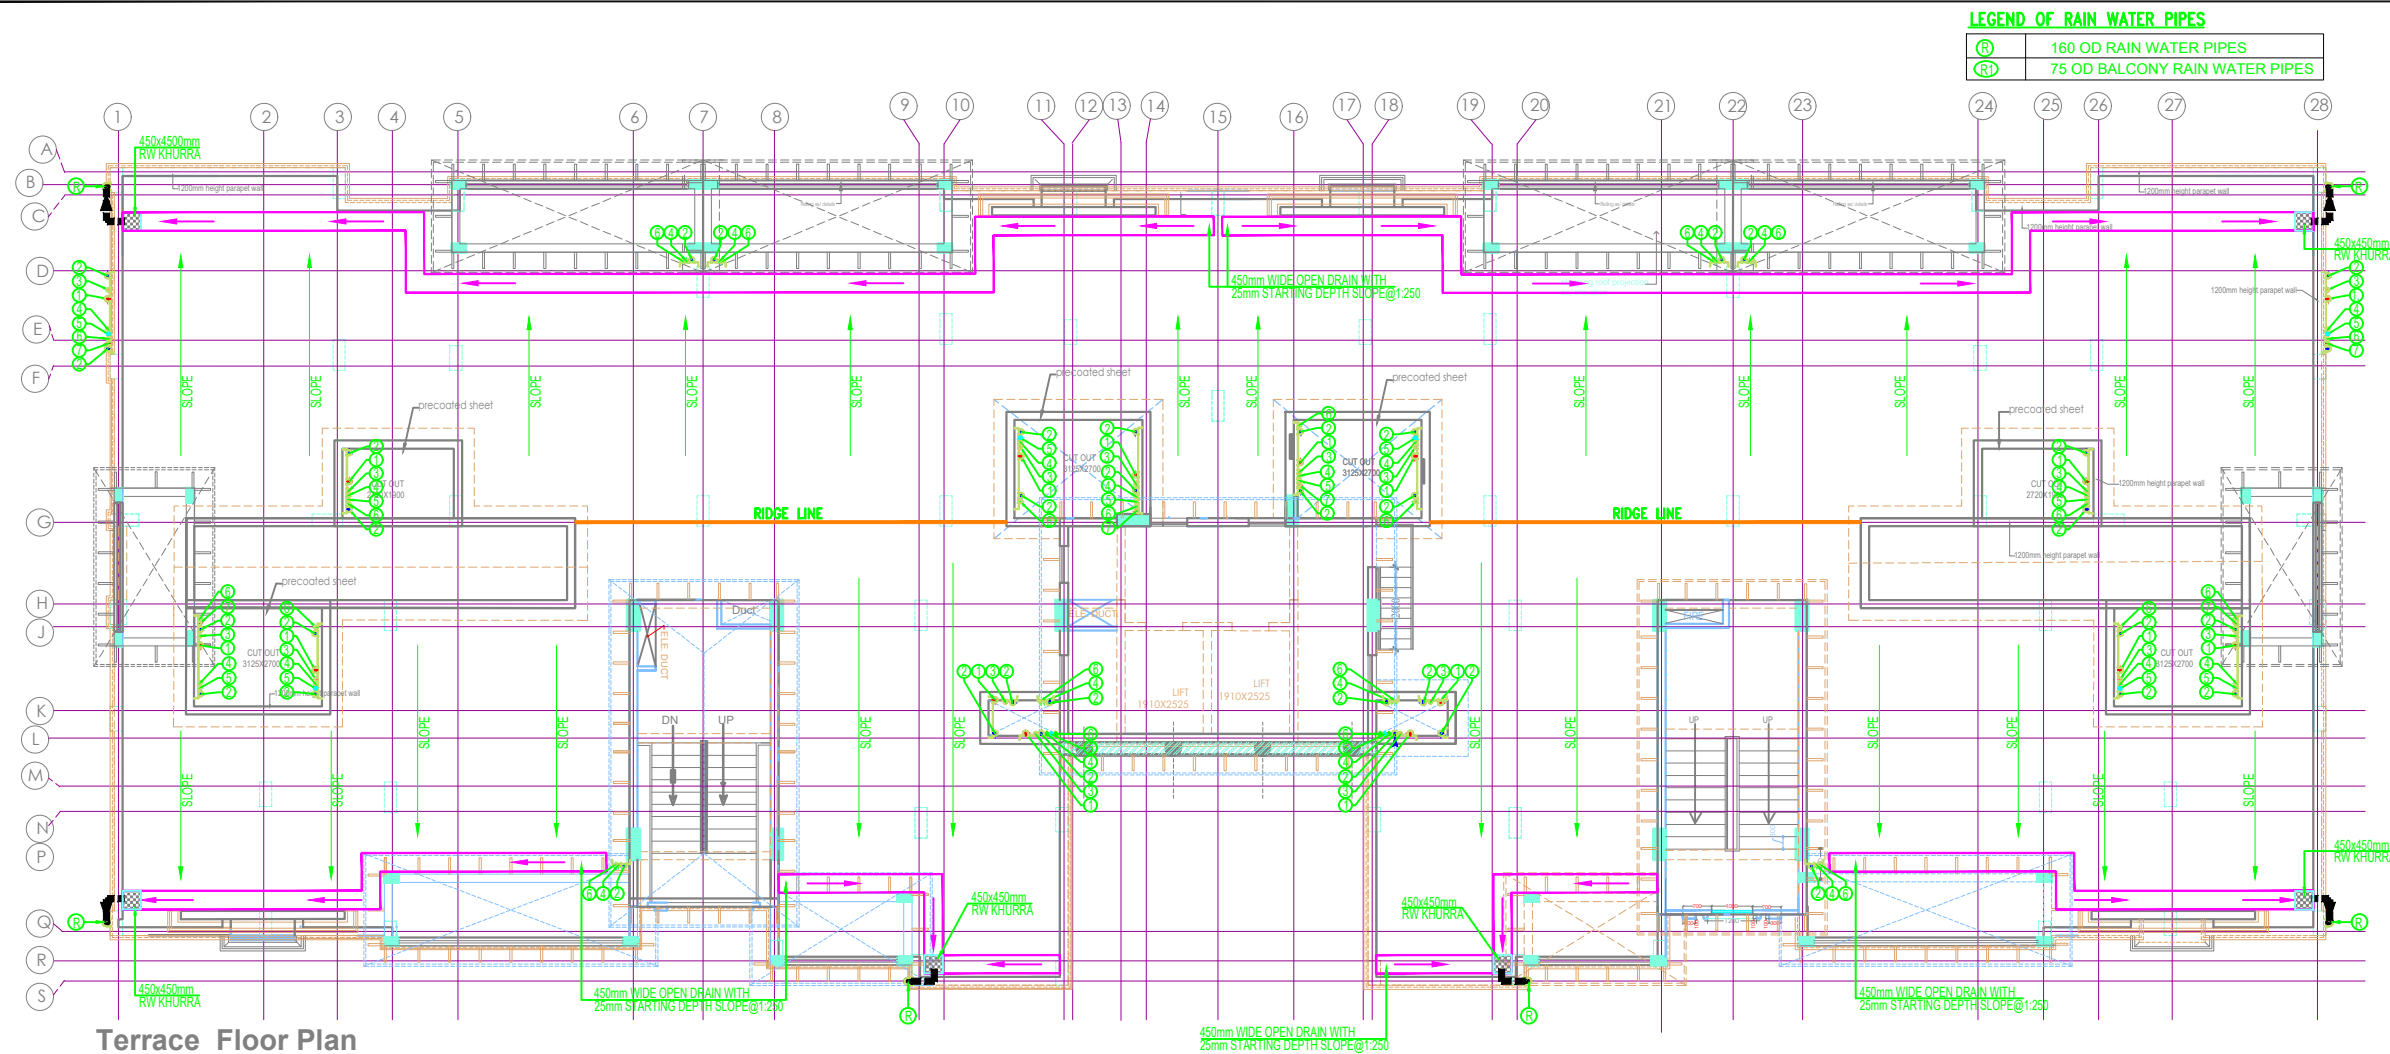


LEGEND OF RAIN WATER PIPES

Ⓡ	160 OD RAIN WATER PIPES
Ⓡ	75 OD BALCONY RAIN WATER PIPES

LEGEND FOR VERTICAL PIPES

- 110 OD uPVC SOIL & VENT PIPE
- 110 OD uPVC WASTE & VENT PIPE
- 75 OD uPVC ANTI SYPHONAGE PIPE
- DOMESTIC WATER SUPPLY PIPE DN.TAKE PIPE
- FLUSHING WATER SUPPLY PIPE DN.TAKE PIPE
- DOMESTIC WATER SUPPLY FROM HYDROPNEUMATIC SYSTEM FOR UPPER THREE FLOORS.
- HOT WATER PIPE FROM SOLAR TO M.BED ROOM
- 63 OD uPVC AC DRAIN PIPE
- FT FLOOR TRAP (110x110 mm)

Terrace Floor Plan

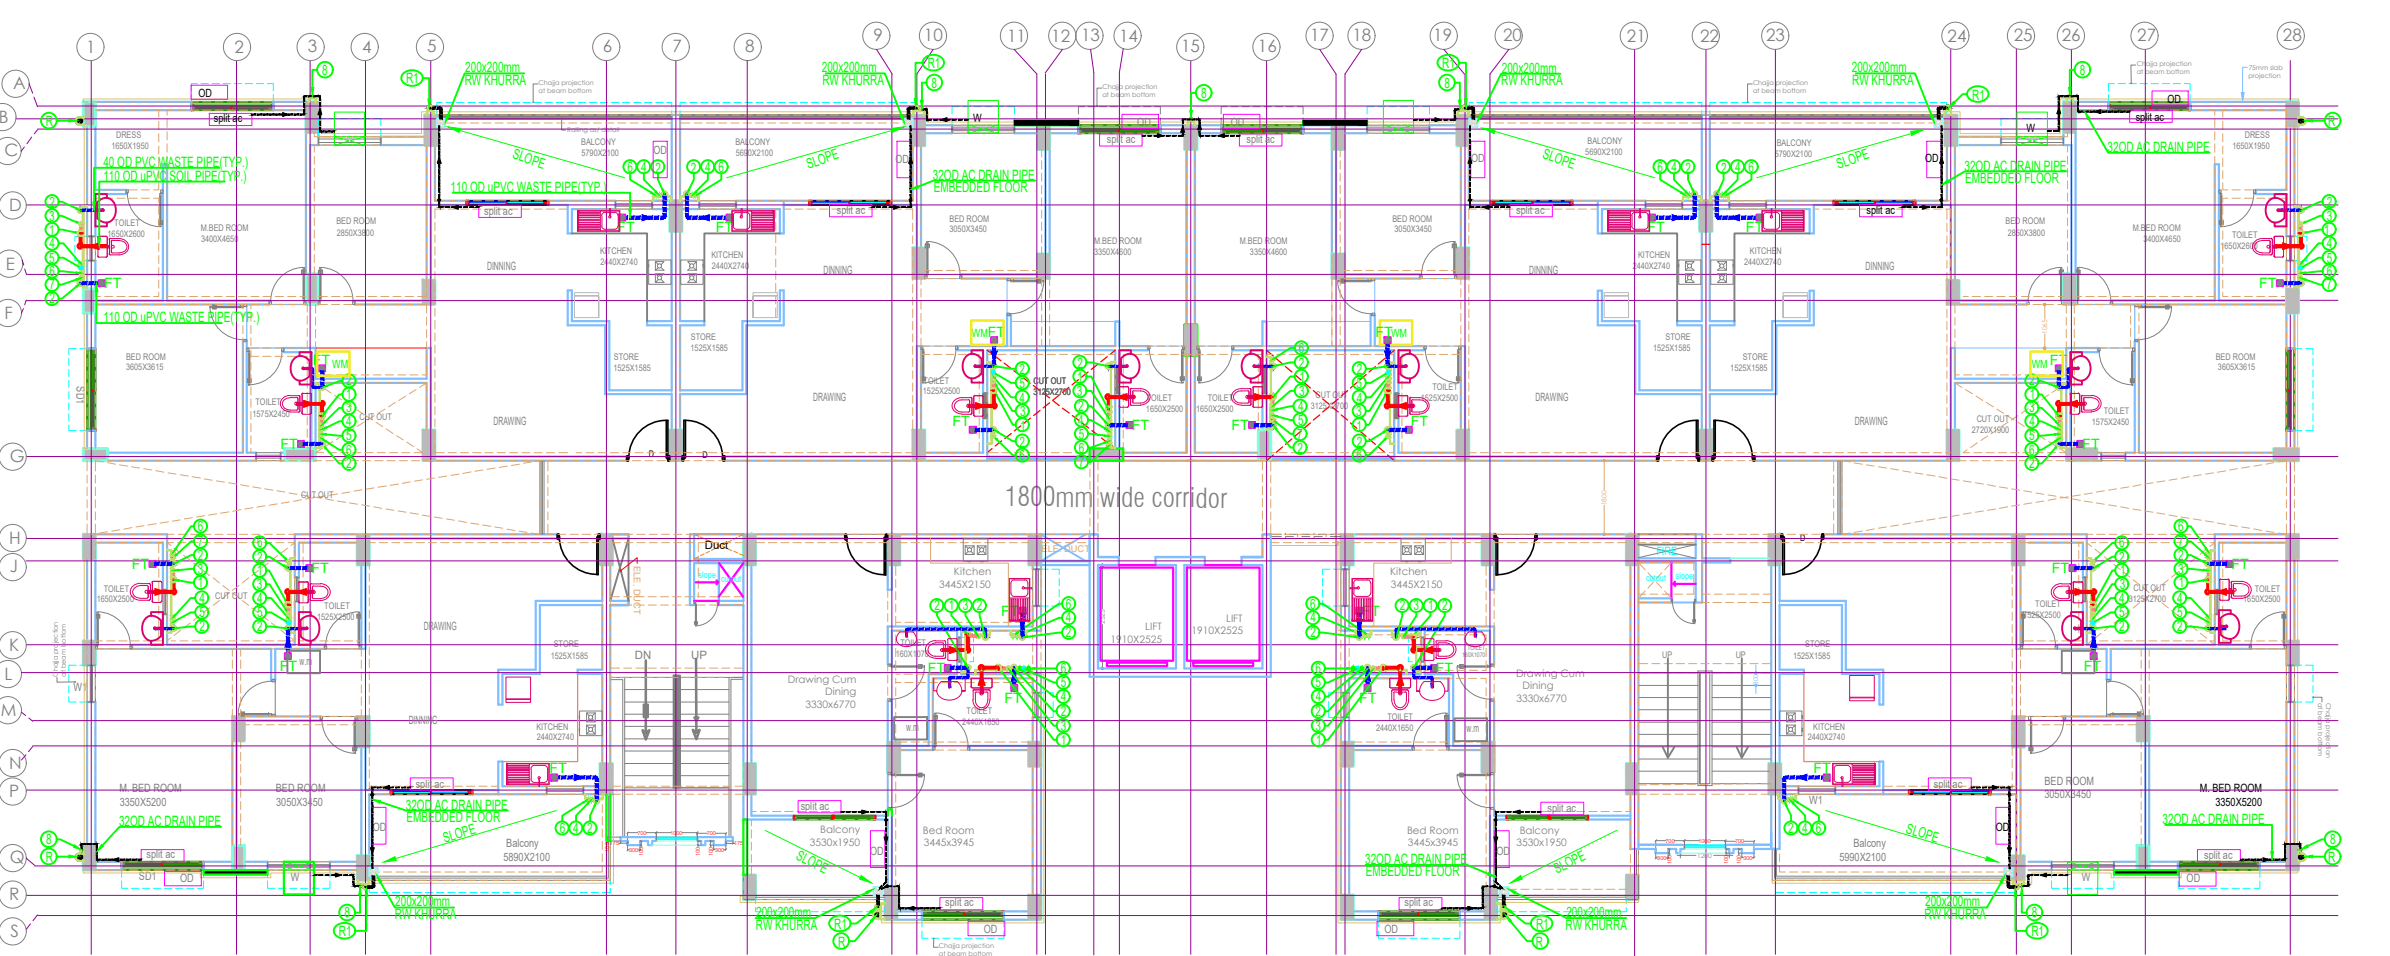

TYPICAL FLOOR PLAN



No.	Date	By	Description
ISSUES			

No.	Date	By	Description
Revisions			

OWNERS NAME
Ashiana Housing Ltd.
 Unit no.4 & 5, Plot No. D-2, 3rd Floor,
 Southern park, Saket District Centre,
 Saket New Delhi - 110017
 Phone no. 011-42 65 42 65

ARCHITECT:-
b.sengupta architect
A-305, RANGOLI, ASHIANA VILLAGE BHIWADI.
PH . 09887488263

Electro - Mechanical Consultants
ABL
ASHISH HINGRAT
 Electro-Mechanical Consulting Engineer
 B-137, Basement, Kalkaji, New Delhi-110019
 P. +91-11-41625566, 46524180, 81.82.83.84
 F. +91-11-46524182
 E-mail: abl@abhospitech.com
 ablhospitech@gmail.com

PROJECT:-
Ashiana Nirmay
AT BHIWADI

Drawing Title
TERRACE PLAN & TYPICAL FLOOR PLAN DRAINAGE LAYOUT (BLOCK)

Job No.	Drawing No.
Drawn S.J.	Checked N.V.
Date 18/07/2018	Scale 1:125
	Revisions DR-02