

Rain Water harvesting/Recharging



LEGEND

| PLUMBING | |
|------------|--|
| EFH | EXTERNAL FIRE HYDRANT (SIZE AS/PLUMBING) |
| GH | GARDEN HYDRANT AS/PLUMBING |
| SMH | STORM WATER MANHOLE (SIZE AS/PLUMBING) |
| RWH | RAIN WATER HARVESTING PIT (SIZE AS/PLUMBING) |
| CB | STORM WATER CATCH BASIN (SIZE AS/PLUMBING) |
| MH | SEWER MANHOLE (SIZE AS/PLUMBING) |
| IC | LAST MANHOLE OF PLOT OWNER |
| | IRRIGATION WATER SUPPLY LINE (AS/PLUMBING) |
| | 3000 STORM WATER SUPPLY LINE (AS/PLUMBING) |
| | POTABLE WATER SUPPLY (AS/PLUMBING) |
| | FLUSHING WATER SUPPLY (AS/PLUMBING) |
| | MUNICIPAL WATER SUPPLY LINE (AS/PLUMBING) |
| | SEWER LINE (AS/PLUMBING) |
| | STORM WATER LINE (AS/PLUMBING) |
| | HUME PIPE (AS/PLUMBING) |
| VC | VALVE WITH CHAMBER - (SPACING OF PIPES & SIZE OF CHAMBER AS/PLUMBING) |
| ELECTRICAL | |
| CSS | COMPACT SUB STATION (SIZE AS/ELECTRICAL) |
| FP | FEEDER PILLAR (SIZE AS/ELECTRICAL) |
| E | EARTH PIT FOR EARTHING (AS/ELECTRICAL) |
| MH1 | MANHOLE 1 FOR LT + LV SYSTEM (AS/ELECTRICAL) |
| MH2 | MANHOLE 2 FOR LT + LV SYSTEM (AS/ELECTRICAL) |
| MH3 | MANHOLE 3 FOR LT + LV SYSTEM (AS/ELECTRICAL) |
| MH4 | MANHOLE 4 FOR LT + LV SYSTEM (AS/ELECTRICAL) |
| | 600MM WIDE CORRIDOR FOR HT CABLE BURIED DIRECT IN GROUND (AS/ELECTRICAL) |
| | HUME PIPE (AS/ELECTRICAL) |
| | LT LINE (AS/ELECTRICAL) |
| | LV LINE (AS/ELECTRICAL) |

Deepak
Er. Deepak Deval
 B-Tech, Civil Engg.

VATIKA LIMITED

Address :-
 Village: Thikaria, Prithvisinghpura, Sanjharia, Bagrukurd, Balmukundpura
 Tehsil: Sanganer, Jaipur

PROJECT NAME :
VATIKA INFOTECH CITY
 For-Part-A

Notes
 1. DO NOT SCALE THE DRAWING.
 2. ALL DIMENSIONS ARE IN METERS.
 3. ALL DIMENSIONS TO BE CHECKED ON SITE BEFORE ANY CONSTRUCTION OR MANUFACTURE.


MASTER PLANNERS & LANDSCAPE CONSULTANTS
 Sakshi Khanna & Associates
 E-39, Lower Ground Floor,
 Mansarovar, Greater Kailash, Part-3,
 New Delhi-110048
 Ph: 011-41837853, 41837856
 Email: sakshi@skai.com

PLUMBING CONSULTANTS
 SAKSHI ENGINEERING CONSULTANTS PVT. LTD.
 22, Durgam Chattri, Vihar, Sec-62,
 INDIA-201301
 New Delhi-110048
 Email: sakshi@scpl.com
ELECTRICAL CONSULTANTS
 Kameer Kulkarni Associates Pvt. Ltd
 F-201, Lohitnagar, New Delhi - 110030
 Ph: 011-26211180, 26211181

North

| R.No. | Description | Date | To | By |
|-------|-------------|------|----|----|
| | | | | |
| | | | | |
| | | | | |

| Scale | Date | Job |
|-------------------------------------|---------------|----------------|
| - | 06.05.2022 | |
| Drawn PK | Checked AK | Approved AK |
| Drawing no. VICJ.TWN002.SW - 102 | | |

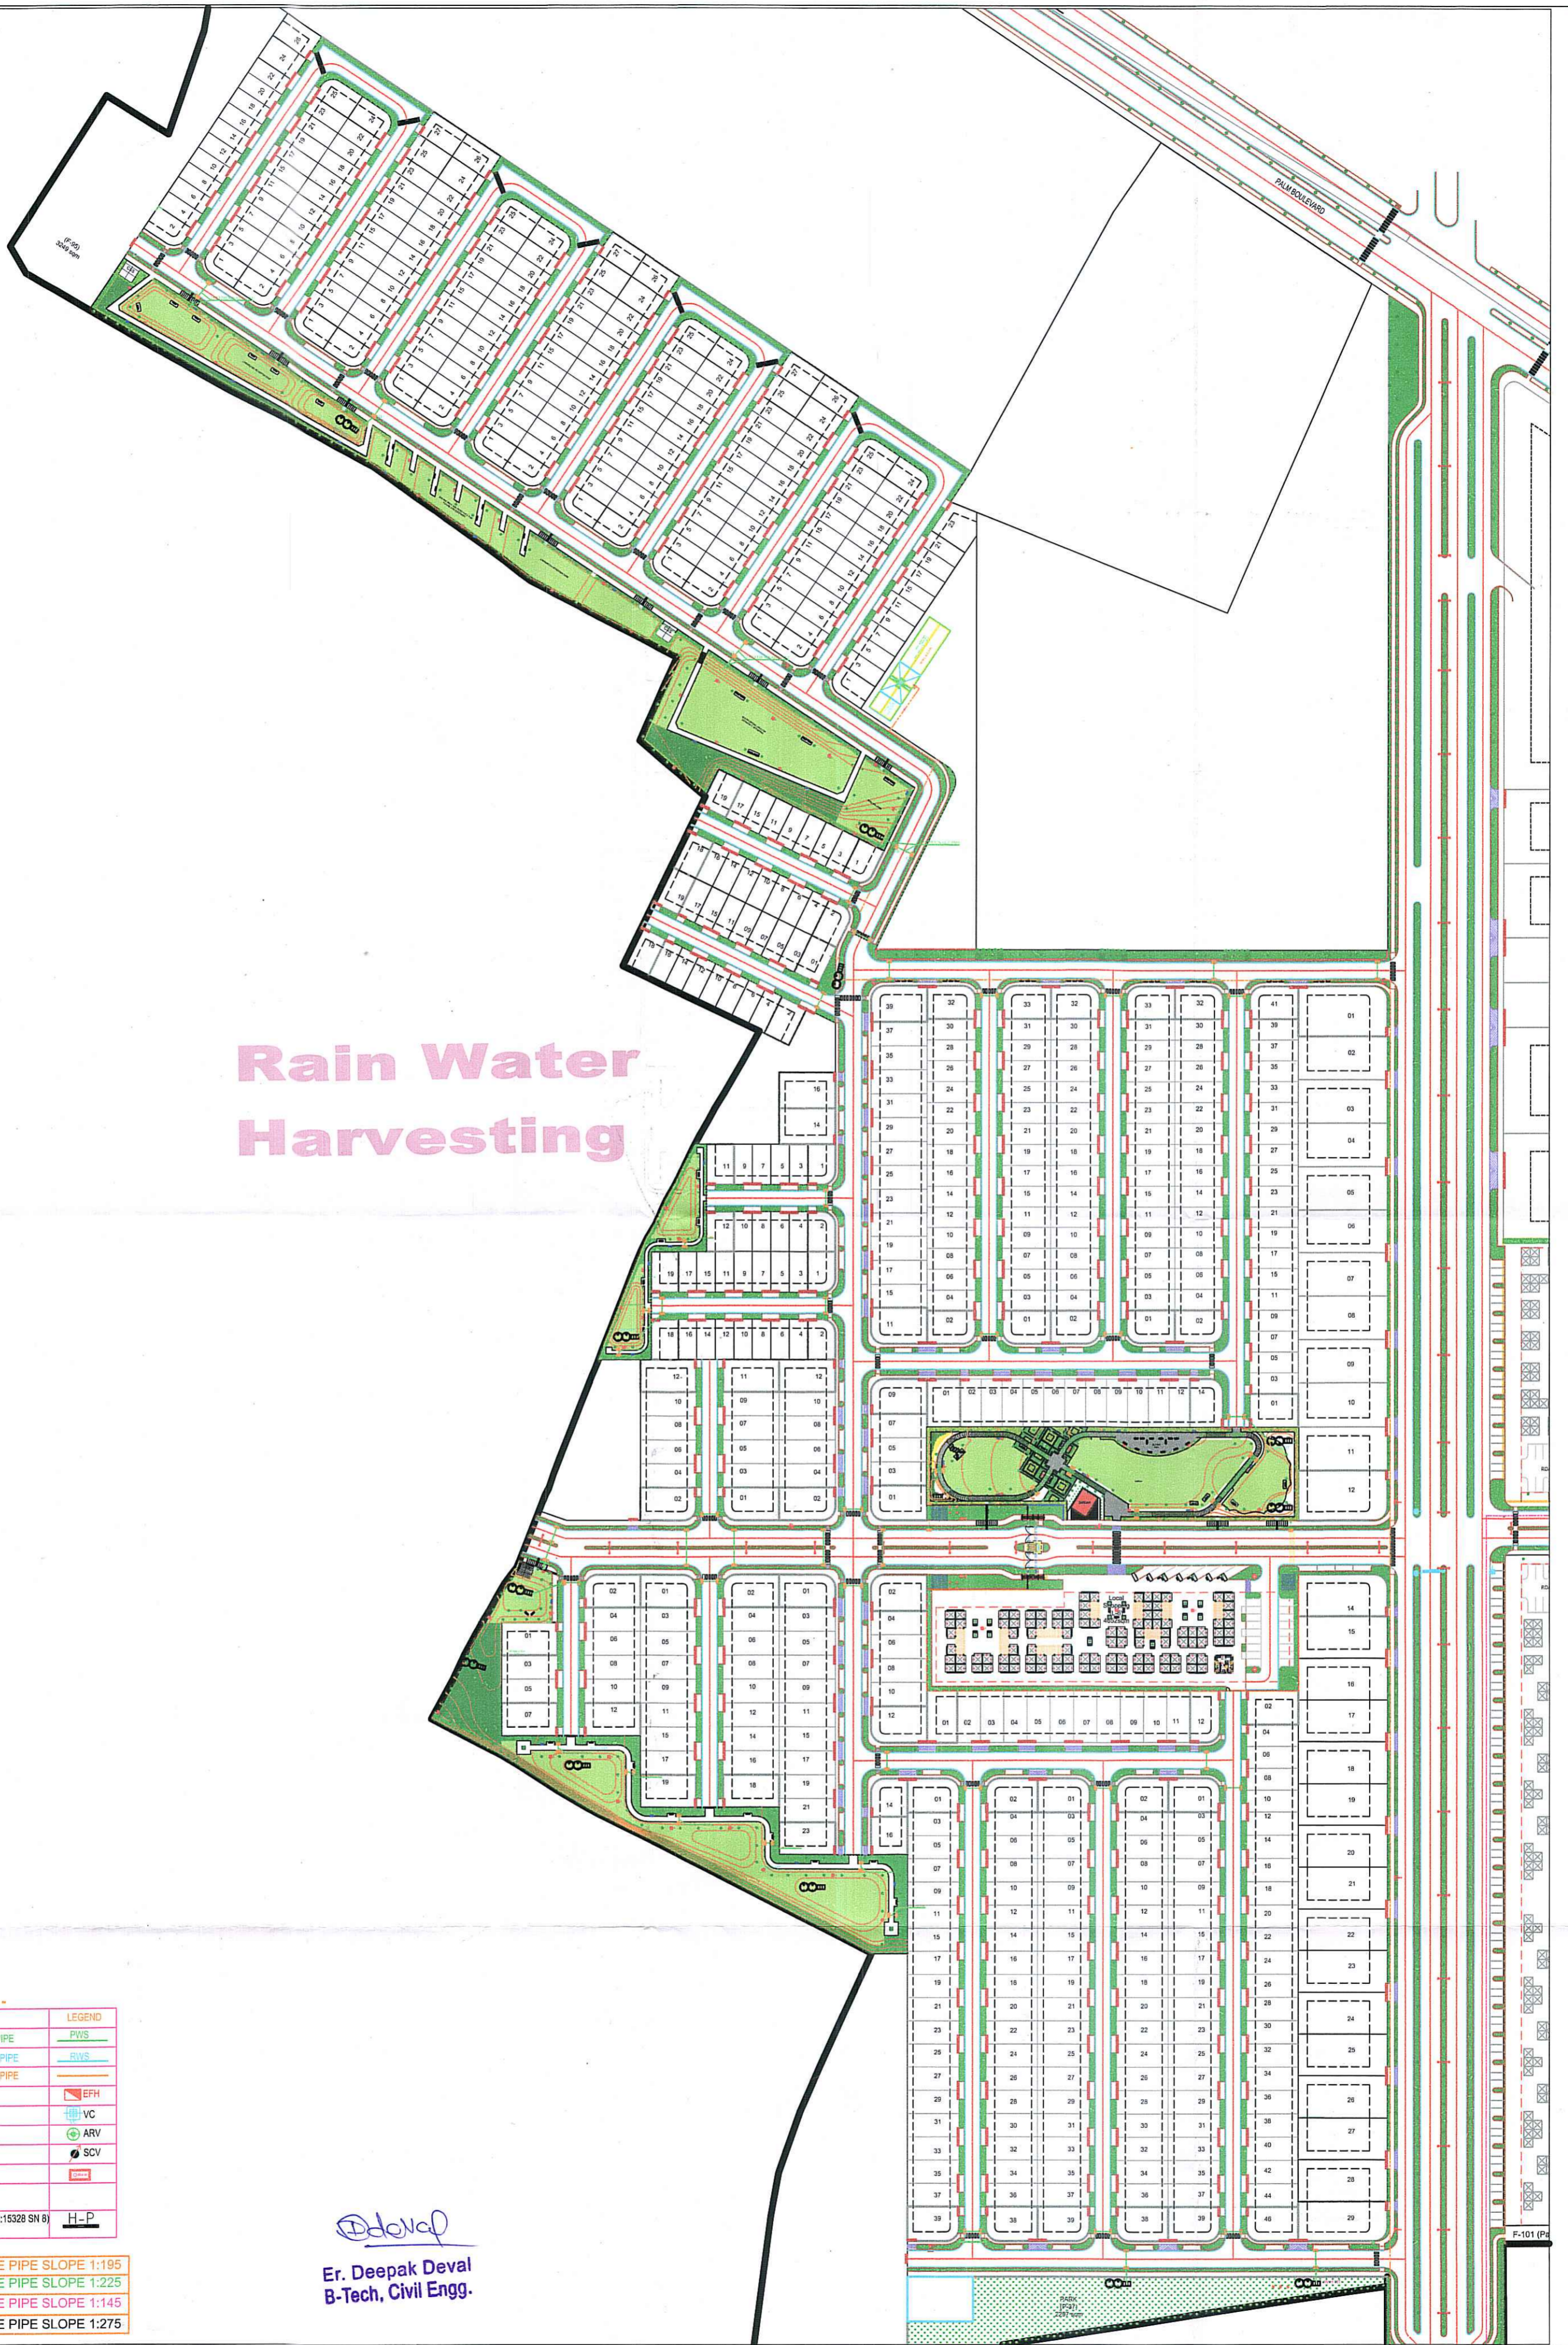

Rain Water Harvesting

PLUMBING LEGEND :-

| S.NO | DESCRIPTION | LEGEND |
|------|--|--------|
| 1. | POTABLE WATER SUPPLY PIPE | PWS |
| 2. | RECYCLED WATER SUPPLY PIPE | RWS |
| 3. | MUNICIPAL WATER SUPPLY PIPE | MWS |
| 4. | EXTERNAL FIRE HYDRANT | EFH |
| 5. | VALVE WITH CHAMBER (100x450x450) | VC |
| 6. | AIR RELEASE VALVE | ARV |
| 7. | SCOUR VALVE | SCV |
| 8. | BORE WELL | BW |
| 9. | GARDEN HYDRANT | GH |
| 10. | 250 oD PVC-U HUME PIPE (IS:15328 SN B) FOR ROAD CROSSING | H-P |

SEWERAGE LEGEND

| | |
|---|--------------------------------|
| Ⓐ | 200Ø SEWERAGE PIPE SLOPE 1:195 |
| Ⓑ | 250Ø SEWERAGE PIPE SLOPE 1:225 |
| Ⓒ | 150Ø SEWERAGE PIPE SLOPE 1:145 |
| Ⓓ | 300Ø SEWERAGE PIPE SLOPE 1:275 |

Er. Deepak Deval
Er. Deepak Deval
 B-Tech, Civil Engg.

VATIKA LIMITED

Address :-
 Village: Thikaria, Prithvisinghpura, Sanjharia, Bagrukurd, Balmukundpura
 Tehsil : Sanganer, Jaipur

PROJECT NAME :
VATIKA INFOTECH CITY
 For-Part-A

Notes
 1. DO NOT SCALE THE DRAWING.
 2. ALL DIMENSIONS ARE IN METERS.
 3. ALL DIMENSIONS TO BE CHECKED ON SITE BEFORE ANY CONSTRUCTION OR MANUFACTURE.

CLIENT :
 Vatika Limited Ltd
 210 Park, Vatika Triangle,
 Sanganer Loc. Phase-4,
 Jaipur - 320022

CONSULTANTS :
PLUMBING CONSULTANTS
 SAHARAN ENGINEERING
 CONSULTANTS PVT. LTD.
 27, Doodh, Nani Vihar, Sec-42,
 MIDC-201 301
 Email: saharan@rediffmail.com

MASTER PLANNERS & ARCHITECTURE CONSULTANTS
 Sankh Khanna & Associates
 C-38, Lower Ground Floor,
 Mansi Moh. Center Kishan, Part-2,
 New Delhi-110048
 Ph: 011-4637655, 4163766
 Email: s.khanna@rediffmail.com

ELECTRICAL CONSULTANTS
 Kewar Kishan Associates Pvt. Ltd
 P-201, Laxminagar, New Delhi - 110020
 Ph: 011-2621180, 2621181
 Email: kishan@rediffmail.com



| R.No. | Description | Date | To | By |
|-------|------------------|----------|----|----|
| R1 | REVISED SERVICES | 23.10.19 | VL | SK |

| | | |
|---|--------------------|--------------------|
| Scale 1:1000 | Date 23.10.2019 | Stage GFC |
| Drawn by k.k | Checked by | Approved by G.M |
| Drawing no. VICJ.TWN002.IPAN.PL- 601 | Revision No. R1 | |