

Julshan Khurana

LEGEND :-

	INTERNAL HYDRANT WITH HOSE REEL
	NON RETURN VALVE
	BUTTER FLY VALVE
	FIRE EXIT SIGN (DOUBLE SIDE)
	FIRE EXIT SIGN (SINGLE SIDE)
	CO2 TYPE FIRE EXTINGUISHER
	ABC TYPE FIRE EXTINGUISHER
	MAUAL CALL POINT & HOOTE R

FIRE CONSULTANTS :-
FYRPROTEK
 (FIRE & LIFE SAFETY CONSULTANTS)
 B-53, NEW KRISHNA PARK,
 VIKAS PURI, NEW DELHI - 110018
 TEL: 25506702, FAX. 91 - 011- 25500102.

ARCHITECT
b.sengupta architect
 A305,RANGOLI,ASHIANAVILLAGEBHIWADI.
 PH . 09887488263


PLOT DETAILS
 KHASRA No.453,454,454/2,454/1,432,433,478,
 479,480,484,485,434,434/735,435,436,437,
 437/736,438,439,440,482,500,502,503,504/1
 478/716 IN VILLAGE JHAI TEH. SAGANER ON
 AJMER ROAD ,JAIPUR

Project:-
 ASHIANA UMANG

Developer:-
 ASHIANA HOUSING LTD.

Sheet title:- FIRE FIGHTING DRAWINGS
 FIRST FLOOR PLAN

SCALE- 1:100 **Block:-**
 UMANG COMMERCIAL

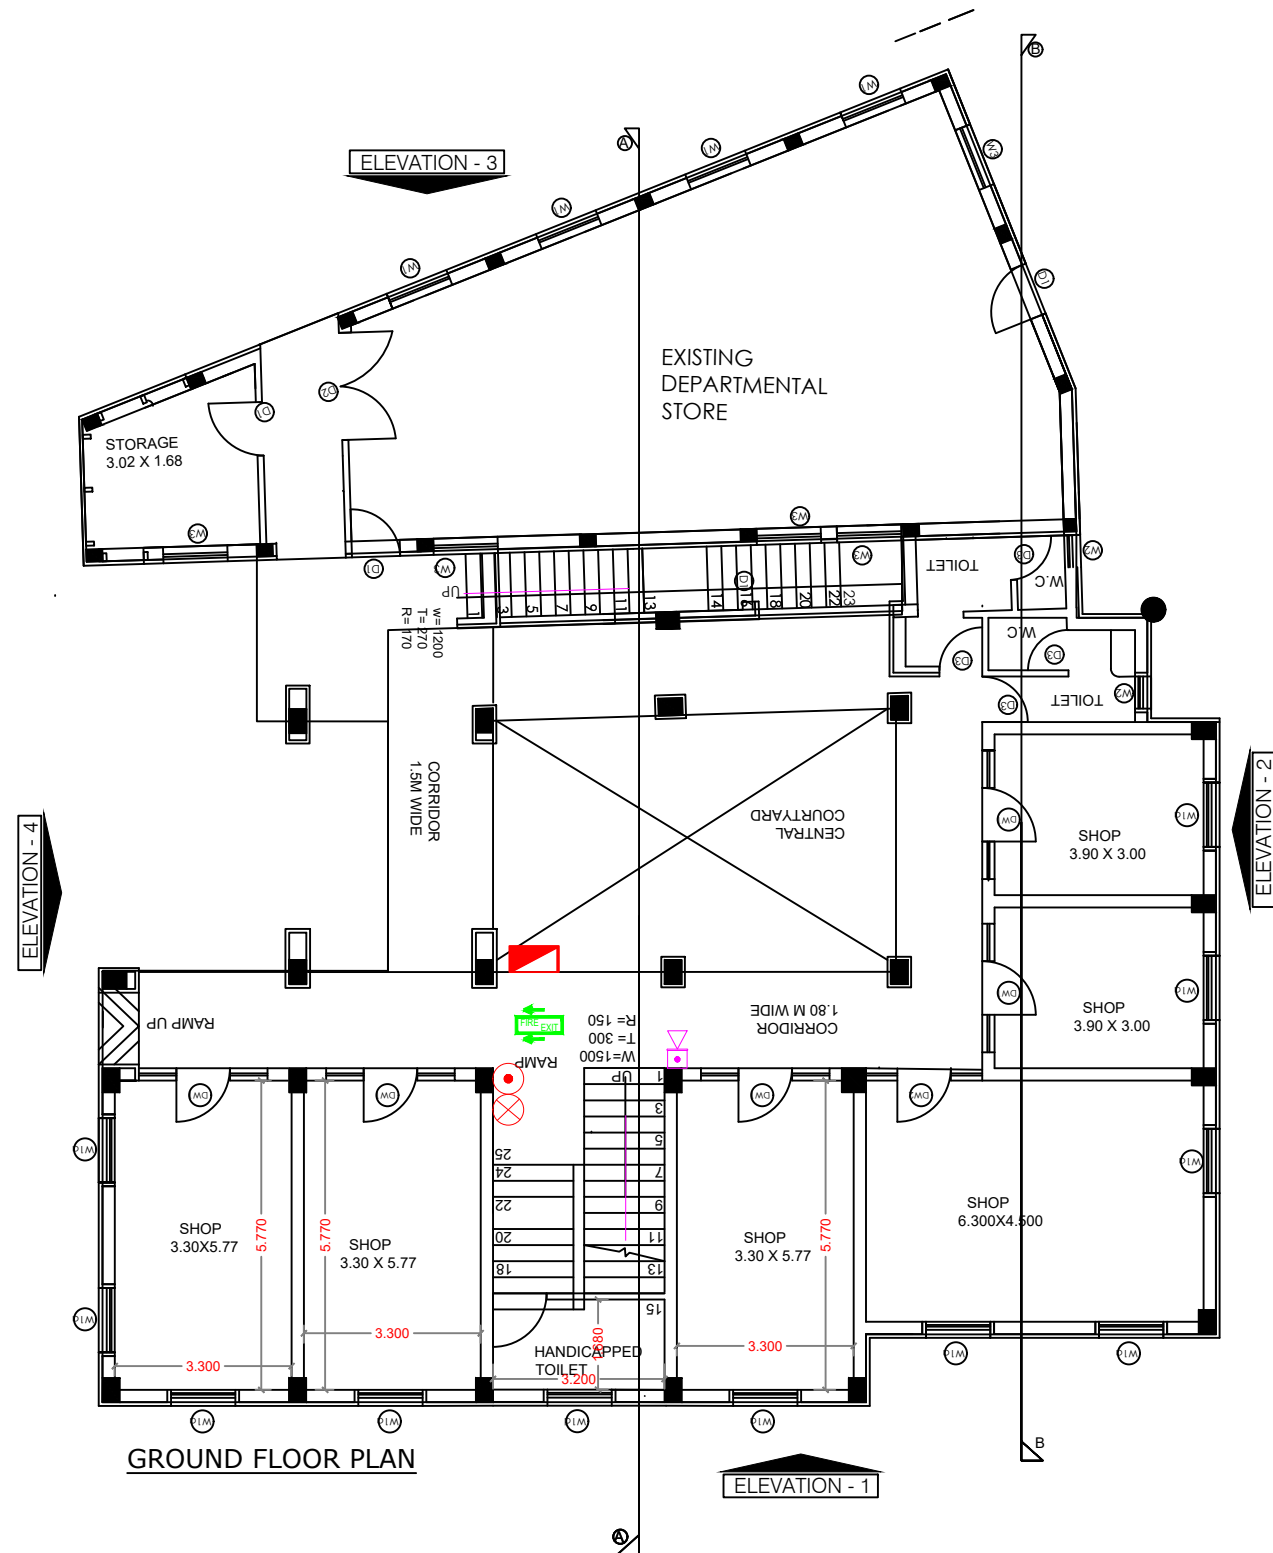

Julshan Khurana

LEGEND :-

	INTERNAL HYDRANT WITH HOSE REEL
	NON RETURN VALVE
	BUTTER FLY VALVE
	FIRE EXIT SIGN (DOUBLE SIDE)
	FIRE EXIT SIGN (SINGLE SIDE)
	CO2 TYPE FIRE EXTINGUISHER
	ABC TYPE FIRE EXTINGUISHER
	MAUAL CALL POINT & HOOTE R

FIRE CONSULTANTS :-
FYRPROTEK
 (FIRE & LIFE SAFETY CONSULTANTS)
 B-53, NEW KRISHNA PARK,
 VIKAS PURI, NEW DELHI - 110018
 TEL: 25506702, FAX. 91 - 011- 25500102.

ARCHITECT
b.sengupta architect
 A305,RANGOLI,ASHIANAVILLAGEBHIWADI.
 PH . 09887488263


PLOT DETAILS
 KHASRA No.453,454,454/2,454/1,432,433,478,
 479,480,484,485,434,434/735,435,436,437,
 437/736,438,439,440,482,500,502,503,504/1
 478/716 IN VILLAGE JHAI TEH. SAGANER ON
 AJMER ROAD ,JAIPUR

Project:-
 ASHIANA UMANG

Developer:-
 ASHIANA HOUSING LTD.

Sheet title:- FIRE FIGHTING DRAWINGS
 GROUND FLOOR PLAN

SCALE- 1:100
Block:-
 UMANG COMMERCIAL

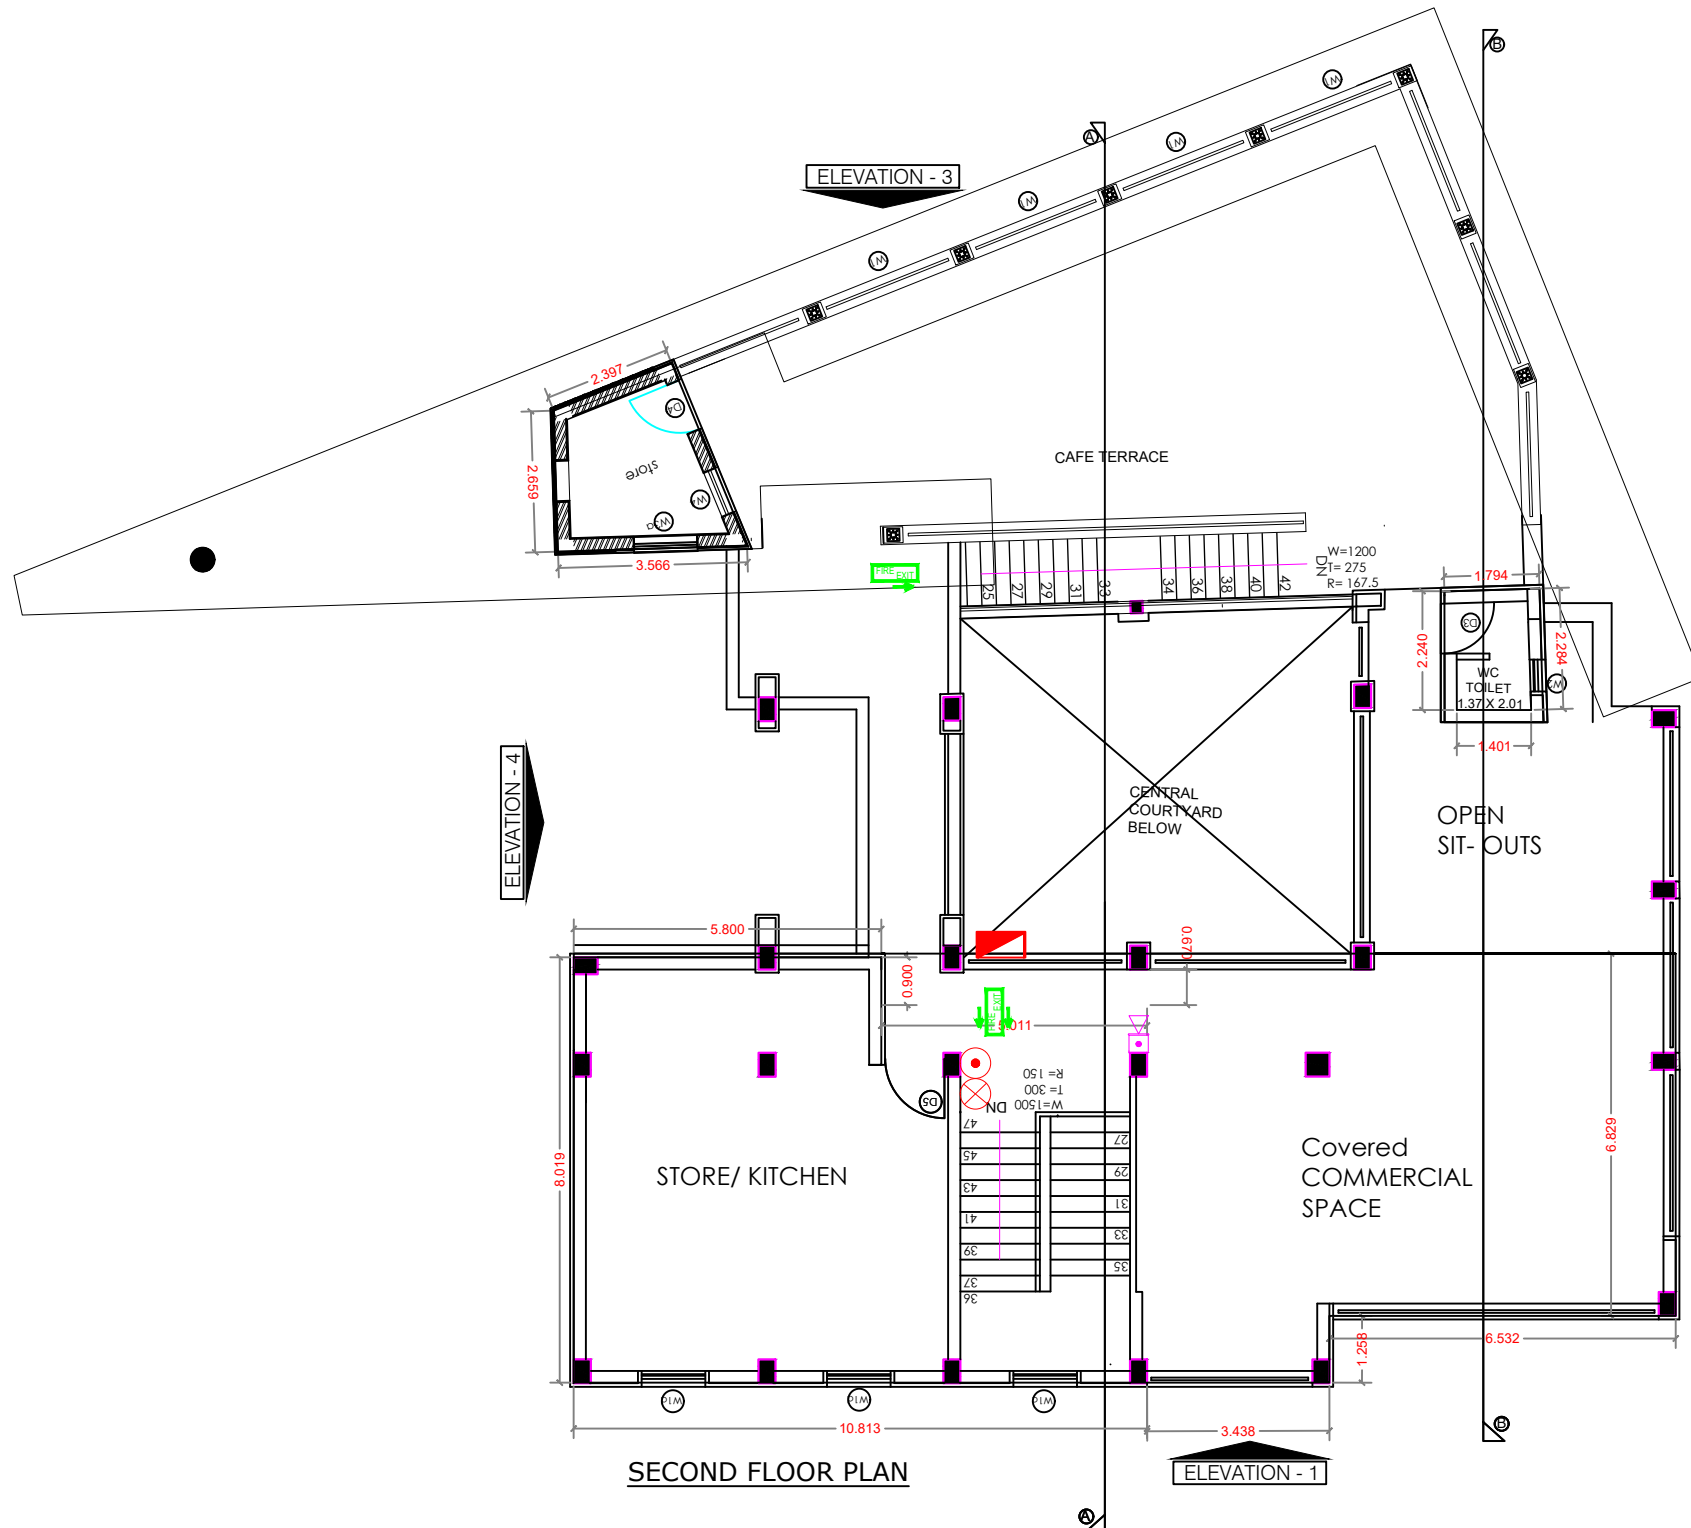

Gulshan Khurana

LEGEND :-

	INTERNAL HYDRANT WITH HOSE REEL
	NON RETURN VALVE
	BUTTER FLY VALVE
	FIRE EXIT SIGN (DOUBLE SIDE)
	FIRE EXIT SIGN (SINGLE SIDE)
	CO2 TYPE FIRE EXTINGUISHER
	ABC TYPE FIRE EXTINGUISHER
	MAUAL CALL POINT & HOOTE R

FIRE CONSULTANTS :-
FYRPROTEK
 (FIRE & LIFE SAFETY CONSULTANTS)
 B-53, NEW KRISHNA PARK,
 VIKAS PURI, NEW DELHI - 110018
 TEL: 25506702, FAX. 91 - 011- 25500102.

ARCHITECT
b.sengupta architect
 A305,RANGOLI,ASHIANAVILLAGEBHIWADI.
 PH . 09887488263

PLOT DETAILS
 KHASRA No.453,454,454/2,454/1,432,433,478,
 479,480,484,485,434,434/735,435,436,437,
 437/736,438,439,440,482,500,502,503,504/1
 478/716 IN VILLAGE JHAI TEH. SAGANER ON
 AJMER ROAD ,JAIPUR

Project:-
 ASHIANA UMANG

Developer:-
 ASHIANA HOUSING LTD.

Sheet title:- FIRE FIGHTING DRAWINGS
SECOND FLOOR PLAN

SCALE- 1:100 **Block:-**
 UMANG COMMERCIAL