
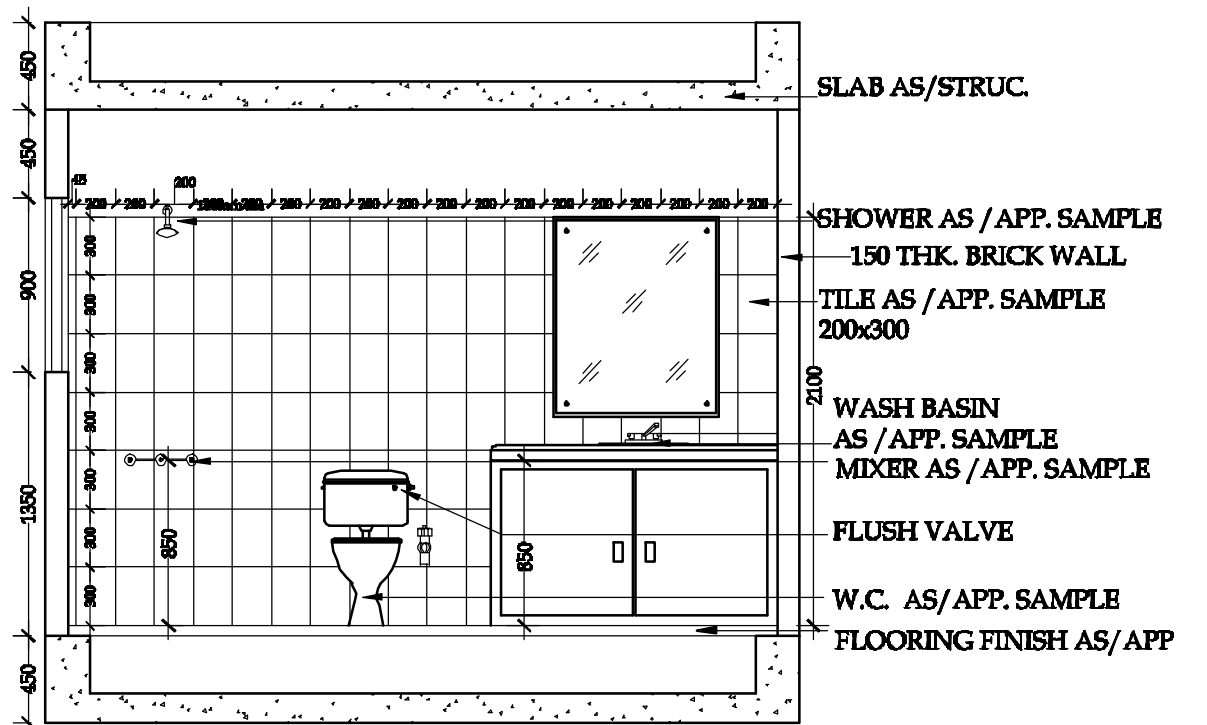
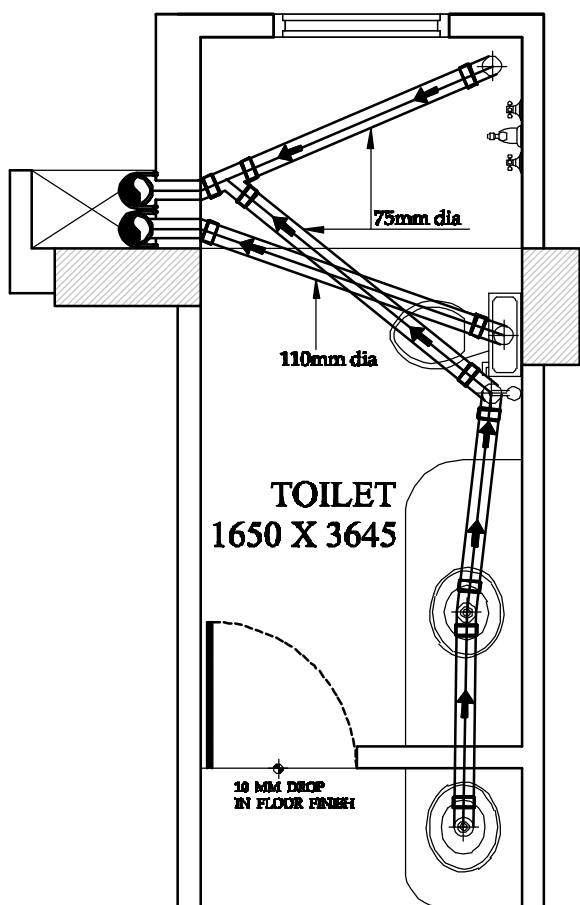
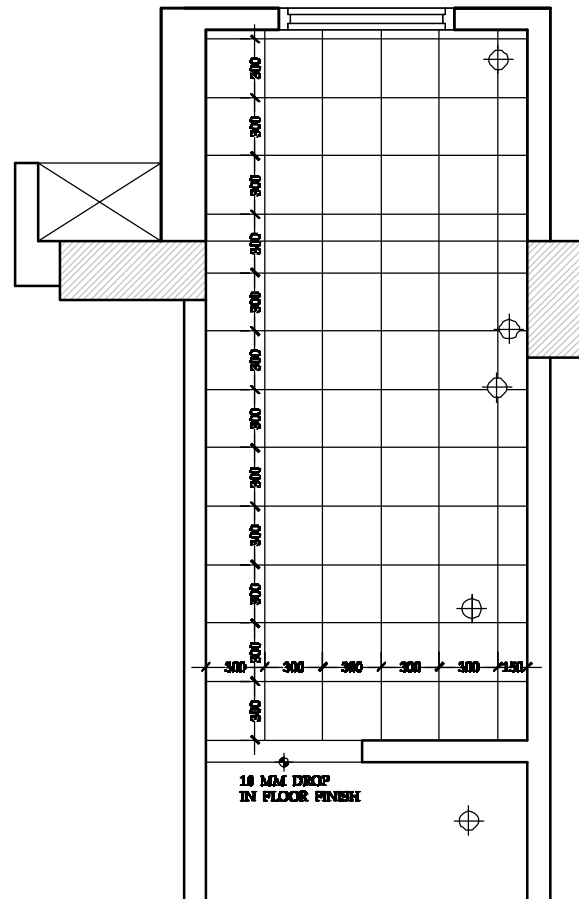
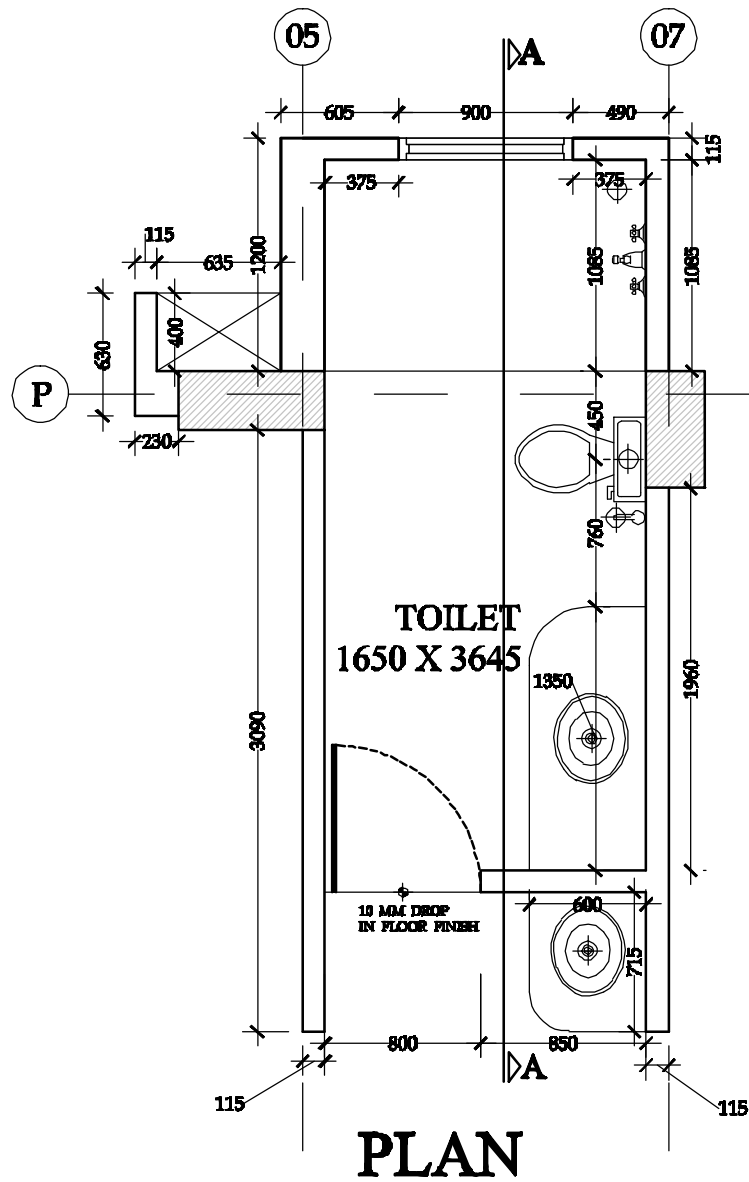
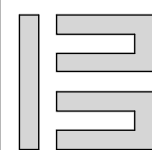


PROJECT:
PROPOSED LAYOUT PLAN OF HIG.
FLATS (B+STILT+ 9), AT DWARKA PATH,
MANSAROVER,
JAIPUR.

DRAWING TITLE:
TOILET (1) DETAIL
FOR GROUND FLOOR TO EIGHT FLOOR

CLIENT:
RAJASTHAN HOUSING BOARD
JAIPUR.

P. N. BHARGAVA
ARCHITECT-PLANNER
CA/78/743

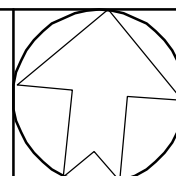

ARCHITECT:
B. E. CONSULTANTS
ARCHITECTURE, PLANNING, INTERIORS
A-237, MALVIYA NAGAR, JAIPUR.
PHONE: 2622374, FAX: 0141-2620294
MOBILE: 0-98290-02207
EMAIL: b.econsultants@yahoo.com
bhargavapn@yahoo.co.in

SCALE :


DATE : 01-12-2014

JOB. NO. :


DWG. NO. :

AB


41R

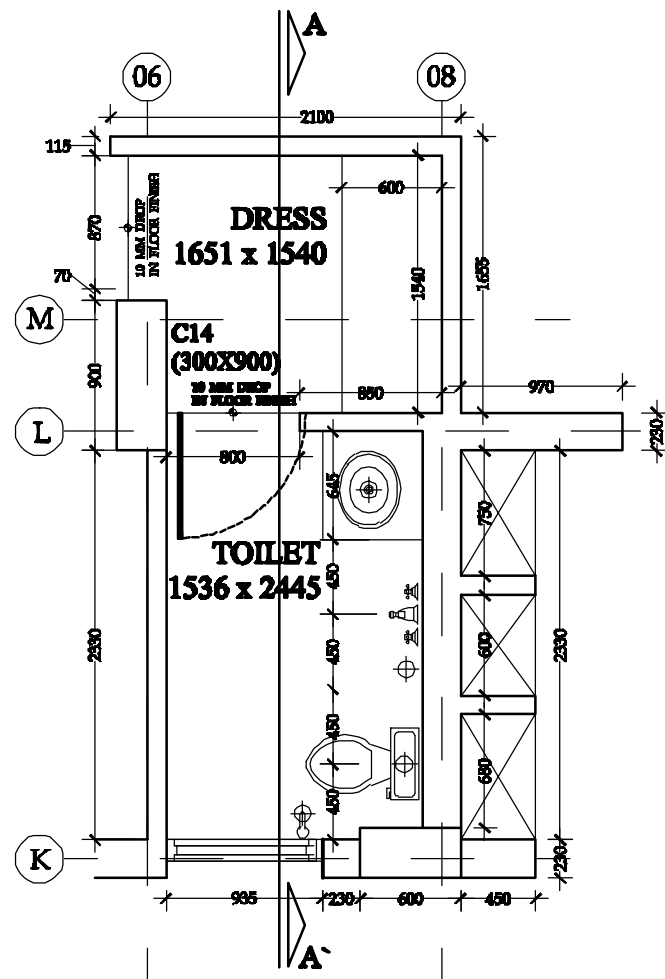


PLAN

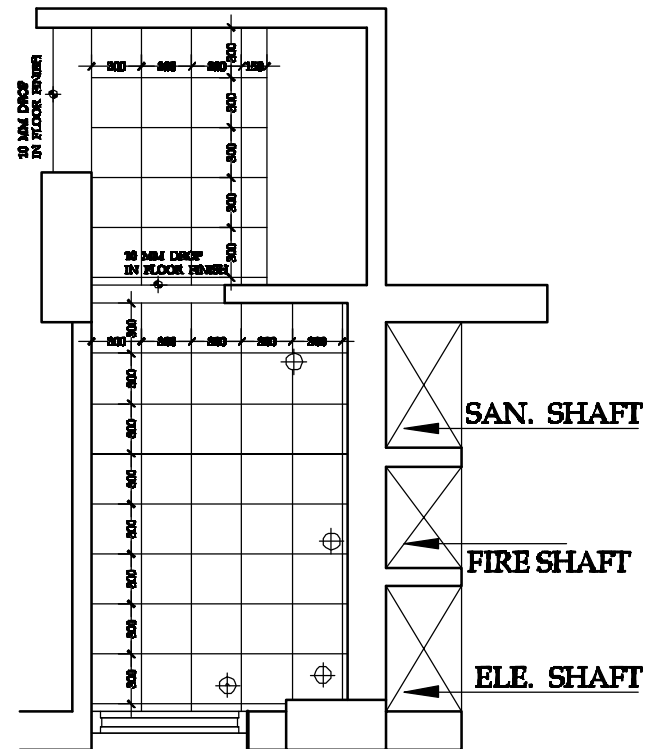


FLOORING DETAIL

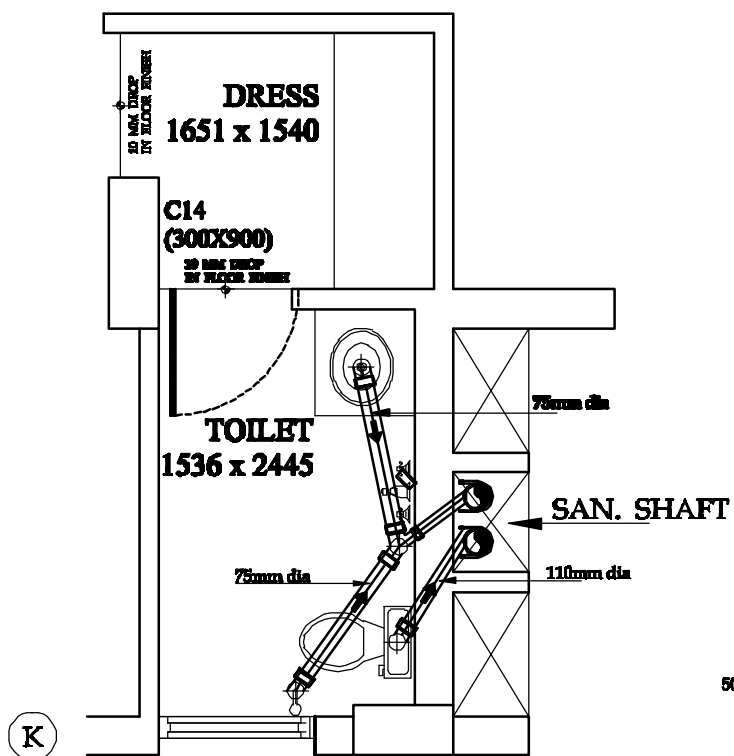

PIPE DETAIL

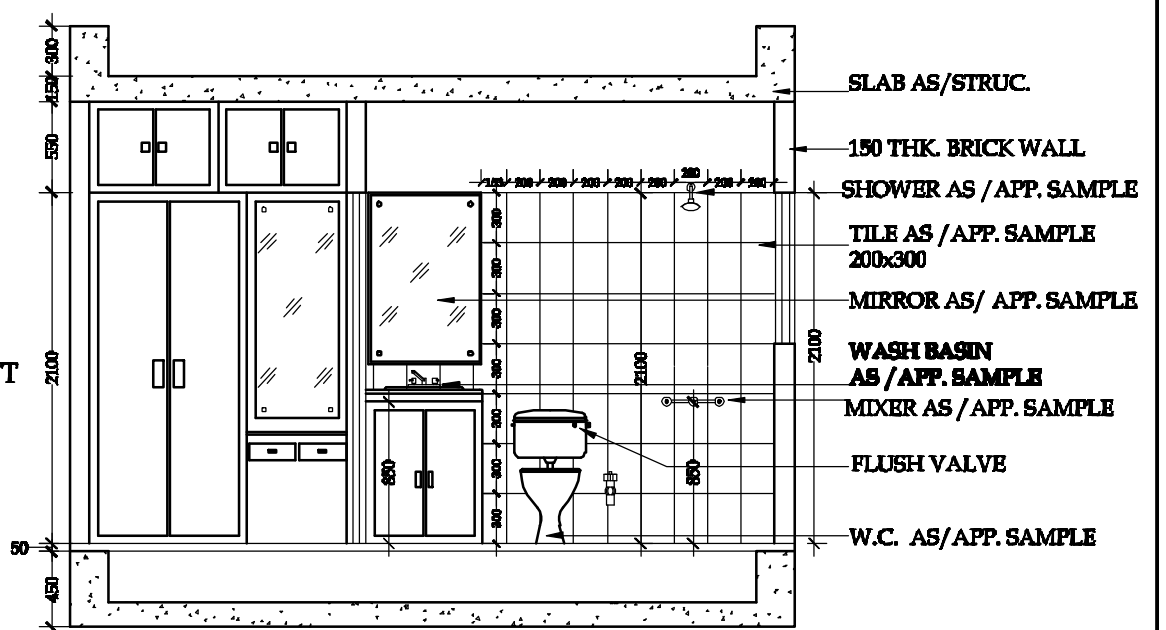

SECTION A-A'

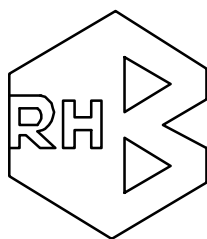


PROJECT:
PROPOSED LAYOUT PLAN OF HIG.
FLATS (B+STILT+ 9), AT DWARKA PATH,
MANSAROVER,
JAIPUR.

DRAWING TITLE:
TOILET (2) DETAIL
FOR GROUND FLOOR TO EIGHT FLOOR

CLIENT:
RAJASTHAN HOUSING BOARD
JAIPUR.

F. N. BHARGAVA
ARCHITECT-PLANNER
CA/75/748

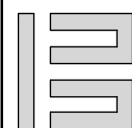

ARCHITECT:
B. E. CONSULTANTS
ARCHITECTURE, PLANNING, INTERIORS
A-237, MALVIYA NAGAR, JAIPUR.
PHONE: 2623274, FAX: 0141-2623274
MOBILE: 98490-08007
EMAIL: b.e.consultants@gmail.com
bhargava@b.e.consultants


SCALE: DATE: 01-12-2014

JOB NO.:

DRS. NO. 1

AB

42R

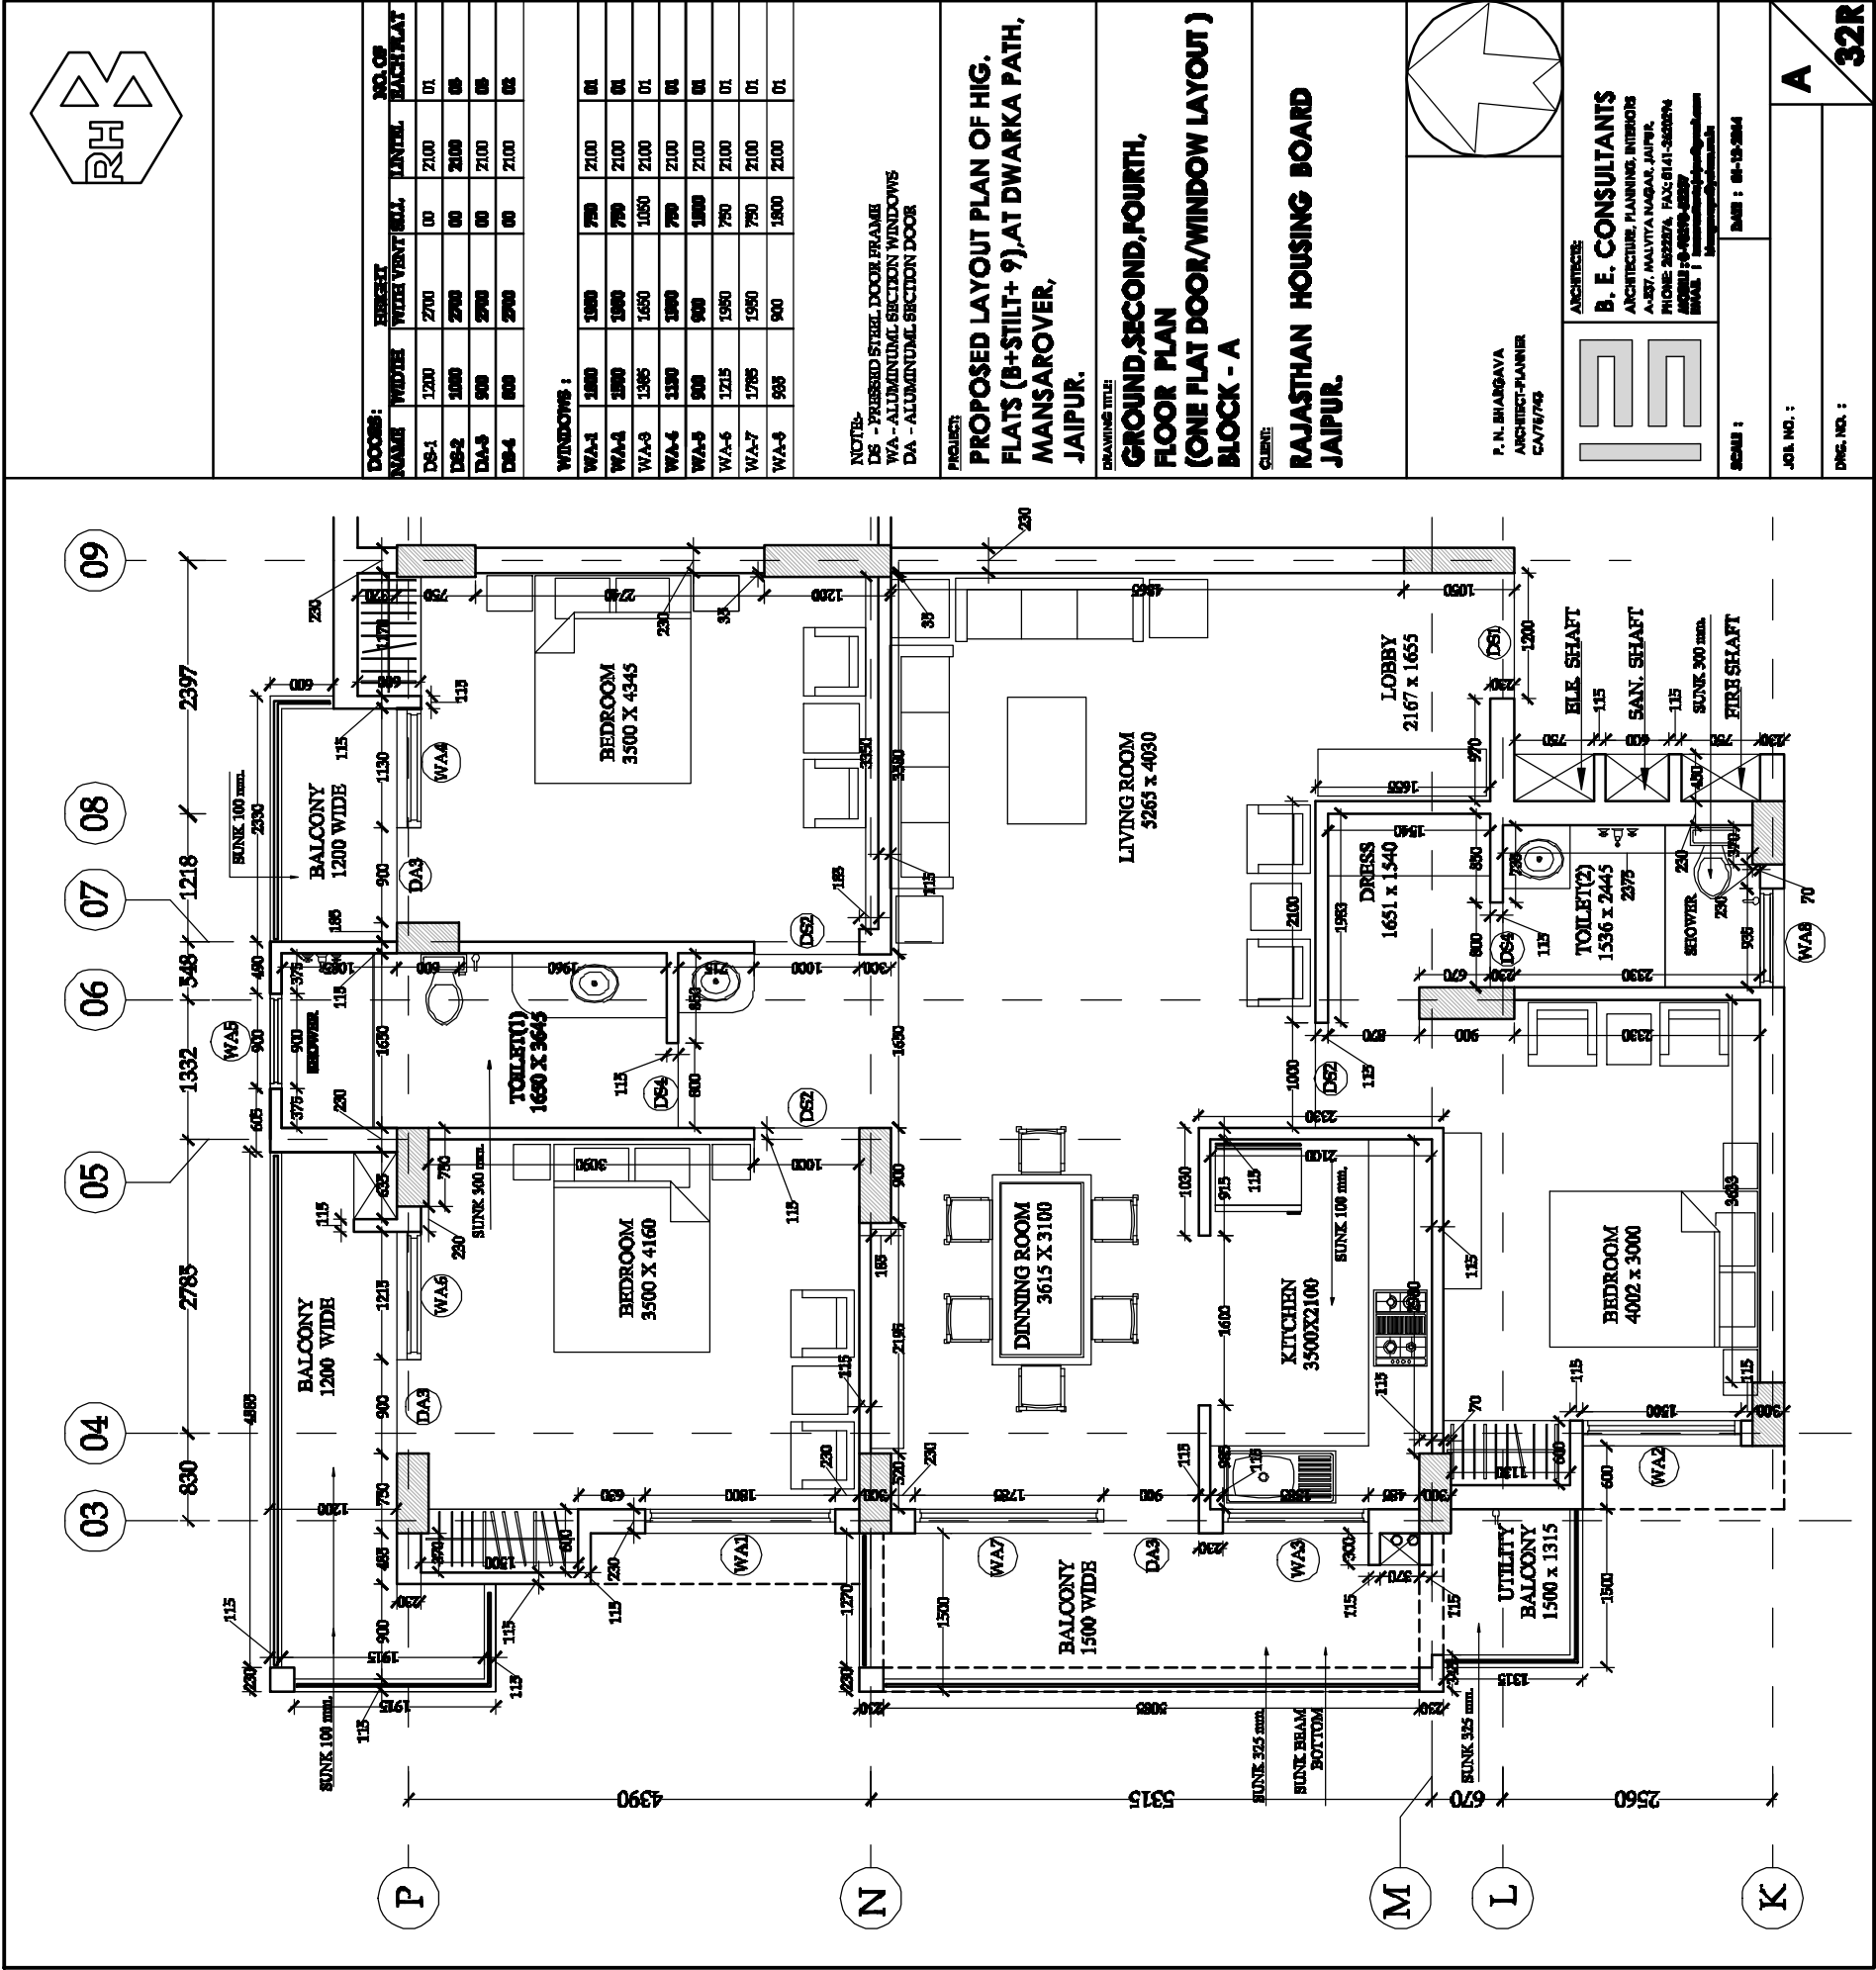

DOORS:				NO. OF EACH FLAT	
NO.	WIDTH	HEIGHT	TYPE	ALL	FLAT
DS-1	1200	2100	00	2100	01
DS-2	1000	2700	00	2100	05
DA-3	900	2700	00	2100	05
DS-4	800	2700	00	2100	02


WINDOWS :				NO. OF EACH FLAT	
NO.	WIDTH	HEIGHT	TYPE	ALL	FLAT
WA-1	1800	1800	750	2100	01
WA-2	2800	1800	750	2100	01
WA-3	1365	1650	1050	2100	01
WA-4	1300	1800	750	2100	01
WA-5	900	900	1800	2100	01
WA-6	1215	1590	750	2100	01
WA-7	1785	1590	750	2100	01
WA-8	585	900	1800	2100	01

NOTE:-
DS - PRESSED STEEL DOOR FRAME
WA - ALUMINUM SECTION WINDOWS
DA - ALUMINUM SECTION DOOR

PROJECT:
**PROPOSED LAYOUT PLAN OF HIG.
FLATS (B+STILT+ 9) AT DWARKA PATH,
MANSAROVER,
JAIPUR.**

DRAWING TITLE:
**GROUND,SECOND,FOURTH,
FLOOR PLAN
(ONE FLAT DOOR/WINDOW LAYOUT)
BLOCK - A**

CLIENT:
**RAJASTHAN HOUSING BOARD
JAIPUR.**

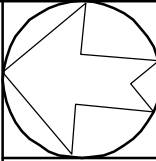

P. N. BHARGAVA
ARCHITECT-PLANNER
CA/76/745

ARCHITECT:
B. E. CONSULTANTS
ARCHITECTURE, PLANNING, INTERIORS
A-187, MALVIYA NAGAR, JAIPUR.
PHONE: 2622876, FAX: 8141-365874
MOBILE: 98-68899-88887
EMAIL: bhargava@bepc.com
www.bepc.com

SCALE : 1 : 100

DATE : 06-10-2014

JOB NO. :

DWG. NO. :

A

32R