


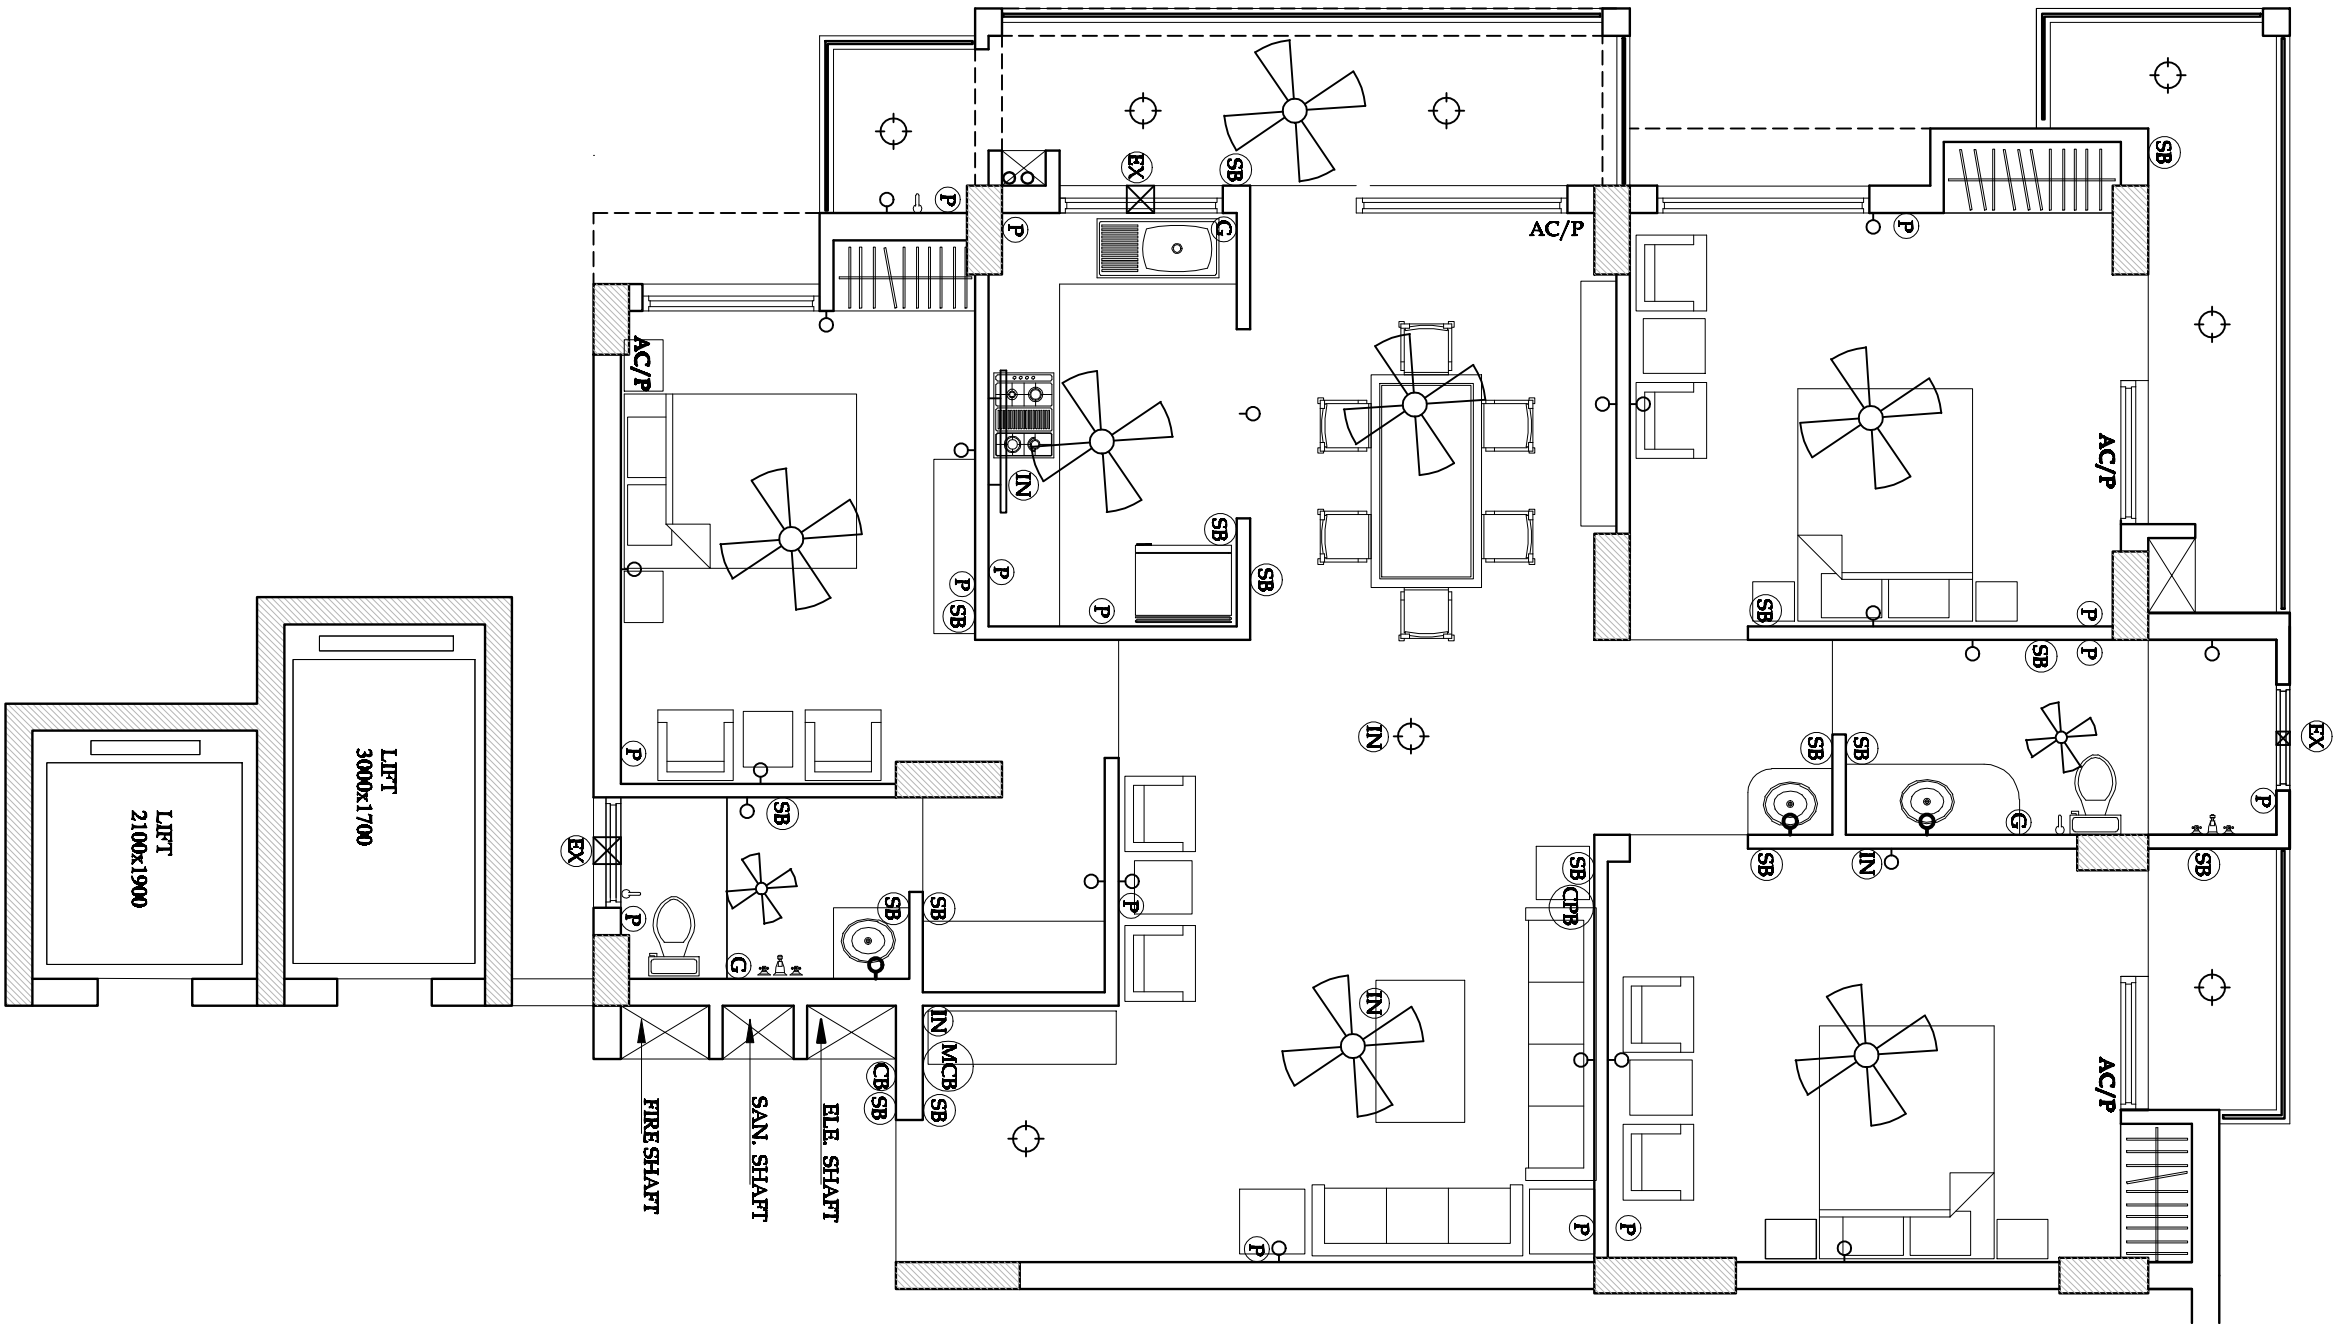

LEGEND:-

- SB - SWITCH BOARD WITH 5 PIN SAMP SOCKET-FFL(BOTTOM OF SWITCH PLATE 1500)
- P - POWER POINT BOARD-450 IN KITCHEN 200 ABOVE PLATFORM
- - WALL LIGHT - 2650 FROM FFL(BOTTOM OF SWITCH)
- CB - CALL BELL-2650 FROM FFL(BOTTOM OF BELL)
- CBP - CALL BELL POINT-1500 FROM FFL(BOTTOM OF SWITCH PLATE)
- ✂ - CEILING FAN -1200 IN ROOMS/ 600 IN TOILET/DRESS/STORE
- ☒ - EXHAUST FAN
- ⊙ - GEYSER - 2650 FROM FFL (BOTTOM OF GEYSER)
- ⊕ - CEILING LIGHT
- MCB - MAIN CIRCUIT BOARD (BOTTOM OF BOARD -2100 FROM FFL)
- AC/P - AIR CONDITIONING POINT
- IN - PLACE FOR INVENTOR/ LIGHT/FAN WITH INVENTOR

PROJECT:
PROPOSED LAYOUT PLAN OF HIG. FLATS (B+STILT+ 9),AT DWARKA PATH, MANSAROVER, JAIPUR.

DRAWING TITLE:
GROUND,SECOND,FOURTH, FLOOR PLAN (ONE FLAT ELECTRIC LAYOUT PLAN) BLOCK - A

CLIENT:
RAJASTHAN HOUSING BOARD JAIPUR.

P. N. BHARGAVA
ARCHITECT-PLANNER
CA/76/743

ARCHITECT:
B. E. CONSULTANTS
ARCHITECTURE, PLANNING, INTERIORS
A-237, MAHATMA NAGAR, JAIPUR.
PHONE 2622376, FAX 0141-262076
MOBILE : 94680-82007
E-MAIL : bhargava@beyond.com
<http://www.beyond.com>

SCALE :

JOB NO. :

DATE : 01-15-2014

DWG. NO. :

A
36R