



LEGEND:-

- SWITCH BOARD WITH 5 PIN SAMP SOCKET — FFL(BOTTOM OF SWITCH)
- CEILING FAN — 1050 IN ROOMS/ 600 IN TOILET/DRESS/STORE
- WALL LIGHT — 2550MM FROM FFL(BOTTOM OF SWITCH)
- POWER POINT — 450 MM
- CEILING LIGHT
- MINIATURE CIRCUIT BREAKER
- 1X 1200W WALL TUBE LIGHT
- CIRCUIT CONDUIT (32mm)
- POWER CONDUIT (25mm)

PROPOSED LAYOUT PLAN OF HIG. FLATS (B+STILT+ 9), AT DWARKA PATH, MANSAROVER, JAIPUR.


**BASMENT FLOOR PLAN
ELECTRIC LAYOUT PLAN
COMPOSITE**

**RAJASTHAN HOUSING BOARD
JAIPUR.**



R. H. CONSULTANTS
ARCHITECTS, ENGINEERS, INTERIORS DESIGNERS, PROJECT MANAGERS, EPC CONTRACTORS
OFFICE: 10/1, KALKAJI MARG, KALKAJI, NEW DELHI-110019
CONTACT: 011-26100000, 011-26100001
WWW.RHCONSULTANTS.COM

AB
20A

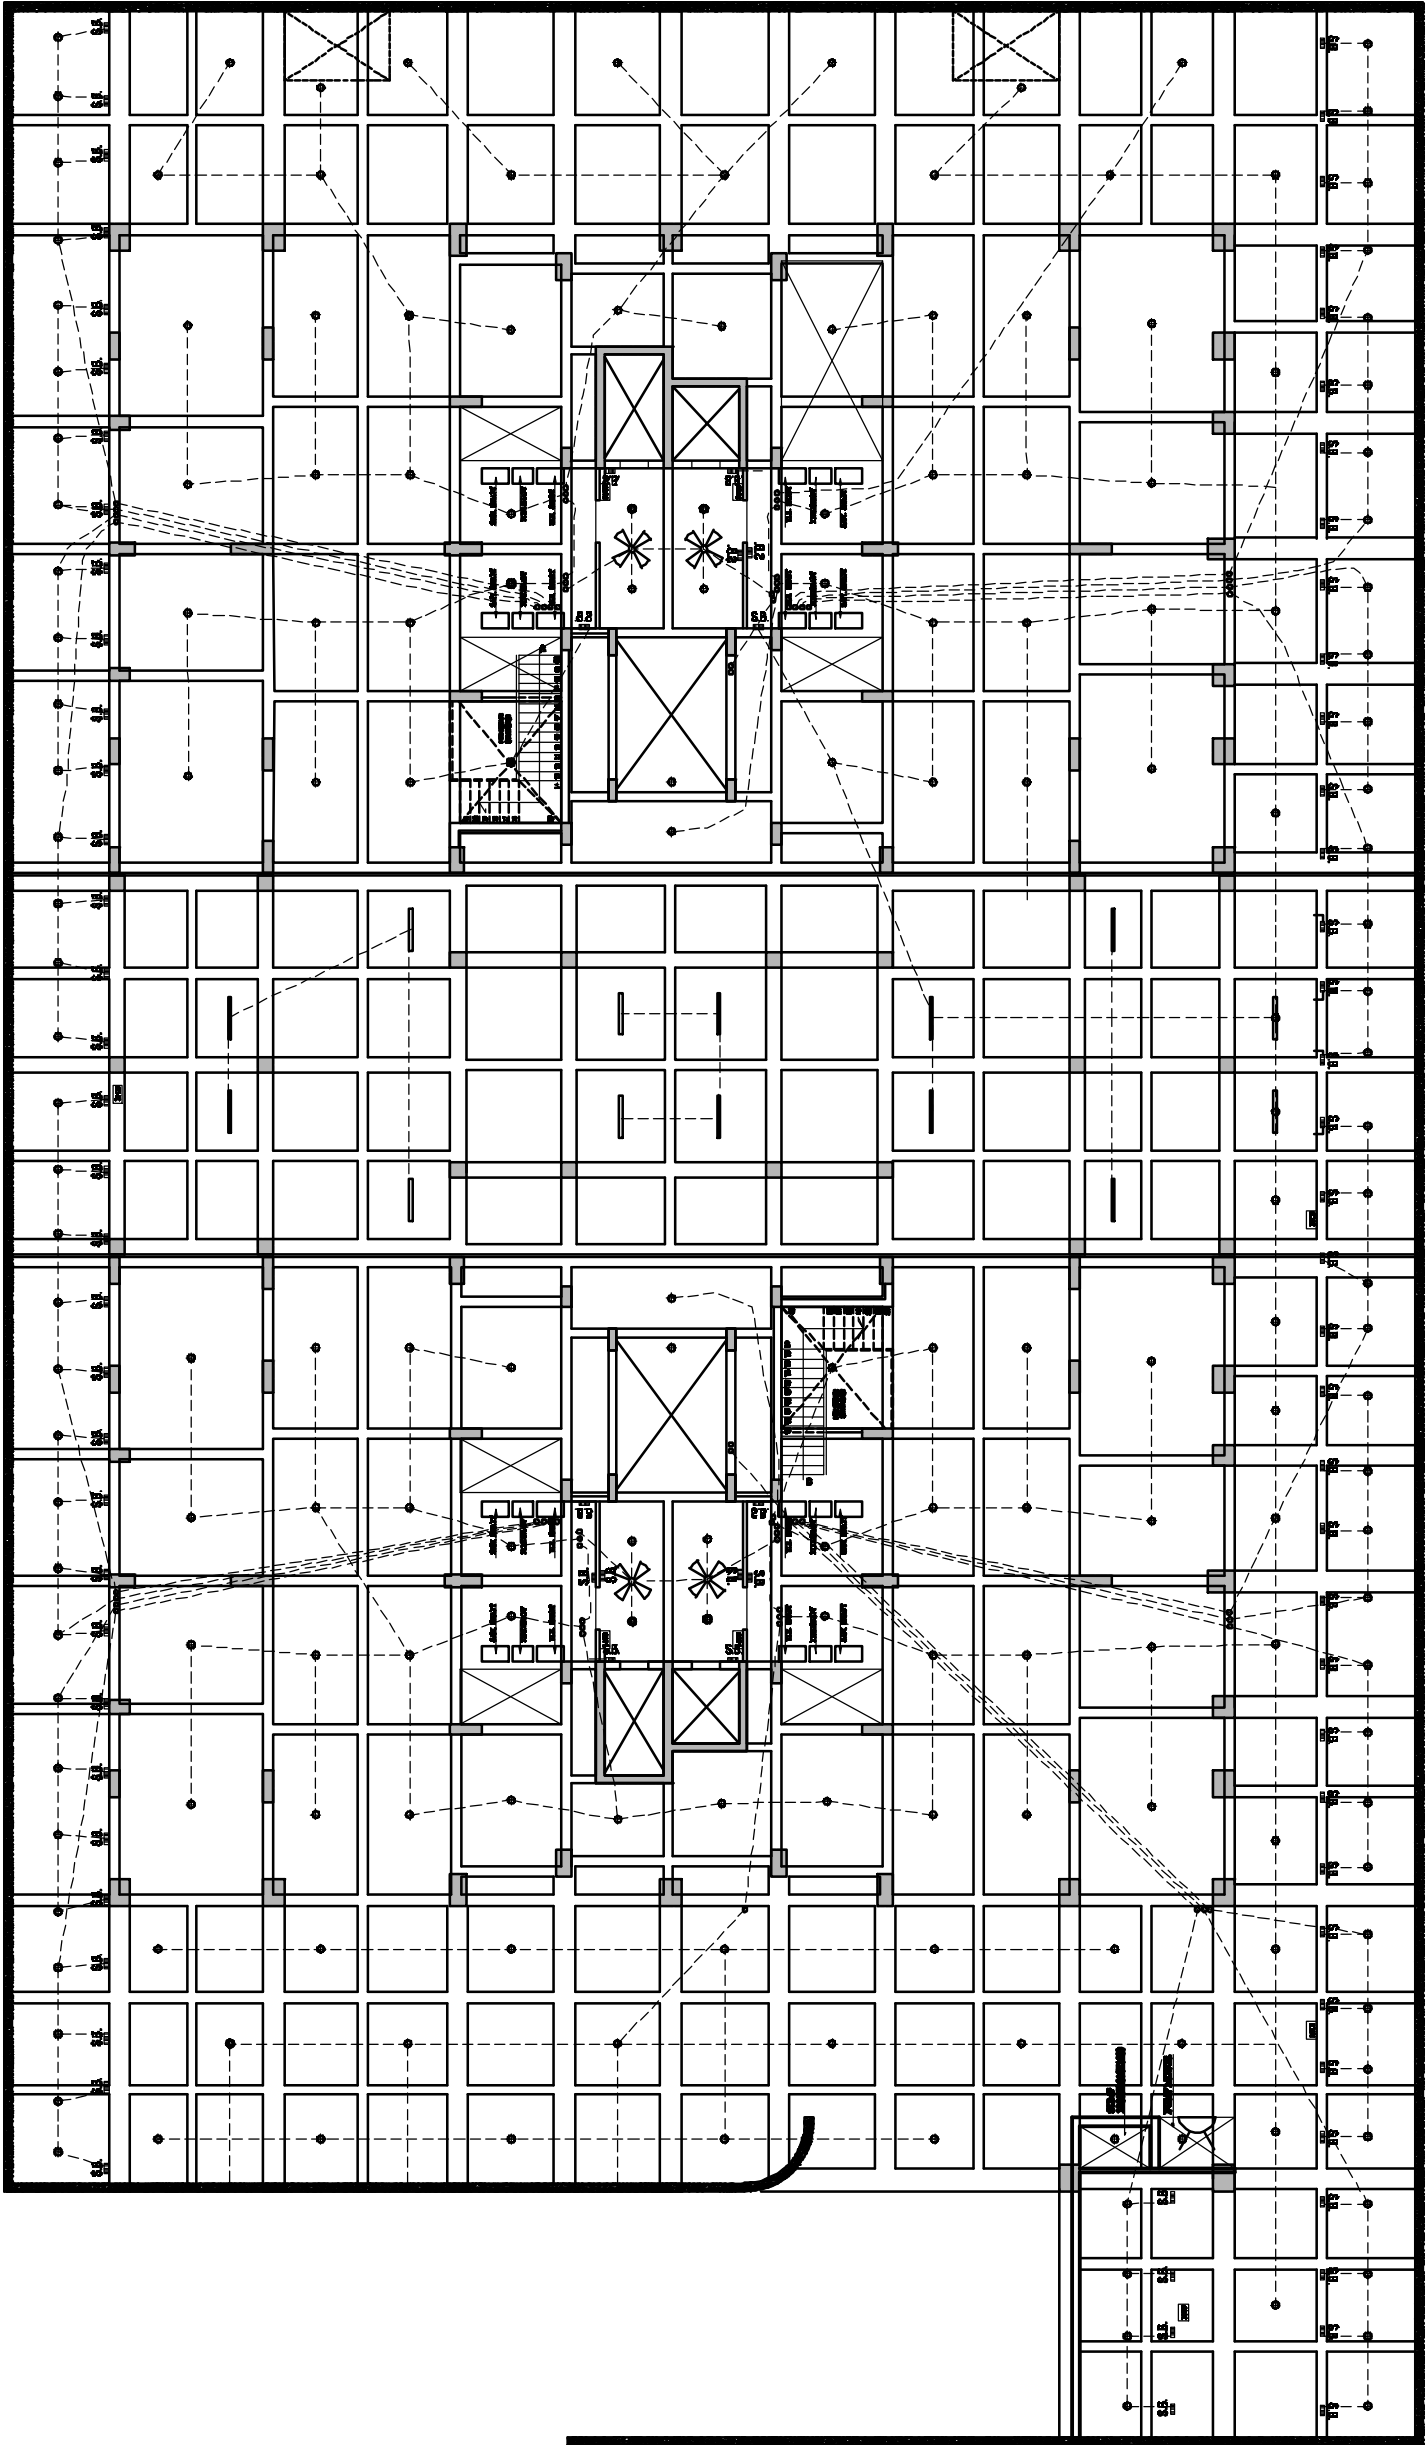



LEGEND:-

- ① SWITCH BOARD WITH 5 PIN SAMP SOCKET - FFL (BOTTOM OF SWITCH PLATE 1500)
- ② POWER POINT BOARD - 450 IN KITCHEN 200 ABOVE PLATFORM
- WALL LIGHT - 2650 FROM FFL (BOTTOM OF SWITCH)
- ✱ CEILING FAN - 1200 IN ROOMS / 600 IN TOILET/DRESS/STORE
- ⊠ EXHAUST FAN
- ⊙ GEYSER - 2650 FROM FFL (BOTTOM OF GEYSER)
- ⊕ CEILING LIGHT
- Ⓜ MAIN CIRCUIT BOARD (BOTTOM OF BOARD - 2100 FROM FFL)

PROJECT

PROPOSED LAYOUT PLAN OF HIG. FLATS (B+STILT+ 9), AT DWARKA PATH, MANSAROVER, JAIPUR.

DRAWING TITLE

**STILT FLOOR PLAN
ELECTRIC LAYOUT PLAN
COMPOSITE**

CLIENT

**RAJASTHAN HOUSING BOARD
JAIPUR.**

P. N. BHARGAVA
ARCHITECT-MANAGER
CA/78/7/3

B. E. CONSULTANTS
ARCHITECTURAL PLANNING ENGINEER
A-107, RAJASTHAN HOUSING BOARD
PREMises, Mansarovar, Jaipur
PH: 2635-2525
MO: 98290-98290
WWW.BECONSULTANTS.COM

SCALE :

DATE : 04-10-2014

JOB. NO. :

AB

DWG. NO. :

21A

