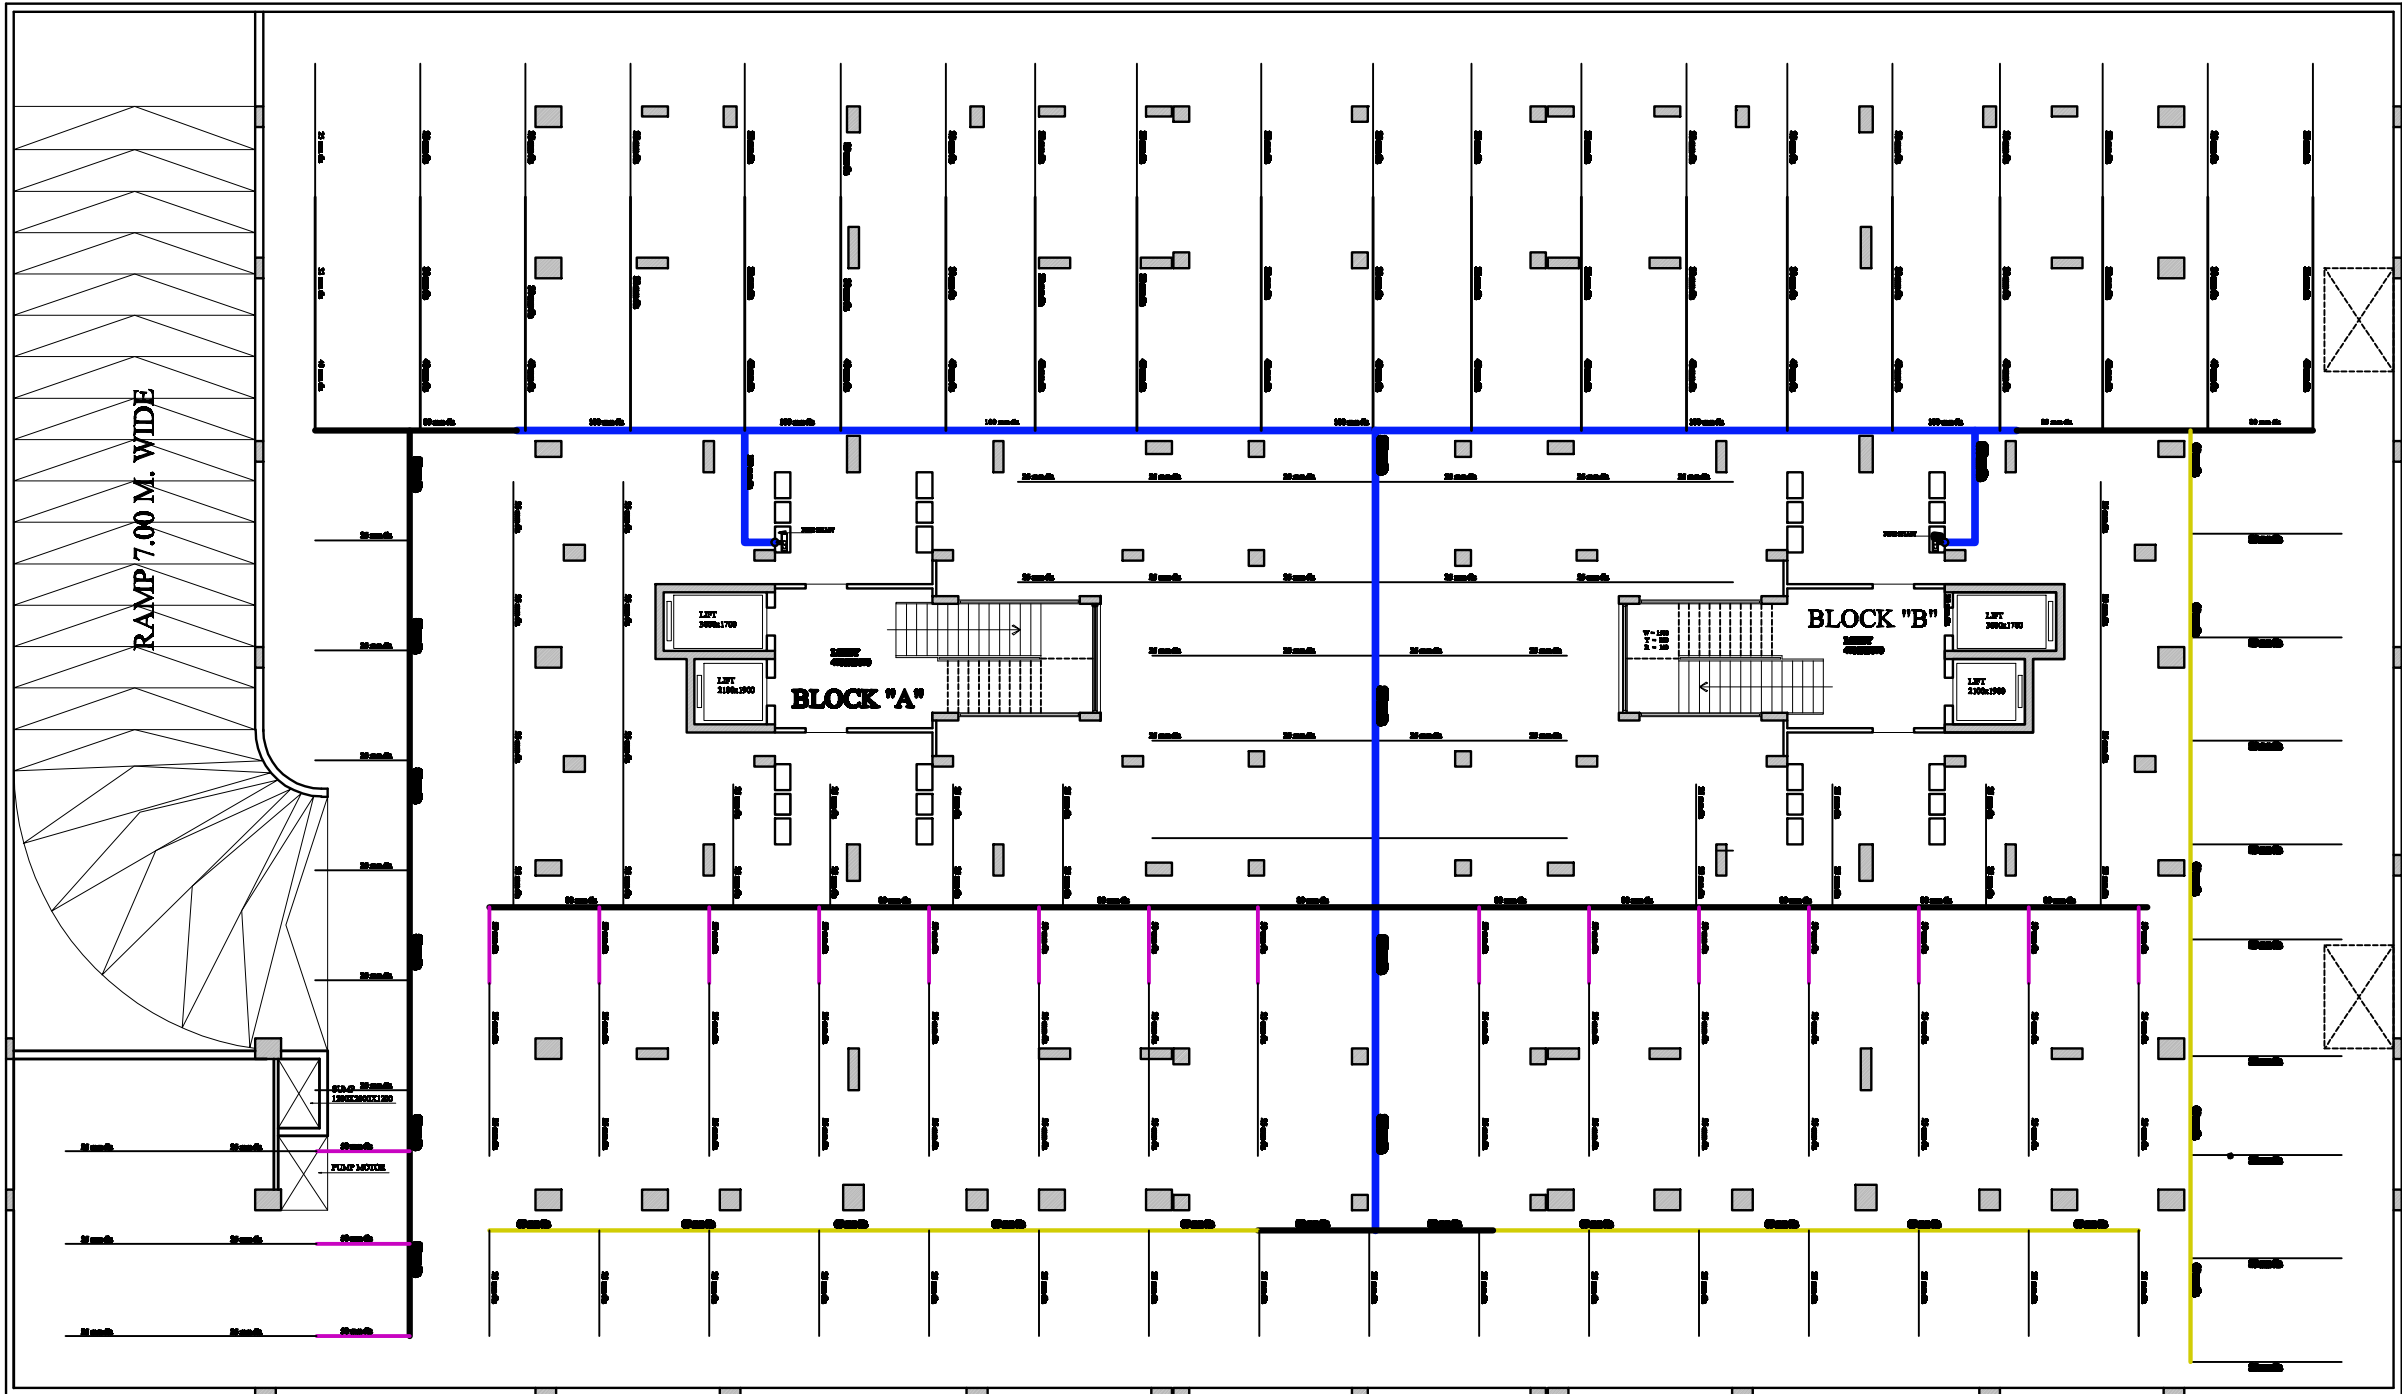


LEGENDS:

SYMBOL	Description	
⊙	Sprinkler	313
—	25mm Ø pipe	
—	32mm Ø pipe	
—	40mm Ø pipe	
—	50mm Ø pipe	
—	60mm Ø pipe	
—	80mm Ø pipe	
—	100mm Ø pipe	
⊕	FIRE HOSE REFL	

PROJECT:
PROPOSED LAYOUT PLAN OF HIG.
FLATS (B+STILT+ 9), AT DWARKA MARG,
MANSAROVER,
JAIPUR.

DRAWING TITLE:
**SPRINKLER LAYOUT
BASEMENT LVL.**

CLIENT:
**RAJASTHAN HOUSING BOARD
JAIPUR.**

A Y INFRA SERVICES

1201, RANI SATI NAGAR, NEAR
MANSAROVER METRO STATION, JAIPUR
PH. +91-9868285005, +91-9868465005
E-MAIL- aybuildingservices@gmail.com

P. N. BHARGAVA
ARCHITECT-PLANNER
CA/78/748

B. E. CONSULTANTS
ARCHITECTURE, PLANNING, INTERIOR
A-407, MANSAR NAGAR, JAIPUR
TEL: 0141-2500000, 0141-2500001
MOB: 9414000000
WWW.BECONSULTANTS.COM

SHEET : 23-01-01

JOB. NO. :

DWG. NO. :

AB
84