
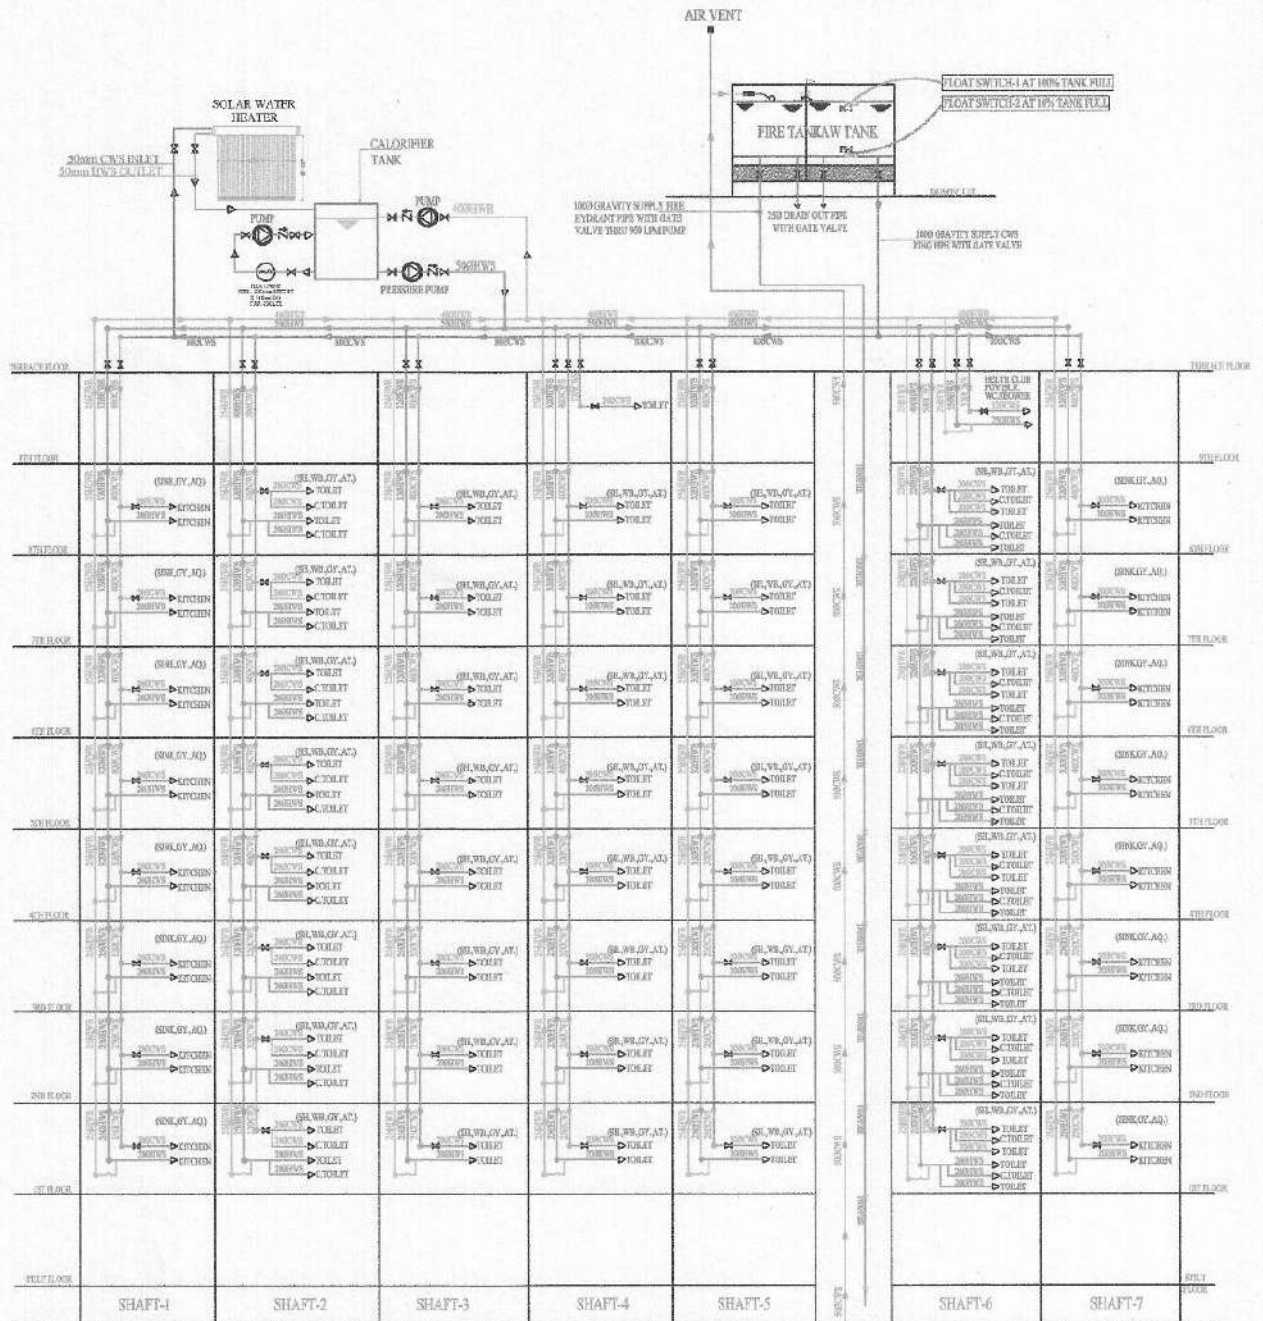


HENDRA YADAV
ARCHITECT
CA/2013/61957

CLIENT: MR. PRAVEEN JAIN KOTA RAJ.	DRAWING TITLE: WATER SUPPLY SCHEMATIC DIG.	DATE: 25/9/20	PROJECT CODE: NHDC 1002	STRUCTURAL CONSULTANT: 	GENERAL NOTES: 1. ALL DIMENSIONS ON THE DRAWING ARE IN FEET & INCHES UNLESS OTHERWISE SPECIFIED. 2. DIMENSIONS ON THE DRAWING ARE NOT TO BE SCALED, ONLY DIMENSIONS ARE TO BE FOLLOWED. 3. THE GROUND LEVEL IS THAT OF GROUND APPROACH ROAD. ALL OTHER LEVELS MENTIONED ARE UNFINISHED FLOOR LEVELS & ALL VERTICALS. 4. DIMENSIONS ARE TO BE MEASURED FROM THIS LEVEL. 5. ALL THE DISCREPANCIES TO BE BROUGHT TO NOTICE OF THE ARCHITECT AND RESOLVED BEFORE THE COMMENCEMENT OF THE WORK.	PRINTED BY: 25/9/20	DRAWN BY: S. SHARMA	CHECKED BY: CHANDRASEKHAR	APPROVED BY: H. YADAV
PROJECT: VASTU 16	SHEET NO. OF TOTAL: 01 OF 01	DATE: 25/9/20	PROJECT CODE: NHDC 1002	STRUCTURAL CONSULTANT: 	GENERAL NOTES: 1. ALL DIMENSIONS ON THE DRAWING ARE IN FEET & INCHES UNLESS OTHERWISE SPECIFIED. 2. DIMENSIONS ON THE DRAWING ARE NOT TO BE SCALED, ONLY DIMENSIONS ARE TO BE FOLLOWED. 3. THE GROUND LEVEL IS THAT OF GROUND APPROACH ROAD. ALL OTHER LEVELS MENTIONED ARE UNFINISHED FLOOR LEVELS & ALL VERTICALS. 4. DIMENSIONS ARE TO BE MEASURED FROM THIS LEVEL. 5. ALL THE DISCREPANCIES TO BE BROUGHT TO NOTICE OF THE ARCHITECT AND RESOLVED BEFORE THE COMMENCEMENT OF THE WORK.	PRINTED BY: 25/9/20	DRAWN BY: S. SHARMA	CHECKED BY: CHANDRASEKHAR	APPROVED BY: H. YADAV
PROJECT: VASTU 16	SHEET NO. OF TOTAL: 01 OF 01	DATE: 25/9/20	PROJECT CODE: NHDC 1002	STRUCTURAL CONSULTANT: 	GENERAL NOTES: 1. ALL DIMENSIONS ON THE DRAWING ARE IN FEET & INCHES UNLESS OTHERWISE SPECIFIED. 2. DIMENSIONS ON THE DRAWING ARE NOT TO BE SCALED, ONLY DIMENSIONS ARE TO BE FOLLOWED. 3. THE GROUND LEVEL IS THAT OF GROUND APPROACH ROAD. ALL OTHER LEVELS MENTIONED ARE UNFINISHED FLOOR LEVELS & ALL VERTICALS. 4. DIMENSIONS ARE TO BE MEASURED FROM THIS LEVEL. 5. ALL THE DISCREPANCIES TO BE BROUGHT TO NOTICE OF THE ARCHITECT AND RESOLVED BEFORE THE COMMENCEMENT OF THE WORK.	PRINTED BY: 25/9/20	DRAWN BY: S. SHARMA	CHECKED BY: CHANDRASEKHAR	APPROVED BY: H. YADAV

This drawing is property of Nityendra Yadav Design Studio and shall not be used without the written consent of the Architect. It shall be used only for the project for which it is prepared and shall not be used for any other project without the written consent of the Architect. The Architect shall not be responsible for any errors or omissions in this drawing. The user of this drawing shall be responsible for its use. The Architect shall not be responsible for any errors or omissions in this drawing. The user of this drawing shall be responsible for its use.

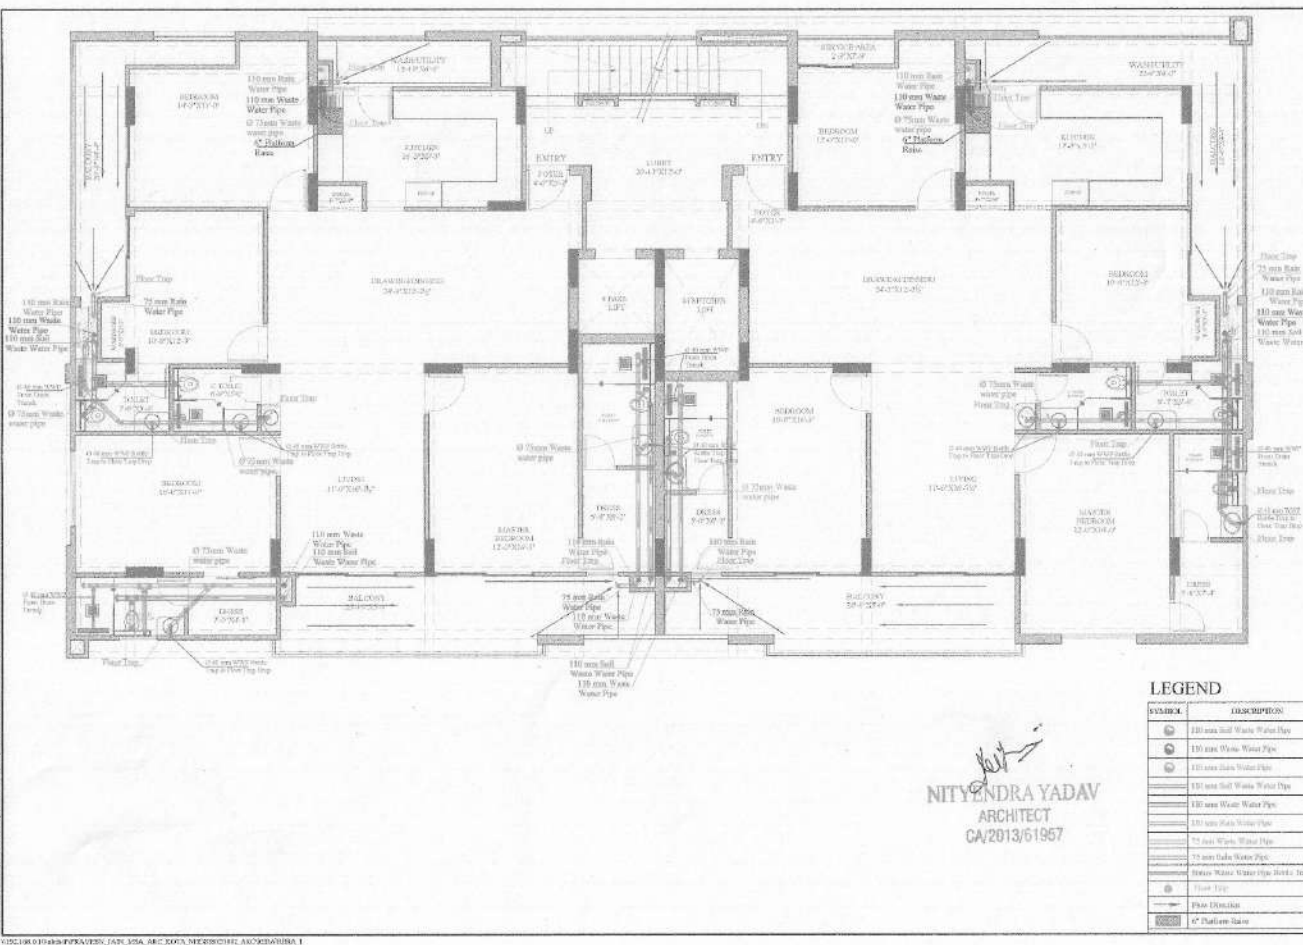

GENERAL NOTES:

- ALL DIMENSIONS ON THE DRAWINGS ARE IN FEET & INCHES UNLESS OTHERWISE SPECIFIED.
- DIMENSIONS ON THE DRAWINGS ARE NOT TO BE CHANGED. ONLY STATED DIMENSIONS ARE TO BE FOLLOWED.
- THE G.C. & L.V. IS THAT OF CREST OF APPROACH ROAD. ALL OTHER LEVELS MENTIONED ARE UNFINISHED FLOOR LEVELS & ALL VERTICAL DIMENSIONS ARE TO BE MEASURED FROM THIS LEVELS.
- ALL THE DISCREPANCIES TO BE BROUGHT TO NOTICE OF THE ARCHITECT AND RESOLVED BEFORE THE COMMENCEMENT OF THE WORK.

EXISTENTIAL CONDITIONS:

ELECTRICAL & MECHANICAL:

REFERENCE:

7.1.100. Indian Standard Code of Practice for Reinforced Concrete Structures (IS:456-1978)

NOTES:

NO.	DATE	BY	CHKD.
1	10/01/2013	MR. PRAVEEN JAIN	KOTA

CLIENT:

MR. PRAVEEN JAIN
KOTA

PROJECT:

MSA

DESIGN TITLE:

DRAINAGE LAYOUT
TYPICAL FLOOR PLAN
SHEET 01 OF 01

LEGEND:


SYMBOL	DESCRIPTION
100 mm dia. Water Pipe	100 mm dia. Water Pipe
150 mm dia. Water Pipe	150 mm dia. Water Pipe
100 mm dia. Waste Water Pipe	100 mm dia. Waste Water Pipe
150 mm dia. Waste Water Pipe	150 mm dia. Waste Water Pipe
75 mm dia. Water Pipe	75 mm dia. Water Pipe
75 mm dia. Waste Water Pipe	75 mm dia. Waste Water Pipe
40 mm dia. Water Pipe	40 mm dia. Water Pipe
40 mm dia. Waste Water Pipe	40 mm dia. Waste Water Pipe
150 mm dia. Water Pipe	150 mm dia. Water Pipe
150 mm dia. Waste Water Pipe	150 mm dia. Waste Water Pipe
75 mm dia. Water Pipe	75 mm dia. Water Pipe
75 mm dia. Waste Water Pipe	75 mm dia. Waste Water Pipe
40 mm dia. Water Pipe	40 mm dia. Water Pipe
40 mm dia. Waste Water Pipe	40 mm dia. Waste Water Pipe
Flow Direction	Flow Direction
4" Plastic Slope	4" Plastic Slope

THANCE DESIGN STUDIO

101, 102, 103, 999, 1000

NITYENDRA YADAV
ARCHITECT
CA/2013/61957

THIS DRAWING IS THE PROPERTY OF NITYENDRA YADAV ARCHITECT. IT IS TO BE USED ONLY FOR THE PROJECT AND SITE SPECIFICALLY MENTIONED. IT IS NOT TO BE REPRODUCED OR COPIED IN ANY MANNER WITHOUT THE WRITTEN PERMISSION OF THE ARCHITECT. ANY VIOLATION OF THIS NOTICE WILL BE PROSECUTED TO THE FULL EXTENT OF THE LAW.

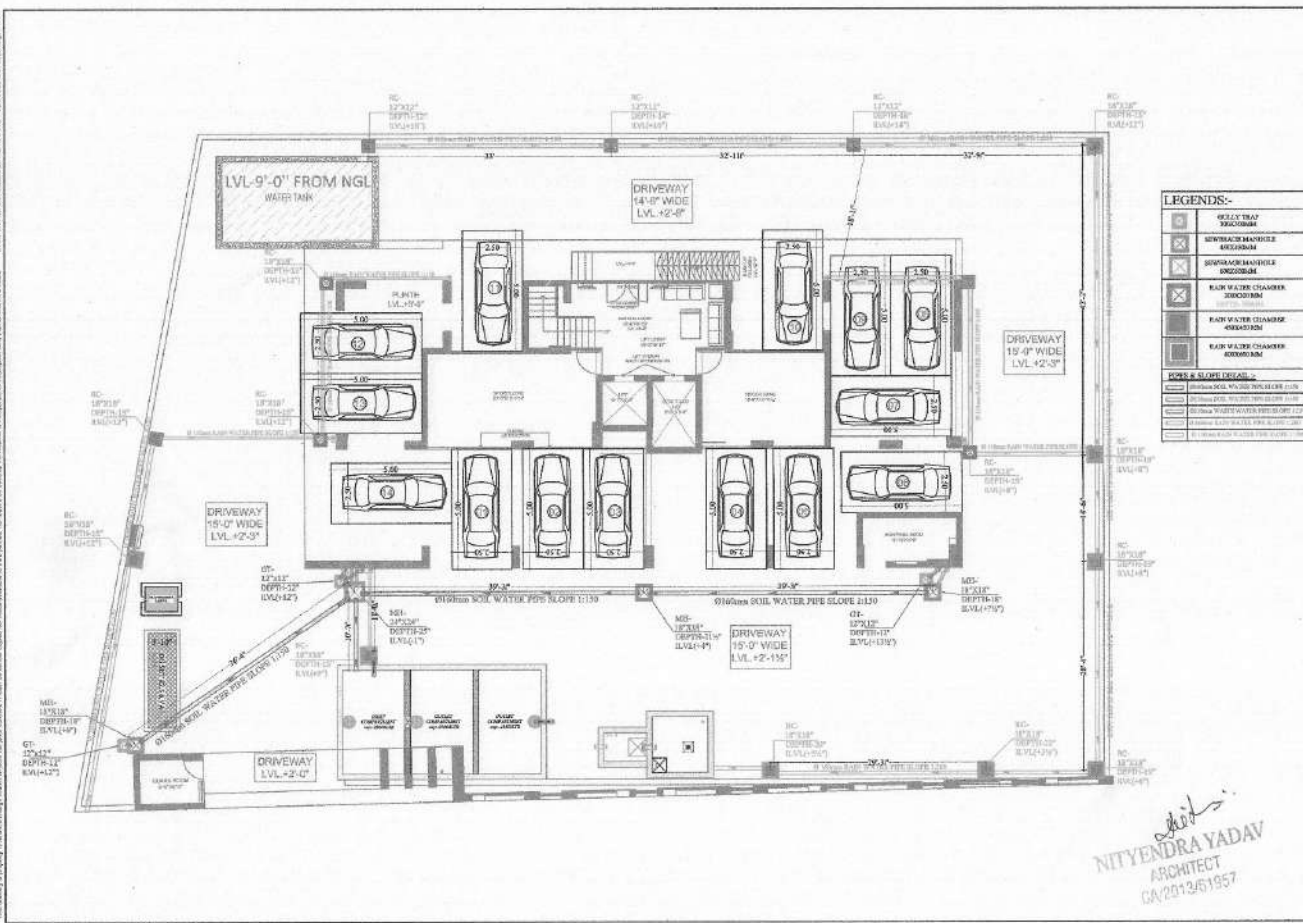

GENERAL NOTES:

- ALL DIMENSIONS ON THE DRAWING ARE IN FEET & INCHES UNLESS MENTIONED OTHERWISE.
- DIMENSIONS ON THE DRAWING ARE NOT TO BE SCALED. ONLY STATED DIMENSIONS ARE TO BE FOLLOWED.
- THE 0.00 + LVL. IS THAT OF GROUND APPROX. ROAD. ALL OTHER LEVELS MENTIONED ARE UNFINISHED FLOOR LEVELS & ALL VERTICAL DIMENSIONS ARE TO BE MEASURED FROM THIS LEVEL.
- ALL THE DISCREPANCIES TO BE BROUGHT TO NOTICE OF THE ARCHITECT AND RESOLVED BEFORE THE COMMENCEMENT OF THE WORK.

LEGENDS:-

- RAIN WATER COLLECTION
- DOWNPIPE
- RAIN WATER CHAMBER
- RAIN WATER CHAMBER
- RAIN WATER CHAMBER

POWER & SLOPE DETAILS:

- DOWNPIPE SLOPE 1:100
- RAIN WATER CHAMBER SLOPE 1:50
- RAIN WATER CHAMBER SLOPE 1:50
- RAIN WATER CHAMBER SLOPE 1:50
- RAIN WATER CHAMBER SLOPE 1:50

GENERAL INFORMATION:

CLIENT: MR. PRAVEEN JAIN KOTA RAJ.

PROJECT: VASTU 16

EXTERNAL DRAINAGE & RAIN WATER PIPE ROUTE PLAN

SHEET 01 OF 01

DATE: 10/10/2013

SCALE: 1/8" = 1'-0"

DESIGNER: NITYENDRA YADAV

ARCHITECT: NITYENDRA YADAV

GA 2013/51957

Nhance DESIGN STUDIO

