


SERVICES CONSULTANT
 TYPE CONSULTING
 P-5-440 KESHAV MARG,
 CHITRAKUT SCHEME, JAIPUR
 PH-0145 4064300
 E-MAIL: yash@yash.com

PROJECT: VASTU 16 KOTA
 TITLE: ALL PANELS
 DRAWING: SINGLE LINE DIAGRAM
 DATE: 17-12-2018 REV: 00
 DRAWN BY: KALASH RISHI
 CHECKED BY: VIPUL AGRAWAL

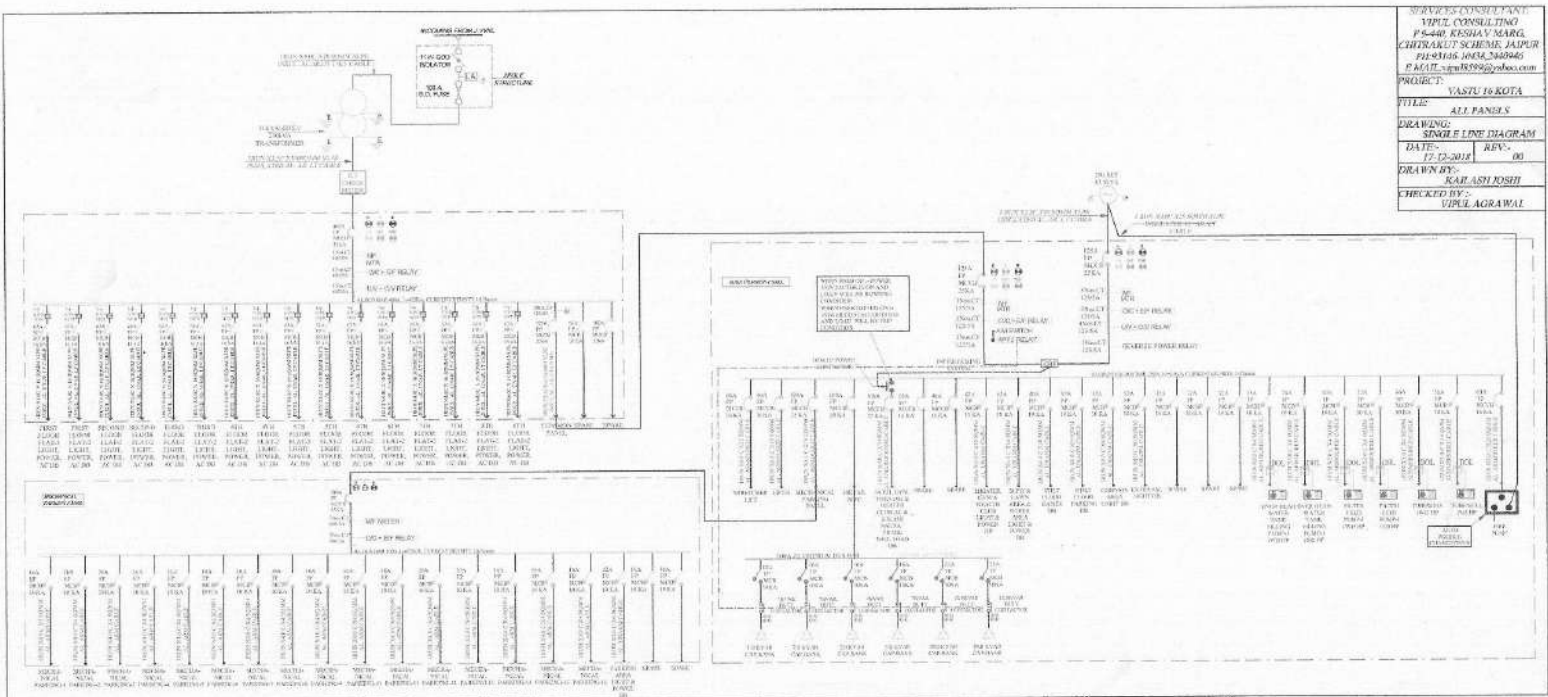

Kalash Rishi
 NITYENDRA YADAV
 ARCHITECT
 CA/2013/61957

