



LEGENDS:				
Mounting Height	No.	I D	Symbol	Description
IN FLOOR				CONTROL WIRING
IN CONDUIT				CONTROL WIRING
IN CONDUIT				AC CONTROL WIRING
IN CONDUIT				GYSER CONTROL WIRING
IN CONDUIT				BUZZER CONTROL WIRING
CEILING	06	FAN/48"		CEILING FAN 48"
CEILING	02	FAN/30"		CEILING FAN 30"
+90"	04	TL		1X40W WALL TUBELIGHT
+90"	04	BULB		WALL BRACKETS AS DESIGN LIGHT
+90"	01	GL		WALL BRACKETS AS DESIGN FOR GANESH LIGHT
	02	GL		WALL BRACKETS AS DESIGN FOR GATE LIGHT
CEILING	21	CFL		CFL CEILING LIGHT
+21"	02	FL		FOOT LIGHT
+48"	14	SB		SWITCH BOARD
+78"	03	ML		1 X 11 W CFL MIRROR LIGHT
VENTILATOR HT.	03	CR		CEILING ROSE
VENTILATOR HT.	03	EXF		9" DIA FRESH AIR FAN
+24"	02	TEL		TELEPHONE POINT
+27"	03	TV		TV COAXIAL POINT.
+24"	02	LP TEL		6 A PLUG POINT FOR TELEPHONE
+27"	03	LP TV		6 A PLUG POINT FOR TV
+24"	02	LP		6 A PLUG POINT
+72"	01	LP-CH		6 A PLUG POINT FOR CHIMNEY
+102"	03	SAC		SPLIT AC
+102"	03	PP-SAC		25 A POWER POINT FOR SPLIT AC
+42"	01	PP-MIX		15 A POWER POINT FOR MIXER
+78"	02	PP-G		15 A POWER POINT FOR GYSER
+54"	01	PP-F		15 A POWER POINT FOR FRIDGE
+78"	01	PP-WP		15 A POWER POINT FOR WATER PURIFIER
+48"	01	PP-WM		15 A POWER POINT FOR WASHING MACHINE
+42"	02	BP		BELL PUSH SWITCH
+90"	01	BZ		BUZZER POINT
+24"	03	AC		AC STARTER
+60"	01	MCB DB		MCB DISTRIBUTION BOARD
	05		SB1/L1	SWITCH BOARD NO. / LIGHT CIRCUIT NO.
	03		AC	AC CIRCUIT NO.
	05		PI	POWER CIRCUIT NO.

PROJECT TITLE :-

PROPOSED RESIDENTIAL BUILDING AT PLOT-20821, HARE KRISHNA VILL.-IIND IN KHAS PER ARA NO.309 T0312.311/374.316 TO 320 VILL.DHOAJI, SANGANER, JAIPUR

DRAWING TITLE :-

TYPICAL FLOOR PLAN ELECTRICAL DRAWING

GENERAL NOTES

1. All dimensions are in feet and inches.
2. Do not scale this drawing follow written dimensions only.
3. This drawing should be read in conjunction with other architectural and structural drawings.
4. Any discrepancy in the drawing should be immediately brought to the notice of architect.

CHKD BY :-

AR. VIJAY SHARMA

DRAWN BY :-

MANOJ KUMAWAT


DATE :-

12-05-2023

SCALE :-

NTS

NORTH :-

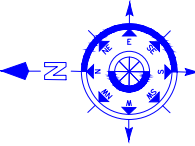

FILE PATH :-


VISTAAR ARCHITECTS & PLANNERS

Architects :: Interior Designers
B-2/12, Chitrkoot scheme,
main Gandhi Path, Opp mall of jaipur, Jaipur-21
Email-Vistaararchitects.web@gmail.com
PH.- 0141-4116461,09001010366

CONSULTANTS
Dr. LOKESH WADHWA
P.Tech.(Civil), M.Tech.(Structure)
IAI-StrucE AM-232

NOTE :-

This drawing is the sole copyright of Architects VISTAAR and should be used for the purpose expressly issued

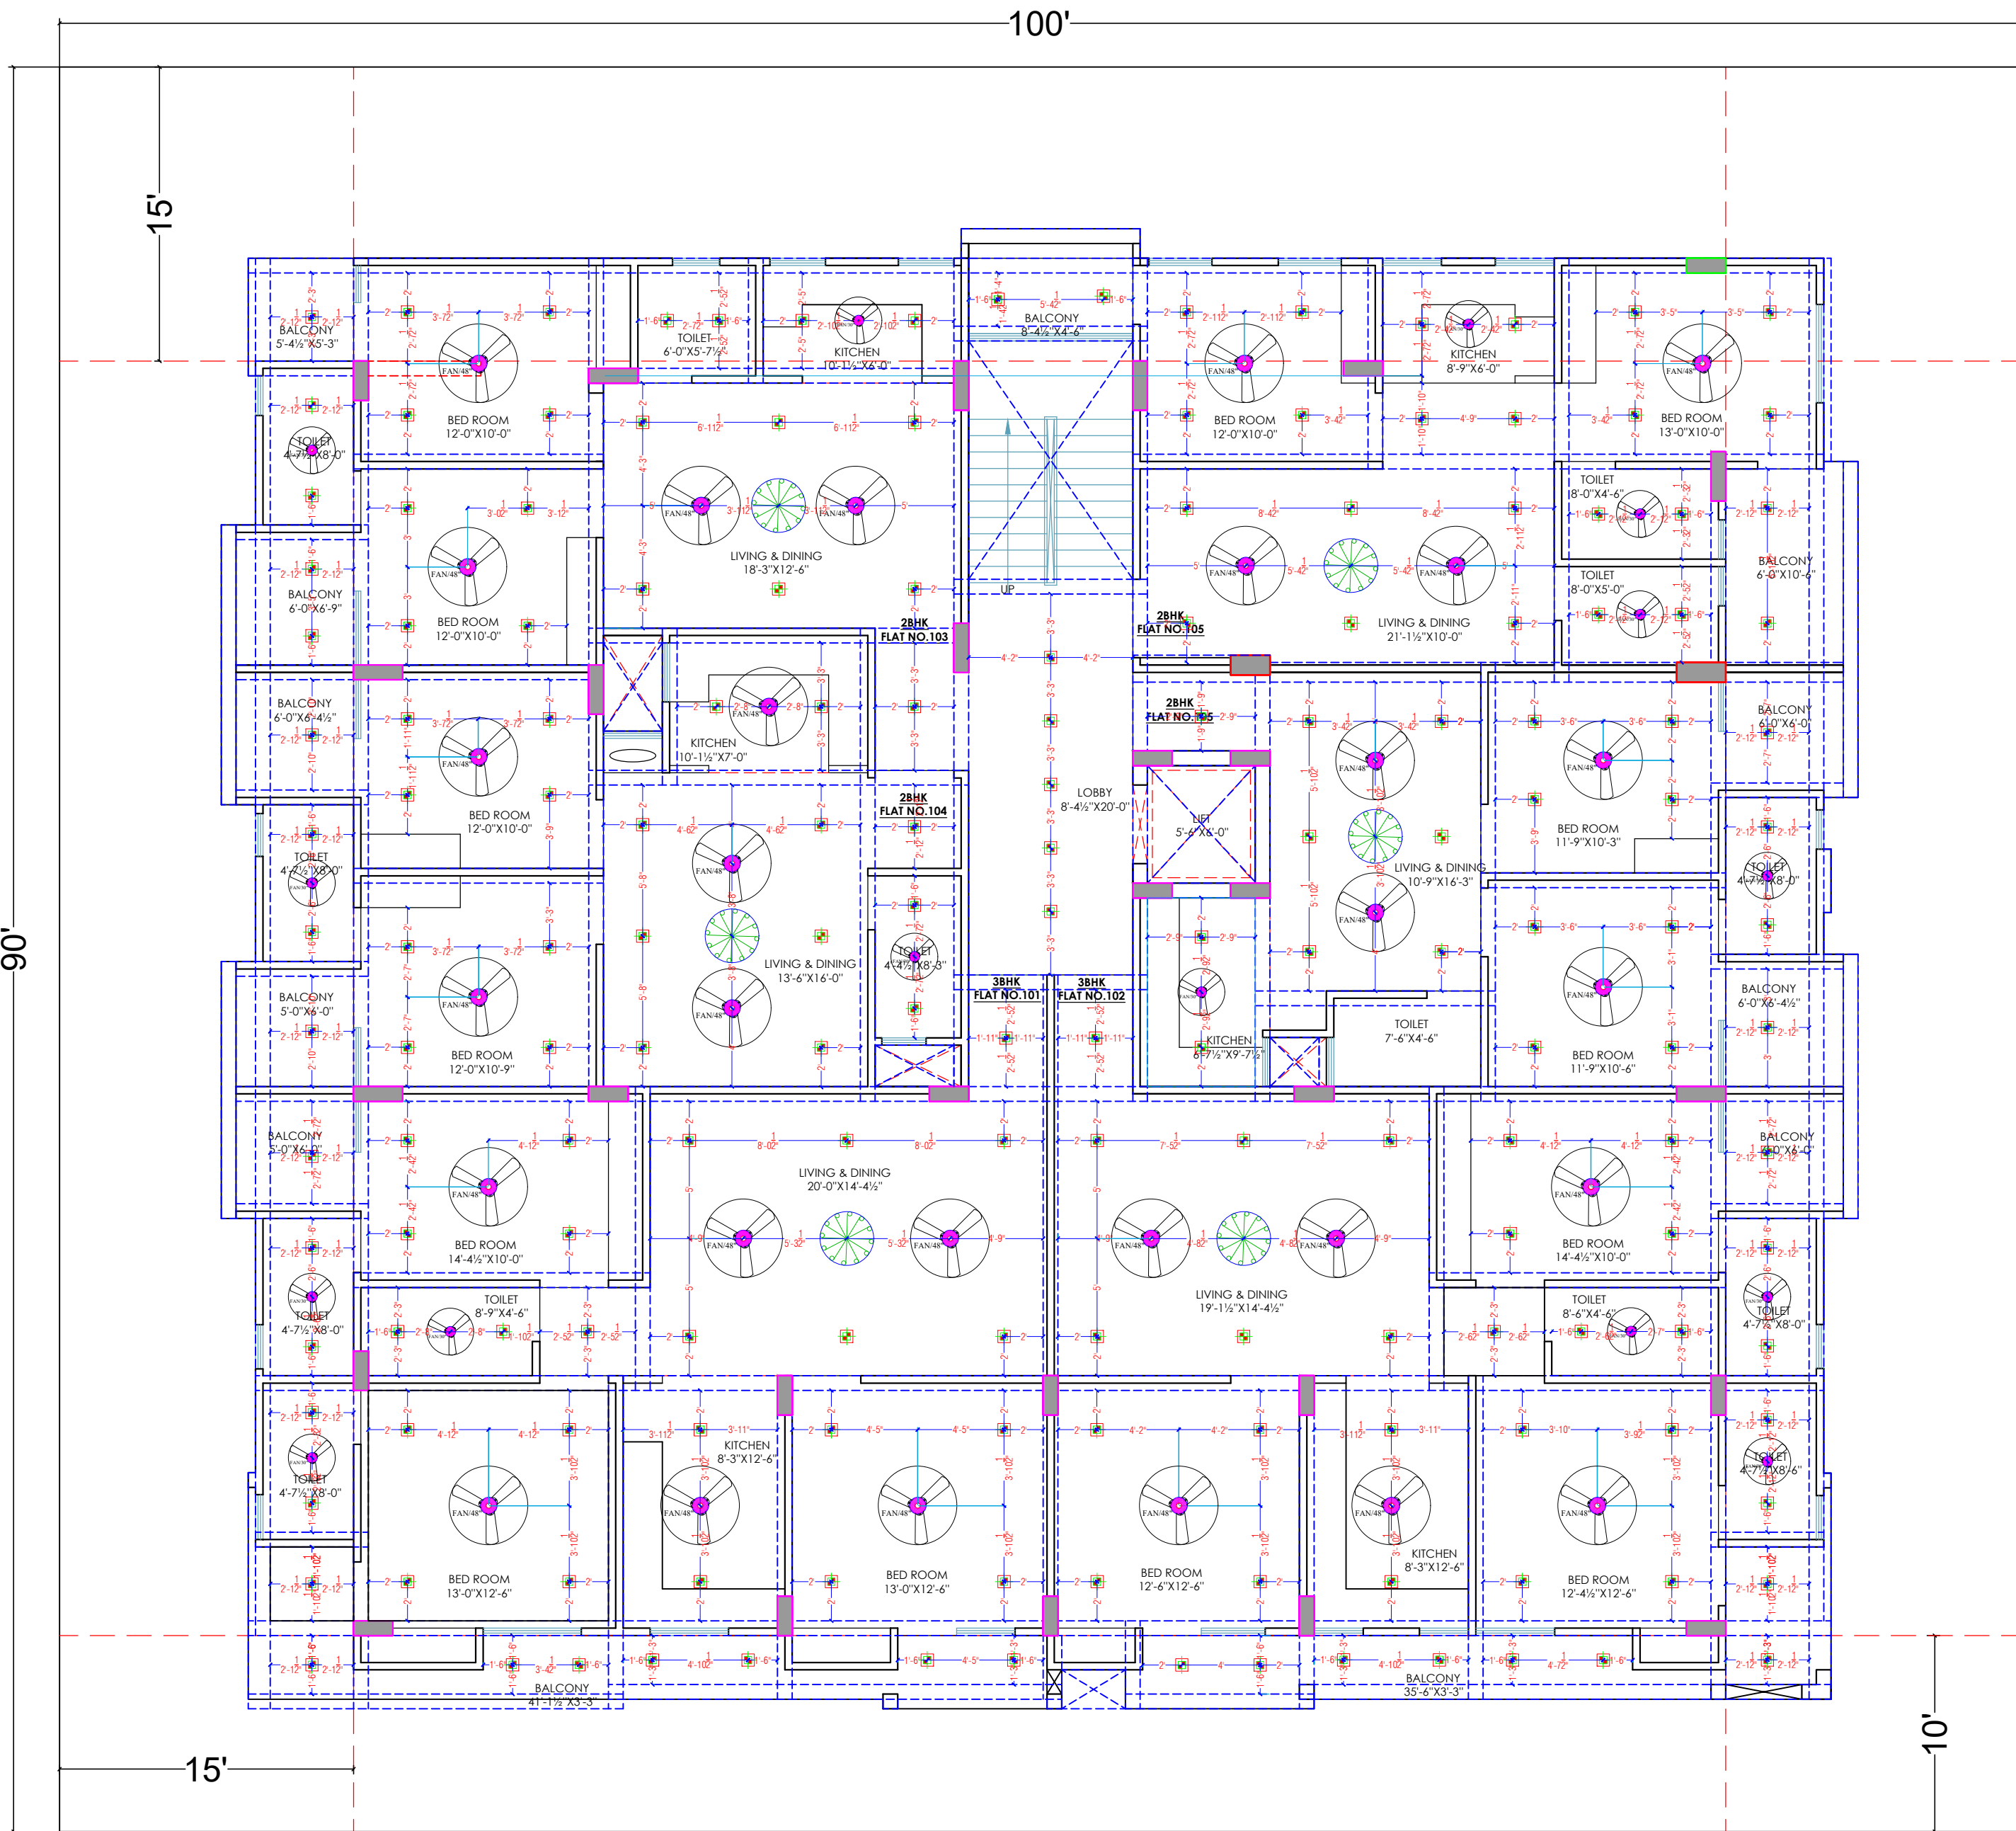

LEGENDS:				
Mounting Height	No.	I D	Symbol	Description
IN FLOOR			---	CONTROL WIRING
IN CONDUIT			---	CONTROL WIRING
IN CONDUIT			---	AC CONTROL WIRING
IN CONDUIT			---	GYSER CONTROL WIRING
IN CONDUIT			---	BUZZER CONTROL WIRING
CEILING	06	FAN/48"		CEILING FAN 48"
CEILING	02	FAN/30"		CEILING FAN 30"
+90"	04	TL		1X40W WALL TUBELIGHT
+90"	04	BULB		WALL BRACKETS AS DESIGN LIGHT
+90"	01	GL		WALL BRACKETS AS DESIGN FOR GANESH LIGHT
	02	GL		WALL BRACKETS AS DESIGN FOR GATE LIGHT
CEILING	21	CFL		CFL CEILING LIGHT
+21"	02	FL		FOOT LIGHT
+48"	14	SB		SWITCH BOARD
+78"	03	ML		1 X 11 W CFL MIRROR LIGHT
VENTILATOR HT.	03	CR		CEILING ROSE
VENTILATOR HT.	03	EXF		9" DIA FRESH AIR FAN
+24"	02	TEL		TELEPHONE POINT
+27"	03	TV		TV COAXIAL POINT.
+24"	02	LP TEL		6 A PLUG POINT FOR TELEPHONE
+27"	03	LP TV		6 A PLUG POINT FOR TV
+24"	02	LP		6 A PLUG POINT
+72"	01	LP-CH		6 A PLUG POINT FOR CHIMNEY
+102"	03	SAC		SPLIT AC
+102"	03	PP-SAC		25 A POWER POINT FOR SPLIT AC
+42"	01	PP-MIX		15 A POWER POINT FOR MIXER
+78"	02	PP-G		15 A POWER POINT FOR GEYSER
+54"	01	PP-F		15 A POWER POINT FOR FRIDGE
+78"	01	PP-WP		15 A POWER POINT FOR WATER PURIFIER
+48"	01	PP-WM		15 A POWER POINT FOR WASHING MACHINE
+42"	02	BP		BELL PUSH SWITCH
+90"	01	BZ		BUZZER POINT
+24"	03	AC		AC STARTER
+60"	01	MCB DB		MCB DISTRIBUTION BOARD
	05			SWITCH BOARD NO./ LIGHT CIRCUIT NO.
	03			AC CIRCUIT NO.
	05			POWER CIRCUIT NO.

PROJECT TITLE :-
PROPOSED RESIDENTIAL
BUILDING AT PLOT-20&21,HARE KRISHNA VILL.-IIND IN KHAS
PER ARA NO.309 TO312,311/374,316 TO 320 VILL.DHOLAI,
SANGANER,JAIPUR

DRAWING TITLE :-
TYPICAL FLOOR PLAN
ELECTRICAL

GENERAL NOTES

1. All dimensions are in feet and inches.
2. Do not scale this drawing follow written dimensions only.
3. This drawing should be read in conjunction with other architectural and structural drawings.
4. Any discrepancy in the drawing should be immediately brought to the notice of architect.


CHKD BY :-
AR. VIJAY SHARMA

DRAWN BY :-
MANOJ KUMAWAT

DATE :-
12-05-2023

SCALE :-
NTS

NORTH :-

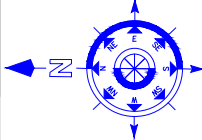


FILE PATH :-

VISTAAR ARCHITECTS & PLANNERS

Architects :: Interior Designers
B-2/12, Chitrakoot scheme,
main Gandhi Path,Opp mall of jaipur,Jaipur-21
Email-Vistaararchitects.web@gmail.com
PH.- 0141-4116461,09001010366

Ar. Lokesh Vaidhava
Ar. Lokesh Vaidhava
B.Tech.(Civil), M.Tech.(Structure)
W3/strudE AM-232

NOTE :-
This drawing is the sole copyright of Architects VISTAAR and should be used for the purpose expressly issued

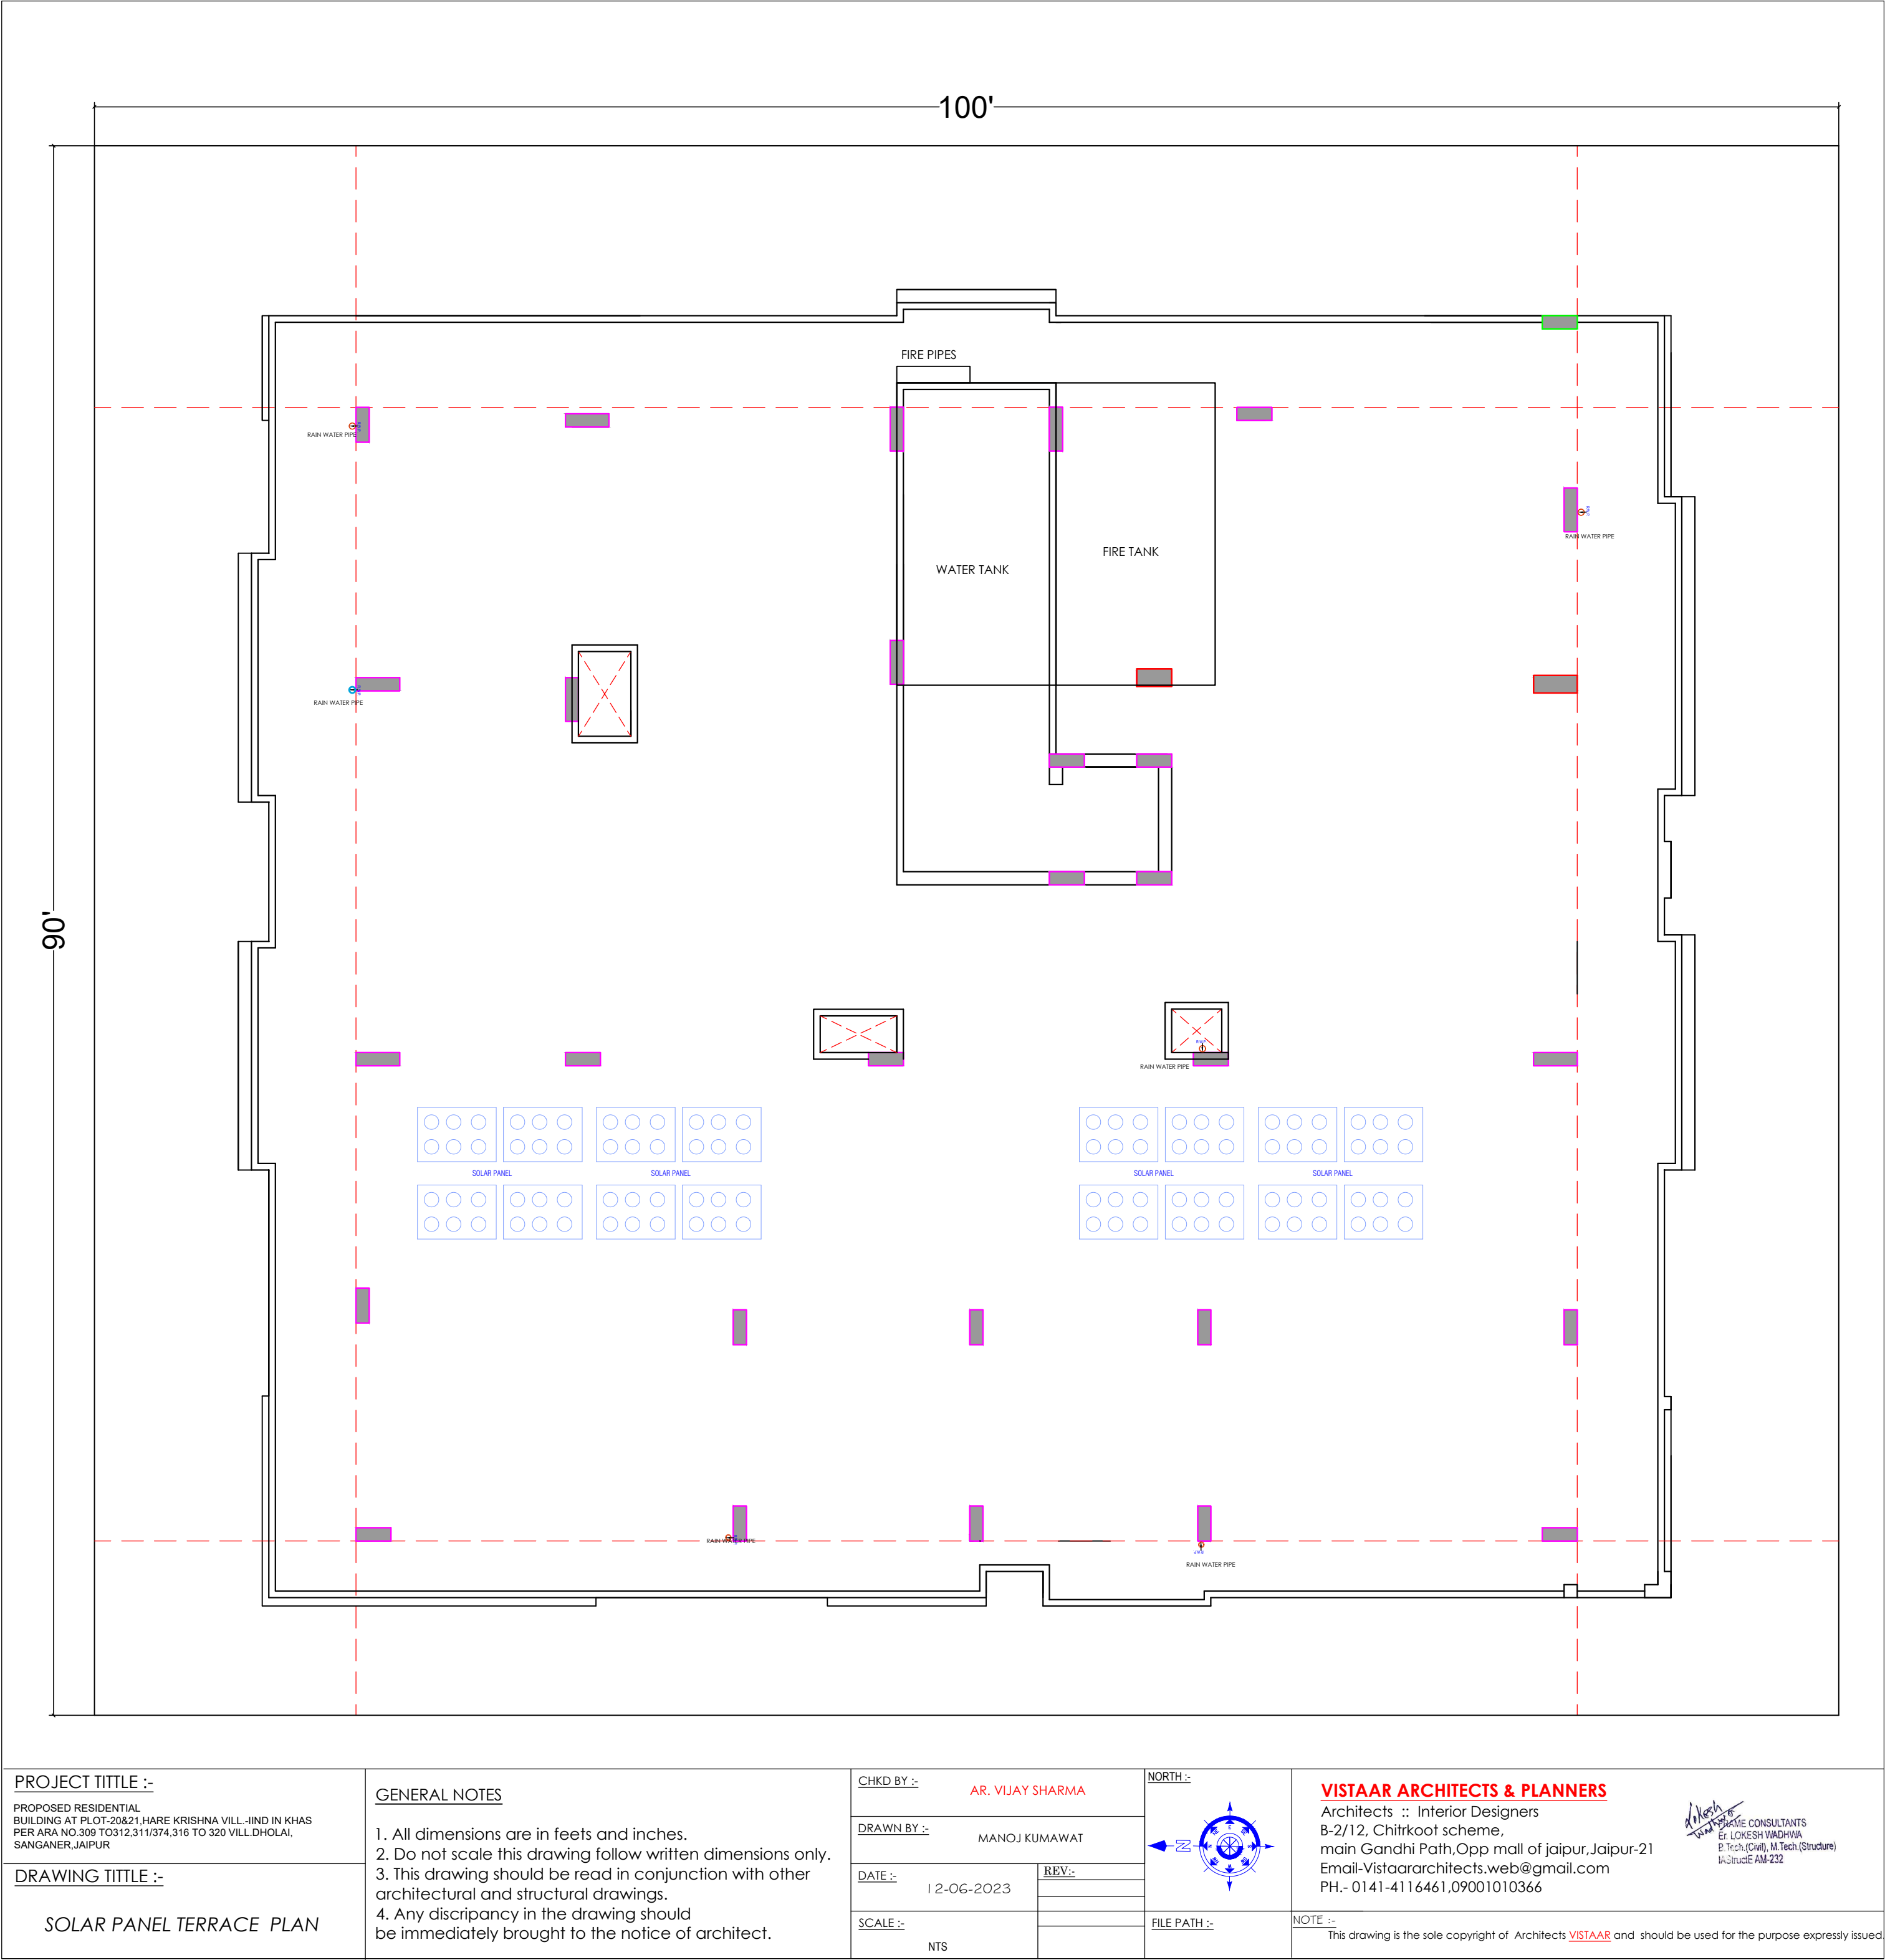

PROJECT TITLE :-
PROPOSED RESIDENTIAL
BUILDING AT PLOT-20&21,HARE KRISHNA VILL-IIND IN KHAS
PER ARA NO.309 TO312,311/374,316 TO 320 VILL.DHOLAI,
SANGANER,JAIPUR

DRAWING TITLE :-

SOLAR PANEL TERRACE PLAN

GENERAL NOTES

1. All dimensions are in feets and inches.
2. Do not scale this drawing follow wrtitten dimensions only.
3. This drawing should be read in conjunction with other
architectural and structural drawings.
4. Any discrepancy in the drawing should
be immediately brought to the notice of architect.

CHKD BY :-
AR. VIJAY SHARMA

DRAWN BY :-
MANOJ KUMAWAT

DATE :-
12-06-2023

SCALE :-
NTS

NORTH :-

FILE PATH :-

VISTAAR ARCHITECTS & PLANNERS
Architects :: Interior Designers
B-2/12, Chitrkoot scheme,
main Gandhi Path,Opp mall of jaipur,Jaipur-21
Email-Vistaararchitects.web@gmail.com
PH.- 0141-4116461,09001010366

NOTE :-
This drawing is the sole copyright of Architects **VISTAAR** and should be used for the purpose expressly issued