


MAIN PANEL

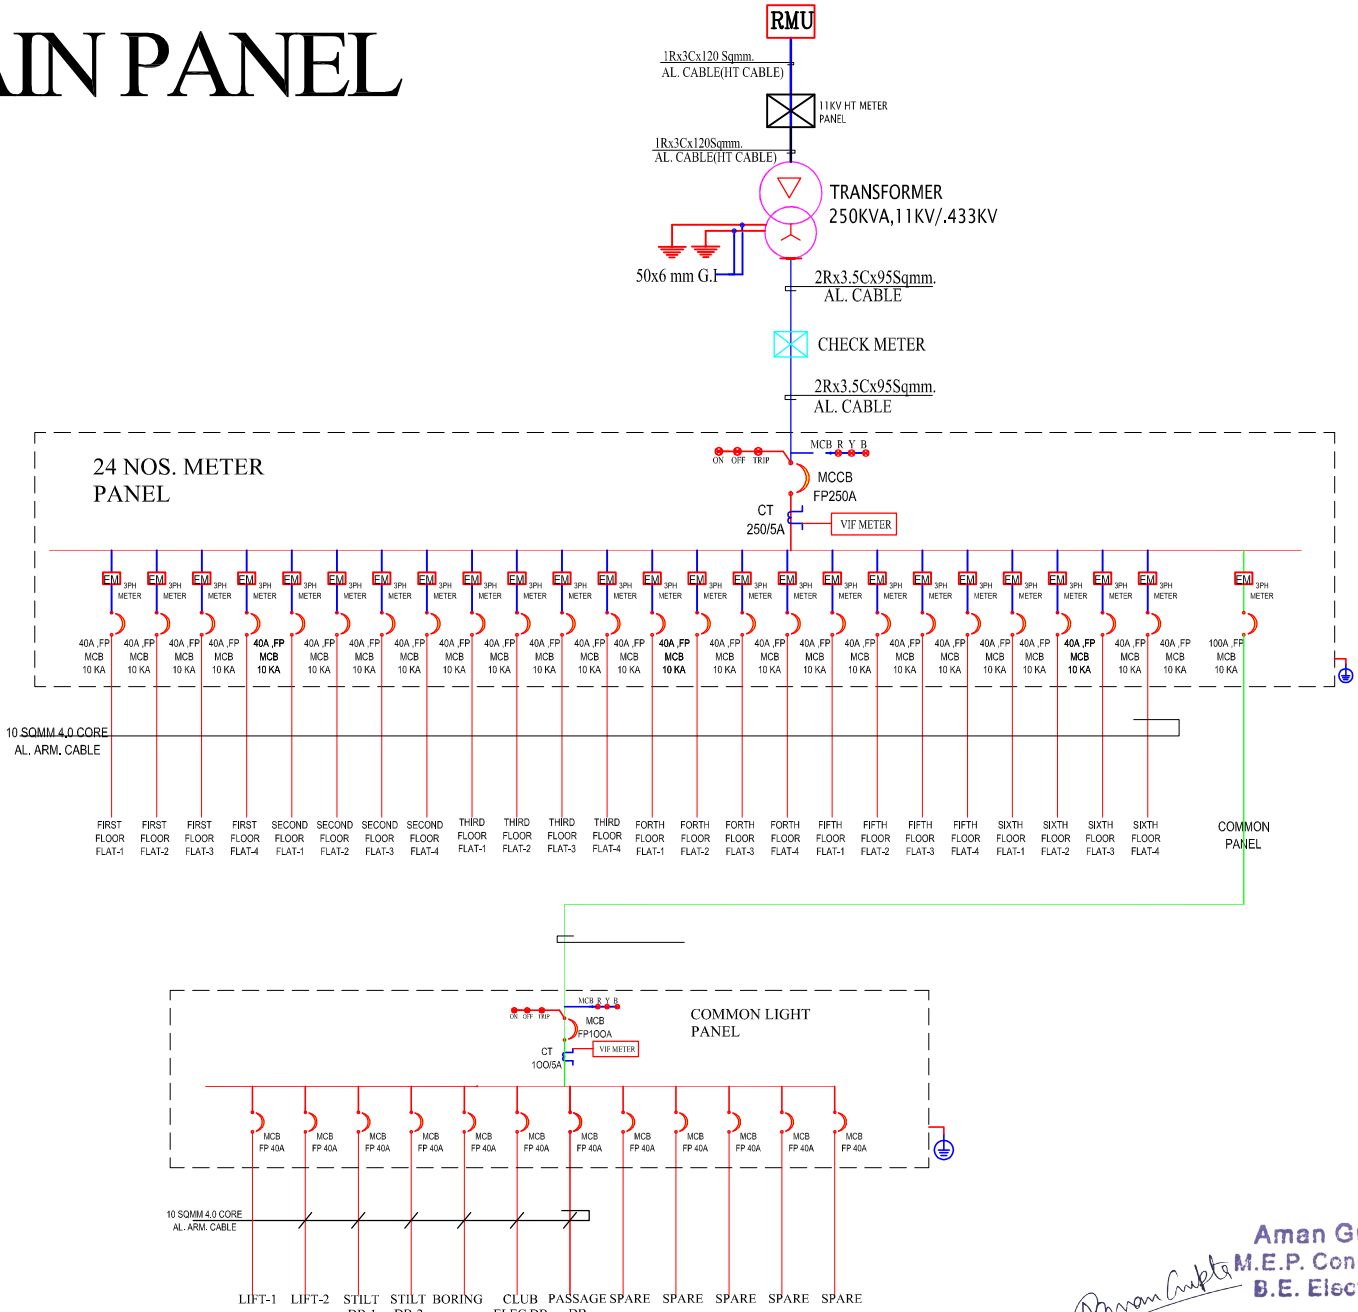

LEGEND:-	
SYMBOL	PARTICULARS
	SOFT STARTER
	VARIABLE FREQUENCY DRIVE
	AIR CIRCUIT BREAKER
	MCB/CCB
	VIF METER
	METERING CT
	CAPACITOR
	CAPACITOR DUTY CONT.
	MANUAL C/O SWITCH

MEP CONSULTANT:-
cube consultant
A-3, PATH NO. 4, JAMUNA NAGAR,
SODRALA, JAIPUR-302006
MAIL:- cubeme@gnail.com
PH. NO. + 91 141 2221089, 9214308430.

DESIGN BY JAMUN GUPTA	REVISION	DATE: 03.10.2023
DRAWING NO.		

TITLE:-
**ALL DISTRIBUTION
PANEL**

DRAWING TITLE:-
SINGLE LINE DIAGRAM




PROJECT:-
PROPOSED RESIDENTIAL APARTMENT FOR
PLOT NO-A-12(N.P) & A-13
CHOPRA ENCLAVE,MANSAROVAR,
VILL-GANPATPURA TEH-SANGANER JAIPUR.

ARCHITECT

M/S AKRITI AYOJAN
ARCHITECTS, INTERIOR DESIGNERS.
E-87, THIRD FLOOR, MANGLAM TOWER, RDH SIDHL,
GOPALPURA, JAIPUR-06, RAJASTHAN. 9351154101
suryaprakash.arch@gmail.com ;

Aman Gupta
M.E.P. Consultant
B.E. Electrical

24 NOS.METERS

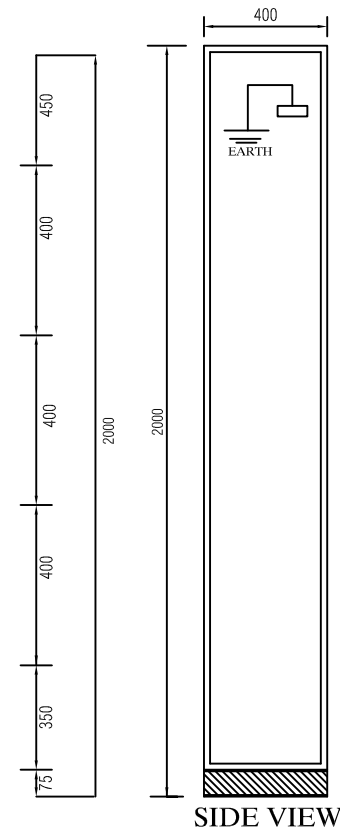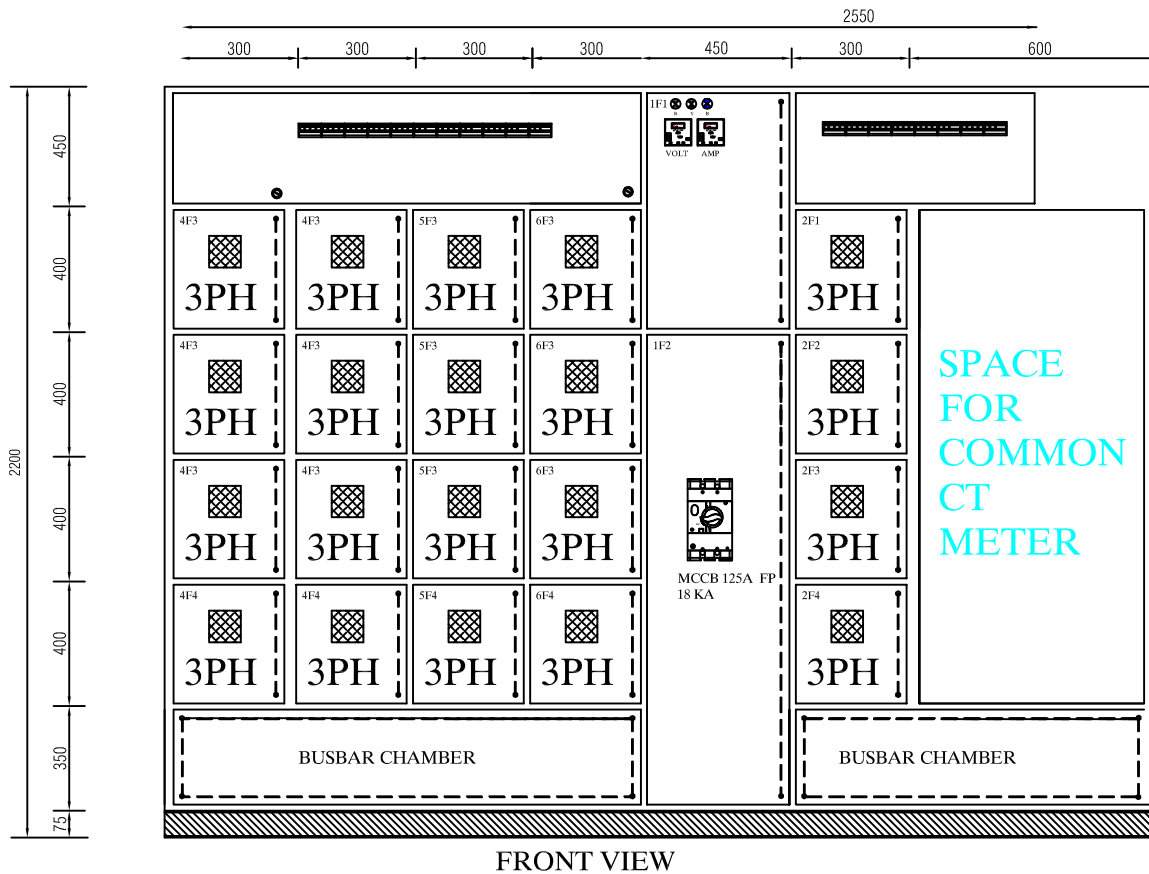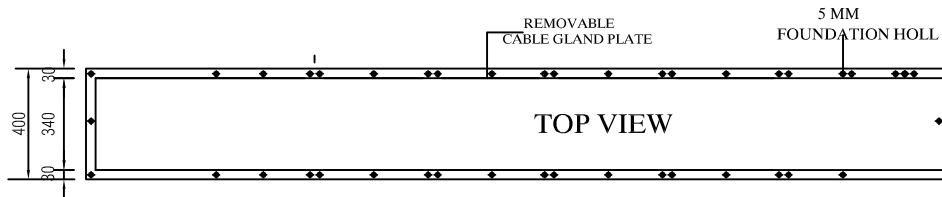

LEGEND:-	
SYMBOL	PARTICULARS
	SOFT STARTER
	VARIABLE FREQUENCY DRIVE
	AIR CIRCUIT BREAKER
	MCB/MCCB
	VIF METER
	METERING CT
	CAPACITOR
	CAPACITOR DUTY CONT.
	MANUAL C/O SWITCH

MEP CONSULTANT:-

cube consultant

A-8, PATH NO. 4, JAMUNA NAGAR,
SODALA, JAIPUR-302006
MAIL:- cube.mep@gmail.com
PH. NO. :- 91 141 2221089, 9214308430.

DEALT BY AMAN GUPTA	REVIEWED	DATE: 01.10.2023
DWG. NO.		

TITLE:-

ALL DISTRIBUTION
PANEL

DRAWING TITLE:-

MATER PANEL

PROJECT:-
PROPOSED RESIDENTIAL APARTMENT FOR


PLOT NO=A-12(N.P) & A-13
CHOPRA ENCLAVE,MANSAROVAR,
VILL-GANPATPURA TEH-SANGANER JAIPUR.

ARCHITECT

M/S AKRITI AYOJAN

ARCHITECTS. INTERIOR DESIGNERS.

E-87, THIRD FLOOR, MANGLAM TOWER ,RIDHI SIDIHI,
GOPALPURA, JAIPUR-06, RAJASTHAN. 9351154101
suryaprakash.arch@gmail.com ;

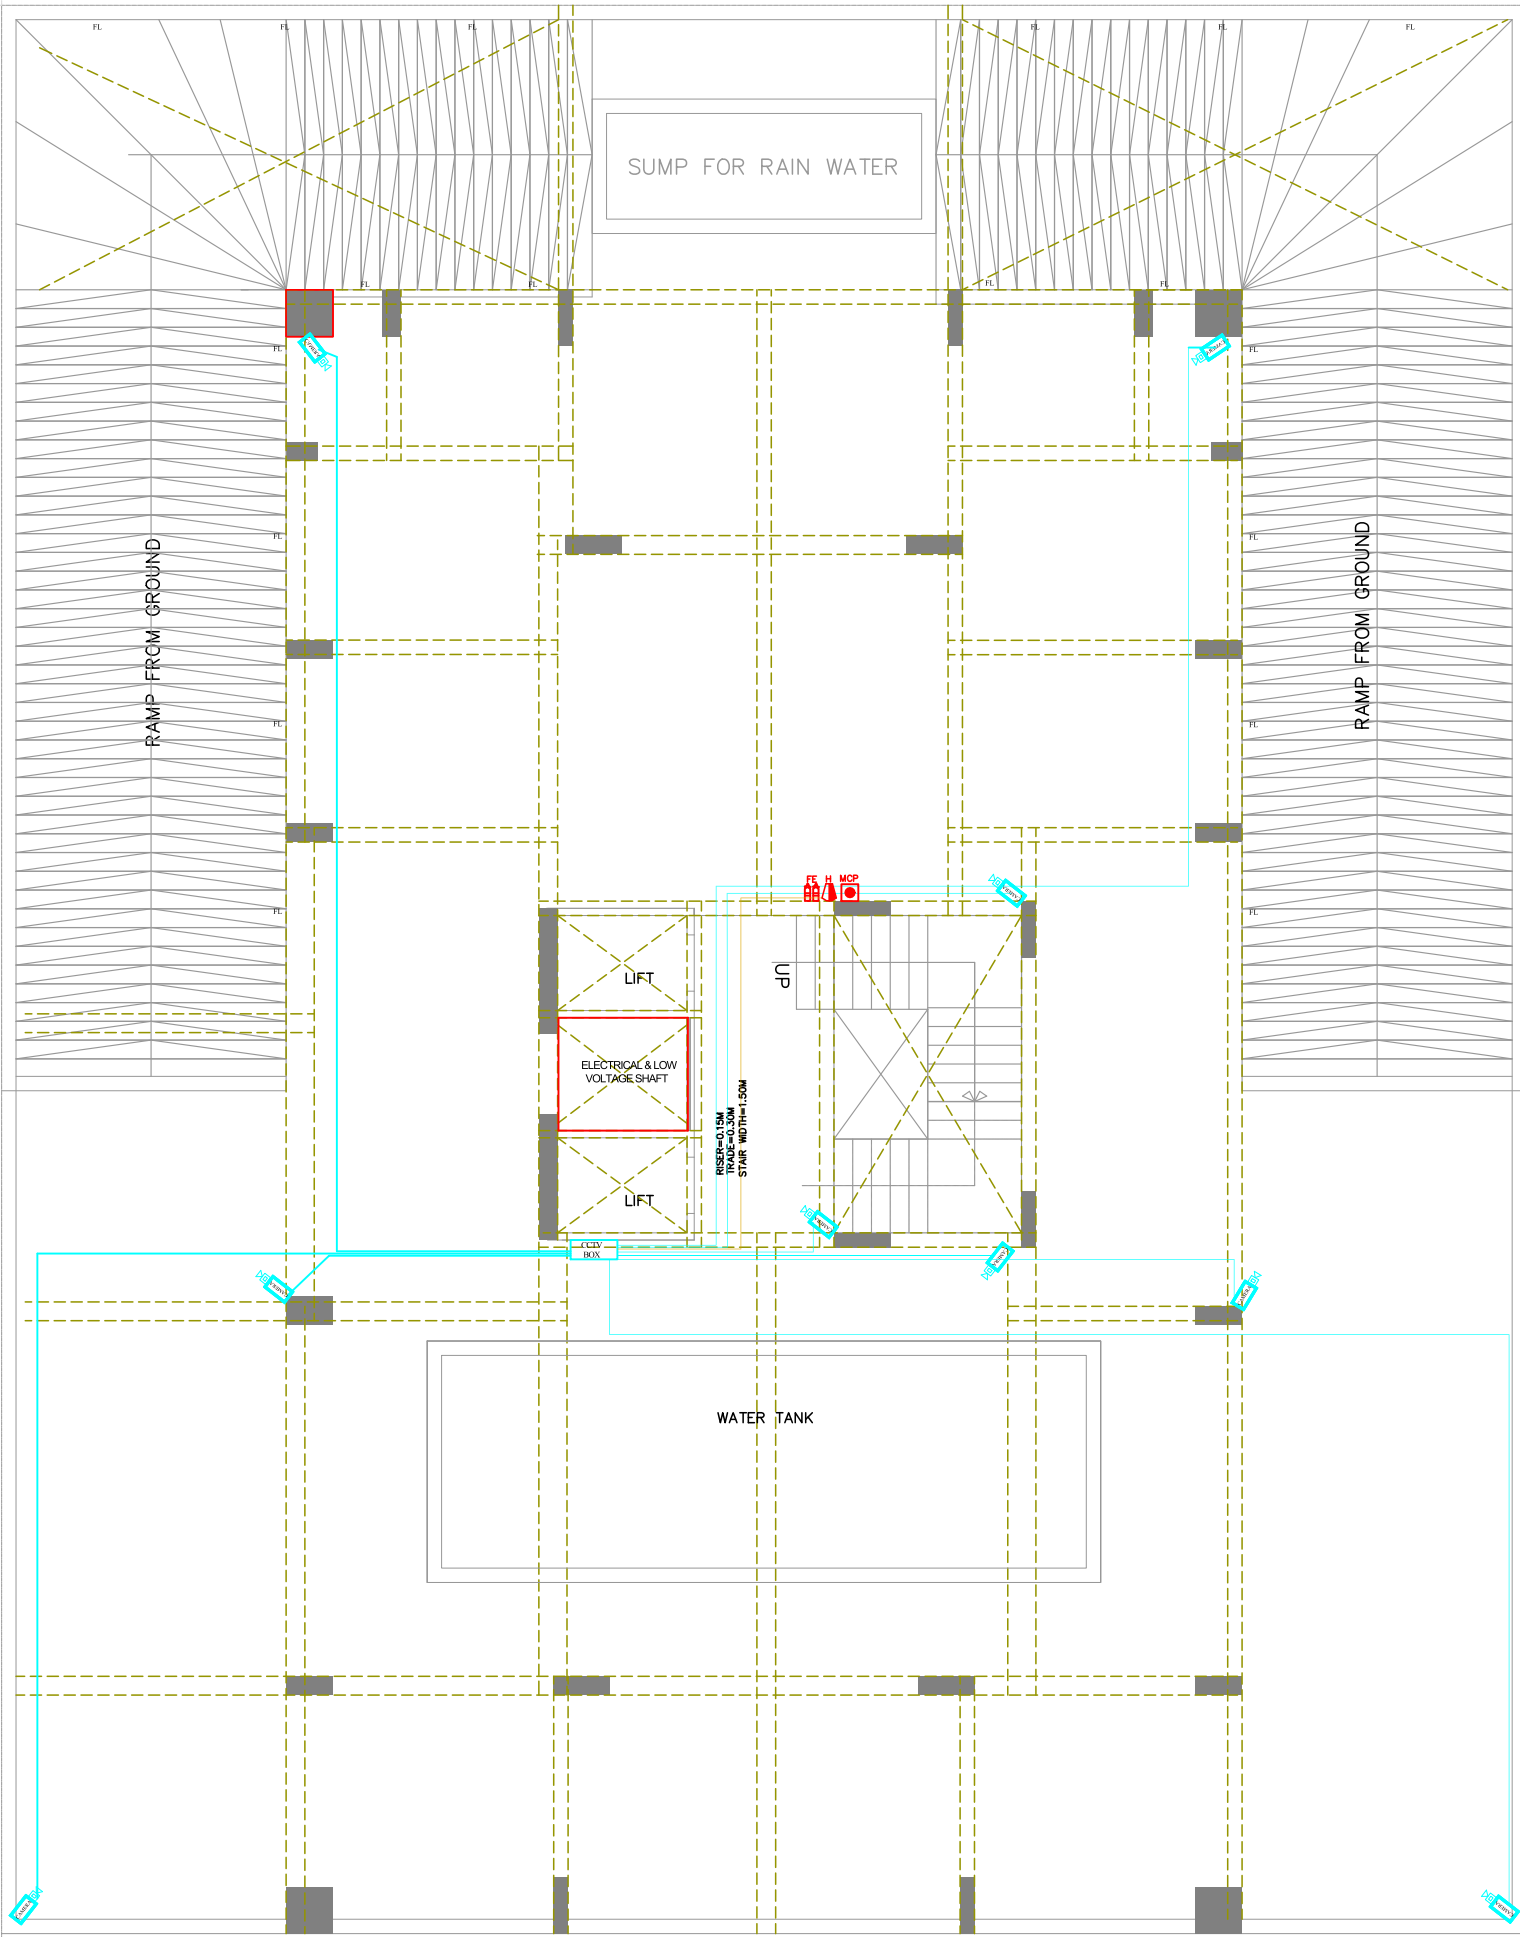

PROPOSED BASEMENT FLOOR
CCTV & FIRE ALARM LAYOUT

Aman Gupta
B.E. Consultant
B.E. Electrical

THIS DRAWING IS THE SOLE PROPERTY OF
M/S AKRITI AYOJAN AND IS NOT TO BE COPIED,
USED OR REPRODUCED FOR ANY PURPOSE
OTHER THAN FOR WHICH IT HAS BEEN LOANED.

LEGEND	
SYMBOL	DESCRIPTION
[Symbol]	DISTRIBUTION BOX
[Symbol]	SWITCH BOARD (6A SOCKET & SWITCHES)
[Symbol]	16 A. SOCKET WITH SWITCH
[Symbol]	6A POWER SOCKET WITH SWITCH
[Symbol]	EXHAUST FAN
[Symbol]	SPLIT AC
[Symbol]	25A SWITCH FOR
[Symbol]	TOILET MIRROR LIGHT 1x10w
[Symbol]	WALL FAN
[Symbol]	CEILING LIGHT
[Symbol]	TUBE LIGHT
[Symbol]	WALL BRACKET LED LIGHT
[Symbol]	1 x 14 W MIRROR LIGHT
[Symbol]	800 / 1200 MM SWEEP CEILING FAN
[Symbol]	1 x 11 W LED CEILING LIGHT
[Symbol]	1 x 72 W CHANDELIER LIGHT
[Symbol]	2 x 3 W CONCEALED FOOT LIGHT
[Symbol]	6A SS FAN REGULATOR TL SWITCH @HT. 2.4'
[Symbol]	6A SS 25 A/C @HT. 2.4'
[Symbol]	6A 2 NOS. SOCKET - 1 NOS.
[Symbol]	16A SWITCH, TV COAXIAL SOCKET @HT. 3.4'
[Symbol]	16A SS FOR CYSEY & 6A SS FOR RO @HT. 5.4'
[Symbol]	16A SS FOR MICROWAVE & 6A SS FOR MINER @HT. 5.4'
[Symbol]	6A SS FOR CHIMNEY @HT. 5.4'
[Symbol]	16A SS FOR FREEZER @HT. 5.4'
[Symbol]	3 x 1.5 SQMM LIGHT CONTROL CU. WIRE
[Symbol]	3 x 1.5 SQMM 2 WAY LIGHT CONTROL WIRE
[Symbol]	3 x 4.0 SQMM CU. WIRE FOR AC IDU
[Symbol]	3 x 4.0 SQMM CU. WIRE FOR POWER CIRCUIT
[Symbol]	3 x 2.5 SQMM CU. WIRE FOR LIGHT CIRCUIT
[Symbol]	CAT-6 LAN WIRE RJ-45 JACK TO LAN SWITCH
[Symbol]	2 PAIR TELEPHONE WIRE RJ-11 JACK TO TTB
[Symbol]	RG-6 TV CABLE SETUP BOX TO TV SPLITTER
[Symbol]	CAT-6 CCTV CABLE CAMERA TO NVR

MEP CONSULTANT 1	
cubeconsultant	
A-8, PATH NO. 4, JAMUNA NAGAR, SODALA, JAIPUR-302006	
MAIL: - cubemep@gmail.com	
PH. NO. +91 141 2221089, 9214306430,	
DEALT BY	REVISION
AMAN GUPTA	
DWG NO	DATE: 03.10.2023

TITLE: -
PROPOSED BASEMENT FLOOR
CCTV & FIRE ALARM LAYOUT
WORKING DRAWINGS

SCALE: - 1= 100 DATE:


PROJECT: -
PROPOSED RESIDENTIAL APARTMENT FOR
JAGDISH NARYAN CHOPRA
PLOT NO=A-12(N.P) & A-13
CHOPRA ENCLAVE, MANSAROVAR,
VILL-GANPATPURA TEH-SANGANER, JAIPUR.


CLIENT NAME: -

ARCHITECT


M/S AKRITI AYOJAN
ARCHITECTS. INTERIOR DESIGNERS.
E-87, THIRD FLOOR, MANGLAM TOWER, RIDHI SIDIHI,
GOPALPURA, JAIPUR-06, RAJASTHAN. 9351154101
suryaprakash.arch@gmailmail.com ;

DATE: NORTH :

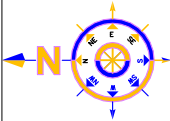

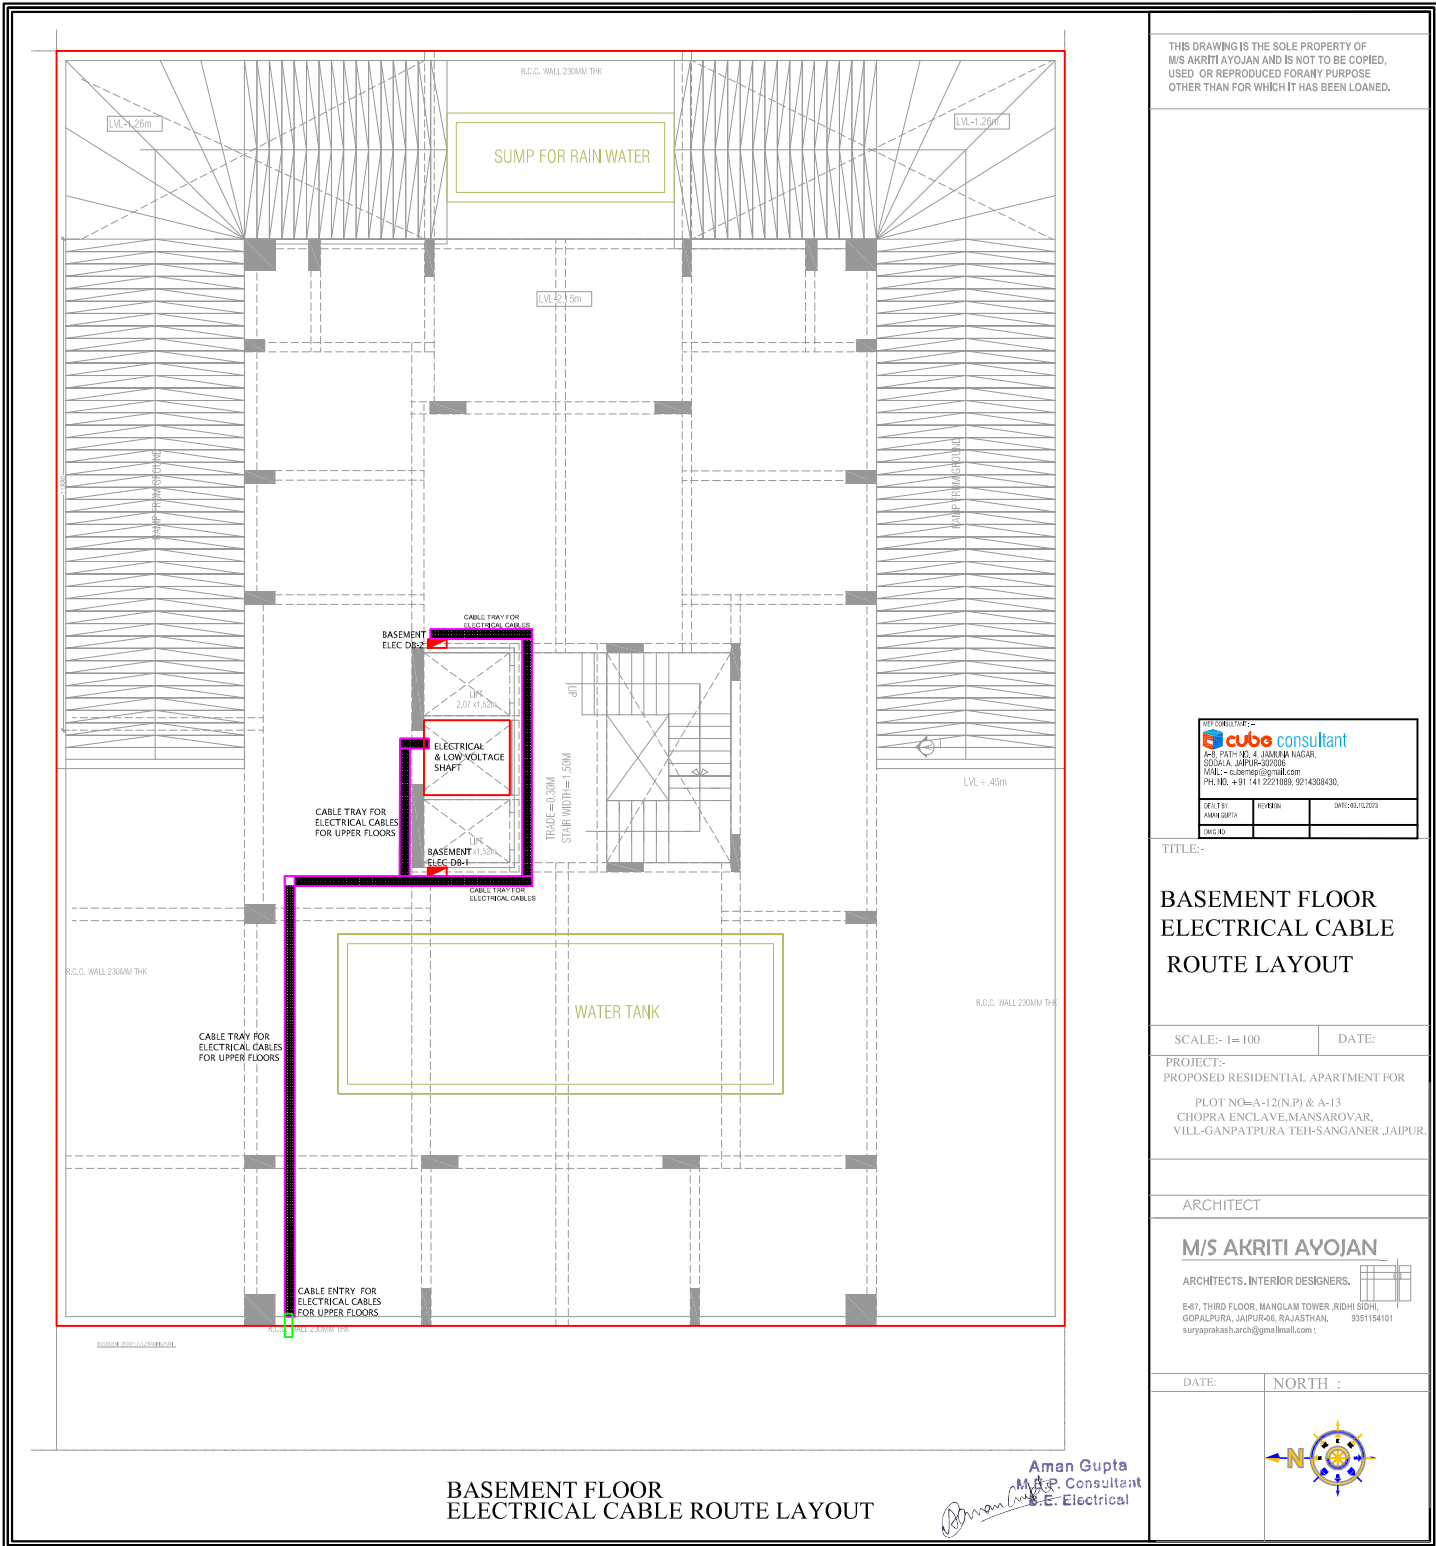

THIS DRAWING IS THE SOLE PROPERTY OF
M/S AKRITI AYOJAN AND IS NOT TO BE COPIED,
USED OR REPRODUCED FOR ANY PURPOSE
OTHER THAN FOR WHICH IT HAS BEEN LOANED.

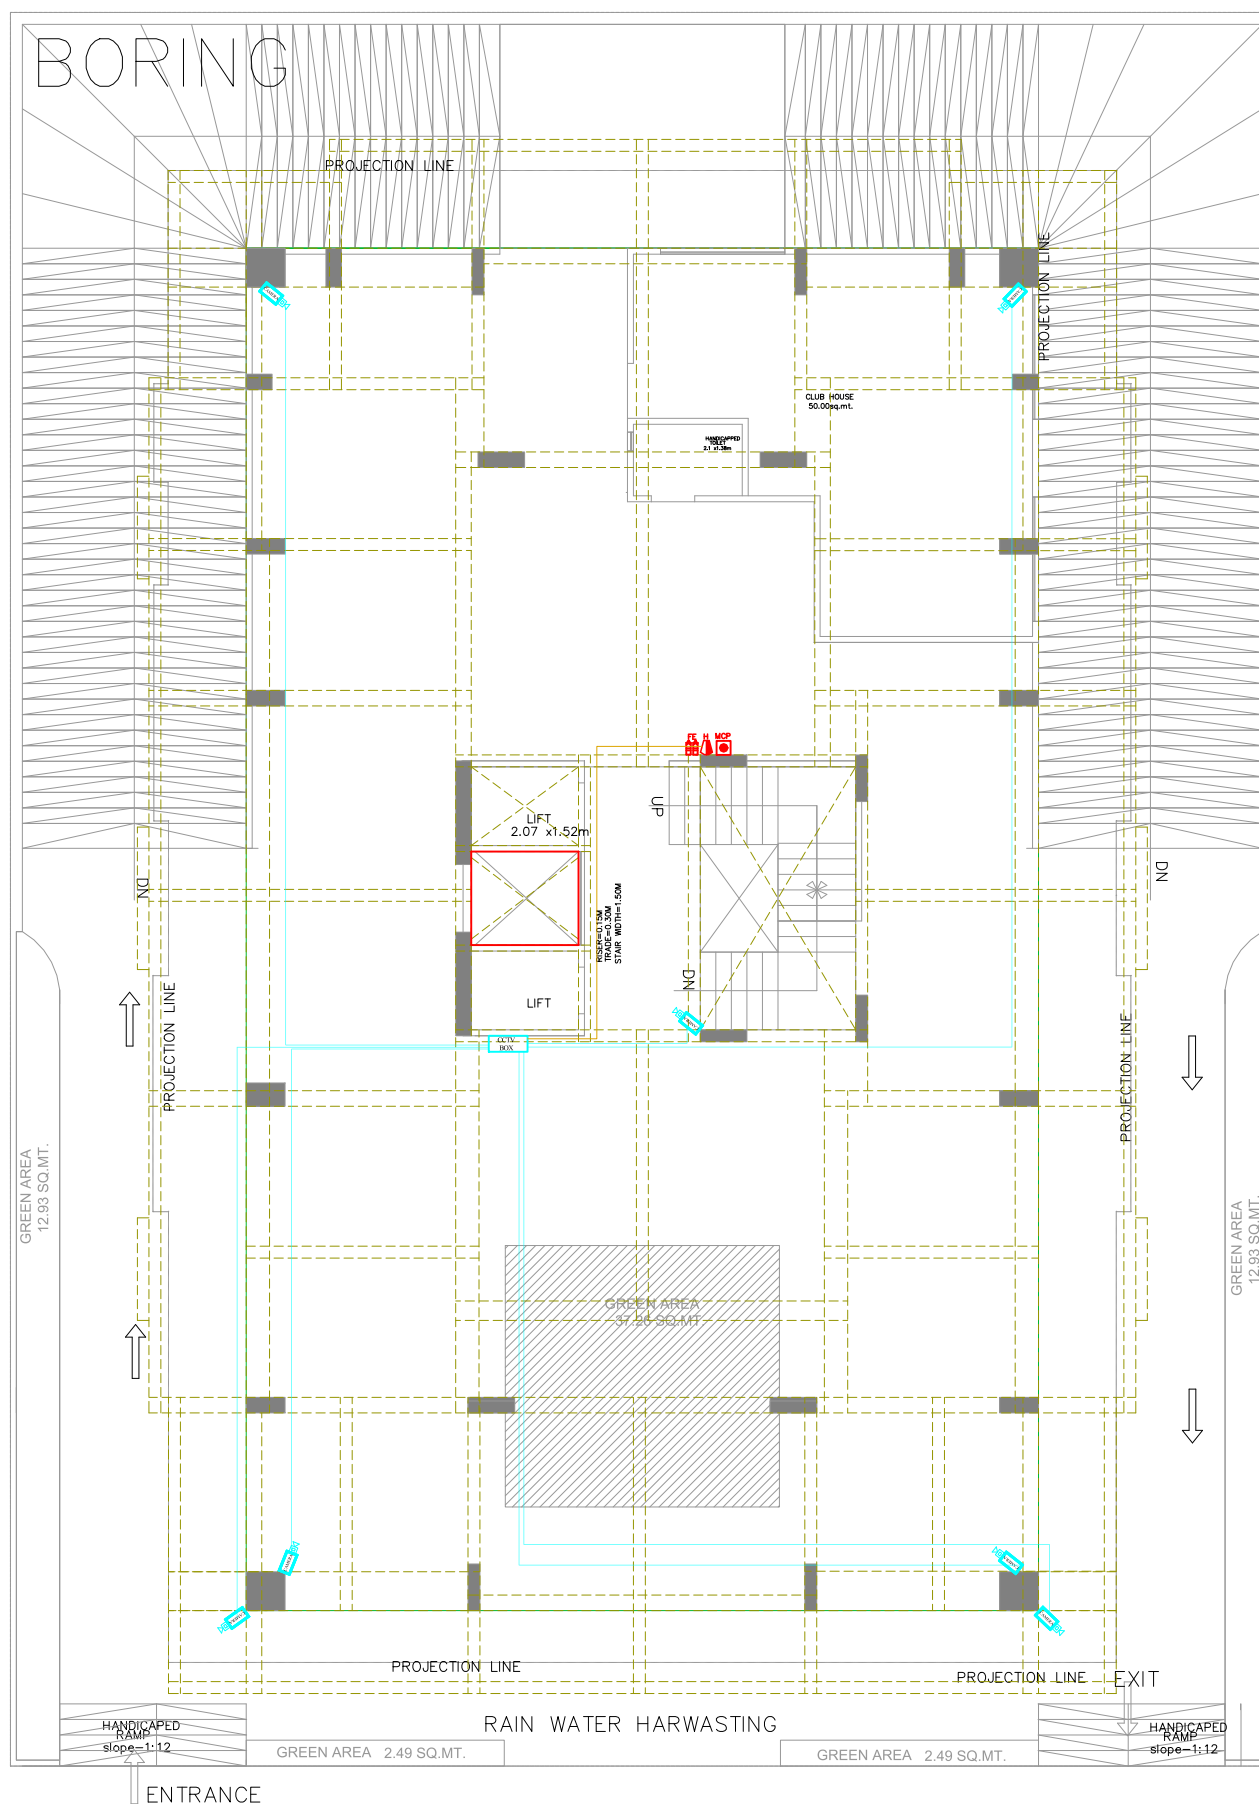

PROPOSED STILT FLOOR CCTV & FIRE ALARM LAYOUT

Aman Gupta
M.E.P. Consultant
E.E. Electrical

LEGEND

[illegible]

MEP CONSULTANT : —		
 A-8, PATH NO. 4, JAMUNA NAGAR, SODALA, JAIPUR-302006 MAIL: — cubemep@gmail.com PH. NO. +91 141 2221089, 921430843		
DEALT BY AMAN GUPTA	REVISION	DATE: 03.10.2023

TITLE: -
PROPOSED STILT FLOOR
CCTV & FIRE ALARM LAYOUT
WORKING DRAWINGS

SCALE: - 1 = 100	DATE:
PROJECT: -	
PROPOSED RESIDENTIAL APARTMENT FOR	
JAGDISH NARYAN CHOPRA	
PLOT NO=A-12(N.P) & A-13	
CHOPRA ENCLAVE,MANSAROVAR,	
VILL-GANPATPURA TEH-SANGANER ,JAIPUR	


CLIENT NAME: —


ARCHITECT

M/S AKRITI AYOJAN
ARCHITECTS. INTERIOR DESIGNERS.

E-87, THIRD FLOOR, MANGLAM TOWER, RIDHI SIDHI,
GOPALPURA, JAIPUR-06, RAJASTHAN. 9351154101
suryaprakash.arch@gmail.com ;

DATE:	NORTH :
-------	---------

 

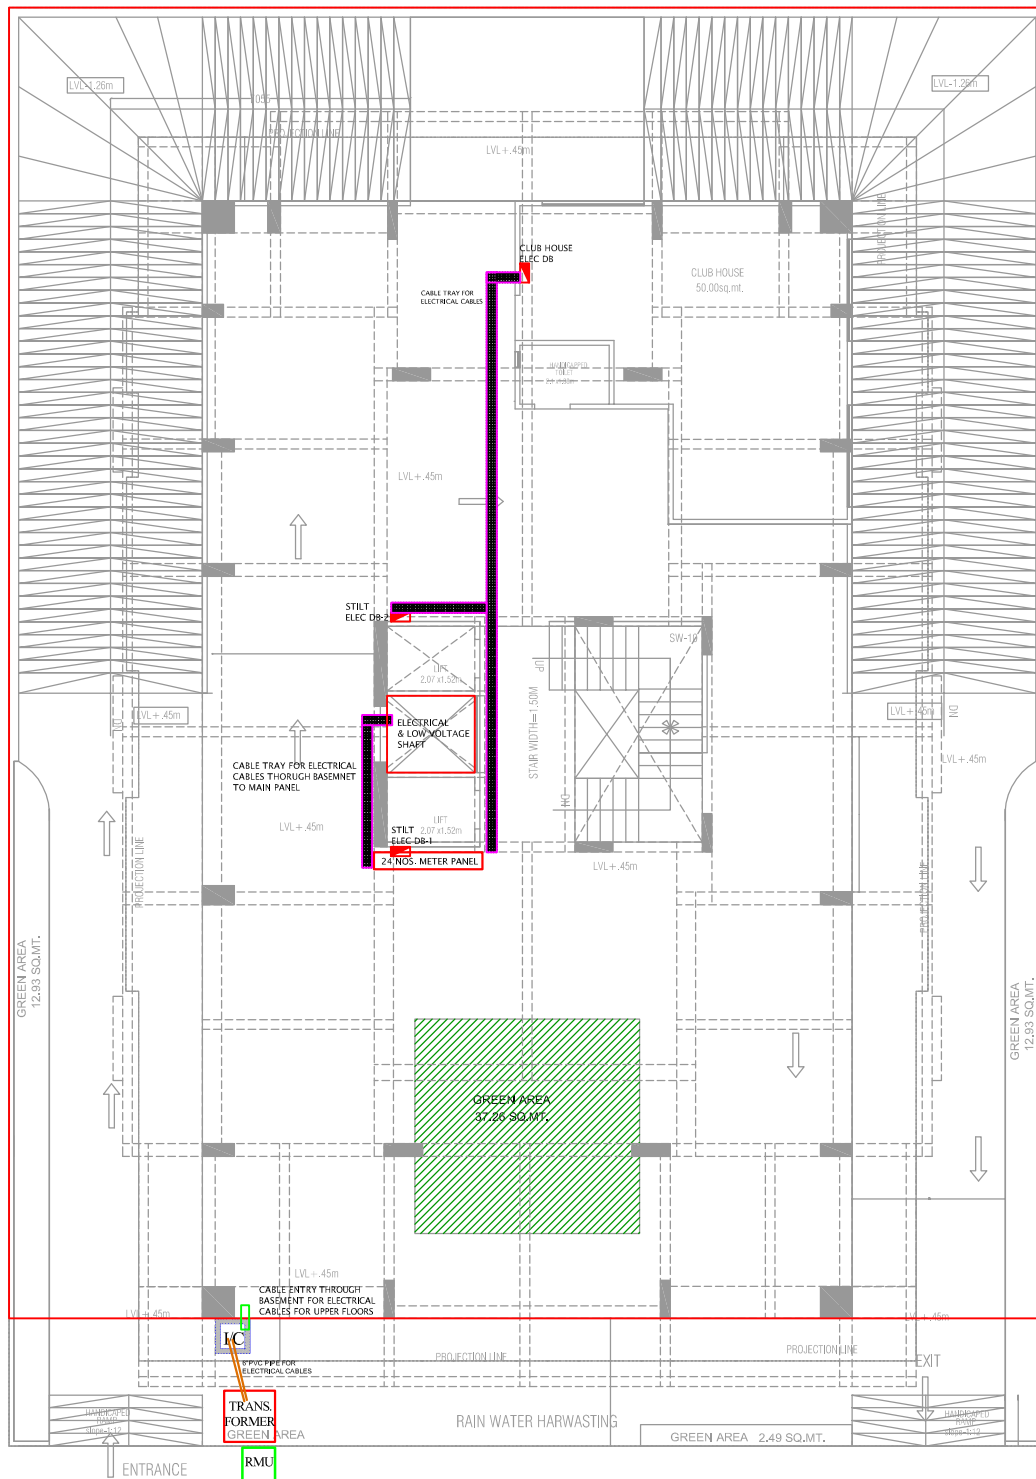

STILT FLOOR
ELECTRICAL CABLE ROUTE LAYOUT

THIS DRAWING IS THE SOLE PROPERTY OF
M/S AKRITI AYOJAN AND IS NOT TO BE COPIED,
USED OR REPRODUCED FOR ANY PURPOSE
OTHER THAN FOR WHICH IT HAS BEEN LOANED.

M/S AKRITI AYOJAN		
PLOT NO. 4, JAMUNA NAGAR, SOULJA, JAIPUR-302008		
W.A.C. - vamsi@gmail.com		
PH. NO. +91 141 2221089, 9214308430		
SCALE 1 BY AMAN GUPTA	REVISION	DATE 03.03.2023
DRAWN BY		

TITLE:-

STILT FLOOR
ELECTRICAL CABLE
ROUTE LAYOUT

SCALE:- 1= 100

DATE:

PROJECT:-
PROPOSED RESIDENTIAL APARTMENT FOR
PLOT NO=A-12(N.P.) & A-13
CHOPRA ENCLAVE, MANSAROVAR,
VILL-GANPATPURA TEH-SANGANER JAIPUR.

ARCHITECT

 
M/S AKRITI AYOJAN

ARCHITECTS, INTERIOR DESIGNERS.

E-87, THIRD FLOOR, MANGLAM TOWER, JODH SIKH,
GOPALPURA, JAIPUR-306, RAJASTHAN. 8351154101
suryaprakash.arch@gmail.com

DATE:


NORTH :



Aman Gupta
W.E.P. Consultant
S.E. Electrical



 NORTH ·



Aman Gupta
M.E.P. Consultant
B.E. Electrical