



PLUMBING LEGEND:-

SCHEDULE OF PIPES	
PIPE NO.	DESCRIPTION
①	110 OD uPVC SOIL PIPE
②	110 OD uPVC WASTE PIPE
③	110 OD uPVC RAIN WATER PIPE FOR TERRACE
④	DOMESTIC WATER SUPPLY D/N TAKE
⑤	DOMESTIC WATER SUPPLY RISER
● FT	FLOOR TRAP (P TRAP) (110 x 110) MM
● FD	FLOOR DRAIN (110 x 63) MM
● MT	MULTI FLOOR TRAP(100 x 63) MM
⑥	CHAMBER-2'0"x2'0"
⑦	GULLY TRAP-1'0"x1'0"
⑧	CATCH BASIN-1'6"x1'6"



N.T.S.		PL/02	
--------	--	-------	--

MISHRA GARG & ASSOCIATES
ARCHITECTS, PLANERS & INTERIOR DESIGNER
C-35, LAJPAT MARG, C-SCHEME, JAIPUR.
TEL. : (0141) 2373274 , 5104986
Email-id :- mishra.garg@gmail.com,
mishra.garg@yahoo.com

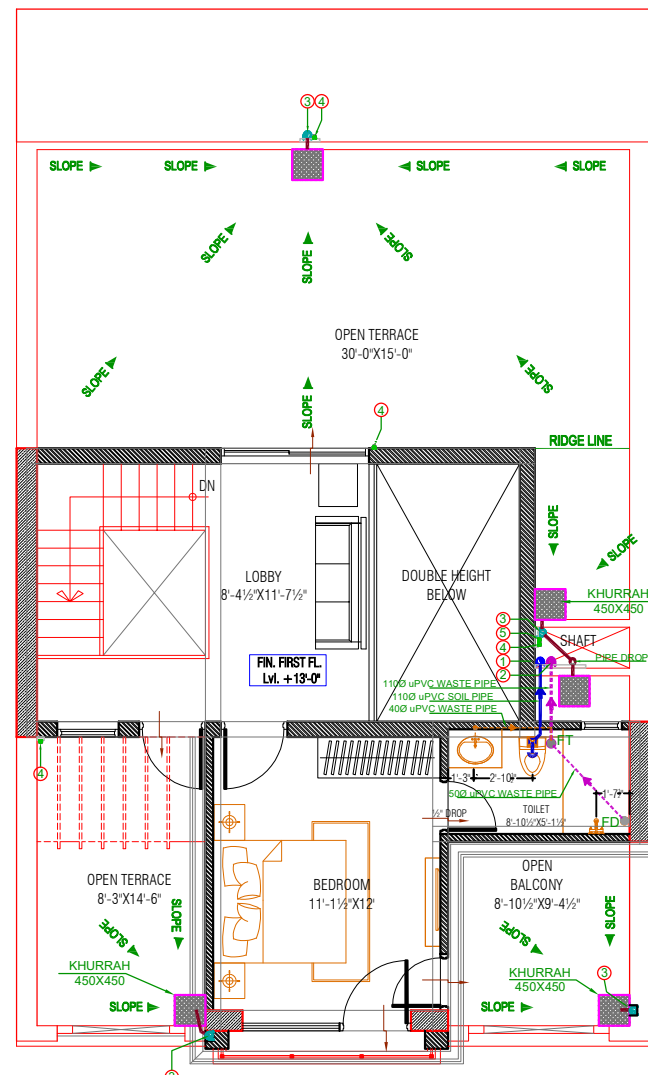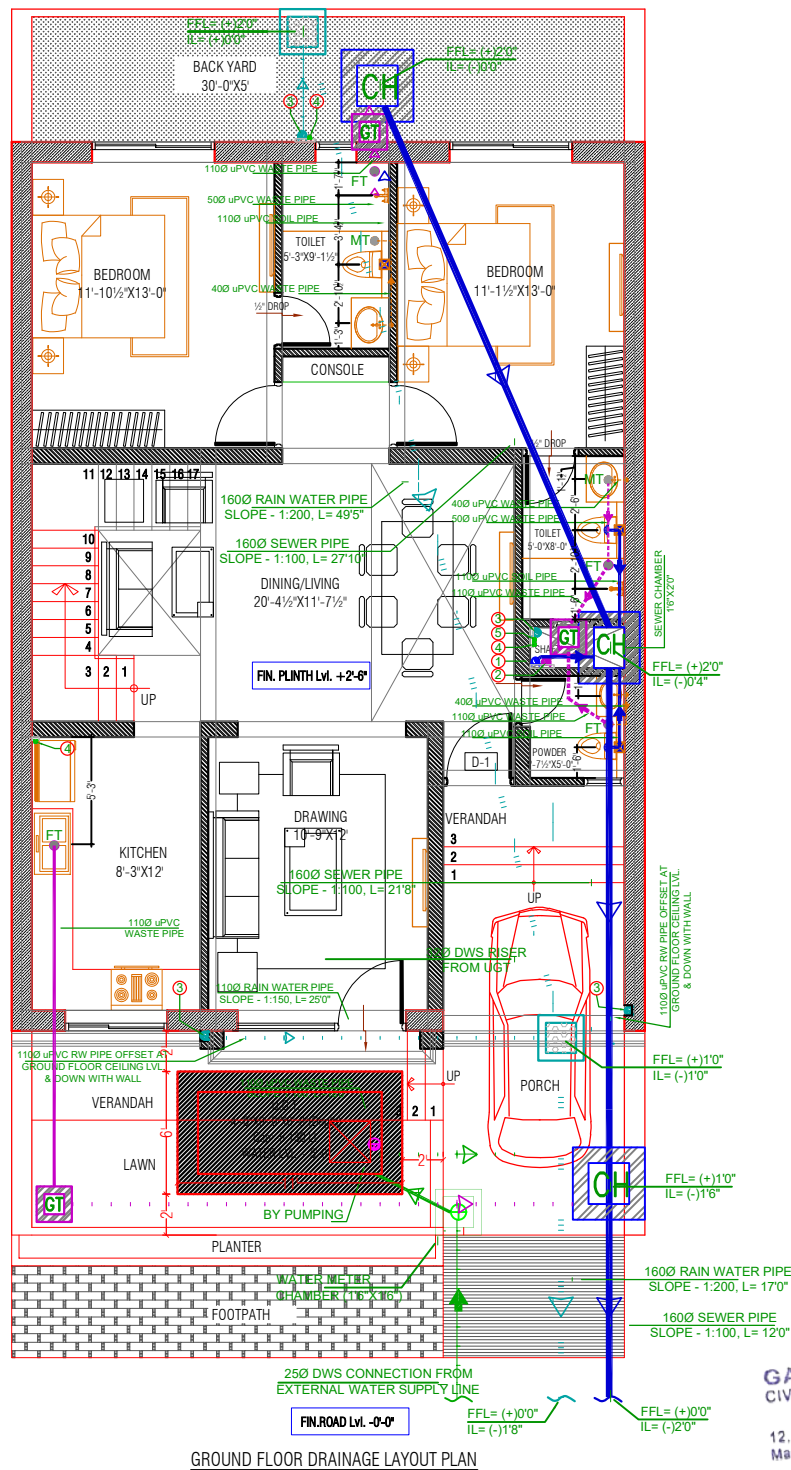

Note : That This design plan is only tentative in nature as promoter may either sell the villas as per the standard specifications and plans or customize them as per the requirement of clients in terms of layout, elevation, design and specification, as the discretion of the promoter

GAURAV JOSHI
CIVIL ENGINEER

12, Near Maheshwari Nayari Rd
Masuriya, Jodhpur

For Villa no. 1 to 4
Ashapura Mohanbagh VII
khasra no. 50/9 ,50/11 , 50/14.
carpet area 1336 sqft
build up area 1702 sqft

PLUMBING NOTES:-	
1	WASH BASIN TO MULTI FLOOR TRAP (MT) 40 OD uPVC PIPE.
2	KITCHEN SINK TO FLOOR TRAP (FT) 50 OD uPVC PIPE
3	FLOOR DRAIN (FD/MT) TO MULTI FLOOR TRAP (MT) 50 OD uPVC WASTE PIPE.
4	110 OD uPVC PIPE USED FOR SOIL & WASTE.
5	110 OD uPVC PIPE USED FOR TERRACE RAIN WATER

SCHEDULE OF PIPES	
PIPE NO.	DESCRIPTION
①	110 OD uPVC SOIL PIPE
②	110 OD uPVC WASTE PIPE
③	110 OD uPVC RAIN WATER PIPE FOR TERRACE
④	DOMESTIC WATER SUPPLY D/M TAKE
⑤	DOMESTIC WATER SUPPLY RISER
⑥ FT	FLOOR TRAP (P TRAP) (110 x 110) MM
⑦ FD	FLOOR DRAIN (110 x 63) MM
⑧ MT	MULTI FLOOR TRAP(100 x 63) MM
⑨	CHAMBER-2'0"x2'0"
⑩	GULLY TRAP-1'0"x1'0"
⑪	CATCH BASIN-1'6"x1'6"

[illegible]

PROJECT TITLE

MOHANBAGH
Residential Township
At JODHPUR

DRAWING TITLE

VILLA TYPE
30'X55' (3bhk)
ALL FLOOR DRAINAGE LAYOUT PLAN

PRIME CONSULTANTS:

SRAJAN ASSOCIATES

C-35A, NAKSHTRA PRIDE, LAJPAT MARG, C-SCHEME, JAIPUR,
PH:+91-141-237-3210, E-MAIL: snajaipur@hotmail.com

ASSOCIATE PLUMBING CONSULTANTS:-





BEHERA & ASSOCIATES PVT. LTD.
F-623a, BEHIND, CNG FILLING STATION,
LADO SARAI, NEW DELHI 110030 PH:-
011-40583898, 09811911853 E mail:-
behera.associates@gmail.com

ARCHITECTS :



MISHRA GARG & ASSOCIATES
ARCHITECTS, PLANERS & INTERIOR DESIGNER
C-35, LAJPAT MARG, C-SCHEME, JAIPUR.
TEL. : (0141) 2373274, 5104986
Email-id :- mishra.garg@gmail.com,
mishra.garg@yahoo.com

DEALT	CHECKED	DATE	
S.SINGH	S.BEHERA	26.01.2024	
SCALE	JOB NO.	DRG. NO.	
N.T.S.		PL/01	

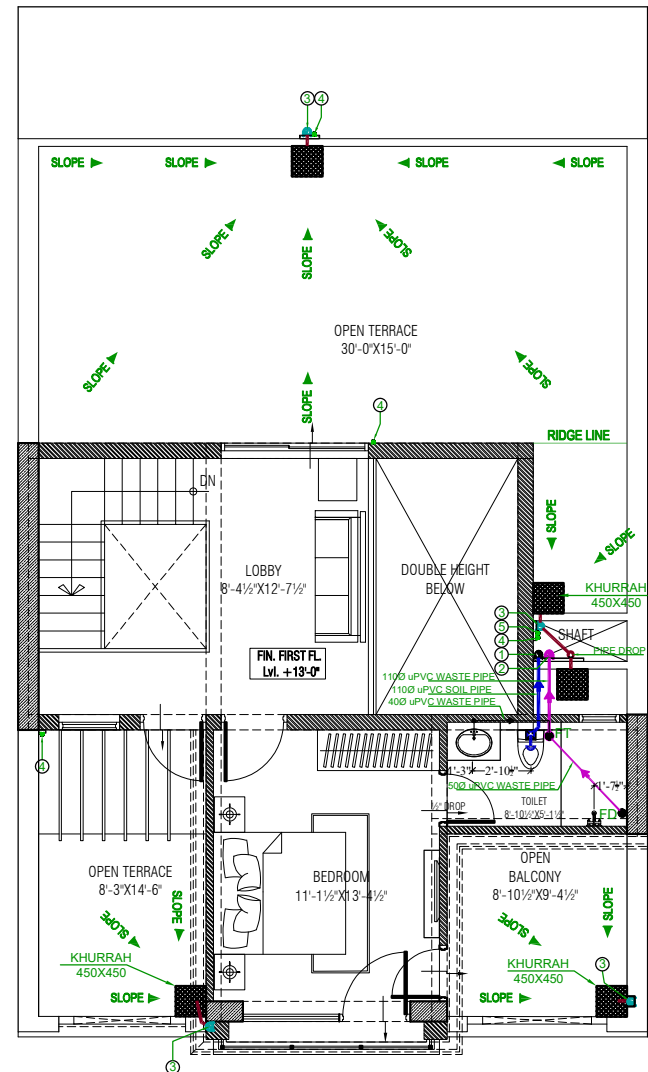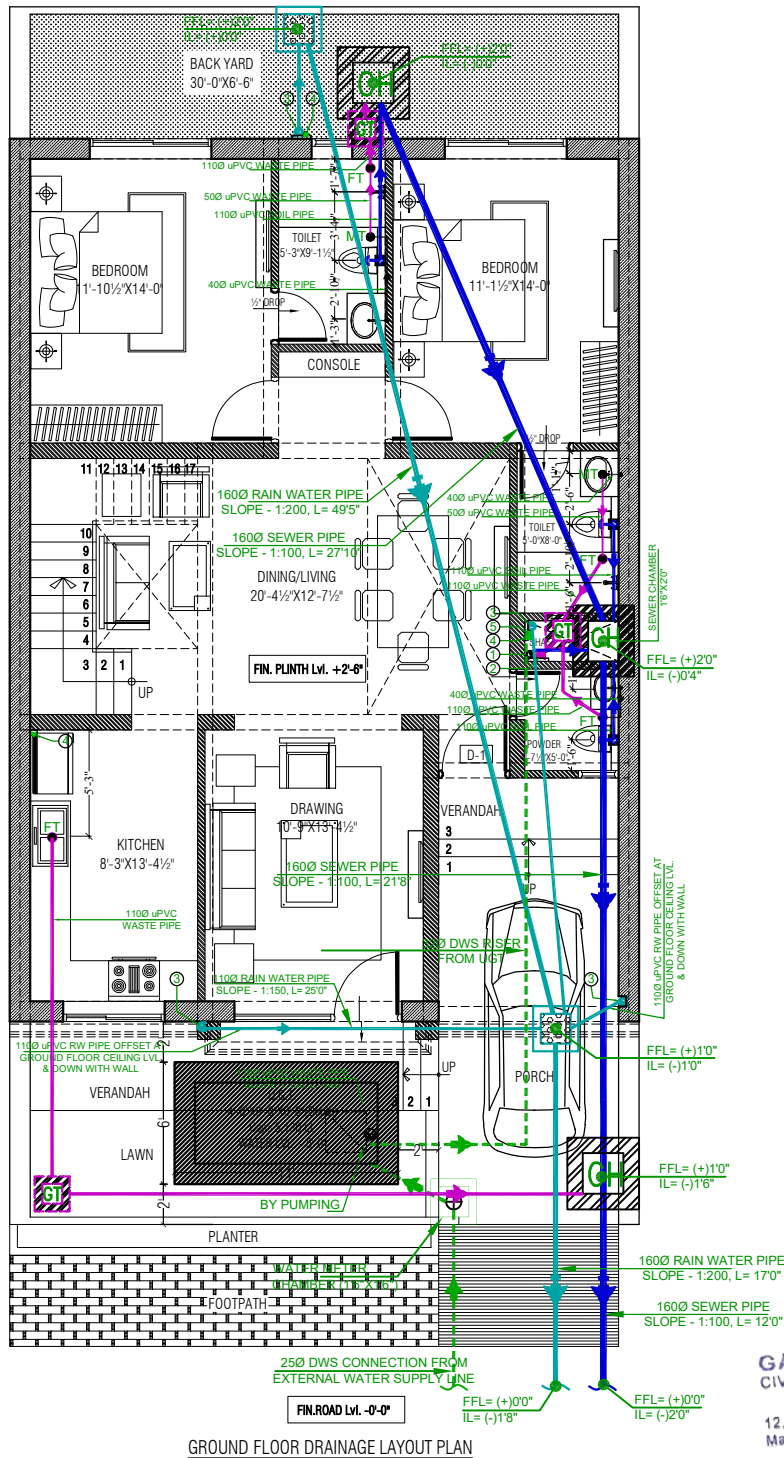

Note : That This design plan is only tentative in nature as promoter may either sell the villas as per the standard specifications and plans or customize them as per the requirement of clients in terms of layout, elevation, design and specification, as the discretion of the promoter

For Villa no. 5 TO 12
Ashapura Mohanbagh VII
khasra no. 50/9 ,50/11 ,50/14 .
carpet area 1423.31 sqft
build up area 1827.95 sqft

PLUMBING NOTES:-	
1	WASH BASIN TO MULTI FLOOR TRAP (MT) 40 OD uPVC PIPE.
2	KITCHEN SINK TO FLOOR TRAP (FT) 50 OD uPVC PIPE
3	FLOOR DRAIN (FD/MT) TO MULTI FLOOR TRAP (MT) 50 OD uPVC WASTE PIPE.
4	110 OD uPVC PIPE USED FOR SOIL & WASTE.
5	110 OD uPVC PIPE USED FOR TERRACE RAIN WATER

SCHEDULE OF PIPES	
PIPE NO.	DESCRIPTION
①	110 OD uPVC SOIL PIPE
②	110 OD uPVC WASTE PIPE
③	110 OD uPVC RAIN WATER PIPE FOR TERRACE
④	DOMESTIC WATER SUPPLY D/N TAKE
⑤	DOMESTIC WATER SUPPLY RISER
● FT	FLOOR TRAP (P TRAP) (110 x 110) MM
● FD	FLOOR DRAIN (110 x 63) MM
● MT	MULTI FLOOR TRAP (100 X 63) MM
● G	CHAMBER-2'0"x2'0"
● G	GULLY TRAP-1'0"x1'0"
● B	CATCH BASIN-1'6"x1'6"

[illegible]

PROJECT TITLE

MOHANBAGH
Residential Township
At JODHPUR

VILLA TYPE
30'X60' (3bhk)
ALL FLOOR DRAINAGE LAYOUT PLAN

PRIME CONSULTANTS:

SRAJAN ASSOCIATES
C-35A, NAKSHTRA PRIDE, LAJPAT MARG, C-SCHEME, JAIPUR,
PH:-91-141-237-3210, E-MAIL: srajaipur@hotmail.com

ASSOCIATE PLUMBING CONSULTANTS:-

 **BEHERA & ASSOCIATES PVT. LTD.**
F-623a, BEHIND, CNG FILLING STATION,
LADO SARAI, NEW DELHI 110030 PH:-
011-40583898, 09811911853 E mail:-
behera.associates@gmail.com

ARCHITECTS :



MISHRA GARG & ASSOCIATES
 ARCHITECTS, PLANNERS & INTERIOR DESIGNER
 C-35, LAIPAT MARG, C-SCHEME, JAIPUR
 TEL. : (0141) 2373274, 5104986
 Email-id : mishra_garg@gmail.com,
mishra_garg@yahoo.com

DEALT	CHECKED	DATE	
S.SINGH	S.BEHERA	26.01.2024	
SCALE	JOB NO.	DRG. NO.	
N.T.S.		PL/01	