


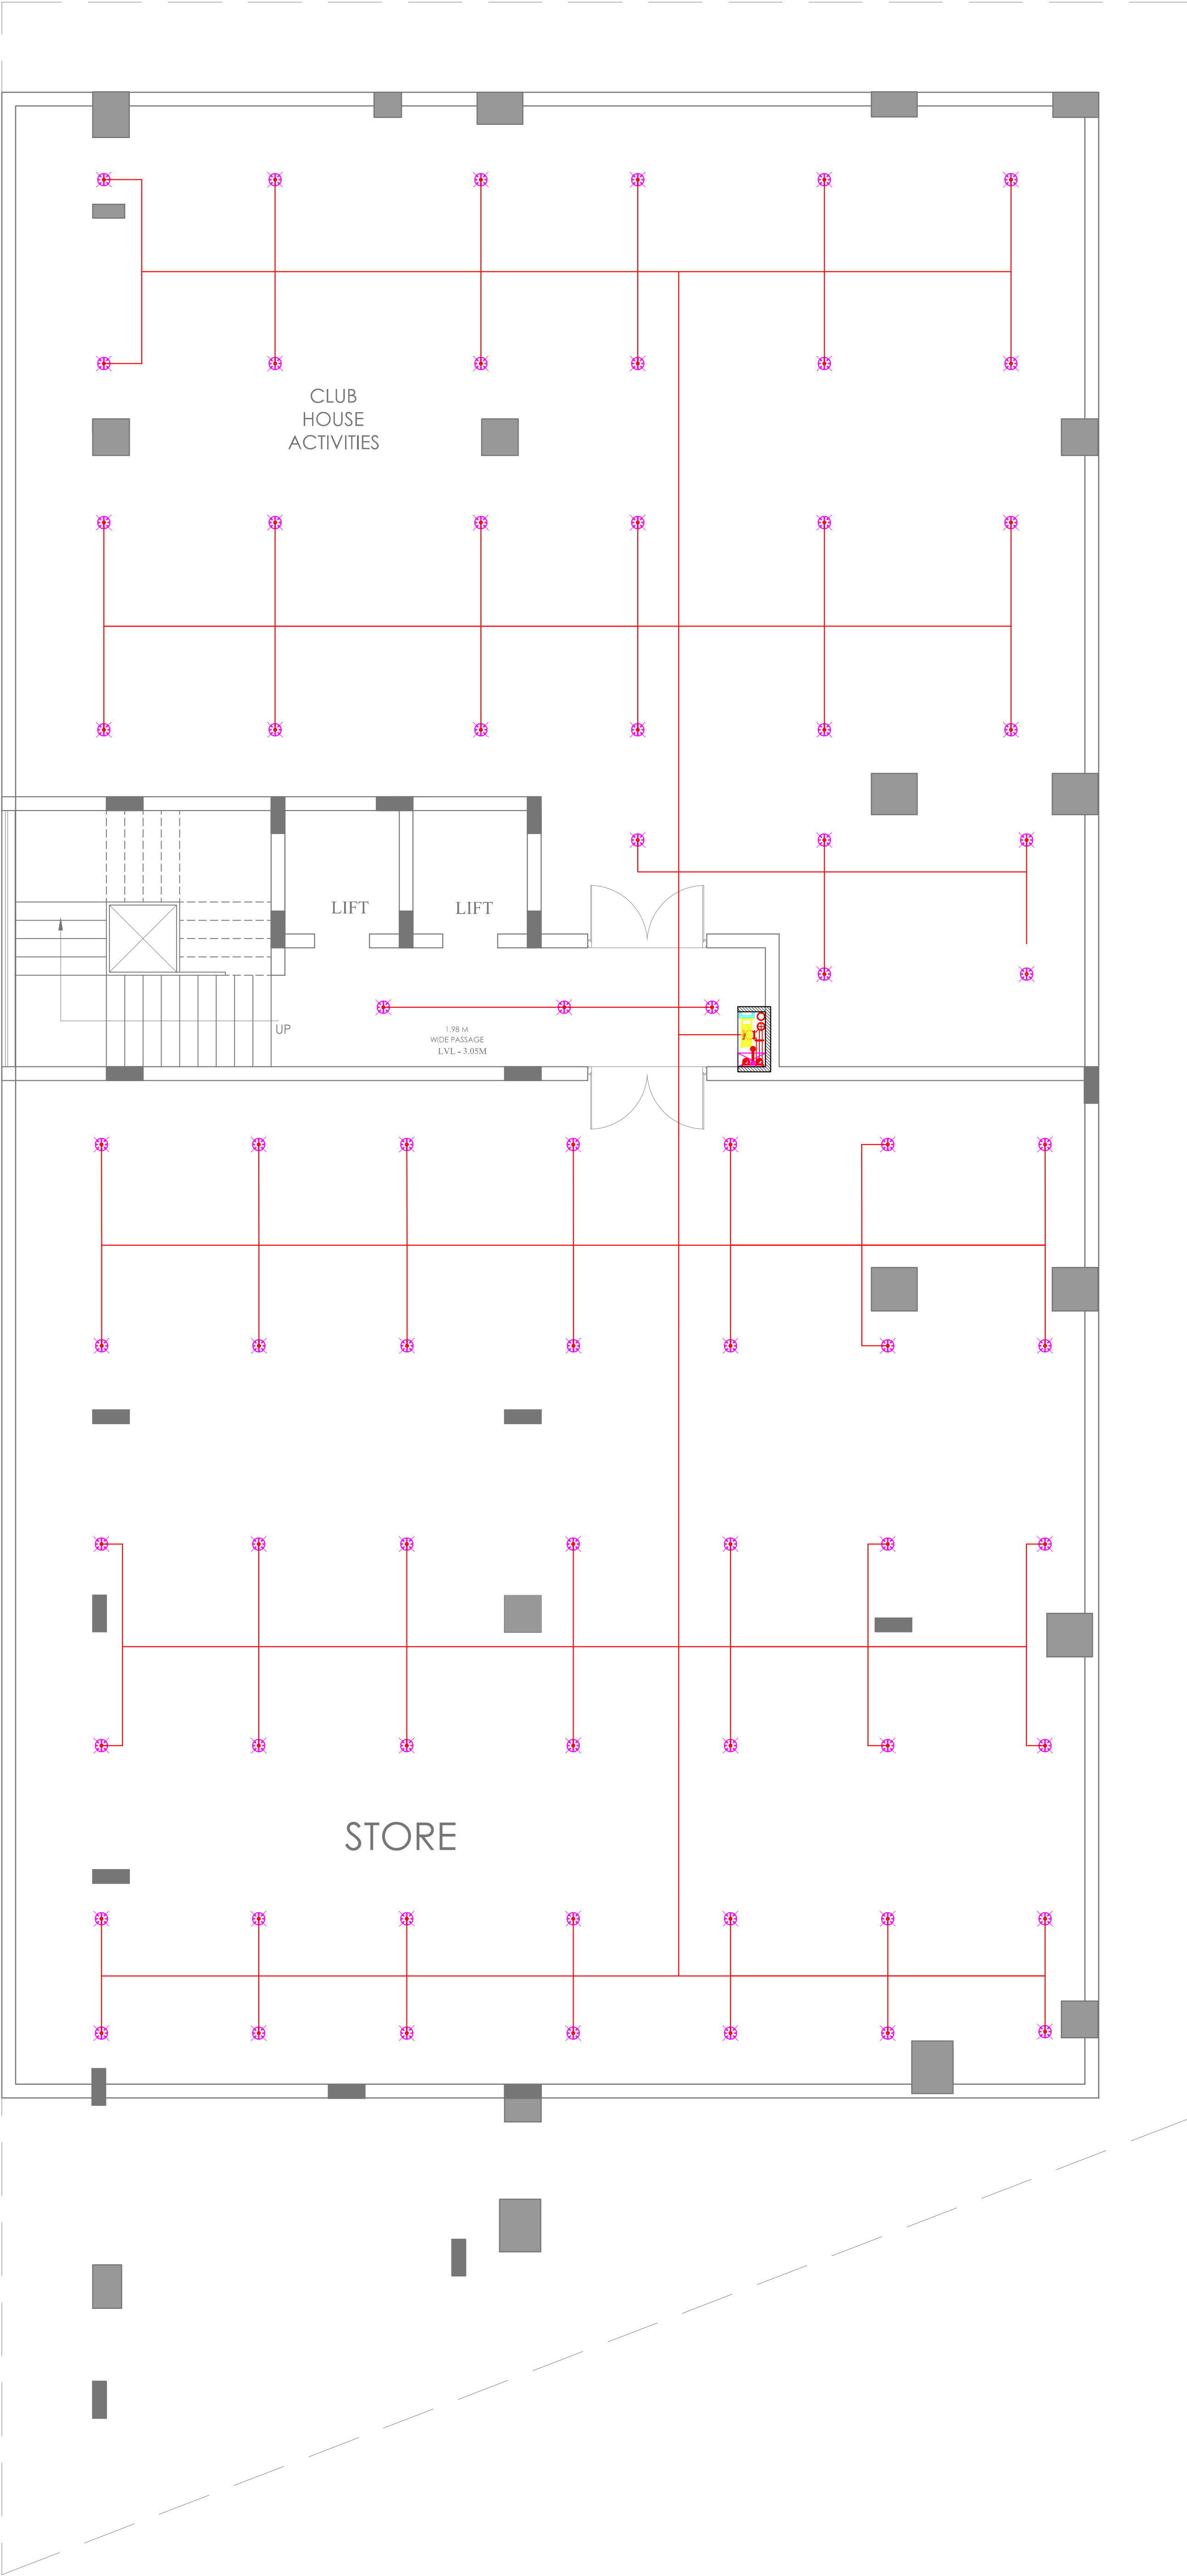

Vipul
VIPUL AGARWAL
M.E.P. CONSULTANT
B.E. ELECTRICAL

LEGENDS:

Mounting Ht.	Qty.	Symbol	Description
CEILING			PENDANT SPRINKLER
CEILING			MS PIPE
			CONTROL VALVE

SERVICES CONSULTANT:
ASHI ASSOCIATES
F9/440,Keshav Marg Chitrakut Scheme,Jaipur
PH:91-0-93146-10438 ,0141-2440946 Mail:vipul8599@yahoo.com

DRAWN. BY:-	CHKD. BY:-
MAHENDRA	SANJAY

APPD. BY:-	VIPUL AGARWAL
------------	---------------

DATE:-	REV.:-	SCALE - NTS
04-10-2024	00	

DRAWING TYPE :-

BASEMENT FLOOR ROOF
FIRE SPRINKLER PLAN

PROJECT NAME :

PARK VIEW APARTMENTS
BY SONI'S

PROMOTERS NAME :



NEHAL
MAHESHWARI

PROJECT ADDRESS :

PLOT NO. 77& 78, VISHVASHRIYA NAGAR VISTAR
(APOLLO NAGAR - GRAH NIRMAN SAHKAR SAMITI
LIMITED), JAIPUR RAJASHTAN

NORTH

HI VE
DESIGNER STUDIO
Architecture | Planning | Interiors

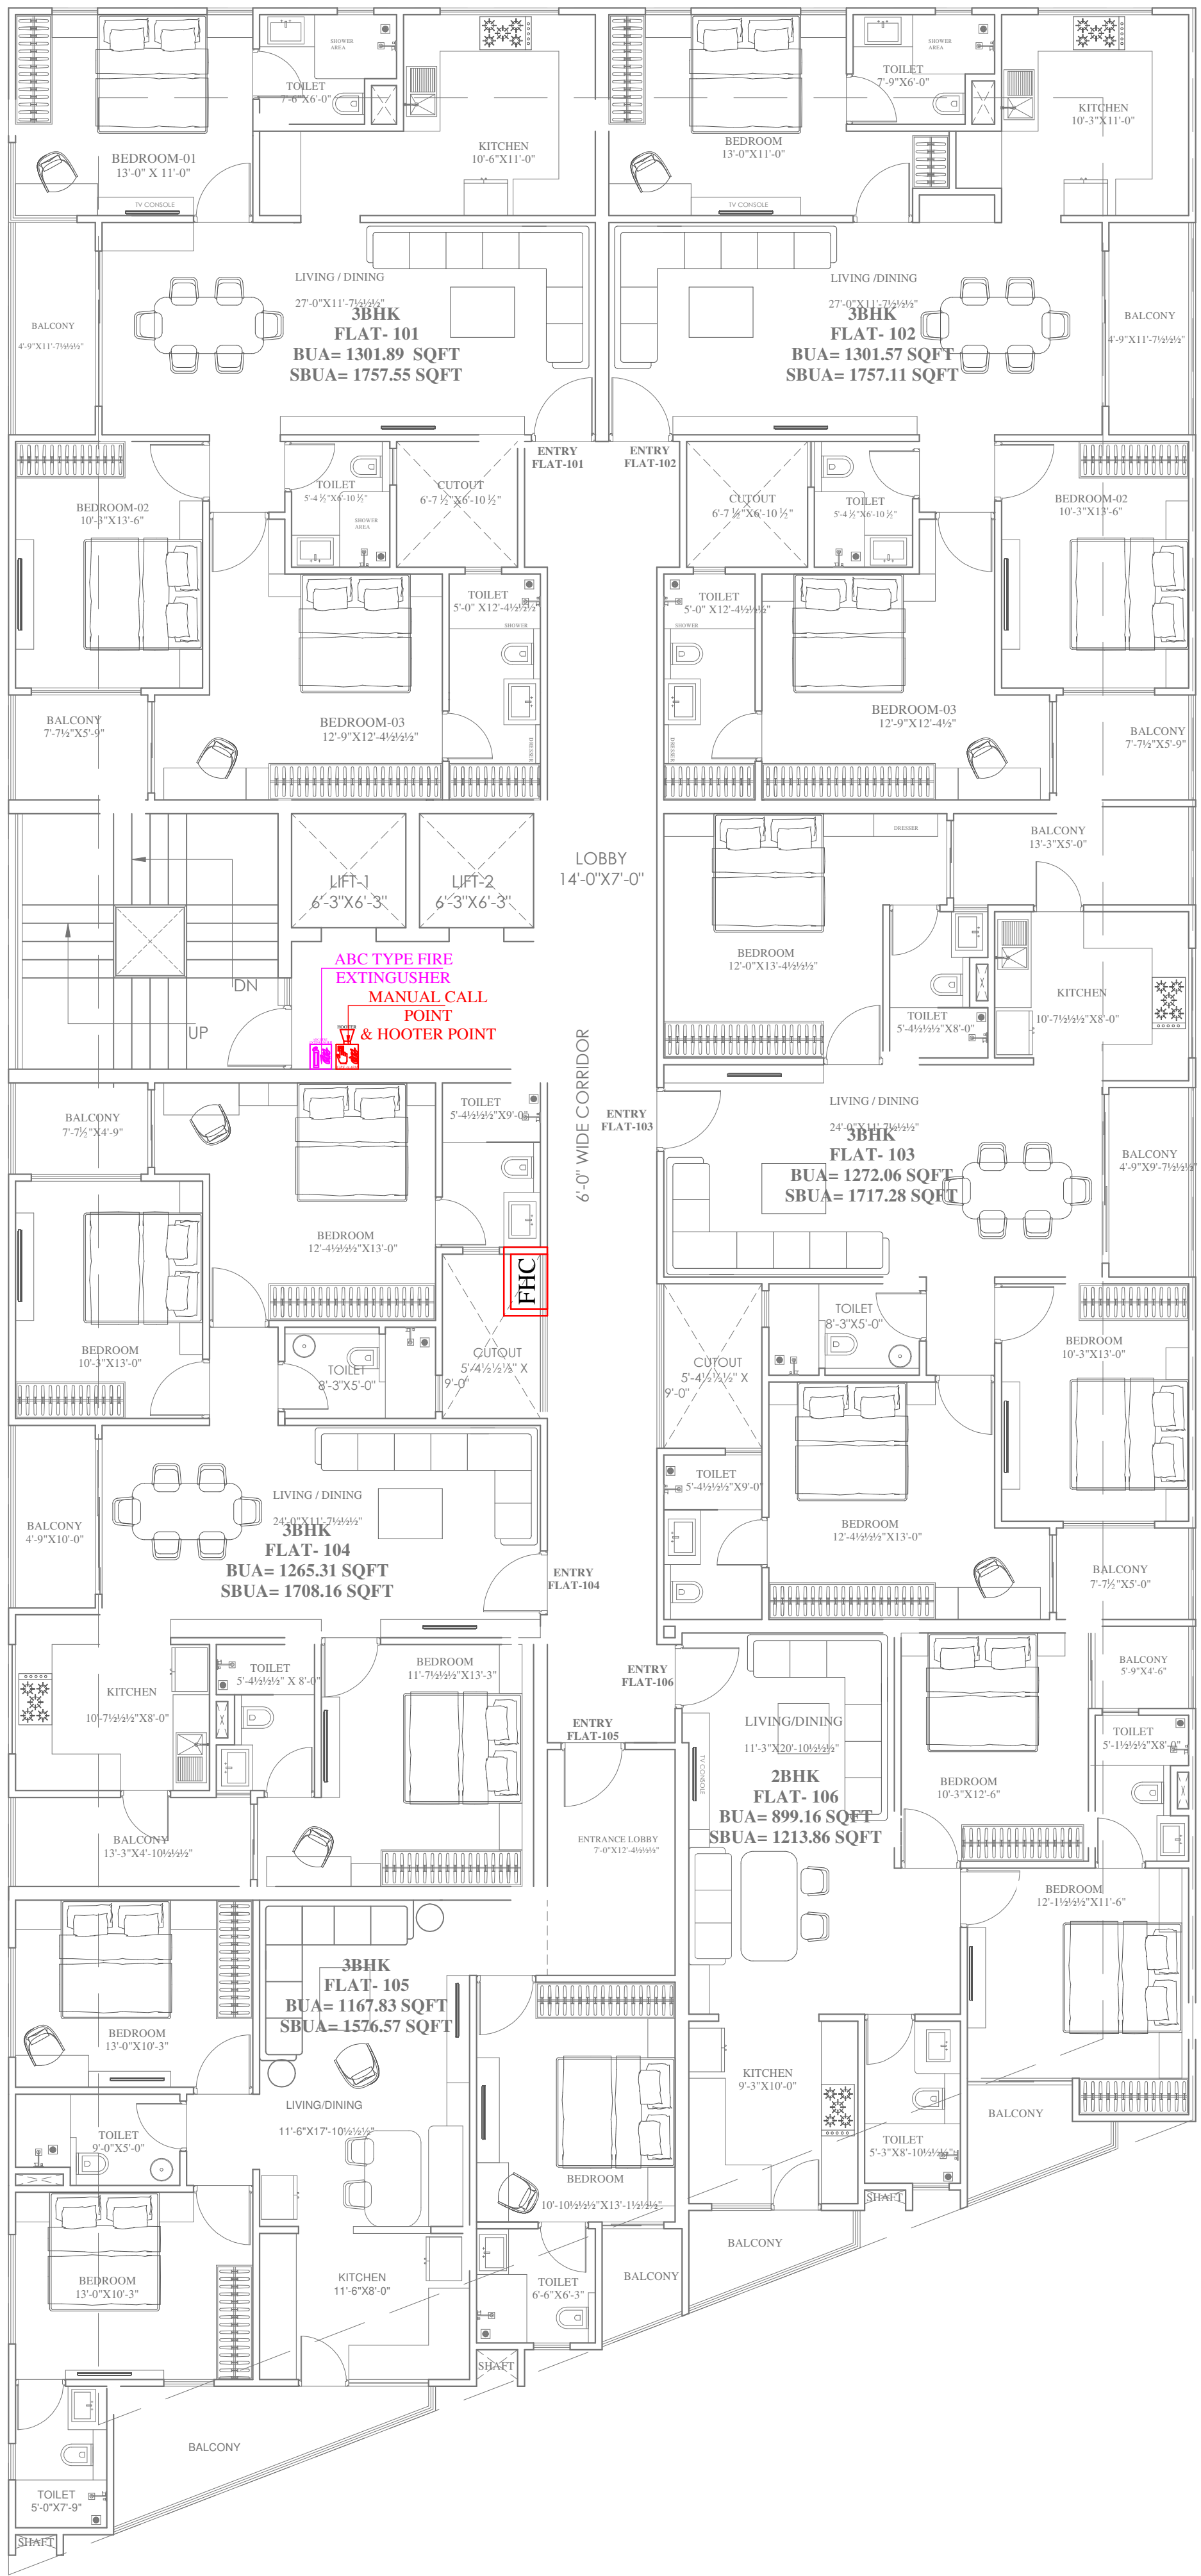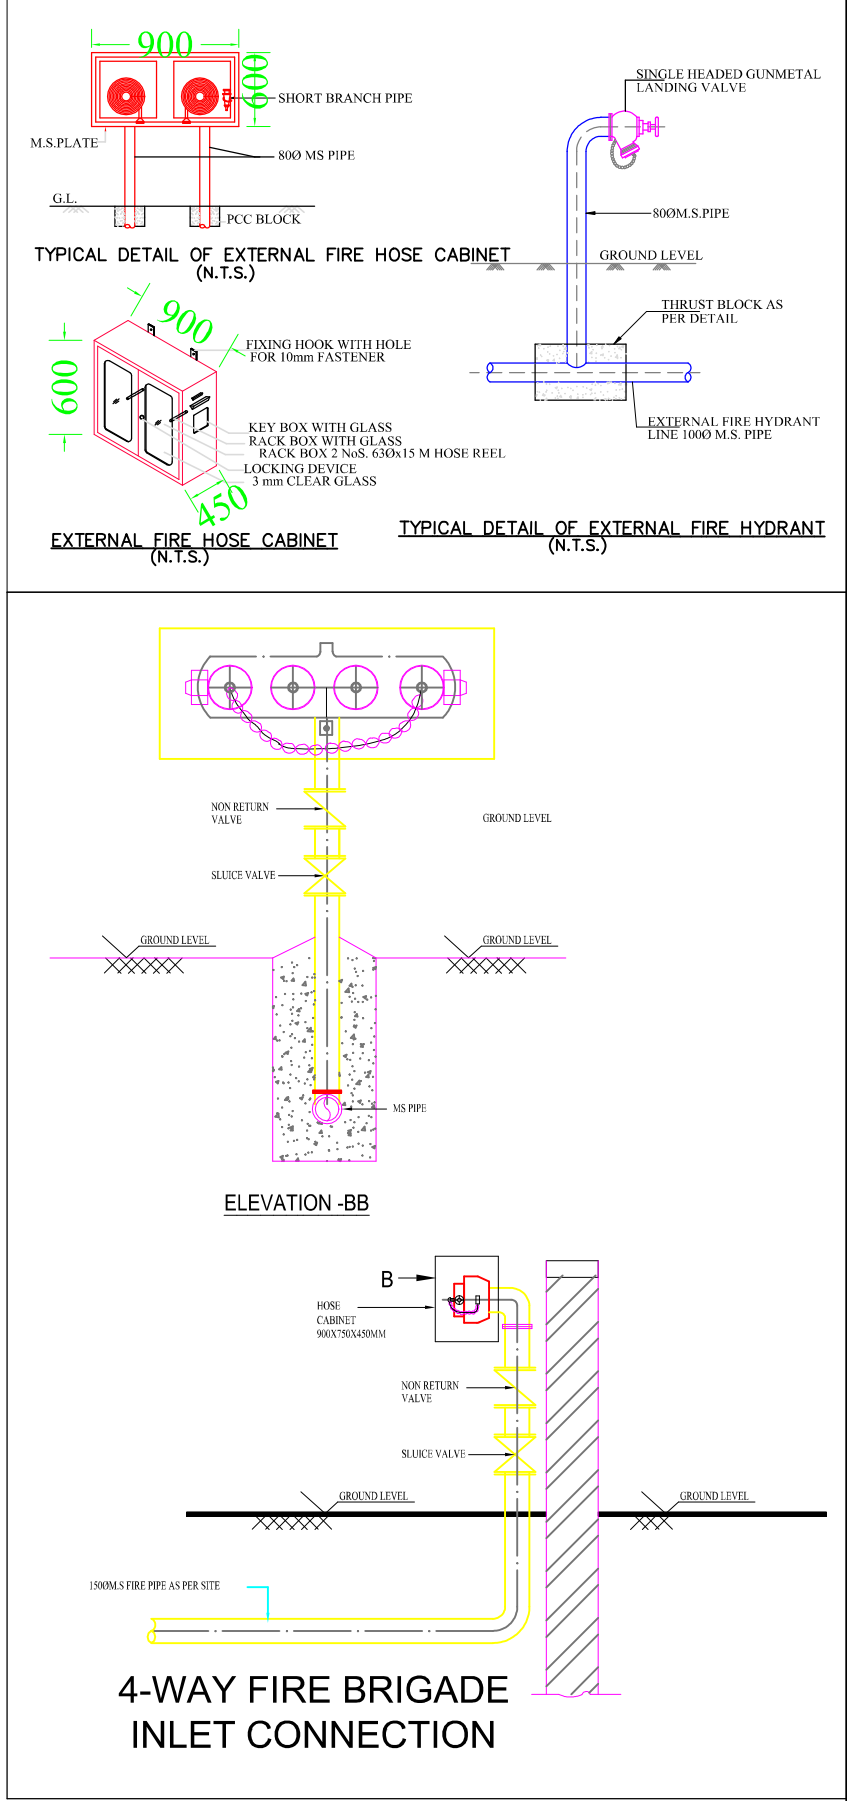





LEGENDS:

Mounting Height	No.	ID	Symbol	Description
+42"	01			ABC TYPE FIRE EXTINGUISHER
+42"	01	MCP		MANUAL CALL POINT
+90"	01	HT		HOOTER

SERVICES CONSULTANT:
ASHI ASSOCIATES
F 9 / 440 , Keshav Marg Chitrakut Scheme,Jaipur
PH:91-0-93146-10438 ,0141-2440946 Mail:vipul8599@yahoo.com

DRAWING TITLE:
**TYPICAL FLOOR
FHC, MCP, HOOTER & FIRE
EXTINGUISHER PLAN**


Vipul
**VIPUL AGARWAL
M.E.P. CONSULTANT
B.E. ELECTRICAL**

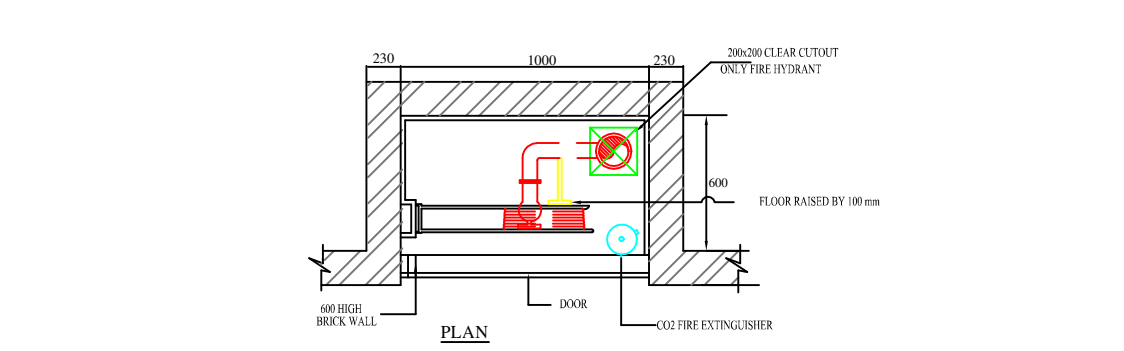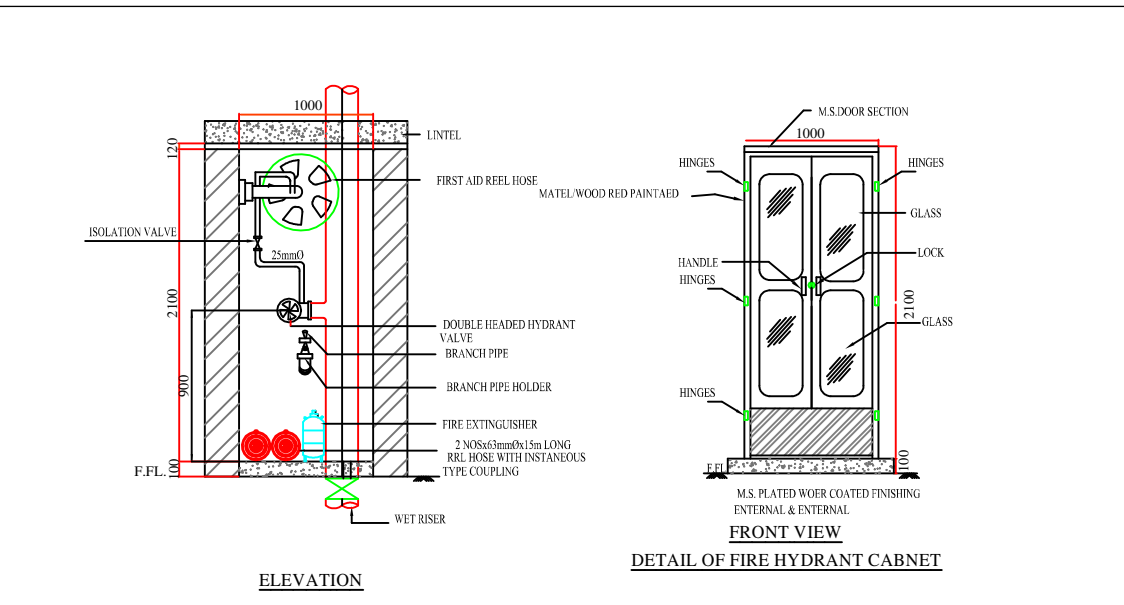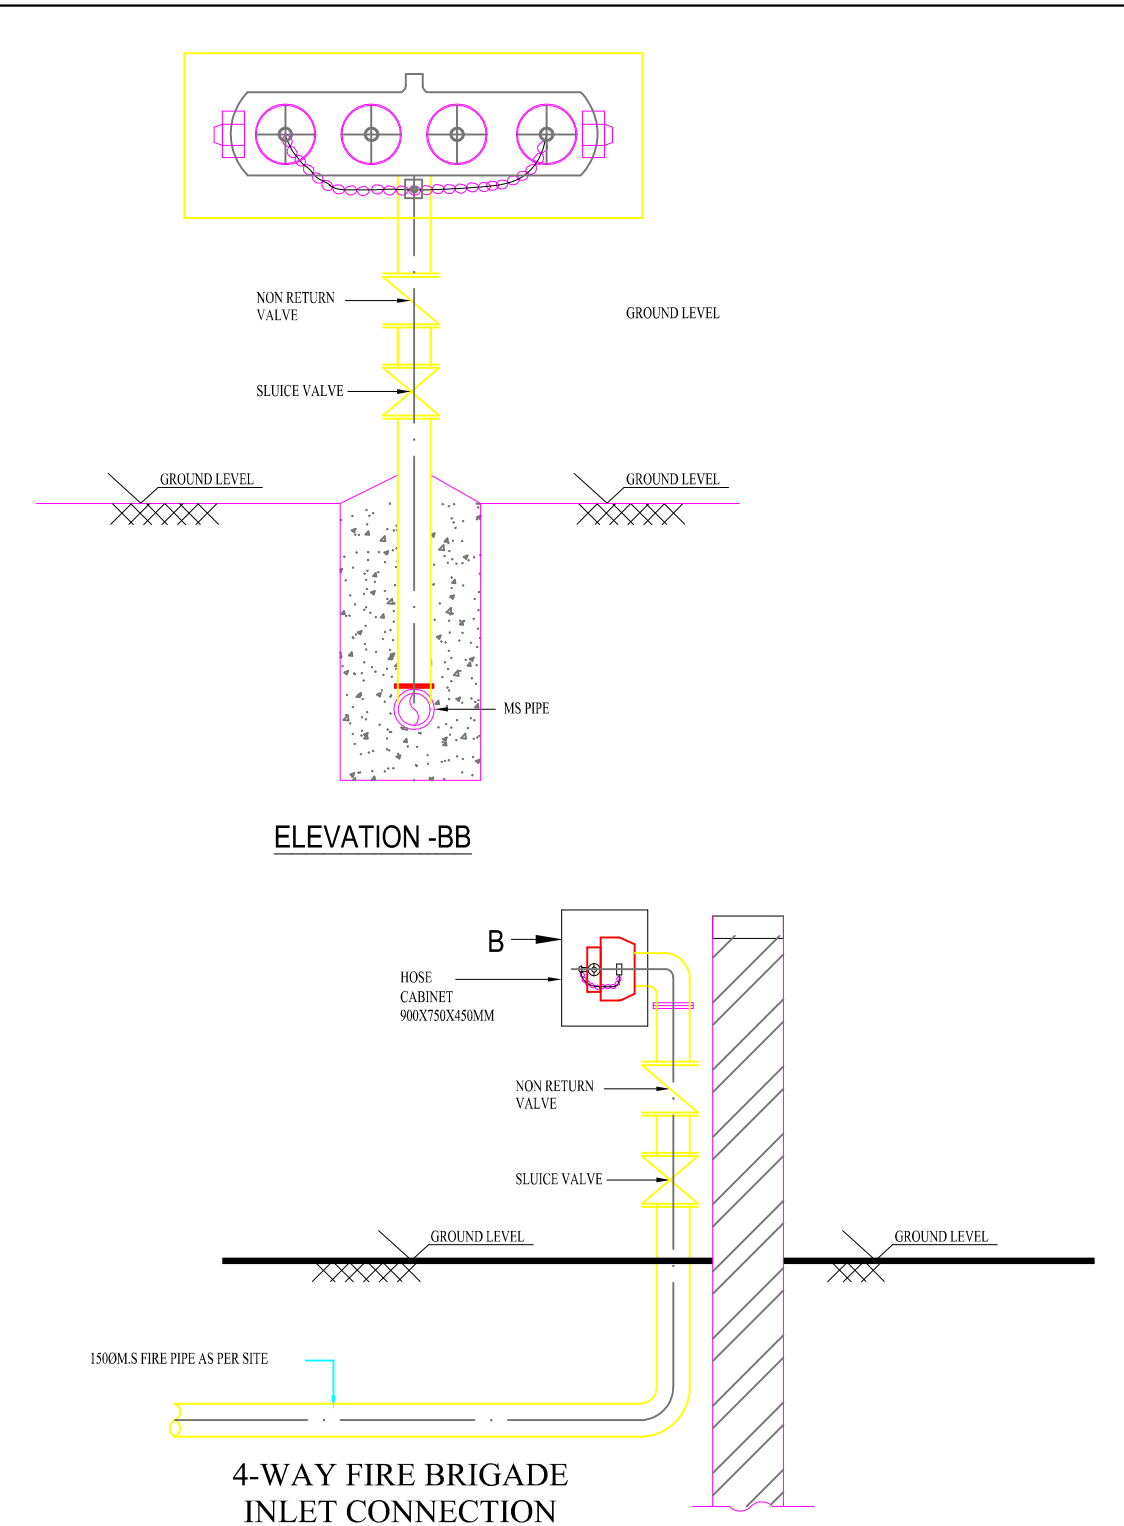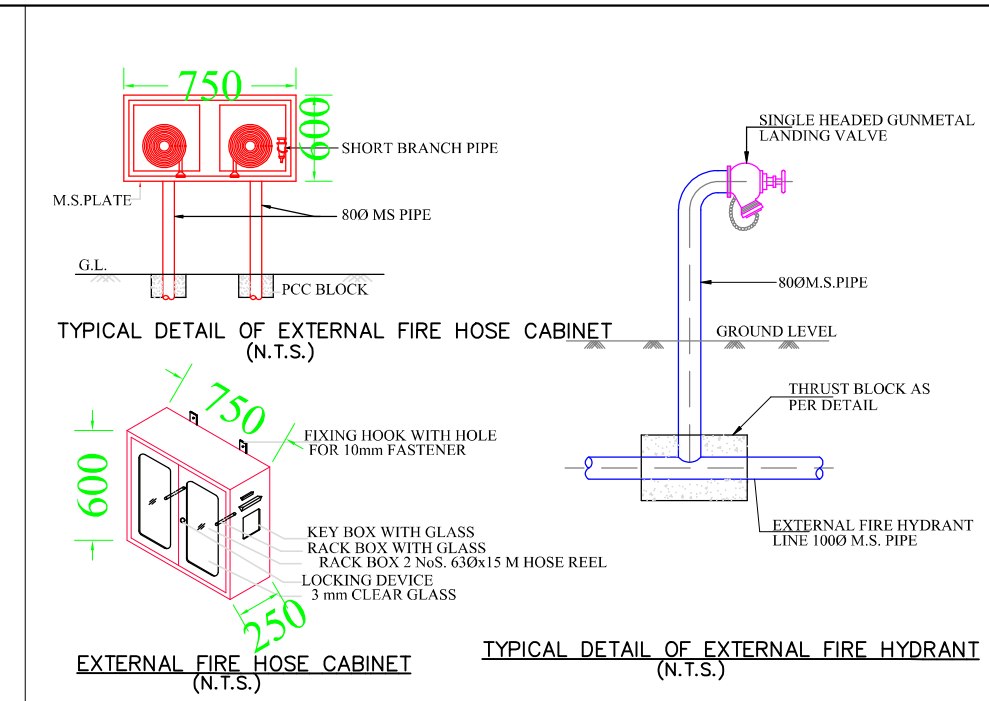

DRAWING:

TYPICAL DETAIL FOR FIRE HOSE CABINET-1

 SCALE=NTS
[FHC-1]

S.no.	Symbol	Description	Size in mm
1.		Butter fly Valve	100Ø
2.		Non Return Valve	100Ø
3.		Landing Valve Single headed	63Ø
4.		Pressure Guage	
5.		FHC	
6.		External Fire Hose Cabinet	

SERVICES CONSULTANT:
ASHI ASSOCIATES
F 9 / 440 , Keshav Marg Chitrakut Scheme,Jaipur
PH:91-0-93146-10438 ,0141-2440946 Mail:vipul8599@yahoo.com
ARCHITECT



PROJECT

**PARK VIEW APARTMENTS
BY SONI'S**

PROJECT ADDRESS

PLOT NO. 77& 78, VISHVASHRIYA
NAGAR VISTAR
(APOLLO NAGAR - GRAH NIRMAN
SAHKAR SAMITI
LIMITED), JAIPUR RAJASHTAN

PROMOTERS NAME :
**NEHAL
MAHESHWARI**

Drawing:

FIRE SCHEMATIC LAYOUT

SCALE :	DATE :
N.T.S.	22-08-2024

Vipul
VIPUL AGARWAL
M.E.P. CONSULTANT
B.E. ELECTRICAL