


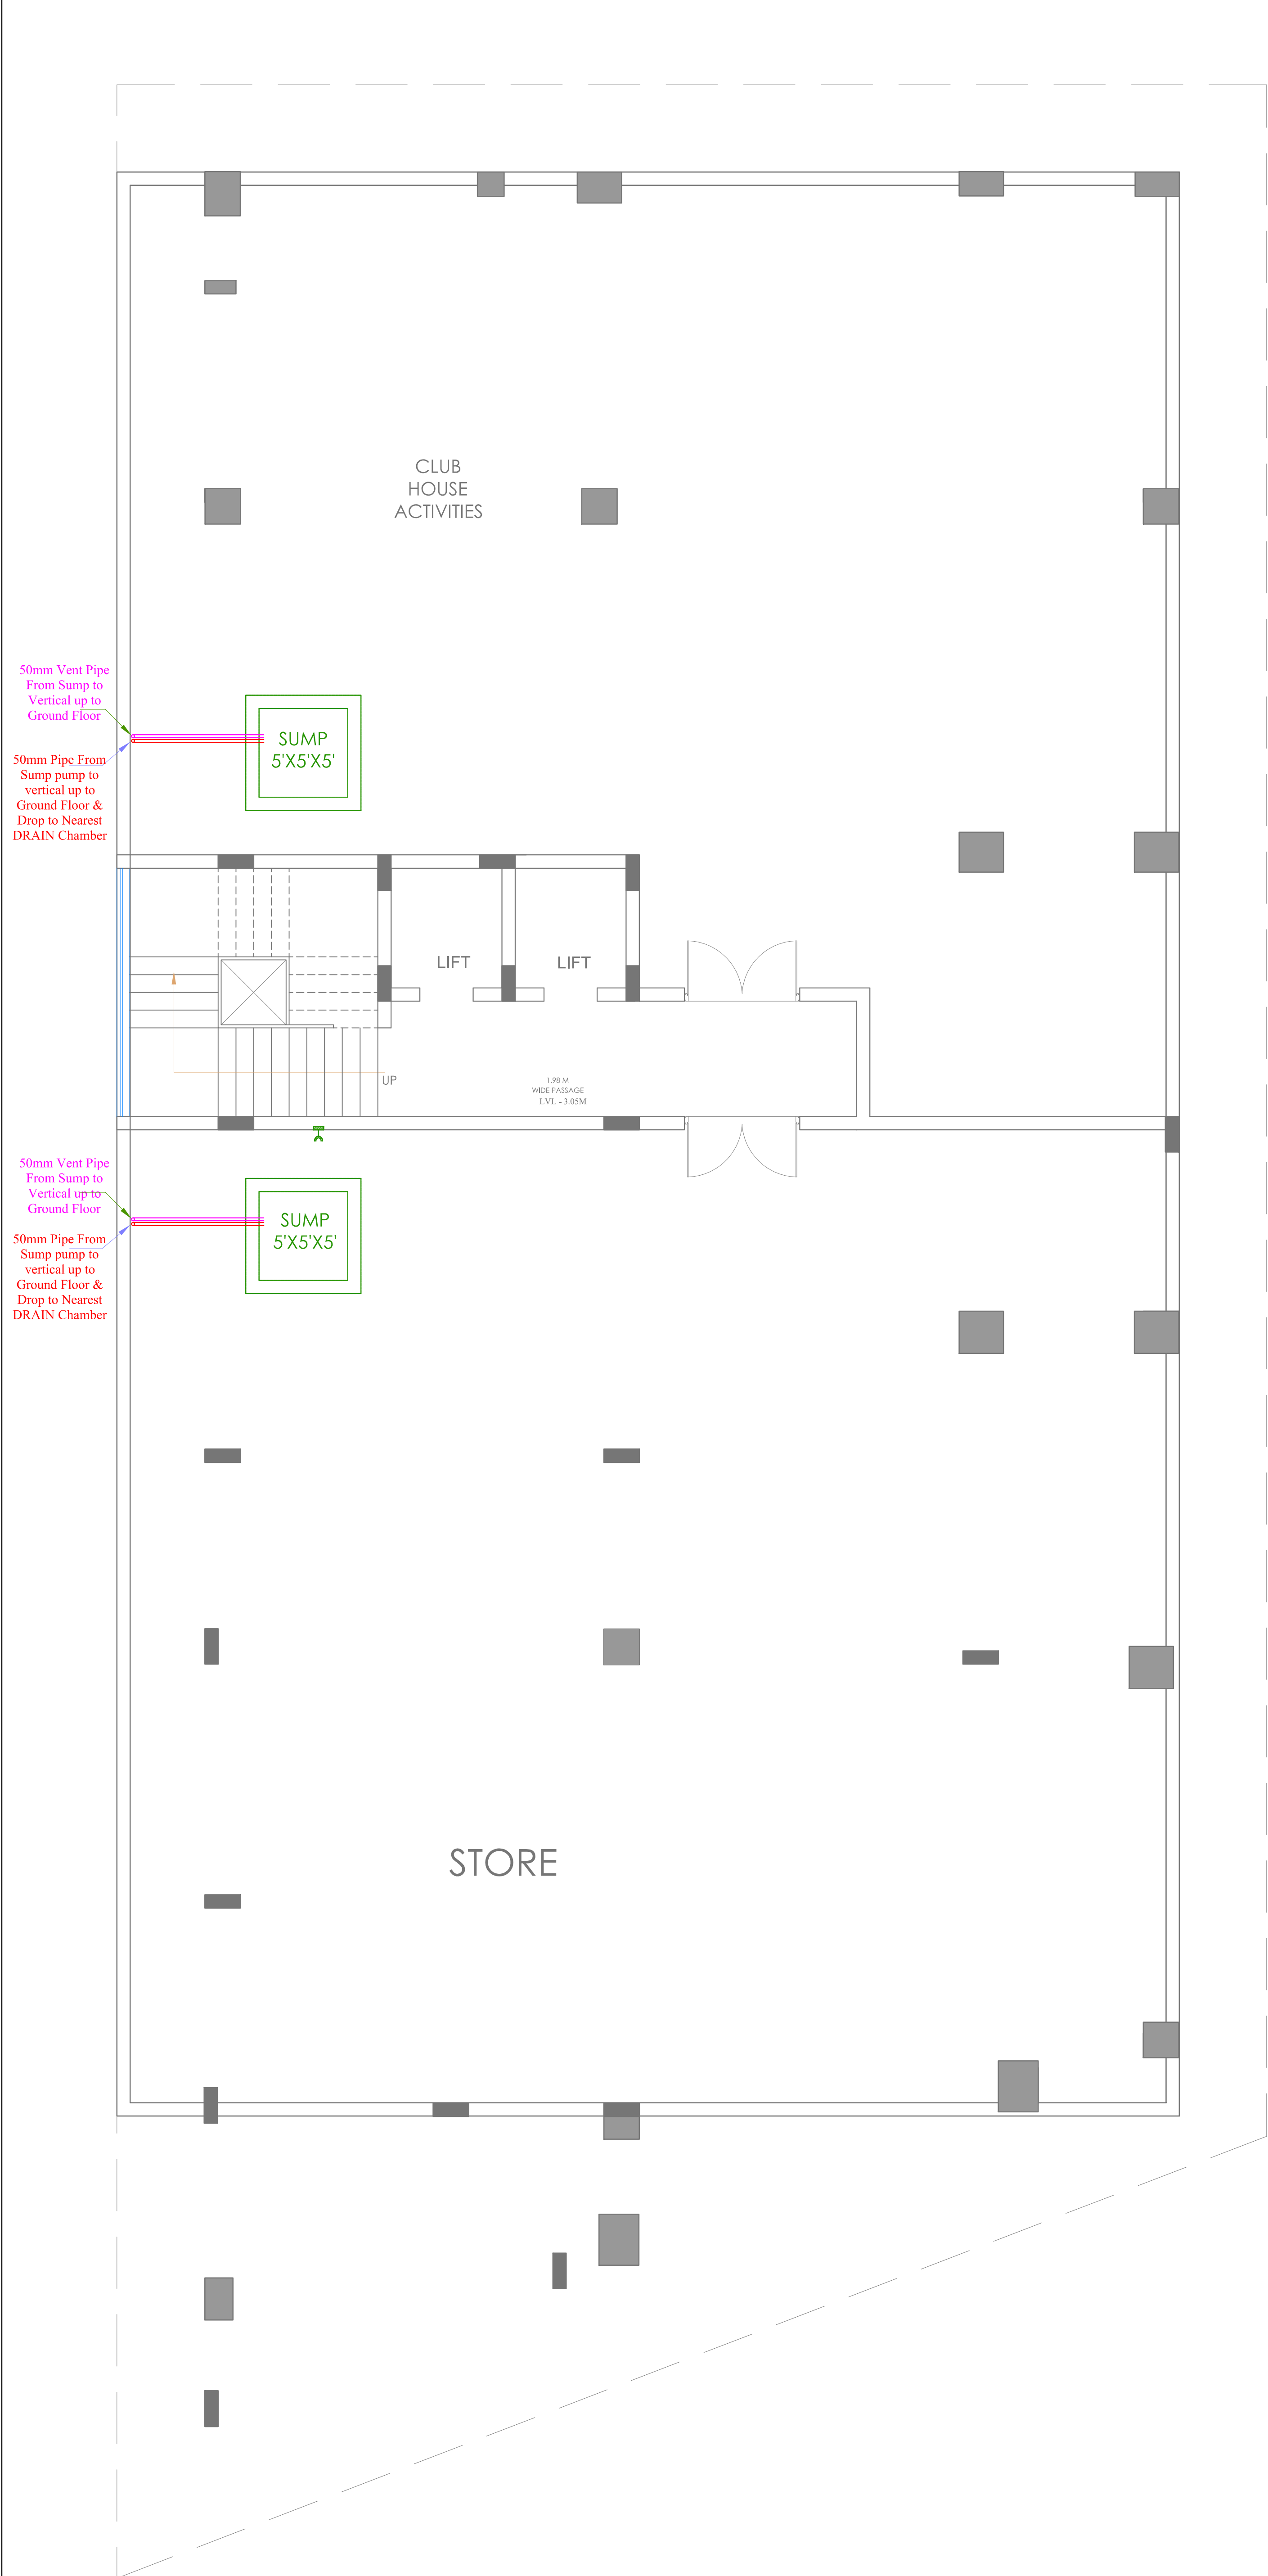

Vipul
VIPUL AGARWAL
M.E.P. CONSULTANT
B.E. ELECTRICAL

SERVICES CONSULTANT:
ASHI ASSOCIATES
F9/440,Keshav Marg Chitrakut Scheme,Jaipur
PH:91-0-93146-10438 ,0141-2440946 Mail:vipul8599@yahoo.com

DRAWN. BY:- MAHENDRA	CHKD. BY:- SANJAY
-----------------------------	--------------------------


APPD. BY:- VIPUL AGARWAL

DATE:- 04-10-2024	REV.:- 00	SCALE - NTS
--------------------------	------------------	-------------

DRAWING TYPE :-

BASEMENT FLOOR
DRAINAGE SUMP LOCATION MARKED PLAN

PROJECT NAME : PARK VIEW APARTMENTS BY SONT'S	PROMOTERS NAME : NEHAL MAHESHWARI	PROJECT ADDRESS : PLOT NO. 77& 78, VISHVASHRIYA NAGAR VISTAR (APOLLO NAGAR - GRAH NIRMAN SAHKAR SAMITI LIMITED), JAIPUR RAJASHTAN	 NORTH	 DESIGNER STUDIO Architecture Planning Interiors
---	---	--	-----------	--

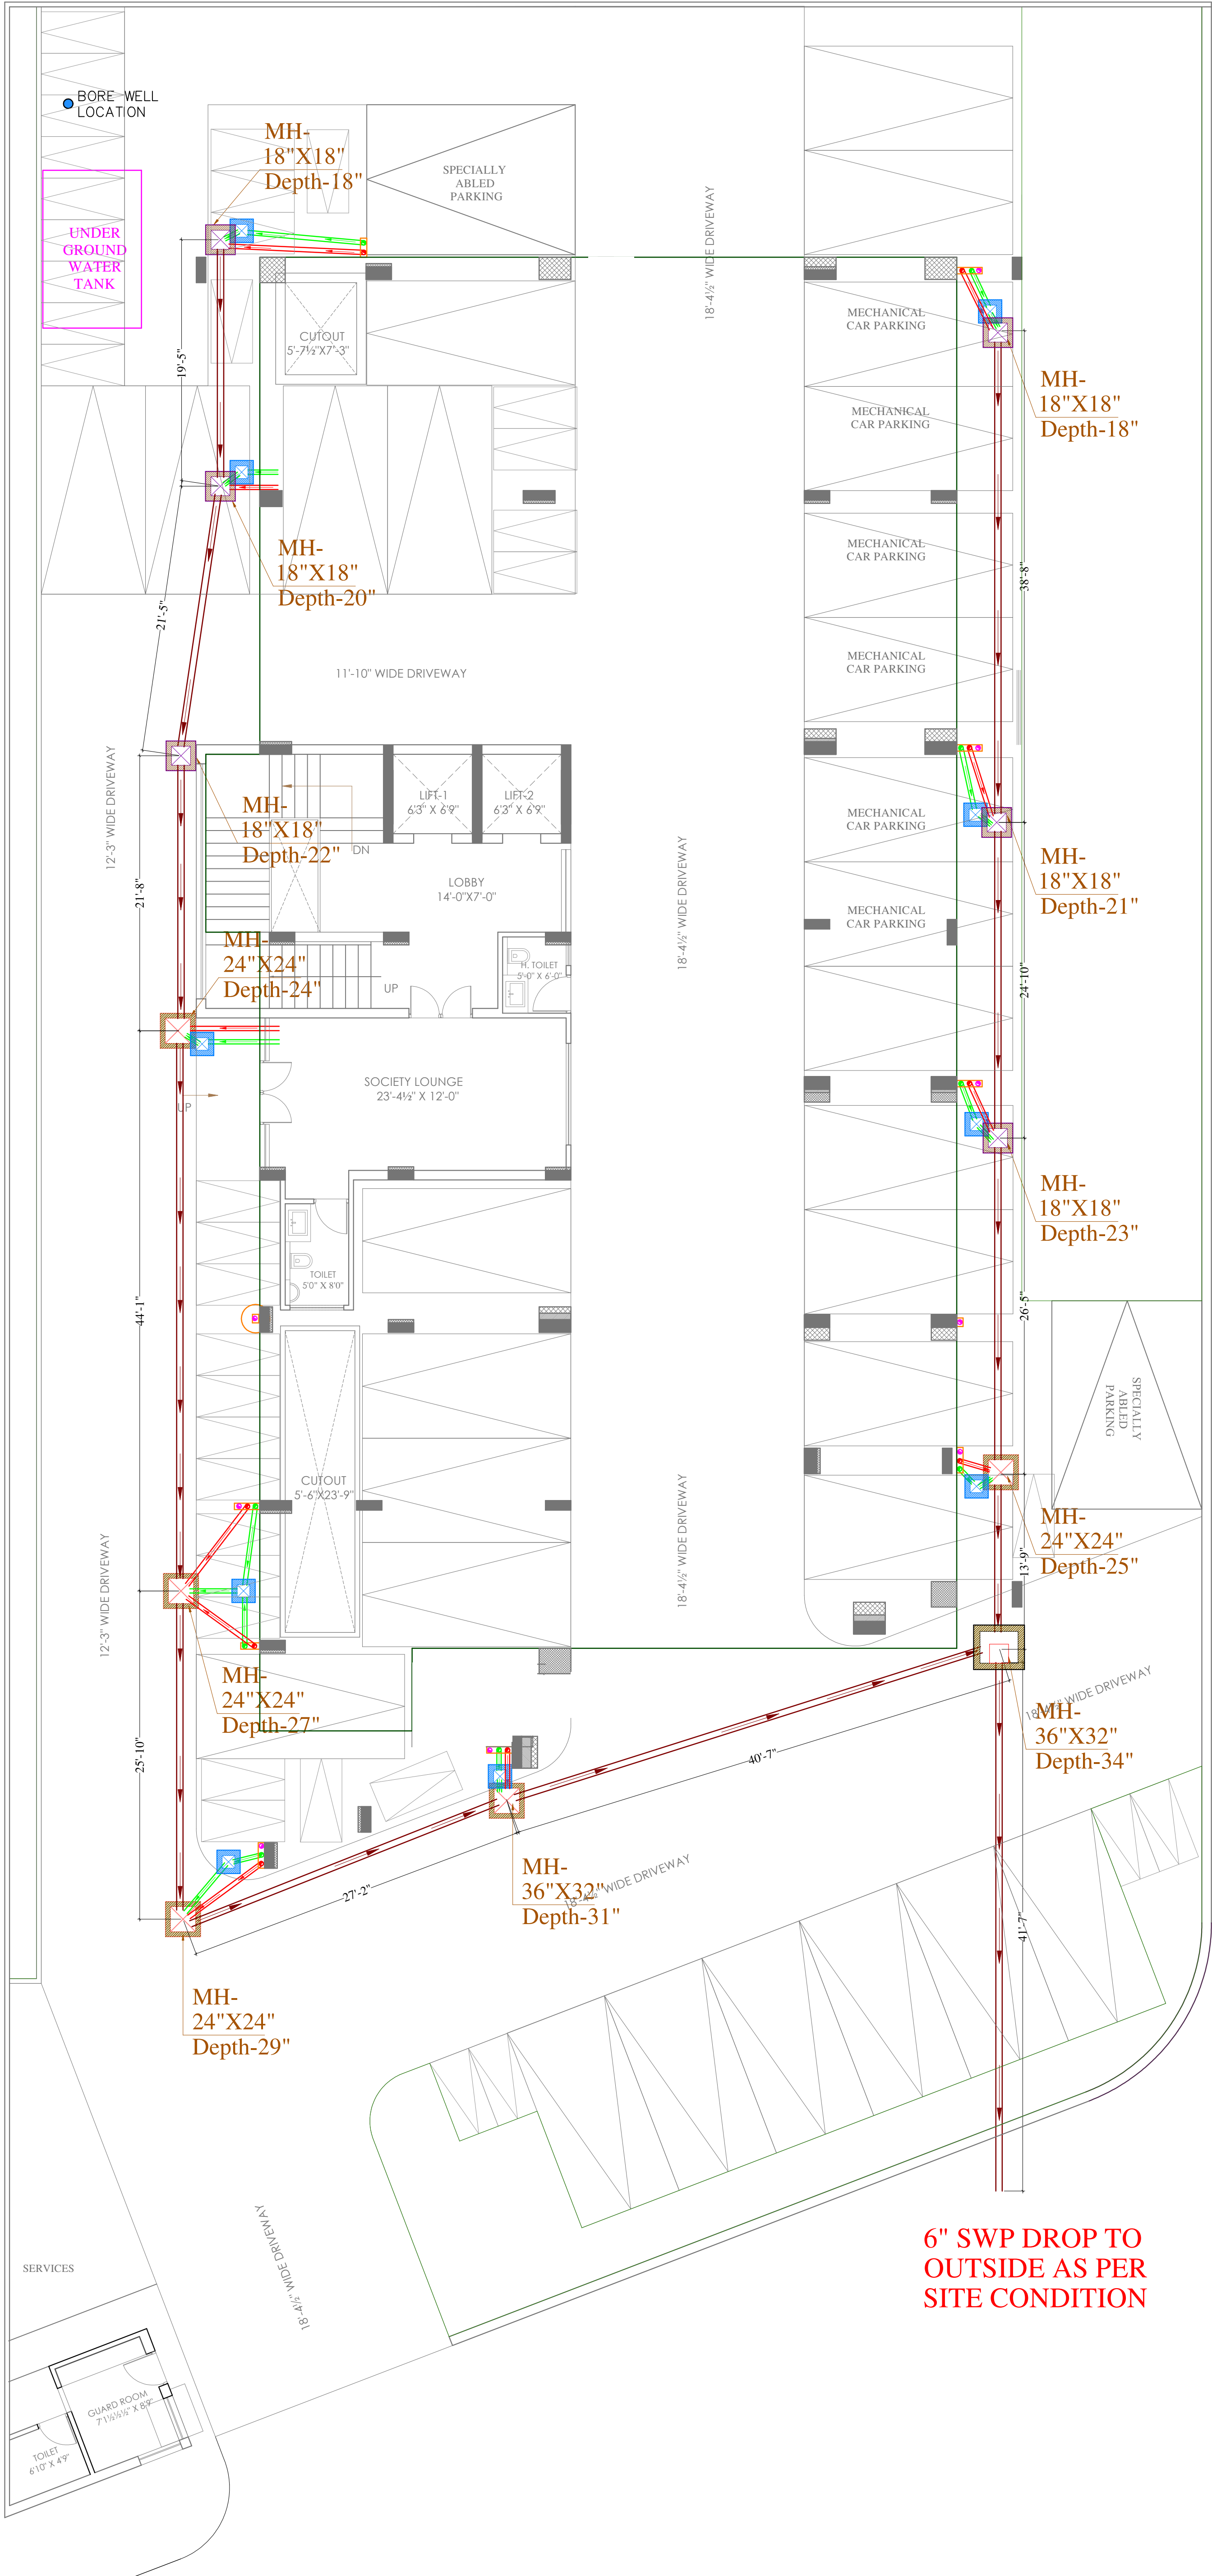

Vipul
VIPUL AGARWAL
M.E.P. CONSULTANT
B.E. ELECTRICAL

SYMBOL	DESCRIPTION
	110 mm Soil Waste Water Pipe
	110 mm Waste Water Pipe
	110 mm Rain Water Pipe
	160 mm Soil Waste Water Pipe Slope 1:200
	110 mm Soil Waste Water Pipe Slope 1:150
	110 mm Waste Water Pipe Slope 1:150
	Gully Trap-300X300mm Depth 300 mm
	Main Hole-450X450mm Depth According to Slope
	Main Hole-600X600mm Depth According to Slope
	Main Hole-900X750mm Depth According to Slope
	Flow Direction
SERVICES CONSULTANT: ASHI ASSOCIATES F 9 / 440 , Keshav Marg Chitrakut Scheme,Jaipur PH:91-0-93146-10438 ,0141-2440946 Mail:vipul8599@yahoo.com	

DRAWING TITLE:
**EXTERNAL SEWERAGE
WATER PIPE ROUTE
PLAN**

PROJECT NAME :

**PARK VIEW APARTMENTS
BY SONI'S**

PROMOTERS NAME :


**NEHAL
MAHESHWARI**

PROJECT ADDRESS :

PLOT NO. 77& 78, VISHVASHRIYA NAGAR VISTAR
(APOLLO NAGAR - GRAH NIRMAN SAHKAR SAMITI
LIMITED), JAIPUR RAJASHTAN

NORTH




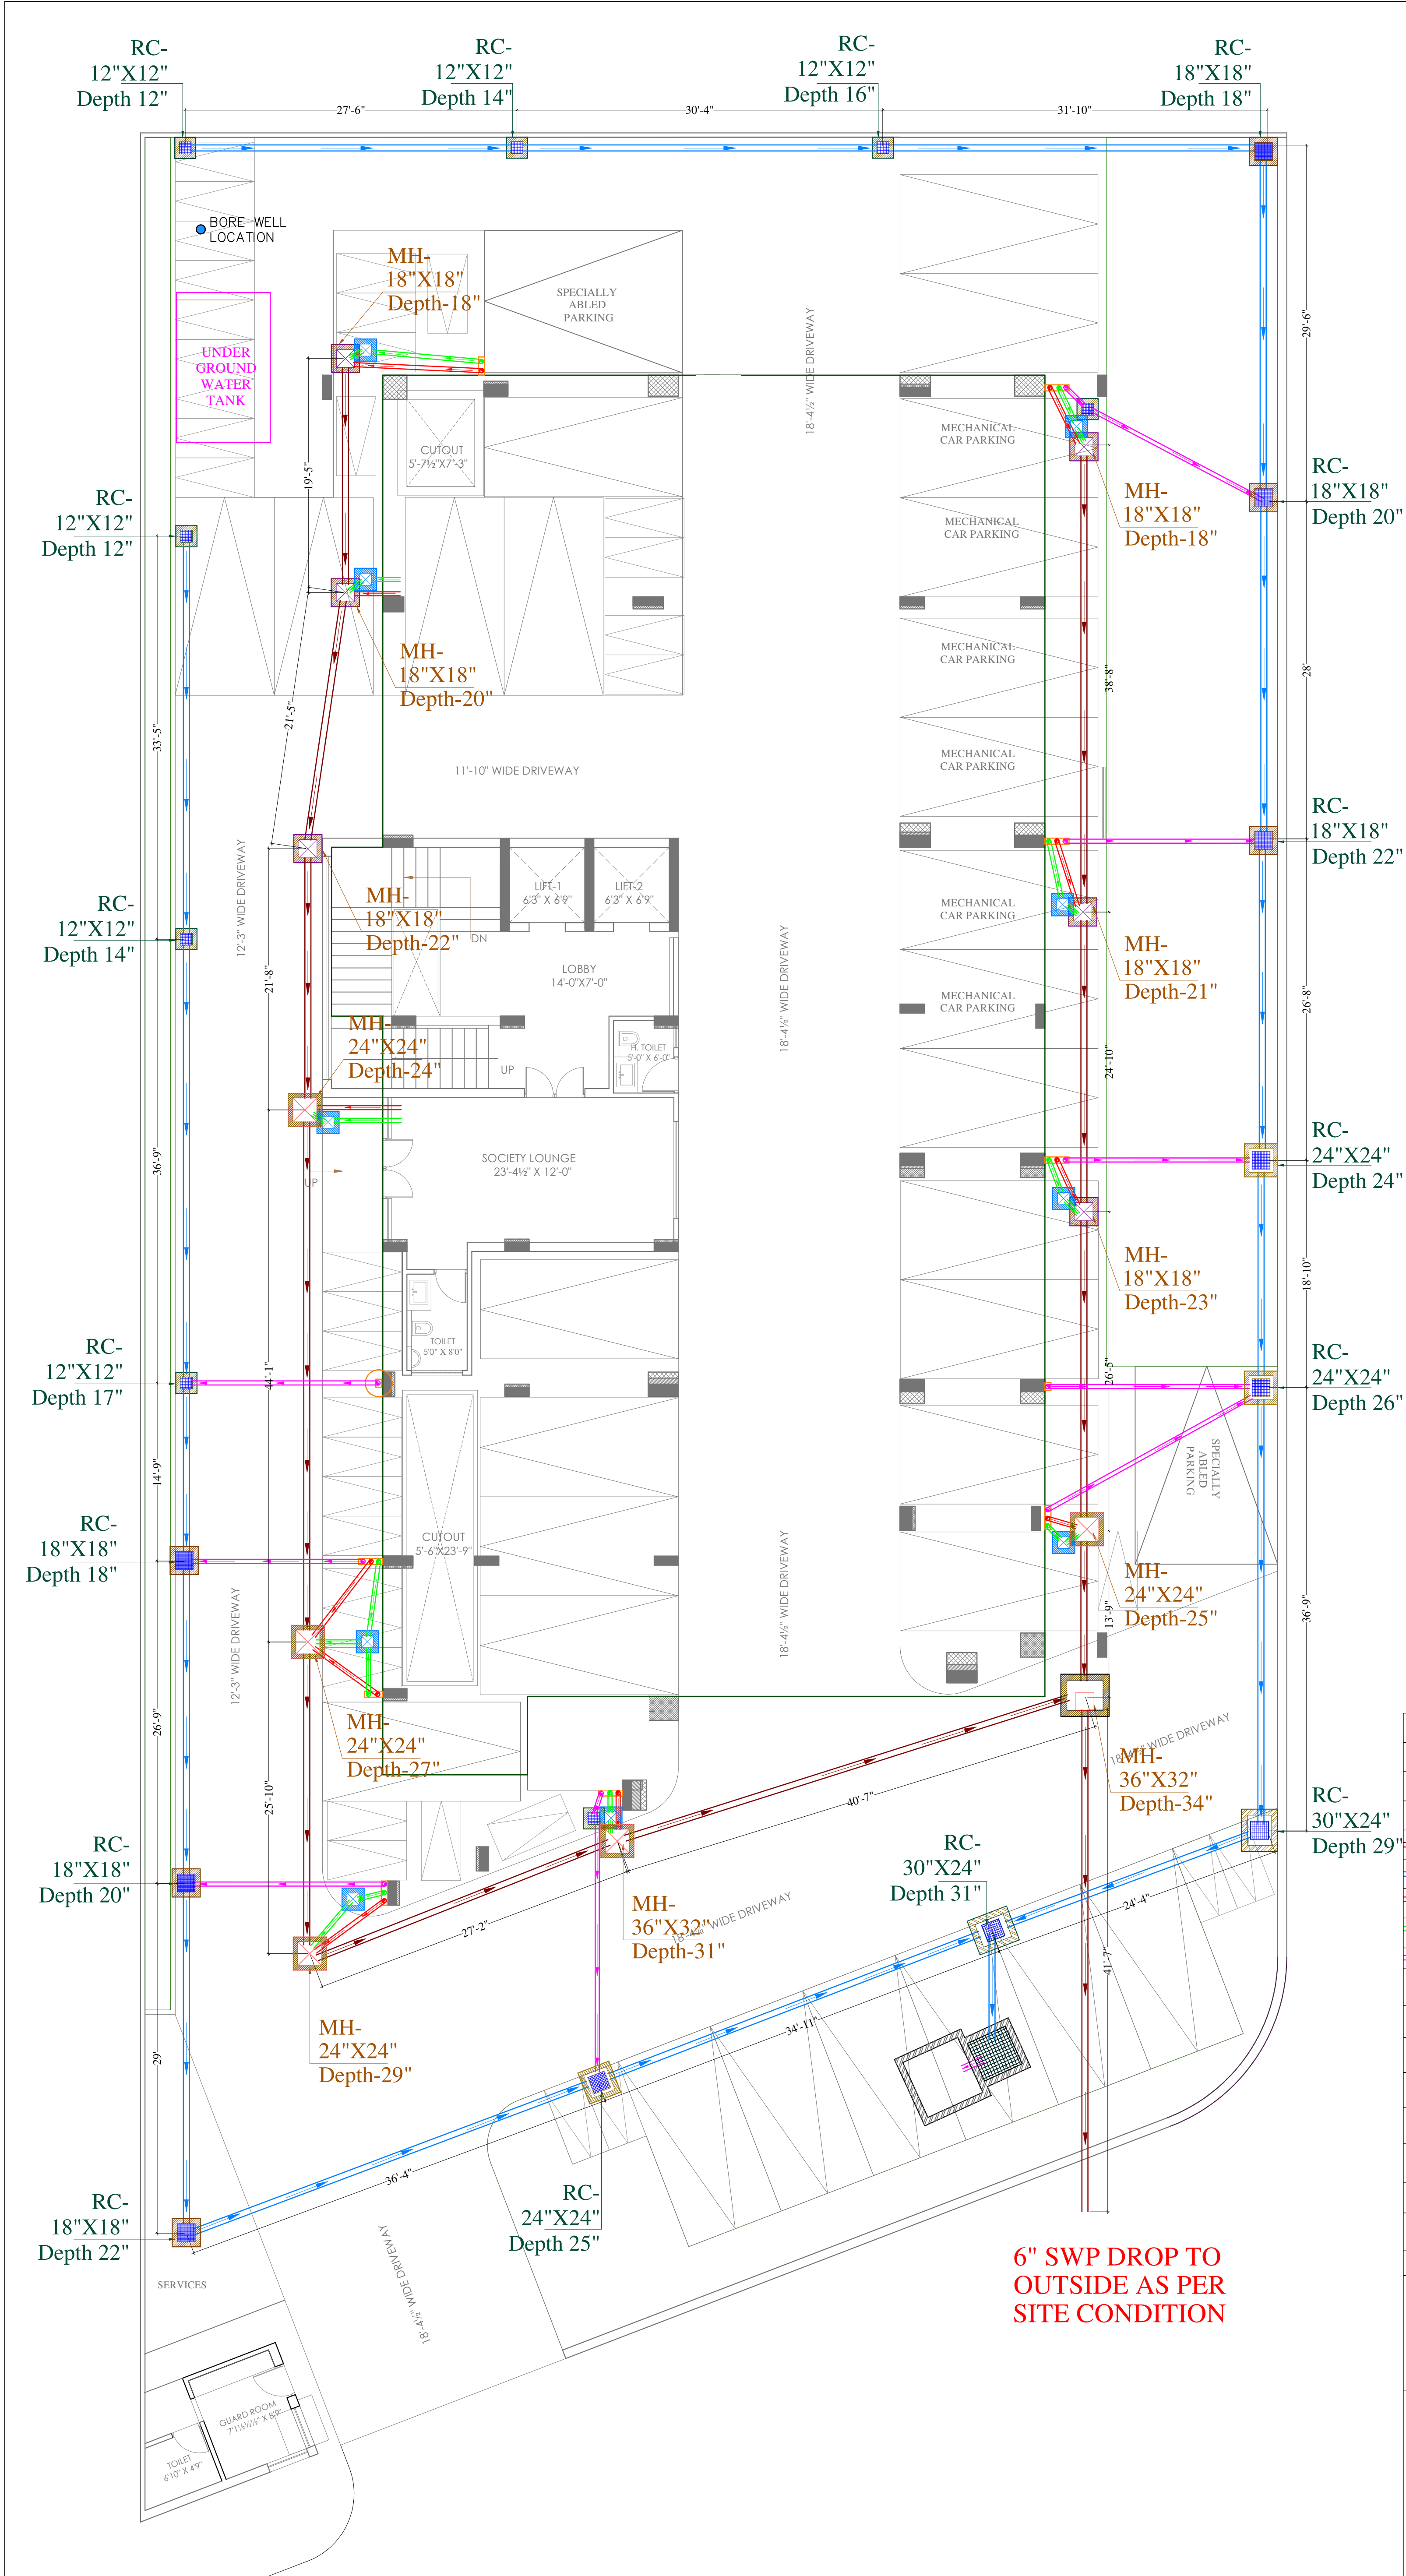

Vipul
VIPUL AGARWAL
M.E.P. CONSULTANT
B.E. ELECTRICAL

SYMBOL	DESCRIPTION
	110 mm Soil Waste Water Pipe
	110 mm Waste Water Pipe
	110 mm Rain Water Pipe
	160 mm Soil Waste Water Pipe Slope 1:200
	160 mm Rain Water Pipe Slope 1:200
	110 mm Soil Waste Water Pipe Slope 1:150
	110 mm Waste Water Pipe Slope 1:150
	110 mm Rain Water Pipe Slope 1:200
	RC-300X300mm Depth According to Slope
	RC-450X450mm Depth According to Slope
	RC-600X600mm Depth According to Slope
	RC-750X600mm Depth According to Slope
	Gully Trap-300X300mm Depth 300 mm
	Main Hole-450X450mm Depth According to Slope
	Main Hole-600X600mm Depth According to Slope
	Main Hole-900X750mm Depth According to Slope
	Flow Direction
SERVICES CONSULTANT: ASHI ASSOCIATES F 9 / 440 , Keshav Marg Chitrakut Scheme,Jaipur PH:91-0-93146-10438 ,0141-2440946 Mail:vipul8599@yahoo.com	

DRAWING TITLE:
EXTERNAL SEWERAGE & RAIN WATER PIPE ROUTE PLAN

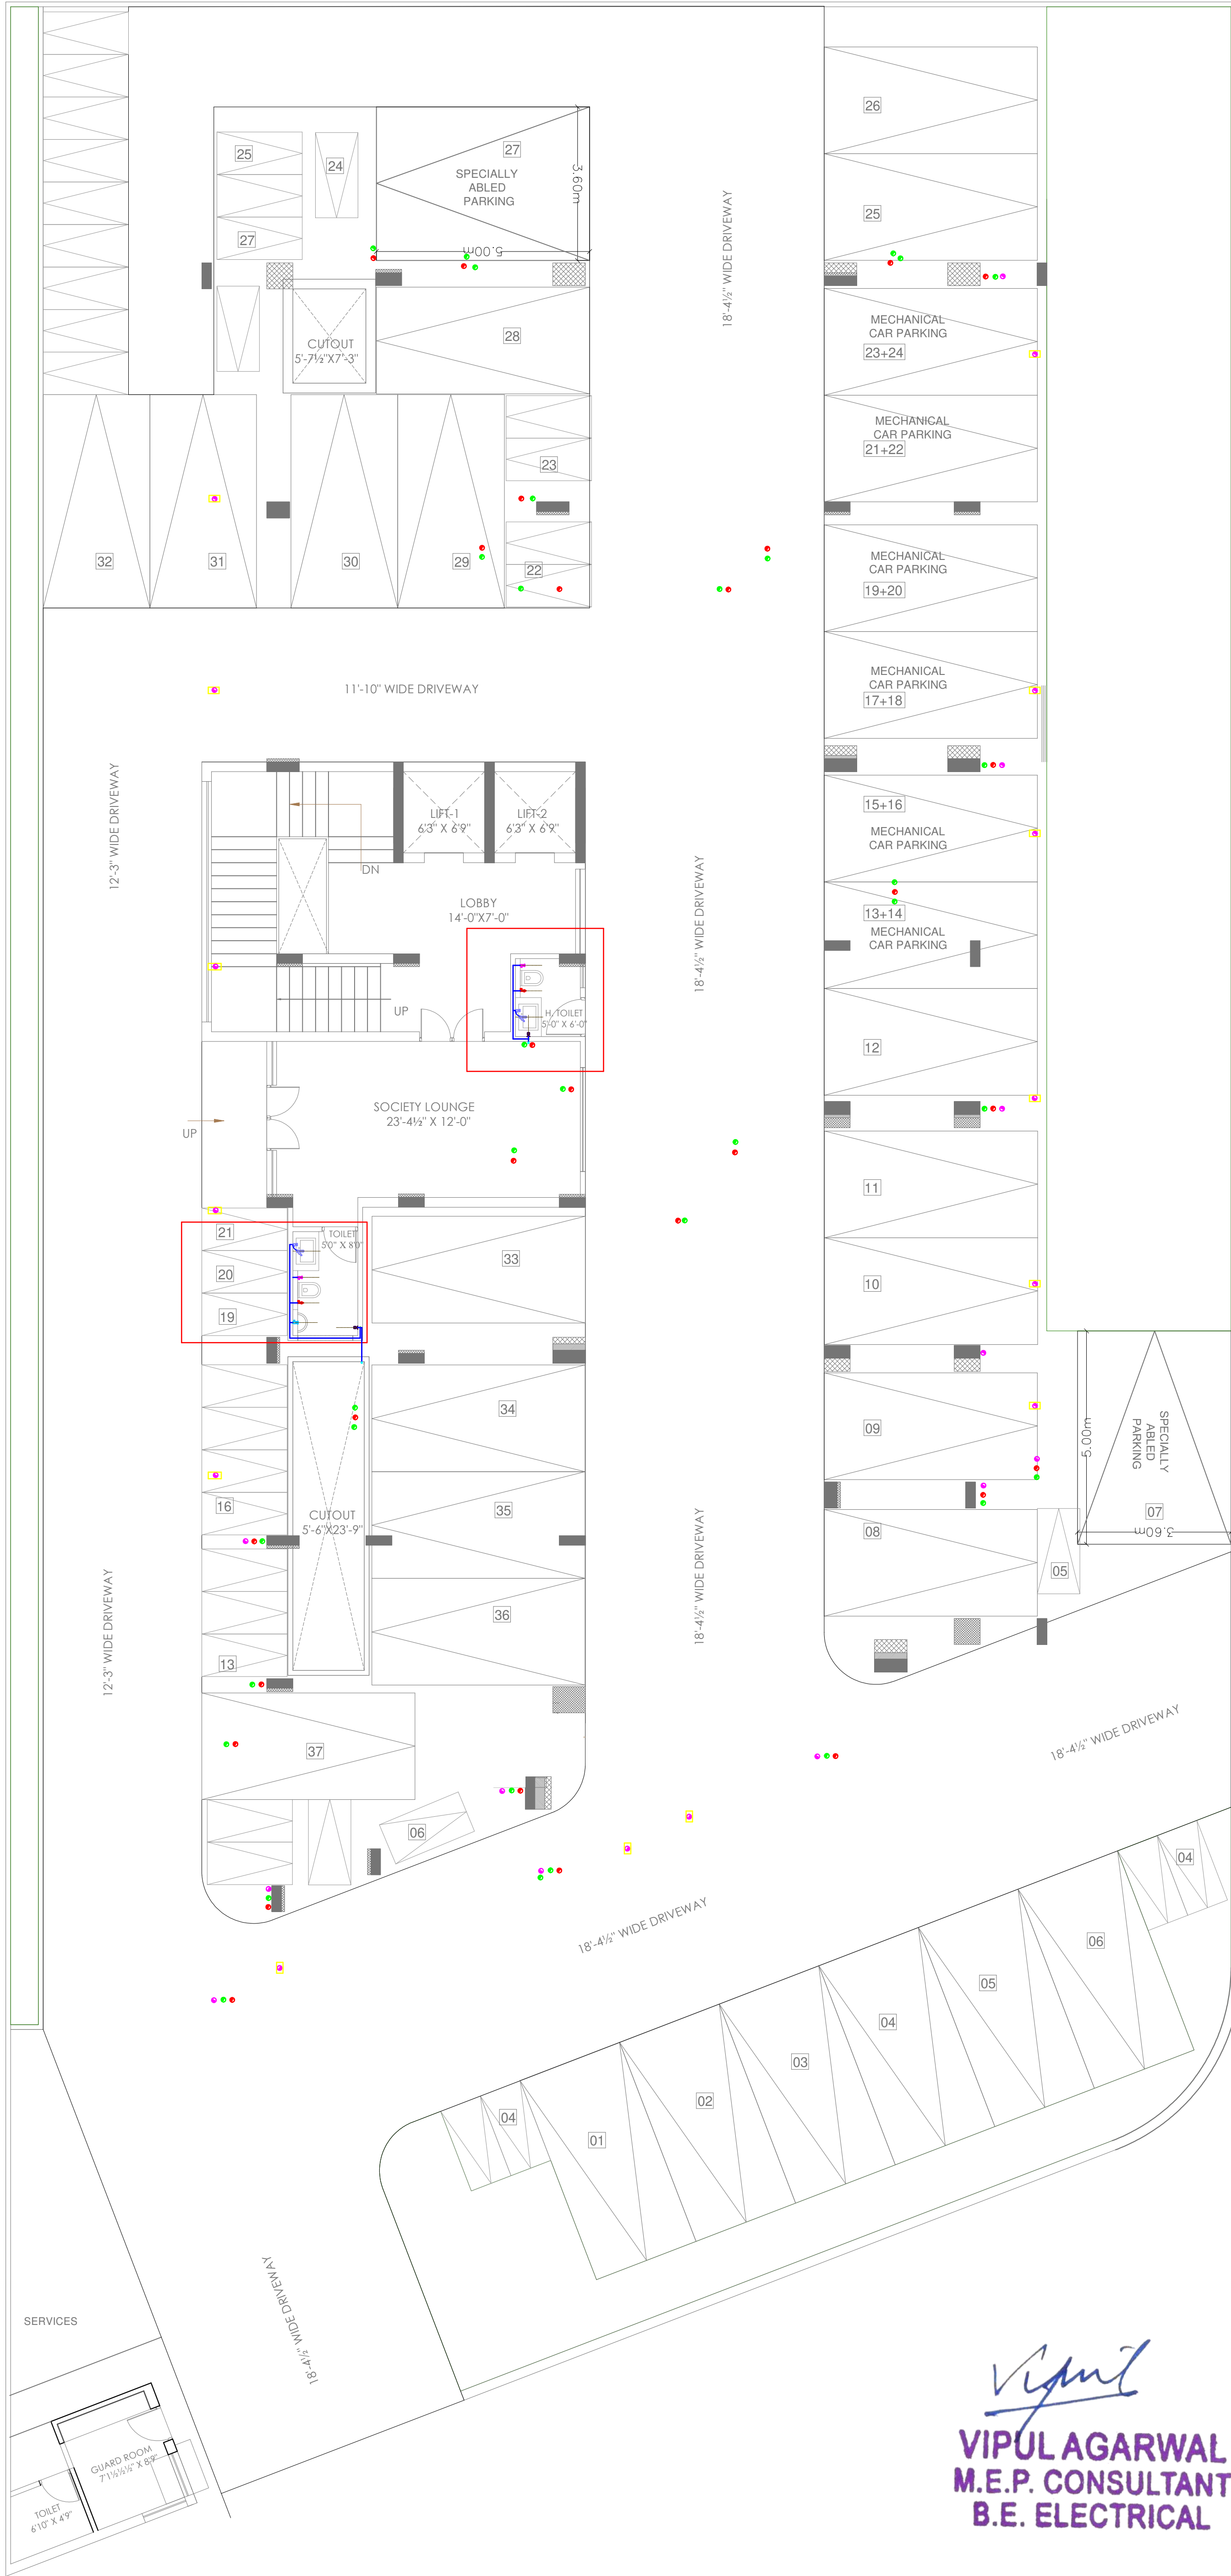

Vipul
VIPUL AGARWAL
M.E.P. CONSULTANT
B.E. ELECTRICAL

All Heights For Finish Floor Lvl	SYMBOL	SYMBOL	DESCRIPTION
+1000MM			Ø 20MM CWS PIPE THRU WALL CHASE TO SINK
			Ø 20MM HWS PIPE THRU WALL CHASE TO SINK
+1950MM			Ø 20MM CWS PIPE THRU WALL CHASE TO GEYSER
			Ø 20MM HWS PIPE THRU WALL CHASE TO GEYSER
+1500MM			Ø 20MM CWS PIPE THRU WALL CHASE TO AQUAGUARD
+450MM			Ø 20MM HWS PIPE THRU WALL CHASE TO BASIN ANGLE VALVE
+800MM			Ø 20MM CWS PIPE THRU WALL CHASE TO BASIN ANGLE VALVE
+2100MM			Ø 20MM CWS PIPE THRU WALL CHASE TO CONCEALED STOP COCK
+300MM			Ø 20MM CWS PIPE THRU WALL CHASE TO FAUCET
+450MM			Ø 20MM CWS PIPE THRU WALL CHASE TO CISTERN ANGLE VALVE
+1000MM WALL MIXER DIVERTOR			Ø 20MM CWS PIPE THRU WALL CHASE TO WALL MIXER / DIVERTOR
+2025MM O.H.SHOWER			Ø 20MM HWS PIPE THRU WALL CHASE TO WALL MIXER / DIVERTOR
+600MM			Ø 20MM CWS PIPE THRU WALL CHASE TO TAP
+450MM			Ø 20MM CWS PIPE THRU WALL CHASE TO CISTERN ANGLE VALVE
			Floor Trap
+950MM	AS PER ARCH.		MIRROR 450X450mm(BOTTOM)
+1000MM	AS PER ARCH.		SOAP DISH
+1500MM	AS PER ARCH.		TOWEL RAIL
+450MM	AS PER ARCH.		PAPER HOLDER
			COLD WATER SUPPLY LINE
			HOT WATER SUPPLY LINE

SERVICES CONSULTANT:
ASHI ASSOCIATES
F 9 / 440 , Keshav Marg Chitrakut
Scheme,Jaipur
PH:91-0-93146-10438 ,0141-2440946
Mail:vipul8599@yahoo.com

DRN BY-	NITIN	CKD BY-	SANJAY
		SCALE-	
APPD. BY:-			
VIPUL AGARWAL			
DRAWING:	STILT FLOOR PLUMBING & WATER SUPPLY LAYOUT PLAN		

PROJECT NAME :

PARK VIEW APARTMENTS
BY SONI'S

PROMOTERS NAME :


NEHAL
MAHESHWARI

PROJECT ADDRESS :

PLOT NO. 77& 78, VISHVASHRIYA NAGAR VISTAR
(APOLLO NAGAR - GRAH NIRMAN SAHKAR SAMITI
LIMITED), JAIPUR RAJASHTAN

NORTH

HIVE
DESIGNER STUDIO
Architecture | Planning | Interiors

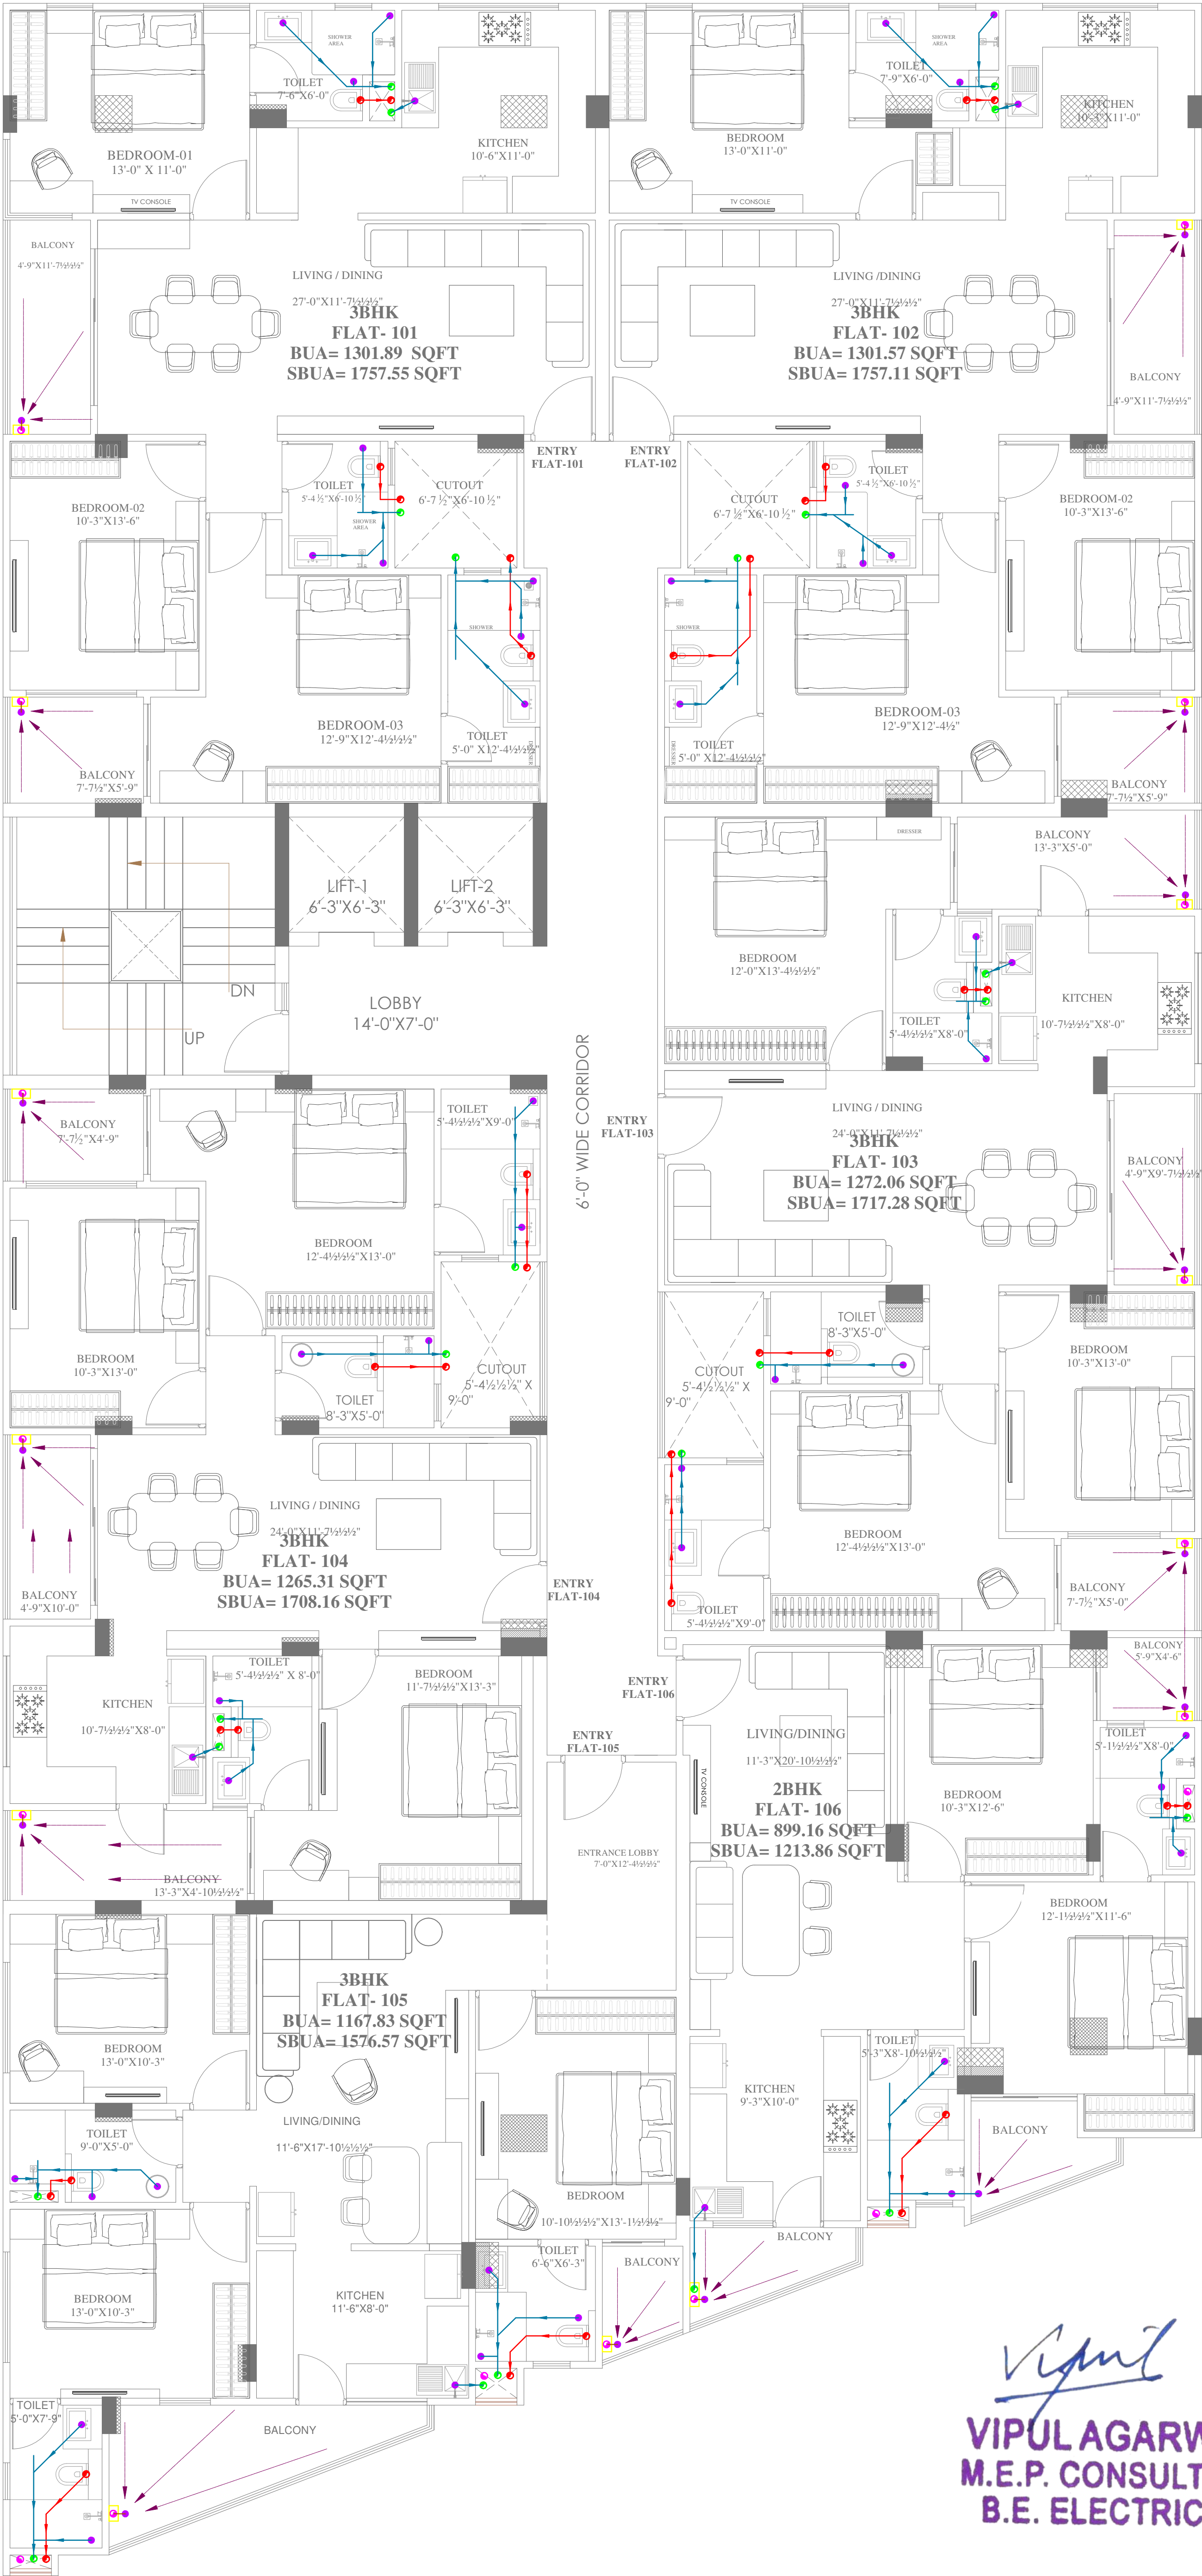

SYMBOL	DESCRIPTION
	110 mm Soil Waste Water Pipe
	110 mm Waste Water Pipe
	110 mm Rain Water Pipe
	110 mm Soil Waste Water Pipe
	110 mm Waste Water Pipe
	110 mm Rain Water Pipe
	75 mm Waste Water Pipe
	75 mm Rain Water Pipe
	50mm Waste Water Pipe Bottle Trap
	Floor Trap
	Flow Direction
	6" Platform Raise
SERVICES CONSULTANT: ASHI ASSOCIATES F 9 / 440 , Keshav Marg Chitrakut Scheme,Jaipur PH:91-0-93146-10438 ,0141-2440946 Mail:vipul8599@yahoo.com	
DRN BY- NITIN	CKD BY- SANJAY
	SCALE-
APPD. BY:-	VIPUL AGARWAL
DRAWING:	TYPICAL FLOOR DRAINAGE LAYOUT PLAN

PROJECT NAME :

PARK VIEW APARTMENTS
BY SONI'S

DEVELOPER NAME :

NEHAL
MAHESHWARI


PROJECT ADDRESS :

PLOT NO. 77& 78, VISHVASHRIYA NAGAR VISTAR
(APOLLO NAGAR - GRAH NIRMAN SAHKAR SAMITI LIMITED), JAIPUR RAJASHTAN



NORTH



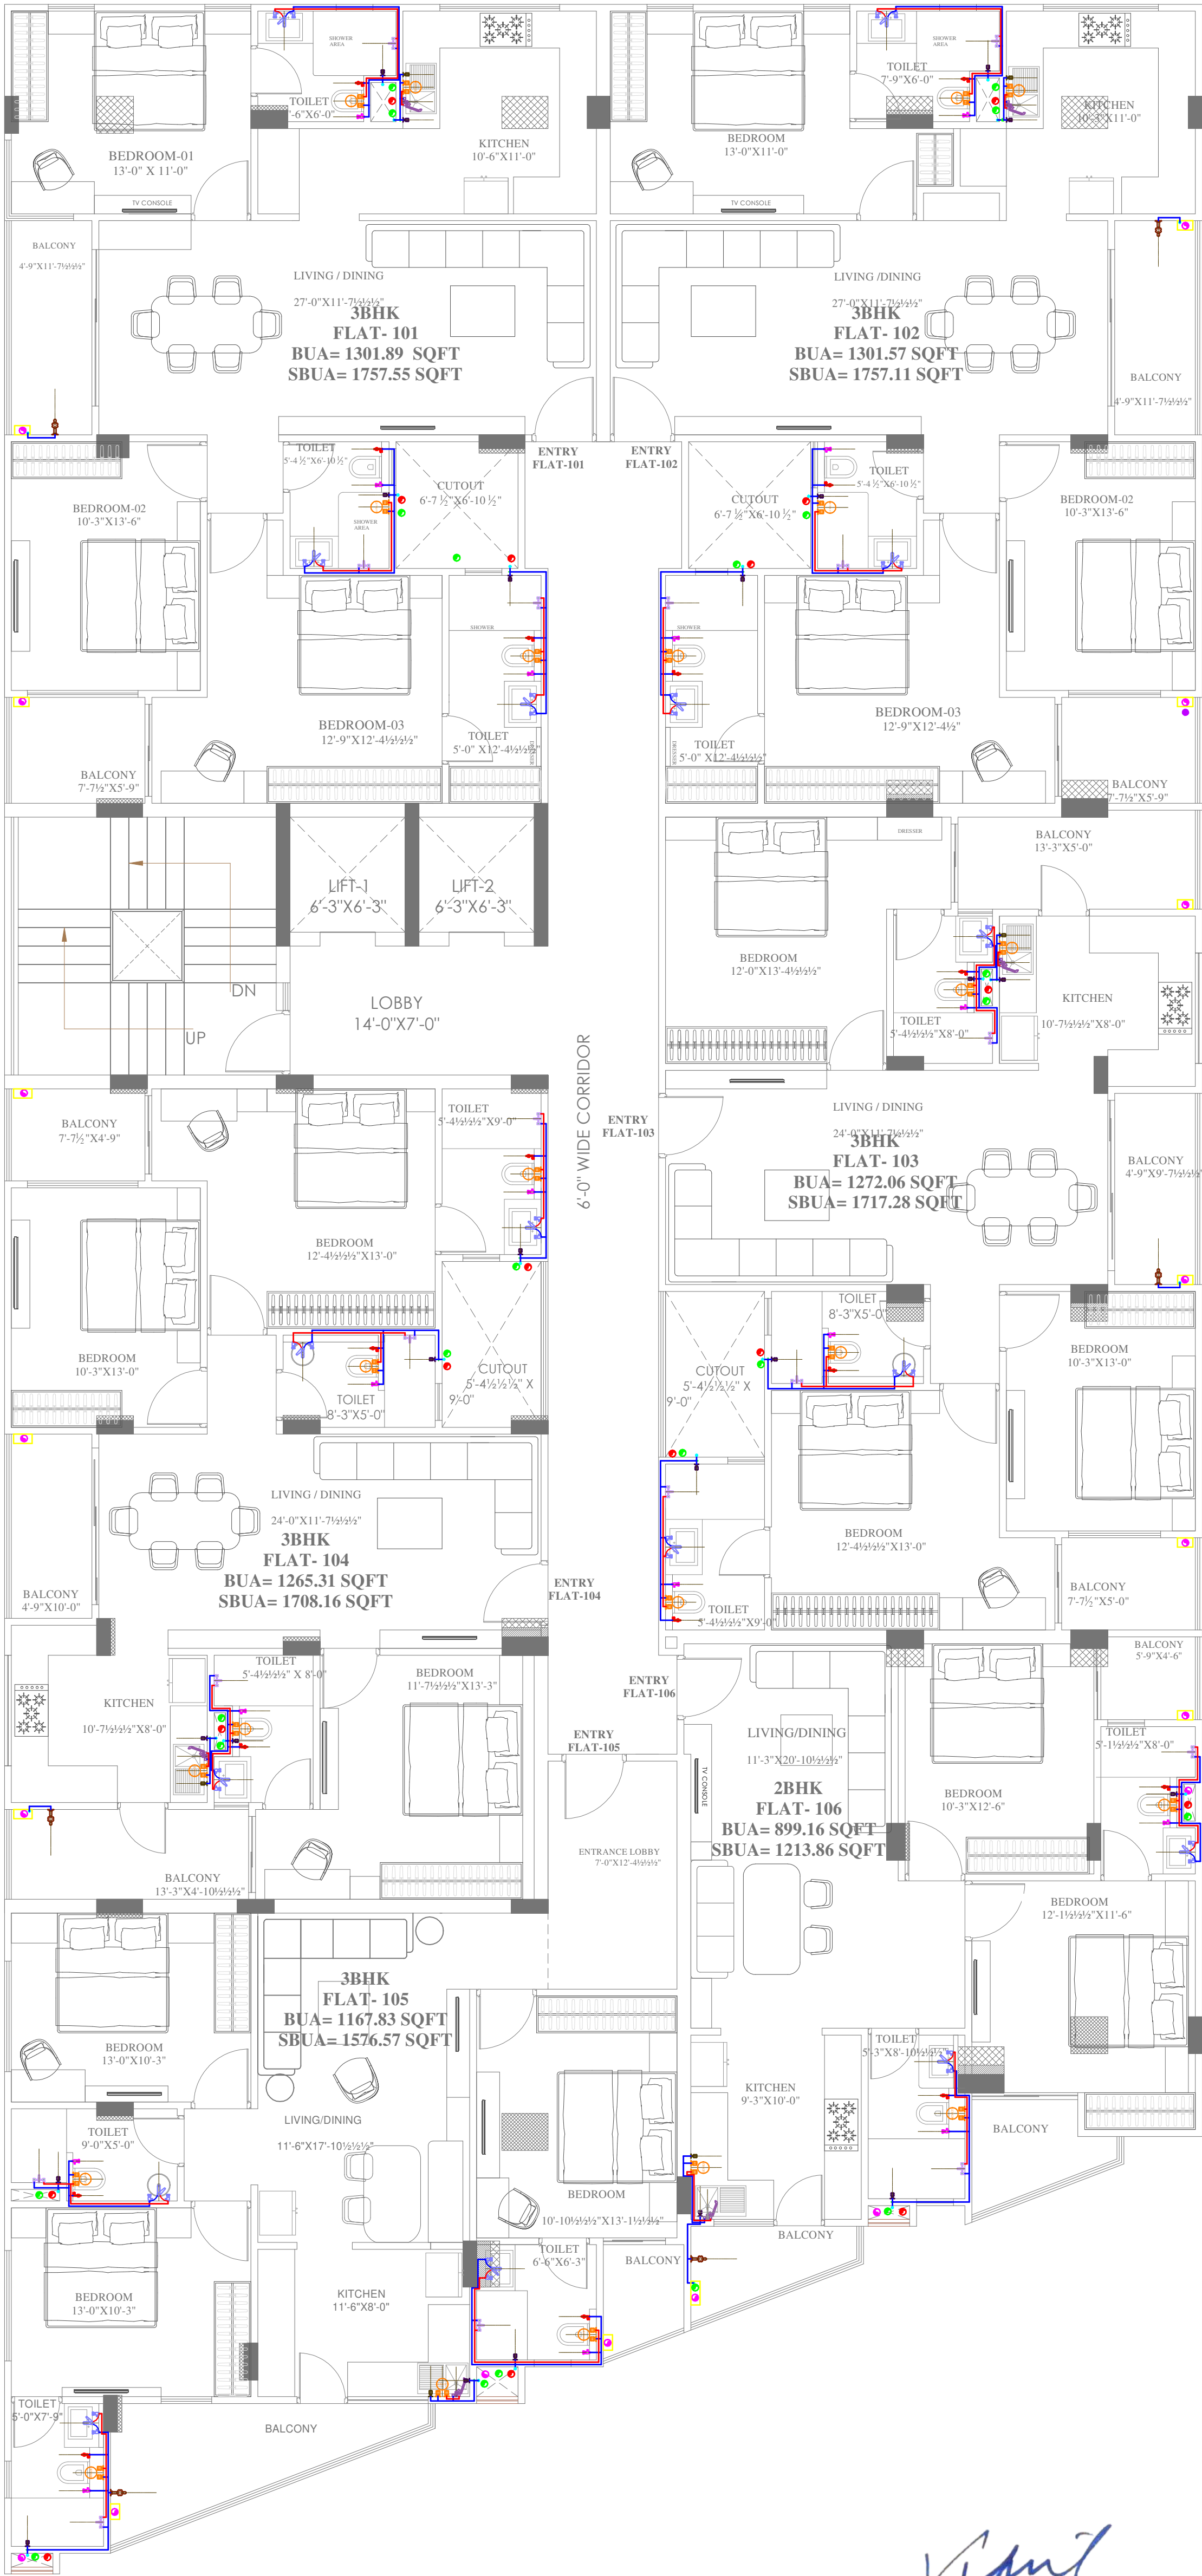

Vipul
VIPUL AGARWAL
M.E.P. CONSULTANT
B.E. ELECTRICAL

All Heights For Finish Floor Lvl	SYMBOL	SYMBOL	DESCRIPTION
+1000MM			Ø 20MM CWS PIPE THRU WALL CHASE TO SINK
			Ø 20MM CWS PIPE THRU WALL CHASE TO GEYSER
+1950MM			Ø 20MM CWS PIPE THRU WALL CHASE TO AQUAGUARD
+1500MM			Ø 20MM CWS PIPE THRU WALL CHASE TO BASIN ANGLE VALVE
+450MM			Ø 20MM CWS PIPE THRU WALL CHASE TO CONCEALED STOP COCK
+800MM			Ø 20MM CWS PIPE THRU WALL CHASE TO FAUCET
+2100MM			Ø 20MM CWS PIPE THRU WALL CHASE TO CISTERN ANGLE VALVE
+300MM			Ø 20MM CWS PIPE THRU WALL CHASE TO MIXER / DIVERTOR
+450MM			Ø 20MM CWS PIPE THRU WALL CHASE TO TAP
+1800MM WALL MIXER DIVERTOR			Ø 20MM CWS PIPE THRU WALL CHASE TO WALL MIXER / DIVERTOR
+2025MM O.H.SHOWER			Ø 20MM HWS PIPE THRU WALL CHASE TO WALL MIXER / DIVERTOR
+600MM			Ø 20MM CWS PIPE THRU WALL CHASE TO CISTERN ANGLE VALVE
+450MM			Ø 20MM CWS PIPE THRU WALL CHASE TO CISTERN ANGLE VALVE
			Floor Trap
+950MM	AS PER/ARCH.		MIRROR 450X450mm(BOTTOM)
+1000MM	AS PER/ARCH.		SOAP DISH
+1500MM	AS PER/ARCH.		TOWEL RAIL
+450MM	AS PER/ARCH.		PAPER HOLDER
			COLD WATER SUPPLY LINE
			HOT WATER SUPPLY LINE

SERVICES CONSULTANT: ASHI ASSOCIATES F 9 / 440 , Keshav Marg Chitrakut Scheme,Jaipur PH:91-0-93146-10438 ,0141-2440946 Mail:vipul8599@yahoo.com		
DRN BY- NITIN	CKD BY- SANJAY	
	SCALE-	
APPD. BY:- VIPUL AGARWAL		
DRAWING:	TYPICAL FLOOR PLUMBING & WATER SUPPLY LAYOUT PLAN	

PROJECT NAME :
PARK VIEW APARTMENTS
BY SONI'S

PROMOTERS NAME :
NEHAL
MAHESHWARI


PROJECT ADDRESS :
PLOT NO. 77& 78, VISHVASHRIYA NAGAR VISTAR
(APOLLO NAGAR - GRAH NIRMAN SAHKAR SAMITI
LIMITED), JAIPUR RAJASHTAN

NORTH

HI VE
DESIGNER STUDIO
Architecture | Planning | Interiors



	N.T.S.
--	--------

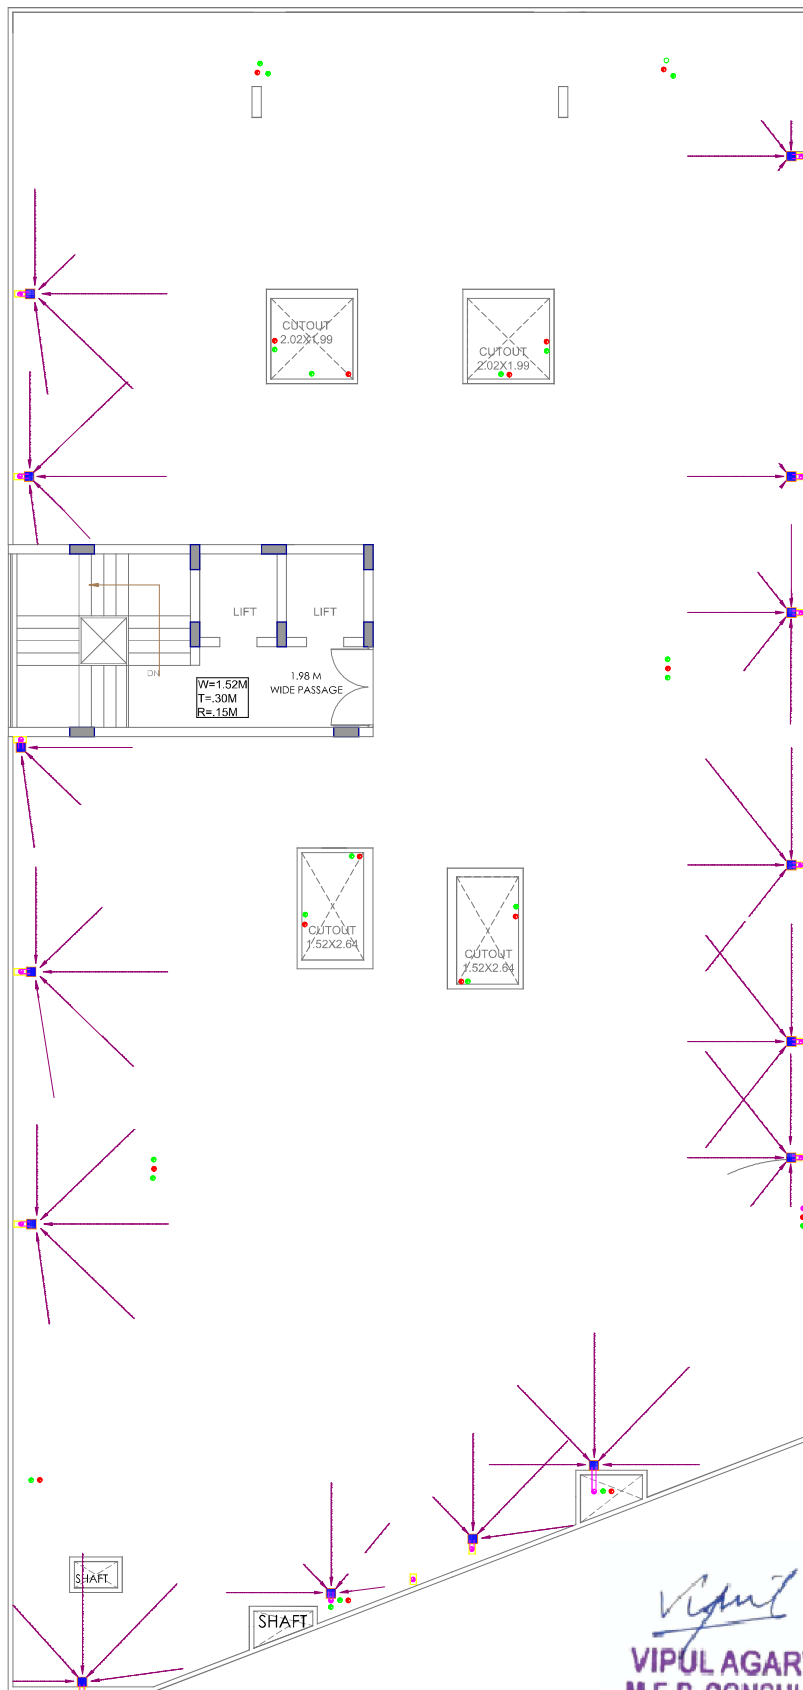

SYMBOL	DESCRIPTION
	110 mm Soil Waste Water Pipe
	110 mm Waste Water Pipe
	110 mm Rain Water Pipe
	110 mm Soil Waste Water Pipe
	110 mm Waste Water Pipe
	110 mm Rain Water Pipe
	KHURRA 9'X9'
	Flow Direction
SERVICES CONSULTANT: ASHI ASSOCIATES F 9 / 440 , Keshav Marg Chitrakut Scheme,Jaipur PH:91-0-93146-10438 ,0141-2440946 Mail:vipul8599@yahoo.com	
DRN BY- NITIN	CKD BY- SANJAY
	SCALE-
APPD. BY:- VIPUL AGARWAL	
DRAWING:	TERRACE FLOOR RAIN WATER SLOPE PLAN

PROJECT NAME :
**PARK VIEW APARTMENTS
BY SONI'S**

PROMOTERS NAME :
NEHAL MAHESHWARI

PROJECT ADDRESS :
**Plot No. 77 & 78, Vishvashriya Nagar Vistar
(Apollo Nagar – Grah Nirman Sahkar Samiti Limited),
Jaipur, Rajasthan**



HI VE
DESIGNER STUDIO
Architecture | Planning | Interiors