

MEP CONSULTANT:
ASHI ASSOCIATES
F 9-440, KESHAV MARG,
CHITRAKUT SCHEME, JAIPUR
PH:93146-10438,2440946
E MAIL:vipul8599@yahoo.com

PROJECT:-
Saket Prestige Homes

DEVELOPER NAME :
SAKET BUILD MART PVT LTD

CLIENT NAME :
Vinay Khandelwal, Ashok Khandelwal

TITLE:-
ALL DISTRIBUTION PANEL


DRAWING:-
SINGLE LINE DIAGRAM

DATE:-
05-09-2024


REV:-
00



VIPUL AGARWAL
M.E.P. CONSULTANT
B.E. ELECTRICAL

MAIN LT PANEL

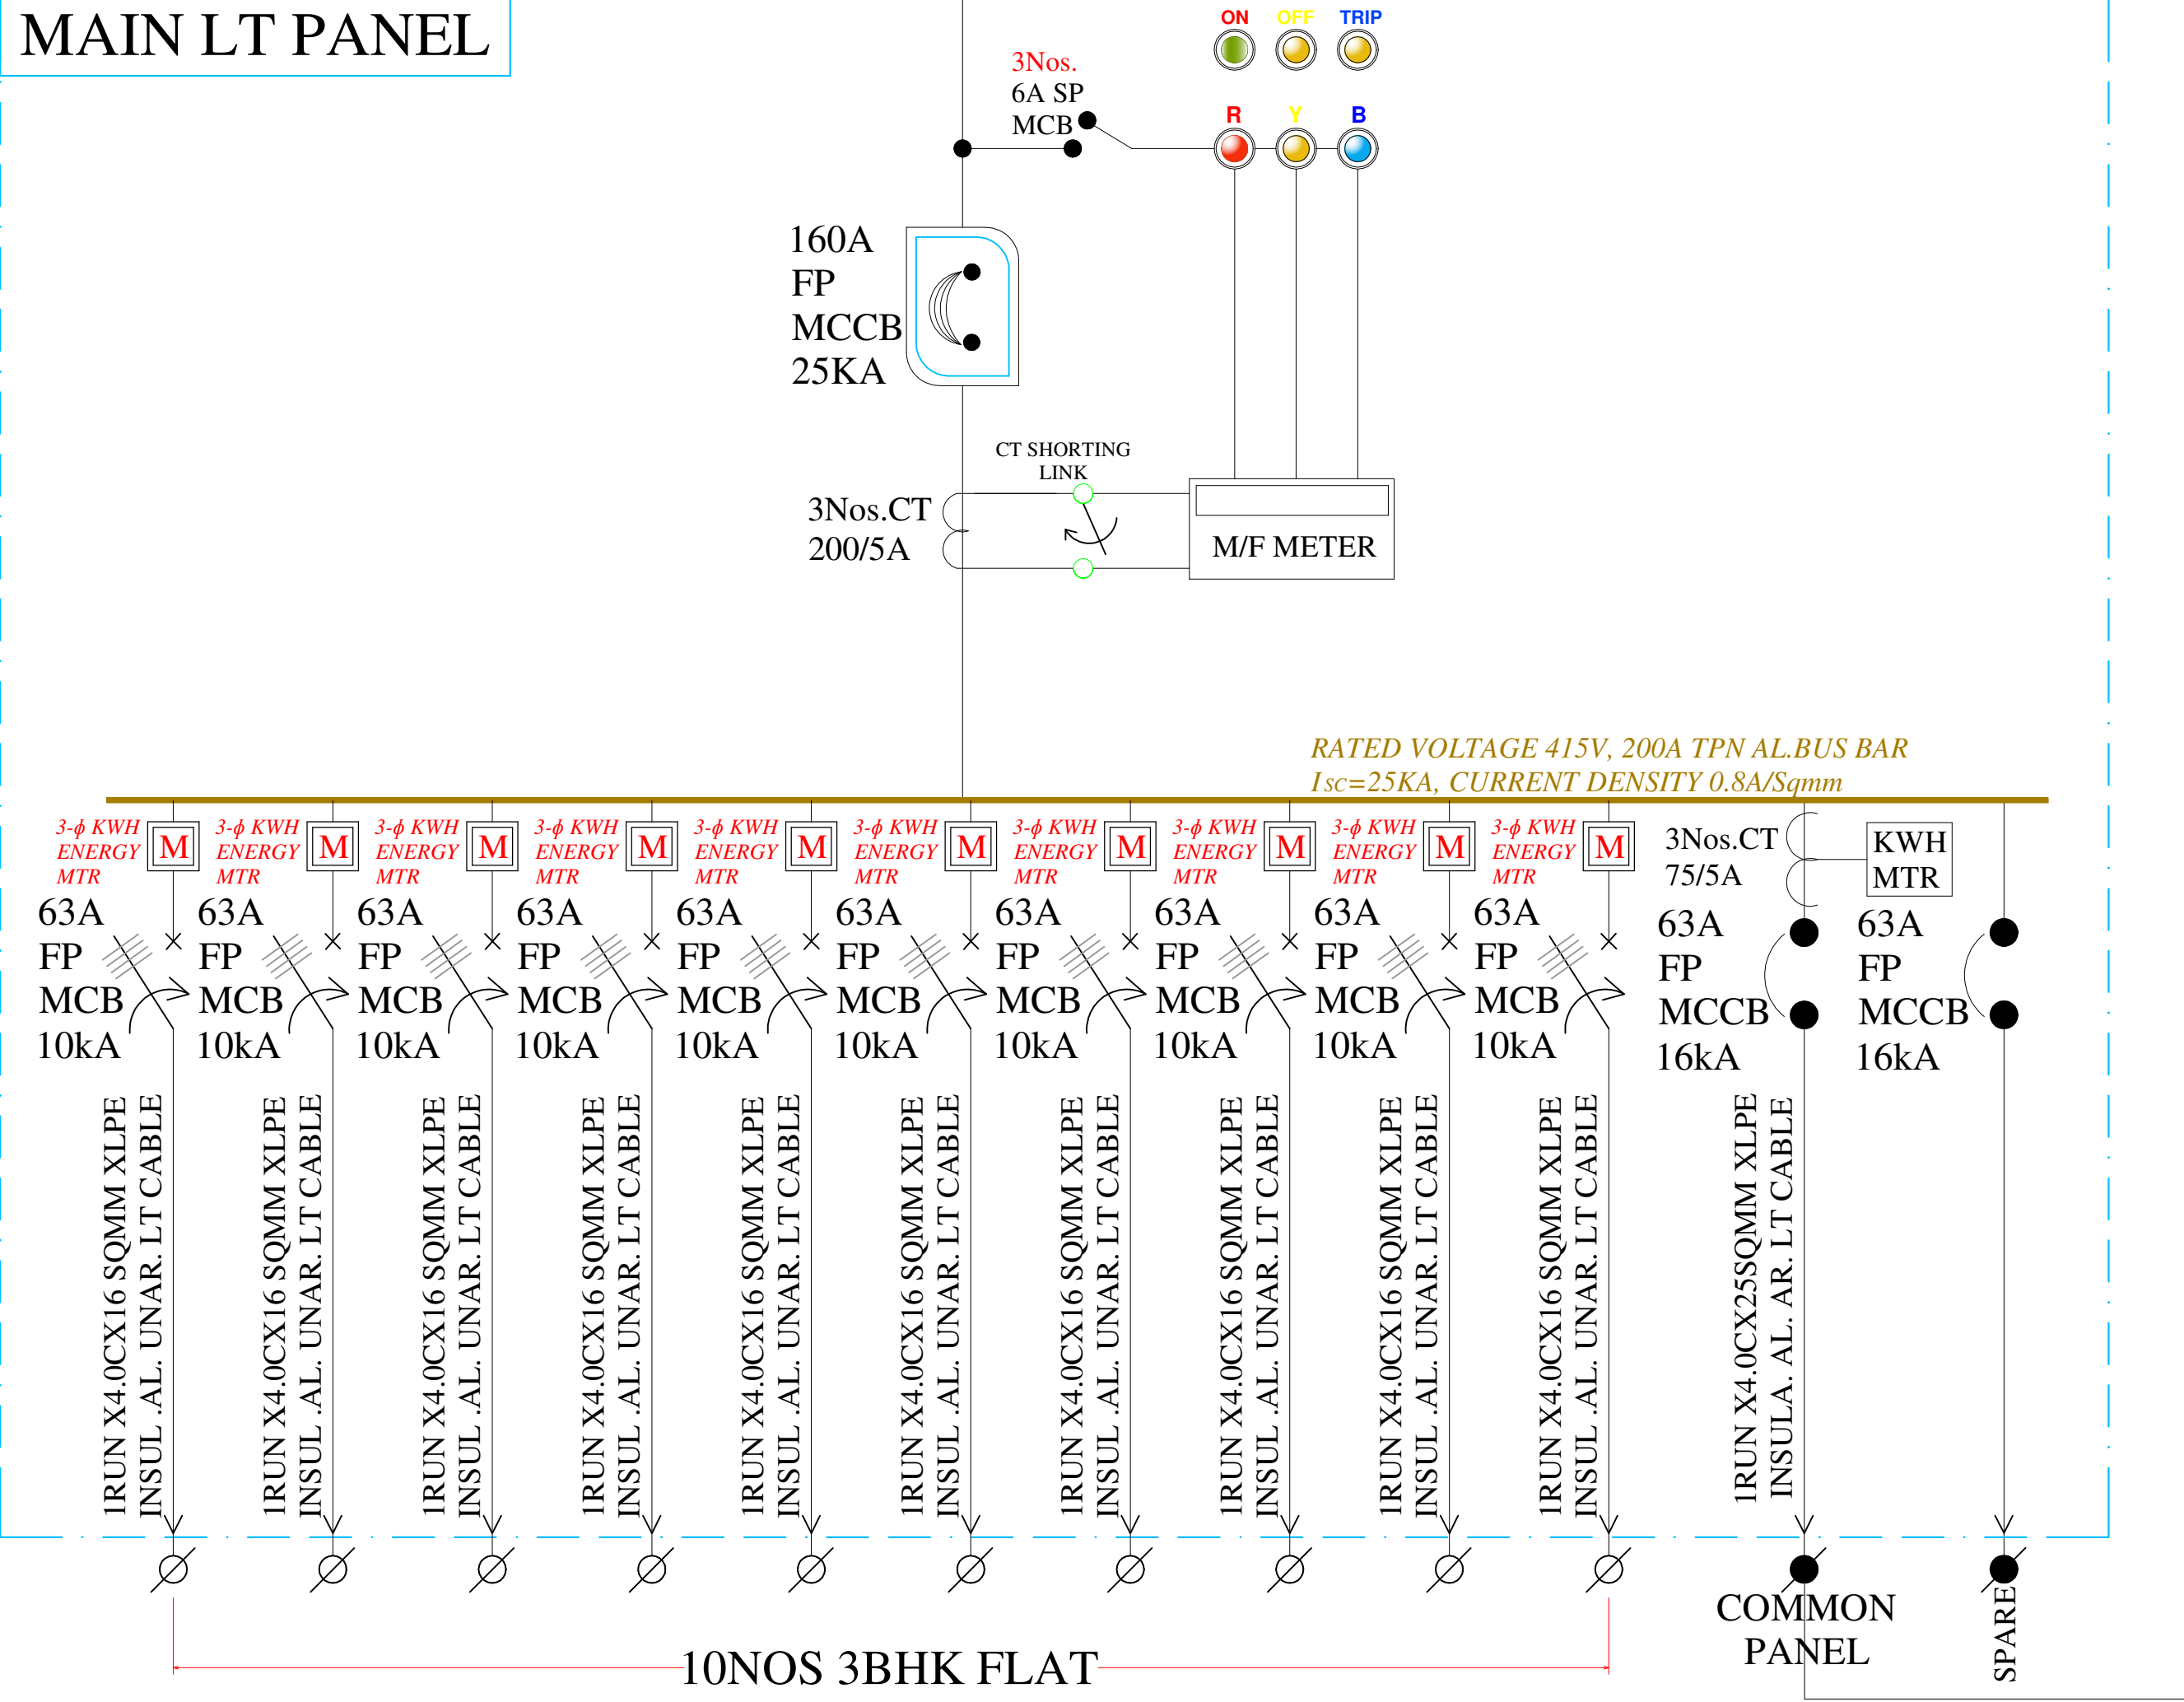

NOTE:-
THIS SLD HAS BEEN PREPARED AS PER CONCEPT STAGE DATA AVAILABLE WITH US. KINDLY CONTACT US FOR FINAL SLD & DETAILS BEFORE PLACING ORDER FOR FABRICATION. WE SHALL NOT BE RESPONSIBLE, IF THE PANELS ARE UNDER UTILISED OR OVER LOADED AT ANY STAGE.

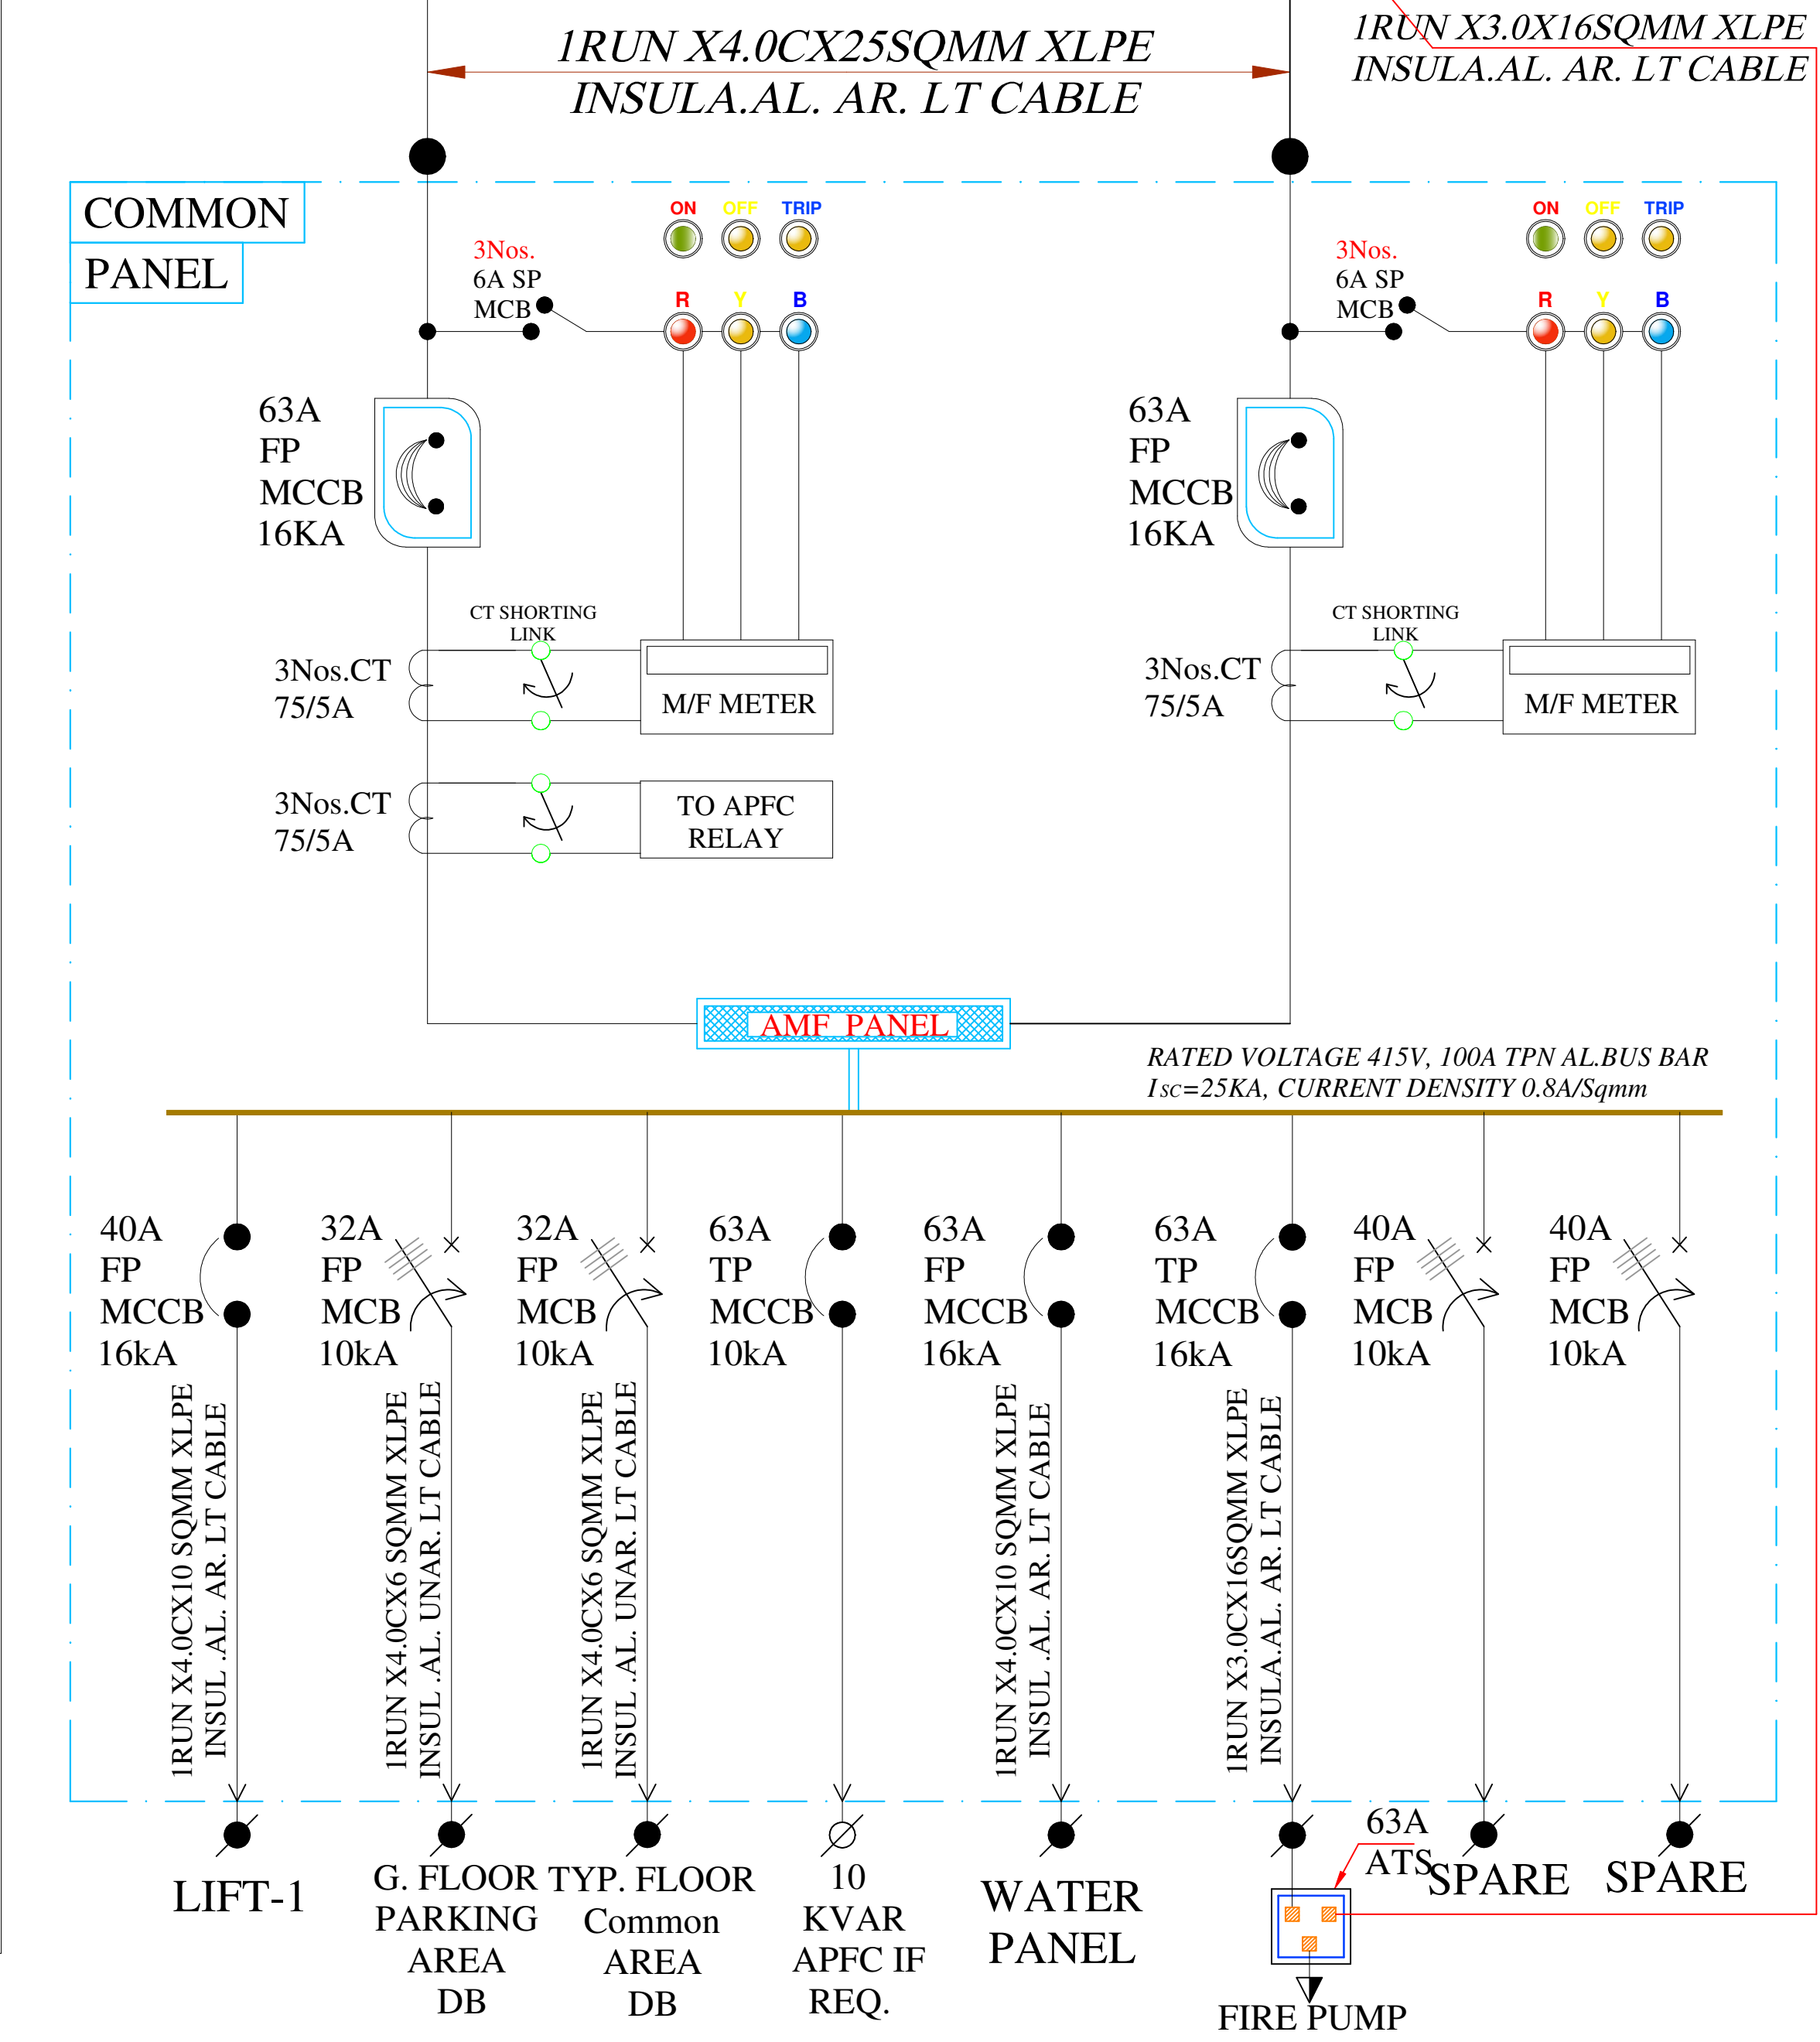

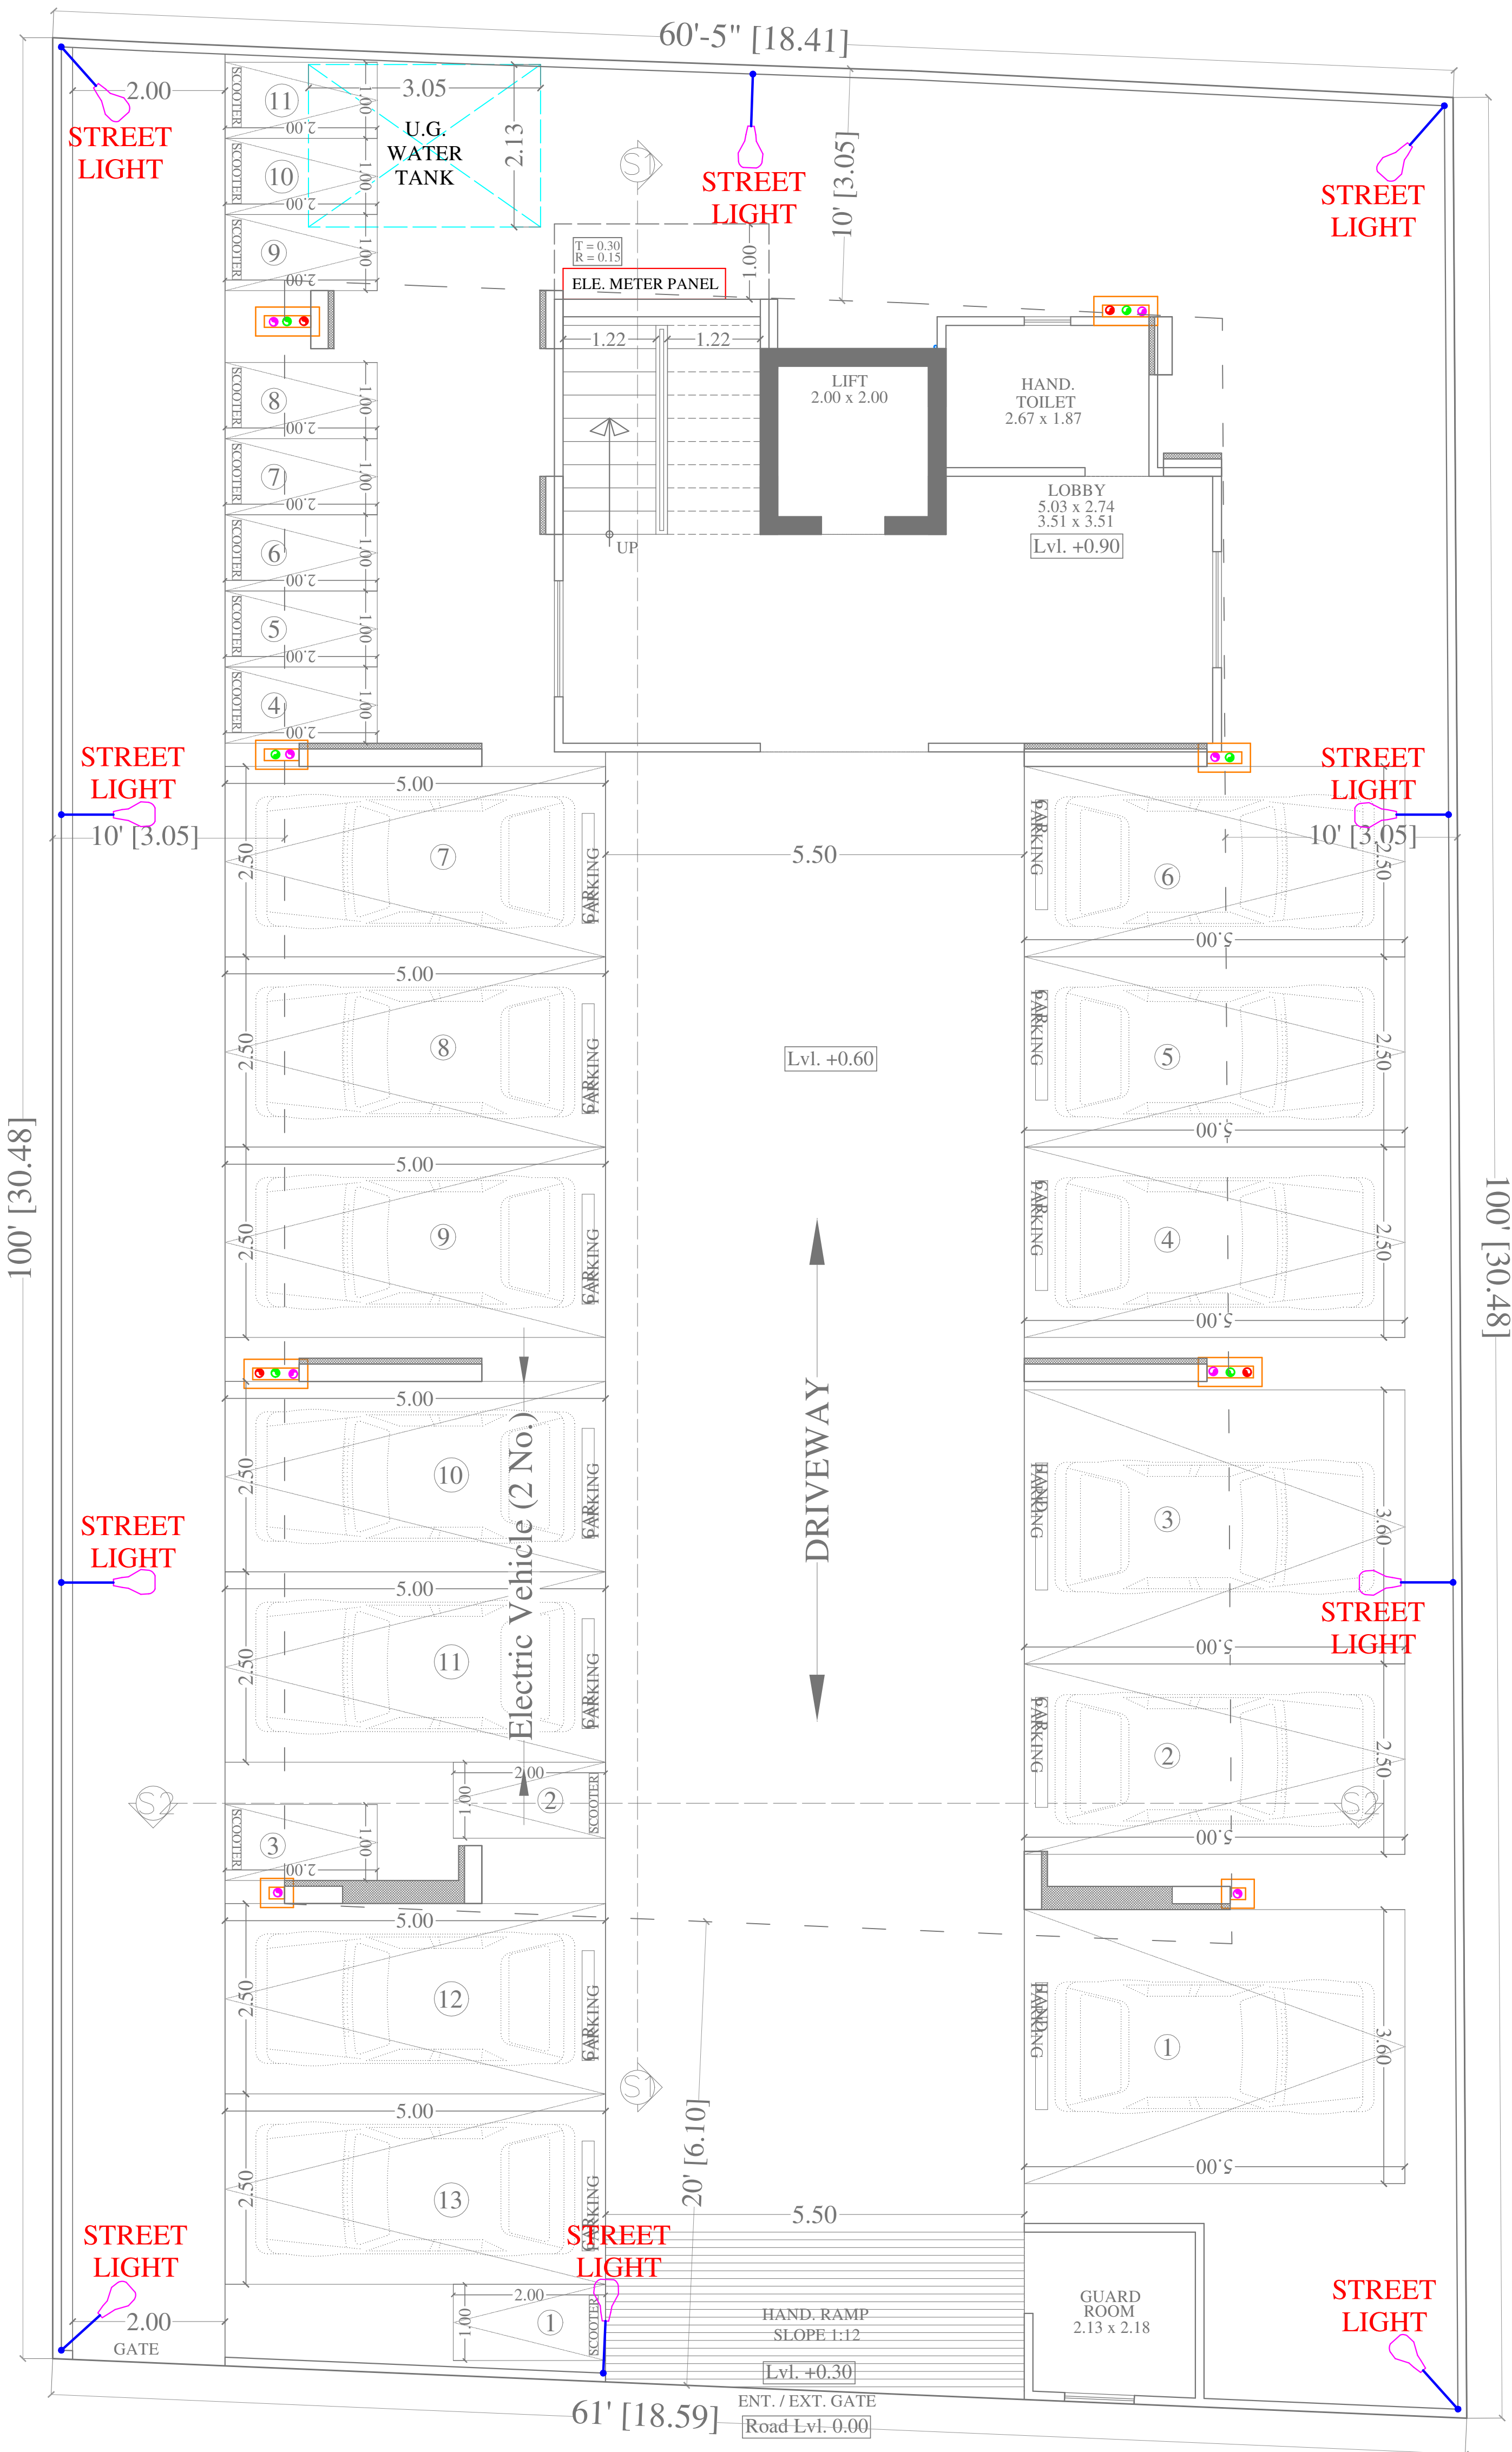

Vipul
VIPUL AGARWAL
M.E.P. CONSULTANT
B.E. ELECTRICAL

NOTE:- ALL EXTERNAL STREET LIGHT
CONTROL BY EXTERNAL LIGHTING DB

LEGENDS:

Qty.	I D	Symbol	Description
10	PL		STREET LIGHT

SERVICE CONSULTANT

ASHI ASSOCIATES
F 9 / 440 , Keshav Marg Chitrakut Scheme,Jaipur
PH:91-0-93146-10438 ,0141-2440946, Mail:vipul8599@yahoo.com

DRG. TITLE:-
STILT FLOOR EXTERNAL
LIGHTING PLAN

OWNER

Vinay Khandelwal,
Ashok Khandelwal

SCALE = 1:100

PROJECT :-
Saket Prestige Homes

DEVELOPER NAME :
SAKET BUILD MART PVT LTD

PROJECT ADDRESS :-
PROPOSED RESIDENTIAL BUILDING
SUBSIVION AT PLOT NO. 29-30
(NORTH PART) LIONS LANE, JAIPUR

ARCHITECT :-
SPACE GRID
C-49,VIDYA
APARTMENT,PARAS MARG,
BAPU NAGAR,NEAR JANTA
STORE CIRCLE, JAIPUR-302015
PH-09314918766,0141-4005506 (O)
Email:-info.spacegrid@gmail.com