

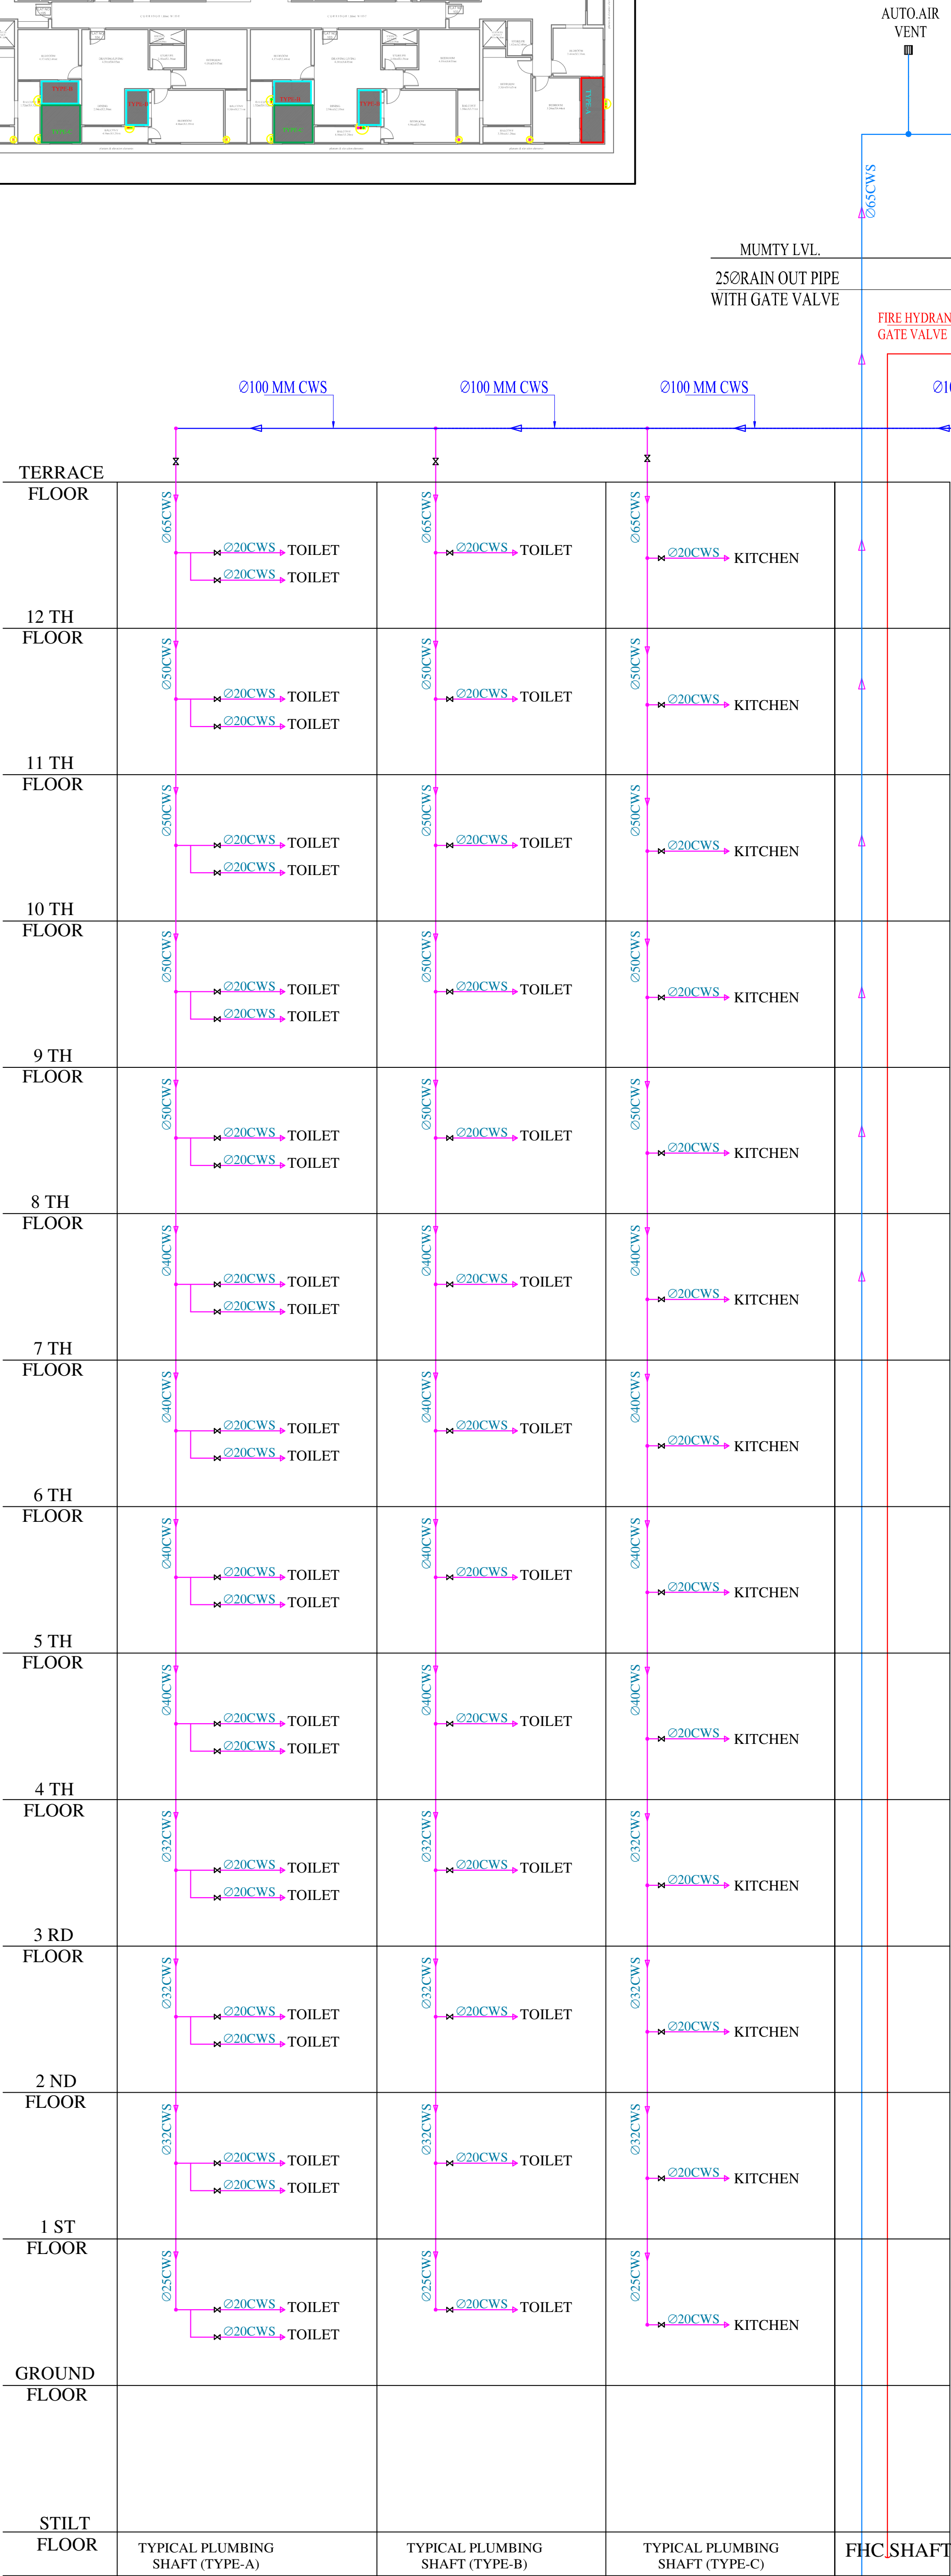


KEY PLAN

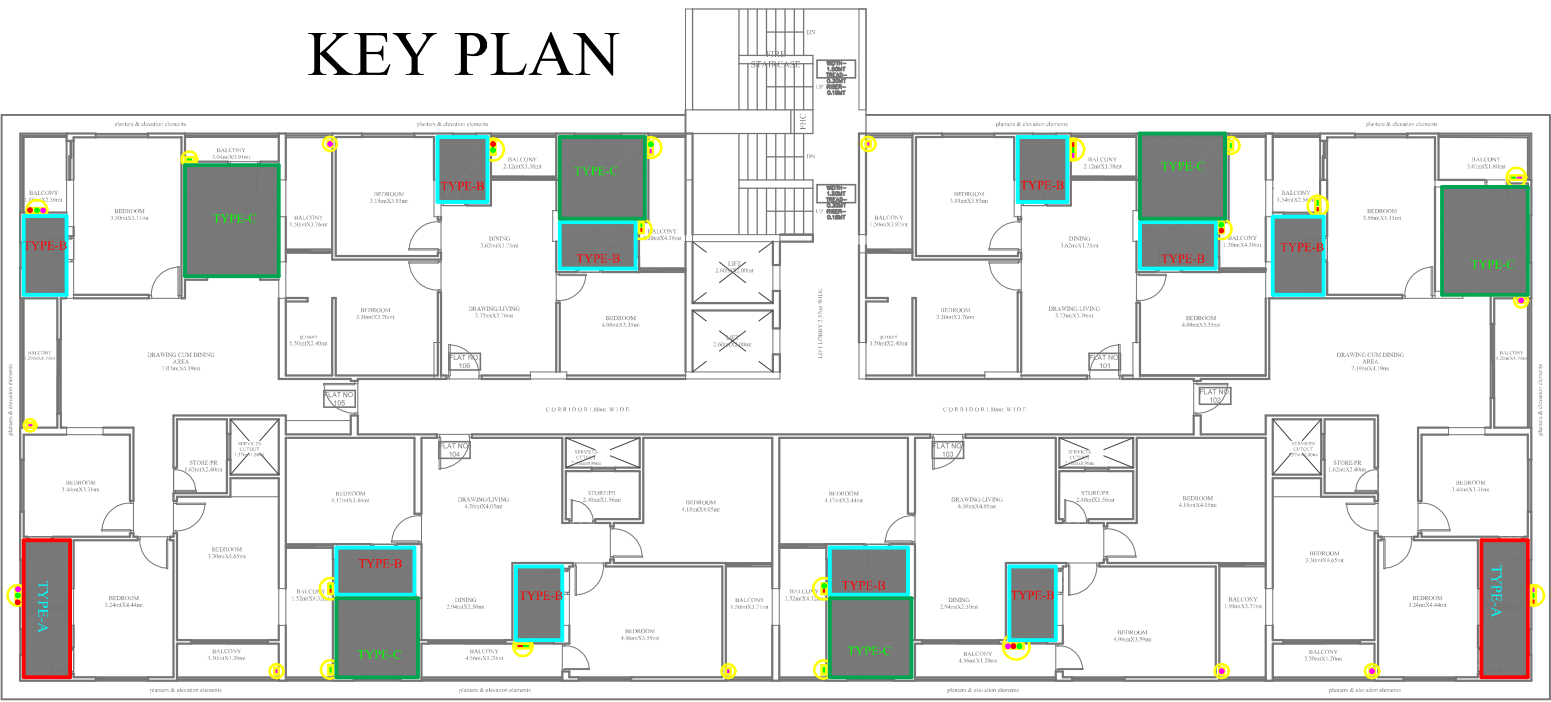

AUTO.AIR
VENT

FLOAT SWITCH-2 AT 10% TANK FULL
FLOAT SWITCH-1 AT 100% TANK FULL

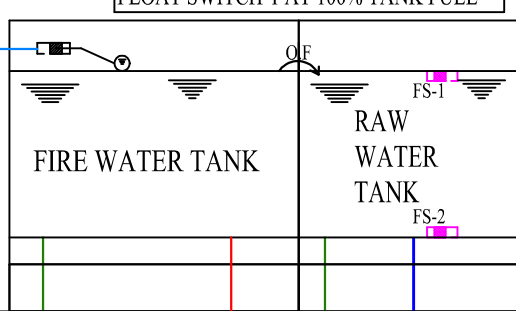

MUMTY LVL.
250RAIN OUT PIPE
WITH GATE VALVE

FIRE HYDRANT PIPE WITH
GATE VALVE DROP TO FHC

1000 GRAVITY COLD
WATER SUPPLY RING PIPE
WITH GATE VALVE

Vipul
VIPUL AGARWAL
M.E.P. CONSULTANT
B.E. ELECTRICAL

SERVICES CONSULTANT:
ASHI ASSOCIATES
F 9 / 440 , Keshav Marg
Chitrakut Scheme,Jaipur
PH:91-0-93146-10438 ,0141-2440946
Mail:vipul8599@yahoo.com

ARCHITECTS: –
KAPPRIS INNOVATION
VAISHALI NAGAR, JAIPUR
Phone No: 0141–4002369
email: –kapprisinnovation@gmail.com

PROJECT:-
**PROPOSED APARTMENT "GOLD
BELLAGIO", CP-6 CORNER,
SWAMI VIVEKANAND NAGAR
SCHEME, KOTA**

DRAWING:
**WATER SUPPLY
SCHEMATIC DIAGRAM**




All Heights For Finish Floor Lvl	SYMBOL	SYMBOL	DESCRIPTION
+1000MM			Ø 20MM CWS PIPE THRU WALL CHASE TO SINK
+1950MM			Ø 20MM CWS PIPE THRU WALL CHASE TO SINK
+1500MM			Ø 20MM CWS PIPE THRU WALL CHASE TO SINK
+450MM			Ø 20MM CWS PIPE THRU WALL CHASE TO SINK
+800MM			Ø 20MM CWS PIPE THRU WALL CHASE TO SINK
+2100MM			Ø 20MM CWS PIPE THRU WALL CHASE TO SINK
+300MM			Ø 20MM CWS PIPE THRU WALL CHASE TO SINK
+1000MM			Ø 20MM CWS PIPE THRU WALL CHASE TO SINK
+1500MM			Ø 20MM CWS PIPE THRU WALL CHASE TO SINK
+450MM			Ø 20MM CWS PIPE THRU WALL CHASE TO SINK
+1200MM			Ø 20MM CWS PIPE THRU WALL CHASE TO SINK
+450MM			Ø 20MM CWS PIPE THRU WALL CHASE TO SINK
+1000MM	AS PER ARCHT.		SOAP DISH
+1500MM	AS PER ARCHT.		TOWEL RAIL
+450MM	AS PER ARCHT.		PAPER HOLDER
			COLD WATER SUPPLY LINE
			HOT WATER SUPPLY LINE

SERVICES CONSULTANT:
ASHI ASSOCIATES
F 9 / 440 , Keshav Marg Chitrakut
Scheme,Jaipur
PH:91-0-93146-10438 ,0141-2440946
Mail:vipul8599@yahoo.com


ARCHITECTS:-
KAPPRIS INNOVATION
VAISHALI NAGAR, JAIPUR
Phone No: 0141-4002369
email:-kapprisinnovation@gmail.com

PROJECT:-
PROPOSED APARTMENT "GOLD
BELLAGIO", CP-6 CORNER,
SWAMI VIVEKANAND NAGAR
SCHEME, KOTA


DRAWING:
GROUND, FIRST, FOURTH, SEVENTH,
TENTH, FLOOR PLUMBING PLAN

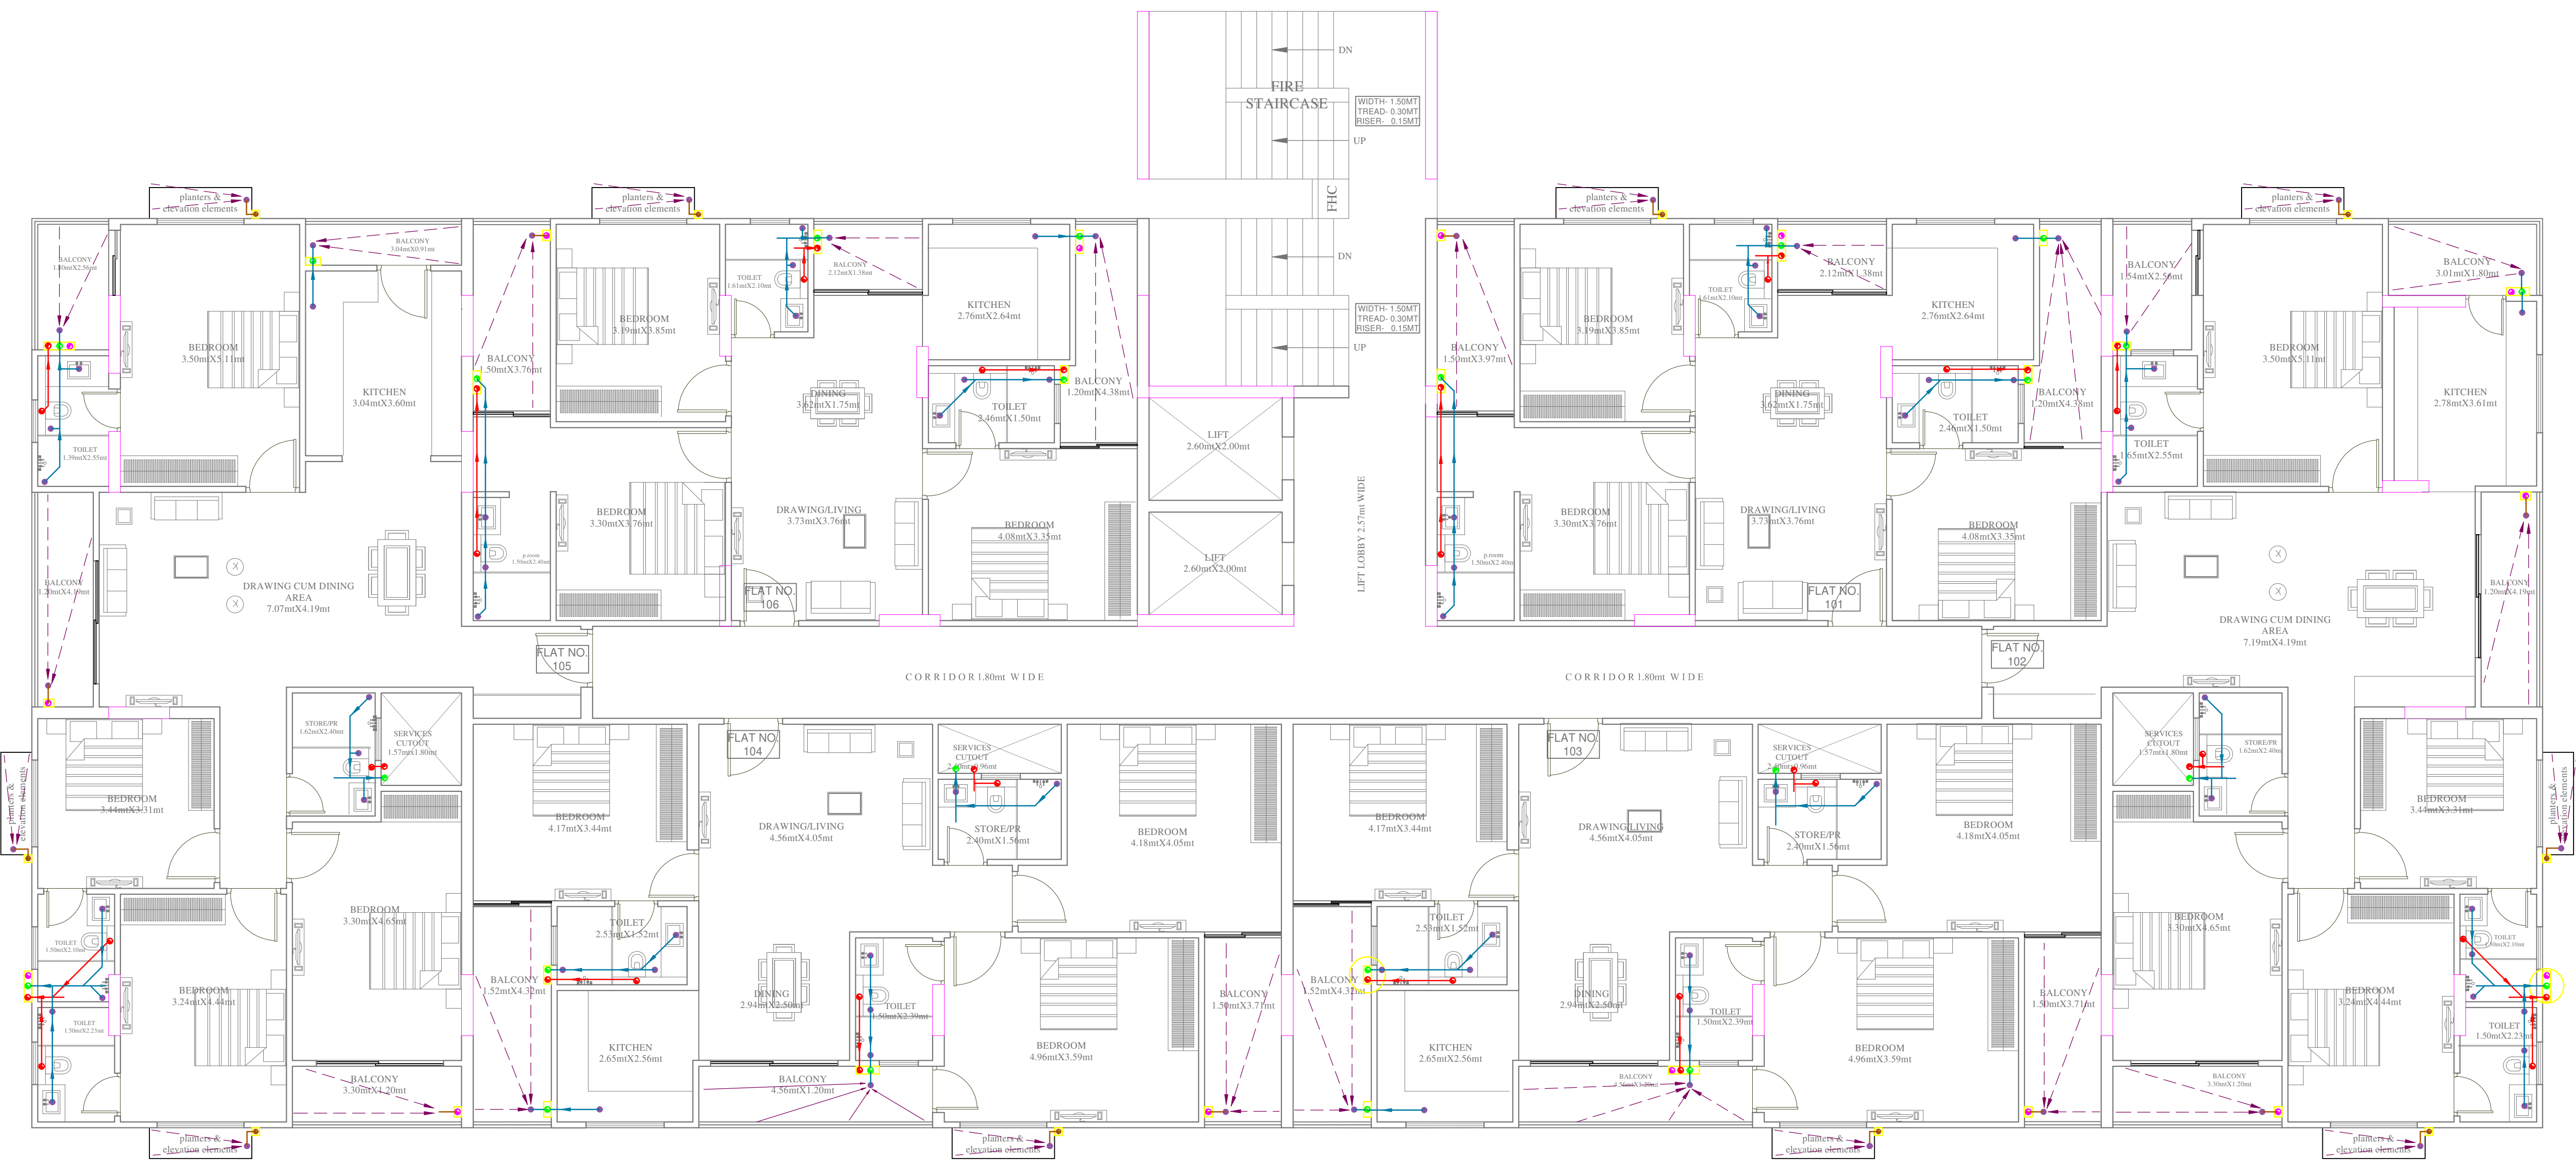

SYMBOL	DESCRIPTION
	110 mm Soil Waste Water Pipe
	110 mm Waste Water Pipe
	110 mm Rain Water Pipe
	75 mm Rain Water Pipe
	110 mm Soil Waste Water Pipe
	110 mm Waste Water Pipe
	110 mm Rain Water Pipe
	75 mm Rain Water Pipe
	75 mm Waste Water Pipe Internal
	40mm Waste Water Pipe Bottle Trap
	FLOOR TRAP
SERVICES CONSULTANT: ASHI ASSOCIATES F 9 / 440 , Keshav Marg Chitrakut Scheme,Jaipur PH:91-0-93146-10438 ,0141-2440946 Mail:vipul8599@yahoo.com	
 VIPUL AGARWAL M.E.P. CONSULTANT B.E. ELECTRICAL	
ARCHITECTS:- KAPPRIS INNOVATION VAISHALI NAGAR, JAIPUR Phone No: 0141-4002369 email:-kapprisinnovation@gmail.com	
PROJECT:- PROPOSED APARTMENT "GOLD BELLAGIO", CP-6 CORNER, SWAMI VIVEKANAND NAGAR SCHEME, KOTA	
DRAWING: SECOND, THIRD, FIFTH, SIXTH, EIGHT, NINTH, ELEVENTH, TWELFTH FLOOR DRAINAGE PLAN	

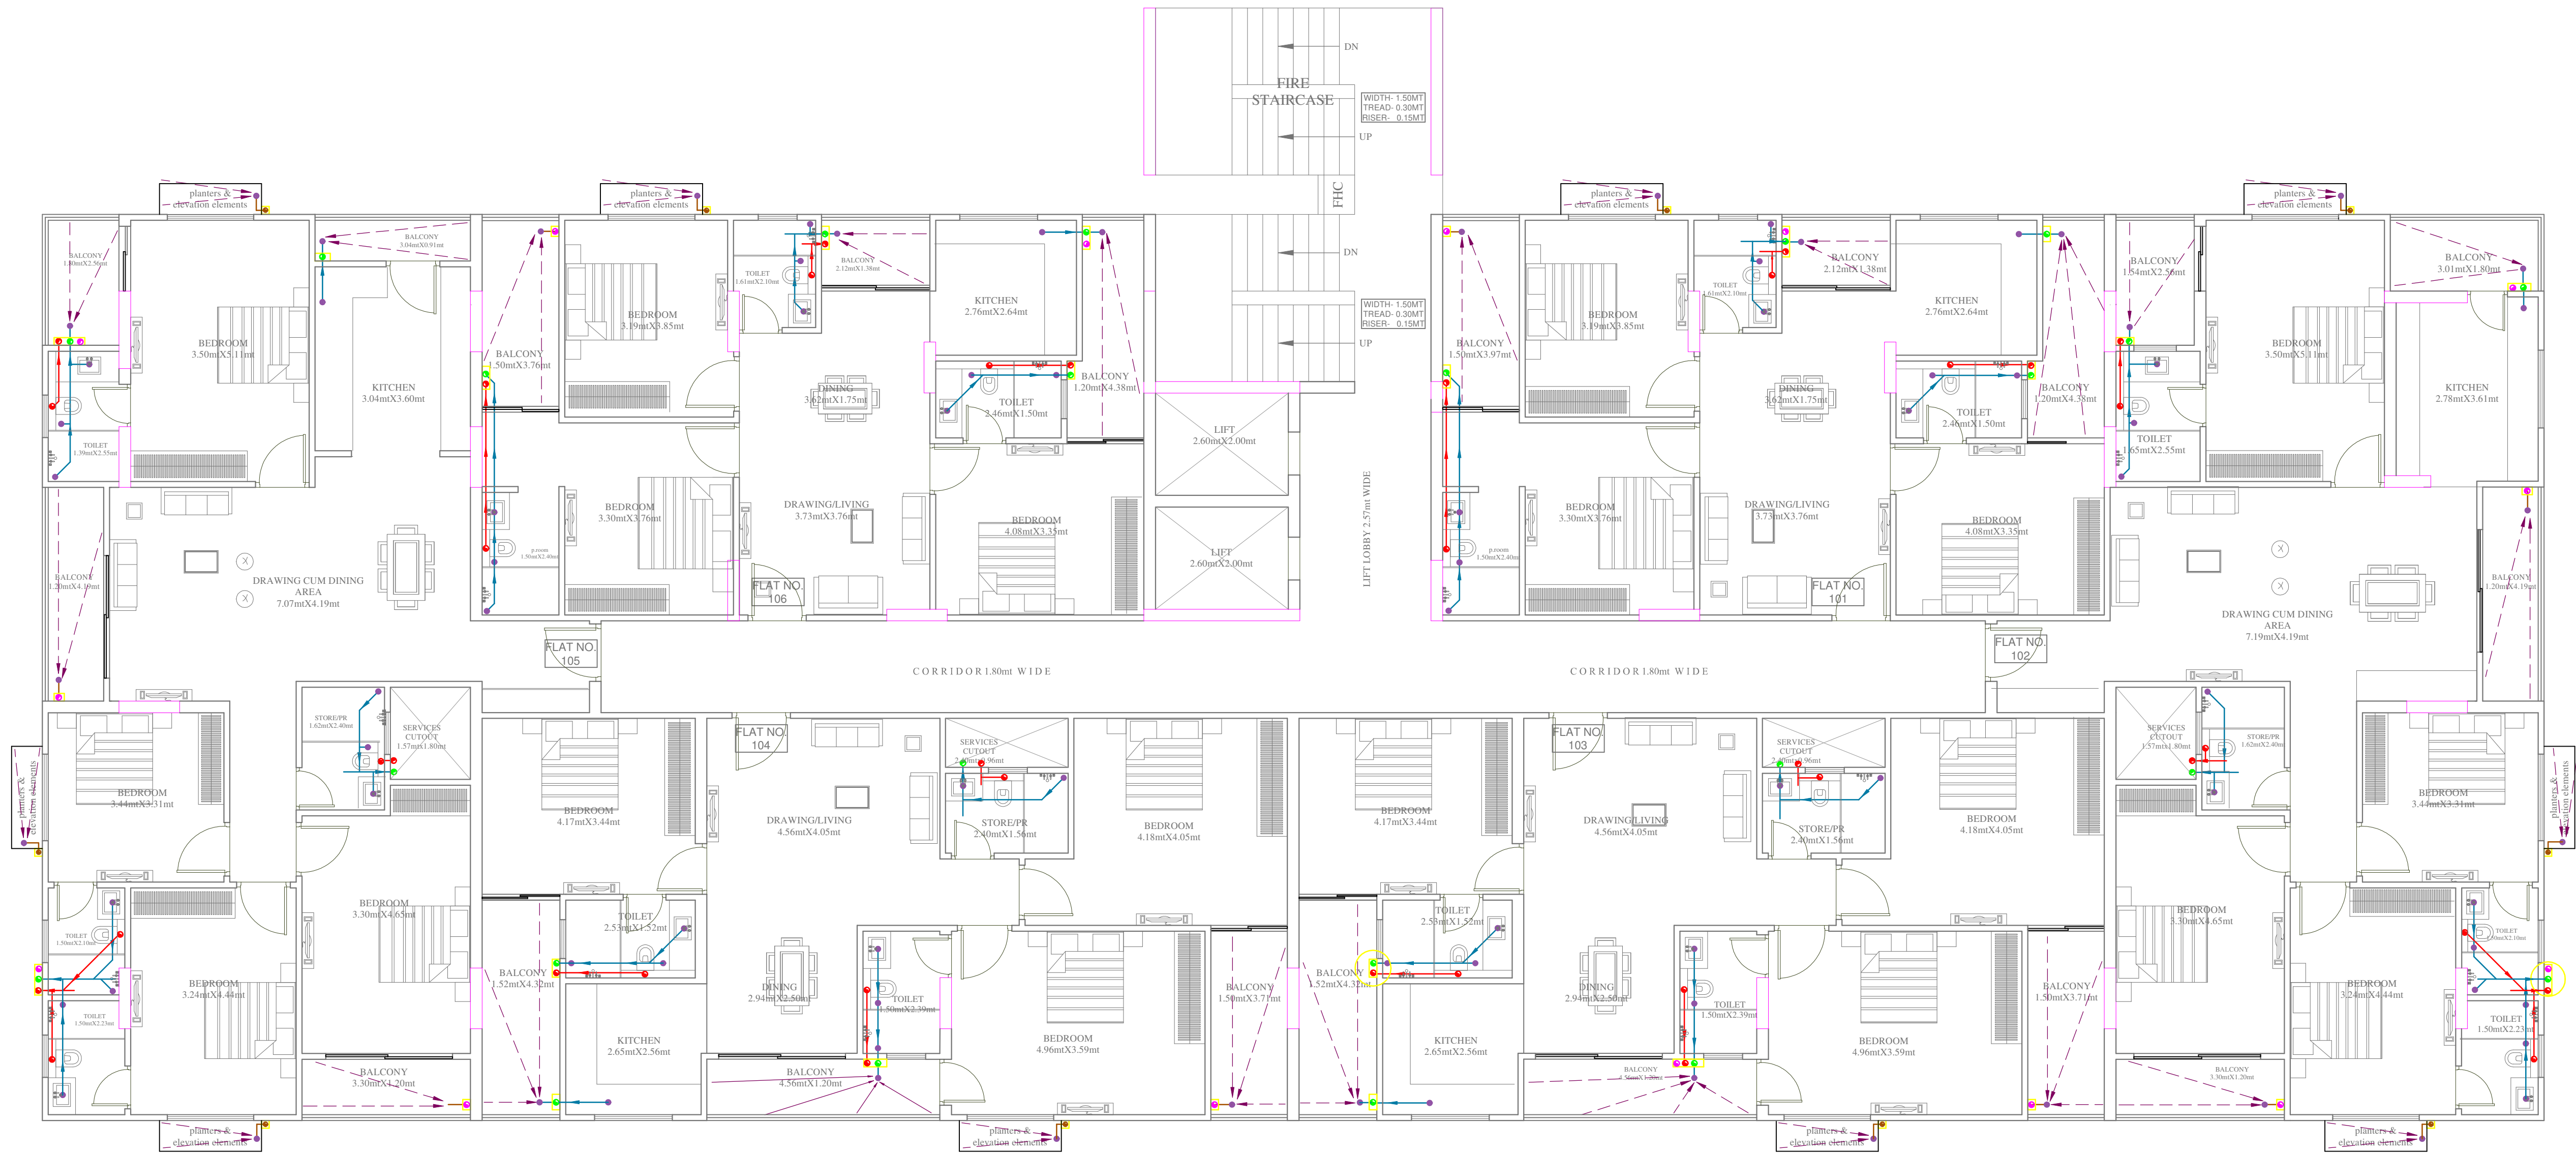

SYMBOL	DESCRIPTION
	110 mm Soil Waste Water Pipe
	110 mm Waste Water Pipe
	110 mm Rain Water Pipe
	75 mm Rain Water Pipe
	110 mm Soil Waste Water Pipe
	110 mm Waste Water Pipe
	110 mm Rain Water Pipe
	75 mm Rain Water Pipe
	75 mm Waste Water Pipe Internal
	40mm Waste Water Pipe Bottle Trap
	FLOOR TRAP
SERVICES CONSULTANT: ASHI ASSOCIATES F 9 / 440 , Keshav Marg Chitrakut Scheme,Jaipur PH:91-0-93146-10438 ,0141-2440946 Mail:vipul8599@yahoo.com	
 VIPUL AGARWAL M.E.P. CONSULTANT B.E. ELECTRICAL	
ARCHITECTS:- KAPPRIS INNOVATION VAISHALI NAGAR, JAIPUR Phone No: 0141-4002369 email:-kapprisinnovation@gmail.com	
PROJECT:- PROPOSED APARTMENT "GOLD BELLAGIO", CP-6 CORNER, SWAMI VIVEKANAND NAGAR SCHEME, KOTA	
DRAWING: GROUND, FIRST, FOURTH, SEVENTH, TENTH, FLOOR DRAINAGE PLAN	

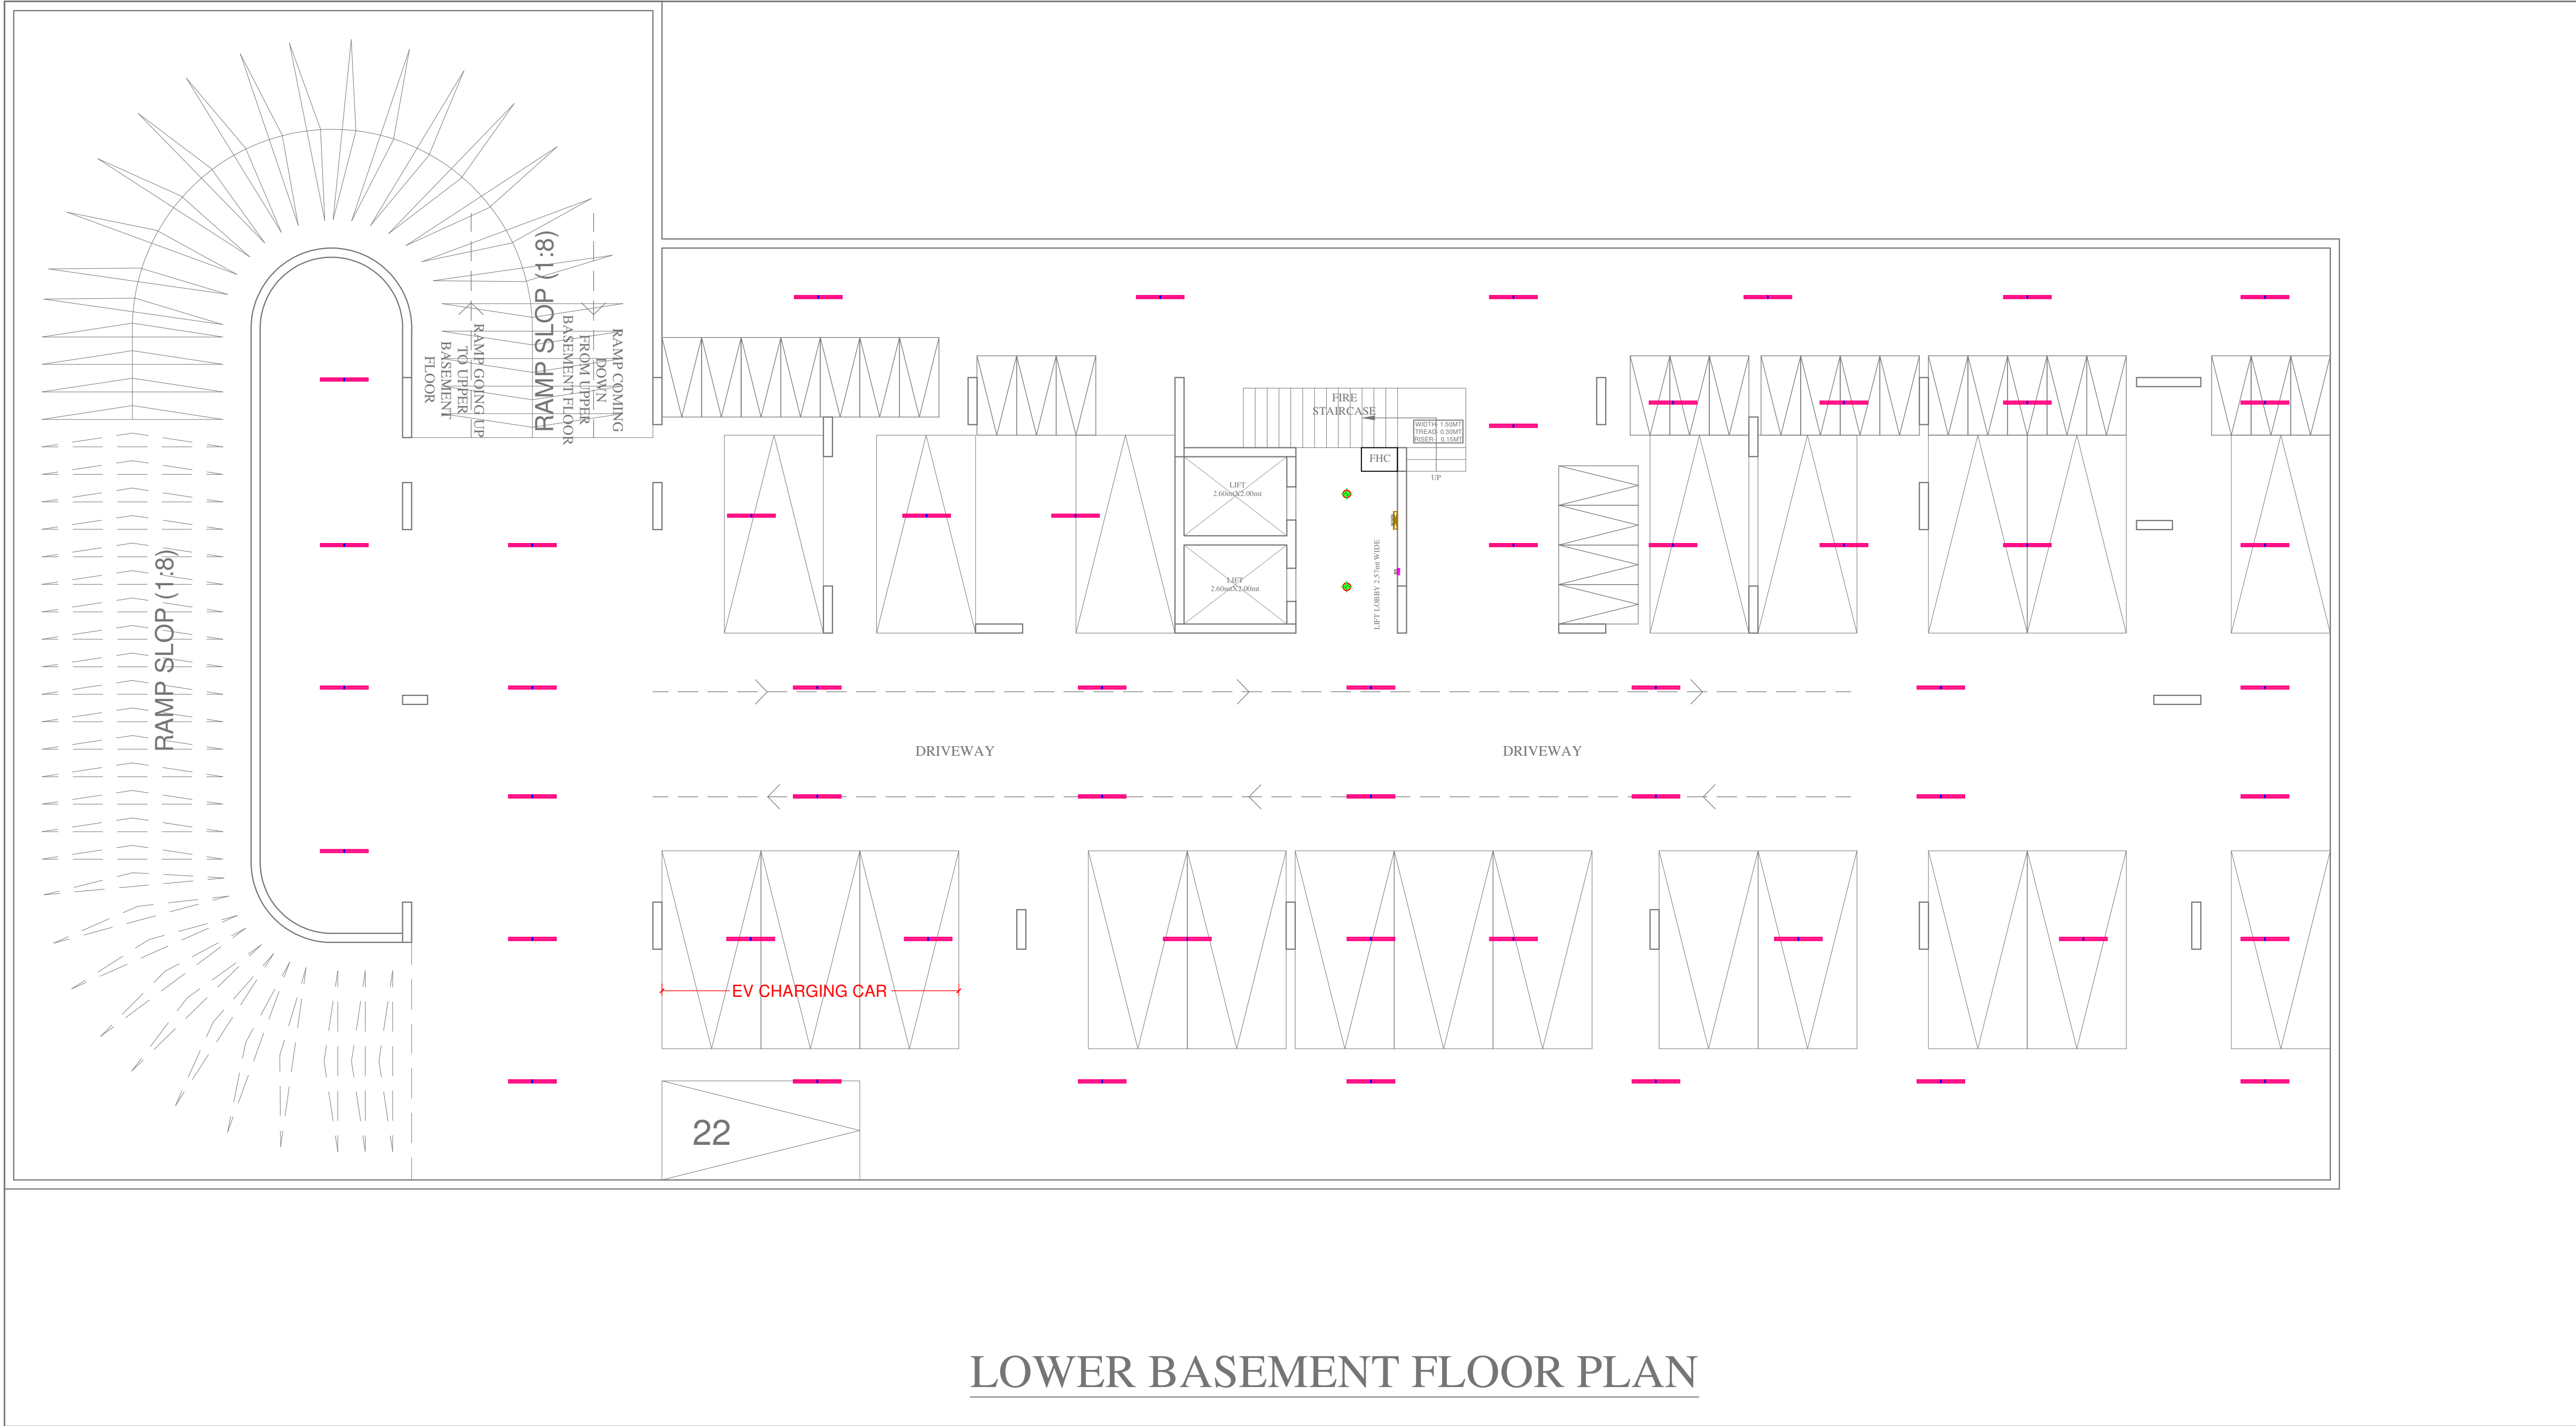


LOWER BASEMENT FLOOR PLAN


Vipul
VIPUL AGARWAL
M.E.P. CONSULTANT
B.E. ELECTRICAL

LEGENDS:				
Mounting Height	No.	I D	Symbol	Description
CEILING		DL		LED 6" DOWNLIGHTER 15W (SURFACE MOUNTED) MAKE SYSKA LED CAT NO.SDL-15W GLD 6.5K/4K
CEILING		TL/C		LED Ceiling Tube Light Make:- Syska Led Cat no:- SSK-TS-20W
+42"		SB		SWITCH BOARD
+60"		MCB DB		MCB DISTRIBUTION BOARD

PROJECT:-	PROPOSED APARTMENT "GOLD BELLAGIO", CP-6 CORNER, SWAMI VIVEKANAND NAGAR SCHEME, KOTA
DRAWING:	LOWER BASEMENT FLOOR ELECTRIC PLAN

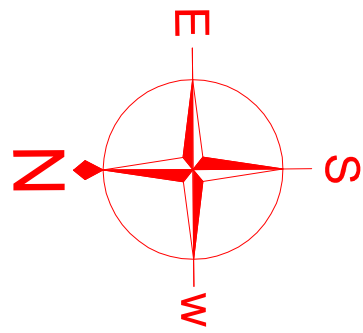


ARCHITECTS:-
KAPPRIS INNOVATION
VAISHALI NAGAR, JAIPUR
Phone No: 0141-4002369
email:-kapprisinnovation@gmail.com

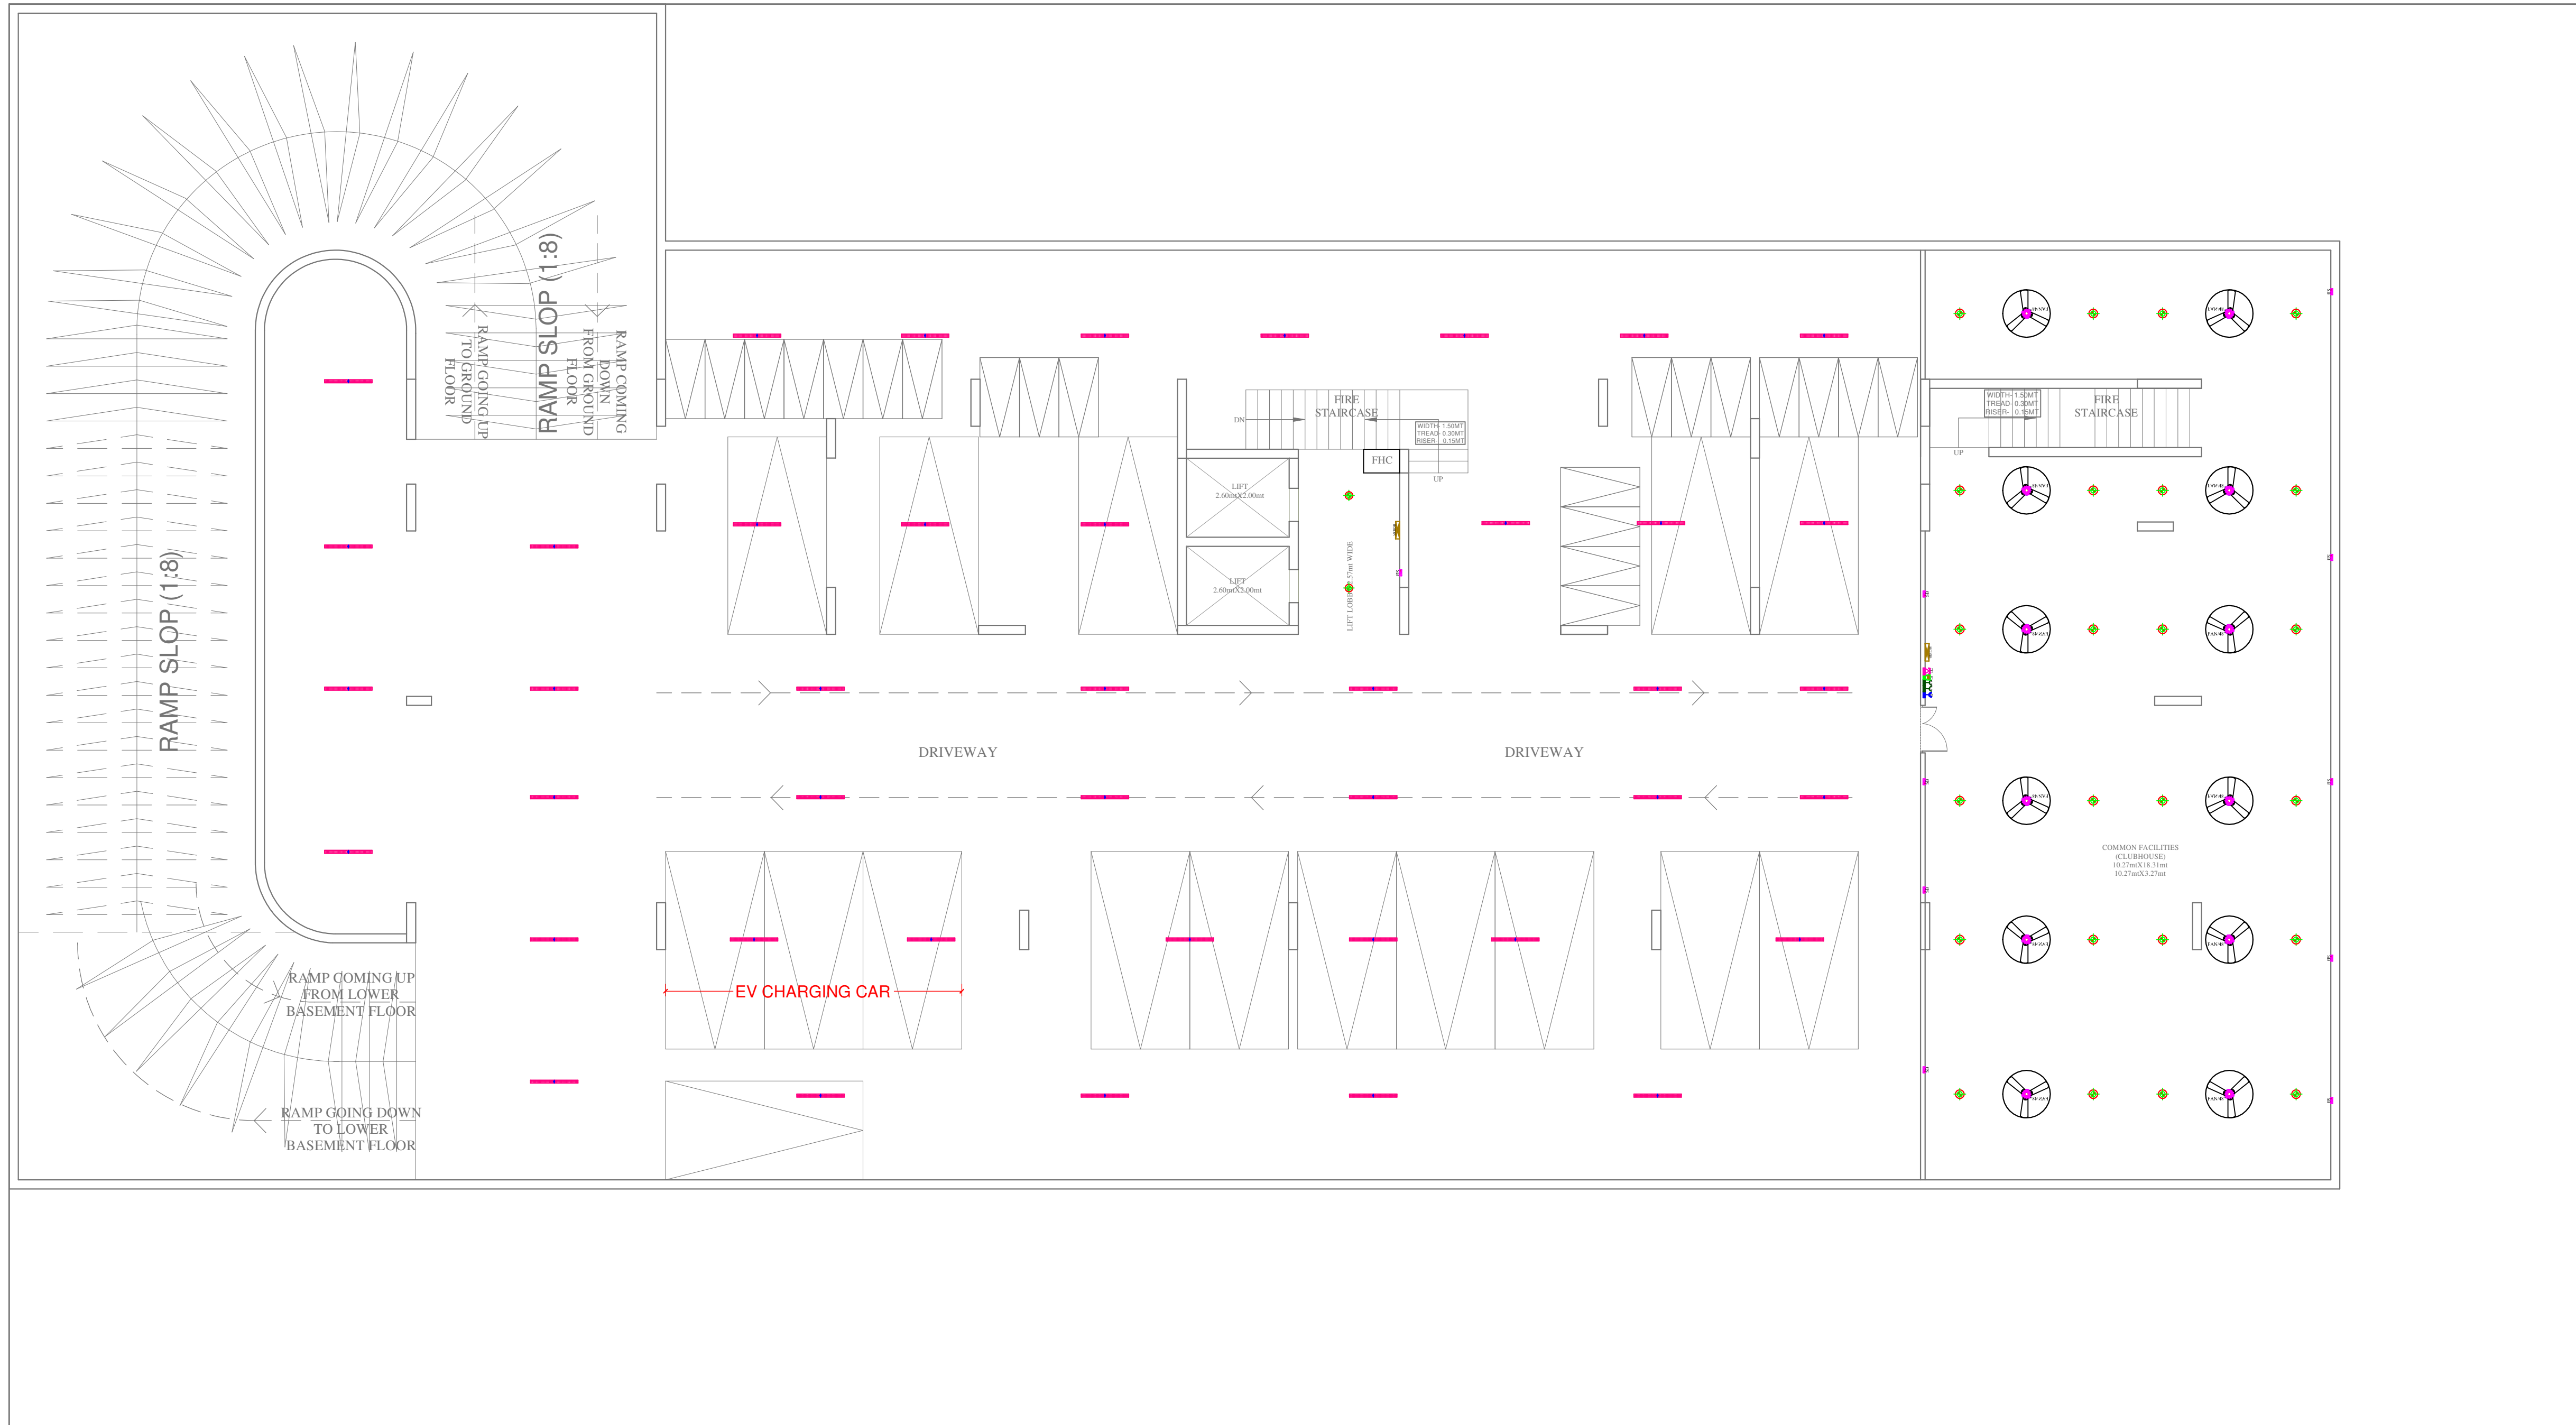


UPPER BASEMENT FLOOR PLAN

**SET-1**





1No. Telephone Jack., 1No.Data Jack
For Computer Point, 2No. 6A Socket
Controlled by 1No. 16A Switch For
UPS & 1No. 16A 5Pin Socket
Controlled by 1No. 16A Switch For
Raw

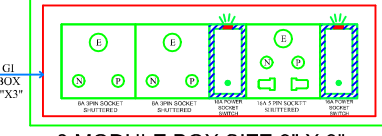**8 MODULE BOX SIZE 9" X 3",
PLATE SIZE 245 X 90 MM**

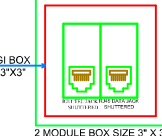**2 MODULE BOX SIZE 9" X 3",
PLATE SIZE 90 X 40 MM**

+36"

    Vignit
VIPUL AGARWAL
M.E.P. CONSULTANT
B.E. ELECTRICAL


LEGENDS:				
Mounting Height	No.	I D	Symbol	Description
CEILING		FAN 48"		CEILING FAN 48"
CEILING		DL		LED 6" DOWNLIGHTER 15W (SURFACE MOUNTED) MAKE: SYSKA LED CAT NO.SDL-15W GLD 6.5K/4K
CEILING		TL/C		Led Ceiling Tube Light Make:- Syska Led Cat no.- SSK-T5-20W
+90"		TL/W		LED WALL TUBE LIGHT MAKE:- SYSKA LED CAT NO.- SSK-T5-20W
+42"		SB		SWITCH BOARD
AS PER ELEVATION		SET-1		1No. Telephone Jack., 1No.Data Jack For Computer Point, 2No. 6A Socket Controlled by 1No. 16A Switch For UPS & 1No. 16A 5Pin Socket Controlled by 1No. 16A Switch For Raw
+60"		MCB DB		MCB DISTRIBUTION BOARD

PROJECT:-


DRAWING:

PROPOSED APARTMENT "GOLD BELLGIO",
CP-6 CORNER, SWAMI VIVEKANAND
NAGAR SCHEME, KOTA


UPPER BASEMENT FLOOR ELECTRIC PLAN

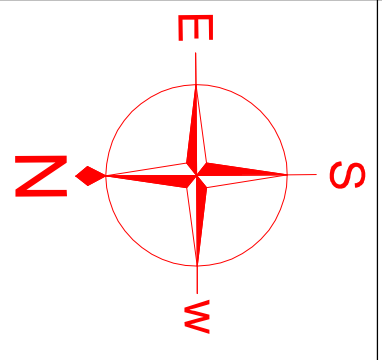


**ARCHITECTS:-**
KAPPRIS INNOVATION
VAISHALI NAGAR, JAIPUR
Phone No: 0141-4002369
email:-kapprisinnovation@gmail.com

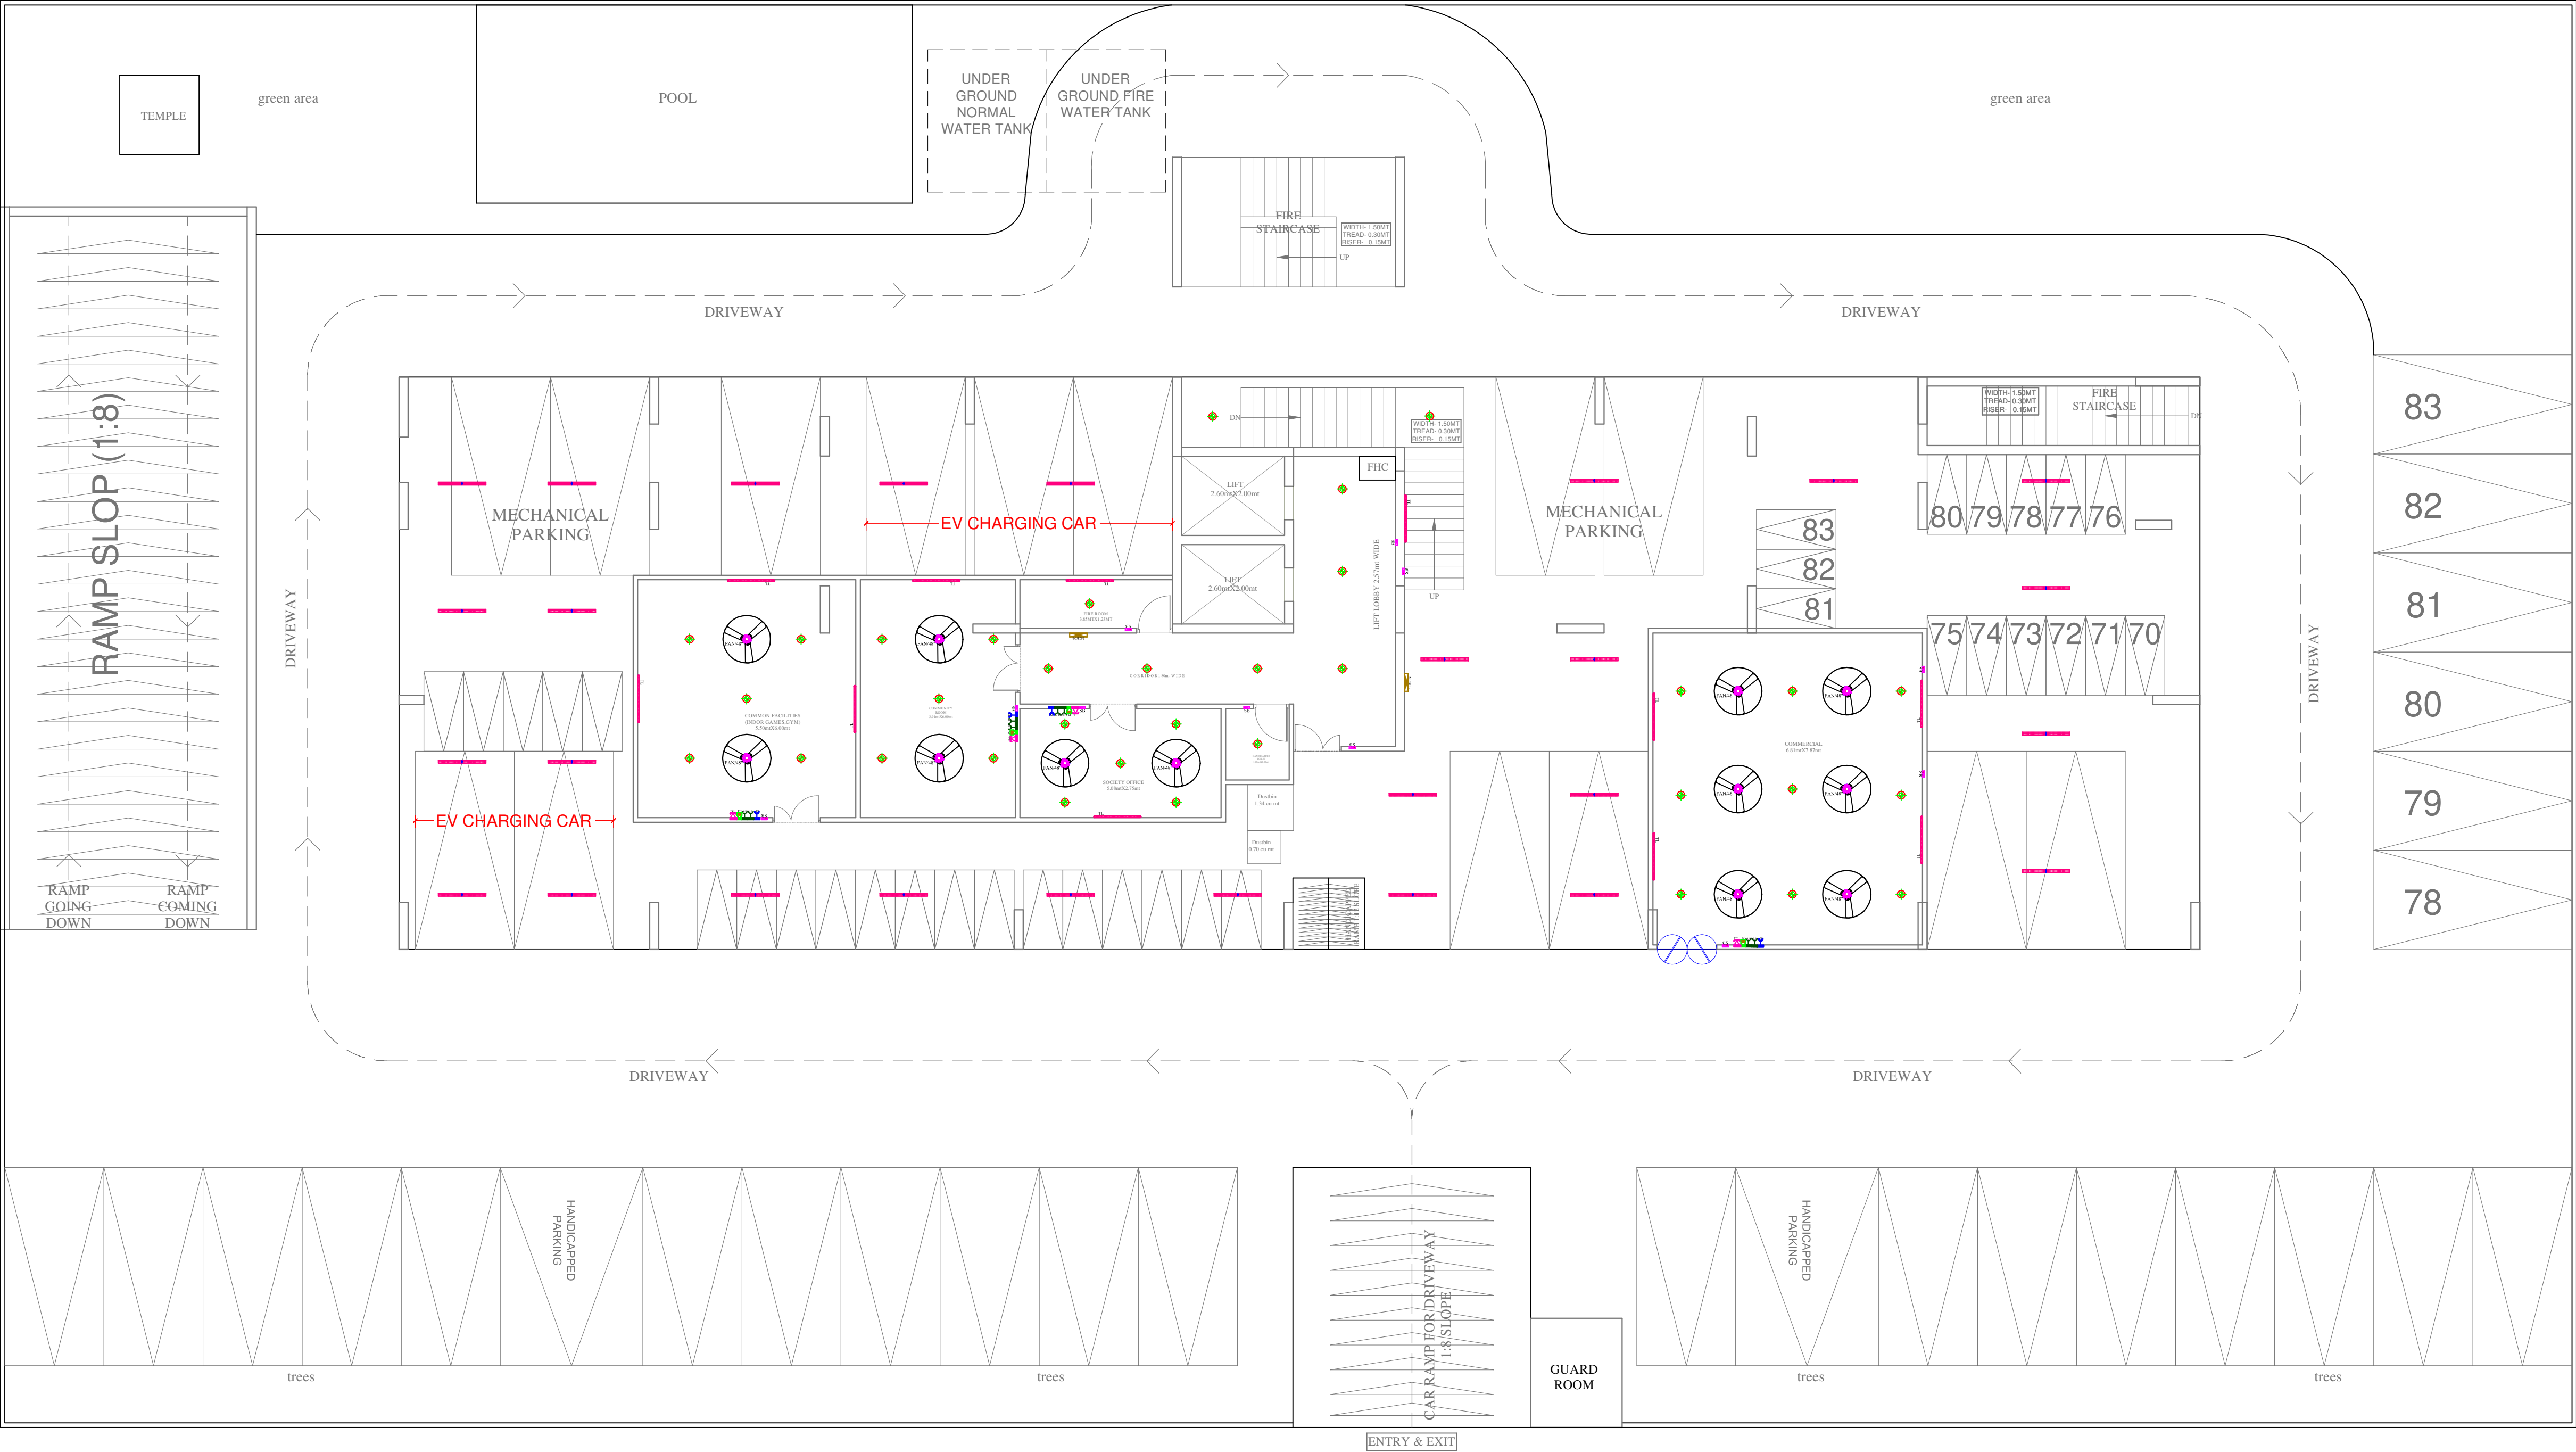

STILT FLOOR PLAN

 

SET-1

 

Raw

 
 
 
 
 
 
1No. Telephone Jack., 1No.Data Jack
For Computer Point, 2No. 6A Socket
Controlled by 1No. 16A Switch For
UPS & 1No. 16A 5Pin Socket
Controlled by 1No. 16A Switch For

8 MODULE BOX SIZE 9" X 3",
PLATE SIZE 245 X 90 MM

+36"



VIPUL AGARWAL
M.E.P. CONSULTANT
B.E. ELECTRICAL


LEGENDS:				
Mounting Height	No.	I D	Symbol	Description
CEILING	FAN 48"			CEILING FAN 48"
CEILING	DL			LED 6" DOWNLIGHTER 15W (SURFACE MOUNTED) MAKE SYSKA LED CAT NO.SDL-15W GLD 6.5K/4K
CEILING	TLC			Led Ceiling Tube Light Make:- Syska Led Cat no.- SSK-T5-20W
+90"	TL/W			LED WALL TUBE LIGHT MAKE:- SYSKA LED CAT NO:- SSK-T5-20W
+90"	BULB			LED BULB 20W MAKE:- SYSKA LED CAT NO. SKC-20W 5.7K/3K
+78"	ML			12X2 LED MIRROR LIGHT MAKE:- SYSKA LED CAT NO.- FPL-12X2
+42"	SB			SWITCH BOARD
VENTILATOR HT.	CR			CEILING ROSE
VENTILATOR HT.	EXF			9" DIA FRESH AIR FAN
AS PER ELEVATION	SET-1			1No. Telephone Jack., 1No.Data Jack For Computer Point, 2No. 6A Socket Controlled by 1No. 16A Switch For UPS & 1No. 16A 5Pin Socket Controlled by 1No. 16A Switch For Raw
+60"	MCB DB			MCB DISTRIBUTION BOARD

PROJECT:-

DRAWING:

PROPOSED APARTMENT "GOLD BELLAGIO",
CP-6 CORNER, SWAMI VIVEKANAND
NAGAR SCHEME, KOTA

STILT FLOOR ELECTRIC PLAN

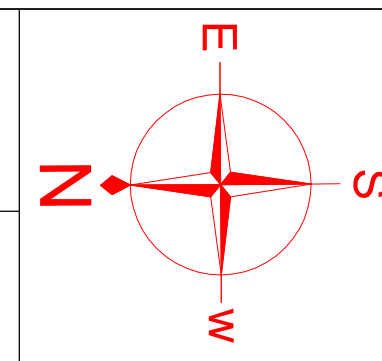


ARCHITECTS:-

KAPPRIS INNOVATION

VAISHALI NAGAR, JAIPUR

Phone No: 0141-4002369

email:-kapprisinnovation@gmail.com

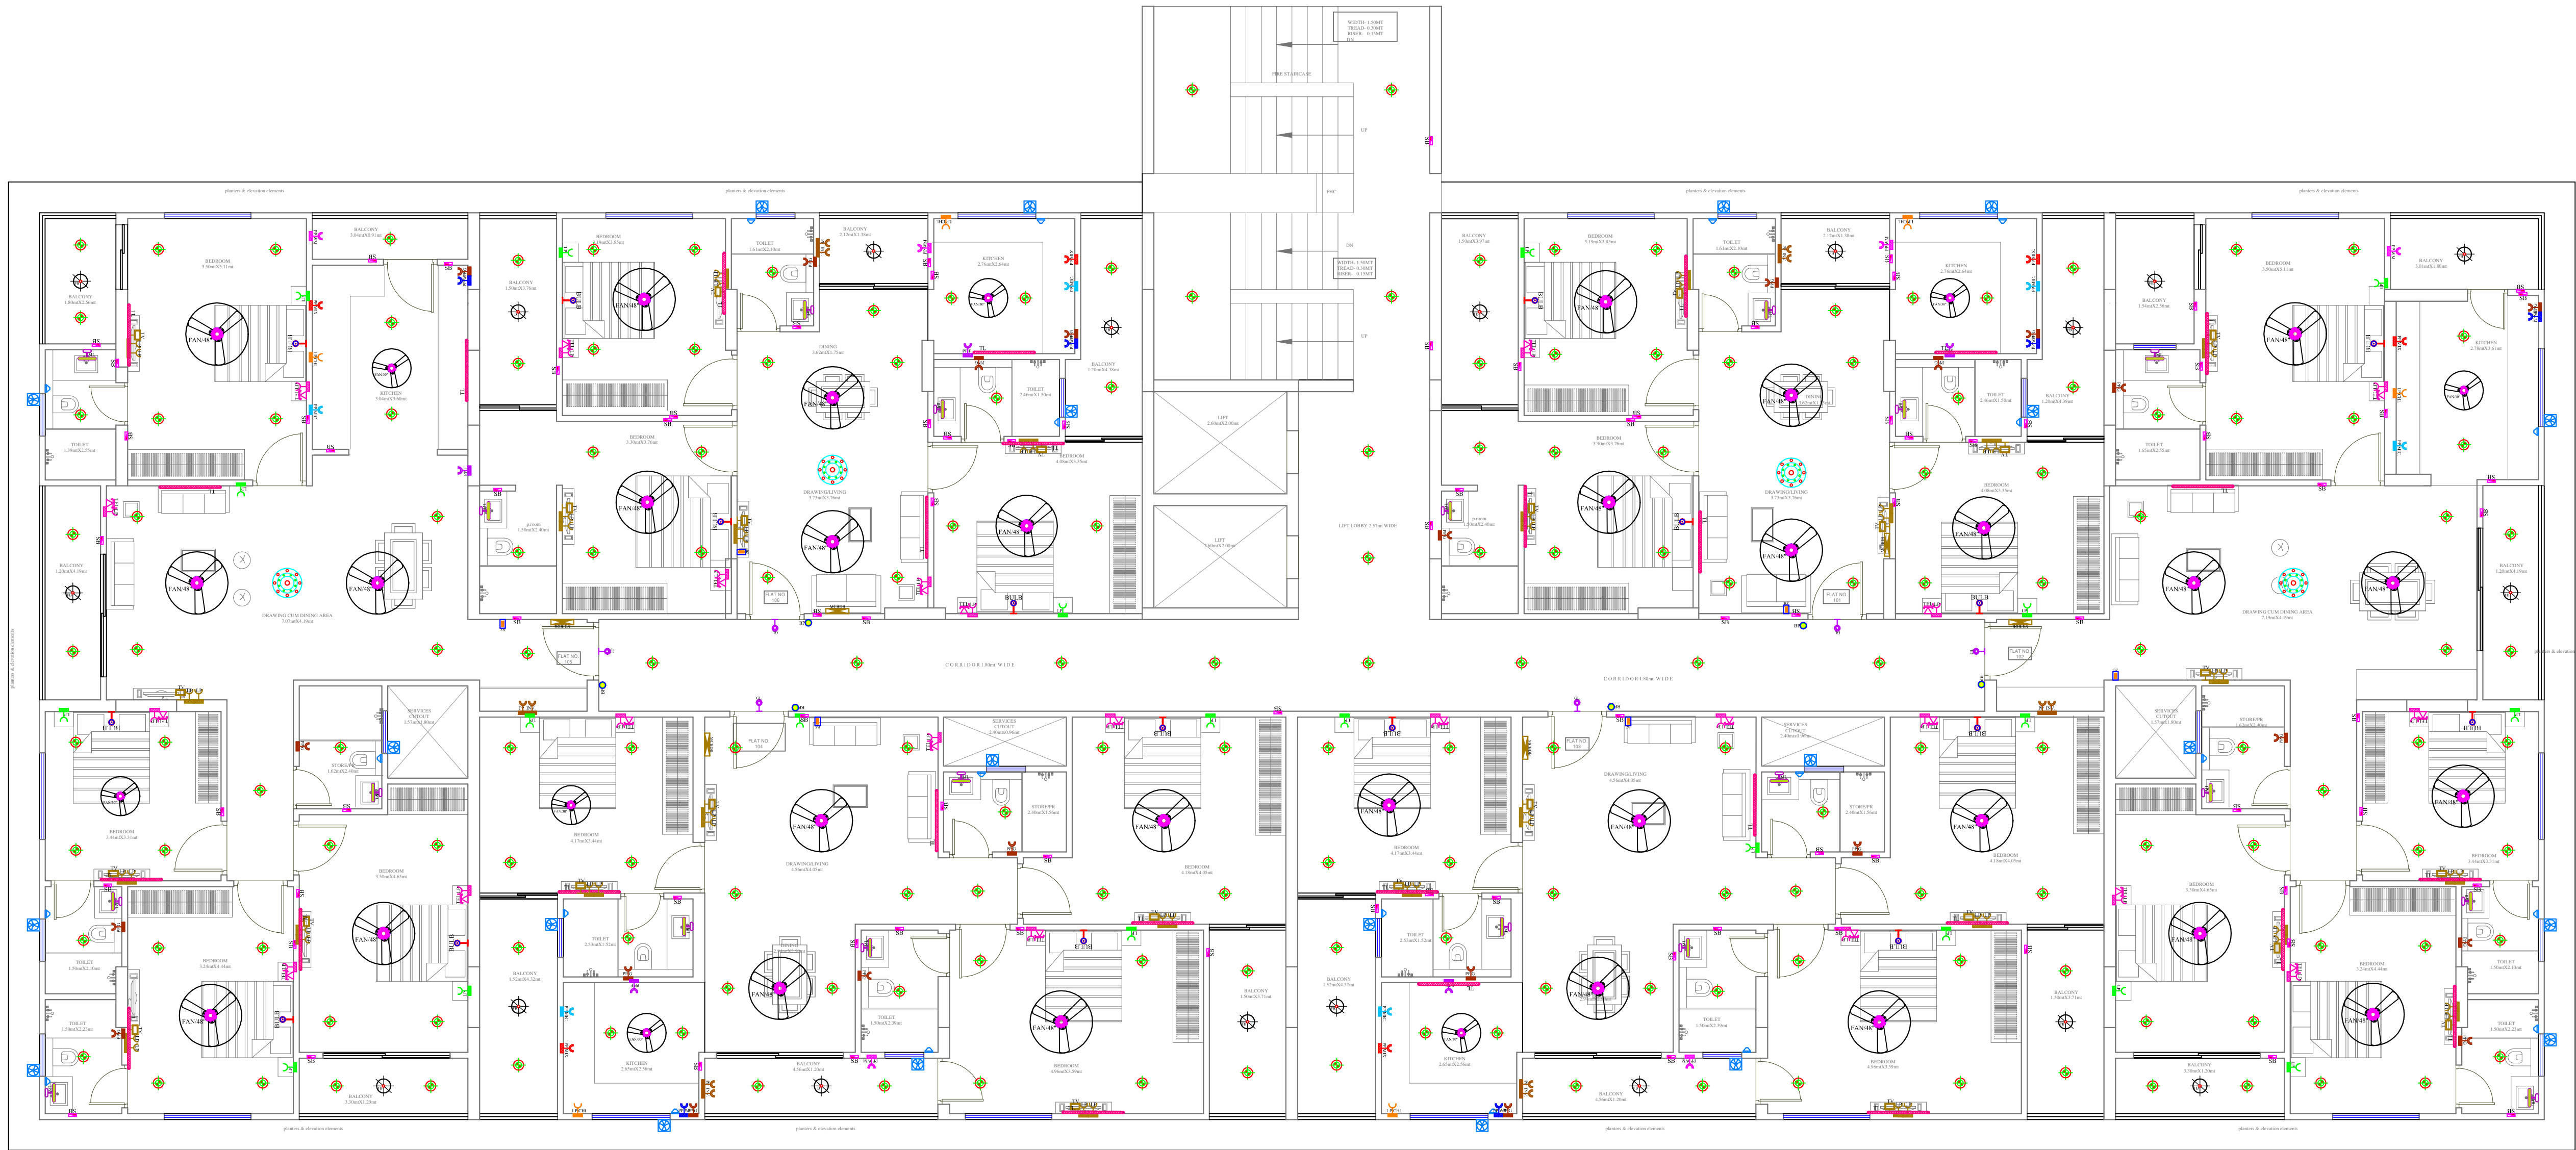

Vipul
VIPUL AGARWAL
M.E.P. CONSULTANT
B.E. ELECTRICAL

LEGENDS:

Mouting Height	No.	I D	Symbol	Description
CEILING		FAN48"		CEILING FAN 48"
CEILING		FAN30"		CEILING FAN 30"
CEILING		FB		FAN BOX
CEILING		CHI		CHANDELIER
+90"		TLW		Led Wall Tube Light Make: Syka Led Cat no. SSK-15-20W
+90"		BULB		Led Bulb 20W Make: Syka Led Cat no. SSK-15W 5.7K/2K
+90"		GL		WALL BRACKETS AS DESIGN FOR GANESH LIGHT
+78"		ML		12x2 Led Mirror Light Make: Syka Led Cat no. PPL-12x2
CEILING		DL		Led 6" Down Lighter 20W (Surface Mounted) Make: Syka Led Cat no. SSK-15W GLD 6.5K/4K
VENTILATOR HT.		CR		CEILING ROSE
VENTILATOR HT.		EXF		9" DIA FRESH AIR FAN
+42"		SB		SWITCH BOARD
+24"		2WSB		2 WAY SWITCH BOARD
+24"		TEL		TELEPHONE POINT
+24"		LP TEL		6 A PLUG POINT FOR TELEPHONE
+48"		TV		TV COAXIAL POINT
+48"		LP TV		6 A PLUG POINT FOR TV
+24"		LP		6 A PLUG POINT FOR SIDE TABLE
+72"		LP-CH		6 A PLUG POINT FOR CHIMNEY
+90"		SAC		SPLIT AC INDOOR UNIT
+42"		PP-MIX		16 A POWER POINT FOR MIXER
+42"		PP-MIC		16 A POWER POINT FOR MICROWAVE
+78"		PP-G		16 A POWER POINT FOR GEYSER
+54"		PP-F		16 A POWER POINT FOR FRIDGE
+78"		PP-WP		16 A POWER POINT FOR WATER PURIFIER
+48"		PP-WM		16 A POWER POINT FOR WASHING MACHINE
+12"		PP-INV		16 A POWER POINT FOR INVERTOR
+60"		BP		6 A BELL PUSH
+90"		BZ		BUZZER FOR CALL BELL
+60"		MCB DB		MCB DISTRIBUTION BOARD

SERVICE CONSULTANT

ASHI ASSOCIATES

F 9 / 440 , Keshav Marg Chitrakut Scheme Jaipur
PH:91-0-93146-10438, 0141-2440946, Mail: vipul8599@yahoo.com

ARCHITECTS:-

KAPPRIS INNOVATION

VAISHALI NAGAR, JAIPUR

Phone No: 0141-4002369


email:-kapprisinnovation@gmail.com


PROJECT:-

PROPOSED APARTMENT "GOLD BELLAGIO",
CP-6 CORNER, SWAMI VIVEKANAND
NAGAR SCHEME, KOTA

DRAWING:

TYPICAL FLOOR ELECTRIC PLAN
(GROUND, FIRST, FOURTH, SEVENTH, TENTH, FLOOR)

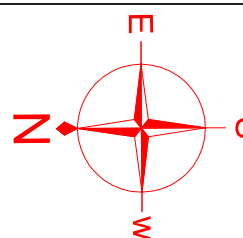

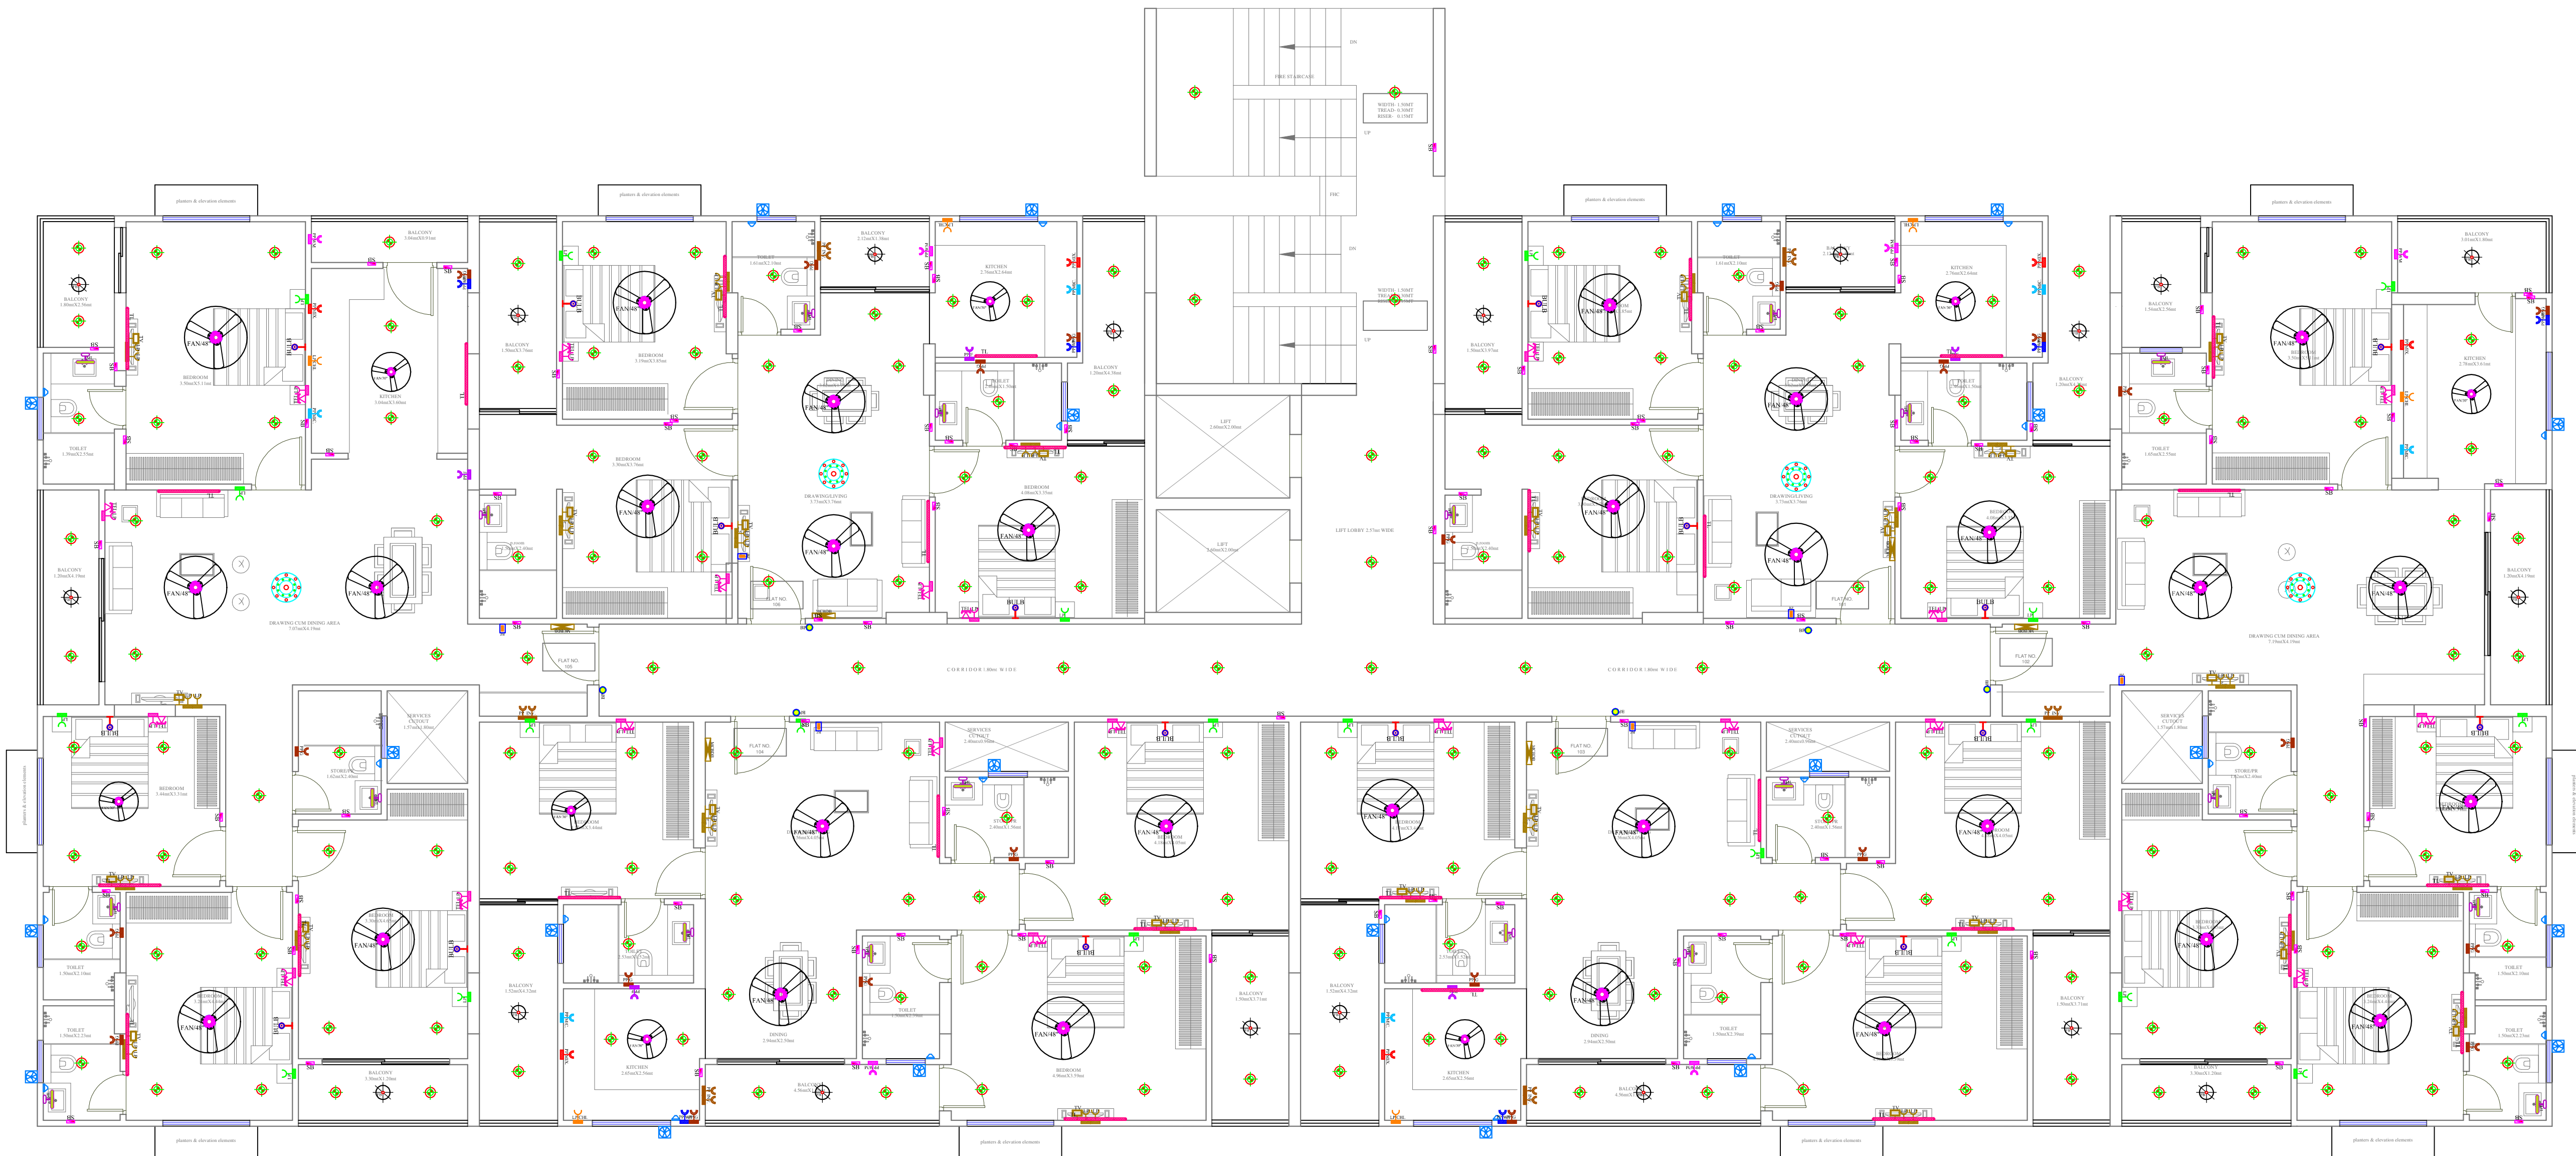

Vipul
VIPUL AGARWAL
M.E.P. CONSULTANT
B.E. ELECTRICAL

LEGENDS:

Mounting Height	No.	1 D	Symbol	Description
CEILING		FAN/48"		CEILING FAN 48"
CEILING		FAN/30"		CEILING FAN 30"
CEILING		FB		FAN BOX
CEILING		CHI		CHANDELIER
+90"		TL/W		Led Wall Tube Light Make:- Syka Led Cat no:- SSK-TS-20W
+90"		BULB		Led Bulb 20W Make:- Syka Led Cat no:- SKC-20W 5.7K/3K
+90"		GL		WALL BRACKETS AS DESIGN FOR GANESHI LIGHT
+78"		ML		Led 6" Down Lighter 20W (Surface Mounted) Make:- Syka Led Cat no:- SDL-15W GLD 6.5K/4K
CEILING		DL		CEILING ROSE
VENTILATOR HT.		CR		9" DIA FRESH AIR FAN
VENTILATOR HT.		EXF		SWITCH BOARD
+42"		SB		2 WAY SWITCH BOARD
+24"		2W/SB		TELEPHONE POINT
+24"		TEL		6 A PLUG POINT FOR TELEPHONE
+24"		LP TEL		TV COAXIAL POINT
+48"		TV		6 A PLUG POINT FOR TV
+24"		LP TV		6 A PLUG POINT FOR SIDE TABLE
+72"		LP-CH		6 A PLUG POINT FOR CHIMNEY
+90"		SAC		SPLIT AC INDOOR UNIT
+42"		PP-MIX		16 A POWER POINT FOR MIXER
+42"		PP-MIC		16 A POWER POINT FOR MICROWAVE
+78"		PP-G		16 A POWER POINT FOR GEYSER
+54"		PP-F		16 A POWER POINT FOR FRIDGE
+78"		PP-WP		16 A POWER POINT FOR WATER PURIFIER
+48"		PP-WM		16 A POWER POINT FOR WASHING MACHINE
+12"		PP-INV		6 A BELL PUSH
+60"		BP		BELL PUSH
+90"		BZ		BUZZER FOR CALL BELL
+60"		MCB DB		MCB DISTRIBUTION BOARD


SERVICE CONSULTANT

ASHI ASSOCIATES


F 9 / 440 , Keshav Marg Chitrakut Scheme, Jaipur
PH-91-0-93146-10438 , 0141-2440946, Mail:vipul8599@yahoo.com

PROJECT:- PROPOSED APARTMENT "GOLD BELLAGIO",
CP-6 CORNER, SWAMI VIVEKANAND
NAGAR SCHEME, KOTA

DRAWING: TYPICAL FLOOR ELECTRIC PLAN
(SECOND, THIRD, FIFTH, SIXTH, EIGHT, NINTH, ELEVENTH,
TWELFTH FLOOR.)

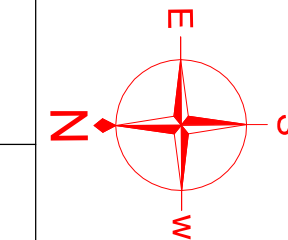

ARCHITECTS:-
KAPPRIS INNOVATION
VAISHALI NAGAR, JAIPUR
Phone No: 0141-4002369
email:-kapprisinnovation@gmail.com

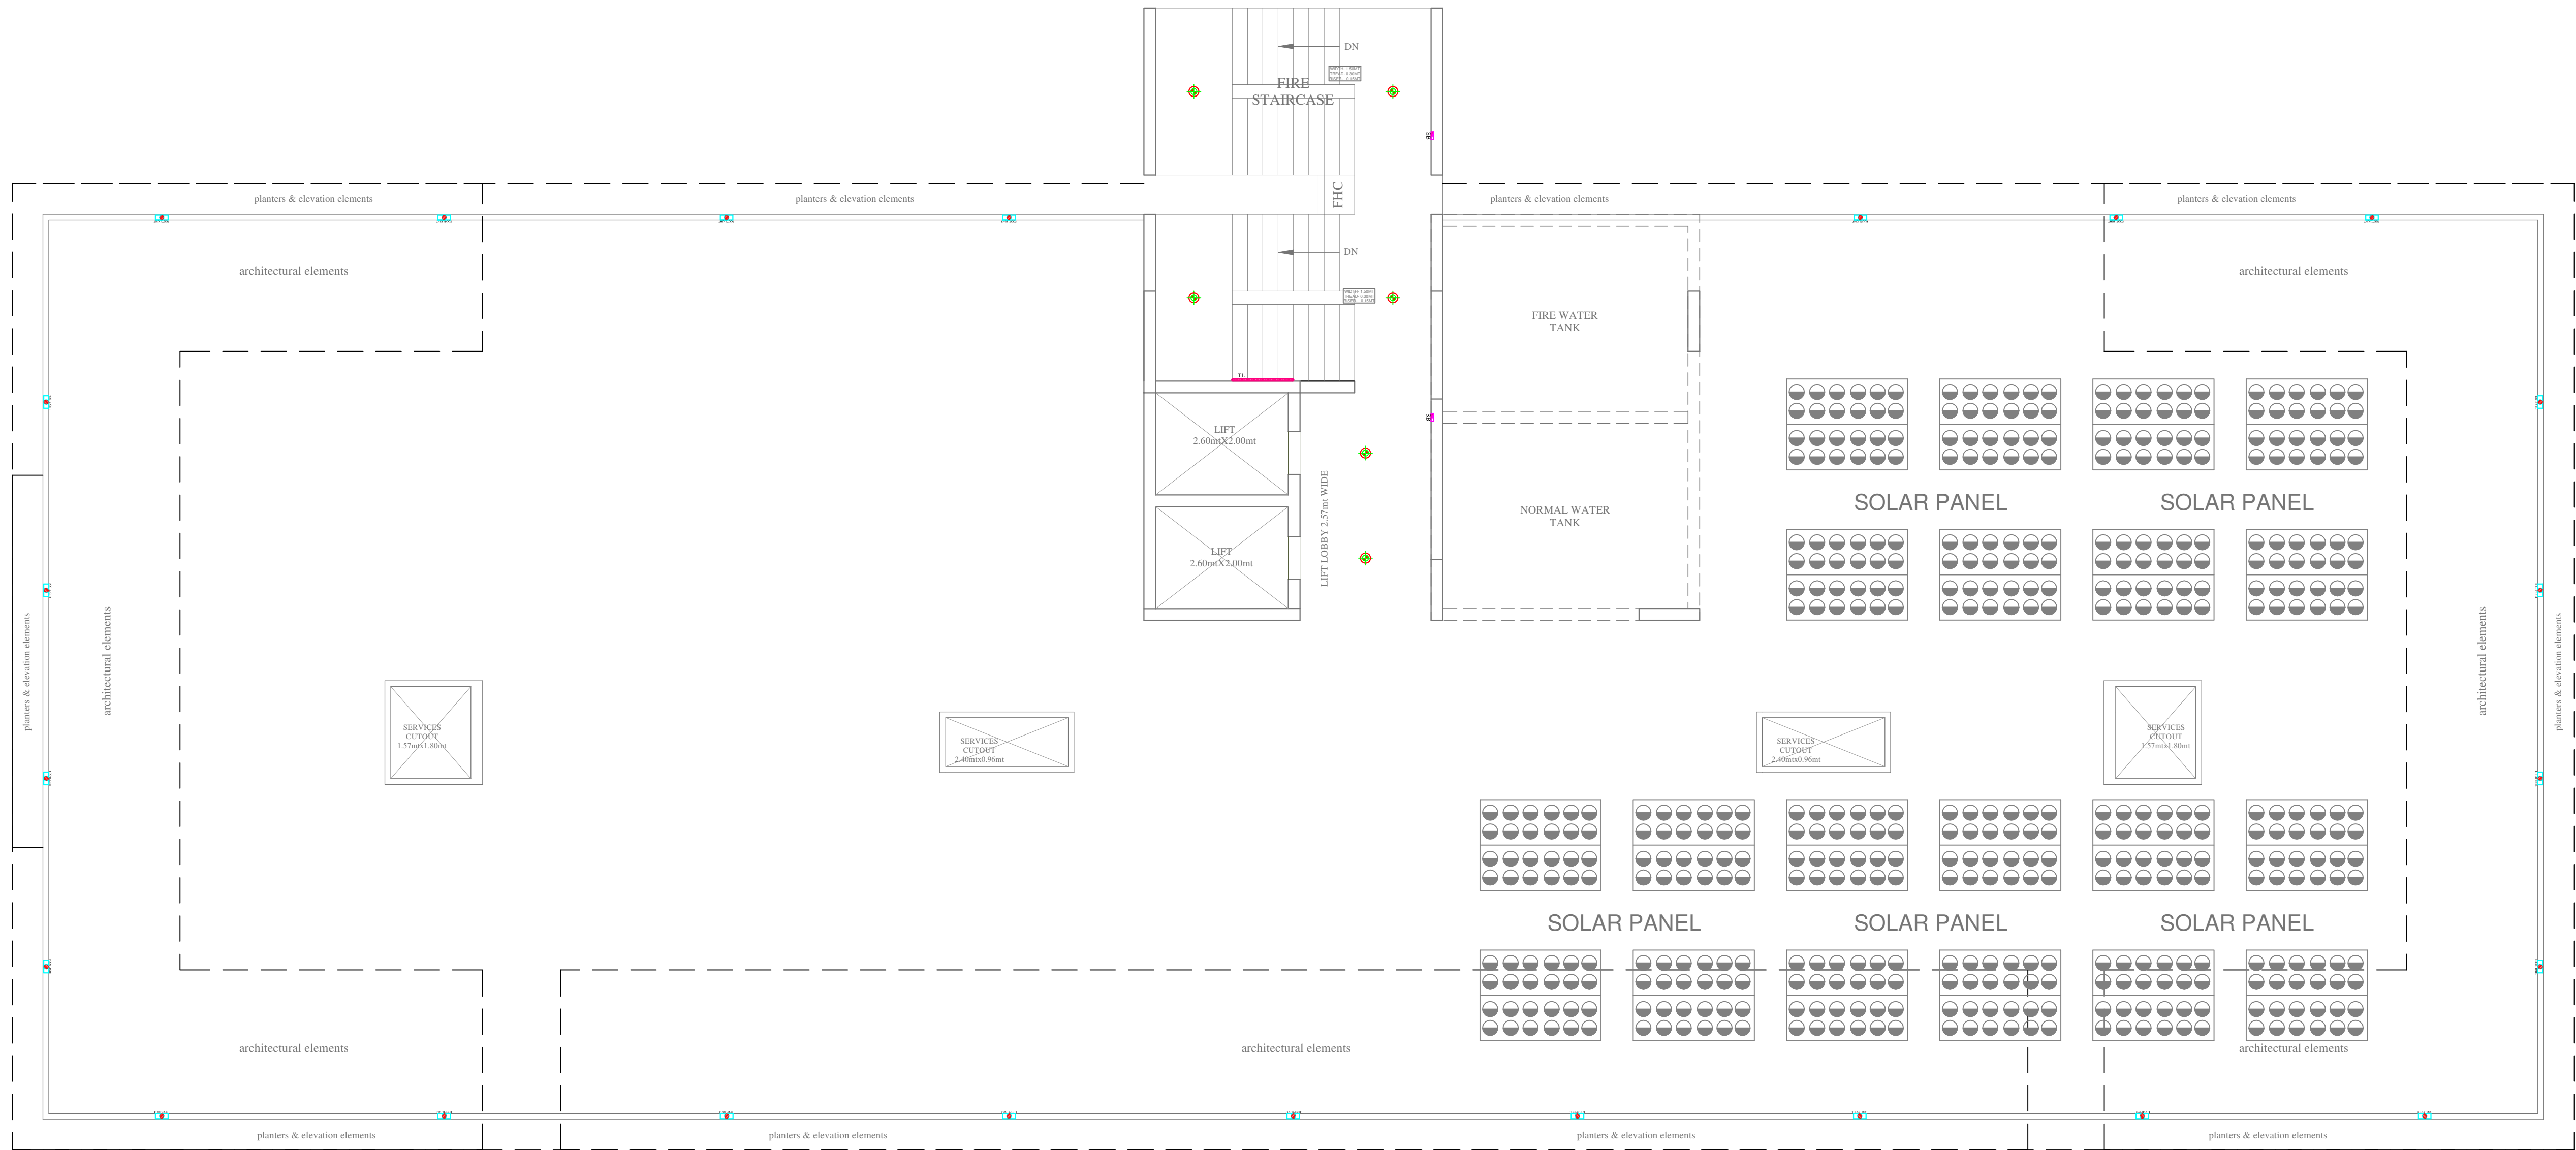


TERRACE FLOOR PLAN

VIPUL AGARWAL
M.E.P. CONSULTANT
B.E. ELECTRICAL


LEGENDS:				
Mounting Height	No.	ID	Symbol	Description
+90"		TLW		Led Wall Tube Light Make:- Syoka Led Cat no:- SSK-T5-20W
CEILING		DL		Led 0" Down Lighter 20W (Surface Mounted) Make:- Syoka Led Cat no:- SSK-15W GLD 6.9K4K
+42"		SB		SWITCH BOARD
+18"		FL		FOOT LIGHT

SERVICE CONSULTANT
ASHI ASSOCIATES
F 9 / 440 - Keshav Marg Chitrakut Scheme, Jaipur
PH: 91-0-93146-10438 , 0141-2440946, Mail: vipul8599@yahoo.com

PROJECT:-	PROPOSED APARTMENT "GOLD BELLAGIO", CP-6 CORNER, SWAMI VIVEKANAND NAGAR SCHEME, KOTA
DRAWING:	TERRACE FLOOR ELECTRIC PLAN

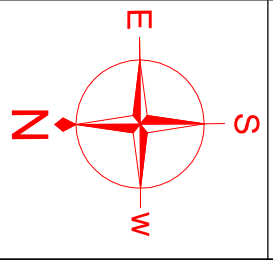

ARCHITECTS:-
KAPPRIS INNOVATION
VAISHALI NAGAR, JAIPUR
Phone No: 0141-4002369
email:- kapprisinnovation@gmail.com

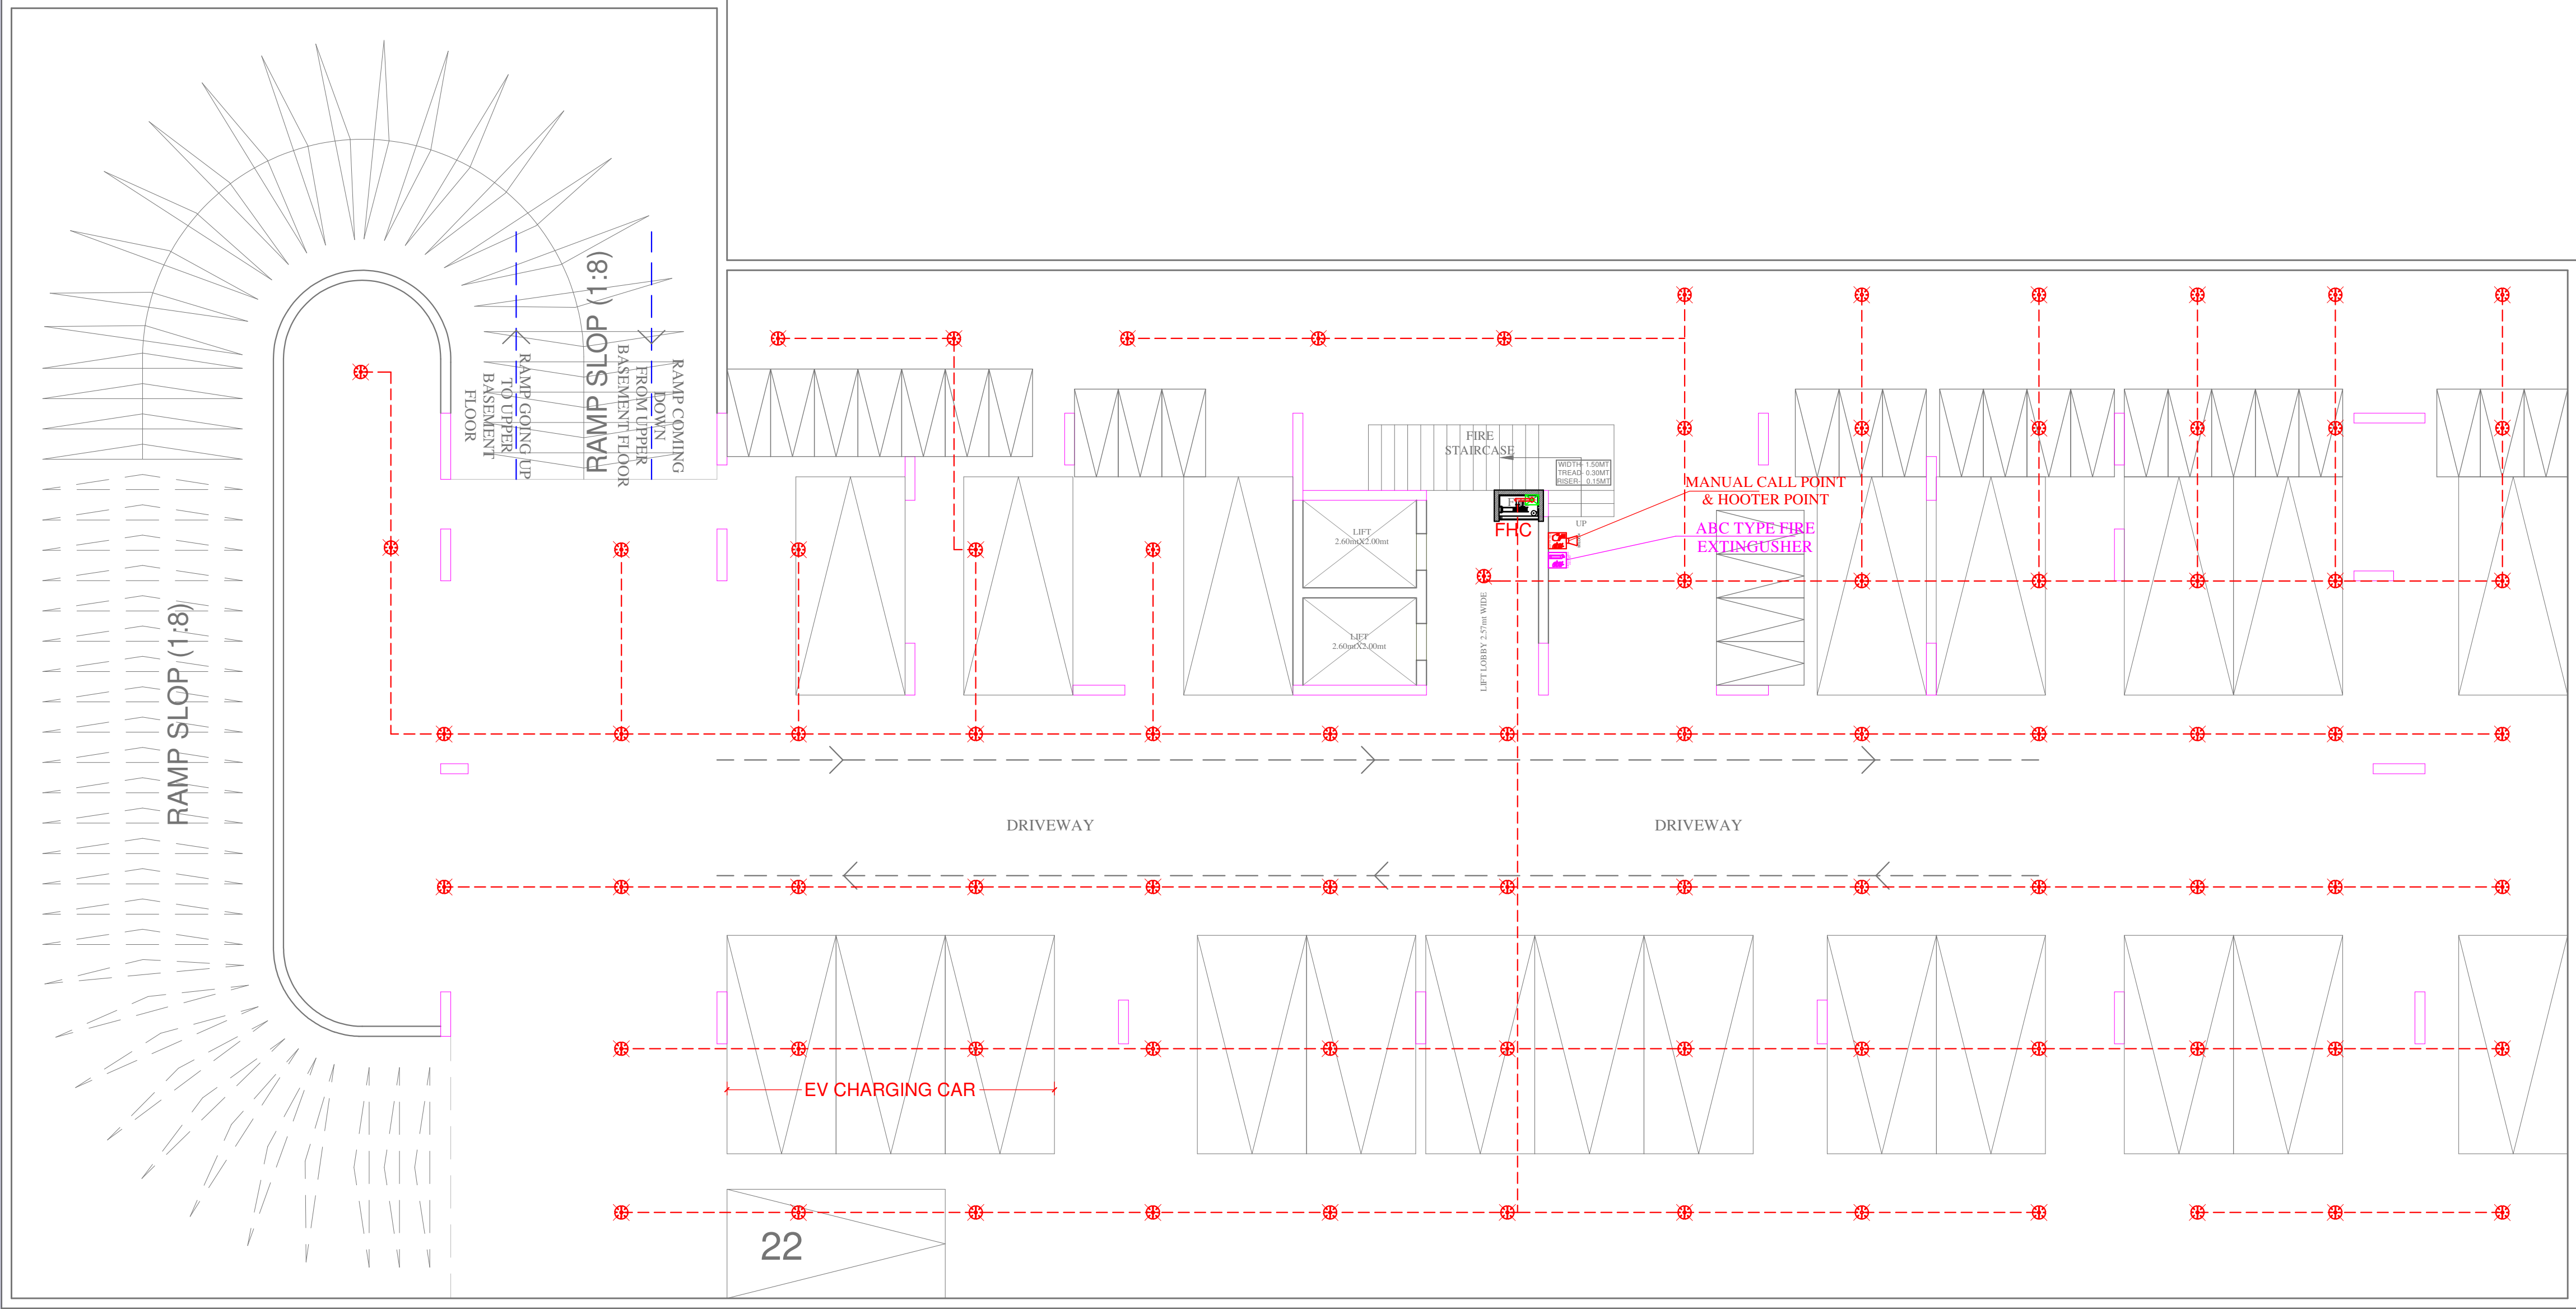

LOWER BASEMENT FLOOR PLAN

Vipul
VIPUL AGARWAL
M.E.P. CONSULTANT
B.E. ELECTRICAL

LEGENDS:


Symbol	Description
	PENDANT TYPE SPRINKLER POINT
	FIRE SPRINKLER PIPE
	MANUAL CALL POINT
	HOOTER POINT
	CONTROL VALVE
	FIRE HOSE CABINET

SERVICES CONSULTANT:
ASHI ASSOCIATES
F9/440, Keshav Marg Chitrakut Scheme, Jaipur
PH: 91-0-93146-10438, 0141-2440946
Mail: vipul8599@yahoo.com

ARCHITECTS:-
KAPPRIS INNOVATION
VAISHALI NAGAR, JAIPUR
Phone No: 0141-4002369
email: kapprisinnoation@gmail.com

PROJECT:-
PROPOSED APARTMENT "GOLD BELLAGIO",
CP-6 CORNER, SWAMI VIVEKANAND
NAGAR SCHEME, KOTA


DRAWING:
LOWER BASEMENT FIRE SPRINKLER
PIPE & MCP, HOOTER PLAN

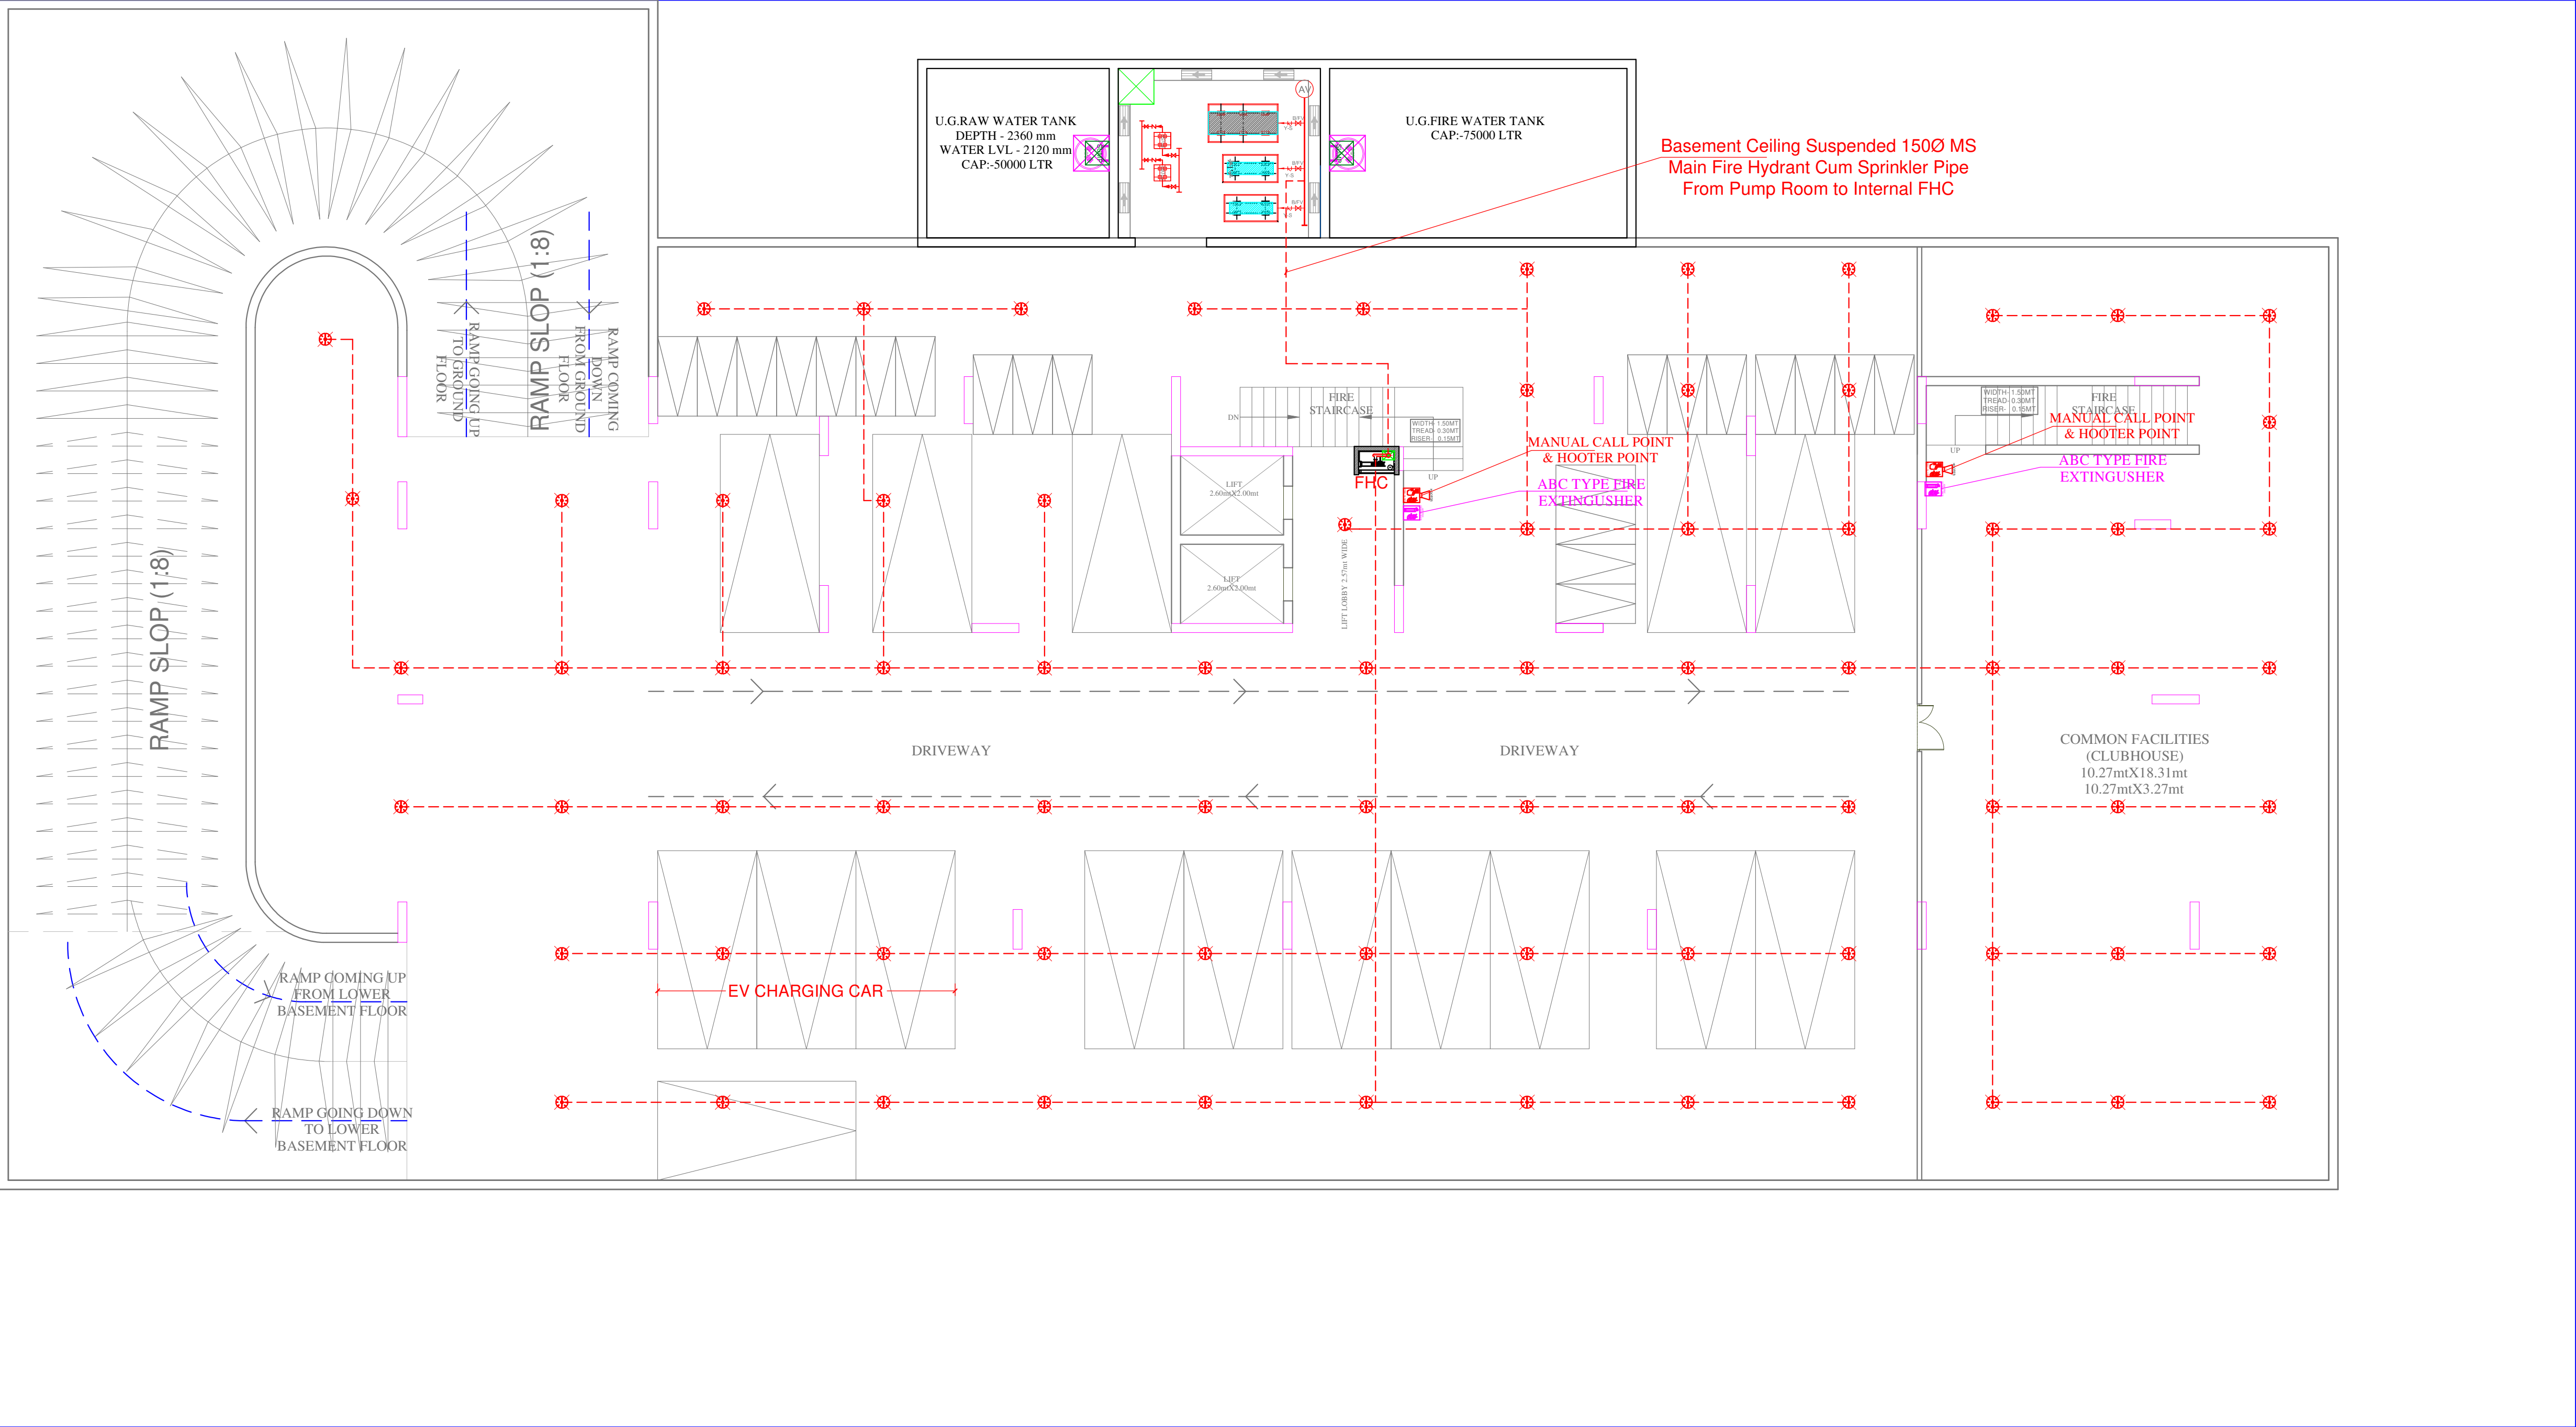


UPPER BASEMENT FLOOR PLAN

Vipul
VIPUL AGARWAL
M.E.P. CONSULTANT
B.E. ELECTRICAL

LEGENDS:	
Symbol	Description
	PENDANT TYPE SPRINKLER POINT
	FIRE SPRINKLER PIPE
	MANUAL CALL POINT
	HOOTER POINT
	CONTROL VALVE
	FIRE HOSE CABINET
SERVICES CONSULTANT: ASHI ASSOCIATES F9/440, Keshav Marg Chitrakut Scheme, Jaipur PH: 91-0-93146-10438, 0141-2440946 Mail: vipul8599@yahoo.com	
ARCHITECTS:- KAPPRIS INNOVATION VAISHALI NAGAR, JAIPUR Phone No: 0141-4002369 email:-kapprisinnovation@gmail.com	
PROJECT:- PROPOSED APARTMENT "GOLD BELLAGIO", CP-6 CORNER, SWAMI VIVEKANAND NAGAR SCHEME, KOTA	
DRAWING: UPPER BASEMENT FIRE SPRINKLER PIPE & MCP, HOOTER PLAN	

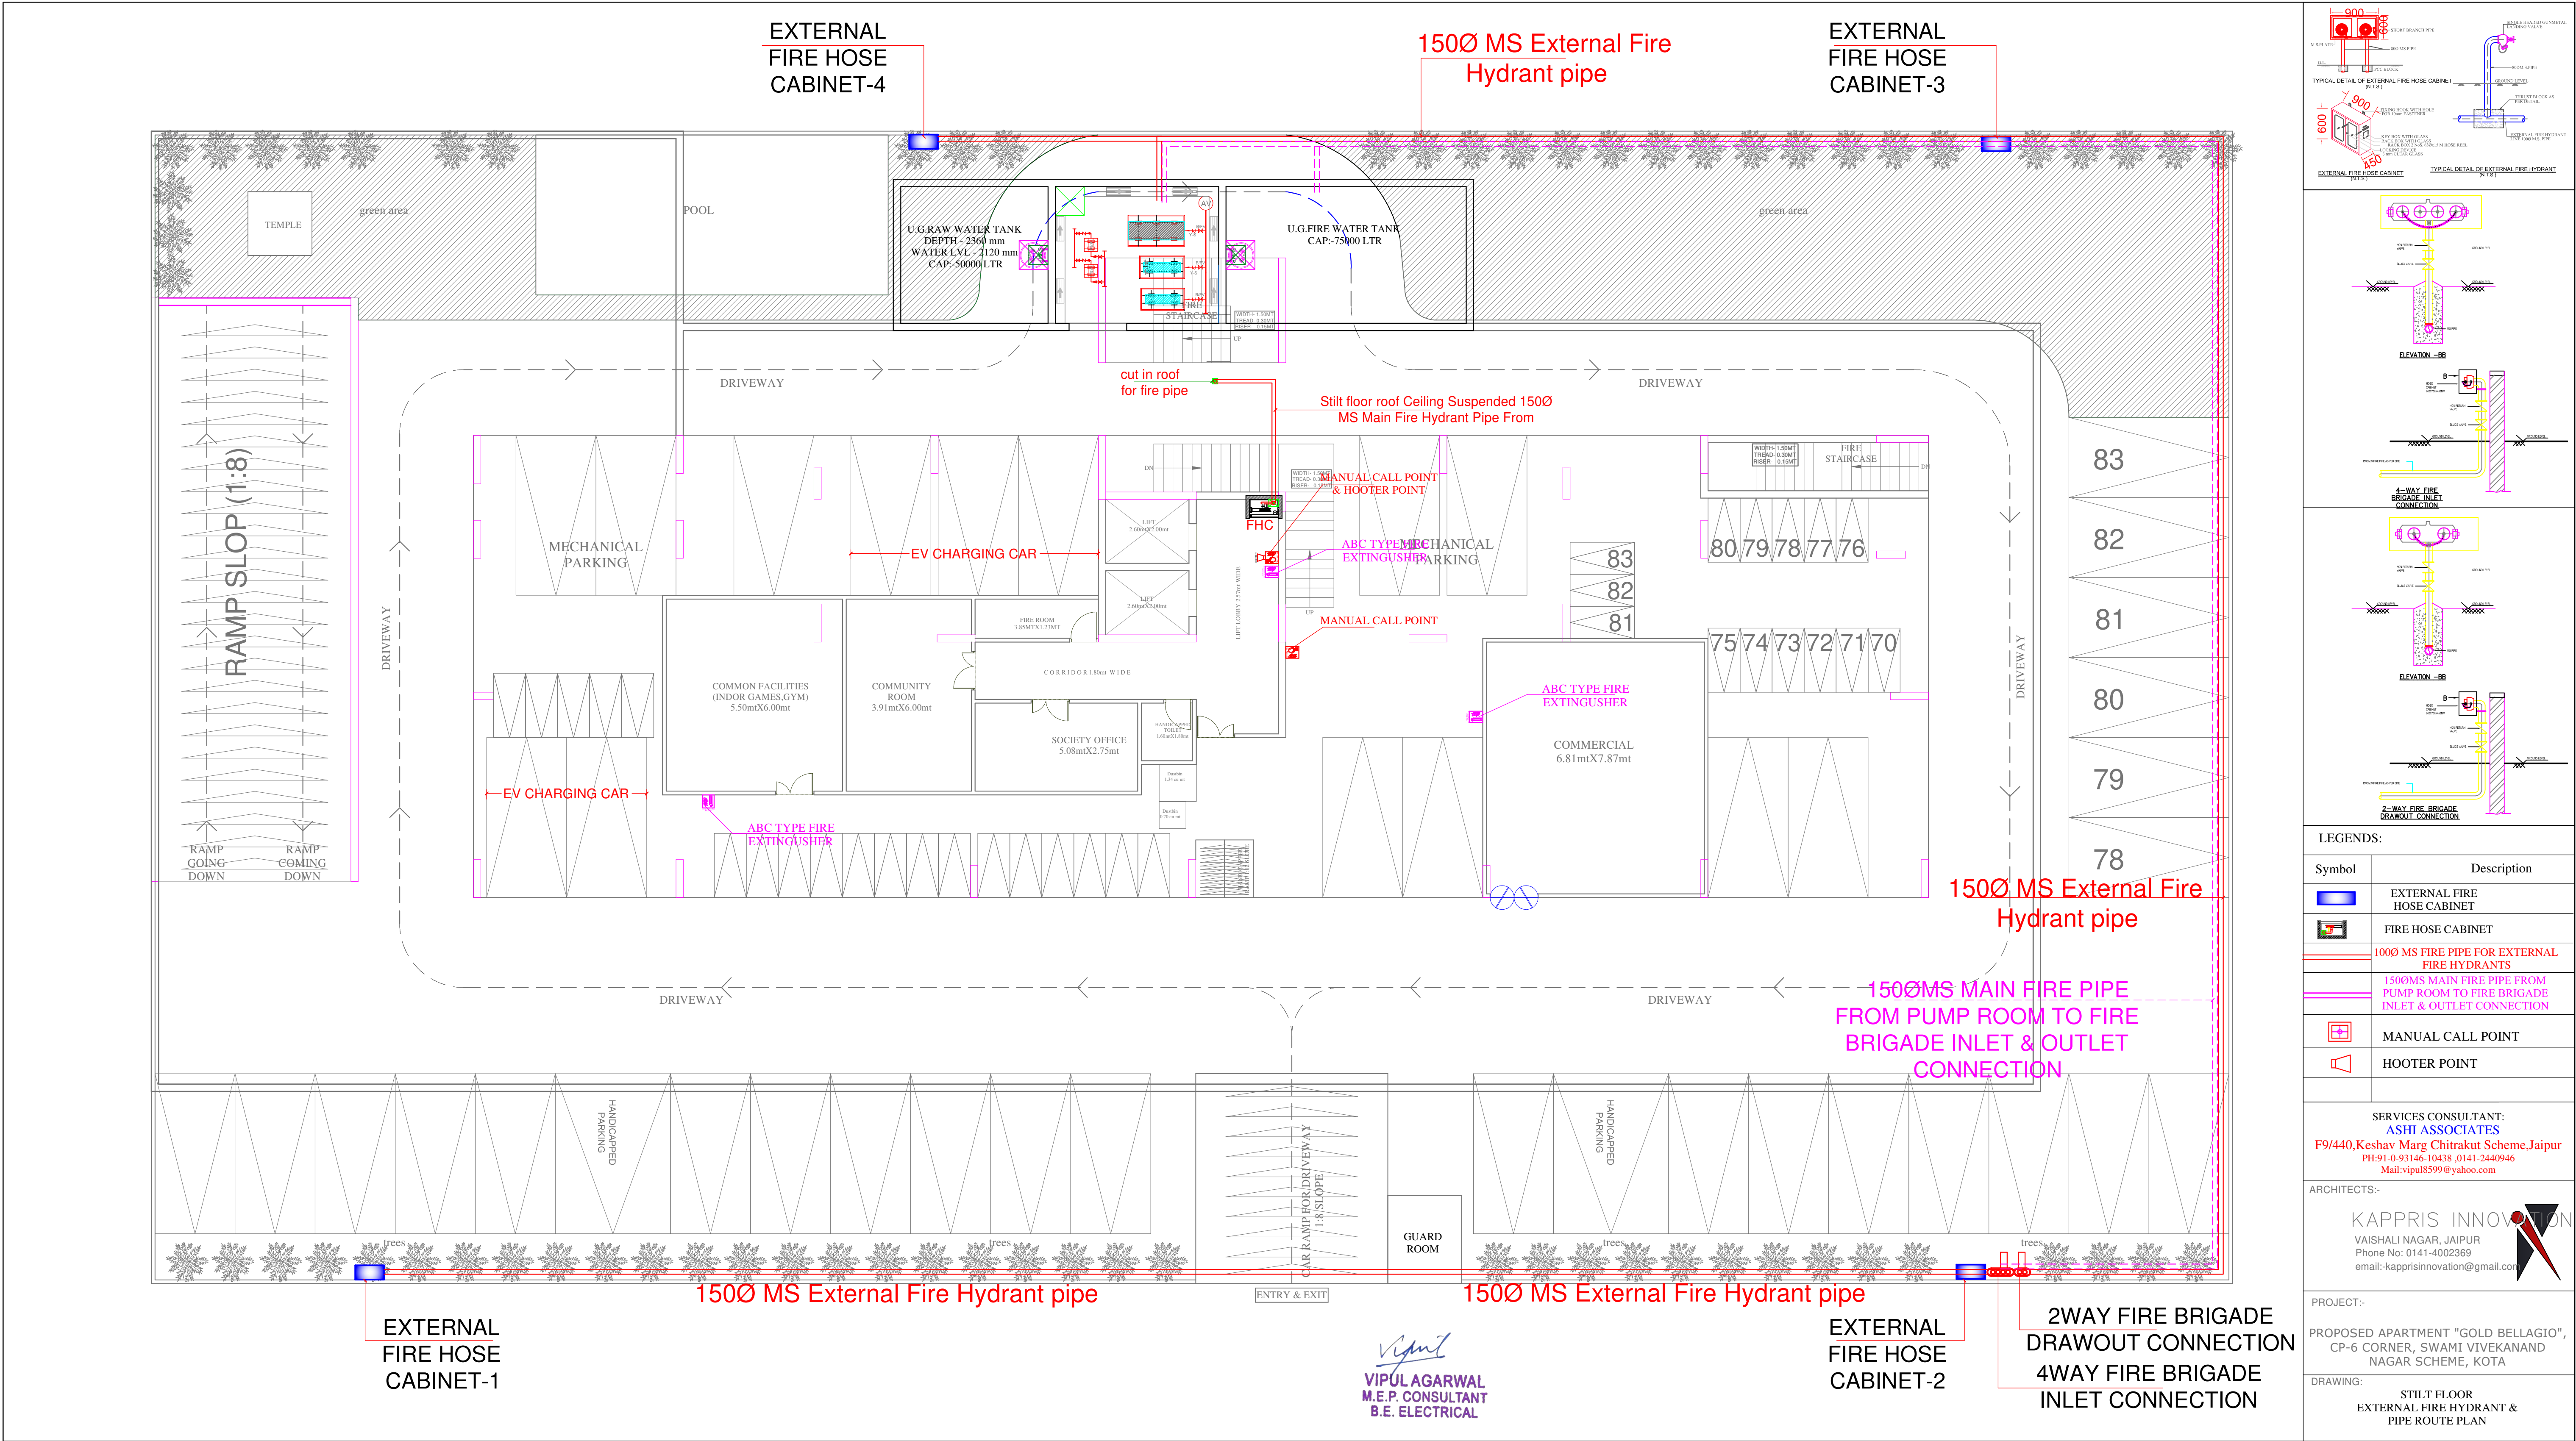

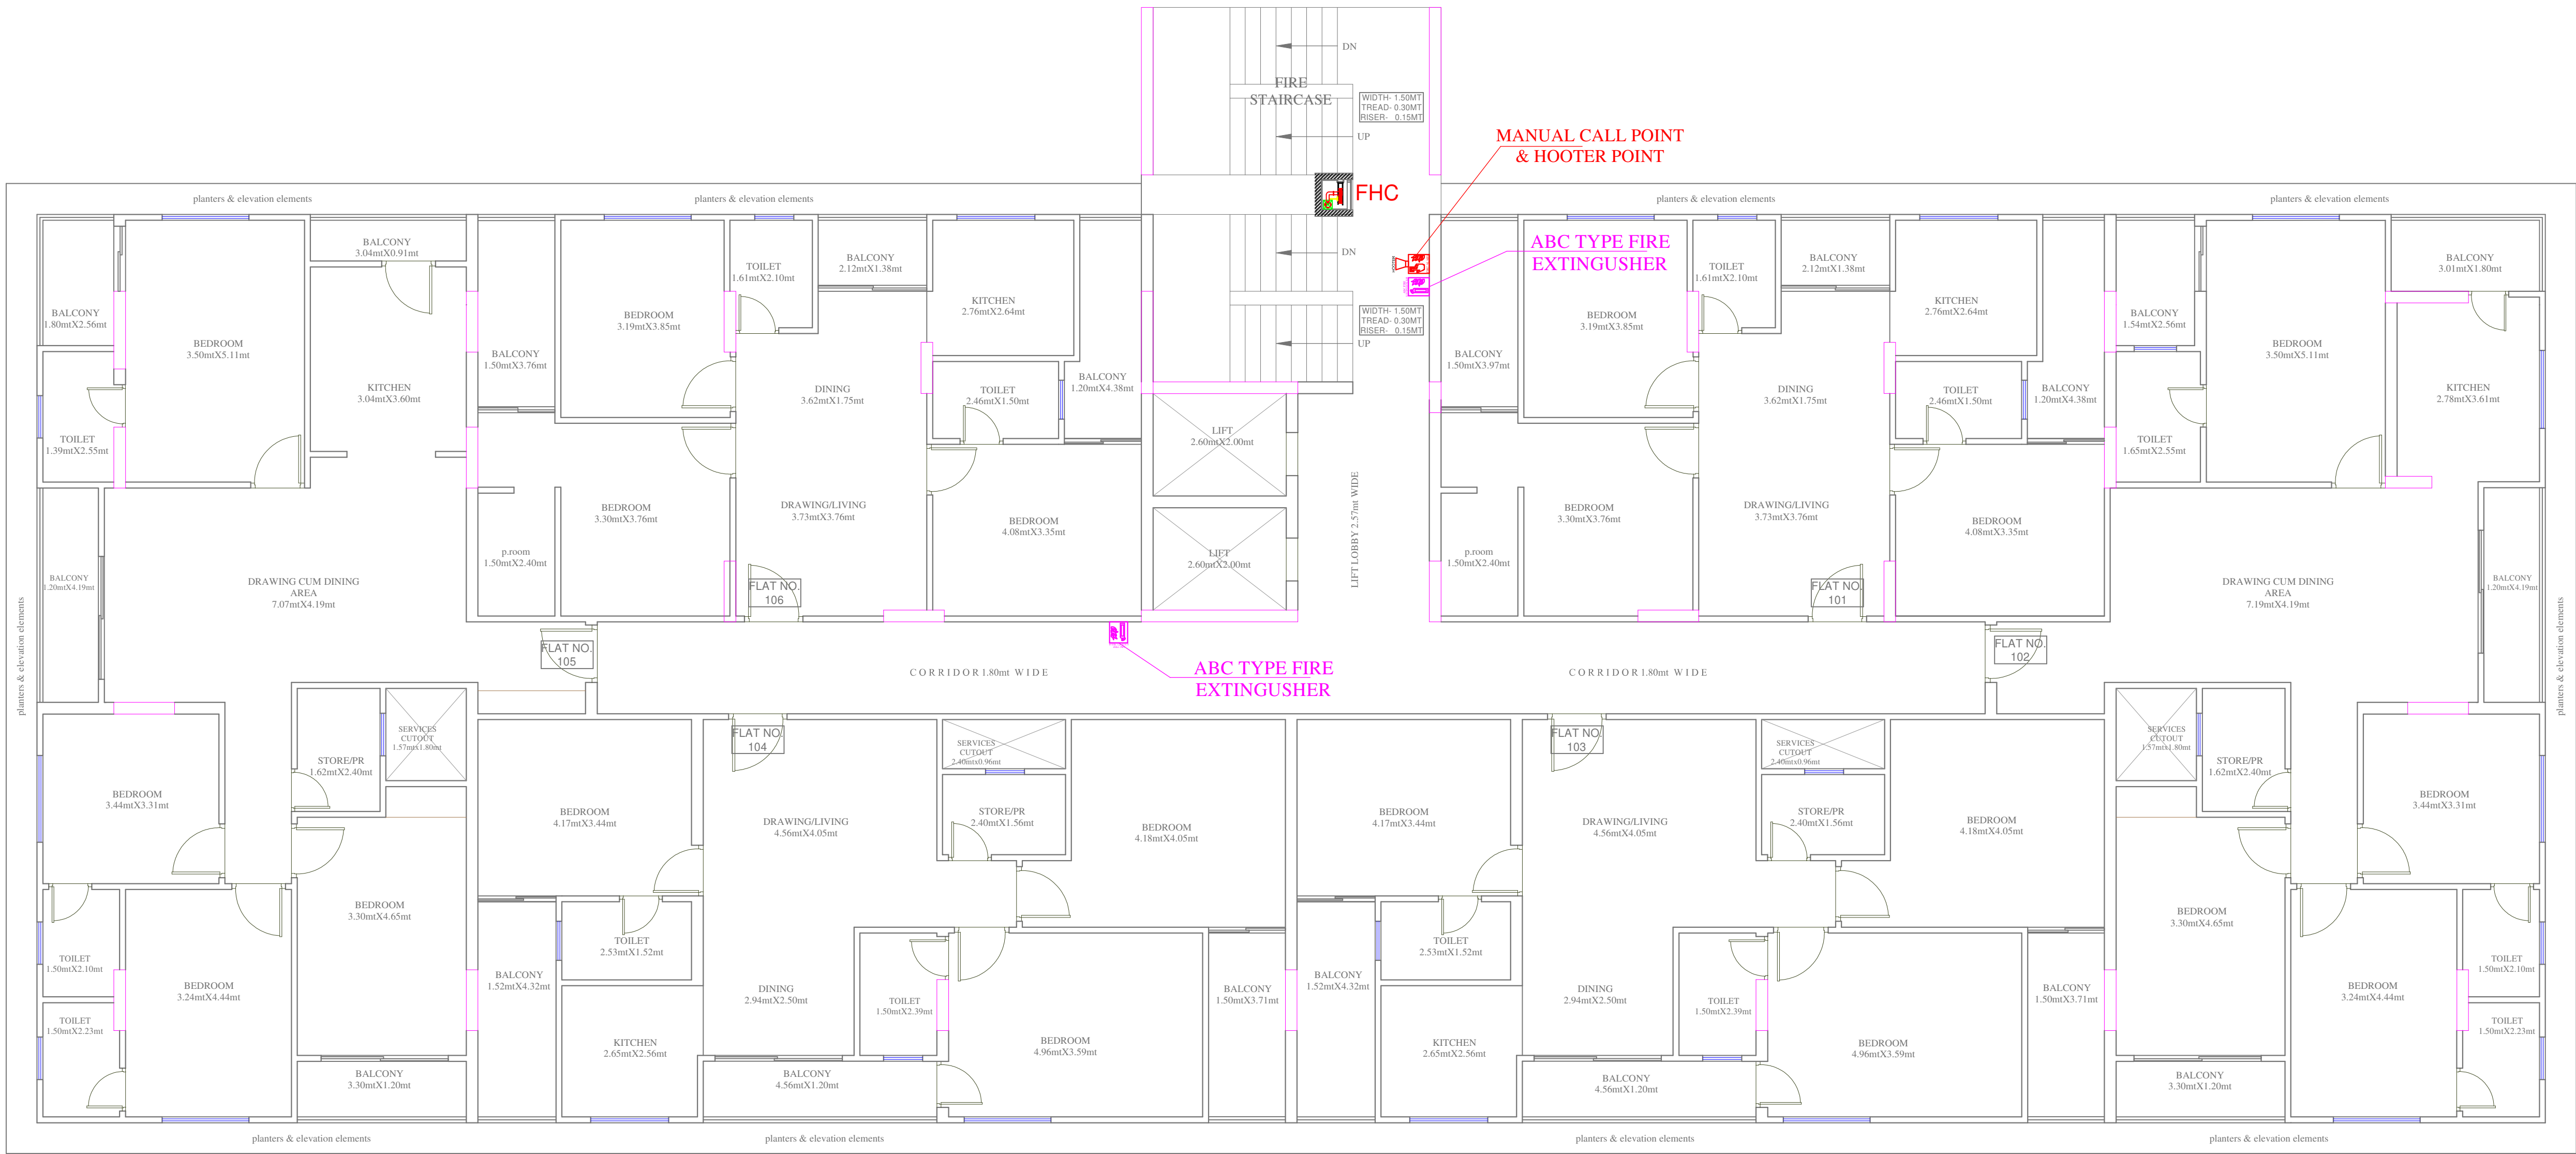

Vipul
VIPUL AGARWAL
M.E.P. CONSULTANT
B.E. ELECTRICAL

LEGENDS:


Symbol	Description
	ABC TYPE FIRE EXTINGUISHER
	MANUAL CALL POINT
	HOOTER POINT
	CONTROL VALVE
	FIRE HOSE CABINET

SERVICES CONSULTANT:
ASHI ASSOCIATES
F9/440,Keshav Marg Chitrakut Scheme,Jaipur
PH:91-0-93146-10438 ,0141-2440946
Mail:vipul8599@yahoo.com

ARCHITECTS:-
KAPPRIS INNOVATION
VAISHALI NAGAR, JAIPUR
Phone No: 0141-4002369
email:kapprisinnovation@gmail.com

PROJECT:-
PROPOSED APARTMENT "GOLD BELLAGIO",
CP-6 CORNER, SWAMI VIVEKANAND
NAGAR SCHEME, KOTA

DRAWING:
TYPICAL FLOOR PLAN
(GROUND, FIRST, FOURTH, SEVENTH, TENTH, FLOOR)
FHC,MCP HOOTER & FIRE EXTINGUISHER MARKED PLAN

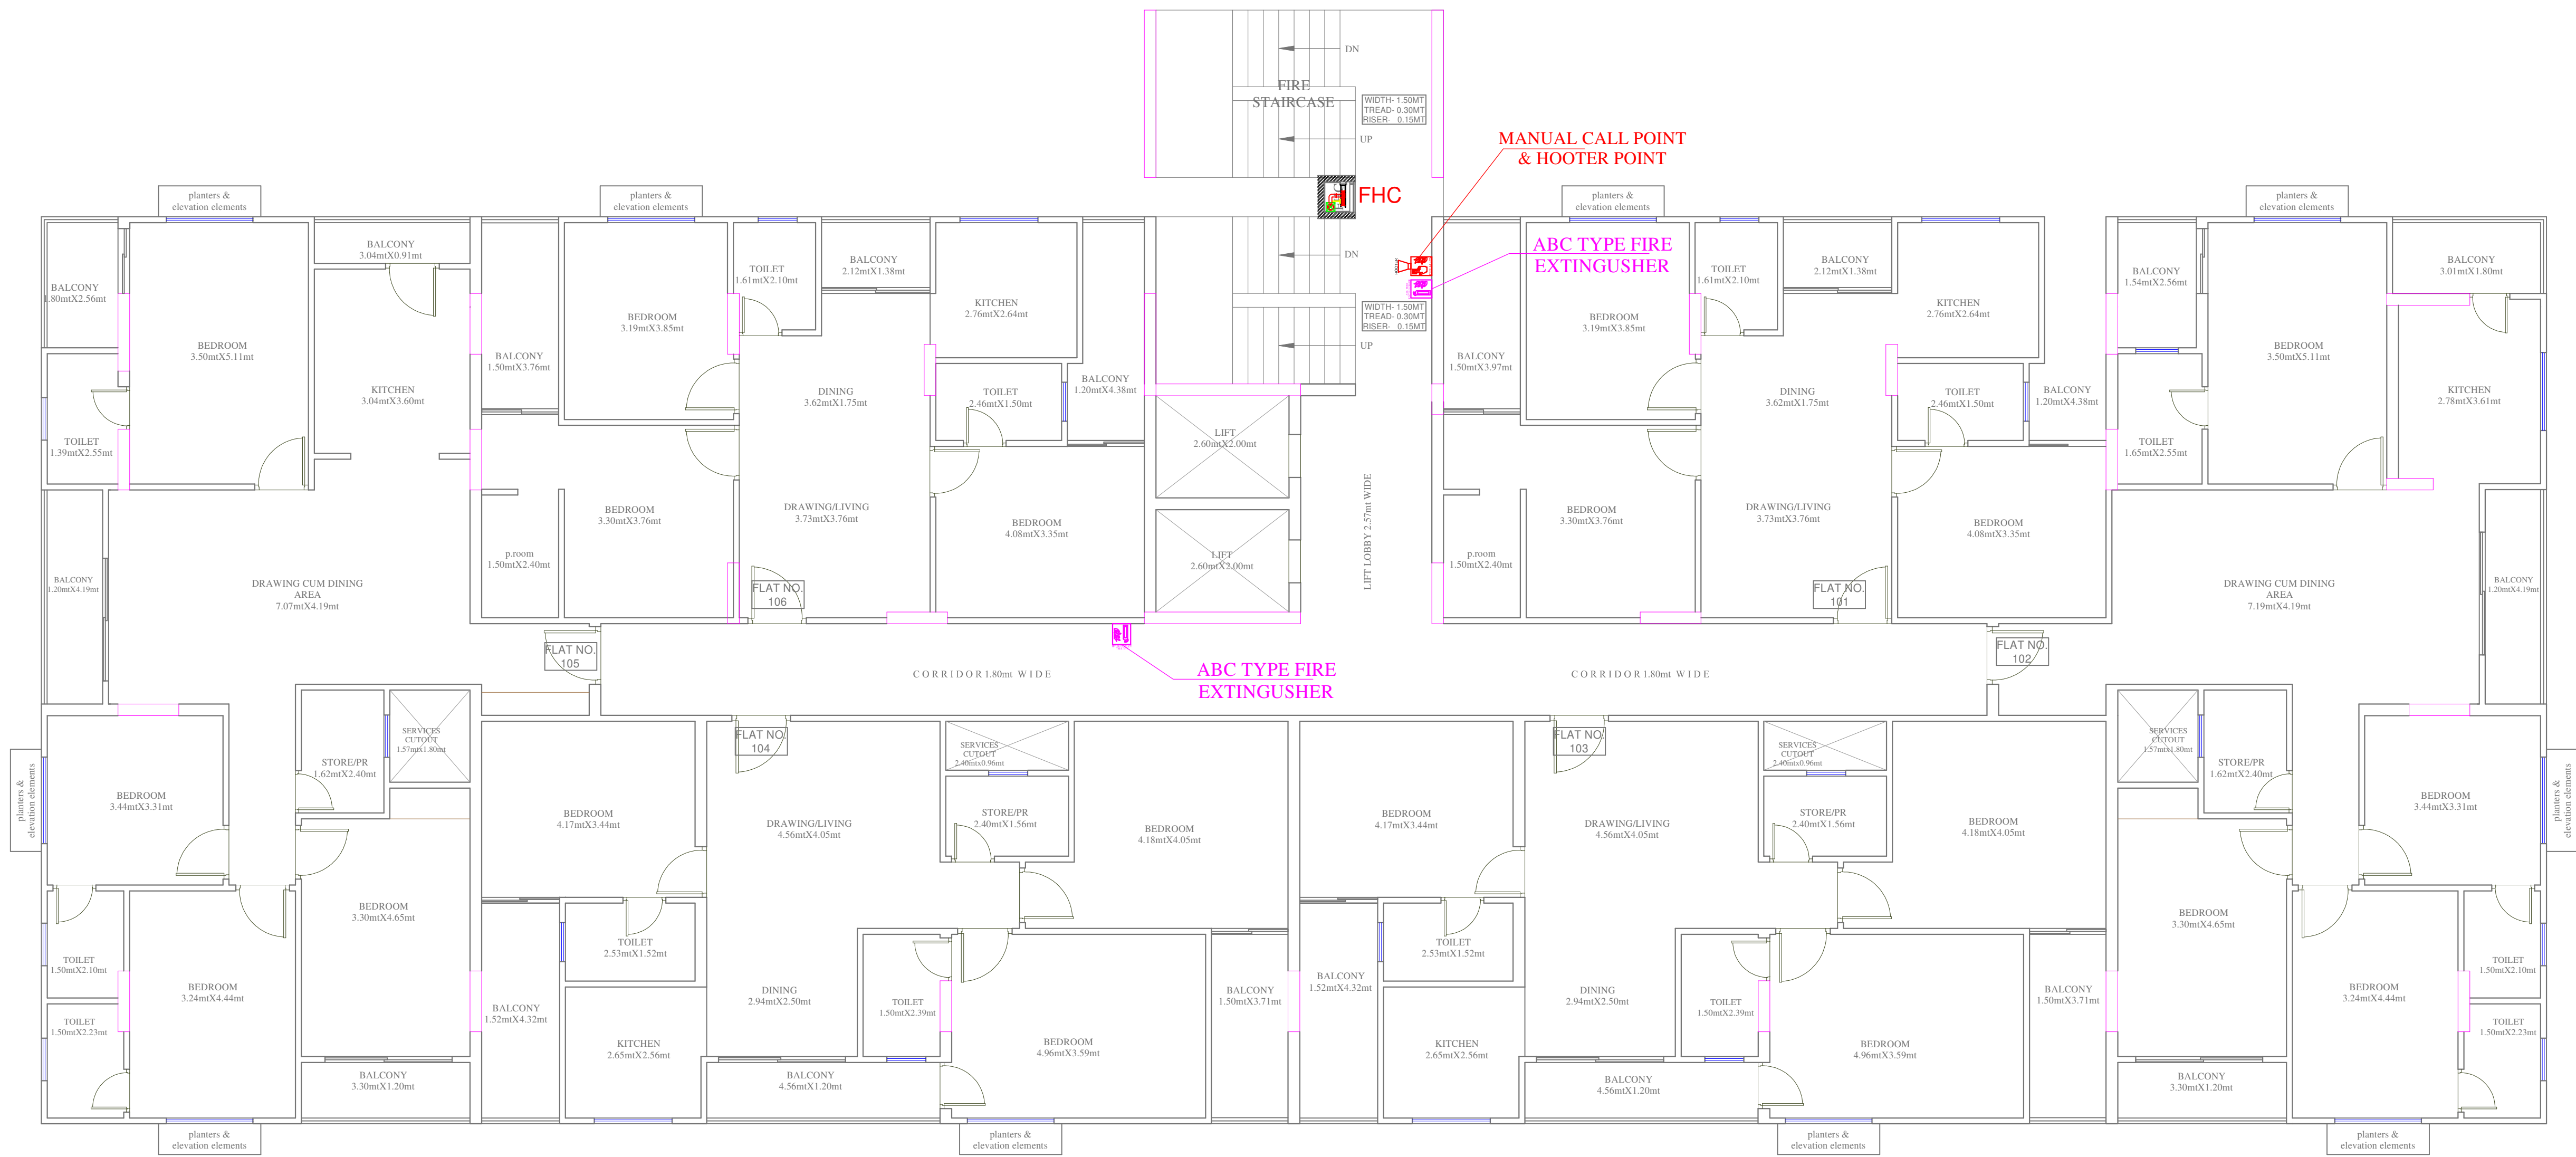

Vipul
VIPUL AGARWAL
M.E.P. CONSULTANT
B.E. ELECTRICAL

LEGENDS:

Symbol	Description
	ABC TYPE FIRE EXTINGUISHER
	MANUAL CALL POINT
	HOOTER POINT
	CONTROL VALVE
	FIRE HOSE CABINET


SERVICES CONSULTANT:
ASHI ASSOCIATES
F9/440,Keshav Marg Chitrakut Scheme,Jaipur
PH:91-0-93146-10438 ,0141-2440946
Mail:vipul8599@yahoo.com

ARCHITECTS:-
KAPPRIS INNOVATION
VAISHALI NAGAR, JAIPUR
Phone No: 0141-4002369
email:-kapprisinnovation@gmail.com

PROJECT:-

PROPOSED APARTMENT "GOLD BELLAGIO",
CP-6 CORNER, SWAMI VIVEKANAND
NAGAR SCHEME, KOTA

DRAWING:
TYPICAL FLOOR PLAN
(SECOND, THIRD, FIFTH, SIXTH, EIGHT, NINTH,
ELEVENTH, TWELFTH FLOOR)
FHC,MCP HOOTER & FIRE EXTINGUISHER MARKED PLAN

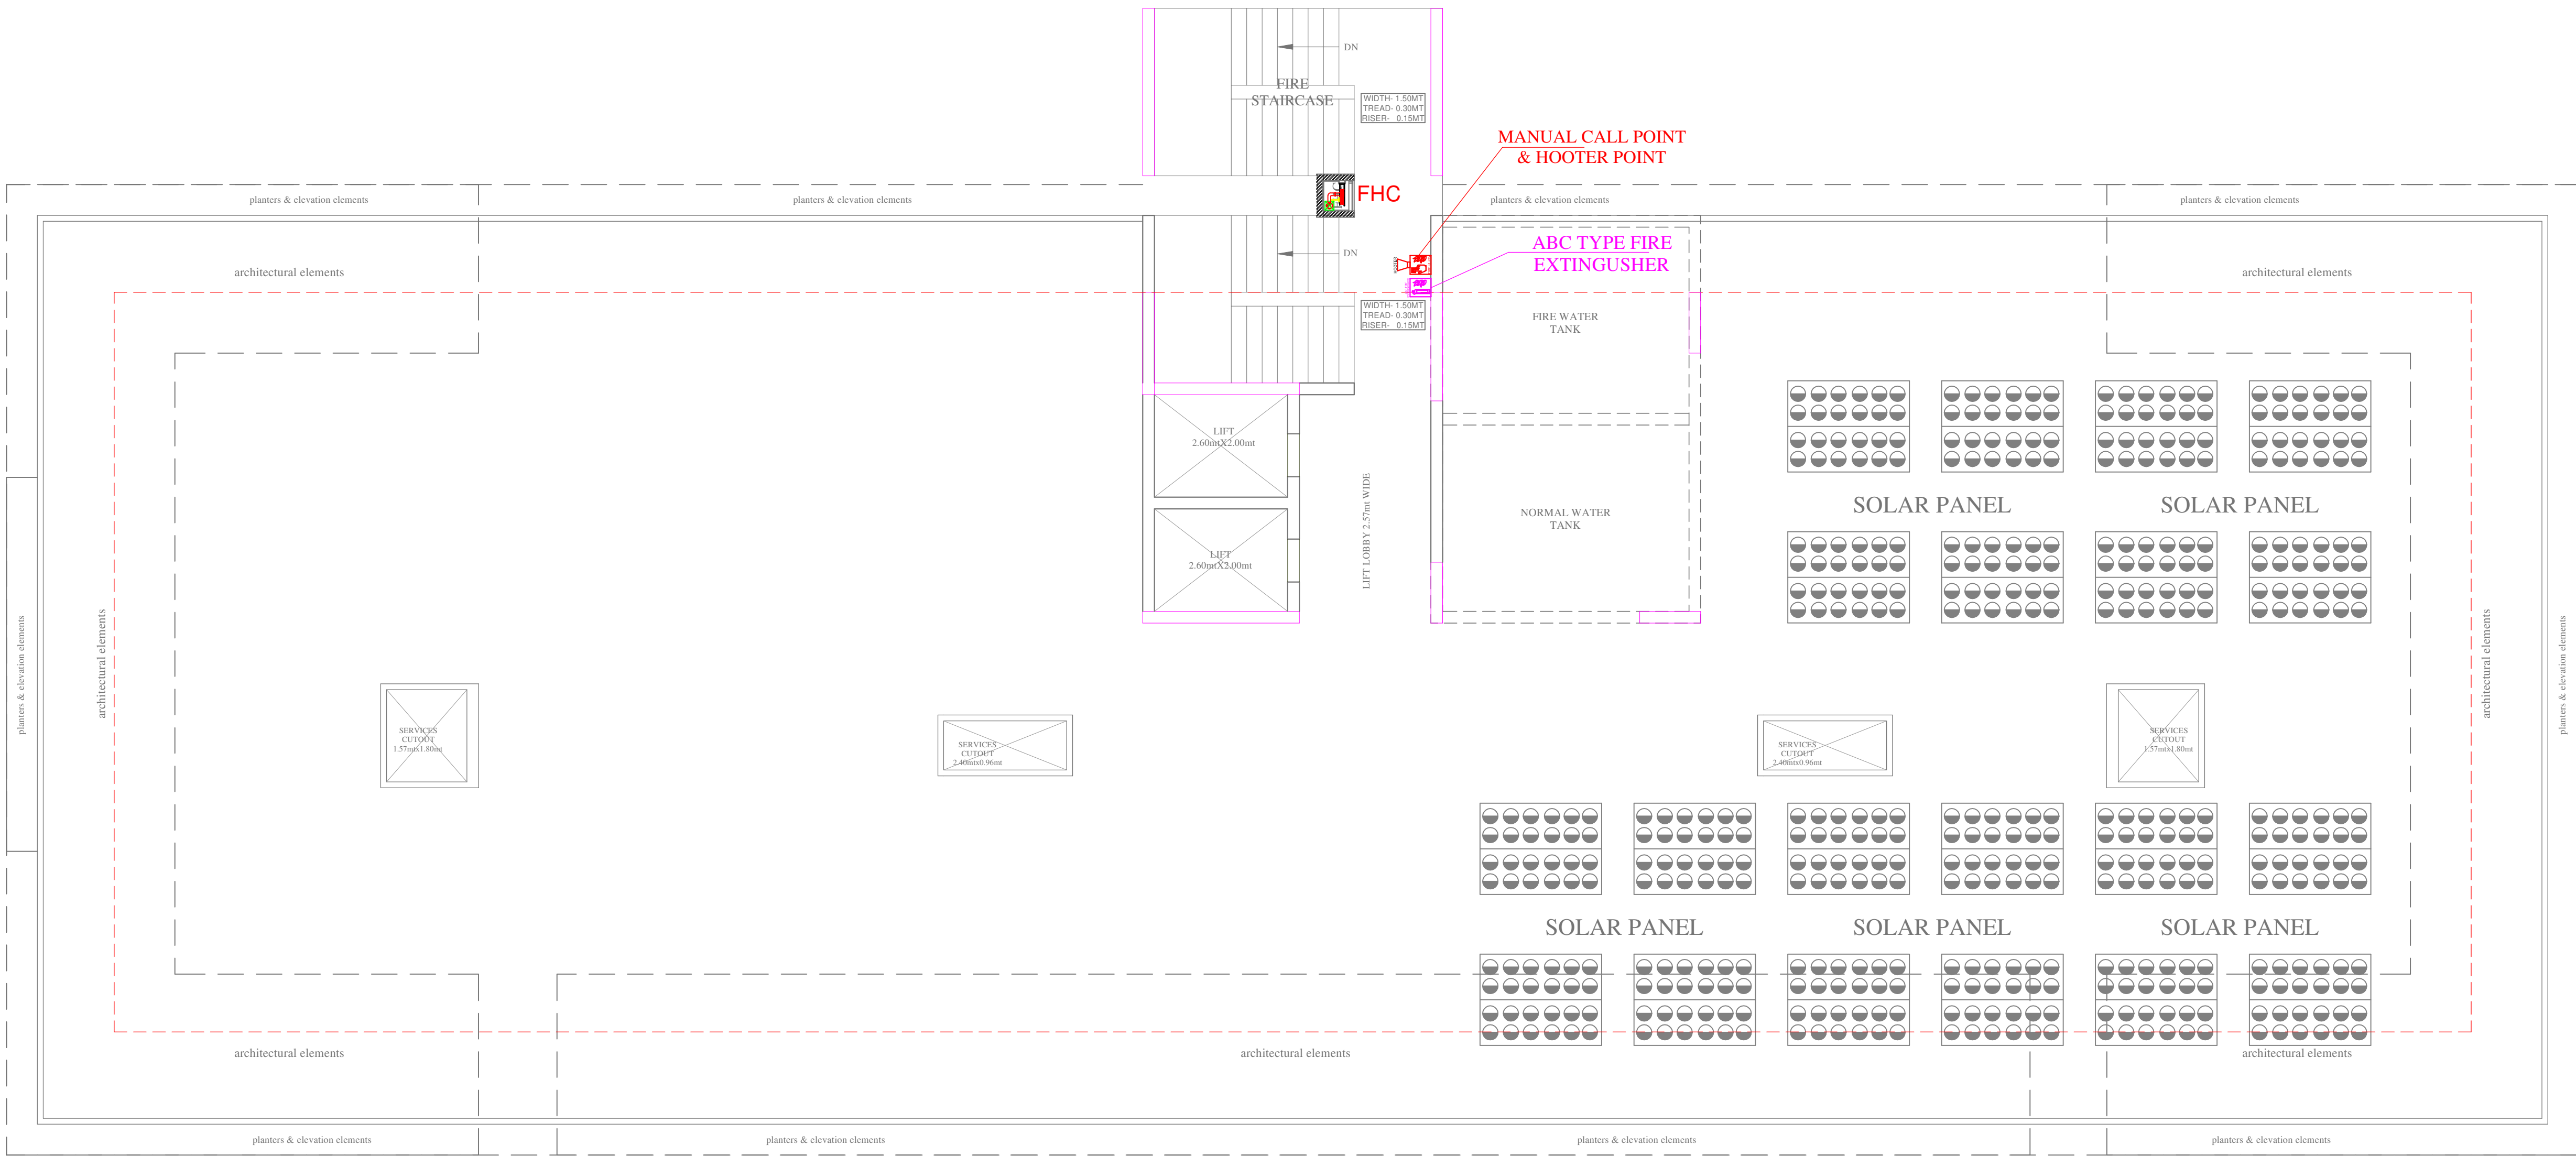

TERRACE FLOOR PLAN

Vipul
VIPUL AGARWAL
M.E.P. CONSULTANT
B.E. ELECTRICAL

LEGENDS:


Symbol	Description
	ABC TYPE FIRE EXTINGUISHER
	MANUAL CALL POINT
	HOOTER POINT
	CONTROL VALVE
	FIRE HOSE CABINET

SERVICES CONSULTANT:
ASHI ASSOCIATES
F9/440,Keshav Marg Chitrakut Scheme,Jaipur
PH:91-0-93146-10438 ,0141-2440946
Mail:vipul8599@yahoo.com

ARCHITECTS:-
 KAPPRIS INNOVATION
VAISHALI NAGAR, JAIPUR
Phone No: 0141-4002369
email:-kapprisinnovation@gmail.com

PROJECT:-
PROPOSED APARTMENT "GOLD BELLAGIO",
CP-6 CORNER, SWAMI VIVEKANAND
NAGAR SCHEME, KOTA



DRAWING:
TERRACE FLOOR PLAN
FHC,MCP HOOTER & FIRE EXTINGUISHER MARKED PLAN

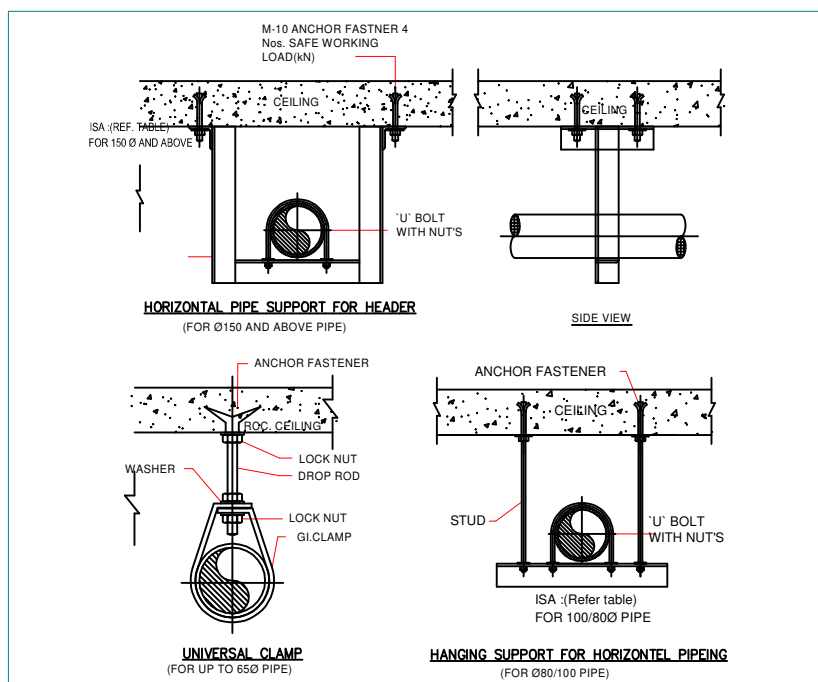


REF. TABLE:-

PIPE DIA(MIN.)	CLAMP DIM (mm.)	DROP ROD DIM (mm)	U BOLT DIA(mm)	ANCHOR DIM(mm)	SPACING (M)
Q25	20x1.2	M8	8	M8	3.0
Q32	20x1.2	M8	8	M8	3.0
Q40	20x1.2	M8	8	M8	3.0
Q50	25x2.0	M8	8	M8	3.0
Q65	25x2.0	M10	8	M10	3.0
Q80	25x2.5	M10	10	M10	3.0
PIPE DIA(MIN.)	CLAMP SIZE (mm)	DROP ROD DIM (mm)	U BOLT DIA(mm)	ANCHOR DIM(mm)	SPACING (M)
Q65	50x50x6	M8	8	M8	3.0
Q80	50x50x6	M10	10	M10	3.0
Q100	50x50x6	M12	10	M12	3.0
Q150	50x50x6	M12	12	M12	3.0
Q200	65x65x6	M12	12	M12	3.0

DRAWING: TYP. DETAIL FOR FIRE FIGHTING HORIZONTAL PIPEING & CLAMP

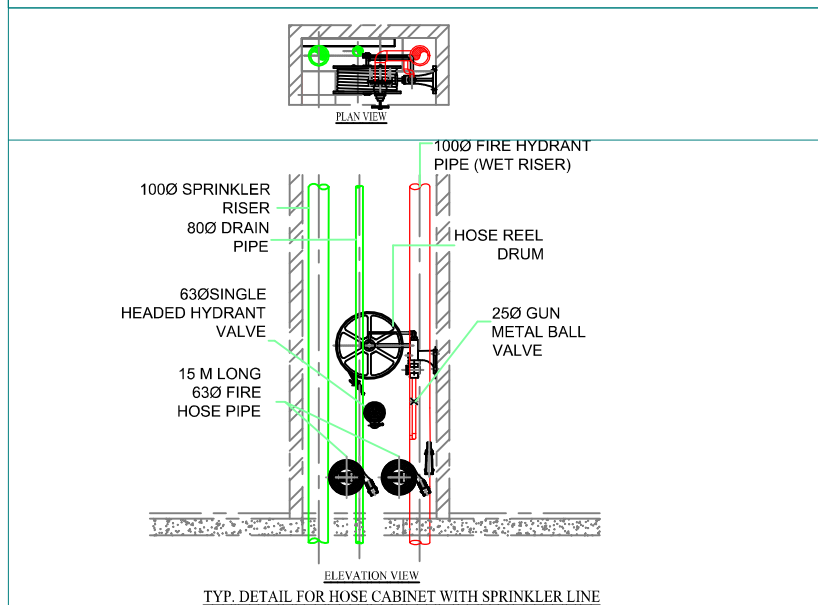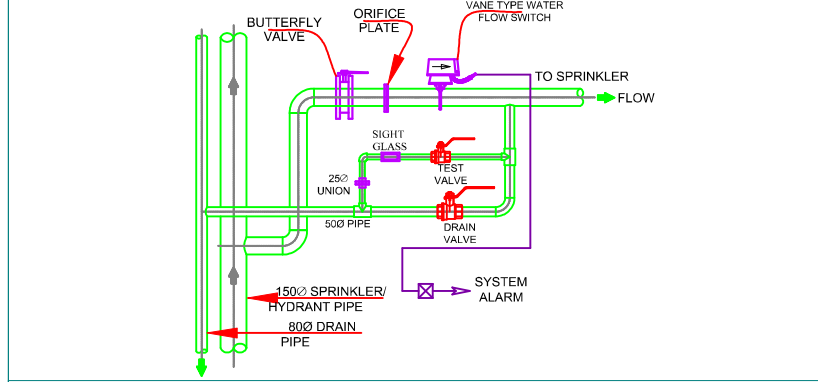

DRAWING: TYP. DETAIL FOR FIRE CABINET
FHC-2


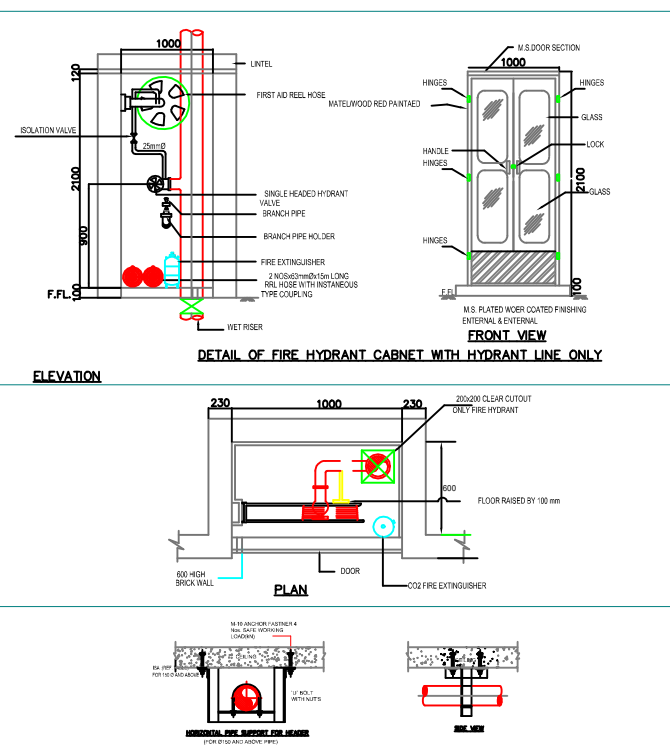


TYPICAL DETAIL FOR FIRE HOSE CABINET-1
SCALE: NTS
FHC-1

S.no.	Symbol	Description	Size inmm
1.		Sluice Valve	150Ø
2.		Butter fly Valve	200Ø
3.		Butter fly Valve	150Ø
4.		Butter fly Valve	100Ø
5.		Butter fly Valve	80Ø
6.		Non Return Valve	200Ø
7.		Non Return Valve	150Ø
8.		Non Return Valve	100Ø
9.		Non Return Valve	80Ø
10.		Landing Valve Single headed	63Ø
11.		Ball Valve	50Ø
12.		Ball Valve	25Ø
13.		Flow Switch	
14.		Y-Strainer	200Ø
15.		External Hydrant	
16.		Pressure Guage	

PUMPS DETAILS

S.NO.	DESCRIPTION	CAPACITY	HEAD	PRIME MOVER
P1	STAND BY PUMP	2280 LPM	88 M	DIESEL ENGINE
P2	MAIN HYDRANT CUM SPRINKLER PUMP	2280 LPM	88 M	ELECT.MOTOR
P3	JOCKEY PUMP (FOR HYDRANT SYSTEM)	180 LPM	88 M	ELECT.MOTOR

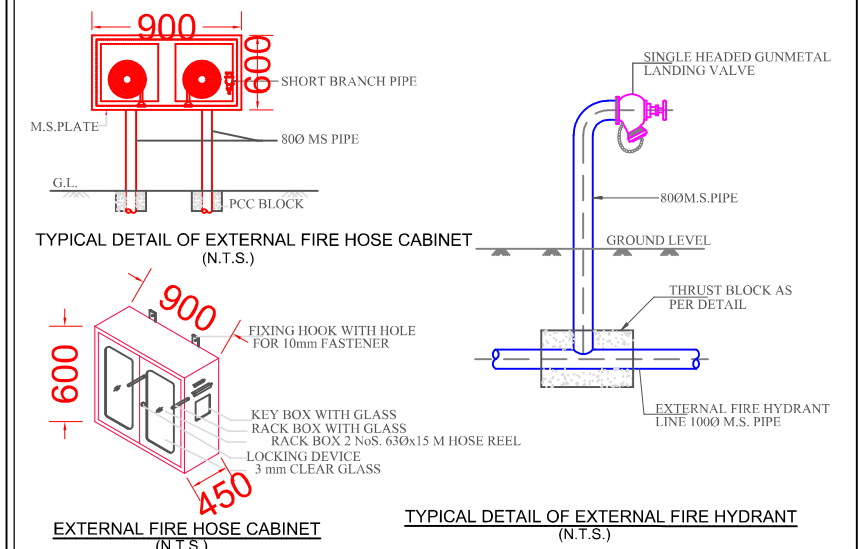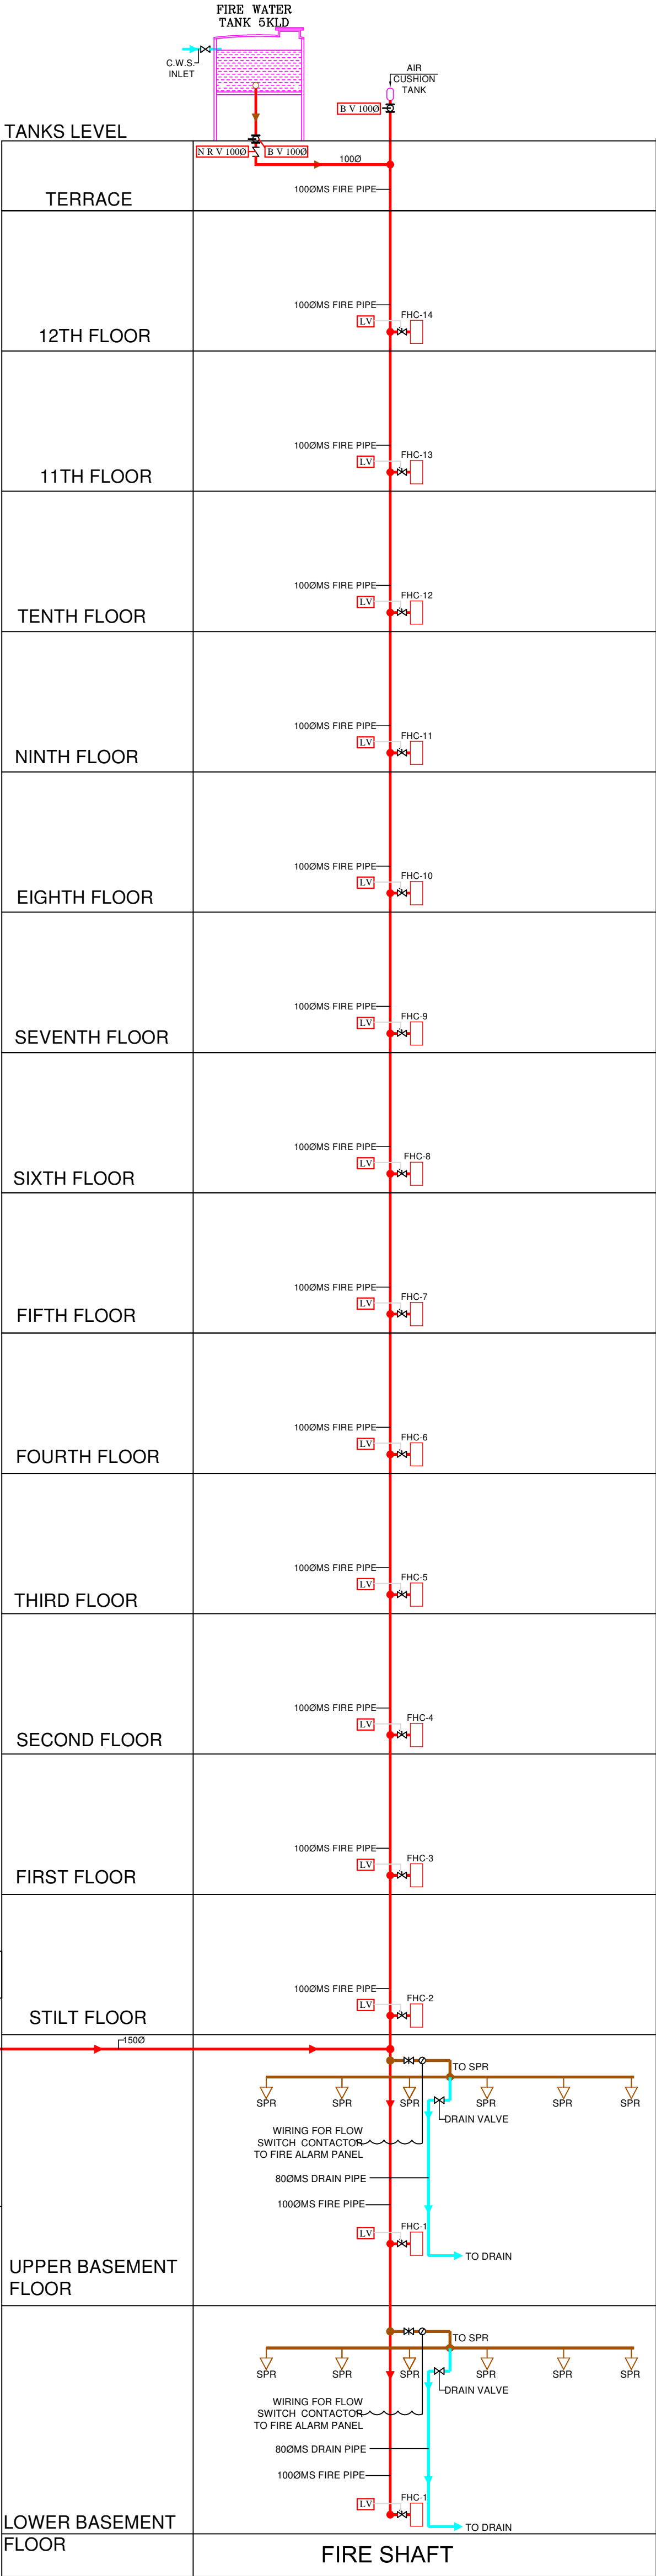


VIPUL AGARWAL
M.E.P. CONSULTANT
B.E. ELECTRICAL

SERVICES CONSULTANT:
ASHI ASSOCIATES
F9/440, Keshav Marg Chitrakut Scheme, Jaipur
PH: 91-0-93146-10438, 0141-2440946
Mail: vipul8599@yahoo.com

ARCHITECTS:-
KAPPRIS INNOVATION
VAISHALI NAGAR, JAIPUR
Phone No: 0141-4002369
email: kapprisinnovation@gmail.com

PROJECT:-
PROPOSED APARTMENT "GOLD BELLAGIO",
CP-6 CORNER, SWAMI VIVEKANAND
NAGAR SCHEME, KOTA

DRAWING:
UPPER BASEMENT FIRE SPRINKLER
PIPE & MCP, HOOTER PLAN

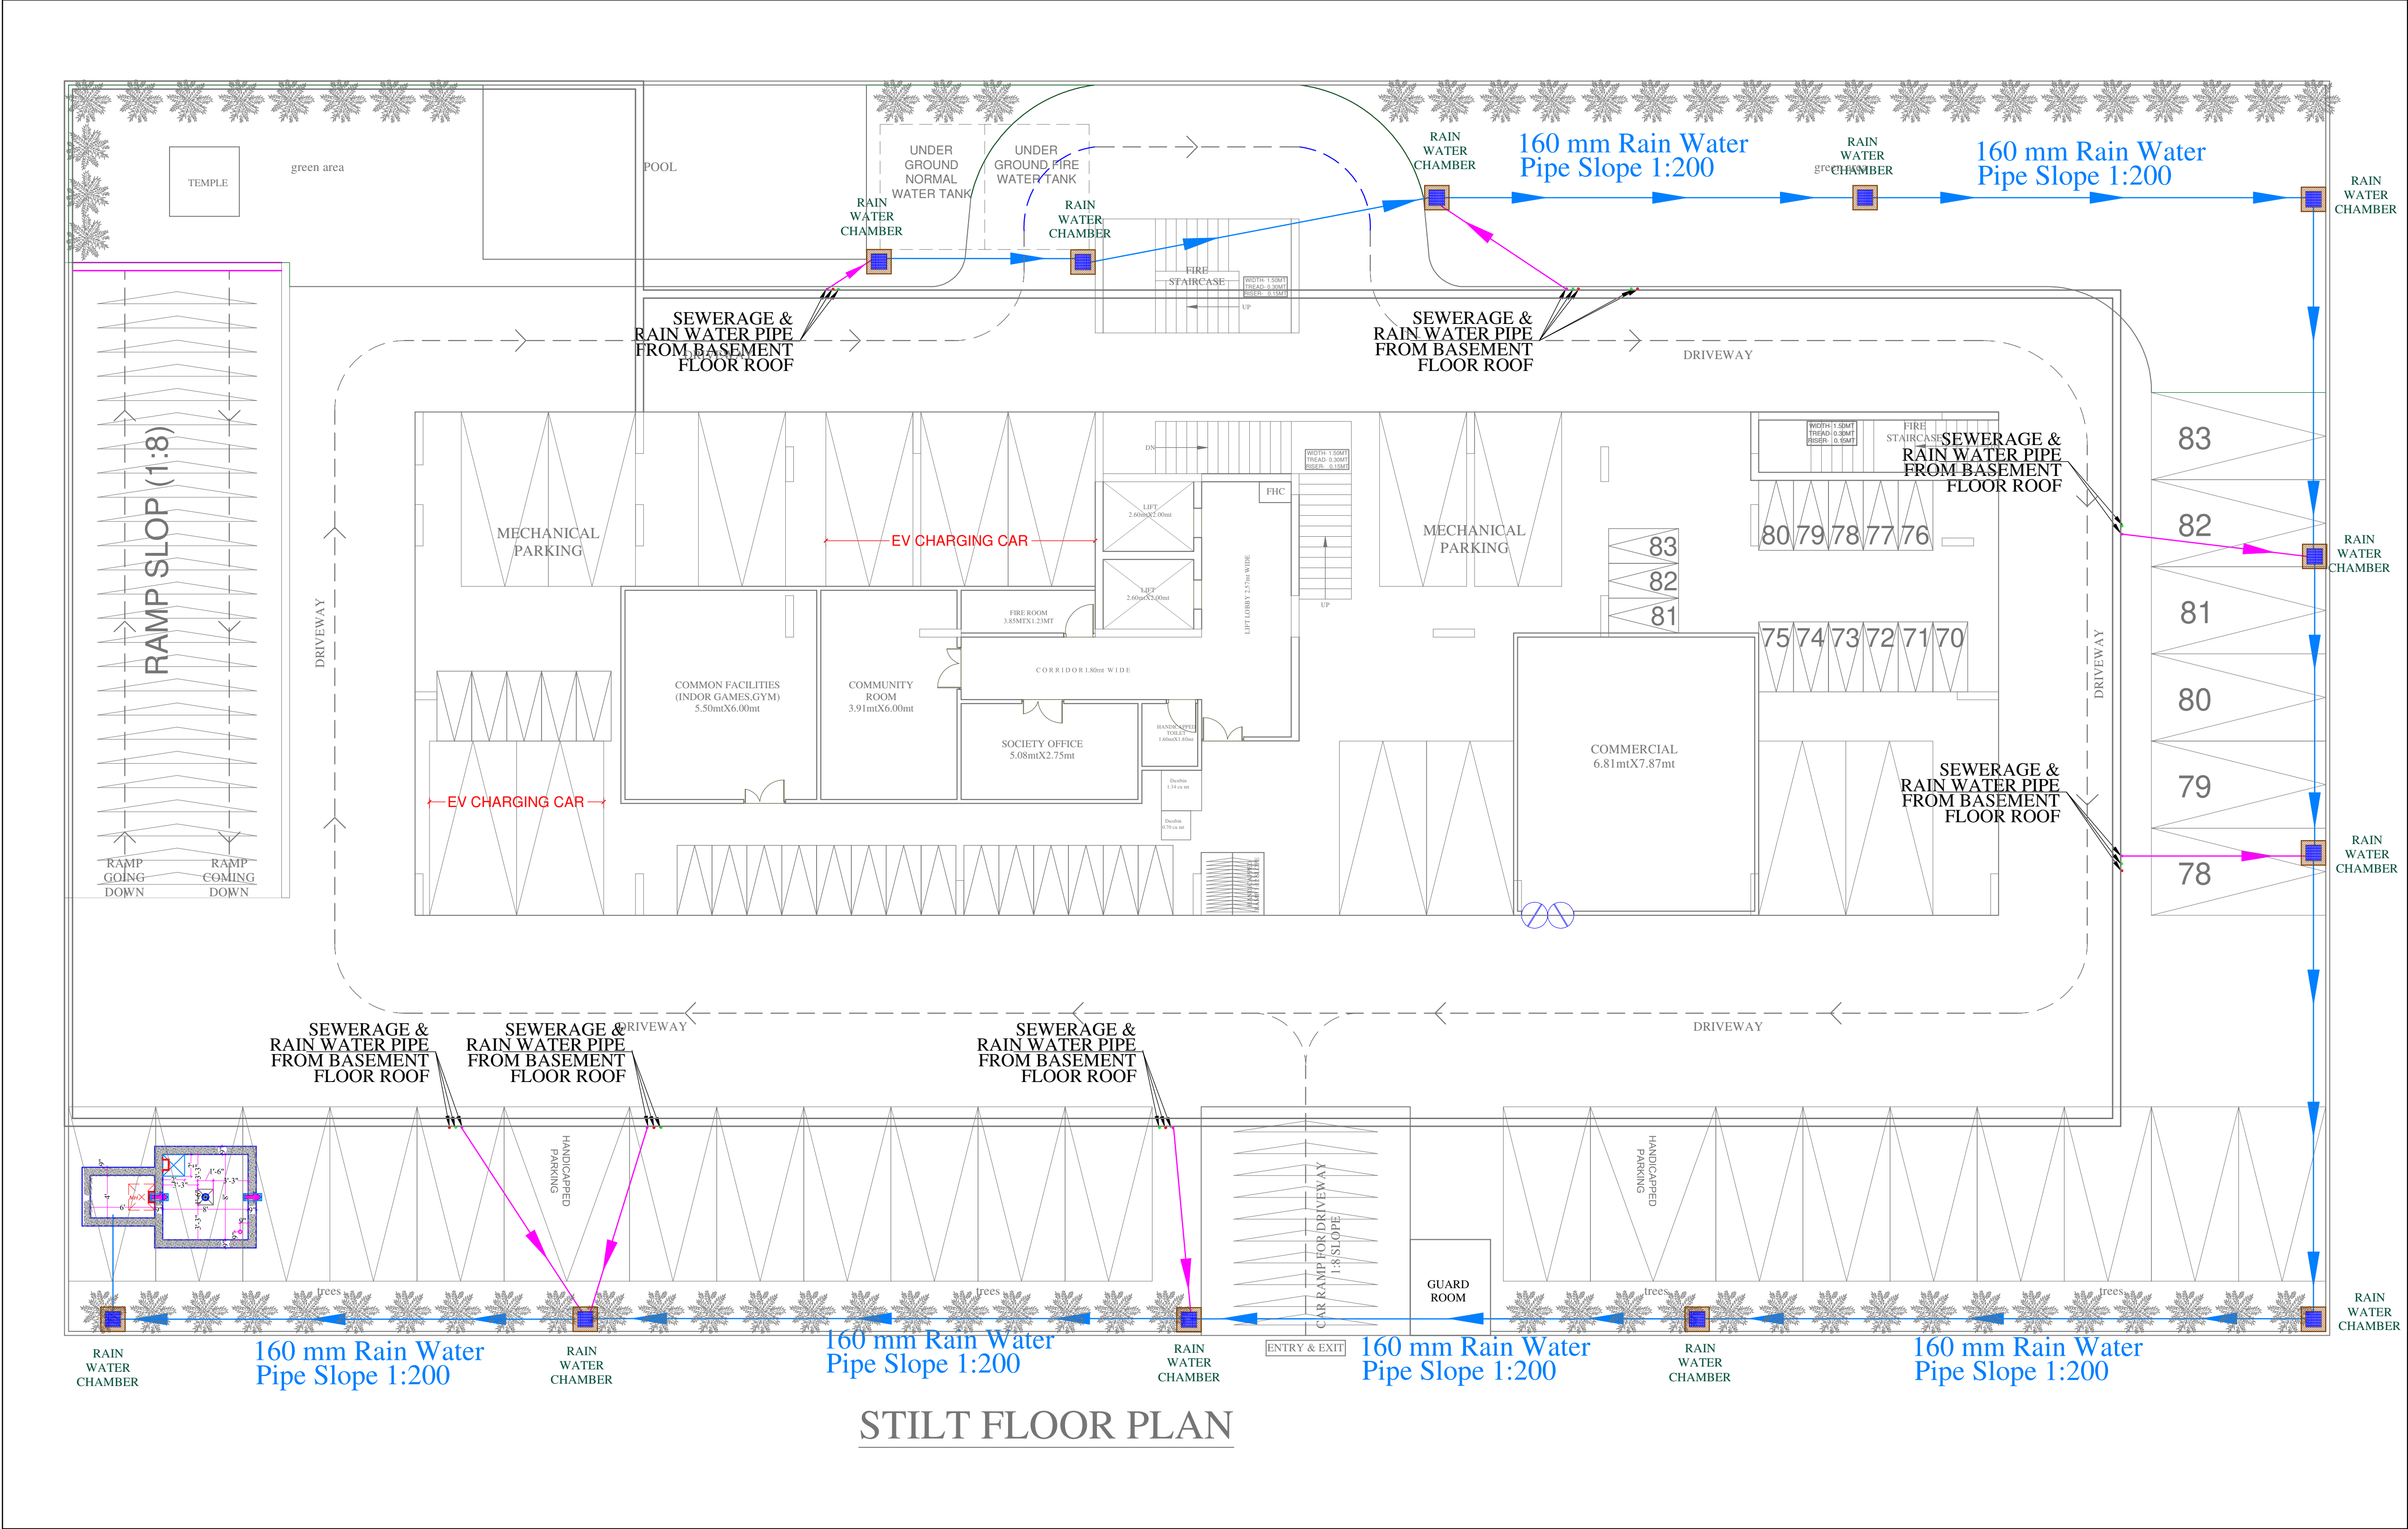

SYMBOL	DESCRIPTION
	110 mm Soil Waste Water Pipe
	110 mm Waste Water Pipe
	110 mm Rain Water Pipe
	160 mm Rain Water Pipe Slope 1:200
	110 mm Soil Waste Water Pipe Slope 1:150
	110 mm Waste Water Pipe Slope 1:150
	110 mm Rain Water Pipe Slope 1:200
	RAIN WATER CHAMBER
	Flow Direction


SERVICES CONSULTANT:
ASHI ASSOCIATES
F 9 / 440 , Keshav Marg
Chitrakut Scheme,Jaipur
PH:91-0-93146-10438 ,0141-2440946
Mail:vipul8599@yahoo.com

VIPUL AGARWAL
M.E.P. CONSULTANT
B.E. ELECTRICAL

ARCHITECTS:-
KAPPRIS INNOVATION
VAISHALI NAGAR, JAIPUR
Phone No: 0141-4002369
email:-kapprisinnovation@gmail.com


PROJECT:-
PROPOSED APARTMENT "GOLD BELLAGIO", CP-6 CORNER, SWAMI VIVEKANAND NAGAR SCHEME, KOTA

DRAWING:
EXTERNAL RAIN WATER PIPE ROUTE PLAN

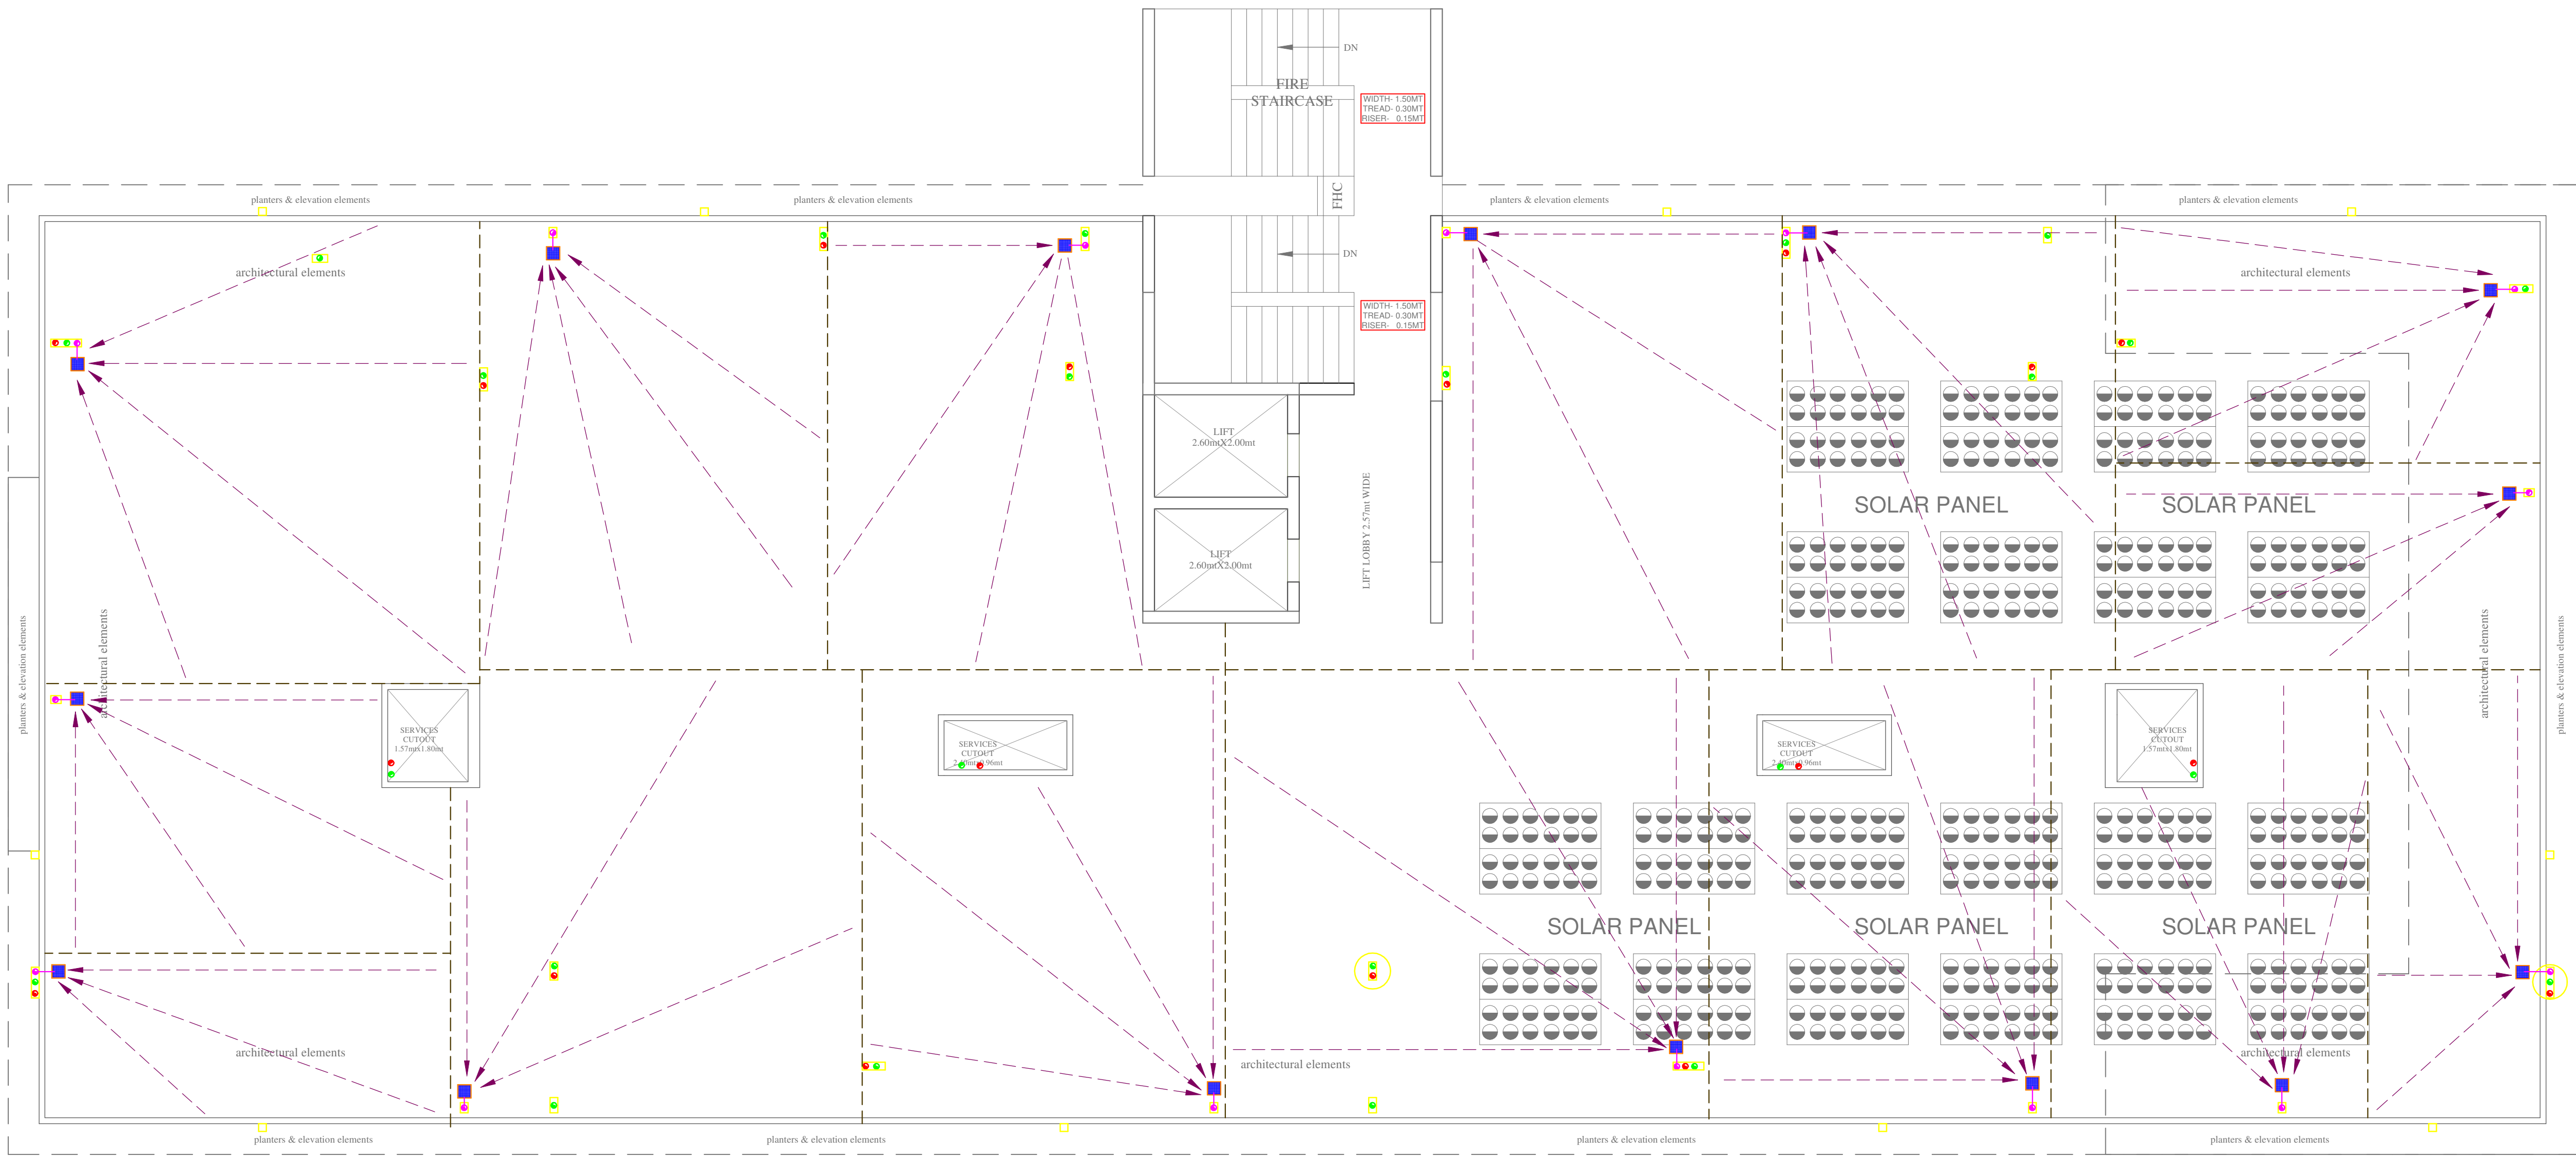

TERRACE FLOOR PLAN

SYMBOL	DESCRIPTION
	110 mm Soil Waste Water Pipe
	110 mm Waste Water Pipe
	110 mm Rain Water Pipe
	110 mm Rain Water Pipe
	Khurrah-9"X9"
	Ridge Line
	Flow Direction
 VIPUL AGARWAL M.E.P. CONSULTANT B.E. ELECTRICAL	
SERVICES CONSULTANT: ASHI ASSOCIATES F 9 / 440 , Keshav Marg Chitrakut Scheme,Jaipur PH:91-0-93146-10438 ,0141-2440946 Mail:vipul8599@yahoo.com	
 ARCHITECTS:- KAPPRIS INNOVATION VAISHALI NAGAR, JAIPUR Phone No: 0141-4002369 email:-kapprisinnovation@gmail.com	
PROJECT:- PROPOSED APARTMENT "GOLD BELLAGIO", CP-6 CORNER, SWAMI VIVEKANAND NAGAR SCHEME, KOTA	
DRAWING: TERRACE FLOOR RAIN WATER SLOPE PLAN	

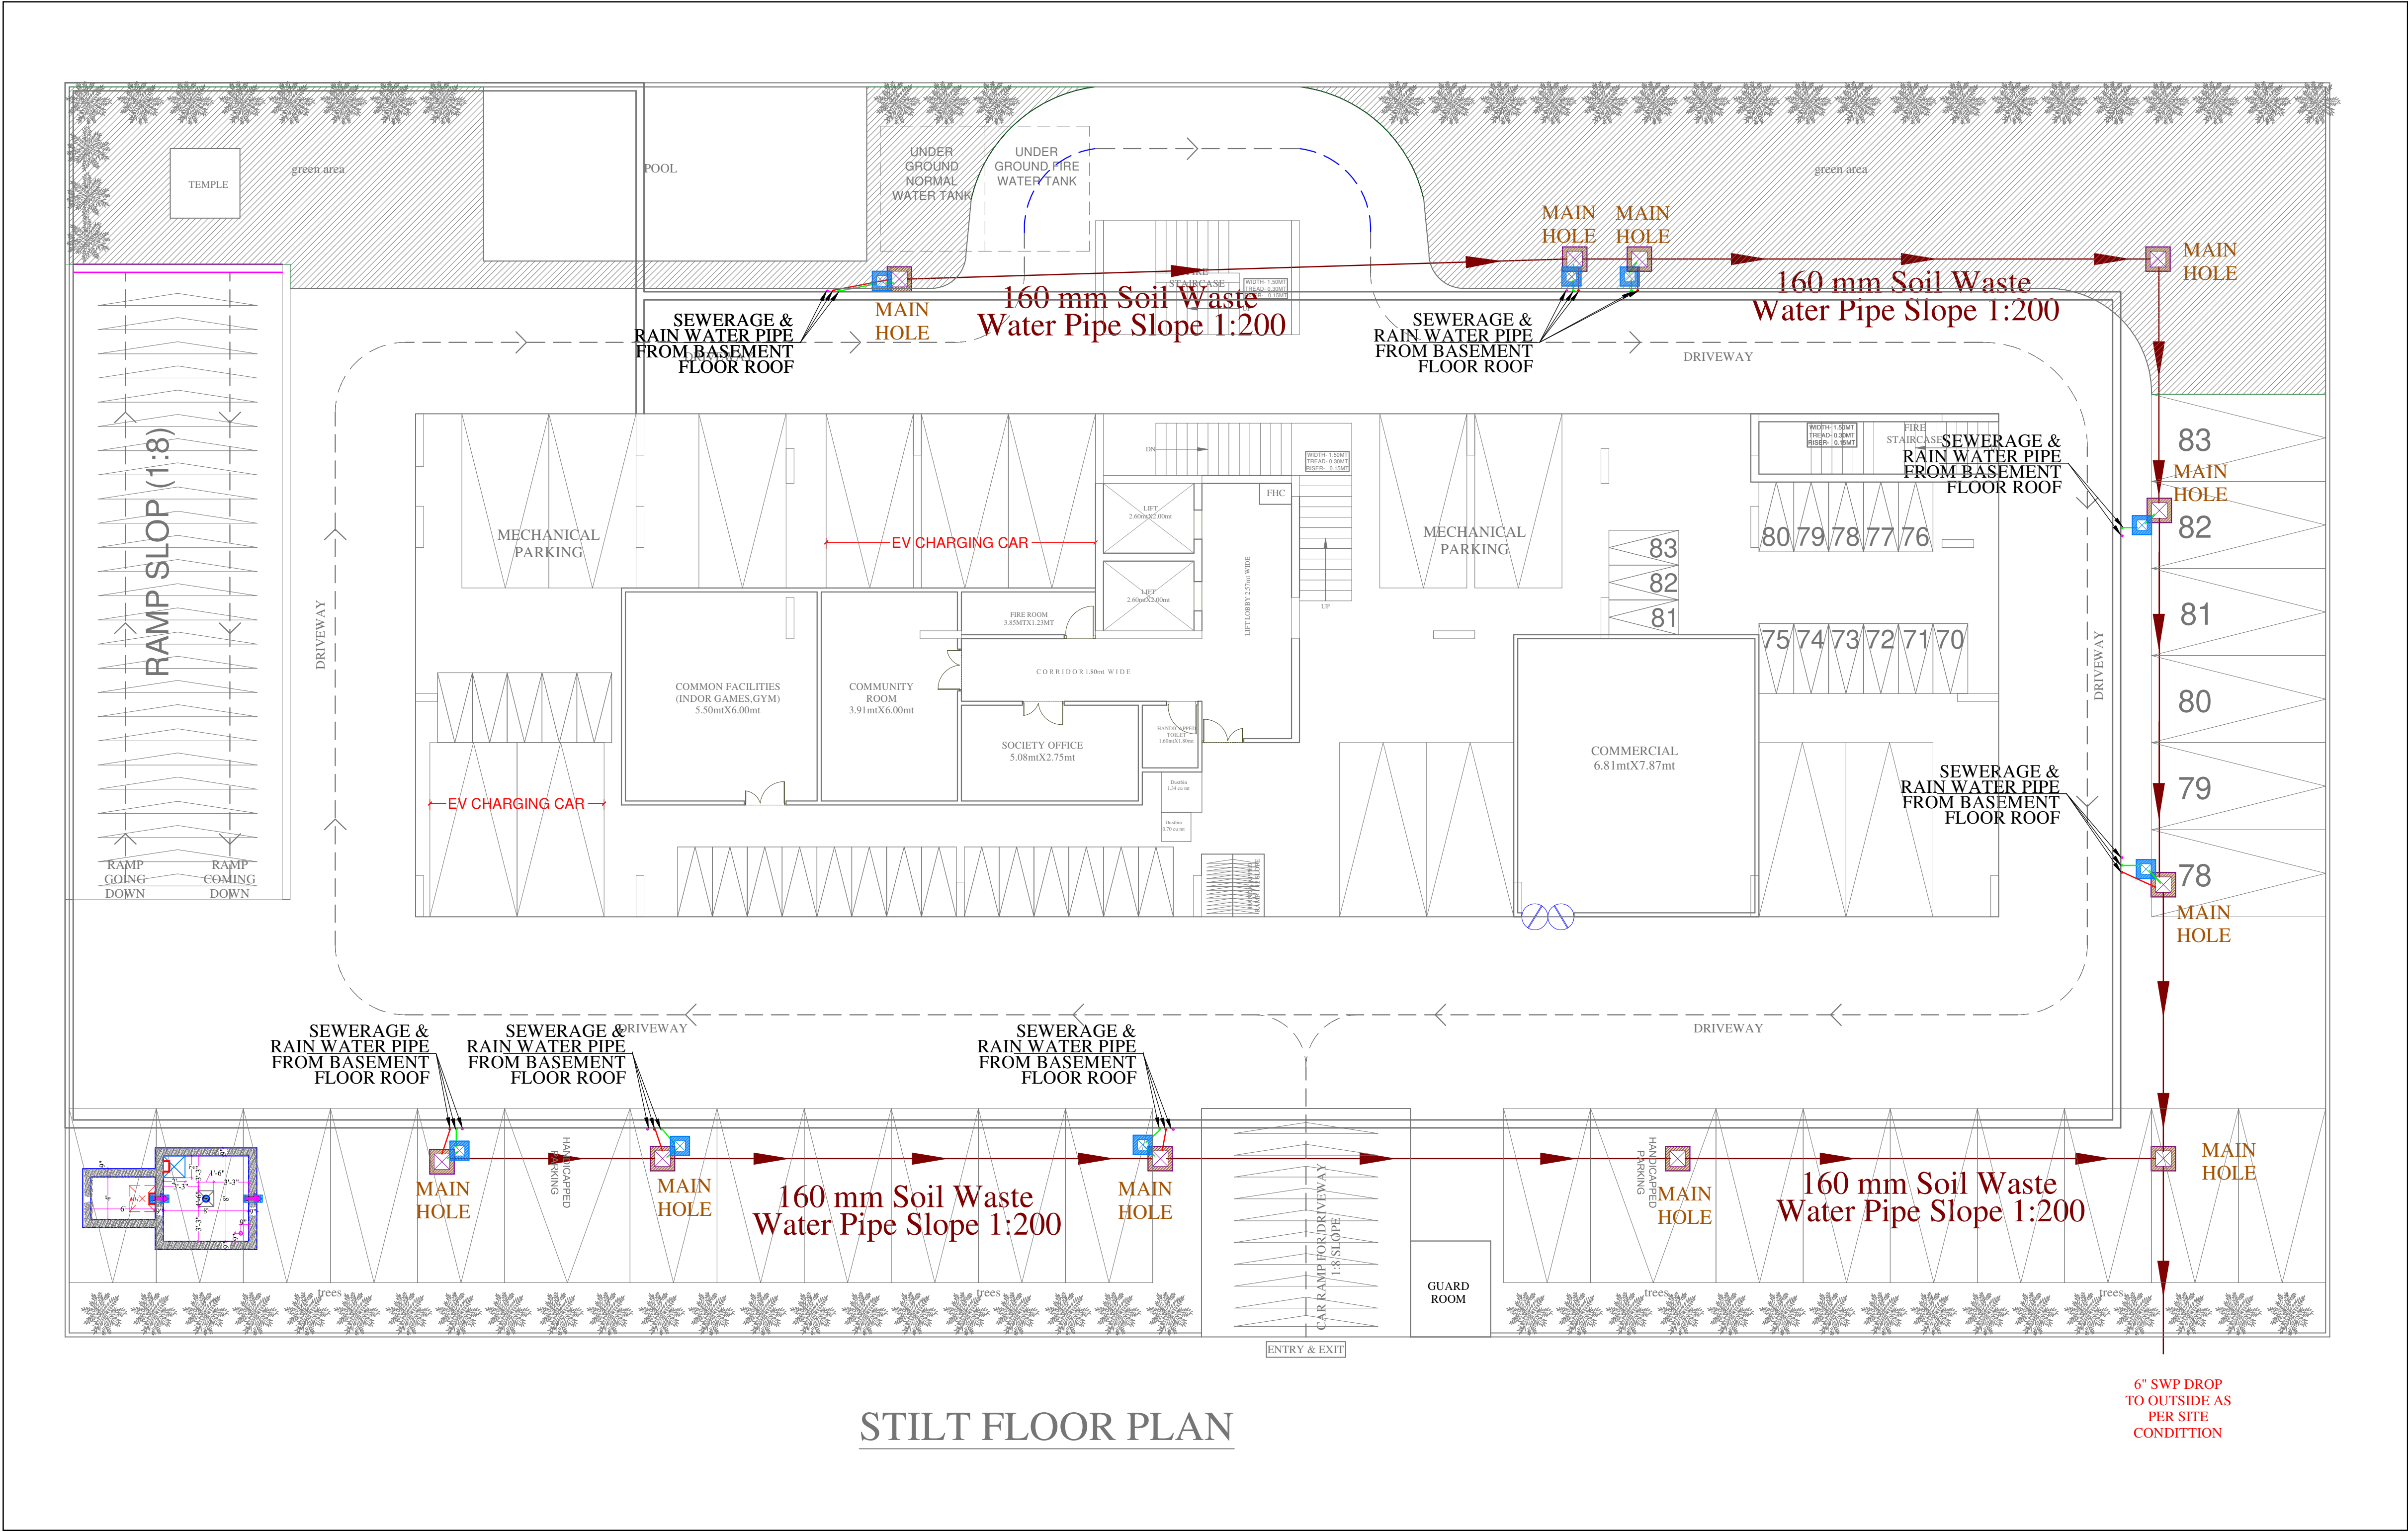

SYMBOL	DESCRIPTION
	110 mm Soil Waste Water Pipe
	110 mm Waste Water Pipe
	110 mm Rain Water Pipe
	160 mm Soil Waste Water Pipe Slope 1:200
	110 mm Soil Waste Water Pipe Slope 1:150
	110 mm Waste Water Pipe Slope 1:150
	110 mm Rain Water Pipe Slope 1:200
	Gully Trap
	Main Hole
	Flow Direction

SERVICES CONSULTANT:
ASHI ASSOCIATES
F 9 / 440 , Keshav Marg
Chitrakut Scheme,Jaipur
PH:91-0-93146-10438 ,0141-2440946
Mail:vipul8599@yahoo.com

Vipul
VIPUL AGARWAL
M.E.P. CONSULTANT
B.E. ELECTRICAL

ARCHITECTS:-
KAPPRIS INNOVATION
VAISHALI NAGAR, JAIPUR
Phone No: 0141-4002369
email:-kapprisinnovation@gmail.com

PROJECT:-
PROPOSED APARTMENT "GOLD
BELLAGIO", CP-6 CORNER,
SWAMI VIVEKANAND NAGAR
SCHEME, KOTA

DRAWING:
EXTERNAL SEWERAGE
WATER PIPE ROUTE
PLAN