


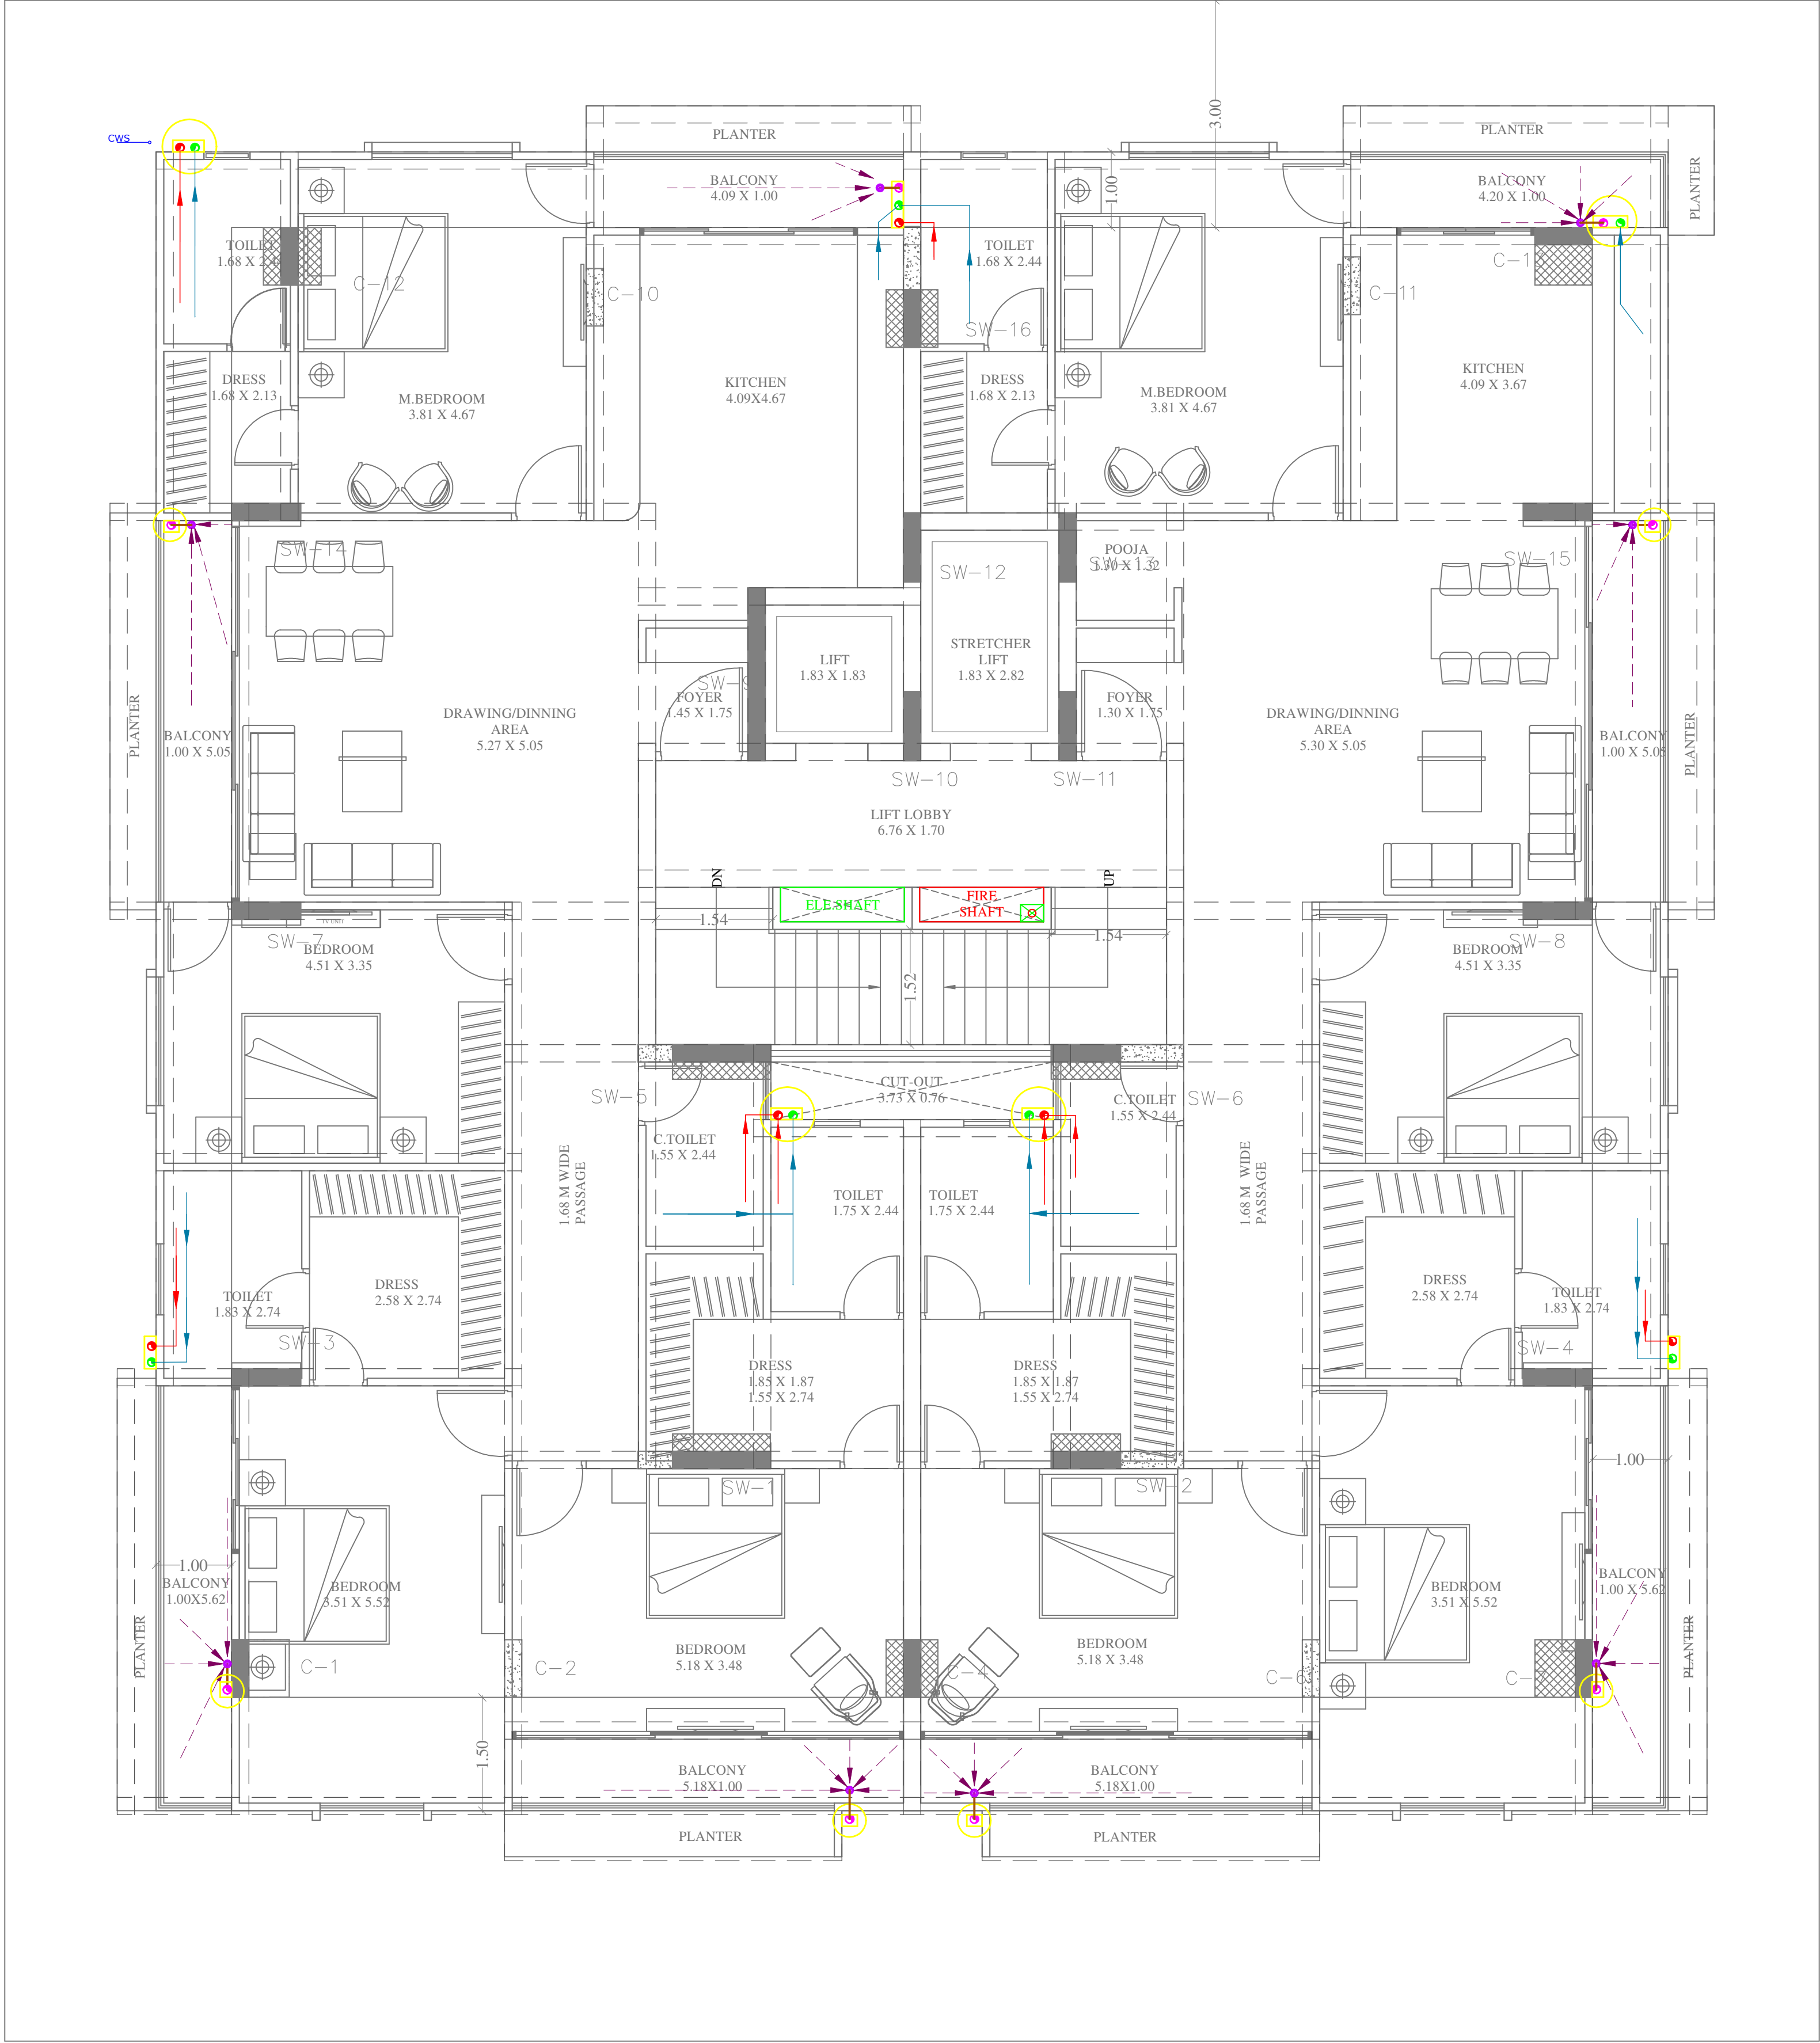


TYPICAL FLOOR [FIRST TO FIFTH]

Vipul
VIPUL AGARWAL
M.E.P. CONSULTANT
B.E. ELECTRICAL

SYMBOL	DESCRIPTION
	Ø110 mm Soil Waste Water Pipe
	Ø110 mm Waste Water Pipe
	Ø110 mm Rain Water Pipe
	Ø110 mm Soil Waste Water Pipe Slope 1:150
	Ø110 mm Waste Water Pipe Slope 1:150
	Ø110 mm Rain Water Pipe Slope 1:200
	Ø75 mm Waste Water Pipe Internal Toilet Slope 1:150
	Ø75 mm Rain Water Pipe
	Ø40mm Waste Water Pipe Bottle Trap
	Ø50mm Waste Water Pipe
	Floor Trap
	Flow Direction
	6" Platform Raise

PROJECT TITLE :- RESIDENTIAL TOWER A KOTA, RAJASTHAN	DRAWING TITLE :- TYPICAL 1st TO 5th FLOOR INTERNAL DRAINAGE PLAN	SCALE OWNER :- BRIJ RAJ SINGH S/O SHRI HARI RAJ SINGH 5-G-13, MAHAVEER NAGAR -3RD, KOTA (324005)	NORTH POINT 	OWNER	ARCHITECT	SERVICE CONSULTANT ASHI ASSOCIATES F 9 / 440 , Keshav Marg Chitrakut Scheme,Jaipur PH:91-0-93146-10438 ,0141-2440946, Mail:vipul8599@yahoo.com
--	--	--	---------------------	-------	-----------	--

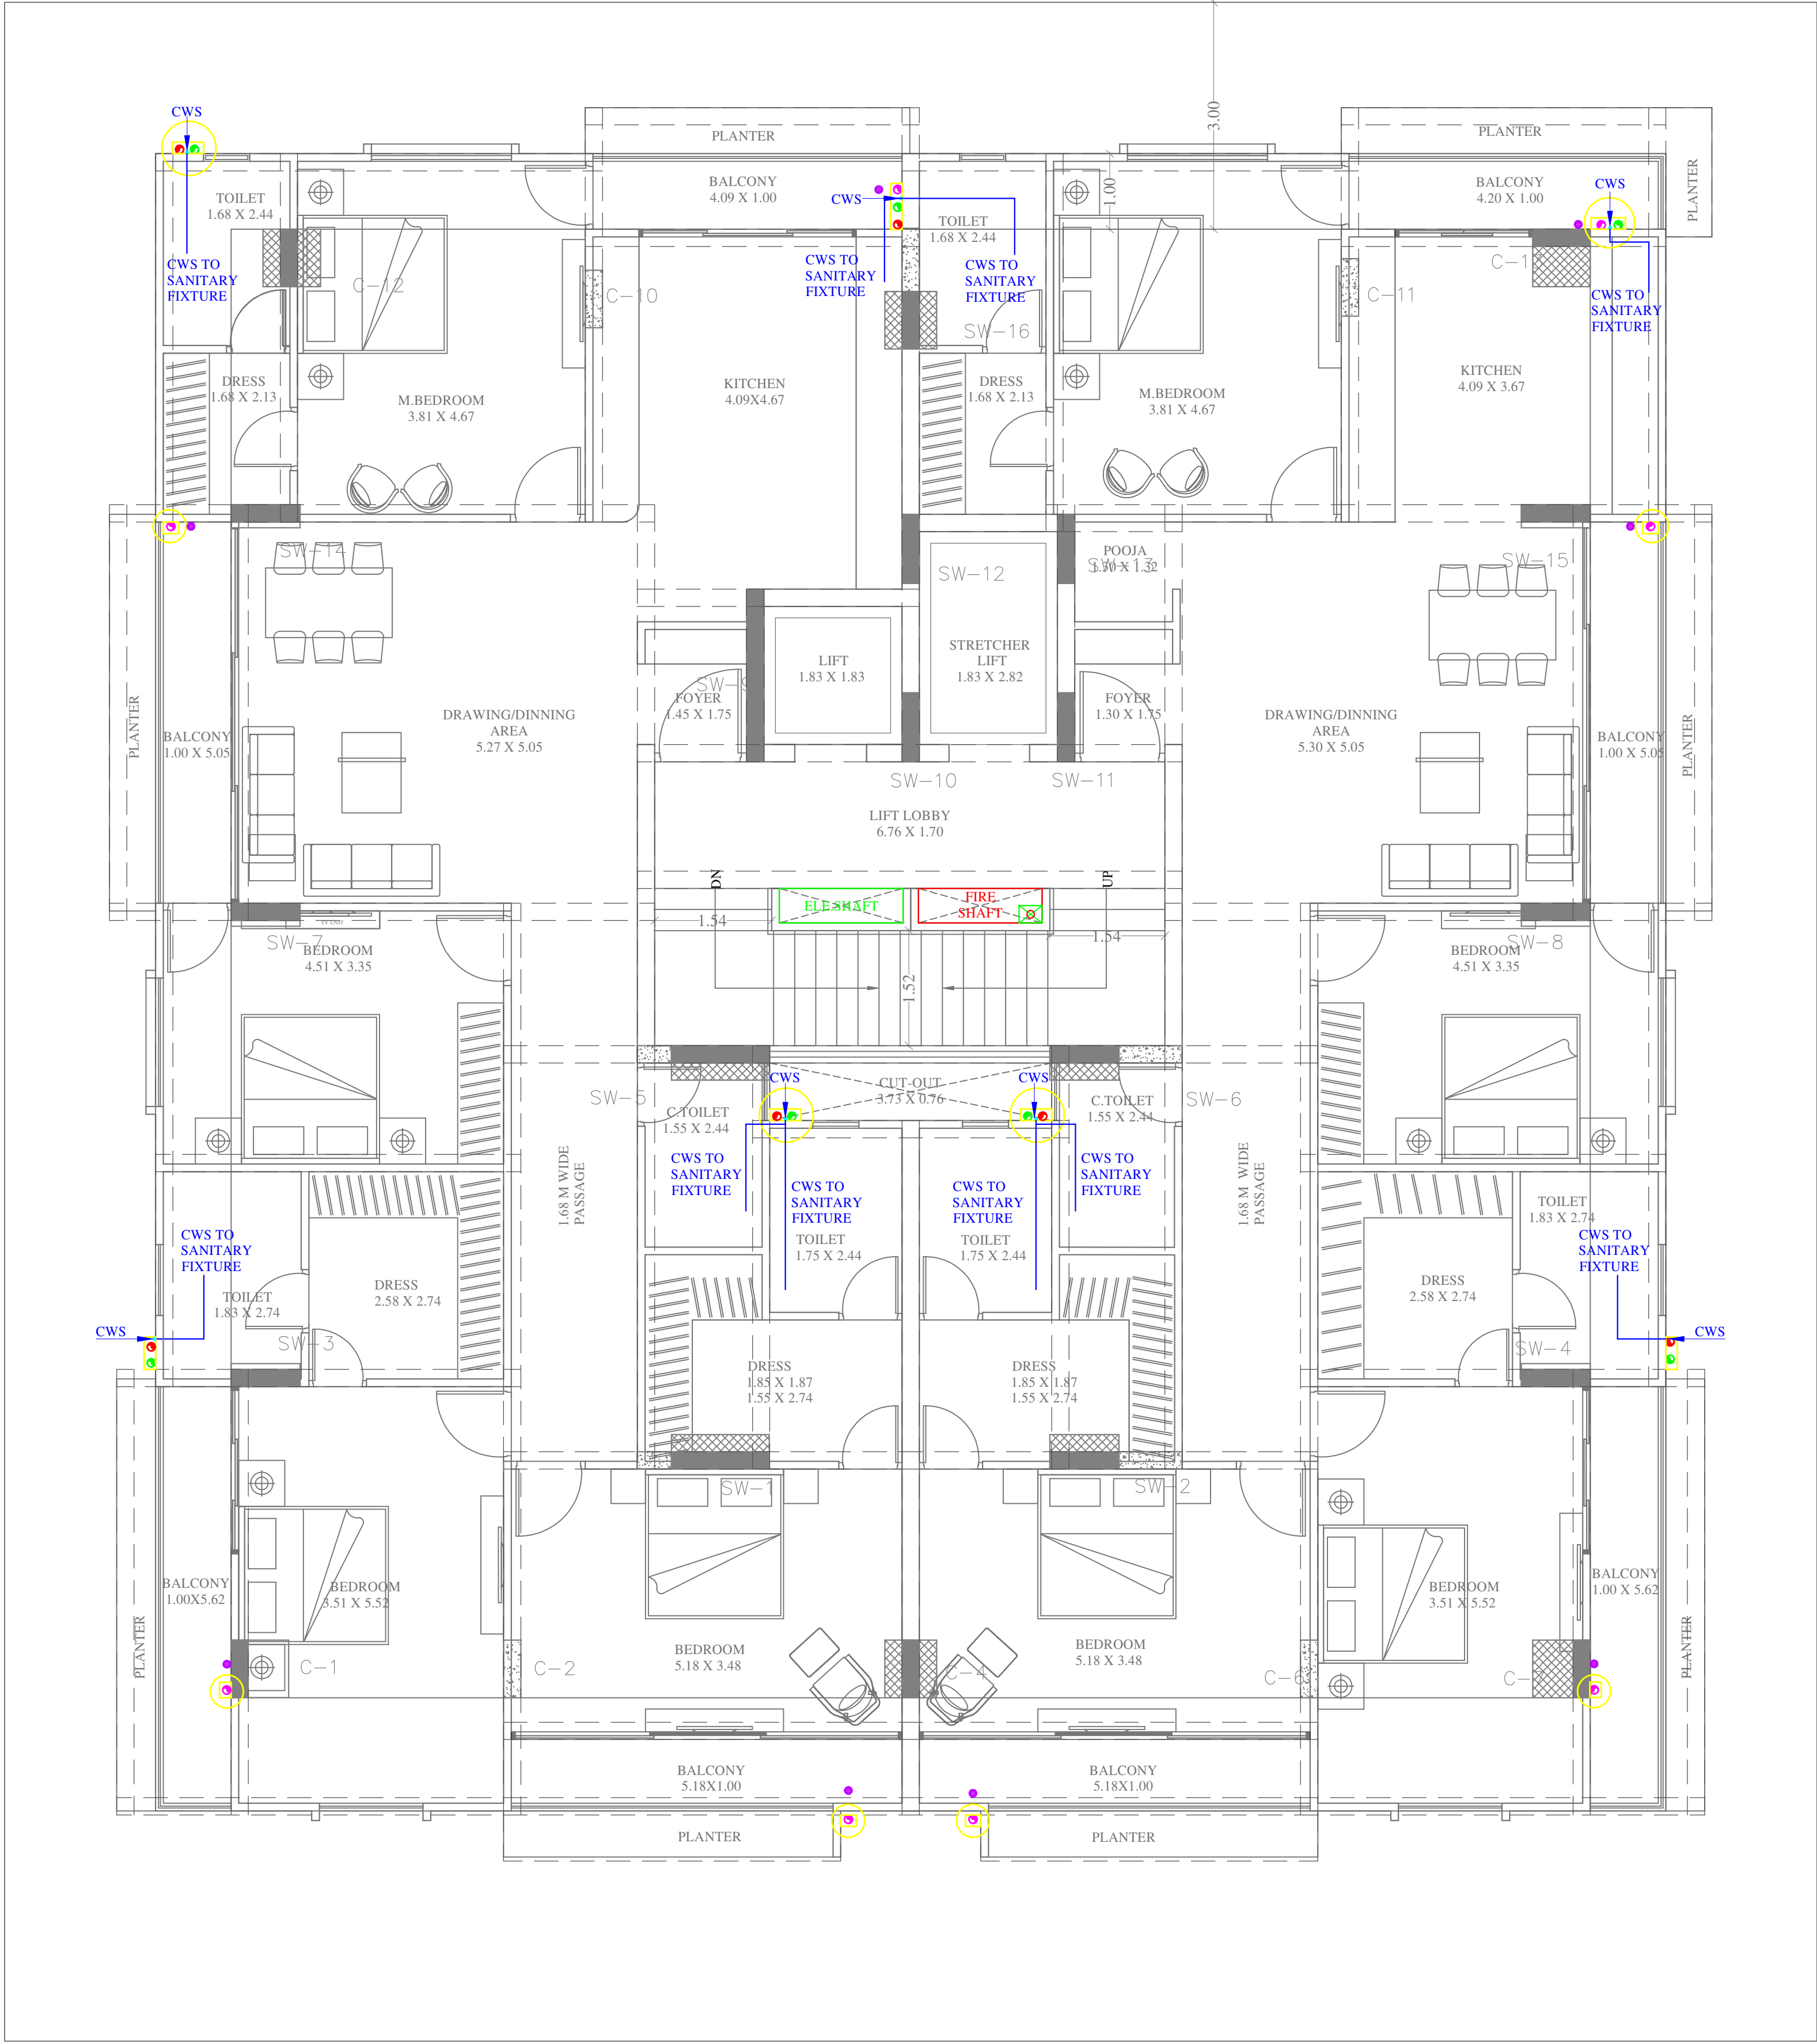

TYPICAL FLOOR [FIRST TO FIFTH]

Vipul
VIPUL AGARWAL
M.E.P. CONSULTANT
B.E. ELECTRICAL

All Heights For Finish Floor Lvl	SYMBOL	SYMBOL	DESCRIPTION
			COLD WATER SUPPLY LINE

PROJECT TITLE :- RESIDENTIAL TOWER A KOTA, RAJASTHAN	DRAWING TITLE :- TYPICAL 1st TO 5th FLOOR INTERNAL PLUMBING PLAN	SCALE OWNER :- BRIJ RAJ SINGH S/O SHRI HARI RAJ SINGH 5-G-13, MAHAVEER NAGAR -3RD, KOTA (324005)	NORTH POINT 	OWNER	ARCHITECT	SERVICE CONSULTANT ASHI ASSOCIATES F 9 / 440 , Keshav Marg Chitrakut Scheme,Jaipur PH:91-0-93146-10438 , 0141-2440946, Mail:vipul8599@yahoo.com
--	--	--	---------------------	-------	-----------	--

