

MEP CONSULTANT:-

ASHI ASSOCIATES

F 9-440, KESHAV MARG,

CHITRAKUT SCHEME, JAIPUR

PH:93146-10438,2440946

E MAIL:vipul8599@yahoo.com

PROJECT:-

BRIJRAJ SINGH

TITLE:-

ALL DISTRIBUTION PANEL

DRAWING:-

SINGLE LINE DIAGRAM

DATE:-

20-09-2024

REV:-

00

DRAWN BY:-

VICKY YADAV

CHECKED BY :-

VIPUL AGARWAL



NOTE:-

THIS SLD HAS BEEN PREPARED AS PER CONCEPT STAGE DATA AVAILABLE WITH US. KINDLY CONTACT US FOR FINAL SLD & DETAILS BEFORE PLACING ORDER FOR FABRICATION. WE SHALL NOT BE RESPONSIBLE, IF THE PANELS ARE UNDER UTILISED OR OVER LOADED AT ANY STAGE.



NOTE FOR WATER PANEL:-

WE CONSIDER ALL WATER PUMP AS PER CONCEPT STAGE DATA AVAILABLE WITH US. KINDLY TELL US WHICH RATING AND HOW MANY PUMPS TO TAKE ON ACTUAL SITE.

Vipul
VIPUL AGARWAL
M.E.P. CONSULTANT
B.E. ELECTRICAL

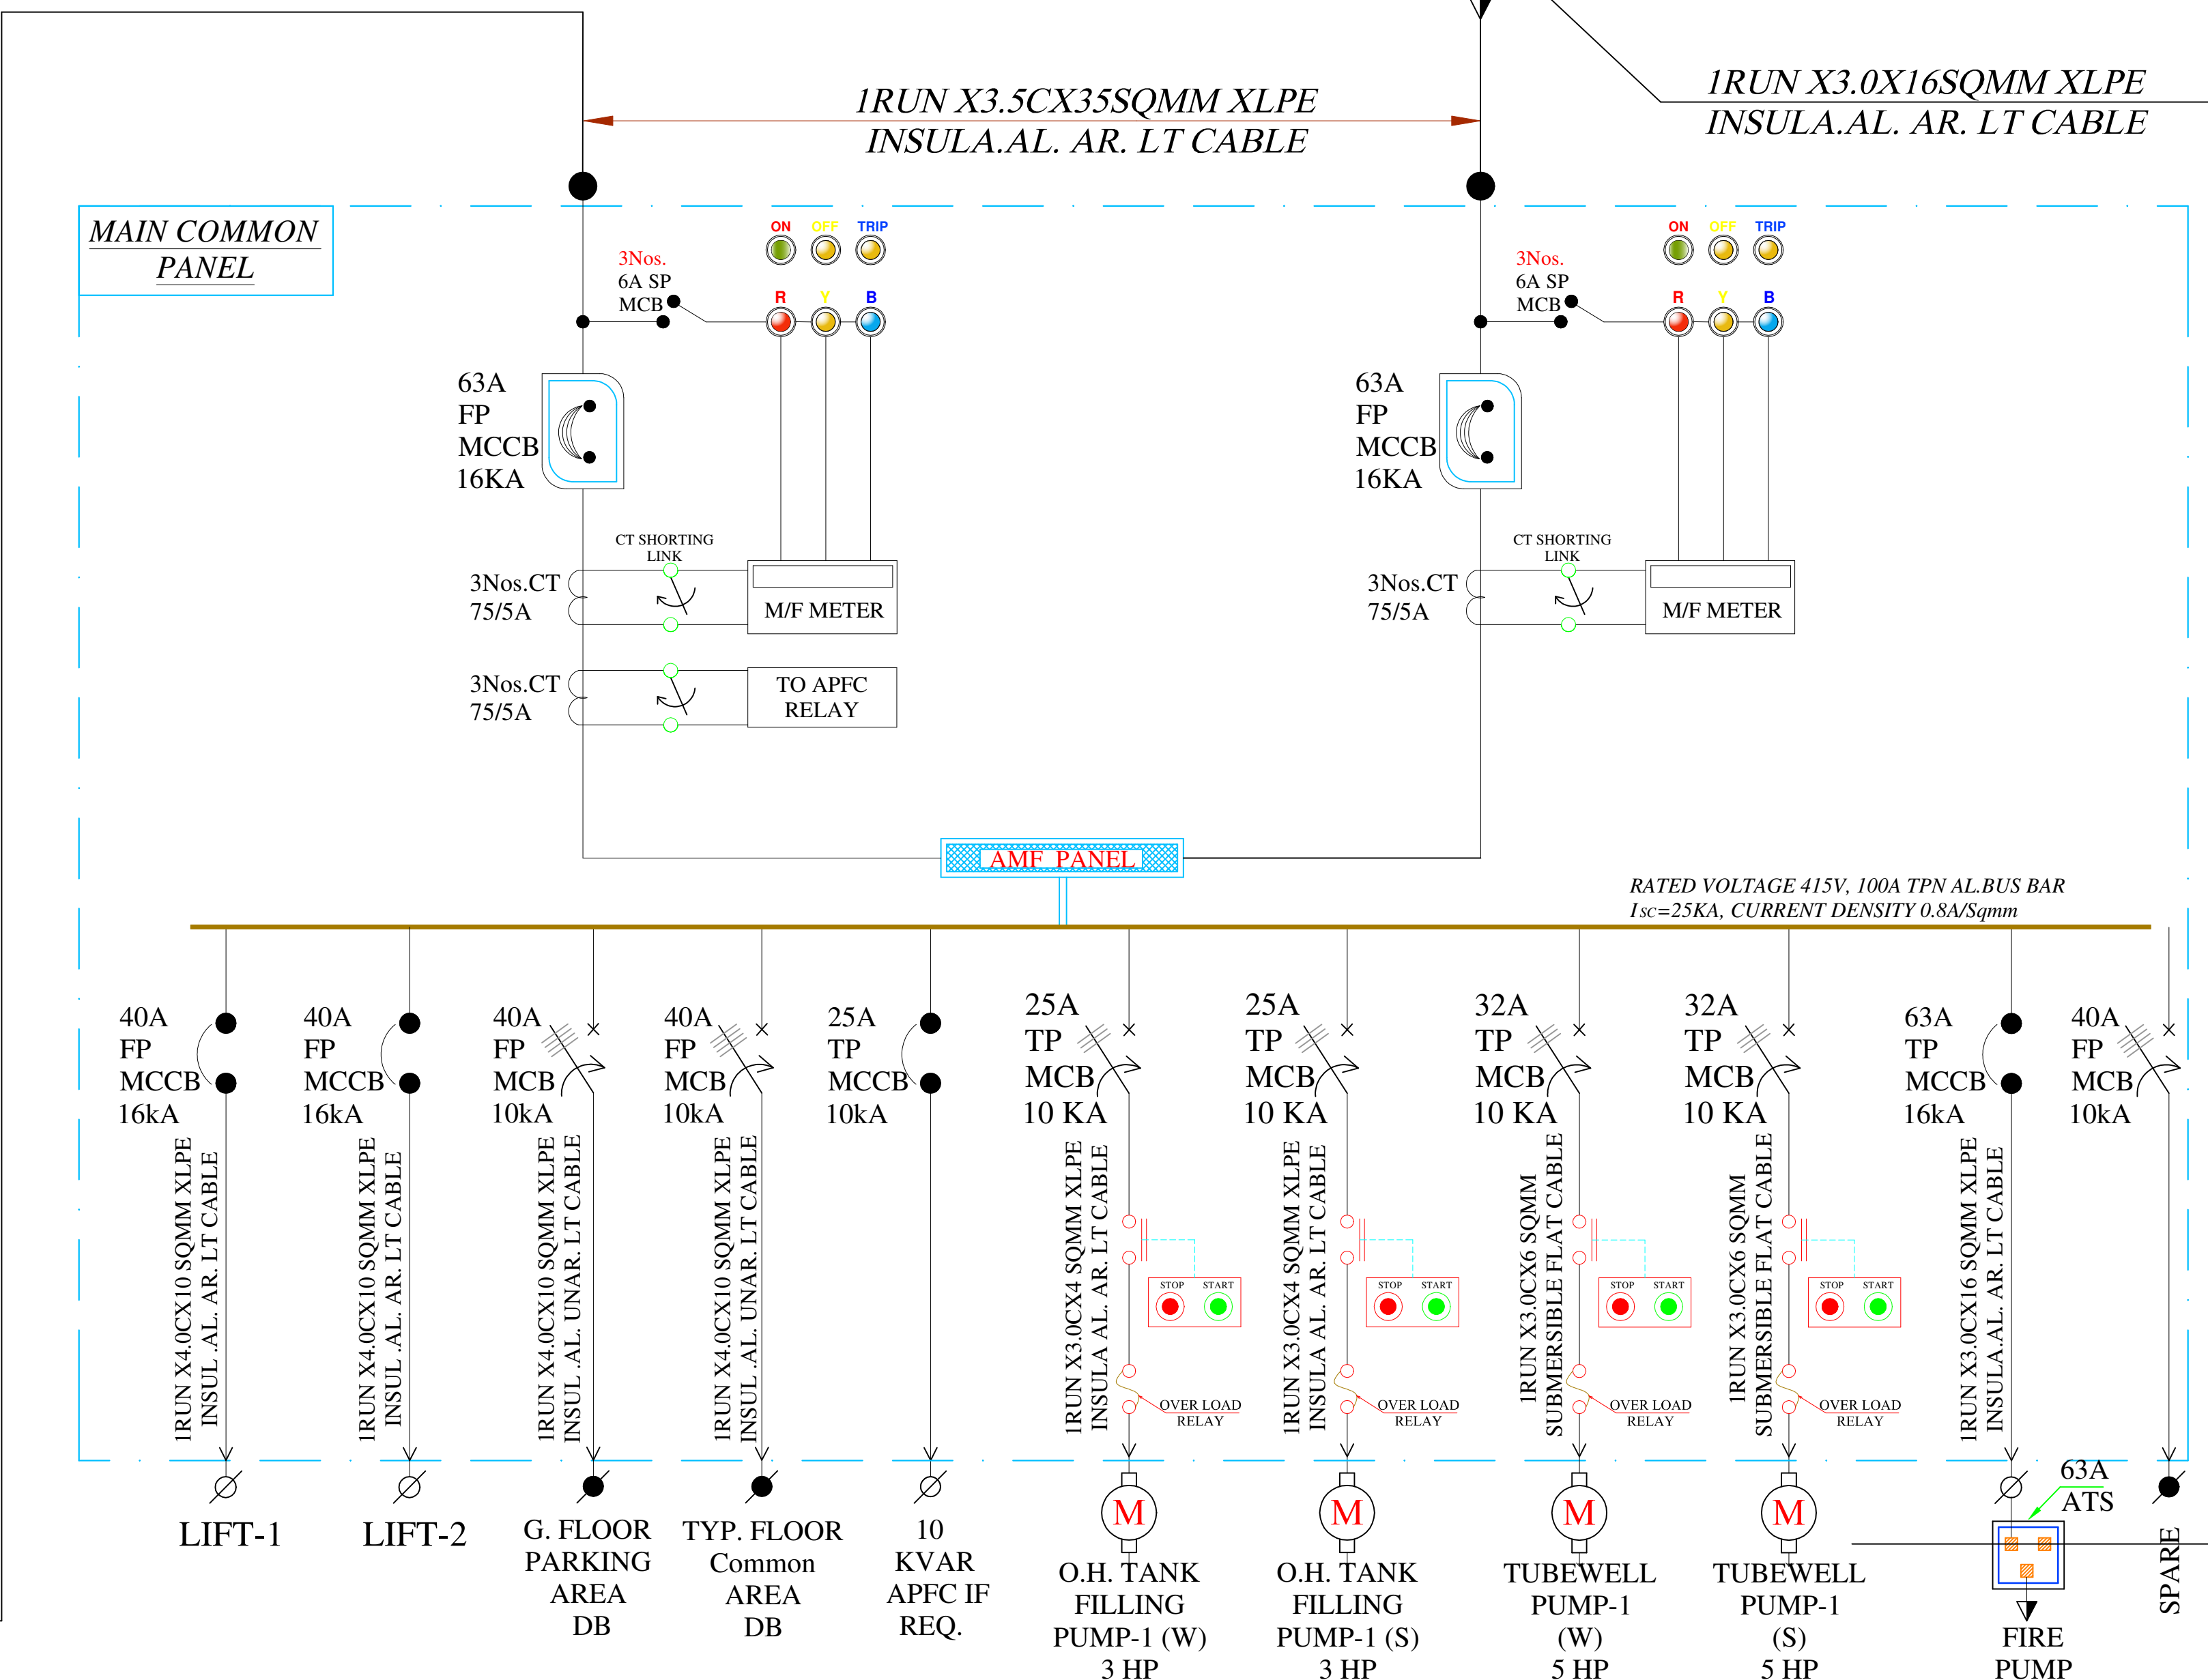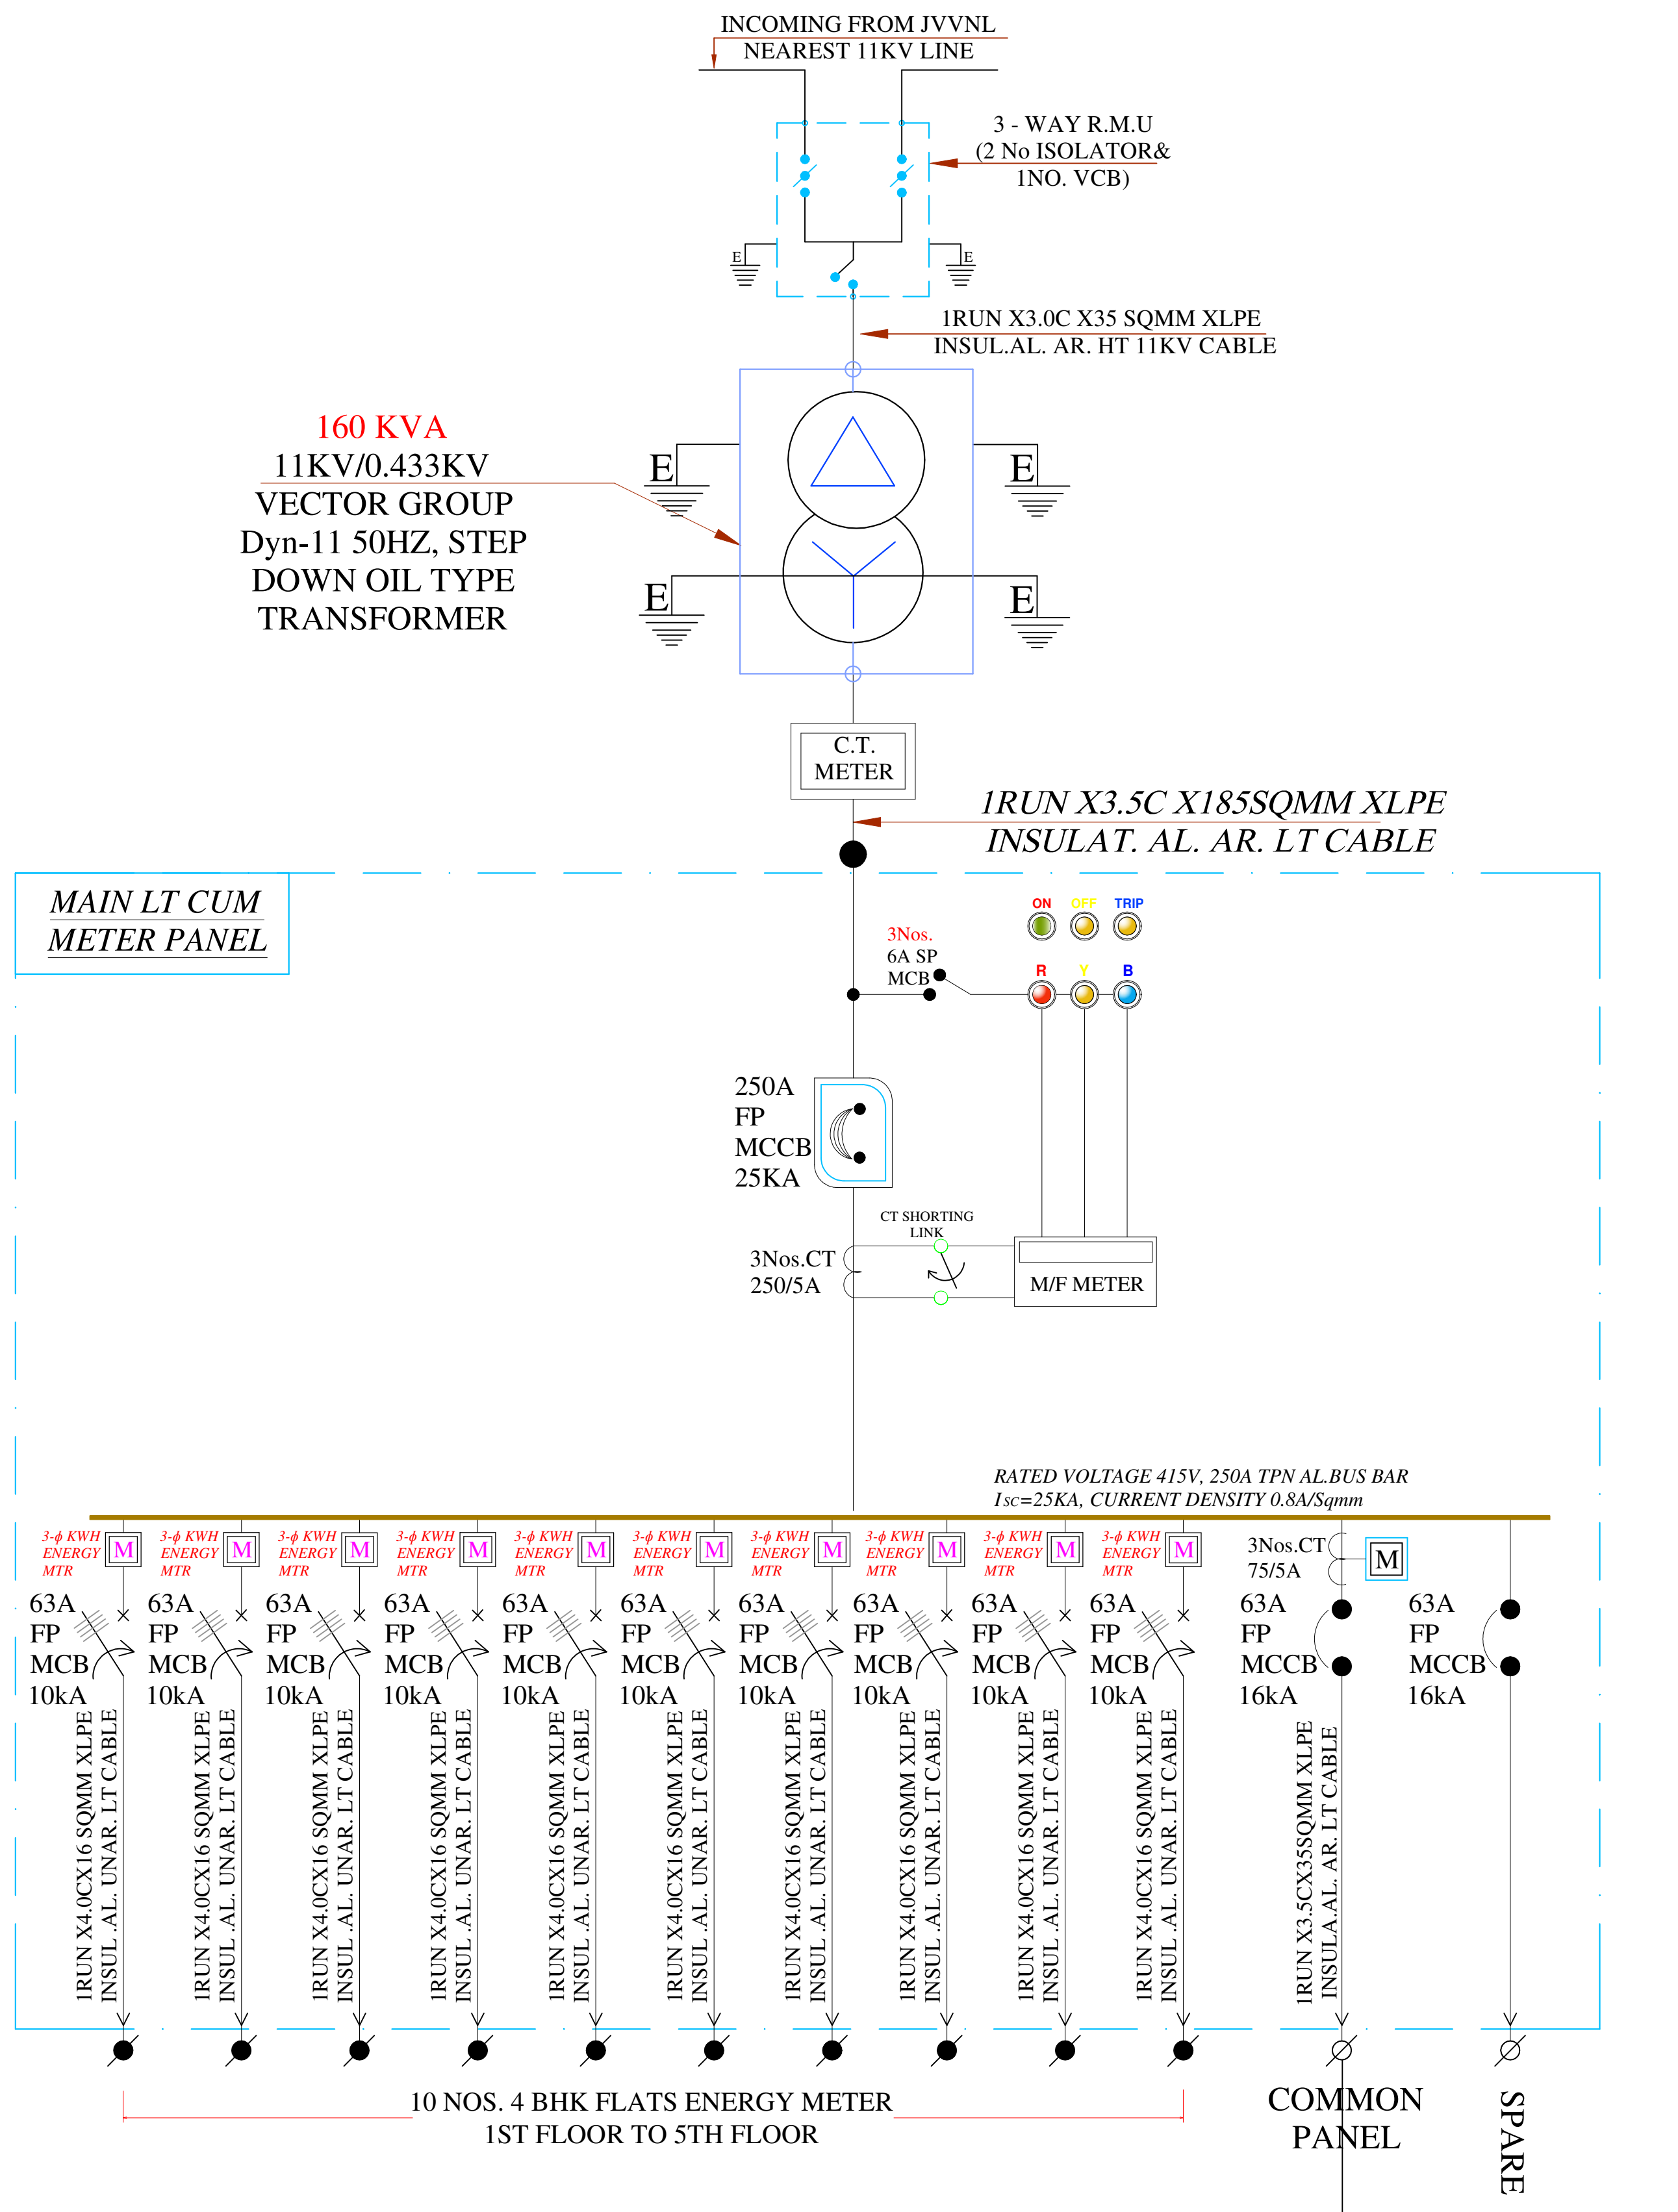

01 No. Rain Water Harvesting Pit of
size :-6'-8" L x 6'-8" Wx 8'-4" effective depth.
TOTAL DEPTH-15'-1"

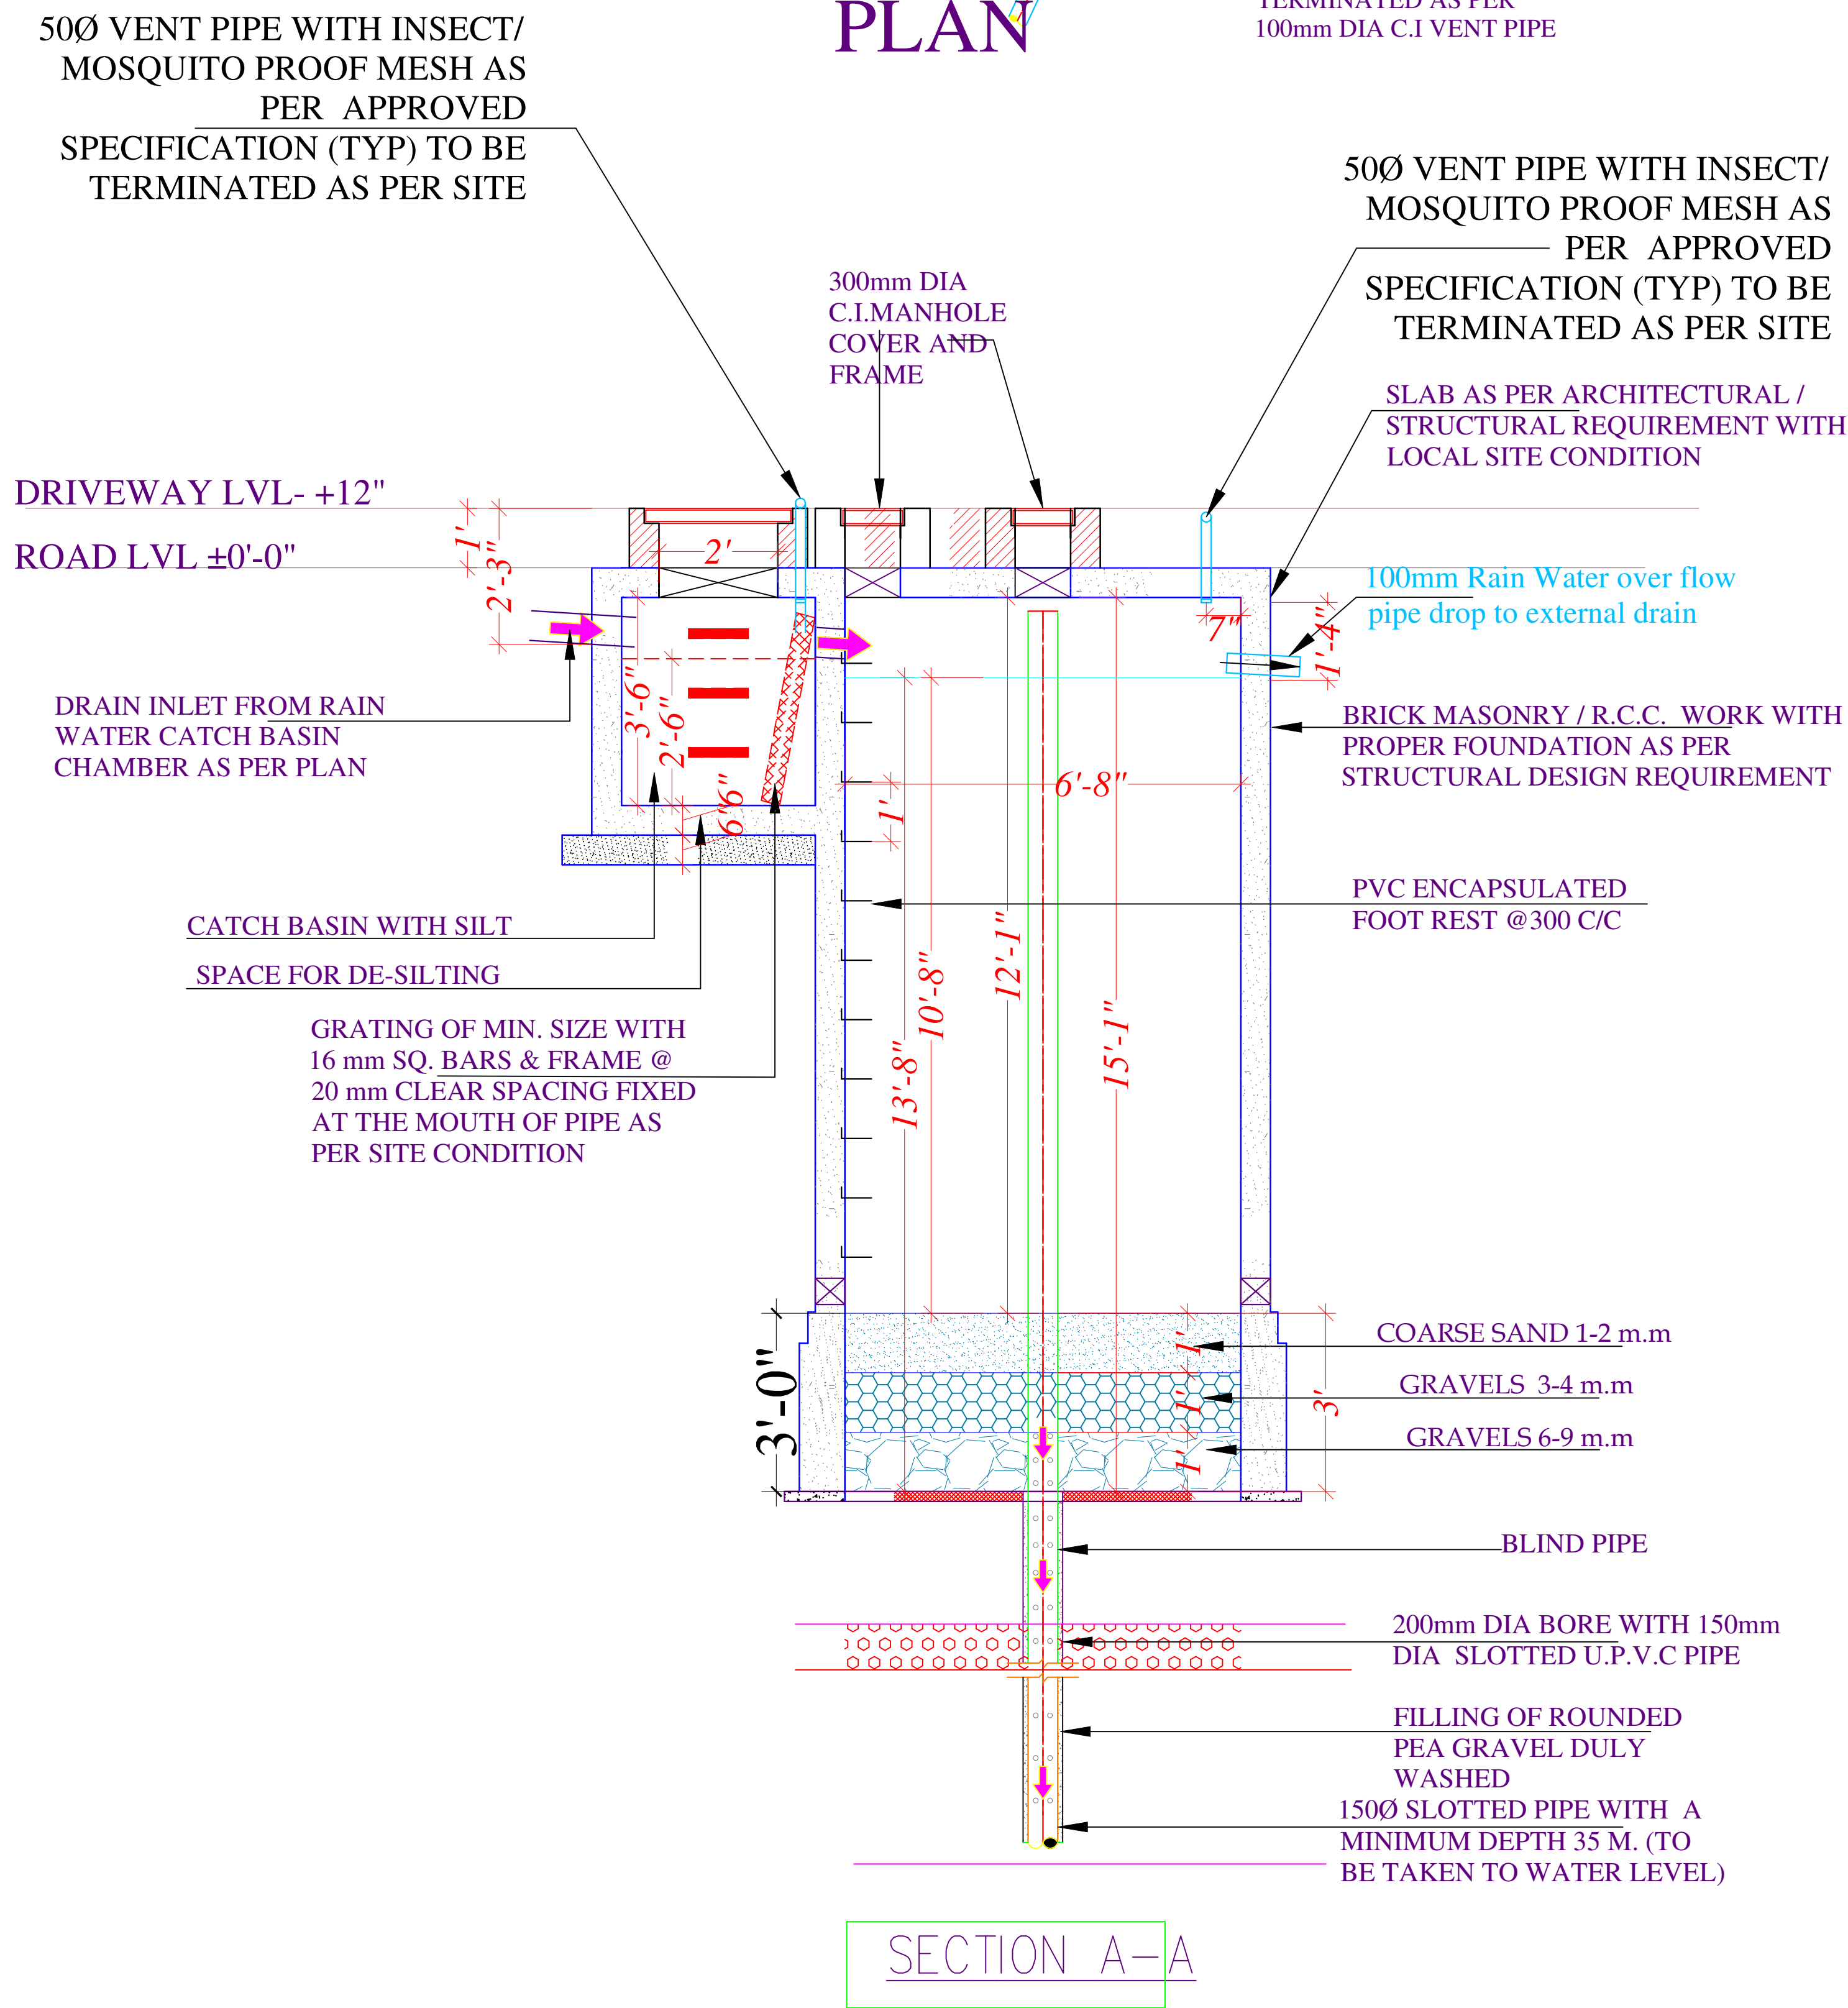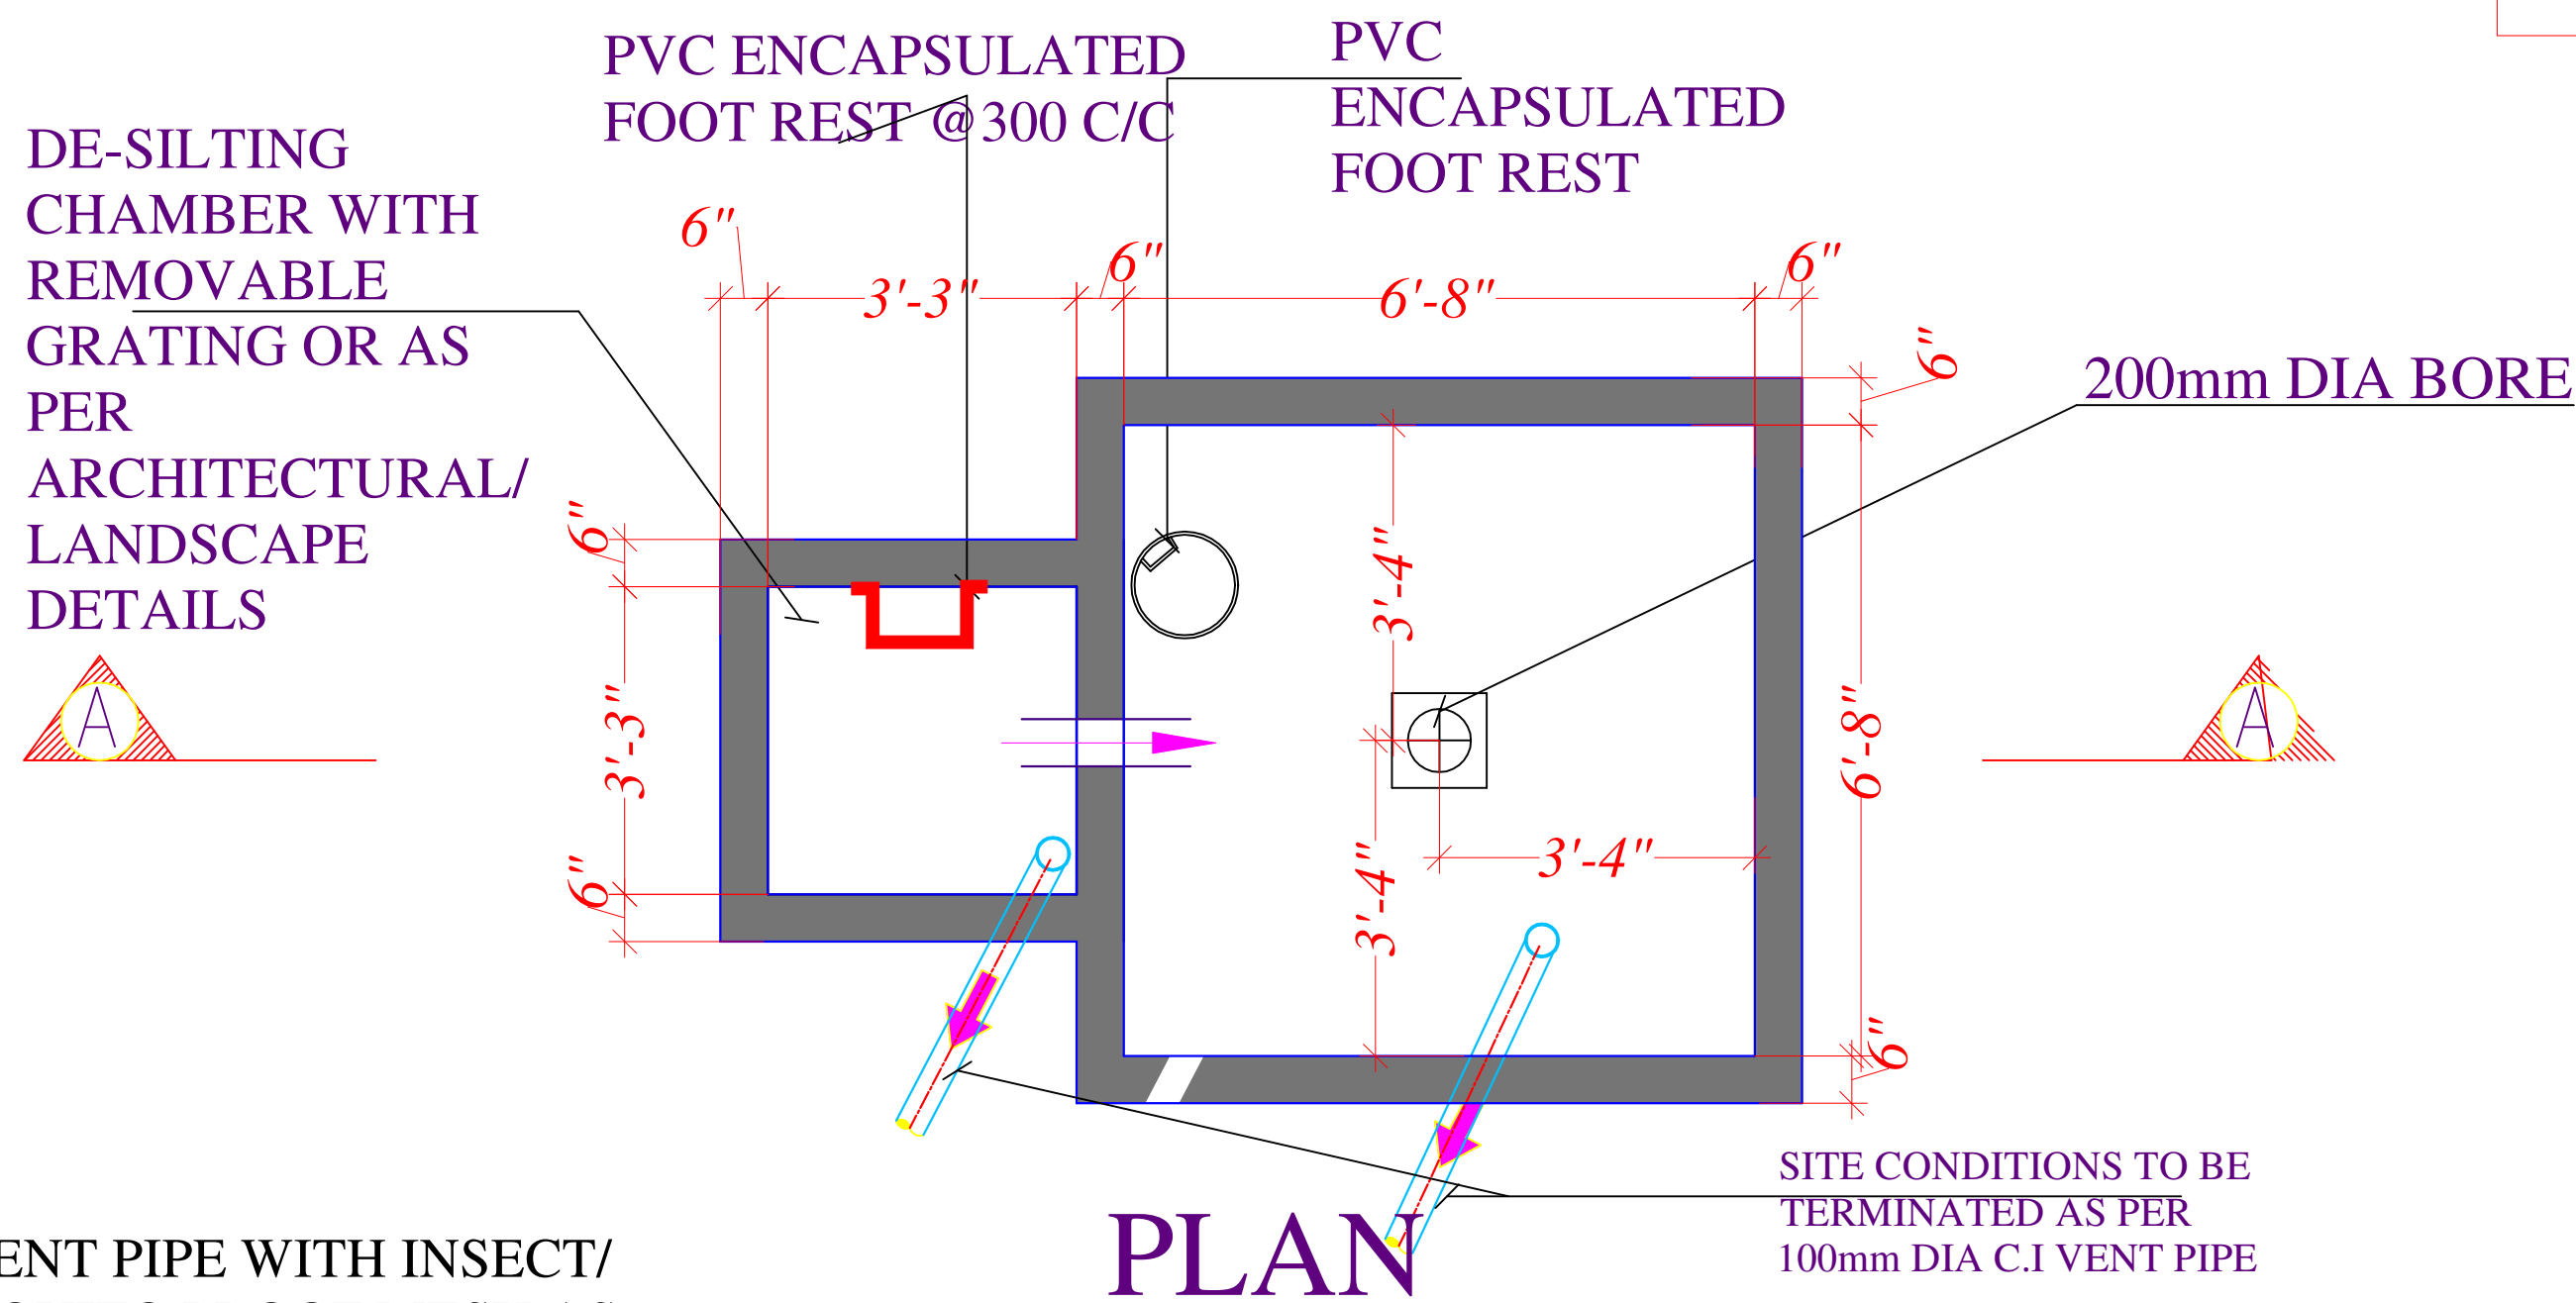

Vipul
VIPUL AGARWAL
M.E.P. CONSULTANT
B.E. ELECTRICAL

SERVICES CONSULTANT: ASHI ASSOCIATES F 9 / 440 , Keshav Marg Chitrakut Scheme,Jaipur PH:91-0-93146-10438 ,0141-2440946 Mail:vipul8599@yahoo.com	
ARCHITECT:- 	
PROJECT TITLE:- RESIDENTIAL TOWER A KOTA, RAJASTHAN	
OWNER:- BRIJ RAJ SINGH S/O SHRI HARI RAJ SINGH 5-G-13, MAHAVEER NAGAR -3RD, KOTA (324005)	
DRAWING: RAIN HARVESTING PIT SECTION DETAILS PLAN	
DATE:- 24-09-2024	REV:- 00

