

PROJECT ADDRESS:

PROPOSED BUILDING AT
PLOT NO.- 04 (RES.),
IN SCHEME :- SHIV SHAKTI NAGAR
VISTAR (NIJI KHATEDARI), JAIPUR

PROJECT NAME:

MJB ATHULYAM- II

PROMOTERS :-

MJB BUILD DEVELOPERS

DRAWING:

STILT FLOOR PLUMBING PLAN

ARCHITECT:

space
edge

Architects

ARCHITECTS, INTERIOR DESIGNERS AND ENGINEERS

B-6, Moti Marg, Babu Nagar, Jaipur.
Ph.: 9314510603
E-Mail: spaceedgejpr@gmail.com

SH.NO.
01

DATE : 05-11-2024

SCALE: NTS

All Heights For Finish Floor Lvl	SYMBOL	SYMBOL	DESCRIPTION
+2100MM			Ø 20MM CWS PIPE THRU WALL CHASE TO CONCELED STOP COCK
+300MM			Ø 20MM CWS PIPE THRU WALL CHASE TO FAUCET
			Basin Angle Valve
+450MM			Ø 20MM CWS PIPE THRU WALL CHASE TO CISTERN ANGLE VALVE
			Floor Trap
+950MM	AS PER/ARCHI.		MIRROR 450X450mm(BOTTOM)
+1000MM	AS PER/ARCHI.		SOAP DISH
+1500MM	AS PER/ARCHI.		TOWEL RAIL
+450MM	AS PER/ARCHI.		PAPER HOLDER
			COLD WATER SUPPLY LINE


SERVICES CONSULTANT:
ASHI ASSOCIATES
F 9 / 440 , Keshav Marg Chitrakut Scheme,Jaipur
PH:91-0-93146-10438 ,0141-2440946 Mail:vipul8599@yahoo.com

DRN BY- NITIN

CKD BY- SANJAY

APPD BY- VIPUL AGARWAL

SCALE-

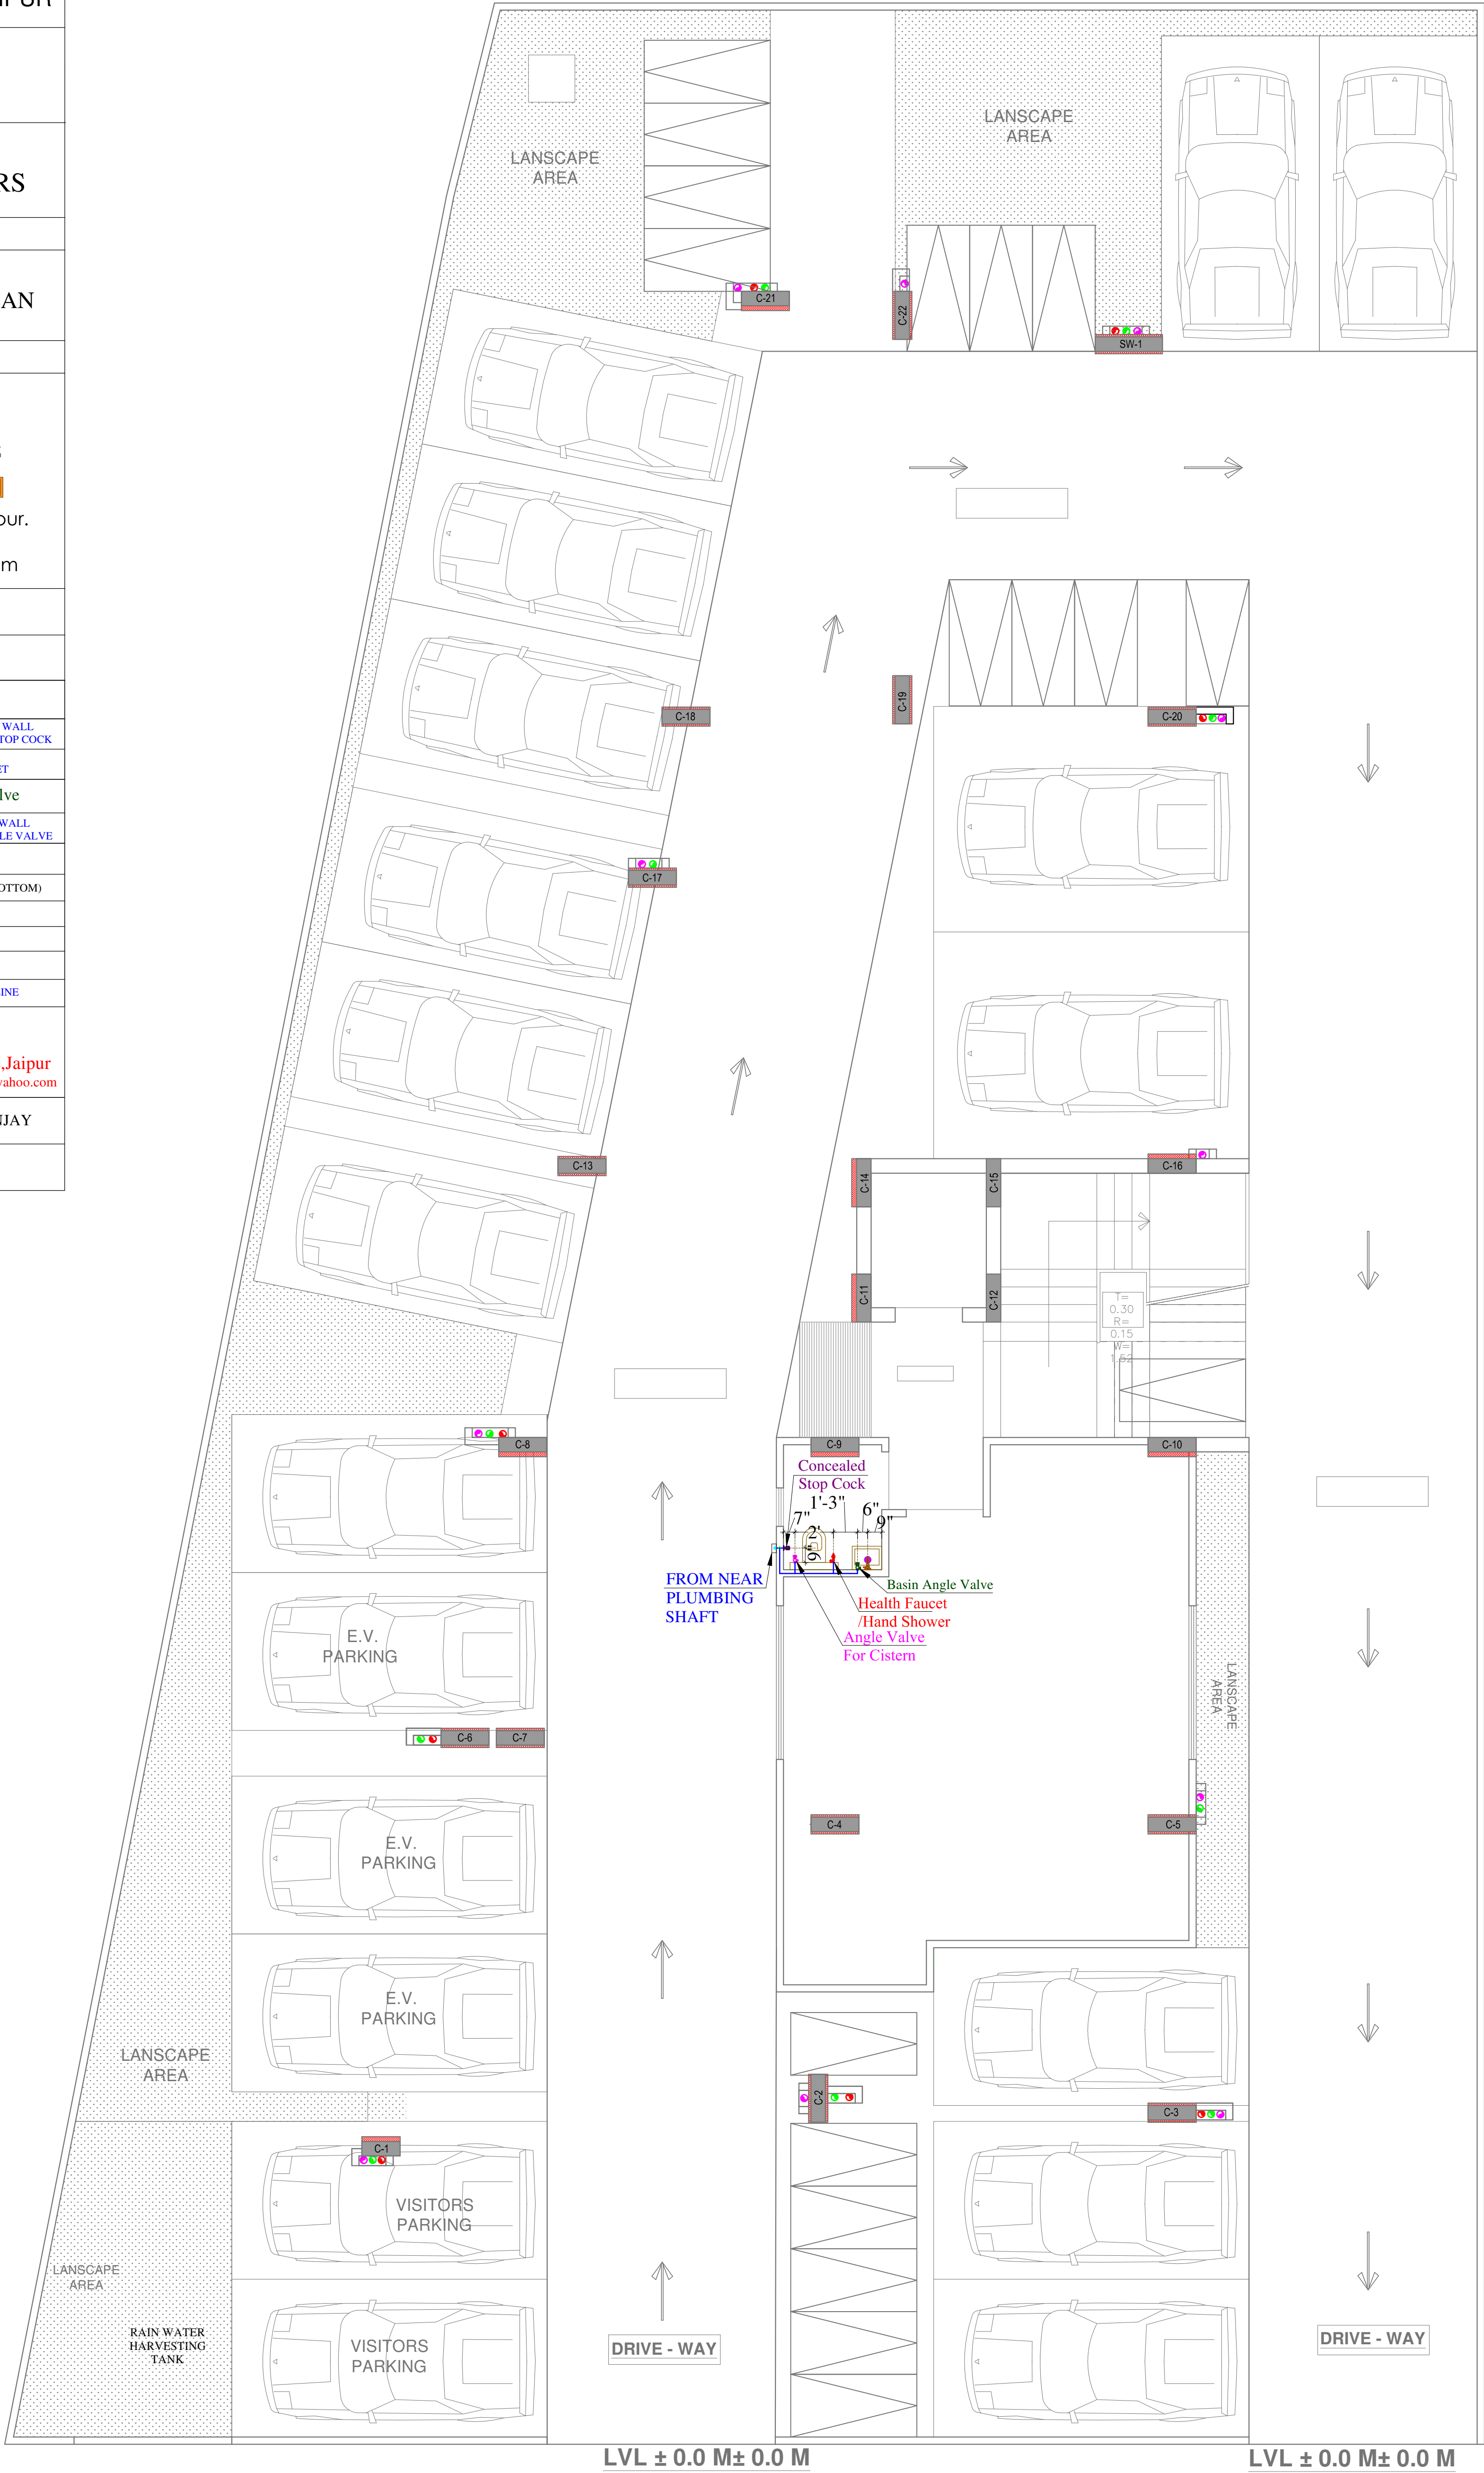

60'-0" WIDE ROAD

PROPOSED BUILDING AT
PLOT NO.- 04 (RES.),
IN SCHEME :- SHIV SHAKTI NAGAR
VISTAR (NIJI KHATEDARI), JAIPUR

MJB ATHULYAM- II

MJB BUILD DEVELOPERS

STILT FLOOR EXTERNAL SEWERAGE WATER PIPE ROUTE PLAN



**space
edge** Architects

ARCHITECTS. INTERIOR DESIGNERS AND ENGINEERS

B-6, Moti Marg, Babu Nagar, Jaipur.
Ph.: 9314510603
E-Mail: spaceedgejpr@gmail.com


SH.NO. 01	DATE : 17-06-2024
	SCALE: NTS

SYMBOL	DESCRIPTION
	Ø110 mm Soil Waste Water Pipe
	Ø110 mm Waste Water Pipe
	Ø110 mm Rain Water Pipe
	Ø160 mm Soil Waste Water Pipe Slope 1:150
	Ø110 mm Soil Waste Water Pipe Slope 1:150
	Ø110 mm Waste Water Pipe Slope 1:150
	Gully Trap-12"X12" Depth 12"
	Main Hole-18"X18" Depth According to Slope
	Main Hole-24"X24" Depth According to Slope
	Flow Direction

SERVICES CONSULTANT:
ASHI ASSOCIATES
F 9 / 440 , Keshav Marg Chitrakut Scheme,Jaipur
PH:91-0-93146-10438 ,0141-2440946 Mail:vipul8599@yahoo.com

DRN BY- RAAJ	CKD BY- SANJAY
APPD BY- VIPUL AGARWAL	SCALE-

Vipul
VIPUL AGARWAL
M.E.P. CONSULTANT
B.E. ELECTRICAL

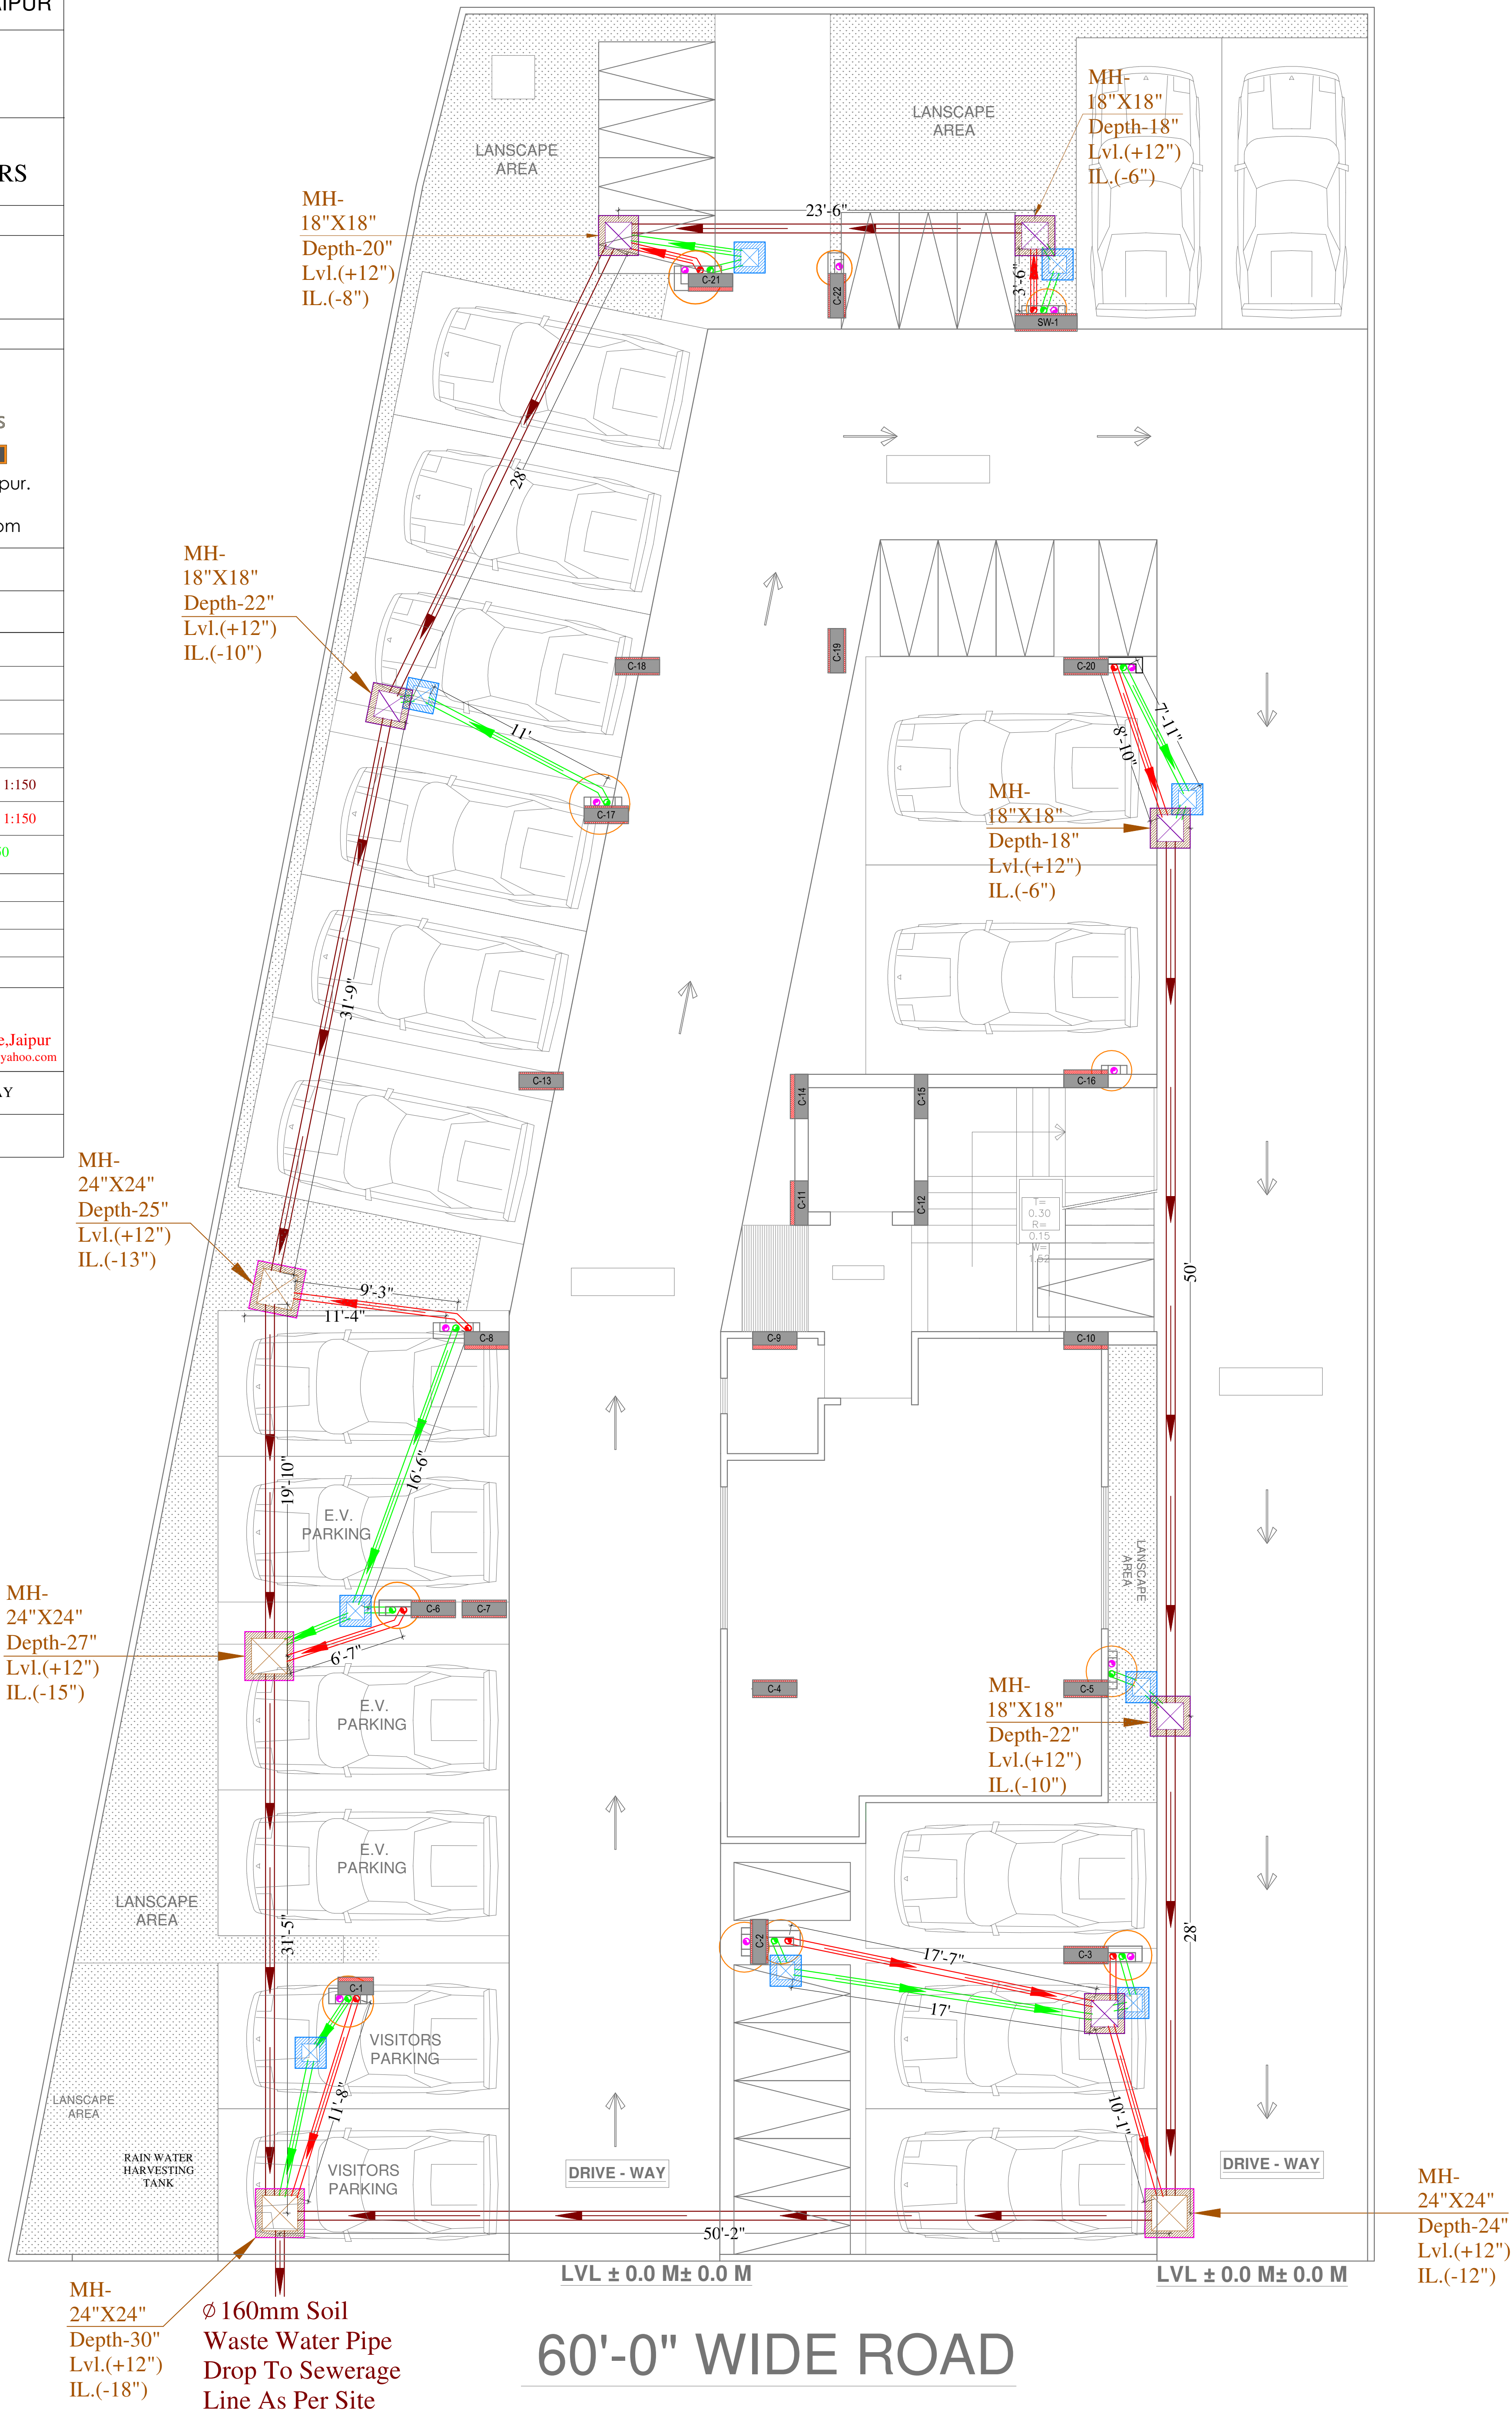

TYPICAL FLOOR WORKING PLAN



SYMBOL	DESCRIPTION
	Ø110 mm Soil Waste Water Pipe
	Ø110 mm Waste Water Pipe
	Ø110 mm Rain Water Pipe
	Ø160 mm Rain Water Pipe
	Ø110 mm Soil Waste Water Pipe Slope 1:150
	Ø110 mm Waste Water Pipe Slope 1:150
	Ø110 mm Rain Water Pipe Slope 1:200
	Ø75 mm Waste Water Pipe Internal Toilet Slope 1:150
	Ø75 mm Rain Water Pipe
	Ø40mm Waste Water Pipe Bottle Trap
	FLOOR TRAP
	Flow Direction
	6" Platform Raise

SERVICES CONSULTANT:
ASHI ASSOCIATES
F 9 / 440 , Keshav Marg Chitrakut Scheme,Jaipur
PH:91-0-93146-10438 ,0141-2440946 Mail:vipul8599@yahoo.com
REV. NO. 00 DATE: 18-07-2024

DRN BY:- NITIN	CKD BY:- SANJAY	APPD:- VIPUL AGARWAL
-------------------	--------------------	-------------------------

PROJECT ADDRESS:

PROPOSED BUILDING AT
PLOT NO.- 04 (RES.),
IN SCHEME :- SHIV SHAKTI NAGAR
VISTAR (NIJI KHATEDARI), JAIPUR

PROJECT NAME:
MJB ATHULYAM- II

PROMOTERS :-
MJB BUILD DEVELOPERS

DRAWING:
**GROUND FLOOR INTERNAL
DRAINAGE WITH STILT
FLOOR DROPAGE PLAN**


ARCHITECT:




ARCHITECTS, INTERIOR DESIGNERS AND ENGINEERS

B-6, Moti Marg, Bapu Nagar, Jaipur.
Ph.: 9314510603
E-Mail: spaceedgejpr@gmail.com

WORKING DRAWING

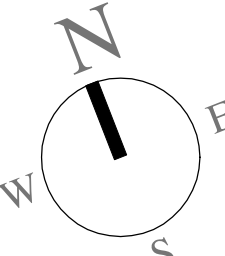SH.NO. 01	DATE : 06-11-2024 SCALE: NTS	
---------------------	---------------------------------	---

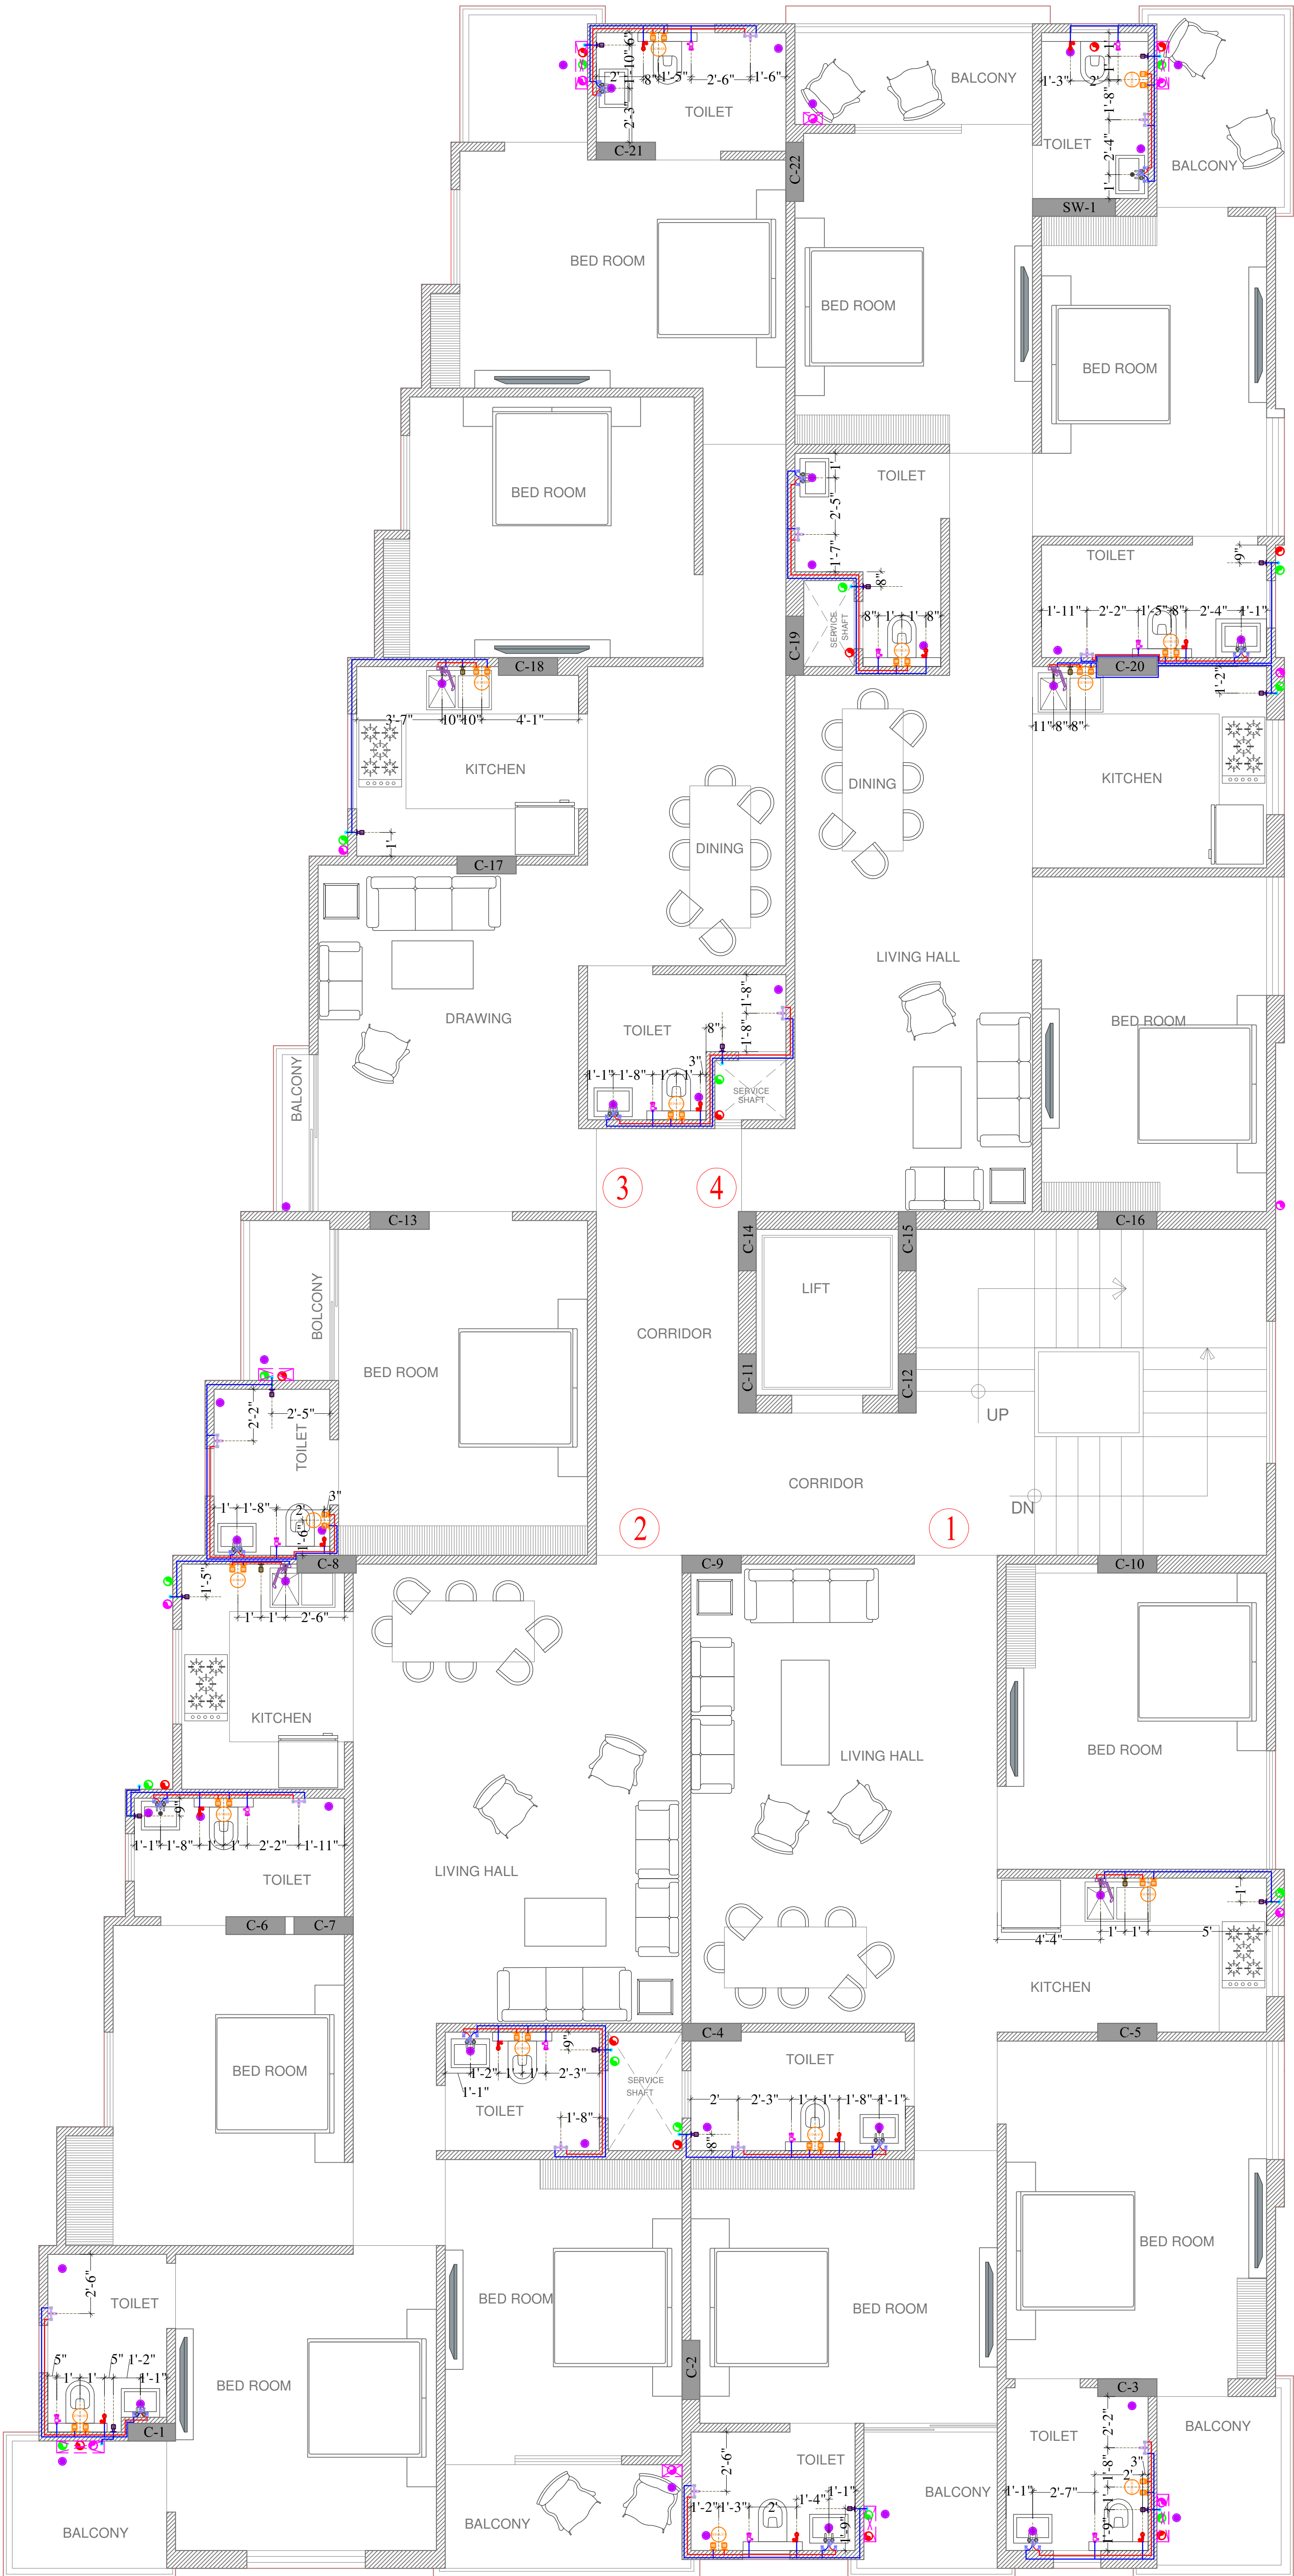

TYPICAL FLOOR WORKING PLAN

All Heights For Finish Floor Lvl	SYMBOL	SYMBOL	DESCRIPTION
+1000MM			Ø 20MM CWS PIPE THRU WALL CHASE TO SINK
			Ø 20MM HWS PIPE THRU WALL CHASE TO SINK
+1950MM			Ø 20MM CWS PIPE THRU WALL CHASE TO GEYSER
			Ø 20MM HWS PIPE THRU WALL CHASE FROM GEYSER
+1500MM			Ø 20MM CWS PIPE THRU WALL CHASE TO AQUAGUARD
+450MM			Ø 20MM HWS PIPE THRU WALL CHASE TO BASIN ANGLE VALVE
+800MM			Ø 20MM CWS PIPE THRU WALL CHASE TO BASIN ANGLE VALVE
+2100MM			Ø 20MM CWS PIPE THRU WALL CHASE TO CONCELED STOP COCK
+300MM			Ø 20MM CWS PIPE THRU WALL CHASE TO FAUCET
+450MM			Ø 20MM CWS PIPE THRU WALL CHASE TO CISTERN ANGLE VALVE
+1000MM WALL MIXER DIVERTOR			Ø 20MM CWS PIPE THRU WALL CHASE TO WALL MIXER / DIVERTOR
+2025MM O.H.SHOWER			Ø 20MM HWS PIPE THRU WALL CHASE TO WALL MIXER / DIVERTOR
+600MM			Ø 20MM CWS PIPE THRU WALL CHASE TO TAP
+450MM			Ø 20MM CWS PIPE THRU WALL CHASE TO CISTERN ANGLE VALVE
			Floor Trap
+950MM	AS PER/ARCHI.		MIRROR 450X450mm(BOTTOM)
+1000MM	AS PER/ARCHI.		SOAP DISH
+1500MM	AS PER/ARCHI.		TOWEL RAIL
+450MM	AS PER/ARCHI.		PAPER HOLDER
			COLD WATER SUPPLY LINE
			HOT WATER SUPPLY LINE

VIPUL AGARWAL
M.E.P. CONSULTANT
B.E. ELECTRICAL


SERVICES CONSULTANT: ASHI ASSOCIATES F 9 / 440 , Keshav Marg Chitrakut Scheme,Jaipur PH:91-0-93146-10438 ,0141-2440946 Mail:vipul8599@yahoo.com REV. NO. 00 DATE: 18-07-2024		
DRN BY:- KEDAR	CKD BY:- SANJAY	APPD:- VIPUL AGARWAL
PROJECT ADDRESS:		
PROPOSED BUILDING AT PLOT NO.- 04 (RES.), IN SCHEME :- SHIV SHAKTI NAGAR VISTAR (NIJI KHATEDARI), JAIPUR		
PROJECT NAME: MJB ATHULYAM- II		
PROMOTERS :- MJB BUILD DEVELOPERS		
DRAWING: GROUND FLOOR PLUMBING LAYOUT PLAN		
ARCHITECT:		
 ARCHITECTS, INTERIOR DESIGNERS AND ENGINEERS B-6, Moti Marg, Bapu Nagar, Jaipur. Ph.: 9314510603 E-Mail: spaceedgejpr@gmail.com		
WORKING DRAWING		
SH.NO. 01	DATE : 06-11-2024	
	SCALE: NTS	




TYPICAL FLOOR WORKING PLAN

All Heights For Finish Floor Lvl	SYMBOL	SYMBOL	DESCRIPTION
+1000MM			Ø 20MM CWS PIPE THRU WALL CHASE TO SINK
			Ø 20MM HWS PIPE THRU WALL CHASE TO SINK
+1950MM			Ø 20MM CWS PIPE THRU WALL CHASE TO GEYSER
			Ø 20MM HWS PIPE THRU WALL CHASE FROM GEYSER
+1500MM			Ø 20MM CWS PIPE THRU WALL CHASE TO AQUAGUARD
+450MM			Ø 20MM HWS PIPE THRU WALL CHASE TO BASIN ANGLE VALVE
+800MM			Ø 20MM CWS PIPE THRU WALL CHASE TO BASIN ANGLE VALVE
+2100MM			Ø 20MM CWS PIPE THRU WALL CHASE TO CONCELED STOP COCK
+300MM			Ø 20MM CWS PIPE THRU WALL CHASE TO FAUCET
+450MM			Ø 20MM CWS PIPE THRU WALL CHASE TO CISTERN ANGLE VALVE
+1000MM WALL MIXER DIVERTOR			Ø 20MM CWS PIPE THRU WALL CHASE TO WALL MIXER / DIVERTOR
+2025MM O.H. SHOWER			Ø 20MM HWS PIPE THRU WALL CHASE TO WALL MIXER / DIVERTOR
+600MM			Ø 20MM CWS PIPE THRU WALL CHASE TO TAP
+450MM			Ø 20MM CWS PIPE THRU WALL CHASE TO CISTERN ANGLE VALVE
			Floor Trap
+950MM	AS PER/ARCHL.		MIRROR 450X450mm(BOTTOM)
+1000MM	AS PER/ARCHL.		SOAP DISH
+1500MM	AS PER/ARCHL.		TOWEL RAIL
+450MM	AS PER/ARCHL.		PAPER HOLDER
			COLD WATER SUPPLY LINE
			HOT WATER SUPPLY LINE

Vipul
VIPUL AGARWAL
M.E.P. CONSULTANT
B.E. ELECTRICAL

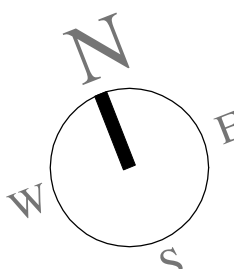SERVICES CONSULTANT: ASHI ASSOCIATES F 9 / 440 , Keshav Marg Chitrakut Scheme,Jaipur PH:91-0-93146-10438 ,0141-2440946 Mail:vipul8599@yahoo.com REV. NO. 00 DATE: 18-07-2024		
DRN BY:- KEDAR	CKD BY:- SANJAY	APPD.:- VIPUL AGARWAL
PROJECT ADDRESS: PROPOSED BUILDING AT PLOT NO.- 04 (RES.), IN SCHEME :- SHIV SHAKTI NAGAR VISTAR (NIJI KHATEDARI), JAIPUR		
PROJECT NAME: MJB ATHULYAM- II		
PROMOTERS :- MJB BUILD DEVELOPERS		
DRAWING: TYPICAL FLOOR PLUMBING LAYOUT PLAN		
ARCHITECT:		
 space edgeArchitects ARCHITECTS, INTERIOR DESIGNERS AND ENGINEERS B-6, Moti Marg, Bapu Nagar, Jaipur. Ph.: 9314510603 E-Mail: spaceedgejpr@gmail.com		
WORKING DRAWING		
DATE : 08/07/2024		
SCALE: NTS 01		

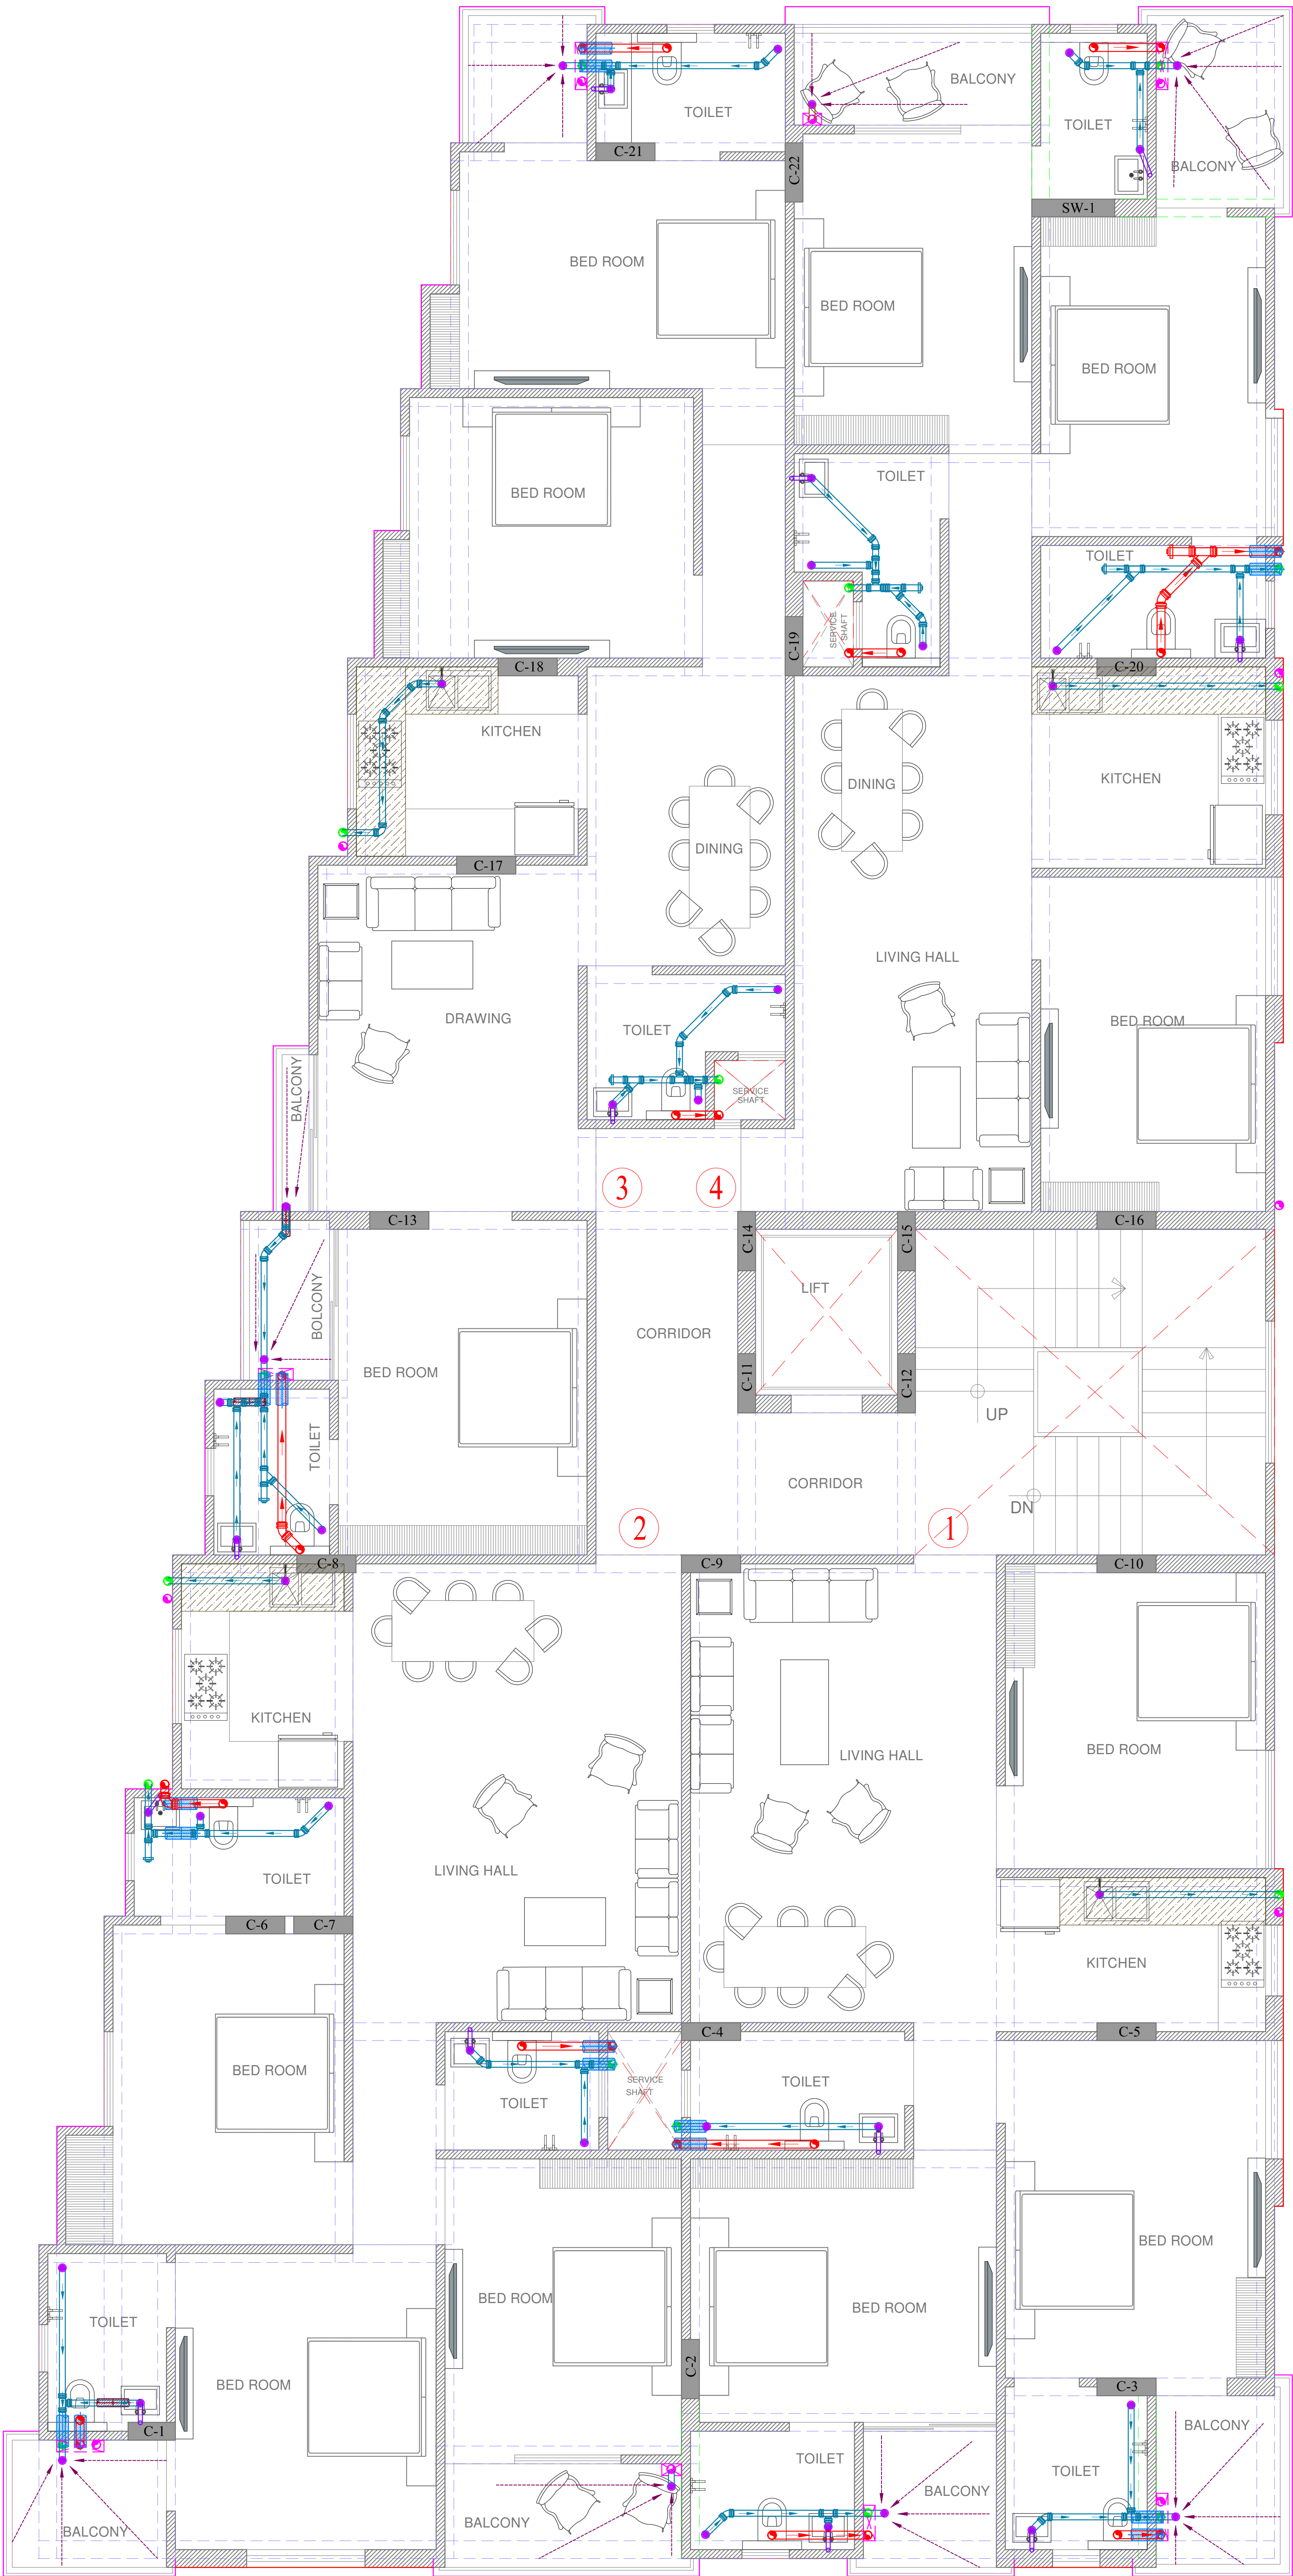

TYPICAL FLOOR WORKING PLAN

SYMBOL	DESCRIPTION
	Ø110 mm Soil Waste Water Pipe
	Ø110 mm Waste Water Pipe
	Ø110 mm Rain Water Pipe
	Ø110 mm Soil Waste Water Pipe Slope 1:150
	Ø110 mm Waste Water Pipe Slope 1:150
	Ø110 mm Rain Water Pipe Slope 1:200
	Ø75 mm Waste Water Pipe Internal Toilet Slope 1:150
	Ø75 mm Rain Water Pipe
	Ø40mm Waste Water Pipe Bottle Trap
	FLOOR TRAP
	Flow Direction
	6" Platform Raise

VIPUL AGARWAL
M.E.P. CONSULTANT
B.E. ELECTRICAL

SERVICES CONSULTANT:
ASHI ASSOCIATES
F 9 / 440 , Keshav Marg Chitrakut Scheme,Jaipur
PH:91-0-93146-10438 ,0141-2440946 Mail:vipul8599@yahoo.com
REV. NO. 00 DATE: 18-07-2024

DRN BY:- KEDAR	CKD BY:- SANJAY	APPD:- VIPUL AGARWAL
-------------------	--------------------	-------------------------

PROJECT ADDRESS:

PROPOSED BUILDING AT
PLOT NO.- 04 (RES.),
IN SCHEME :- SHIV SHAKTI NAGAR
VISTAR (NIJI KHATEDARI), JAIPUR

PROJECT NAME:
MJB ATHULYAM- II

PROMOTERS :-
MJB BUILD DEVELOPERS

DRAWING:
TYPICAL FLOOR DRAINAGE
LAYOUT PLAN

ARCHITECT:




ARCHITECTS, INTERIOR DESIGNERS AND ENGINEERS


B-6, Moti Marg, Bapu Nagar, Jaipur.
Ph.: 9314510603
E-Mail: spaceedgejpr@gmail.com

WORKING DRAWING

DATE : 08/07/2024

SCALE: NT

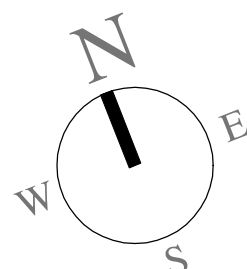

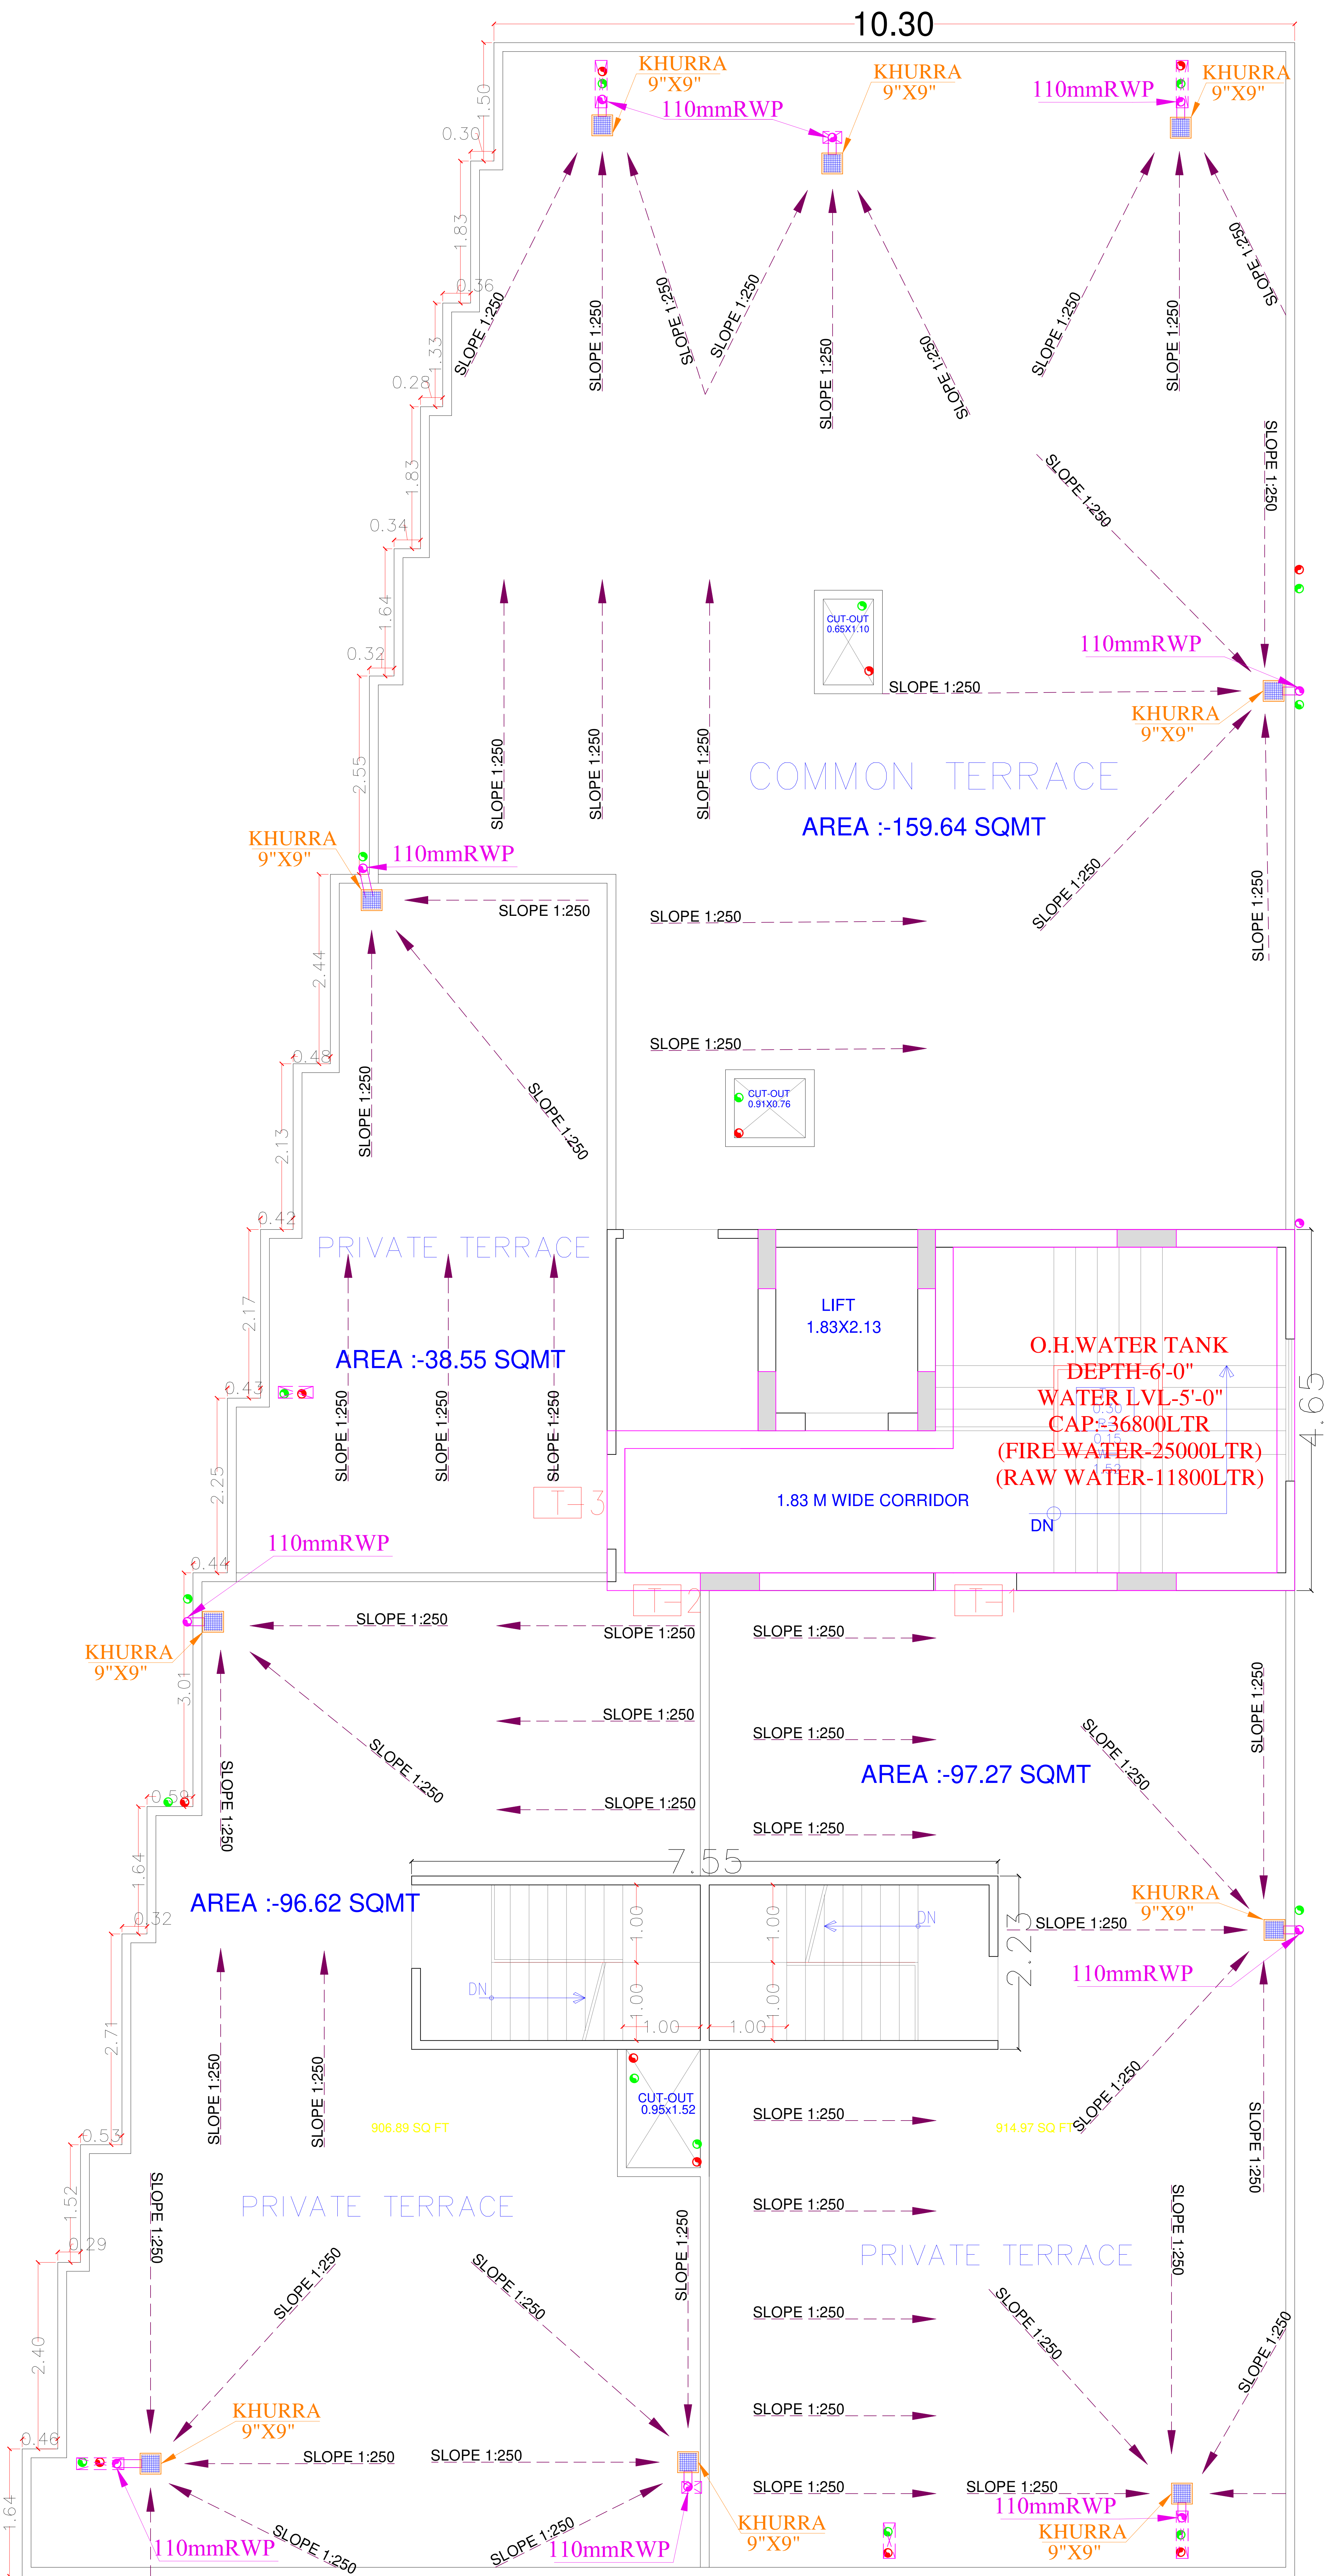

TERRACE FLOOR PLAN

SYMBOL	DESCRIPTION
	Ø110 mm Soil Waste Water Pipe
	Ø110 mm Waste Water Pipe
	Ø110 mm Rain Water Pipe
	Ø110 mm Soil Waste Water Pipe Slope 1:150
	Ø75mm Rain Water Pipe Slope 1:150
	Ø110 mm Rain Water Pipe Slope 1:150
	Floor Trap
	Flow Direction
	KHURRA 12"X12"

Vipul
VIPUL AGARWAL
M.E.P. CONSULTANT
B.E. ELECTRICAL

SERVICES CONSULTANT:
ASHI ASSOCIATES
F 9 / 440 , Keshav Marg Chitrakut Scheme,Jaipur
PH:91-0-93146-10438 ,0141-2440946 Mail:vipul8599@yahoo.com
REV. NO. 00 DATE: 18-07-2024

DRN BY: -	CKD BY: -	APPD.: -
NITIN	SANJAY	VIPUL AGARWAL

PROJECT ADDRESS:
**PROPOSED BUILDING AT
PLOT NO.- 04 (RES.),
IN SCHEME :- SHIV SHAKTI NAGAR
VISTAR (NIJI KHATEDARI), JAIPUR**

PROJECT NAME:
MJB ATHULYAM- II

PROMOTERS :-
MJB BUILD DEVELOPERS

DRAWING:
**TERRACE FLOOR RAIN
WATER SLOPE PLAN**

ARCHITECT:





ARCHITECTS, INTERIOR DESIGNERS AND ENGINEERS

B-6, Moti Marg, Bapu Nagar, Jaipur.
Ph.: 9314510603
E-Mail: spaceedgejpr@gmail.com

WORKING DRAWING

SH.NO.	DATE : 12-12-2024
01	SCALE: NTS

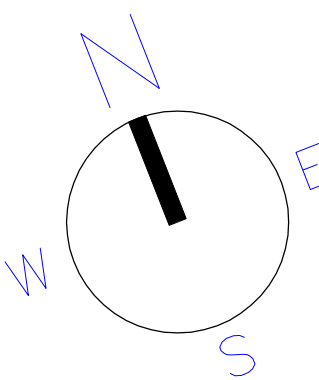

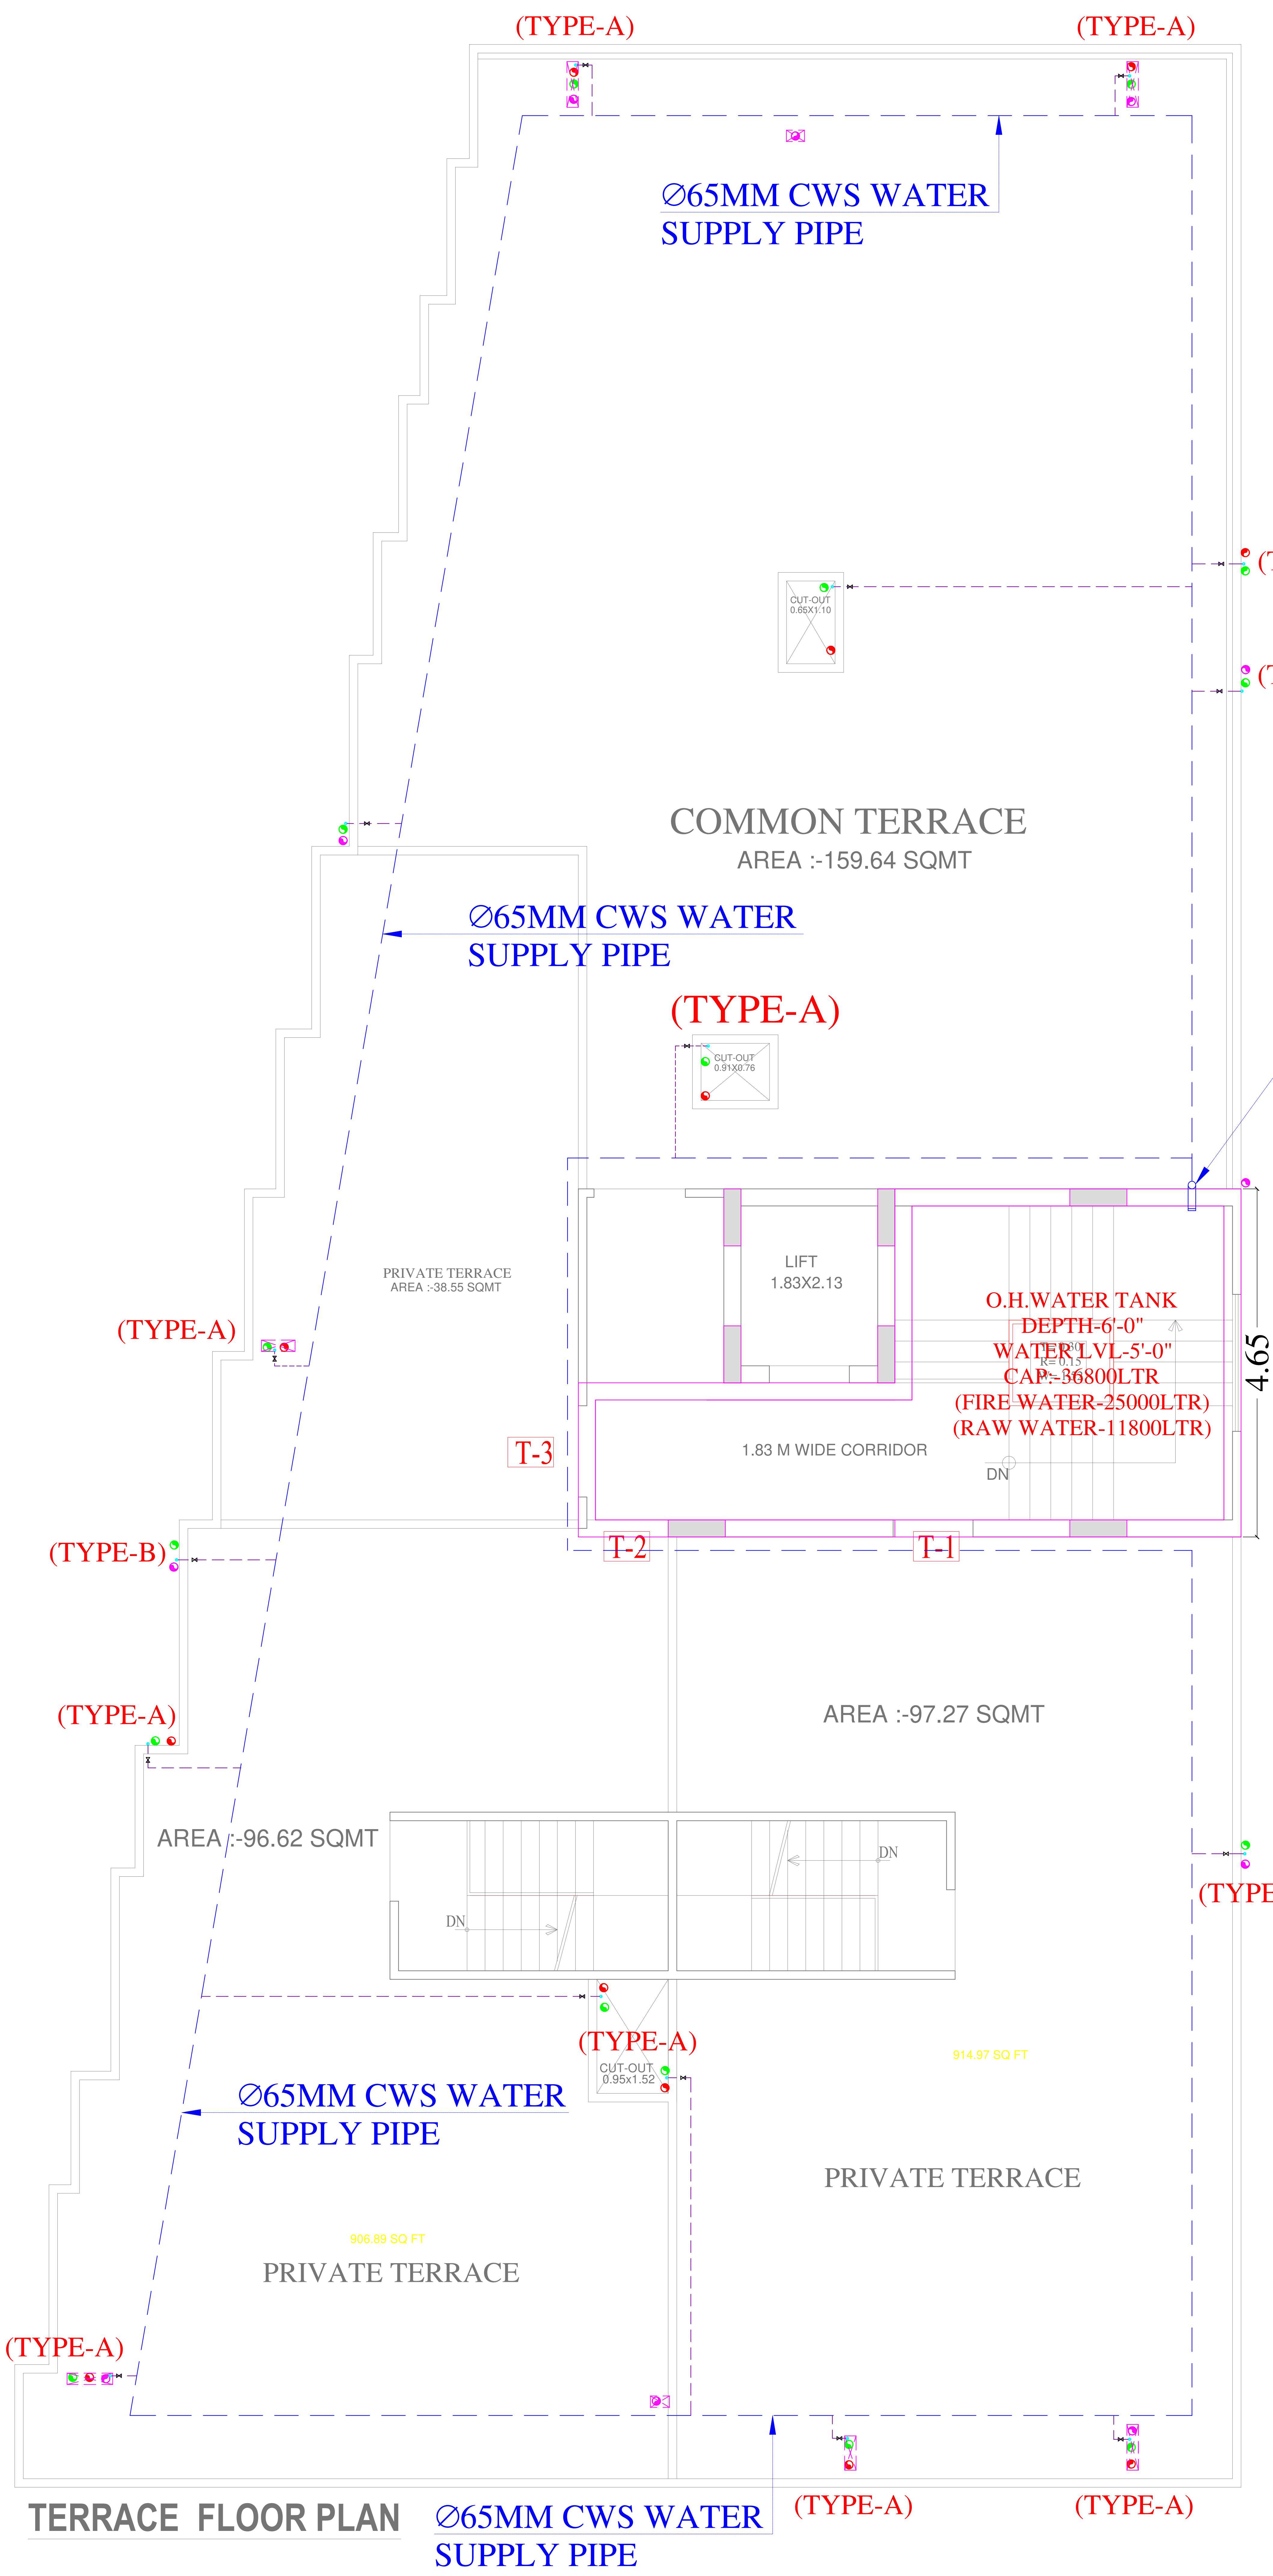

Cold Water Pipes Detail :-

	Ø65 mm CWS
	Ø40 mm CWS
✕	VALVE
CWS	Cold Water Supply Pipe
TYPICAL 6NOs. TOILET & KITCHEN SHAFT DOWN TAKE CWS PIPE DETAILS	
50MM - 5th. Floor only	
32mm- 2nd. TO 4th Floor only	
25mm-GROUND TO 1st Floor only	

Ø65MM CWS Gravity
Supply Pipe With 80MM
Stop Valve Vertical Down To
Terrace Level & Connected
To CWS Main Ring



SERVICES CONSULTANT:
ASHI ASSOCIATES
F 9 / 440 , Keshav Marg Chitrakut Scheme,Jaipur
PH:91-0-93146-10438 ,0141-2440946 Mail:vipul8599@yahoo.com

DRN BY:- RAAJ	CKD BY:- SANJAY	APPD.:- VIPUL AGARWAL
------------------	--------------------	--------------------------

PROJECT ADDRESS:


PROPOSED BUILDING AT
PLOT NO.- 04 (RES.),
IN SCHEME :- SHIV SHAKTI NAGAR
VISTAR (NIJI KHATEDARI), JAIPUR

PROJECT NAME:
MJB ATHULYAM- II

PROMOTERS :-
MJB BUILD DEVELOPERS

DRAWING:
**TERRACE FLOOR WATER
SUPPLY RING PLAN**

ARCHITECT:

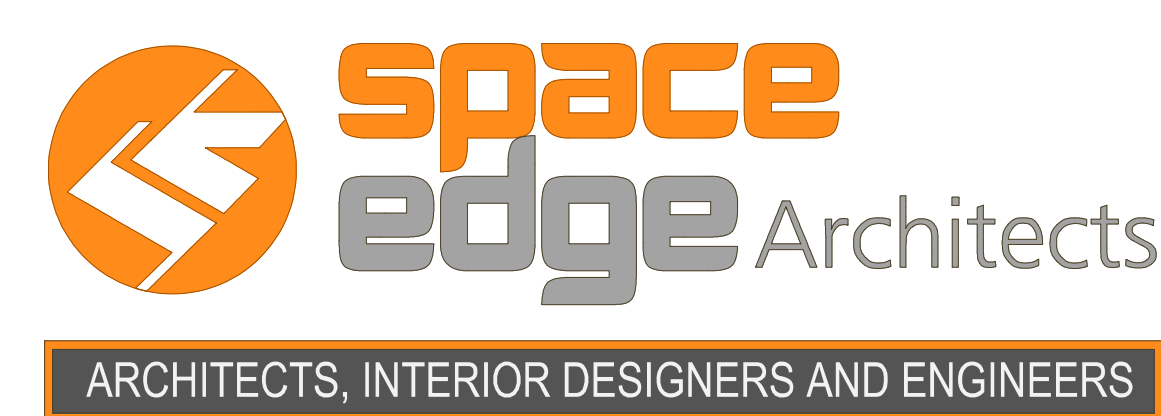

B-6, Moti Marg, Babu Nagar, Jaipur.
Ph.: 9314510603
E-Mail: spaceedgejpr@gmail.com

WORKING DRAWING

SH.NO. 01	DATE : 14-12-2024 SCALE: NTS
---------------------	---------------------------------

