


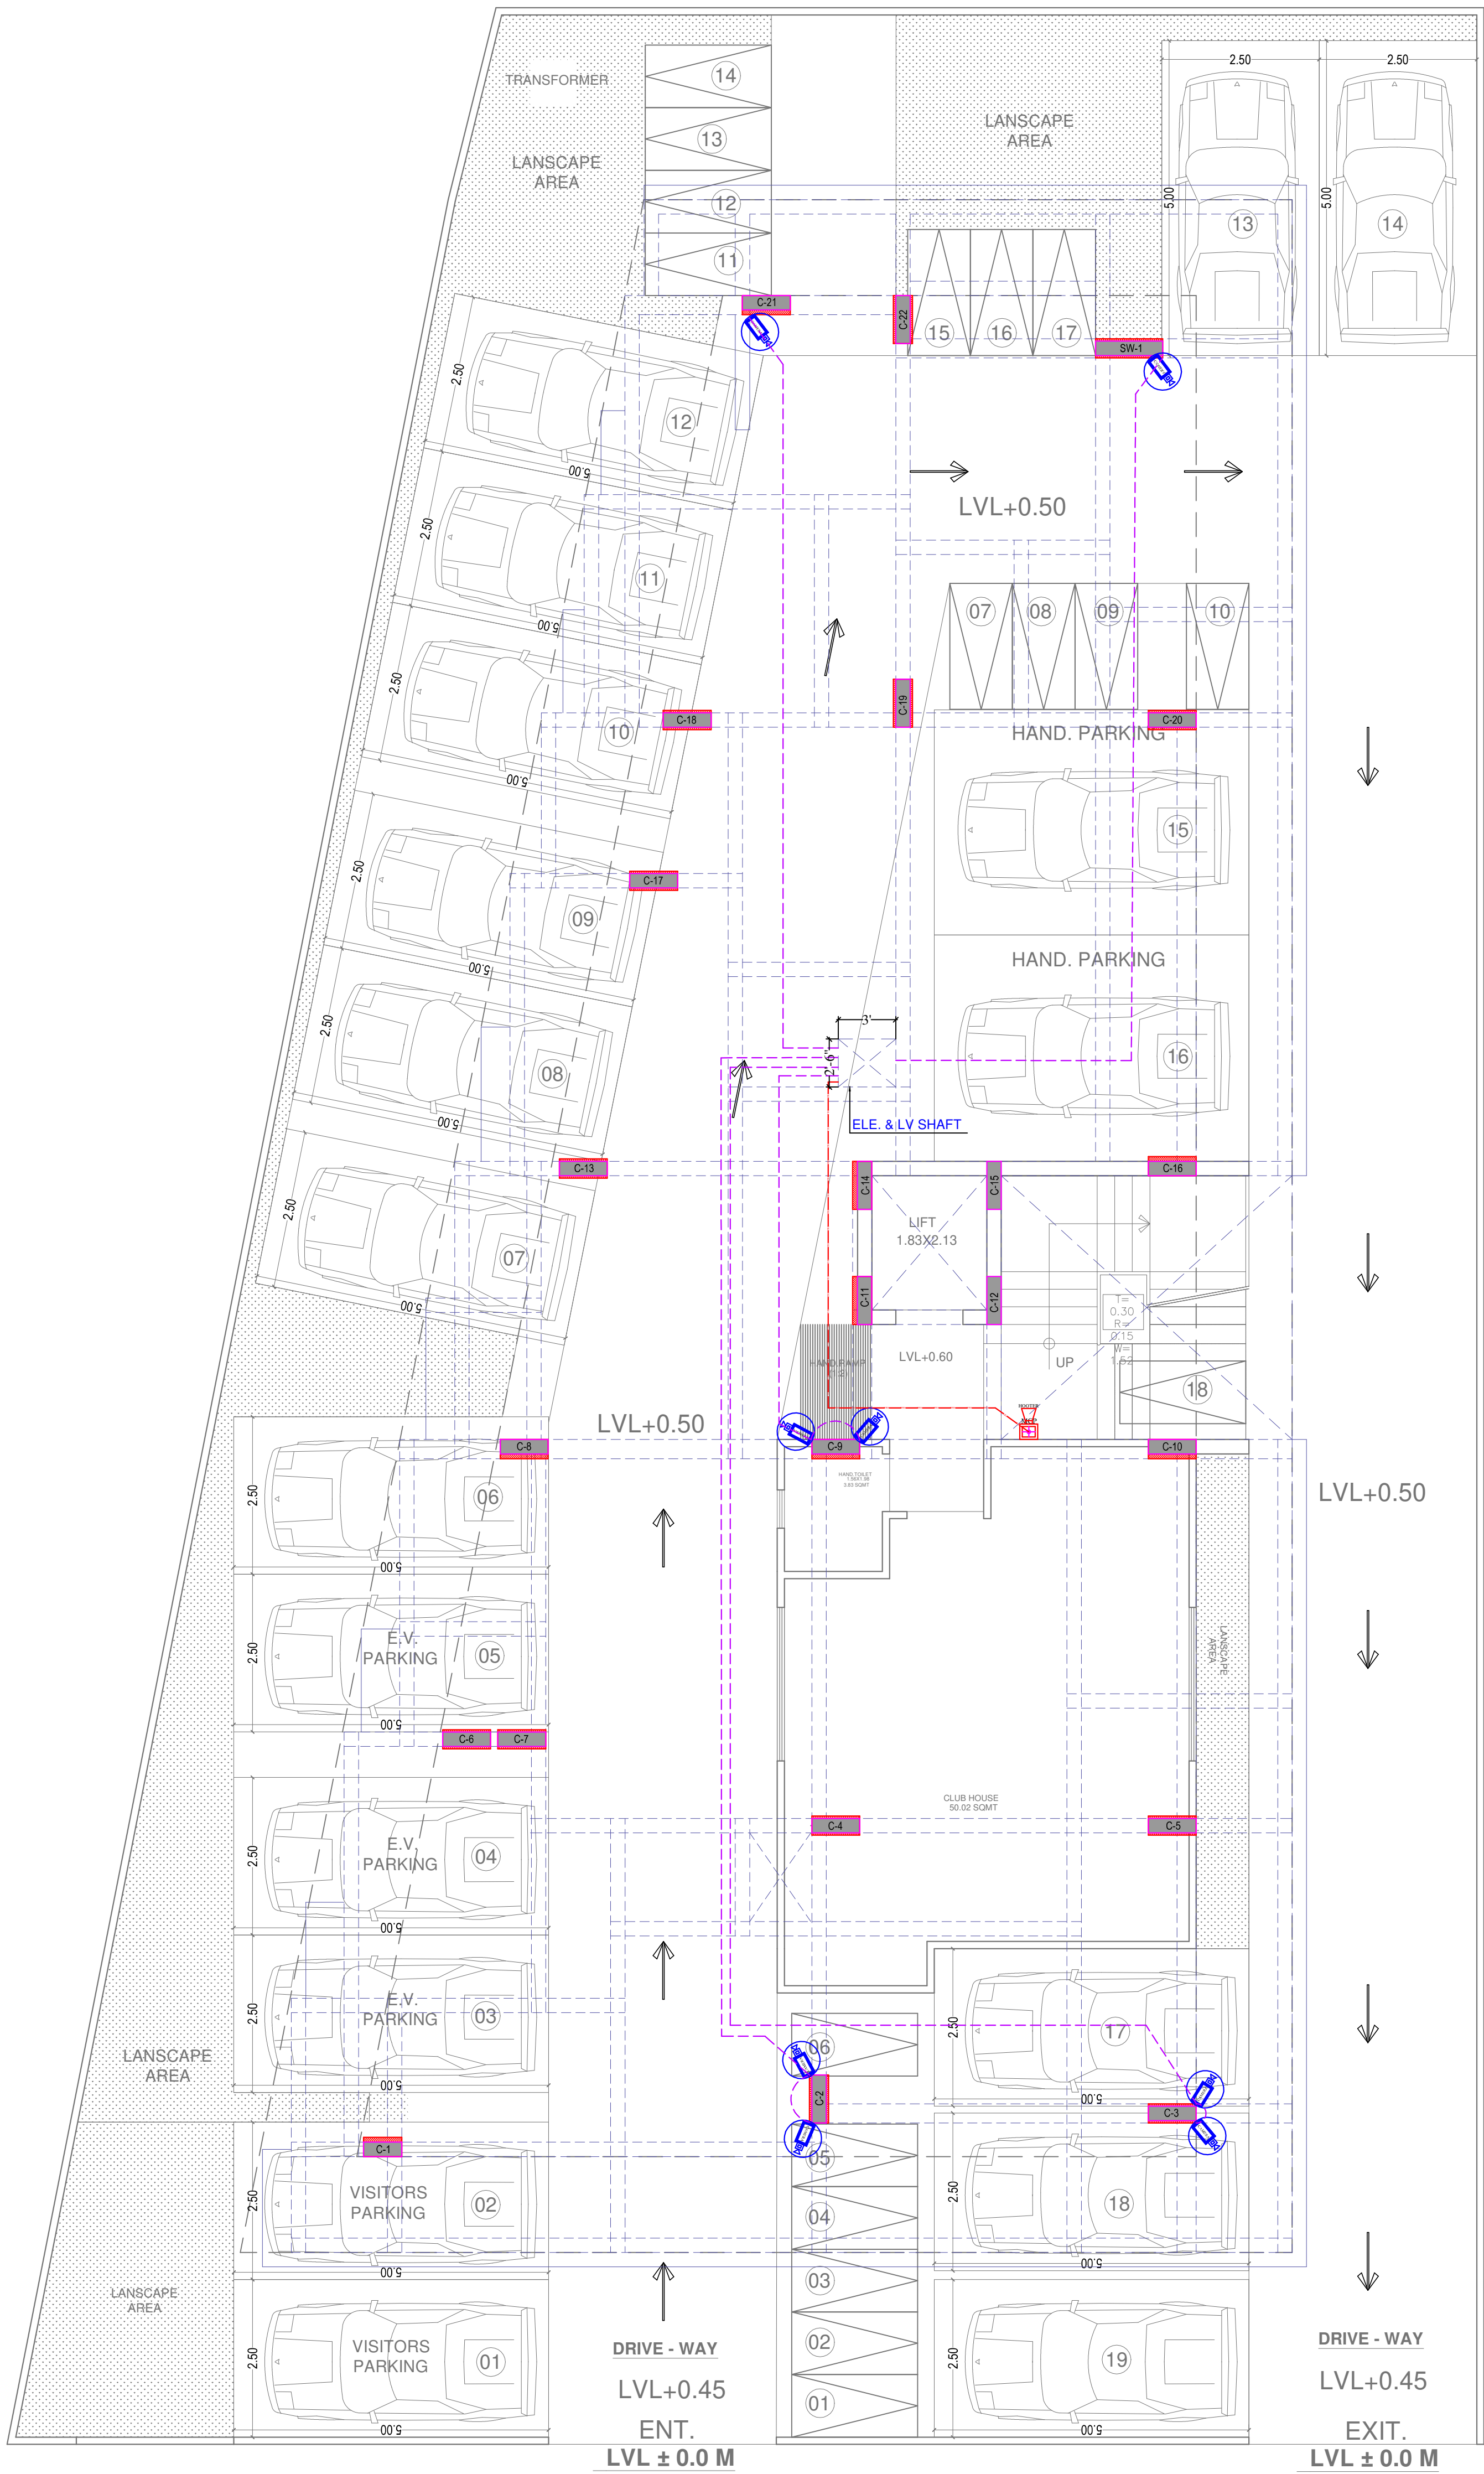

STILT FLOOR PLAN

60'-0" WIDE ROAD


Vipul
VIPUL AGARWAL
M.E.P. CONSULTANT
B.E. ELECTRICAL

LEGENDS:				
Mounting Height	No.	ID	Symbol	Description
IN RCC SLAB		CONDUIT	FIRE	Rigid PVC Conduit 25mm/ 2X1.5 sq. mm Copper Wire for Fire Alarm
IN RCC SLAB		CONDUIT	CCTV	Rigid PVC Conduit 25mm/3+1 coaxial wire/Cat-6 Cable for Security Camera (C.C.T.V.).
+42"	01	MCP		MANUAL CALL POINT
+90"	01	HO		HOOTER POINT
+90"	08	CCTV		WALL MOUNTED CCTV CAMERA

SERVICES CONSULTANT: ASHI ASSOCIATES F9/440,Keshav Marg Chitrakut Scheme,Jaipur PH:91-0-93146-10438 ,0141-2440946 Mail:vipul8599@yahoo.com	
DRAWN. BY: – HIMANSHU	CHKD. BY: – SANJAY
APPD. BY: – VIPUL AGARWAL	
DATE: – 12-06-2024	REV.: – 00

PROJECT ADDRESS:- PROPOSED BUILDING AT PLOT NO.- 04 (RES.), IN SCHEME :- SHIV SHAKTI NAGAR VISTAR (NIJI KHATEDARI), JAIPUR	PROJECT NAME: MJB ATHULYAM- II	NORTH:- 	ARCHITECT:- B-6, GANESH KRIPA, MOTI MARG, BAPU NAGAR JAIPUR - 302015. TEL. 9314510603, 0141-4062903
	PROMOTERS :- MJB BUILD DEVELOPERS		

STILT FLOOR
LV CONDUIT PLAN

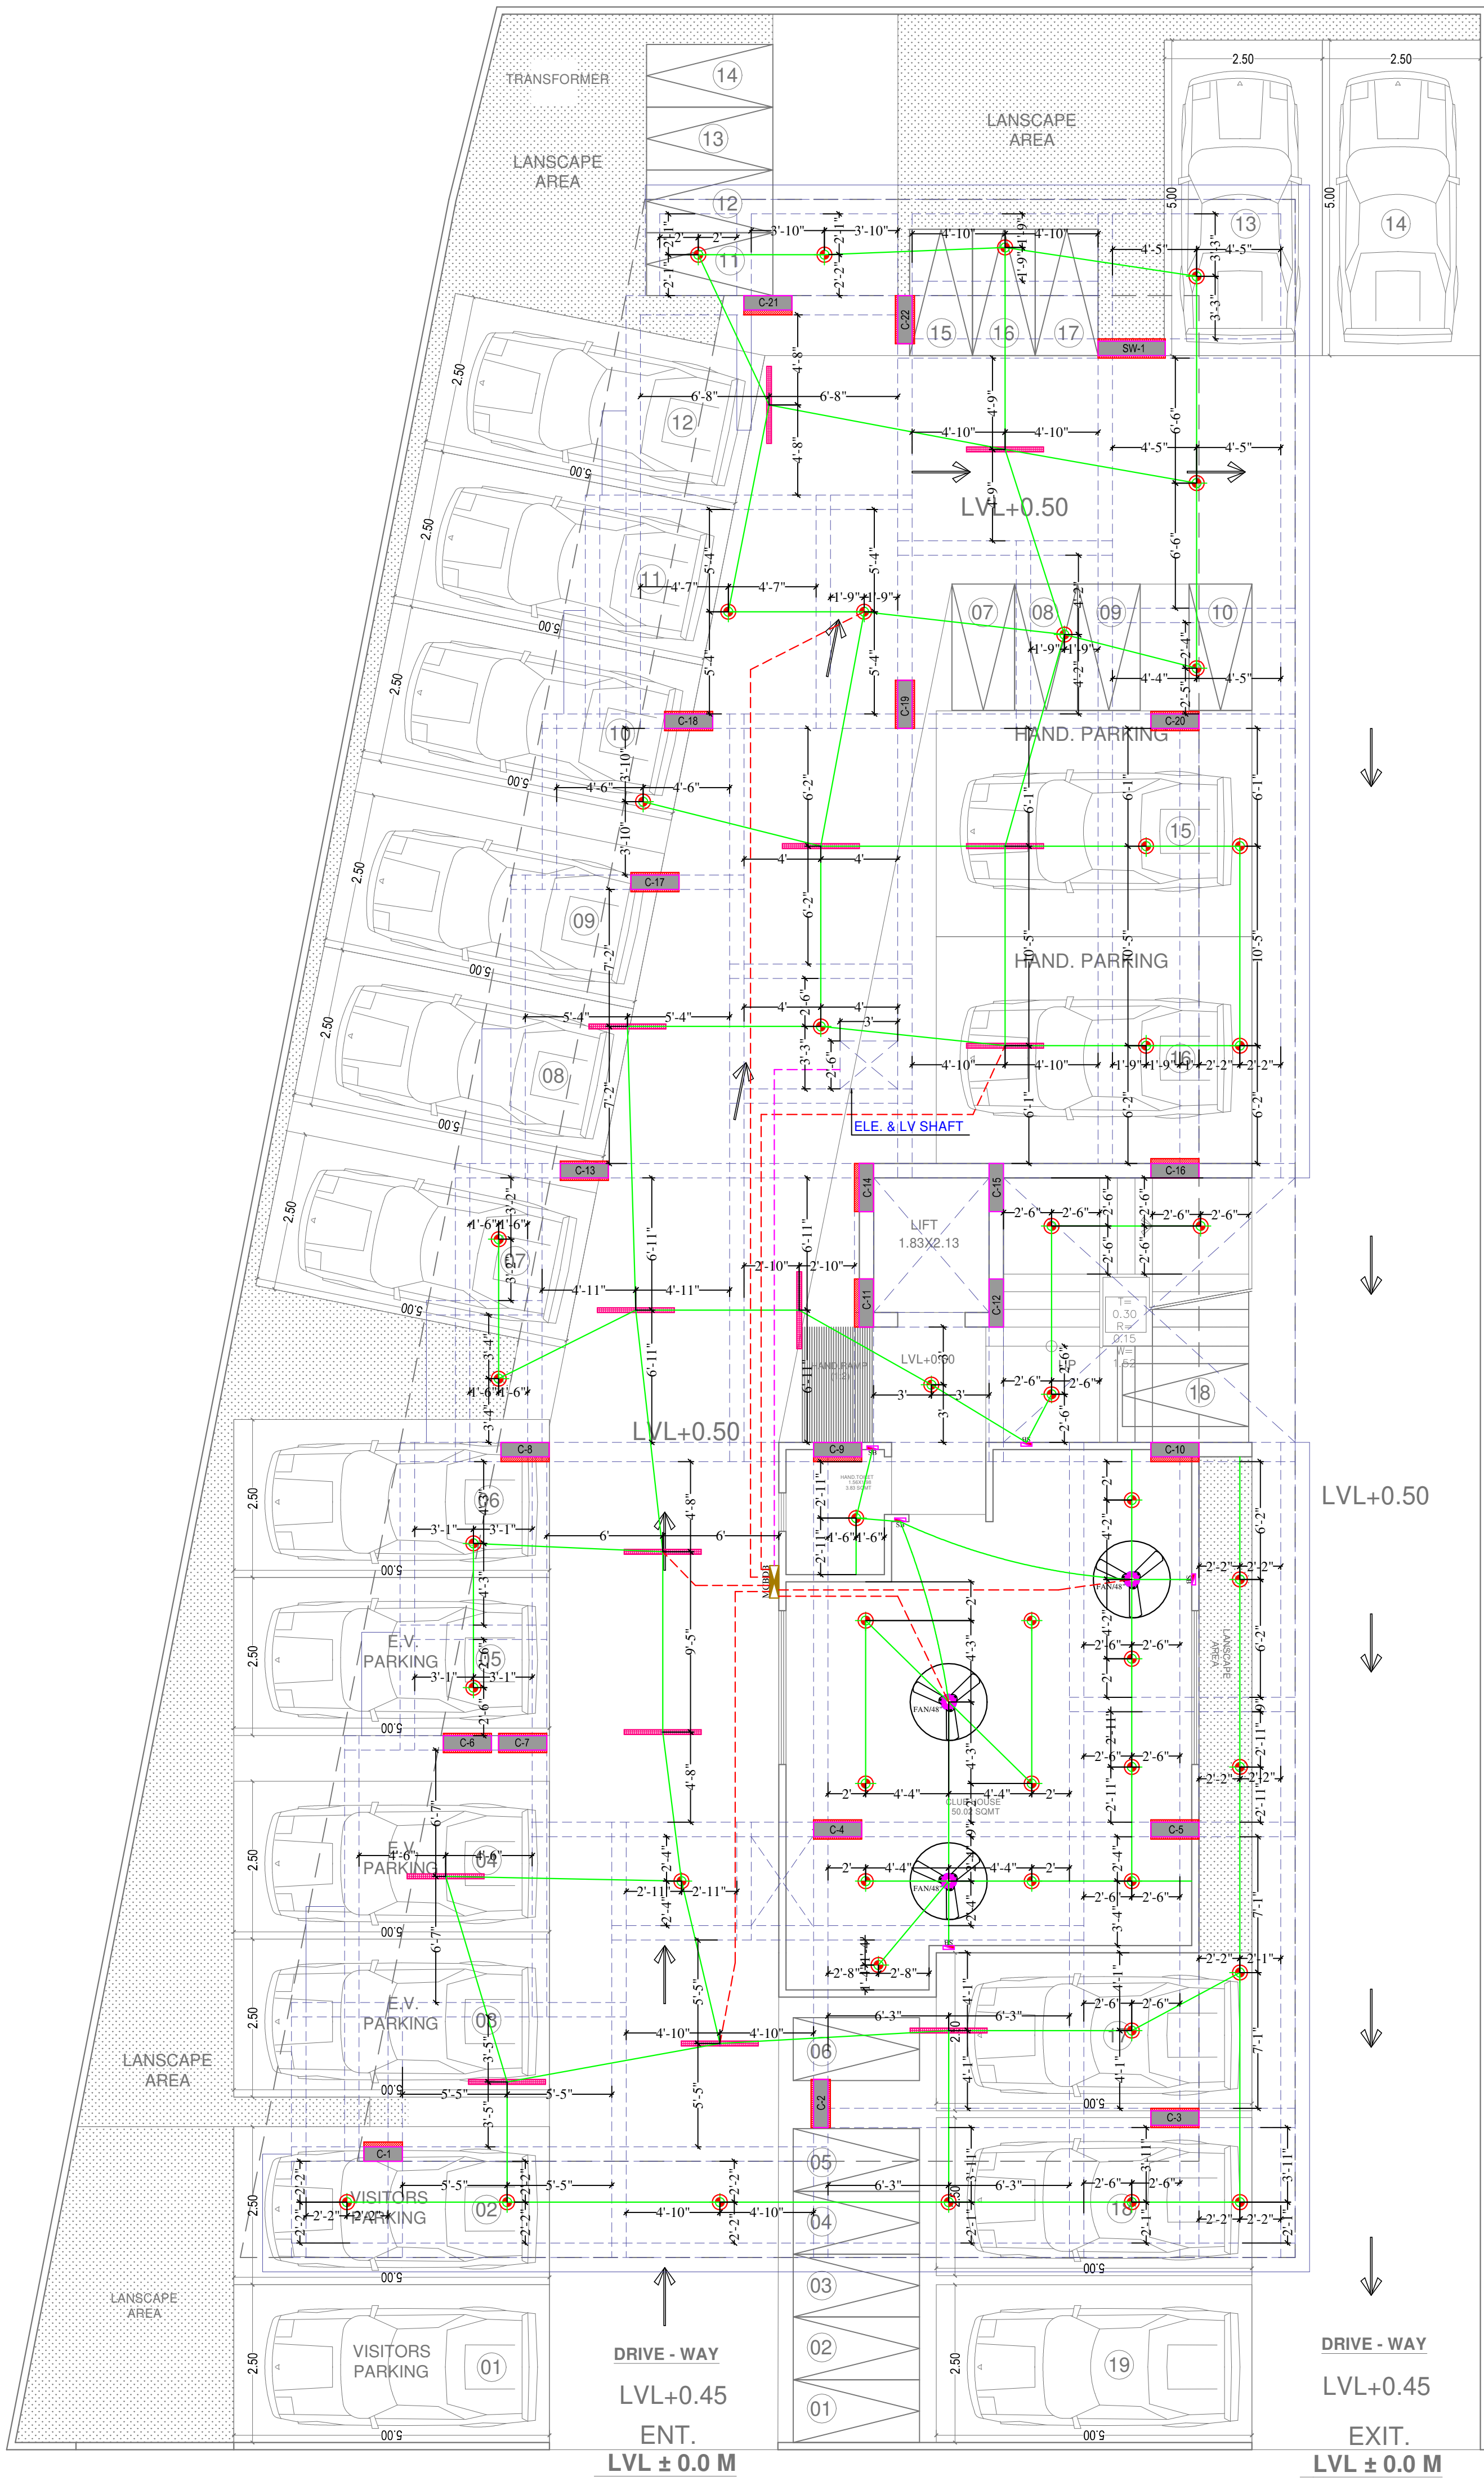

STILT FLOOR PLAN

60'-0" WIDE ROAD

Vipul
VIPUL AGARWAL
M.E.P. CONSULTANT
B.E. ELECTRICAL

LEGENDS:				
Mounting Height	No.	ID	Symbol	Description
IN RCC SLAB			CONDUIT	Rigid PVC Conduit 25mm/1.5 sqmm wire for Light points
IN RCC SLAB			CONDUIT	Rigid PVC Conduit 25mm/2.5 sqmm wire for Light Circuits
IN RCC SLAB			CONDUIT	Submain wire to DB from Main Panel on Ground Floor in 1 nos. 32mm dia conduits
CEILING	03	FAN/48"		CEILING FAN 48"
CEILING	12	TL		LED CEILING TUBE LIGHT MAKE:- SYSKA LED CAT NO:- SSK-T5-20W
CEILING	46	DL		Led 6" Down Lighter 20W (Surface Mounted) Make:- Syska Led Cat no:- SDL-15W GLD 6.5K/4K
+42"	05	SB		SWITCH BOARD
+60"	01	MCB DB		MCB DISTRIBUTION BOARD

SERVICES CONSULTANT:
ASHI ASSOCIATES
F9/440,Keshav Marg Chitrakut Scheme,Jaipur
PH:91-0-93146-10438 ,0141-2440946 Mail:vipul8599@yahoo.com

DRAWN. BY: —
HIMANSHU

CHKD. BY: —
SANJAY

APPD. BY: —

VIPUL AGARWAL


DATE: —
12-06-2024

REV.: —
00

PROJECT ADDRESS:-
PROPOSED BUILDING AT PLOT NO.- 04 (RES.),
IN SCHEME :- SHIV SHAKTI NAGAR
VISTAR (NIJI KHATEDARI), JAIPUR


PROJECT NAME:
MJB ATHULYAM- II

PROMOTERS :-
MJB BUILD DEVELOPERS

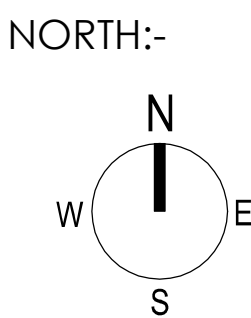

ARCHITECT:-
space edge Architects
B-6, GANESH KRIPA, MOTI MARG,
BAPU NAGAR JAIPUR - 302015.
TEL. 9314510603, 0141-4062903

STILT FLOOR ELECTRICAL
CONDUIT PLAN

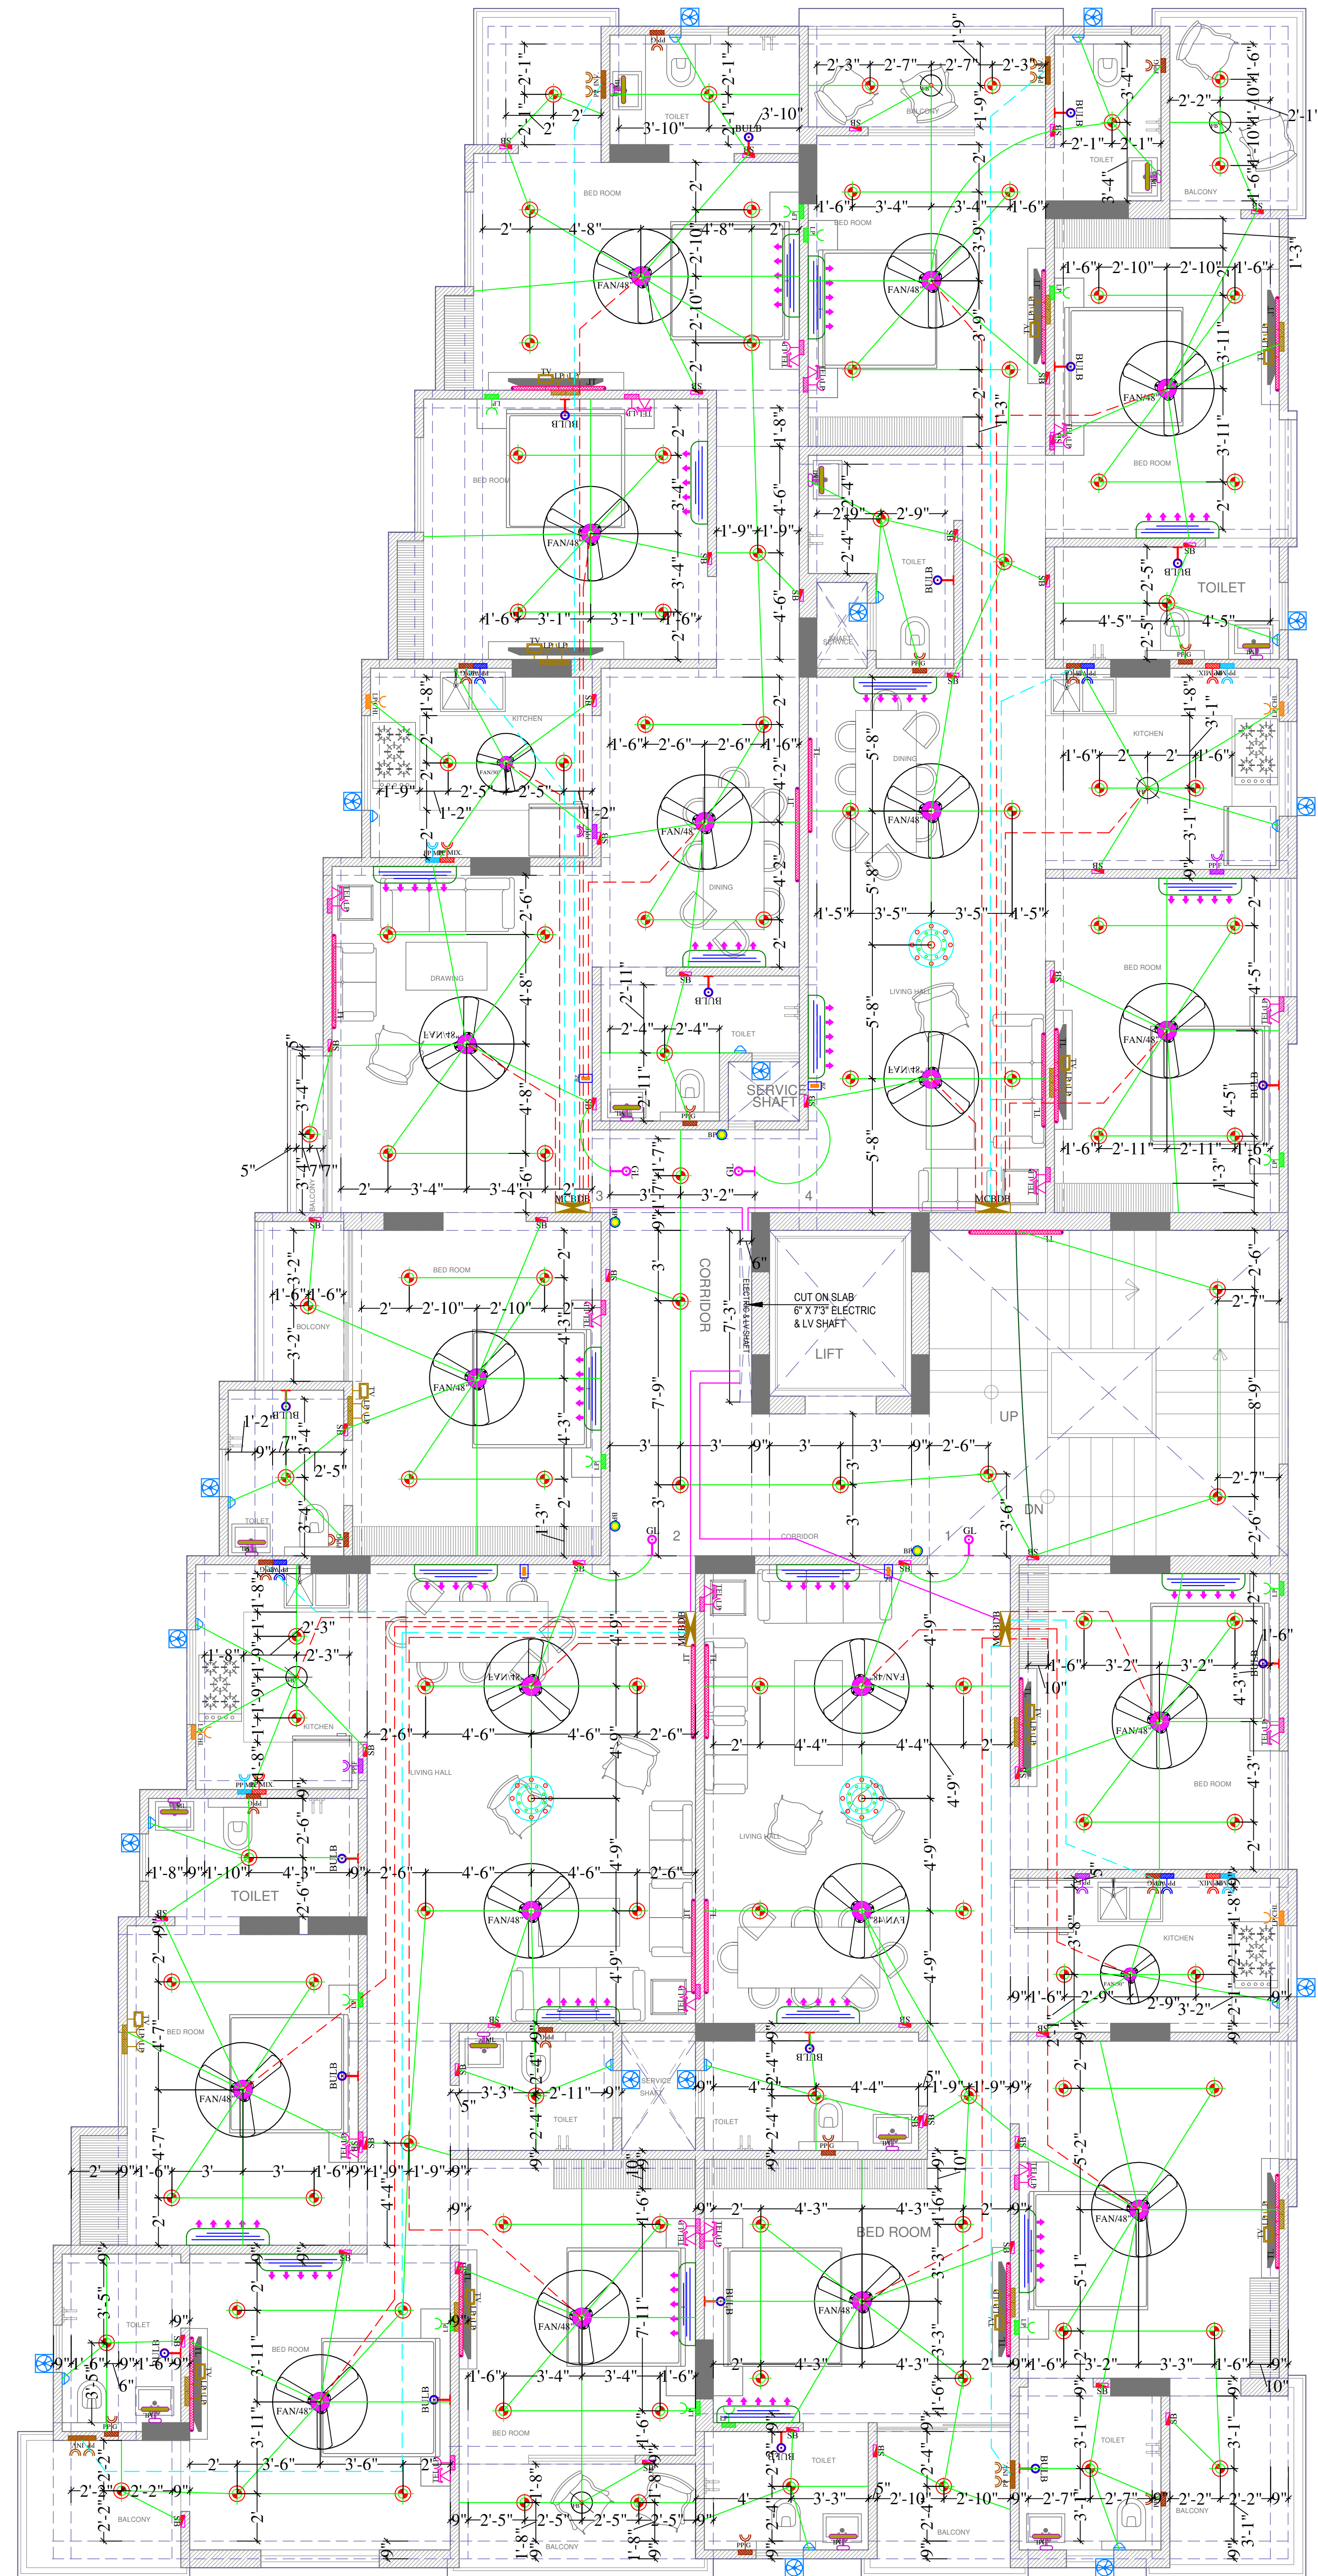

GROUND FLOOR WORKING PLAN

VIPUL AGARWAL
M.E.P. CONSULTANT
B.E. ELECTRICAL

LEGENDS:				
Mounting Height	No.	I D	Symbol	Description
IN RCC SLAB		CONDUIT		Rigid PVC 25mm dia. Conduit /1.5 sqmm Wire For Light Points
IN FLOOR		CONDUIT		Rigid PVC 25mm dia. Conduit /1.5 sqmm Wire For Light Points
IN RCC SLAB		CONDUIT		Rigid PVC 25mm dia. Conduit /2.5 sqmm Wire For Light Circuits
IN RCC SLAB		CONDUIT		Rigid PVC 25mm dia. Conduit / 4.00 sqmm Wire For Power Circuits
IN RCC SLAB		CONDUIT		Submain Wire to DB From Main Panel on Ground Floor in 1nos. 32mm dia Conduits
CEILING	20	FAN/48"		CEILING FAN 48"
CEILING	02	FAN/30"		CEILING FAN 30"
CEILING	05	FB		FAN BOX
CEILING	03	CH1		CHANDELIER
+90"	18	TL/W		LED WALL TUBE LIGHT MAKE:- SYSKA LED CAT NO.- SSK-TS-20W
+90"	18	BULB		LED BULB 20W MAKE:- SYSKA LED CAT NO.- SKC-20W 5.7K/3K
+90"	04	GL		WALL BRACKETS AS DESIGN FOR GANESH LIGHT
+78"	12	ML		12X2 LED MIRROR LIGHT MAKE:- SYSKA LED CAT NO.- FPL-12X2
CEILING	111	DL		LED 6" DOWN LIGHTER 20W (SURFACE MOUNTED) MAKE:- SYSKA LED CAT NO.- SDL-15W GLD 6.5K/4K
VENTILATOR HT.	16	CR		CEILING ROSE
VENTILATOR HT.	16	EXP		9" DIA FRESH AIR FAN
+42"	51	SB		SWITCH BOARD
+24"	16	TEL		TELEPHONE POINT
+24"	16	LP TEL		6 A PLUG POINT FOR TELEPHONE
+48"	12	TV		TV COAXIAL POINT
+48"	24	LP TV		6 A PLUG POINT FOR TV
+24"	12	LP		6 A PLUG POINT FOR SIDE TABLE
+72"	04	LP-CH		6 A PLUG POINT FOR CHIMNEY
+90"	20	SAC		SPLIT AC INDOOR UNIT
+42"	04	PP-MIX		16 A POWER POINT FOR MIXER
+42"	04	PP-MIC		16 A POWER POINT FOR MICROWAVE
+78"	16	PP-G		16 A POWER POINT FOR GEYSER
+54"	04	PP-F		16 A POWER POINT FOR FRIDGE
+78"	04	PP-WP		16 A POWER POINT FOR WATER PURIFIER
+48"	00	PP-WM		16 A POWER POINT FOR WASHING MACHINE
+12"	08	PP-INV.		16 A POWER POINT FOR INVERTOR
+60"	04	BP		6 A BELL PUSH
+90"	04	BZ		BUZZER FOR CALL BELL
+60"	04	MCB DB		MCB DISTRIBUTION BOARD

SERVICES CONSULTANT:
ASHI ASSOCIATES
F 9 / 440 , Keshav Marg Chitrakut Scheme,Jaipur
PH:91-0-93146-10438 ,0141-2440946 Mail:vipul8599@yahoo.com
REV. NO. 00 DATE: 18-07-2024

DRN BY:- KEDAR	CKD BY:- SANJAY	APPD.:- VIPUL AGARWAL
-------------------	--------------------	--------------------------

PROJECT ADDRESS:

PROPOSED BUILDING AT
PLOT NO.- 04 (RES.),
IN SCHEME :- SHIV SHAKTI NAGAR
VISTAR (NIJI KHATEDARI), JAIPUR


PROJECT NAME:
MJB ATHULYAM- II
PROMOTERS :-
MJB BUILD DEVELOPERS


DRAWING:
**GROUND FLOOR ROOF
ELECTRIC CONDUIT PLAN**
ARCHITECT:




ARCHITECTS, INTERIOR DESIGNERS AND ENGINEERS

B-6, Moti Marg, Bapu Nagar, Jaipur.
Ph.: 9314510603
E-Mail: spaceedgejpr@gmail.com

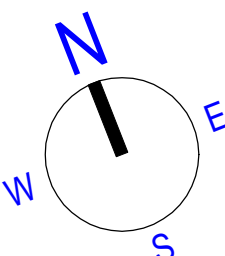WORKING DRAWING	
DATE : 08-10-2024	
SCALE: NT=01	

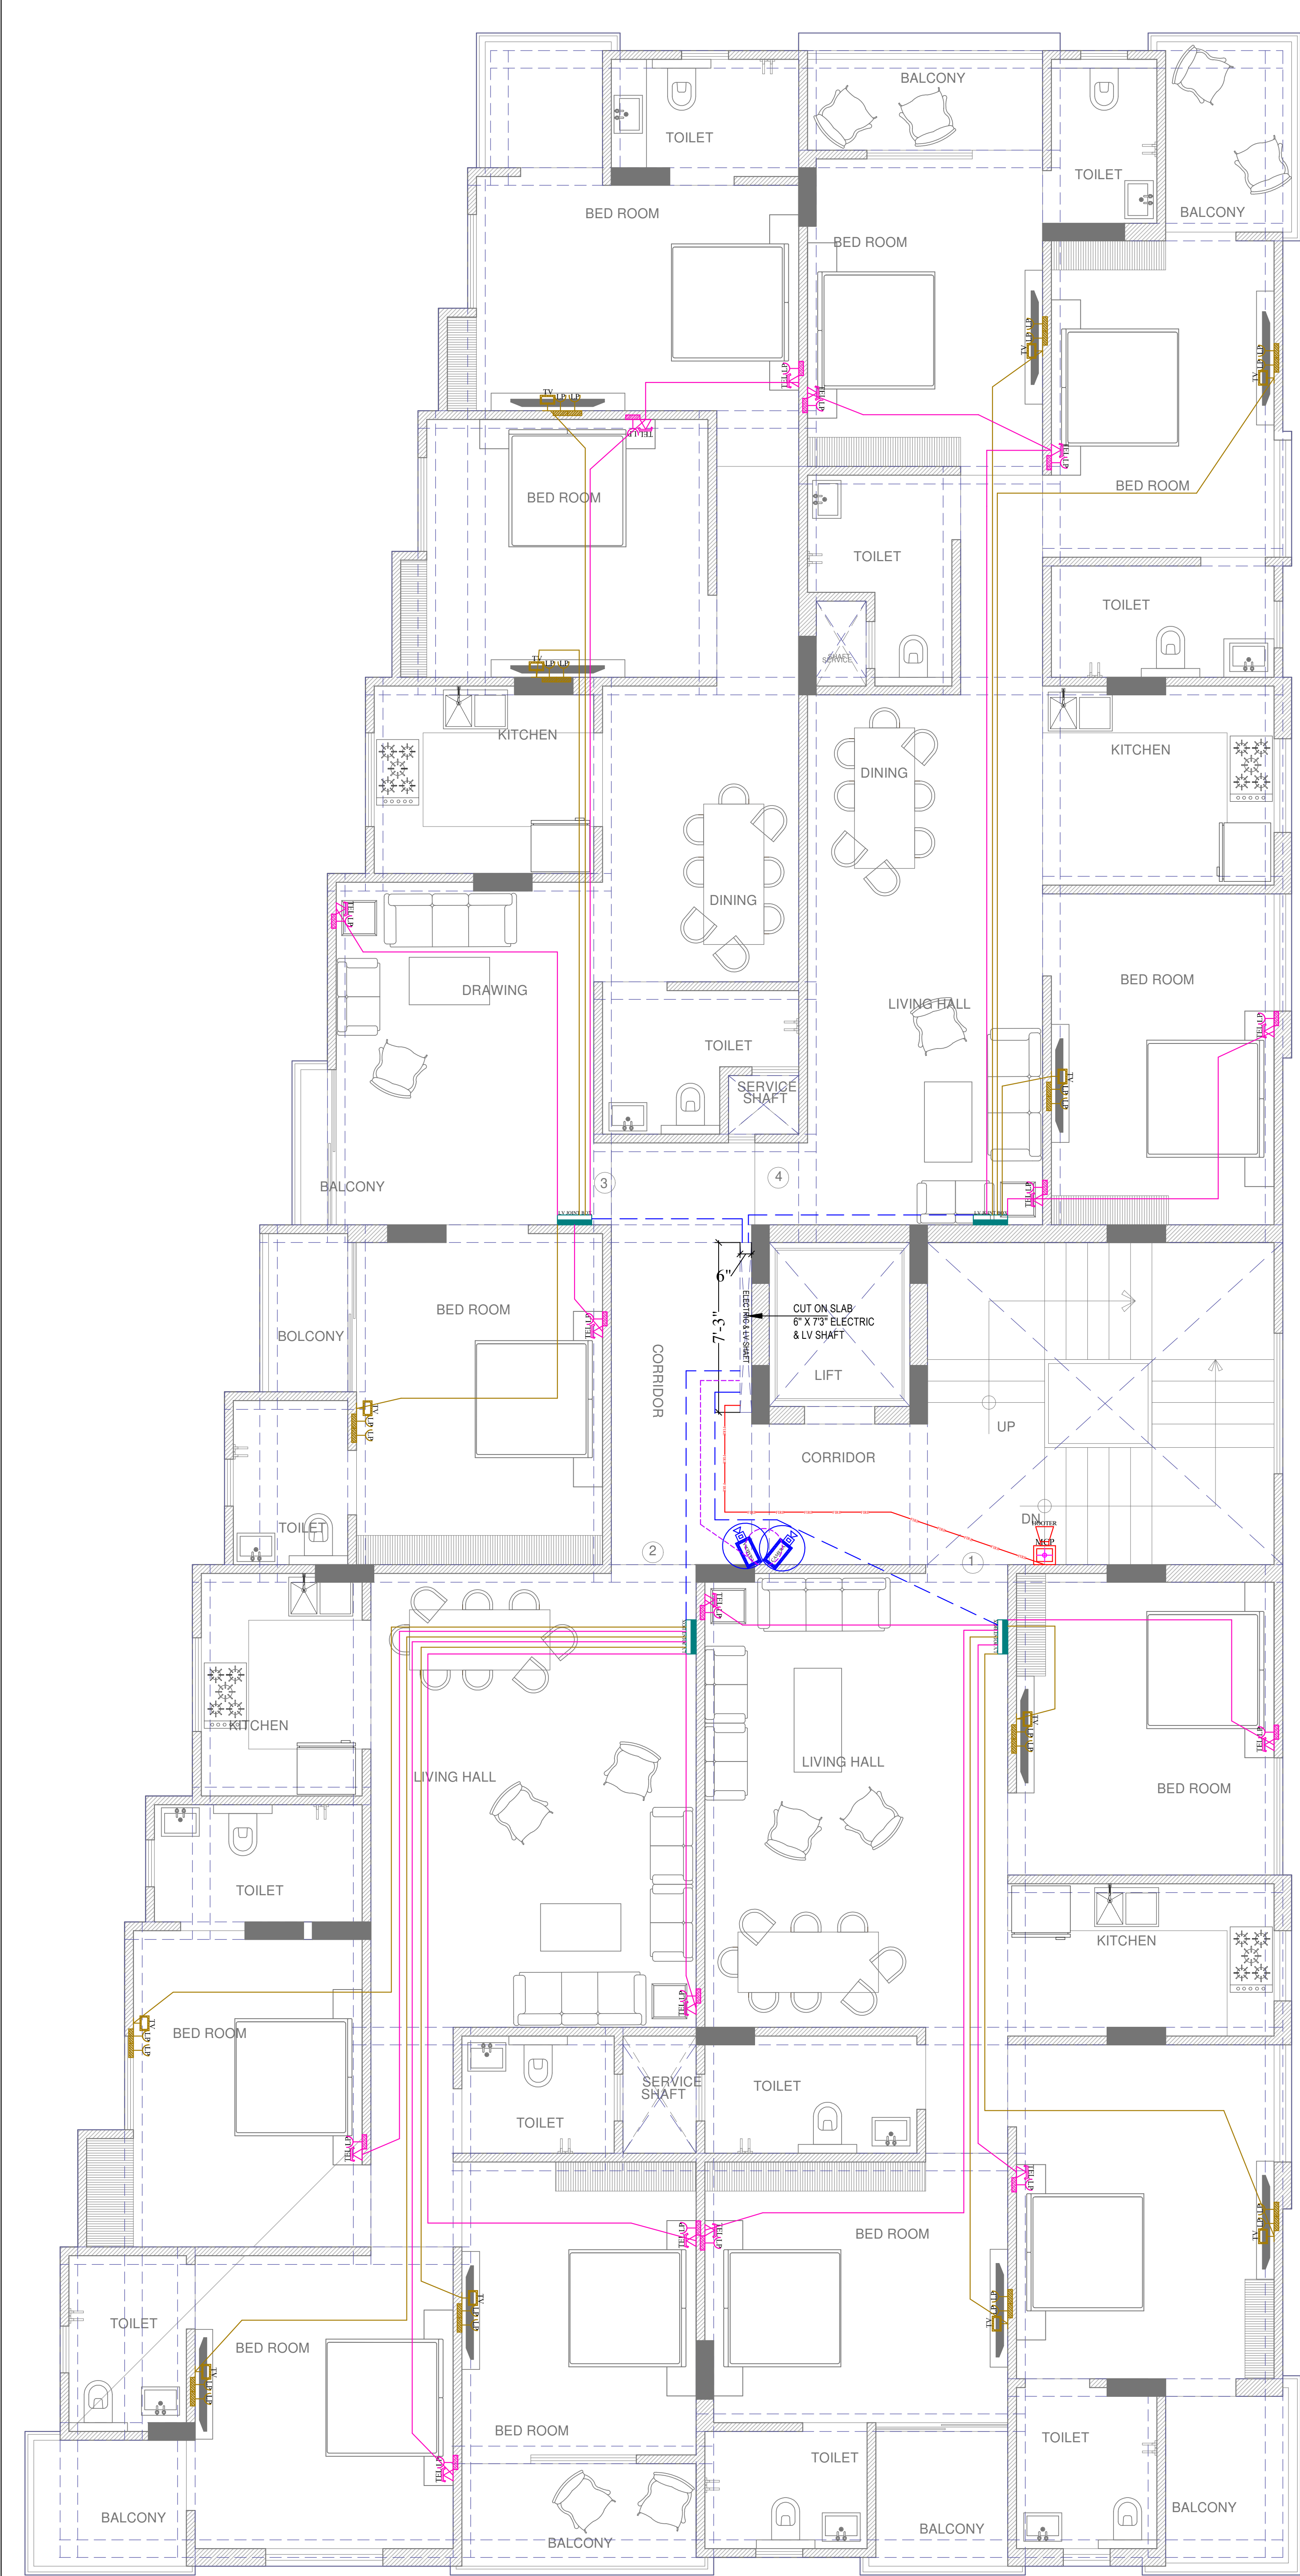

GROUND FLOOR WORKING PLAN

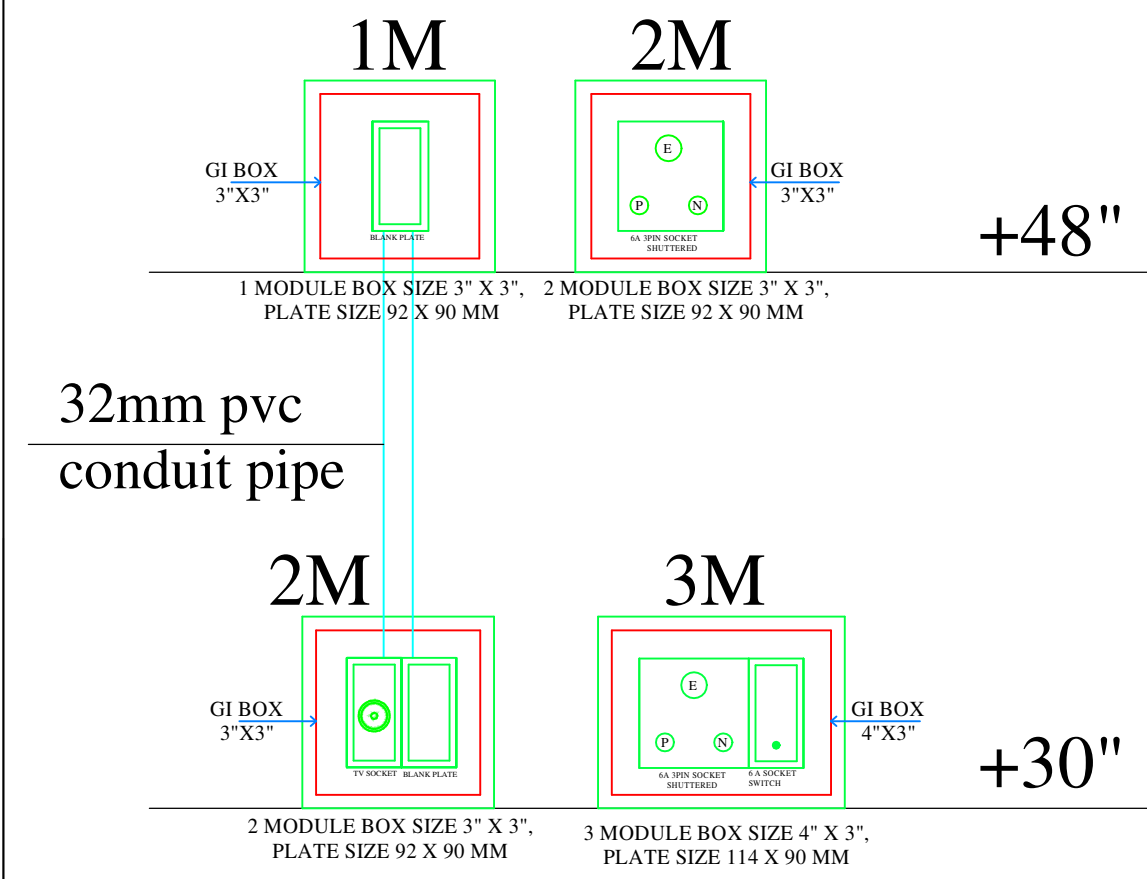

TYPICAL TV WALL ELEVATION PLAN

 VIPUL AGARWAL M.E.P. CONSULTANT B.E. ELECTRICAL				
LEGENDS:				
Mounting Height	No.	I D	Symbol	Description
IN FLOOR		CONDUIT		Rigid PVC 25mm dia. Conduit / 0.5mm 2 Pair Wire For Tel Wiring
IN FLOOR		CONDUIT		Rigid PVC 25mm dia. Conduit / RG6 Cable For TV Wiring
IN RCC SLAB		CONDUIT		1Nos. 32 mm dia Conduits From Flat LV System to Drop LV Shaft
IN RCC SLAB		CONDUIT		Rigid PVC Conduit 25mm/3+1 Coaxial Wire/Cat-6 Cable for Video Door Phone & Security Camera (C.C.T.V.).
IN RCC SLAB		CONDUIT		Rigid PVC 25mm dia. Conduit / 2X1.5 sq. mm Copper Wire For Fire Alarm
+24"	16	TEL		TELEPHONE POINT
+24"	16	LP TEL		6 A PLUG POINT FOR TELEPHONE
+48"	12	TV		TV COAXIAL POINT
+48"	24	LP TV		6 A PLUG POINT FOR TV
+24"	04			LV JOINT BOX
+42"	01	MCP		MANUAL CALL POINT
+90"	01	HO		HOOTER POINT
+90"	02	CCTV		WALL MOUNTED CCTV CAMERA

SERVICES CONSULTANT:
ASHI ASSOCIATES
F 9 / 440 , Keshav Marg Chitrakut Scheme,Jaipur
PH:91-0-93146-10438 ,0141-2440946 Mail:vipul8599@yahoo.com
REV. NO. 00 DATE: 18-07-2024

DRN BY:- KEDAR	CKD BY:- SANJAY	APPD.:- VIPUL AGARWAL
-------------------	--------------------	--------------------------

PROJECT ADDRESS:

PROPOSED BUILDING AT
PLOT NO.- 04 (RES.),
IN SCHEME :- SHIV SHAKTI NAGAR
VISTAR (NIJI KHATEDARI), JAIPUR

PROJECT NAME:
MRB ATHULYAM- II

PROMOTERS :-
MRB BUILD DEVELOPERS

DRAWING:

**GROUND FLOOR ROOF LV
CONDUIT PLAN**

ARCHITECT:




**space
edge** Architects

ARCHITECTS, INTERIOR DESIGNERS AND ENGINEERS

B-6, Moti Marg, Bapu Nagar, Jaipur.
Ph.: 9314510603
E-Mail: spaceedgejpr@gmail.com

WORKING DRAWING

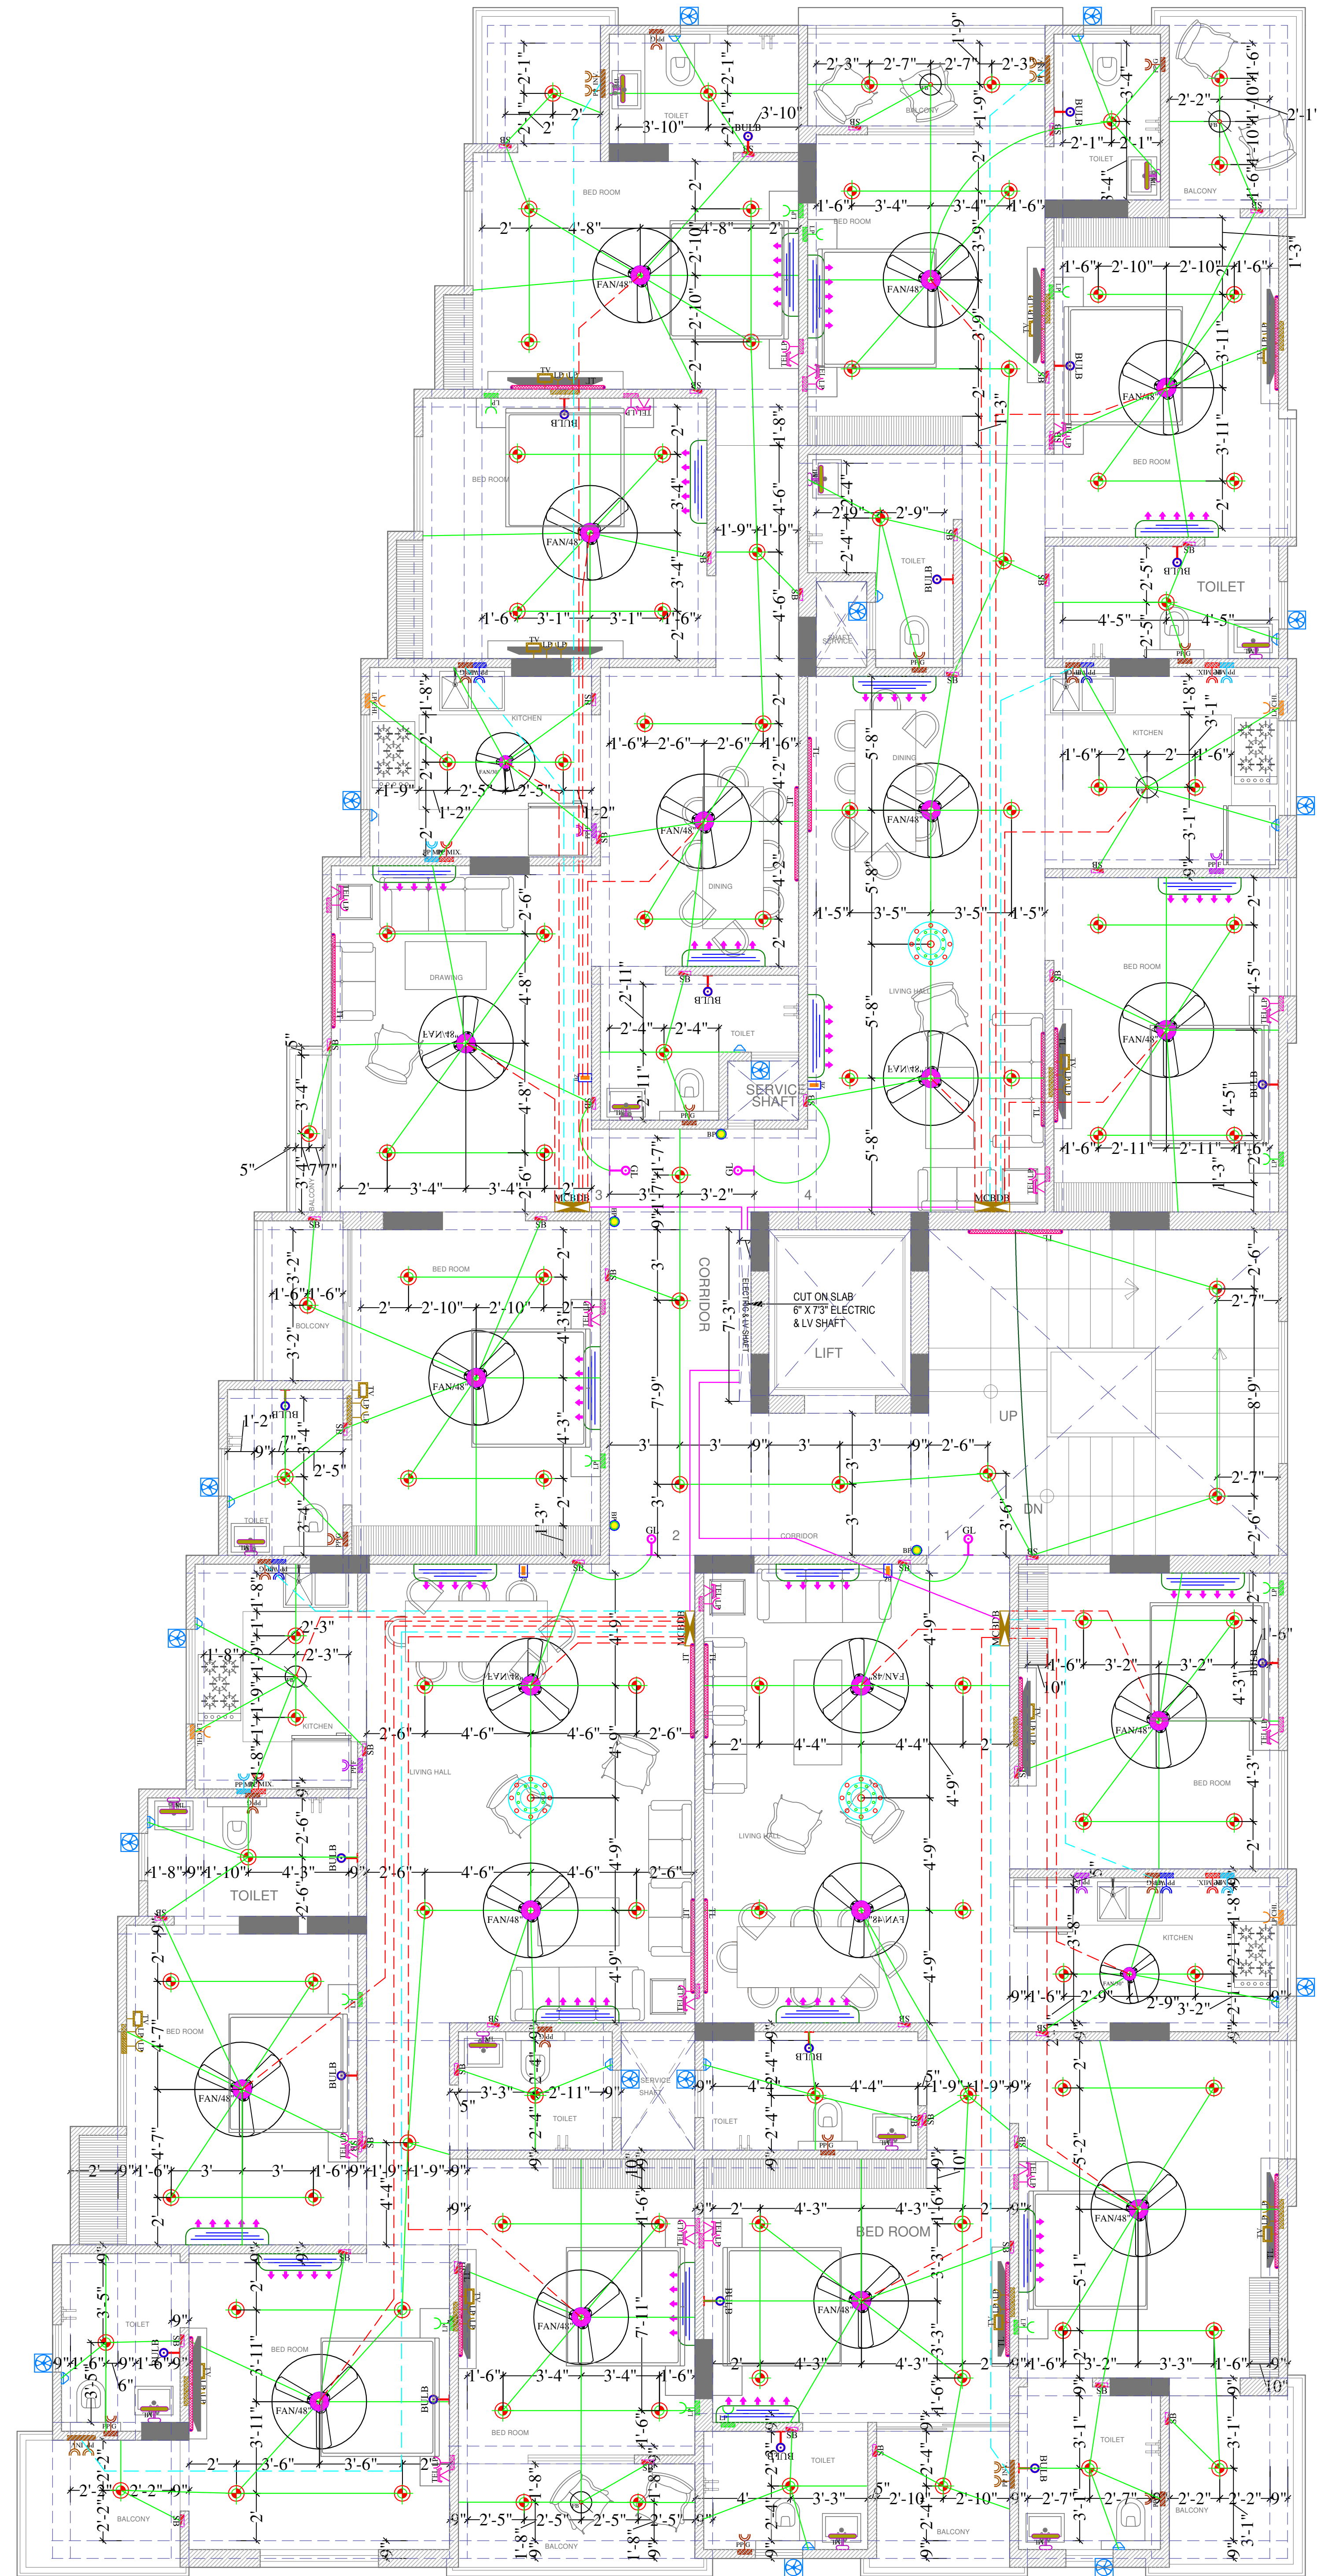

GROUND FLOOR WORKING PLAN

Vipul
VIPUL AGARWAL
M.E.P. CONSULTANT
B.E. ELECTRICAL

LEGENDS:

Mounting Height	No.	ID	Symbol	Description
IN RCC SLAB		CONDUIT		Rigid PVC 25mm dia. Conduit /1.5 sqmm Wire For Light Points
IN FLOOR		CONDUIT		Rigid PVC 25mm dia. Conduit /1.5 sqmm Wire For Light Points
IN RCC SLAB		CONDUIT		Rigid PVC 25mm dia. Conduit /2.5 sqmm Wire For Light Circuits
IN RCC SLAB		CONDUIT		Rigid PVC 25mm dia. Conduit / 4.00 sqmm Wire For Power Circuits
IN RCC SLAB		CONDUIT		Submain Wire to DB From Main Panel on Ground Floor in 1nos. 32mm dia Conduits
CEILING	20	FAN/48"		CEILING FAN 48"
CEILING	02	FAN/30"		CEILING FAN 30"
CEILING	05	FB		FAN BOX
CEILING	03	CH1		CHANDELIER
+90"	18	TL/W		LED WALL TUBE LIGHT MAKE:- SYSKA LED CAT NO.- SSK-TS-20W
+90"	18	BULB		LED BULB 20W MAKE:- SYSKA LED CAT NO. SKC-20W 5.7K/3K
+90"	04	GL		WALL BRACKETS AS DESIGN FOR GANESH LIGHT
+78"	12	ML		12X2 LED MIRROR LIGHT MAKE:- SYSKA LED CAT NO.- FPL-12X2
CEILING	111	DL		LED 6" DOWN LIGHTER 20W (SURFACE MOUNTED) MAKE:- SYSKA LED CAT NO.- SDL-15W GLD 6.5K/4K
VENTILATOR HT.	16	CR		CEILING ROSE
VENTILATOR HT.	16	EXF		9" DIA FRESH AIR FAN
+42"	51	SB		SWITCH BOARD
+24"	16	TEL		TELEPHONE POINT
+24"	16	LP TEL		6 A PLUG POINT FOR TELEPHONE
+48"	12	TV		TV COAXIAL POINT
+48"	24	LP TV		6 A PLUG POINT FOR TV
+24"	12	LP		6 A PLUG POINT FOR SIDE TABLE
+72"	04	LP-CH		6 A PLUG POINT FOR CHIMNEY
+90"	20	SAC		SPLIT AC INDOOR UNIT
+42"	04	PP-MIX		16 A POWER POINT FOR MIXER
+42"	04	PP-MIC		16 A POWER POINT FOR MICROWAVE
+78"	16	PP-G		16 A POWER POINT FOR GEYSER
+54"	04	PP-F		16 A POWER POINT FOR FRIDGE
+78"	04	PP-WP		16 A POWER POINT FOR WATER PURIFIER
+48"	00	PP-WM		16 A POWER POINT FOR WASHING MACHINE
+12"	08	PP-INV.		16 A POWER POINT FOR INVERTOR
+60"	04	BP		6 A BELL PUSH
+90"	04	BZ		BUZZER FOR CALL BELL
+60"	04	MCB DB		MCB DISTRIBUTION BOARD

SERVICES CONSULTANT:
ASHI ASSOCIATES
F 9 / 440 , Keshav Marg Chitrakut Scheme,Jaipur
PH:91-0-93146-10438 ,0141-2440946 Mail:vipul8599@yahoo.com
REV. NO. 00 DATE: 18-07-2024

DRN BY:- KEDAR	CKD BY:- SANJAY	APPD:- VIPUL AGARWAL
-------------------	--------------------	-------------------------

PROJECT ADDRESS:

PROPOSED BUILDING AT
PLOT NO.- 04 (RES.),
IN SCHEME :- SHIV SHAKTI NAGAR
VISTAR (NIJI KHATEDARI), JAIPUR

PROJECT NAME:
MJB ATHULYAM- II

PROMOTERS :-
MJB BUILD DEVELOPERS

DRAWING:
TYPICAL FLOOR ELECTRIC
CONDUIT PLAN


ARCHITECT:




B-6, Moti Marg, Babu Nagar, Jaipur.
Ph.: 9314510603
E-Mail: spaceedgejpr@gmail.com

WORKING DRAWING

DATE : 08/07/2024
SCALE: NTS 01

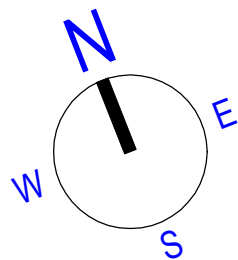

GROUND FLOOR WORKING PLAN

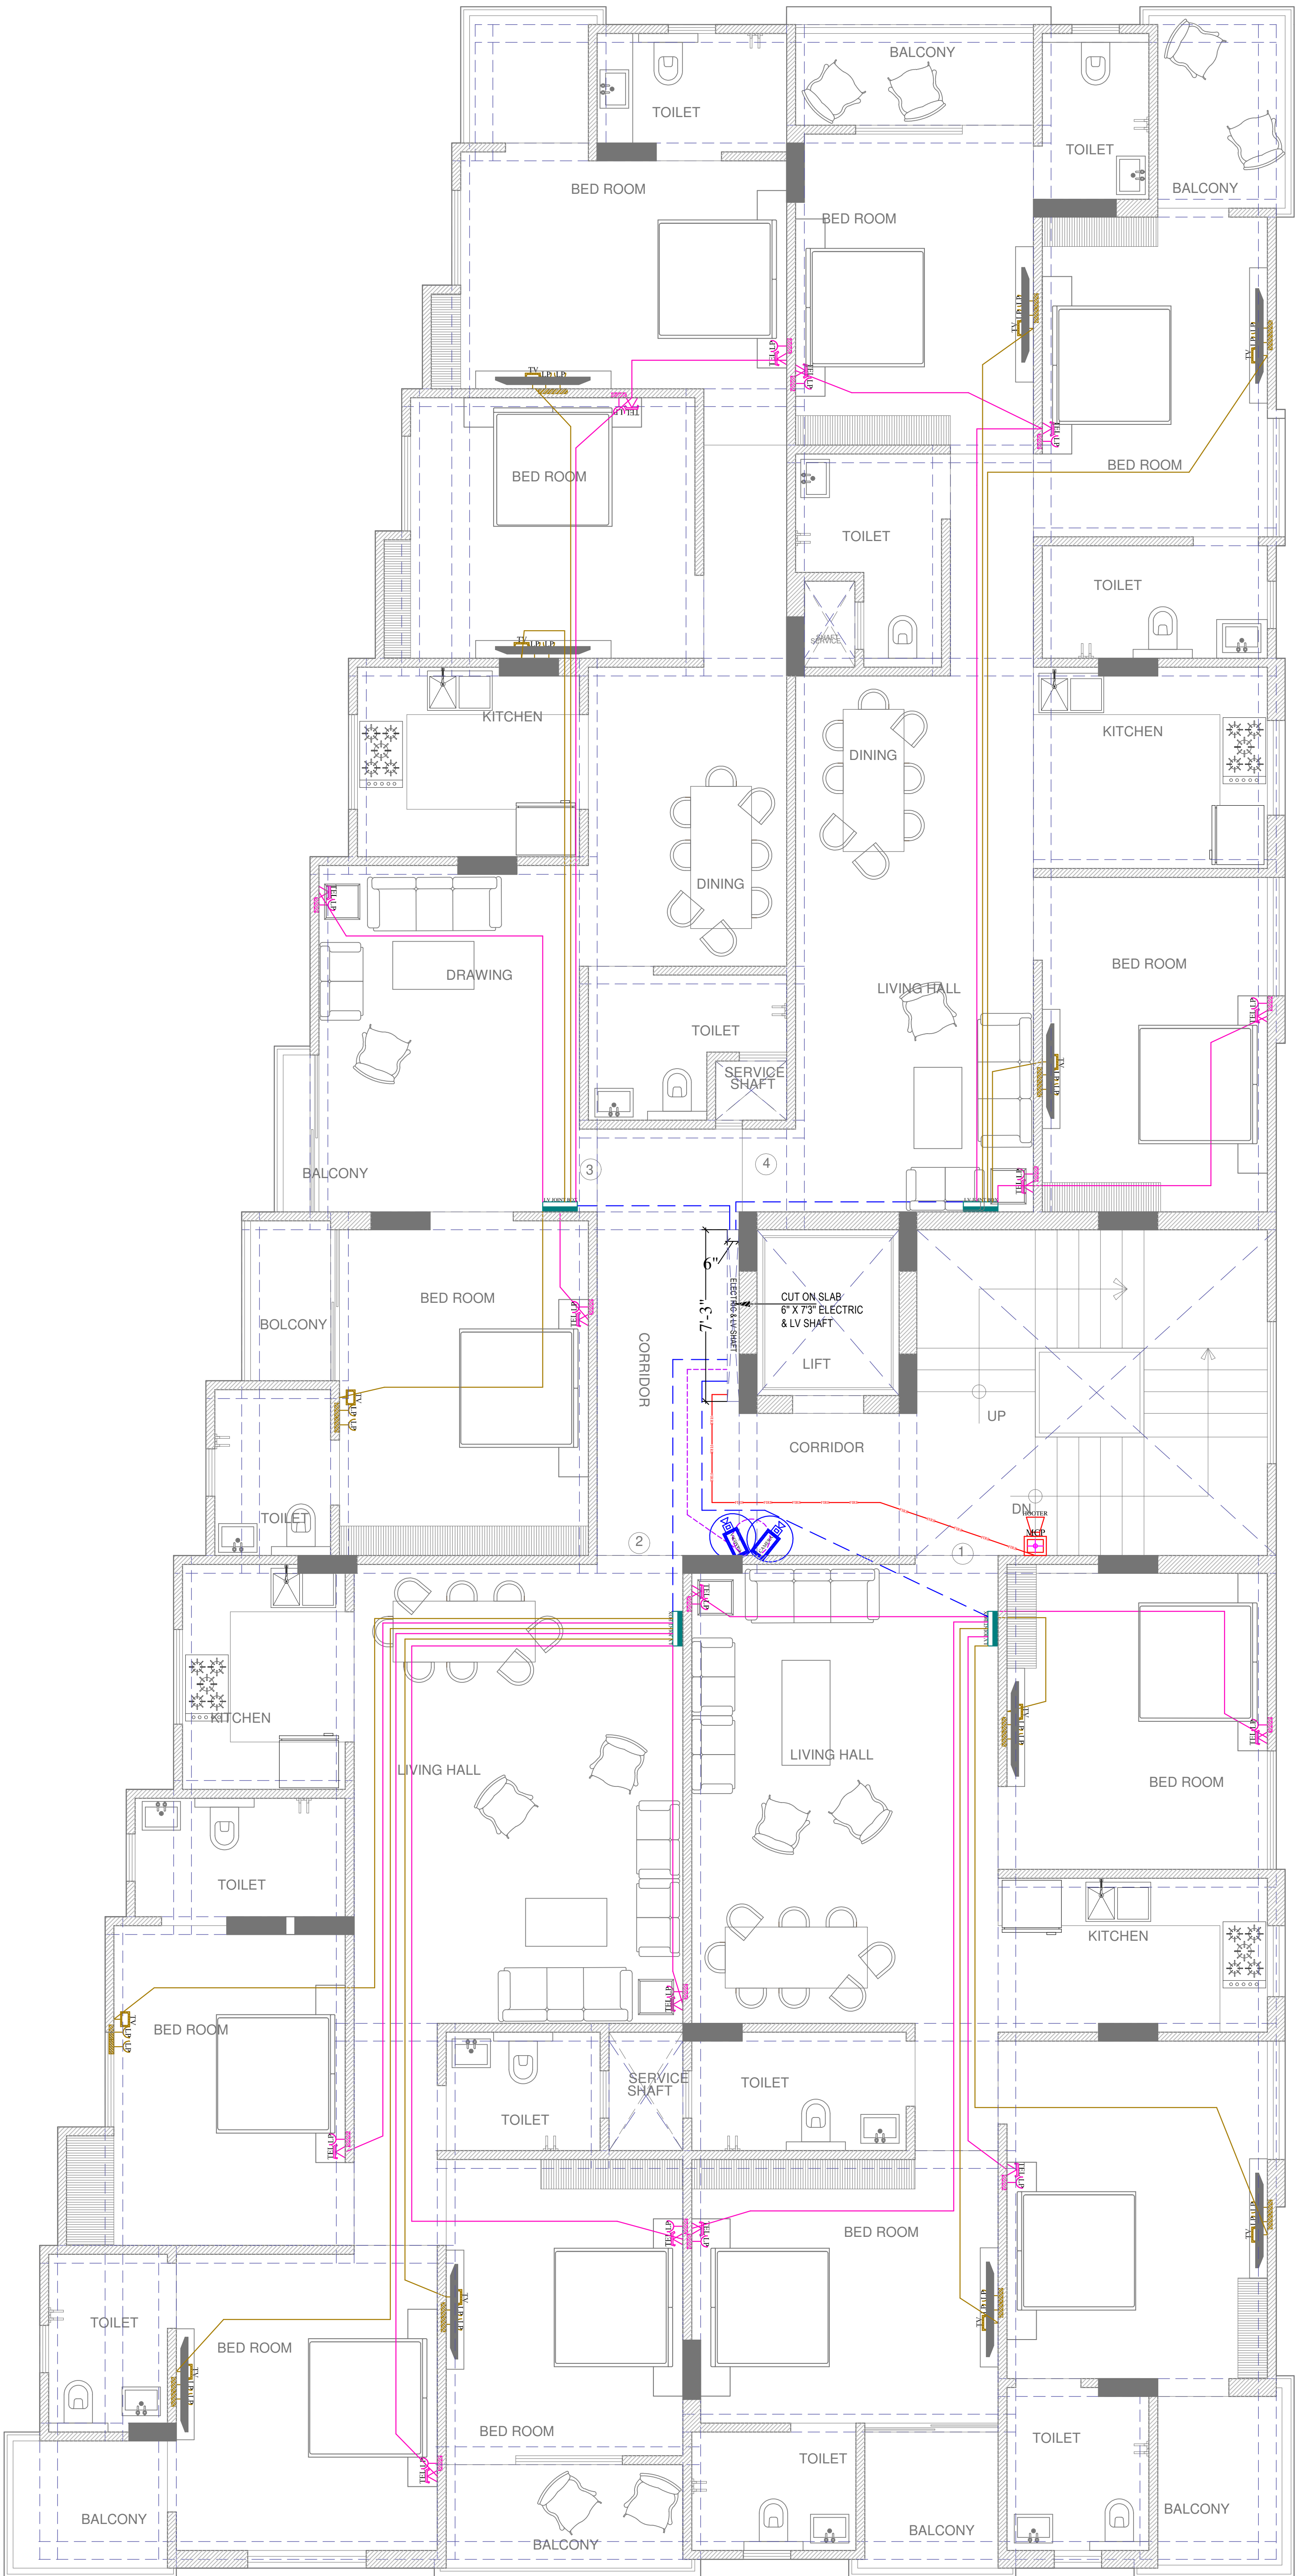

1M

GI BOX
3"X3"

1 MODULE BOX SIZE 3" X 3",
PLATE SIZE 92 X 90 MM

2M

GI BOX
3"X3"

2 MODULE BOX SIZE 3" X 3",
PLATE SIZE 92 X 90 MM

2M

GI BOX
3"X3"

2 MODULE BOX SIZE 3" X 3",
PLATE SIZE 92 X 90 MM

3M

GI BOX
4"X3"

3 MODULE BOX SIZE 4" X 3",
PLATE SIZE 114 X 90 MM

32mm pvc
conduit pipe

+48"

+30"

TYPICAL TV WALL ELEVATION PLAN

Vipul

VIPUL AGARWAL
M.E.P. CONSULTANT
B.E. ELECTRICAL

LEGENDS:

Mounting Height	No.	ID	Symbol	Description
IN FLOOR		CONDUIT	TEL	Rigid PVC 25mm dia. Conduit /0.5mm 2 Pair Wire For Tel Wiring
IN FLOOR		CONDUIT	TV	Rigid PVC 25mm dia. Conduit /RG6 Cable For TV Wiring
IN RCC SLAB		CONDUIT		1Nos. 32 mm dia Conduits From Flat LV System to Drop LV Shaft
IN RCC SLAB		CONDUIT	CCTV	Rigid PVC Conduit 25mm/3+1 Coaxial Wire/Cat-6 Cable for Video Door Phone & Security Camera (C.C.T.V.).
IN RCC SLAB		CONDUIT	FIRE	Rigid PVC 25mm dia. Conduit / 2X1.5 sq. mm Copper Wire For Fire Alarm
+24"	16	TEL	TEL	TELEPHONE POINT
+24"	16	LP TEL	LP TEL	6 A PLUG POINT FOR TELEPHONE
+48"	12	TV	TV	TV COAXIAL POINT
+48"	24	LP TV	LP TV	6 A PLUG POINT FOR TV
+24"	04		LV	LV JOINT BOX
+42"	01	MCP	MCP	MANUAL CALL POINT
+90"	01	HO	HO	HOOTER POINT
+90"	02	CCTV	CCTV	WALL MOUNTED CCTV CAMERA

SERVICES CONSULTANT:
ASHI ASSOCIATES
F 9 / 440 , Keshav Marg Chitrakut Scheme,Jaipur
PH:91-0-93146-10438 ,0141-2440946 Mail:vipul8599@yahoo.com
REV. NO. 00 DATE: 18-07-2024

DRN BY:- KEDAR	CKD BY:- SANJAY	APPD.:- VIPUL AGARWAL
-------------------	--------------------	--------------------------

PROJECT ADDRESS:

PROPOSED BUILDING AT
PLOT NO.- 04 (RES.),
IN SCHEME :- SHIV SHAKTI NAGAR
VISTAR (NIJI KHATEDARI), JAIPUR

PROJECT NAME:
MJB ATHULYAM- II

PROMOTERS :-
MJB BUILD DEVELOPERS

DRAWING:

TYPICAL FLOOR LV
CONDUIT PLAN

ARCHITECT:

space
edgeArchitects

ARCHITECTS, INTERIOR DESIGNERS AND ENGINEERS

B-6, Moti Marg, Bapu Nagar, Jaipur.
Ph.: 9314510603
E-Mail: spaceedgejpr@gmail.com

WORKING DRAWING

DATE : 08/07/2024	N E S W
SCALE: NTD 01	