

LEGEND

- EMERGENCY ASSEMBLY POINT
- FIRE POINT
- FIRE HYDRANT
- EMERGENCY CONTROL ROOM
- HOSE REEL

Krishna
KRISHNA KUMAR
B. Tech. (Mechanical)
M.E.P Consultant

WARNING

1. This drawing is the sole copyright of Architects VISTAAR and should be used for the purpose expressly issued.

GENERAL NOTES

1. All dimensions are in feet and inches.
2. Do not scale this drawing follow written dimensions only.
3. This drawing should be read in conjunction with other architectural and structural drawings.
4. Any discrepancy in the drawing should be immediately brought to the notice of architect.

PROJECT TITLE

PROJECT:-
SHREE SHYAM HOME
BUILDING AT PLOT-637/632, &
639/634,GANPATPURA,SANGANER
JAIPUR

DRAWING TITLE

STILT FLOOR FIRE FIGHTER PLAN

ARCHITECTS :

VISTAAR ARCHITECTS &
PLANNERS
Architects :: Interior Designers
B-2/12, Chitrkoot scheme,
main Gandhi Path, Opp mall of jaipur, Jaipur
PH.- 0141-4116461,09001010366

DATE

DRN

MANOJ KUMARWAT

SCALE

N.T.S

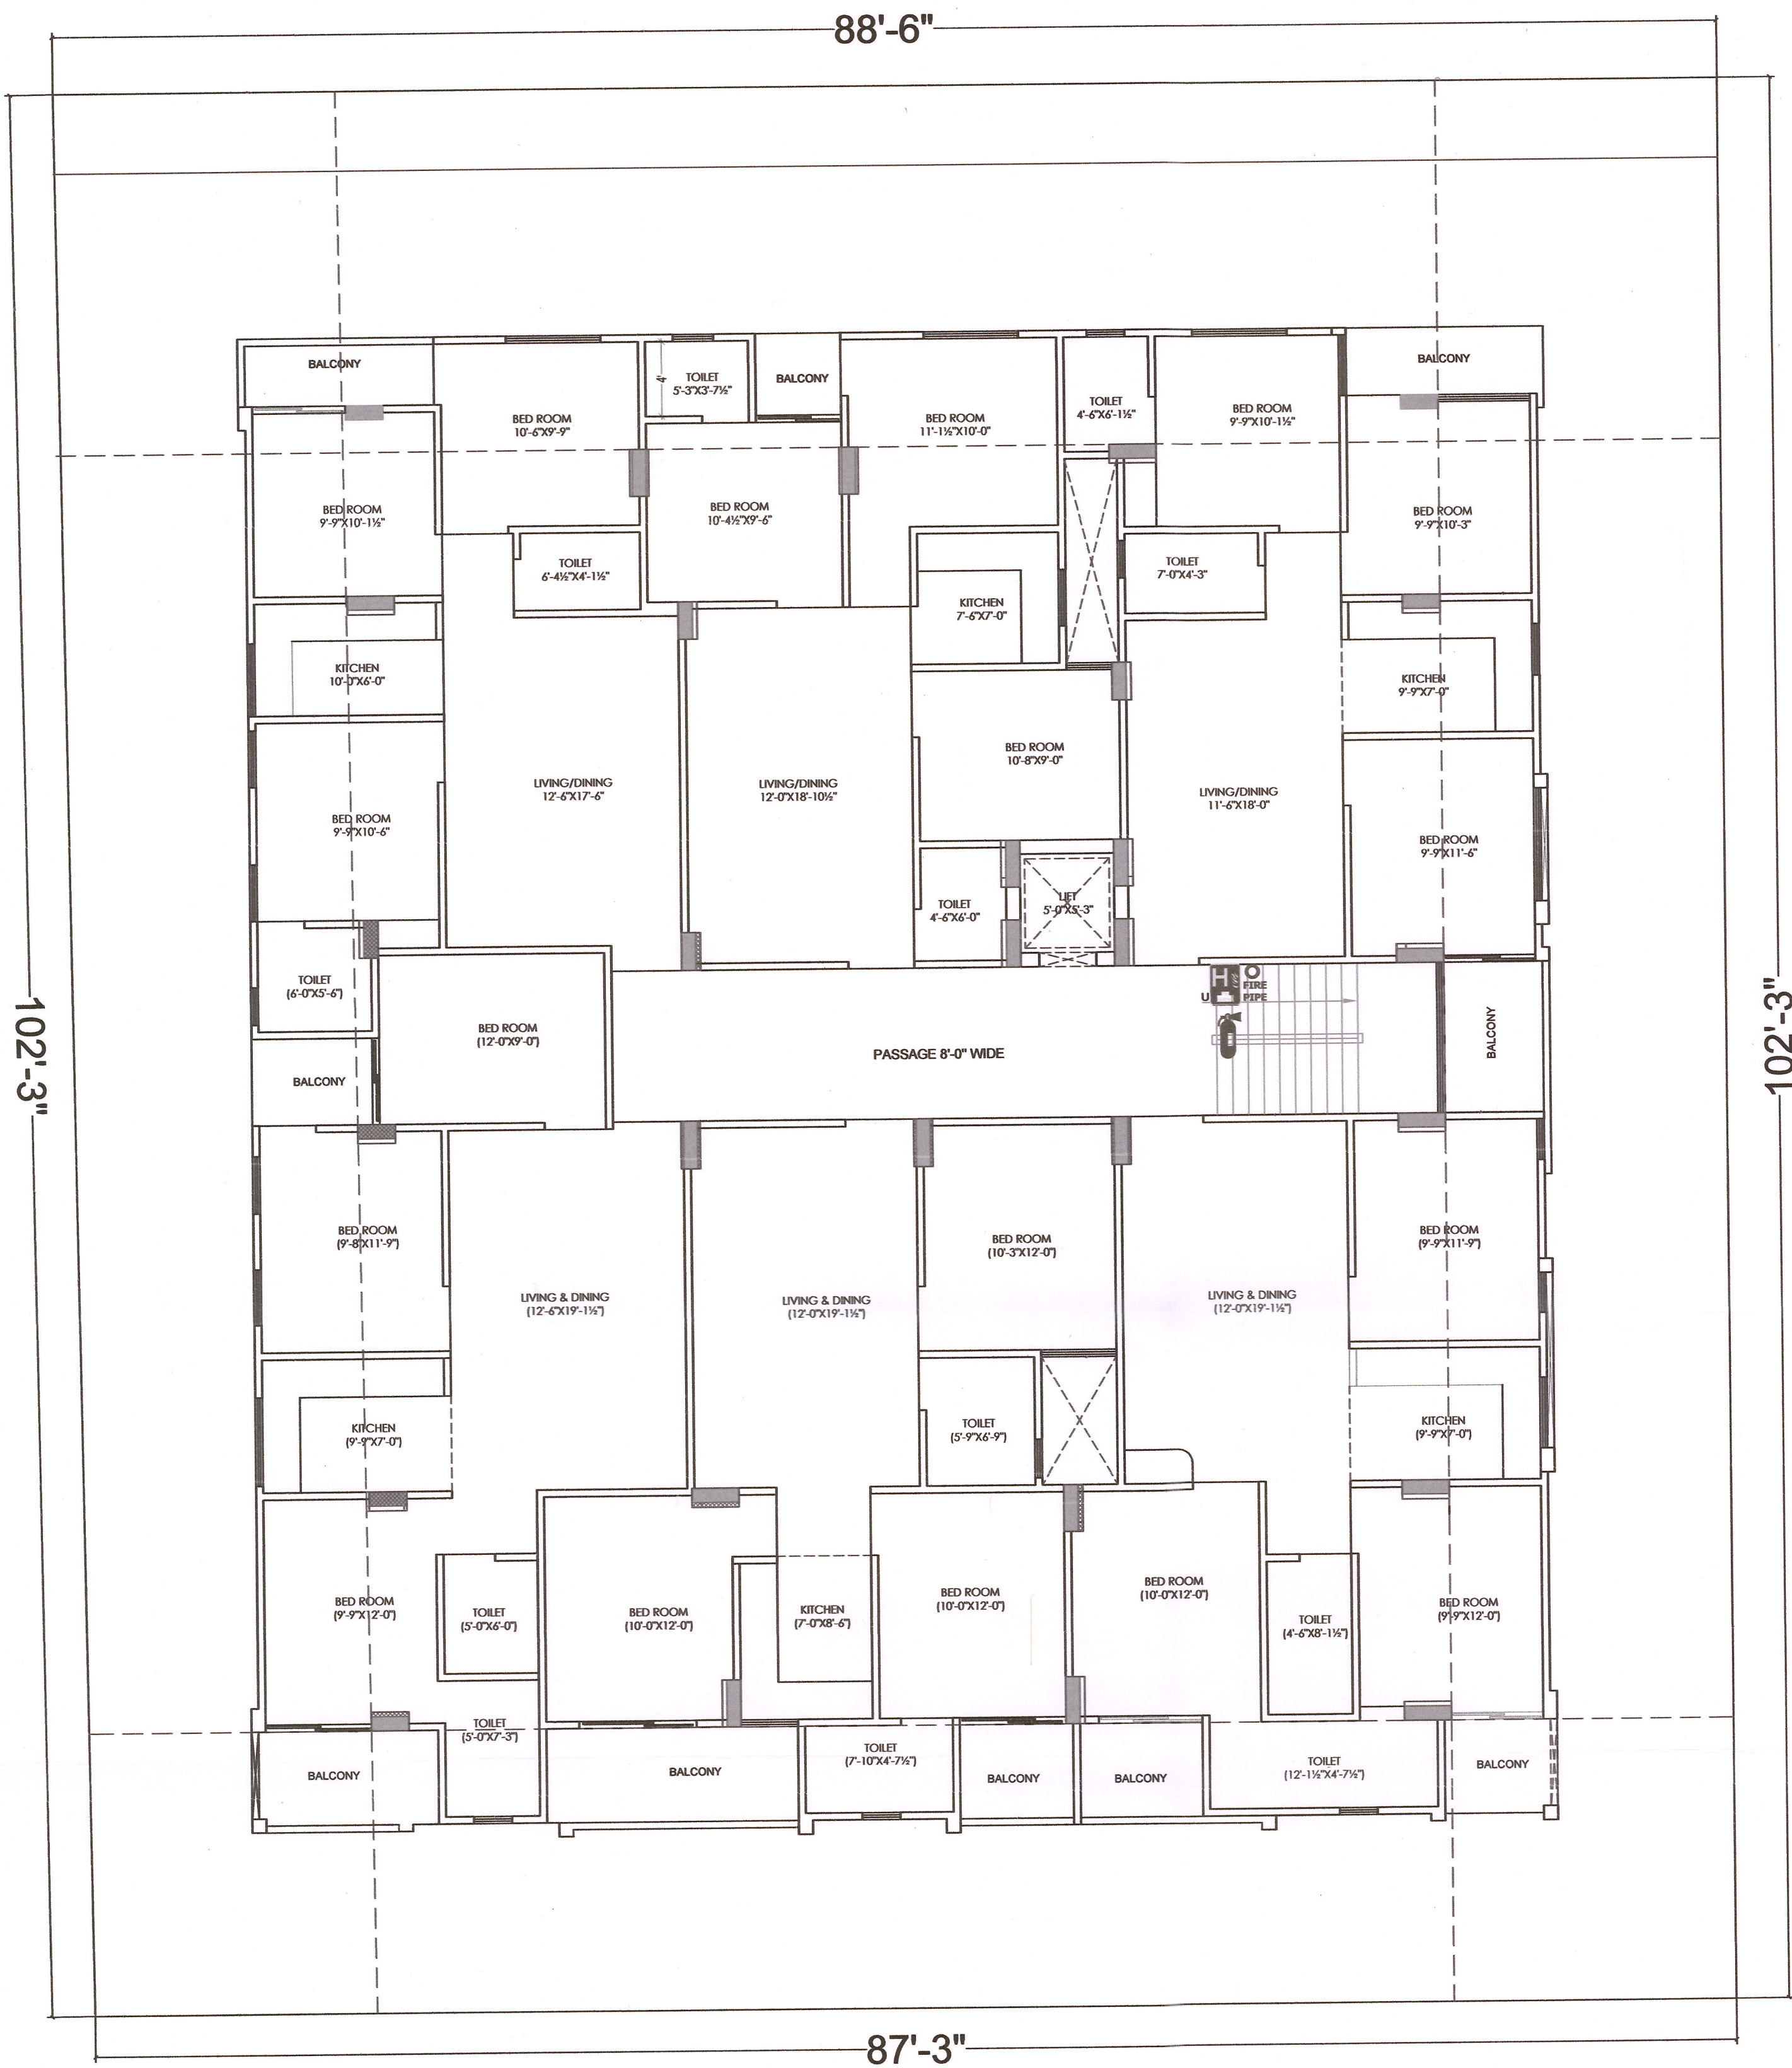
DATE

10-06-2024






JOB NO

REV

NORTH



LEGEND

-  EMERGENCY ASSEMBLY POINT
-  FIRE POINT
-  FIRE HYDRANT
-  EMERGENCY CONTROL ROOM
-  HOSE REEL

Krishna
KRISHNA KUMAR
B. Tech. (Mechanical)
M.E.P Consultant

WARNING

1. This drawing is the sole copyright of Architects VISTAAR and should be used for the purpose expressly issued.

GENERAL NOTES

1. All dimensions are in feet and inches.
2. Do not scale this drawing follow written dimensions only.
3. This drawing should be read in conjunction with other architectural and structural drawings.
4. Any discrepancy in the drawing should be immediately brought to the notice of architect.

PROJECT TITLE

PROJECT:-
SHREE SHYAM HOME
BUILDING AT PLOT-637/632, &
639/634, GANPATPURA, SANGANER
JAIPUR

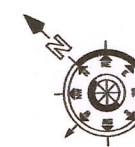
DRAWING TITLE

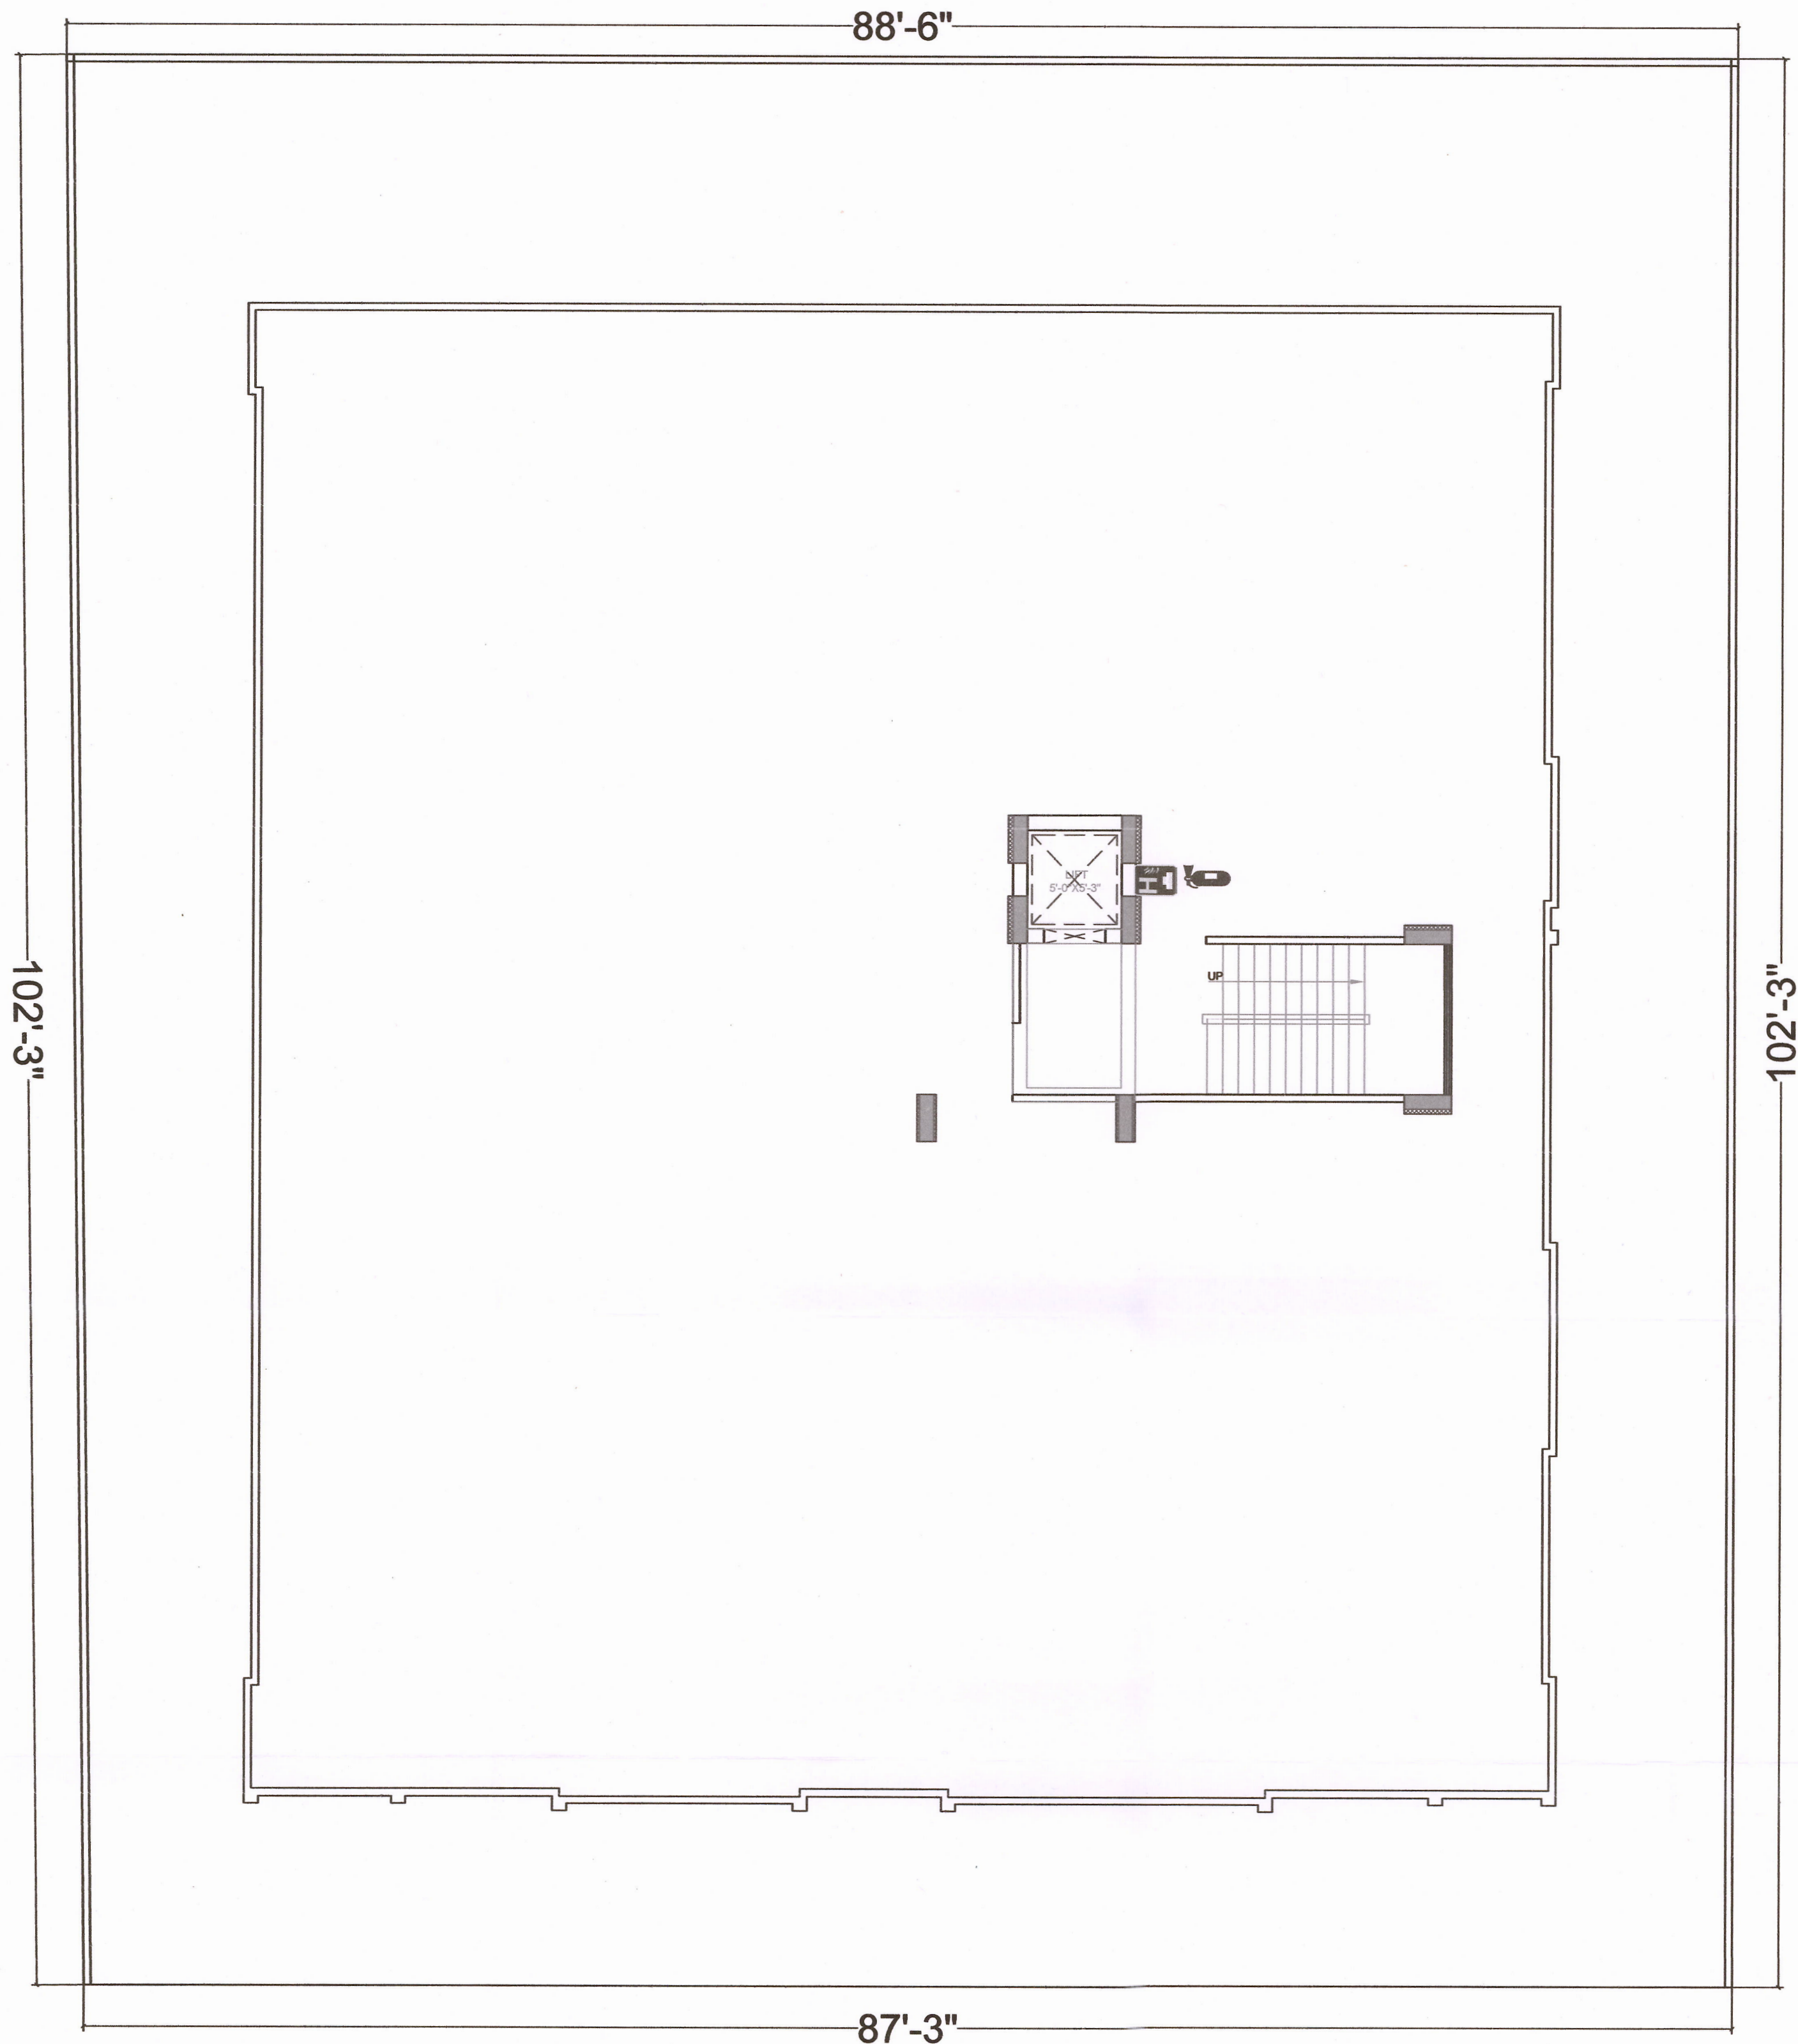
FIRE FIGHTER TYPICAL FLOOR PLAN

ARCHITECTS:





 
VISTAAR ARCHITECTS &
PLANNERS
Architects :: Interior Designers
B-2/12, Chitrkoot scheme,
main Gandhi Path, Opp mall of jaipur, Jaipur
PH. - 0141-4116461, 09001010366

PATH:

DRN.	DATE	REV.	NORTH
MANUJ KUMAR	15-06-2024		
SCALE	JOB NO.		
NTS			



LEGEND

-  EMERGENCY ASSEMBLY POINT
-  FIRE POINT
-  FIRE HYDRANT
-  EMERGENCY CONTROL ROOM
-  HOSE REEL

Krishna
KRISHNA KUMAR
B. Tech. (Mechanical)
M.E.P Consultant

WARNING

1. This drawing is the sole copyright of Architects VISTAAR and should be used for the purpose expressly issued.

GENERAL NOTES

1. All dimensions are in feet and inches.
2. Do not scale this drawing follow written dimensions only.
3. This drawing should be read in conjunction with other architectural and structural drawings.
4. Any discrepancy in the drawing should be immediately brought to the notice of architect.

PROJECT TITLE

PROJECT:-
SHREE SHYAM HOME
BUILDING AT PLOT-637/632, &
639/634,GANPATPURA,SANGANER
JAIPUR

DRAWING TITLE

TERRACE FIRE FIGHTER

ARCHITECTS:

VISTAAR ARCHITECTS &
PLANNERS
Architects :: Interior Designers
B-2/12, Chitrkoot scheme,
main Gandhi Path,Opp mall of jaipur,Jaipur
PH:- 0141-4116461,09001010366

PMD:

DRN:

SCALE

NTS

DATE

SCALE

NTS

REV.

DATE

SCALE

NTS

NORTH

DATE

SCALE

NTS

