[illegible]

**ARCHITECT**

des<sup>i</sup>gn<sup>studio</sup>

**GRAPHITE DESIGN STUDIO**  
ARCHITECTS, INTERIOR DESIGNERS, PLANNERS

66, Janak Puri -1st, Indirawati phatak, Opp Jain Mandir, Jaipur  
CONTACT NO. +91-9628334414, 0141-2594414  
email- [studiographite@gmail.com](mailto:studiographite@gmail.com)  
Website- [www.graphitedesignstudio.com](http://www.graphitedesignstudio.com)

STRUCTURAL CONSULTANT

PROJECT NAME

GT BLVU

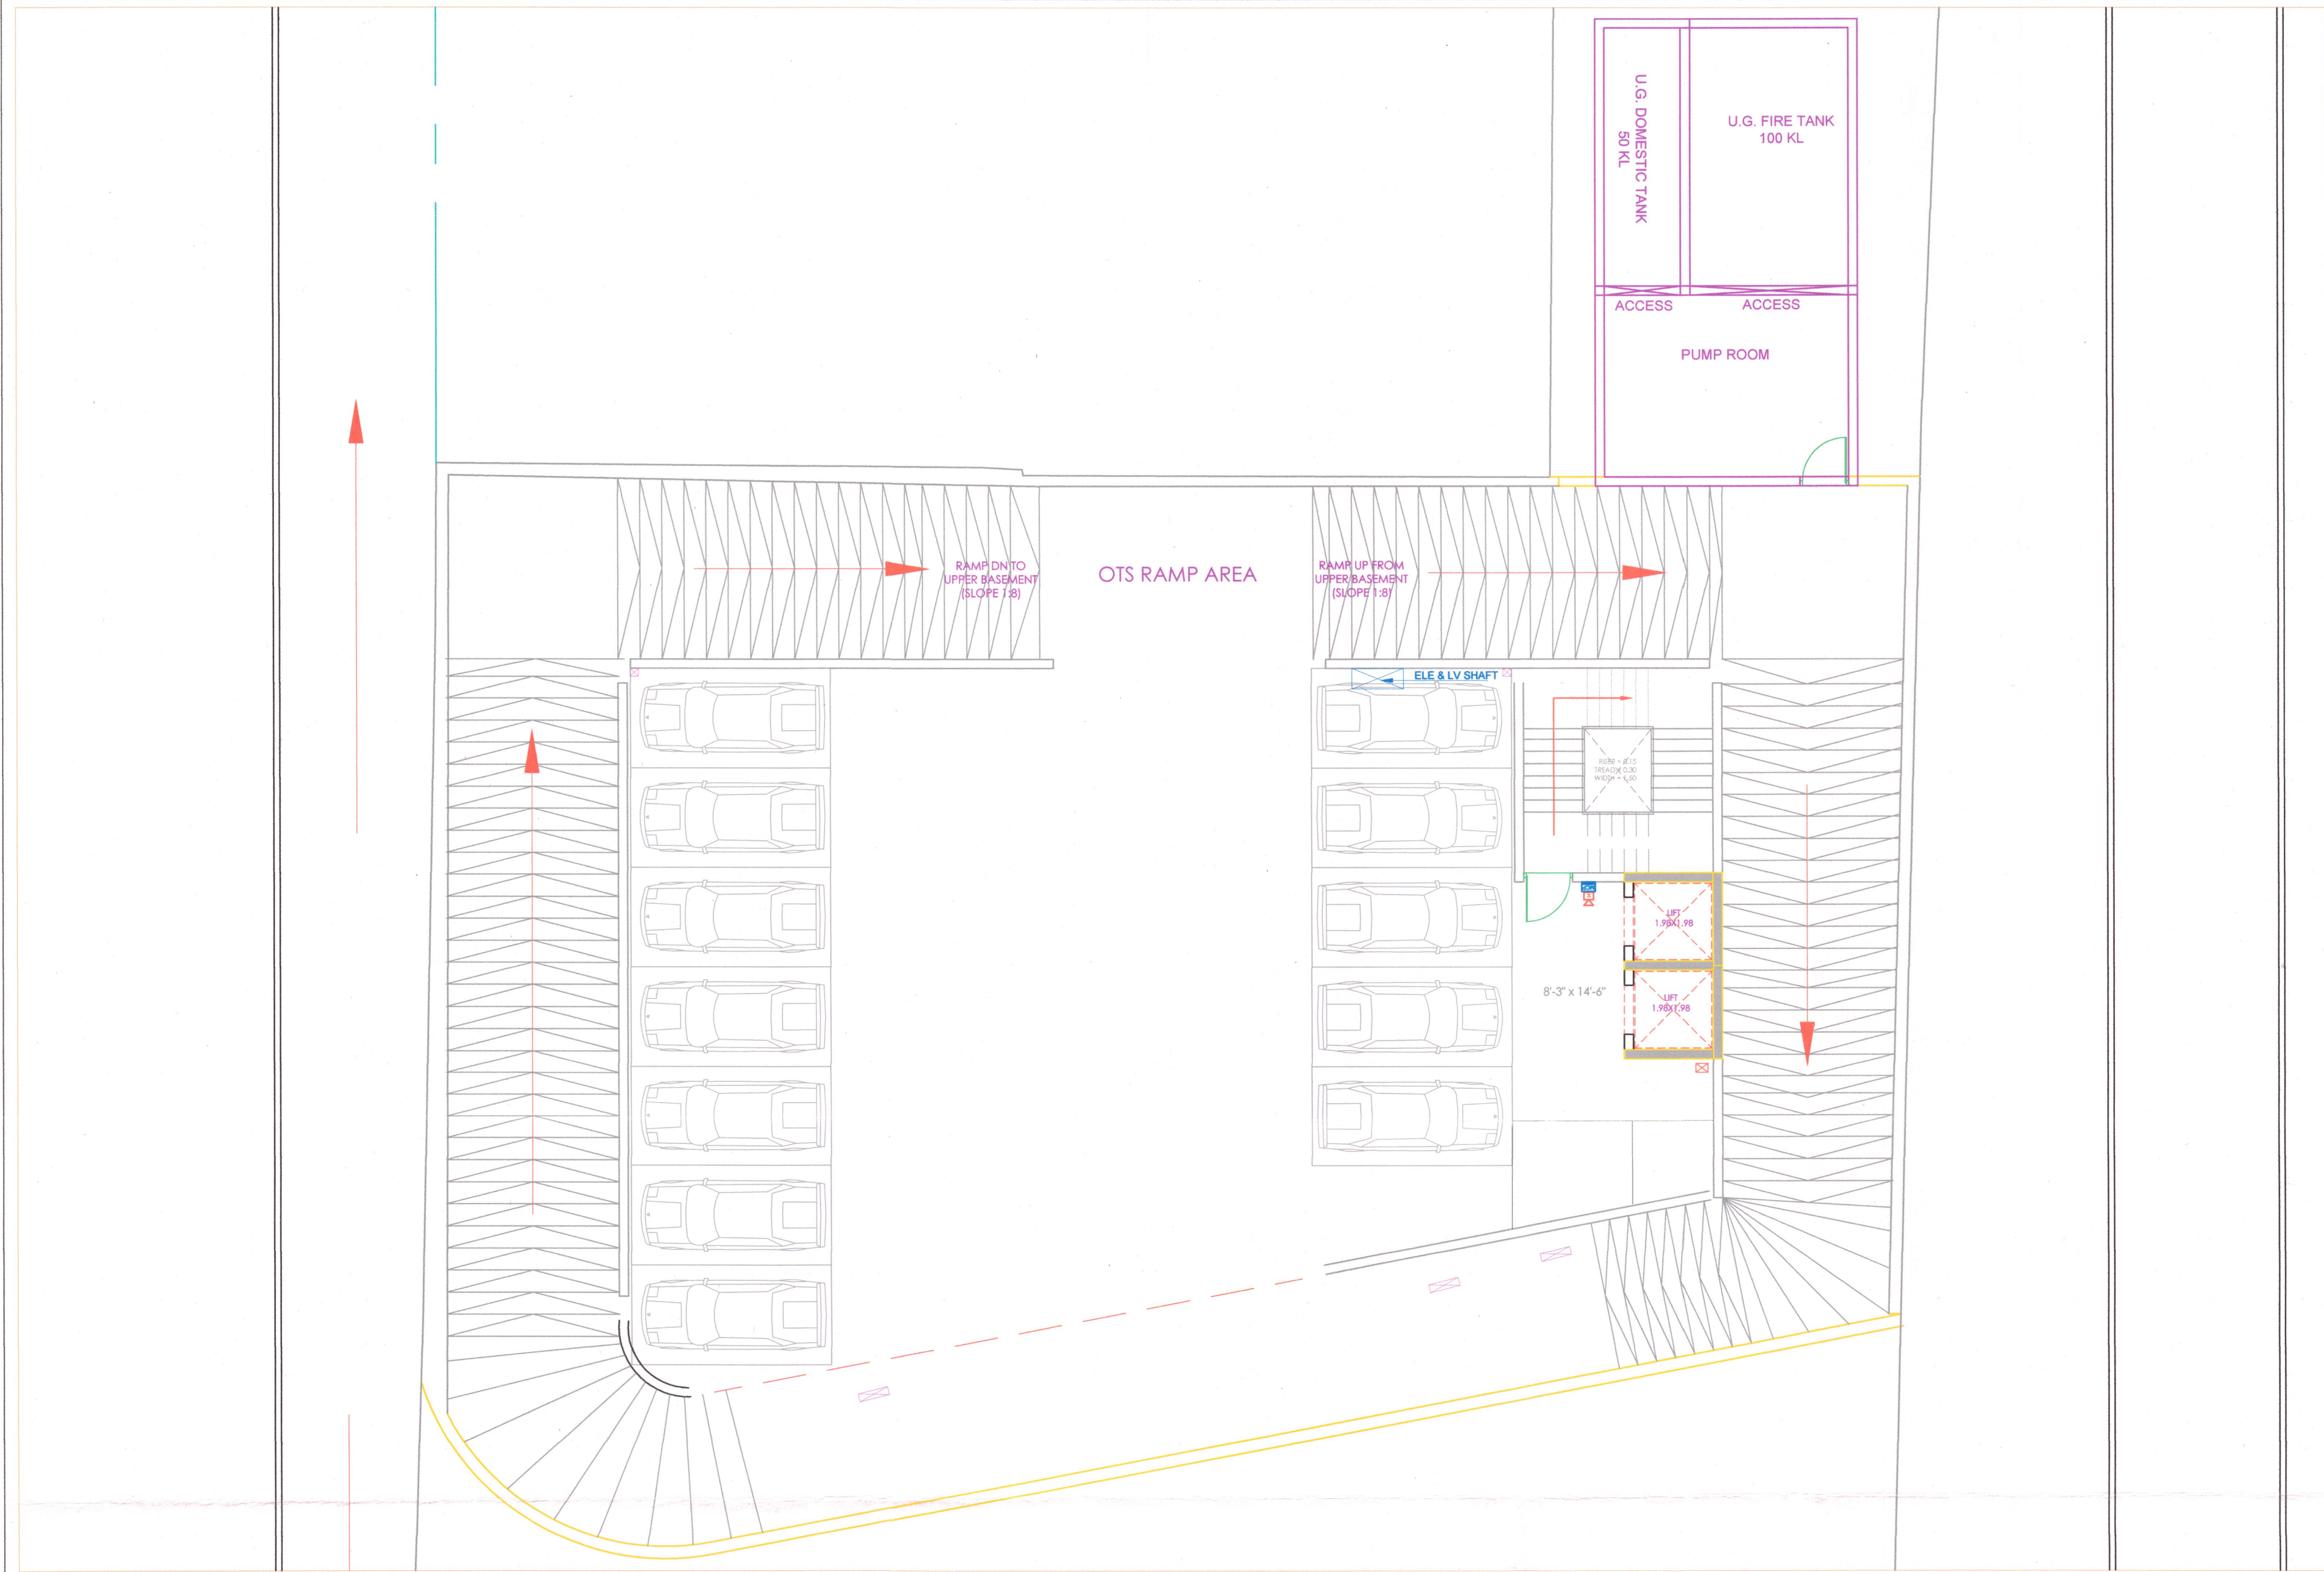
DWG STATUS:

FOR RERA SUBMISSION



|           |        |             |            |            |
|-----------|--------|-------------|------------|------------|
| DEALT BY: |        | CHECKED BY: |            | DIRECTION: |
| DEVENDRA  |        | SACHIN      |            |            |
| DRAWN NO. | SCALE: | SHEET SIZE  | DATE:      |            |
|           | NTS    | A1          | 27.11.2024 |            |







**SUDHIR MATHUR**  
M.E.P.F. CONSULTANT  
B.E. MECHANICAL

LEGEND

| SYMBOL                                                                                | DESCRIPTION              |
|---------------------------------------------------------------------------------------|--------------------------|
|  | MANUAL CALL POINT @4'-0" |
|  | HOOTER @8'-0"            |

| REV. NO. | DESCRIPTION TO REVISION | REV. BY | DATE |
|----------|-------------------------|---------|------|
| -        | -                       | -       | -    |
| -        | -                       | -       | -    |
**GRAPHITE DESIGN STUDIO**  
ARCHITECTS, INTERIOR DESIGNERS, PLANNERS  
60, Janki Puri -1st, Bhubaneswar, Odisha, India  
CONTACT NO. +91-9620334414, 0141-2594414  
email: studio@graphitedesignstudio.com  
Website: www.graphitedesignstudio.com

STRUCTURAL CONSULTANT

CLIENT

**BARDIYA GROUP**

PROJECT NAME

**GT BLVU**

DWG TITLE

**UPPER BEAMENT ELECTRICAL PLAN**

DWG STATUS

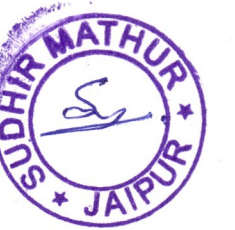
**FOR RERA SUBMISSION**




**SHRESHTHA**  
the heartbeat of your building

|           |        |             |            |            |
|-----------|--------|-------------|------------|------------|
| DEALT BY: |        | CHECKED BY: |            | DIRECTION: |
| DEVENDRA  |        | SACHIN      |            |            |
| DRAWN NO: | SCALE: | SHEET SIZE: | DATE:      |            |
|           | NTS    | A1          | 27.11.2024 |            |





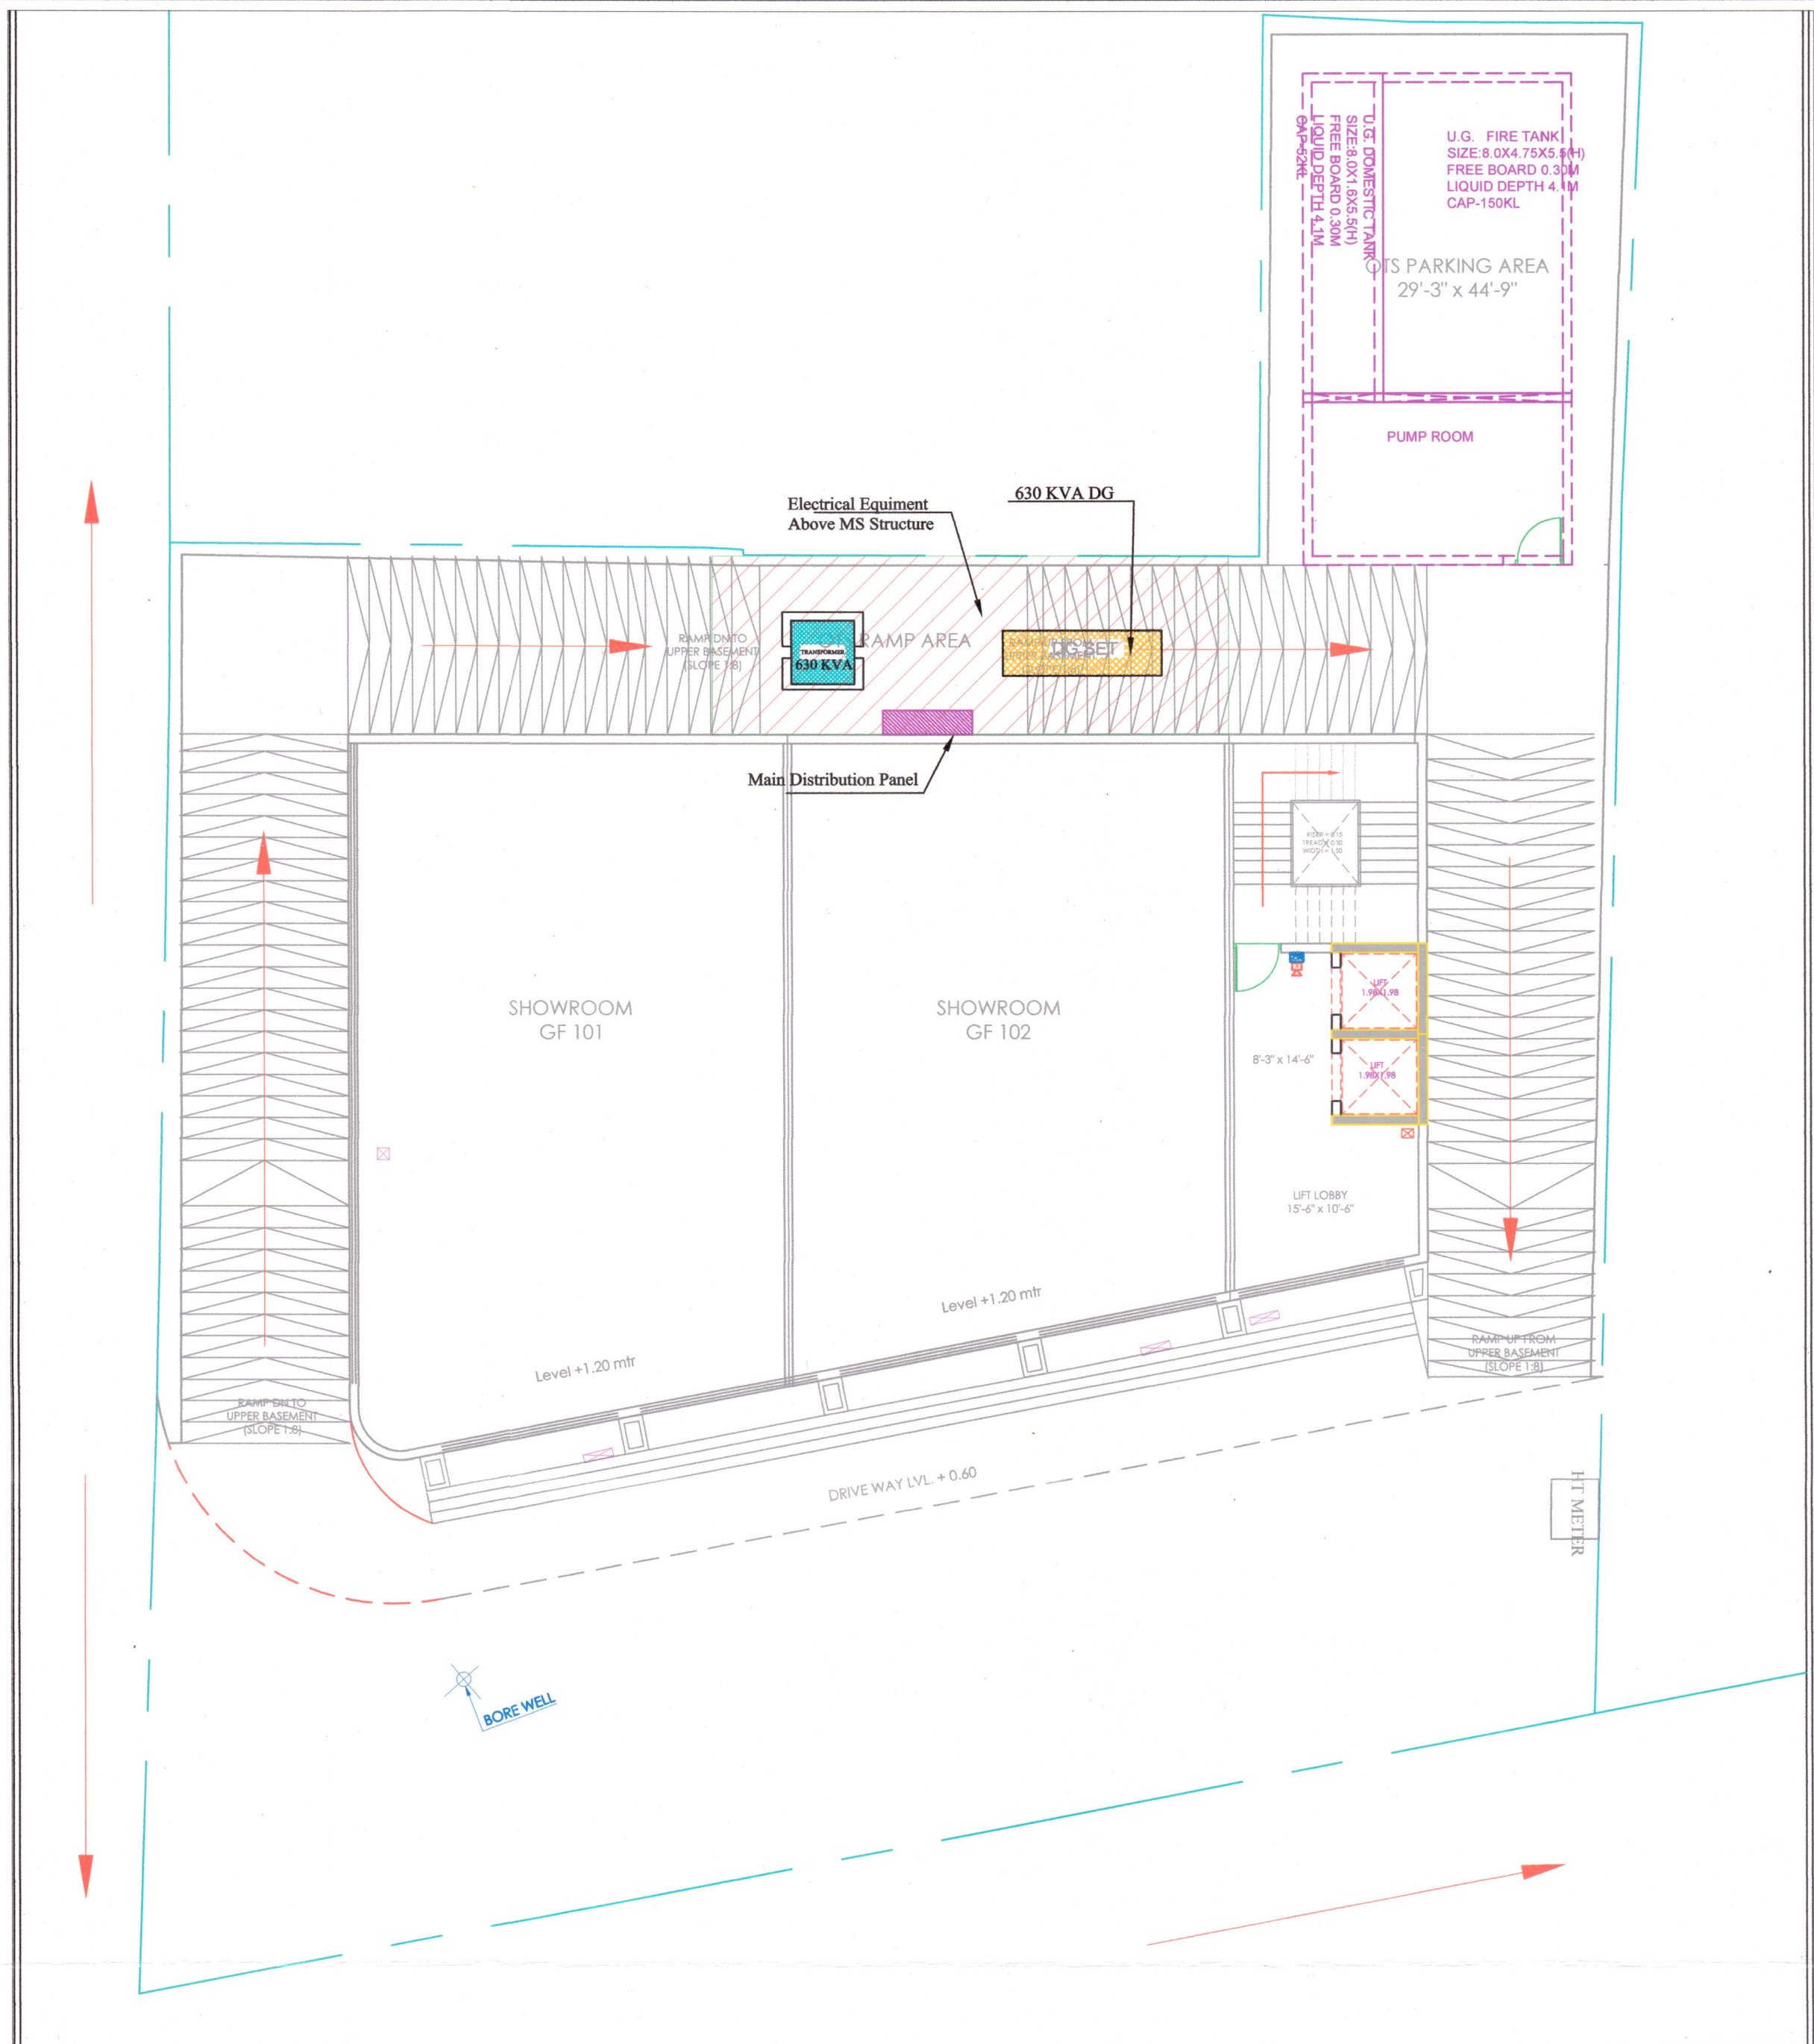SUDHIR MATHUR  
M.E.P.F. CONSULTANT  
B.E. MECHANICAL



| LEGEND |                          |
|--------|--------------------------|
| SYMBOL | DESCRIPTION              |
|        | MANUAL CALL POINT @4'-0" |
|        | HOOTER @8'-0"            |

| REV. NO. | DESCRIPTION TO REVISION | REV. BY | DATE |
|----------|-------------------------|---------|------|
| -        | -                       | -       | -    |
| -        | -                       | -       | -    |
ARCHITECT

**des g**  
raphite  
udio

GRAPHITE DESIGN STUDIO  
ARCHITECTS, INTERIOR DESIGNERS, PLANNERS  
65, Janta Puri-1st, Indrawati, Jaipur  
CONTACT NO. +91-9928334414, 0141-2594414  
email: studio@graphitedesignstudio.com  
Website: www.graphitedesignstudio.com

STRUCTURAL CONSULTANT

Vijaytech Consultants Pvt. Ltd.  
H-17, GANPATI MANSION, SHYAM NAGAR, JAIPUR-302001  
Phone: 91-141-2284432, 3257952, Fax: 91-141-4022198  
E-mail: vijaytech.pr@gmail.com

CLIENT

BARDIYA GROUP

PROJECT NAME

GT BLVU

DWG TITLE

GROUND FLOOR ELECTRICAL  
PLAN

DWG STATUS


FOR RERA SUBMISSION

MEP CONSULTANTS

SHRESHTHA  
the heartbeat of your building

|                           |                   |                           |                         |            |
|---------------------------|-------------------|---------------------------|-------------------------|------------|
| DEALT BY:<br><br>DEVENDRA |                   | CHECKED BY:<br><br>SACHIN |                         | DIRECTION: |
| DRAWING NO:               | SCALE:<br><br>NTS | SHEET SIZE:<br><br>A1     | DATE:<br><br>27.11.2024 |            |



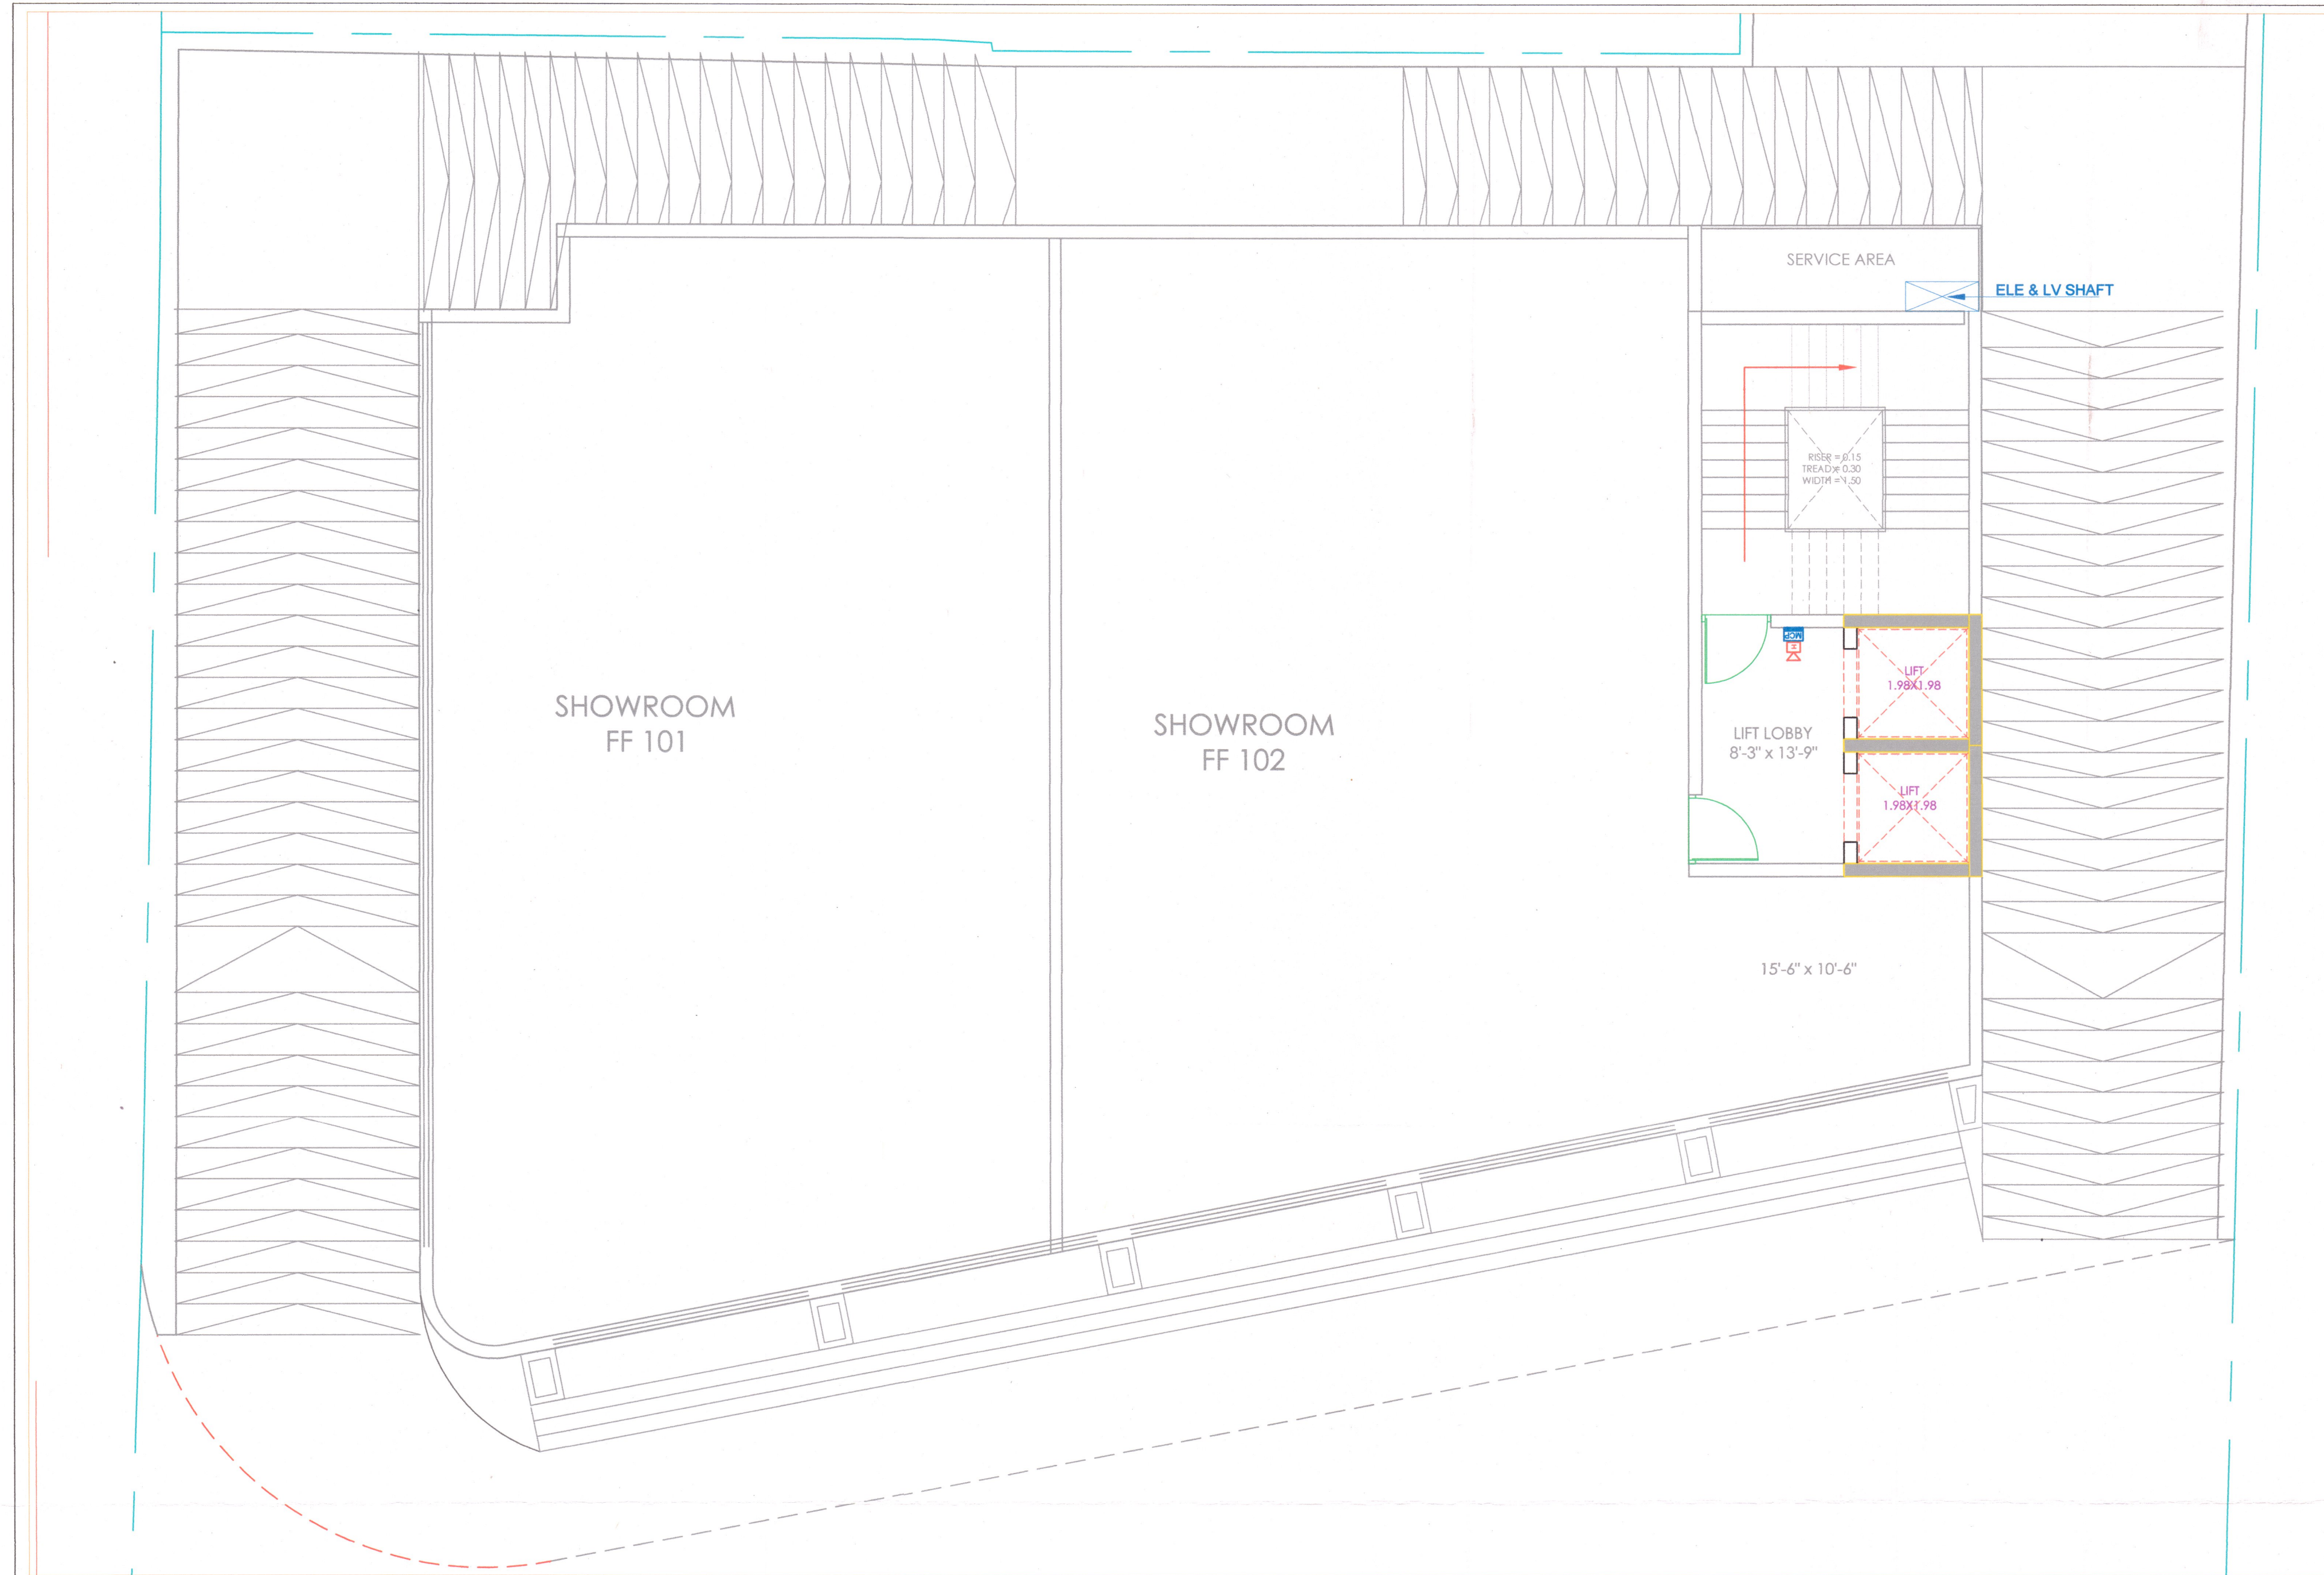

| LEGEND |                          |
|--------|--------------------------|
| SYMBOL | DESCRIPTION              |
|        | MANUAL CALL POINT @4'-0" |
|        | HOOTER @8'-0"            |

| REV. NO. | DESCRIPTION TO REVISION | REV. BY | DATE |
|----------|-------------------------|---------|------|
| -        | -                       | -       | -    |
| -        | -                       | -       | -    |
ARCHITECT

**des<sup>g</sup>n<sup>studio</sup>**

**GRAPHITE DESIGN STUDIO**  
ARCHITECTS, INTERIOR DESIGNERS, PLANNERS  
68, Janak Puri-1st, Indrawati phatak, Opp Jain Mandir, Jaipur  
CONTACT NO. +91-9620334114, 0141-2594414  
email: studio@graphitedesignstudio.com  
Website: www.graphitedesignstudio.com

STRUCTURAL CONSULTANT

**Vijaytech Consultants Pvt. Ltd.**  
11-12, 2nd Floor, Main Market, Shivdas Nagar, Jaipur-302001  
Phone: 91-141-2264432, 3257562, Fax: 91-141-4022198  
E-mail: vijaytech.jr@gmail.com

CLIENT

**BARDIYA GROUP**

PROJECT NAME

**GT BLVU**

DWG TITLE

**FIRST FLOOR ELECTRICAL PLAN**

DWG STATUS

**FOR RERA SUBMISSION**

MEP CONSULTANTS

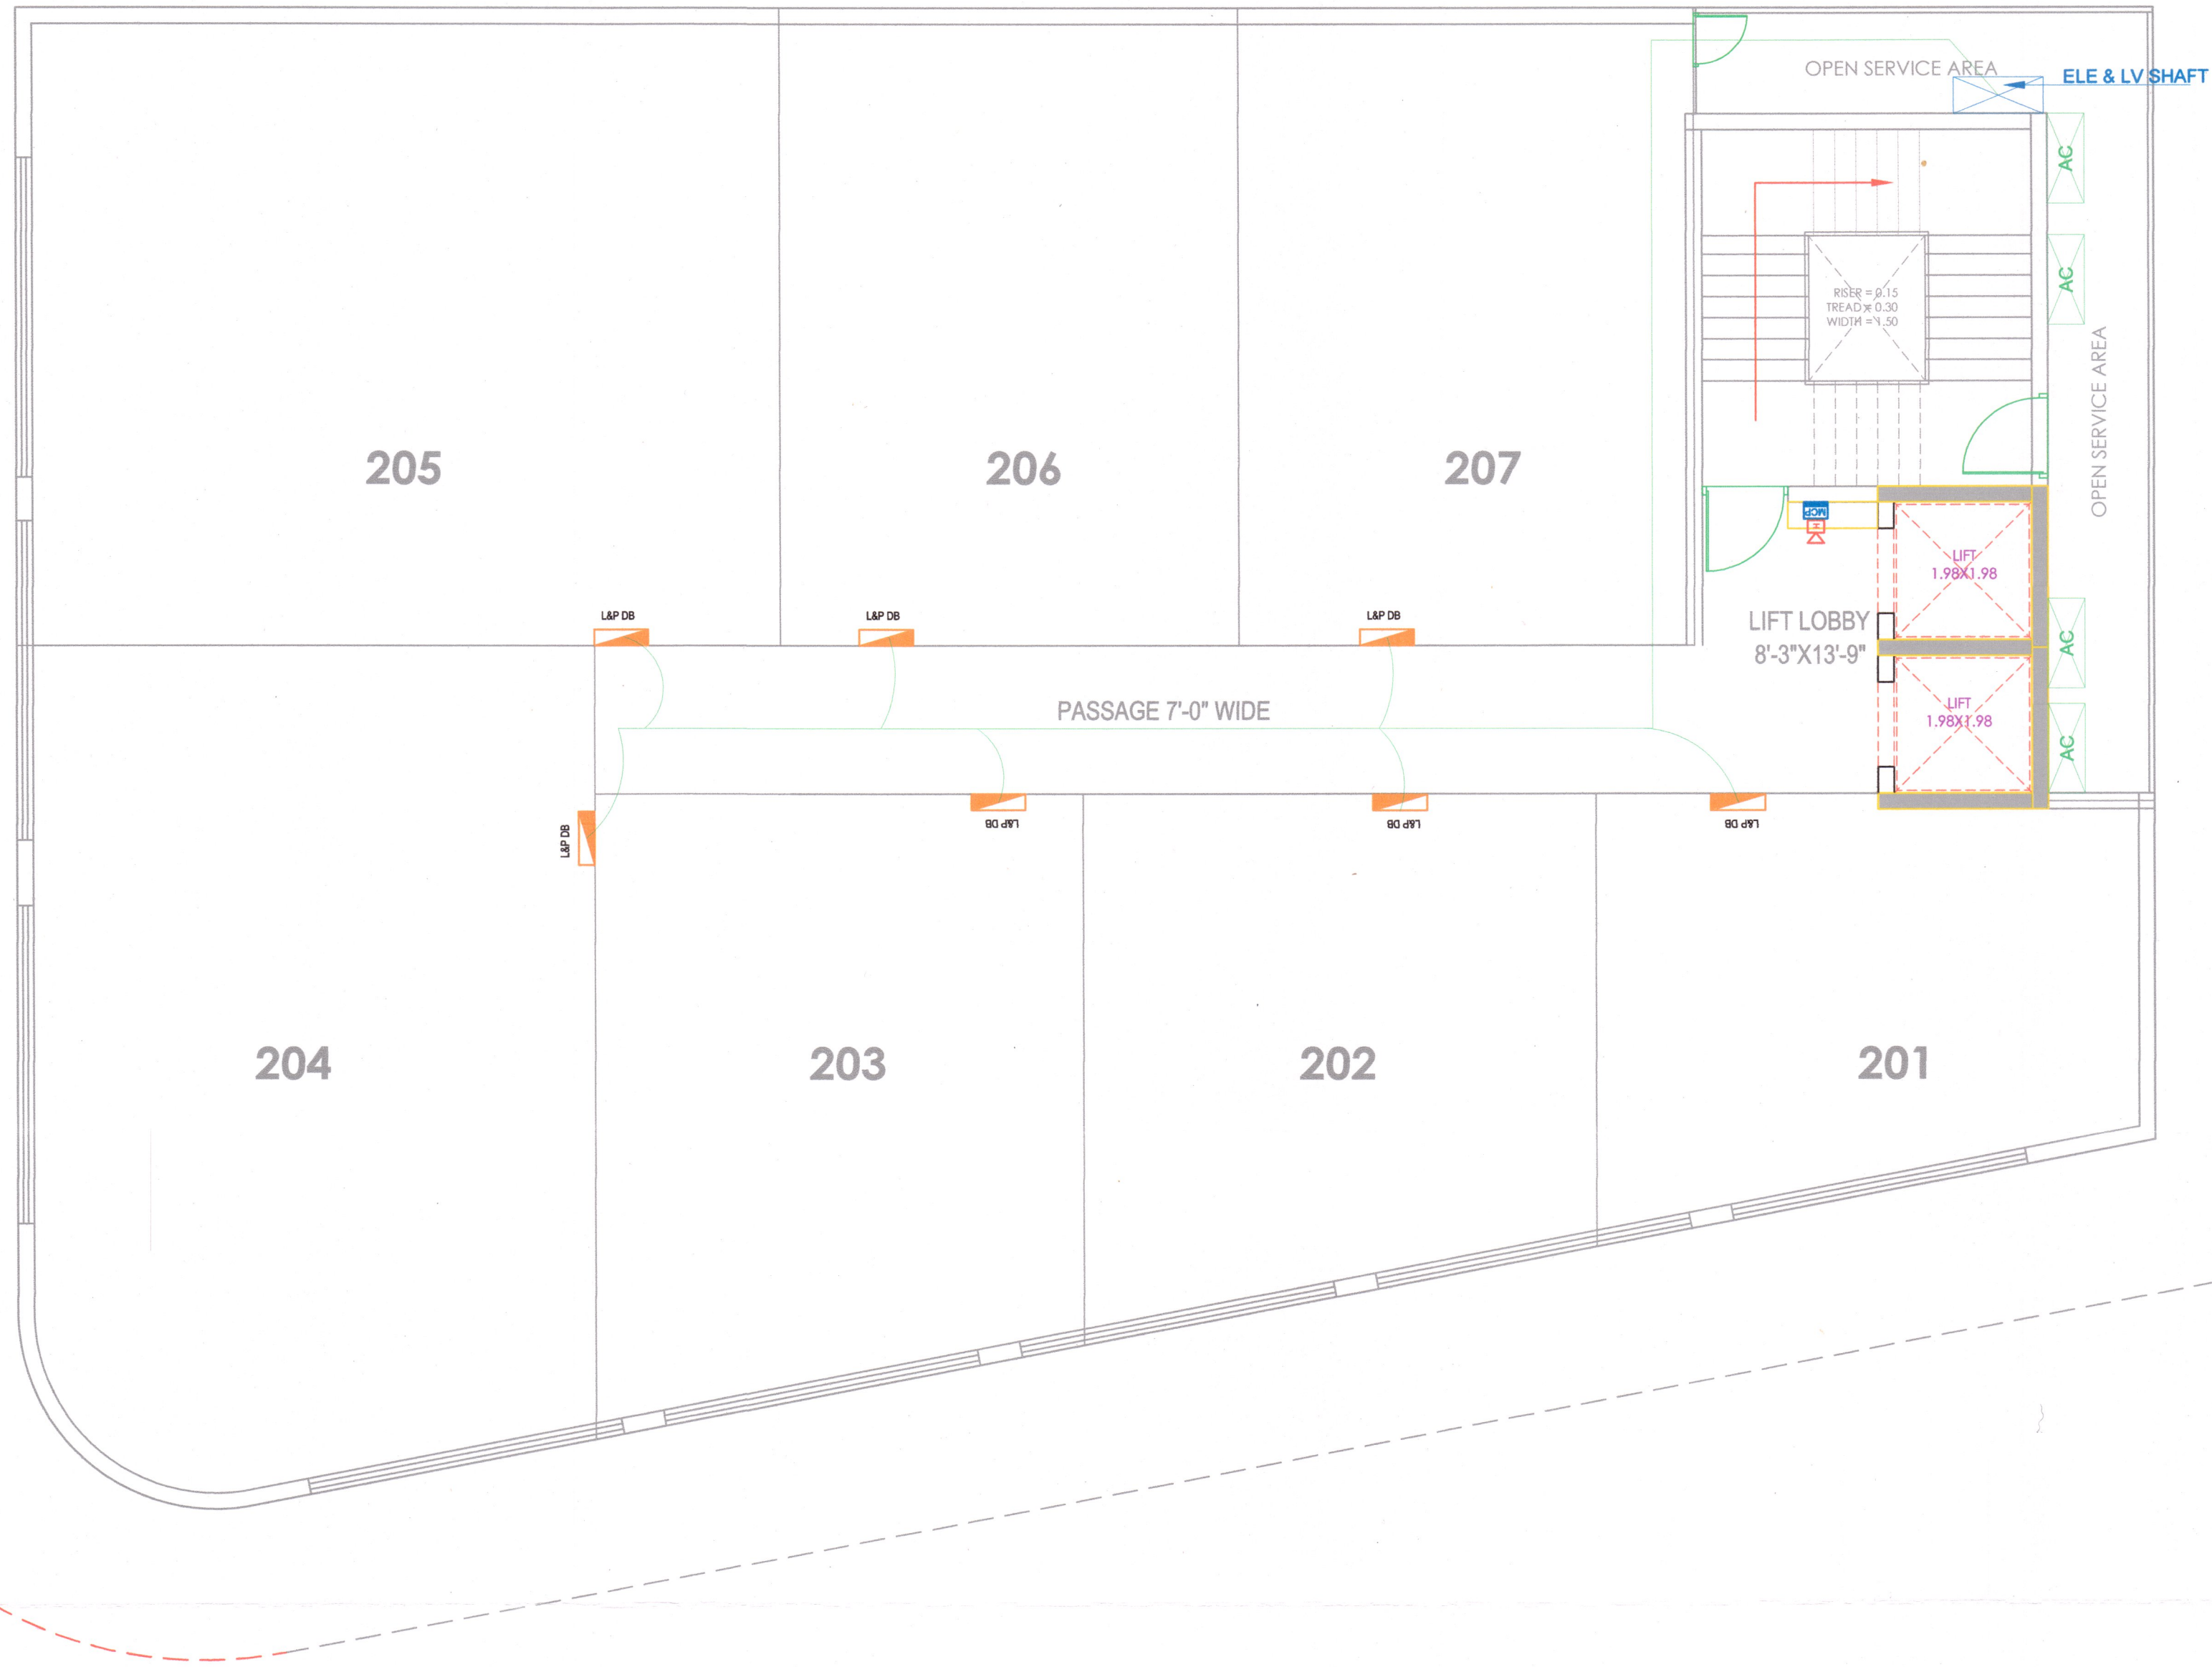
**SHRESHTHA**  
the heartbeat of your building

|                           |                   |                           |                         |            |
|---------------------------|-------------------|---------------------------|-------------------------|------------|
| DEALT BY:<br><br>DEVENDRA |                   | CHECKED BY:<br><br>SACHIN |                         | DIRECTION: |
| DRAWN NO.                 | SCALE:<br><br>NTS | SHEET SIZE:<br><br>A1     | DATE:<br><br>27.11.2024 |            |





**SUDHIR MATHUR**  
M.E.P.F. CONSULTANT  
B.E. MECHANICAL



| LEGEND |                          |
|--------|--------------------------|
| SYMBOL | DESCRIPTION              |
|        | MANUAL CALL POINT @4'-0" |
|        | HOOTER @8'-0"            |

| REV. NO. | DESCRIPTION TO REVISION | REV. BY | DATE |
|----------|-------------------------|---------|------|
| -        | -                       | -       | -    |
| -        | -                       | -       | -    |
**ARCHITECT**

**GRAPHITE DESIGN STUDIO**  
ARCHITECTS, INTERIOR DESIGNERS, PLANNERS  
G8, Janak Puri -1st, Indiradevi Phatak, Opp. Jain Mandir, Jaipur  
CONTACT NO. +91-982834414, 0141-2584414  
email: studio@graphitedesignstudio.com  
Website: www.graphitedesignstudio.com

**STRUCTURAL CONSULTANT**

**Vijaytech Consultants Pvt. Ltd.**  
H-57, GANESH NAGAR, BHAYAM NAGAR, JAIPUR-302018  
Phone: 01-141-2264432, 3257592, Fax: 01-141-4221198  
E-mail: vijaytech.jr@gmail.com

**CLIENT**

**BARDIYA GROUP**

**PROJECT NAME**

**GT BLVU**

**DWG TITLE**

**SECOND FLOOR ELECTRICAL PLAN**

**DWG STATUS**

**FOR RERA SUBMISSION**

**MEP CONSULTANTS**

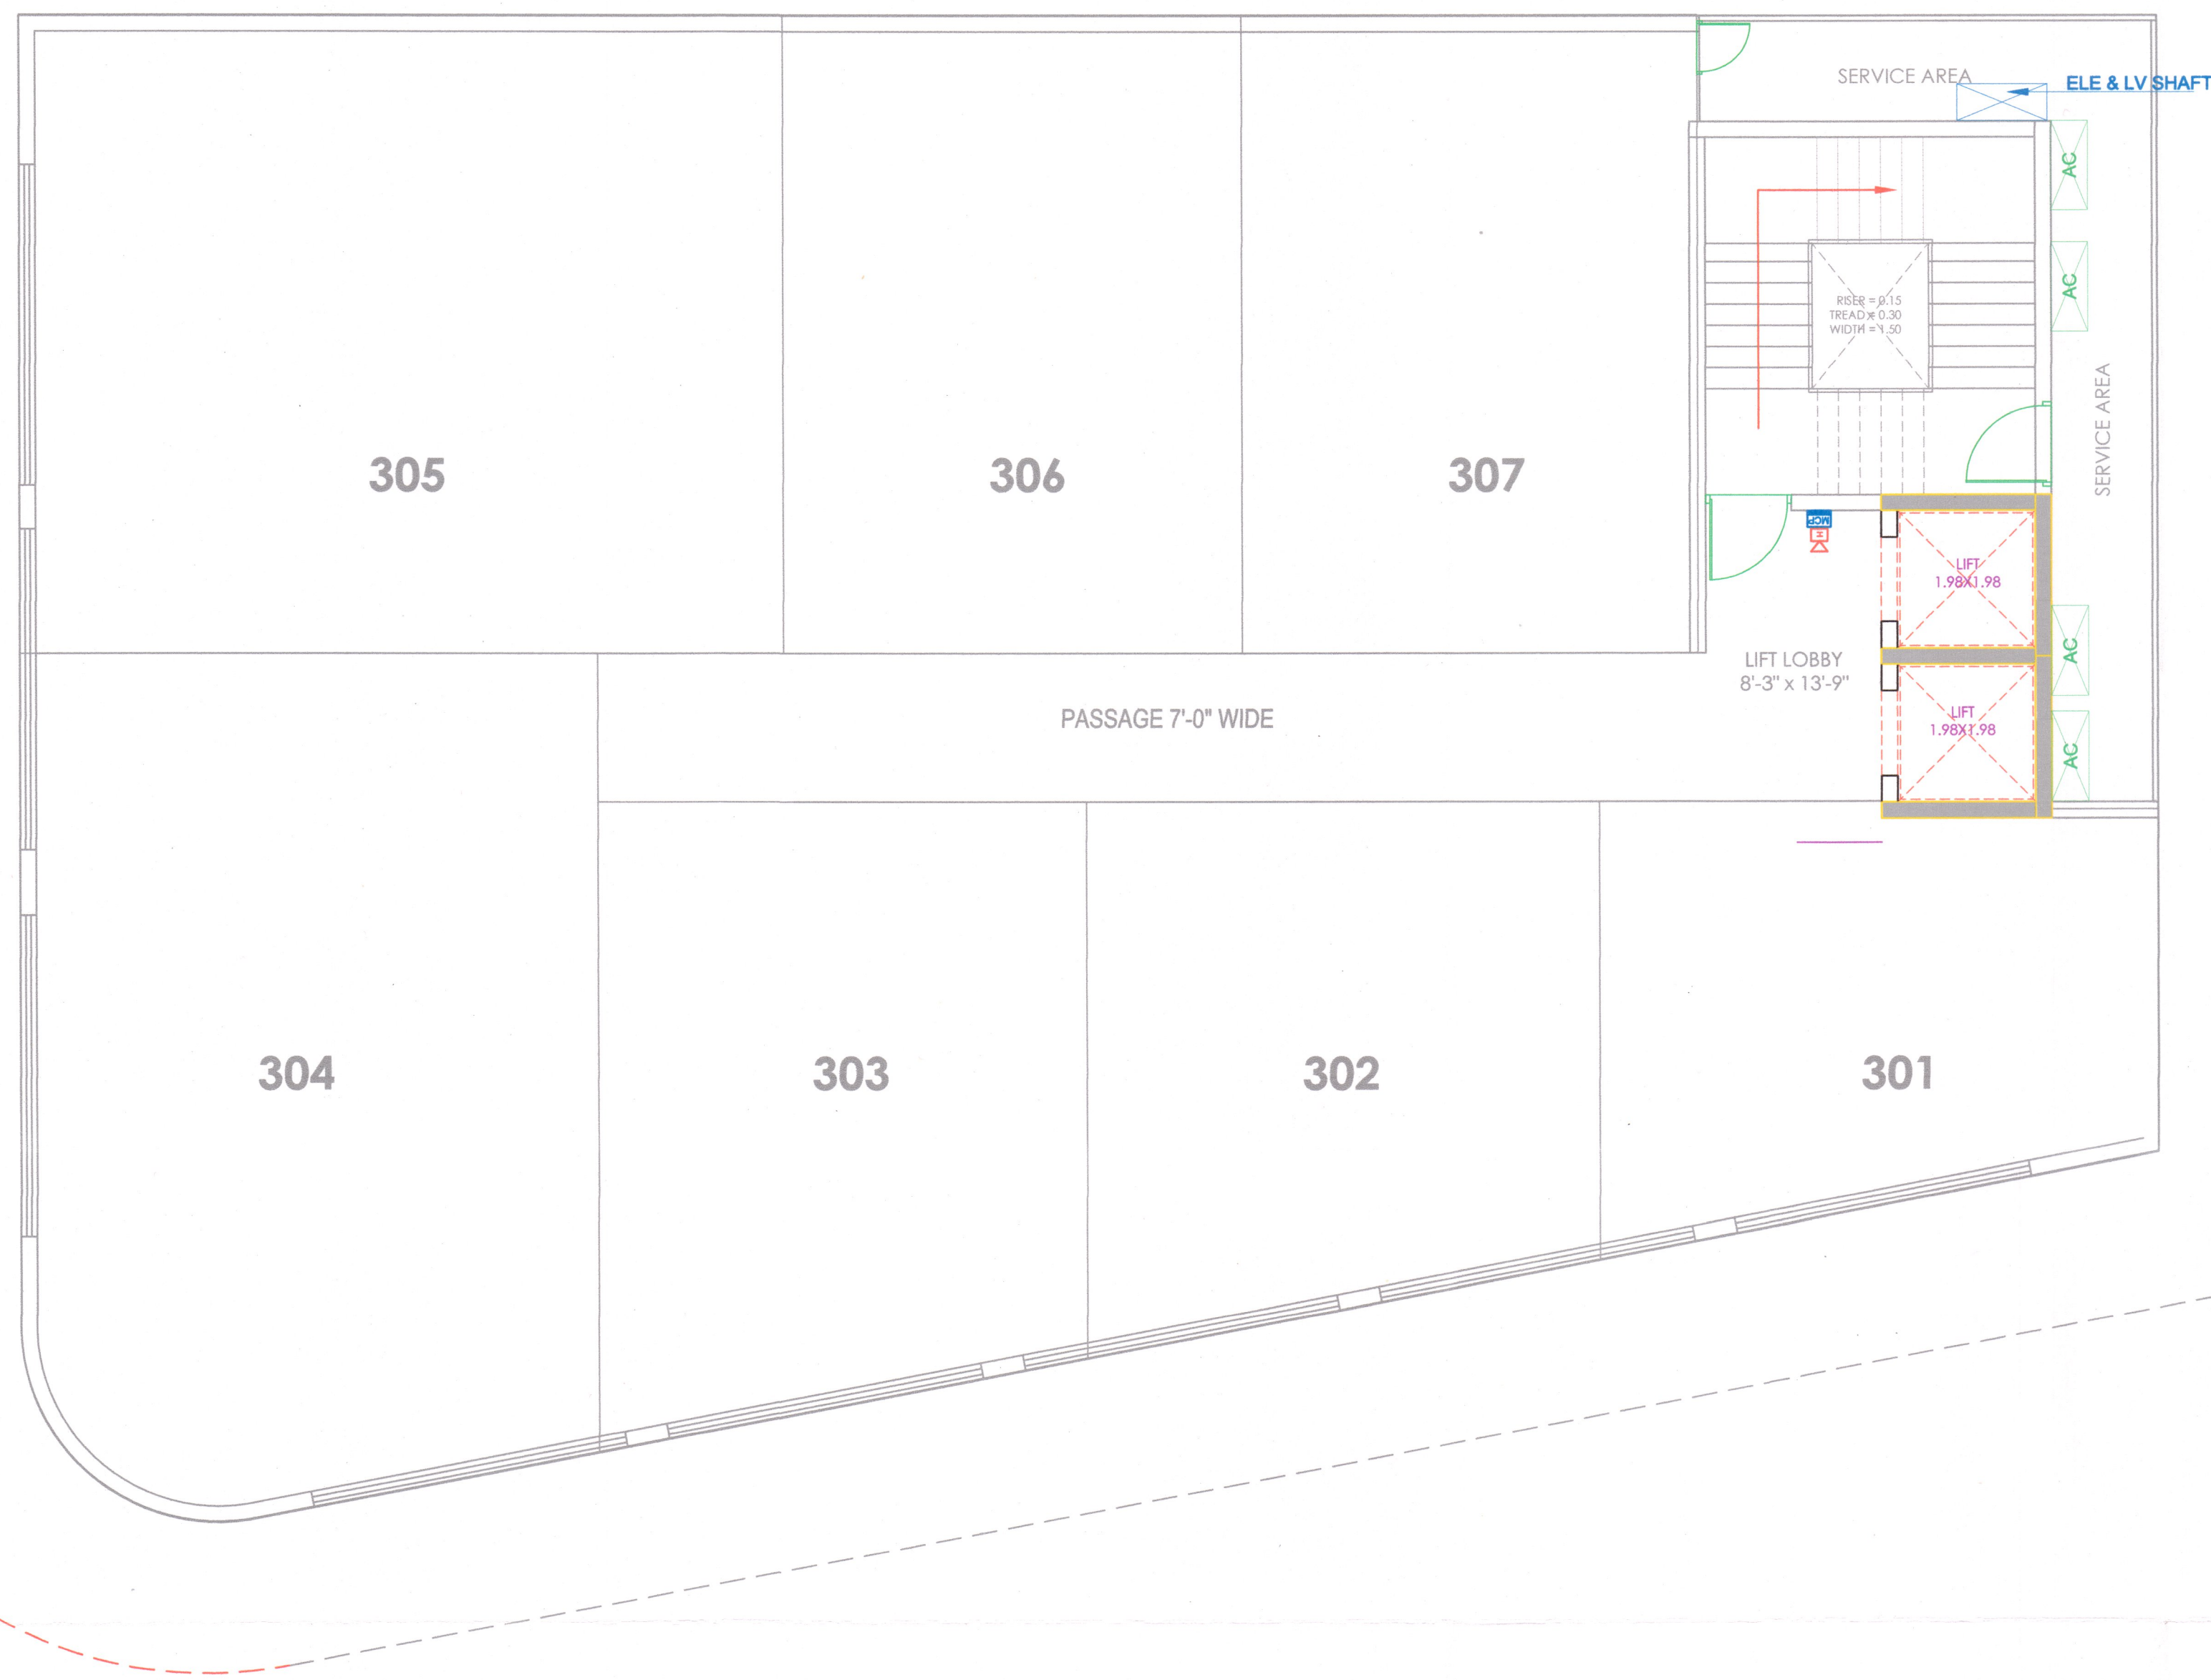
**SHRESHTHA**  
the heartbeat of your building

|           |        |             |            |            |
|-----------|--------|-------------|------------|------------|
| DEALT BY: |        | CHECKED BY: |            | DIRECTION: |
| DEVENDRA  |        | SACHIN      |            |            |
| DRAWN NO. | SCALE: | SHEET NO.   | DATE       |            |
|           | NTS    | A1          | 27.11.2024 |            |





**SUDHIR MATHUR**  
M.E.P.F. CONSULTANT  
B.E. MECHANICAL



| LEGEND |                          |
|--------|--------------------------|
| SYMBOL | DESCRIPTION              |
|        | MANUAL CALL POINT @4'-0" |
|        | HOOTER @8'-0"            |

| REV. NO. | DESCRIPTION TO REVISION | REV. BY | DATE |
|----------|-------------------------|---------|------|
| -        | -                       | -       | -    |
| -        | -                       | -       | -    |
**ARCHITECT**

**des<sup>ig</sup>n<sup>studio</sup>**

**GRAPHITE DESIGN STUDIO**  
ARCHITECTS, INTERIOR DESIGNERS, PLANNERS

68, Janki Puri-1st, Indiradevi Phatak, Opp. Jain Mandir, Jaipur  
CONTACT NO. +91-9626234414, 0141-2994414  
email: studio@graphitestudio.com  
Website: www.graphitedesignstudio.com

**STRUCTURAL CONSULTANT**

**Vijaytech Consultants Pvt. Ltd.**

11-17, SAJJAN MANSI, SHYAM NAGAR, JAIPUR-302004  
Phone: 91-141-2294432, 3257582, Fax: 91-141-4023198  
E-mail: vijaytech.ja@gmail.com

**CLIENT**

**BARDIYA GROUP**

**PROJECT NAME**

**GT BLVU**

**DWG TITLE**

**THIRD FLOOR ELECTRICAL PLAN**

**DWG STATUS**

**FOR RERA SUBMISSION**

**MEP CONSULTANTS**

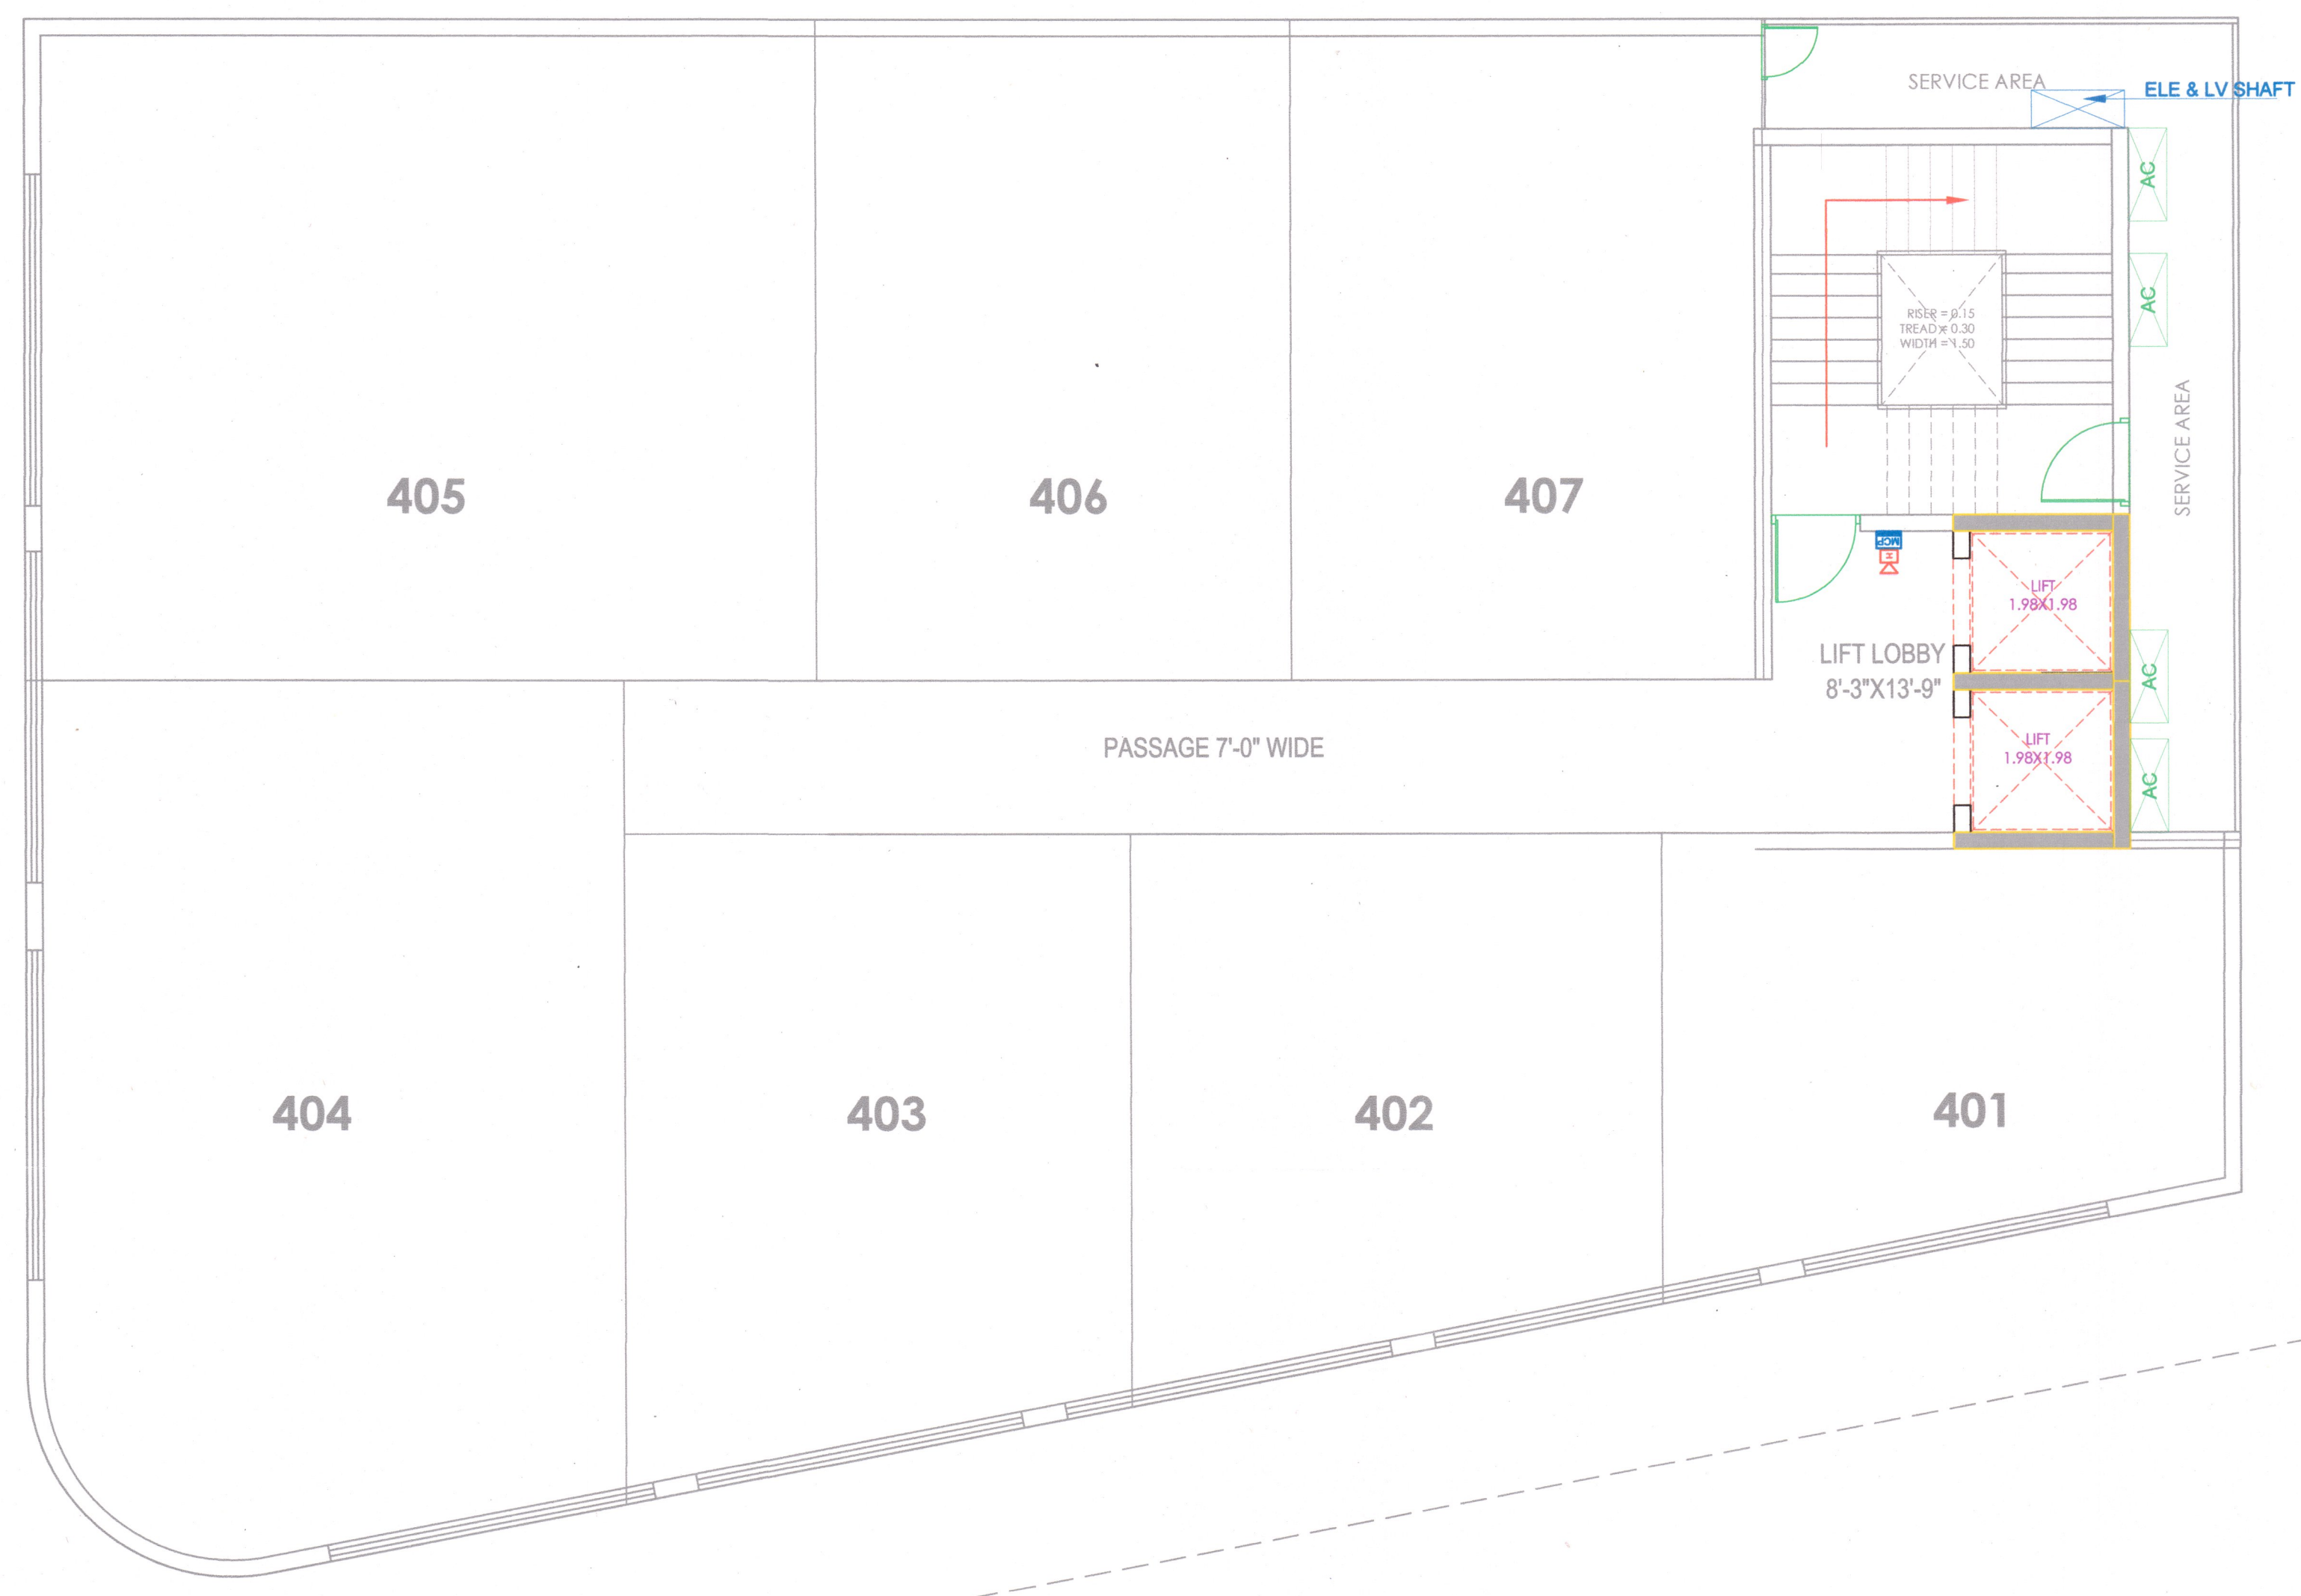
**SHRESHTHA**  
the heartbeat of your building

|                    |               |                    |              |                   |
|--------------------|---------------|--------------------|--------------|-------------------|
| <b>DEALT BY:</b>   |               | <b>CHECKED BY:</b> |              | <b>DIRECTION:</b> |
| DEVENDRA           |               | SACHIN             |              |                   |
| <b>DRAWING NO.</b> | <b>SCALE:</b> | <b>SHEET SIZE:</b> | <b>DATE:</b> |                   |
|                    | NTS           | A1                 | 27.11.2024   |                   |





**SUDHIR MATHUR**  
M.E.P.F. CONSULTANT  
B.E. MECHANICAL



| LEGEND |                           |
|--------|---------------------------|
| SYMBOL | DESCRIPTION               |
|        | MANUAL CALL POINT @ 4'-0" |
|        | HOOTER @ 8'-0"            |

| REV. NO. | DESCRIPTION TO REVISION | REV. BY | DATE |
|----------|-------------------------|---------|------|
| -        | -                       | -       | -    |
| -        | -                       | -       | -    |
**ARCHITECT**

**GRAPHITE DESIGN STUDIO**  
ARCHITECTS, INTERIOR DESIGNERS, PLANNERS  
68, Janak Puri-1st, Indrawati Phatak, Opp. Jain Mandir, Jaipur  
CONTACT NO. +91-9828334414, 0141-2584414  
email: studio@graphitedesignstudio.com  
Website: www.graphitedesignstudio.com

**STRUCTURAL CONSULTANT**

**Vijaytech Consultants Pvt. Ltd.**  
R-17, GALIYAM MARK, SURYAM NAGAR, JAIPUR-302018  
Phone: 91-141-224432, 3227592, Fax: 91-141-4022188  
Email: vijaytech@vjcpl.com

**CLIENT**

**BARDIYA GROUP**

**PROJECT NAME**

**GT BLVU**

**DWG TITLE**

**FOURTH FLOOR ELECTRICAL PLAN**

**DWG STATUS**

**FOR RERA SUBMISSION**

**MEP CONSULTANTS**

**SHRESHTHA**  
the heartbeat of your building

|            |        |             |            |            |
|------------|--------|-------------|------------|------------|
| DEALT BY:  |        | CHECKED BY: |            | DIRECTION: |
| DEVENDRA   |        | SACHIN      |            |            |
| DRAWN NO.: | SCALE: | SHEET SIZE: | DATE:      |            |
|            | NTS    | A1          | 27.11.2024 |            |