


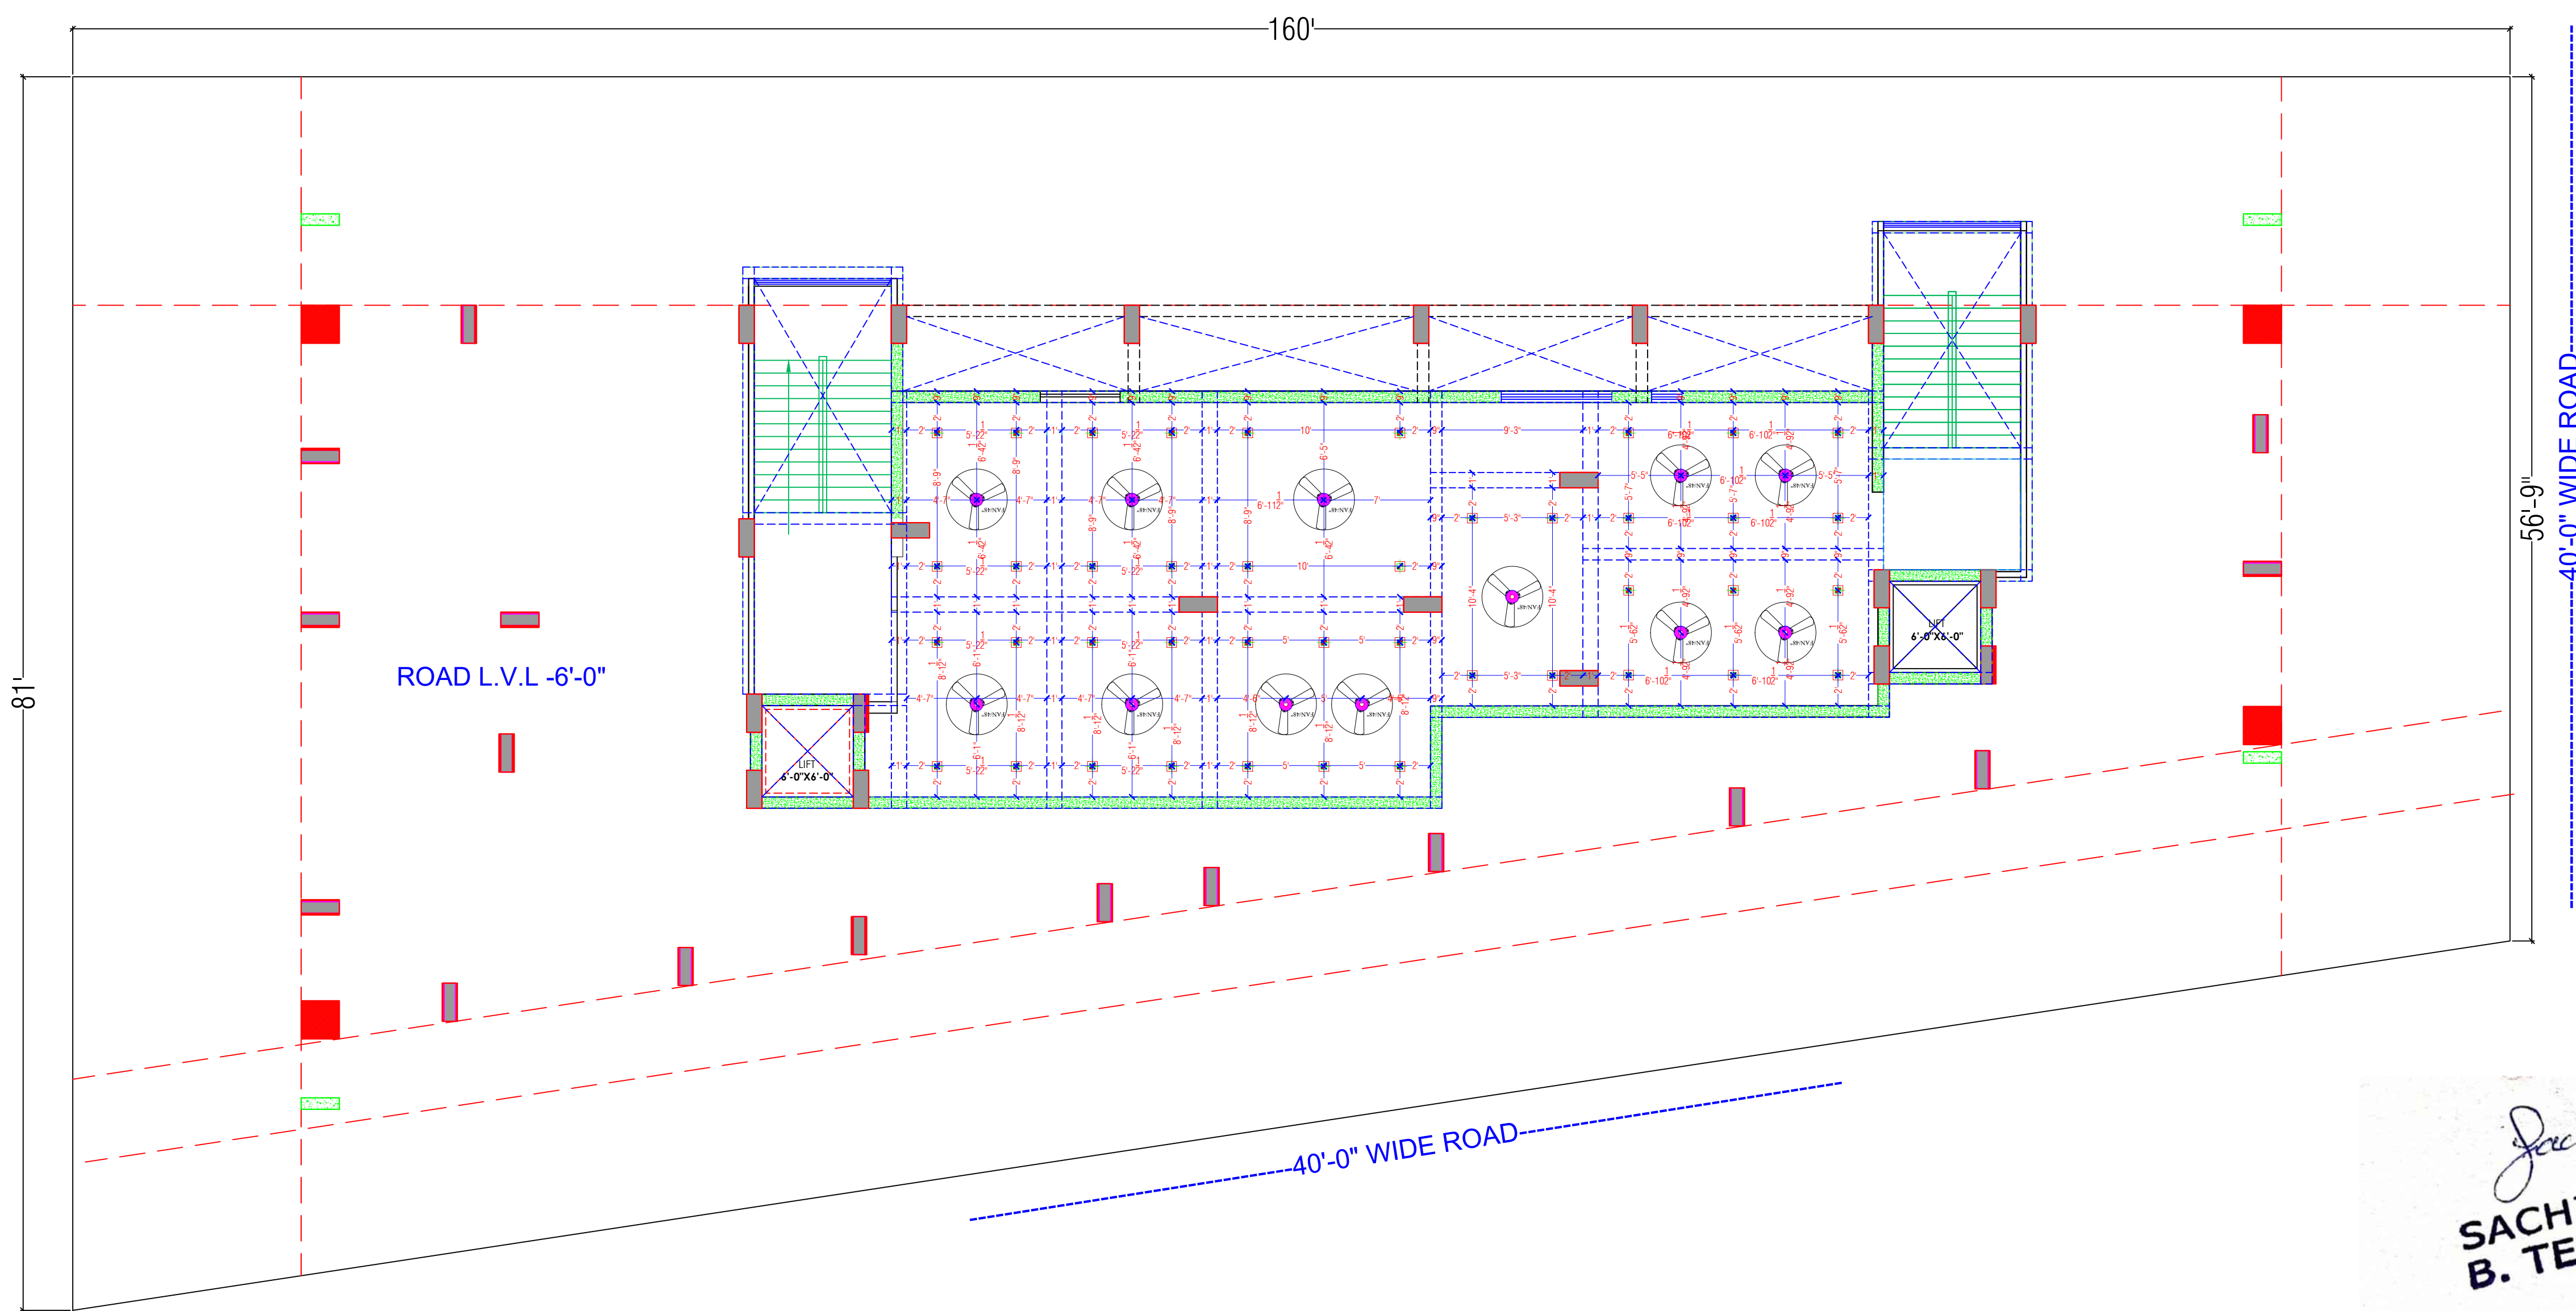

LEGENDS:			
Mounting Height	No.	I D	Description
IN FLOOR			CONTROL WIRING
CONDUIT			CONTROL WIRING
CONDUIT			AC CONTROL WIRING
IN CONDUIT			CHUSER CONTROL WIRING
CONDUIT			BULZER CONTROL WIRING
CEILING	FAN 48"		CEILING FAN 48"
CEILING	FAN 36"		CEILING FAN 36"
+90"	TL		TL WALL TUBELIGHT
+90"	BULB		WALL BRACKETS AS DESIGN LIGHT
+90"	GL		WALL BRACKETS AS DESIGN FOR GANESH LIGHT
CEILING	CFL		CFL CEILING LIGHT
+21"	FL		FOOT LIGHT
+48"	SB		SWITCH BOARD
+70"	ML		1 X 11 W CFL MIRROR LIGHT
VENTILATOR HT.	CR		CEILING ROSE
+24"	EXP		8" DIA FRESH AIR FAN
+24"	TEL		TELEPHONE POINT
+27"	TV		TV COMAL POINT
+27"	LP TV		6 A PLUS POINT FOR TV
+72"	LP CH		6 A PLUS POINT FOR CHIMNEY
+102"	SAC		SPLIT AC
+102"	PP-SAC		25 A POWER POINT FOR SPLIT AC
+42"	PP-MIX		15 A POWER POINT FOR MIXER
+78"	PP-G		15 A POWER POINT FOR GEYSER
+34"	PP-F		15 A POWER POINT FOR FRIDGE
+78"	PP-WP		15 A POWER POINT FOR WATER PURIFIER
+48"	PP-WM		15 A POWER POINT FOR WASHING MACHINE
+42"	BZ		BELL PUSH SWITCH
+90"	BP		BULZER POINT
+48"	AC		AC STARTER
+40"	MCB DB		MCB DISTRIBUTION BOARD

WARNING
1. This drawing is the sole copyright of Architects **VISTAAR** and should be used for the purpose expressly issued.


GENERAL NOTES
1. All dimensions are in feet and inches.
2. Do not scale this drawing follow written dimensions only.
3. This drawing should be read in conjunction with other architectural and structural drawings.
4. Any discrepancy in the drawing should be immediately brought to the notice of architect.

PROJECT TITLE
PUJA PRIME II
PLOT NO. B-107 & B-138
VAISHALI ESTATE BLOCK-B SIRSJI,JAIPUR

DRAWING TITLE
BASEMENT FLOOR
CEILING ELECTRICAL PLAN

ARCHITECTS :
VISTAAR ARCHITECTS & PLANNERS
Architects :: Interior Designers
B-2/12, Chitrkoot scheme,
main Gandhi Path,Opp mall of jaipur,Jaipur-21
Email-Vistaararchitects.web@gmail.com
PH.- 0141-4116461,09001010366

PATH :-			
DRN.	DATE	REV.	NORTH
MANOJ KUMAWAT	12-6-2024		
SCALE	JOB NO.		
N.T.S			

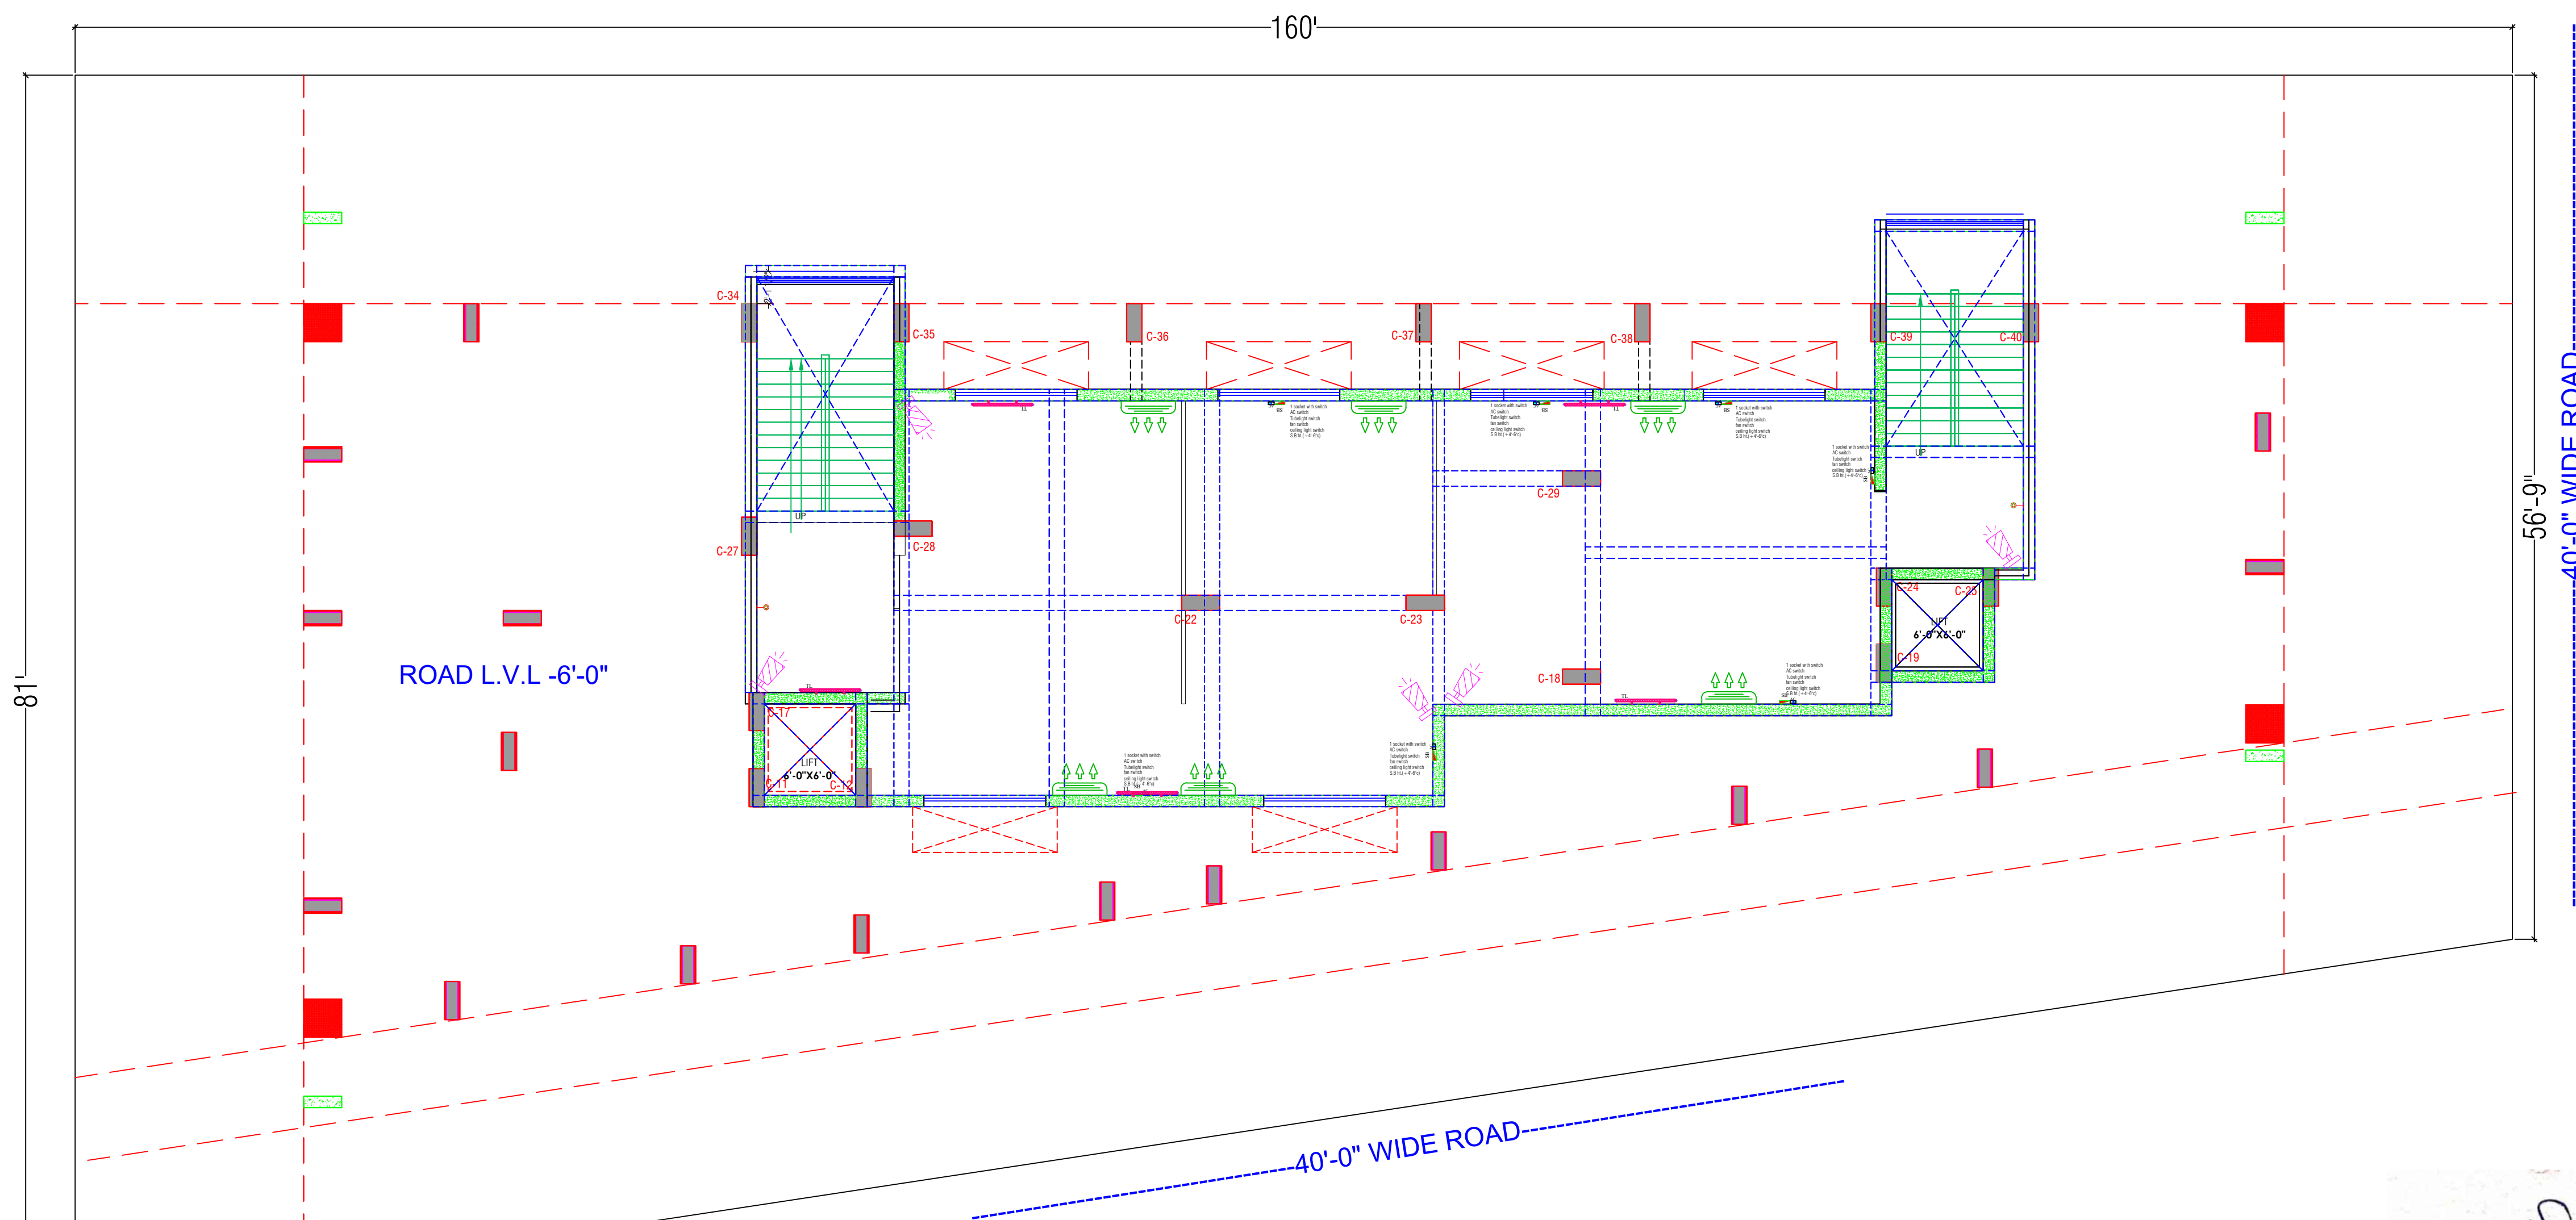

LEGENDS:				
Mounting Height	No.	I D	Symbol	Description
IN FLOOR				CONTROL WIRING
IN CONDUIT				CONTROL WIRING
IN CONDUIT				AC CONTROL WIRING
IN CONDUIT				CHUCKER CONTROL WIRING
IN CONDUIT				BELLER CONTROL WIRING
CEILING	FAN 45°			CEILING FAN 45°
CEILING	FAN 30°			CEILING FAN 30°
+90°	TL			TL 400W WALL TUBELIGHT
+90°	BULB			WALL BRACKETS AS DESIGN LIGHT
+90°	GL			WALL BRACKETS AS DESIGN FOR GANESH LIGHT
+90°	GL			WALL BRACKETS AS DESIGN FOR GANESH LIGHT
CEILING	CFL			CFL CEILING LIGHT
+21°	FL			FOOT LIGHT
+45°	SB			SWITCH BOARD
+70°	ML			1 X 11 W CFL MIRROR LIGHT
VENTILATOR HT.	CR			CEILING ROSE
VENTILATOR HT.	EXP			12 DIA FRESH AIR FAN
+24°	TEL			TELEPHONE POINT
+27°	TV			TV COAXIAL POINT
+27°	LP TV			6 A PLUS POINT FOR TV
+72°	LP CH			6 A PLUS POINT FOR CHIMNEY
+102°	SAC			SPLIT AC
+102°	PP-SAC			25 A POWER POINT FOR SPLIT AC
+42°	PP-ME			15 A POWER POINT FOR MMR
+78°	PP-G			15 A POWER POINT FOR GENSER
+34°	PP-F			15 A POWER POINT FOR FIDGE
+78°	PP-WP			15 A POWER POINT FOR WATER PURIFIER
+48°	PP-WM			15 A POWER POINT FOR WASHING MACHINE
+42°	BP			BELL PUSH SWITCH
+90°	BZ			BELLER POINT
+48°	AC			AC SEATER
+40°	MCB DB			MCB DISTRIBUTION BOARD

WARNING
1. This drawing is the sole copyright of Architects **VISTAAR** and should be used for the purpose expressly issued.


GENERAL NOTES
1. All dimensions are in feet and inches.
2. Do not scale this drawing follow written dimensions only.
3. This drawing should be read in conjunction with other architectural and structural drawings.
4. Any discrepancy in the drawing should be immediately brought to the notice of architect.

PROJECT TITLE
PUJA PRIME II
PLOT NO. B-107 & B-138
VAISHALI ESTATE BLOCK-B SIRSI,JAIPUR

DRAWING TITLE
BASEMENT FLOOR
WALL ELECTRICAL PLAN

ARCHITECTS :
VISTAAR ARCHITECTS & PLANNERS
Architects :: Interior Designers
B-2/12, Chitrkoot scheme,
main Gandhi Path,Opp mall of jaipur,Jaipur-21
Email-Vistaararchitects.web@gmail.com
PH.- 0141-4116461,09001010366

PATH :-			
DRN.	DATE	REV.	NORTH
SACHIN	12-6-2024		
SCALE	JOB NO.		
N.T.S			

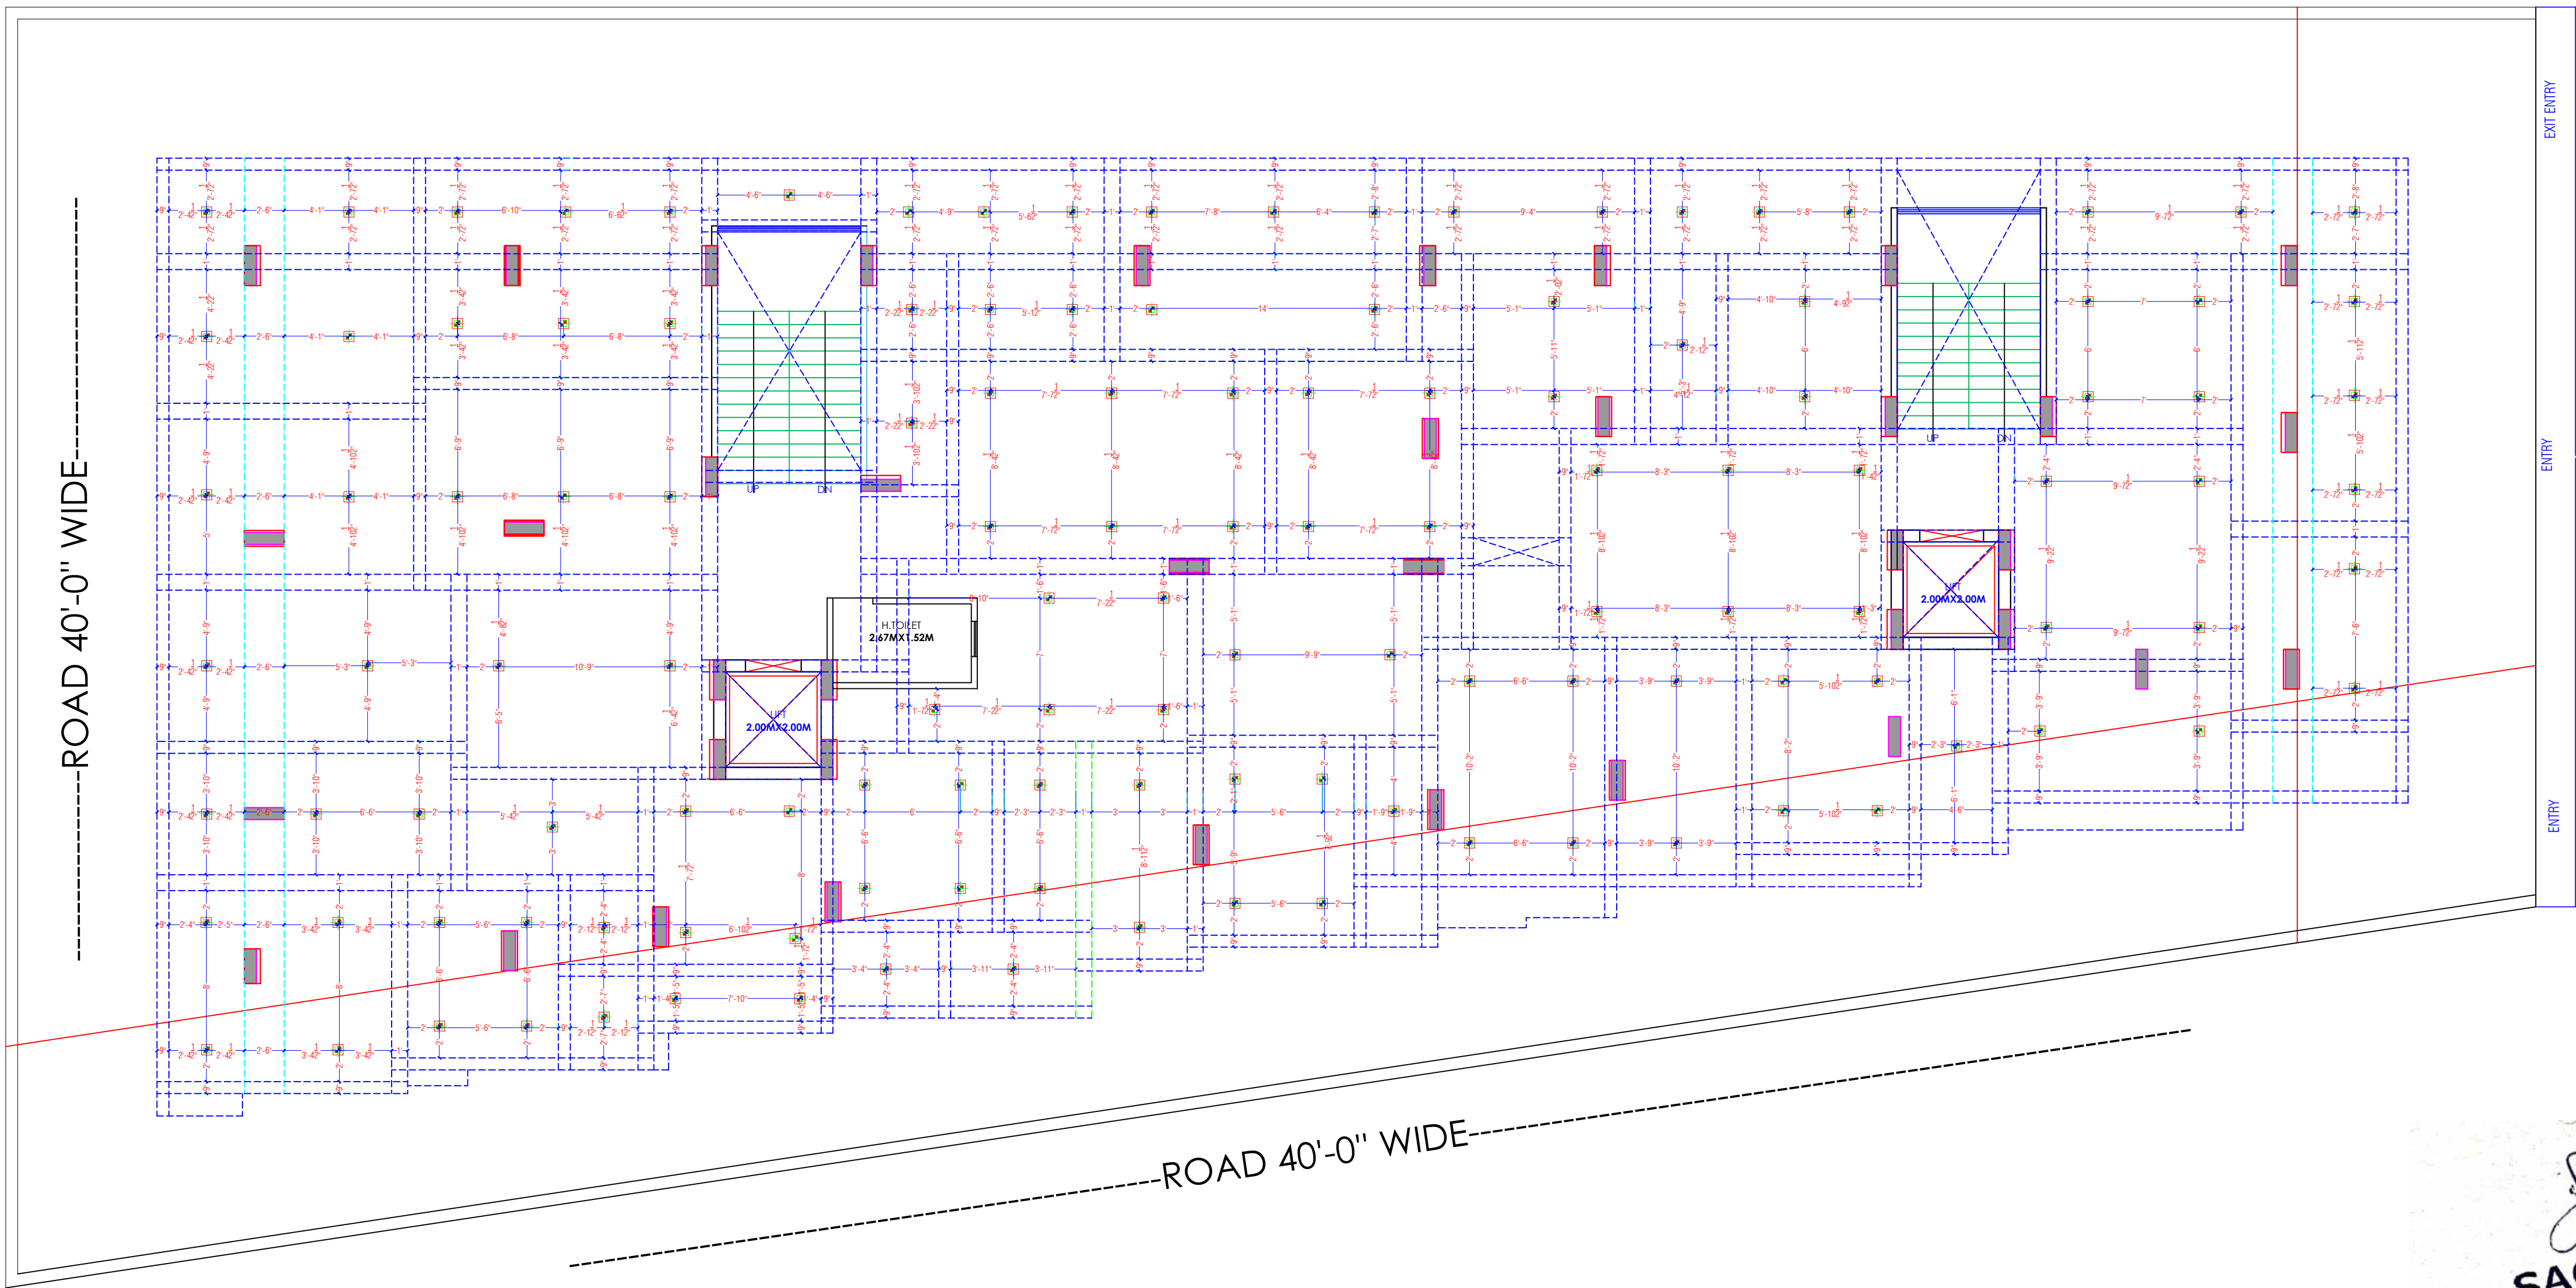

LEGENDS:				
Mounting Height	No.	I D	Symbol	Description
IN FLOOR				CONTROL WIRING
IN CONDUIT				CONTROL WIRING
IN CONDUIT				AC CONTROL WIRING
IN CONDUIT				OTHER CONTROL WIRING
IN CONDUIT				Buzzer CONTROL WIRING
CEILING	FANW*			CEILING FAN 40"
CEILING	FANW*			CEILING FAN 30"
+80"	TL			EXHIB WALL TUBELIGHT
+80"	BULB			WALL BRACKETS AS DESIGN LIGHT
+80"	GL			WALL BRACKETS AS DESIGN FOR GALLERY LIGHT
	GL			WALL BRACKETS AS DESIGN FOR GATE LIGHT
CEILING	CFL			CFL CEILING LIGHT
+21"	FL			FOOT LIGHT
+48"	SB			SWITCH BOARD
+70"	ML			1 X 11 W CFL MIRROR LIGHT
VENTILATOR	CR			CEILING ROSE
VENTILATOR	EXF			9" DIA FRESH AIR FAN
+24"	TEL			TELEPHONE POINT
+27"	TV			TV COAXIAL POINT
+27"	LP TV			5 A PLUG POINT FOR TV
+72"	LP CH			5 A PLUG POINT FOR CHIMNEY
+102"	SAC			SPLIT AC
+102"	PP-SAC			5 A POWER POINT FOR SPLIT AC
+42"	PP-MIX			5 A POWER POINT FOR MIXER
+78"	PP-G			5 A POWER POINT FOR GEYSER
+54"	PP-F			5 A POWER POINT FOR FRIDGE
+78"	PP-WP			5 A POWER POINT FOR WATER PURIFIER
+48"	PP-WM			5 A POWER POINT FOR WASHING MACHINE
+42"	BP			BELL PUSH SWITCH
+90"	BZ			Buzzer Point
+48"	AC			AC STARTER
+60"	MCB DB			MCB DISTRIBUTION BOARD

WARNING

1. This drawing is the sole copyright of Architects **VISTAAR** and should be used for the purpose expressly issued.

GENERAL NOTES

1. All dimensions are in feet and inches.

2. Do not scale this drawing follow written dimensions only.

3. This drawing should be read in conjunction with other architectural and structural drawings.

4. Any discrepancy in the drawing should be immediately brought to the notice of architect.

PROJECT TITLE

PUJA PRIME II
PLOT NO. B-107 & B-138
VAISHALI ESTATE BLOCK-B SIRSI,JAIPUR

DRAWING TITLE

STILT FLOOR
CEILING ELECTRICAL PLAN


ARCHITECTS :

VISTAAR ARCHITECTS & PLANNERS

Architects :: Interior Designers
B-2/12, Chitrkoot scheme,
main Gandhi Path,Opp mall of jaipur,Jaipur-21
Email-Vistaararchitects.web@gmail.com
PH.- 0141-4116461,09001010366

PATH :-			
DRN.	DATE	REV.	NORTH
MANOJ KUMAWAT	12-6-2024		
SCALE	JOB NO.		
N.T.S			

ROAD 40'-0" WIDE

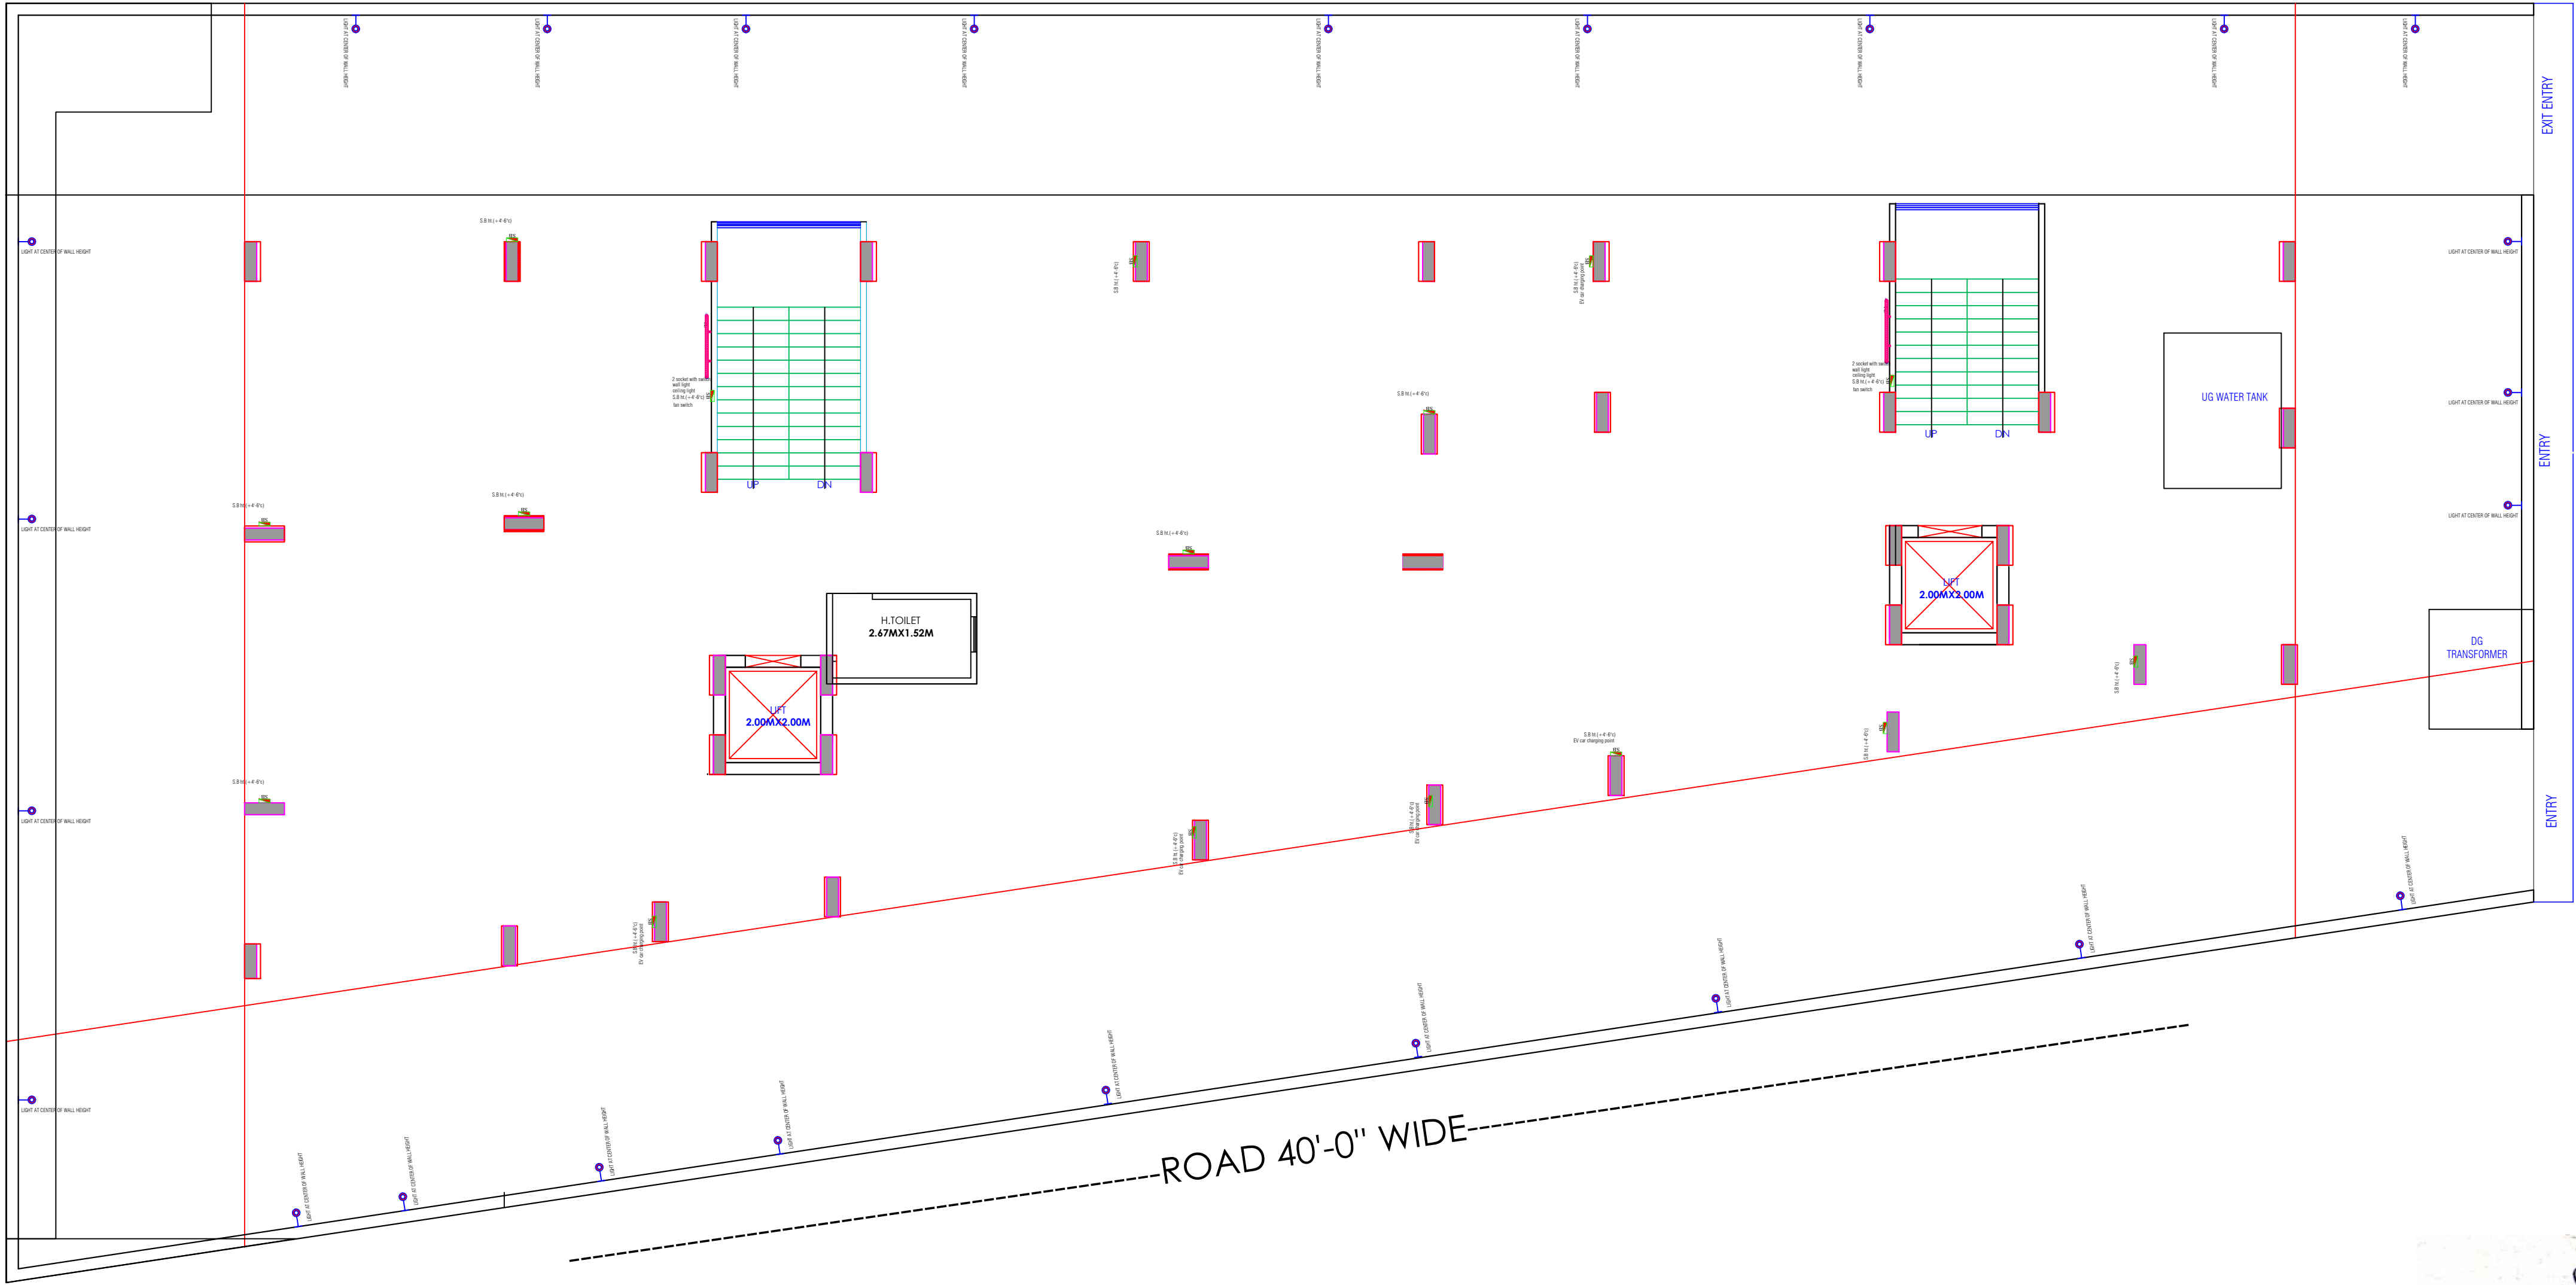

LEGENDS:				
Mounting Height	No.	I D	Symbol	Description
IN FLOOR CONDUIT				CONTROL WIRING
				CONTROL WIRING
				AC CONTROL WIRING
				OTHER CONTROL WIRING
CEILING	FAN-40"			BUZZER CONTROL WIRING
	FAN-30"			CEILING FAN 40"
+90"	TL			CEILING FAN 30"
	TL			1X/4W WALL TUBELIGHT
+90"	BULB			WALL BRACKETS AS DESIGN LIGHT
	GL			WALL BRACKETS AS DESIGN FOR GLASSH LIGHT
CEILING	CFL			WALL BRACKETS AS DESIGN FOR CEST LIGHT
	CFL			CFL CEILING LIGHT
+21"	FL			FOOT LIGHT
+48"	SB			SWITCH BOARD
+75"	ML			1 X 11 W CFL MIRROR LIGHT
VENTILATOR 10"	CR			CEILING ROSE
+54"	EXP			8" DIA FRESH AIR FAN
	TEL			TELEPHONE POINT
+27"	TV			TV COAXIAL POINT
+27"	LP TV			6 A PLUS POINT FOR TV
+72"	LP-CH			6 A PLUS POINT FOR CHIMNEY
+102"	SAC			SPLIT AC
+102"	PP-SAC			25 A POWER POINT FOR SPLIT AC
+42"	PP-MIX			15 A POWER POINT FOR MIXER
+78"	PP-G			15 A POWER POINT FOR GEYSER
+54"	PP-F			15 A POWER POINT FOR FRIDGE
+78"	PP-WP			15 A POWER POINT FOR WATER PURIFIER
+48"	PP-WM			15 A POWER POINT FOR WASHING MACHINE
+42"	BP			BELL PUSH SWITCH
+90"	BZ			BUZZER POINT
+48"	AC			AC STARTER
+80"	MCB DB			MCB DISTRIBUTION BOARD

WARNING
1. This drawing is the sole copyright of Architects **VISTAAR** and should be used for the purpose expressly issued.

GENERAL NOTES
1. All dimensions are in feet and inches.
2. Do not scale this drawing follow written dimensions only.
3. This drawing should be read in conjunction with other architectural and structural drawings.
4. Any discrepancy in the drawing should be immediately brought to the notice of architect.


PROJECT TITLE
PUJA PRIME II
PLOT NO. B-107 & B-138
VAISHALI ESTATE BLOCK-B SIRSI,JAIPUR

DRAWING TITLE
STILT FLOOR WALL ELECTRICAL PLAN

ARCHITECTS :
VISTAAR ARCHITECTS & PLANNERS
Architects :: Interior Designers
B-2/12, Chitrkoot scheme,
main Gandhi Path,Opp mall of jaipur,Jaipur-21
Email-Vistaararchitects.web@gmail.com
PH.- 0141-4116461,09001010366

PATH :-			
DRN.	DATE	REV.	NORTH
MANOJ KUMAWAT	12-6-2024		
SCALE	JOB NO.		
N.T.S			

Sachin
SACHIN KUMAR
B. TECH. (CIVIL)

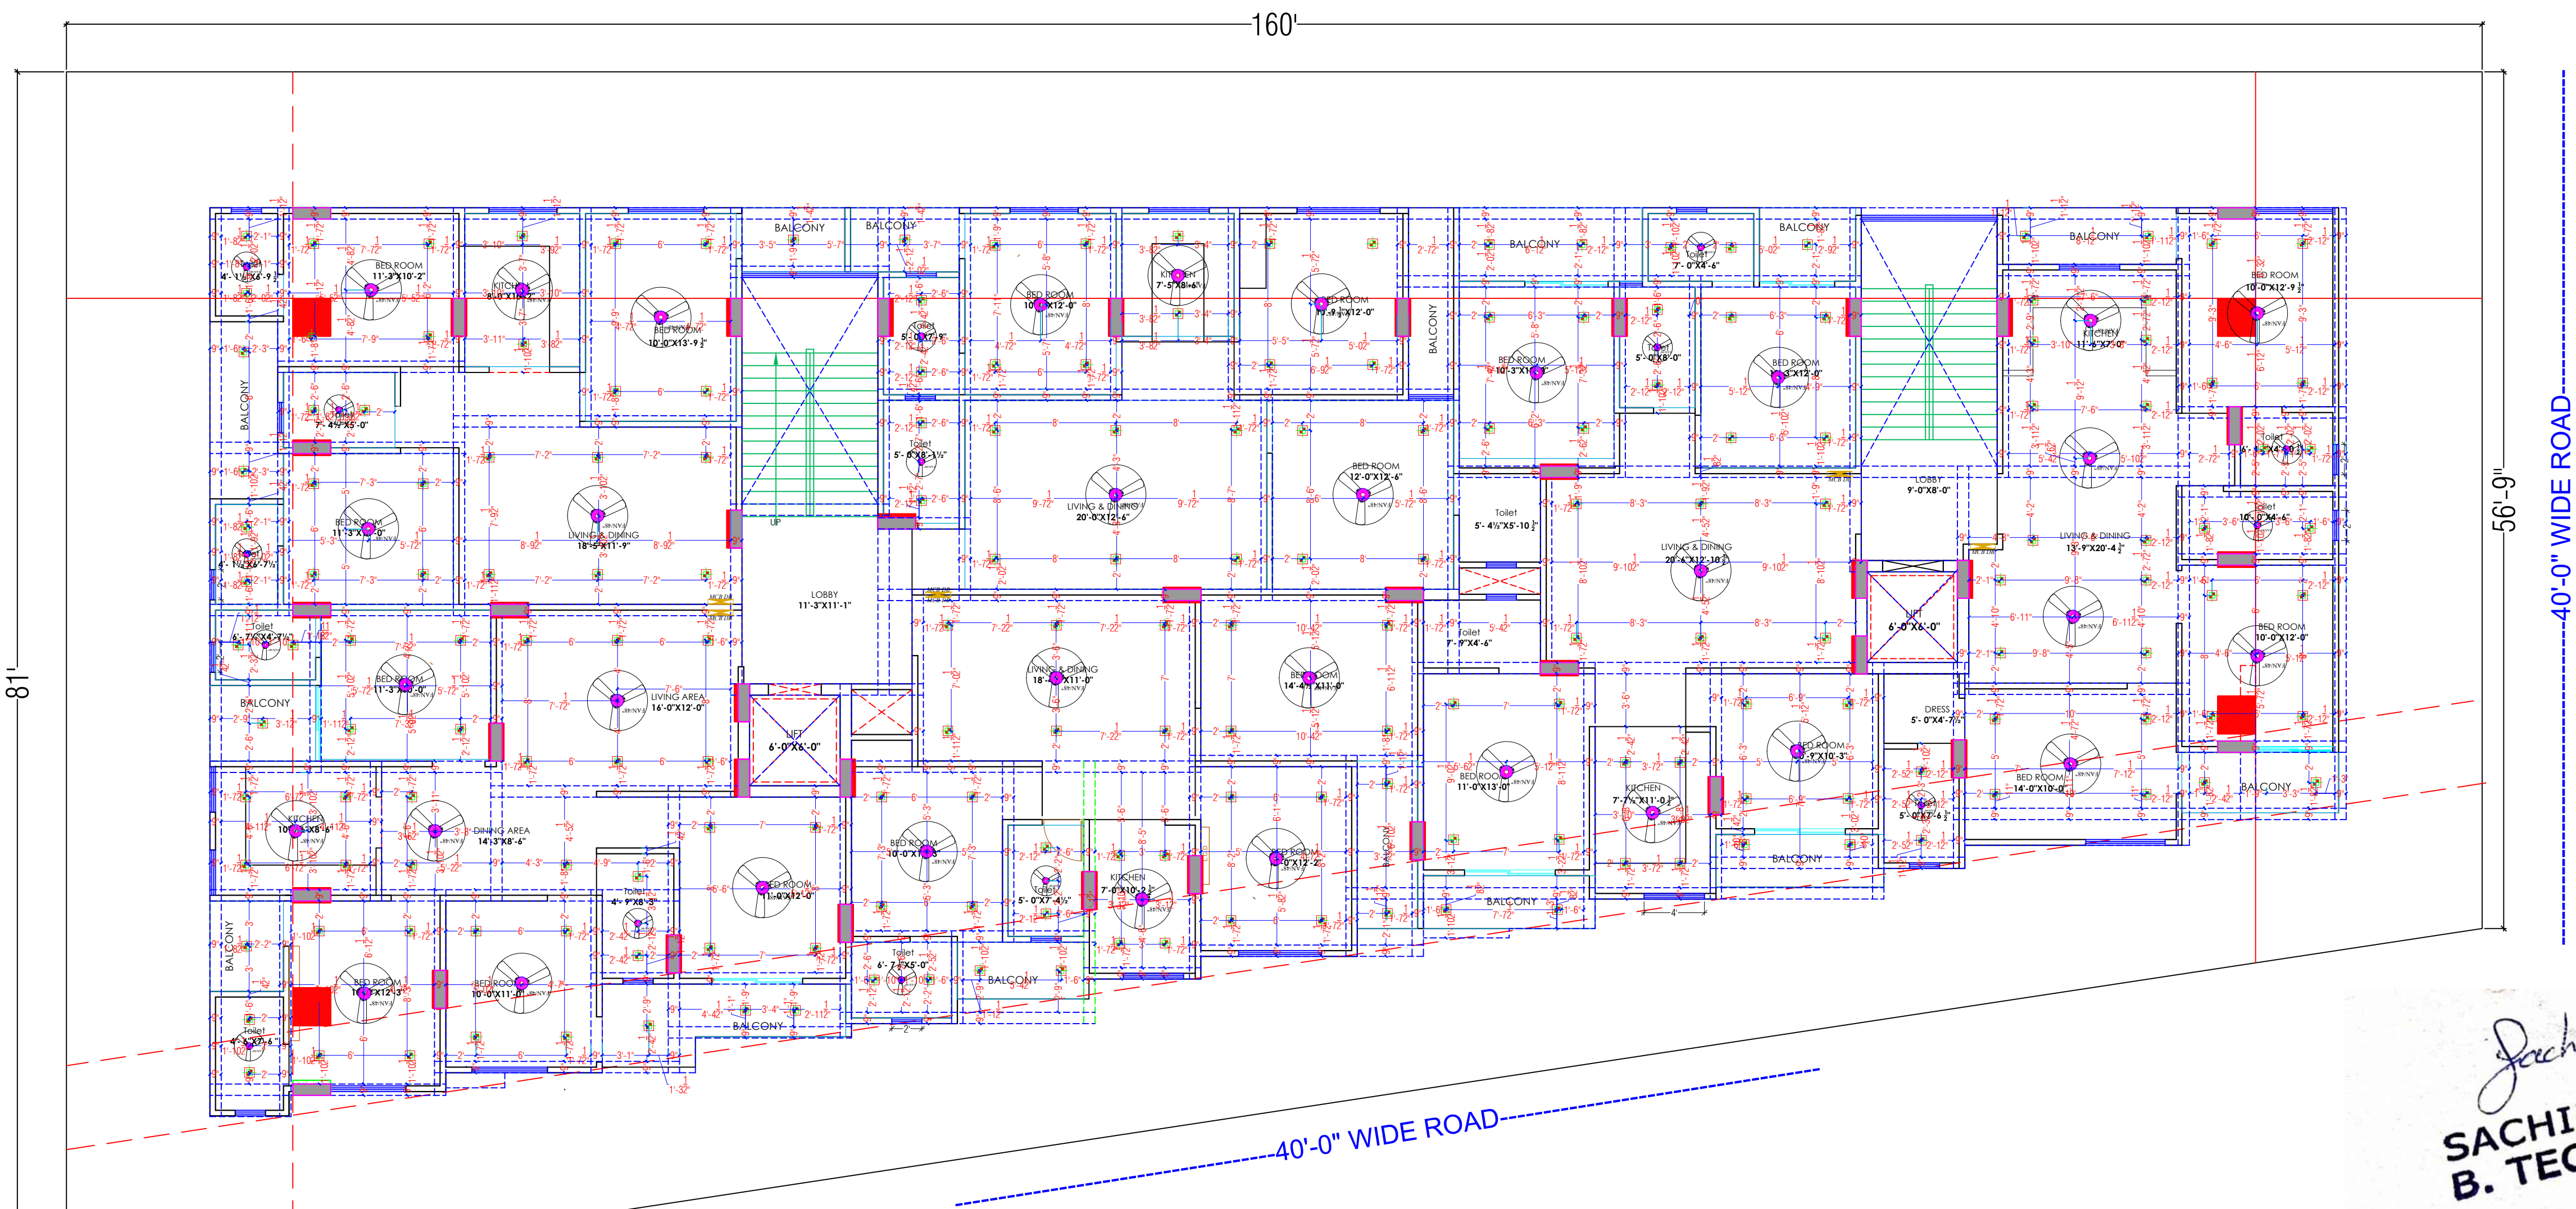

LEGENDS:				
Mounting Height	No.	I D	Symbol	Description
IN FLOOR				CONTROL WIRING
IN CONDUIT				CONTROL WIRING
IN CONDUIT				AC CONTROL WIRING
IN CONDUIT				CHYSER CONTROL WIRING
IN CONDUIT				BULZER CONTROL WIRING
CEILING	FAN48"			CEILING FAN 48"
CEILING	FAN36"			CEILING FAN 36"
-90"	TL			1X1W WALL TUBELIGHT
-90"	BULB			WALL BRACKETS AS DESIGN LIGHT
-90"	GL			WALL BRACKETS AS DESIGN FOR GLASS LIGHT
CEILING	CFL			CTL CEILING LIGHT
-21"	FL			FOOT LIGHT
-48"	SB			SWITCH BOARD
-75"	ML			1 X 1 W CFL MIRROR LIGHT
VENTILATOR HT	CR			CEILING ROSE
VENTILATOR HT	EXP			5" DIA FRESH AIR FAN
-24"	TEL			TELEPHONE POINT
-21"	TV			TV COAXIAL POINT
-21"	LP-TV			G A PLUG POINT FOR TV
-72"	LP-CP			G A PLUG POINT FOR CHIMNEY
-102"	SAC			SPUT AC
-102"	PP-SAC			25 A POWER POINT FOR SPUT AC
-42"	PP-MIX			15 A POWER POINT FOR MIXER
-74"	PP-G			15 A POWER POINT FOR GEYSER
-54"	PP-F			15 A POWER POINT FOR FRIDGE
-59"	PP-BP			15 A POWER POINT FOR WATER PUMPER
-48"	PP-WM			15 A POWER POINT FOR WASHING MACHINE
-42"	BP			BELL PUSH SWITCH
-90"	BZ			BULZER POINT
-48"	AC			AC STARTER
-60"	MCR DB			MCR DISTRIBUTION BOARD

WARNING
1. This drawing is the sole copyright of Architects **VISTAAR** and should be used for the purpose expressly issued.

GENERAL NOTES
1. All dimensions are in feet and inches.
2. Do not scale this drawing follow written dimensions only.
3. This drawing should be read in conjunction with other architectural and structural drawings.
4. Any discrepancy in the drawing should be immediately brought to the notice of architect.


PROJECT TITLE
PUJA PRIME II
PLOT NO. B-107 & B-138
VAISHALI ESTATE BLOCK-B SIRSI,JAIPUR

DRAWING TITLE
GROUND FLOOR
CEILING ELECTRICAL PLAN

ARCHITECTS :
VISTAAR ARCHITECTS & PLANNERS
Architects :: Interior Designers
B-2/12, Chitrkoot scheme,
main Gandhi Path,Opp mall of jaipur,Jaipur-21
Email-Vistaararchitects.web@gmail.com
PH.- 0141-4116461,09001010366

PATH :-			
DRN.	DATE	REV.	NORTH
MANOJ KUMAWAT	11-6-2024		
SCALE	JOB NO.		
N.T.S			

SACHIN KUMAR
B. TECH. (CIVIL)

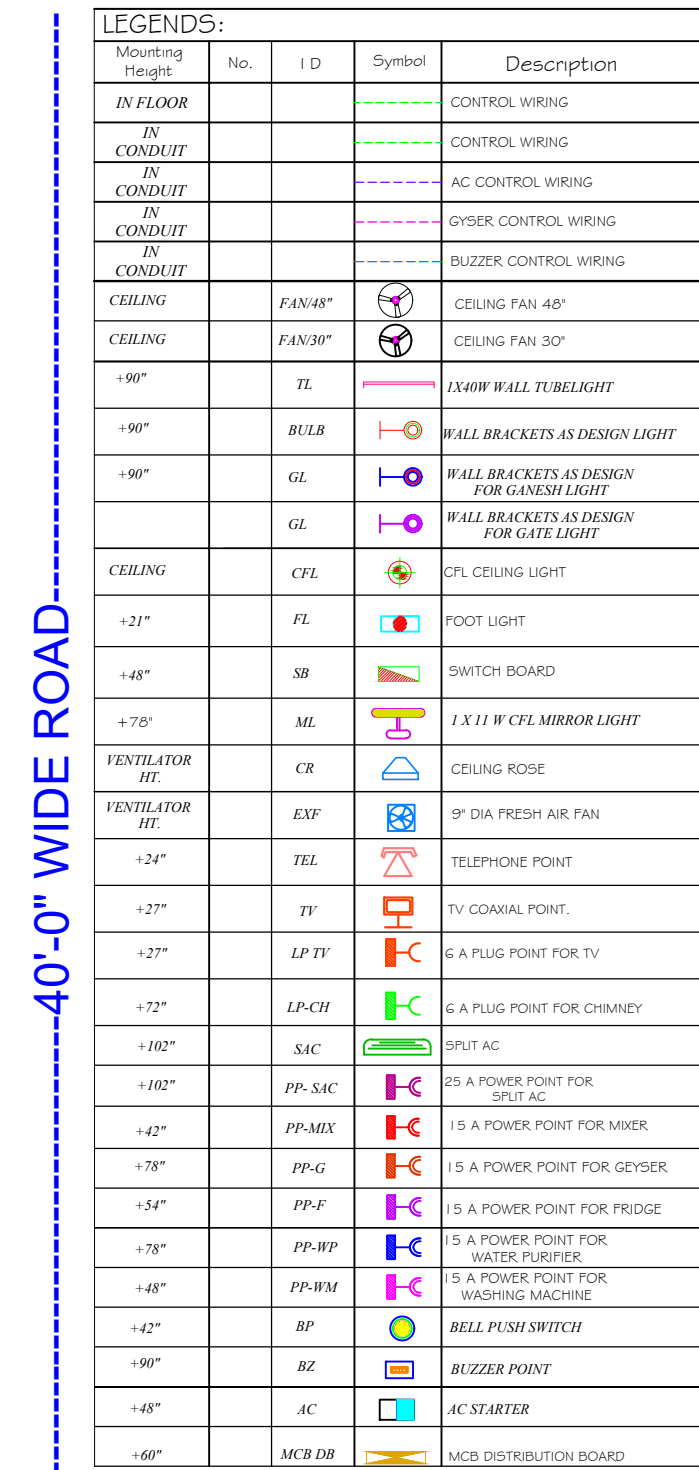

GENERAL NOTES

1. All dimensions are in feet and inches.
2. Do not scale this drawing follow written dimensions only.
3. This drawing should be read in conjunction with other architectural and structural drawings.
4. Any discrepancy in the drawing should be immediately brought to the notice of architect.


PROJECT TITLE
PUJA PRIME II
PLOT NO. B-107 & B-138
VAISHALI ESTATE BLOCK-B SIRSI, JAIPUR

RAWING TITLE

GROUND FLOOR
WALL ELECTRICAL PLAN

ARCHITECTS :
VISTAAR ARCHITECTS & PLANNERS
Architects :: Interior Designers
-2/12, Chitrkoot scheme,
Main Gandhi Path, Opp mall of jaipur, Jaipur-21
mail-Vistaararchitects.web@gmail.com
PH.- 0141-4116461,09001010366

PATH :-		NORTH	
MANOJ JUMAWAT	11-6-2024		
SCALE	JOB NO.		
N.T.S			

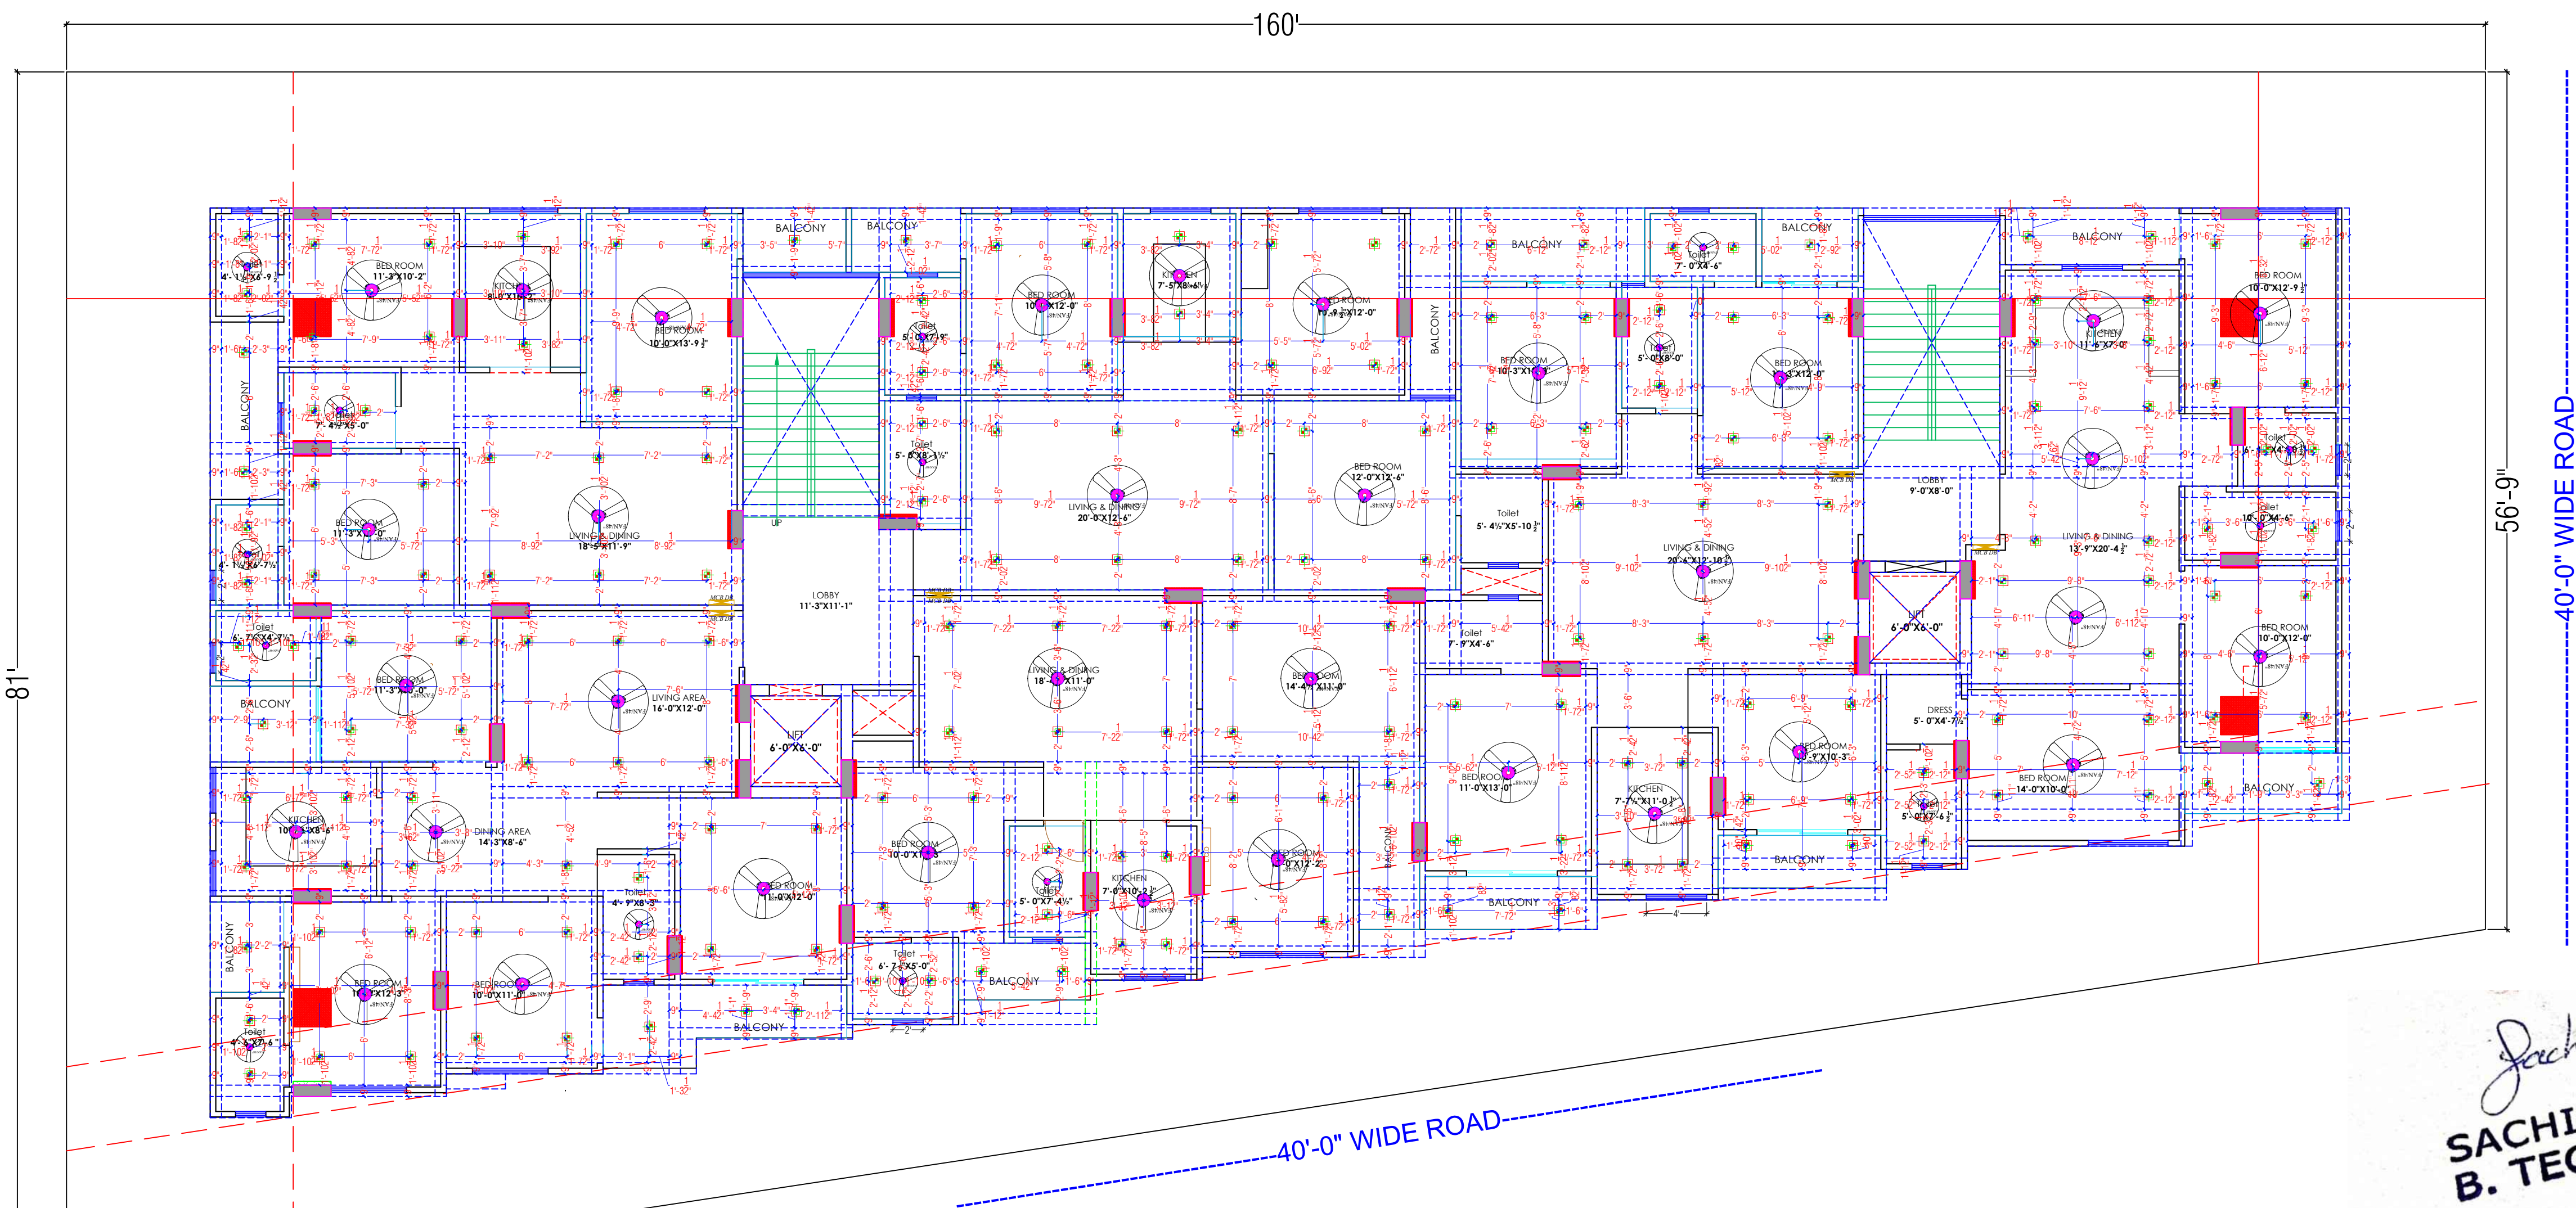

LEGENDS:				
Mounting Height	No.	I D	Symbol	Description
IN FLOOR				CONTROL WIRING
IN CONDUIT				CONTROL WIRING
IN CONDUIT				AC CONTROL WIRING
IN CONDUIT				CHYSER CONTROL WIRING
IN CONDUIT				BULZER CONTROL WIRING
CEILING	FAN48"			CEILING FAN 48"
CEILING	FAN36"			CEILING FAN 36"
-90"	TL			1X1W WALL TUBELIGHT
-90"	BULB			WALL BRACKETS AS DESIGN LIGHT
-90"	GL			WALL BRACKETS AS DESIGN FOR GLASS LIGHT
CEILING	CFL			CTL CEILING LIGHT
-21"	FL			FOOT LIGHT
-48"	SB			SWITCH BOARD
-75"	ML			1 X 1 W CFL MIRROR LIGHT
VENTILATOR HT	CR			CEILING ROSE
VENTILATOR HT	EXP			5" DIA FRESH AIR FAN
-24"	TEL			TELEPHONE POINT
-22"	TV			TV COAXIAL POINT
-22"	LPTV			G A PLUG POINT FOR TV
-72"	LP-CH			G A PLUG POINT FOR CHIMNEY
-102"	SAC			SPUT AC
-102"	PP-SAC			25 A POWER POINT FOR SPUT AC
-42"	PP-MIX			15 A POWER POINT FOR MIXER
-74"	PP-G			15 A POWER POINT FOR GEYSER
-54"	PP-F			15 A POWER POINT FOR FRIDGE
-50"	PP-BP			15 A POWER POINT FOR WATER PUMPER
-48"	PP-WM			15 A POWER POINT FOR WASHING MACHINE
-42"	BP			BELL PUSH SWITCH
-90"	BZ			BULZER POINT
-48"	AC			AC STARTER
-60"	MCD DB			MCD DISTRIBUTION BOARD

WARNING
1. This drawing is the sole copyright of Architects **VISTAAR** and should be used for the purpose expressly issued.

GENERAL NOTES
1. All dimensions are in feet and inches.
2. Do not scale this drawing follow written dimensions only.
3. This drawing should be read in conjunction with other architectural and structural drawings.
4. Any discrepancy in the drawing should be immediately brought to the notice of architect.


PROJECT TITLE
PUJA PRIME II
PLOT NO. B-107 & B-138
VAISHALI ESTATE BLOCK-B SIRSI, JAIPUR

DRAWING TITLE
TYPICAL FLOOR
CEILING ELECTRICAL PLAN

ARCHITECTS :
VISTAAR ARCHITECTS & PLANNERS
Architects :: Interior Designers
B-2/12, Chitrkoot scheme,
main Gandhi Path, Opp mall of jaipur, Jaipur-21
Email-Vistaararchitects.web@gmail.com
PH.- 0141-4116461, 09001010366

PATH :-			
DRN.	DATE	REV.	NORTH
MANOJ KUMAWAT	11-6-2024		
SCALE	JOB NO.		
N.T.S			

SACHIN KUMAR
B. TECH. (CIVIL)

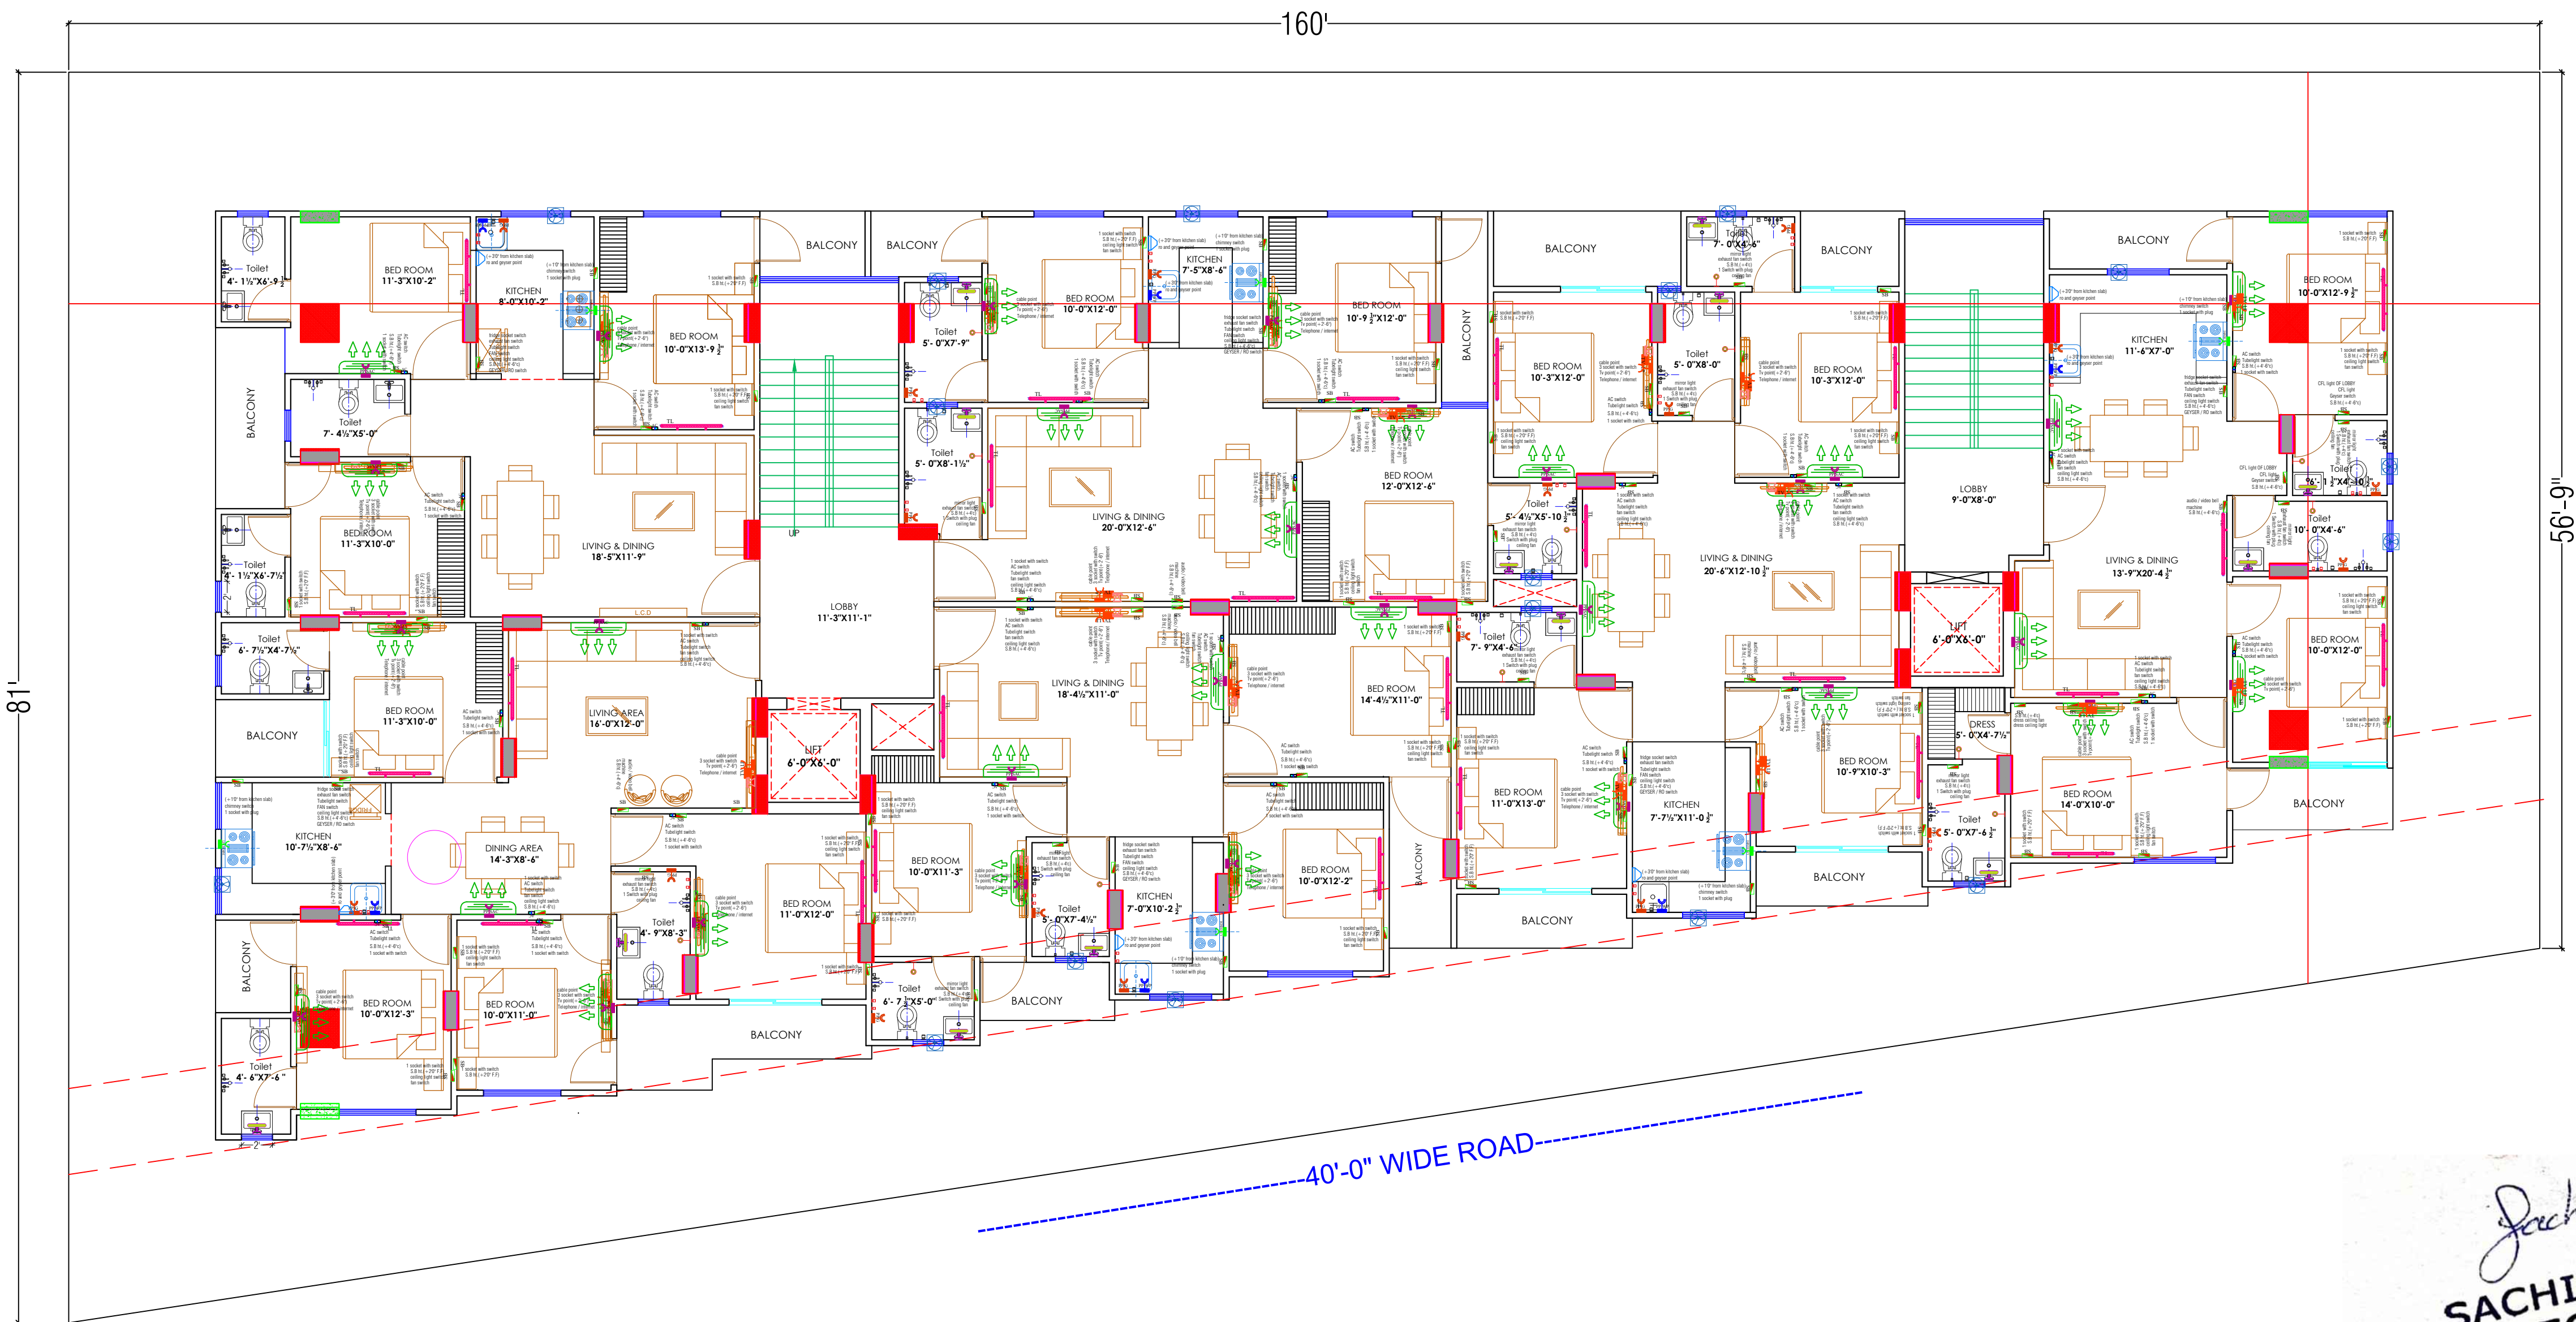

LEGENDS:				
Mounting Height	No.	I.D.	Symbol	Description
IN FLOOR				CONTROL WIRING
IN CONDUIT				CONTROL WIRING
IN CONDUIT				AC CONTROL WIRING
IN CONDUIT				OTHER CONTROL WIRING
IN CONDUIT				Buzzer control wiring
CEILING	FAN/6"			CEILING FAN 40"
CEILING	FAN/30"			CEILING FAN 30"
+90"	TL			LUXUR WALL TUBELIGHT
+90"	BULB			WALL BRACKETS AS DESIGN LIGHT
+90"	GL			WALL BRACKETS AS DESIGN FOR GARDEN LIGHT
+90"	GL			WALL BRACKETS AS DESIGN FOR GATE LIGHT
CEILING	CFL			CFL CEILING LIGHT
+21"	FL			FOOT LIGHT
+48"	SB			SWITCH BOARD
+70"	ML			1 X 11 W CFL MIRROR LIGHT
VENTILATOR 10"	CR			CEILING ROSE
VENTILATOR 10"	EXF			9" DIA FRESH AIR FAN
+34"	TEL			TELEPHONE POINT
+27"	TP			TV COAXIAL POINT
+27"	LP TV			1/2" A PLUG POINT FOR TV
+72"	LP CH			1/2" A PLUG POINT FOR CHIMNEY
+102"	SAC			1/2" A PLUG POINT FOR SPLIT AC
+102"	PP-SAC			1/2" A PLUG POINT FOR SPLIT AC
+42"	PP-MIX			1/2" A PLUG POINT FOR MIXER
+78"	PP-G			1/2" A PLUG POINT FOR GEYSER
+54"	PP-F			1/2" A PLUG POINT FOR FRIDGE
+78"	PP-WP			1/2" A PLUG POINT FOR WATER PURIFIER
+48"	PP-WM			1/2" A PLUG POINT FOR WASHING MACHINE
+42"	BP			BELL PUSH SWITCH
+90"	BZ			Buzzer POINT
+48"	AC			AC STARTER
+40"	MDR DB			MDR DISTRIBUTION BOARD

WARNING
1. This drawing is the sole copyright of Architects **VISTAAR** and should be used for the purpose expressly issued.

GENERAL NOTES
1. All dimensions are in feet and inches.
2. Do not scale this drawing follow written dimensions only.
3. This drawing should be read in conjunction with other architectural and structural drawings.
4. Any discrepancy in the drawing should be immediately brought to the notice of architect.

PROJECT TITLE
PUJA PRIME II
PLOT NO. B-107 & B-138
VAISHALI ESTATE BLOCK-B SIRSI,JAIPUR

DRAWING TITLE
TYPICAL FLOOR
WALL ELCTRICAL PLAN

ARCHITECTS :
VISTAAR ARCHITECTS & PLANNERS
Architects :: Interior Designers
B-2/12, Chitrkoot scheme,
main Gandhi Path,Opp mall of jaipur,Jaipur-21
Email-Vistaararchitects.web@gmail.com
PH.- 0141-4116461,09001010366

PATH :-			
DRN.	DATE	REV.	NORTH
MANOJ KUMAWAT	11-6-2024		
SCALE	JOB NO.		
N.T.S			

SACHIN KUMAR
B. TECH. (CIVIL)