


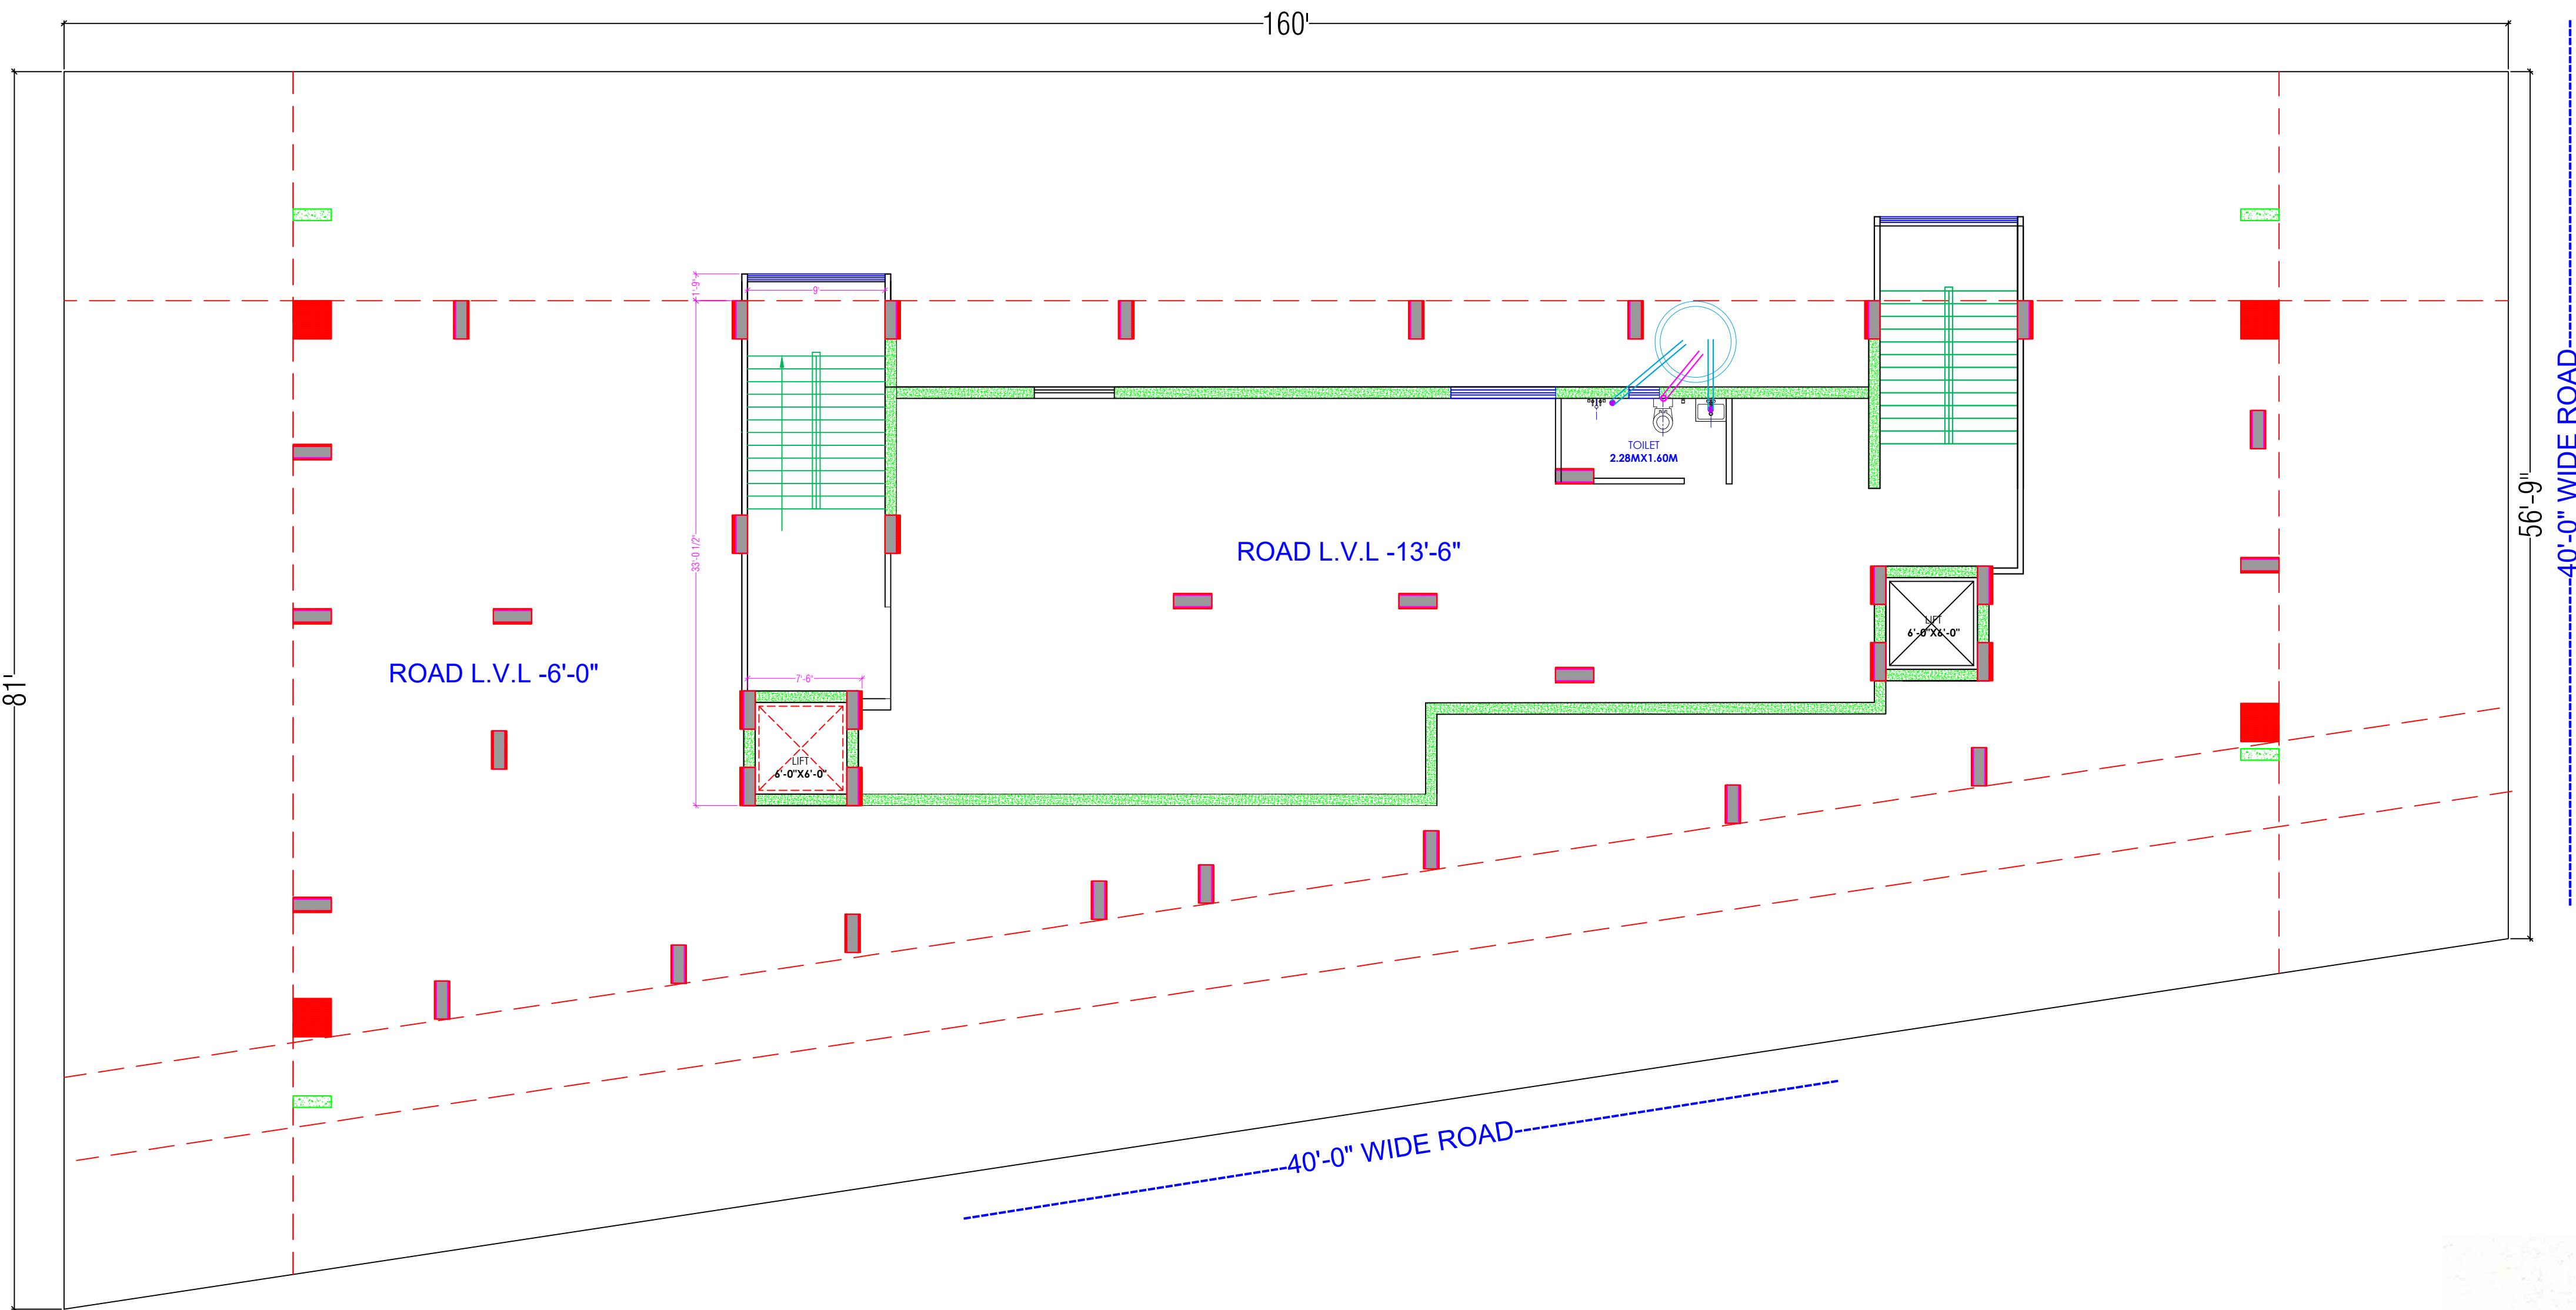

LEGENDS		
S.NO.	SYMBOL	DESCRIPTION
1.		SDR-11 Fresh Water Pipe
2.		SDR-11 Solar Water Pipe
3.		Waste Water Pipe (W.P.)
4.		Soil Pipe (S.P.)
5.		Rain Water Pipe (R.W.P.)
6.		Butter Fly Valve(B.F.V.)
7.		Geyser
8.		RO
9.		Single Lever Diverter
10.		Concealed Valve
11.		Angle Valve
12.		Nahani Trap
13.		P-Trap
14.		Tap
15.		Floor Drain (F.D.)
16.		Plain Tee (P-tee)
17.		Gully Trap (G.T.)
18.		

WARNING

1. This drawing is the sole copyright of Architects **VISTAAR** and should be used for the purpose expressly issued.

GENERAL NOTES

1. All dimensions are in feets and inches.
2. Do not scale this drawing follow written dimensions only.
3. This drawing should be read in conjunction with other architectural and structural drawings.
4. Any discrepancy in the drawing should be immediatly brought to the notice of architect.

PROJECT TITLE

PUJA PRIME II
PLOT NO. B-107 & B-138
VAISHALI ESTATE BLOCK-B SIRSI,JAIPUR

DRAWING TITLE

**BASEMENT FLOOR
DRAINAGE PLAN**


ARCHITECTS :

VISTAAR ARCHITECTS & PLANNERS

Architects :: Interior Designers
B-2/12, Chitrkoot scheme,
main Gandhi Path,Opp mall of jaipur,Jaipur-21
Email-Vistaararchitects.web@gmail.com
PH.- 0141-4116461,09001010366

PATH :-		REV.	NORTH
DRN.	DATE		
MANOJ KUMAWAT	12-6-2024		
SCALE	JOB NO.		
N.T.S			

Sachin
SACHIN KUMAR
B. TECH. (CIVIL)

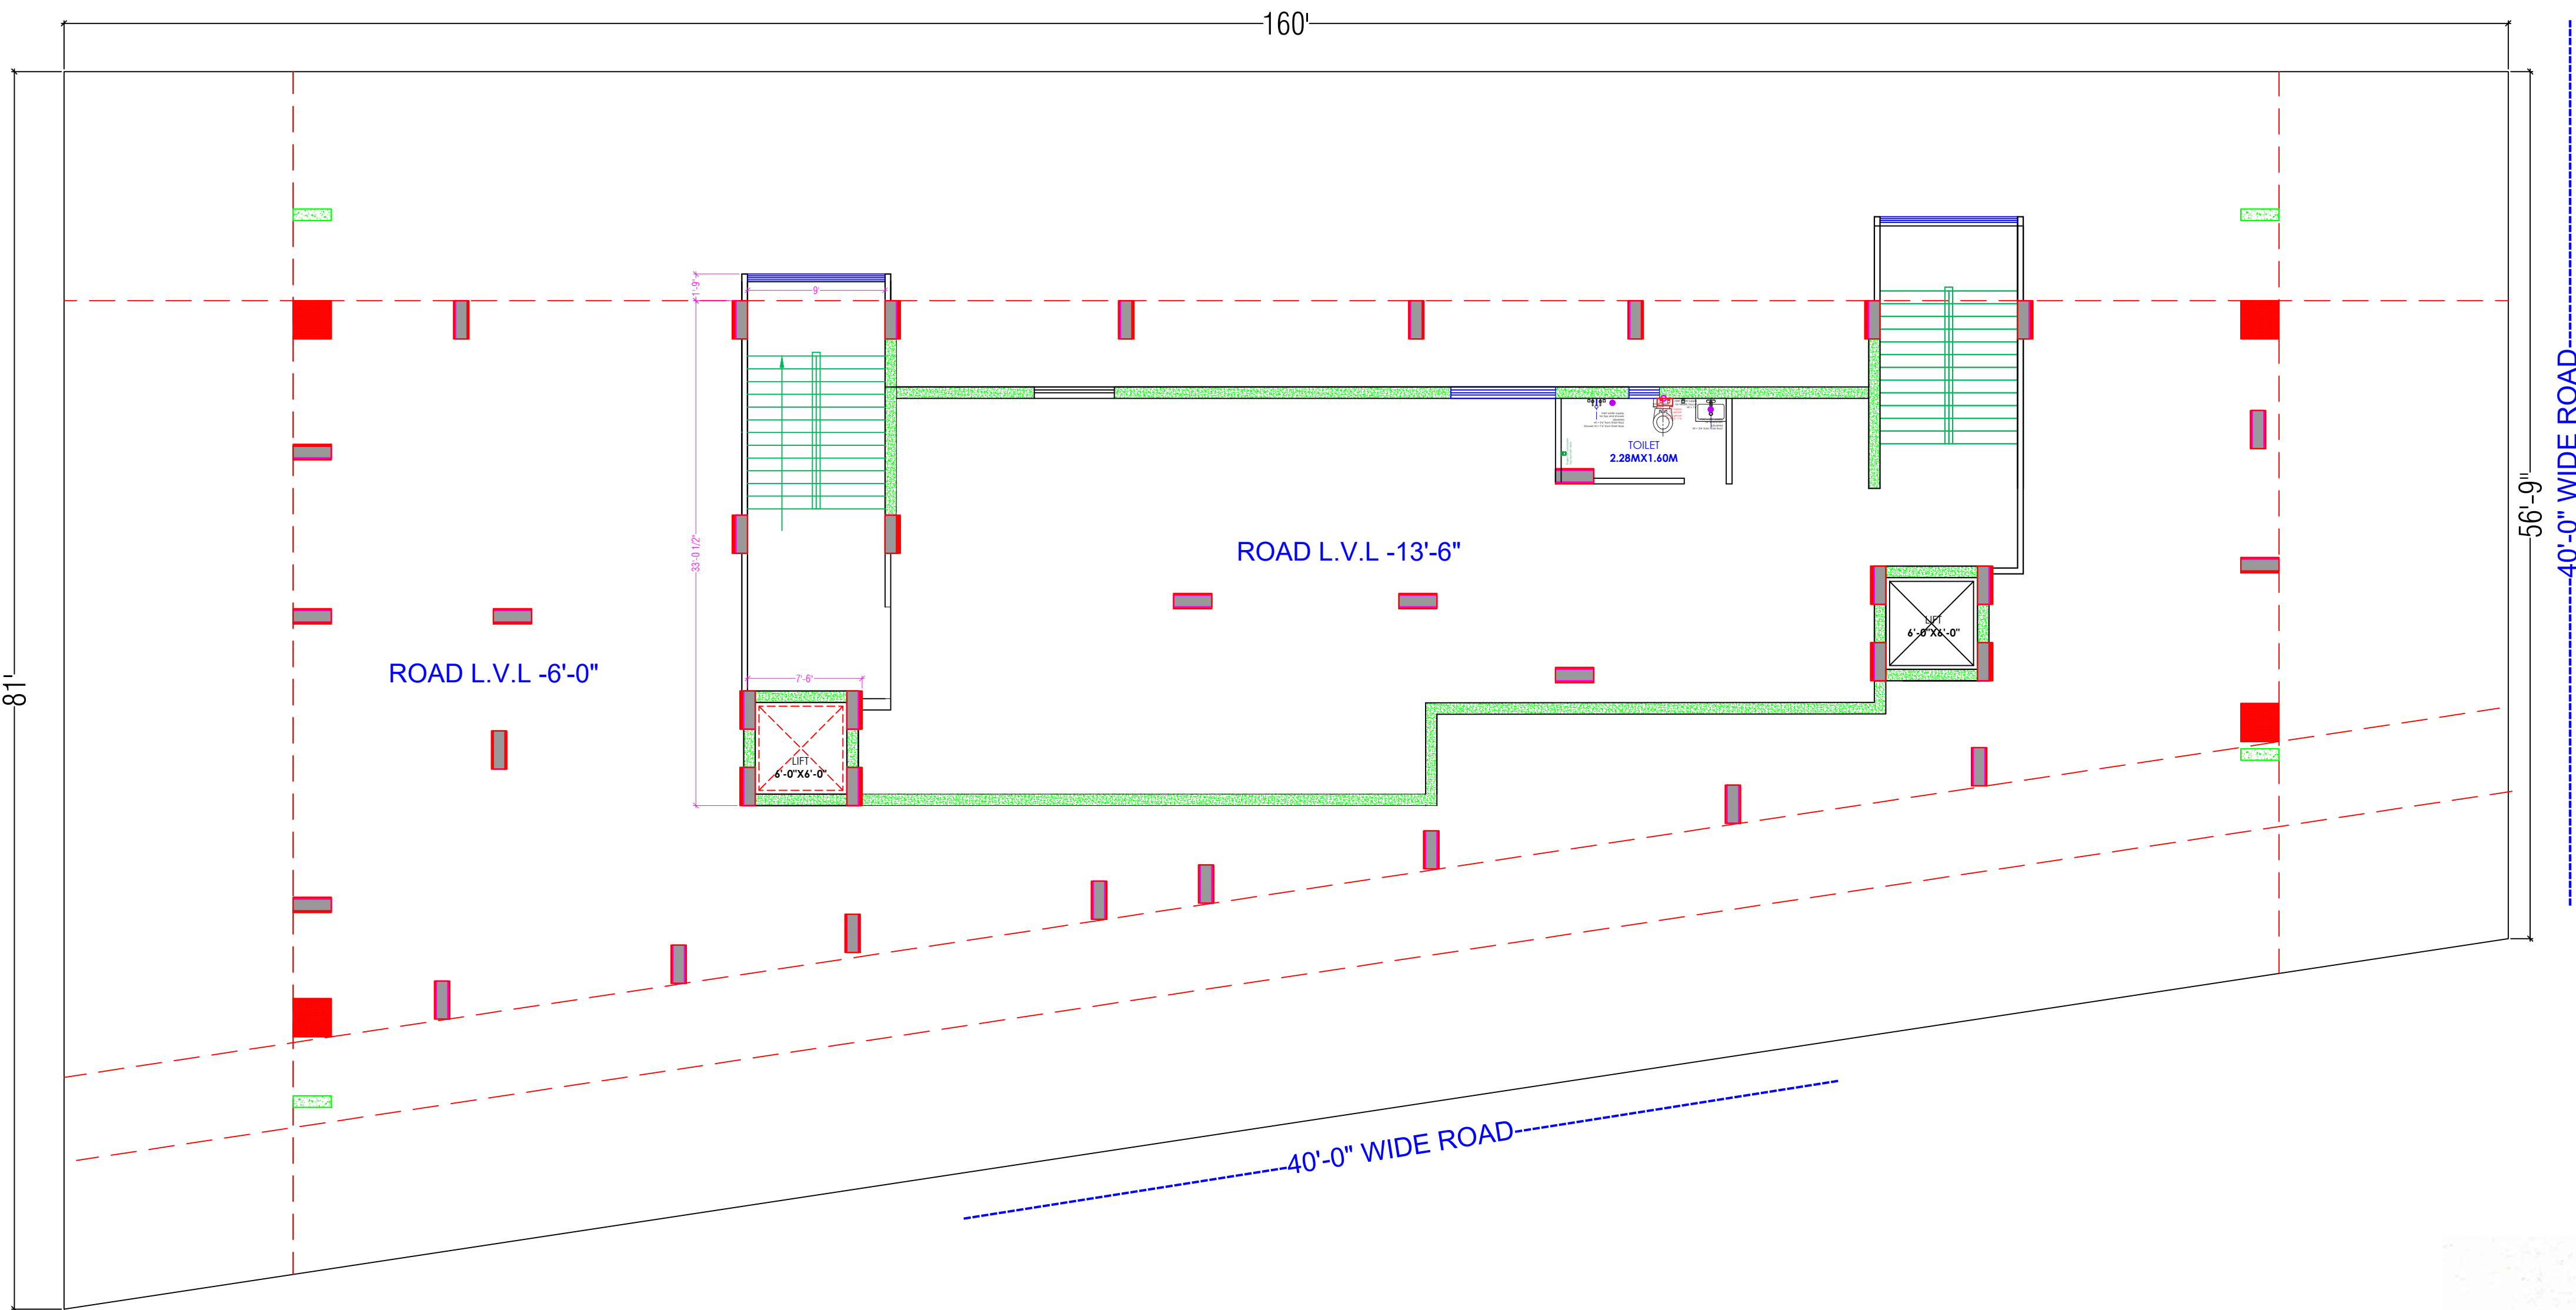

LEGENDS		
S.NO.	SYMBOL	DESCRIPTION
1.		SDR-11 Fresh Water Pipe
2.		SDR-11 Solar Water Pipe
3.		Waste Water Pipe (W.P.)
4.		Soil Pipe (S.P.)
5.		Rain Water Pipe (R.W.P.)
6.		Butter Fly Valve(B.F.V.)
7.		Geyser
8.		RO
9.		Single Lever Diverter
10.		Concealed Valve
11.		Angle Valve
12.		Nahani Trap
13.		P-Trap
14.		Tap
15.		Floor Drain (F.D.)
16.		Plain Tee (P-tee)
17.		Gully Trap (G.T.)
18.		

WARNING

1. This drawing is the sole copyright of Architects **VISTAAR** and should be used for the purpose expressly issued.

GENERAL NOTES

1. All dimensions are in feets and inches.
2. Do not scale this drawing follow written dimensions only.
3. This drawing should be read in conjunction with other architectural and structural drawings.
4. Any disciprancy in the drawing should be immediatly brought to the notice of architect.

PROJECT TITLE

PUJA PRIME II
PLOT NO. B-107 & B-138
VAISHALI ESTATE BLOCK-B SIRSI,JAIPUR

DRAWING TITLE

**BASEMENT FLOOR
PLUMBING PLAN**


ARCHITECTS :

VISTAAR ARCHITECTS & PLANNERS

Architects :: Interior Designers
B-2/12, Chitrkoot scheme,
main Gandhi Path,Opp mall of jaipur,Jaipur-21
Email-Vistaararchitects.web@gmail.com
PH.- 0141-4116461,09001010366

PATH :-		REV.	NORTH
DRN.	DATE		
MANOJ KUMAWAT	12-6-2024		
SCALE	JOB NO.		
N.T.S			

Sachin
SACHIN KUMAR
B. TECH. (CIVIL)

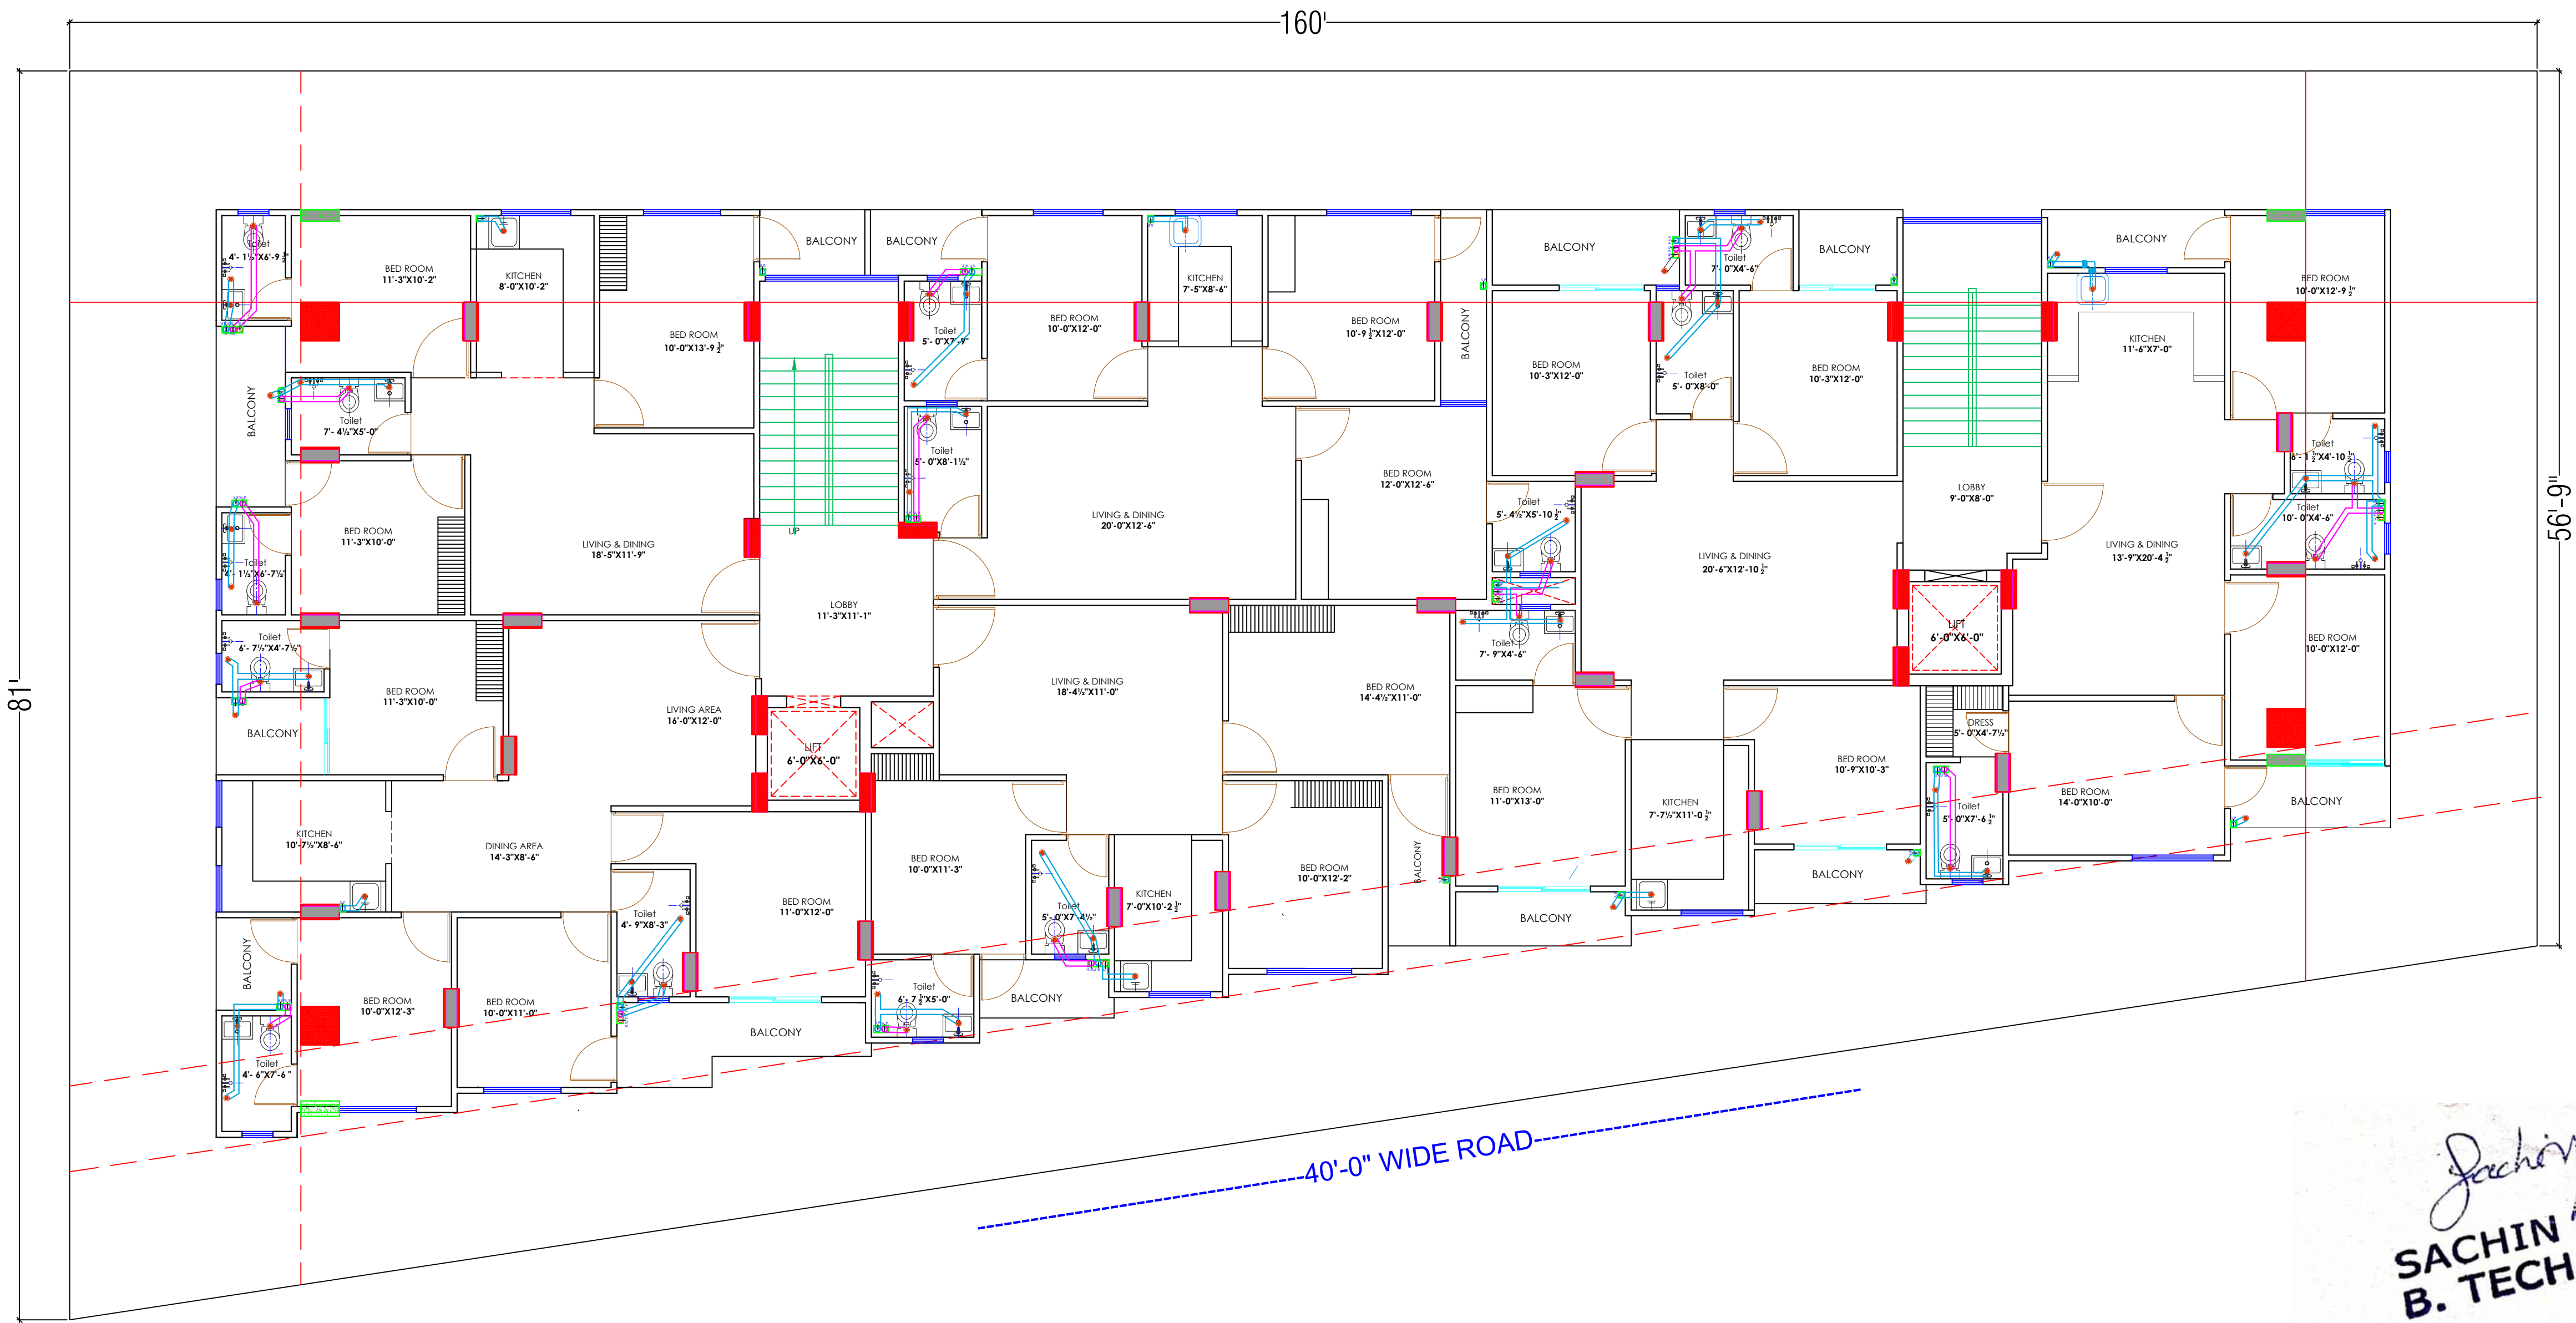

①	RAIN WATER PIPE	○	—
②	WEST WATER PIPE	○	—
③	SOILWATER PIPE	○	—

LEGENDS		
S.NO.	SYMBOL	DESCRIPTION
1.	—	SDR-11 Fresh Water Pipe
2.	—	SDR-11 Solar Water Pipe
3.	—	Waste Water Pipe (W.P.)
4.	—	Soil Pipe (S.P.)
5.	—	Rain Water Pipe (R.W.P.)
6.	⊗	Butter Fly Valve(B.F.V.)
7.	☺	Geyser
8.	☺	RO
9.	⊗	Single Lever Diverter
10.	⊗	Concealed Valve
11.	⊗	Angle Valve
12.	⊗	Nahani Trap
13.	⊗	P-Trap
14.	⊗	Tap
15.	⊗	Floor Drain (F.D.)
16.	⊗	Plain Tee (P-tee)
17.	⊗	Gully Trap (G.T.)
18.	⊗	

SACHIN KUMAR
B. TECH. (CIVIL)

WARNING
1. This drawing is the sole copyright of Architects **VISTAAR** and should be used for the purpose expressly issued.


GENERAL NOTES
1. All dimensions are in feet and inches.
2. Do not scale this drawing follow written dimensions only.
3. This drawing should be read in conjunction with other architectural and structural drawings.
4. Any discrepancy in the drawing should be immediately brought to the notice of architect.

PROJECT TITLE
PUJA PRIME II
PLOT NO. B-107 & B-138
VAISHALI ESTATE BLOCK-B SIRSI,JAIPUR

DRAWING TITLE
GROUND FLOOR DRAINAGE PLAN

ARCHITECTS :
VISTAAR ARCHITECTS & PLANNERS
Architects :: Interior Designers
B-2/12, Chitrkoot scheme,
main Gandhi Path,Opp mall of jaipur,Jaipur-21
Email-Vistaararchitects.web@gmail.com
PH.- 0141-4116461,09001010366

PATH :-			
DRN.	DATE	REV.	NORTH
MANOJ KUMAWAT	11-6-2024		
SCALE	JOB NO.		
N.T.S			

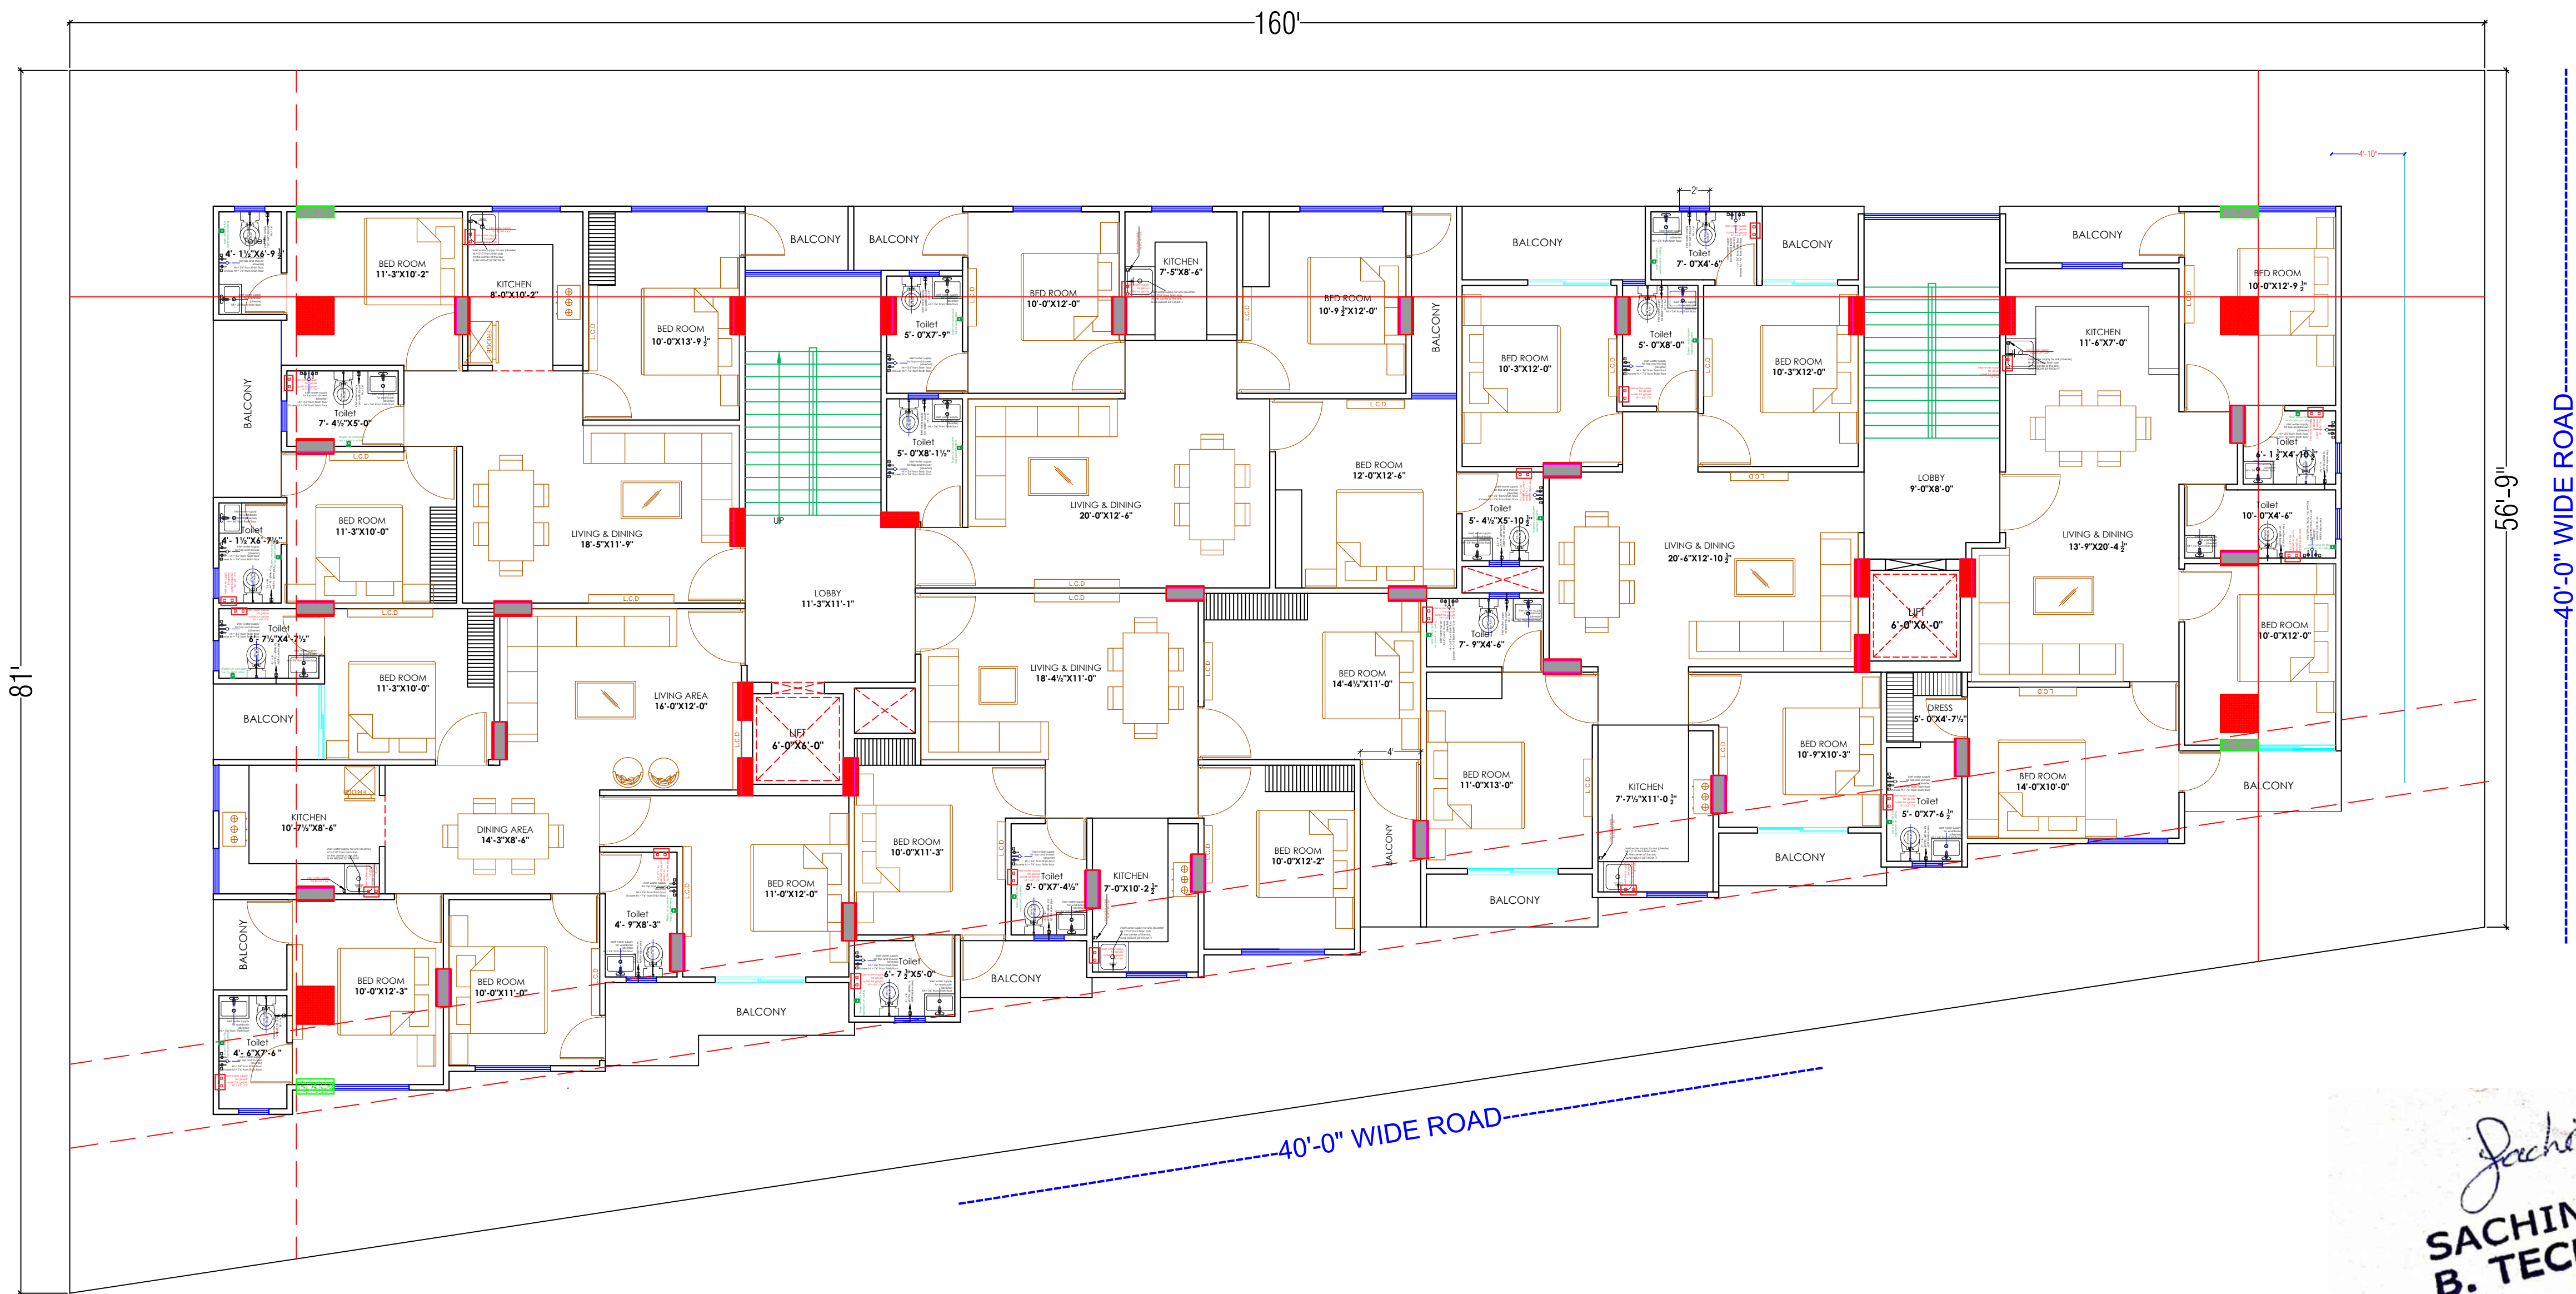

LEGENDS		
S.NO.	SYMBOL	DESCRIPTION
1.		SDR-11 Fresh Water Pipe
2.		SDR-11 Solar Water Pipe
3.		Waste Water Pipe (W.P.)
4.		Soil Pipe (S.P.)
5.		Rain Water Pipe (R.W.P.)
6.		Butter Fly Valve(B.F.V.)
7.		Geyser
8.		RO
9.		Single Lever Diverter
10.		Concealed Valve
11.		Angle Valve
12.		Nahani Trap
13.		P-Trap
14.		Tap
15.		Floor Drain (F.D.)
16.		Plain Tee (P-tee)
17.		Gully Trap (G.T.)
18.		

WARNING
1. This drawing is the sole copyright of Architects **VISTAAR** and should be used for the purpose expressly issued.

GENERAL NOTES
1. All dimensions are in feet and inches.
2. Do not scale this drawing follow written dimensions only.
3. This drawing should be read in conjunction with other architectural and structural drawings.
4. Any discrepancy in the drawing should be immediately brought to the notice of architect.

PROJECT TITLE
PUJA PRIME II
PLOT NO. B-107 & B-138
VAISHALI ESTATE BLOCK-B SIRSI,JAIPUR


DRAWING TITLE
GROUND FLOOR PLUMBING PLAN

ARCHITECTS :
VISTAAR ARCHITECTS & PLANNERS
Architects :: Interior Designers
B-2/12, Chitrkoot scheme,
main Gandhi Path,Opp mall of jaipur,Jaipur-21
Email-Vistaararchitects.web@gmail.com
PH.- 0141-4116461,09001010366

PATH :-			
DRN.	DATE	REV.	NORTH
MANOJ KUMAWAT	11-6-2024		
SCALE	JOB NO.		
N.T.S			

Sachin
SACHIN KUMAR
B. TECH. (CIVIL)

ROAD 40'-0" WIDE

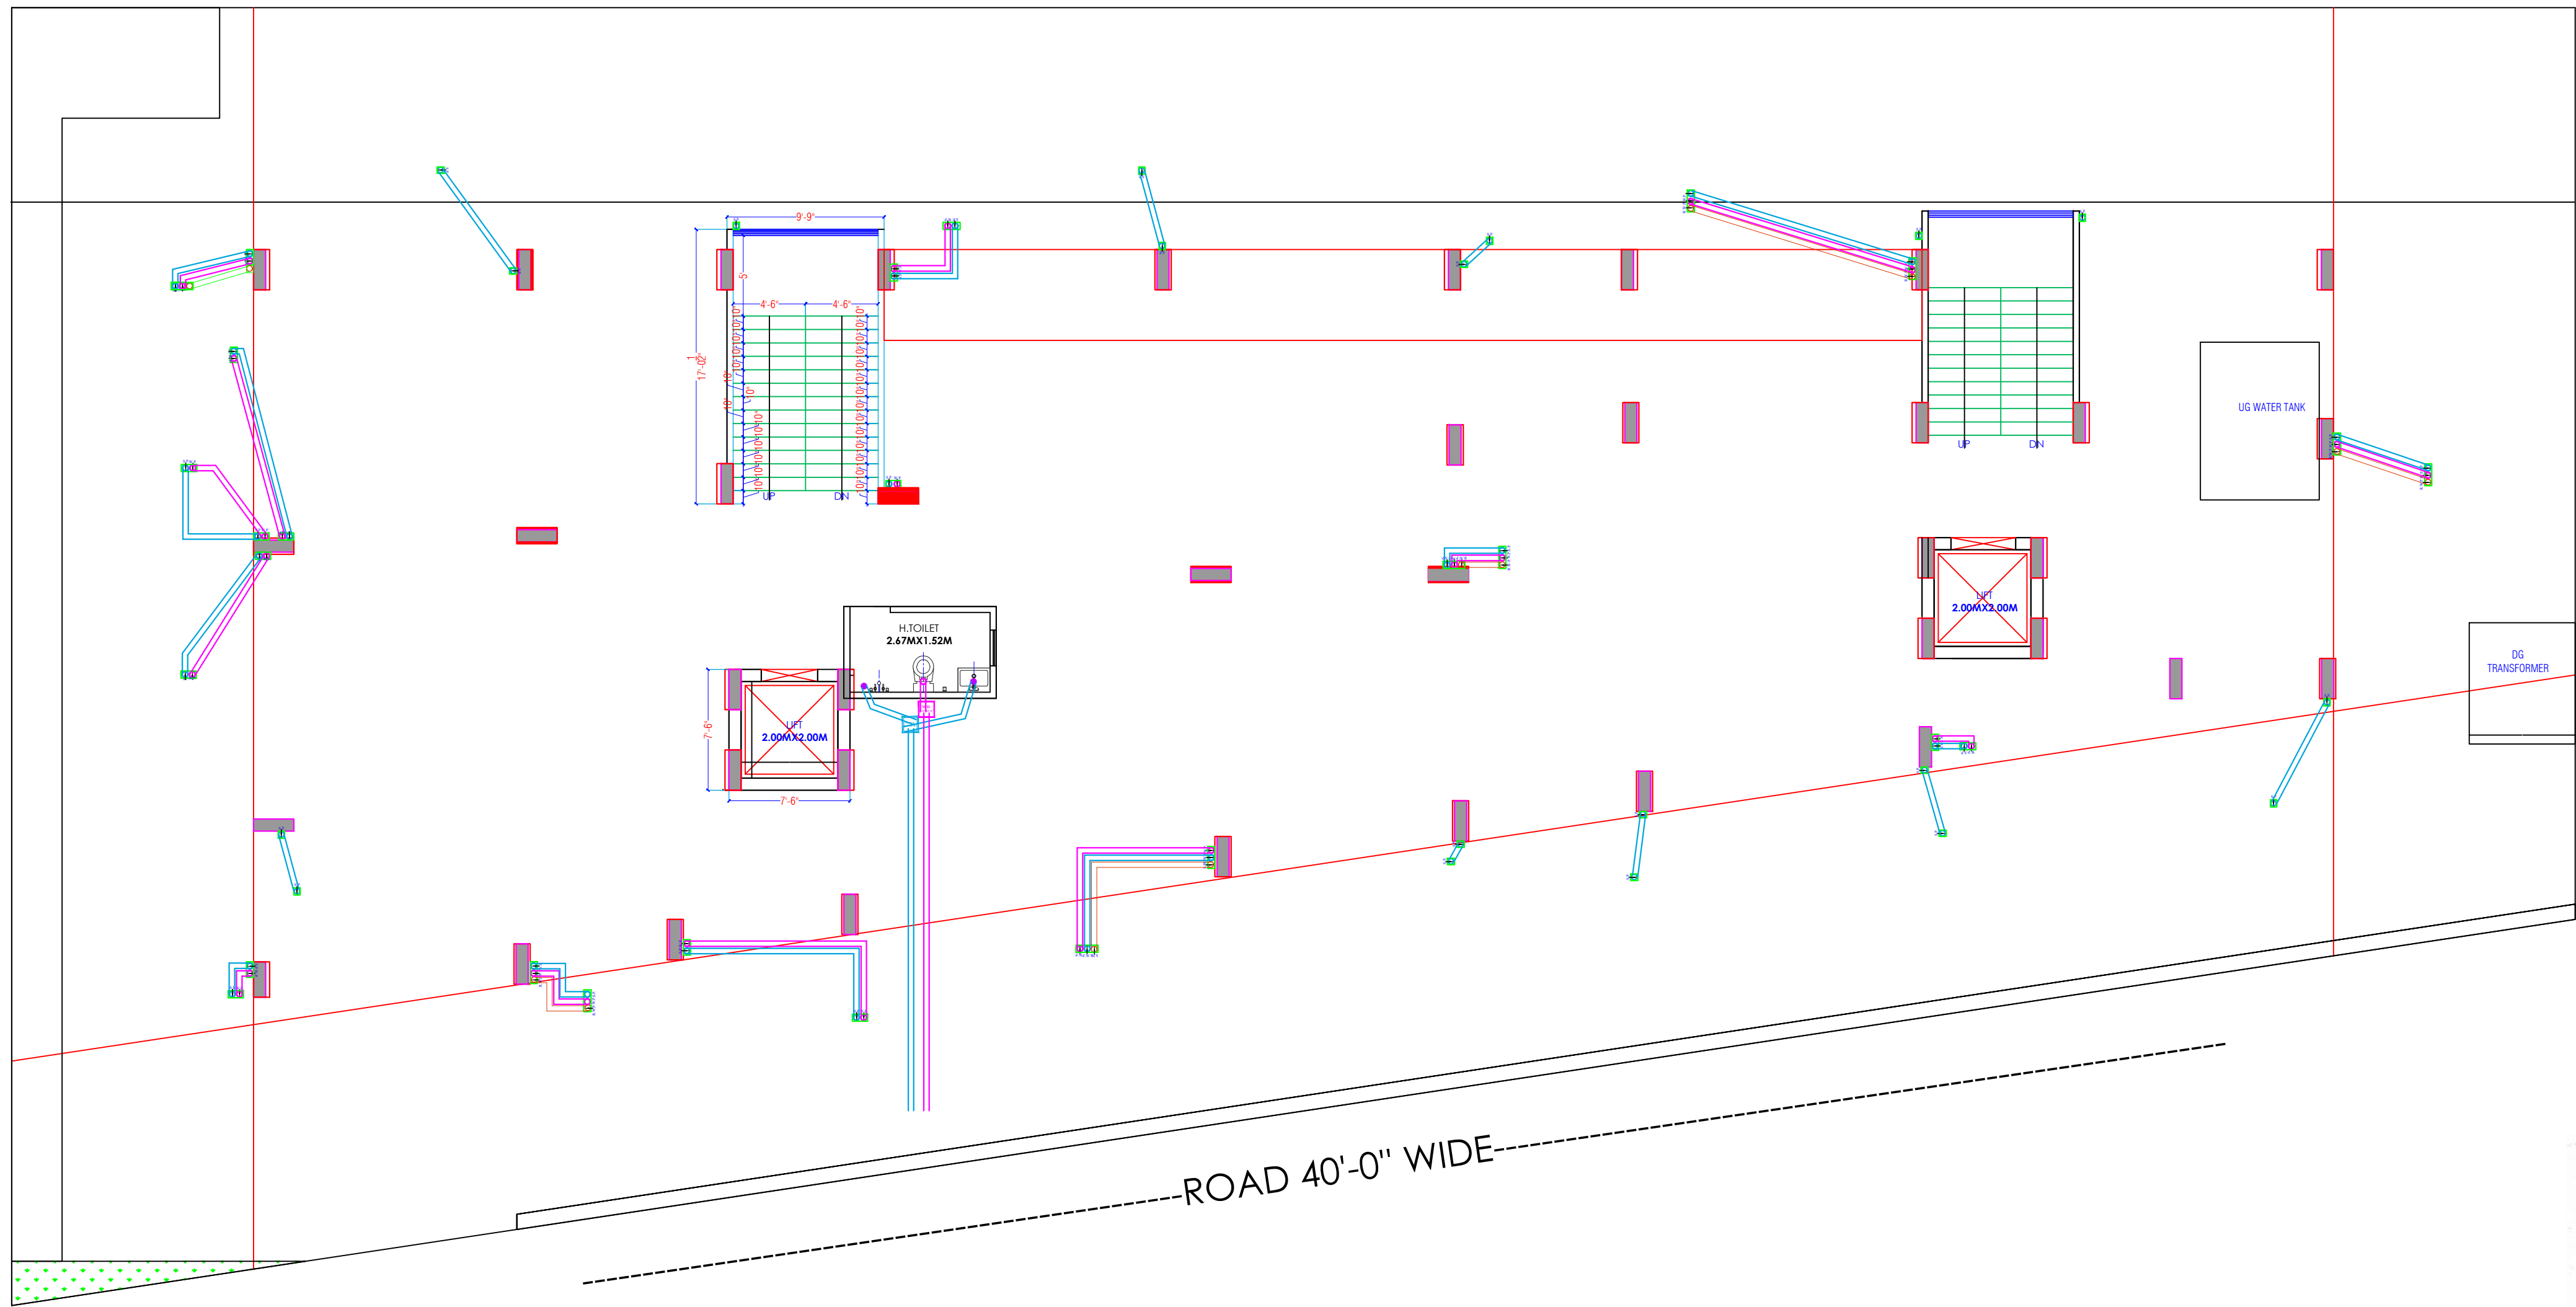

ROAD 40'-0" WIDE

EXIT ENTRY

ENTRY

ENTRY

ROAD 40'-0" WIDE

LEGENDS		
S.NO.	SYMBOL	DESCRIPTION
1.		SDR-11 Fresh Water Pipe
2.		SDR-11 Solar Water Pipe
3.		Waste Water Pipe (W.P.)
4.		Soil Pipe (S.P.)
5.		Rain Water Pipe (R.W.P.)
6.		Butter Fly Valve (B.F.V.)
7.		Geyser
8.		RO
9.		Single Lever Diverter
10.		Concealed Valve
11.		Angle Valve
12.		Nahani Trap
13.		P-Trap
14.		Tap
15.		Floor Drain (F.D.)
16.		Plain Tee (P-tee)
17.		Gully Trap (G.T.)
18.		

	RAIN WATER PIPE	
	WEST WATER PIPE	
	SOIL WATER PIPE	

WARNING

1. This drawing is the sole copyright of Architects **VISTAAR** and should be used for the purpose expressly issued.

GENERAL NOTES

1. All dimensions are in feet and inches.
2. Do not scale this drawing follow written dimensions only.
3. This drawing should be read in conjunction with other architectural and structural drawings.
4. Any discrepancy in the drawing should be immediately brought to the notice of architect.

PROJECT TITLE

PUJA PRIME II
PLOT NO. B-107 & B-138
VAISHALI ESTATE BLOCK-B SIRSI,JAIPUR

DRAWING TITLE

STILT FLOOR DRAINAGE PLAN


ARCHITECTS :

VISTAAR ARCHITECTS & PLANNERS
Architects :: Interior Designers
B-2/12, Chitrkoot scheme,
main Gandhi Path,Opp mall of jaipur,Jaipur-21
Email-Vistaararchitects.web@gmail.com
PH.- 0141-4116461,09001010366

PATH :-

DRN.	DATE	REV.	NORTH
MANOJ KUMAWAT	12-6-2024		
SCALE	JOB NO.		
N.T.S			

SACHIN KUMAR
B. TECH. (CIVIL)

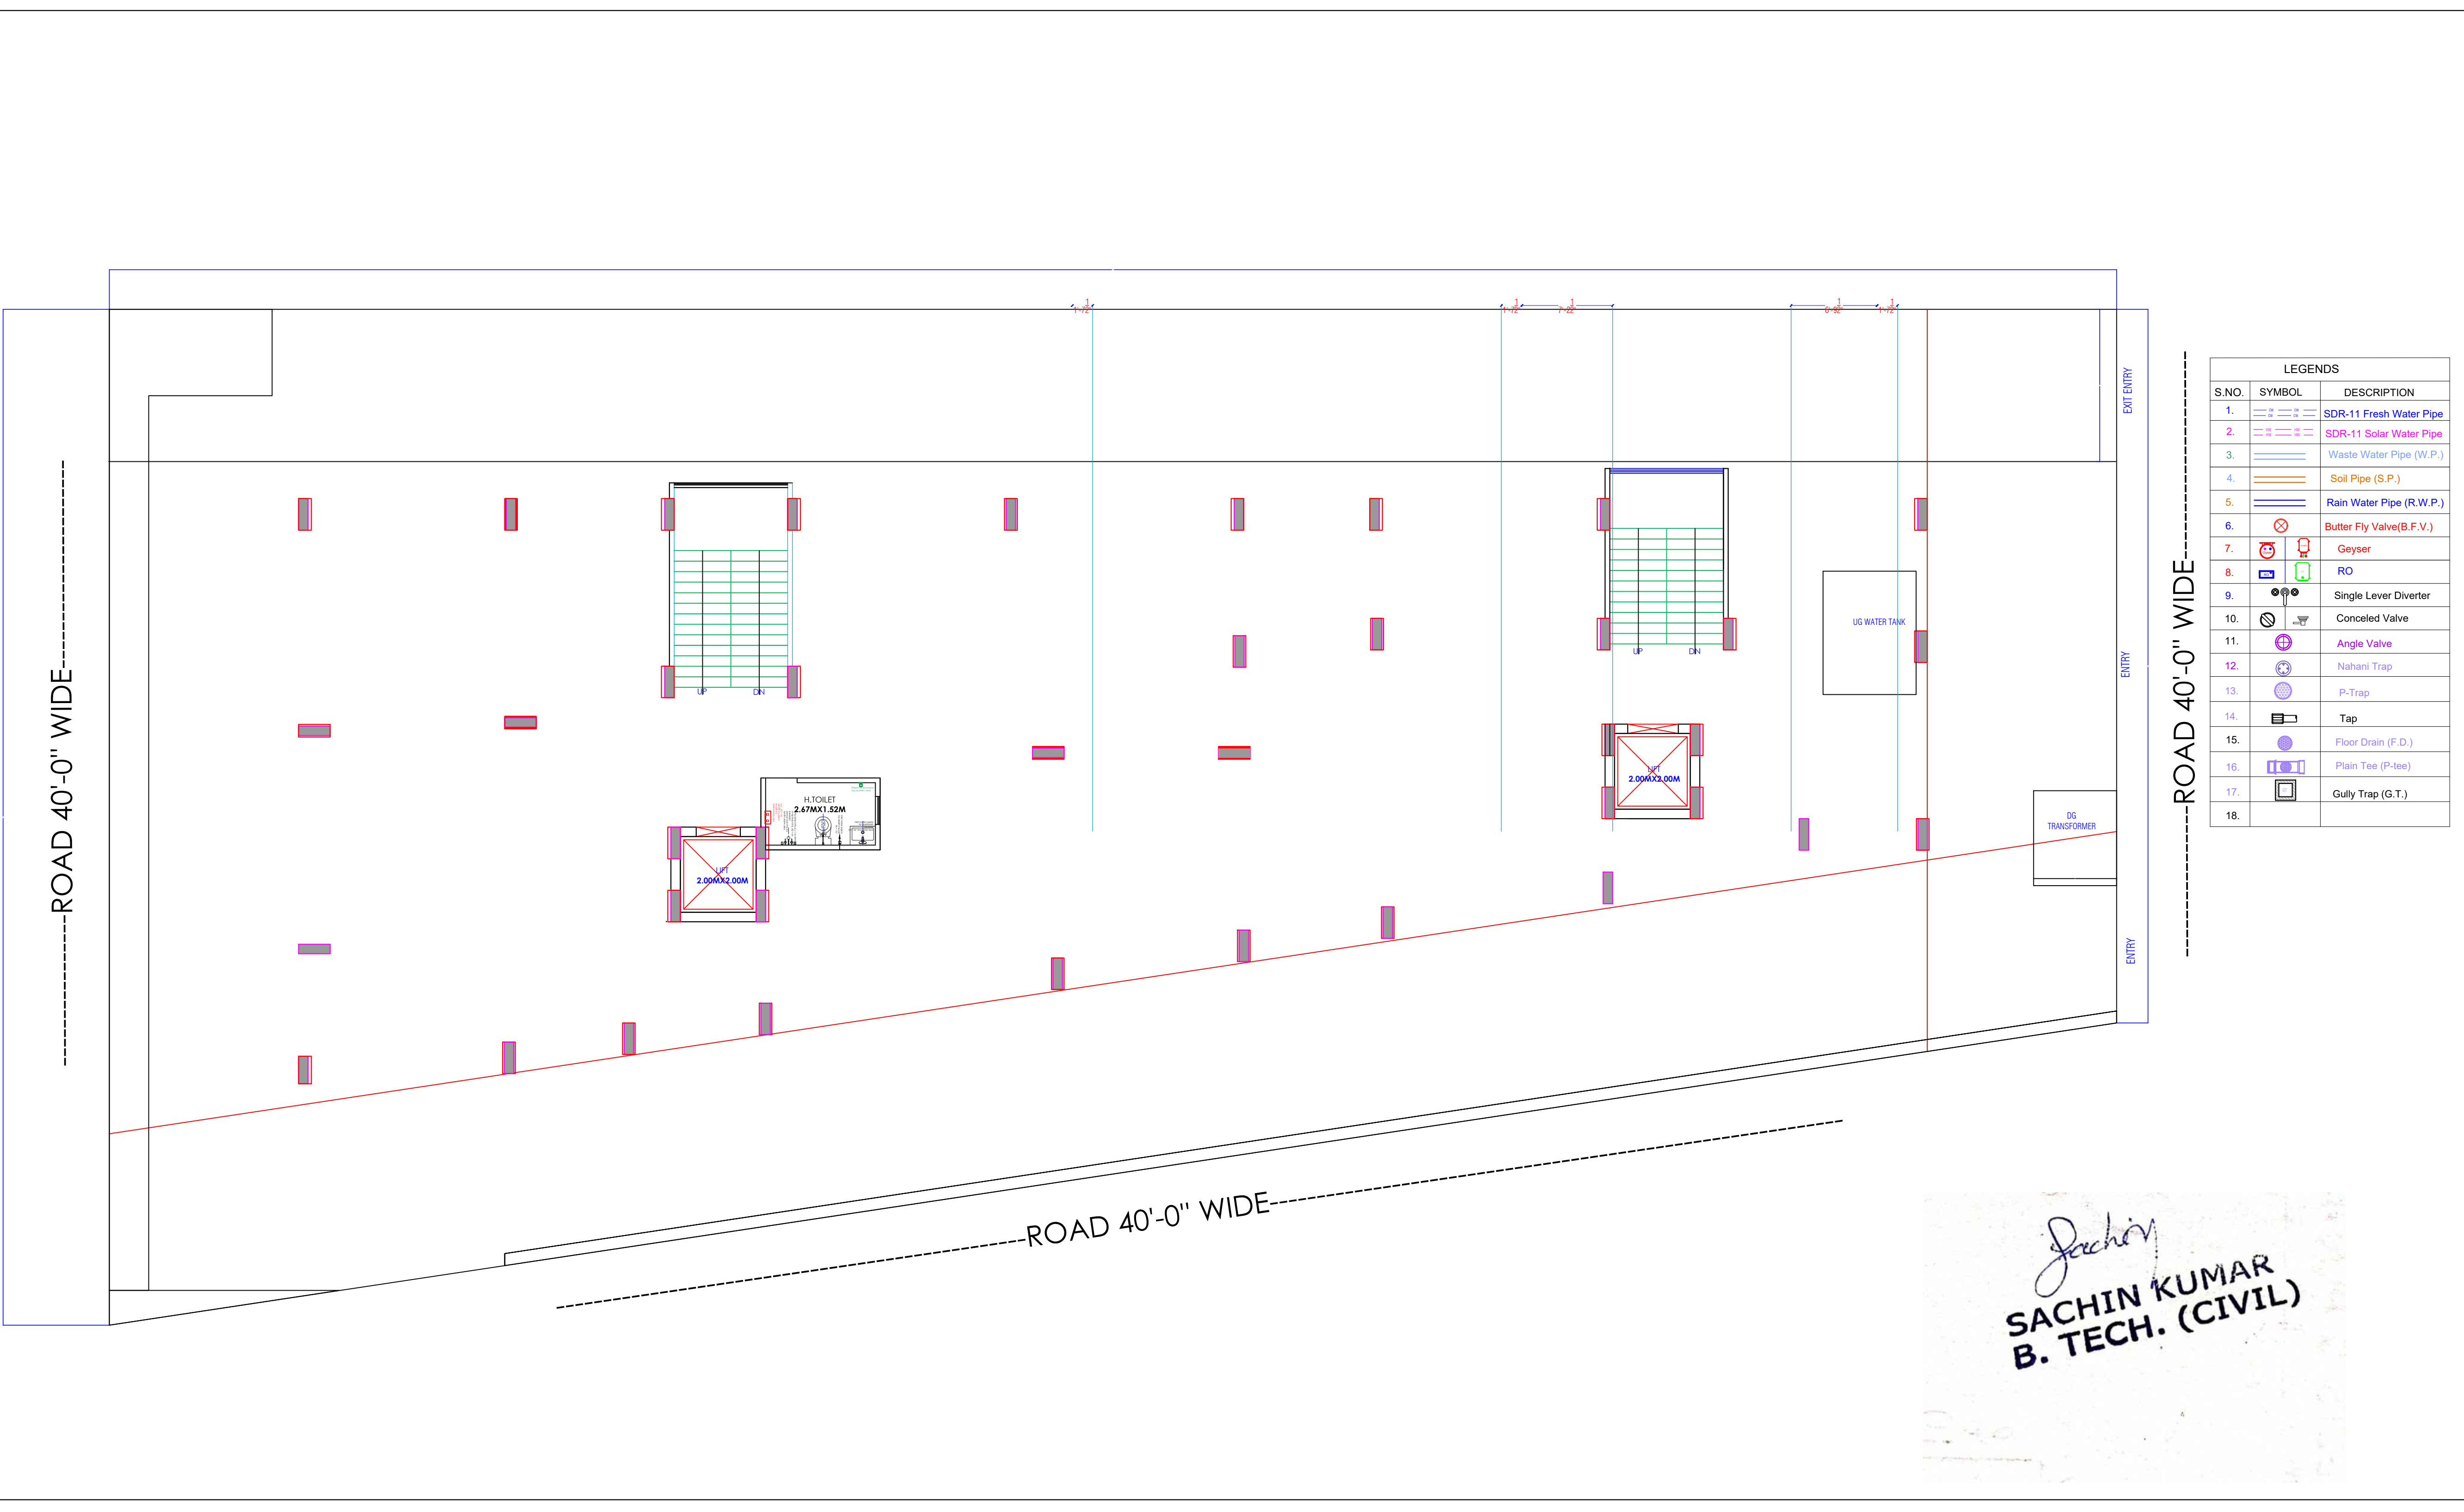

LEGENDS		
S.NO.	SYMBOL	DESCRIPTION
1.		SDR-11 Fresh Water Pipe
2.		SDR-11 Solar Water Pipe
3.		Waste Water Pipe (W.P.)
4.		Soil Pipe (S.P.)
5.		Rain Water Pipe (R.W.P.)
6.		Butter Fly Valve(B.F.V.)
7.		Geyser
8.		RO
9.		Single Lever Diverter
10.		Concealed Valve
11.		Angle Valve
12.		Nahani Trap
13.		P-Trap
14.		Tap
15.		Floor Drain (F.D.)
16.		Plain Tee (P-tee)
17.		Gully Trap (G.T.)
18.		

WARNING
1. This drawing is the sole copyright of Architects **VISTAAR** and should be used for the purpose expressly issued.

GENERAL NOTES
1. All dimensions are in feet and inches.
2. Do not scale this drawing follow written dimensions only.
3. This drawing should be read in conjunction with other architectural and structural drawings.
4. Any discrepancy in the drawing should be immediately brought to the notice of architect.


PROJECT TITLE
PUJA PRIME II
PLOT NO. B-107 & B-138
VAISHALI ESTATE BLOCK-B SIRSI,JAIPUR

DRAWING TITLE
STILT FLOOR PLUMBING PLAN

ARCHITECTS :
VISTAAR ARCHITECTS & PLANNERS
Architects :: Interior Designers
B-2/12, Chitrkoot scheme,
main Gandhi Path,Opp mall of jaipur,Jaipur-21
Email-Vistaararchitects.web@gmail.com
PH.- 0141-4116461,09001010366

PATH :-	DATE	REV.	NORTH
DRN.			
MANOJ KUMAWAT	12-6-2024		
SCALE	JOB NO.		
N.T.S			

Sachin
SACHIN KUMAR
B. TECH. (CIVIL)

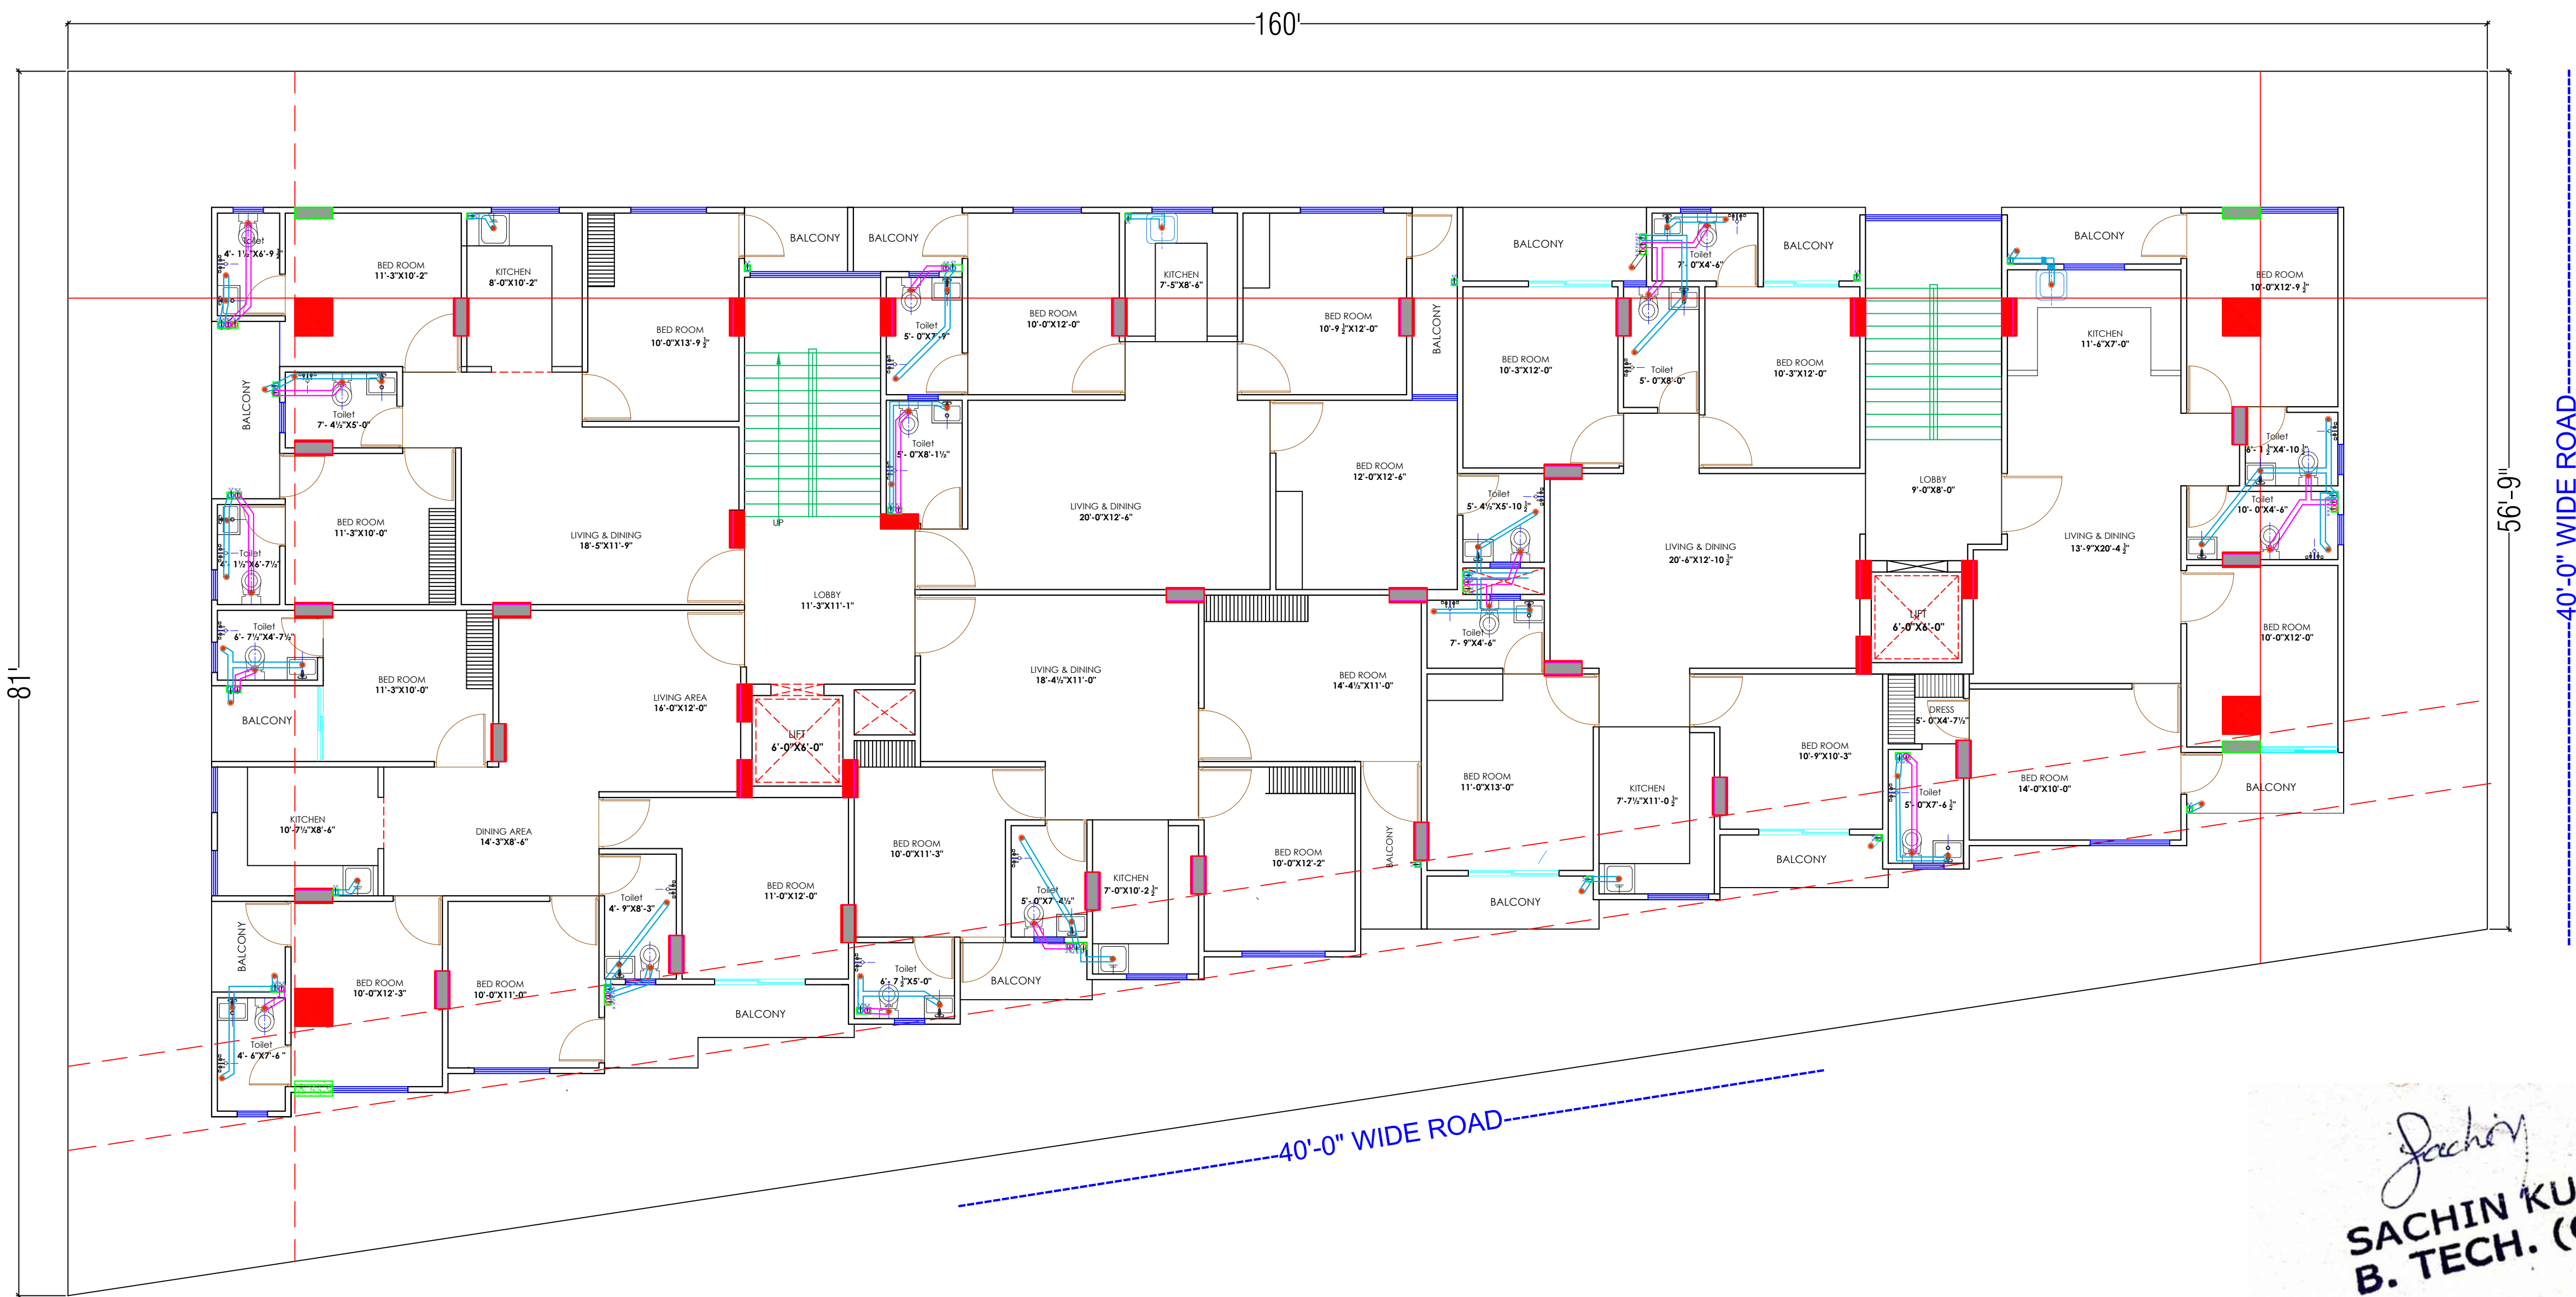

①	RAIN WATER PIPE	
②	WEST WATER PIPE	
③	SOIL WATER PIPE	

LEGENDS		
S.NO.	SYMBOL	DESCRIPTION
1.		SDR-11 Fresh Water Pipe
2.		SDR-11 Solar Water Pipe
3.		Waste Water Pipe (W.P.)
4.		Soil Pipe (S.P.)
5.		Rain Water Pipe (R.W.P.)
6.		Butter Fly Valve(B.F.V.)
7.		Geyser
8.		RO
9.		Single Lever Diverter
10.		Concealed Valve
11.		Angle Valve
12.		Nahani Trap
13.		P-Trap
14.		Tap
15.		Floor Drain (F.D.)
16.		Plain Tee (P-tee)
17.		Gully Trap (G.T.)
18.		

Sachin
SACHIN KUMAR
B. TECH. (CIVIL)

WARNING
1. This drawing is the sole copyright of Architects **VISTAAR** and should be used for the purpose expressly issued.


GENERAL NOTES
1. All dimensions are in feet and inches.
2. Do not scale this drawing follow written dimensions only.
3. This drawing should be read in conjunction with other architectural and structural drawings.
4. Any discrepancy in the drawing should be immediately brought to the notice of architect.

PROJECT TITLE
PUJA PRIME II
PLOT NO. B-107 & B-138
VAISHALI ESTATE BLOCK-B SIRSI,JAIPUR

DRAWING TITLE
TYPICAL FLOOR DRAINAGE PLAN

ARCHITECTS :
VISTAAR ARCHITECTS & PLANNERS
Architects :: Interior Designers
B-2/12, Chitrkoot scheme,
main Gandhi Path,Opp mall of jaipur,Jaipur-21
Email-Vistaararchitects.web@gmail.com
PH.- 0141-4116461,09001010366

PATH :-			
DRN.	DATE	REV.	NORTH
MANOJ KUMAWAT	11-6-2024		
SCALE	JOB NO.		
N.T.S			

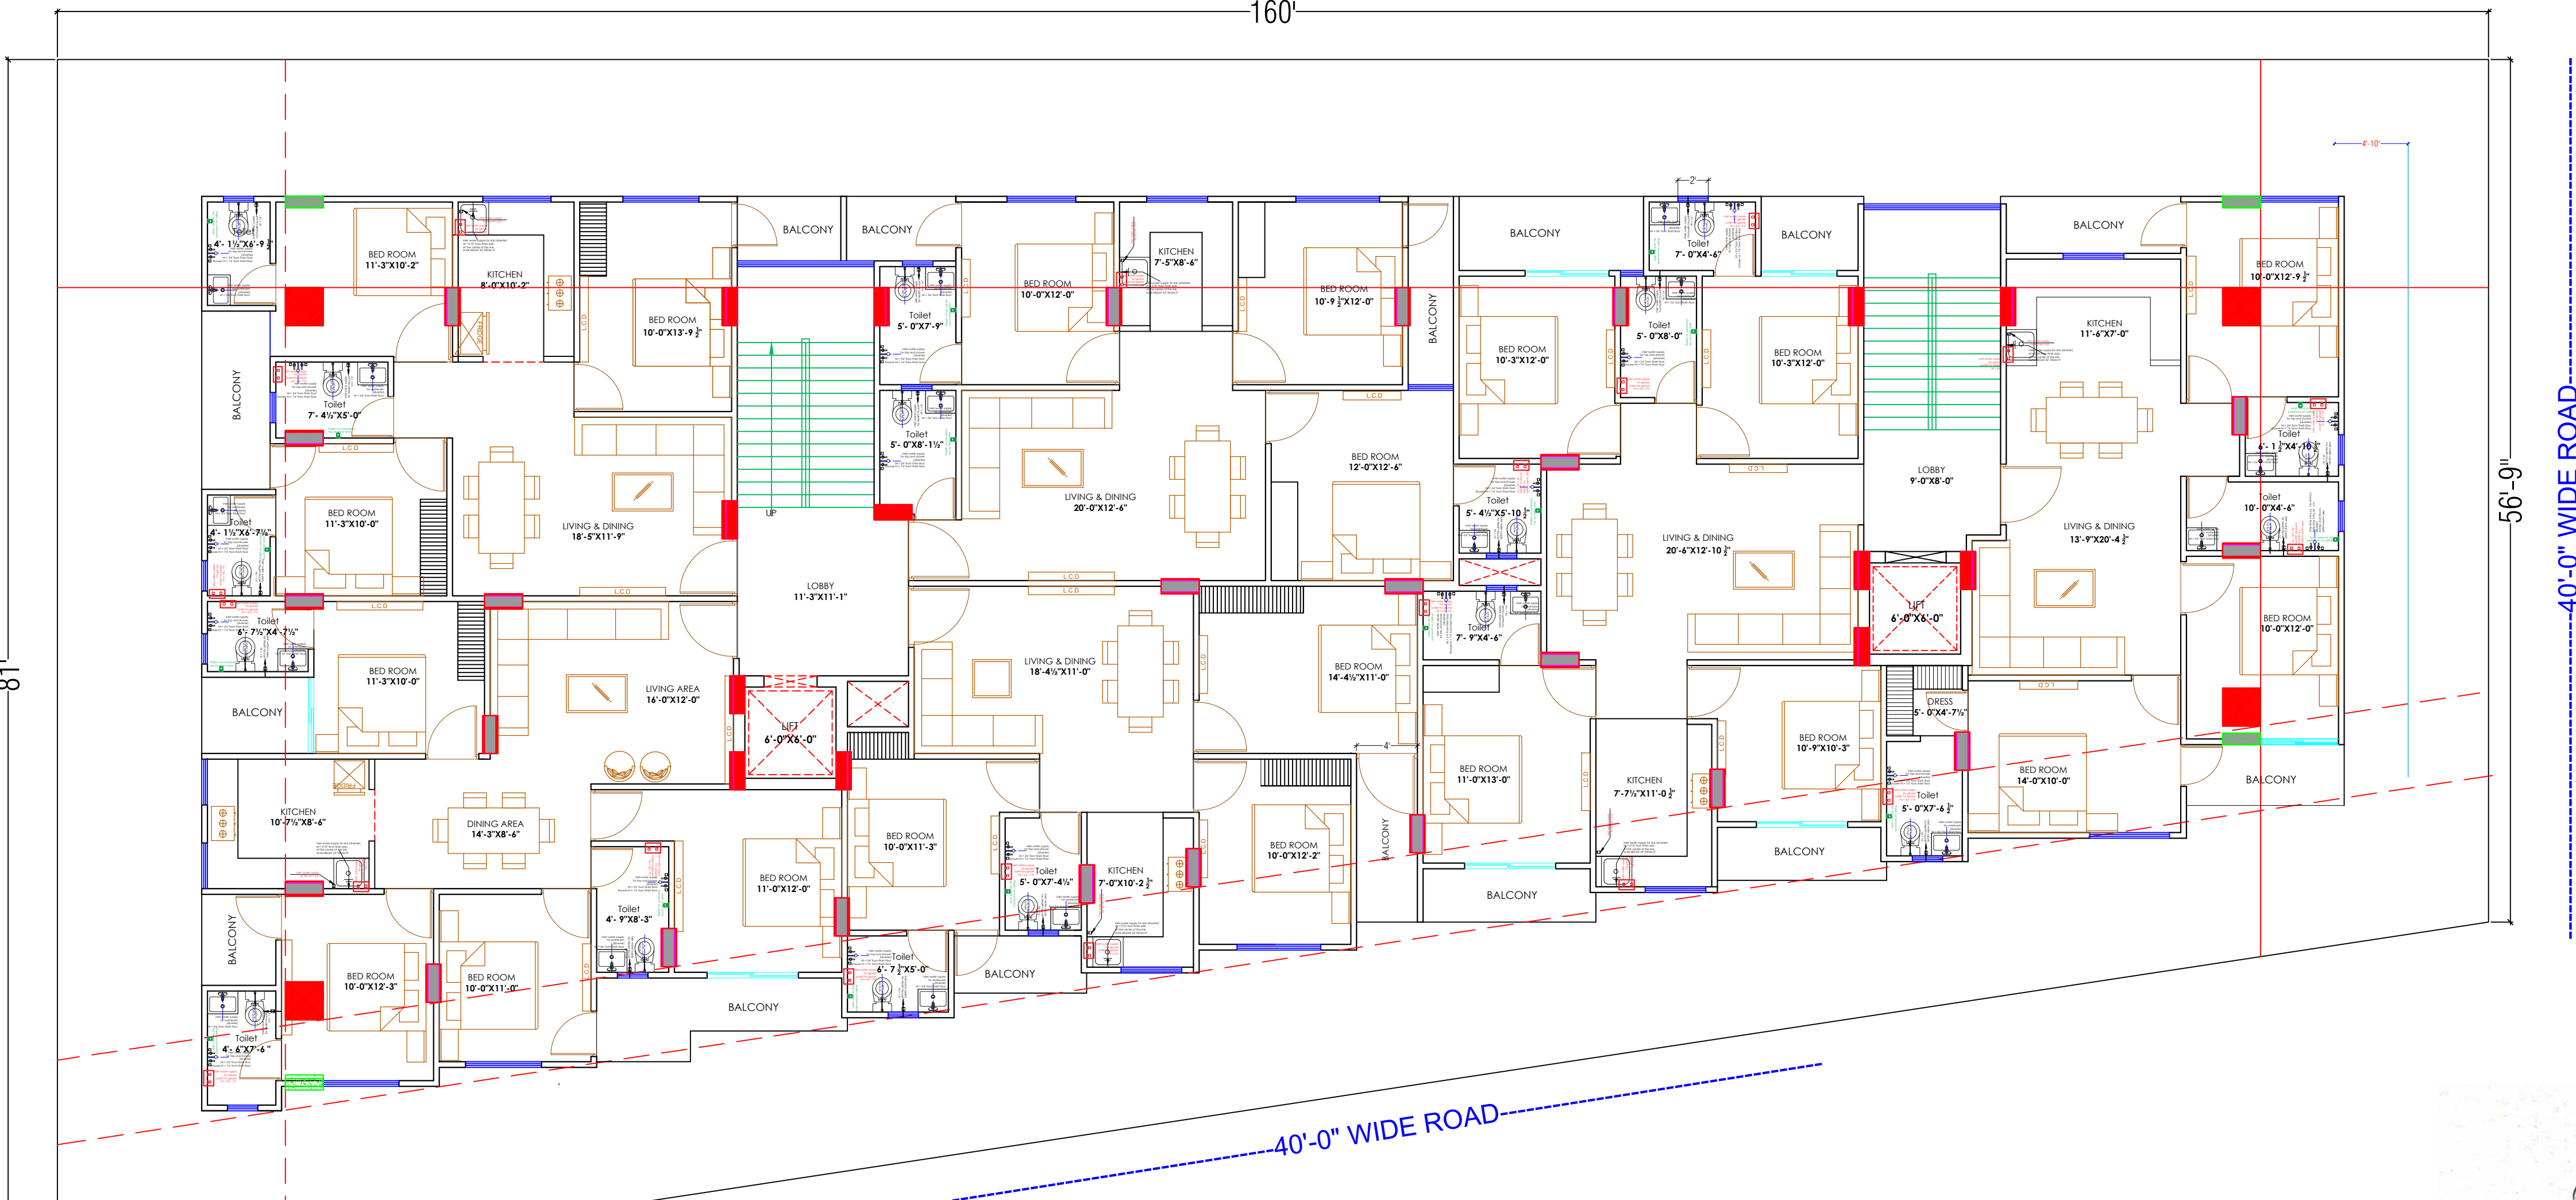

LEGENDS		
S.NO.	SYMBOL	DESCRIPTION
1.		SDR-11 Fresh Water Pipe
2.		SDR-11 Solar Water Pipe
3.		Waste Water Pipe (W.P.)
4.		Soil Pipe (S.P.)
5.		Rain Water Pipe (R.W.P.)
6.		Butter Fly Valve (B.F.V.)
7.		Geyser
8.		RO
9.		Single Lever Diverter
10.		Concealed Valve
11.		Angle Valve
12.		Nahani Trap
13.		P-Trap
14.		Tap
15.		Floor Drain (F.D.)
16.		Plain Tee (P-tee)
17.		Gully Trap (G.T.)
18.		

Sachin
SACHIN KUMAR
B. TECH. (CIVIL)

WARNING
1. This drawing is the sole copyright of Architects **VISTAAR** and should be used for the purpose expressly issued.

GENERAL NOTES
1. All dimensions are in feet and inches.
2. Do not scale this drawing follow written dimensions only.
3. This drawing should be read in conjunction with other architectural and structural drawings.
4. Any discrepancy in the drawing should be immediately brought to the notice of architect.

PROJECT TITLE
PUJA PRIME II
PLOT NO. B-107 & B-138
VAISHALI ESTATE BLOCK-B SIRSI, JAIPUR

DRAWING TITLE
TYPICAL FLOOR PLUMBING PLAN

ARCHITECTS :
VISTAAR ARCHITECTS & PLANNERS
Architects :: Interior Designers
B-2/12, Chitarkoot scheme,
main Gandhi Path, Opp mall of jaipur, Jaipur-21
Email-Vistaararchitects.web@gmail.com
PH.- 0141-4116461,09001010366

PATH :-			
DRN.	DATE	REV.	NORTH
MANOJ KUMAWAT	11-6-2024		
SCALE	JOB NO.		
N.T.S			