


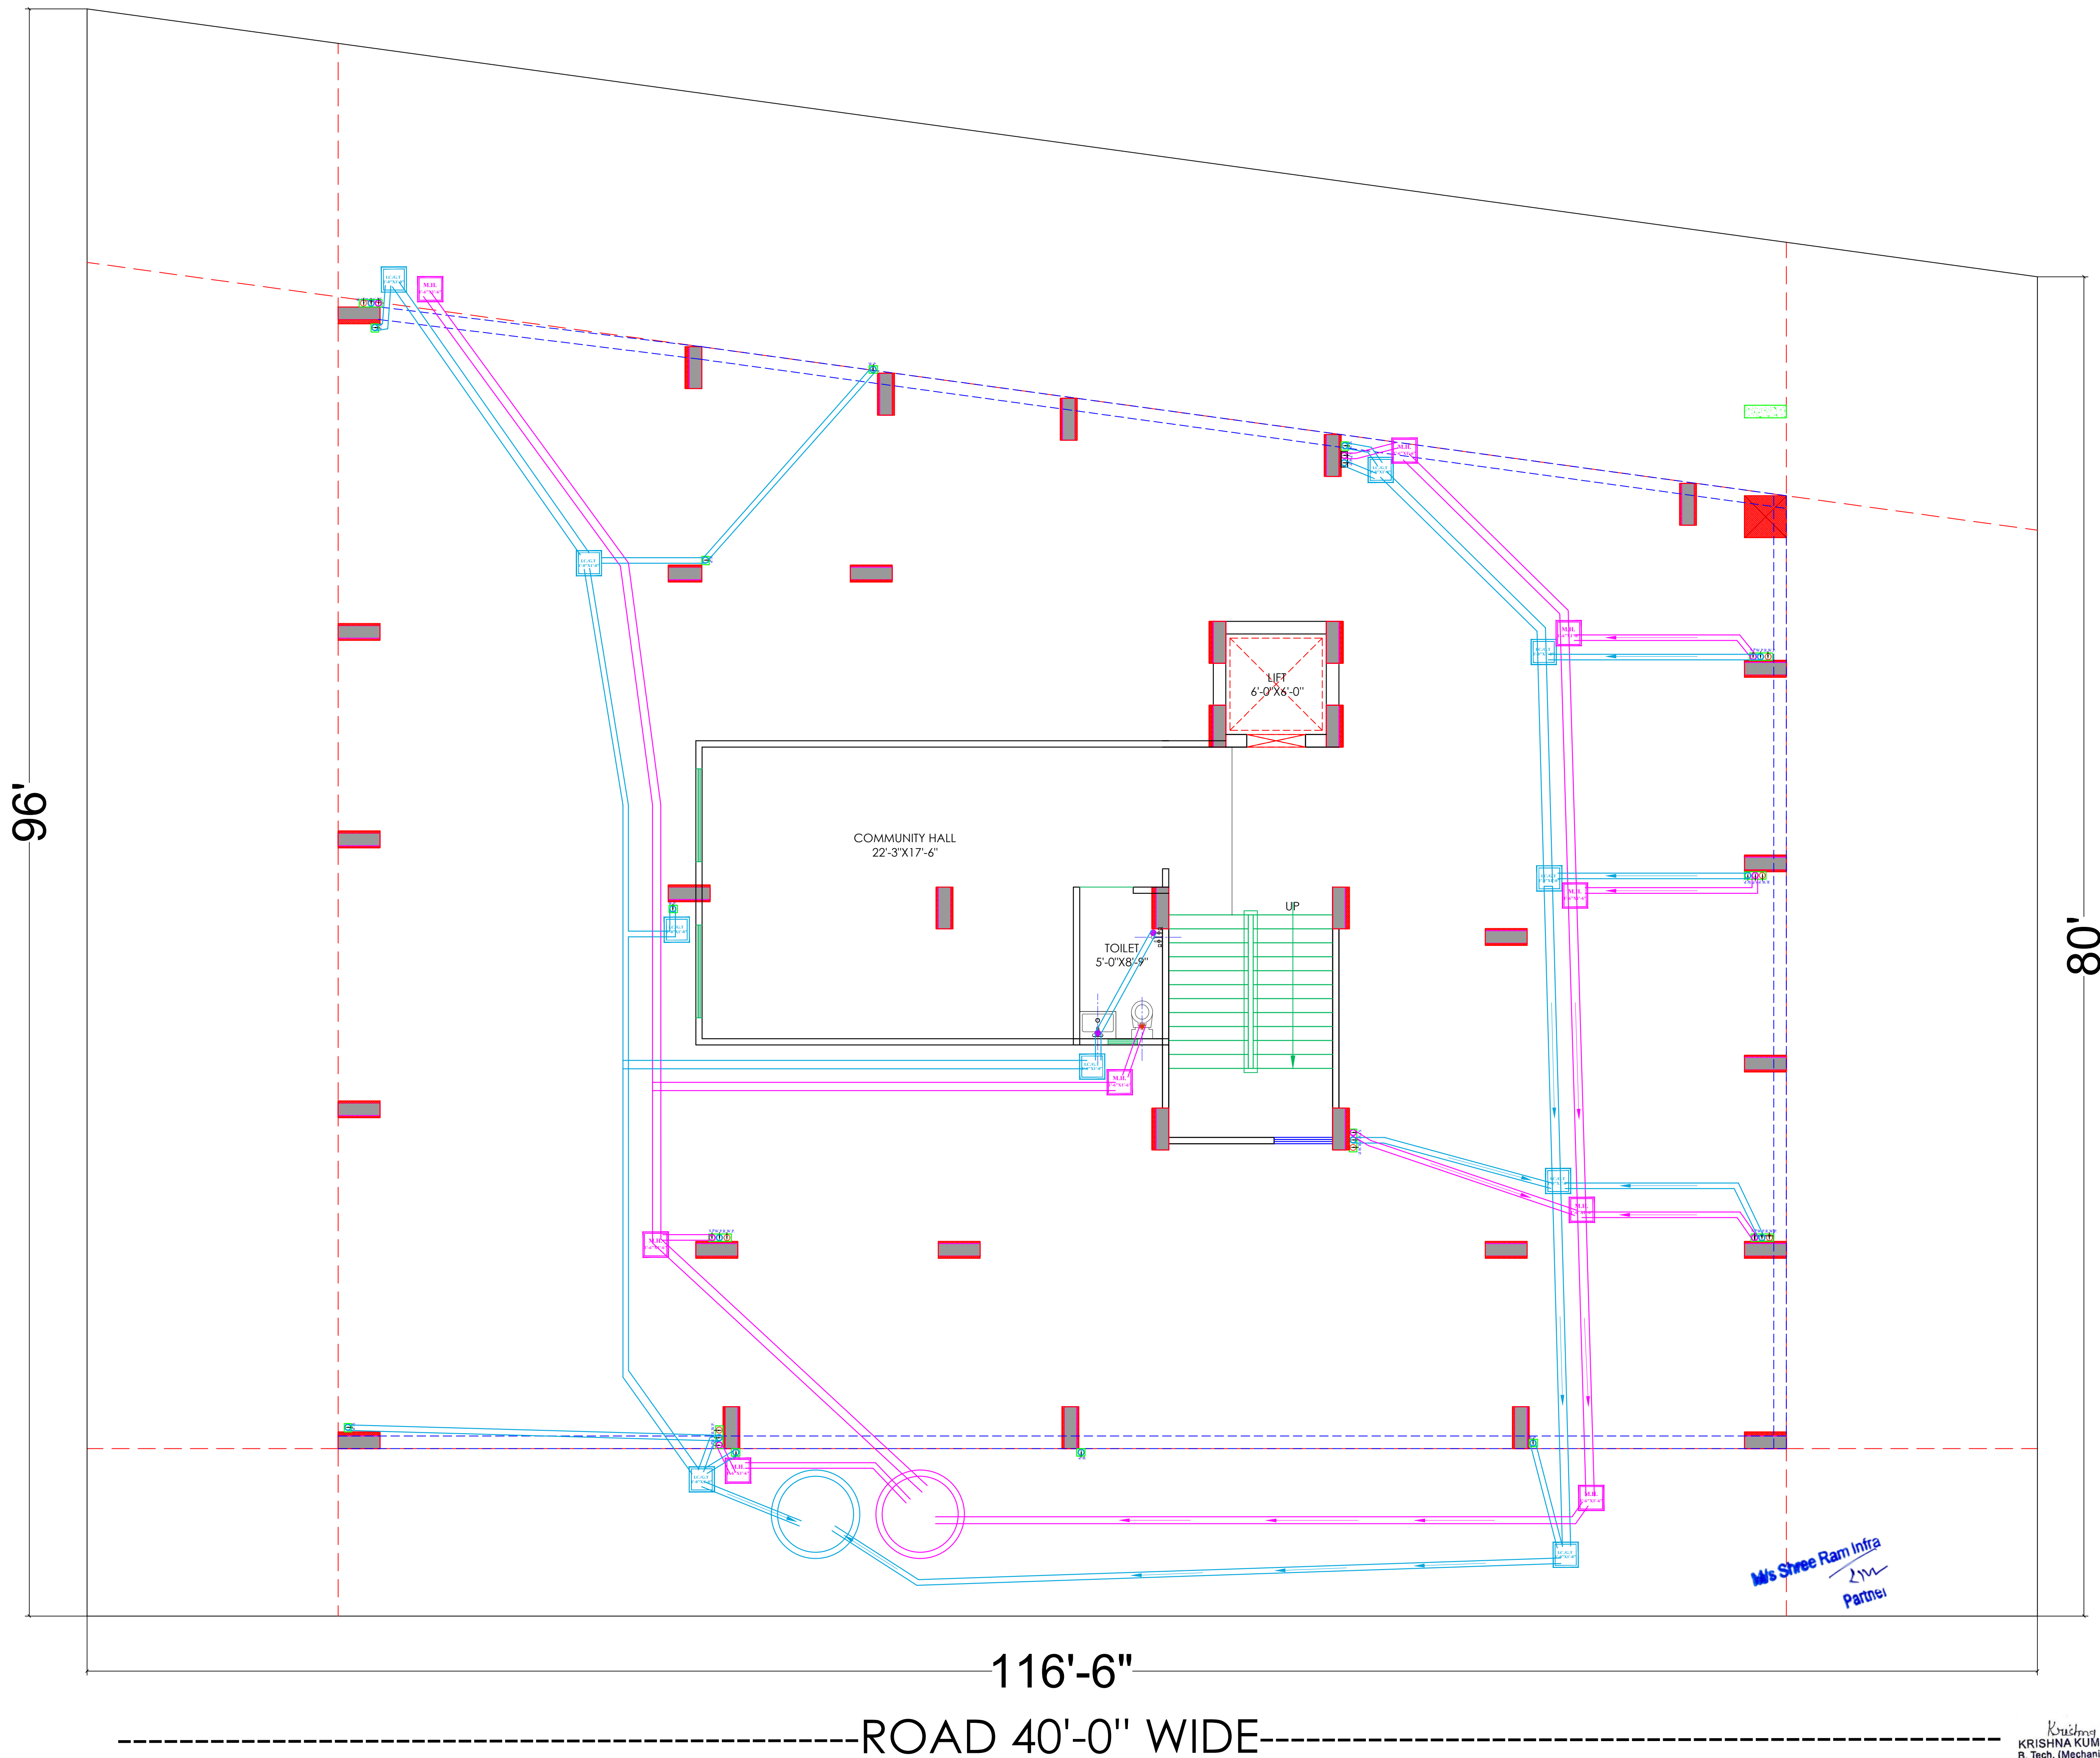

①	RAIN WATER PIPE	
②	WEST WATER PIPE	
③	SOILWATER PIPE	

LEGENDS		
S.NO.	SYMBOL	DESCRIPTION
1.		SDR-11 Fresh Water Pipe
2.		SDR-11 Solar Water Pipe
3.		Waste Water Pipe (W.P.)
4.		Soil Pipe (S.P.)
5.		Rain Water Pipe (R.W.P.)
6.		Butter Fly Valve (B.F.V.)
7.		Geyser
8.		RO
9.		Single Lever Diverter
10.		Concealed Valve
11.		Angle Valve
12.		Nahani Trap
13.		P-Trap
14.		Tap
15.		Floor Drain (F.D.)
16.		Plain Tee (P-tee)
17.		Gully Trap (G.T.)
18.		

WARNING
1. This drawing is the sole copyright of Architects **VISTAAR** and should be used for the purpose expressly issued.

GENERAL NOTES
1. All dimensions are in feet and inches.
2. Do not scale this drawing follow written dimensions only.
3. This drawing should be read in conjunction with other architectural and structural drawings.
4. Any discrepancy in the drawing should be immediately brought to the notice of architect.

PROJECT TITLE

SHREE RAM GREEN PARK
BUILDING AT PLOT-D-567,D-568,D-569
(RECONSTITUTION), JAGDAMBA NAGER-D, JAIPUR

DRAWING TITLE


STILT FLOOR DRAINAGE PLAN

ARCHITECTS :
VISTAAR ARCHITECTS & PLANNERS
Architects :: Interior Designers
B-2/12, Chitrkoot scheme,
main Gandhi Path,Opp mall of jaipur,Jaipur-21
Email-Vistaararchitects.web@gmail.com
PH.- 0141-4116461,09001010366

PATH :-		REV.	NORTH
DRN.	DATE		
	28-03-2024		
SCALE	JOB NO.		
N.T.S			

Prepared by
KRISHNA KUMAR
B. Tech. (Mechanical)
M.E.P Consultant

Ms Shree Ram Infra
Partner

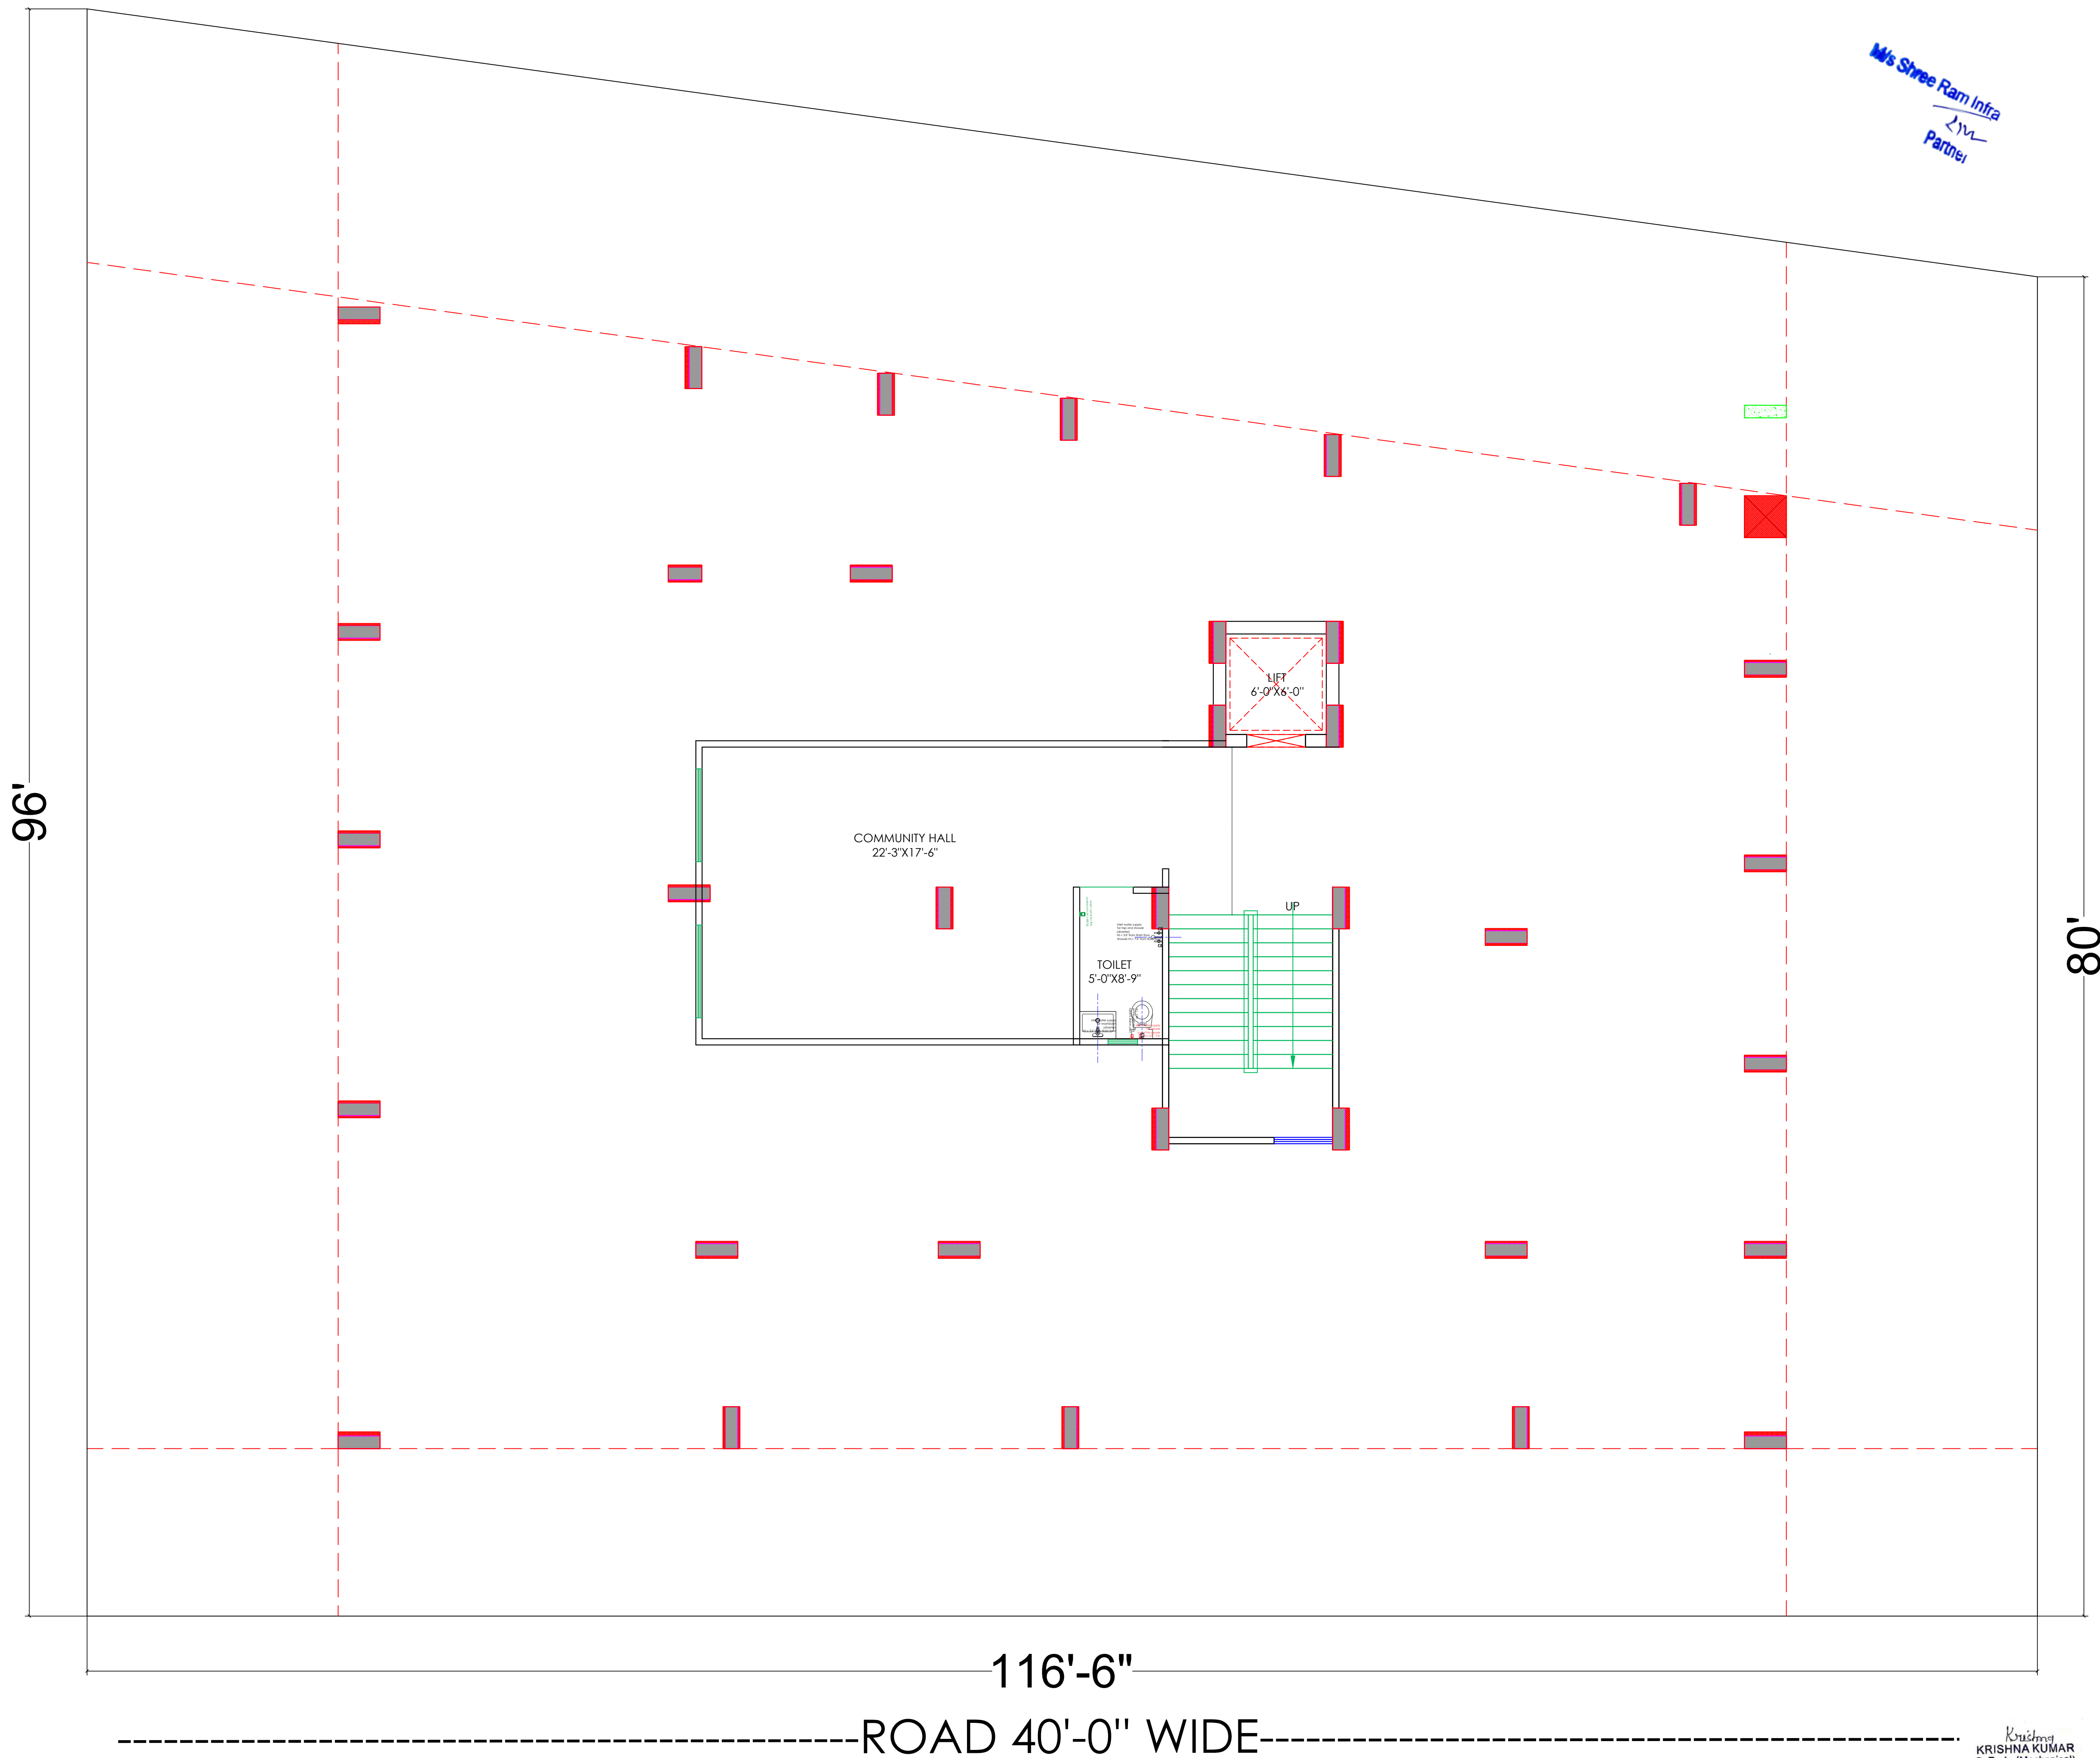

①	RAIN WATER PIPE		
②	WEST WATER PIPE		
③	SOILWATER PIPE		

LEGENDS		
S.NO.	SYMBOL	DESCRIPTION
1.		SDR-11 Fresh Water Pipe
2.		SDR-11 Solar Water Pipe
3.		Waste Water Pipe (W.P.)
4.		Soil Pipe (S.P.)
5.		Rain Water Pipe (R.W.P.)
6.		Butter Fly Valve(B.F.V.)
7.		Geyser
8.		RO
9.		Single Lever Diverter
10.		Concealed Valve
11.		Angle Valve
12.		Nahani Trap
13.		P-Trap
14.		Tap
15.		Floor Drain (F.D.)
16.		Plain Tee (P-tee)
17.		Gully Trap (G.T.)
18.		

WARNING
1. This drawing is the sole copyright of Architects **VISTAAR** and should be used for the purpose expressly issued.

GENERAL NOTES
1. All dimensions are in feets and inches.
2. Do not scale this drawing follow written dimensions only.
3. This drawing should be read in conjunction with other architectural and structural drawings.
4. Any discrepancy in the drawing should be immediately brought to the notice of architect.

PROJECT TITLE

SHREE RAM GREEN PARK
BUILDING AT PLOT-D-567,D-568,D-569
(RECONSTITUTION), JAGDAMBA NAGER-D, JAIPUR

DRAWING TITLE

STILT FLOOR PLUMBING PLAN

ARCHITECTS :
VISTAAR ARCHITECTS & PLANNERS
Architects :: Interior Designers
B-2/12, Chitrkoot scheme,
main Gandhi Path,Opp mall of jaipur,Jaipur-21
Email-Vistaararchitects.web@gmail.com
PH.- 0141-4116461,09001010366

PATH :-		REV.	NORTH
DRN.	DATE		
	28-03-2024		
SCALE	JOB NO.		
N.T.S			



①	RAIN WATER PIPE	
②	WEST WATER PIPE	
③	SOILWATER PIPE	

LEGENDS		
S.NO.	SYMBOL	DESCRIPTION
1.		SDR-11 Fresh Water Pipe
2.		SDR-11 Solar Water Pipe
3.		Waste Water Pipe (W.P.)
4.		Soil Pipe (S.P.)
5.		Rain Water Pipe (R.W.P.)
6.		Butter Fly Valve(B.F.V.)
7.		Geyser
8.		RO
9.		Single Lever Diverter
10.		Concealed Valve
11.		Angle Valve
12.		Nahani Trap
13.		P-Trap
14.		Tap
15.		Floor Drain (F.D.)
16.		Plain Tee (P-tee)
17.		Gully Trap (G.T.)
18.		

WARNING
1. This drawing is the sole copyright of Architects VISTAAR and should be used for the purpose expressly issued.

GENERAL NOTES
1. All dimensions are in feet and inches.
2. Do not scale this drawing follow written dimensions only.
3. This drawing should be read in conjunction with other architectural and structural drawings.
4. Any discrepancy in the drawing should be immediately brought to the notice of architect.

PROJECT TITLE

SHREE RAM GREEN PARK
BUILDING AT PLOT-D-567,D-568,D-569
(RECONSTITUTION), JAGDAMBA NAGER-D, JAIPUR

DRAWING TITLE

TYPICAL FLOOR DRAINAGE PLAN

ARCHITECTS :
VISTAAR ARCHITECTS & PLANNERS
Architects :: Interior Designers
B-2/12, Chitrkoot scheme,
main Gandhi Path,Opp mall of jaipur,Jaipur-21
Email-Vistaararchitects.web@gmail.com
PH.- 0141-4116461,09001010366

PATH :-		NORTH	
DRN.	DATE	REV.	
	28-03-2024		
SCALE	JOB NO.		
N.T.S			

Krishna
KRISHNA KUMAR
B. Tech. (Mechanical)
M.E.P Consultant

96'

80'

116'-6"

ROAD 40'-0" WIDE

M/s Shree Ram Infra
Partner

Krishna
KRISHNA KUMAR
B. Tech. (Mechanical)
M.E.P Consultant

LEGENDS		
S.NO.	SYMBOL	DESCRIPTION
1.		SDR-11 Fresh Water Pipe
2.		SDR-11 Solar Water Pipe
3.		Waste Water Pipe (W.P.)
4.		Soil Pipe (S.P.)
5.		Rain Water Pipe (R.W.P.)
6.		Butter Fly Valve(B.F.V.)
7.		Geyser
8.		RO
9.		Single Lever Diverter
10.		Concealed Valve
11.		Angle Valve
12.		Nahani Trap
13.		P-Trap
14.		Tap
15.		Floor Drain (F.D.)
16.		Plain Tee (P-tee)
17.		Gully Trap (G.T.)
18.		

WARNING

1. This drawing is the sole copyright of Architects VISTAAR and should be used for the purpose expressly issued.

GENERAL NOTES

1. All dimensions are in feet and inches.
2. Do not scale this drawing follow written dimensions only.
3. This drawing should be read in conjunction with other architectural and structural drawings.
4. Any discrepancy in the drawing should be immediately brought to the notice of architect.

PROJECT TITLE

SHREE RAM GREEN PARK
BUILDING AT PLOT-D-567,D-568,D-569
(RECONSTITUTION), JAGDAMBA NAGER-D, JAIPUR

DRAWING TITLE

TYPICAL FLOOR PLUMBING PLAN


ARCHITECTS :

VISTAAR ARCHITECTS & PLANNERS

Architects :: Interior Designers
B-2/12, Chitrkoot scheme,
main Gandhi Path, Opp mall of jaipur, Jaipur-21
Email-Vistaararchitects.web@gmail.com
PH.- 0141-4116461,09001010366

PATH :-

DRN.	DATE	REV.	NORTH
	13-04-2024		
SCALE	JOB NO.		
N.T.S			

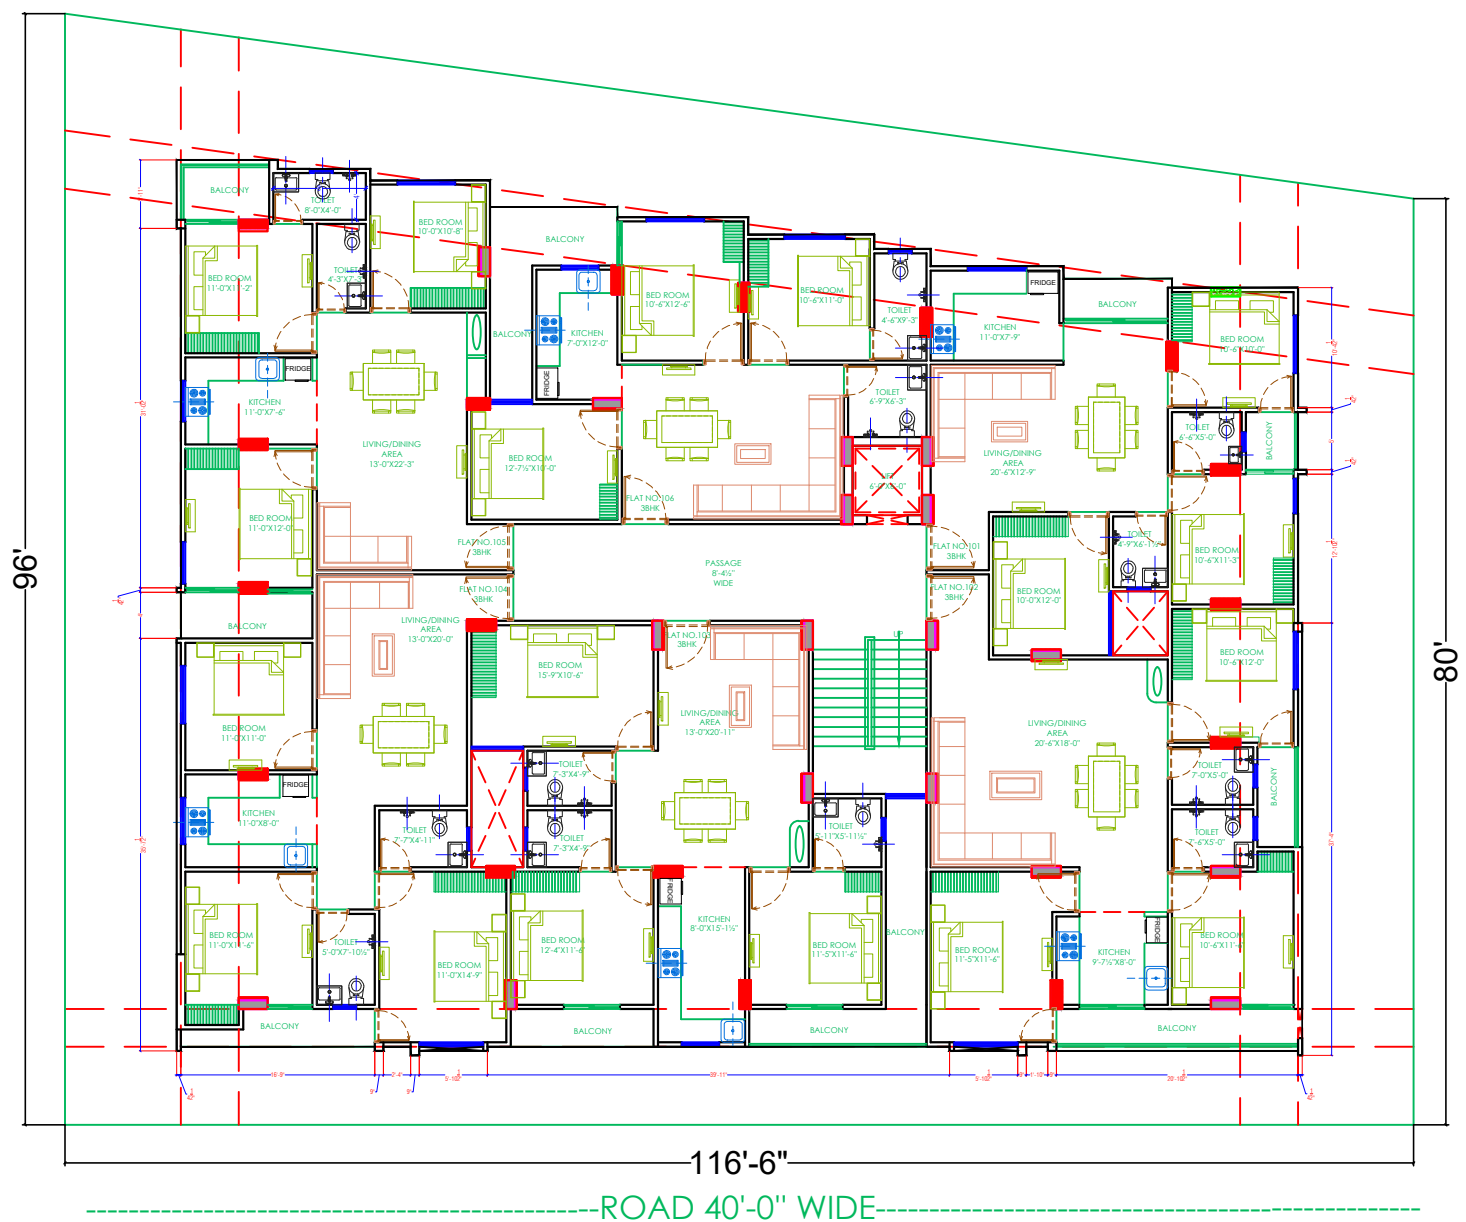

TERRACE
FLOOR

6 TH
FLOOR


5 TH
FLOOR

4 TH
FLOOR

3 RD
FLOOR

2 ND
FLOOR

1 ST
FLOOR

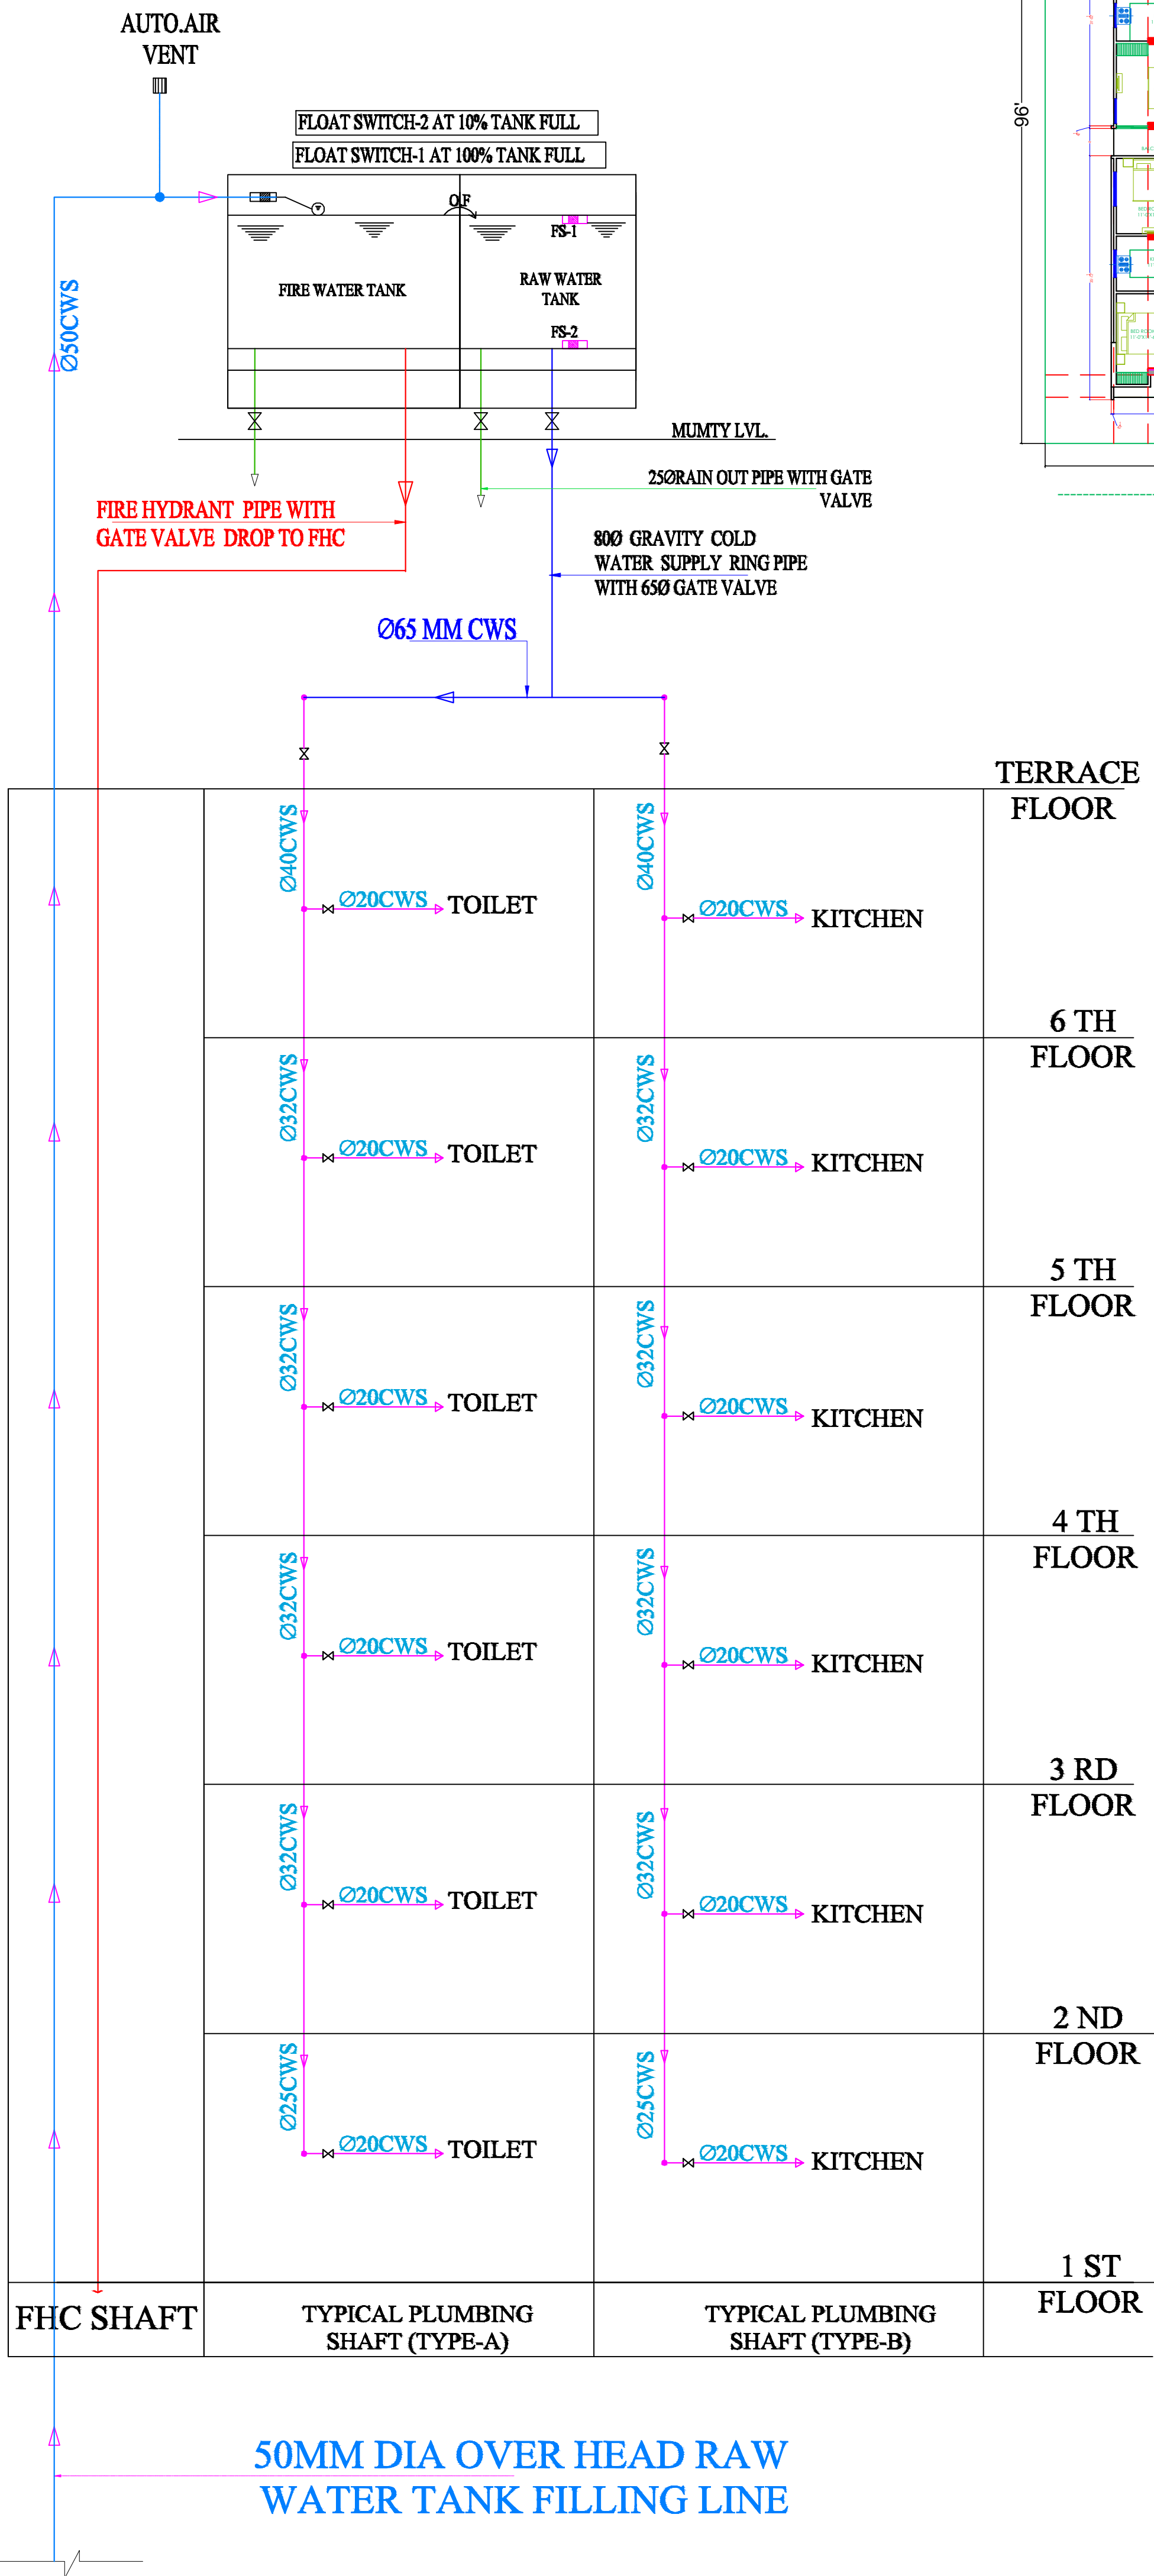

WARNING

1. This drawing is the sole copyright of Architects **VISTAAR** and should be used for the purpose expressly issued.

GENERAL NOTES

1. All dimensions are in feet and inches.
2. Do not scale this drawing follow written dimensions only.
3. This drawing should be read in conjunction with other architectural and structural drawings.
4. Any discrepancy in the drawing should be immediately brought to the notice of architect.

PROJECT TITLE

SHREE RAM GREEN PARK
BUILDING AT PLOT-D-567,D-568,D-569
(RECONSTITUTION), JAGDAMBA NAGAR-D, JAIPUR

DRAWING TITLE

WATER SUPPLY DIAGRAM

ARCHITECTS :

VISTAAR ARCHITECTS & PLANNERS

Architects :: Interior Designers
B-2/12, Chitrkoot scheme,
main Gandhi Path, Opp mall of jaipur, Jaipur-21
Email-Vistaararchitects.web@gmail.com
PH.- 0141-4116461,09001010366

PATH :-

DRN.	DATE	REV.	NORTH
SACHIN	13-04-2024		
SCALE	JOB NO.		
N.T.S			