


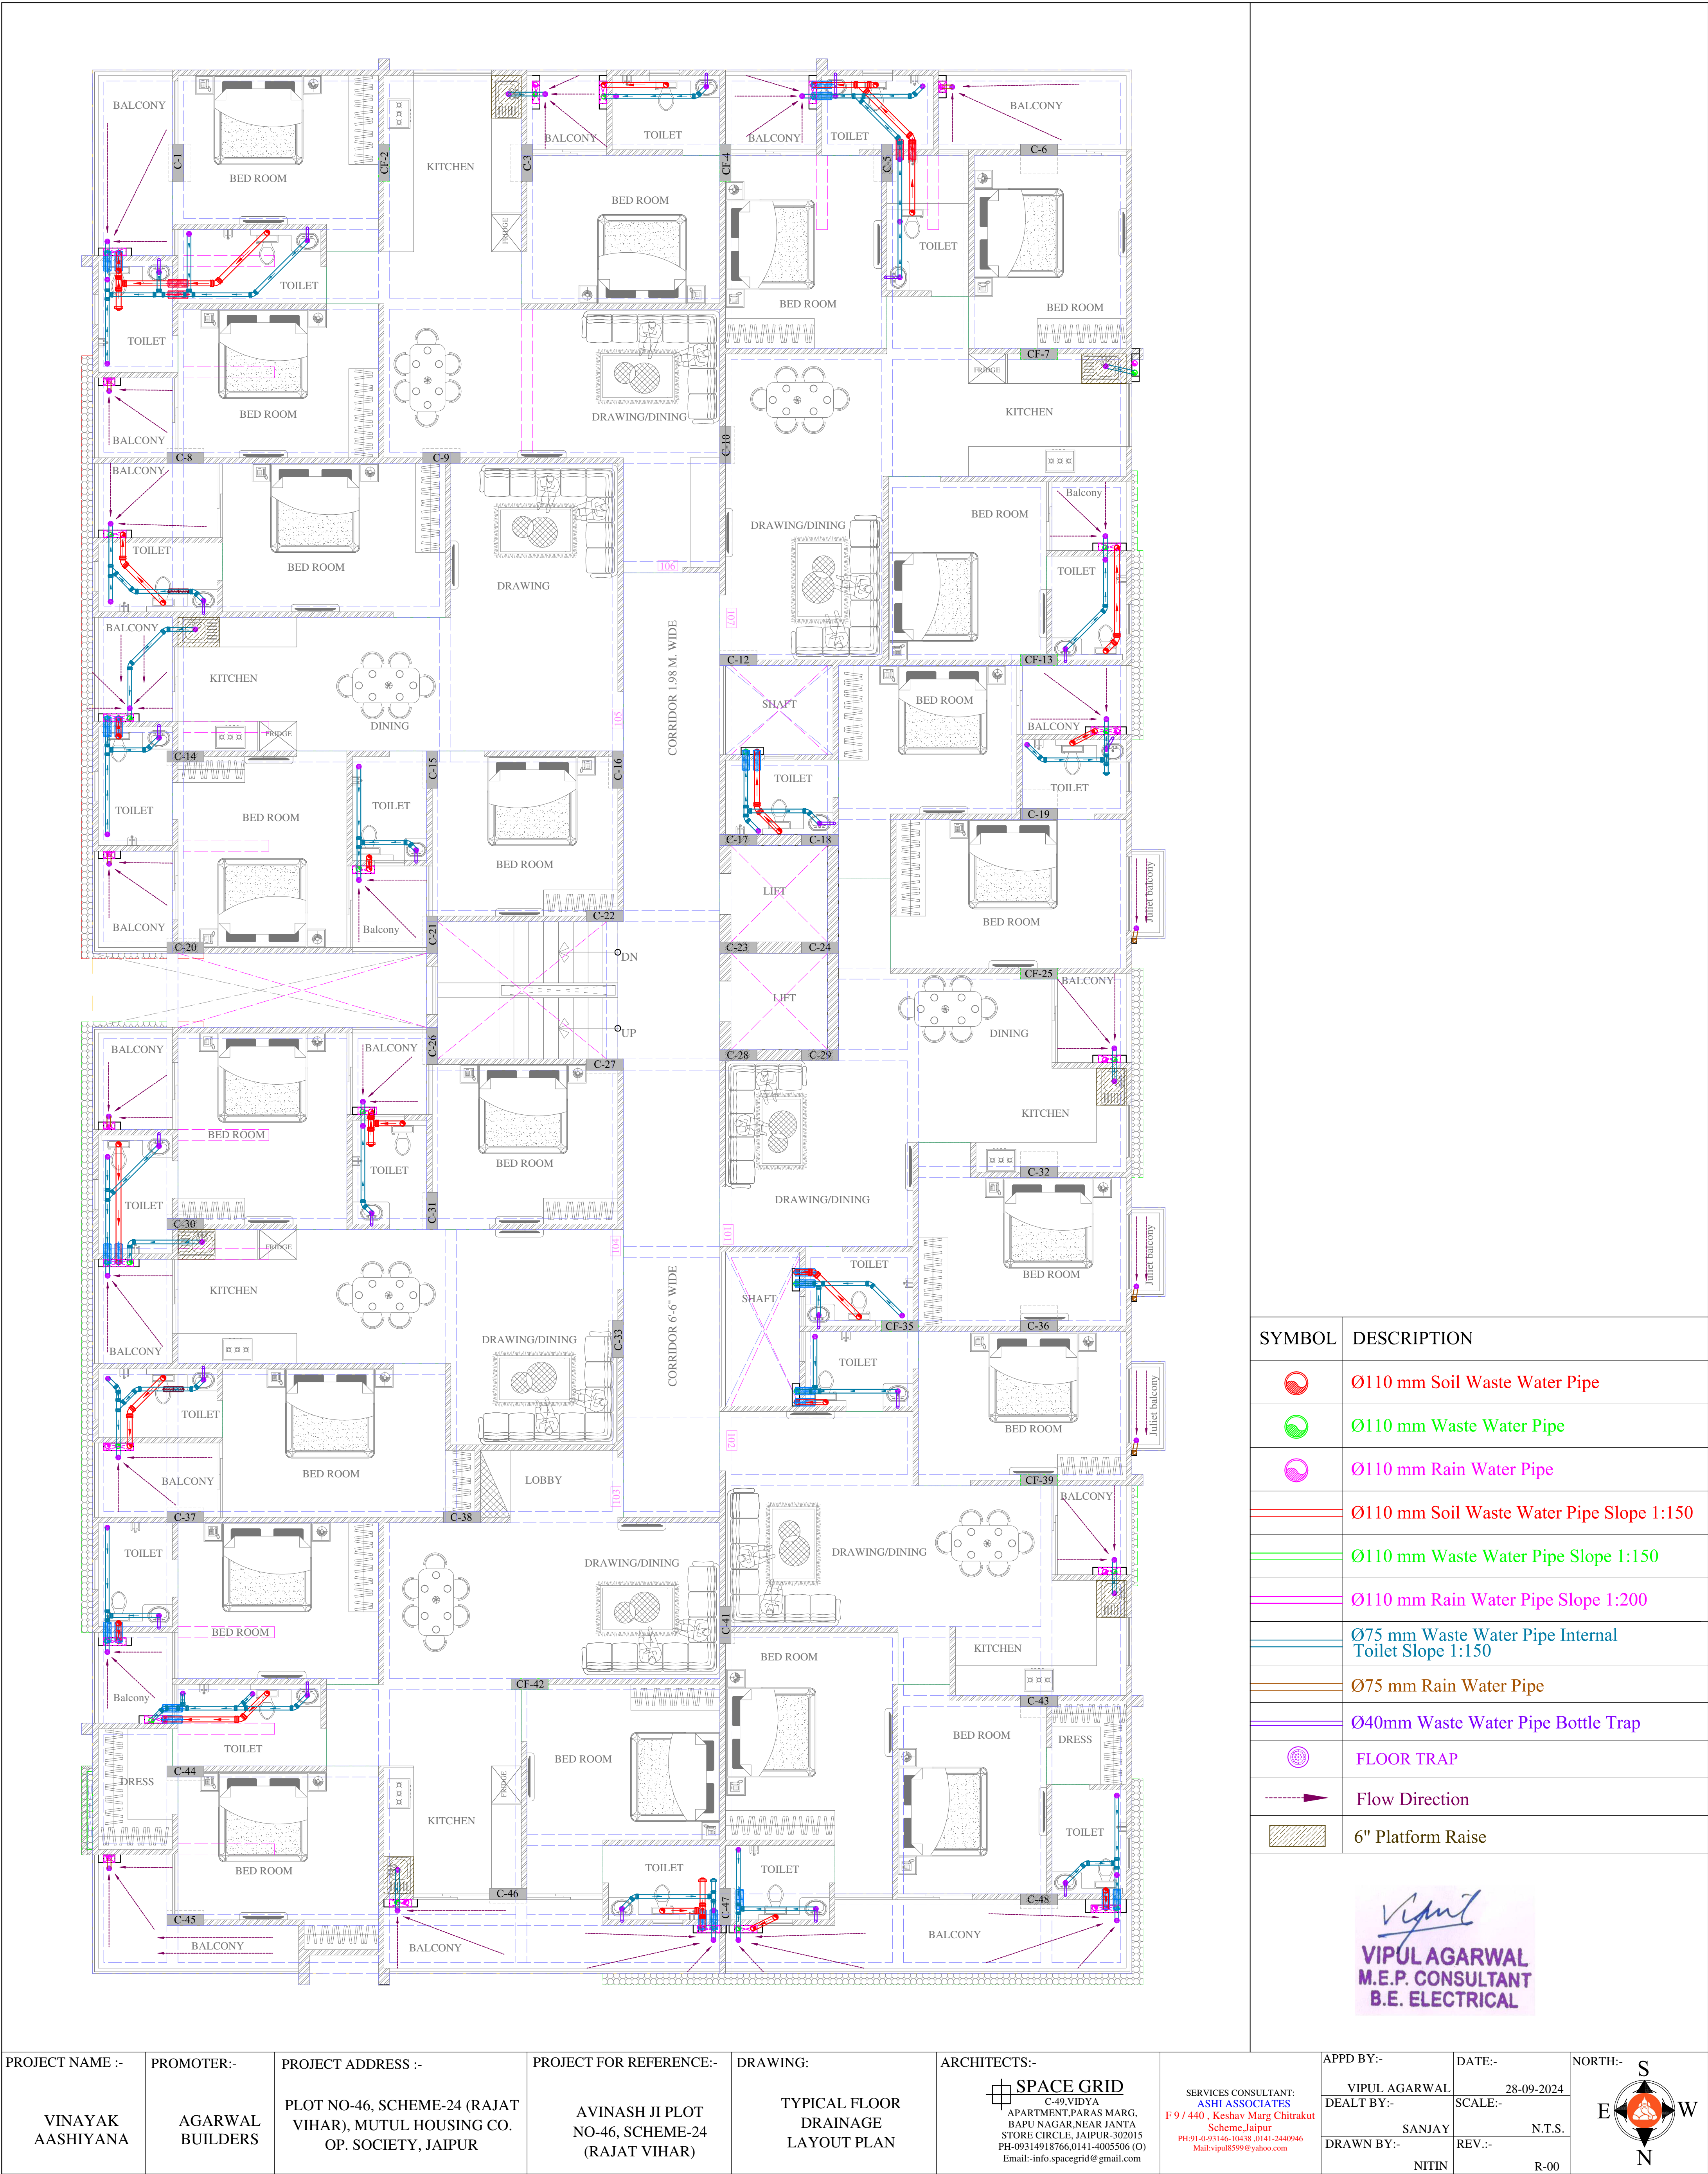




All Heights For Finish Floor Lvl	SYMBOL	SYMBOL	DESCRIPTION
+1000MM			Ø 20MM CWS PIPE THRU WALL CHASE TO SINK
			Ø 20MM HWS PIPE THRU WALL CHASE TO SINK
+1950MM			Ø 20MM CWS PIPE THRU WALL CHASE TO GEYSER
			Ø 20MM HWS PIPE THRU WALL CHASE TO GEYSER
+1500MM			Ø 20MM CWS PIPE THRU WALL CHASE TO AQUAGUARD
			Ø 20MM HWS PIPE THRU WALL CHASE TO BASIN ANGLE VALVE
+450MM			Ø 20MM CWS PIPE THRU WALL CHASE TO BASIN ANGLE VALVE
			Ø 20MM CWS PIPE THRU WALL CHASE TO BASIN ANGLE VALVE
+2100MM			Ø 20MM CWS PIPE THRU WALL CHASE TO CONCEALED STOP COCK
			Ø 20MM CWS PIPE THRU WALL CHASE TO FAUCET
+300MM			Ø 20MM CWS PIPE THRU WALL CHASE TO FAUCET
			Ø 20MM CWS PIPE THRU WALL CHASE TO CISTERN ANGLE VALVE
+450MM			Ø 20MM CWS PIPE THRU WALL CHASE TO WALL MIXER / DIVERTOR
			Ø 20MM HWS PIPE THRU WALL CHASE TO WALL MIXER / DIVERTOR
+1000MM WALL MIXER DIVERTOR +2025MM O.H SHOWER			Ø 20MM CWS PIPE THRU WALL CHASE TO WALL MIXER / DIVERTOR
+600MM			Ø 20MM CWS PIPE THRU WALL CHASE TO TAP
			Ø 20MM CWS PIPE THRU WALL CHASE TO CISTERN ANGLE VALVE
+450MM			Ø 20MM CWS PIPE THRU WALL CHASE TO CISTERN ANGLE VALVE
			Ø 20MM CWS PIPE THRU WALL CHASE TO CISTERN ANGLE VALVE
			Floor Trap
+950MM	AS PER/ARCHI.		MIRROR 450X450mm(BOTTOM)
+1000MM	AS PER/ARCHI.		SOAP DISH
+1500MM	AS PER/ARCHI.		TOWEL RAIL
+450MM	AS PER/ARCHI.		PAPER HOLDER
			COLD WATER SUPPLY LINE
			HOT WATER SUPPLY LINE

Vipul
VIPUL AGARWAL
M.E.P. CONSULTANT
B.E. ELECTRICAL

PROJECT NAME :- VINAYAK AASHIYANA	PROMOTER:- AGARWAL BUILDERS	PROJECT ADDRESS :- PLOT NO-46, SCHEME-24 (RAJAT VIHAR), MUTUL HOUSING CO. OP. SOCIETY, JAIPUR	PROJECT FOR REFERENCE:- AVINASH JI PLOT NO-46, SCHEME-24 (RAJAT VIHAR)	DRAWING: TYPICAL FLOOR PLUMBING LAYOUT PLAN	ARCHITECTS:- SPACE GRID C-49, VIDYA APARTMENT, PARAS MARG, BAPU NAGAR, NEAR JANTA STORE CIRCLE, JAIPUR-302015 PH: 09314918766, 0141-4005506 (O) Email: info.spacegrid@gmail.com	SERVICES CONSULTANT: ASHI ASSOCIATES F 9 / 440 , Keshav Marg Chitrakut Scheme, Jaipur PH: 91-0-93146-10438, 0141-2440946 Mail: vipul8599@yahoo.com	APPD BY:- VIPUL AGARWAL DEALT BY:- SANJAY DRAWN BY:- NITIN	DATE:- 28-09-2024 SCALE:- N.T.S. REV:- R-00	NORTH:-
---	---------------------------------------	---	--	---	--	---	--	---	-------------

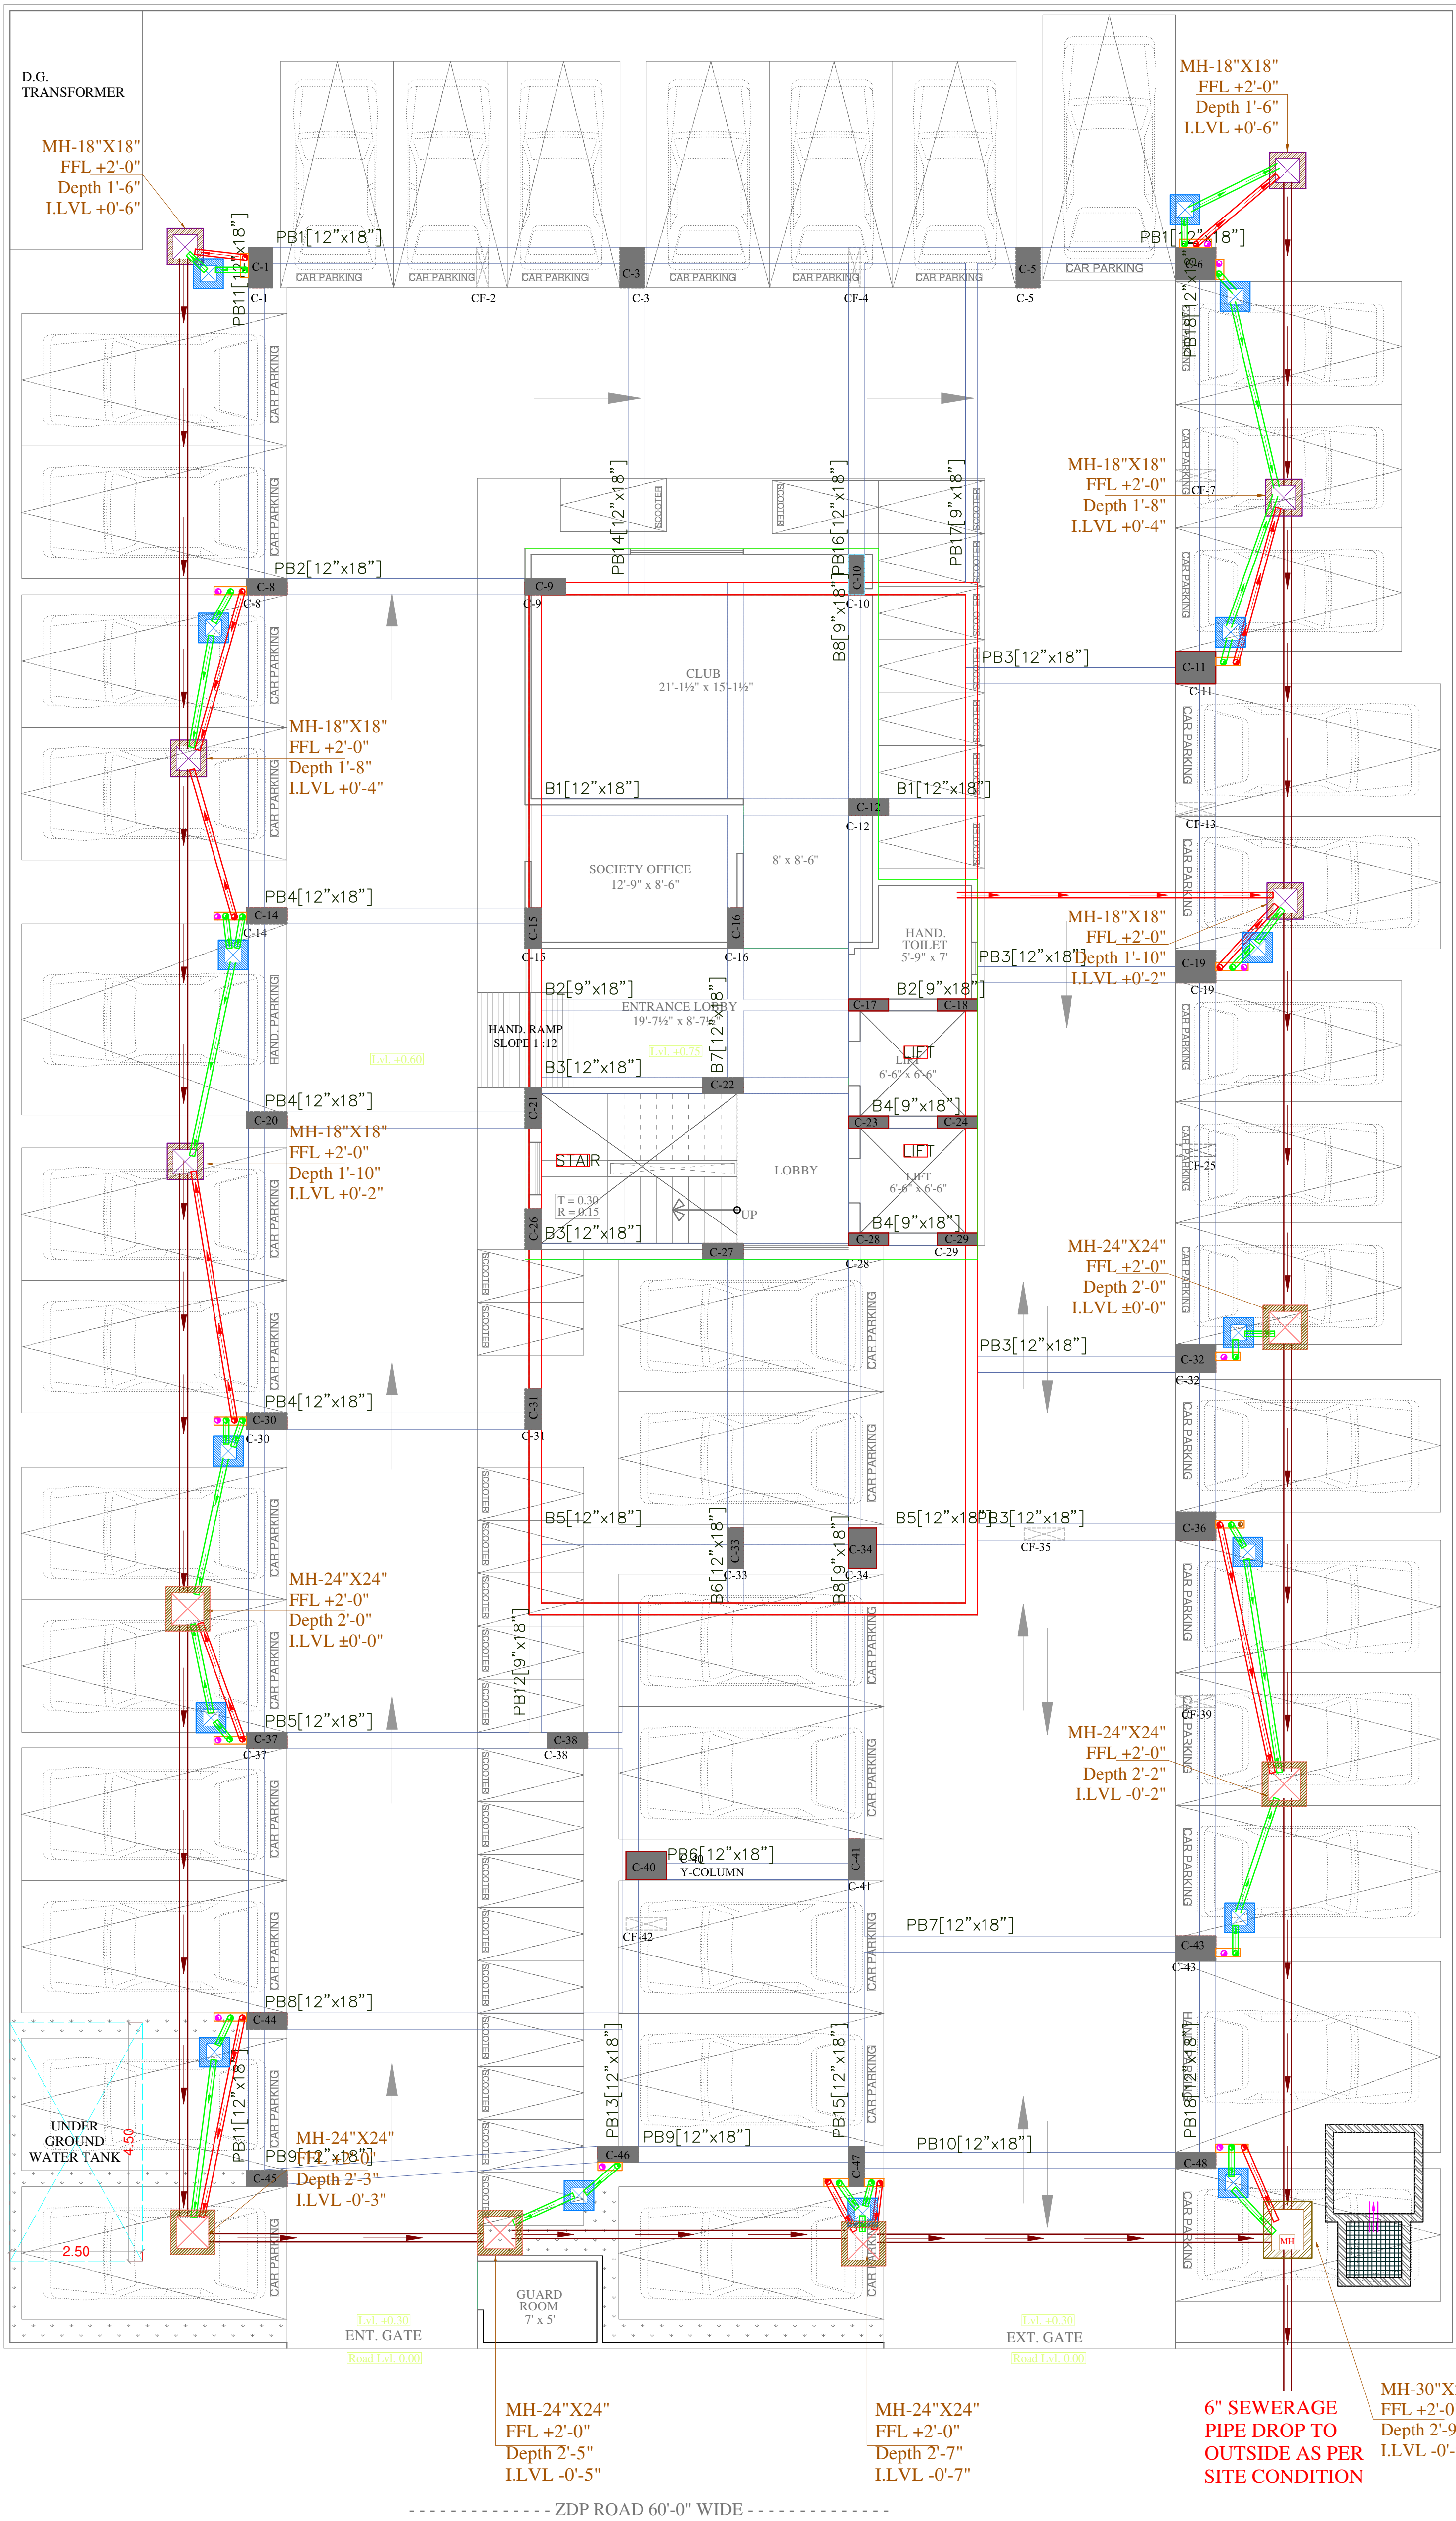

For AGARWAL BUILDERS

Signature
Partner

Signature
VIPUL AGARWAL
M.E.P. CONSULTANT
B.E. ELECTRICAL

SYMBOL	DESCRIPTION
	110 mm Soil Waste Water Pipe
	110 mm Waste Water Pipe
	110 mm Rain Water Pipe
	75 mm Rain Water Pipe
	160 mm Soil Waste Water Pipe Slope 1:200
	110 mm Soil Waste Water Pipe Slope 1:150
	110 mm Waste Water Pipe Slope 1:150
	75 mm Rain Water Pipe Slope 1:200
	Gully Trap-300X300mm Depth -300mm
	Main Hole-450X450mm Depth According to Slope
	Main Hole-600X600mm Depth According to Slope
	Main Hole-750X600mm Depth According to Slope
	Flow Direction

PROJECT NAME :- VINAYAK AASHIYANA	PROMOTER:- AGARWAL BUILDERS	PROJECT ADDRESS :- PLOT NO-46, SCHEME-24 (RAJAT VIHAR), MUTUL HOUSING CO. OP. SOCIETY, JAIPUR	PROJECT FOR REFERENCE:- AVINASH JI PLOT NO-46, SCHEME-24 (RAJAT VIHAR)	DRAWING: STILT FLOOR EXTERNAL SWERAGE WATER PIPE ROUTE PLAN	ARCHITECTS:- SPACE GRID C-49, VIDYA APARTMENT, PARAS MARG, BAPU NAGAR, NEAR JANTA STORE CIRCLE, JAIPUR-302015 PH-09314918766, 0141-4005506 (O) Email- info.spacegrid@gmail.com	SERVICES CONSULTANT: ASHI ASSOCIATES F 9 / 440 , Keshav Marg Chitrakut Scheme, Jaipur PH-91-0-93146-10438 , 0141-2440946 Mail- vipul8599@yahoo.com	APPD BY:- VIPUL AGARWAL DEALT BY:- SANJAY DRAWN BY:- SNEHA	DATE:- 19-07-2024 SCALE:- N.T.S. REV:- R-00	NORTH:-
--	------------------------------------	--	---	---	---	---	---	--	-----------------



All Heights For Finish Floor Lvl	SYMBOL	SYMBOL	DESCRIPTION
+1000MM			Ø 20MM CWS PIPE THRU WALL CHASE TO SINK
			Ø 20MM HWS PIPE THRU WALL CHASE TO SINK
+1950MM			Ø 20MM CWS PIPE THRU WALL CHASE TO GEYSER
			Ø 20MM HWS PIPE THRU WALL CHASE FROM GEYSER
+1500MM			Ø 20MM CWS PIPE THRU WALL CHASE TO AQUAGUARD
+450MM			Ø 20MM HWS PIPE THRU WALL CHASE TO BASIN ANGLE VALVE
+800MM			Ø 20MM CWS PIPE THRU WALL CHASE TO BASIN ANGLE VALVE
+2100MM			Ø 20MM CWS PIPE THRU WALL CHASE TO CONCEALED STOP COCK
+300MM			Ø 20MM CWS PIPE THRU WALL CHASE TO FAUCET
+450MM			Ø 20MM CWS PIPE THRU WALL CHASE TO CISTERN ANGLE VALVE
+1000MM WALL MIXER DIVERTOR			Ø 20MM CWS PIPE THRU WALL CHASE TO WALL MIXER / DIVERTOR
+2025MM O.I.SHOWER			Ø 20MM HWS PIPE THRU WALL CHASE TO WALL MIXER / DIVERTOR
+600MM			Ø 20MM CWS PIPE THRU WALL CHASE TO TAP
+450MM			Ø 20MM CWS PIPE THRU WALL CHASE TO CISTERN ANGLE VALVE
			Floor Trap
+950MM	AS PER/ARCHL		MIRROR 450X450mm(BOTTOM)
+1000MM	AS PER/ARCHL		SOAP DISH
+1500MM	AS PER/ARCHL		TOWEL RAIL
+450MM	AS PER/ARCHL		PAPER HOLDER
			COLD WATER SUPPLY LINE
			HOT WATER SUPPLY LINE

Vipul
VIPUL AGARWAL
M.E.P. CONSULTANT
B.E. ELECTRICAL


PROJECT NAME :- VINAYAK AASHIYANA	PROMOTER:- AGARWAL BUILDERS	PROJECT ADDRESS :- PLOT NO-46, SCHEME-24 (RAJAT VIHAR), MUTUL HOUSING CO. OP. SOCIETY, JAIPUR	PROJECT FOR REFERENCE:- AVINASH JI PLOT NO-46, SCHEME-24 (RAJAT VIHAR)	DRAWING: 6TH FLOOR PLUMBING LAYOUT PLAN	ARCHITECTS:- SPACE GRID C-49 VIDYA APARTMENT, PARAS MARG, BAPU NAGAR, NEAR JANTA STORE CIRCLE, JAIPUR-302015 PH-09314918766, 0141-4005506 (O) Email:-info.spacegrid@gmail.com	SERVICES CONSULTANT: ASHI ASSOCIATES F 9 / 440 , Keshav Marg Chitrakut Scheme Jaipur PH:91-09314610438 ,0141-2440946 Mail:vipul8599@yahoo.com	APPD BY:- VIPUL AGARWAL DEALT BY:- SANJAY DRAWN BY:- NITIN	DATE:- 28-09-2024 SCALE:- N.T.S. REV:- R-00	NORTH:-
---	---------------------------------------	---	--	---	---	---	--	---	-------------



SYMBOL	DESCRIPTION
	Ø110 mm Soil Waste Water Pipe
	Ø110 mm Waste Water Pipe
	Ø110 mm Rain Water Pipe
	Ø110 mm Soil Waste Water Pipe Slope 1:150
	Ø110 mm Waste Water Pipe Slope 1:150
	Ø110 mm Rain Water Pipe Slope 1:200
	Ø75 mm Waste Water Pipe Internal Toilet Slope 1:150
	Ø75 mm Rain Water Pipe
	Ø40mm Waste Water Pipe Bottle Trap
	FLOOR TRAP
	Flow Direction
	6" Platform Raise

Vipul
VIPUL AGARWAL
M.E.P. CONSULTANT
B.E. ELECTRICAL

PROJECT NAME :- VINAYAK AASHIYANA	PROMOTER:- AGARWAL BUILDERS	PROJECT ADDRESS :- PLOT NO-46, SCHEME-24 (RAJAT VIHAR), MUTUL HOUSING CO. OP. SOCIETY, JAIPUR	PROJECT FOR REFERENCE:- AVINASH JI PLOT NO-46, SCHEME-24 (RAJAT VIHAR)	DRAWING: 6TH FLOOR DRAINAGE LAYOUT PLAN	ARCHITECTS:- SPACE GRID C-49, VIDYA APARTMENT, PARAS MARG, BAPU NAGAR, NEAR JANTA STORE CIRCLE, JAIPUR-302015 PH: 09314918766, 0141-4005506 (O) Email: info.spacegrid@gmail.com	SERVICES CONSULTANT:- ASHI ASSOCIATES F 9 / 440 , Keshav Marg Chitrakut Scheme, Jaipur PH: 91-0-93146-10438 , 0141-2440946 Mail: vipul8599@yahoo.com	APPD BY:- VIPUL AGARWAL DEALT BY:- SANJAY DRAWN BY:- NITIN	DATE:- 28-09-2024 SCALE:- N.T.S. REV.:- R-00	NORTH:- S E W N
---	---------------------------------------	--	---	--	---	--	---	---	-------------------------------------

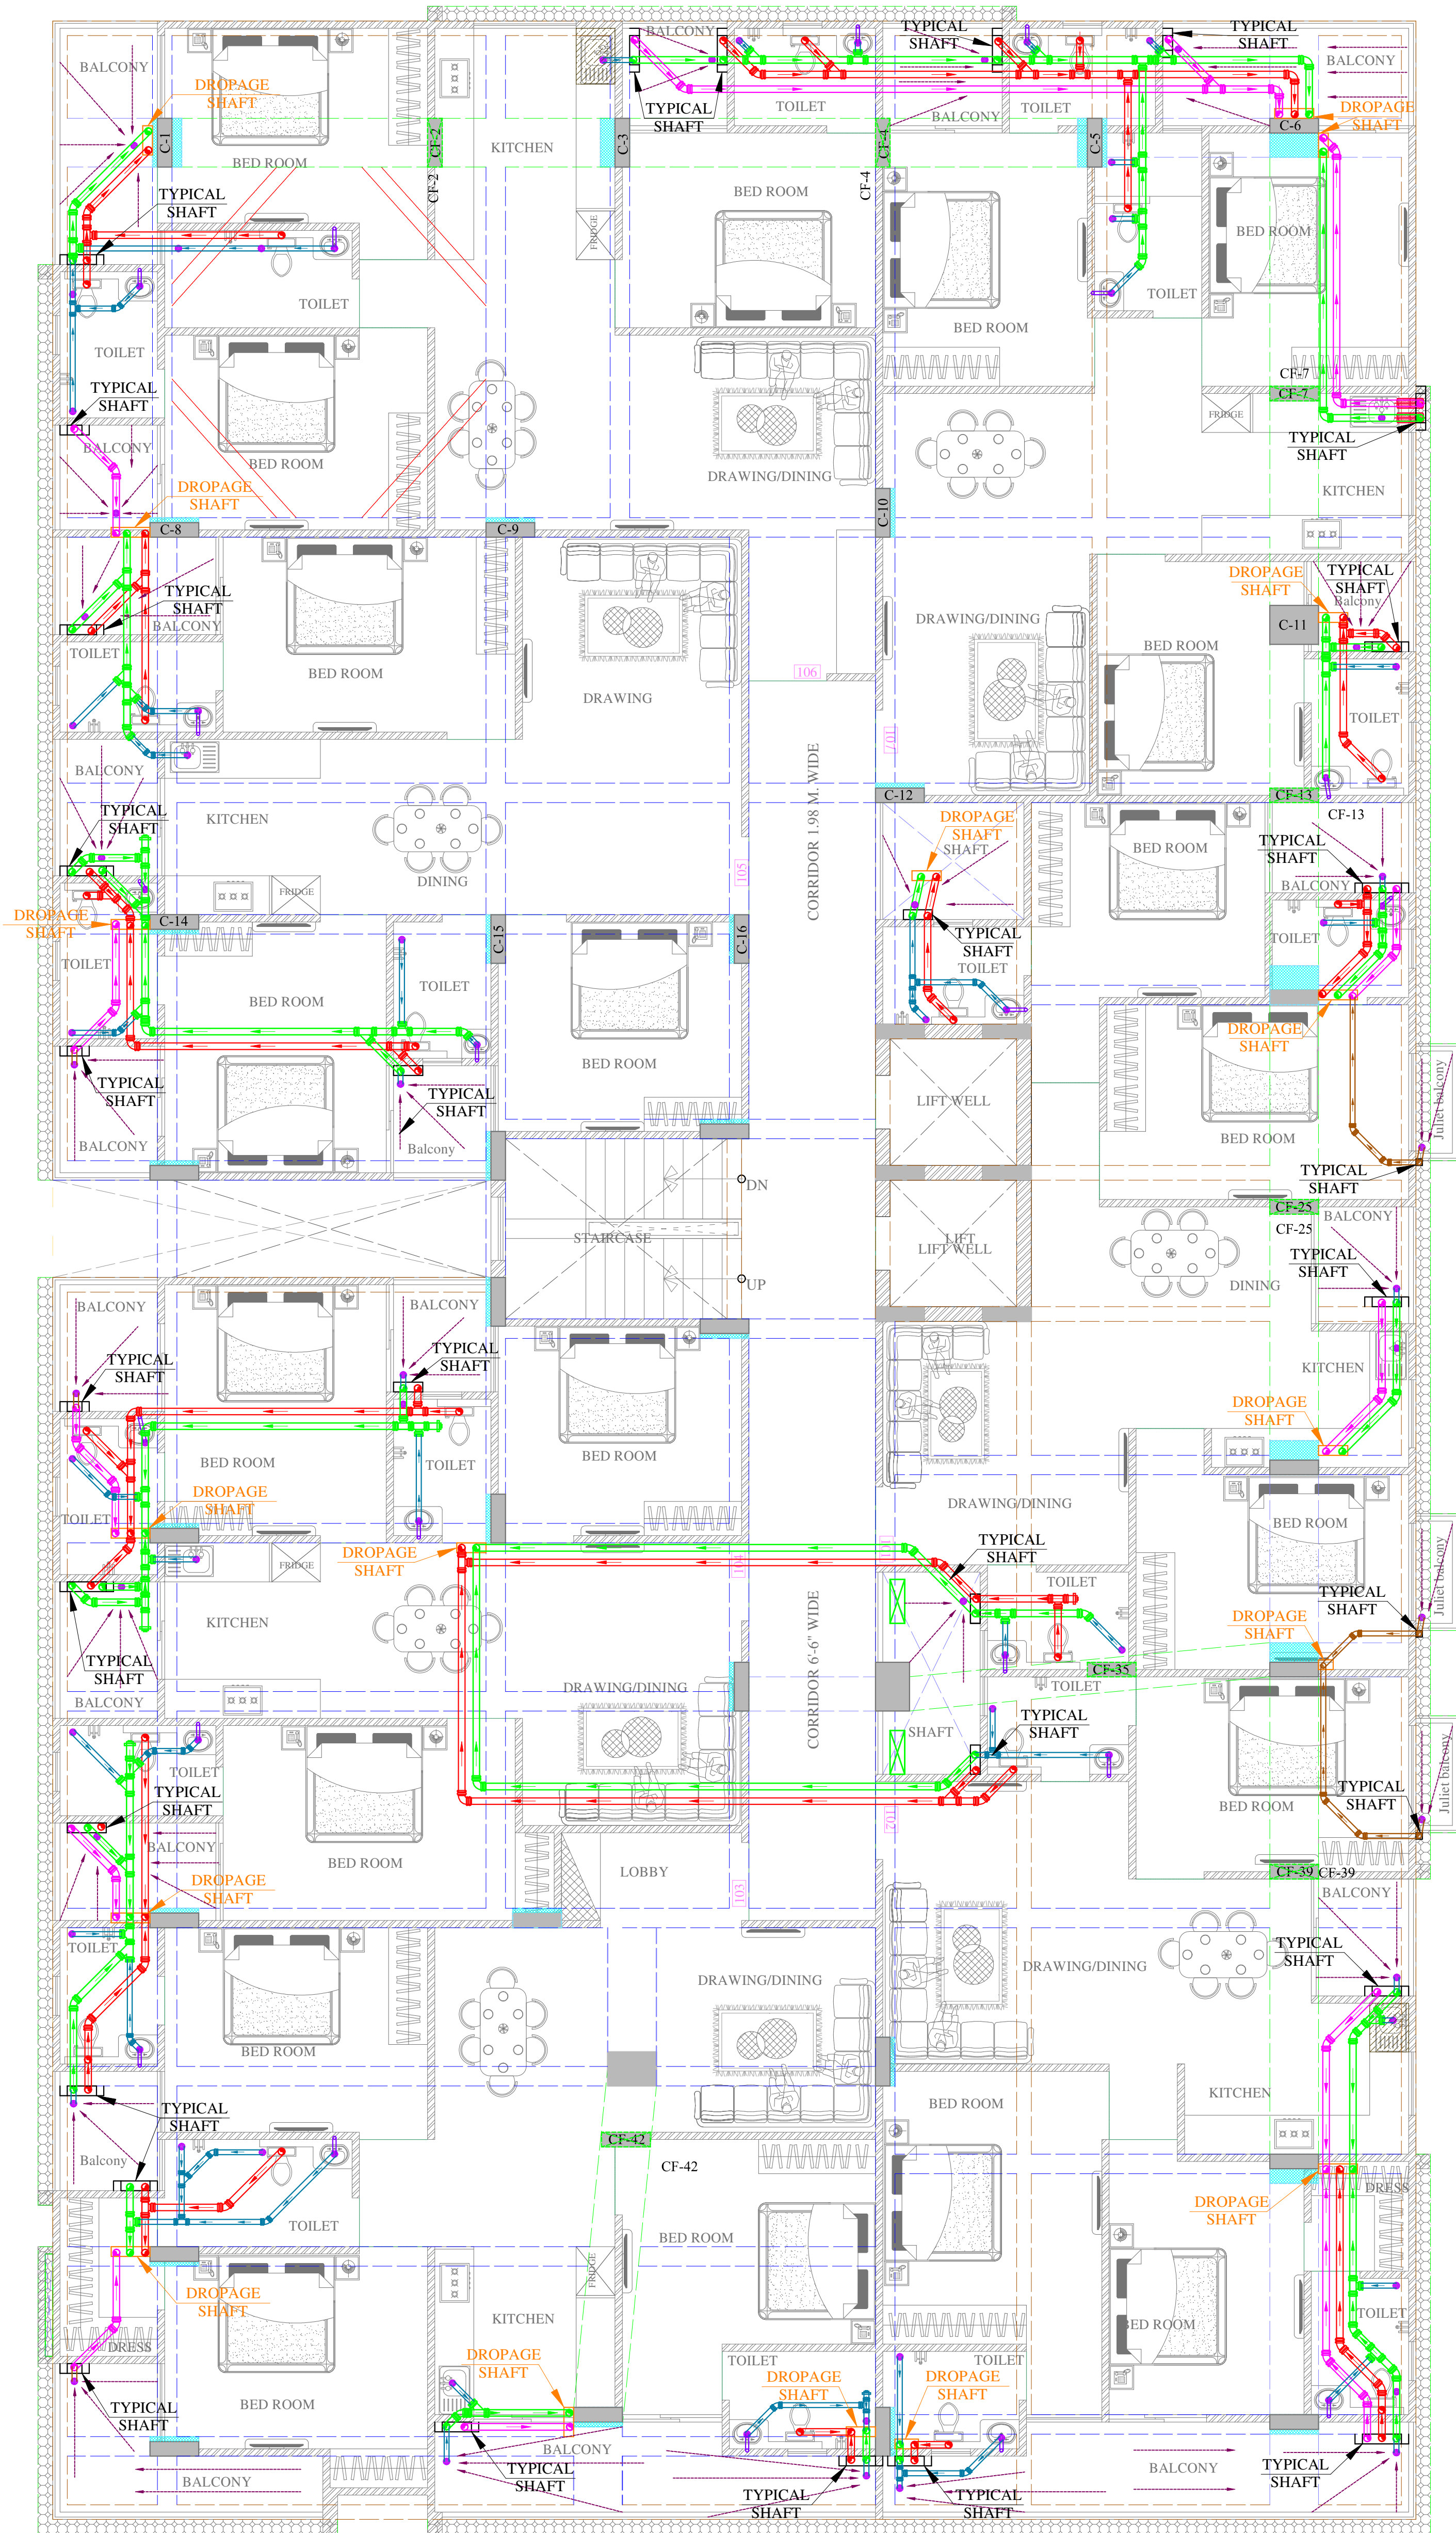

SYMBOL	DESCRIPTION
	Ø110 mm Soil Waste Water Pipe
	Ø110 mm Waste Water Pipe
	Ø110 mm Rain Water Pipe
	Ø110 mm Soil Waste Water Pipe Slope 1:150
	Ø110 mm Waste Water Pipe Slope 1:150
	Ø110 mm Rain Water Pipe Slope 1:200
	Ø75 mm Waste Water Pipe Internal Toilet Slope 1:150
	Ø75 mm Rain Water Pipe
	Ø40mm Waste Water Pipe Bottle Trap
	FLOOR TRAP
	Flow Direction
	6" Platform Raise

Vipul
VIPUL AGARWAL
M.E.P. CONSULTANT
B.E. ELECTRICAL

PROJECT NAME :- VINAYAK AASHIYANA	PROMOTER:- AGARWAL BUILDERS	PROJECT ADDRESS :- PLOT NO-46, SCHEME-24 (RAJAT VIHAR), MUTUL HOUSING CO. OP. SOCIETY, JAIPUR	PROJECT FOR REFERENCE:- AVINASH JI PLOT NO-46, SCHEME-24 (RAJAT VIHAR)	DRAWING: FIRST FLOOR DRAINAGE WITH DROPAGE LAYOUT PLAN	ARCHITECTS:- SPACE GRID C-49, VIDYA APARTMENT, PARAS MARG, BAPU NAGAR, NEAR JANTA STORE CIRCLE, JAIPUR-302015 PH-09314918766, 0141-4005506 (O) Email:-info.spacegrid@gmail.com	SERVICES CONSULTANT:- ASHI ASSOCIATES F 9 / 440 , Keshav Marg Chitrakut Scheme, Jaipur PH-91-0-93146-10438 ,0141-2440946 Mail:-vipul8599@yahoo.com	APPD BY:- VIPUL AGARWAL DEALT BY:- SANJAY DRAWN BY:- NITIN	DATE:- 04-10-2024 SCALE:- N.T.S. REV:- R-00	NORTH:-
---	---------------------------------------	--	---	---	---	---	---	--	-------------