



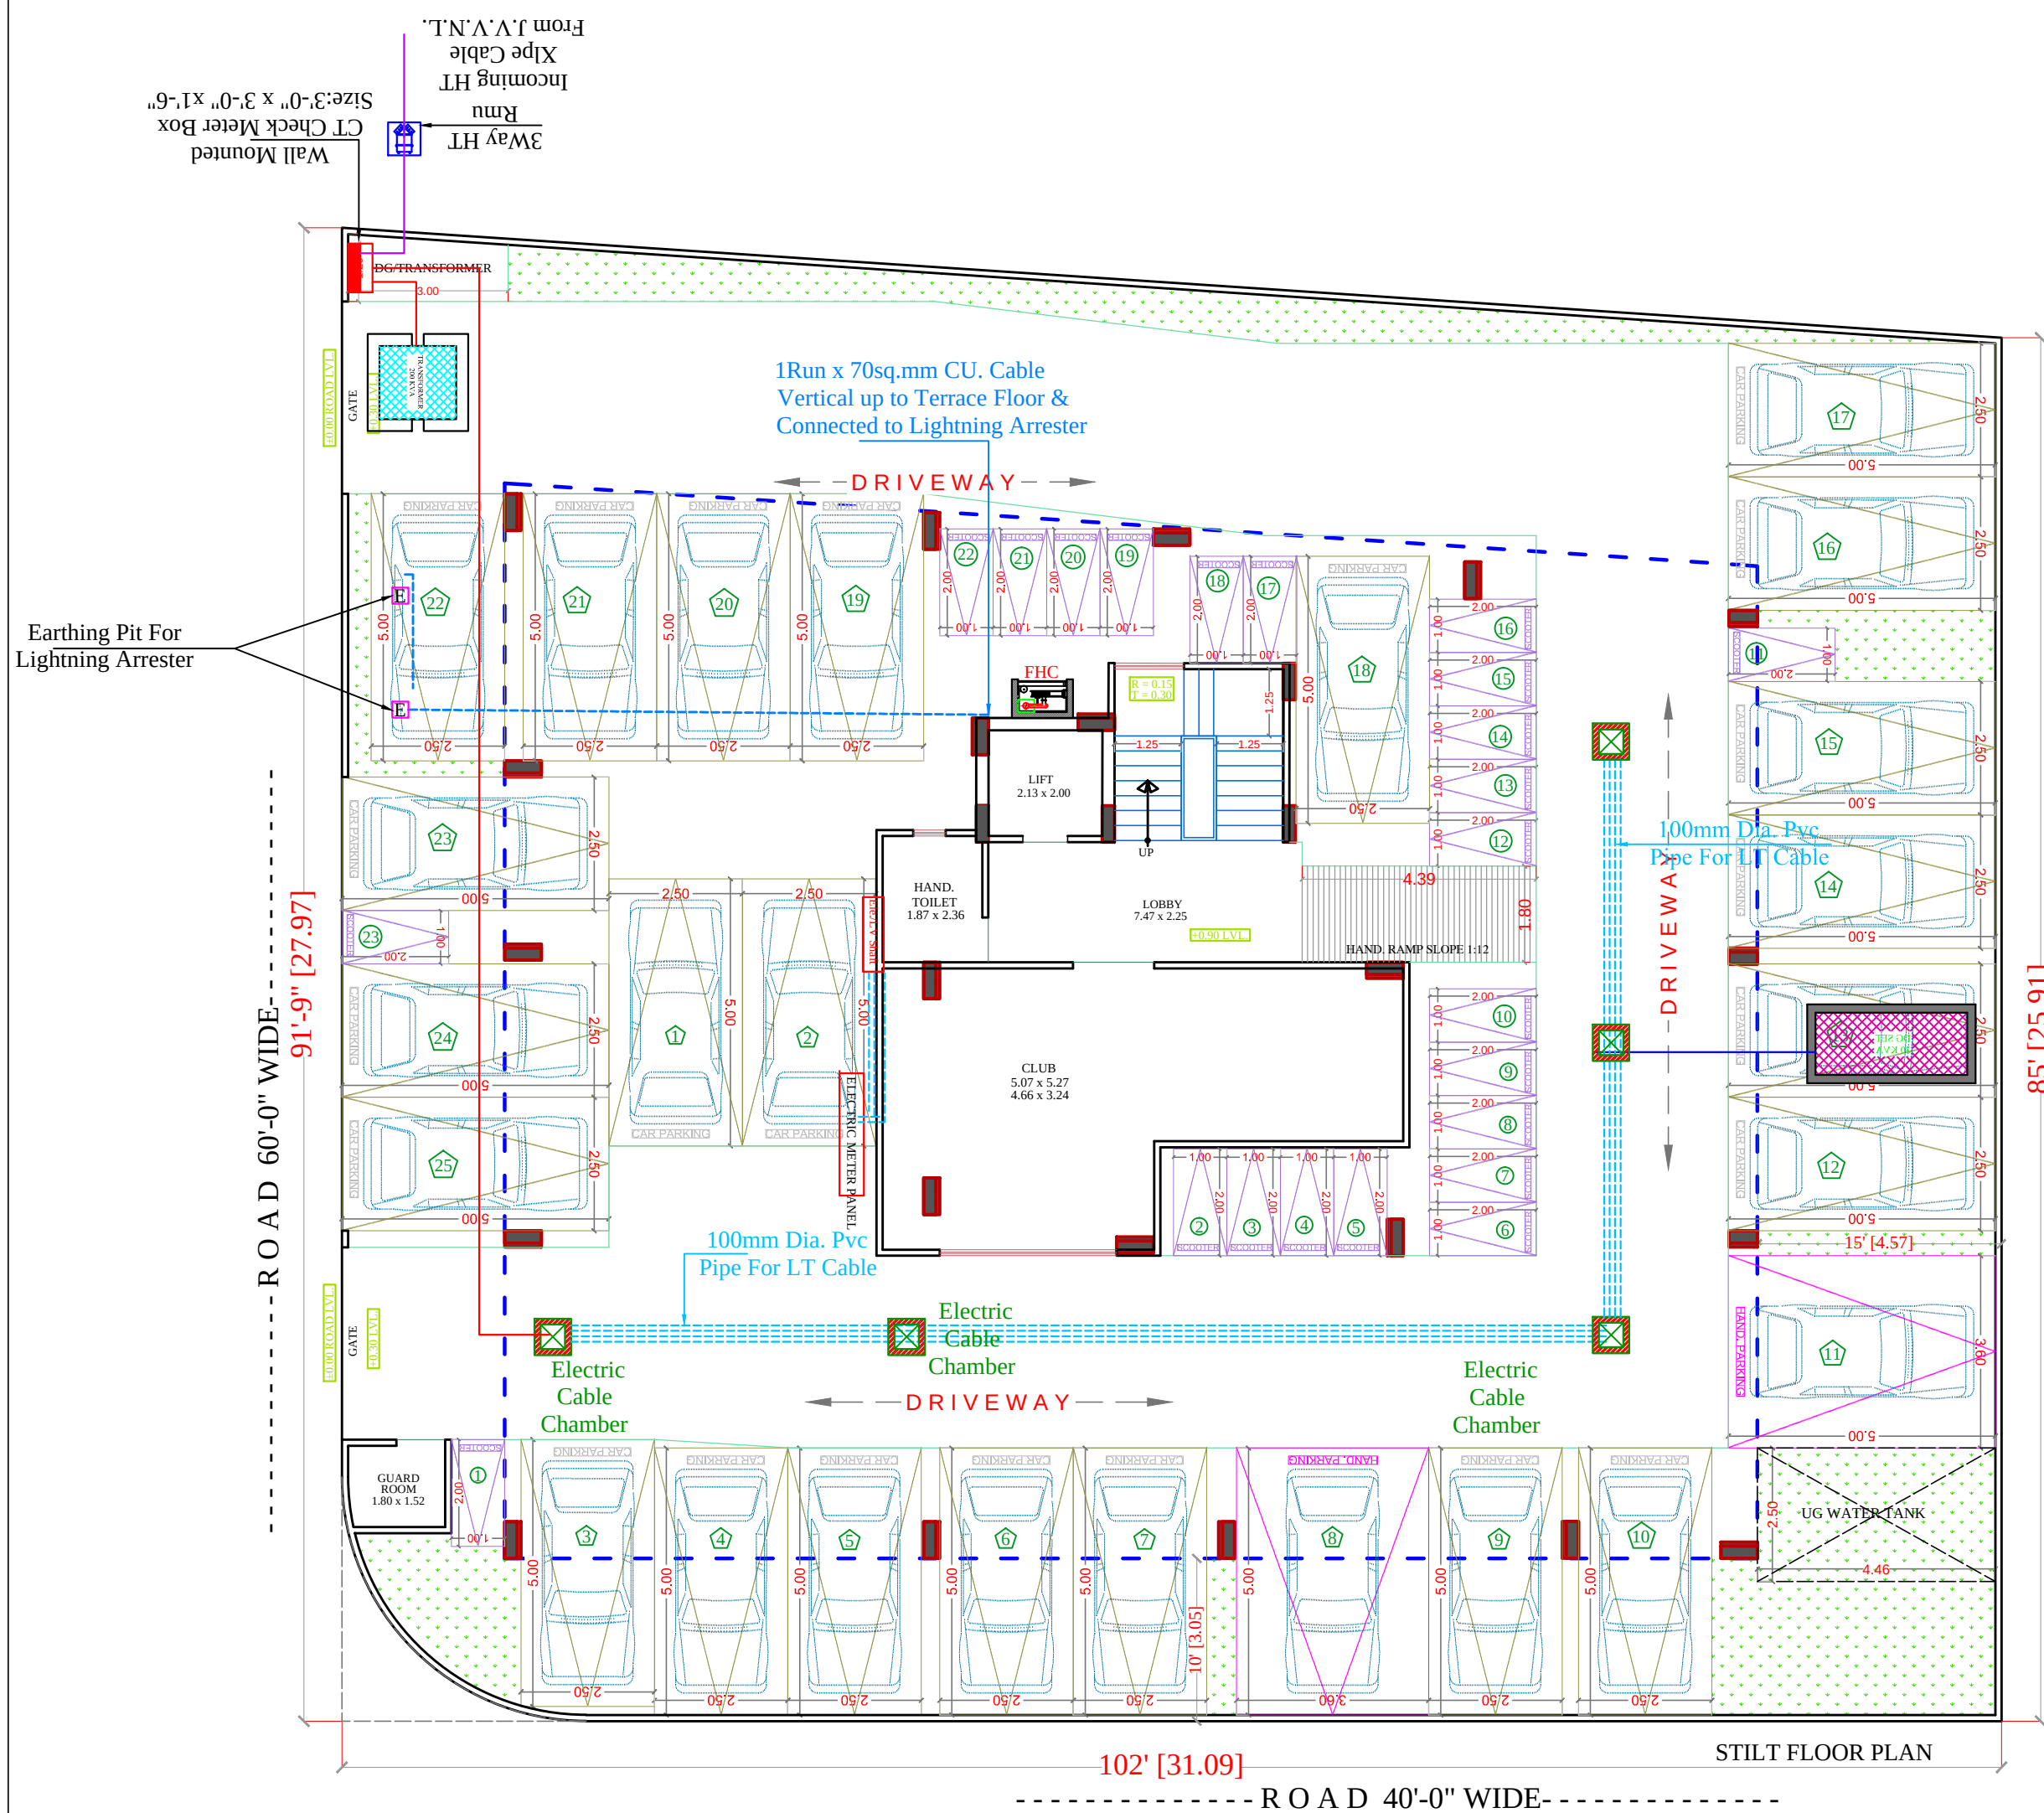

Lightning
Arrester

Model: Stormaster – ESE
- 30 (Level 2/Medium
Protection)
(Protection radius - 25M,
Mast Height -2 Mtr)

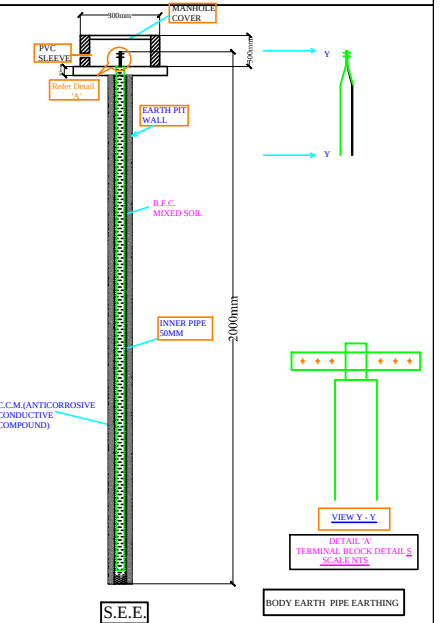

SIGN:-

SEAL:-



SPACE CONSULTANT

PLOT-A-173, JAGDAMBA NAGAR, HEERAPURA
POWER HOWER, JAIPUR (RAJ) 302024

ARCHITECT :-

FRANK SQUARE

ARCHITECTURE | PLANNER | DESIGNER
C-49 VIDYA APARTMENT PARAS MARG,
BAPU NAGAR JAIPUR, (RAJ.)
Email-franksquare@gmail.com
Mobile-9461302542

PROJECT :-

PROPOSED BUILDING AT PLOT
NO.-A1 & A2, NARAYANPURI-A,
JAIPUR


DRAWING:

STILT FLOOR
ELECTRIC SUB STATION,
CABLE ROUTE &
LIGHTNING ARRESTER FOR
RERA SUBMISSION PLAN

DATE

SCALE:-

N.T.S.

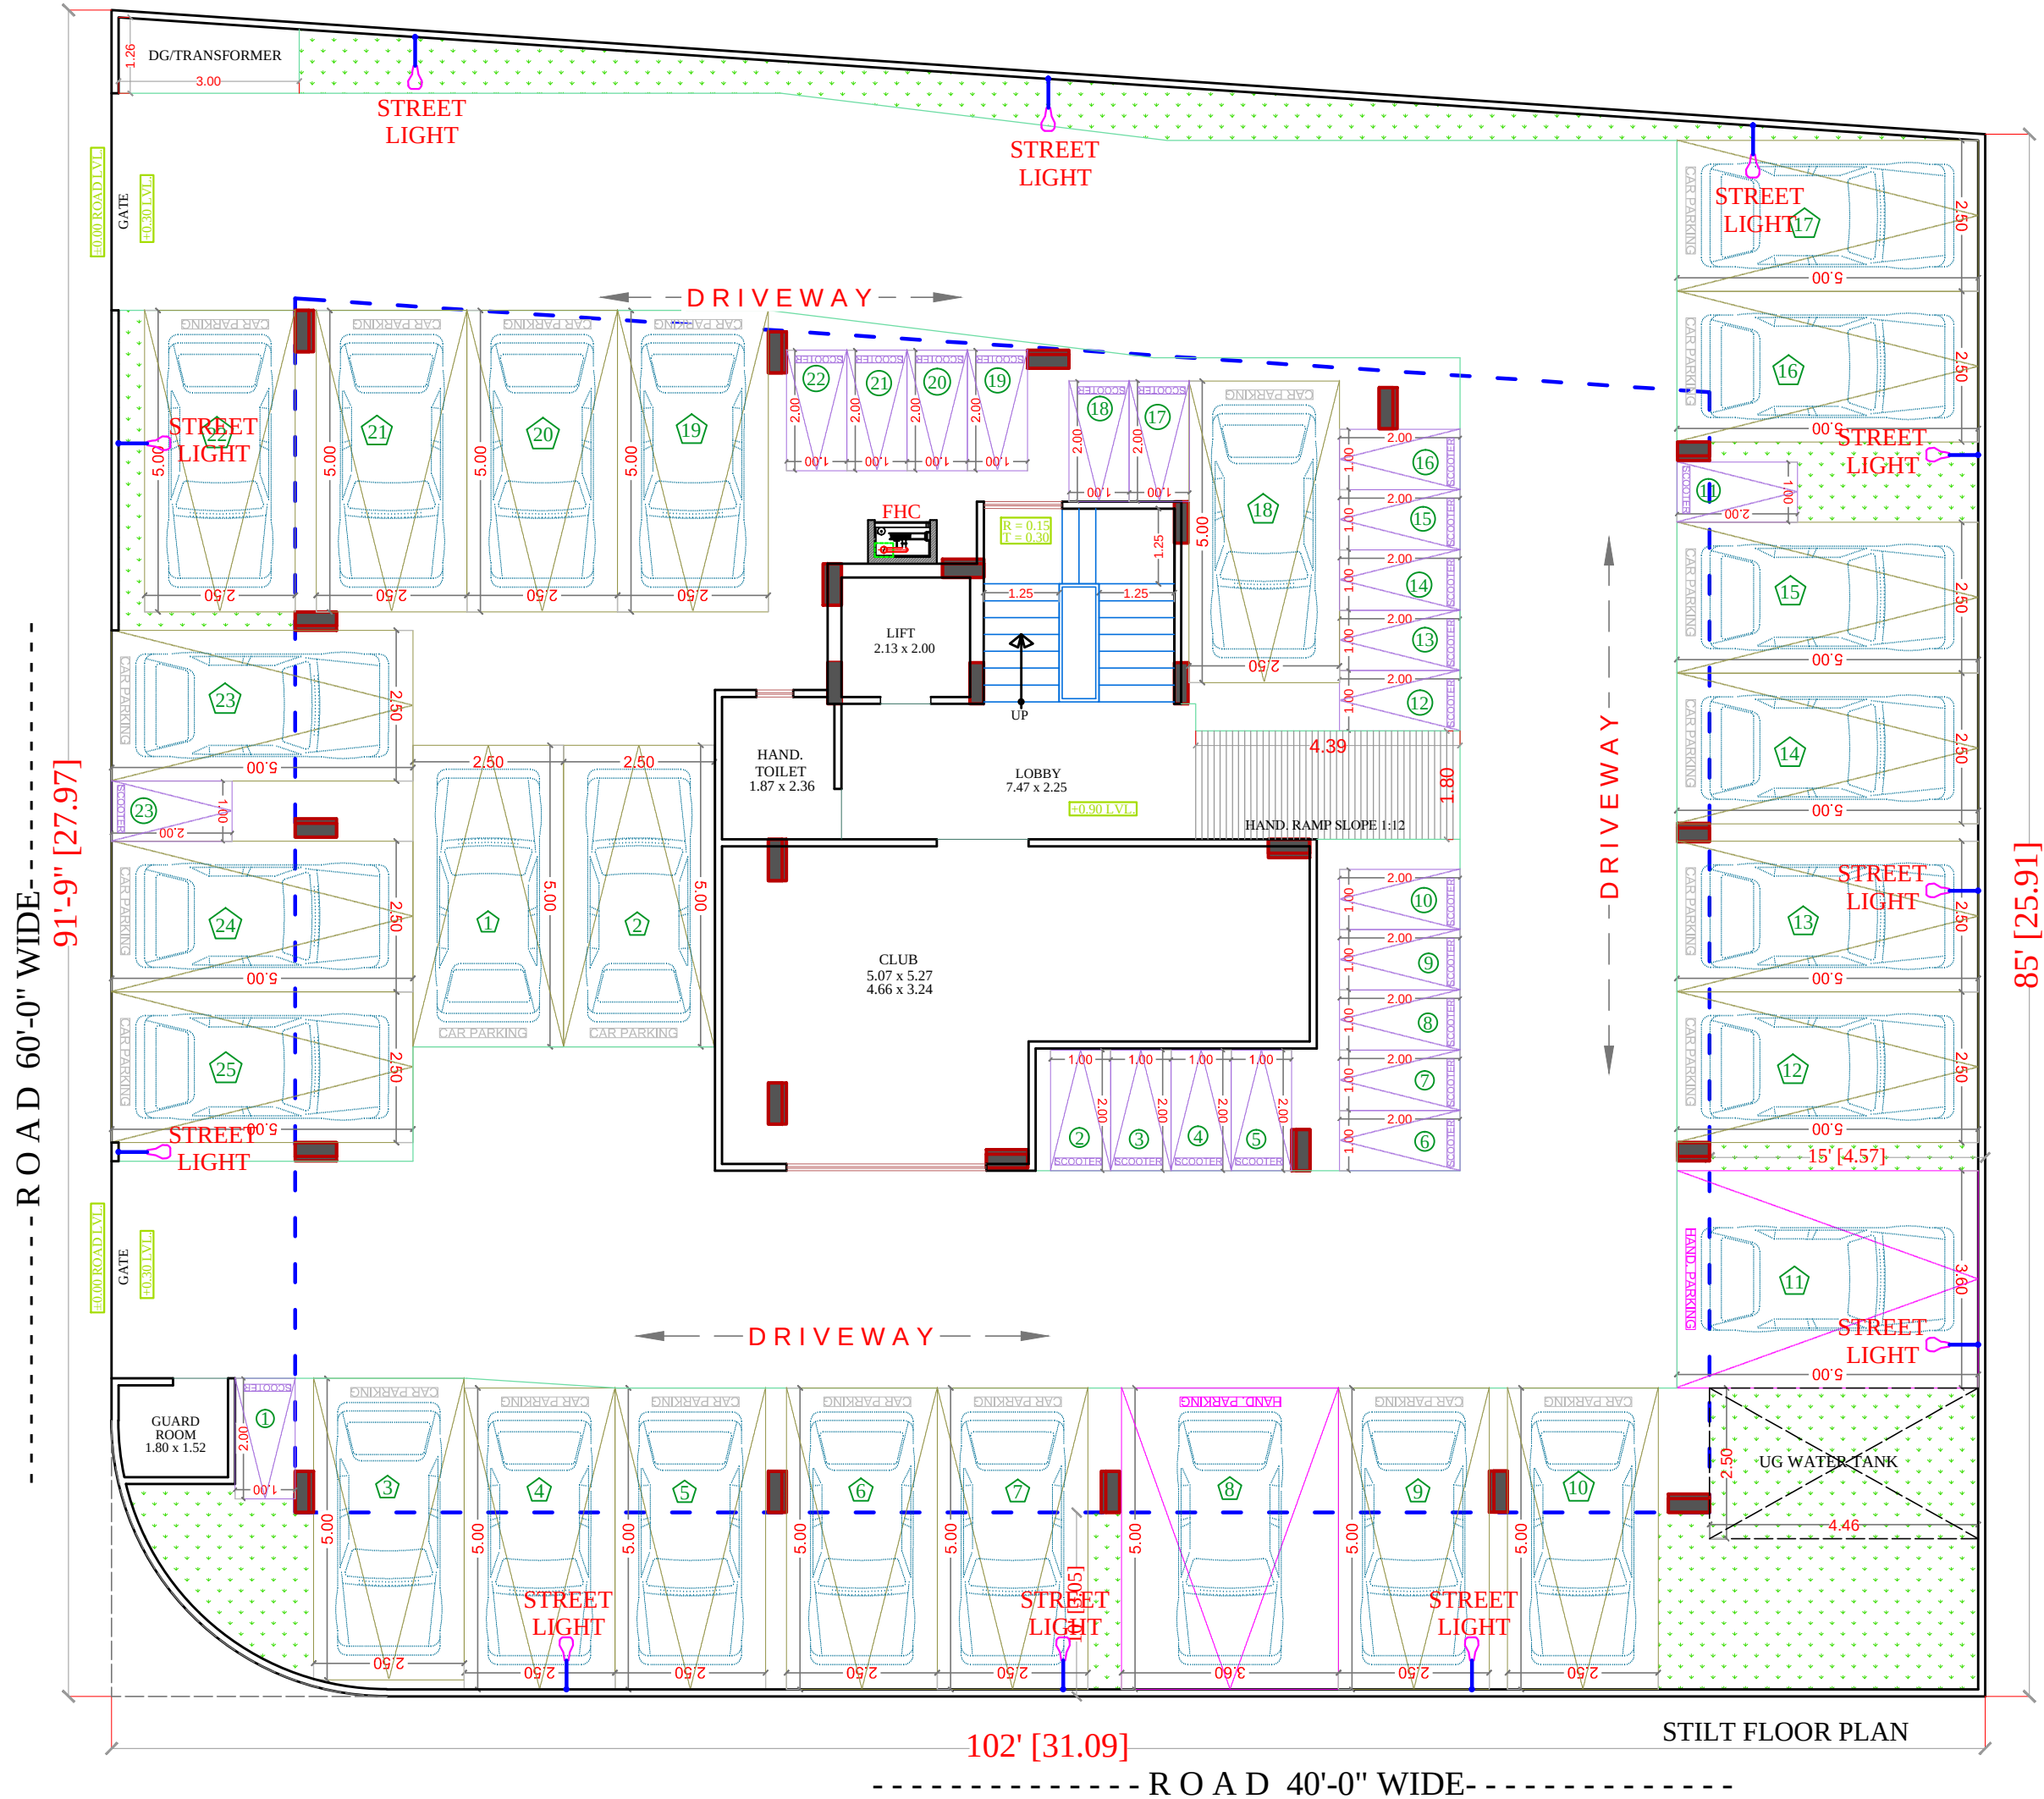

LEGENDS:

Qty.	I D	Symbol	Description
14	PL		STREET LIGHT

SIGN:- SEAL:-



SPACE CONSULTANT

PLOT-A-173, JAGDAMBA NAGAR, HEERAPURA
POWER HOWER, JAIPUR (RAJ) 302024

ARCHITECT :-

FRANK SQUARE

ARCHITECTURE | PLANNER | DESIGNER
C-49 VIDYA APARTMENT PARAS MARG,
BAPU NAGAR JAIPUR, (RAJ.)
Email-franksquare@gmail.com
Mobile-9461302542

PROJECT :-

PROPOSED BUILDING AT PLOT
NO.-A1 & A2, NARAYANPURI-A,
JAIPUR

DRAWING:

STILT FLOOR
EXTERNAL STREET LIGHT
FOR RERA SUBMISSION PLAN

DATE
18-08-2023

SCALE:-
N.T.S.




24/2

Space Consultant
S No
016180
B Tech (Civil)

GROUND TO FORTH FLOOR ELECTRIC PLAN

PROJECT TITLE :- PROPOSED BUILDING AT PLOT NO.-A1 & A2, NARAYANPURI-A, JAIPUR	SPACE CONSULTANT PLOT-A-173, JAGDAMBA NAGAR, HEERAPURA POWER HOWER, JAIPUR (RAJ) 302024	DRN. BY		DATE	
		APPD. BY		REVISION	
		SCALE	N.T.S		

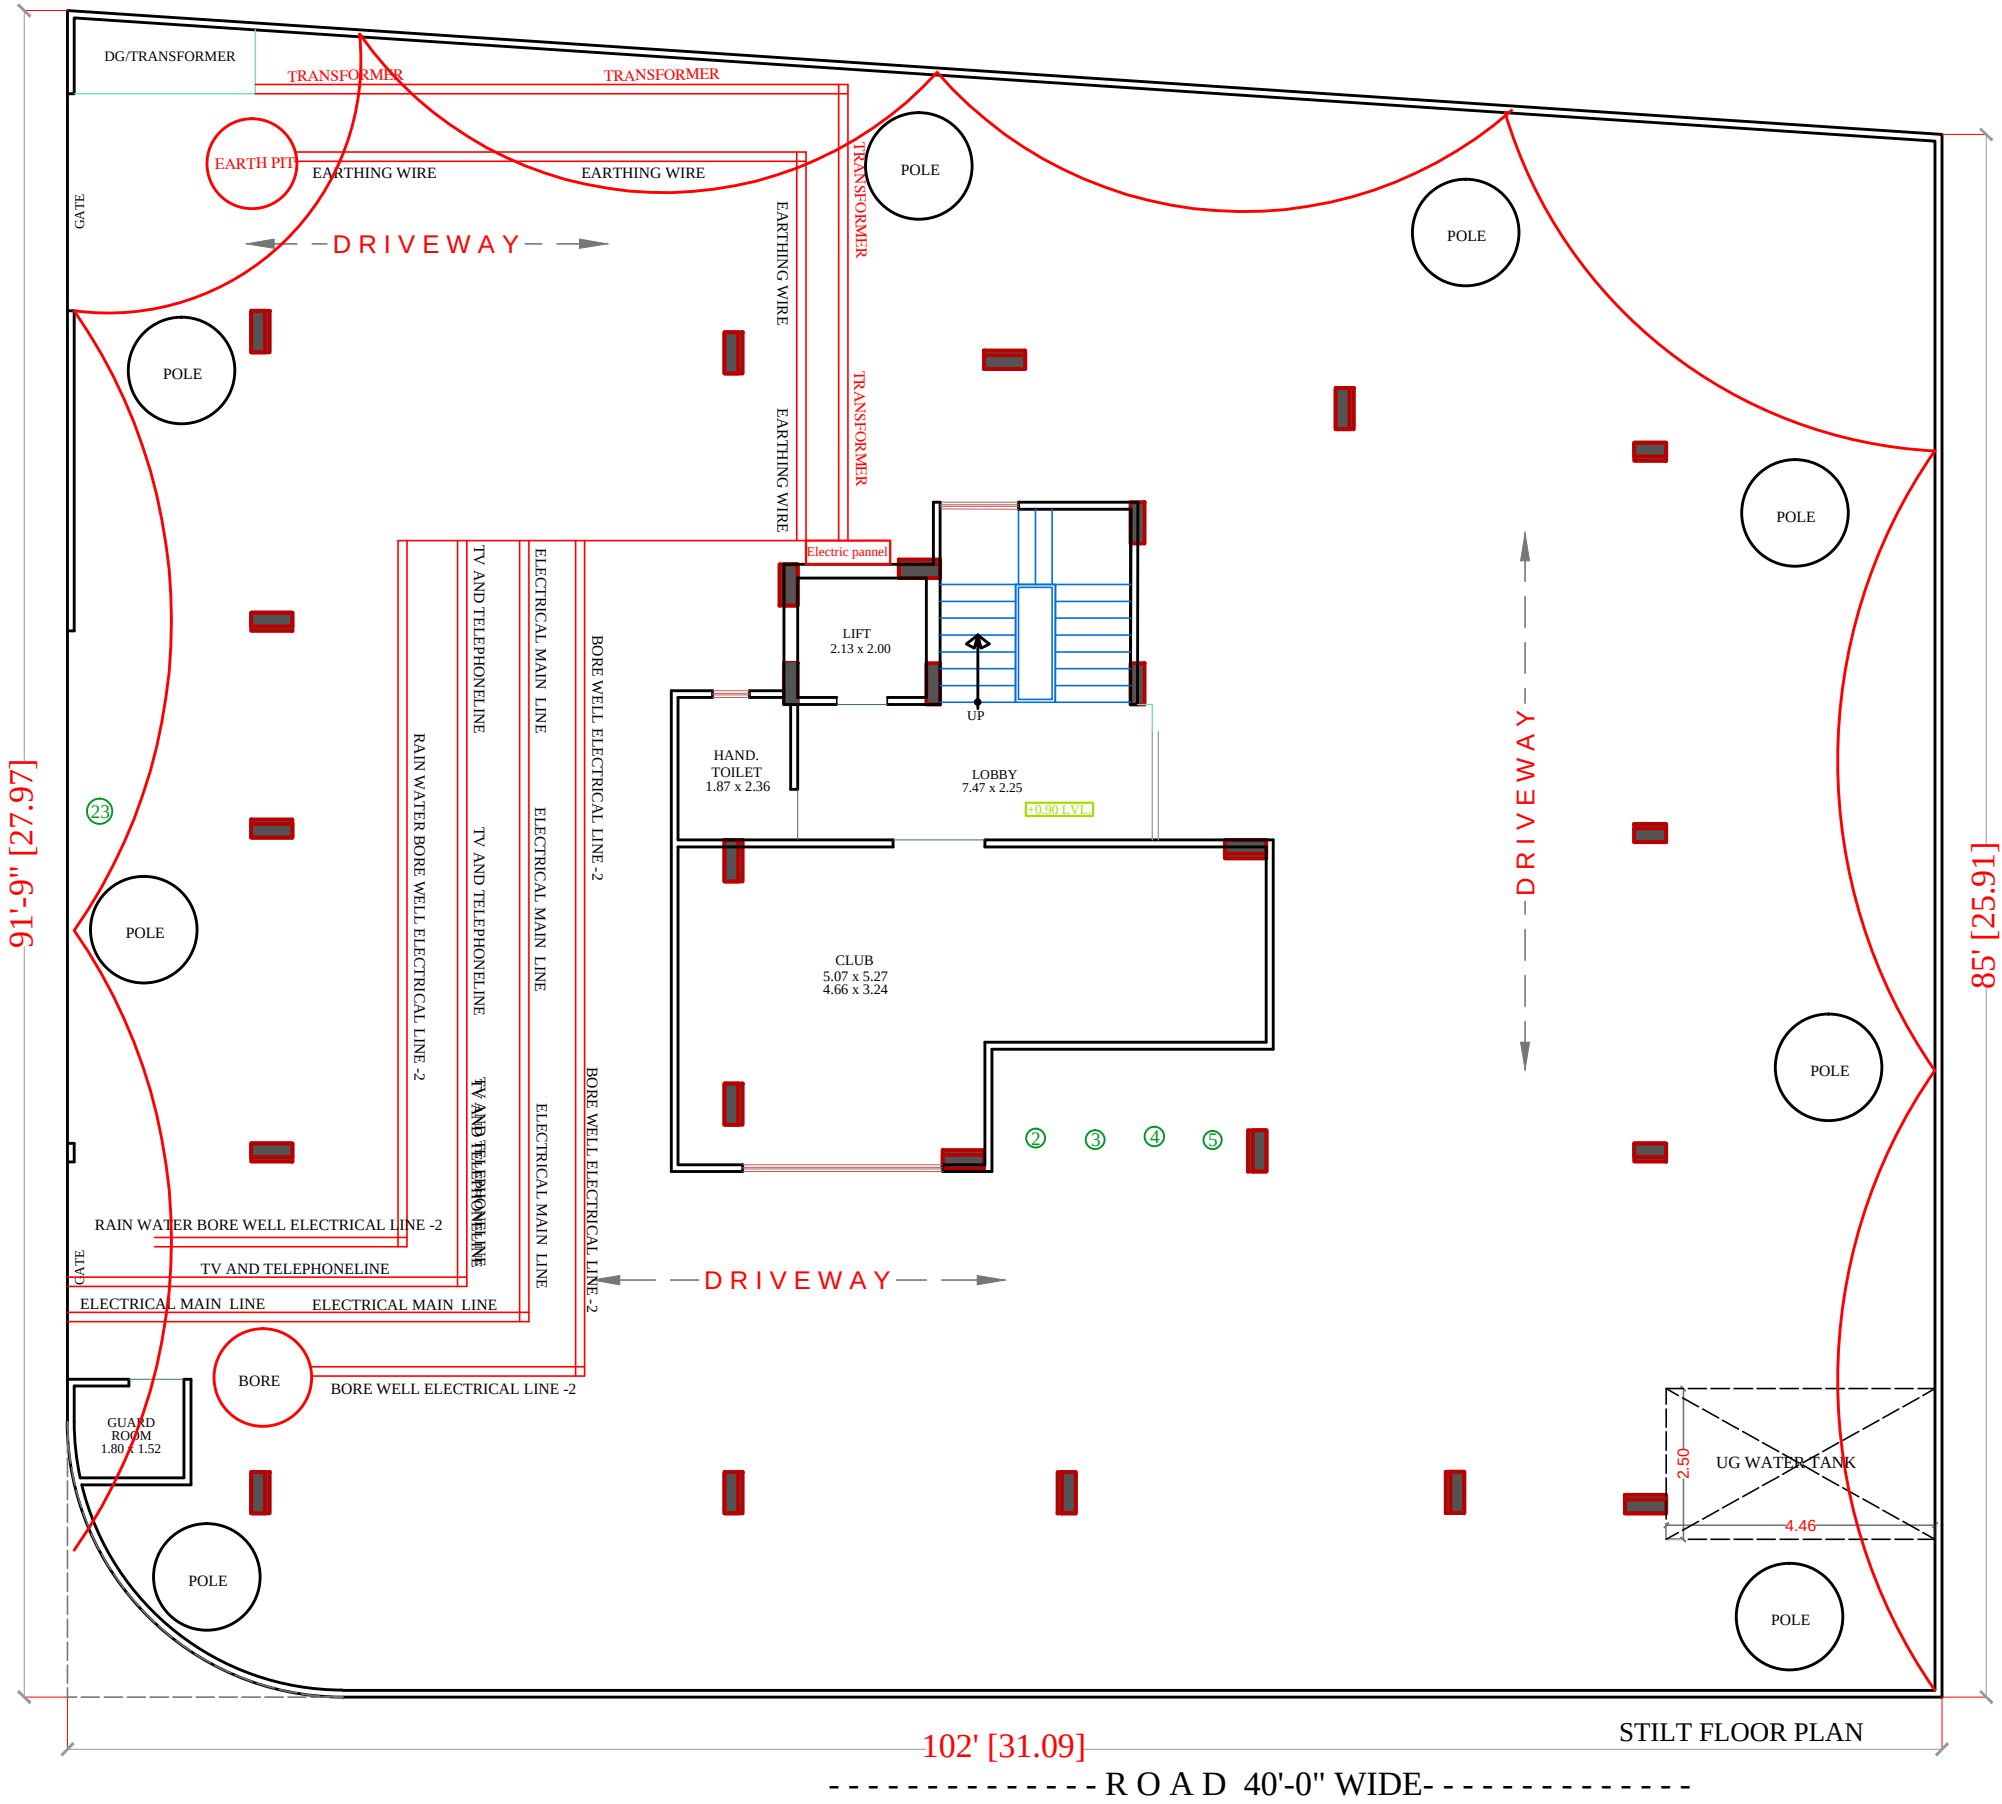

NO	ITEM	SYMBOL
1	CEILING FAN	ROOF
2	TUBE LIGHT	+8'6"
3	BULB	+8'6"
4	POWER POINT	+1'6"
5	BED POINT	+4'3"
6	CEILING LIGHT	ROOF
7	A.C.POINT	+6'6"
8	SWITCH BOARD	+4'3"
9	EXHAUST	VENT
10	TELEPHONE	+1'6"
11	GYSER	+6'0"
12	BELL POINT	+8'6"
13	T.V.	+1'6"
14	M.BOX	M.B
15	M.C.B.	M.C.B
16	FANCY LIGHT	+8'6"
17	HANGING LIGHT	ROOF

STILT (PARKING) FLOOR PLAN



PROJECT TITLE :-

PROPOSED BUILDING AT PLOT NO.-A1 & A2, NARAYANPURI-A, JAIPUR

DRAWING TITLE :-

SERVICE DRAWING SLD/DISTRIBUTION AFTER LT PANEL, EARTHING LAYOUT,EXTERNAL LIGHTING PLAN, TV & TELEPHONE RISER,LIGHTING ARRESTR, & PIT LOCATION COMMON AREA TRANSFORMER

SPACE CONSULTANT

PLOT-A-173, JAGDAMBA NAGAR, HEERAPURA POWER HOWER, JAIPUR (RAJ) 302024

DRN. BY

APPD. BY

SCALE


DATE

REVISION

N.T.S

NORTH



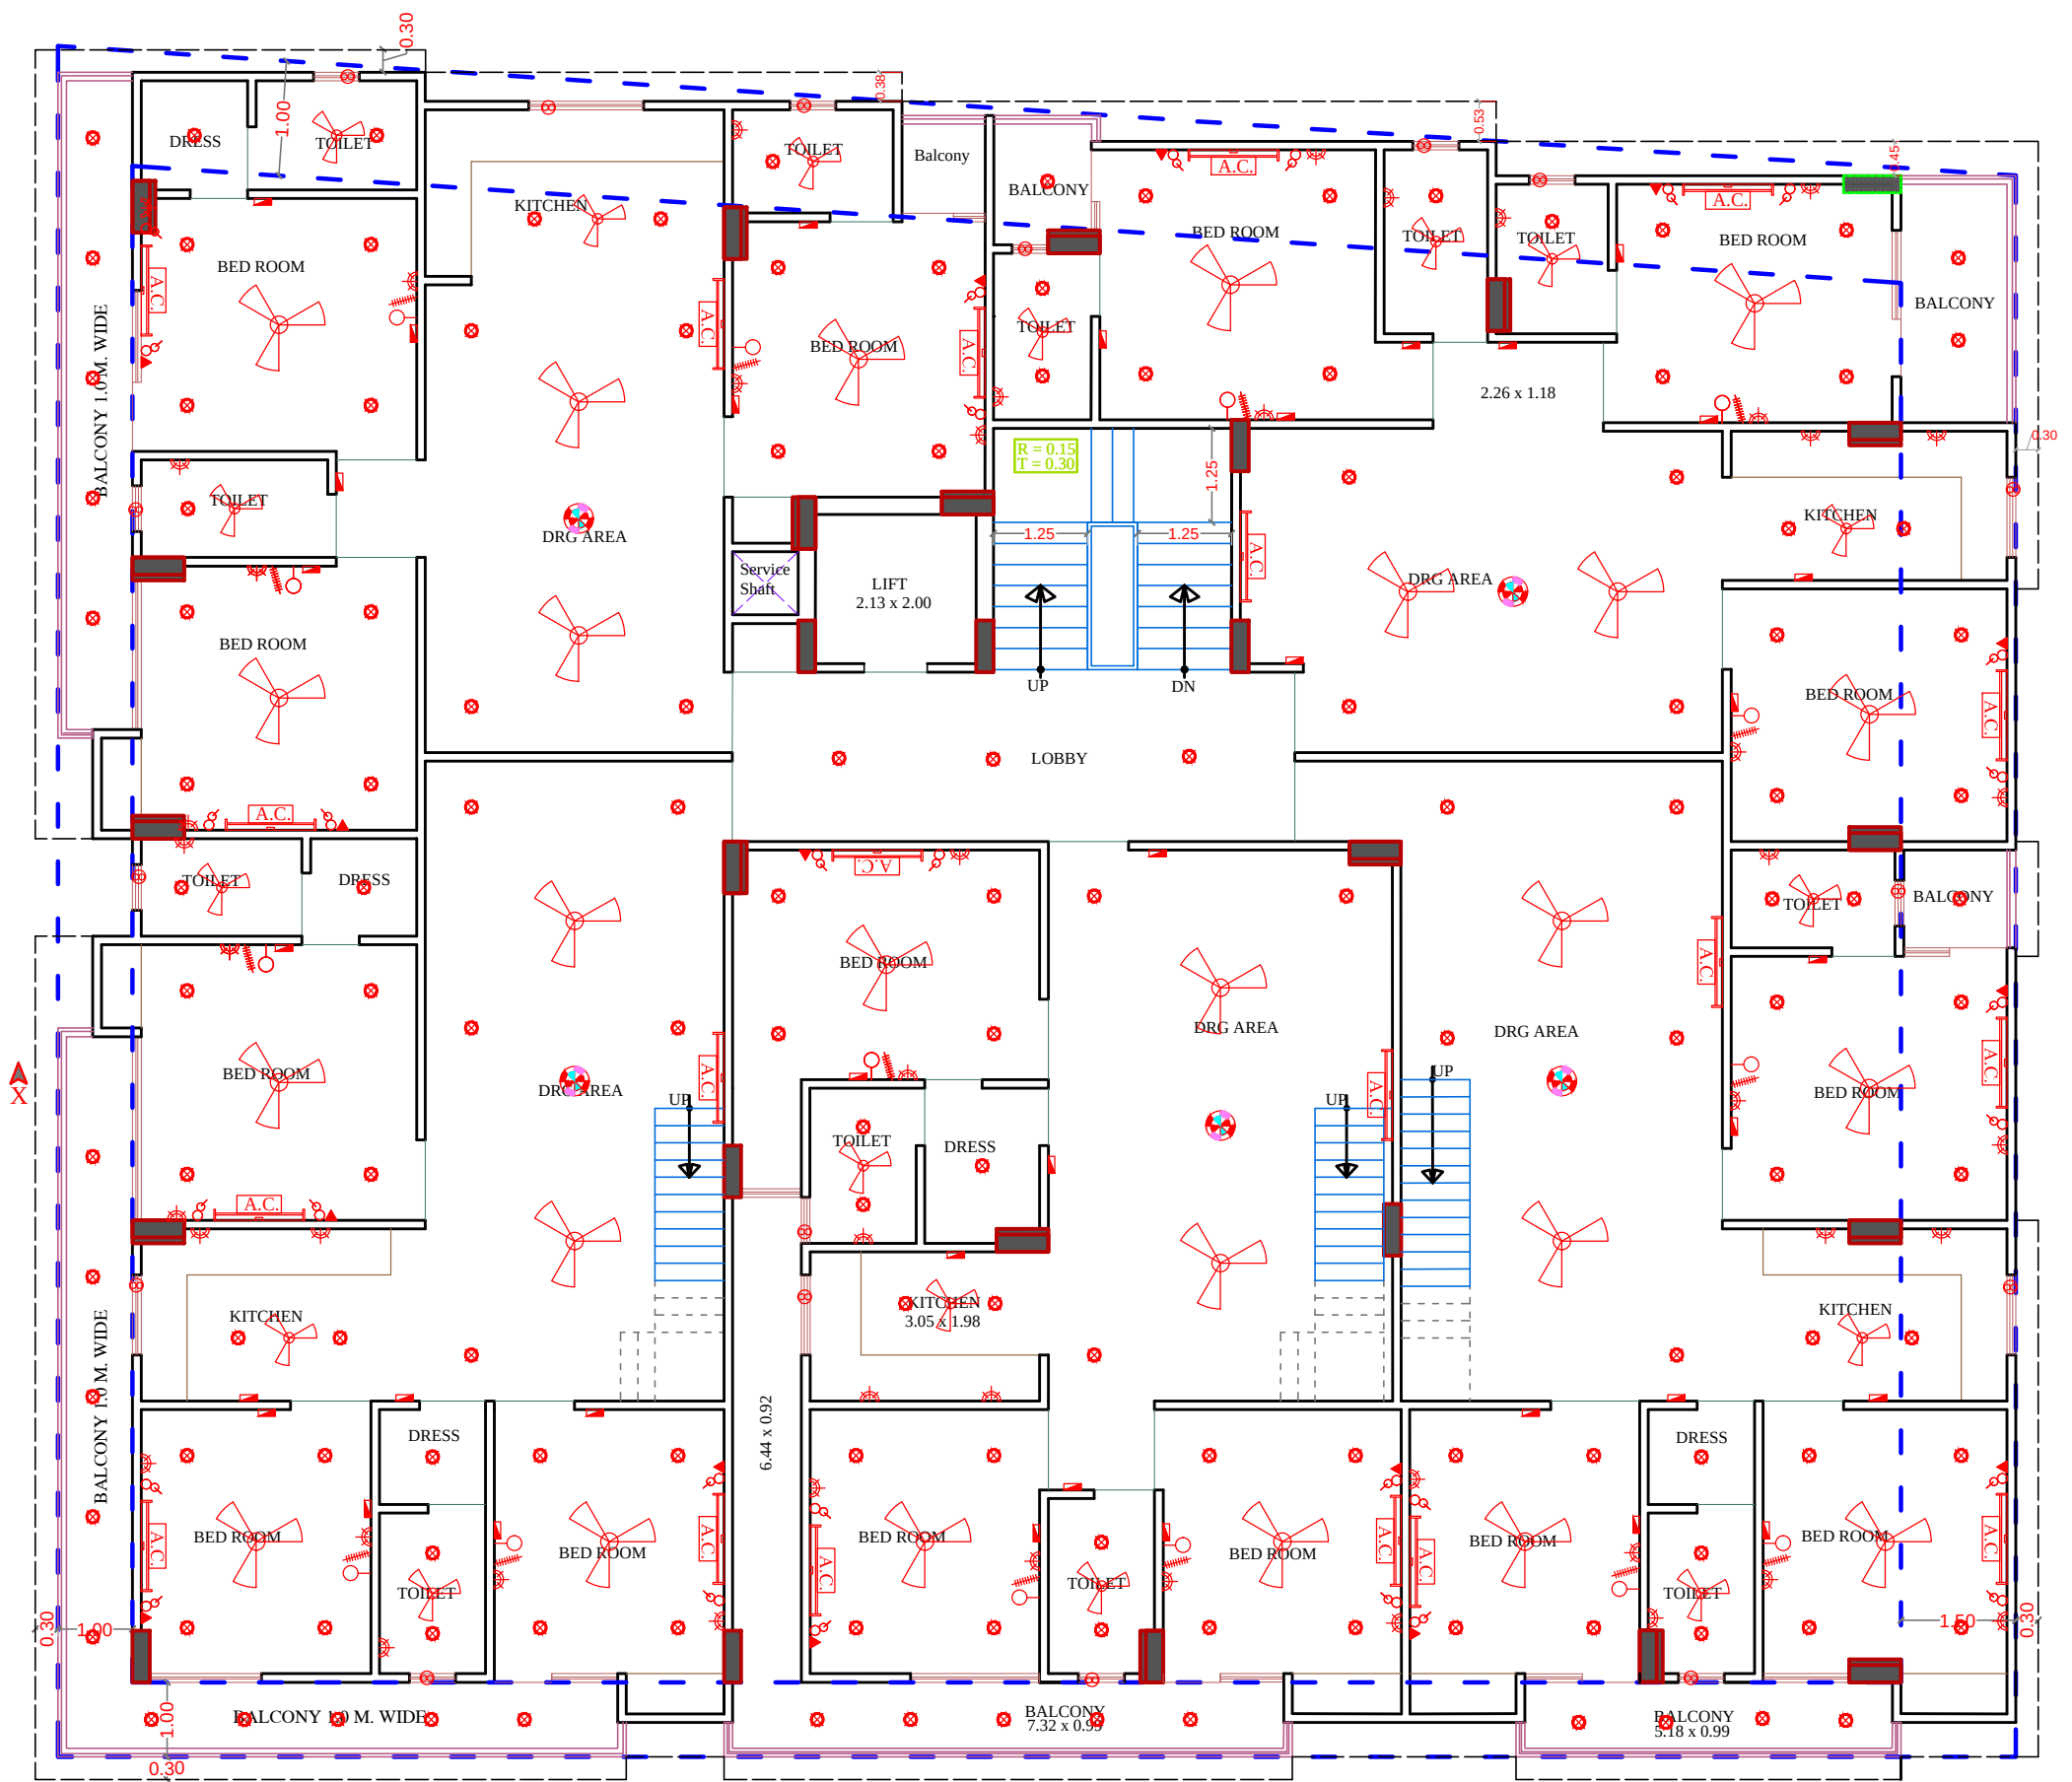

5th FLOOR PLAN



FIFTH FLOOR ELECTRIC PLAN

PROJECT TITLE :- PROPOSED BUILDING AT PLOT NO.-A1 & A2, NARAYANPURI-A, JAIPUR	<u>SPACE CONSULTANT</u> PLOT-A-173, JAGDAMBA NAGAR, HEERAPURA POWER HOWER, JAIPUR (RAJ) 302024	DRN. BY		DATE
		APPD. BY		24-02-2023
		SCALE	N.T.S	REVISION
				