




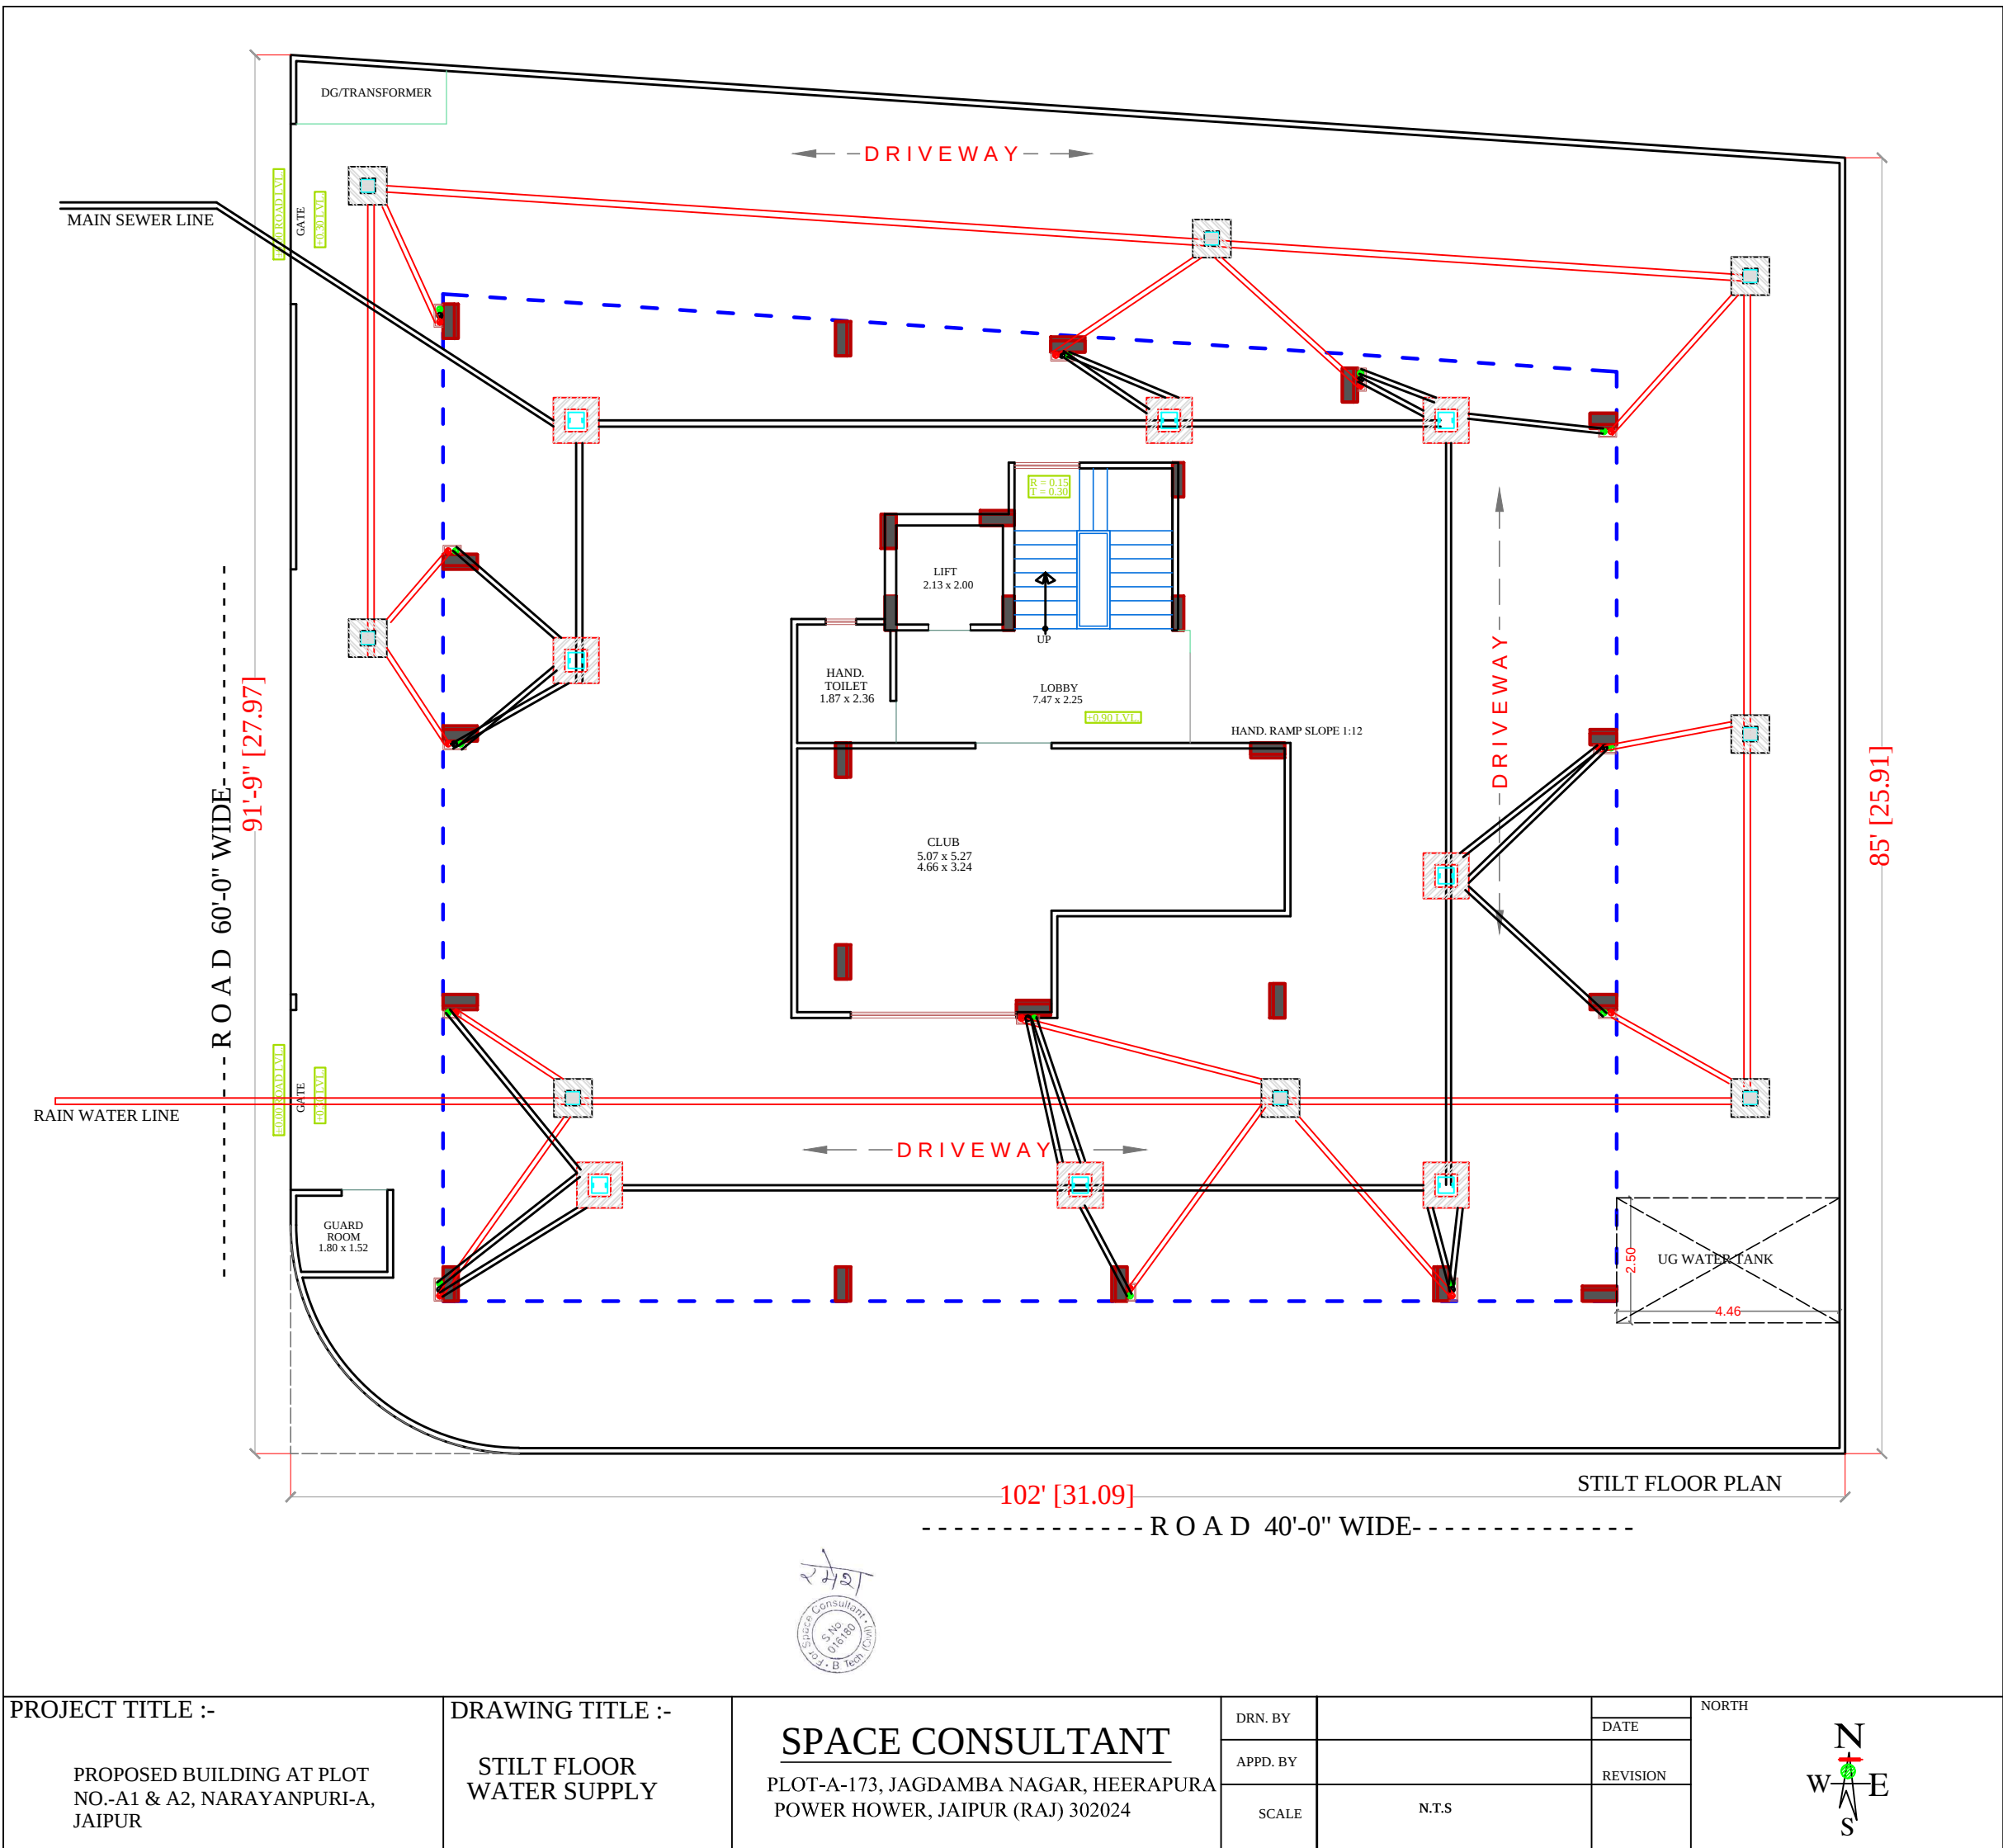

PROJECT TITLE :- PROPOSED BUILDING AT PLOT NO.-A1 & A2, NARAYANPURI-A, JAIPUR	DRAWING TITLE :- STILT FLOOR WATER SUPPLY	SPACE CONSULTANT PLOT-A-173, JAGDAMBA NAGAR, HEERAPURA POWER HOWER, JAIPUR (RAJ) 302024	DRN. BY		DATE	NORTH 
			APPD. BY		REVISION	
			SCALE	N.T.S		

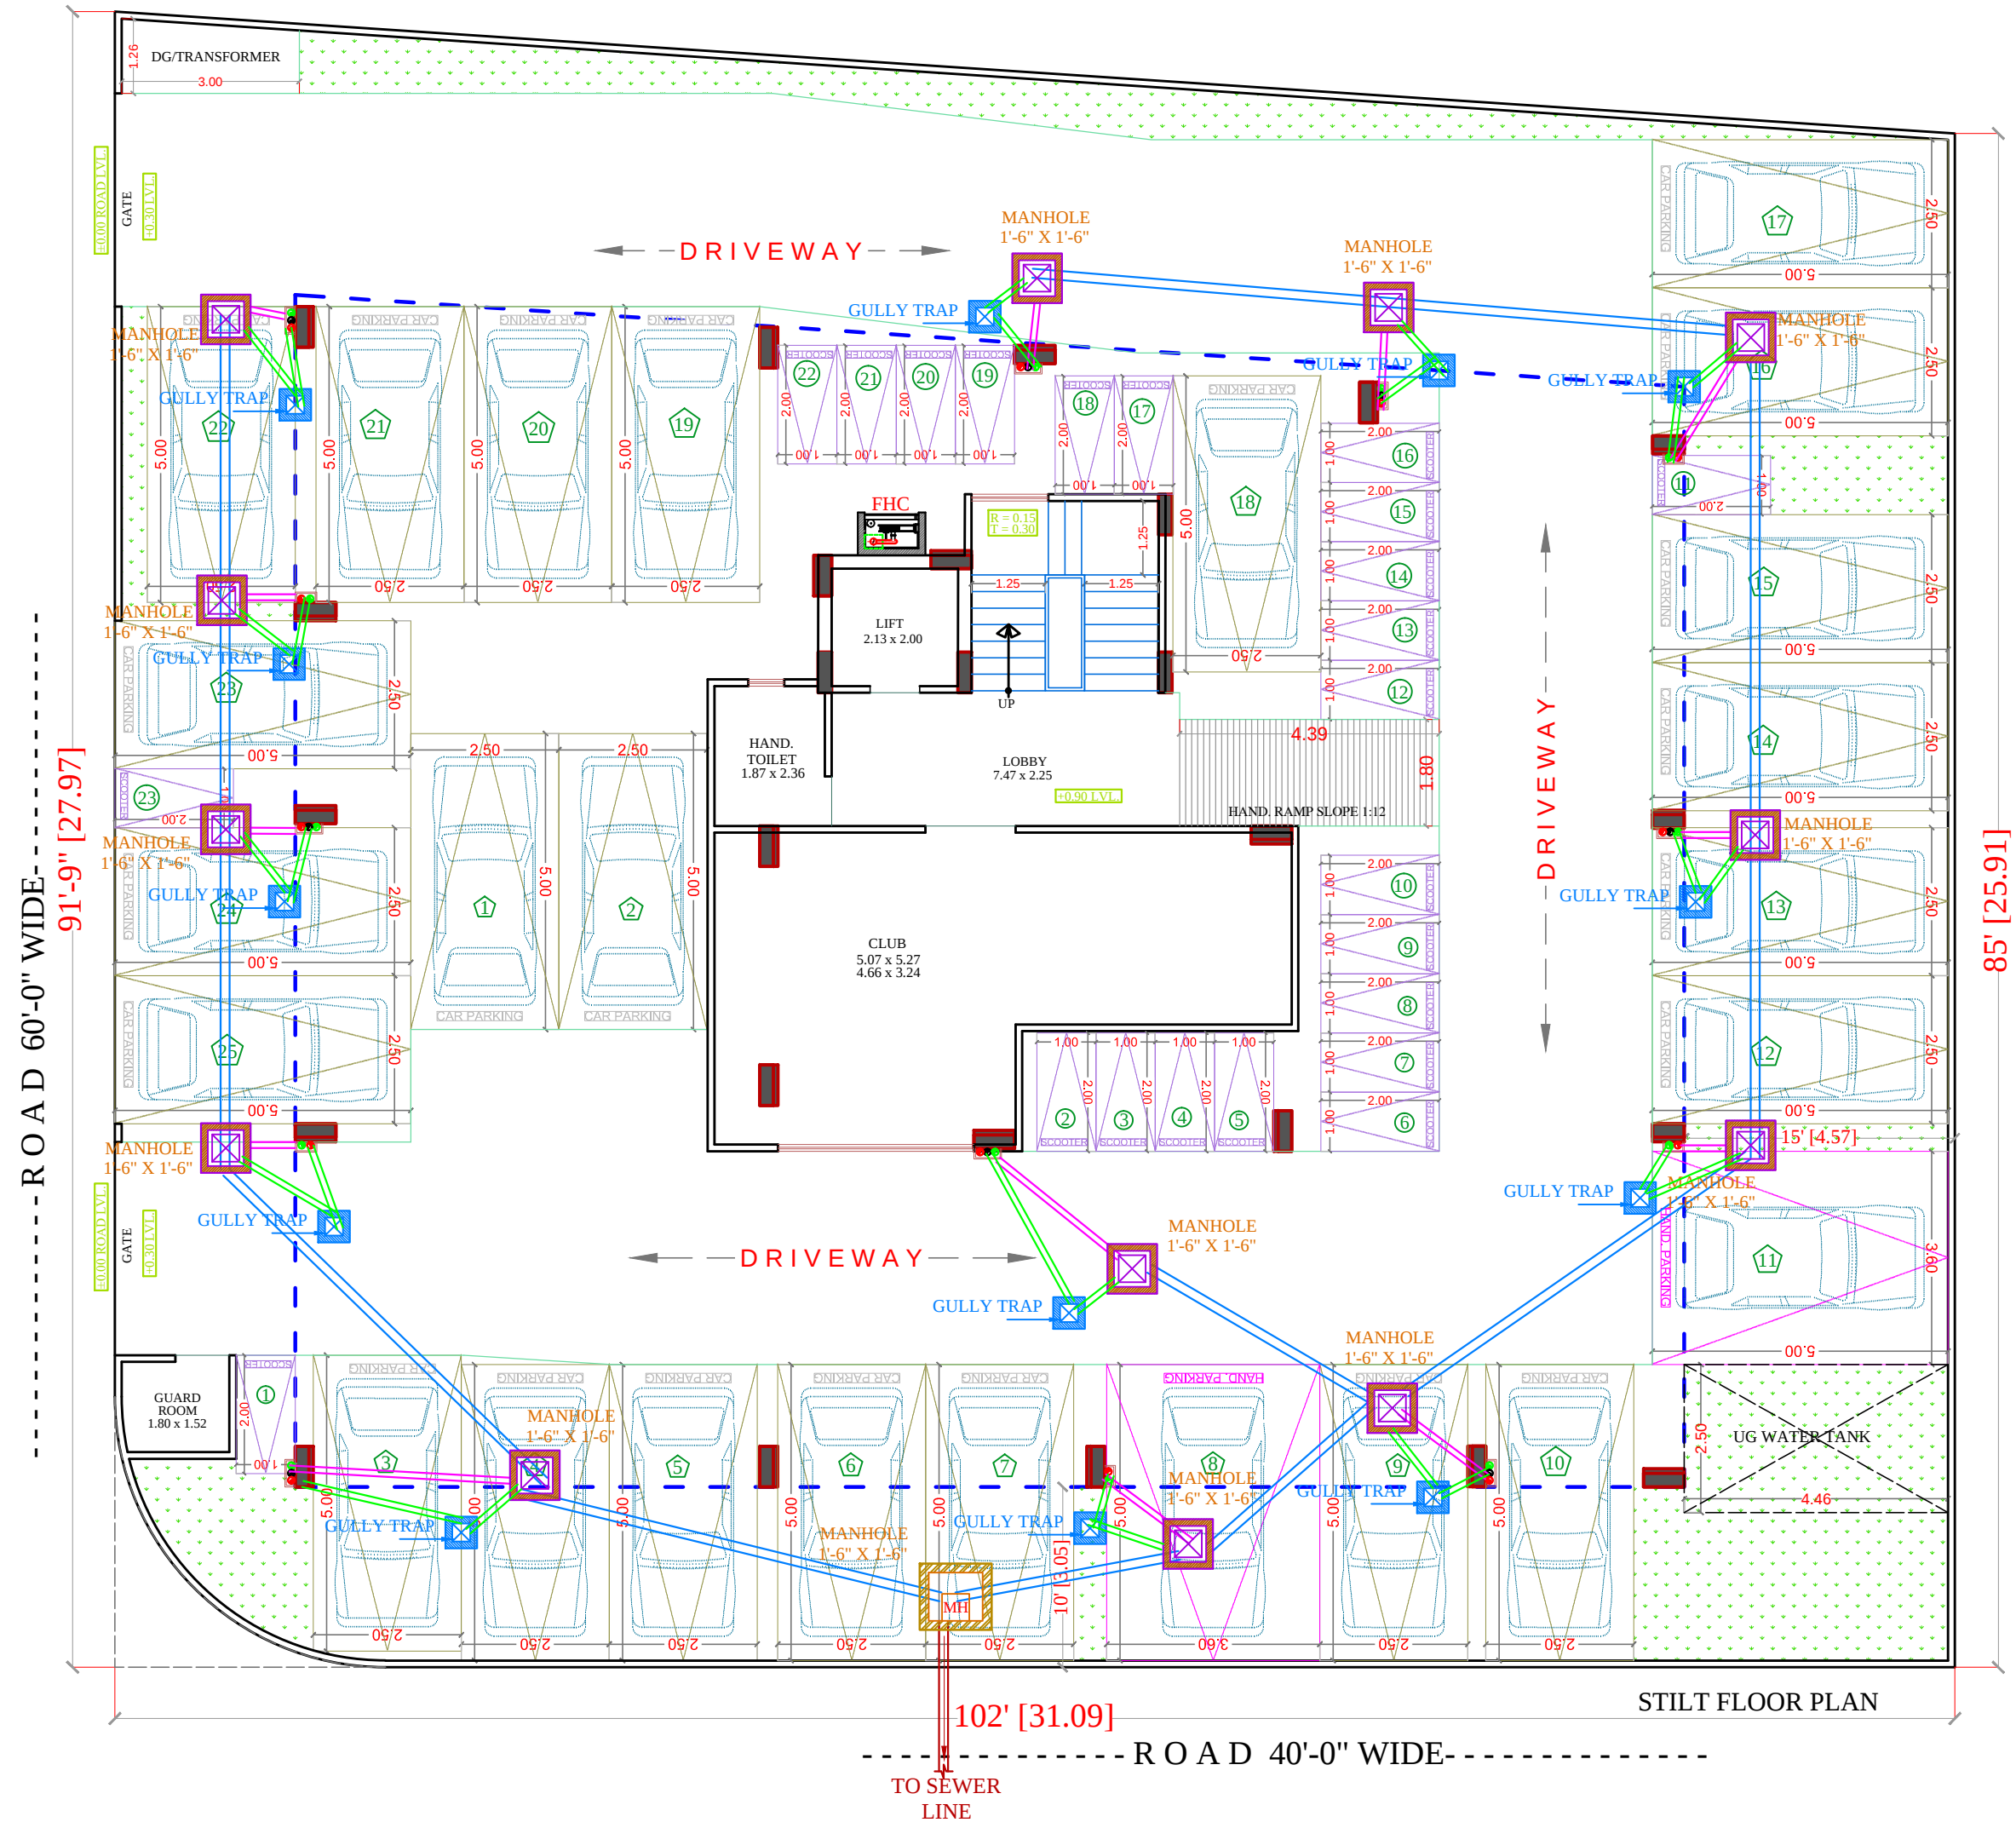

SYMBOL	DESCRIPTION
	Ø 110 mm Soil Waste Water Pipe
	Ø 110 mm Waste Water Pipe
	Ø 110 mm Rain Water Pipe
	Ø 160 mm Soil Waste Water Pipe Slope 1:150
	Ø 110 mm Soil Waste Water Pipe Slope 1:150
	Ø 110 mm Waste Water Pipe Slope 1:150
	Ø 75 mm Waste Water Pipe Slope 1:150
	50mm Waste Water Pipe Bottle Trap
	Floor Trap
	P-Trap Required
	Gully Trap-12"X12" Depth According to Slope
	Main Hole-18"X18" Depth According to Slope
	Main Hole-24"X24" Depth According to Slope
	Main Hole-36"X32" Depth According to Slope
	Flow Direction
SIGN:- SEAL:-	
SPACE CONSULTANT PLOT-A-173, JAGDAMBA NAGAR, HEERAPURA POWER HOWER, JAIPUR (RAJ) 302024	
ARCHITECT :- FRANK SQUARE ARCHITECTURE PLANNER DESIGNER C-49 VIDYA APARTMENT PARAS MARG, BAPU NAGAR JAIPUR, (RAJ.) Email-afranksquare@gmail.com Mobile-9461302542	
PROJECT :- PROPOSED BUILDING AT PLOT NO.-A1 & A2, NARAYANPURI-A, JAIPUR	
DRAWING: STILT FLOOR EXTERNAL SEWERAGE CHAMBER & PIPE ROUTE FOR RERA SUBMISSION PLAN	
DATE	18-08-2023
SCALE:-	N.T.S.

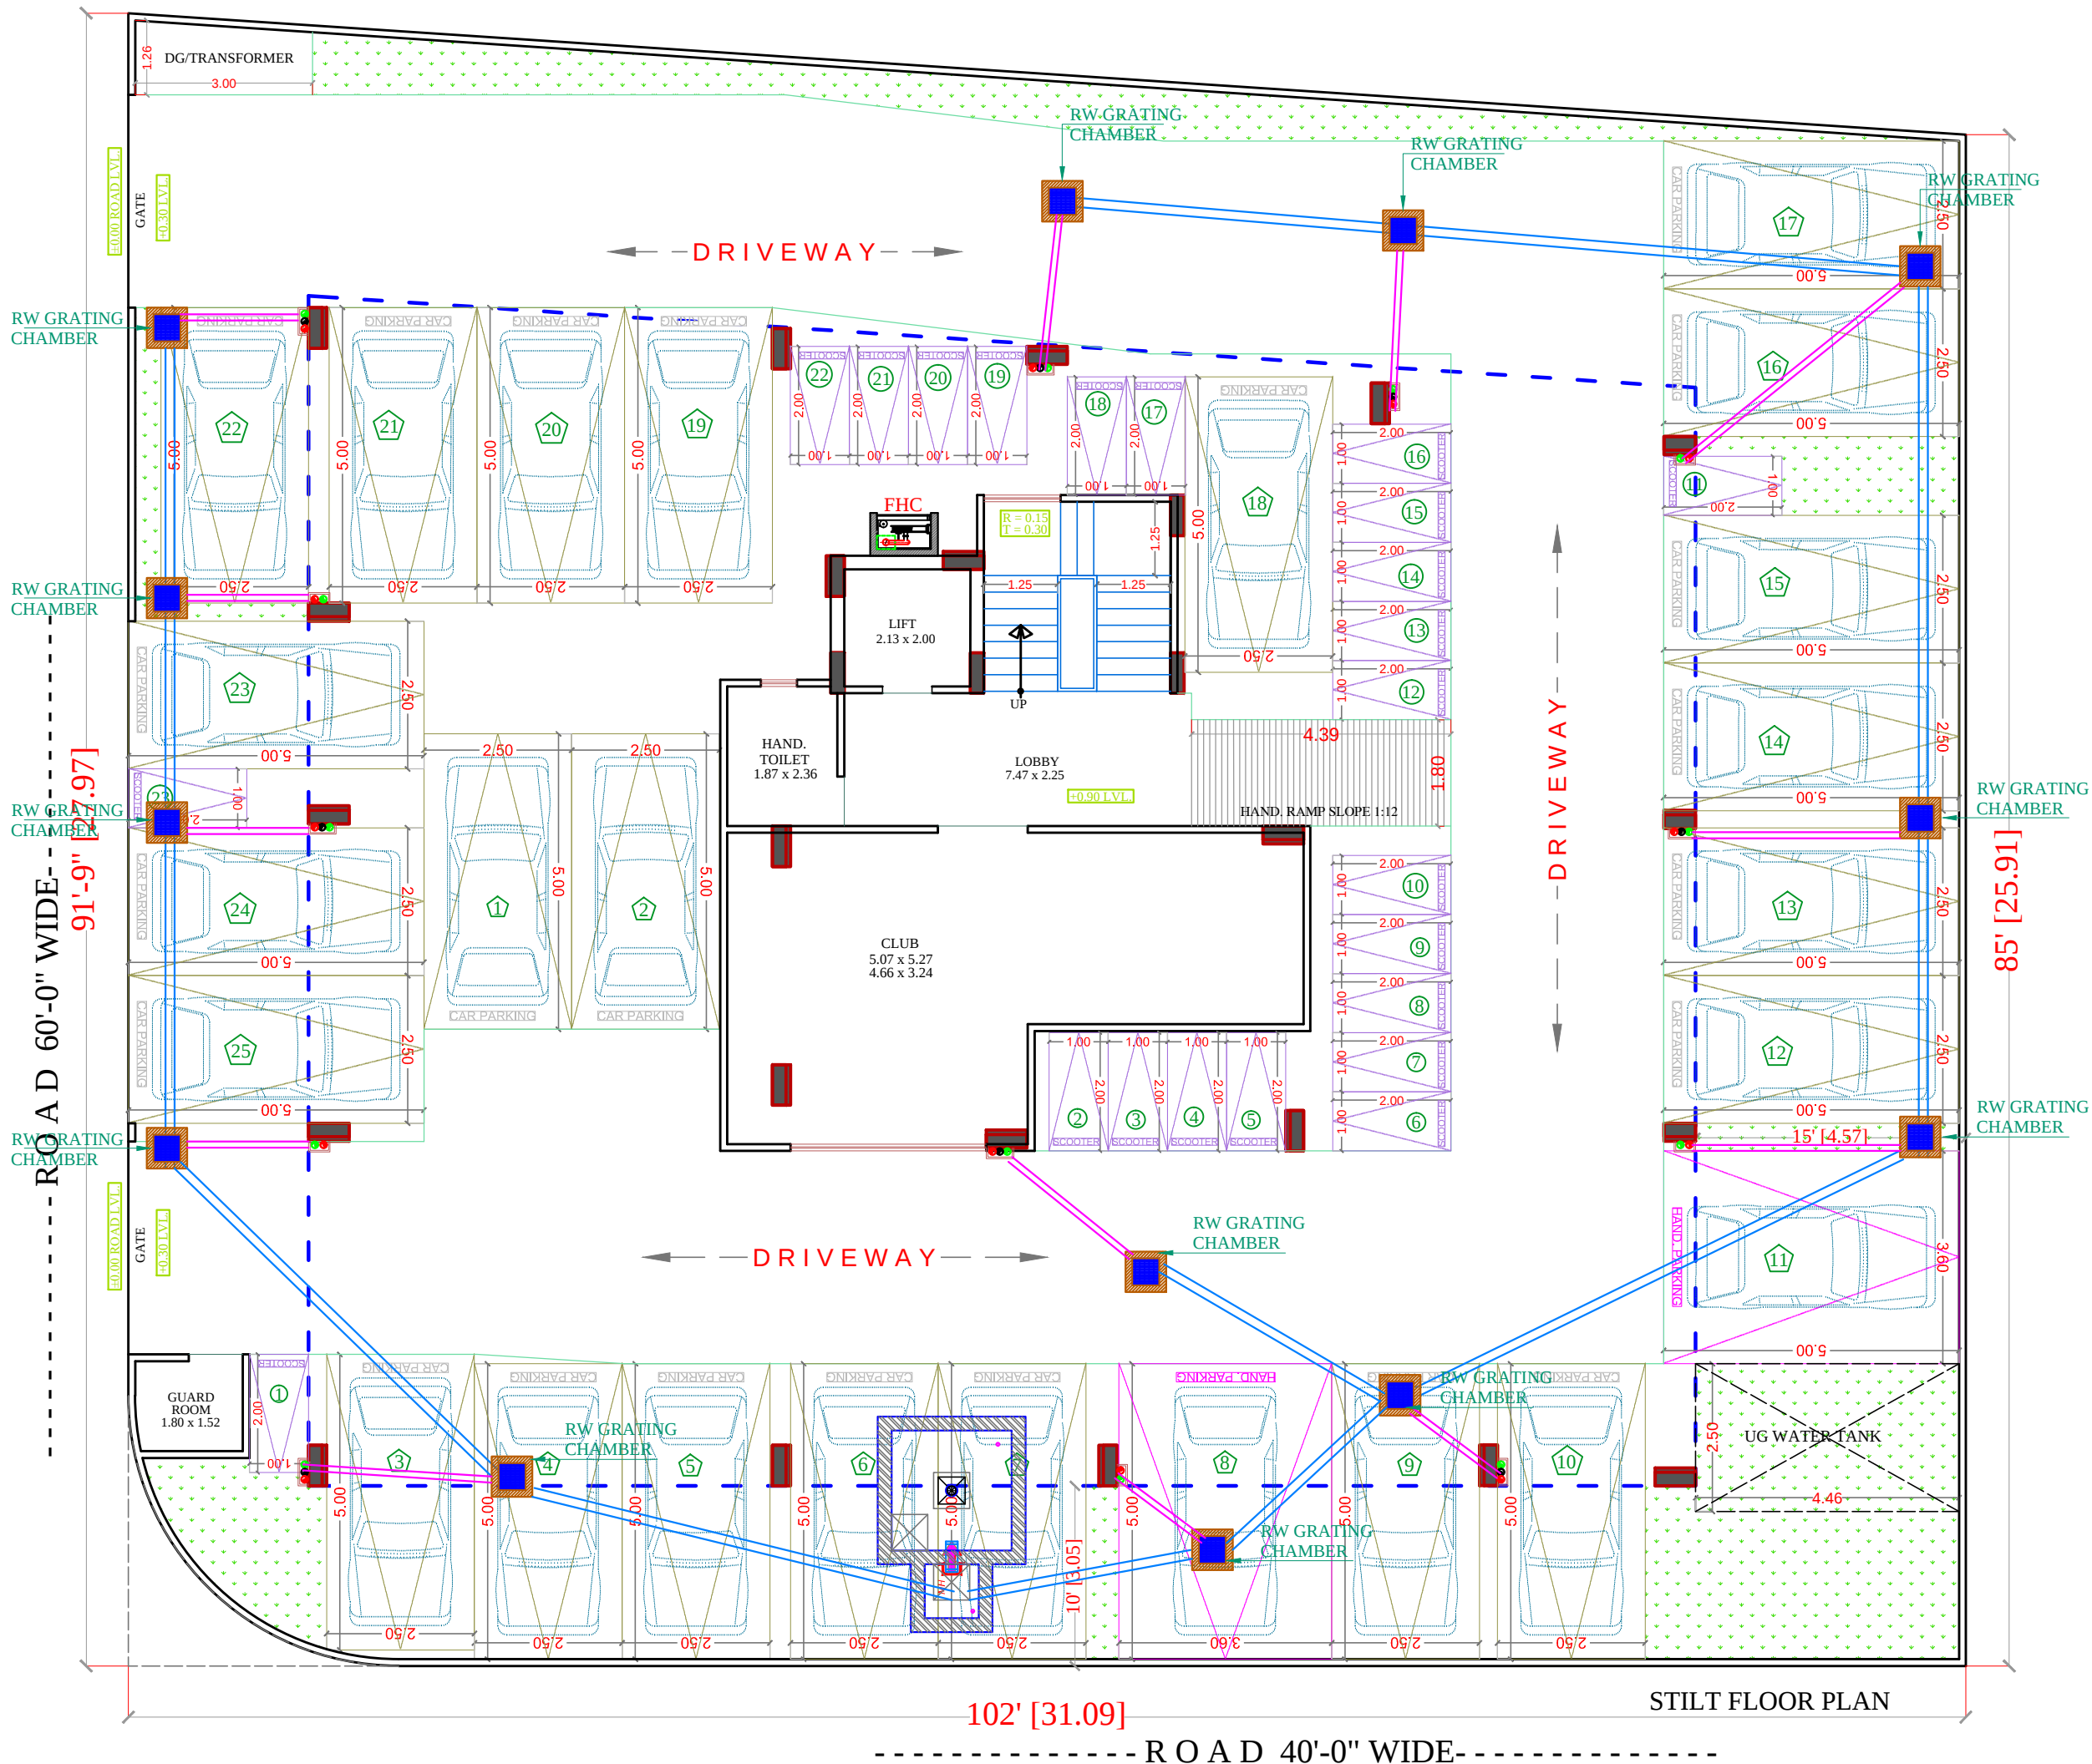

SYMBOL	DESCRIPTION
○	ϕ 110 mm Soil Waste Water Pipe
○	ϕ 110 mm Waste Water Pipe
○	ϕ 110 mm Rain Water Pipe
—	ϕ 160 mm Rain Water Pipe Slope 1:200
—	ϕ 110 mm Rain Water Pipe Slope 1:200
■	RC-12"X12" Depth According to Slope
■	RC-18"X18" Depth According to Slope
■	RC-24"X24" Depth According to Slope
→	Flow Direction

SIGN:-

SEAL:-

SPACE CONSULTANT
PLOT-A-173, JAGDAMBA NAGAR, HEERAPURA
POWER HOWER, JAIPUR (RAJ) 302024

ARCHITECT :-
 FRANK SQUARE
ARCHITECTURE | PLANNER | DESIGNER
C-49 VIDYA APARTMENT PARAS MARG,
BAPU NAGAR JAIPUR, (RAJ.)
Email-afranksquare@gmail.com
Mobile-9461302542

PROJECT :-
PROPOSED BUILDING AT PLOT NO.-A1 & A2, NARAYANPURI-A, JAIPUR

DRAWING:
STILT FLOOR
EXTERNAL STORM DRAIN
AND RAIN WATER CHAMBER
PIPE ROUTE FOR
RERA SUBMISSION PLAN

DATE	
SCALE:-	N.T.S.



TYPICAL FLOOR SENITARY PLAN

PROJECT TITLE :-

PROPOSED BUILDING AT PLOT
NO.-A1 & A2, NARAYANPURI-A,
JAIPUR

SERVICES CONSULTANT

DRN. BY		DATE	NORTH
APPD. BY		24-02-2023	
SCALE	N.T.S	REVISION	




TYPICAL FLOOR SENITARY PLAN

PROJECT TITLE :-

PROPOSED BUILDING AT PLOT
NO.-A1 & A2, NARAYANPURI-A,
JAIPUR

SERVICES CONSULTANT

DRN. BY		DATE	NORTH
APPD. BY		24-02-2023	
SCALE	N.T.S	REVISION	

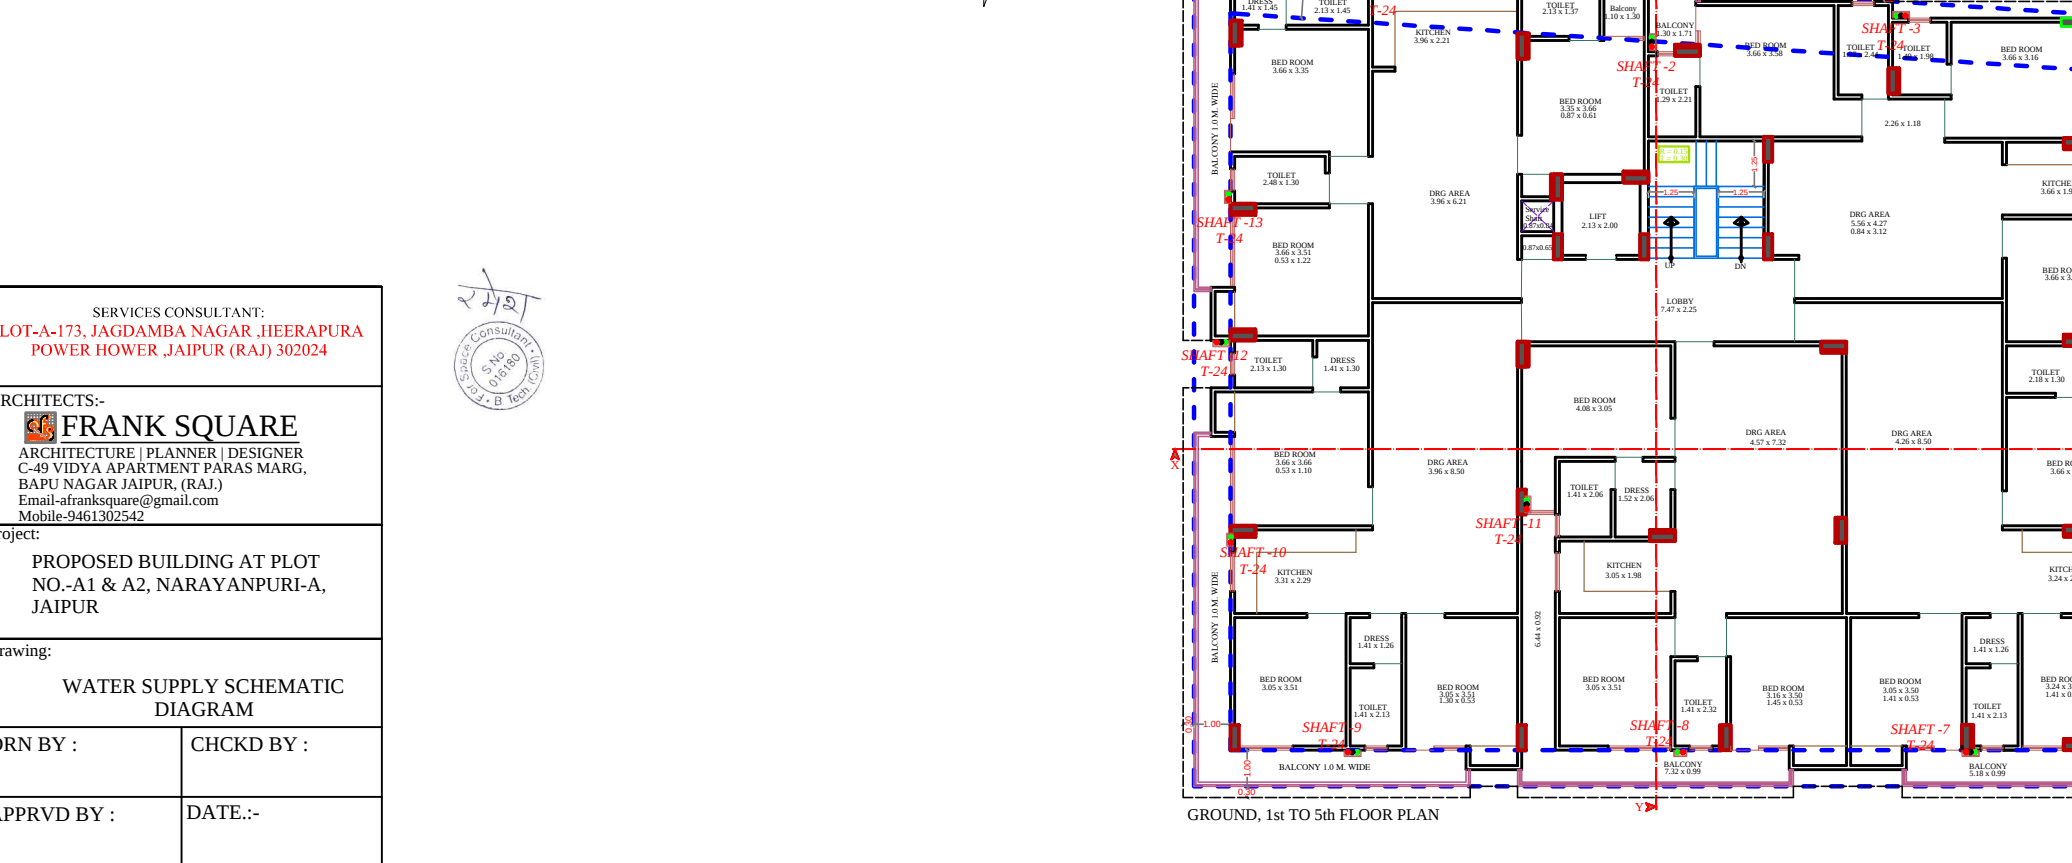[illegible][illegible]

GROUND, 1st TO 5th FLOOR PLAN

APPRVD BY :	DATE:-
-------------	--------

DATE:-

DATE:-
