

This architectural floor plan depicts a building with a total width of 80'-3" and a total depth of 195'-6". The layout includes a central corridor with stairs (UP and DOWN) and a lift (6'-0" x 6'-0"). Key areas include:

- Swimming Pool:** Located at the top, with a width of 40'-6" and a length of 35'-6". It includes two change rooms and a level of LVL = -2'-0".
- Kid's Play Area:** 5.59 x 7.06, adjacent to the pool.
- Gym:** 5.59 x 7.06, adjacent to the play area.
- Lobby:** Centrally located, containing a lift and stairs.
- Residential Flats:** Multiple flats are arranged around the central corridor, each with a resident store.
- UG Water Tank:** 35'-0" x 11'-0" x 7'-0", with a capacity of 64,500 Lt., located at the bottom.
- Drainage:** Numerous 300mm wide drains with gratings and slopes of 1:300 are indicated throughout the plan.
- Dimensions:** Extensive dimensions are provided for all rooms and overall building measurements.
- North Arrow:** Located at the bottom right, pointing towards the top of the page.

The plan also shows a road 60'-0" wide at the bottom and various structural details like columns and walls.

OTHER'S LAND

Er. SANJEEV SHARMA
B.E (Electrical)

ARCHITECTS :

LEGEND :		
①	SOIL PIPE	
②	WASTE PIPE	
③	VENT PIPE	
④	COLD WATER SUPPLY (CWS)	
⑤	HOT WATER SUPPLY (HWS)	
	RAIN WATER PIPE	
SW	SEWER LINE - EXTERNAL	
RW	STORM WATER DRAINAGE PIPE	
	SEWERAGE MANHOLE (2 x 2)	 M.H.
	STORM WATER MANHOLE (2 x 2)	 M.H.
GT	GULLY TRAP	
BV	BALL VALVE	
FT	FLOOR TRAP	
FD	FLOOR FLOOR DRAIN	
	RAIN WATER COLLECTION CHAMBER 450X450MM	
	KHURA	

PROJECT:

PROPOSED RESIDENTIAL FLATS
ON PLOT. NO. -O-29B
SCHEME- 6-D ENGINEERS COLONY
"O" BLOCK, JAIPUR.

NAME OF DRAWING:

BASEMENT DRAINAGE & SUMP DRAWING

DRAWING	NORTH:
WORKING DRAWING	
PROJECT NO. :	DATE :
	20-08-2024
SCALE :	REV NO. :
NTS	R-0

DRAWING NO. :

--	--	--

 /

-

 /

--	--


 /

--	--

 /

A-01

P.NO.
29

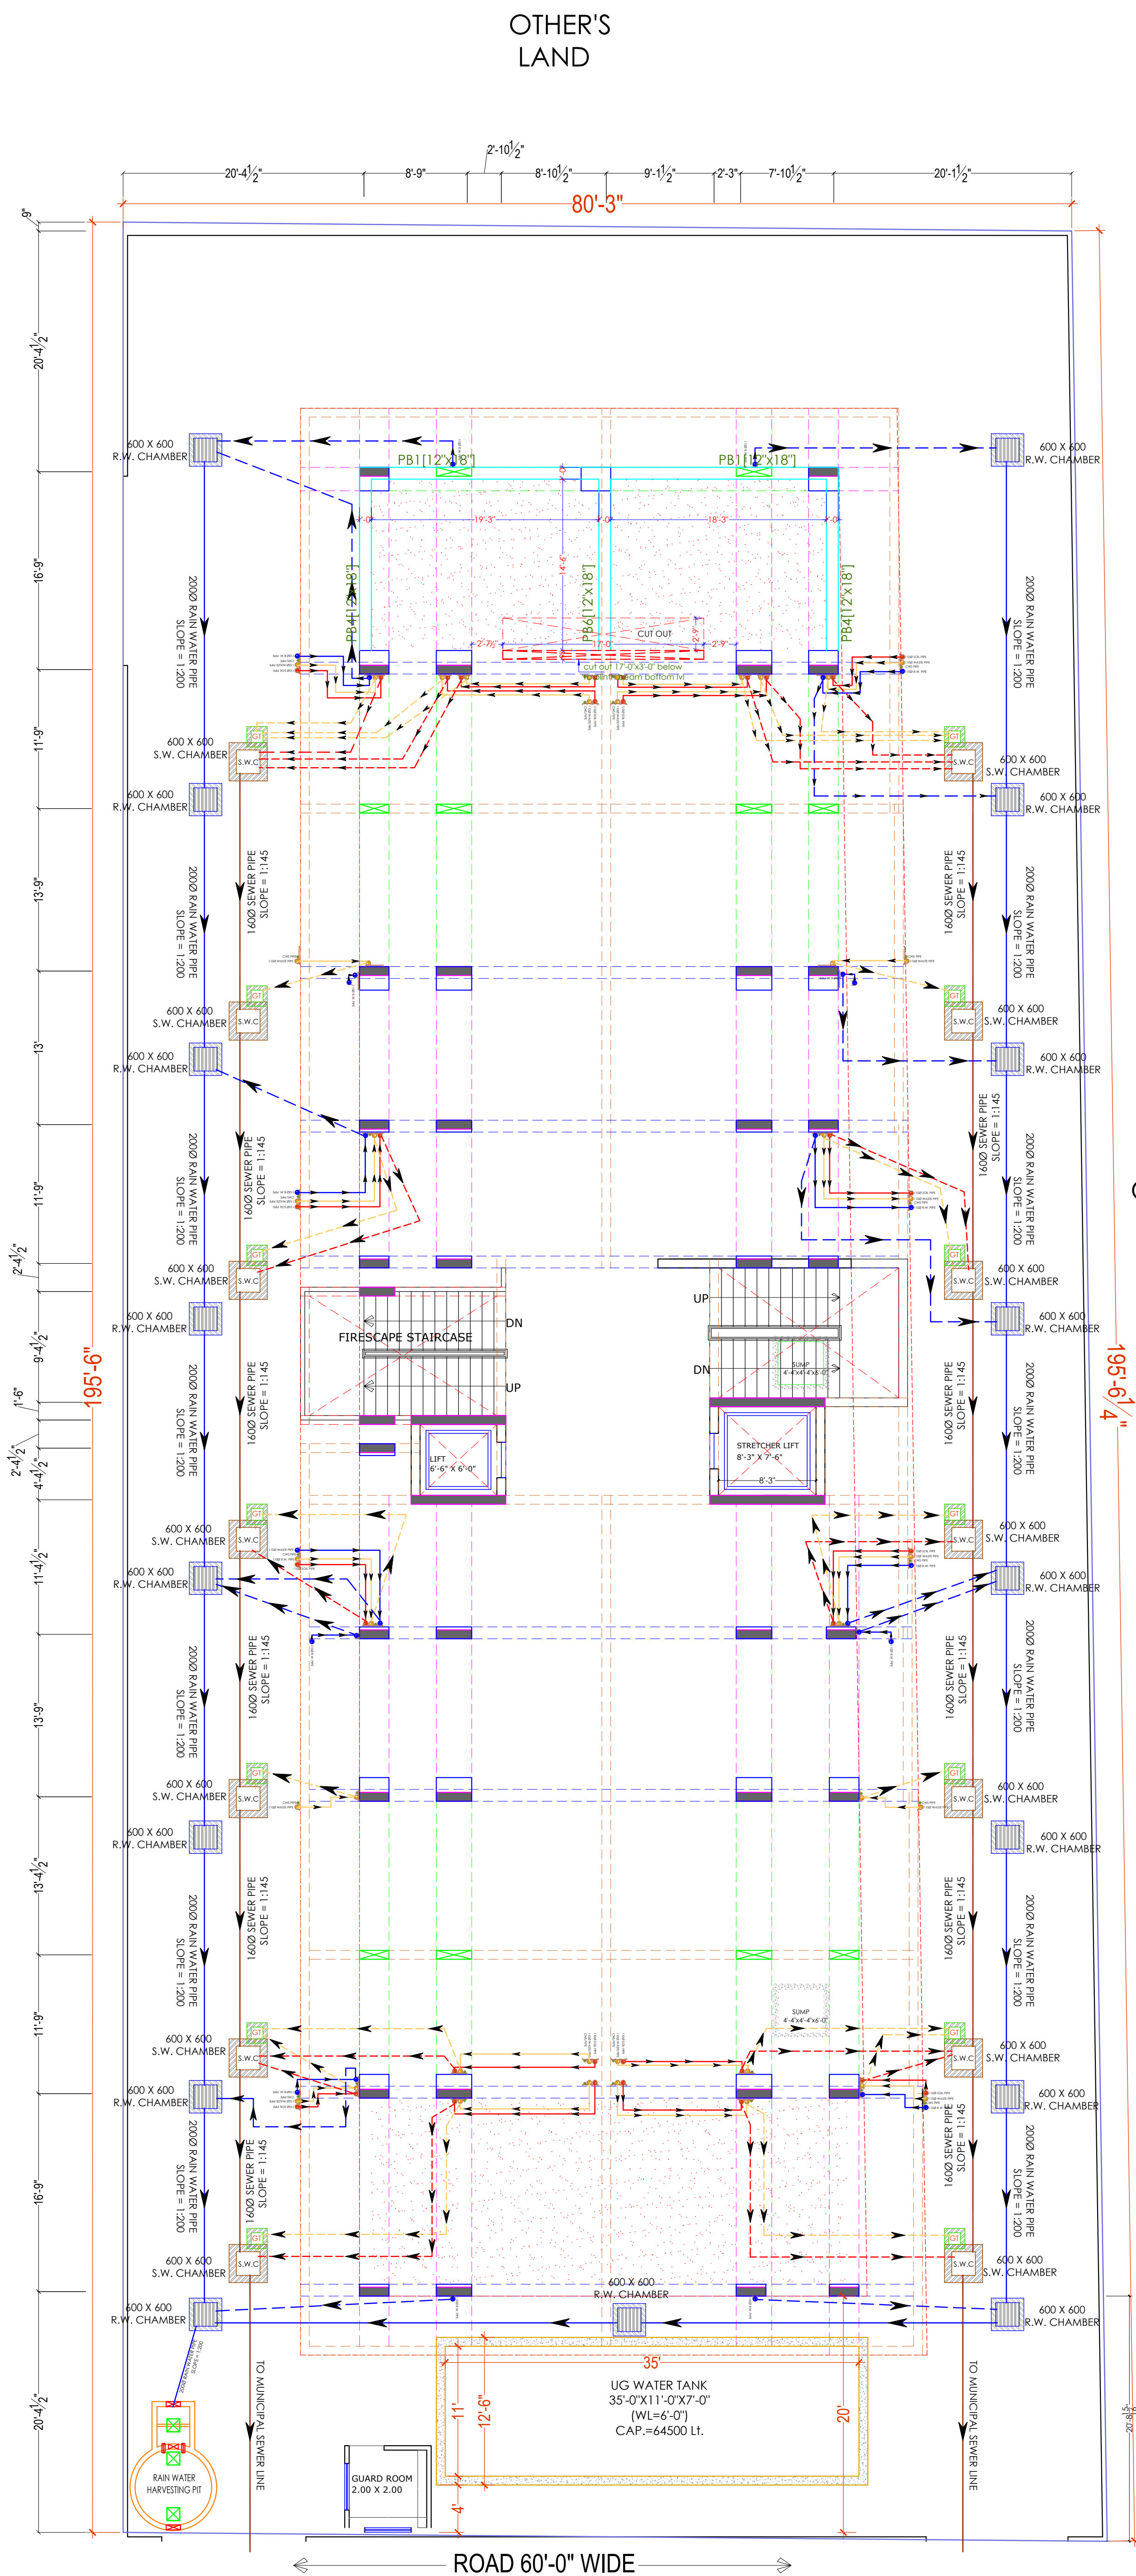

OTHER'S
LAND

195'-6"
4"

Shame
Er. SANJEEV SHARMA
B.E (Electrical)

CLIENT :

Mr. JITENDRA SINGH JI

ARCHITECTS :

LEGEND:-

①	SOIL PIPE	—
②	WASTE PIPE	—
③	VENT PIPE	—
④	COLD WATER SUPPLY (CWS)	—
⑤	HOT WATER SUPPLY (HWS)	—
	RAIN WATER PIPE	—
SW	SEWER LINE- EXTERNAL	—
RW	STORM WATER DRAINAGE PIPE	—
	SEWERAGE MANHOLE (2' x 2')	M.H.
	STORM WATER MANHOLE (2' x 2')	M.H.
GT	GULLY TRAP	—
BV	BALL VALVE	—
FT	FLOOR TRAP	—
FD	FLOOR FLOOR DRAIN	—
	RAIN WATER COLLECTION CHAMBER 450X500MM	—
	KHURRA	—

PROJECT:

PROPOSED RESIDENTIAL FLATS
ON PLOT. NO. -O-29B
SCHEME- 6-D ENGINEERS COLONY
"O" BLOCK, JAIPUR.

NAME OF DRAWING:

STILT FLOOR WATER SUPPLY,
EXTERNAL RAIN WATER HARVESTING AND
PIPE ROUTE PLAN ,EXTERNAL SEWERAGE
WATER PIPE ROUTE PLAN ,UG WATER TANK,
SANITATION & COMMON
PLUMBING DRAWING

DRAWING
WORKING DRAWING

PROJECT NO. :

DATE :
20-08-2024

SCALE :
NTS

REV NO. :
R-0

DRAWING NO. :

PROJECT	CATEGORY	BLOCK	FLOOR	TYPE	NUMBER

A-01

STILT FLOOR WATER SUPPLY, EXTERNAL RAIN WATER HARVESTING AND PIPE ROUTE PLAN ,EXTERNAL SEWERAGE
WATER PIPE ROUTE PLAN ,UG WATER TANK , SANITATION & COMMON PLUMBING DRAWING

CLIENT :

Mr. JITENDRA SINGH JI

ARCHITECTS :

LEGEND:-

①	SOIL PIPE	
②	WASTE PIPE	
③	VENT PIPE	
④	COLD WATER SUPPLY (CWS)	
⑤	HOT WATER SUPPLY (HWS)	
	RAIN WATER PIPE	
SW	SEWER LINE- EXTERNAL	
RW	STORM WATER DRAINAGE PIPE	
	SEWERAGE MANHOLE (2' x 2')	
	STORM WATER MANHOLE (2' x 2')	
GT	GULLY TRAP	
BV	BALL VALVE	
FT	FLOOR TRAP	
FD	FLOOR FLOOR DRAIN	
	RAIN WATER COLLECTION CHAMBER 450X450MM	
	KHURRA	

PROJECT:

PROPOSED RESIDENTIAL FLATS
ON PLOT. NO. -O-29B
SCHEME- 6-D ENGINEERS COLONY
"O" BLOCK, JAIPUR.

NAME OF DRAWING:


**STILT FLOOR CEILING
DRAINAGE LAYOUT PLAN /
SANITATION**

DRAWING WORKING DRAWING	NORTH:
PROJECT NO. :	DATE : 20-08-2024
SCALE : NTS	REV NO. : R-0

DRAWING NO. :	
PROJECT	CATEGORY
BLOCK	FLOOR
TYPE	NUMBER

A-01

OTHER'S
LAND

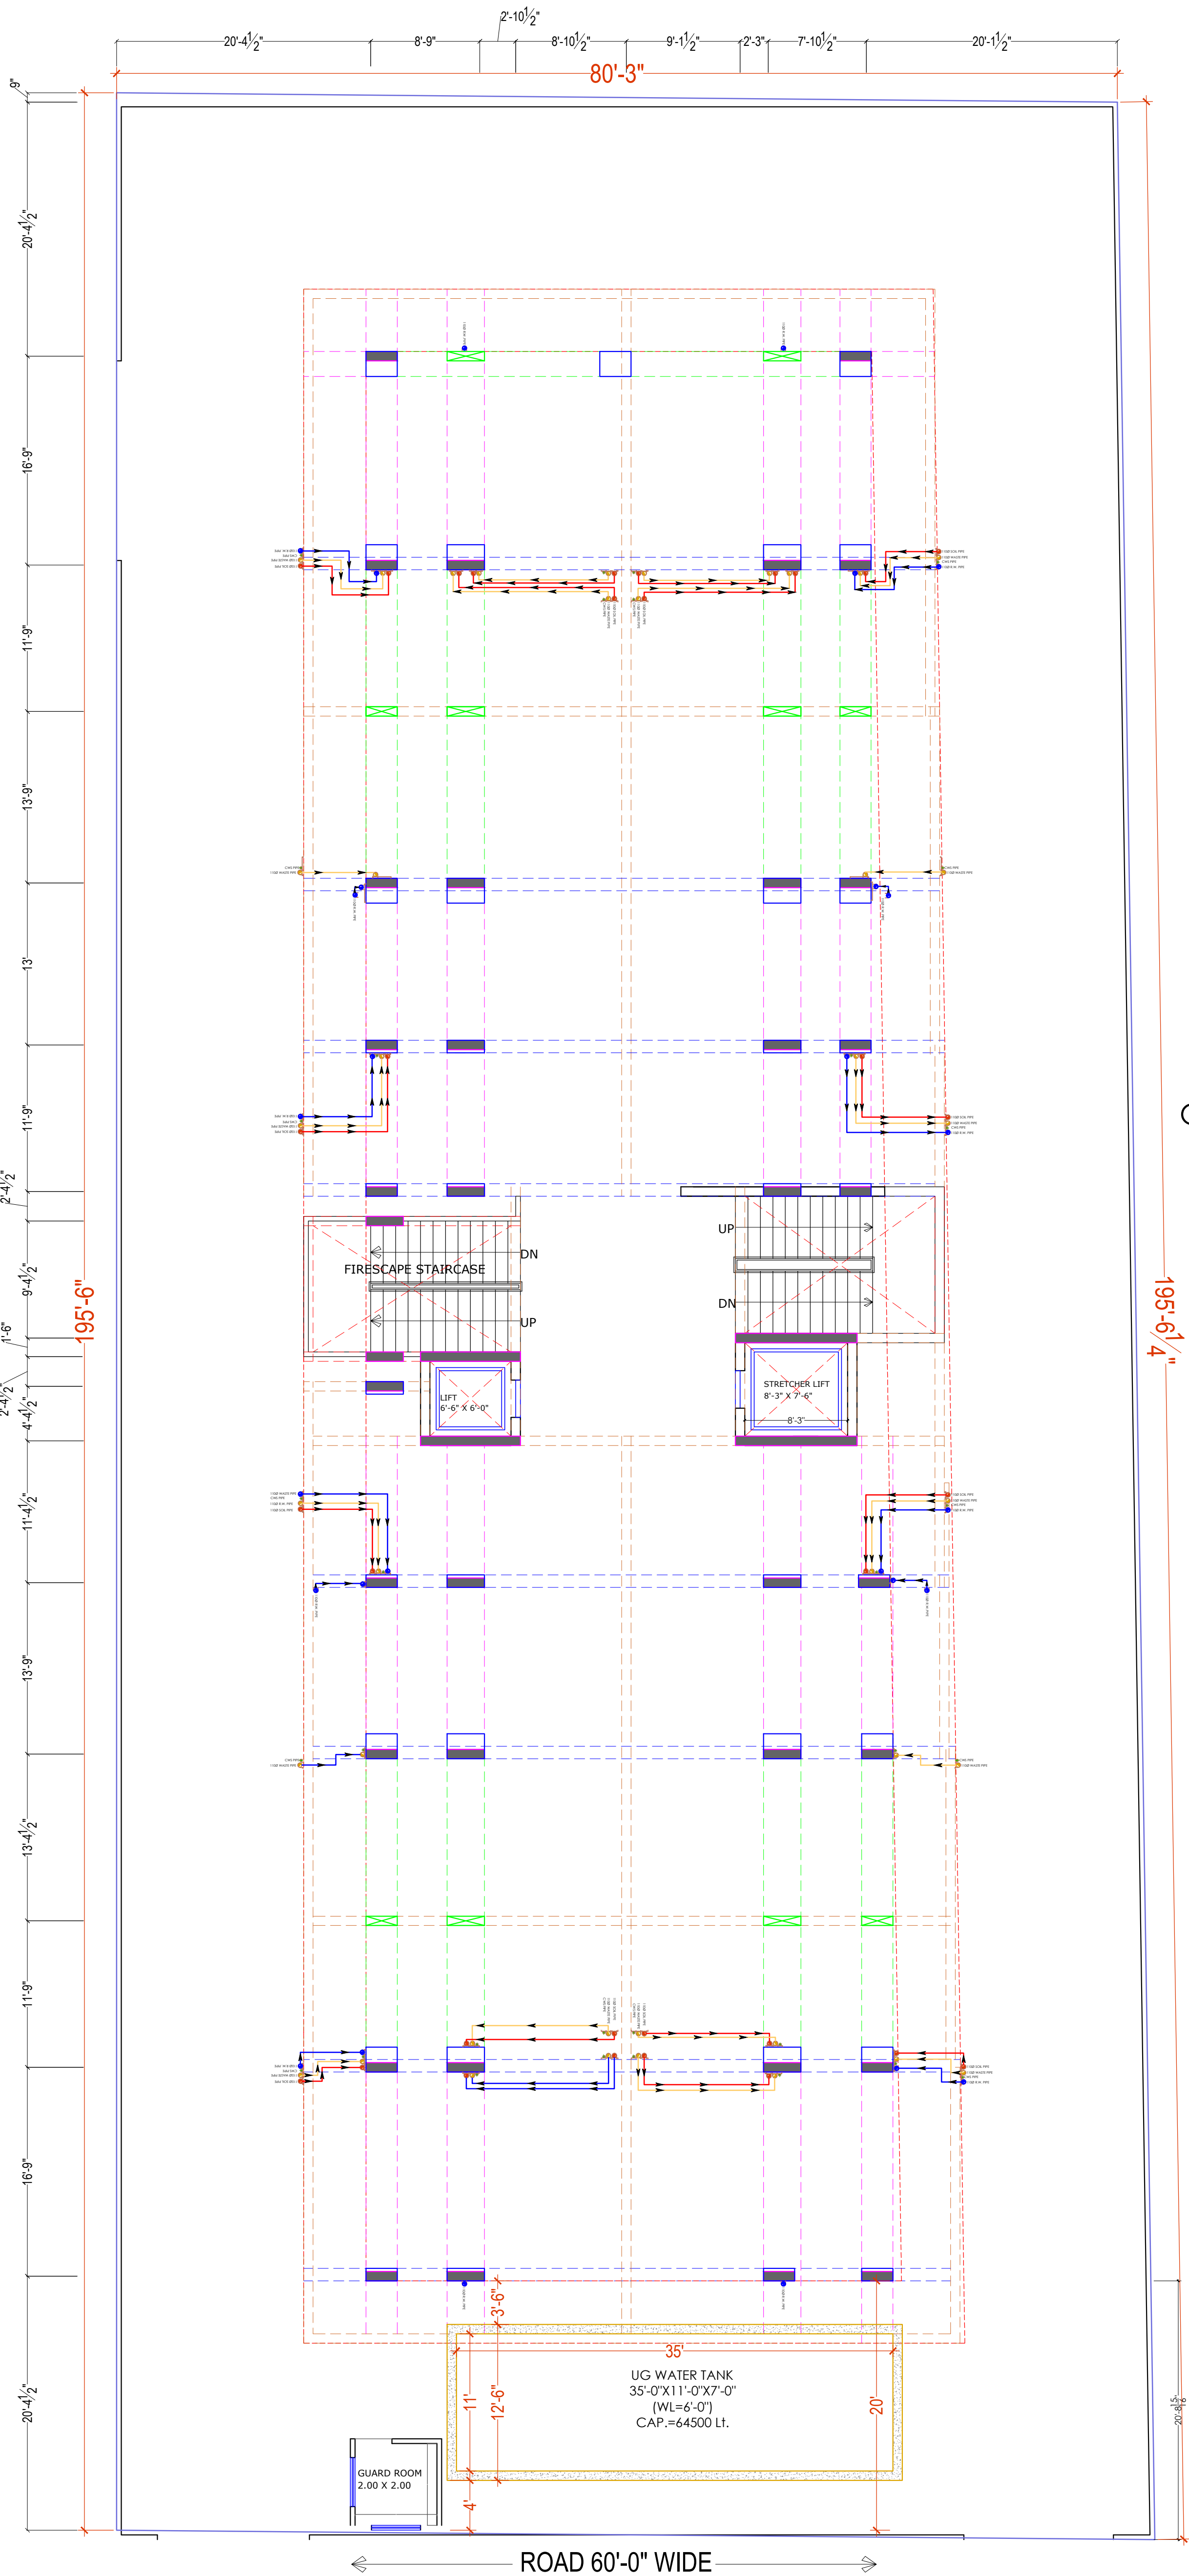

OTHER'S
LAND

P.NO.
29

STILT FLOOR CEILING DRAINAGE LAYOUT PLAN / SANITATION

OTHER'S
LAND

CLIENT :

Mr. JITENDRA SINGH JI

ARCHITECTS :

LEGEND:-

①	SOIL PIPE	
②	WASTE PIPE	
③	VENT PIPE	
④	COLD WATER SUPPLY (CWS)	
⑤	HOT WATER SUPPLY (HWS)	
	RAIN WATER PIPE	
SW	SEWER LINE- EXTERNAL	
RW	STORM WATER DRAINAGE PIPE	
	SEWERAGE MANHOLE (2' x 2')	M.H.
	STORM WATER MANHOLE (2' x 2')	M.H.
GT	GULLY TRAP	
BV	BALL VALVE	
FT	FLOOR TRAP	
FD	FLOOR FLOOR DRAIN	
	RAIN WATER COLLECTION CHAMBER 450X450MM	
	KHURRA	

3" less

195'-6 1/4"

6" less

Sham
Er. SANJEEV SHARMA
B.E (Electrical)

P.NO.
29

TYPICAL FLOOR (WATER SUPPLY, RAINWATER, SANITATION & COMMON PLUMBING)
INTERNAL DRAINAGE & PLUMBING DRAWING

PROJECT:

PROPOSED RESIDENTIAL FLATS
ON PLOT. NO. -O-29B
SCHEME- 6-D ENGINEERS COLONY
"O" BLOCK, JAIPUR.


NAME OF DRAWING:

TYPICAL FLOOR (WATER SUPPLY,
RAINWATER, SANITATION & COMMON
PLUMBING)
INTERNAL DRAINAGE & PLUMBING
DRAWING

DRAWING WORKING DRAWING	NORTH:
PROJECT NO. :	DATE : 18-10-2024
SCALE : NTS	REV NO. : R-0

DRAWING NO. :	
PROJECT	CATEGORY
BLOCK	FLOOR
TYPE	NUMBER

A-01

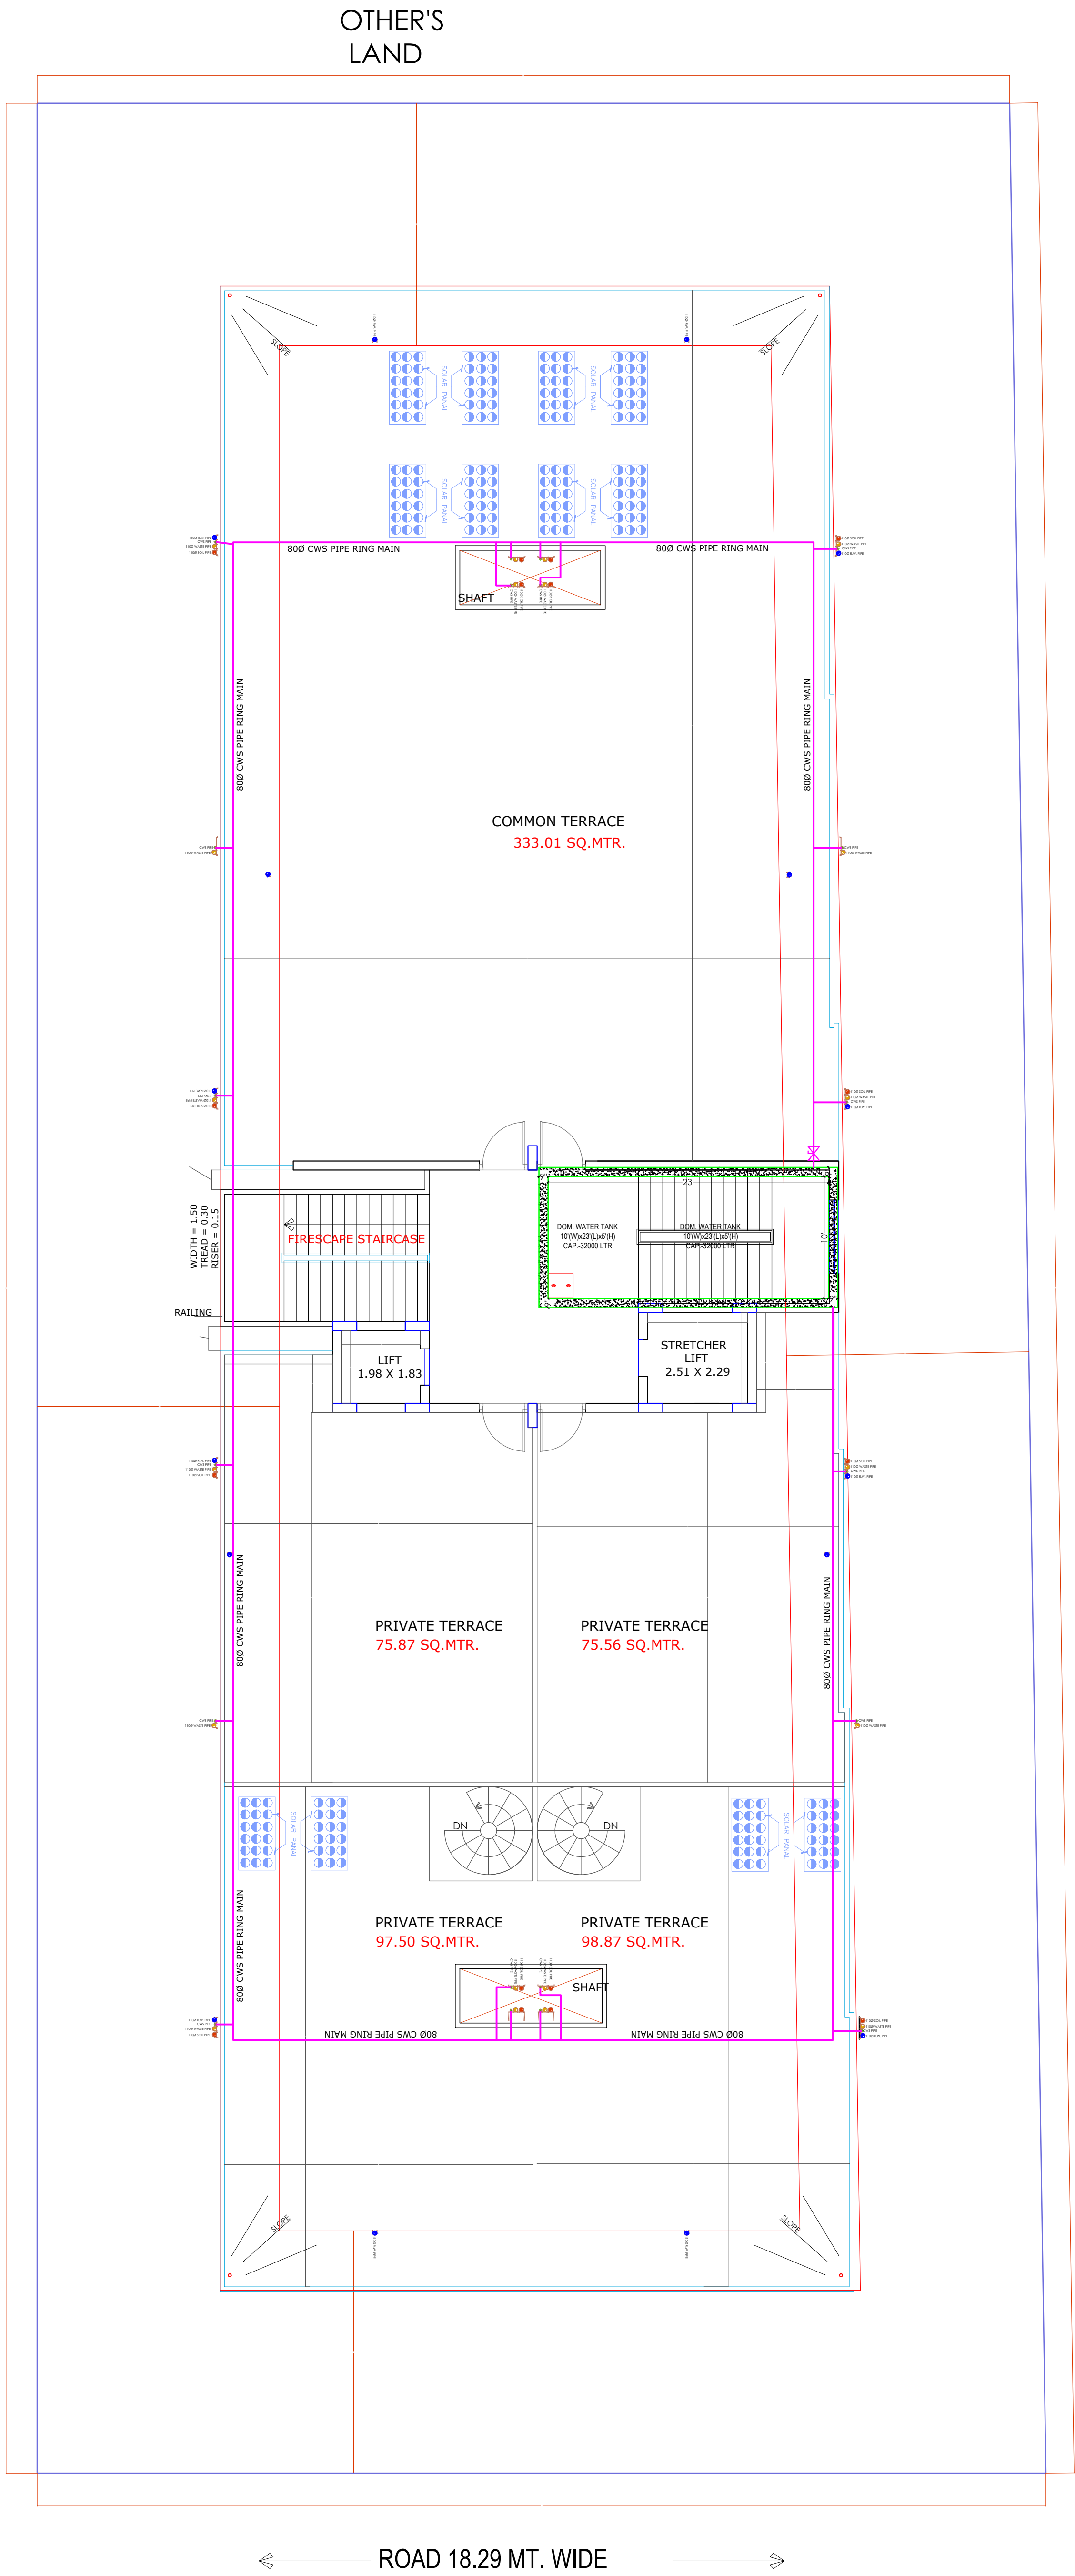

PROJECT NAME :

THE SIGNATURE

DEVELOPER NAME :

M/S SHREE ENTERPRISES

ARCHITECTS :

4 INSIDE
ARCHITECTURE N INTERIORS
Plot no. 72, S.P. Marg, C-Scheme
jaipur, rajasthan, India
cont: +91 9950595991, 91
9982812777
e.mail: jeets.arch@gmail.com

LEGEND:-

①	SOIL PIPE	—
②	WASTE PIPE	—
③	VENT PIPE	—
④	COLD WATER SUPPLY (CWS)	—
⑤	HOT WATER SUPPLY (HWS)	—
	RAIN WATER PIPE	—
SW	SEWER LINE- EXTERNAL	—
RW	STORM WATER DRAINAGE PIPE	—
	SEWERAGE MANHOLE (2' x 2')	M.H.
	STORM WATER MANHOLE (2' x 2')	M.H.
GT	GULLY TRAP	—
BV	BALL VALVE	—
FT	FLOOR TRAP	—
FD	FLOOR FLOOR DRAIN	—
	RAIN WATER COLLECTION CHAMBER 450X450MM	—
	KHURRA	—

PROJECT:

PROPOSED RESIDENTIAL FLATS
ON PLOT. NO. -O-29B
SCHEME- 6-D ENGINEERS COLONY
"O" BLOCK, JAIPUR.

NAME OF DRAWING:

Terrace floor (water supply,
R.W.H.,Sewerage, Sanitation,
& common plumbing)

DRAWING
WORKING DRAWING

PROJECT NO. :
DATE :
20-08-2024

SCALE :
NTS

REV NO. :
R-0

DRAWING NO. :
A-01