

CLIENT :

Mr. JITENDRA SINGH JI

ARCHITECTS :

LEGENDS:


Mounting Height	I D	Symbol	Description
CEILING	FAN48"		CEILING FAN 48"
CEILING	FAN30"		CEILING FAN 30"
CEILING	CH1		CHANDIELIER
+93"	TLW		1x2 Tubelight
+93"	BULB		1x2 Bulb 20W
+93"	GL		WALL BRACKETS AS DESIGN FOR GANESH LIGHT
+78"	ML		12x2 Led Mirror Light
CEILING	DL		1x2 6" Down Lighter 20W (Surface Mounted)
VENTILATOR HT	CR		CEILING ROSE
VENTILATOR HT	EXP		9" DIA FRESH AIR FAN
+24"	2xSB		2xSWITCH BOARD
+42"	SB		SWITCH BOARD(6A SOCKET & SWITCH)
+24"	TEL		TELEPHONE POINT
+24"	LP TEL		6A PLUG POINT FOR TELEPHONE
+48"	TV		TV COAXIAL POINT
+48"	LP TV		6 A PLUG POINT FOR TV
+24"	LP		6 A PLUG POINT FOR SIDE TABLE
+72"	LP CH		6 A PLUG POINT FOR CHIMNEY
+12"	LP PC		6 A PLUG FOR COMPUTER POINT
+93"	SAC		SPLIT AC INDOOR UNIT
+42"	PP-MIX		16 A POWER POINT FOR MIXER
+42"	PP-MIC		16 A POWER POINT FOR MICROWAVE
+78"	PP-G		16 A POWER POINT FOR GEYSER
+54"	PP-F		16 A POWER POINT FOR FRIDGE
+78"	PP-WP		16 A POWER POINT FOR WATER PURIFIER
+48"	PP-WM		16 A POWER POINT FOR WASHING MACHINE
+12"	PP-INV		16 A POWER POINT FOR INVERTER
+93"	PP-AC		25A SWITCHMCB FOR AC
			CHAMBER(2' X 2')
+18"			6A 220V SOCKET +1 NOS. (AS SWITCH, TELEPHONE, LAN)
+60"	MCB DB		MCB DISTRIBUTION BOARD
			CAMERA
			WALL FAN

BSB

6A SS FAN REGULATOR TL SWITCH

BAC

6A SS 25AAC

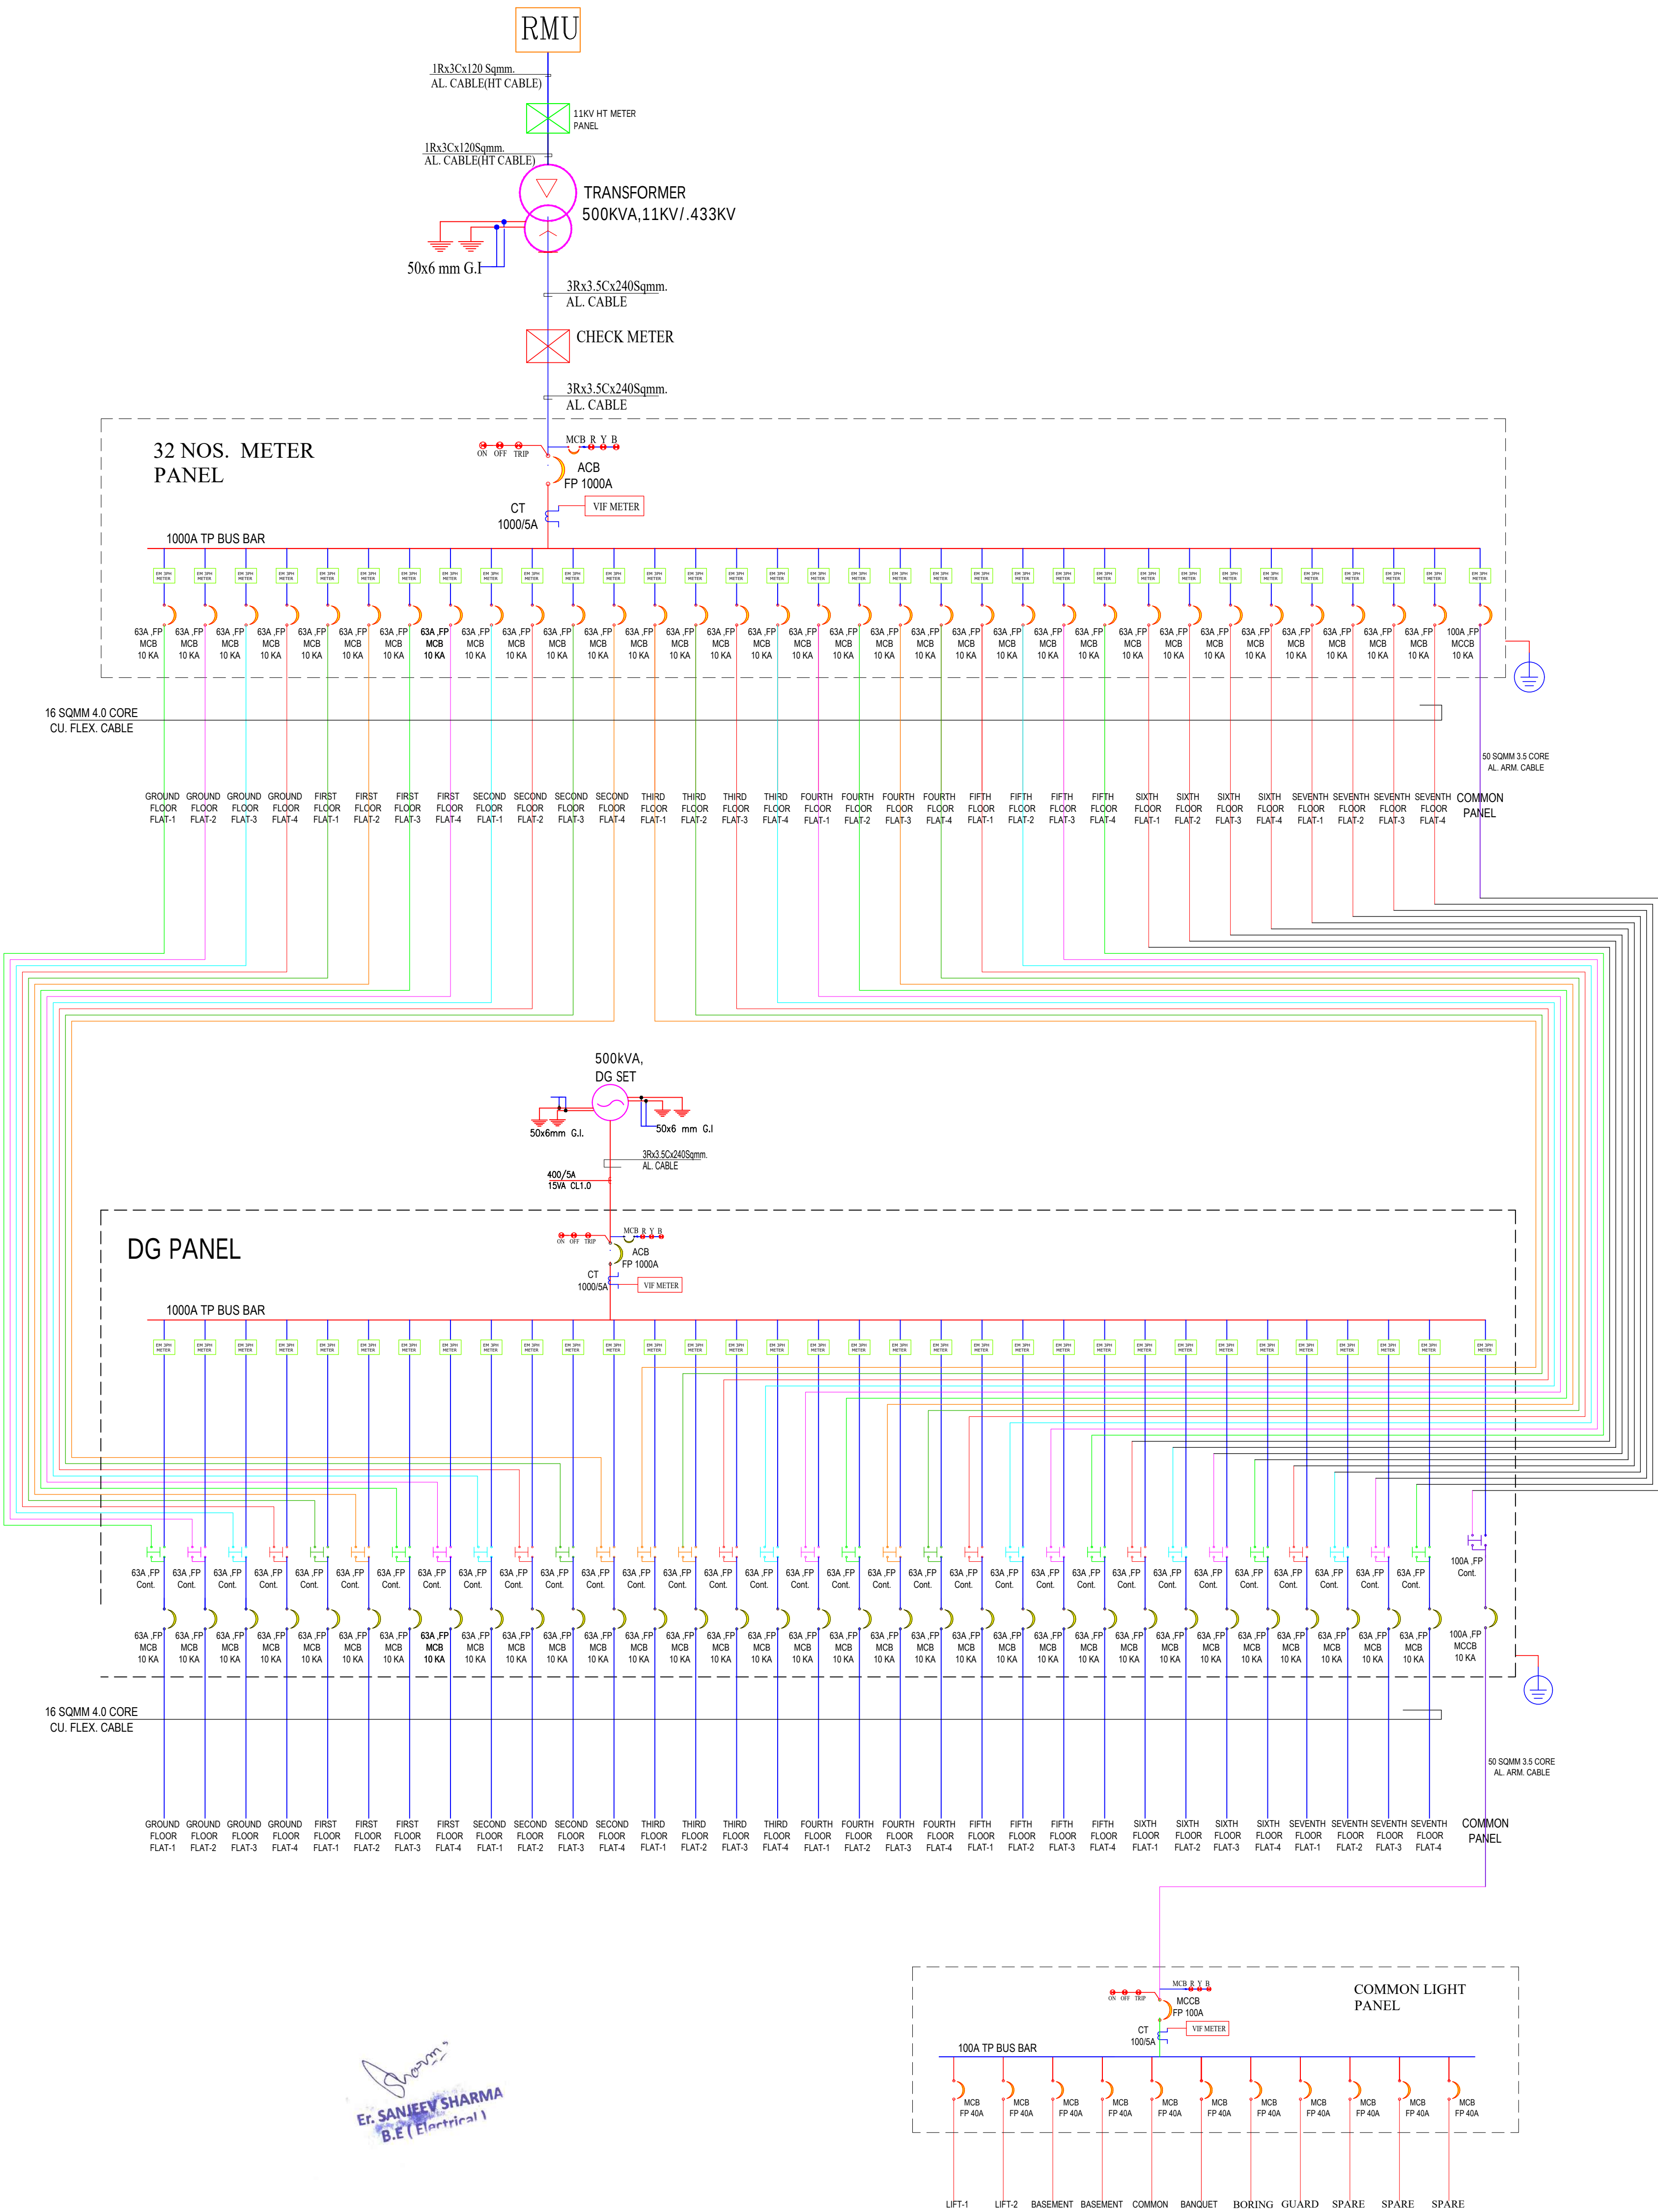

S No

DATE

REVISION DESCRIPTION

GENERAL NOTES :

1.

All dimension on this drawing are in MMS System Only written dimensions are to be followed. drawing should not be scaled.

2.

All measurements must be checked and verified by the contractors prior to execution of work at the site.

3.

This drawing is to be read in conjunction with all relevant structural, services & planning drawings.

4.

Architectural drawings are to be followed for the location of all structural members & masonry walls. for sizes & reinforcement details of structural members, relevant structural drawings are to be referred.

5.

Any discrepancies between architectural, structural and services drawings must be brought to the notice of the architect immediately & prior to execution at site.

6.

Coordination with services such as fire, plumbing & electrical, etc. is the responsibility of the contractor.

7.

All masonry walls should be aligned with the columns as indicated on the plan, irrespective of the position as calculated with the dimensions.

8.

For details, refer relevant large scale detail drawings as indicated.

PROJECT:

VENTURA SIGNATURE

PROJECT ADDRESS:

PROPOSED RESIDENTIAL FLATS ON PLOT. NO. -O-29B SCHEME- 6-D ENGINEERS COLONY "O" BLOCK, JAIPUR.

NAME OF DRAWING:

MAIN PANEL(SLD/DISTRIBUTION DETAILS AFTER LT PANEL

DRAWING

WORKING DRAWING

PROJECT NO. :

DATE :

SCALE :

NTS

REV NO. :

R-0

DRAWING NO. :

PROJECT

CATEGORY

BLOCK

FLOOR

TYPE

NUMBER

A-01

SINGLE LINE DIAGRAM

MAIN PANEL(SLD/DISTRIBUTION DETAILS AFTER LT PANEL