

PLOT NO. 244

ELECTRICAL
YARD

SHEET NO. - 02 /09

STILT FLOOR PLAN

DRIVEWAY 3.6m WIDE

SETBACK LINE

DRIVEWAY 3.6m WIDE

DRIVEWAY 3.6m WIDE

PLOT NO. 260

Typical Section Of
Mechanical Car Parking

LEGEND			
NO	DESCRIPTION	SYMBOL	FROM FFL
1.	CEILING FAN		CEILING
2.	EXHAUST		6'-0"
3.	WALL FAN POINT		6'-0"
4.	A C POINT(WINDOW AC)		1'-0"
5.	A C POINT(SPLIT AC)		AS PER SITE
6.	3 PHASE POINT		AS PER SITE
7.	A C SOCKET		AS PER SITE
8.	16 AMP POWER PLUG POINT(GENERAL)		1'-0"
9.	GYSER SOCKET 16 AMP		6'-0"
10.	16 AMP POWER PLUG POINT(KITCHEN)		KITCHEN SLAB
11.	16 AMP SOCKET		AS PER SITE
12.	6 AMP PLUG POINT (BED SIDE)		2'-6"
13.	6 AMP SOCKET (CHIMNEY)		7'-0"
14.	6 AMP SOCKET		AS PER SITE
15.	2 NOS 6 AMP POWER PLUG POINT (FOR TV)		1'-6"/4'-6"
16.	2 NOS 6 AMP POWER PLUG POINT		1'-6"/4'-6"
17.	6 AMP PLUG POINT (GENERAL)		1'-0"
18.	NIGHT LAMP		1'-6"
19.	KEY TAG		4'-0"
20.	INVERTOR SOCKET		1'-6"
21.	SWITCH BOARD WITH OUT 6 AMP POINT		4'-0"
22.	SWITCH BOARD WITH 6 AMP POINT		4'-0"
23.	BELL PUSH		4'-0"
24.	GYSER SWITCH 16 AMP		4'-0"
25.	PROJECTOR POINT		3'-6"
26.	TELEPHONE POINT(BED SIDE)		2'-6"
27.	TELEPHONE POINT (GENERAL)		1'-0"
28.	TV POINT (GENERAL)		2'-6"
29.	LAN POINT		2'-6"
30.	CEILING LIGHT (X)		CEILING
31.	CEILING LIGHT		CEILING
32.	CHANDELIER		CEILING
33.	40W TUBE LIGHT ON CEILING		CEILING
34.	BULB HOLDER ON SIDE WALL		7'-0"
35.	TUBE LIGHT ON WALL		7'-0"
36.	BULKHEAD FOR RAMP		2'-6"
37.	DISTRIBUTION BOX		5'-6"
38.	BELL		7'-0"
39.	CONDUIT CIRCUIT (25MM)		CEILING
40.	CONDUIT POINT WIRING (25MM)		CEILING
41.	CONDUIT SUB MAIN WIRING (25MM)		CEILING
43.	split ac		7'-0"
44.	ac outdoor		7'-0"

SERVICES CONSULTANTS

SRAJAN ASSOCIATES
C35 LAJPAT MARG
C-SCHEME JAIPUR

TITLE:- STILT FLOOR
ELECTRICAL PLAN

SCALE:- 1= 100

DATE : 25/07/2024



PROJECT:-

PLOT NO. 259, BLOCK-C, SEZ
(SETTLEMENT) SCHEME, VILLAGE
BHAMBORIYA, TEHSIL SANGANER, JAIPUR
(RAJASTHAN)

ARCHITECTS:-

PANKAJ GUPTA & ASSOCIATES
Flat no. 603 B, Golden Leaf Apartment, Tonk
Road, Near Gandhi Nagar Station, Jaipur-15

OWNER

ARCHITECTS

ROAD 18.0M WIDE

ENTRY/EXIT
LVL.±0.0 M

Praveen
PRAVEEN KUMAR
BTECH (ELECT)

PLOT NO. 258

50.00

GREEN AREA = 33.75 SQ.MT.

DRIVEWAY 3.6m WIDE

DRIVEWAY 3.6m WIDE



DRIVEWAY 3.6m WIDE


SETBACK LINE

GREEN AREA = 73.25 SQ.MT.

GUARD ROOM
1.80X1.80

GREEN AREA = 15.10 SQ.MT.

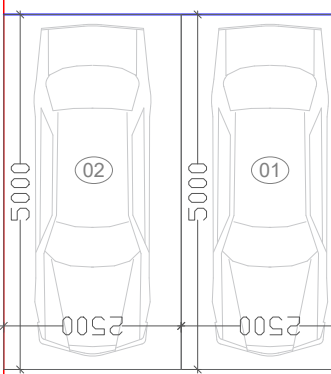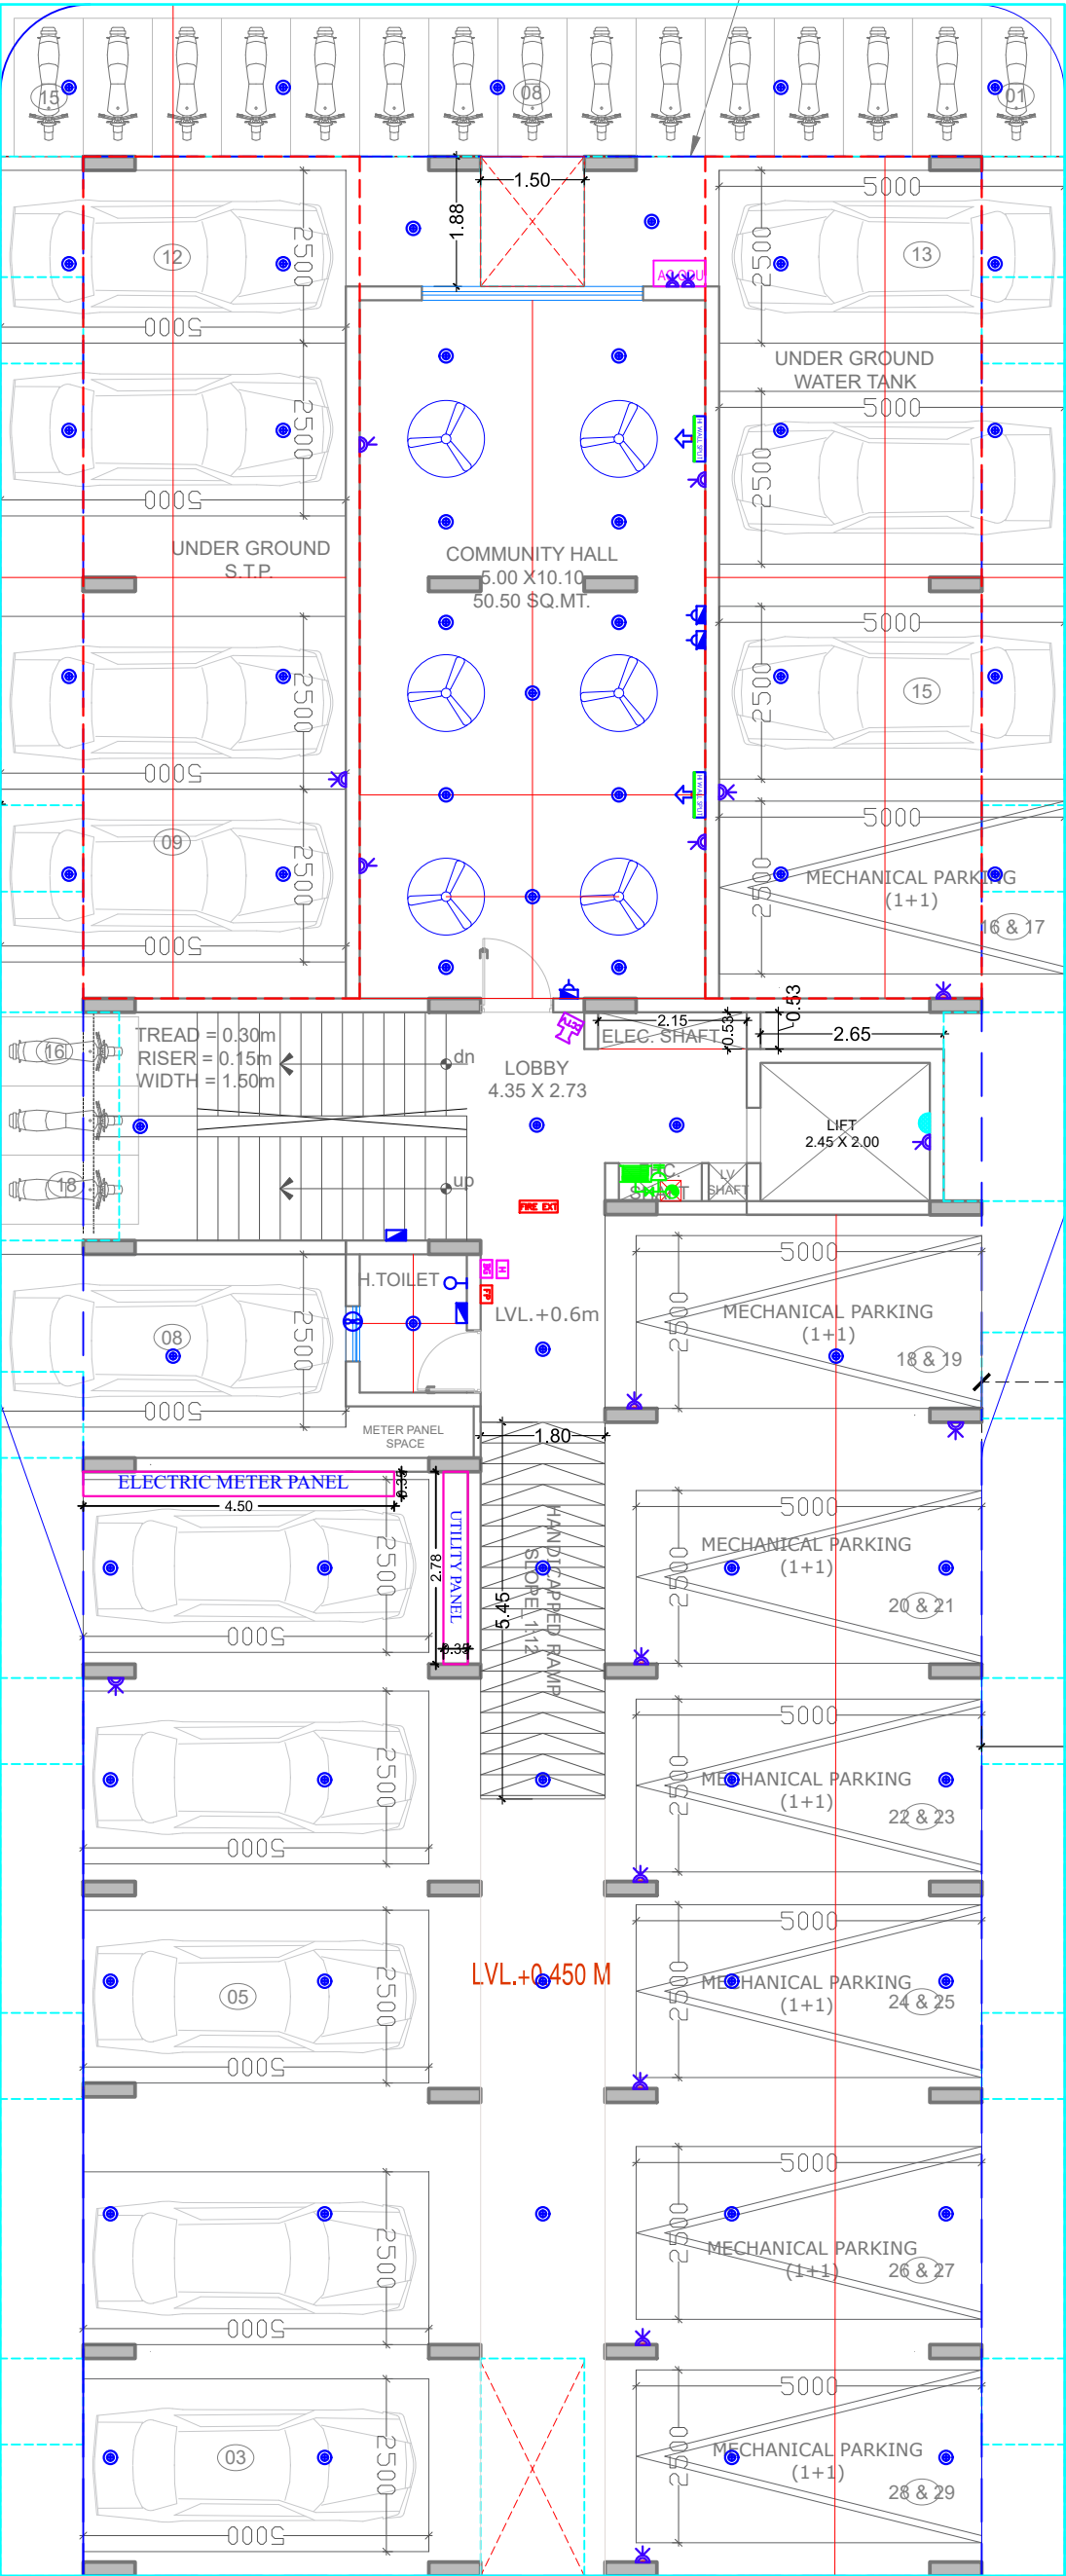

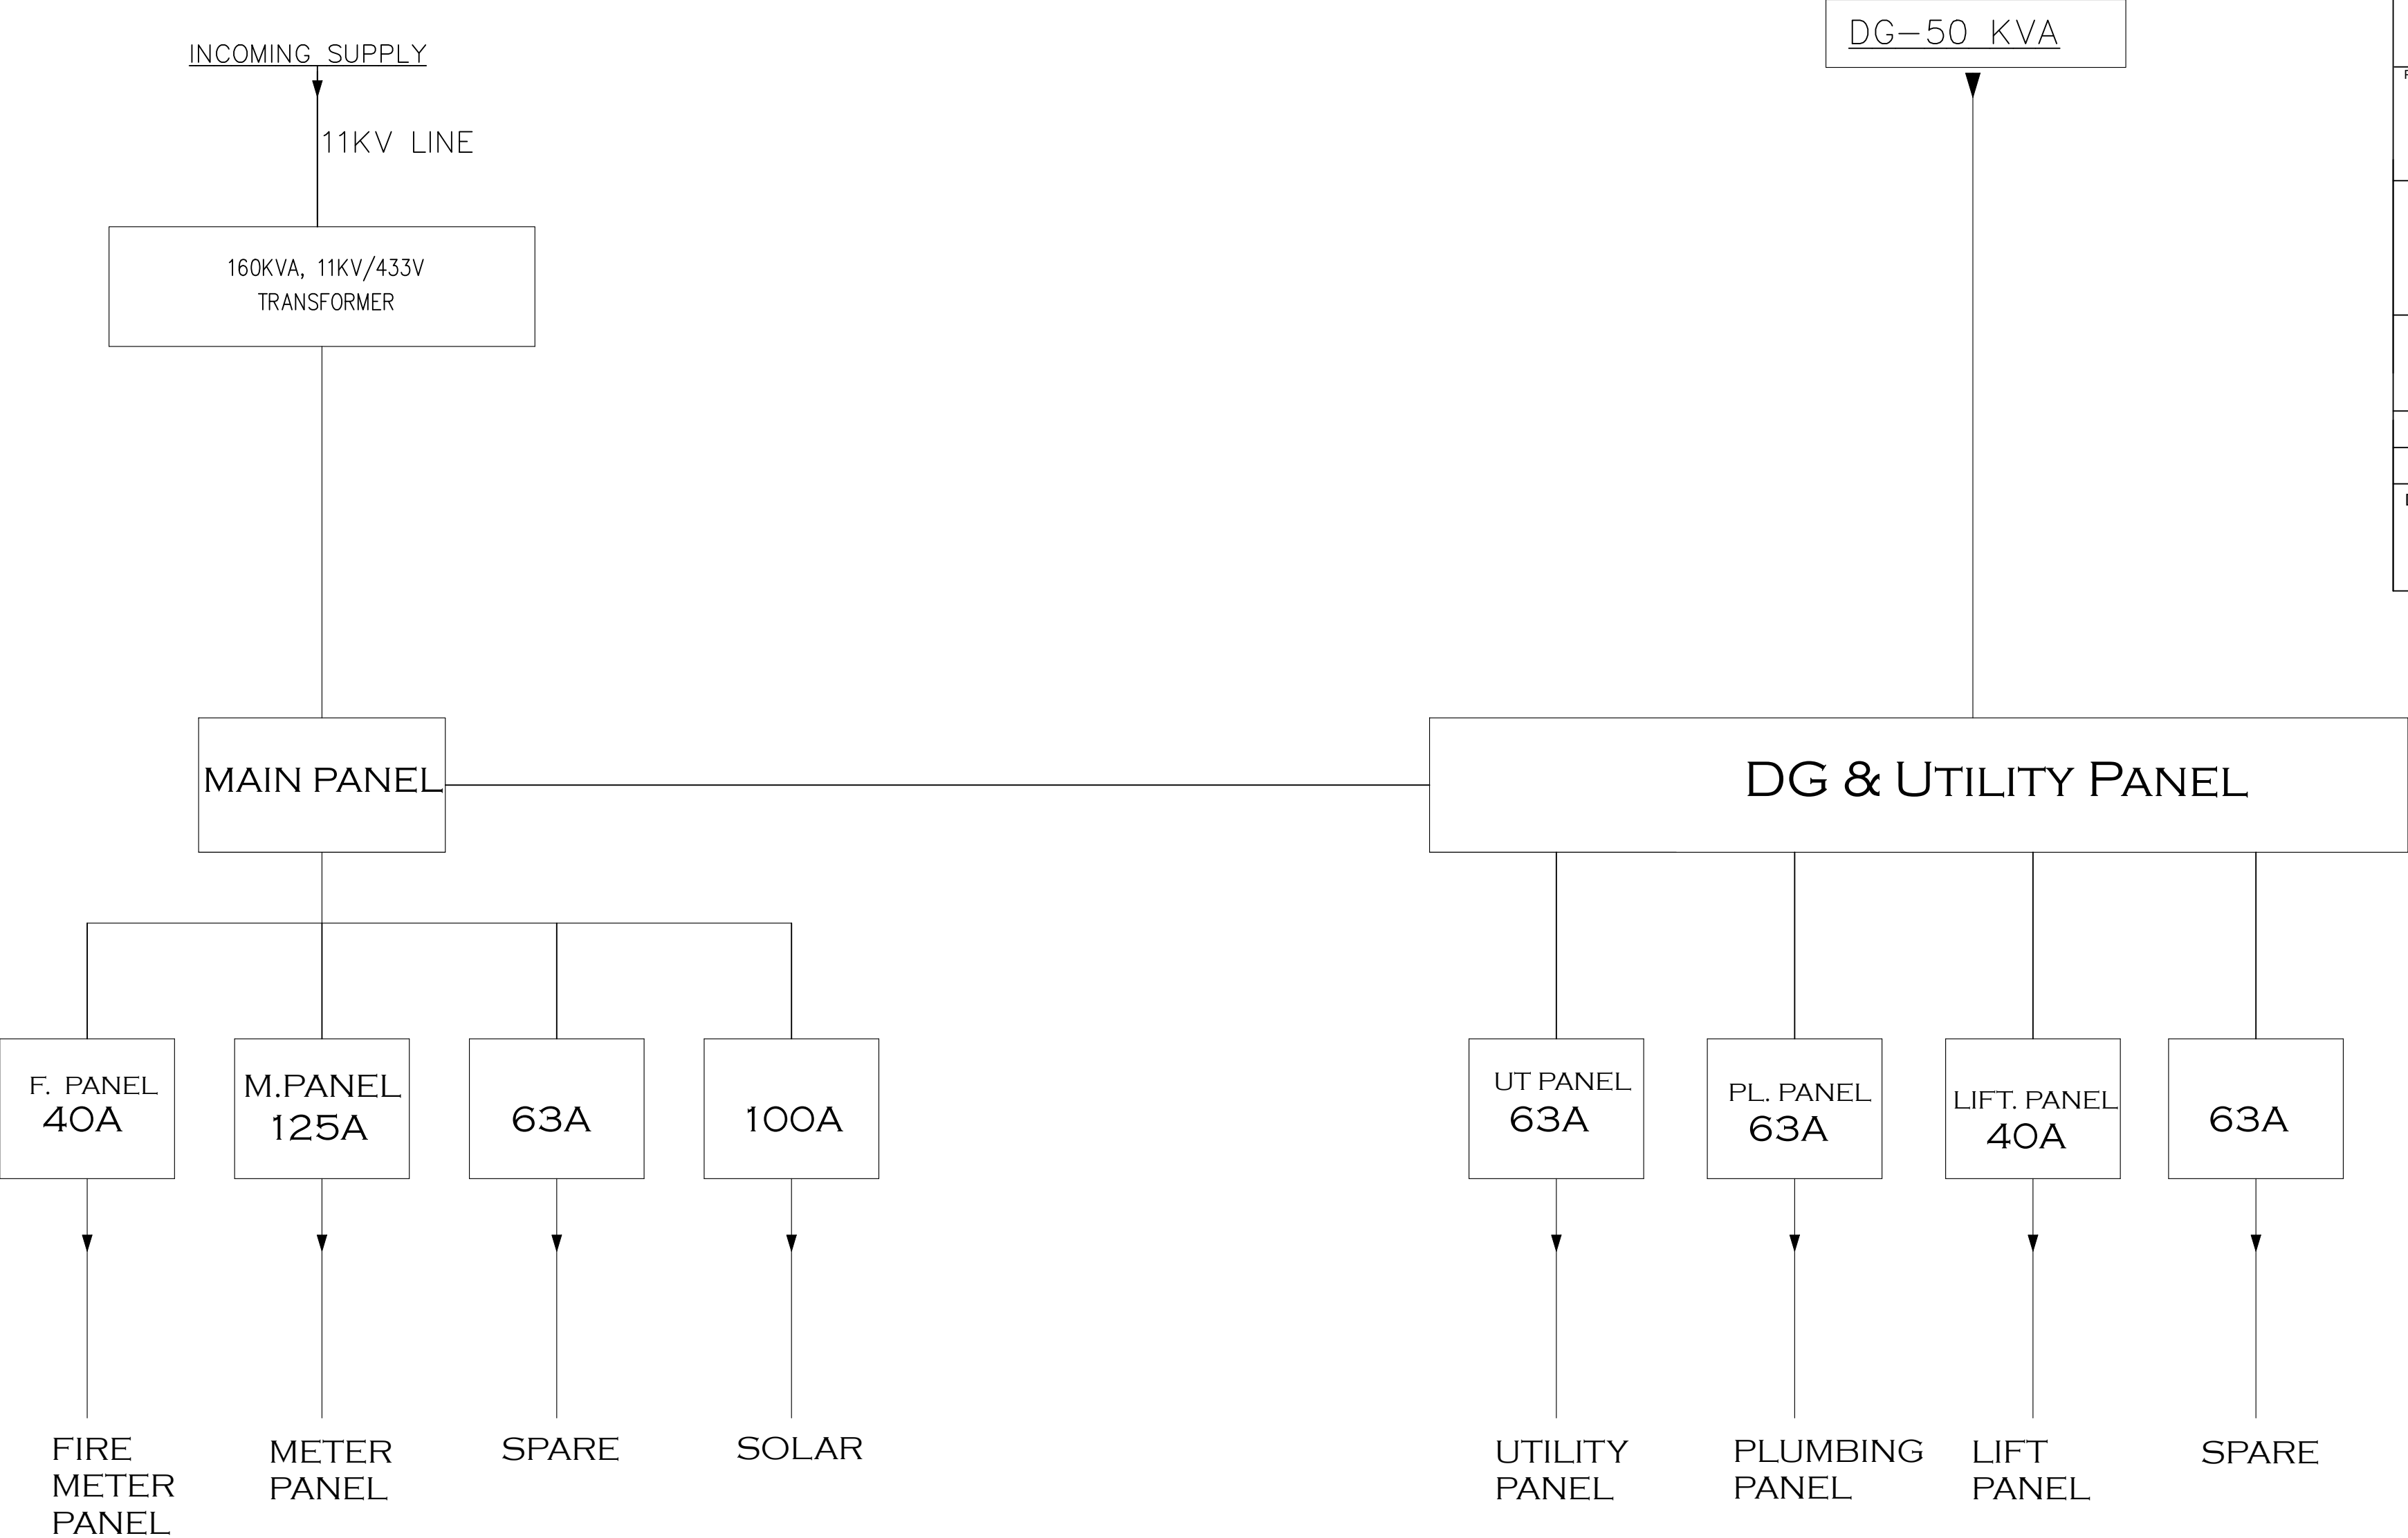

NOTE			
1. GA DRAWING OF THE PANEL SHOULD BE GOT APPROVED FROM THE CONSULTANT BEFORE EXECUTION.			
2. FOR MCCB ALL BREAKING VALUE ARE Ics VALUES.			
PROJECT TITLE			
RESIDENTIAL APARTMENT BHAMBHORIYA			
ELECTRICAL CONSULTANT			
SRAJAN ASSOCIATES JAIPUR			
DRAWING TITLE			
ELECTRICAL SINGLE LINE DIAGRAM (MAIN PANEL)			
DATE	12-02-2025	DEALT	RAHMAN
SCALE	N.T.S.	CHKD.	PG
DRAWING NO.			REV
			00

Praveen
PRAVEEN KUMAR
BTECH (ELECT)

-25.00-


PLOT NO. 258

50.00

PLOT NO. 260

ROAD 18.0M WIDE

TYPICAL FLOOR PLAN
(1ST TO 8TH)

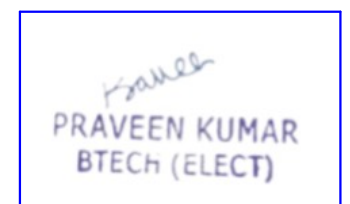

LEGEND			
NO	DESCRIPTION	SYMBOL	FROM FFL
1.	CEILING FAN		CEILING
2.	EXHAUST		6'-0"
3.	WALL FAN POINT		6'-0"
4.	A C POINT(WINDOW AC)		1'-0"
5.	A C POINT(SPLIT AC)		AS PER SITE
6.	3 PHASE POINT		AS PER SITE
7.	A C SOCKET		AS PER SITE
8.	16 AMP POWER PLUG POINT(GENERAL)		1'-0"
9.	GYSER SOCKET 16 AMP		6'-0"
10.	16 AMP POWER PLUG POINT(KITCHEN)		1'4" ABOVE KITCHEN SLAB
11.	16 AMP SOCKET		AS PER SITE
12.	6 AMP PLUG POINT (RED SIDE)		2'-6"
13.	6 AMP SOCKET (CHIMNEY)		7'-0"
14.	6 AMP SOCKET		AS PER SITE
15.	2 NOS 6 AMP POWER PLUG POINT (FOR TV)		1'-6"/4'-6"
16.	2 NOS 6 AMP POWER PLUG POINT		1'-6"/4'-6"
17.	6 AMP PLUG POINT (GENERAL)		1'-0"
18.	NIGHT LAMP		1'-6"
19.	KEY TAG		4'-0"
20.	INVERTOR SOCKET		1'-6"
21.	SWITCH BOARD WITH 6 AMP POINT		4'-0"
22.	SWITCH BOARD WITH 6 AMP POINT		4'-0"
23.	BELL PUSH		4'-0"
24.	GYSER SWITCH 16 AMP		4'-0"
25.	PROJECTOR POINT		3'-6"
26.	TELEPHONE POINT(BED SIDE)		2'-6"
27.	TELEPHONE POINT (GENERAL)		1'-0"
28.	TV POINT (GENERAL)		2'-6"
29.	LAN POINT		2'-6"
30.	CEILING LIGHT 'FX'		CEILING
31.	CEILING LIGHT		CEILING
32.	CHANDELIER		CEILING
33.	40W TUBE LIGHT ON CEILING		CEILING
34.	BULB HOLDER ON SIDE WALL		7'-0"
35.	TUBE LIGHT ON WALL		7'-0"
36.	BULKHEAD FOR RAMP		2'-6"
37.	DISTRIBUTION BOX		5'-6"
38.	BELL		7'-0"
39.	CONDUIT CIRCUIT (25MM)		CEILING
40.	CONDUIT POINT WIRING (25MM)		CEILING
41.	CONDUIT SUB MAIN WIRING (25MM)		CEILING
42.	split ac		7'-0"
43.	ac outdoor		7'-0"

SRAJAN ASSOCIATES
C35 LAJPAT MARG
C-SCHEME JAIPUR

SCALE:- 1= 100

DATE : 25/07/202



ARCHITECTS:-

PANKAJ GUPTA & ASSOCIATES
Flat no. 603 B, Golden Leaf Apartment, Tonk
Road, Near Gandhi Nagar Station, Jaipur-15


OWNER	ARCHITECTS
-------	------------

PLOT NO. 244

25.00

REAR

SETBACK LINE

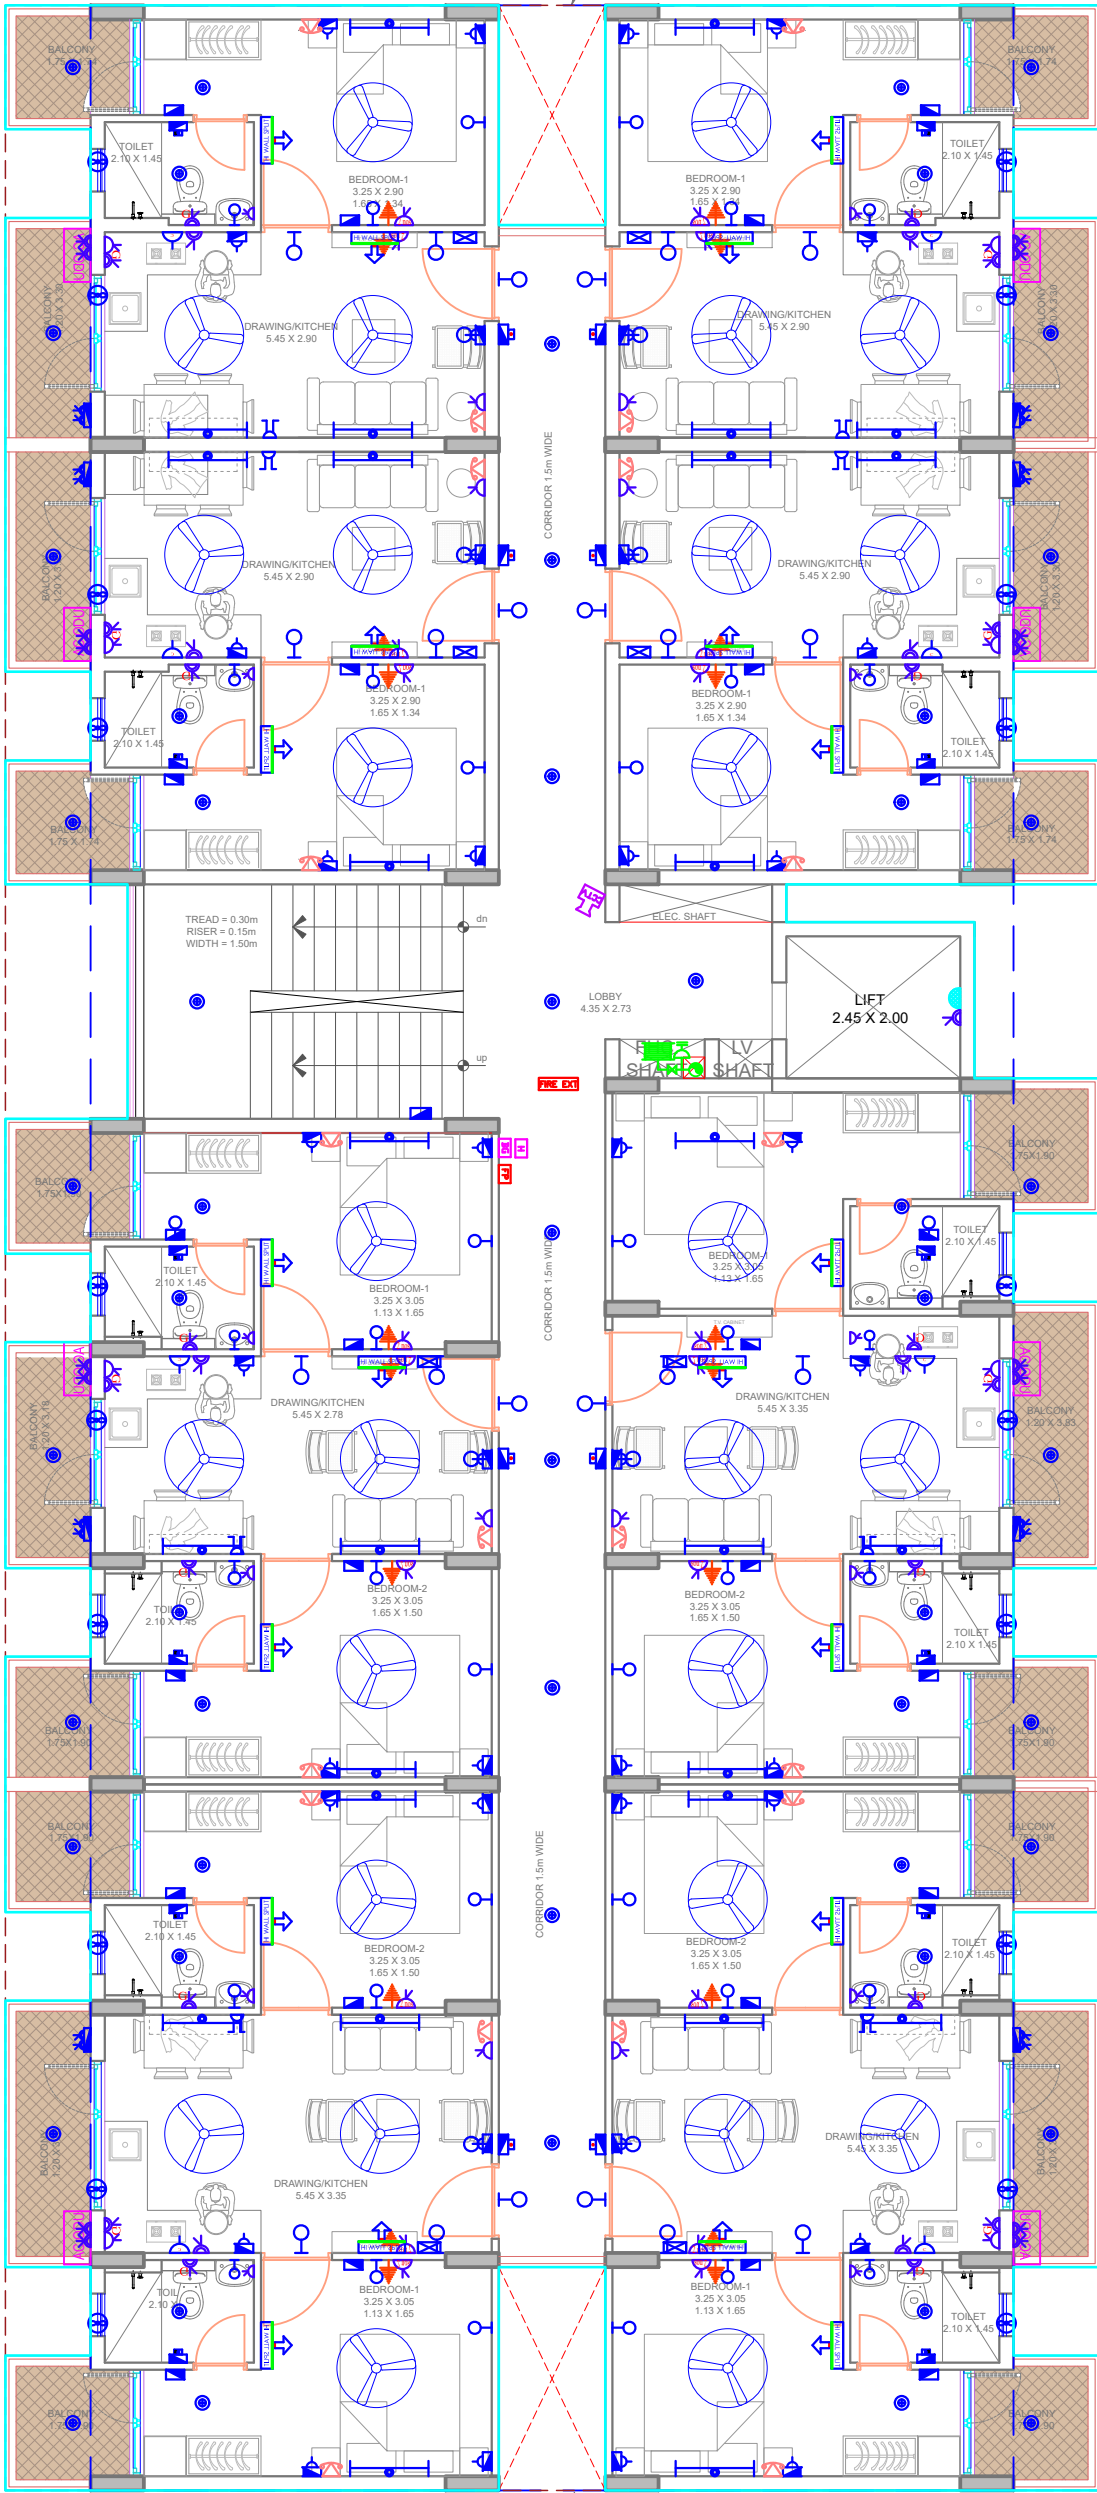

EAST SIDE

WEST SIDE

SETBACK LINE

FRONT

ROAD 18.0M WIDE

SHEET NO. - 04 /09

TYPICAL FLOOR PLAN
(1ST TO 8TH)

Praveen
PRAVEEN KUMAR
BTECH (ELECT)

LEGEND			
NO	DESCRIPTION	SYMBOL	FROM FFL
1.	CEILING FAN		CEILING
2.	EXHAUST		6'-0"
3.	WALL FAN POINT		6'-0"
4.	A C POINT(WINDOW AC)		1'-0"
5.	A C POINT(SPLIT AC)		AS PER SITE
6.	3 PHASE POINT		AS PER SITE
7.	A C SOCKET		AS PER SITE
8.	16 AMP POWER PLUG POINT(GENERAL)		1'-0"
9.	GYSER SOCKET 16 AMP		6'-0"
10.	16 AMP POWER PLUG POINT(KITCHEN)		1'-0" ABOVE KITCHEN SLAB
11.	16 AMP SOCKET		AS PER SITE
12.	6 AMP PLUG POINT (BED SIDE)		2'-6"
13.	6 AMP SOCKET (CHIMNEY)		7'-0"
14.	6 AMP SOCKET		AS PER SITE
15.	2 NOS 6 AMP POWER PLUG POINT (FOR TV)		1'-6"/4'-6"
16.	2 NOS 6 AMP POWER PLUG POINT		1'-6"/4'-6"
17.	6 AMP PLUG POINT (GENERAL)		1'-0"
18.	NIGHT LAMP		1'-6"
19.	KEY TAG		4'-0"
20.	INVERTOR SOCKET		1'-6"
21.	SWITCH BOARD WITH OUT 6 AMP POINT		4'-0"
22.	SWITCH BOARD WITH 6 AMP POINT		4'-0"
23.	BELL PUSH		4'-0"
24.	GYSER SWITCH 16 AMP		4'-0"
25.	PROJECTOR POINT		3'-6"
26.	TELEPHONE POINT (BED SIDE)		2'-6"
27.	TELEPHONE POINT (GENERAL)		1'-0"
28.	TV POINT (GENERAL)		2'-6"
29.	LAN POINT		2'-6"
30.	CEILING LIGHT (XU)		CEILING
31.	CEILING LIGHT		CEILING
32.	CHANDELIER		CEILING
33.	40W TUBE LIGHT ON CEILING		CEILING
34.	BULB HOLDER ON SIDE WALL		7'-0"
35.	TUBE LIGHT ON WALL		7'-0"
36.	BULKHEAD FOR RAMP		2'-6"
37.	DISTRIBUTION BOX		5'-6"
38.	BELL		7'-0"
39.	CONDUIT CIRCUIT (25MM)		CEILING
40.	CONDUIT POINT WIRING (25MM)		CEILING
41.	CONDUIT SUB MAIN WIRING (25MM)		CEILING
43.	split ac		7'-0"
44.	ac outdoor		7'-0"

SERVICES CONSULTANTS

SRAJAN ASSOCIATES
C35 LAJPAT MARG
C-SCHEME JAIPUR

TITLE:- TYPICAL FLOOR ELECTRICAL
SUBMISSION PLAN

SCALE:- 1= 100
DATE : 25/07/2024



PROJECT:-

PLOT NO. 259, BLOCK-C, SEZ
(SETTLEMENT) SCHEME, VILLAGE
BHAMBORIYA, TEHSIL SANGANER, JAIPUR
(RAJASTHAN)

ARCHITECTS:-

PANKAJ GUPTA & ASSOCIATES
Flat no. 603 B, Golden Leaf Apartment, Tonk
Road, Near Gandhi Nagar Station, Jaipur-15

OWNER

ARCHITECTS