


PLOT NO. 244

25.00

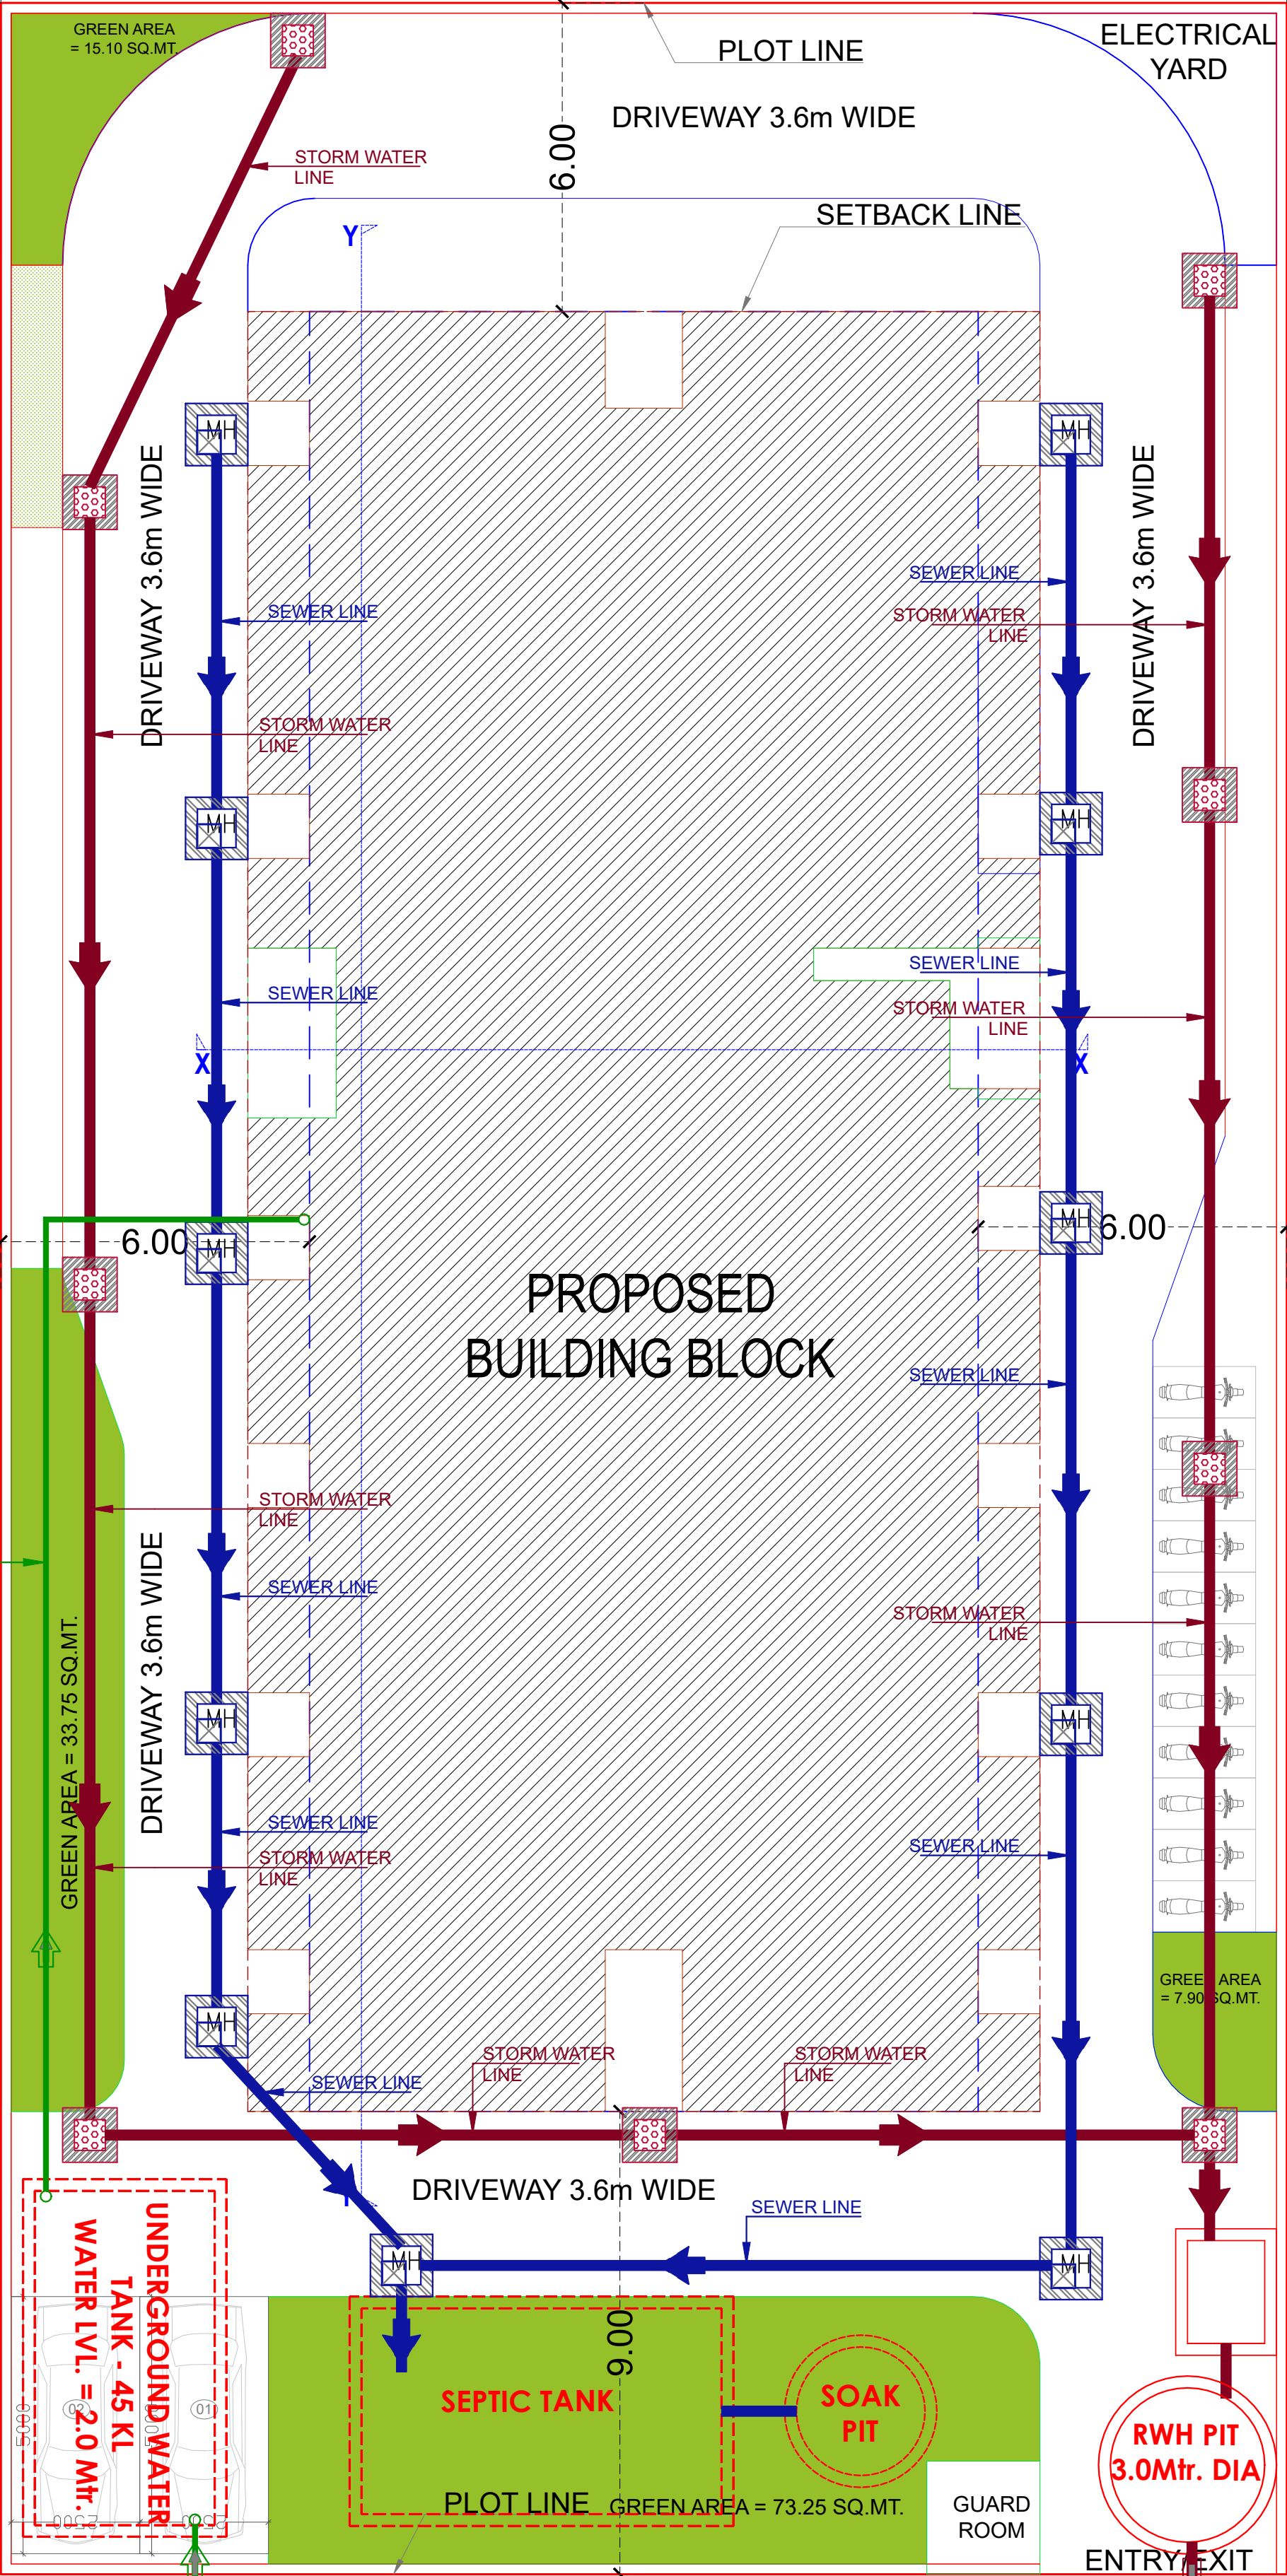

SHEET NO. - 01 /06

STILT FLOOR PLAN

SOMANATH BEHARA
BTECH (CIVIL)

TITLE:- SUBMISSION DRAWINGS
PLUMBING SITE PLAN

SCALE:- 1= 100

DATE : 14/02/2025



PROJECT:-

PLOT NO. 259, BLOCK-C, SEZ
(SETTLEMENT) SCHEME, VILLAGE
BHAMBORIYA, TEHSIL SANGANER, JAIPUR
(RAJASTHAN)

ARCHITECTS:-

PANKAJ GUPTA & ASSOCIATES
Flat no. 603 B, Golden Leaf Apartment, Tonk
Road, Near Gandhi Nagar Station, Jaipur-15


OWNER

ARCHITECTS

PLOT NO. 244

SHEET NO. - 04 /06

TERRACE FLOOR PLAN

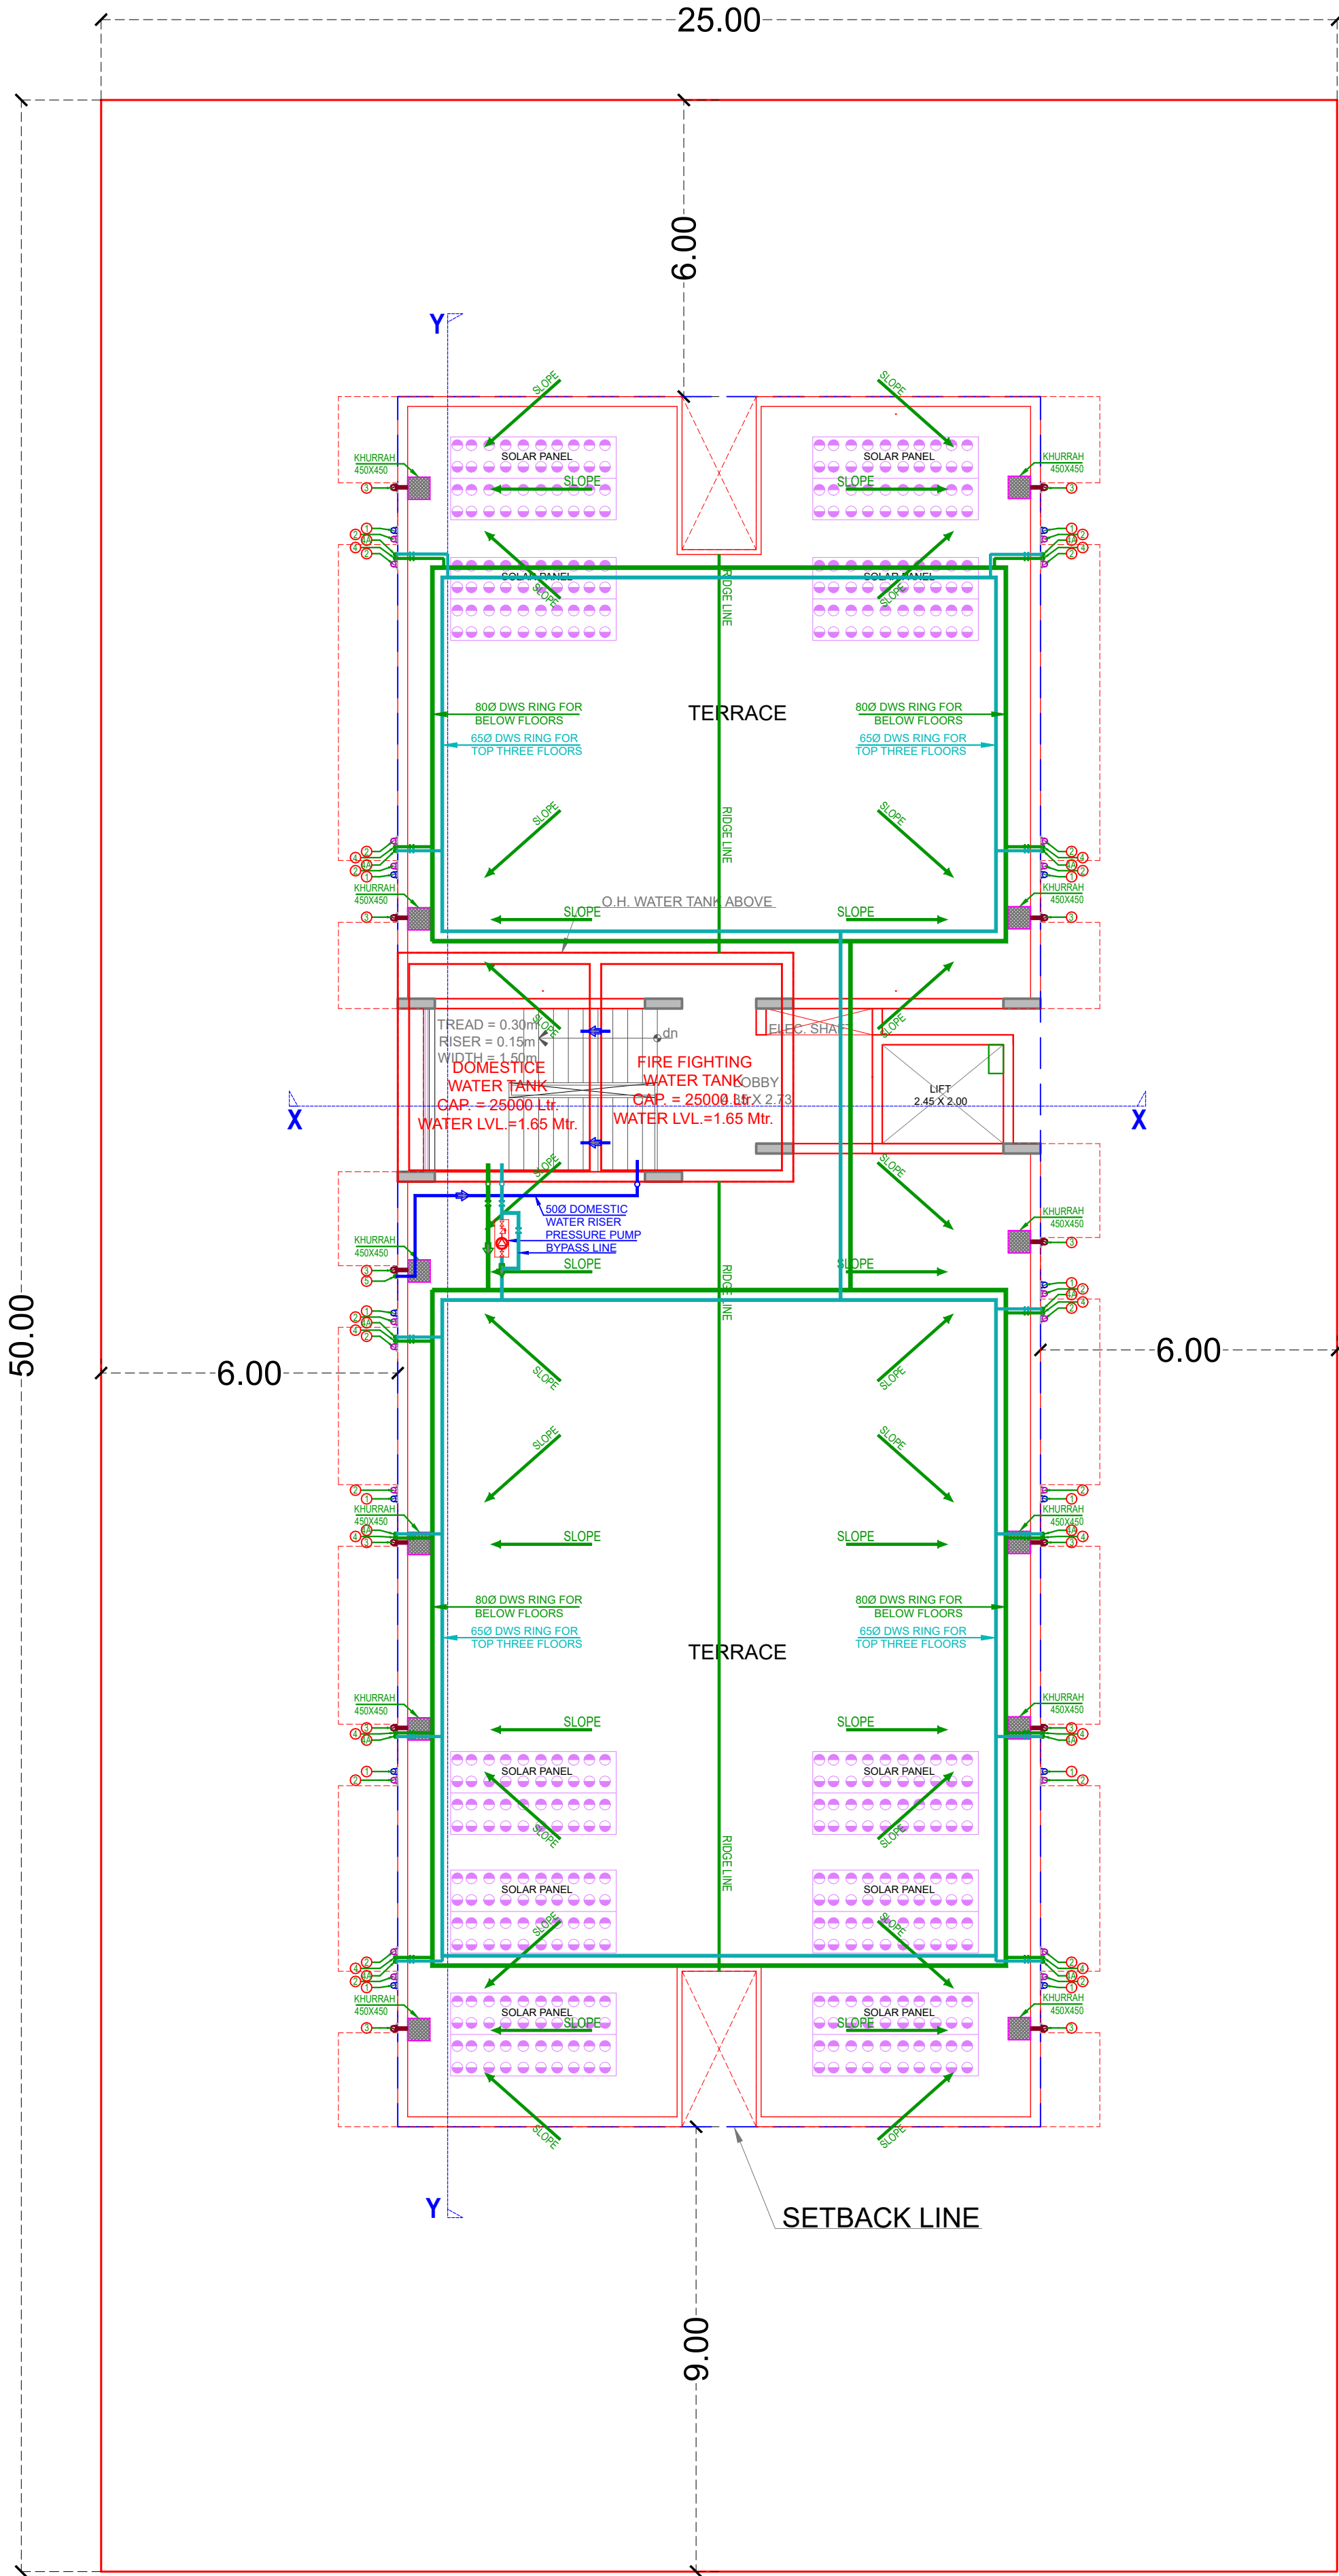

SOMANATH BEHARA
BTECH (CIVIL)

LEGENDS	
S.NO.	DESCRIPTION
①	DWS DOMESTIC WATER SUPPLY BELOW FLOOR
②	DWS DOMESTIC WATER SUPPLY TOP THREE FLOOR
③	ALL TERRACE RING(GI PIPE)
④	ALL WATER SUPPLY VERTICAL PIPE
⑤	ARV AIR RELEASE VALVE
TOP THREE FLOORS WATER SUPPLY SYSTEM BY PUMPING	
BELOW FLOORS WATER SUPPLY SYSTEM BY GRAVITY	

SCHEDULE OF PIPES

PIPE NO.	DESCRIPTION
①	110 OD uPVC SWR TYPE B SOIL PIPE
②	110 OD uPVC SWR TYPE B WASTE PIPE
③	110 OD uPVC RAIN WATER PIPE FOR TERRACE
④	DOMESTIC WATER SUPPLY D/N TAKE PIPE BELOW FLOORS
④A	DOMESTIC WATER SUPPLY D/N TAKE PIPE TOP 3 FLOORS
⑤	WATER SUPPLY RISER PIPE * (DOMESTIC)
⑥	90 OD uPVC RAIN WATER PIPE FOR BALCONY

TITLE:- SUBMISSION DRAWINGS
TERRACE PLUMBING LAYOUT PLAN

SCALE:- 1= 100
DATE : 14/02/2025



PROJECT:-

PLOT NO. 259, BLOCK-C, SEZ
(SETTLEMENT) SCHEME, VILLAGE
BHAMBORIYA, TEHSIL SANGANER, JAIPUR
(RAJASTHAN)

ARCHITECTS:-

PANKAJ GUPTA & ASSOCIATES
Flat no. 603 B, Golden Leaf Apartment, Tonk
Road, Near Gandhi Nagar Station, Jaipur-15

OWNER ARCHITECTS

ROAD 18.0M WIDE


PLOT NO. 244

25.00

REAR

6.00

SETBACK LINE

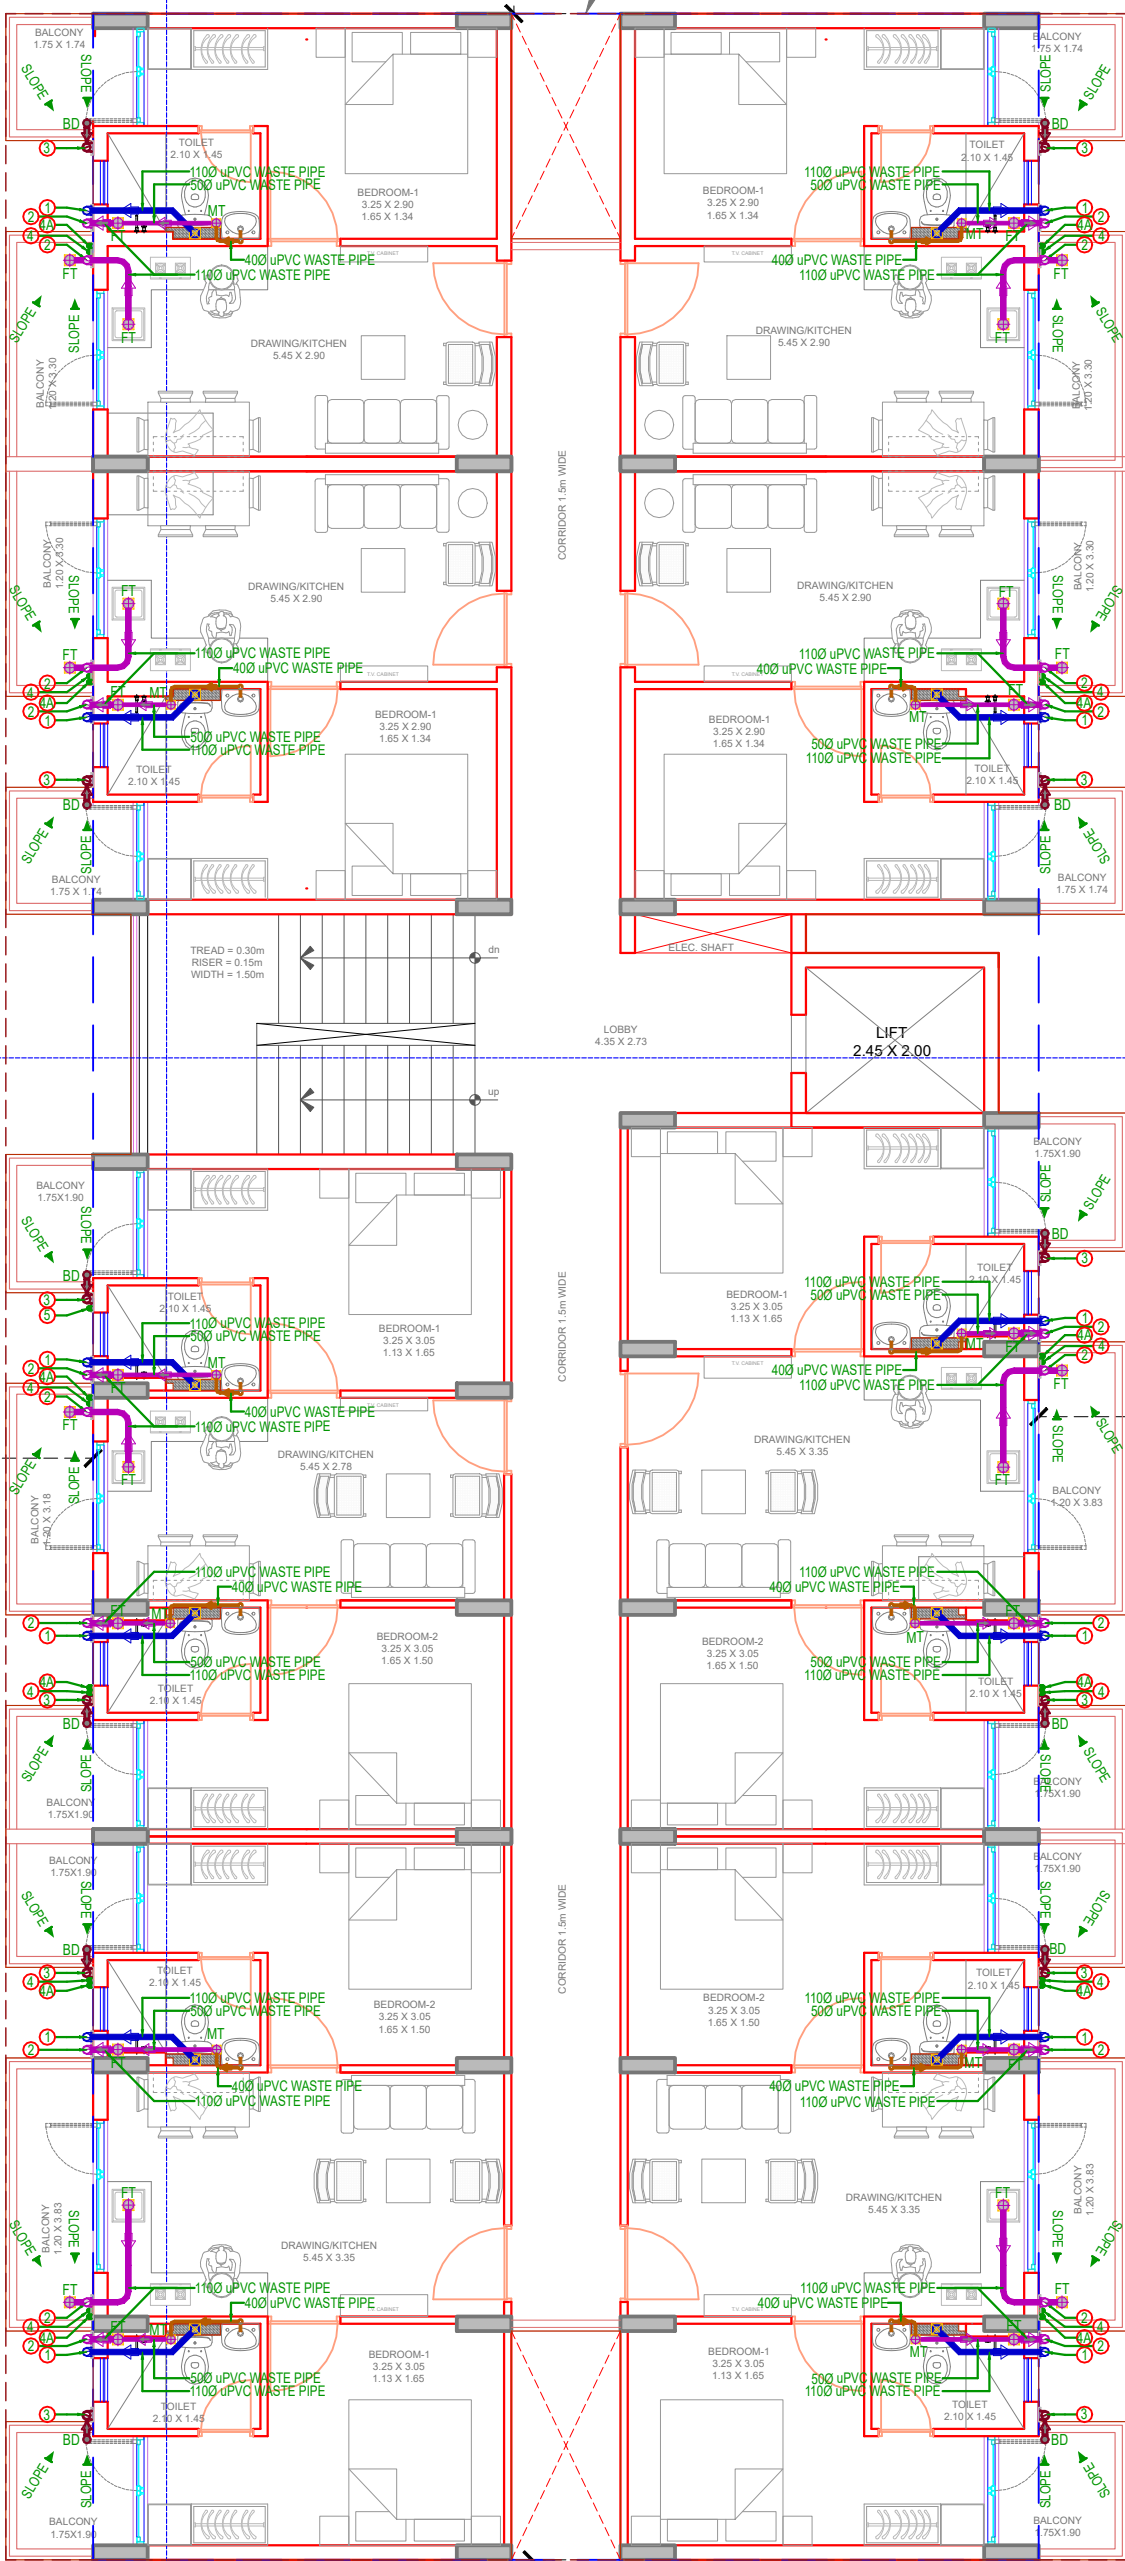

FRONT

9.00

SETBACK LINE

ROAD 18.0M WIDE

SHEET NO. - 02 /06

TYPICAL FLOOR PLAN
(1ST TO 8TH)

SOMANATH BEHARA
BTECH (CIVIL)

PLUMBING NOTES:-

- 1 WASH BASIN TO MULTI TRAP (MT) 40 OD uPVC 6 KG PIPE.
- 2 (MT) TO FLOOR TRAP (FT) 50 OD uPVC WASTE PIPE
- 3 110 OD uPVC PIPE USED FOR SOIL & WASTE.
- 4 110 OD uPVC PIPE USED FOR TERRACE RAIN WATER

PLUMBING LEGEND:-

- FT FLOOR TRAP 110X110mm
- MT MULTI TRAP 110X50mm
- FD FLOOR DRAIN 110X63mm
- BD BALCONY DRAIN 110X63mm

SCHEDULE OF PIPES

PIPE NO.	DESCRIPTION
1	110 OD uPVC SWR TYPE B SOIL PIPE
2	110 OD uPVC SWR TYPE B WASTE PIPE
3	110 OD uPVC RAIN WATER PIPE FOR TERRACE
4	DOMESTIC WATER SUPPLY D/N TAKE PIPE BELOW FLOORS
4A	DOMESTIC WATER SUPPLY D/N TAKE PIPE TOP 3 FLOORS
5	WATER SUPPLY RISER PIPE * (DOMESTIC)
6	90 OD uPVC RAIN WATER PIPE FOR BALCONY

TITLE:- SUBMISSION DRAWINGS
TYPICAL FLOOR DRAINAGE PLAN
(1ST TO 8TH)

SCALE:- 1= 100
DATE : 14/02/2025



PROJECT:-

PLOT NO. 259, BLOCK-C, SEZ
(SETTLEMENT) SCHEME, VILLAGE
BHAMBORIYA, TEHSIL SANGANER, JAIPUR
(RAJASTHAN)

ARCHITECTS:-

PANKAJ GUPTA & ASSOCIATES
Flat no. 603 B, Golden Leaf Apartment, Tonk
Road, Near Gandhi Nagar Station, Jaipur-15

OWNER

ARCHITECTS


PLOT NO. 244

25.00

REAR

6.00

SETBACK LINE

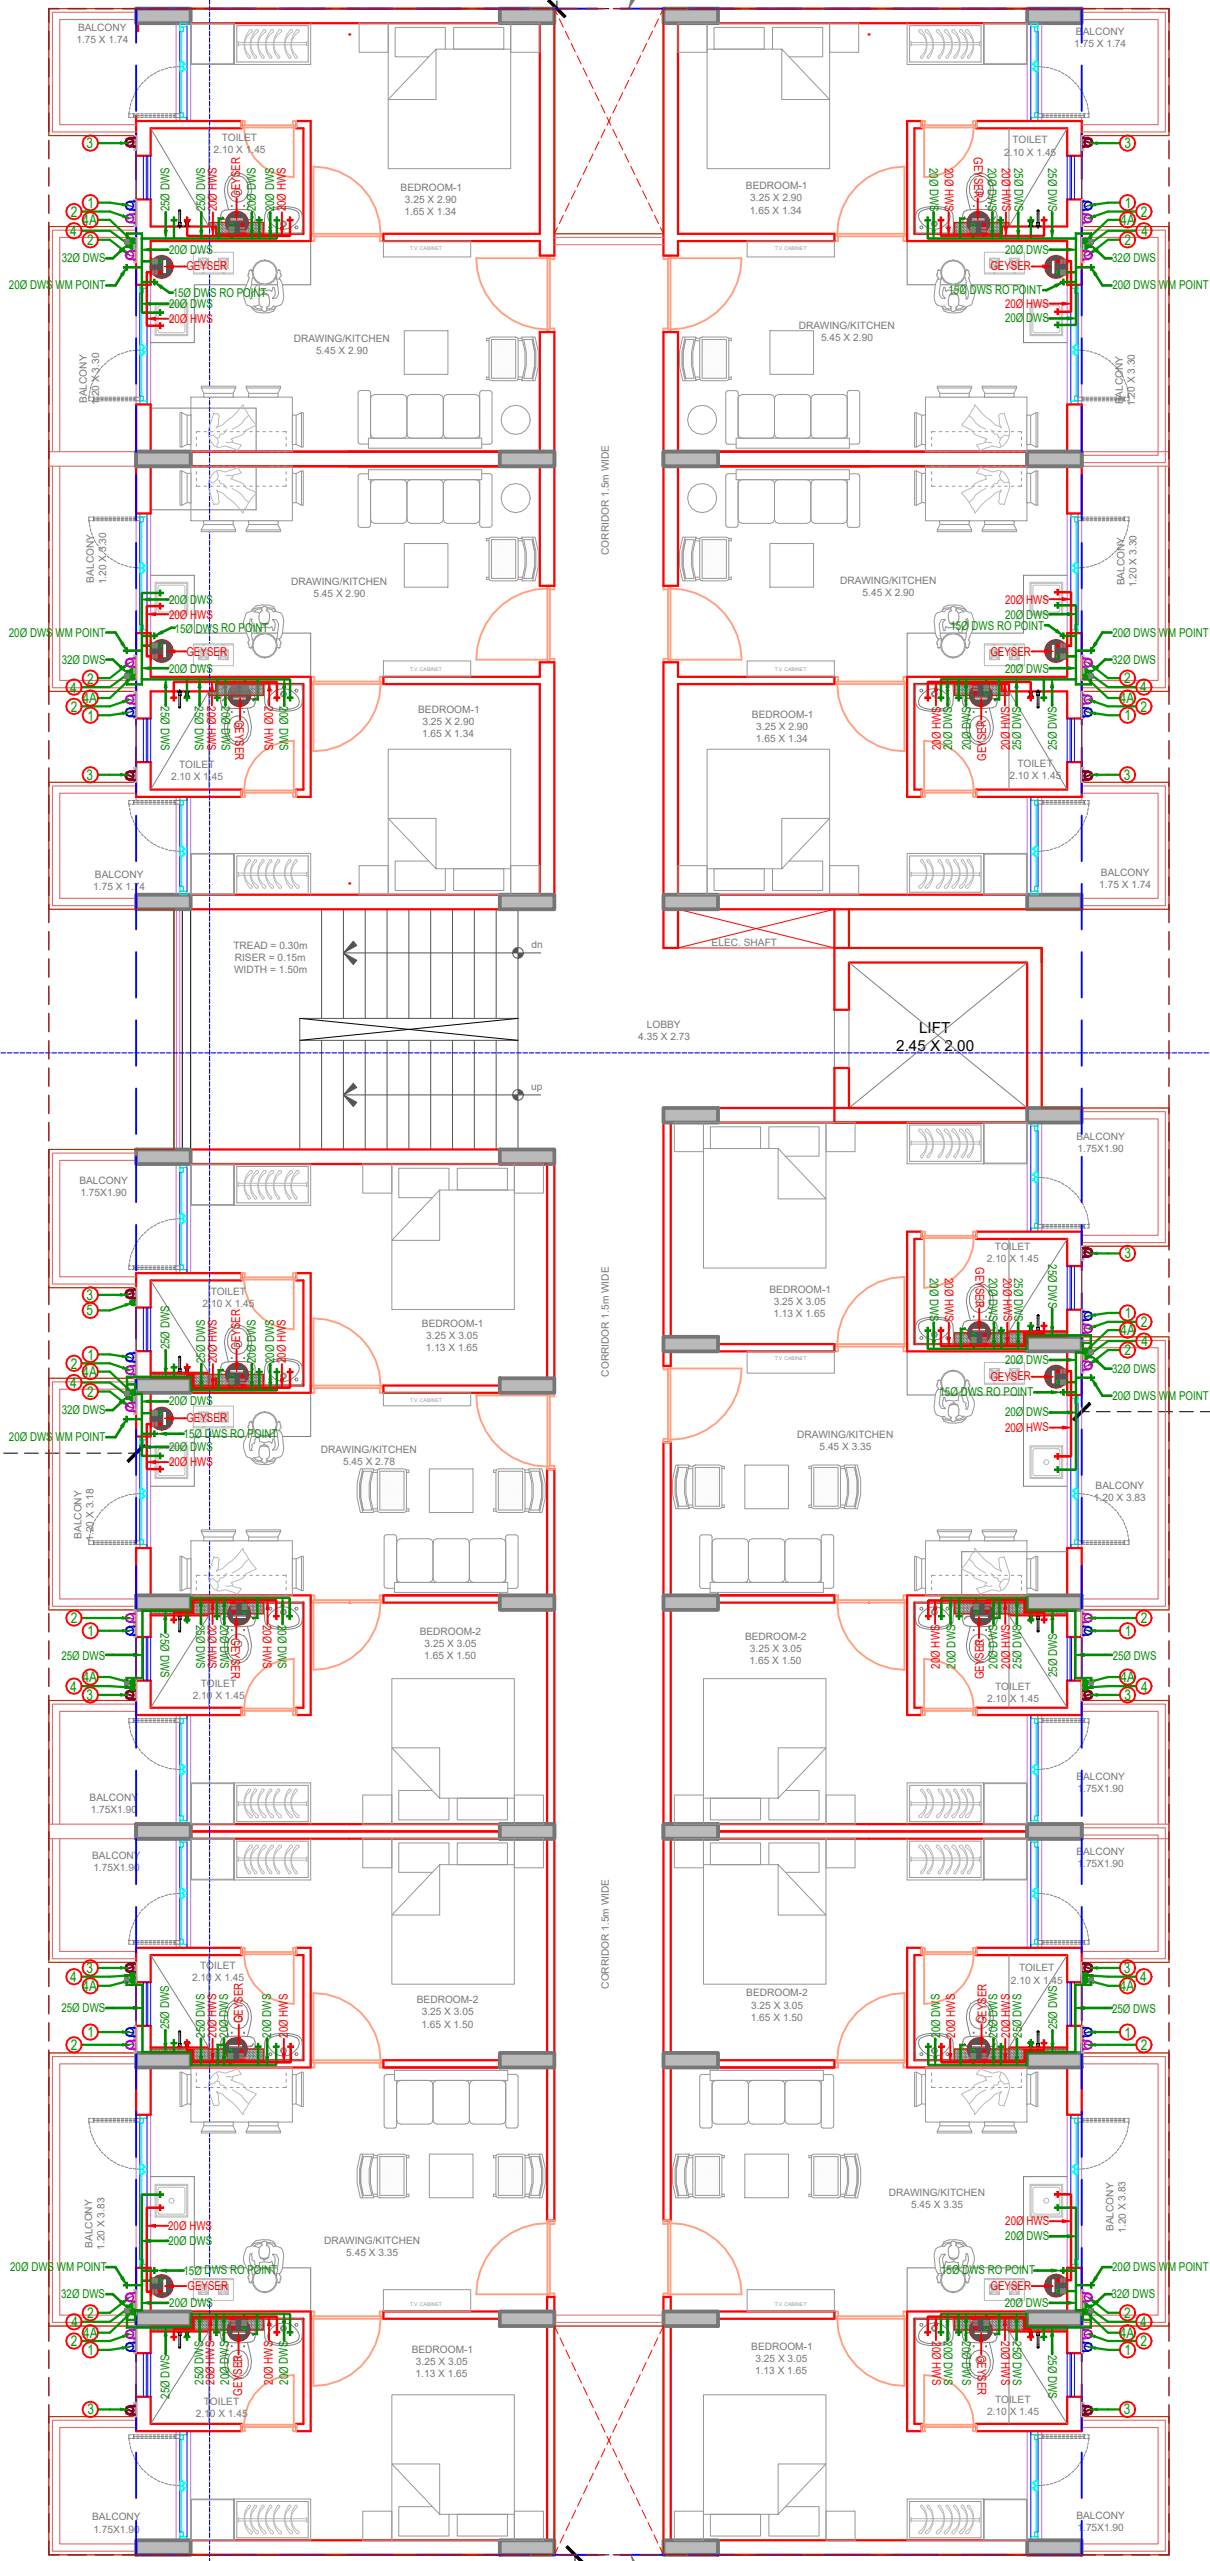

EAST SIDE

WEST SIDE

SETBACK LINE

FRONT

9.00

ROAD 18.0M WIDE

SHEET NO. - 03 /06

TYPICAL FLOOR PLAN
(1ST TO 8TH)

SOMANATH BEHARA
BTECH (CIVIL)

PLUMBING NOTES:-

DWS - DOMESTICS WATER SUPPLY

HWS - HOT WATER SUPPLY

VALVE

GEYSER

SCHEDULE OF PIPES

PIPE NO.	DESCRIPTION
1	110 OD uPVC SWR TYPE B SOIL PIPE
2	110 OD uPVC SWR TYPE B WASTE PIPE
3	110 OD uPVC RAIN WATER PIPE FOR TERRACE
4	DOMESTIC WATER SUPPLY D/N TAKE PIPE BELOW FLOOR
4A	DOMESTIC WATER SUPPLY D/N TAKE PIPE TOP 3 FLOORS
5	WATER SUPPLY RISER PIPE * (DOMESTIC)
6	90 OD uPVC RAIN WATER PIPE FOR BALCONY

TITLE:- SUBMISSION DRAWINGS
TYPICAL FLOOR WATER SUPPLY LAYOUT PLAN
(1ST TO 8TH)

SCALE:- 1= 100

DATE : 14/02/2025



PROJECT:-



PLOT NO. 259, BLOCK-C, SEZ
(SETTLEMENT) SCHEME, VILLAGE
BHAMBORIYA, TEHSIL SANGANER, JAIPUR
(RAJASTHAN)

ARCHITECTS:-


PANKAJ GUPTA & ASSOCIATES
Flat no. 603 B, Golden Leaf Apartment, Tonk
Road, Near Gandhi Nagar Station, Jaipur-15

OWNER


ARCHITECTS

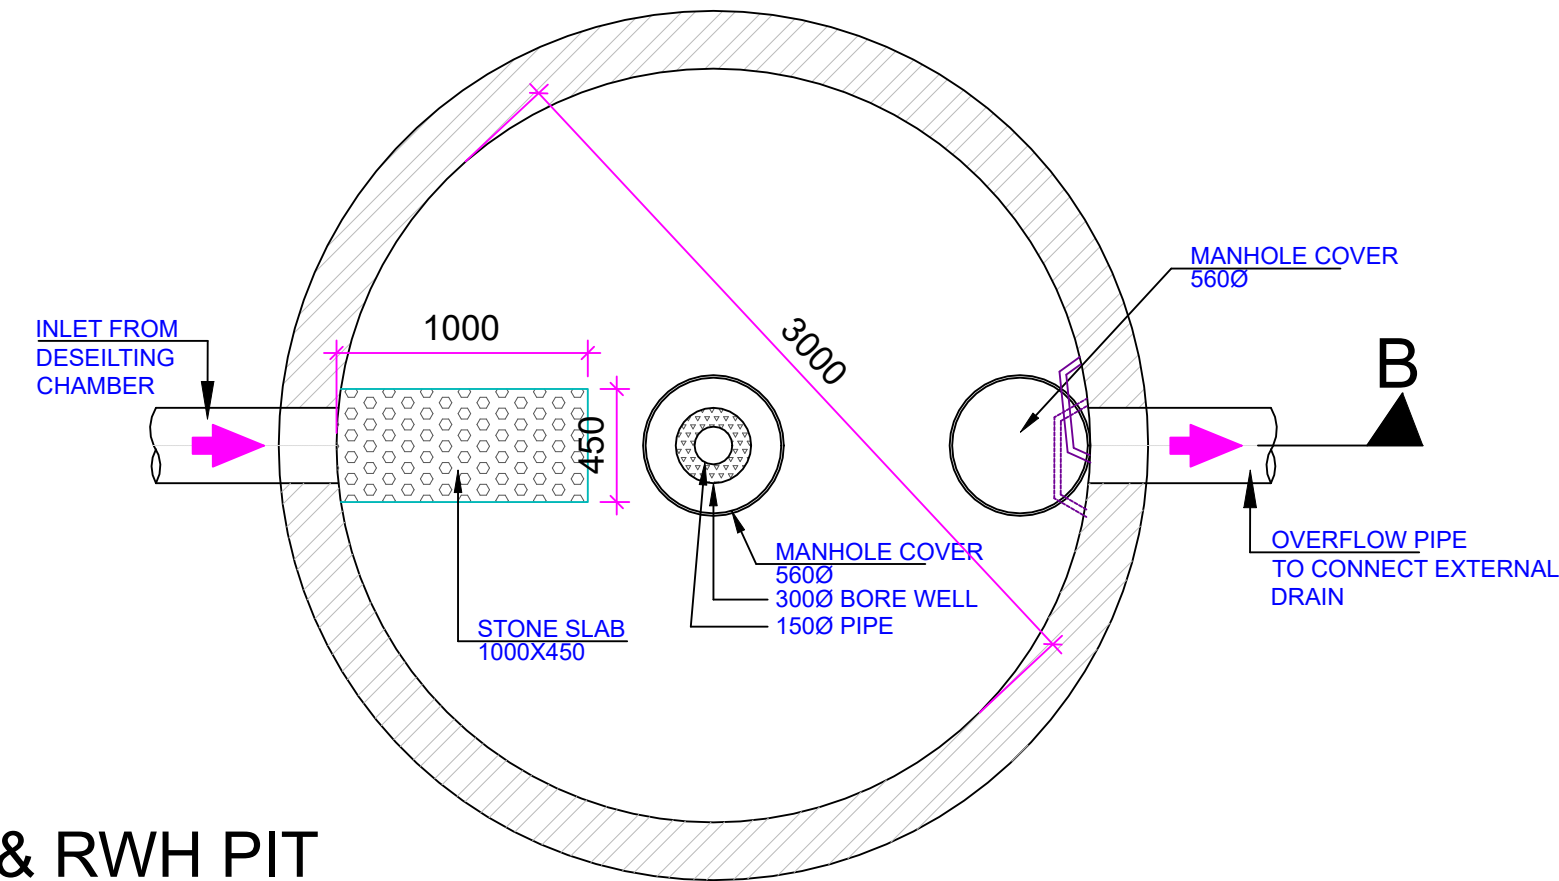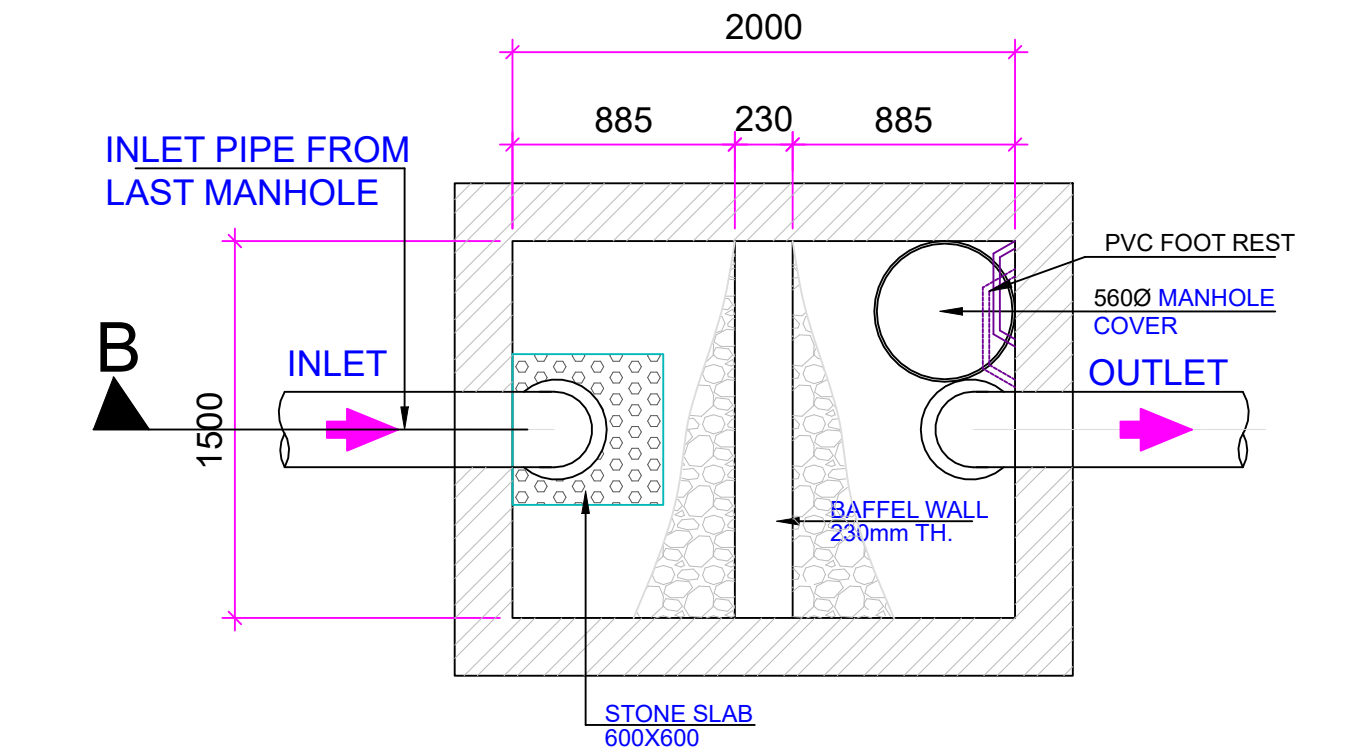

PLAN OF DESILTING CHAMBER & RWH PIT

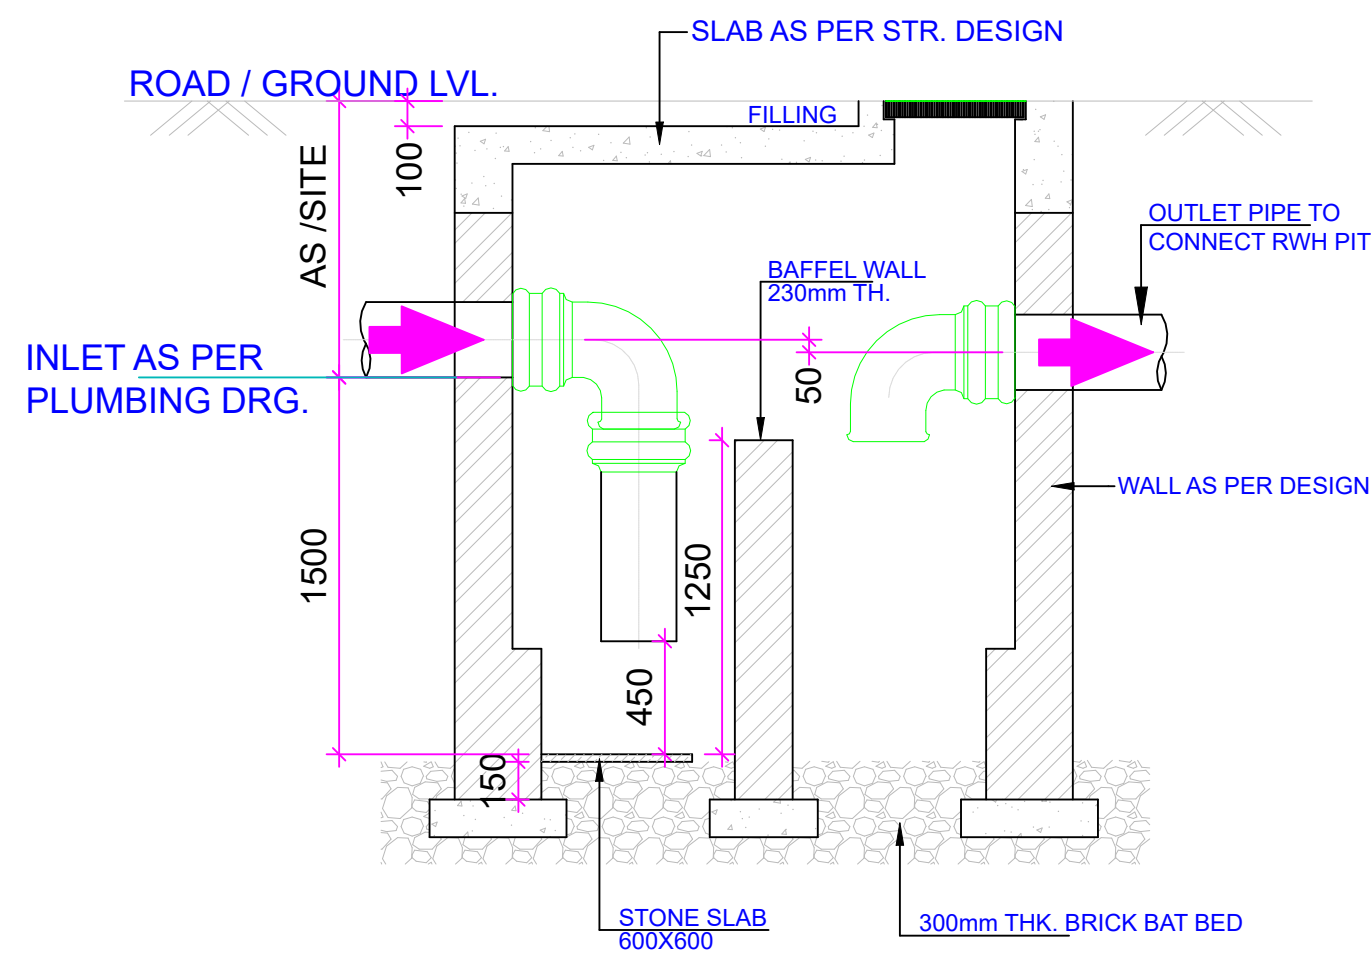

SECTION-B B

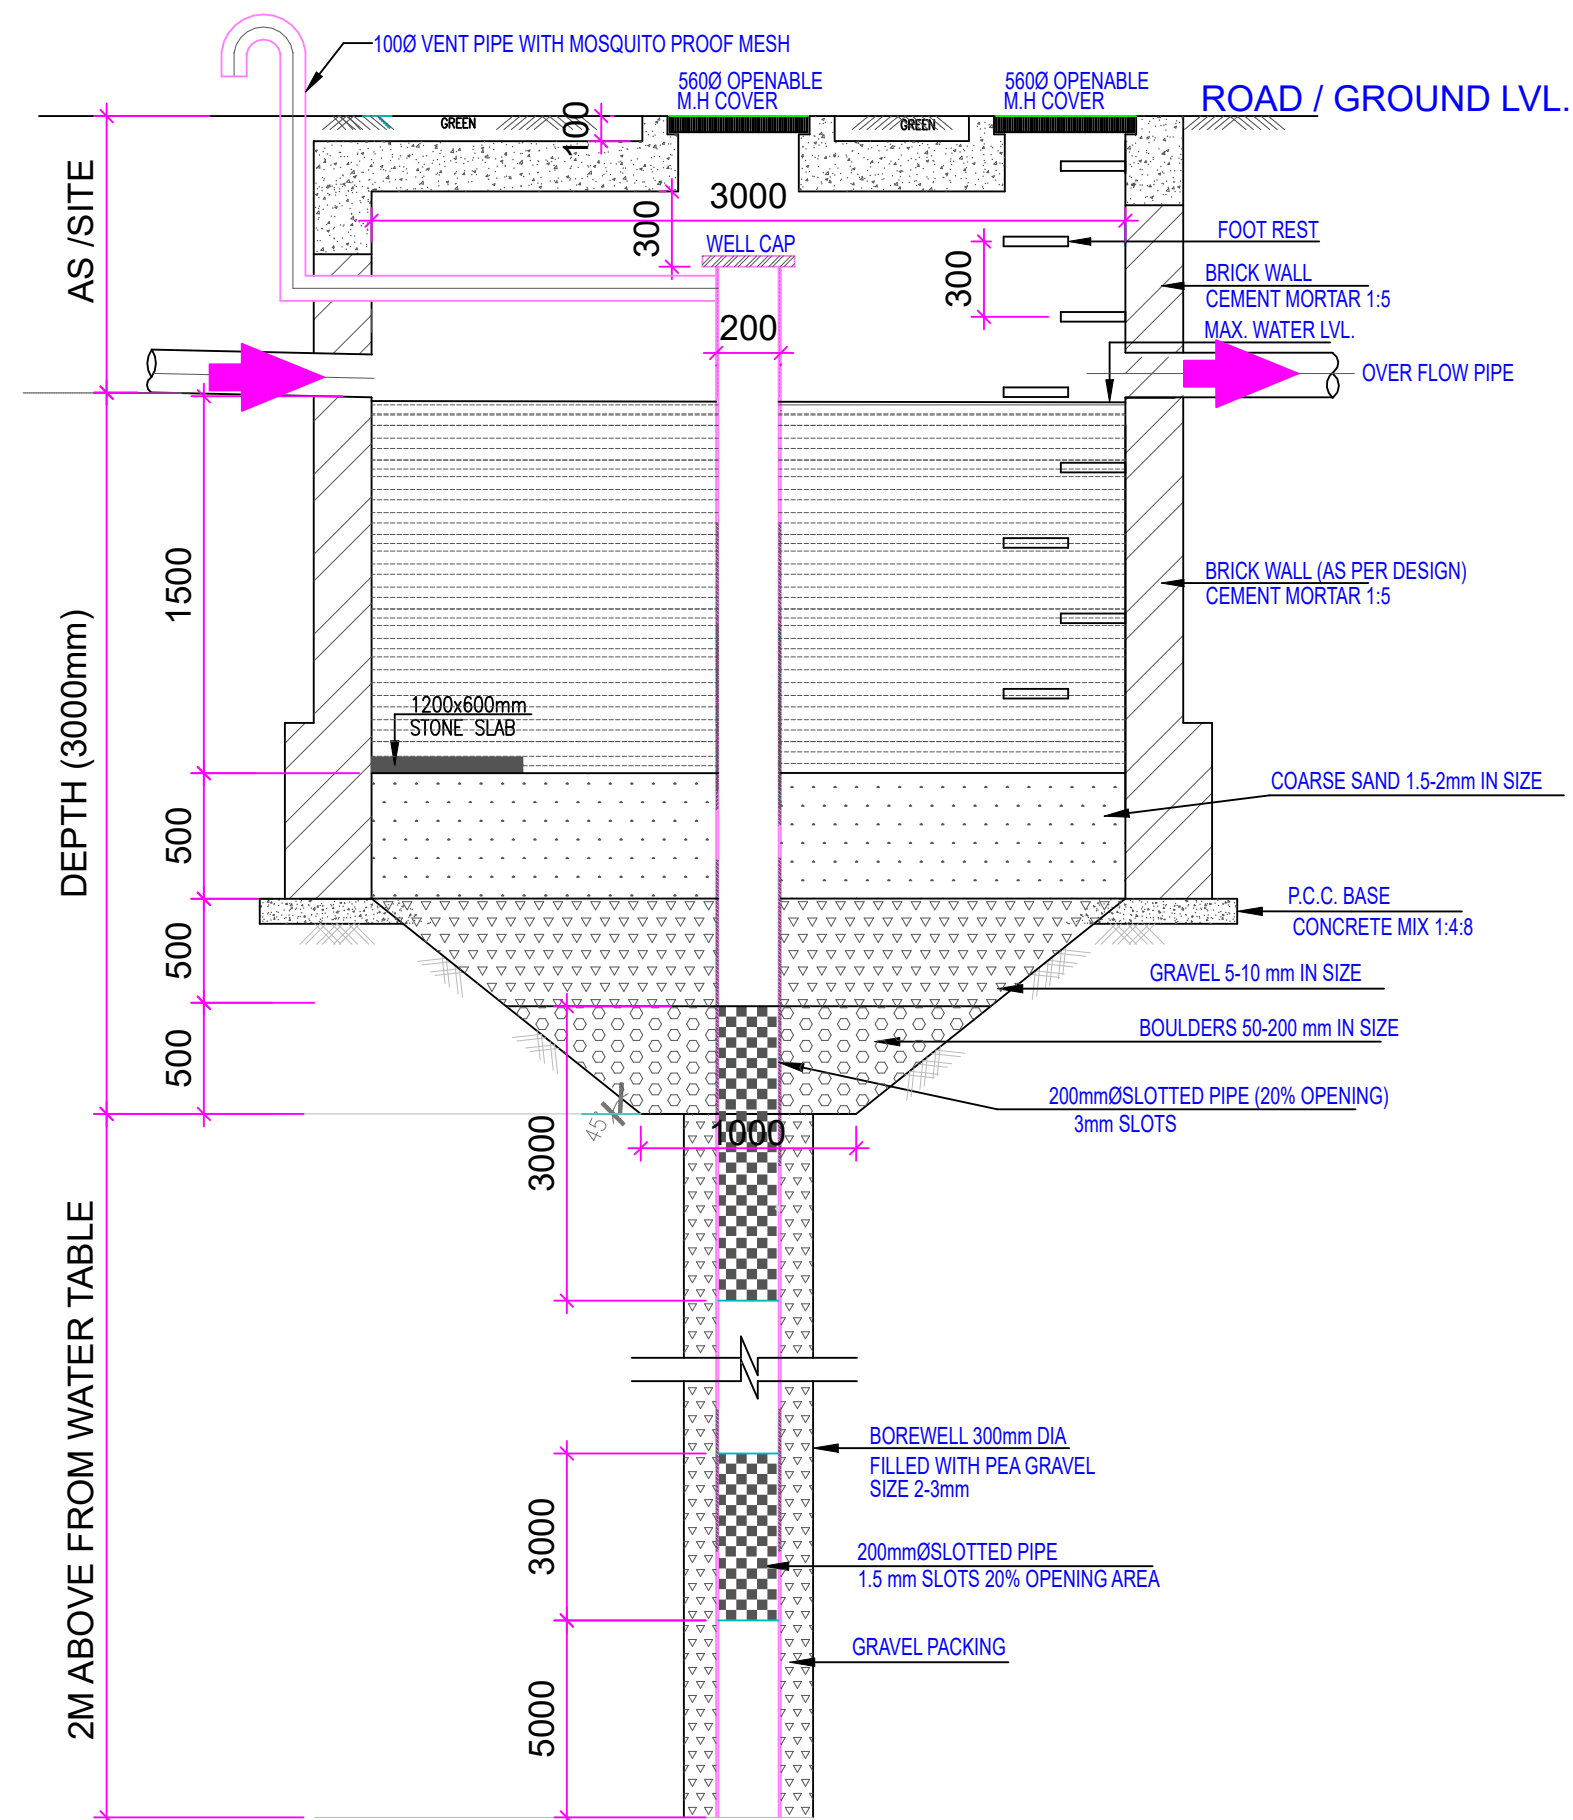

SOMANATH BEHARA
BTECH (CIVIL)

TITLE:- SUBMISSION DRAWINGS
TYPICAL RAIN WATER HARVESTING
PIT DETAIL DRG

SCALE:- 1= 100
DATE : 14/02/2025



PROJECT:-
PLOT NO. 259, BLOCK-C, SEZ
(SETTLEMENT) SCHEME, VILLAGE
BHAMBORIYA, TEHSIL SANGANER, JAIPUR
(RAJASTHAN)

ARCHITECTS:-
PANKAJ GUPTA & ASSOCIATES
Flat no. 603 B, Golden Leaf Apartment, Tonk
Road, Near Gandhi Nagar Station, Jaipur-15

OWNER ARCHITECTS


SOMANATH BEHARA
BTECH (CIVIL)

PLOT NO. 259, BLOCK-C, SEZ
(SETTLEMENT) SCHEME, VILLAGE
BHAMBORIYA, TEHSIL SANGANER, JAIPUR
(RAJASTHAN)

PANKAJ GUPTA & ASSOCIATES
Flat no. 603 B, Golden Leaf Apartment, Tonk
Road, Near Gandhi Nagar Station, Jaipur-15

ARCHITECTS



LEGENDS	
S.NO.	DESCRIPTION
①	 DWS DOMESTIC WATER SUPPLY BELOW FLOOR
②	 DWS DOMESTIC WATER SUPPLY TOP THREE FLOOR
③	 ALL TERRACE RING(GI PIPE)
④	 ALL WATER SUPPLY VERTICAL PIPE
⑤	ARV AIR RELEASE VALVE
TOP THREE FLOORS WATER SUPPLY SYSTEM BY PUMPING	
BELOW FLOORS WATER SUPPLY SYSTEM BY GRAVITY	