

①	RAIN WATER PIPE		
②	WEST WATER PIPE		
③	SOIL WATER PIPE		
④	INSPECTION CHAMBER / GULLY TRAP		2'6" DEPTH
⑤	MAN HOLE		2'6" DEPTH
⑥	ELECTRICAL PIPELINE		

LEGENDS		
S.NO.	SYMBOL	DESCRIPTION
1.		SDR-11 Fresh Water Pipe
2.		SDR-11 Solar Water Pipe
3.		Waste Water Pipe (W.P.)
4.		Soil Pipe (S.P.)
5.		Rain Water Pipe (R.W.P.)
6.		Butter Fly Valve(B.F.V.)
7.		Geyser
8.		RO
9.		Single Lever Diverter
10.		Concealed Valve
11.		Angle Valve
12.		Nahani Trap
13.		P-Trap
14.		Tap
15.		Floor Drain (F.D.)
16.		Plain Tee (P-tee)
17.		Gully Trap (G.T.)
18.		

WARNING

1. This drawing is the sole copyright of Architects **VISTAAR** and should be used for the purpose expressly issued.

GENERAL NOTES

1. All dimensions are in feet and inches.
2. Do not scale this drawing follow written dimensions only.
3. This drawing should be read in conjunction with other architectural and structural drawings.
4. Any discrepancy in the drawing should be immediately brought to the notice of architect.

PROJECT TITLE

THE URBAN CREST
PLOT NO. - A-9,A-10,A-11,A-12
A-21,A-22,A-23,A-24, SHYAM VATIKA,
MANYAWAS,MANSROVAR, JAIPUR.

DRAWING TITLE

STILT FLOOR PLAN
COMMON AREA WATER SUPPLY PLAN

ARCHITECTS :


VISTAAR ARCHITECTS & PLANNERS
Architects :: Interior Designers
B-2/12, Chitrkoot scheme,
main Gandhi Path,Opp mall of jaipur,Jaipur
PH.- 0141-4370233,09001010366

PATH :-

DRN.	DATE	REV.	NORTH
MANOJ KUMAWAT	26-08-2024		
SCALE	JOB NO.		
N.T.S			


Shree Gurukulji Homes
B. Tech (Mechanical)
Pater

KRISHNA KUMAR
B. Tech (Mechanical)
M.P. Consultant

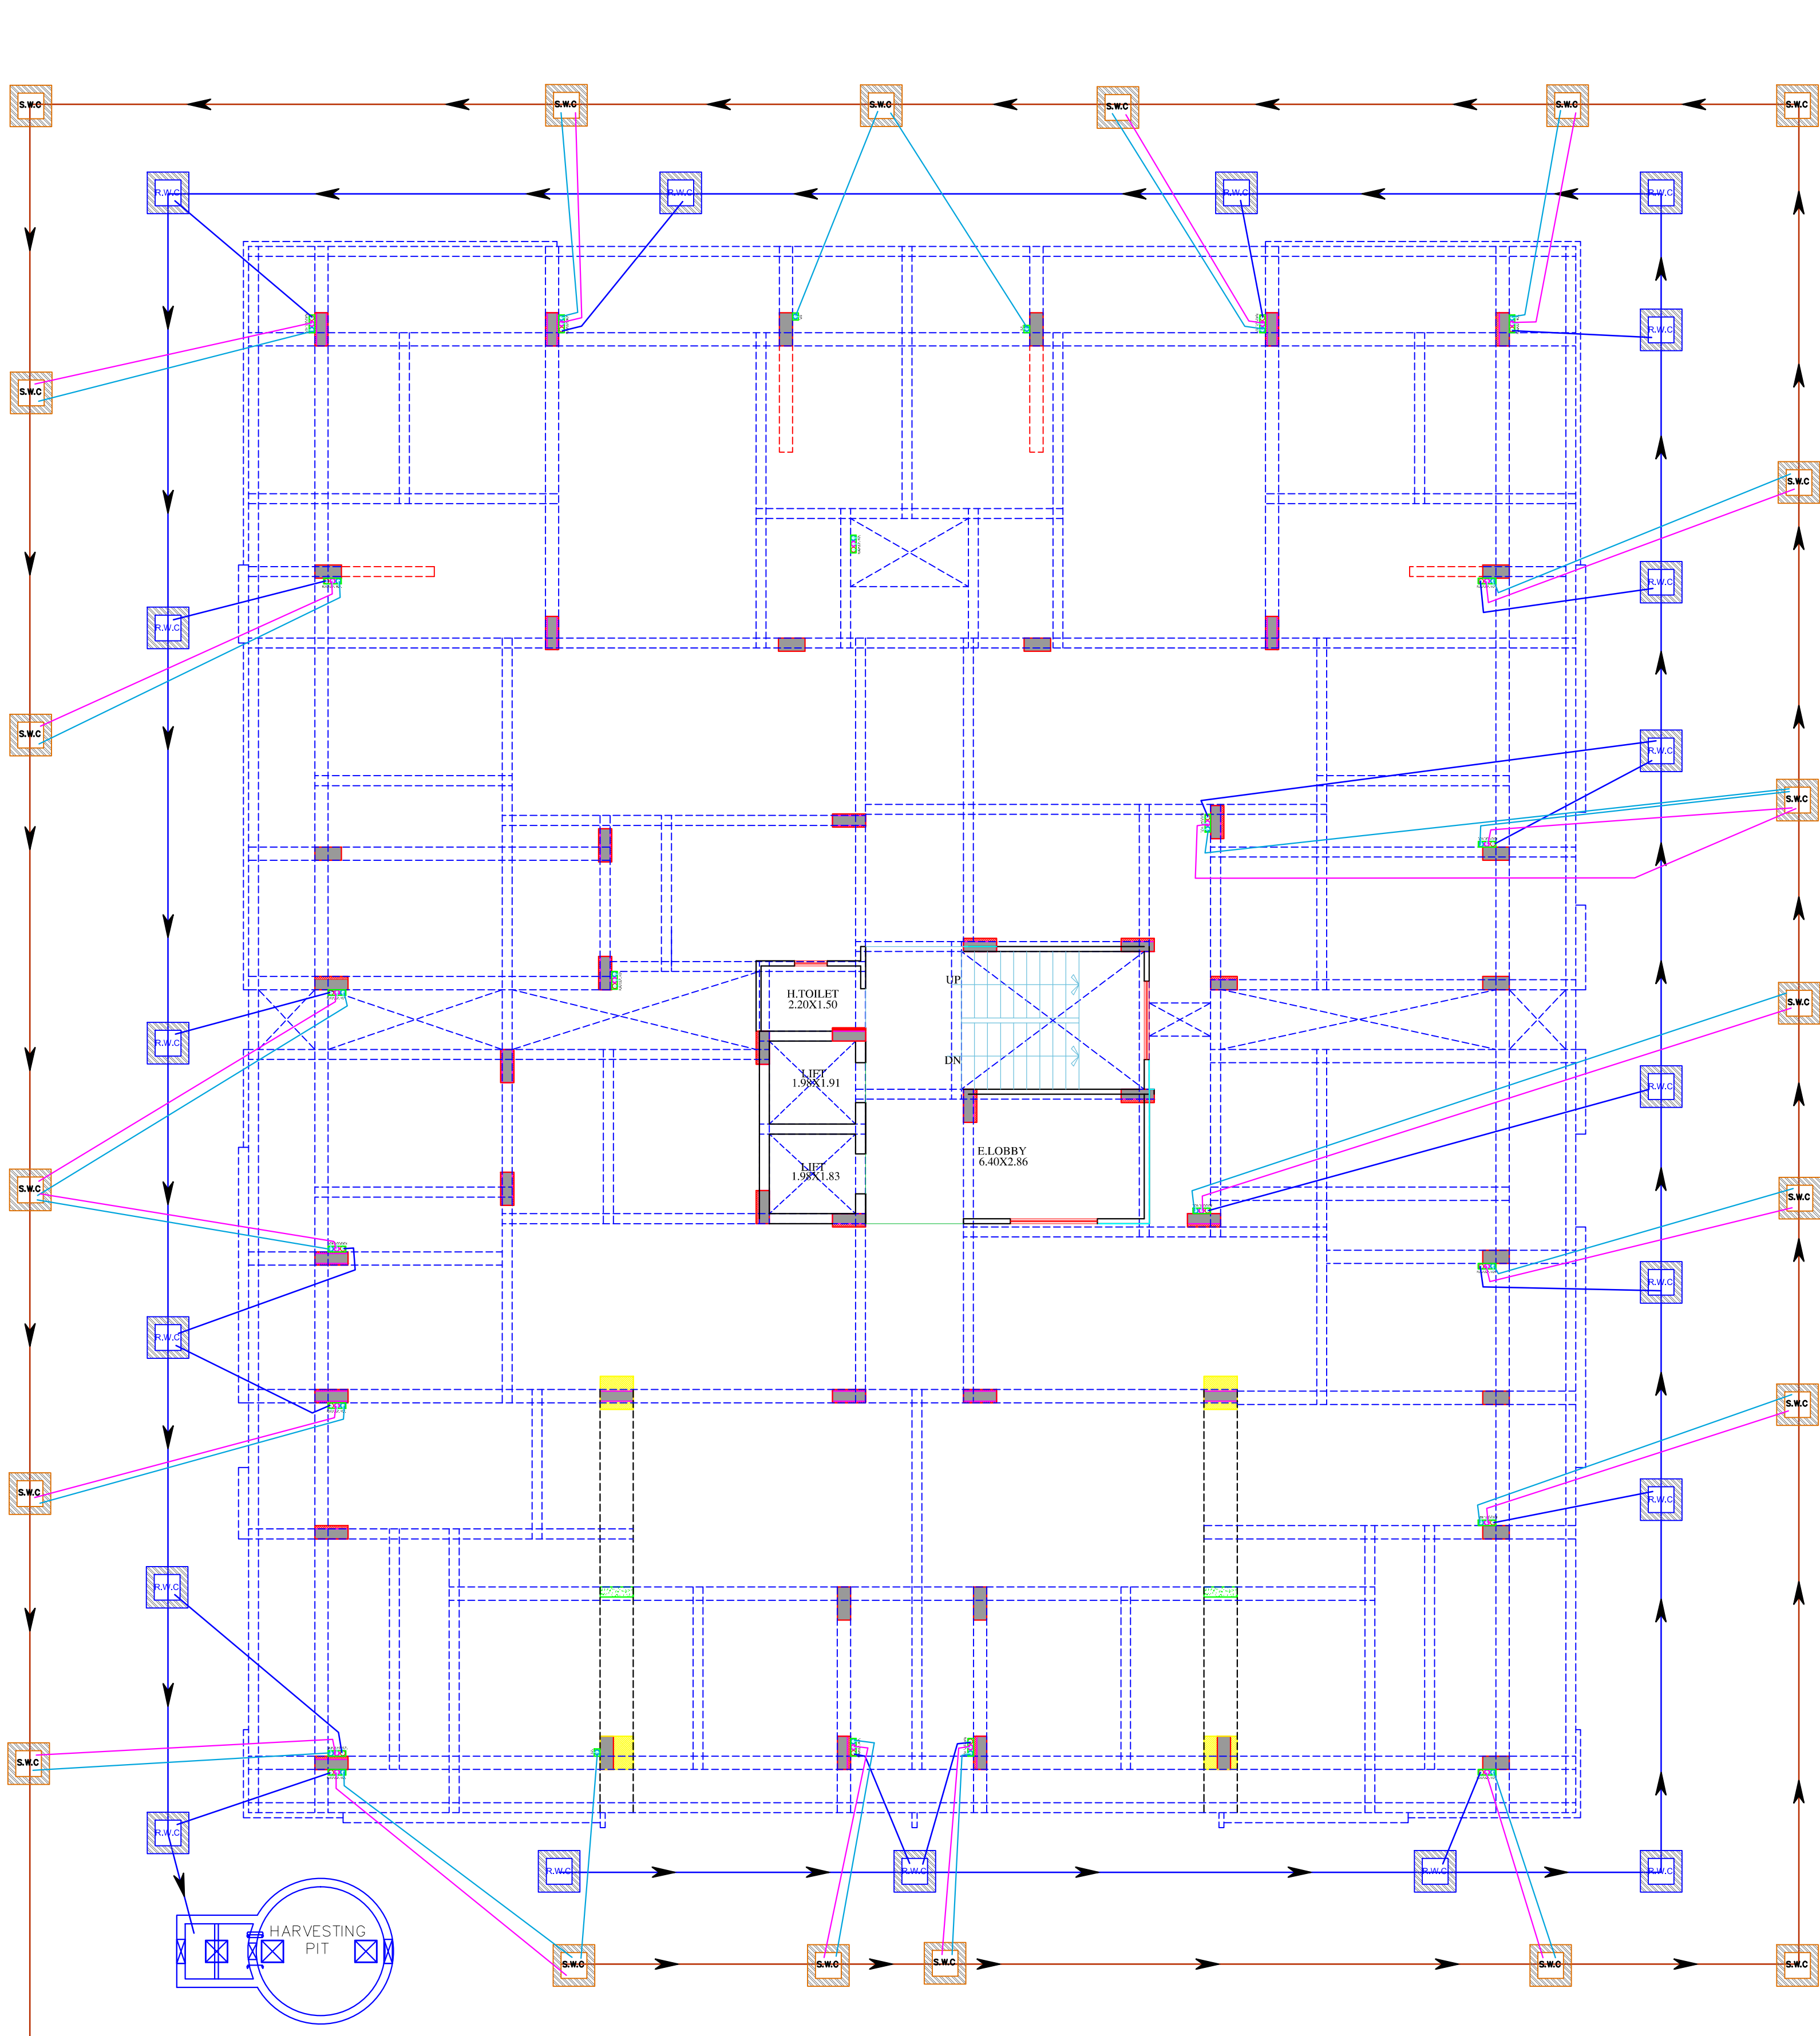

1	RAIN WATER PIPE	
2	WASTE WATER PIPE	
3	SOIL WATER PIPE	
4	INSPECTION CHAMBER / SULLY TRAP	2'6" DEPTH
5	MAN HOLE	2'6" DEPTH
6	ELECTRICAL TYPING	

S.NO.	SYMBOL	DESCRIPTION
1.		SDR-11 Fresh Water Pipe
2.		SDR-11 Solar Water Pipe
3.		Waste Water Pipe (W.P.)
4.		Soil Pipe (S.P.)
5.		Rain Water Pipe (R.W.P.)
6.		Butter Fly Valve(B.F.V.)
7.		Geyser
8.		RO
9.		Single Lever Diverter
10.		Concealed Valve
11.		Angle Valve
12.		Nahani Trap
13.		P-Trap
14.		Tap
15.		Floor Drain (F.D.)
16.		Plain Tee (P-tee)
17.		Gully Trap (G.T.)
18.		

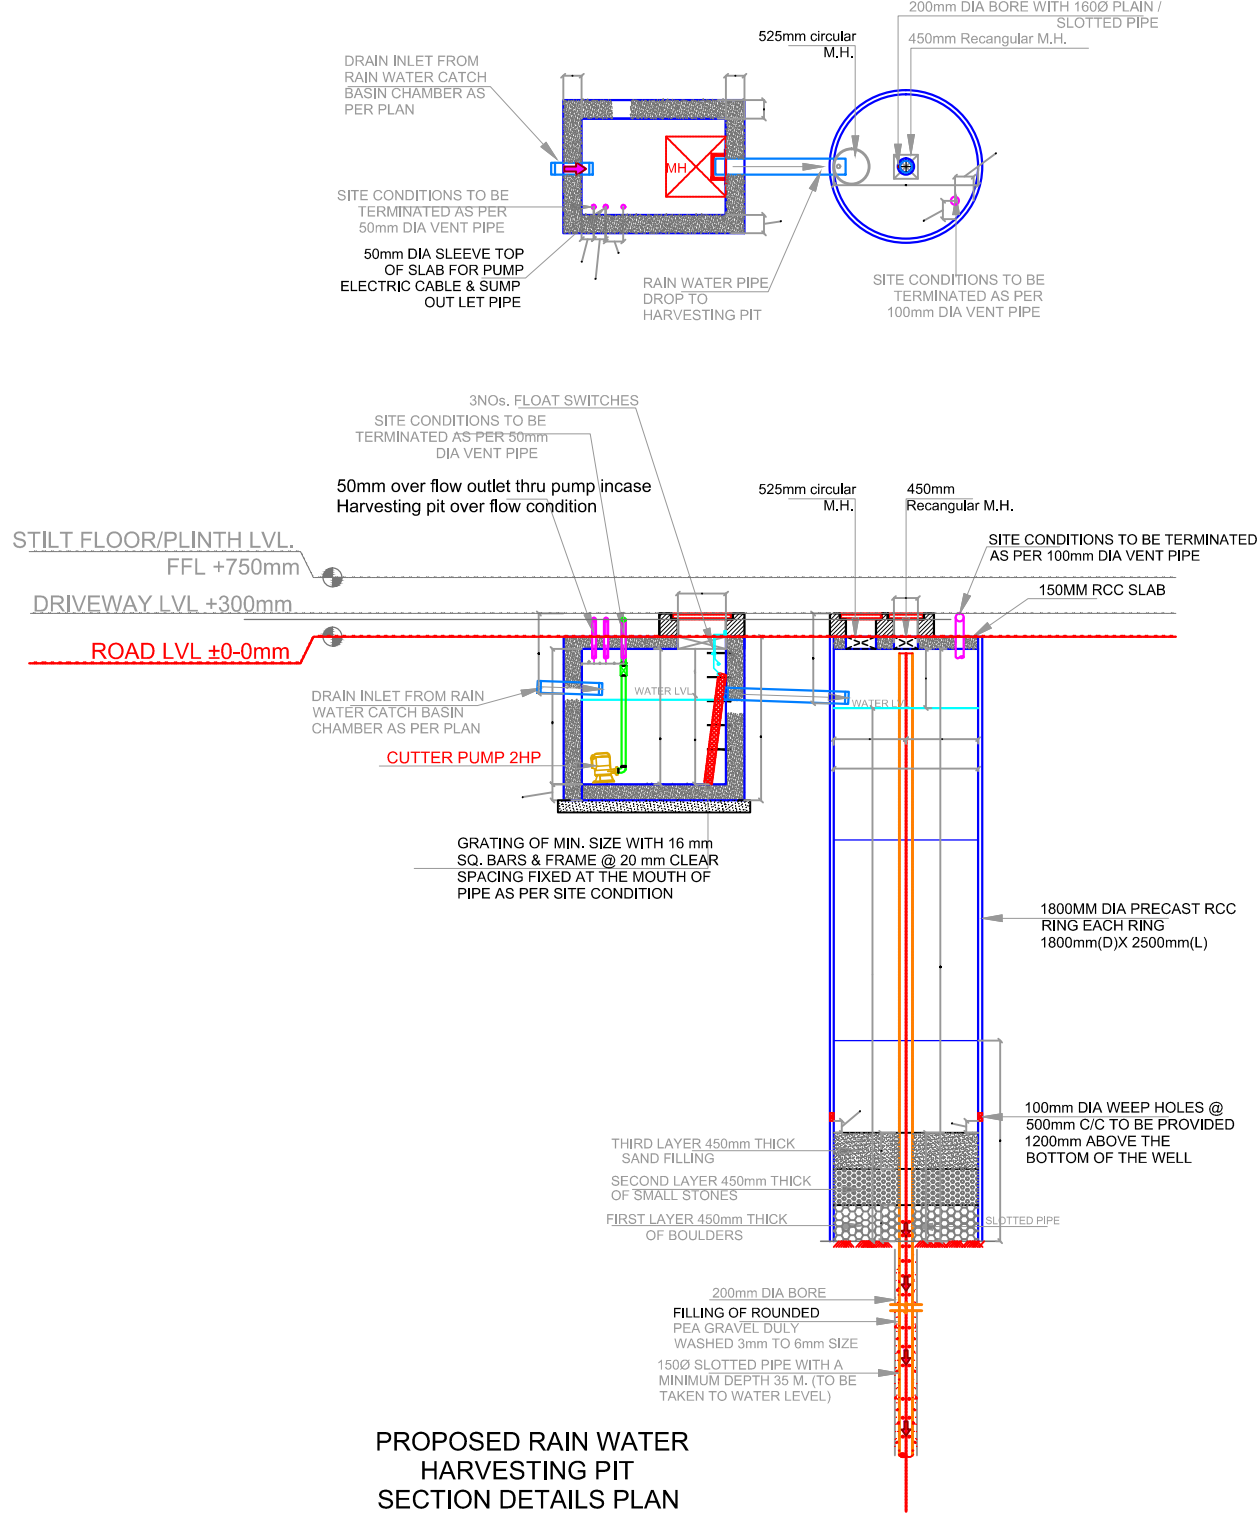

PROPOSED RAIN WATER HARVESTING PIT SECTION DETAILS PLAN

WARNING

1. This drawing is the sole copyright of Architects **VISTAAR** and should be used for the purpose expressly issued.

GENERAL NOTES

1. All dimensions are in feet and inches.
2. Do not scale this drawing follow written dimensions only.
3. This drawing should be read in conjunction with other architectural and structural drawings.
4. Any discrepancy in the drawing should be immediately brought to the notice of architect.

PROJECT TITLE

THE URBAN CREST
PLOT NO. - A-9,A-10,A-11,A-12
A-21,A-22,A-23,A-24, SHYAM VATIKA,
MANYAWAS,MANSROVAR, JAIPUR.

DRAWING TITLE


SANITATION(STORM WATER DRAINAGE,
SEWERAGE,STP,SOLID WATER DISPOSAL) AND
RAIN WATER HARVESTING PLAN

ARCHITECTS :

VISTAAR ARCHITECTS & PLANNERS
Architects :: Interior Designers
B-2/12, Chitrkoot scheme,
main Gandhi Path,Opp mall of jaipur,Jaipur
PH.- 0141-4370233,09001010366

PATH >

DRN.	DATE	REV.	NORTH
MANOJ KUMAR	26-08-2024		
SCALE	JOB NO.		
N.T.S			

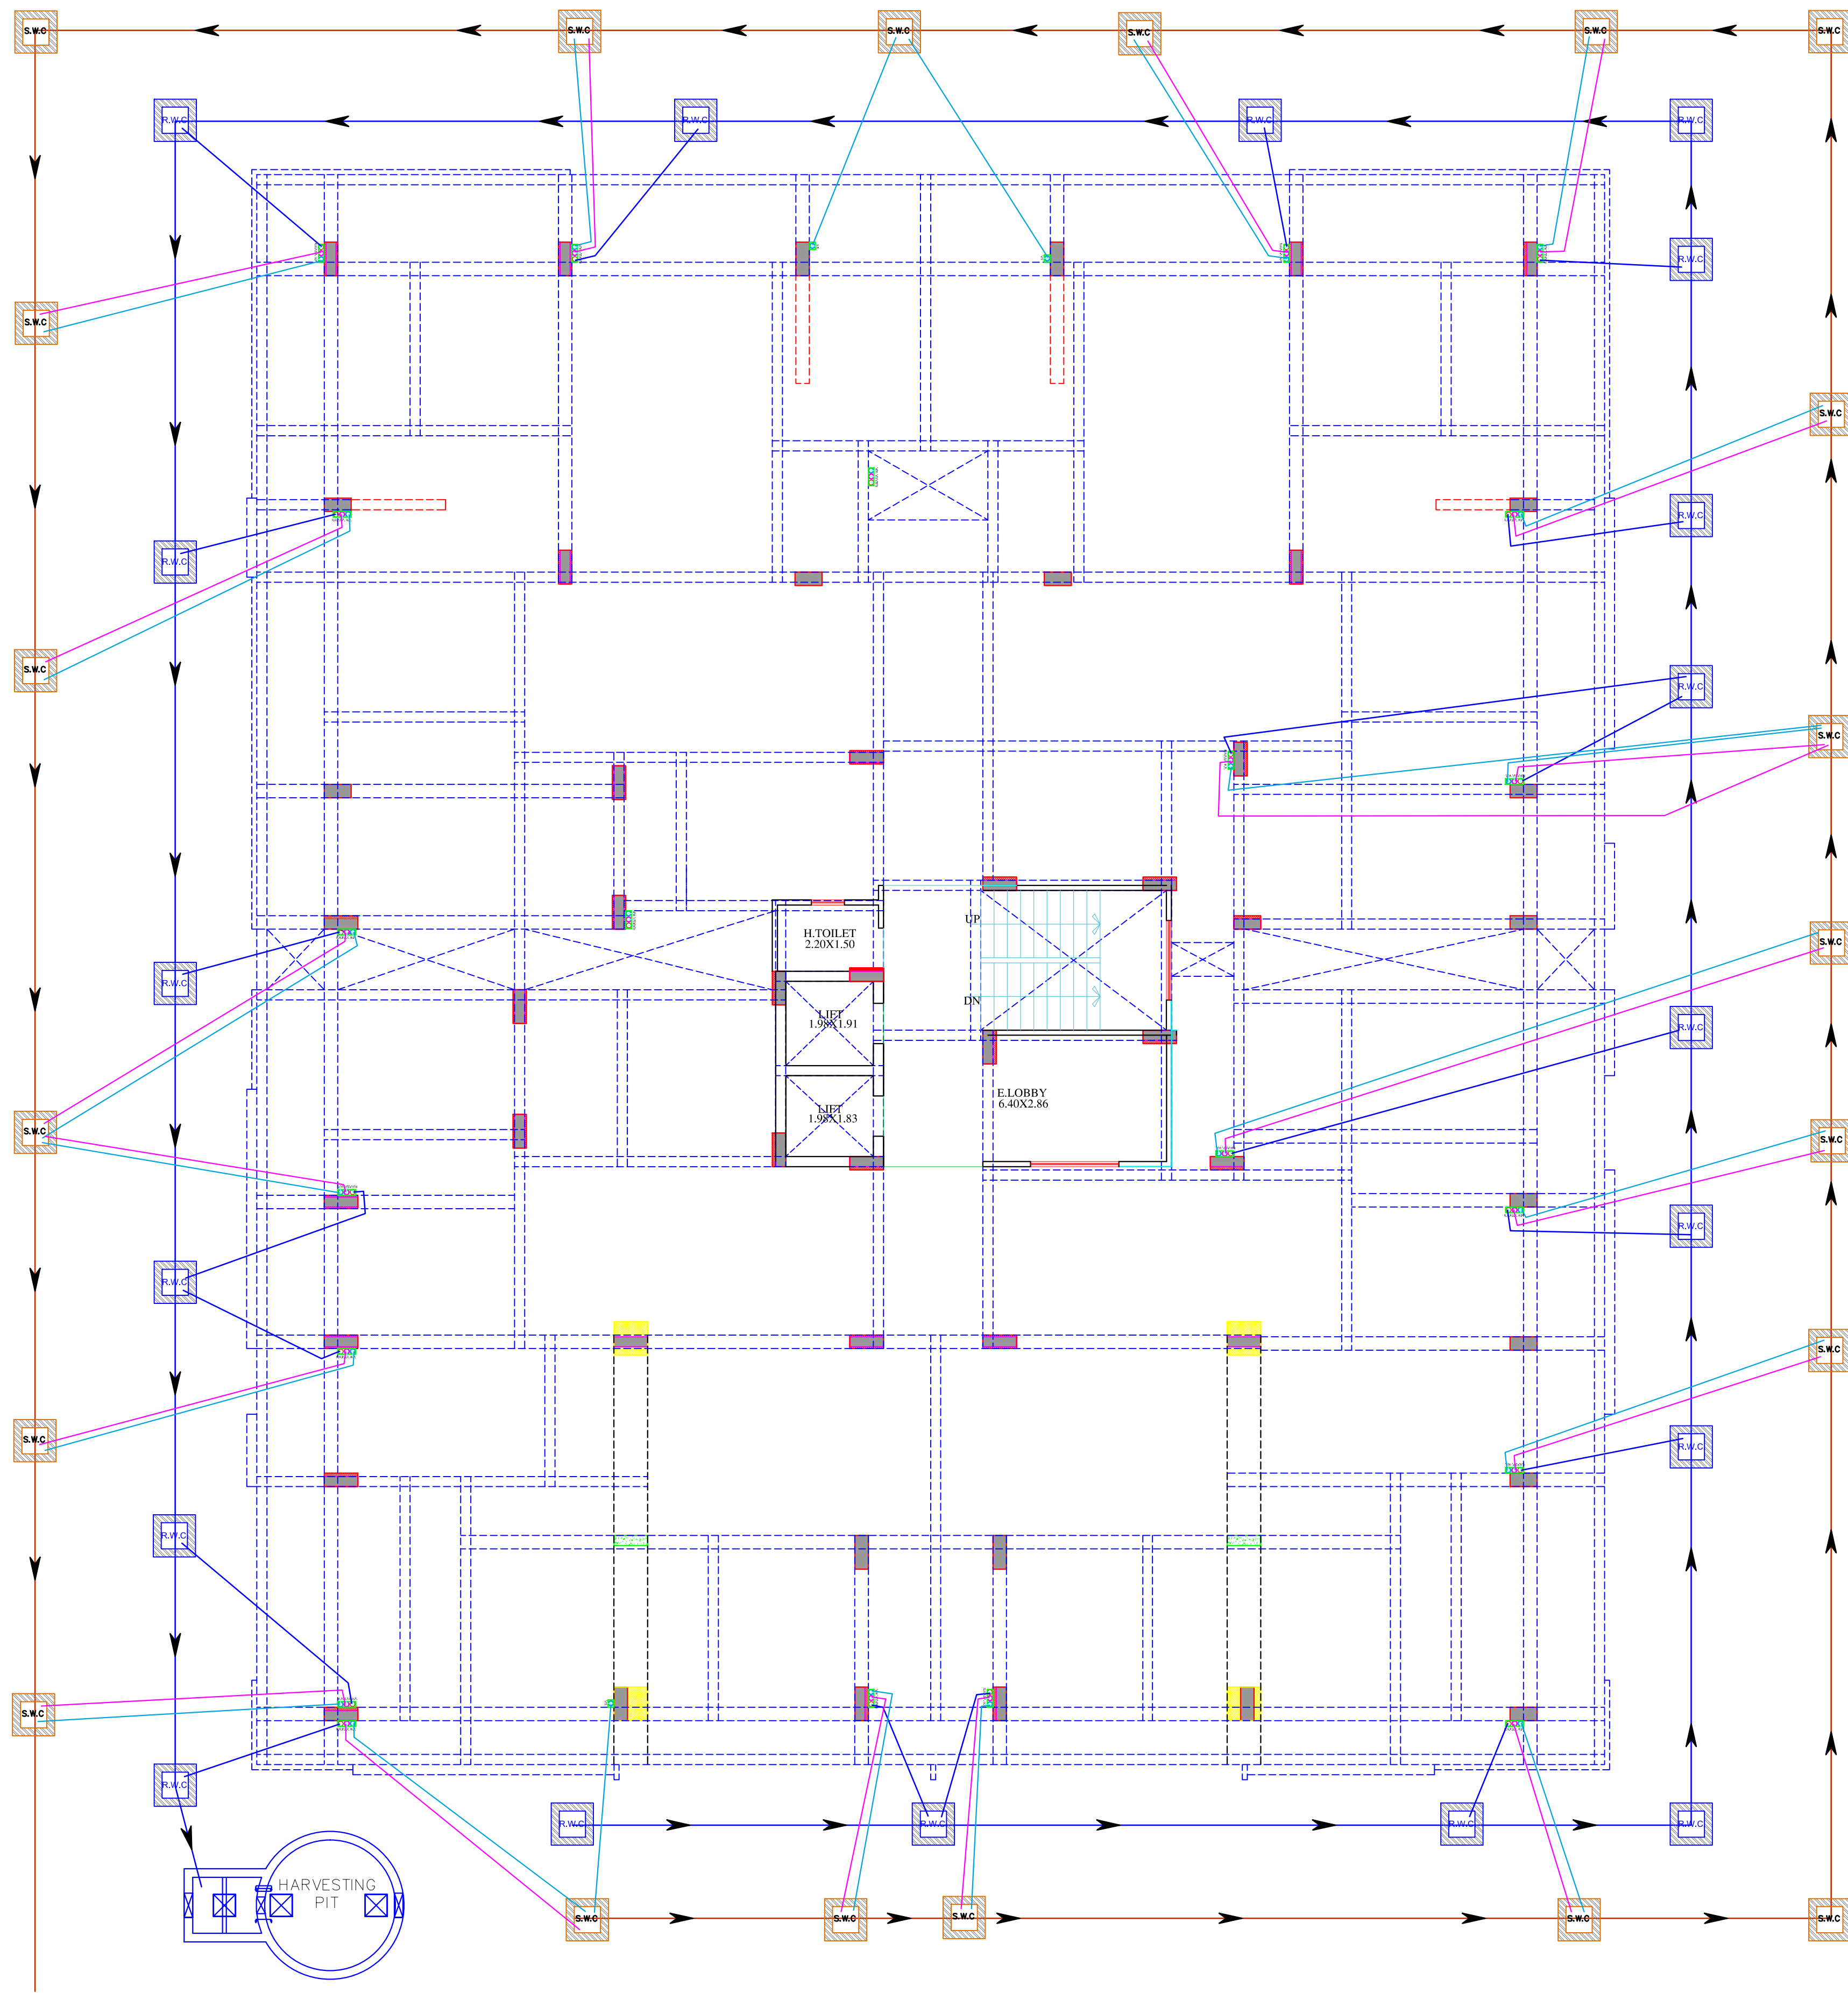

WARNING

1. This drawing is the sole copyright of Architects **VISTAAR** and should be used for the purpose expressly issued.

GENERAL NOTES

1. All dimensions are in feet and inches.
2. Do not scale this drawing follow written dimensions only.
3. This drawing should be read in conjunction with other architectural and structural drawings.
4. Any discrepancy in the drawing should be immediately brought to the notice of architect.

PROJECT TITLE

THE URBAN CREST
PLOT NO. - A-9,A-10,A-11,A-12
A-21,A-22,A-23,A-24, SHYAM VATIKA,
MANYAWAS,MANSROVAR, JAIPUR.


DRAWING TITLE

STILT FOOR DRAINAGE PLAN

ARCHITECTS :

VISTAAR ARCHITECTS & PLANNERS
Architects :: Interior Designers
B-2/12, Chitrkoot scheme,
main Gandhi Path,Opp mall of jaipur,Jaipur
PH.- 0141-4370233,09001010366

PATH -		DATE		REV.		NORTH	
DRN.		MANOJ KUMAWAT	26-08-2024				
SCALE			JOB NO.				
N.T.S							

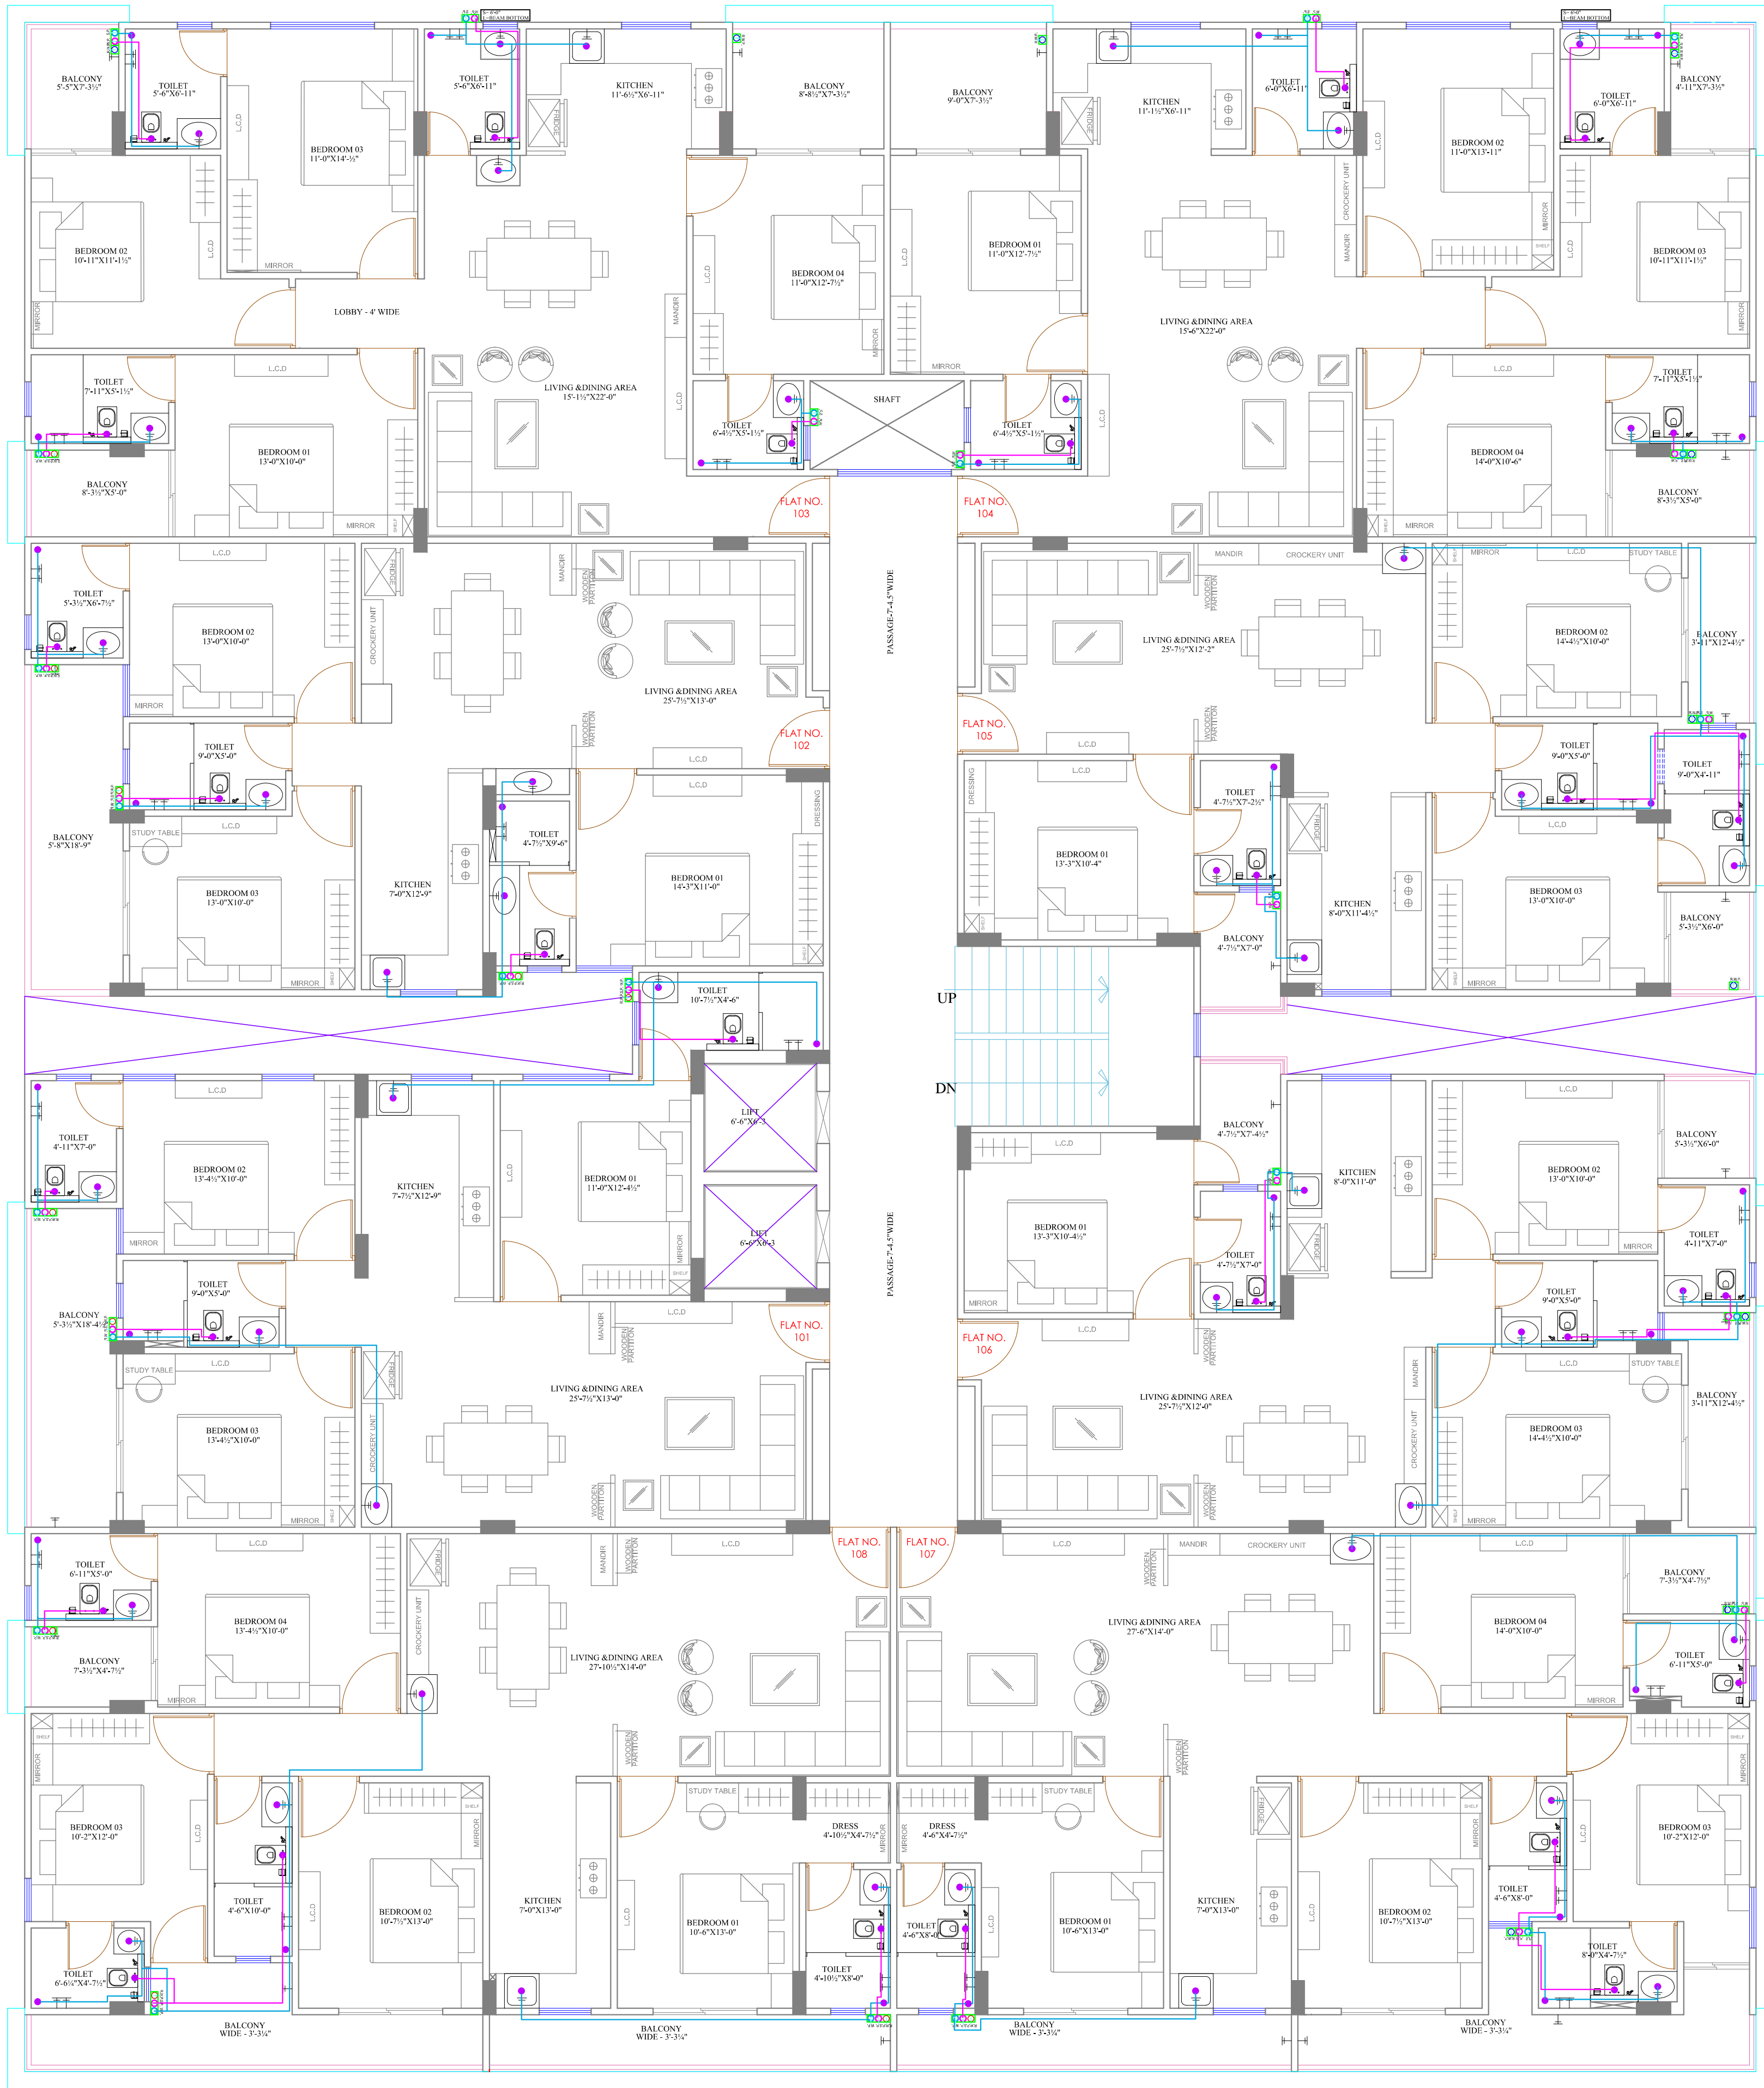

Shree Gururaj Home
Patner

KRISHNA KUMAR
B. Tech (Mechanical)
M.E.P Consultant

WARNING

1. This drawing is the sole copyright of Architects **VISTAAR** and should be used for the purpose expressly issued.

GENERAL NOTES

1. All dimensions are in feet and inches.
2. Do not scale this drawing follow written dimensions only.
3. This drawing should be read in conjunction with other architectural and structural drawings.
4. Any discrepancy in the drawing should be immediately brought to the notice of architect.

PROJECT TITLE

THE URBAN CREST
PLOT NO. - A-9,A-10,A-11,A-12
A-21,A-22,A-23,A-24, SHYAM VATIKA,
MANYAWAS,MANSROVAR, JAIPUR.

DRAWING TITLE

GROUND TO 5TH FLOOR DRAINAGE
PLAN

ARCHITECTS :

VISTAAR ARCHITECTS & PLANNERS
Architects :: Interior Designers
B-2/12, Chitrkoot scheme,
main Gandhi Path,Opp mall of jaipur,Jaipur.
PH.- 0141-4370233,09001010366

PATH -

DRN.

MANOJ
KUMAWAT

SCALE

N.T.S


DATE


26-08-2024

JOB NO.

REV.

NORTH

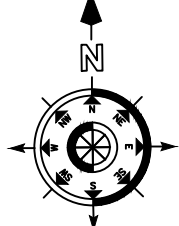

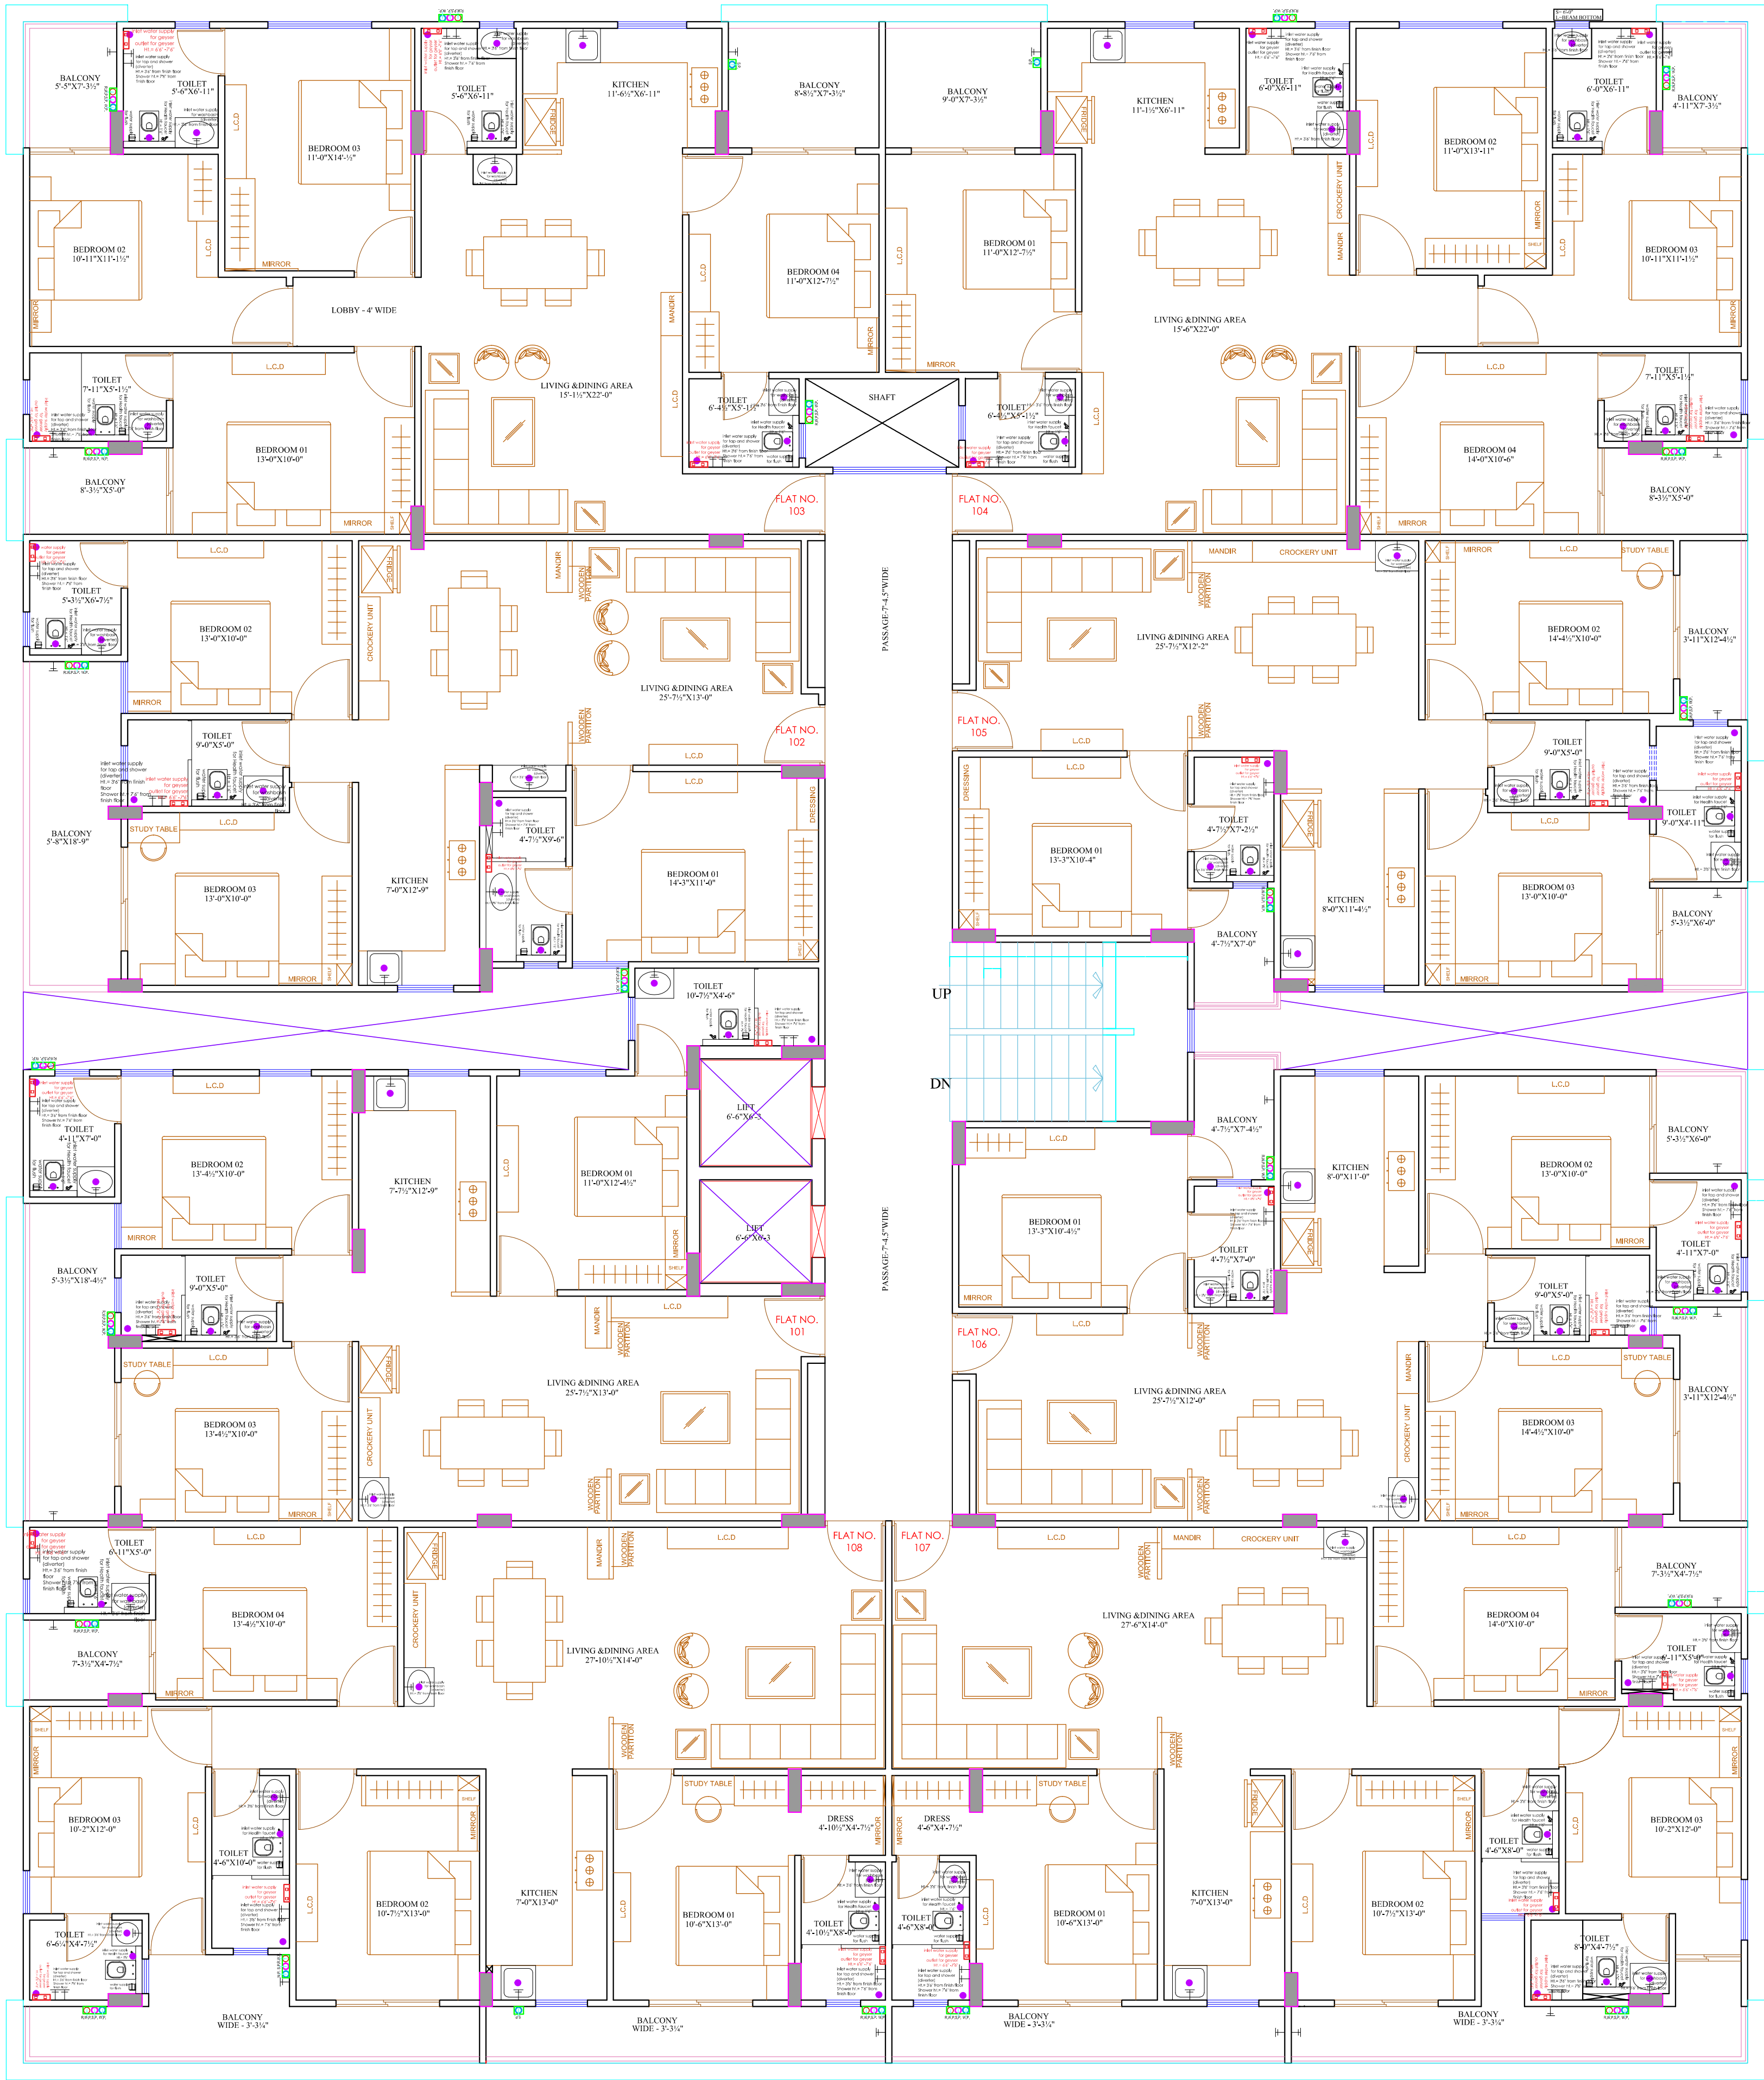

LEGENDS		
S.NO.	SYMBOL	DESCRIPTION
1.		SDR-11 Fresh Water Pipe
2.		SDR-11 Solar Water Pipe
3.		Waste Water Pipe (W.P.)
4.		Soil Pipe (S.P.)
5.		Rain Water Pipe (R.W.P.)
6.		Butter Fly Valve (B.F.V.)
7.		Geyser
8.		RO
9.		Single Lever Diverter
10.		Concealed Valve
11.		Angle Valve
12.		Nahani Trap
13.		P-Trap
14.		Tap
15.		Floor Drain (F.D.)
16.		Plain Tee (P-tee)
17.		Gully Trap (G.T.)
18.		

WARNING
1. This drawing is the sole copyright of Architects **VISTAAR** and should be used for the purpose expressly issued.

GENERAL NOTES
1. All dimensions are in feet and inches.
2. Do not scale this drawing follow written dimensions only.
3. This drawing should be read in conjunction with other architectural and structural drawings.
4. Any discrepancy in the drawing should be immediately brought to the notice of architect.

PROJECT TITLE
THE URBAN CREST
PLOT NO. - A-9,A-10,A-11,A-12
A-21,A-22,A-23,A-24, SHYAM VATIKA,
MANYAWAS,MANSROVAR, JAIPUR.


DRAWING TITLE
GROUND TO 5TH FLOOR PLUMBING PLAN

ARCHITECTS :
VISTAAR ARCHITECTS & PLANNERS
Architects :: Interior Designers
B-2/12, Chitrkoot scheme,
main Gandhi Path,Opp mall of jaipur,Jaipur
PH.- 0141-4370233,09001010366

PATH -			
DRN.	DATE	REV.	NORTH
MANOJ KUMAWAT	26-08-2024		
SCALE	JOB NO.		
N.T.S			

Shree Gurukul Homes
Partner

Krishna Kumar
B.Tech. (Mechanical)
M.E.P Consultant

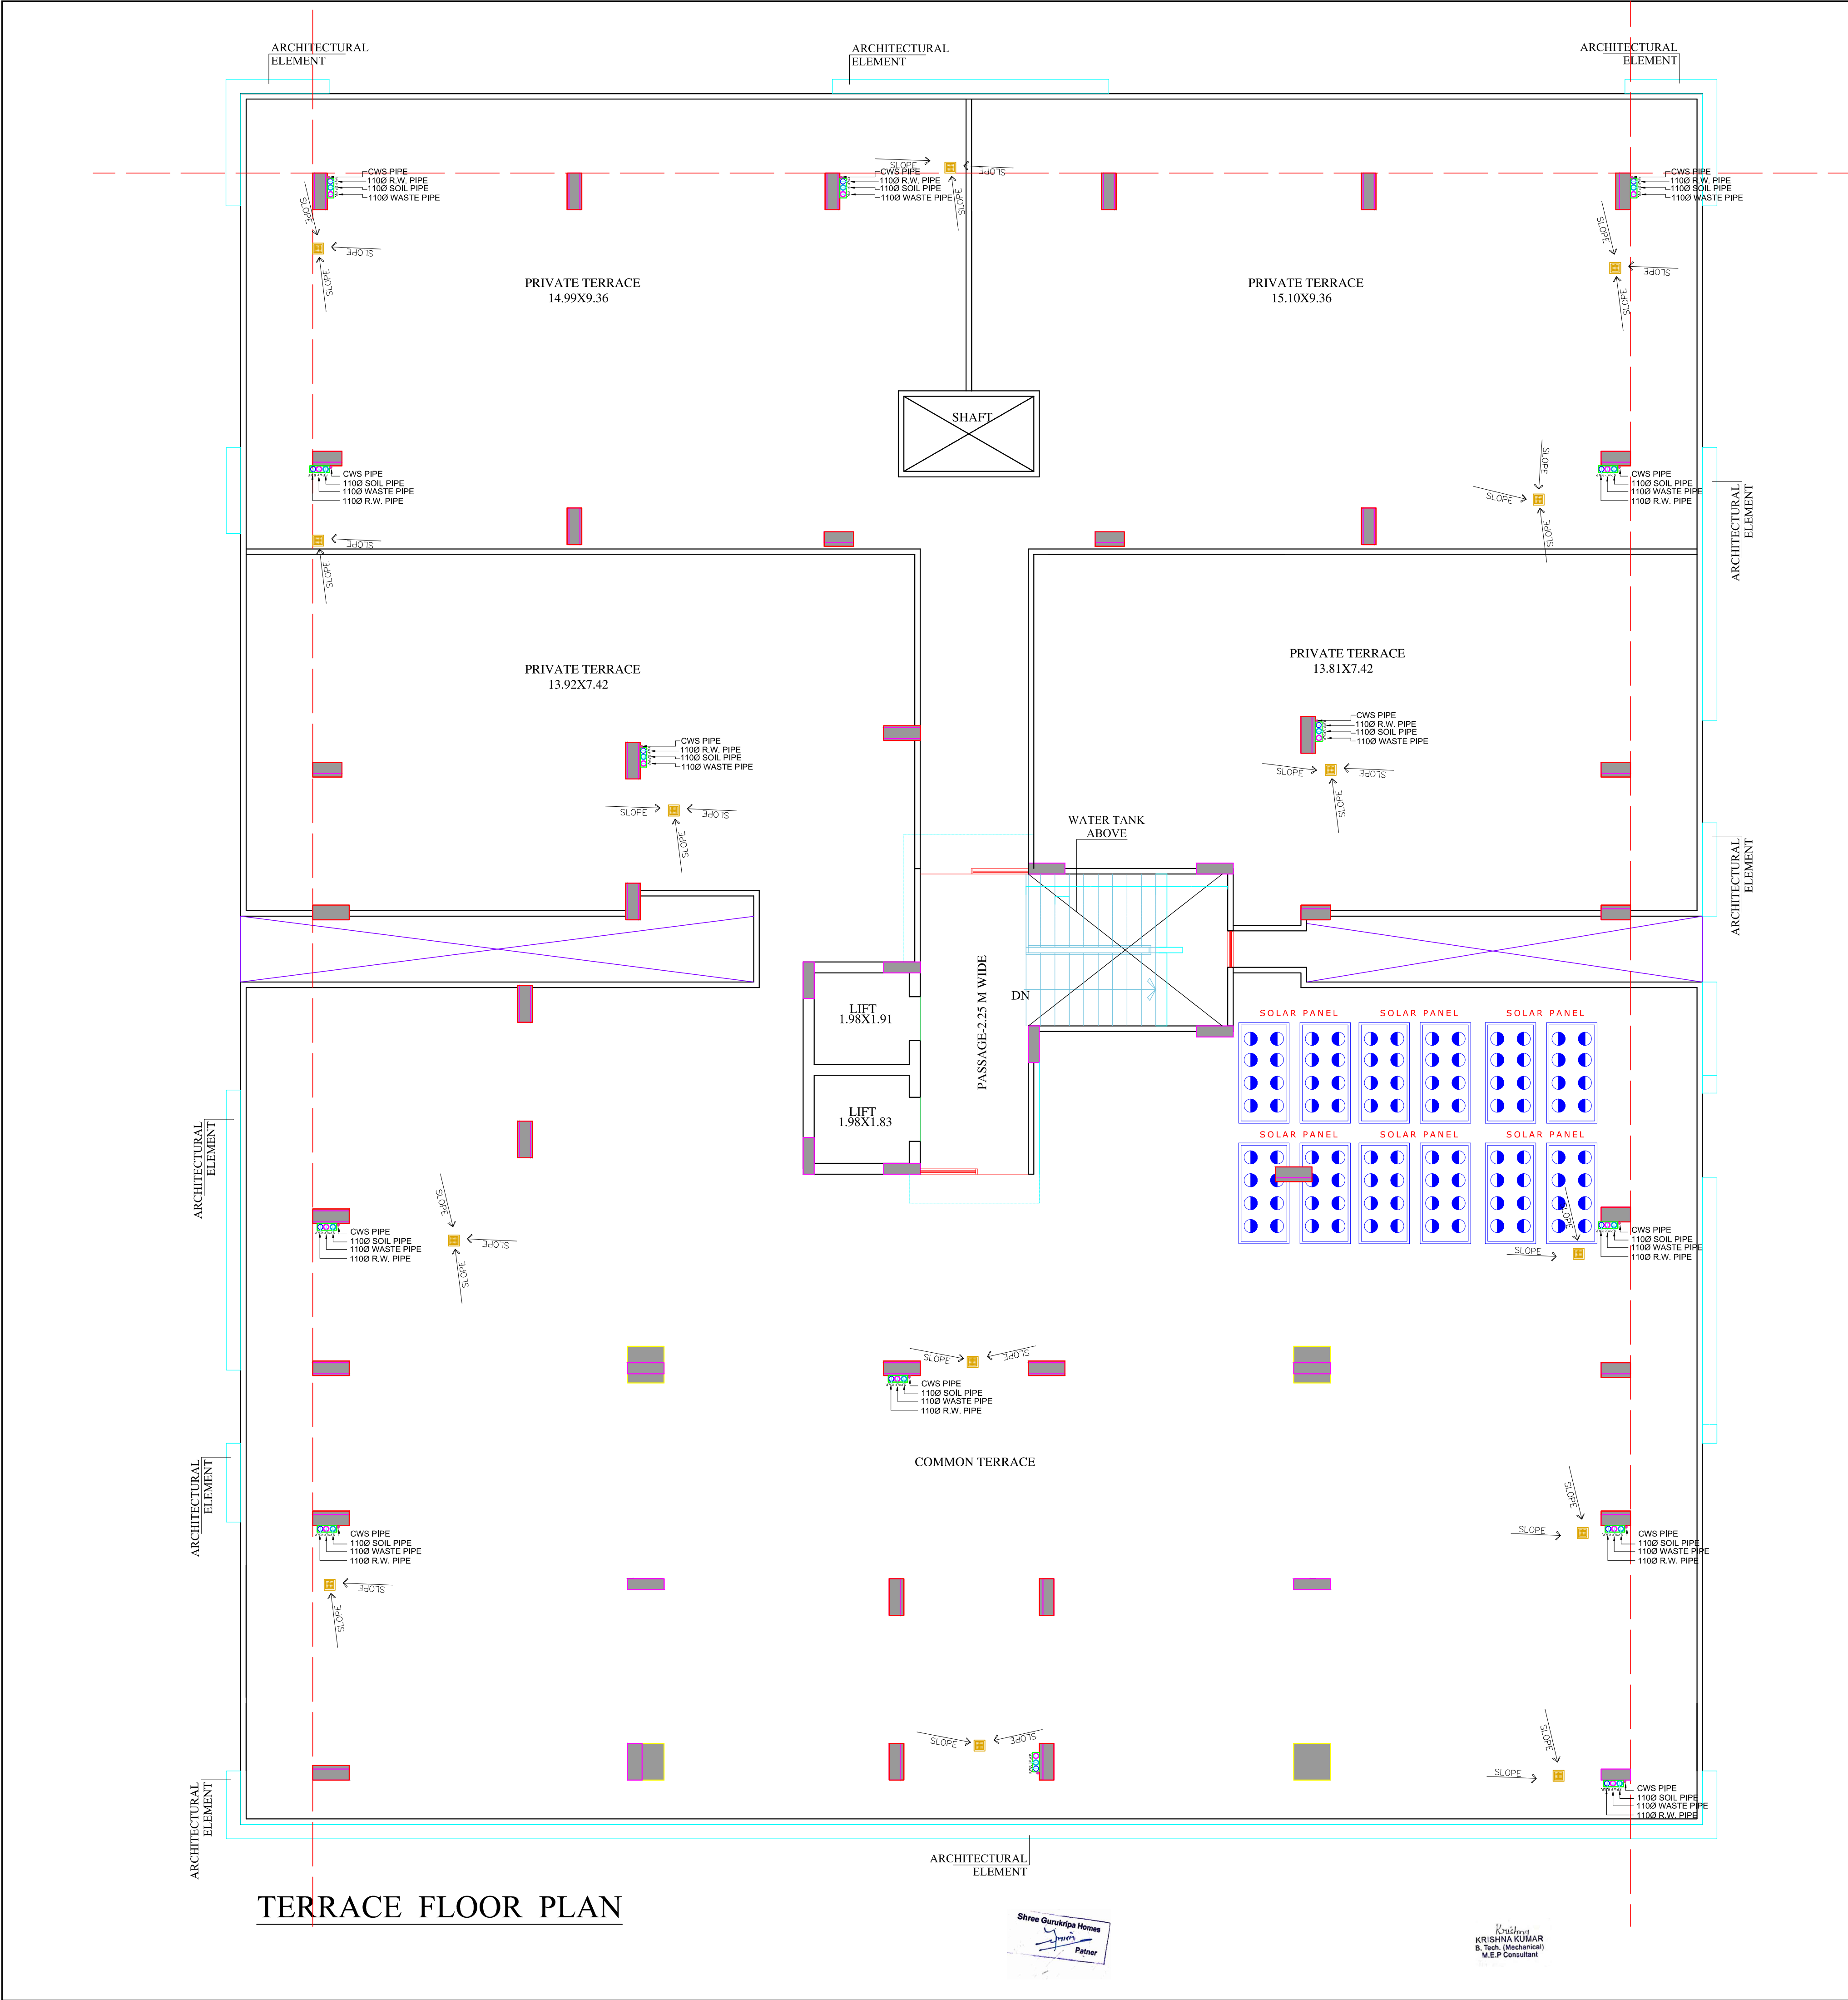

TERRACE FLOOR PLAN

LEGENDS

S.NO.	SYMBOL	DESCRIPTION
1.		SDR-11 Fresh Water Pipe
2.		SDR-11 Solar Water Pipe
3.		Waste Water Pipe (W.P.)
4.		Soil Pipe (S.P.)
5.		Rain Water Pipe (R.W.P.)
6.		Butter Fly Valve(B.F.V.)
7.		Geyser
8.		RO
9.		Single Lever Diverter
10.		Concealed Valve
11.		Angle Valve
12.		Nahani Trap
13.		P-Trap
14.		Tap
15.		Floor Drain (F.D.)
16.		Plain Tee (P-tee)
17.		Gully Trap (G.T.)
18.		

WARNING

1. This drawing is the sole copyright of Architects **VISTAAR** and should be used for the purpose expressly issued.

GENERAL NOTES

1. All dimensions are in feet and inches.
2. Do not scale this drawing follow written dimensions only.
3. This drawing should be read in conjunction with other architectural and structural drawings.
4. Any discrepancy in the drawing should be immediately brought to the notice of architect.

PROJECT TITLE

THE URBAN CREST
PLOT NO. - A-9,A-10,A-11,A-12
A-21,A-22,A-23,A-24, SHYAM VATIKA,
MANYAWAS,MANSROVAR, JAIPUR.

DRAWING TITLE


TERRACE DRAINAGE
LAYOUT

ARCHITECTS :

VISTAAR ARCHITECTS & PLANNERS
Architects :: Interior Designers
B-2/12, Chitrkoot scheme,
main Gandhi Path,Opp mall of jaipur,Jaipur
PH.- 0141-4370233,09001010366

PATH :-

DRN.	DATE	REV.	NORTH
MANOJ KUMAWAT	26-08-2024		
SCALE	JOB NO.		
N.T.S			

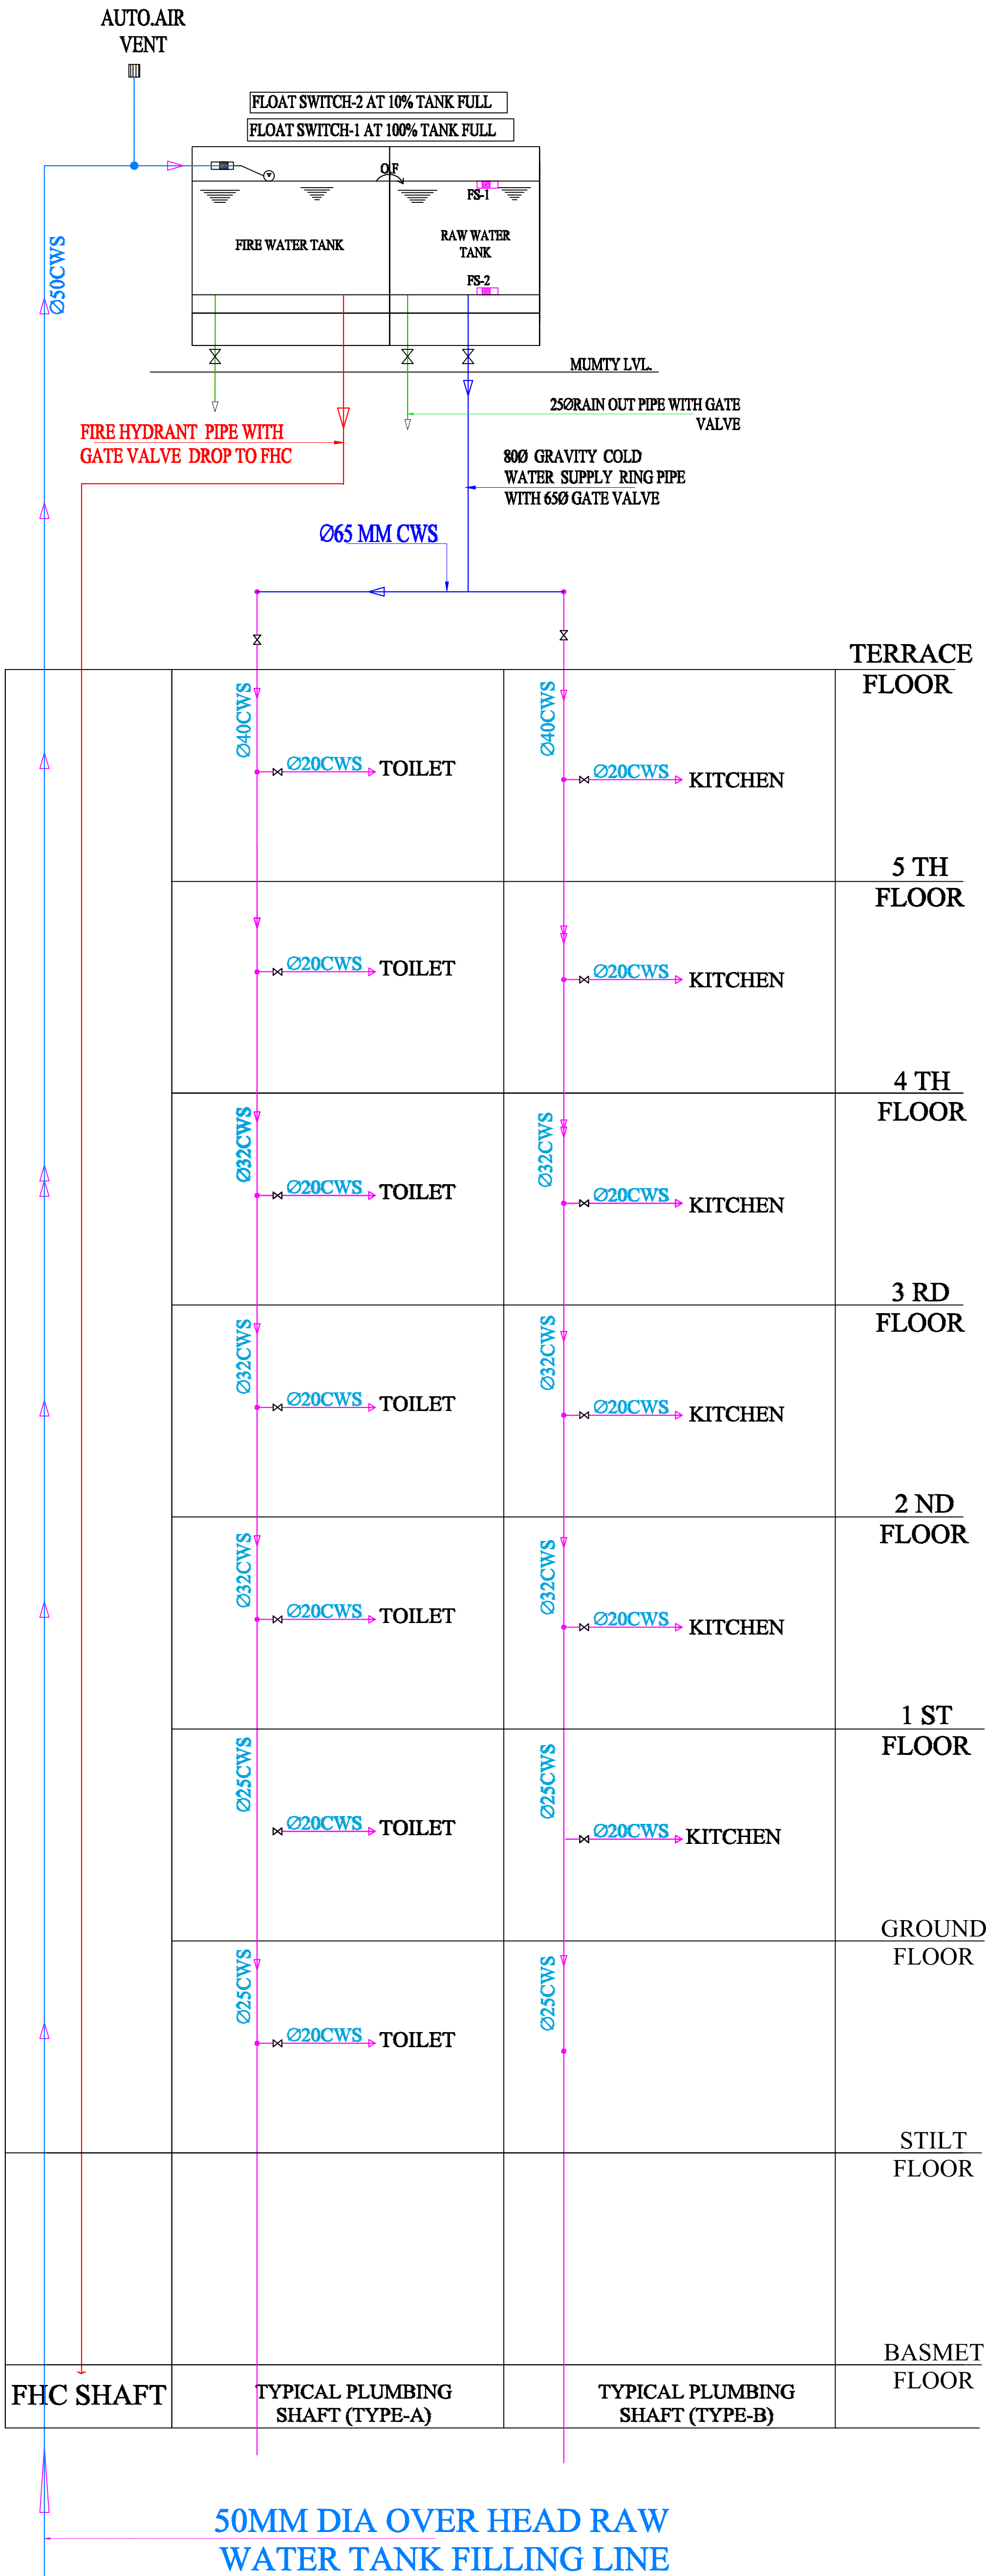


WARNING
1. This drawing is the sole copyright of Architects **VISTAAR** and should be used for the purpose expressly issued.

GENERAL NOTES
1. All dimensions are in feet and inches.
2. Do not scale this drawing follow written dimensions only.
3. This drawing should be read in conjunction with other architectural and structural drawings.
4. Any discrepancy in the drawing should be immediately brought to the notice of architect.

PROJECT TITLE
THE URBAN CREST
PLOT NO. - A-9,A-10,A-11,A-12
A-21,A-22,A-23,A-24, SHYAM VATIKA,
MANYAWAS,MANSROVAR, JAIPUR.

DRAWING TITLE
WATER SUPPLY DIAGRAM

ARCHITECTS:
VISTAAR ARCHITECTS & PLANNERS
Architects :: Interior Designers
B-2/12, Chitrkoot scheme,
main Gandhi Path,Opp mall of jaipur,Jaipur
PH.- 0141-4116461,09001010366

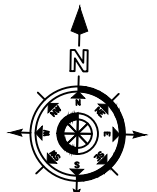PATH:-		DATE	REV.	NORTH
DEN.	MANOJ KUMAWA	23-05-2024		
SCALE	JOB NO.			
N.T.S.				