


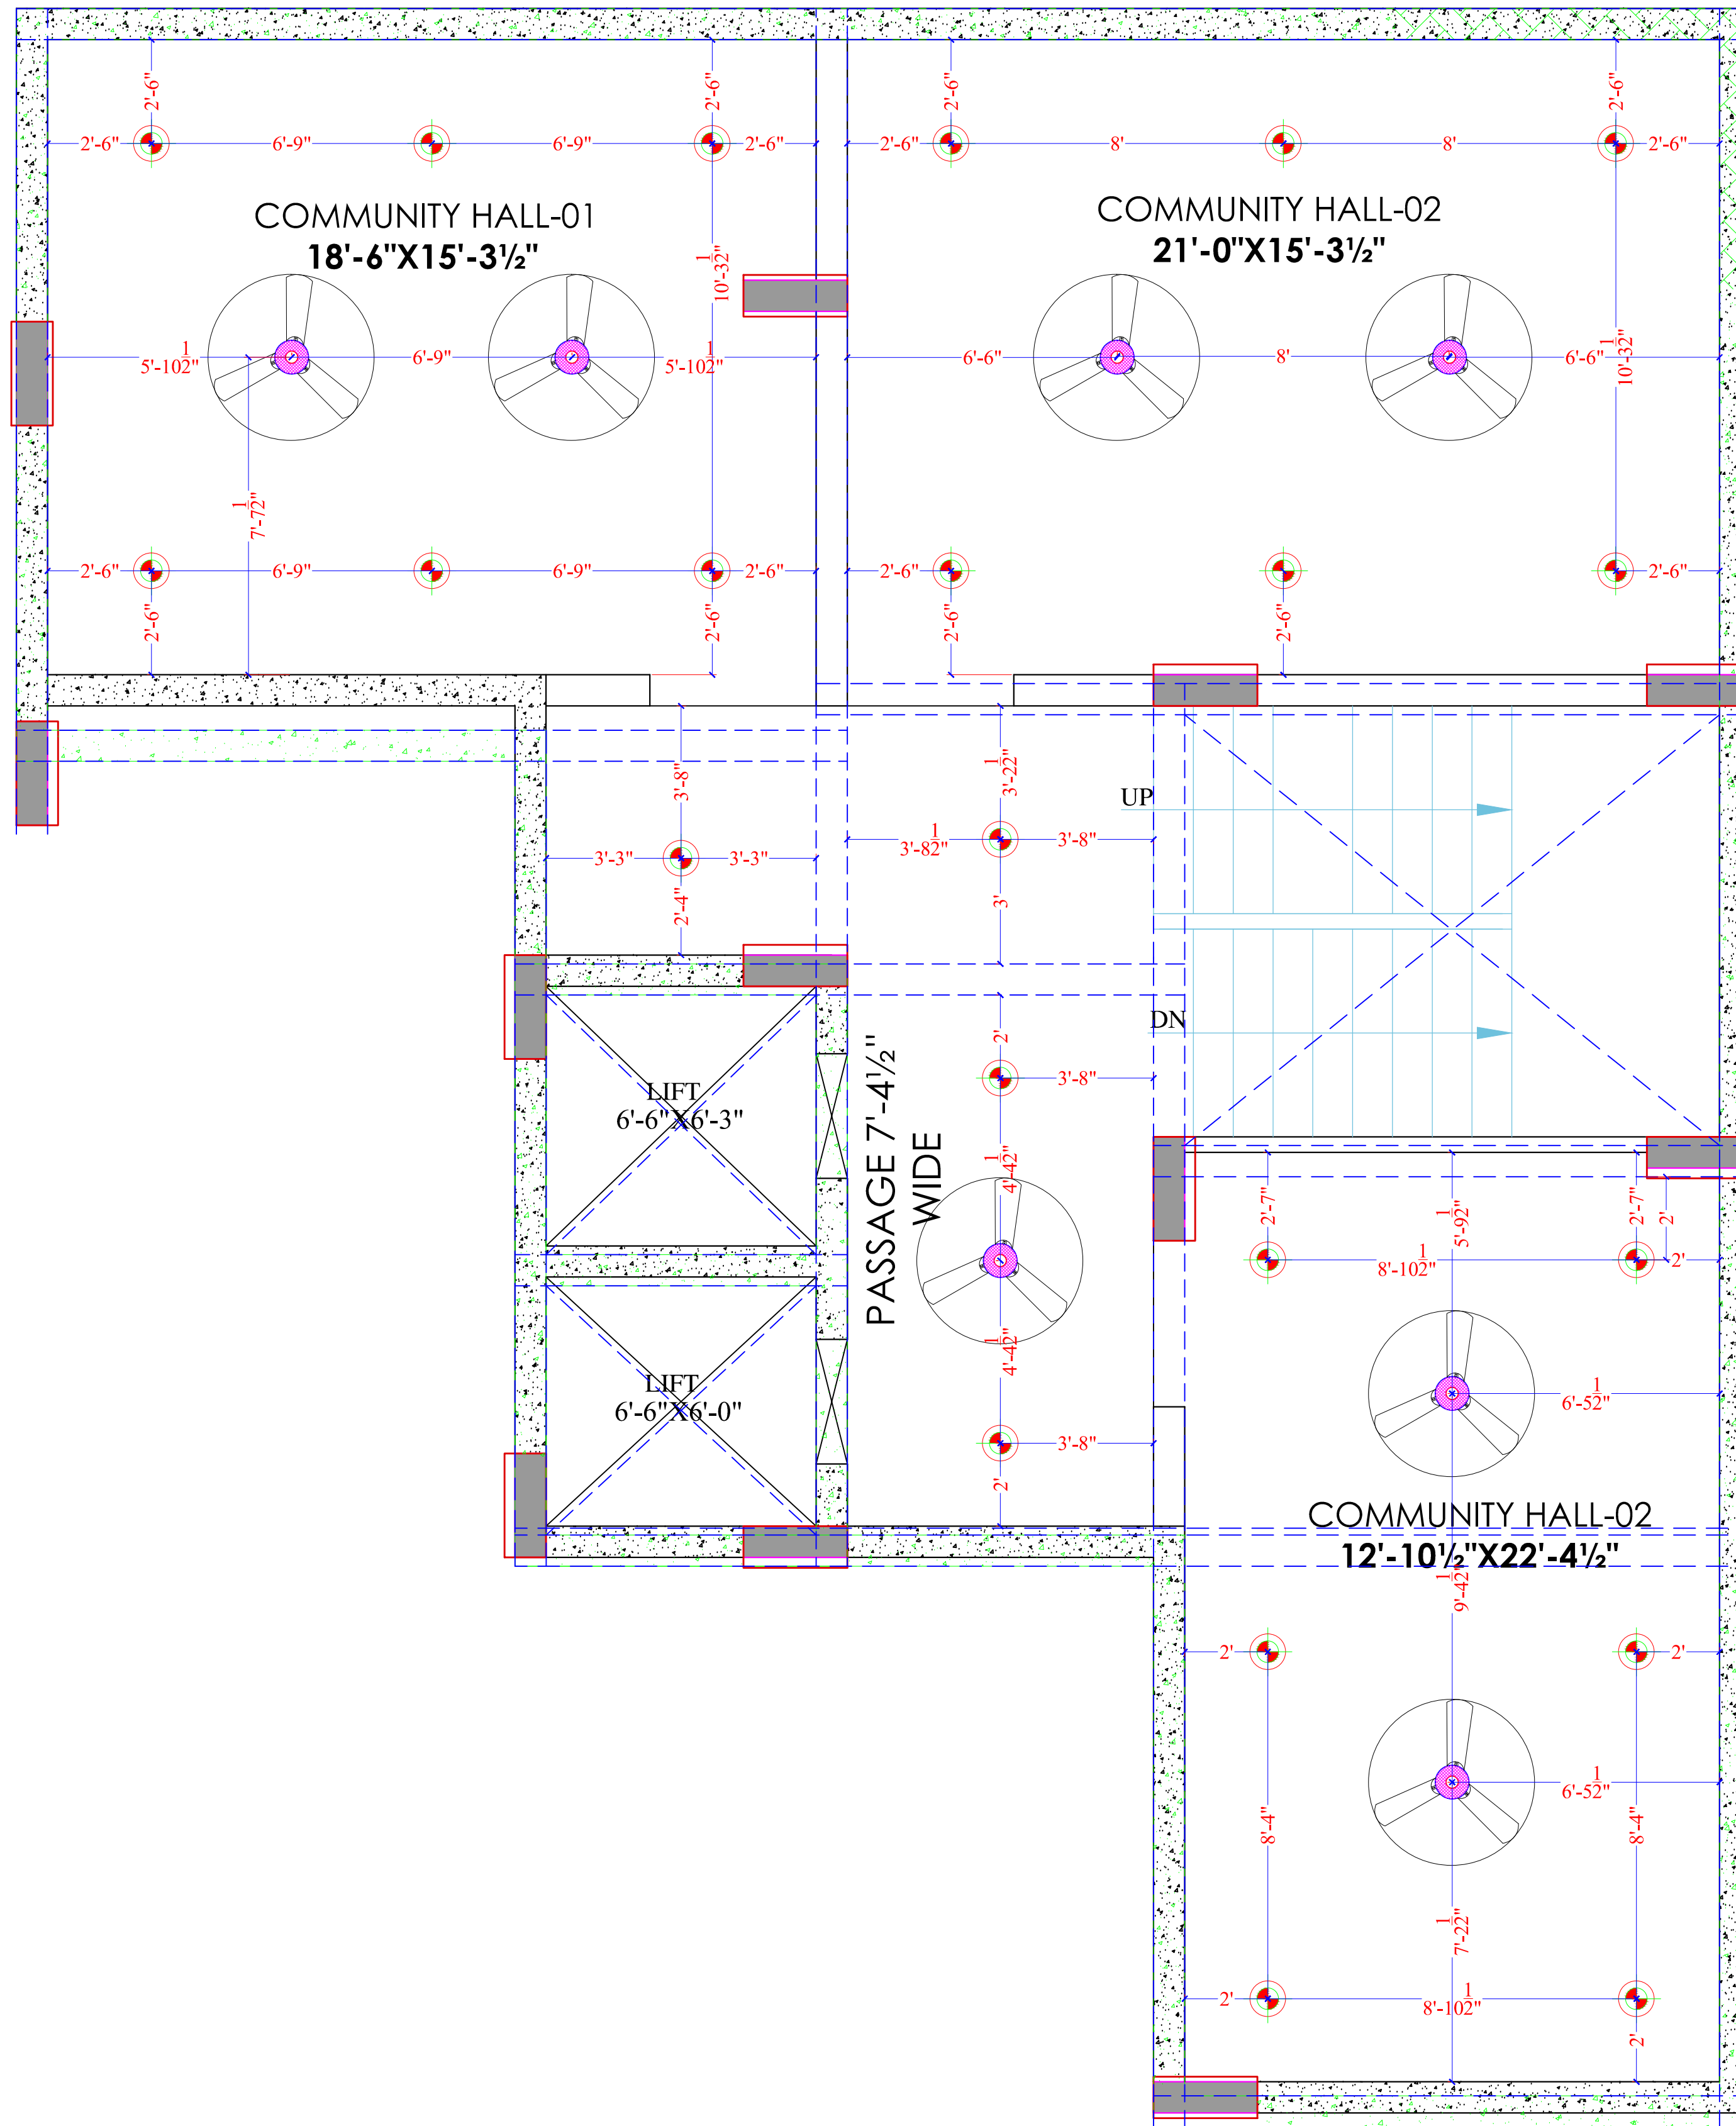

Shree Gurukripa Homes
Patner

Krishna
KRISHNA KUMAR
B. Tech. (Mechanical)
M.E.P Consultant

WARNING

1. This drawing is the sole copyright of Architects **VISTAAR** and should be used for the purpose expressly issued.

GENERAL NOTES

1. All dimensions are in feet and inches.
2. Do not scale this drawing follow written dimensions only.
3. This drawing should be read in conjunction with other architectural and structural drawings.
4. Any discrepancy in the drawing should be immediately brought to the notice of architect.

PROJECT TITLE

THE URBAN CREST
PLOT NO. - A-9,A-10,A-11,A-12
A-21,A-22,A-23,A-24, SHYAM VATIKA,
MANYAWAS,MANSROVAR, JAIPUR.

DRAWING TITLE

BASEMENT FLOOR CEILING
ELECTRICAL PLAN

ARCHITECTS :

VISTAAR ARCHITECTS & PLANNERS
Architects :: Interior Designers
B-2/12, Chitrkoot scheme,
main Gandhi Path,Opp mall of jaipur,Jaipur
PH.- 0141-4370233,09001010366

PATH -

DRN.

DATE

MANOJ
KUMAWAT

24-08-2024


SCALE


N.T.S

REV.

JOB NO.

NORTH

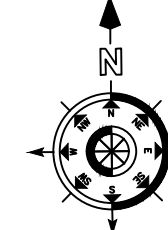

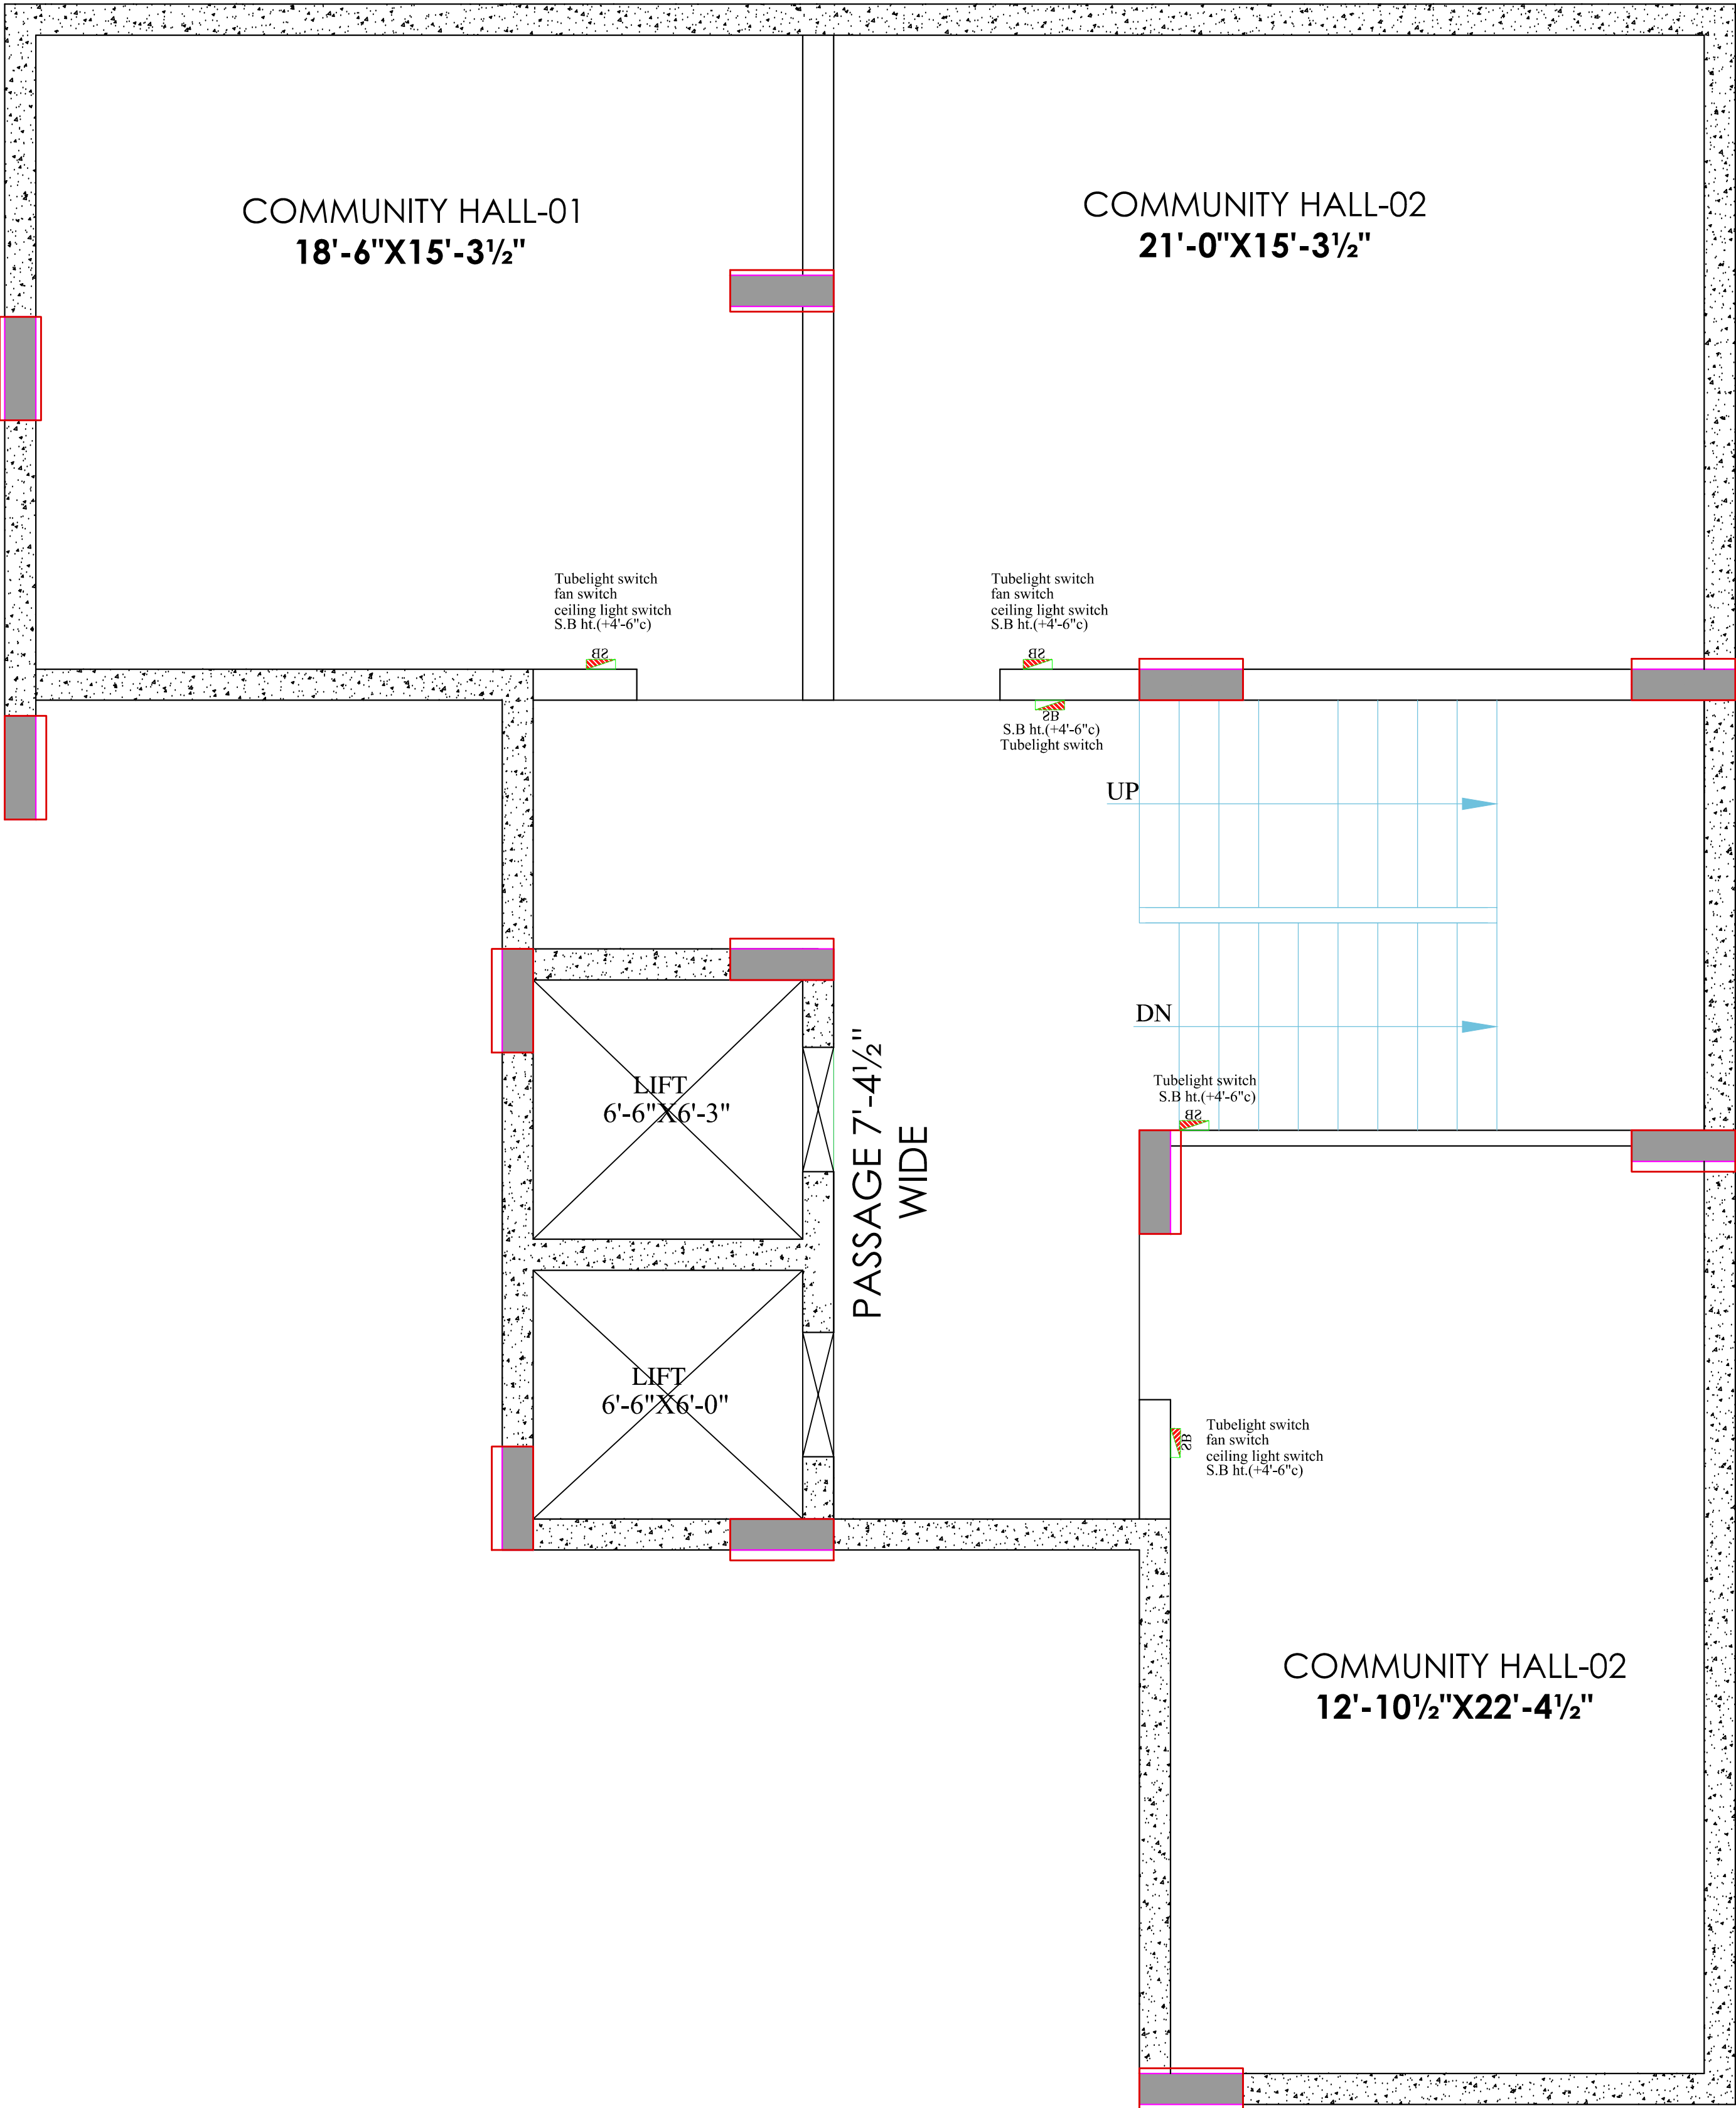

WARNING
1. This drawing is the sole copyright of Architects **VISTAAR** and should be used for the purpose expressly issued.

GENERAL NOTES
1. All dimensions are in feet and inches.
2. Do not scale this drawing follow written dimensions only.
3. This drawing should be read in conjunction with other architectural and structural drawings.
4. Any discrepancy in the drawing should be immediately brought to the notice of architect.

PROJECT TITLE
THE URBAN CREST
PLOT NO. - A-9,A-10,A-11,A-12
A-21,A-22,A-23,A-24, SHYAM VATIKA,
MANYAWAS,MANSROVAR, JAIPUR.


DRAWING TITLE
**BASEMENT FLOOR WALL
ELECTRICAL PLAN**

ARCHITECTS :
VISTAAR ARCHITECTS & PLANNERS
Architects :: Interior Designers
B-2/12, Chitrkoot scheme,
main Gandhi Path,Opp mall of jaipur,Jaipur
PH.- 0141-4370233,09001010366

PATH -			
DRN.	DATE	REV.	NORTH
MANOJ KUMAWAT	26-08-2024		
SCALE	JOB NO.		
N.T.S			

Shree Gurukripa Homes
Yashin
Patner

Krishna
KRISHNA KUMAR
B. Tech. (Mechanical)
M.E.P Consultant

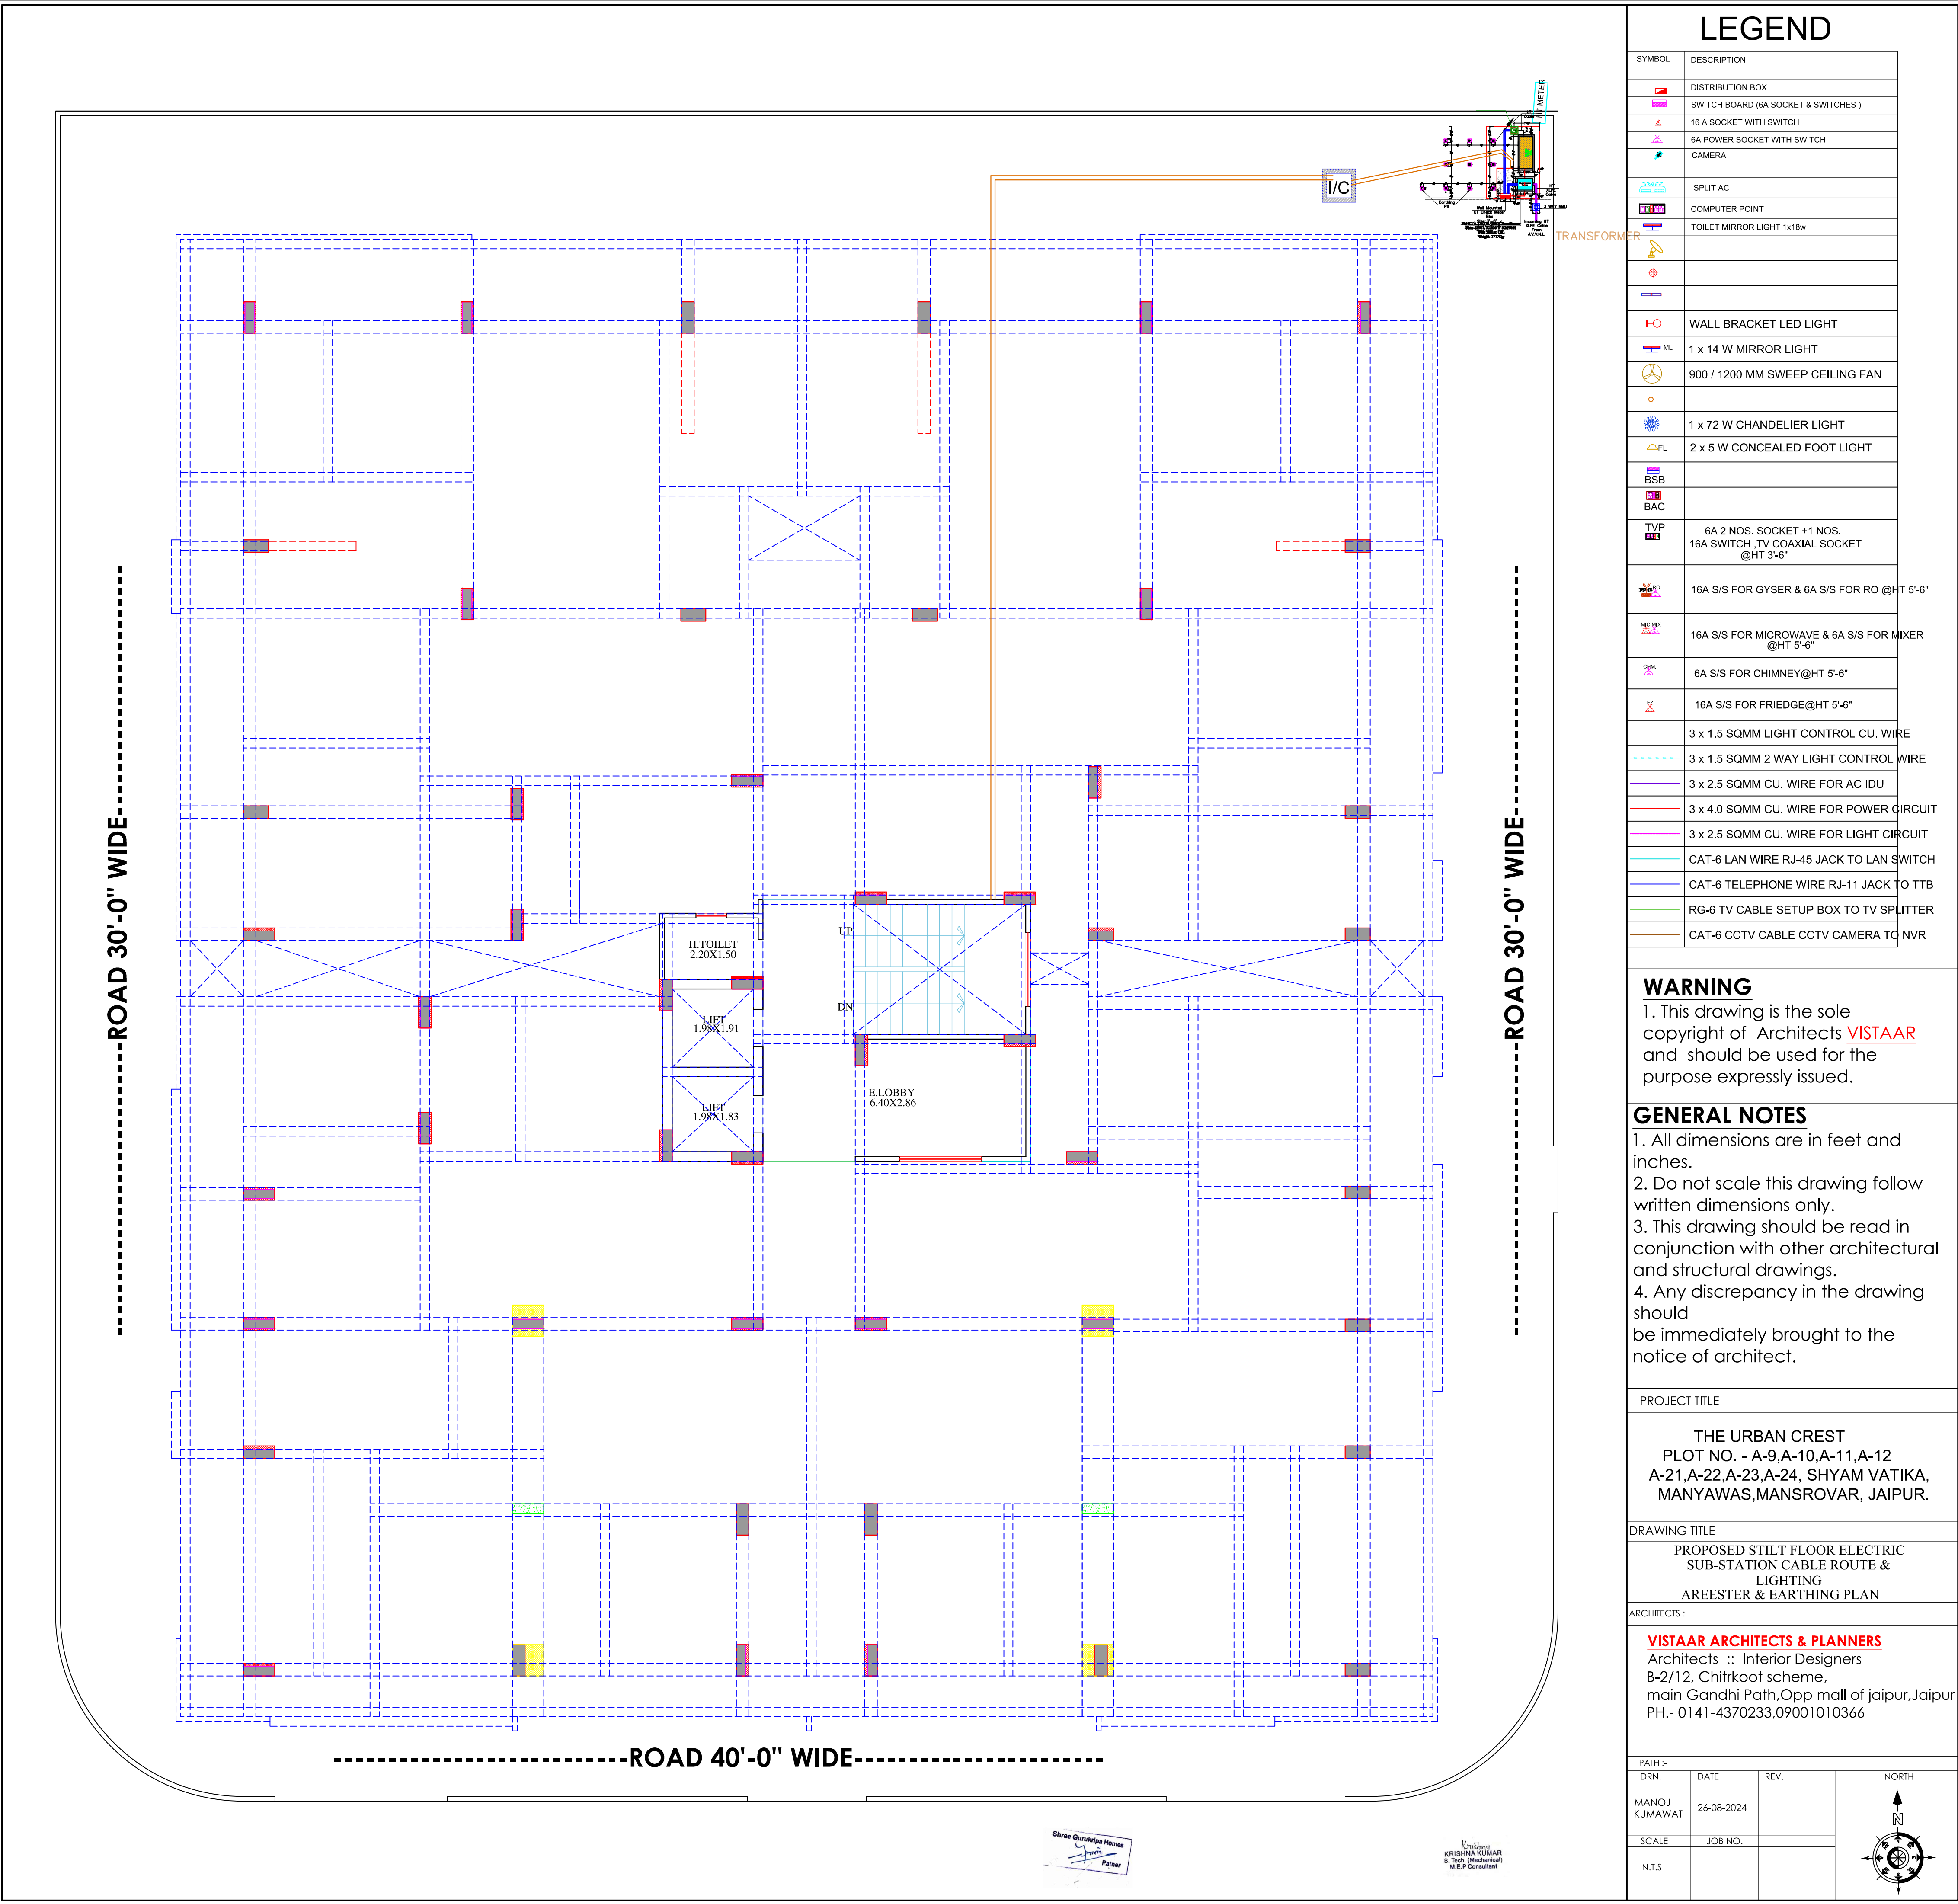

LEGEND

SYMBOL	DESCRIPTION
	DISTRIBUTION BOX
	SWITCH BOARD (6A SOCKET & SWITCHES)
	16 A SOCKET WITH SWITCH
	6A POWER SOCKET WITH SWITCH
	CAMERA
	SPLIT AC
	COMPUTER POINT
	TOILET MIRROR LIGHT 1x18w
	WALL BRACKET LED LIGHT
	1 x 14 W MIRROR LIGHT
	900 / 1200 MM SWEEP CEILING FAN
	1 x 72 W CHANDELIER LIGHT
	2 x 5 W CONCEALED FOOT LIGHT
	BSB
	BAC
	6A 2 NOS. SOCKET +1 NOS. 16A SWITCH ,TV COAXIAL SOCKET @HT 3'-6"
	16A S/S FOR GYSER & 6A S/S FOR RO @HT 5'-6"
	16A S/S FOR MICROWAVE & 6A S/S FOR MIXER @HT 5'-6"
	6A S/S FOR CHIMNEY@HT 5'-6"
	16A S/S FOR FRIEDGE@HT 5'-6"
	3 x 1.5 SQMM LIGHT CONTROL CU. WIRE
	3 x 1.5 SQMM 2 WAY LIGHT CONTROL WIRE
	3 x 2.5 SQMM CU. WIRE FOR AC IDU
	3 x 4.0 SQMM CU. WIRE FOR POWER CIRCUIT
	3 x 2.5 SQMM CU. WIRE FOR LIGHT CIRCUIT
	CAT-6 LAN WIRE RJ-45 JACK TO LAN SWITCH
	CAT-6 TELEPHONE WIRE RJ-11 JACK TO TTB
	RG-6 TV CABLE SETUP BOX TO TV SPLITTER
	CAT-6 CCTV CABLE CCTV CAMERA TO NVR

WARNING

1. This drawing is the sole copyright of Architects **VISTAAR** and should be used for the purpose expressly issued.

GENERAL NOTES

1. All dimensions are in feet and inches.
2. Do not scale this drawing follow written dimensions only.
3. This drawing should be read in conjunction with other architectural and structural drawings.
4. Any discrepancy in the drawing should be immediately brought to the notice of architect.

PROJECT TITLE

THE URBAN CREST
PLOT NO. - A-9,A-10,A-11,A-12
A-21,A-22,A-23,A-24, SHYAM VATIKA,
MANYAWAS,MANSROVAR, JAIPUR.


DRAWING TITLE

PROPOSED STILT FLOOR ELECTRIC
SUB-STATION CABLE ROUTE &
LIGHTING
AREESTER & EARTHING PLAN

ARCHITECTS :

VISTAAR ARCHITECTS & PLANNERS
Architects :: Interior Designers
B-2/12, Chitrkoot scheme,
main Gandhi Path,Opp mall of jaipur,Jaipur
PH.- 0141-4370233,09001010366

PATH -		NORTH	
DRN.	DATE	REV.	
MANOJ KUMAWAT	24-08-2024		
SCALE	JOB NO.		
N.T.S			

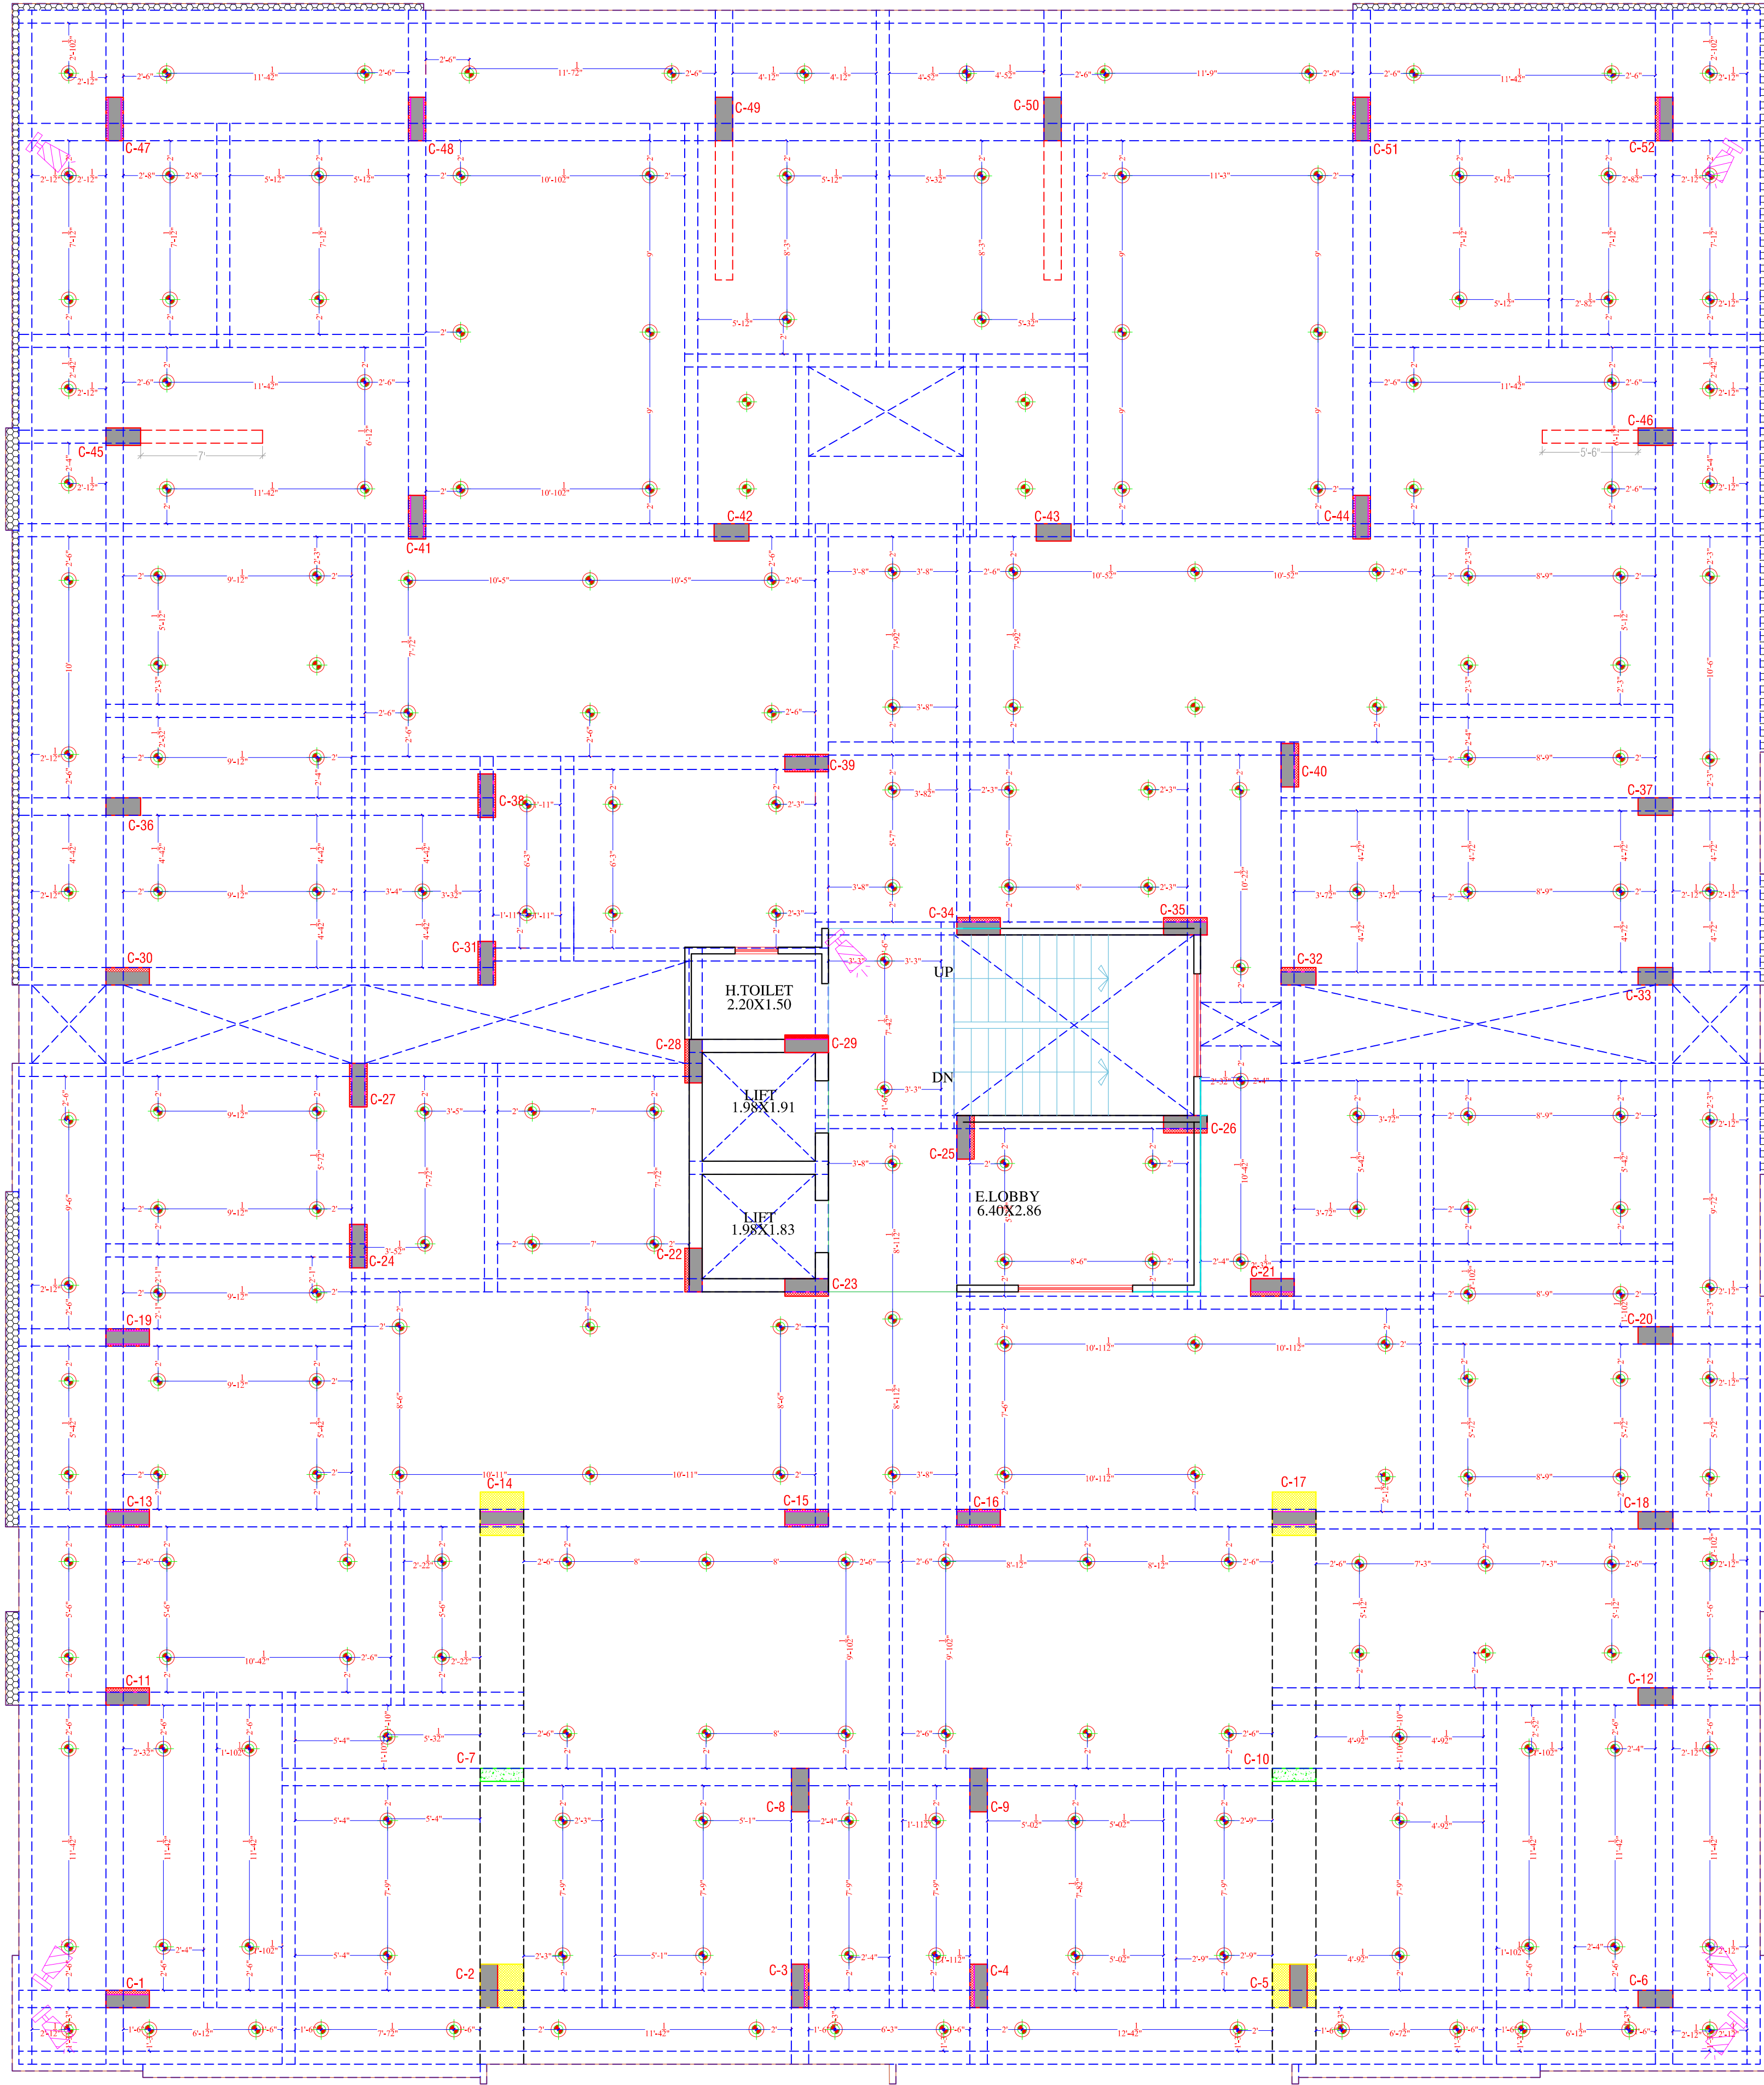

Shree Gurukrupa Homes
Partner

KRISHNA KUMAR
B. Tech. (Mechanical)
M.E.P. Consultant

LEGENDS:				
Mounting Height	No.	I D	Symbol	Description
IN FLOOR				CONTROL WIRING
IN CONDUIT				CONTROL WIRING
IN CONDUIT				AC CONTROL WIRING
IN CONDUIT				GEYSER CONTROL WIRING
IN CONDUIT				BUZZER CONTROL WIRING
CEILING	FAN48"			CEILING FAN 48"
CEILING	FAN30"			CEILING FAN 30"
+90"	TL			1X40W WALL TUBELIGHT
+90"	BULB			WALL BRACKETS AS DESIGN LIGHT
+90"	GL			WALL BRACKETS AS DESIGN FOR GANESH LIGHT
	GL			WALL BRACKETS AS DESIGN FOR GATE LIGHT
CEILING	CFL			CFL CEILING LIGHT
+21"	FL			FOOT LIGHT
+48"	SB			SWITCH BOARD
+75"	ML			1 X 11 W CFL MIRROR LIGHT
VENTILATOR HT.	CR			CEILING ROSE
VENTILATOR HT.	EXP			9" DIA FRESH AIR FAN
+24"	TEL			TELEPHONE POINT
+27"	TV			TV COAXIAL POINT
+27"	LP TV			6 A PLUG POINT FOR TV
+72"	LP-CH			6 A PLUG POINT FOR CHIMNEY
+102"	SAC			SPILT AC
+102"	PP-SAC			25 A POWER POINT FOR SPILT AC
+42"	PP-MIX			15 A POWER POINT FOR MIXER
+78"	PP-G			15 A POWER POINT FOR GEYSER
+54"	PP-F			15 A POWER POINT FOR FRIDGE
+78"	PP-WP			15 A POWER POINT FOR WATER PURIFIER
+48"	PP-WM			15 A POWER POINT FOR WASHING MACHINE
+42"	BP			BELL PUSH SWITCH
+90"	BZ			BUZZER POINT
+48"	AC			AC STARTER
+60"	MCB DB			MCB DISTRIBUTION BOARD

WARNING
1. This drawing is the sole copyright of Architects **VISTAAR** and should be used for the purpose expressly issued.

GENERAL NOTES
1. All dimensions are in feet and inches.
2. Do not scale this drawing follow written dimensions only.
3. This drawing should be read in conjunction with other architectural and structural drawings.
4. Any discrepancy in the drawing should be immediately brought to the notice of architect.

PROJECT TITLE

THE URBAN CREST
PLOT NO. - A-9,A-10,A-11,A-12
A-21,A-22,A-23,A-24, SHYAM VATIKA,
MANYAWAS,MANSROVAR, JAIPUR.


DRAWING TITLE

STILT FLOOR CEILING ELECTRICAL PLAN

ARCHITECTS :

VISTAAR ARCHITECTS & PLANNERS
Architects :: Interior Designers
B-2/12, Chitrkoot scheme,
main Gandhi Path,Opp mall of jaipur,Jaipur
PH.- 0141-4370233,09001010366

PATH -			
DRN.	DATE	REV.	NORTH
MANOJ KUMAWAT	26-08-2024		
SCALE	JOB NO.		
N.T.S			

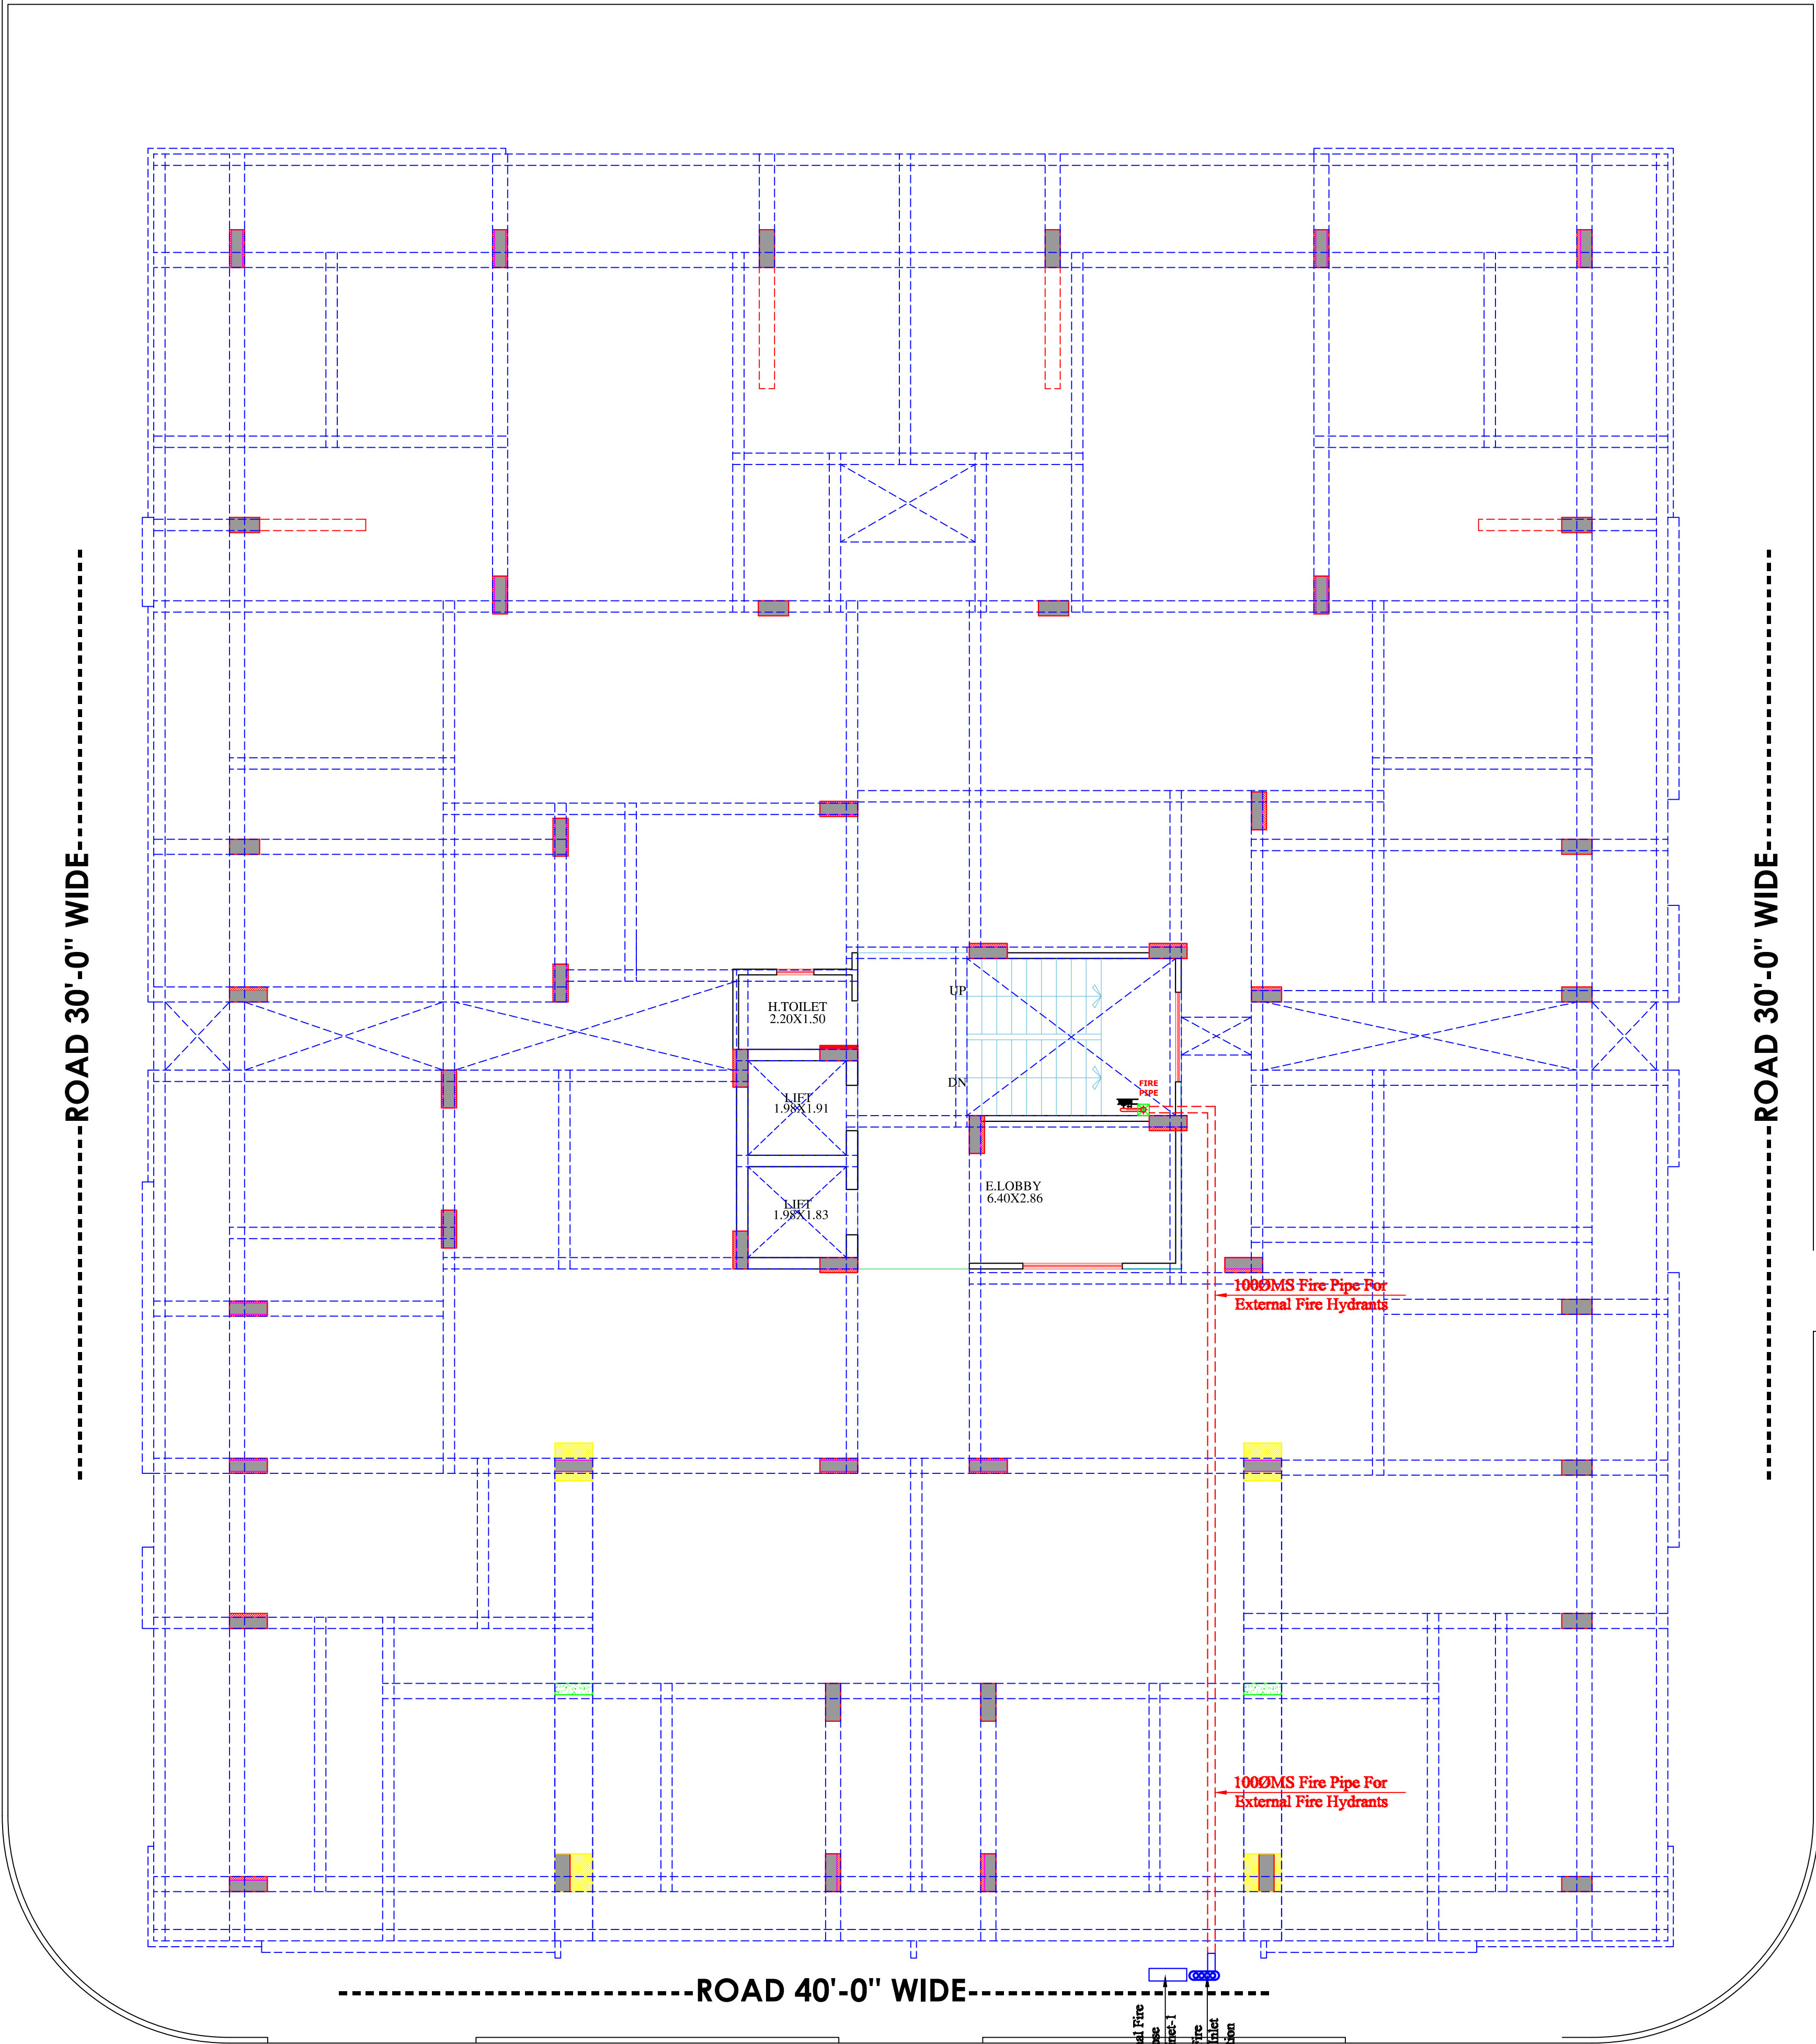

LEGEND

EMERGENCY ASSEMBLY POINT

FIRE POINT

FIRE HYDRANT

EMERGENCY CONTROL ROOM

HOSE REEL

WARNING
1. This drawing is the sole copyright of Architects **VISTAAR** and should be used for the purpose expressly issued.


GENERAL NOTES
1. All dimensions are in feet and inches.
2. Do not scale this drawing follow written dimensions only.
3. This drawing should be read in conjunction with other architectural and structural drawings.
4. Any discrepancy in the drawing should be immediately brought to the notice of architect.

PROJECT TITLE
THE URBAN CREST
PLOT NO. - A-9,A-10,A-11,A-12
A-21,A-22,A-23,A-24, SHYAM VATIKA,
MANYAWAS,MANSROVAR, JAIPUR.

DRAWING TITLE
STILT FLOOR FALSE CEILING PLAN

ARCHITECTS :
VISTAAR ARCHITECTS & PLANNERS
Architects :: Interior Designers
B-2/12, Chitrkoot scheme,
main Gandhi Path,Opp mall of jaipur,Jaipur
PH.- 0141-4370233,09001010366

PATH -			NORTH
DRN.	DATE	REV.	
MANOJ KUMAWAT	26-08-2024		
SCALE	JOB NO.		
N.T.S			

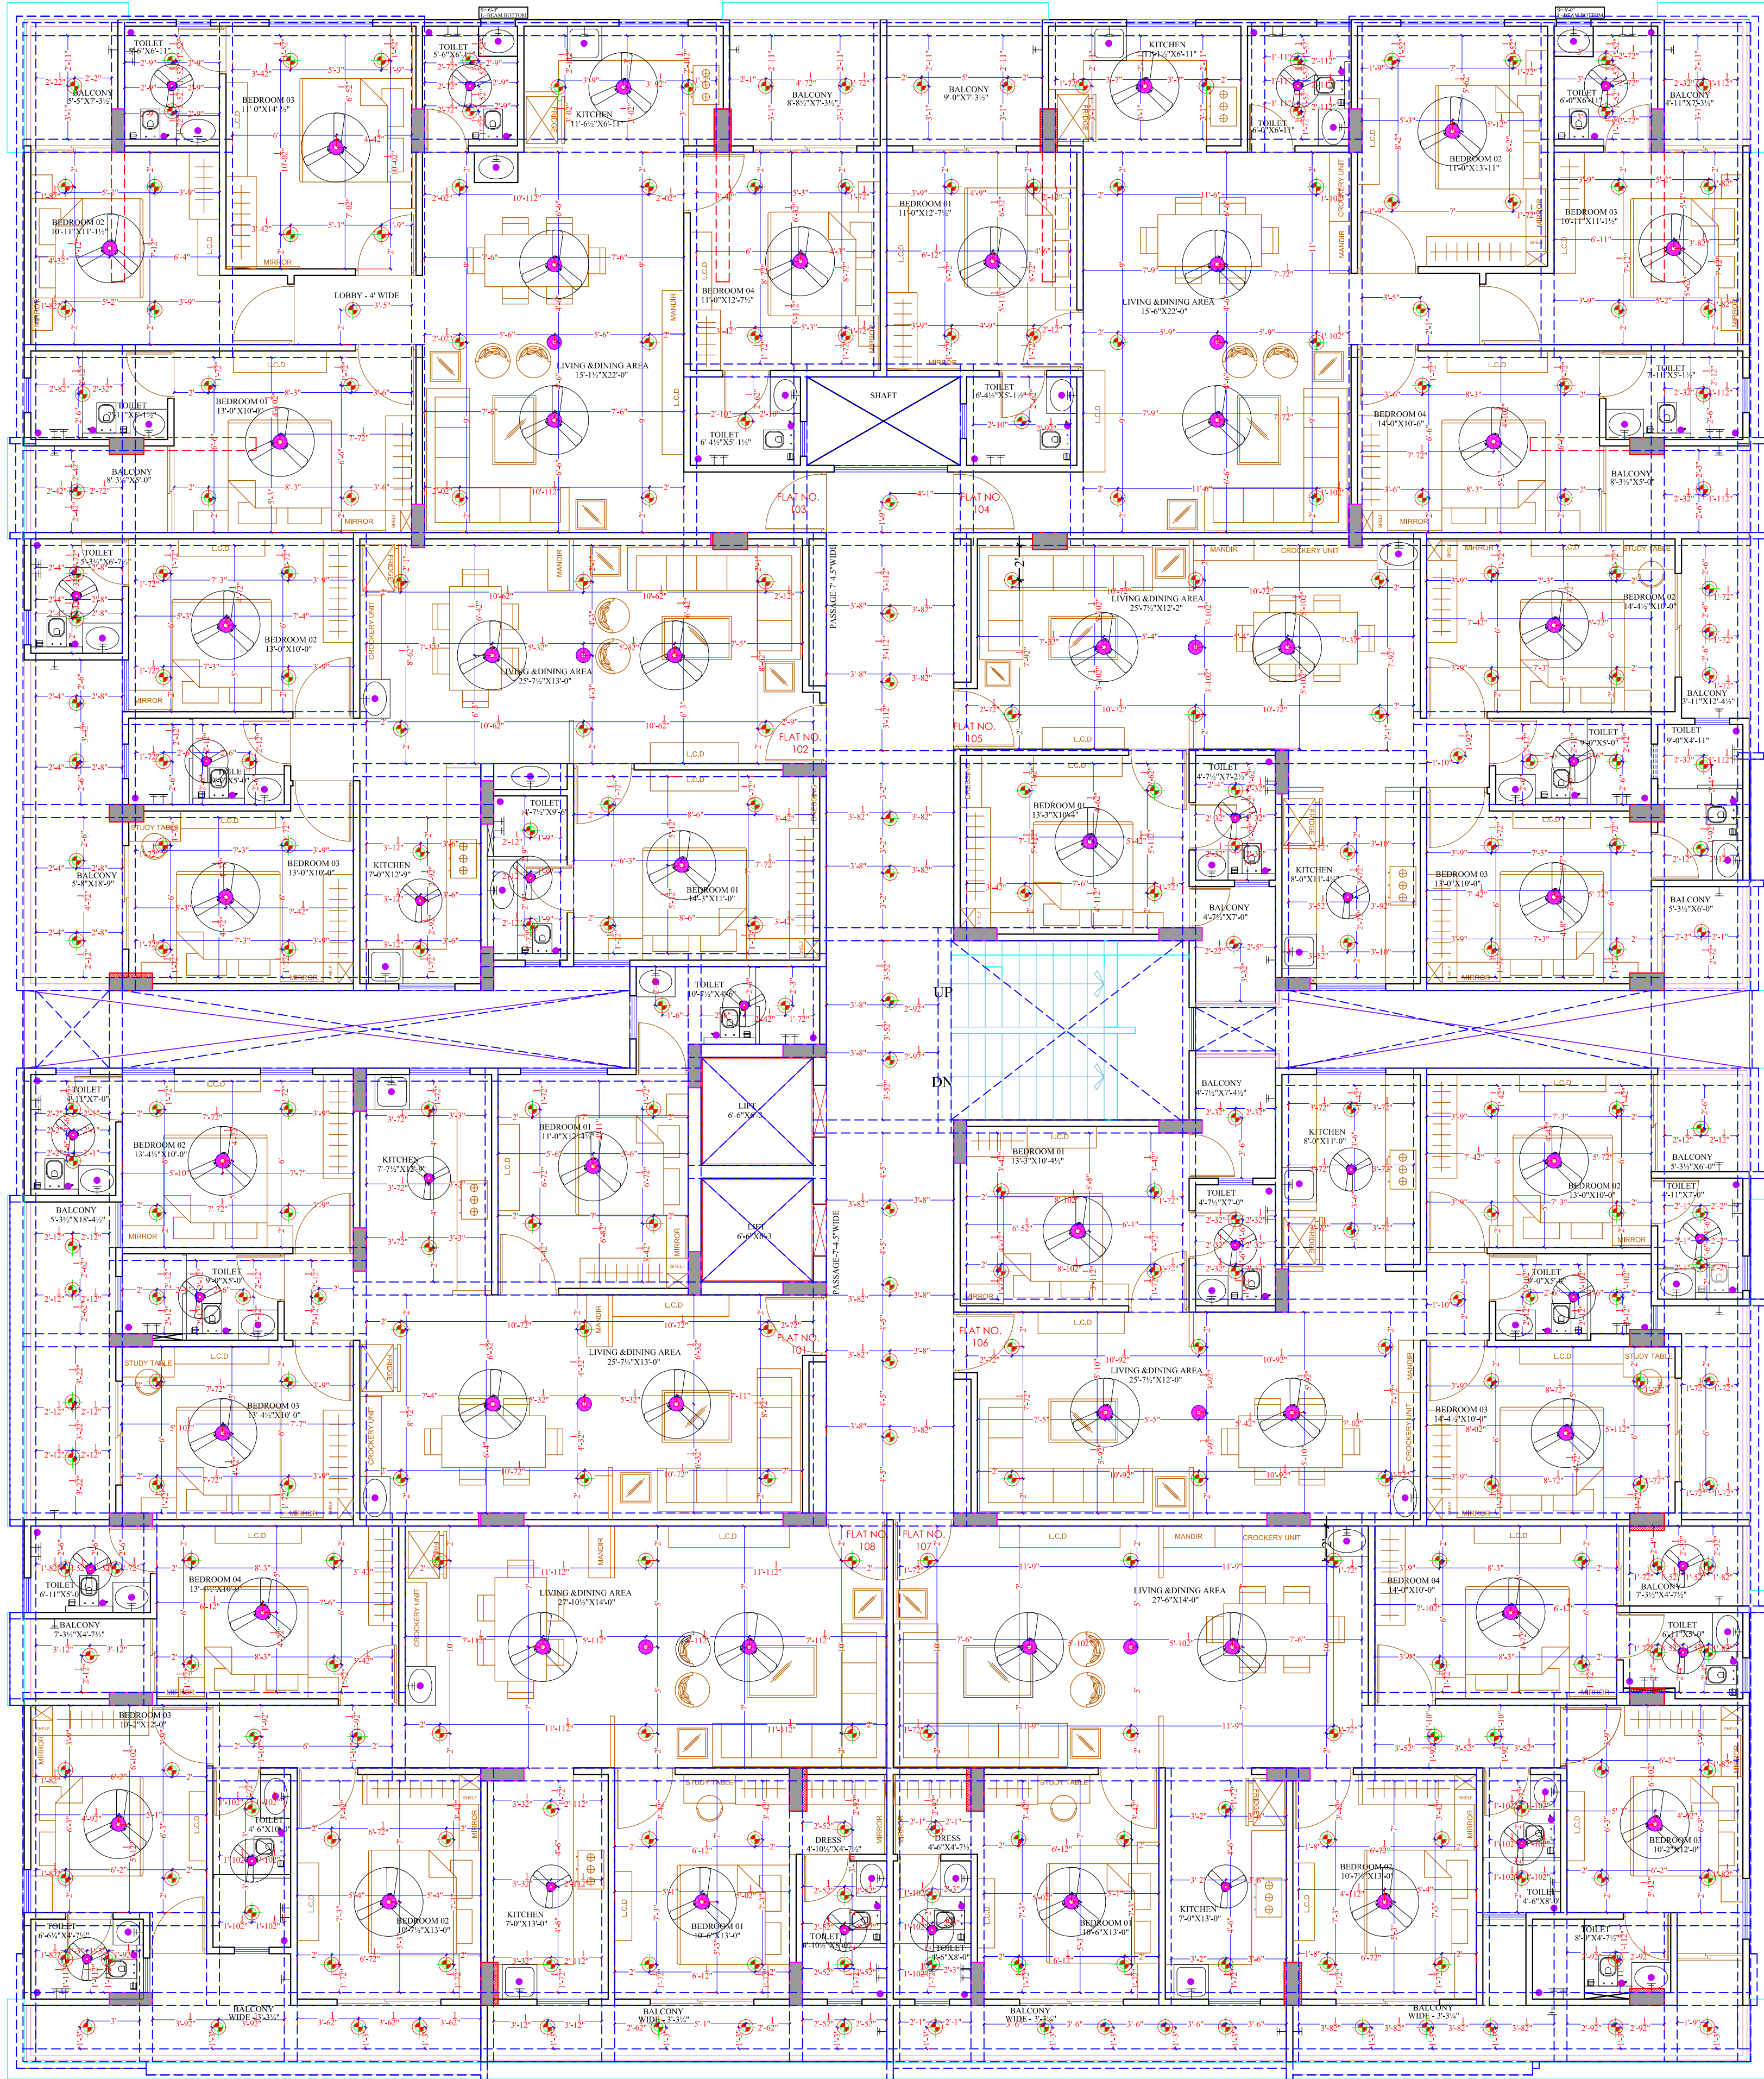

LEGENDS:				
Mounting Height	No.	I D	Symbol	Description
IN FLOOR				CONTROL WIRING
CONDUIT				CONTROL WIRING
IN CONDUIT				AC CONTROL WIRING
IN CONDUIT				GEYSER CONTROL WIRING
IN CONDUIT				BUZZER CONTROL WIRING
CEILING	FAN48"			CEILING FAN 48"
CEILING	FAN30"			CEILING FAN 30"
+90"	TL			1X40W WALL TUBELIGHT
+90"	BULB			WALL BRACKETS AS DESIGN LIGHT
+90"	GL			WALL BRACKETS AS DESIGN FOR GANESH LIGHT
	GL			WALL BRACKETS AS DESIGN FOR GATE LIGHT
CEILING	CFL			CFL CEILING LIGHT
+21"	FL			FOOT LIGHT
+48"	SB			SWITCH BOARD
+75"	ML			1 X 11 W CFL MIRROR LIGHT
VENTILATOR HT.	CR			CEILING ROSE
VENTILATOR HT.	EXP			9" DIA FRESH AIR FAN
+24"	TEL			TELEPHONE POINT
+27"	TV			TV COAXIAL POINT
+27"	LP TV			6 A PLUG POINT FOR TV
+72"	LP-CH			6 A PLUG POINT FOR CHIMNEY
+102"	SAC			SPUT AC
+102"	PP-SAC			25 A POWER POINT FOR SPUT AC
+42"	PP-MIX			15 A POWER POINT FOR MIXER
+78"	PP-G			15 A POWER POINT FOR GEYSER
+54"	PP-F			15 A POWER POINT FOR FRIDGE
+78"	PP-WP			15 A POWER POINT FOR WATER PURIFIER
+48"	PP-WM			15 A POWER POINT FOR WASHING MACHINE
+42"	BP			BELL PUSH SWITCH
+90"	BZ			BUZZER POINT
+48"	AC			AC STARTER
+60"	MCB DB			MCB DISTRIBUTION BOARD

WARNING
1. This drawing is the sole copyright of Architects **VISTAAR** and should be used for the purpose expressly issued.

GENERAL NOTES
1. All dimensions are in feet and inches.
2. Do not scale this drawing follow written dimensions only.
3. This drawing should be read in conjunction with other architectural and structural drawings.
4. Any discrepancy in the drawing should be immediately brought to the notice of architect.

PROJECT TITLE
THE URBAN CREST
PLOT NO. - A-9,A-10,A-11,A-12
A-21,A-22,A-23,A-24, SHYAM VATIKA,
MANYAWAS,MANSROVAR, JAIPUR.

DRAWING TITLE
**GROUND TO 5TH FLOOR CEILING
ELECTICAL PLAN**

ARCHITECTS :
VISTAAR ARCHITECTS & PLANNERS
Architects :: Interior Designers
B-2/12, Chitrkoot scheme,
main Gandhi Path,Opp mall of jaipur,Jaipur
PH.- 0141-4370233,09001010366

PATH -			NORTH
DRN.	DATE	REV.	
MANOJ KUMAWAT	26-08-2024		
SCALE	JOB NO.		
N.T.S			



WARNING

1. This drawing is the sole copyright of Architects VISTAAR and should be used for the purpose expressly issued.

1. All dimensions are in feet and inches.
2. Do not scale this drawing follow written dimensions only.
3. This drawing should be read in conjunction with other architectural and structural drawings.
4. Any discrepancy in the drawing should be immediately brought to the notice of architect.

PROJECT TITLE

THE URBAN CREST
PLOT NO. - A-9,A-10,A-11,A-12
A-21,A-22,A-23,A-24, SHYAM VATIKA,
MANYAWAS,MANSROVAR, JAIPUR.


DRAWING TITLE

TERRACE WALL ELECTRICAL PLAN

ARCHITECTS

VISTAAR ARCHITECTS & PLANNERS
Architects :: Interior Designers
B-2/12, Chitarkoot scheme,
main Gandhi Path, Opp mall of jaipur, Jaipur
PH.- 0141-4370233, 09001010366

PATH :-			
DRN.	DATE	REV.	NORTH
MANOJ KUMAWAT	26-08-2024		
SCALE	JOB NO.		
N.T.S			

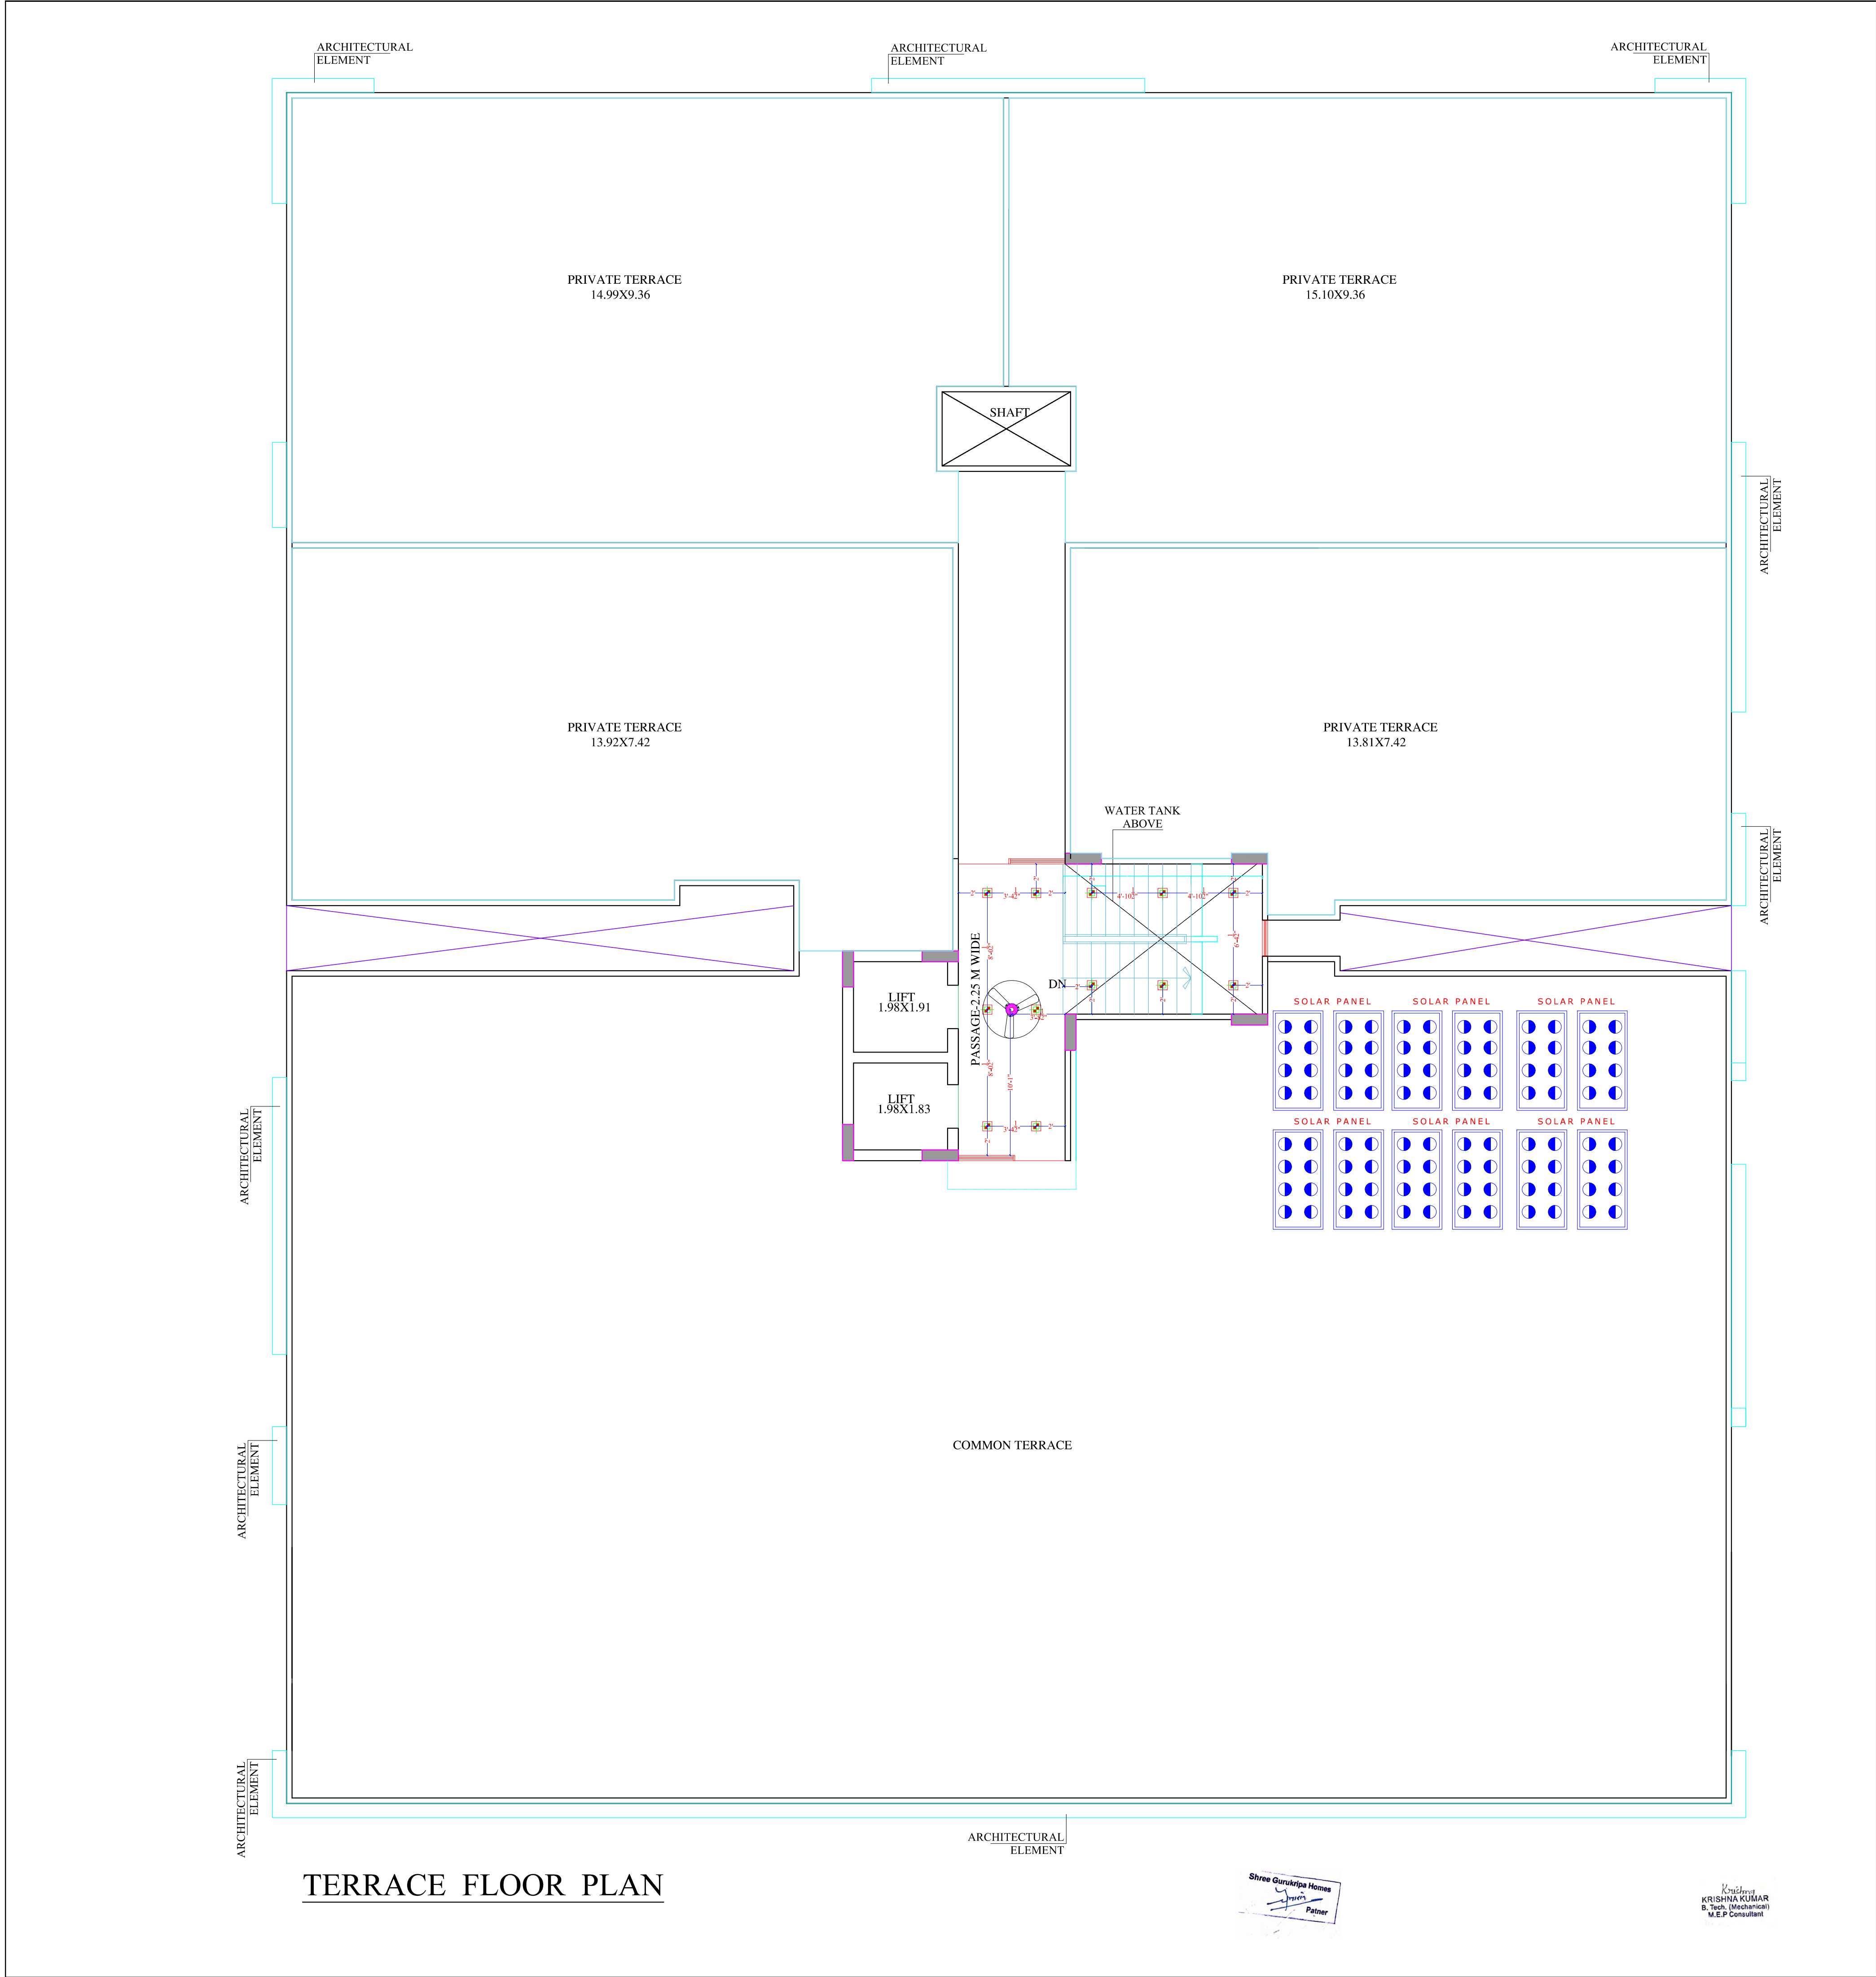

TERRACE FLOOR PLAN

LEGENDS:				
Mounting Height	No.	I D	Symbol	Description
IN FLOOR				CONTROL WIRING
IN CONDUIT				CONTROL WIRING
IN CONDUIT				AC CONTROL WIRING
IN CONDUIT				GEYSER CONTROL WIRING
IN CONDUIT				DUZZER CONTROL WIRING
CEILING		FAN 48"		CEILING FAN 48"
CEILING		FAN 30"		CEILING FAN 30"
+90"		TL		1X40W WALL TUBELIGHT
+90"		BULB		WALL BRACKETS AS DESIGN LIGHT
+90"		GL		WALL BRACKETS AS DESIGN FOR GANESH LIGHT
		GL		WALL BRACKETS AS DESIGN FOR GATE LIGHT
CEILING		CFL		CFL CEILING LIGHT
+21"		FL		FOOT LIGHT
+48"		SB		SWITCH BOARD
+78"		ML		1 X 11 W CFL MIRROR LIGHT
VENTILATOR HT		CR		CEILING ROSE
VENTILATOR HT		EXP		9" DIA FRESH AIR FAN
+24"		TEL		TELEPHONE POINT
+27"		TV		TV COAXIAL POINT
+27"		LP TV		6 A PLUG POINT FOR TV
+72"		LP-CH		6 A PLUG POINT FOR CHIMNEY
+102"		SAC		SPLIT AC
+102"		PP-SAC		25 A POWER POINT FOR SPLIT AC
+42"		PP-MIX		15 A POWER POINT FOR MIXER
+78"		PP-G		15 A POWER POINT FOR GEYSER
+54"		PP-F		15 A POWER POINT FOR FRIDGE
+78"		PP-WP		15 A POWER POINT FOR WATER PURIFIER
+48"		PP-WM		15 A POWER POINT FOR WASHING MACHINE
+42"		BP		BELL PUSH SWITCH
+90"		BZ		BUZZER POINT
+48"		AC		AC STARTER
+60"		MCB DB		MCB DISTRIBUTION BOARD

WARNING

1. This drawing is the sole copyright of Architects **VISTAAR** and should be used for the purpose expressly issued.

GENERAL NOTES

- All dimensions are in feet and inches.
- Do not scale this drawing follow written dimensions only.
- This drawing should be read in conjunction with other architectural and structural drawings.
- Any discrepancy in the drawing should be immediately brought to the notice of architect.

PROJECT TITLE

THE URBAN CREST
PLOT NO. - A-9,A-10,A-11,A-12
A-21,A-22,A-23,A-24. SHYAM VATIKA,
MANYAWAS,MANSROVAR, JAIPUR.

DRAWING TITLE

TERRACE FLOOR CEILING PLAN

ARCHITECTS :

VISTAAR ARCHITECTS & PLANNERS
Architects :: Interior Designers
B-2/12, Chitrkoot scheme,
main Gandhi Path,Opp mall of jaipur,Jaipur
PH.- 0141-4370233,09001010366

PATH :-			
DRN.	DATE	REV.	NORTH
MANOJ KUMAWAT	26-08-2024		
SCALE	JOB NO.		
N.T.S			



WARNING

1. This drawing is the sole copyright of Architects
VISTAAR and should be used for the purpose
expressly issued.

GENERAL NOTES

1. All dimensions are in feet and inches.
2. Do not scale this drawing follow written dimensions
only.
3. This drawing should be read in conjunction with other
architectural and structural drawings.
4. Any discrepancy in the drawing should
be immediately brought to the notice of architect.

PROJECT TITLE

THE URBAN CREST
PLOT NO. - A-9,A-10,A-11,A-12
A-21,A-22,A-23,A-24, SHYAM VATIKA,
MANYAWAS,MANSROVAR, JAIPUR.

DRAWING TITLE


TELEPHONE
SINGLE LINE DIAGRAM

ARCHITECTS:

**VISTAAR ARCHITECTS &
PLANNERS**
Architects - Interior Designers
B-2/12, Chitrkoot scheme,
main Gandhi Path,Opp mall of jaipur,Jaipur
PH.- 0141-4116461,09001010366

DATE	REV.	NORTH
24-08-2024		
SCALE	JOB NO.	
N.T.S		



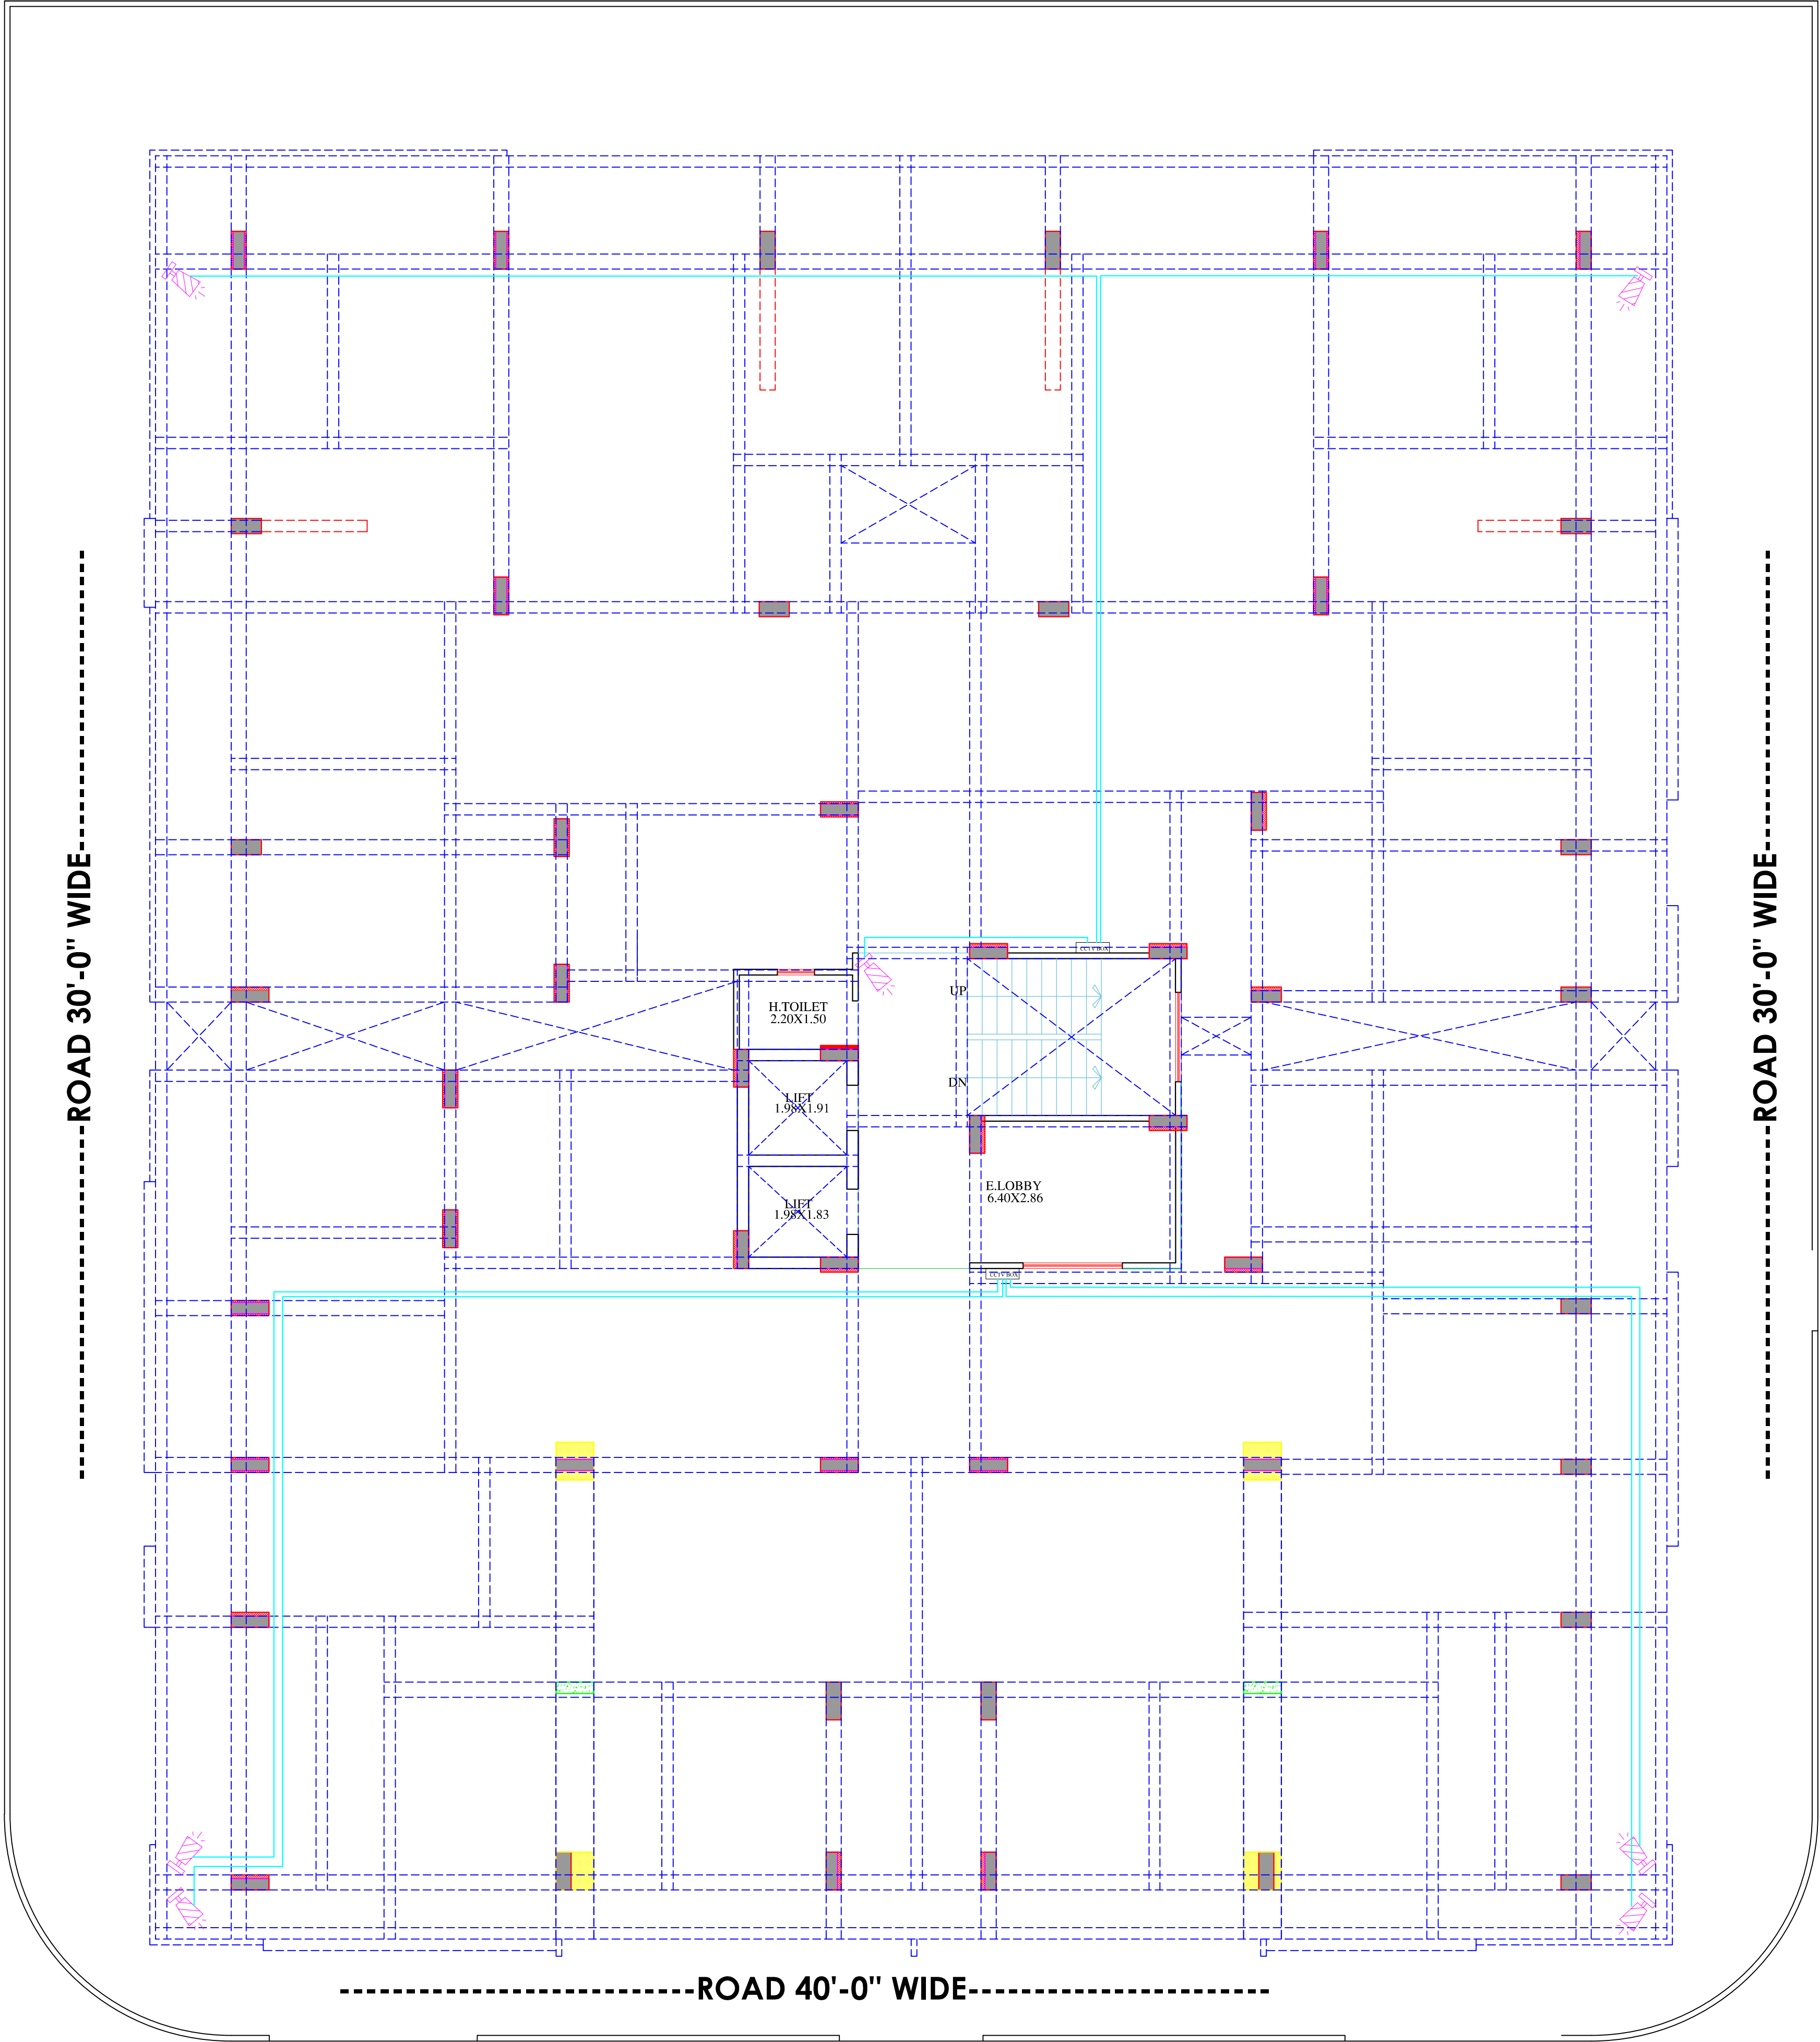

WARNING
1. This drawing is the sole copyright of Architects **VISTAAR** and should be used for the purpose expressly issued.

GENERAL NOTES
1. All dimensions are in feet and inches.
2. Do not scale this drawing follow written dimensions only.
3. This drawing should be read in conjunction with other architectural and structural drawings.
4. Any discrepancy in the drawing should be immediately brought to the notice of architect.

PROJECT TITLE
THE URBAN CREST
PLOT NO. - A-9,A-10,A-11,A-12
A-21,A-22,A-23,A-24, SHYAM VATIKA,
MANYAWAS,MANSROVAR, JAIPUR.

DRAWING TITLE
CCTV

ARCHITECTS :
VISTAAR ARCHITECTS & PLANNERS
Architects :: Interior Designers
B-2/12, Chitrkoot scheme,
main Gandhi Path,Opp mall of jaipur,Jaipur
PH.- 0141-4370233,09001010366

PATH -		NORTH	
DRN.	DATE	REV.	
MANOJ KUMAWAT	26-08-2024		
SCALE	JOB NO.		
N.T.S			